



NORTH ELEVATION

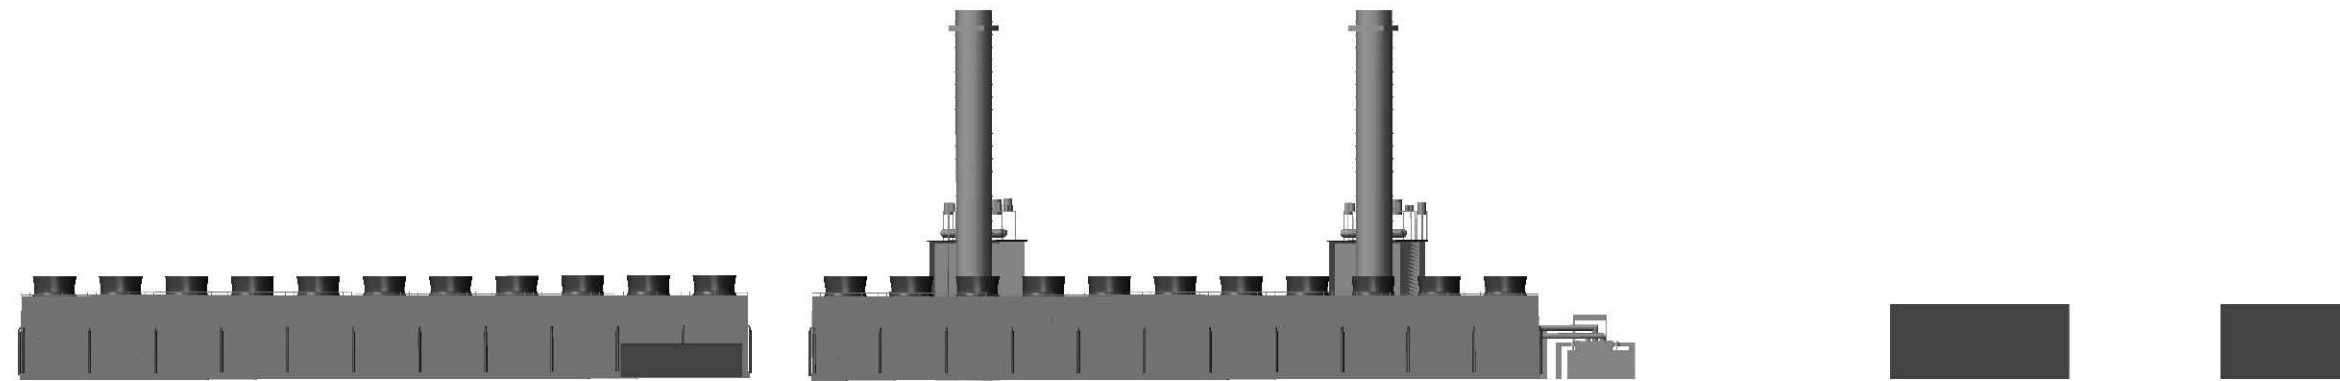

SOUTH ELEVATION

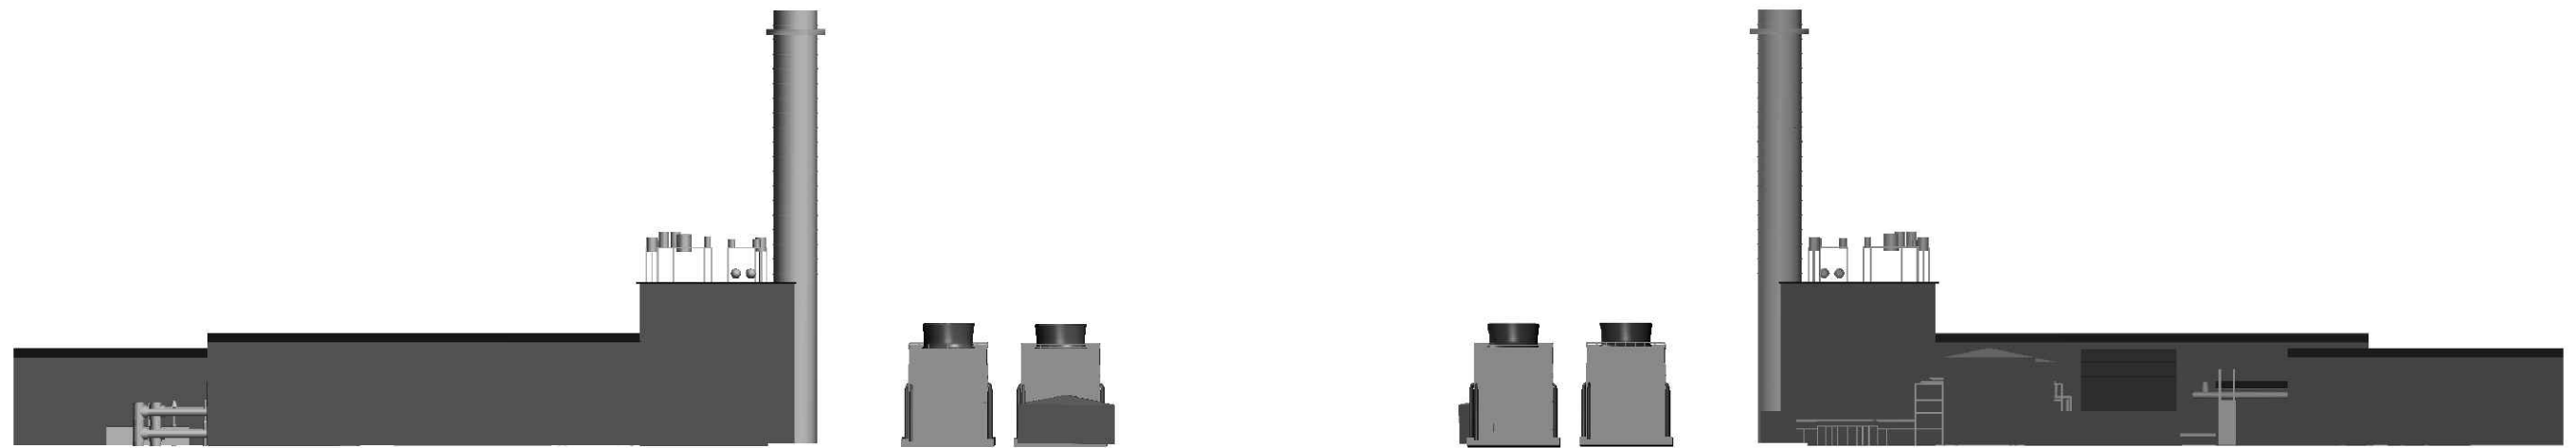

EAST ELEVATION

WEST ELEVATION

**Tees Combined-Cycle Power Plant (CCPP) Order**  
**Infrastructure Planning**  
**(Applications: Prescribed Forms and Procedures)**  
**Regulations 2009 - Regulation 5(2)(o)**

REV	DESCRIPTION	DRAWN	CHK'D	APP.	DATE
1	FIRST ISSUE	PS			
	ALTERATION				



Title APPLICATION DOCUMENT REFERENCE No. 4.5  
 INDICATIVE GENERATING STATION PLAN SHEET 3 of 3  
 SCALE 1:2500

Size  
**A3**

Reference  
**GIS-00-L-02717**

Date  
 9/11/17

Revision  
**1**