



NORTH ELEVATION

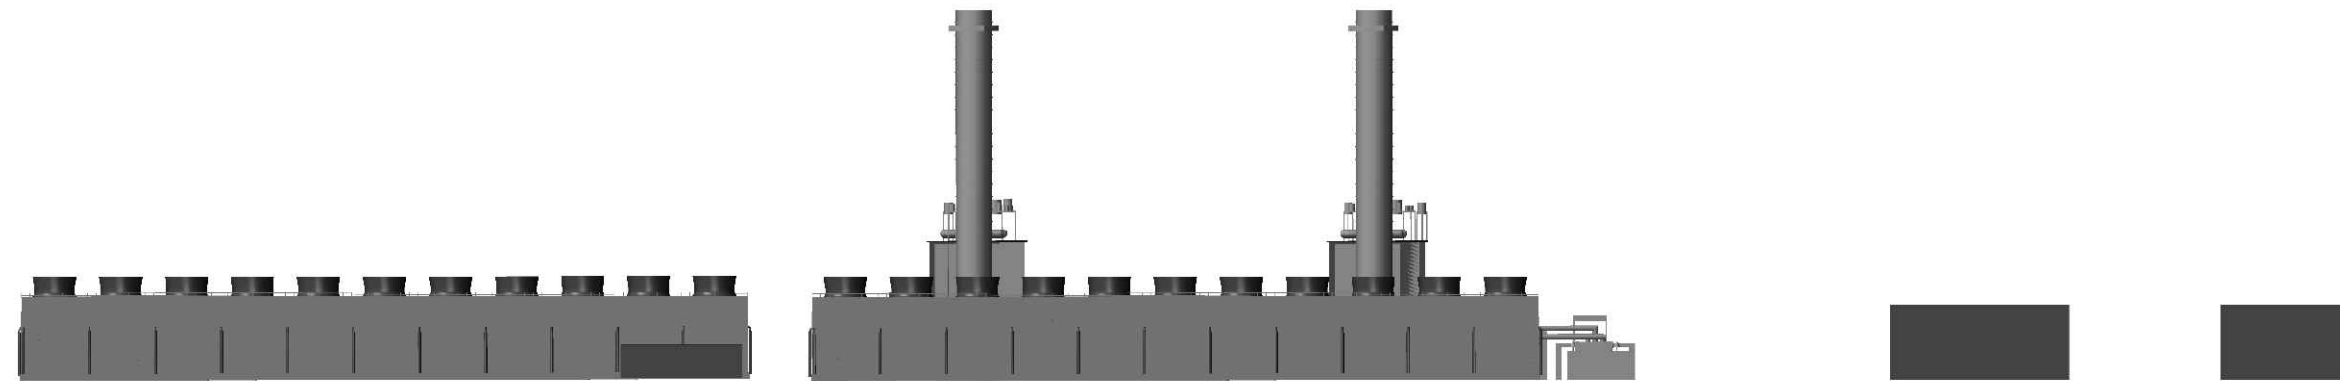

SOUTH ELEVATION

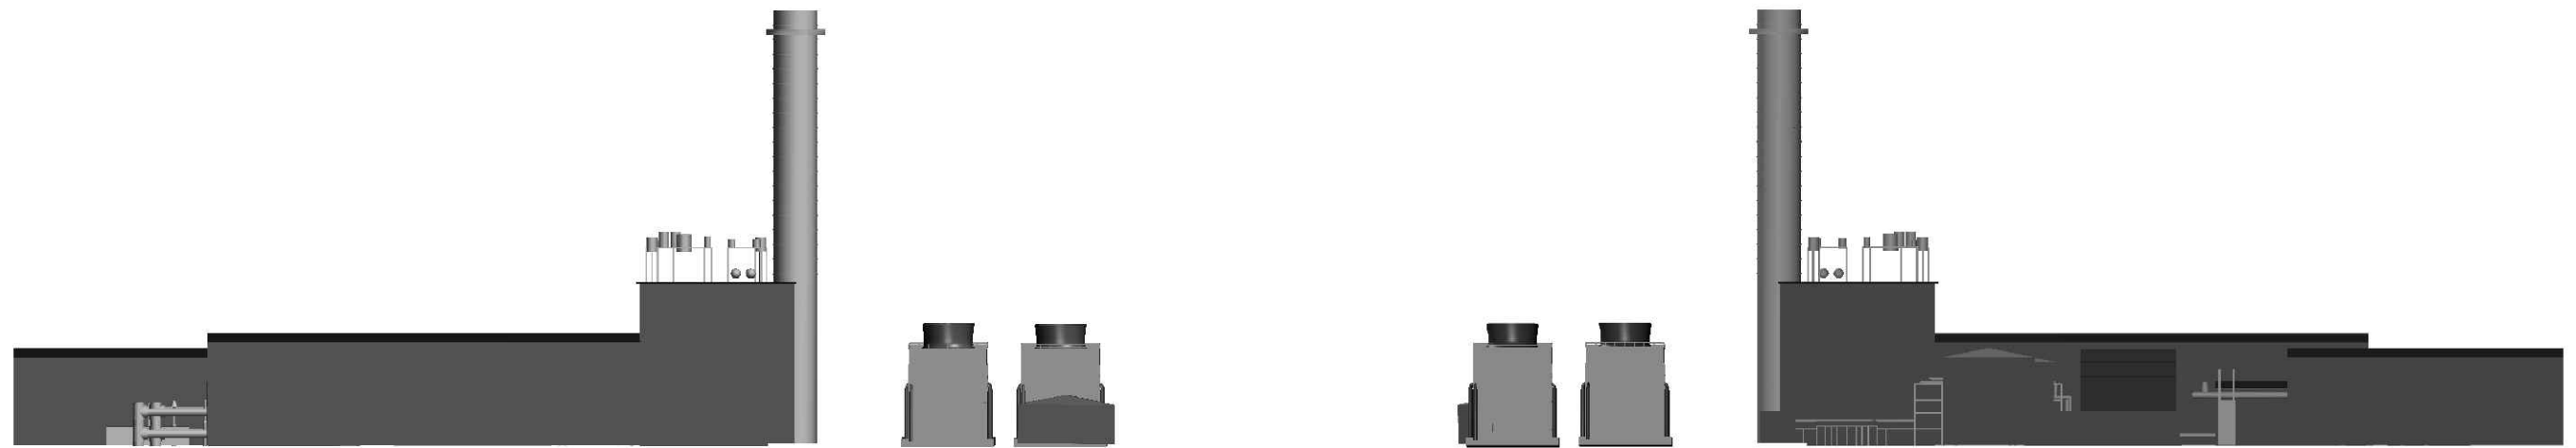

EAST ELEVATION

WEST ELEVATION



Tees Combined-Cycle Power Plant (CCPP) Order
Infrastructure Planning
(Applications: Prescribed Forms and Procedures)
Regulations 2009 - Regulation 5(2)(o)

REV	ALTERATION	DRAWN	CHK'D	APP.	DATE
2	DRAWING REVISED TO INCLUDE SCALE BAR	PS			
1	FIRST ISSUE	PS			



Title APPLICATION DOCUMENT REFERENCE No. 4.5
 INDICATIVE GENERATING STATION PLAN SHEET 3 of 3
 SCALE 1:2500

Size
A3

Reference
GIS-00-L-02717

Date
 16/1/18

Revision
2