


ELEVATION ON D-D

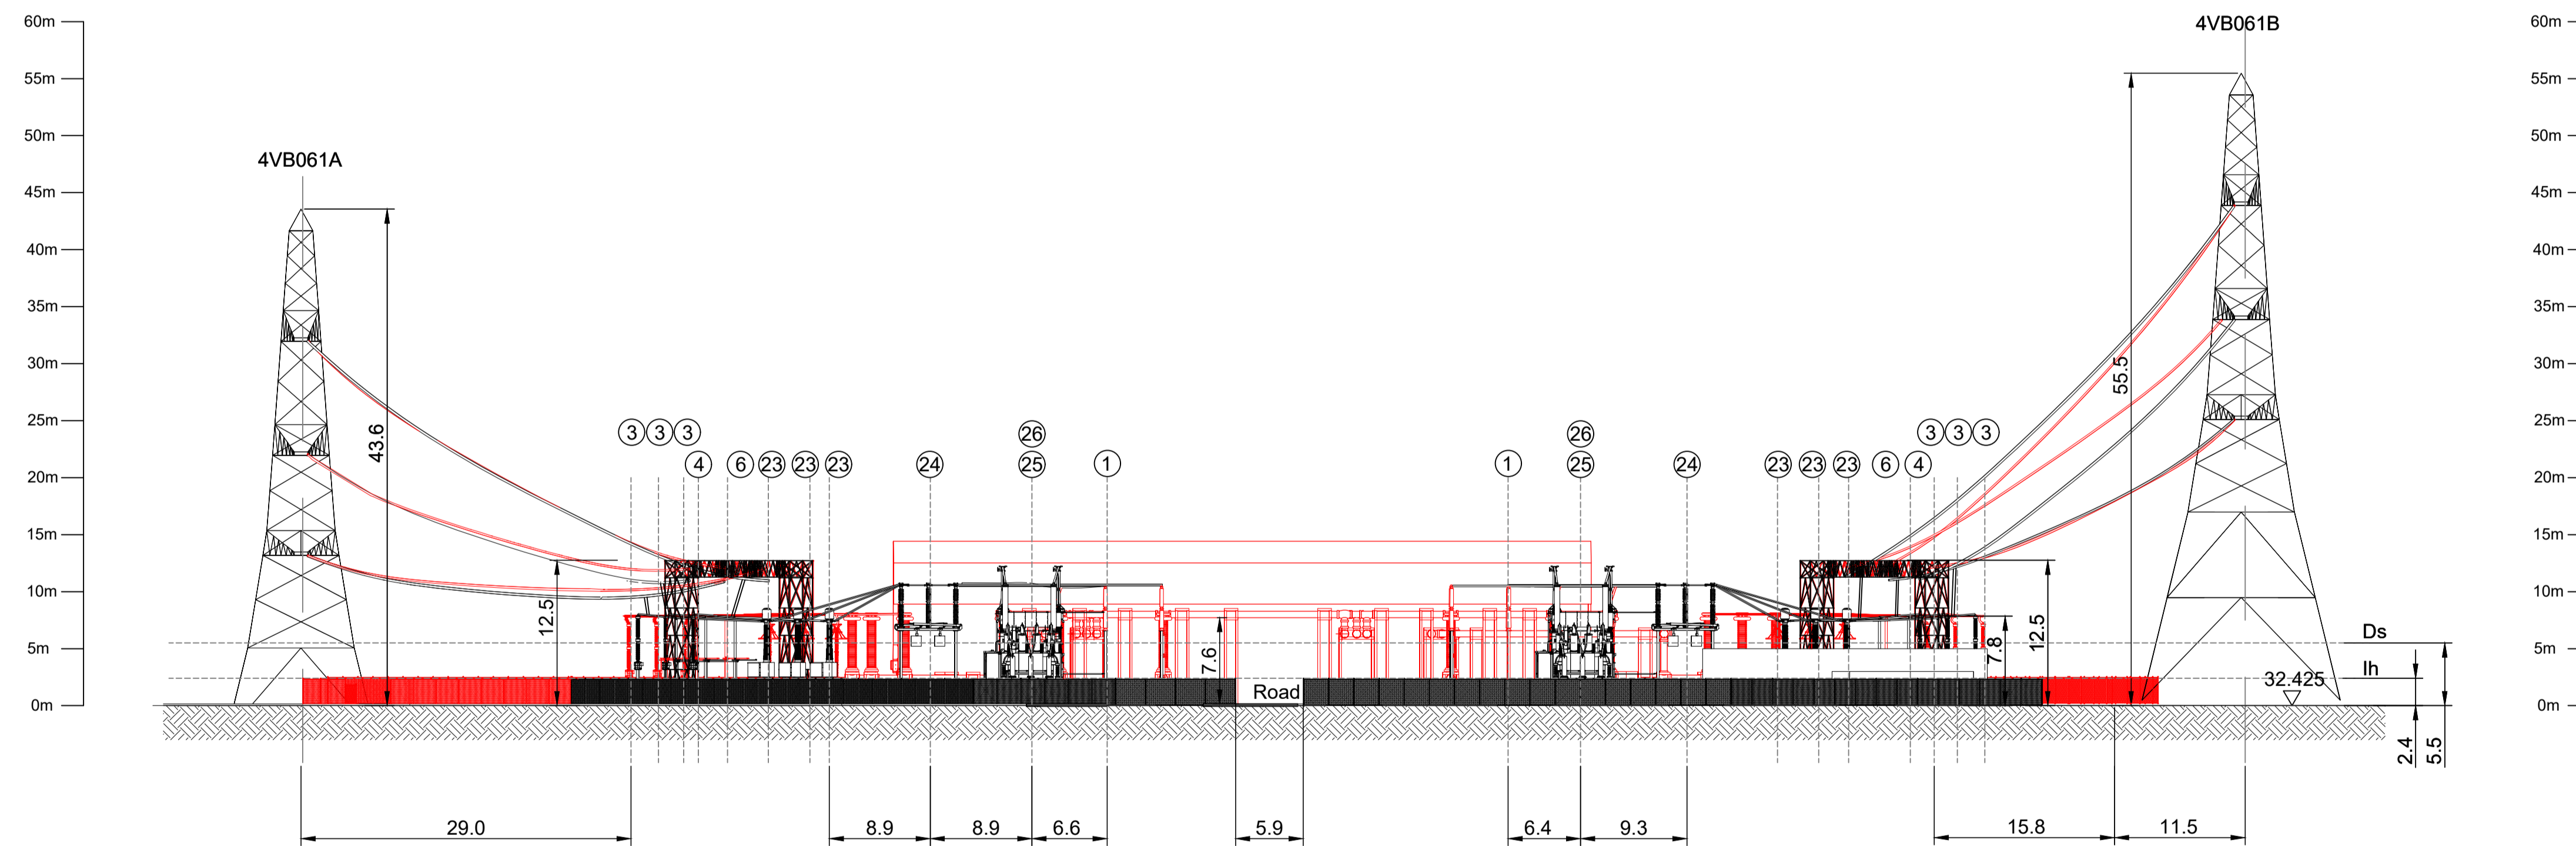

ELEVATION ON E-E

REF	DESCRIPTION
1	400kV SINGLE PHASE POST INSULATOR
2	CABLE SEALING END
3	400kV CAPACITIVE VOLTAGE TRANSFORMER
4	400kV EARTHING SWITCH
5	400kV SURGE ARRESTOR
6	LANDING GANTRY
7	400kV GIB BUSHINGS
8	GIS SUPPORT
9	GIS/AIS CABLE SEALING END
10	GIS BUILDING
11	SF6 BOTTLE STORAGE AREA

REF	DESCRIPTION
12	SF6 WASH DOWN AREA
13	CONTROL ROOM/PERMIT
14	RELAY ROOM
15	TELECOMS ROOM
16	LVAC ROOM
17	BATTERY ROOM
18	MOBILE DG PARKING AREA
19	DIESEL GENERATOR
20	HEIGHT BARRIER
21	LONGFIELD PORTABLE RELAY ROOM
22	OFFICE AREA

REF	DESCRIPTION
23	400kV LOW LEVEL CURRENT TRANSFORMER
24	400kV HIGH LEVEL RCP DISCONNECTOR
25	400/25kV TRACTION TRANSFORMER
26	400kV HIGH LEVEL FREE STANDING EARTH SWITCH 2 Phase
27	400kV LOW LEVEL POST INSULATOR
28	400kV LOW LEVEL FREE STANDING EARTH SWITCH 2 Phase
29	400kV LIVE TANK DISCONNECTING CIRCUIT BREAKER
30	25kV LOW LEVEL SURGE ARRESTOR
31	25kV LOW LEVEL CURRENT TRANSFORMER
32	25kV LOW LEVEL CAPACITOR VOLTAGE TRANSFORMER
33	72.5kV LOW LEVEL RCP DISCONNECTOR

REF	DESCRIPTION
34	25kV LOW LEVEL CABLE SEALING END
35	CAR PARKING

MINIMUM SUBSTATION ELECTRICAL CLEARANCES TO NGTS 2.1 FOR 400 kV	
P-E PHASE TO EARTH	2800mm
P-P PHASE TO PHASE	3600mm
MINIMUM SUBSTATION SAFETY CLEARANCES TO NGTS 2.1	
lh INSULATION HEIGHT	2400mm
Sd SAFETY DISTANCE	3100mm
Ds DESIGN SAFETY CLEARANCE	5500mm
Dsh DESIGN SAFETY CLEARANCE (Horizontal)	4600mm
Db DESIGN CLEARANCE FOR MEWP OPERATION	7500mm
Da DESIGN CLEARANCE MEWP OPERATION (Horizontal)	6600mm
MINIMUM HEIGHT OF CONDUCTORS ABOVE SUBSTATION ROADWAYS TO ELECTRICITY SUPPLY REGULATIONS 1988	7300mm

IT IS GENERAL PRACTICE, WHERE POSSIBLE, TO APPLY THE VERTICAL DESIGN CLEARANCE D<sub>s</sub> IN ALL DIRECTIONS

NOTES

 
- SUBSTATION HAZARD PLAN SHALL BE FOLLOWED DURING ALL STAGES OF WORK.
- GIS SUPPORTS SHOWN FOR INDICATION PURPOSES ONLY.
- GIS EQUIPMENT TO BE NON SF6.

LEGEND

- EXISTING EQUIPMENT
- NEW EQUIPMENT

REFERENCE DRAWINGS

- PDD-100504-SLD-101 Single Line Diagram
- PDD-100504-ELE-102 Substation Elevations West
- PDD-100504-ELE-103 Substation Elevations South
- PDD-100504-ELE-104 Substation Elevations North
- PDD-100504-LAY-105 Layout Plan



ILLUSTRATIVE DRAWING

Rev	Description	Cre'd	Ch'kd	App'd	Date
P05	Environmental Statement * APFP Regulation: 5(2)(a) *			JK HC AC	02/02/22
P04	Issued for DCO			JK HC AC	17/12/21
P03	Revised after DA and NG Comments			JK HC AC	24/11/21
P02	Preliminary Issue			JK HC AC	10/09/21
P01	Preliminary Issue	EW	HC	AC	03/09/2021

**nationalgrid**

Investment No: 100504	Project No: 201083	Site: Bulls Lodge
Investment Name: Longfield Solar Farm Connection		

Document Title: Bulls Lodge Substation Extension Elevations East					
Created by: E.Wren	Date: 25/08/2021	Checked by: H.Conceicao	Date: 25/08/2021	Approved by: A.Coffey	Date: 25/08/2021
Development Eng: S.Stoyanov	Document Type: DWG	Scale: 1:400	Format: A1	Sheet(s): 1	Rev: P05

National Grid Document Number: PDD-100504-ELE-101	Figure Number: Figure 2-39
FEED Document Number: 422215-MMD-00-XX-DR-E-0103	PINS Ref: EN010118

© Mott MacDonald  
This document is issued for the party which commissioned it and for specific purposes connected with the captioned project only. It should not be relied upon by any other party or used for any other purpose. We accept no responsibility for the consequences of this document being relied upon by any other party, or being used for any other purpose, or containing any error or omission which is due to an error or omission in data supplied to us by other parties.