
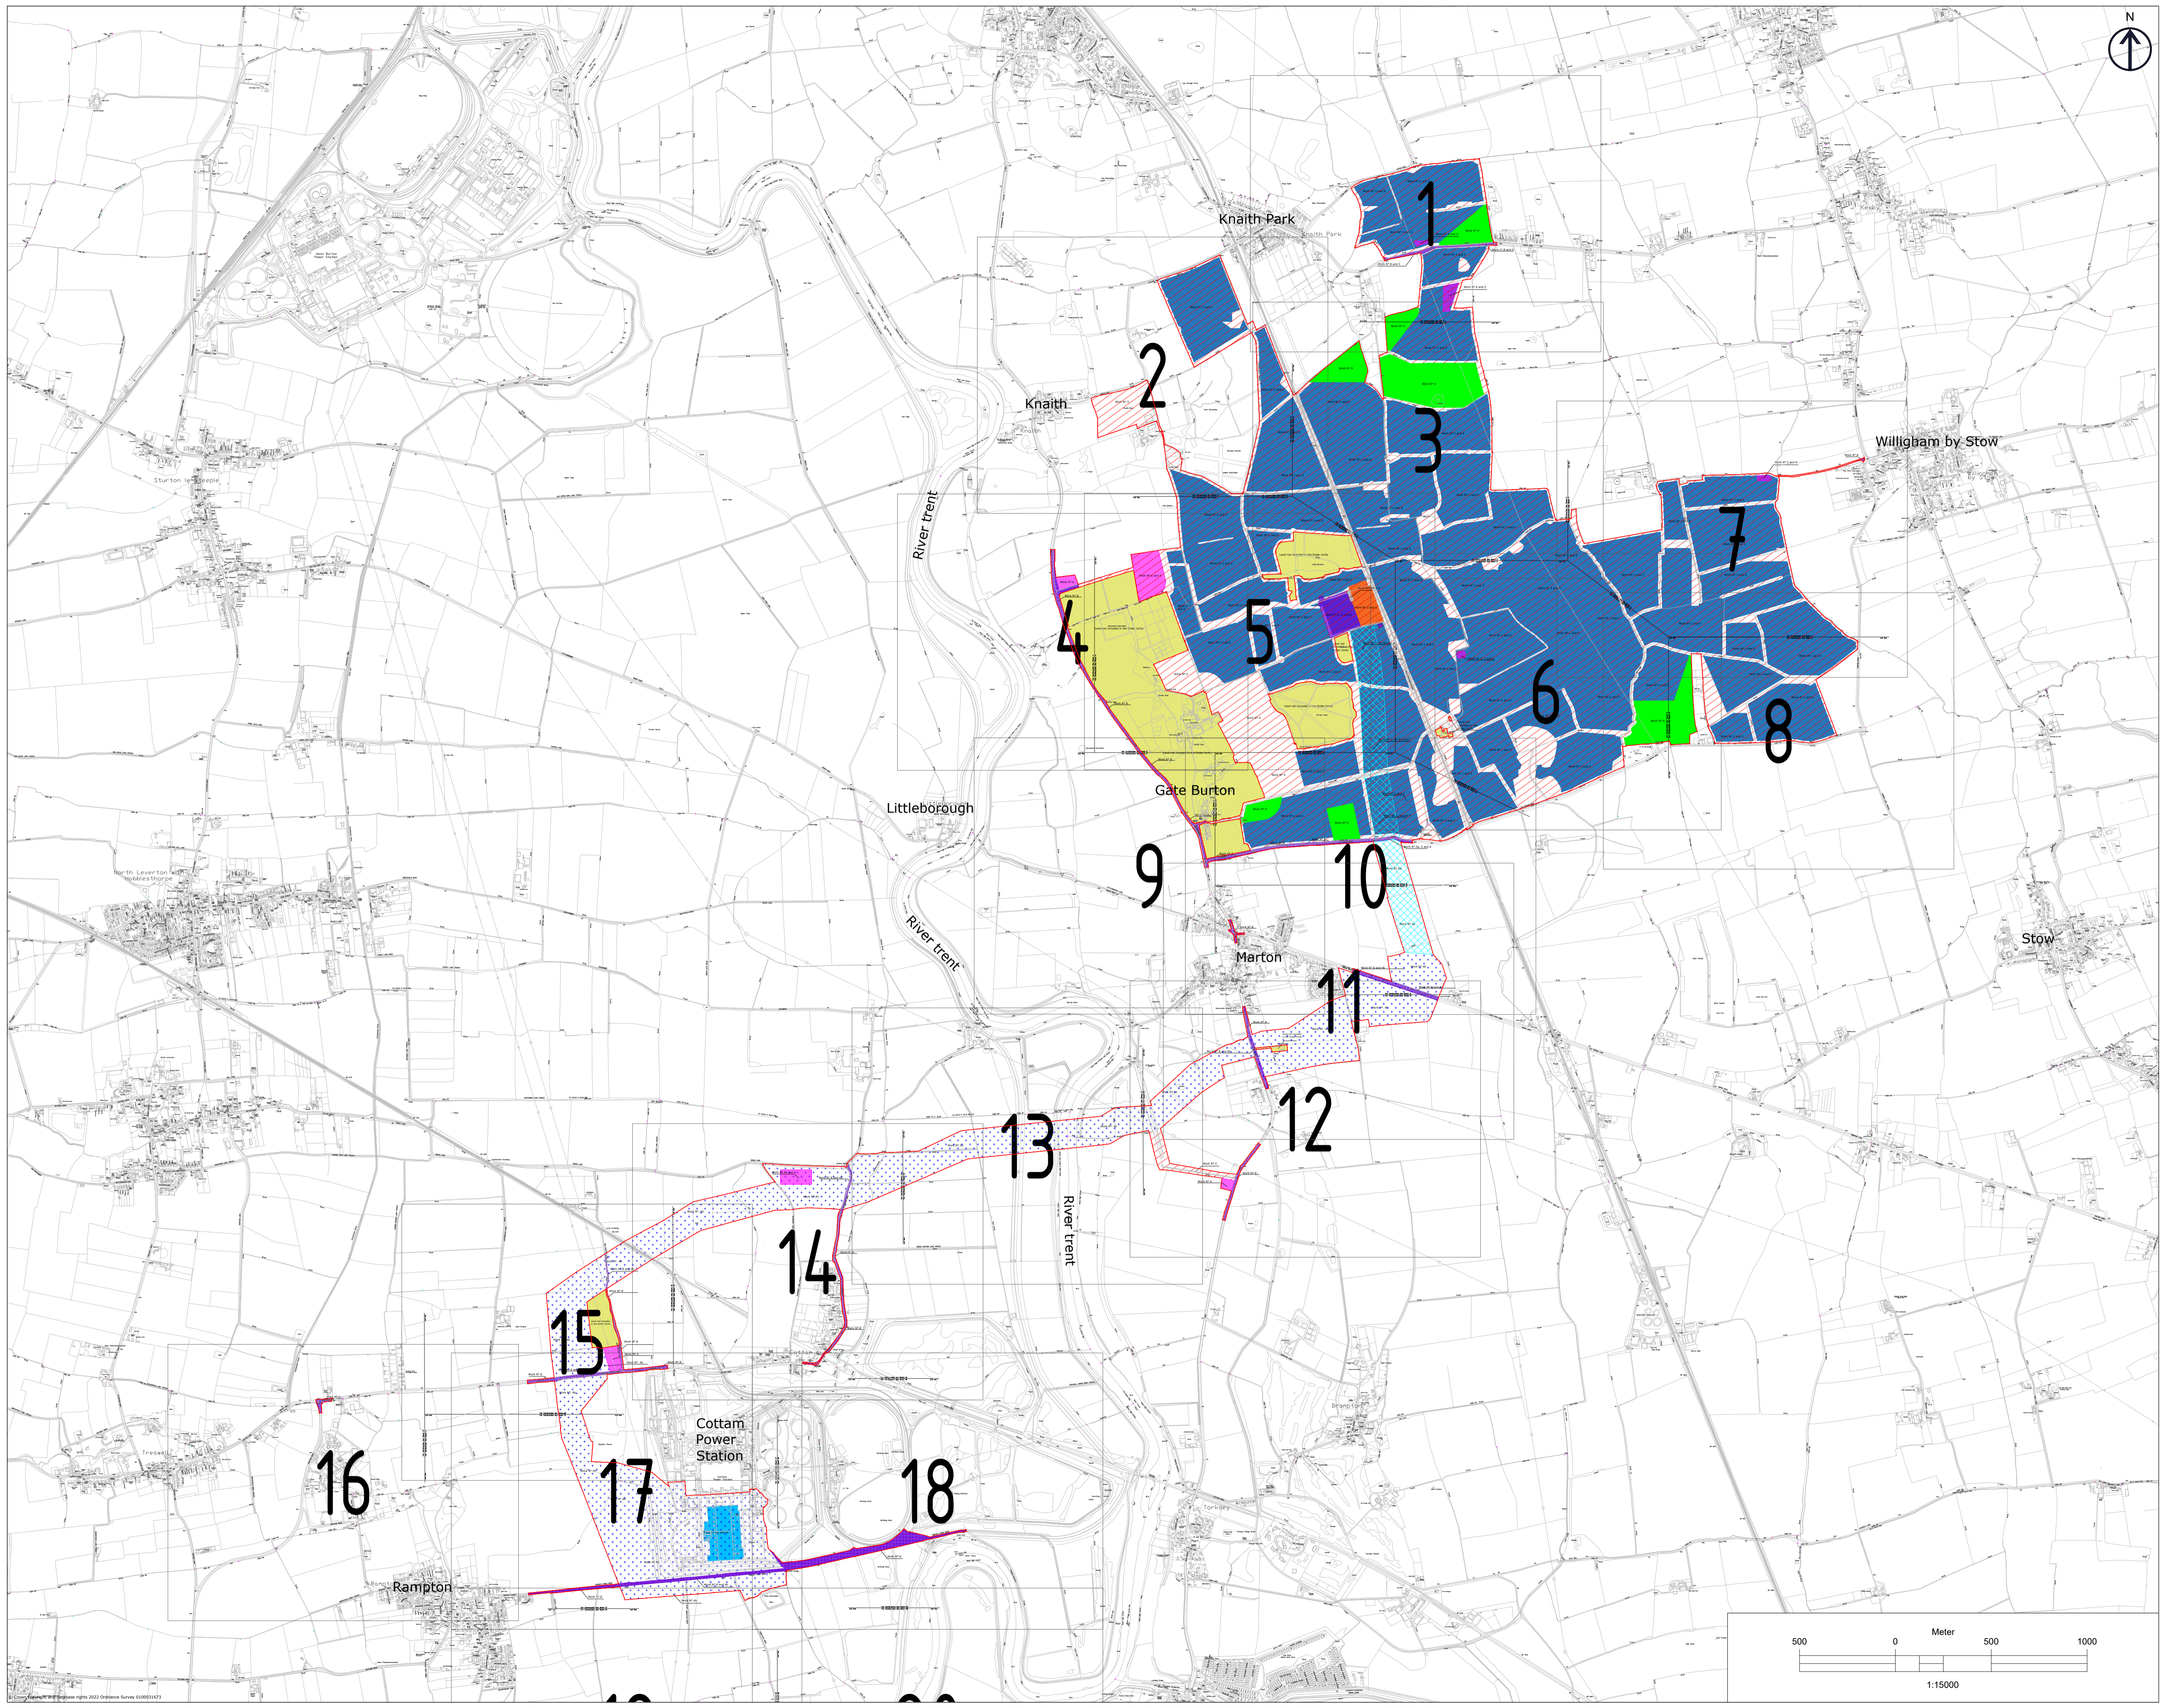


Gate Burton Energy Park EN010131

Works Plan (**Change Request Version**) Rev.4
Document Reference: EN010131/APP/5.2
October 2023

Regulation 5(j)
Infrastructure Planning (Applications: Prescribed Forms and Procedure) Regulations 2009

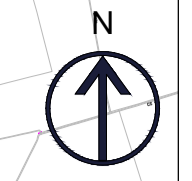




LEGEND

- Work No.1
- Work No.2
- Work No.3
- Work No.4a
- Work No.4b
- Work No.4c
- Work No.5
- Work No.6
- Work No.7
- Work No.8
- Work No.9
- Land not included in the Order limits


1. THIS DRAWING IS TO BE READ IN CONJUNCTION WITH ALL OTHER RELEVANT DOCUMENTATION.
2. ALL DIMENSIONS, COORDINATES, LEVELS AND CONTROLS ARE IN METRES UNLESS OTHERWISE SPECIFIED.
3. THE WORKS ARE SUBJECT TO CHANGE THROUGH DETAILED DESIGN IN ACCORDANCE WITH THE TERMS OF THE DEVELOPMENT CONSENT GRANT.

Index	Date	Changes	Writer	Checker
A	19/01/23	Original	ABO	GDA
B	07/03/23	S51 advice update	ABO	GDA
C	03/10/23	Update for Deadline4	ABO	GDA

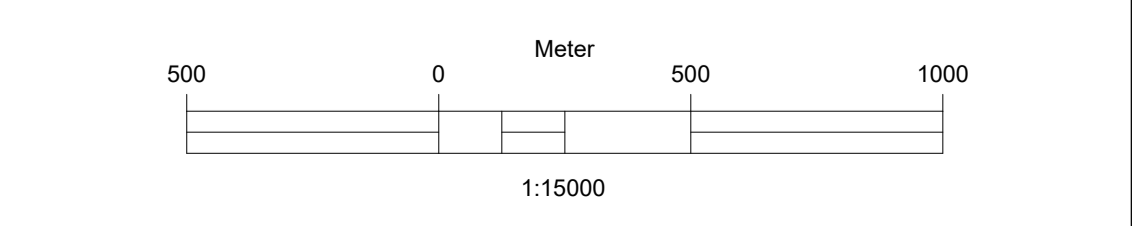

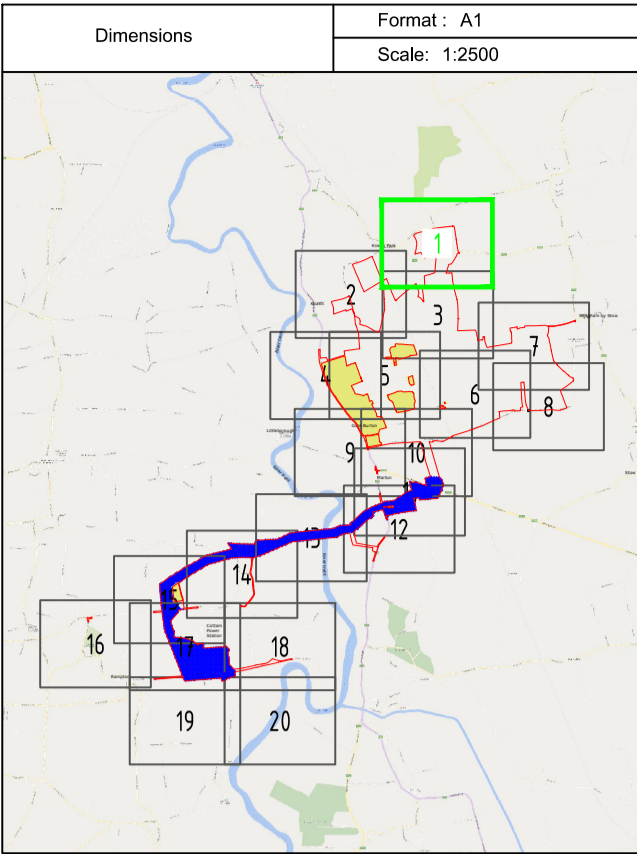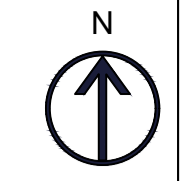


 


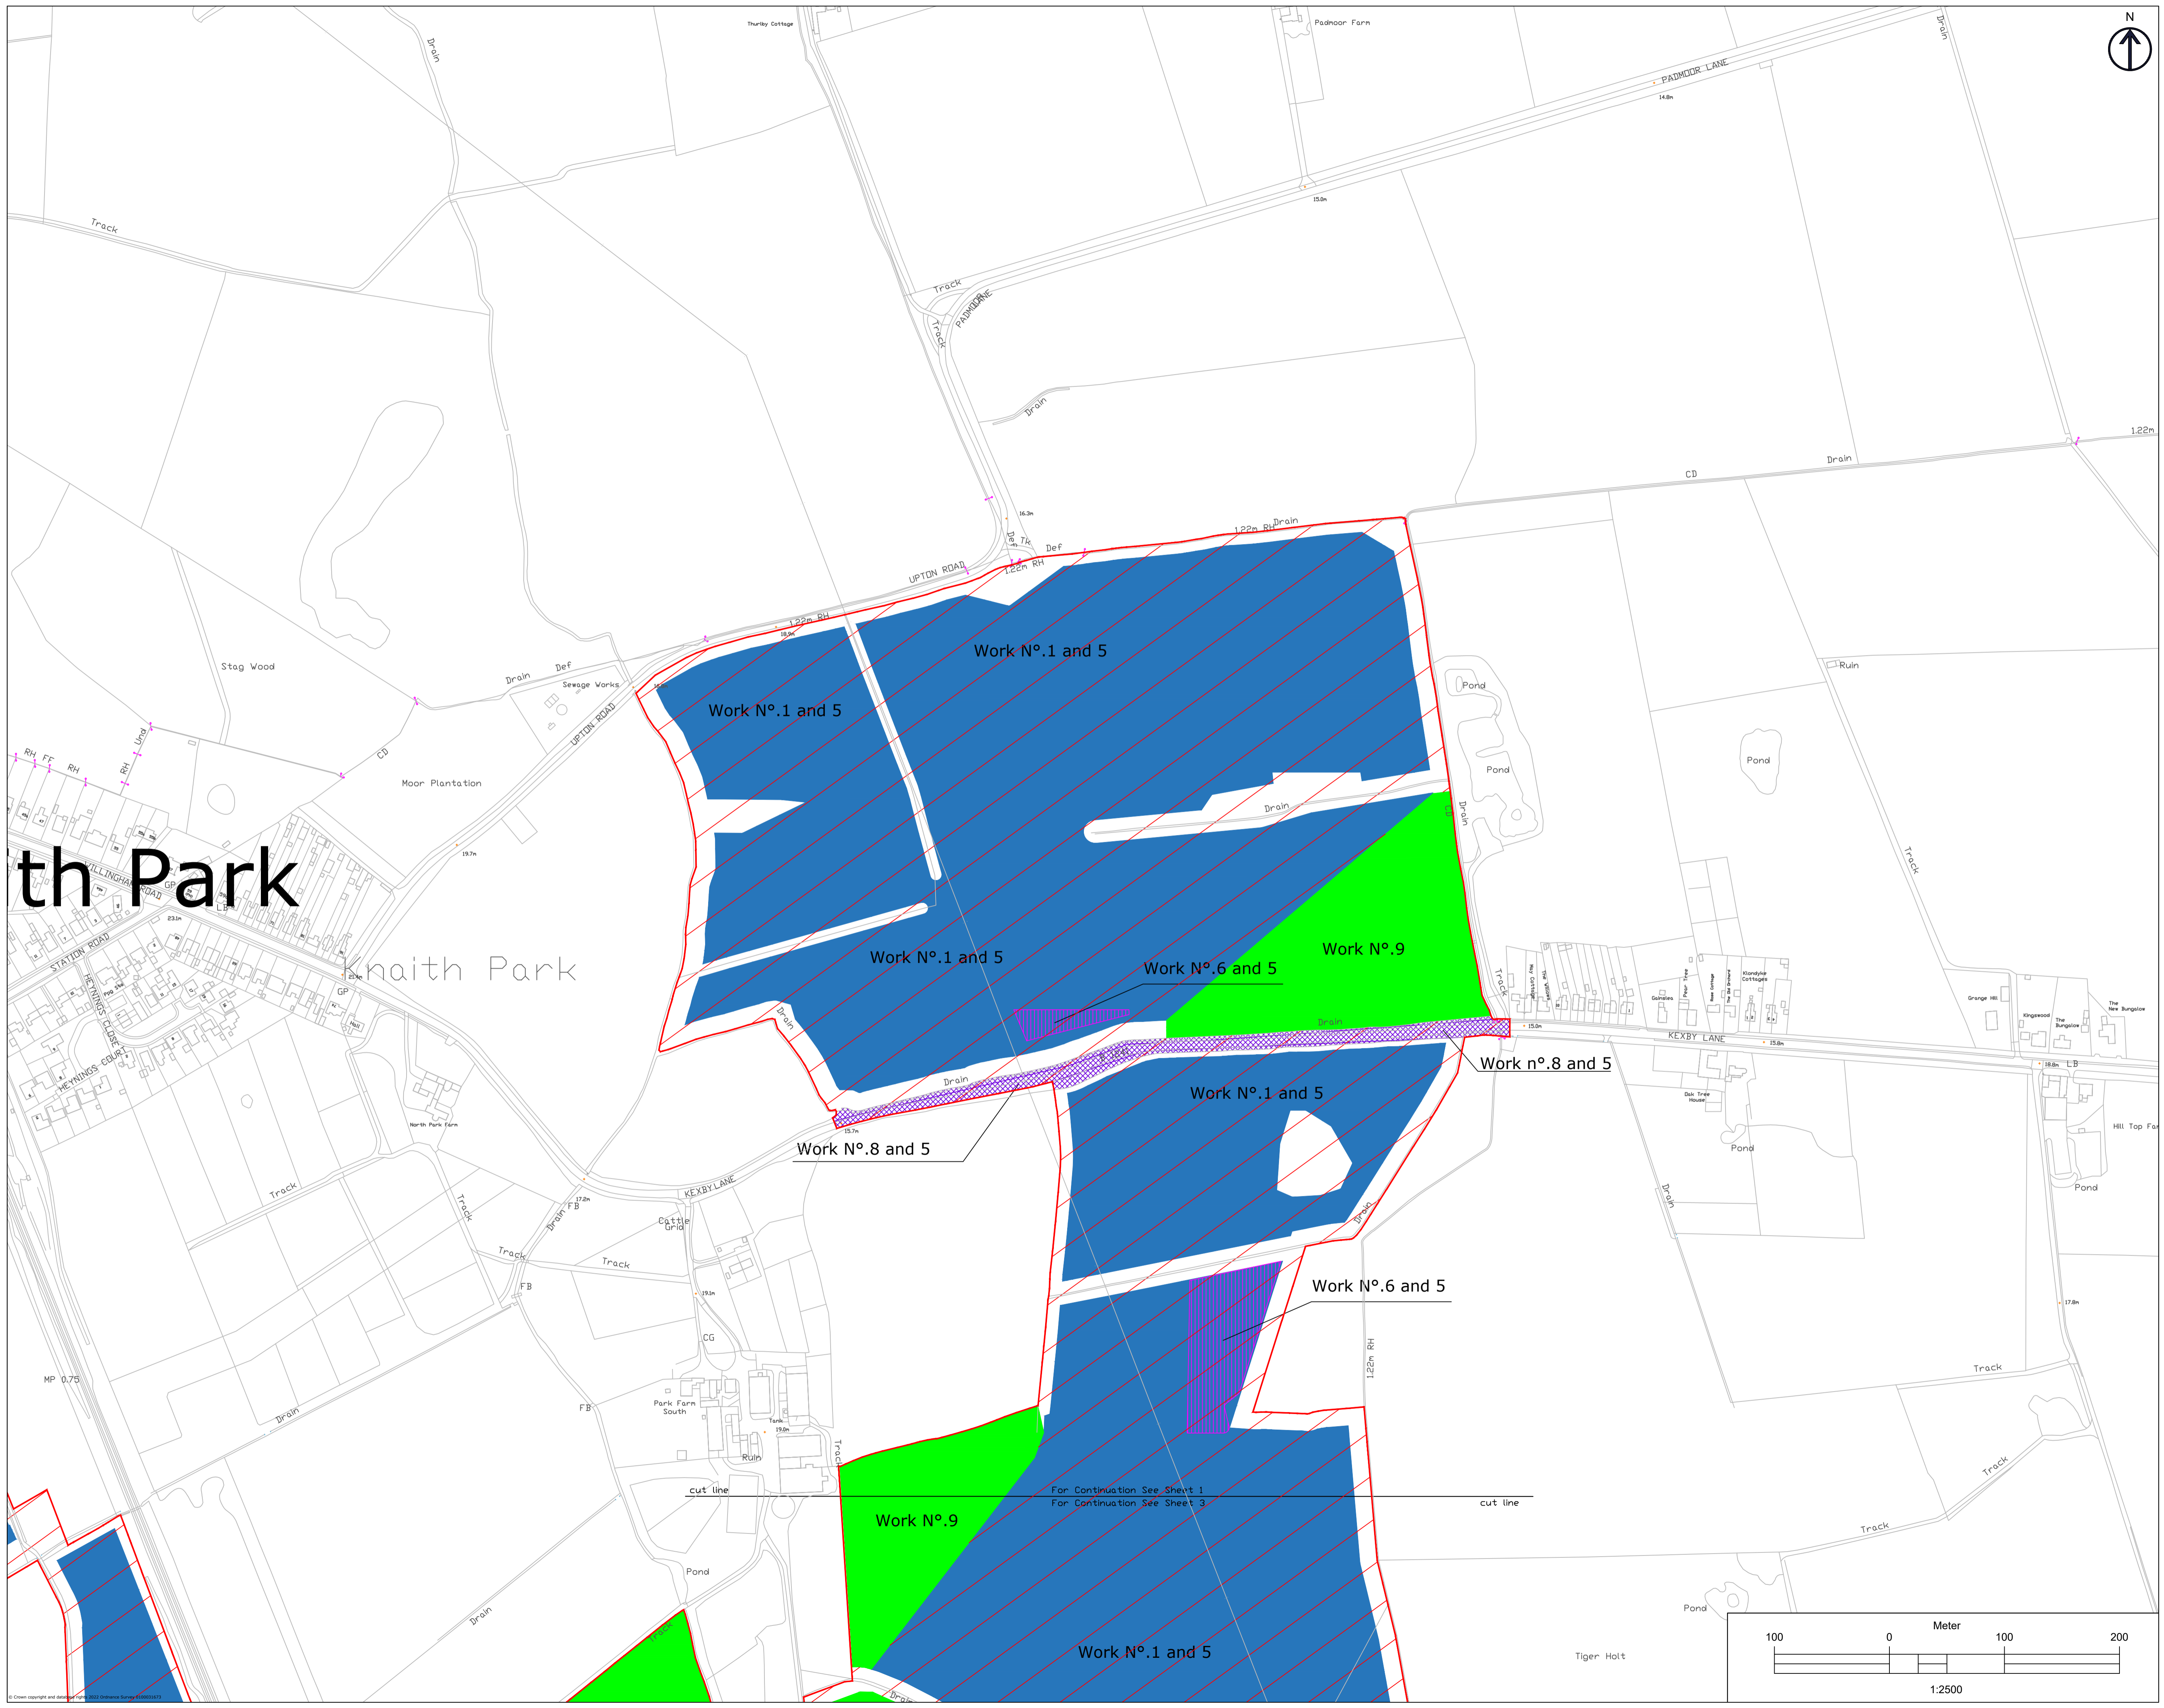







Dimensions	Format: A1
	Scale: 1:2500

 

th Park

 
naith Park


LEGEND

-  Work No.1
-  Work No.2
-  Work No.3
-  Work No.4a
-  Work No.4b
-  Work No.4c
-  Work No.5
-  Work No.6
-  Work No.7
-  Work No.8
-  Work No.9
-  Land not included in the Order limits


1. THIS DRAWING IS TO BE READ IN CONJUNCTION WITH ALL OTHER RELEVANT DOCUMENTATION.
 2. WORKS SHALL BE CONDUCTED IN ACCORDANCE WITH THE INSTRUCTIONS IN THESE SPECIFICATIONS.
 3. ALL DIMENSIONS, UNLESS OTHERWISE SPECIFIED, ARE IN METRES UNLESS OTHERWISE SPECIFIED.
 4. ALL DIMENSIONS, CORNERS, LEVELS AND COORDINATES ARE TO BE CHECKED ON SITE, AND ANY DISCREPANCIES REPORTED IMMEDIATELY TO THE PROJECT MANAGER.
 5. THE WORKER SHALL BE RESPONSIBLE FOR OBTAINING ALL NECESSARY PERMITS AND APPROVALS.
 6. THE WORKER SHALL BE RESPONSIBLE FOR OBTAINING ALL NECESSARY PERMITS AND APPROVALS.
 7. THE WORKER SHALL BE RESPONSIBLE FOR OBTAINING ALL NECESSARY PERMITS AND APPROVALS.

Index	Date	Changes	Writer	Checker
A	19/01/23	Original	ABO	GDA
B	07/03/23	SS1 advice update	ABO	GDA
C	03/10/23	Update for Deadlined	ABO	GDA

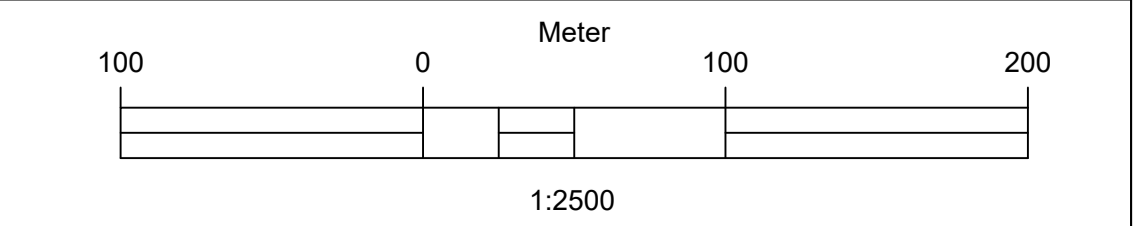

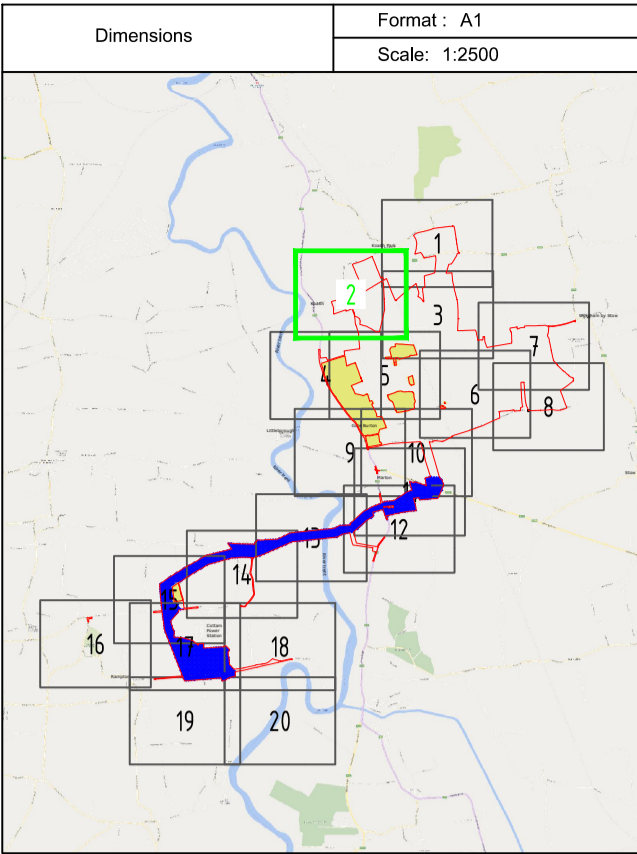

Dimensions	Format: A1
	Scale: 1:2500

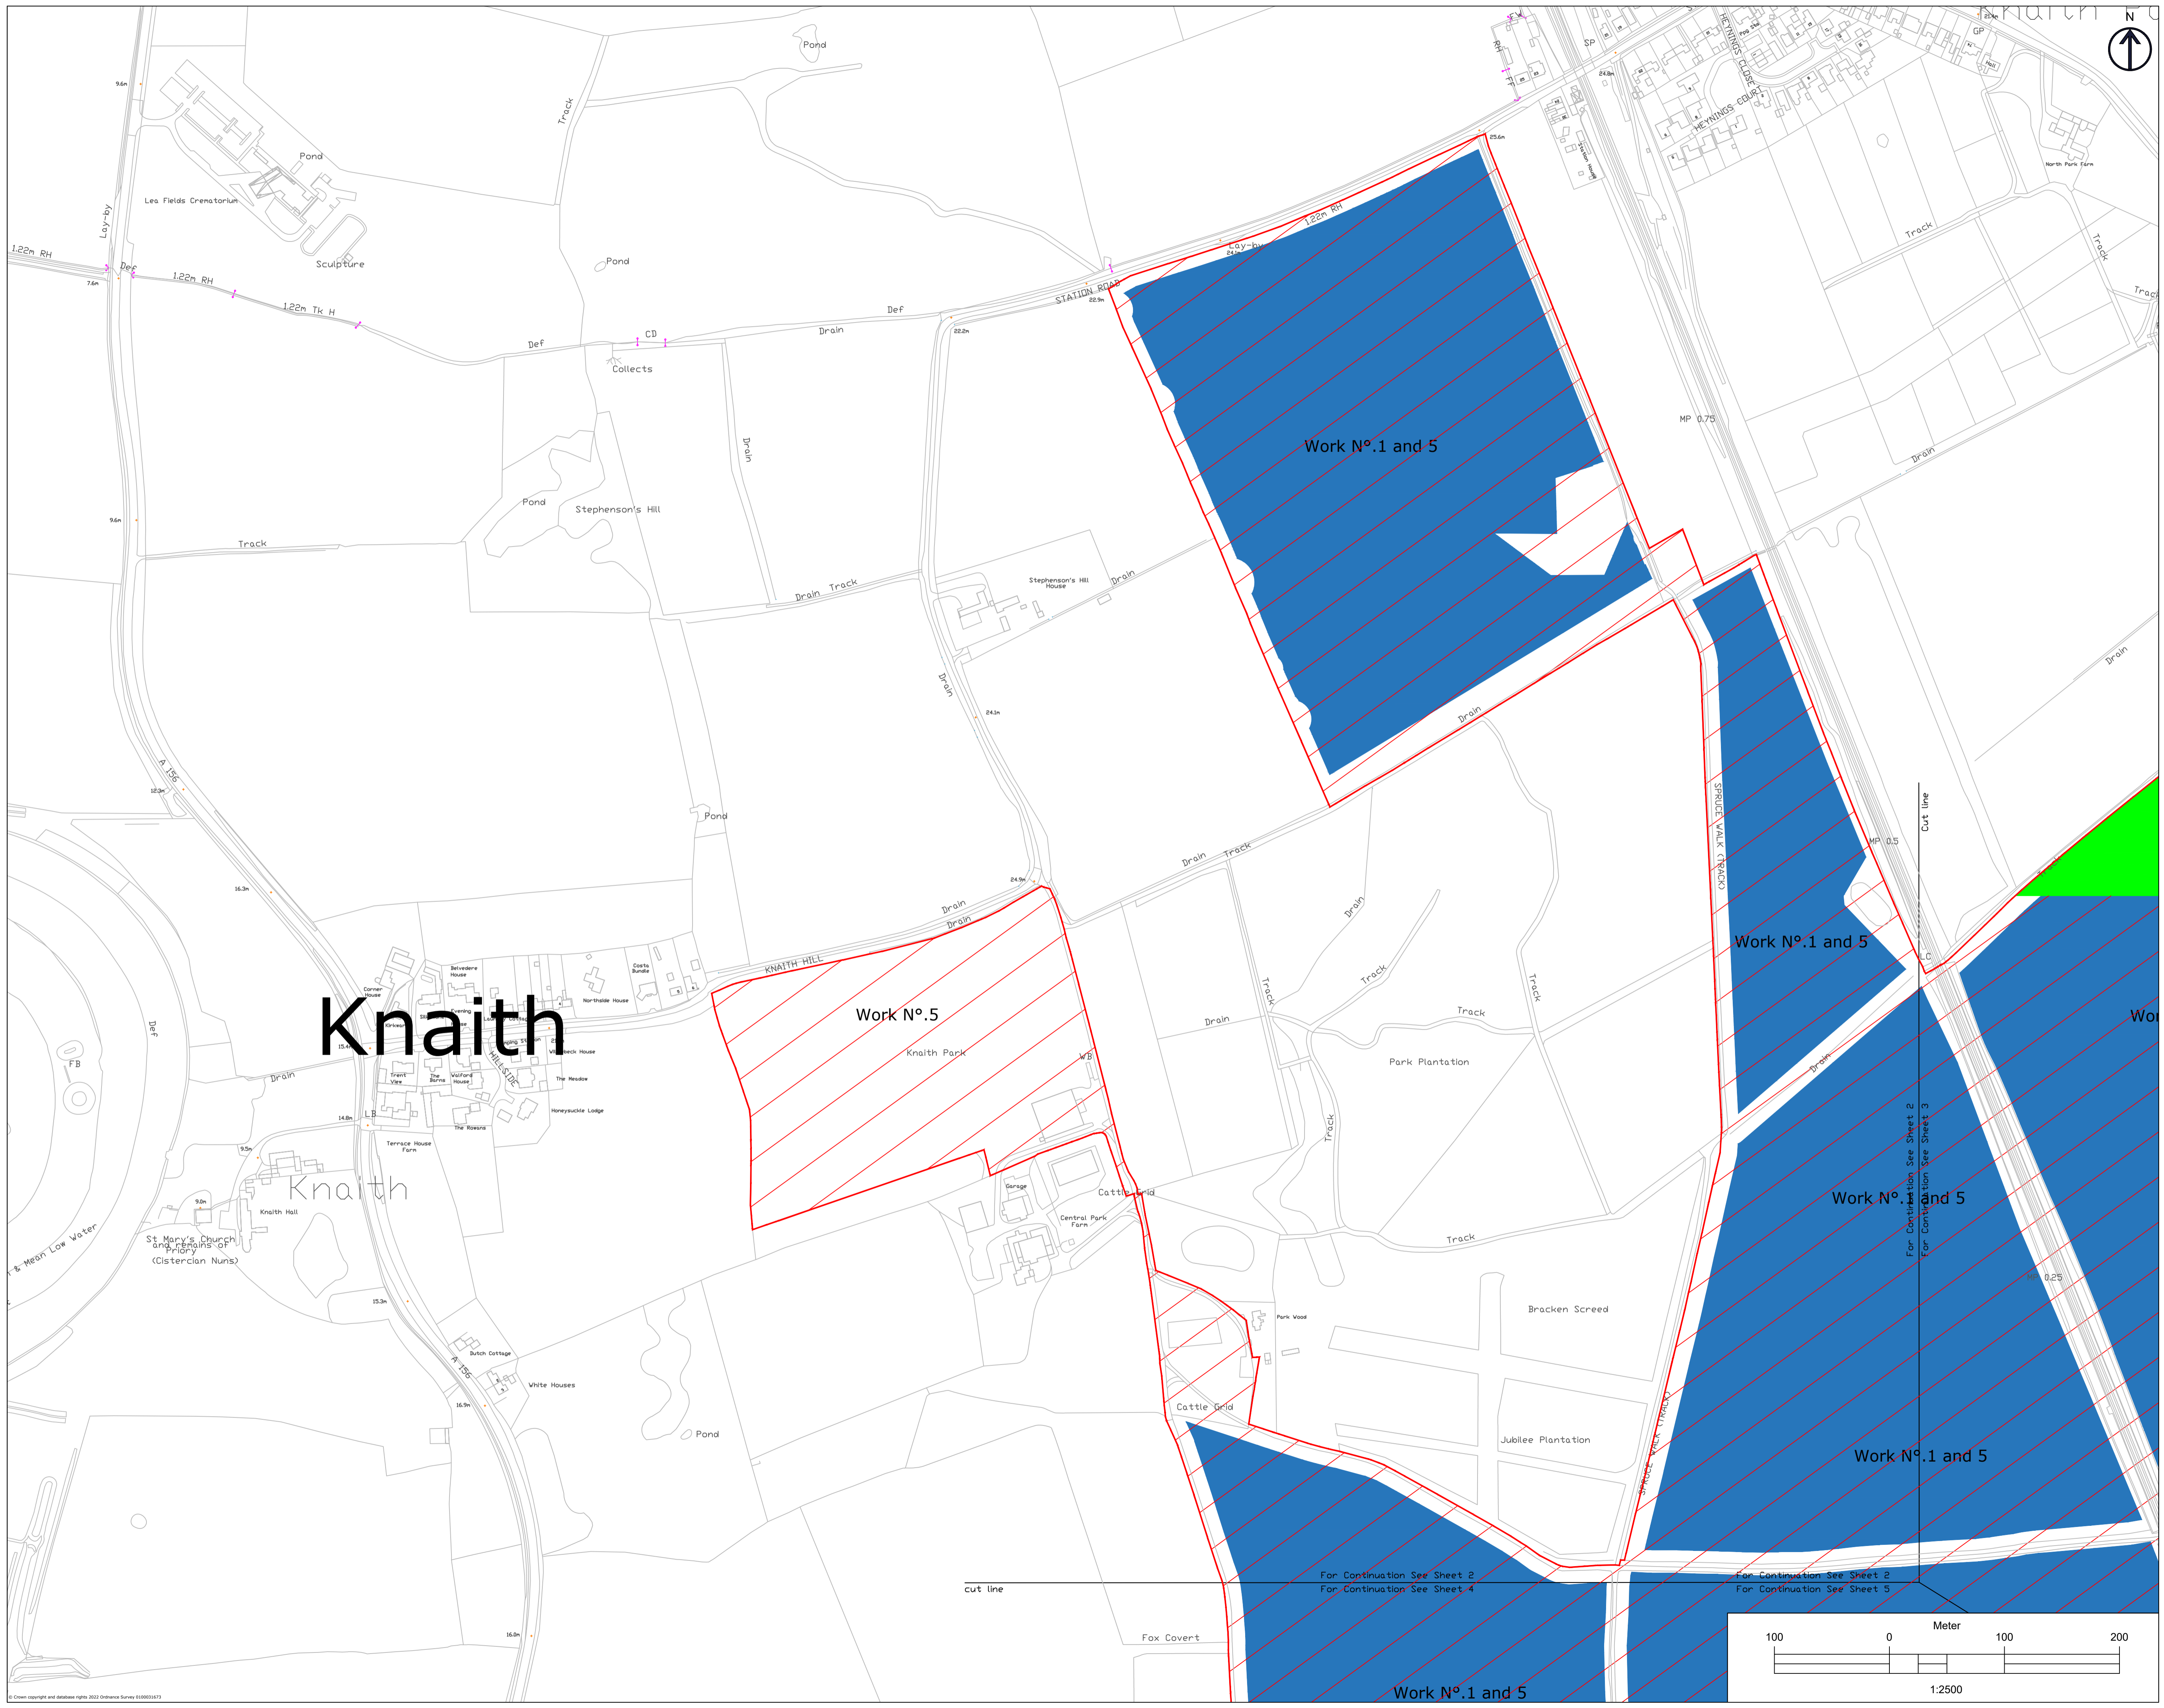


Knaiith


LEGEND

- Work No.1
- Work No.2
- Work No.3
- Work No.4a
- Work No.4b
- Work No.4c
- Work No.5
- Work No.6
- Work No.7
- Work No.8
- Work No.9
- Land not included in the Order limits

1. THIS DRAWING IS TO BE READ IN CONJUNCTION WITH ALL OTHER RELEVANT DOCUMENTATION.
2. WORKS SHALL BE IN ACCORDANCE WITH REGULATIONS AND ALL OTHER RELEVANT DOCUMENTATION.
3. ALL DIMENSIONS, COORDINATES, LEVELS AND CONDIMENTS ARE IN METRES UNLESS OTHERWISE SPECIFIED.
4. THE WORKER SHALL BE RESPONSIBLE FOR CHECKING THE POSITION OF ALL WORK POINTS TO BE CHECKED ON SITE, AND ANY DISCREPANCIES SHALL BE REPORTED TO SKYRAY ENGINEERING LTD IMMEDIATELY UPON DISCOVERY.
5. THE WORKER SHALL BE RESPONSIBLE FOR CHECKING THE POSITION OF ALL WORK POINTS TO BE CHECKED ON SITE, AND ANY DISCREPANCIES SHALL BE REPORTED TO SKYRAY ENGINEERING LTD IMMEDIATELY UPON DISCOVERY.

Index	Date	Changes	Writer	Checker
A	19/01/23	Original	ABO	GDA
B	07/03/23	SS1 advice update	ABO	GDA
C	03/10/23	Update for Deadline	ABO	GDA

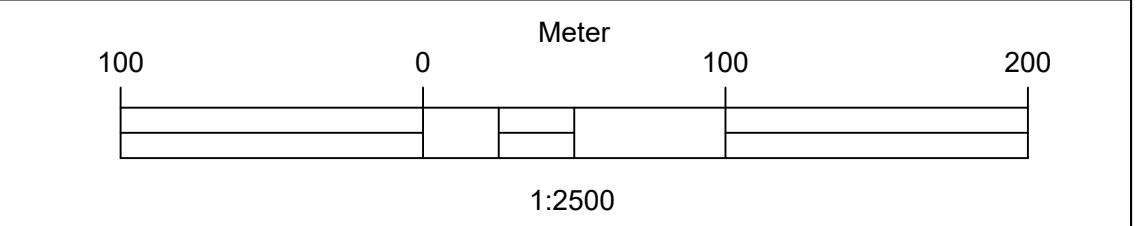

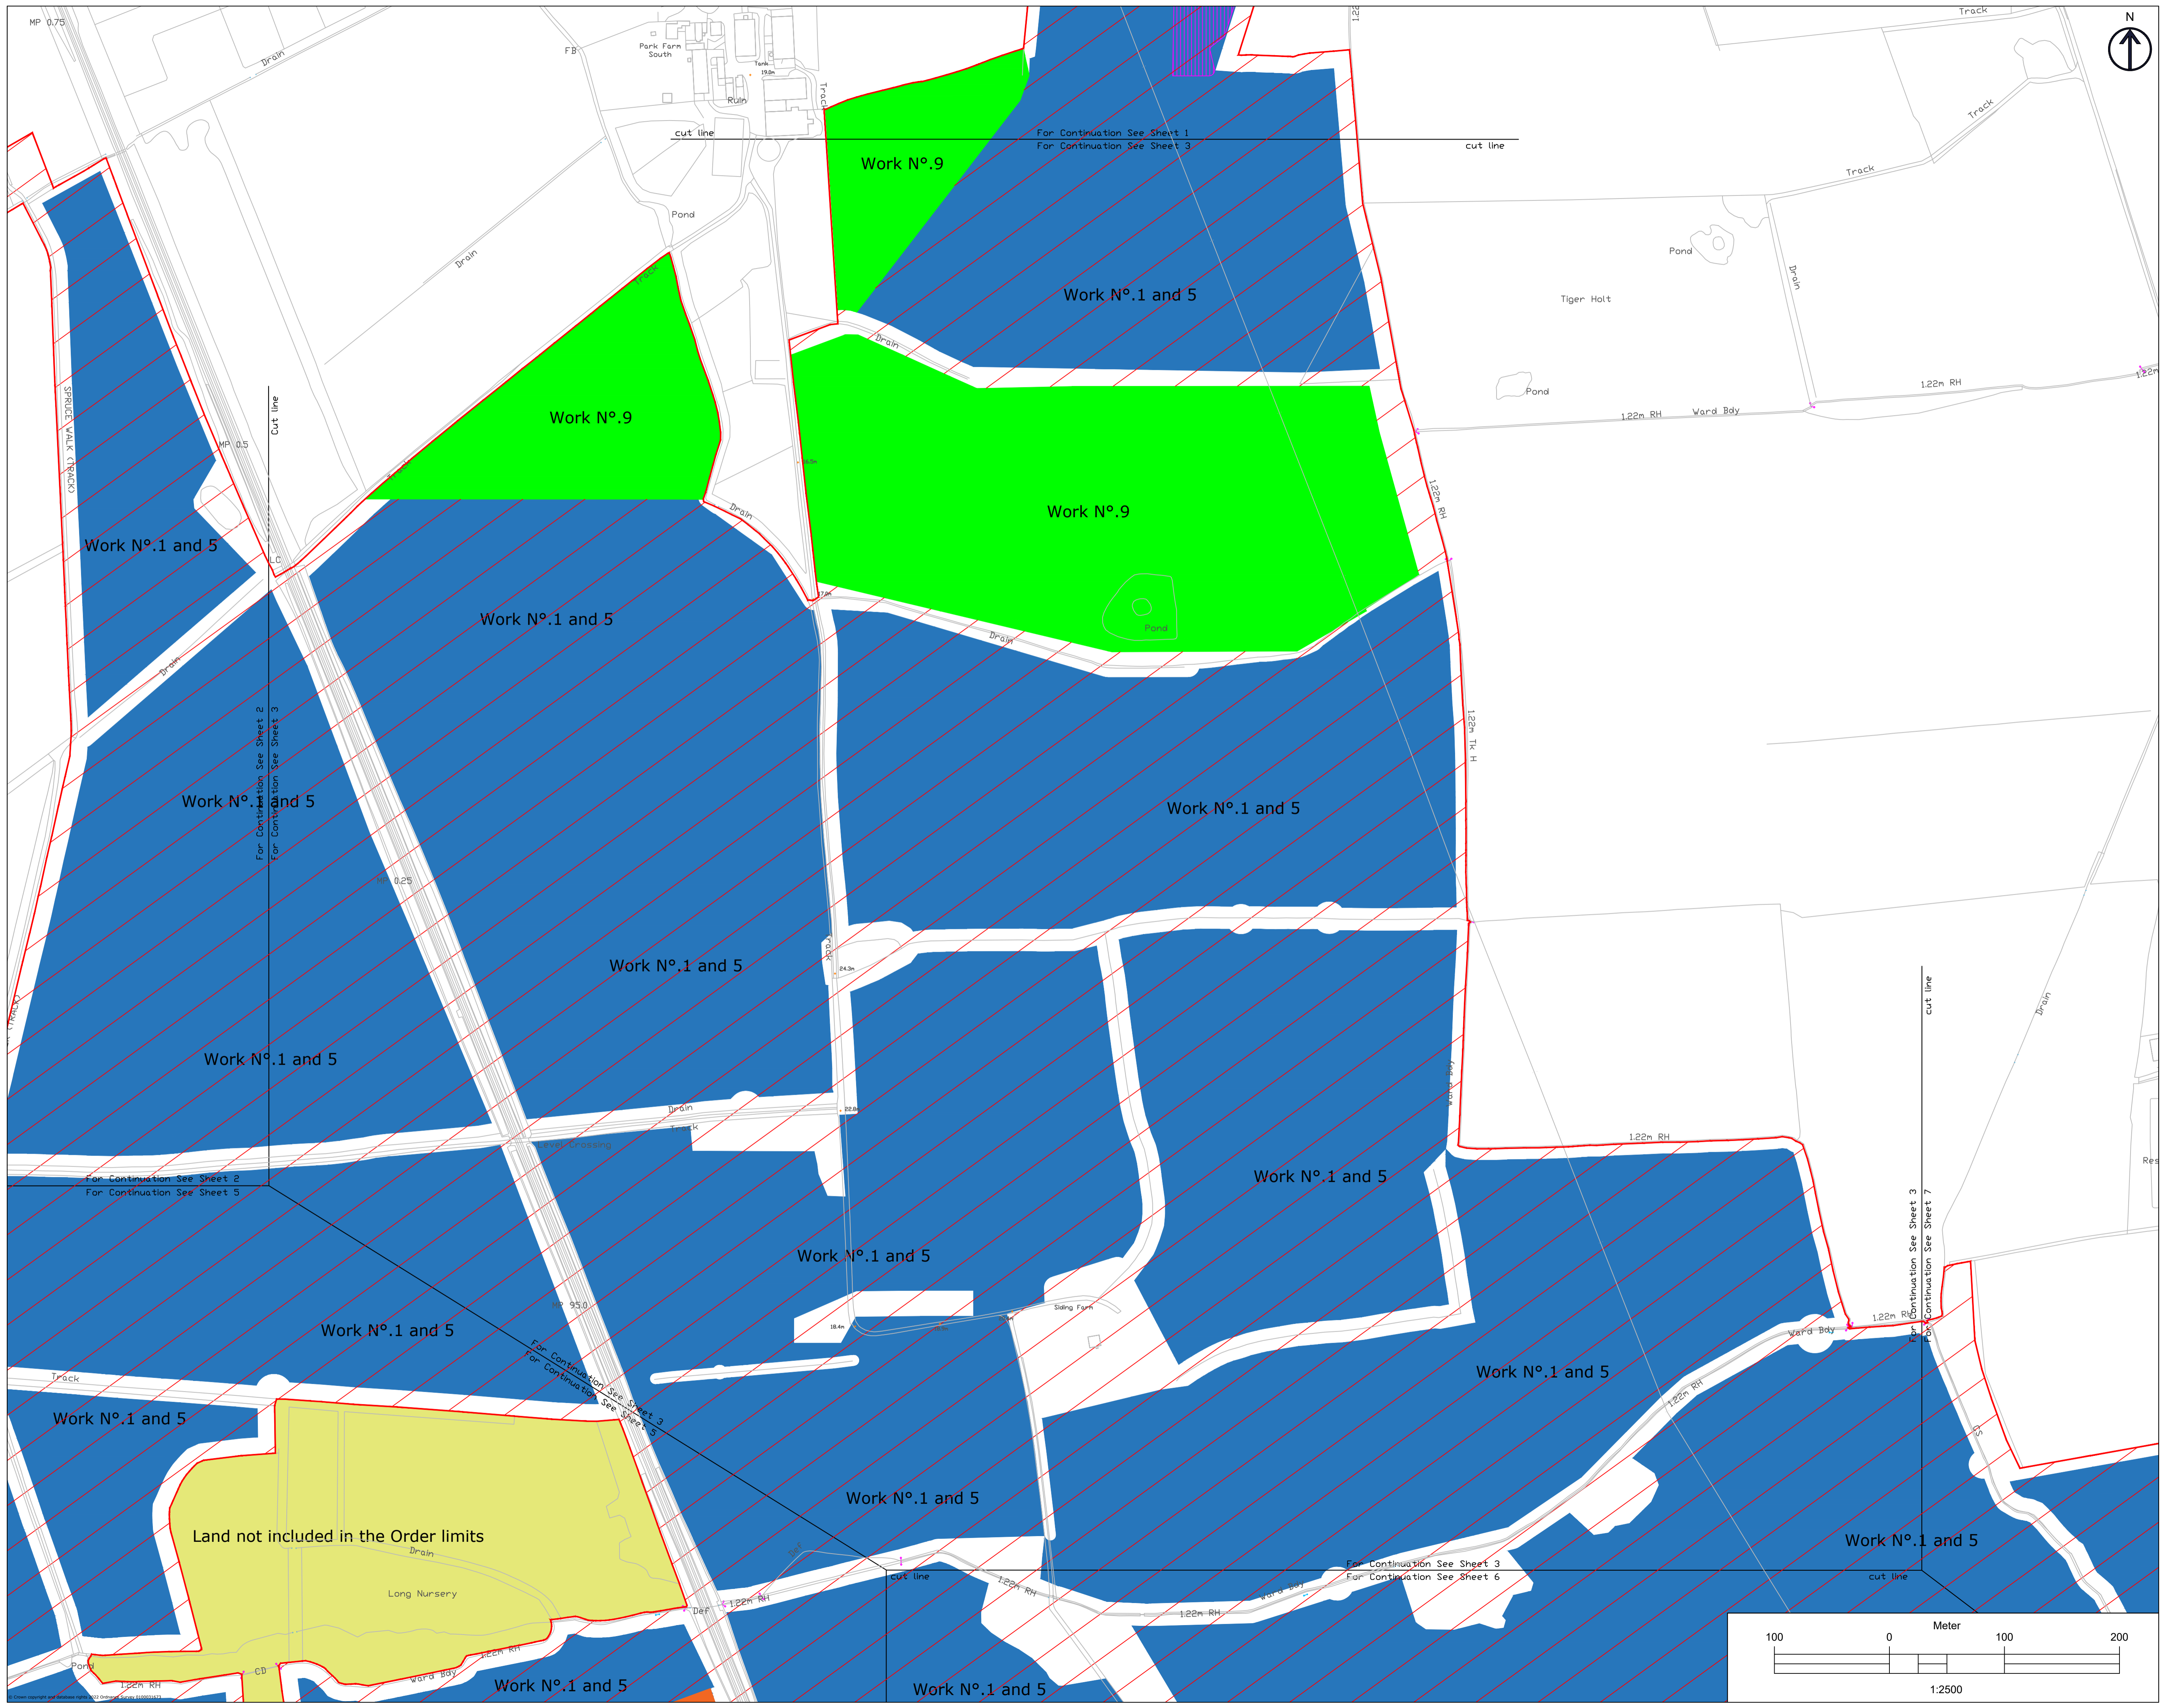


LEGEND

- Work No.1
- Work No.2
- Work No.3
- Work No.4a
- Work No.4b
- Work No.4c
- Work No.5
- Work No.6
- Work No.7
- Work No.8
- Work No.9
- Land not included in the Order limits

1. THIS DRAWING IS TO BE READ IN CONJUNCTION WITH ALL OTHER RELEVANT DOCUMENTATION.
 2. WORKS MUST BE ACCORDANCE WITH REGULATIONS AND THE INSTRUCTIONS IN ANY RELEVANT DOCUMENTATION.
 3. ALL OPERATIONS, CONSTRUCTION AND CONDITIONS ARE IN ACCORDANCE WITH THE INSTRUCTIONS IN ANY RELEVANT DOCUMENTATION.
 4. THE WORKS ARE SUBJECT TO CHANGE THROUGH DETAILED DESIGN IN ACCORDANCE WITH THE TERMS OF THE DEVELOPMENT CONSENT ORDER.

Index	Date	Changes	Writer	Checker
A	18/01/23	Original	ABO	GDA
B	07/03/23	SSI advice update	ABO	GDA
C	03/10/23	Update for Deadline	ABO	GDA

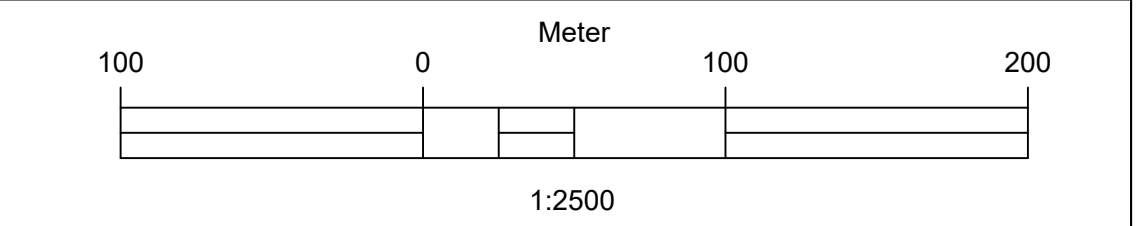


River trent

EN010131/APP/5.2
LCA-2021-01-GateBurton

Gate Burton
ENERGY PARK

Works Plans: **Sheet 04**

Dimensions: Format: A1 Scale: 1:2500

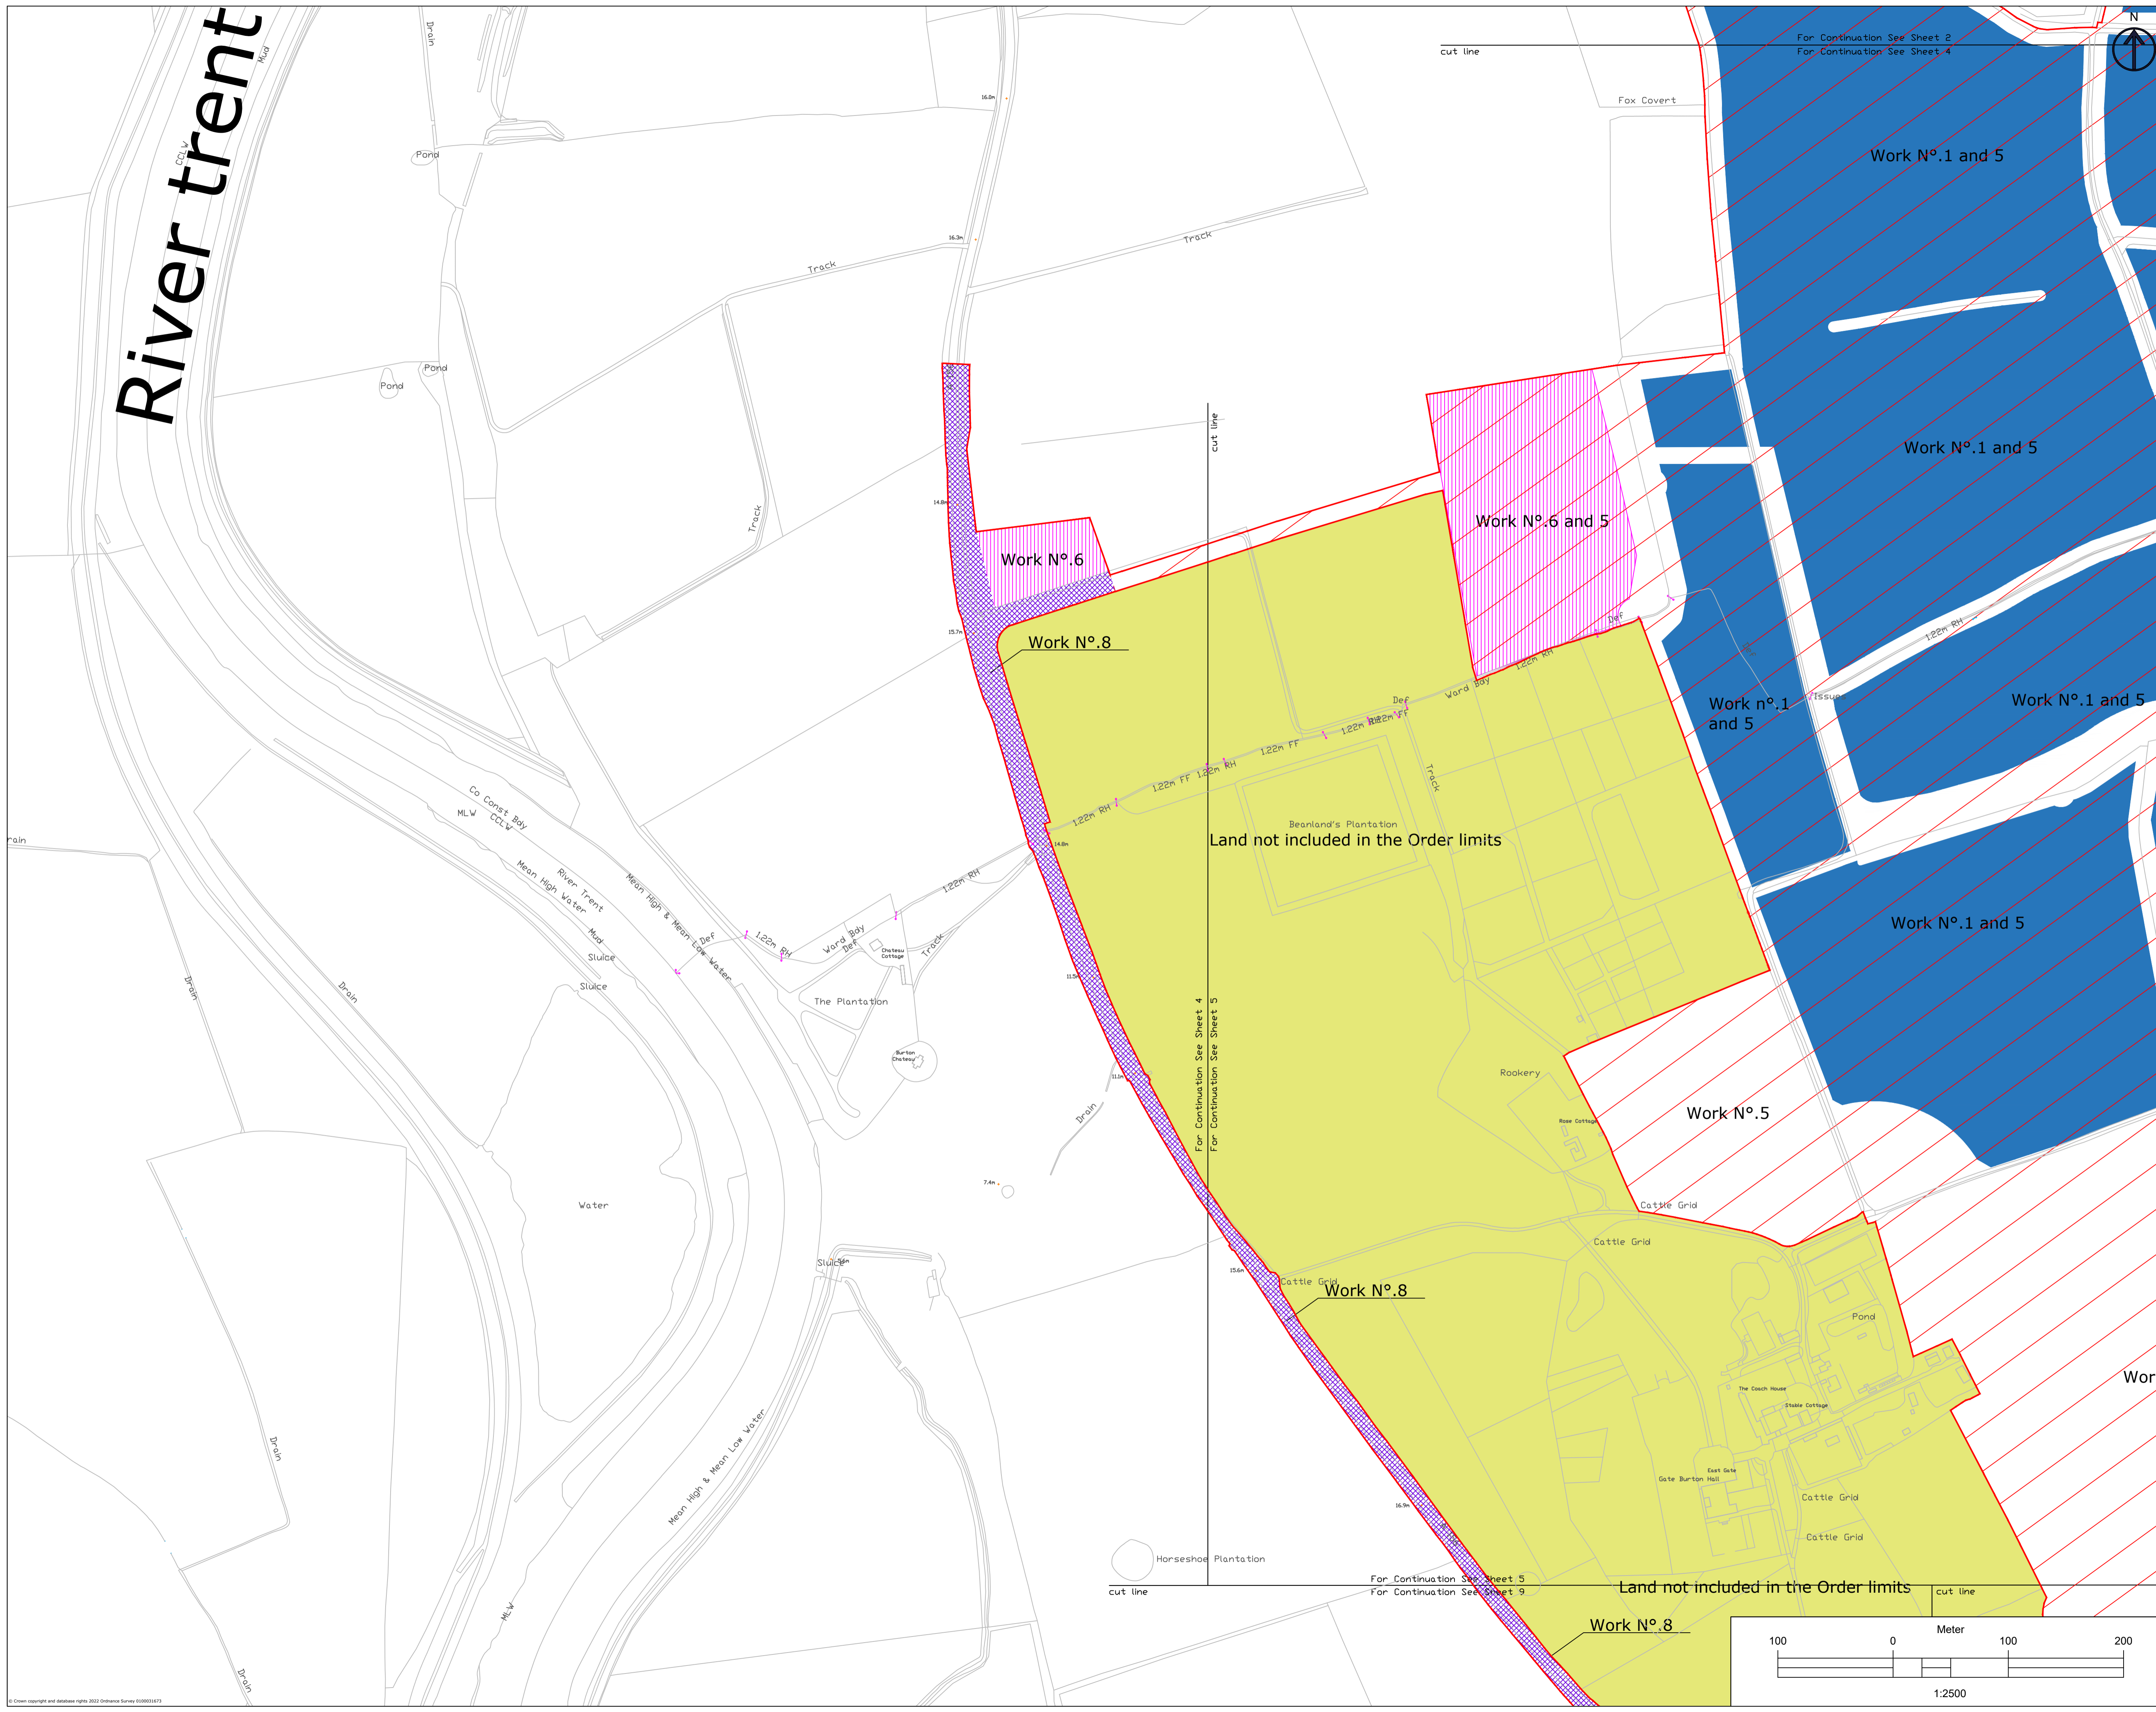



LEGEND

- Work No.1
- Work No.2
- Work No.3
- Work No.4a
- Work No.4b
- Work No.4c
- Work No.5
- Work No.6
- Work No.7
- Work No.8
- Work No.9
- Land not included in the Order limits

1. THIS DRAWING IS TO BE READ IN CONJUNCTION WITH ALL OTHER RELEVANT DOCUMENTATION.
2. WORKS MUST BE CONDUCTED IN ACCORDANCE WITH THE INSTRUCTIONS IN THESE DRAWINGS.
3. ALL DIMENSIONS, COORDINATES, LEVELS AND CORRECTIONS ARE IN METRES UNLESS SPECIFIC OTHERWISE.
4. THE WORKER SHALL BE RESPONSIBLE FOR CHECKING THE ACCURACY OF THE INFORMATION ON SITE AND ANY DISCREPANCIES SHALL BE REPORTED IMMEDIATELY TO THE PROJECT MANAGER.
5. THE WORKER SHALL BE RESPONSIBLE FOR CHECKING THE ACCURACY OF THE INFORMATION ON SITE AND ANY DISCREPANCIES SHALL BE REPORTED IMMEDIATELY TO THE PROJECT MANAGER.

Index	Date	Changes	Writer	Checker
A	19/01/23	Original	ABO	GDA
B	07/03/23	S&I advice update	ABO	GDA
C	03/10/23	Update for Deadline	ABO	GDA

100 0 100 200
Meter
1:2500

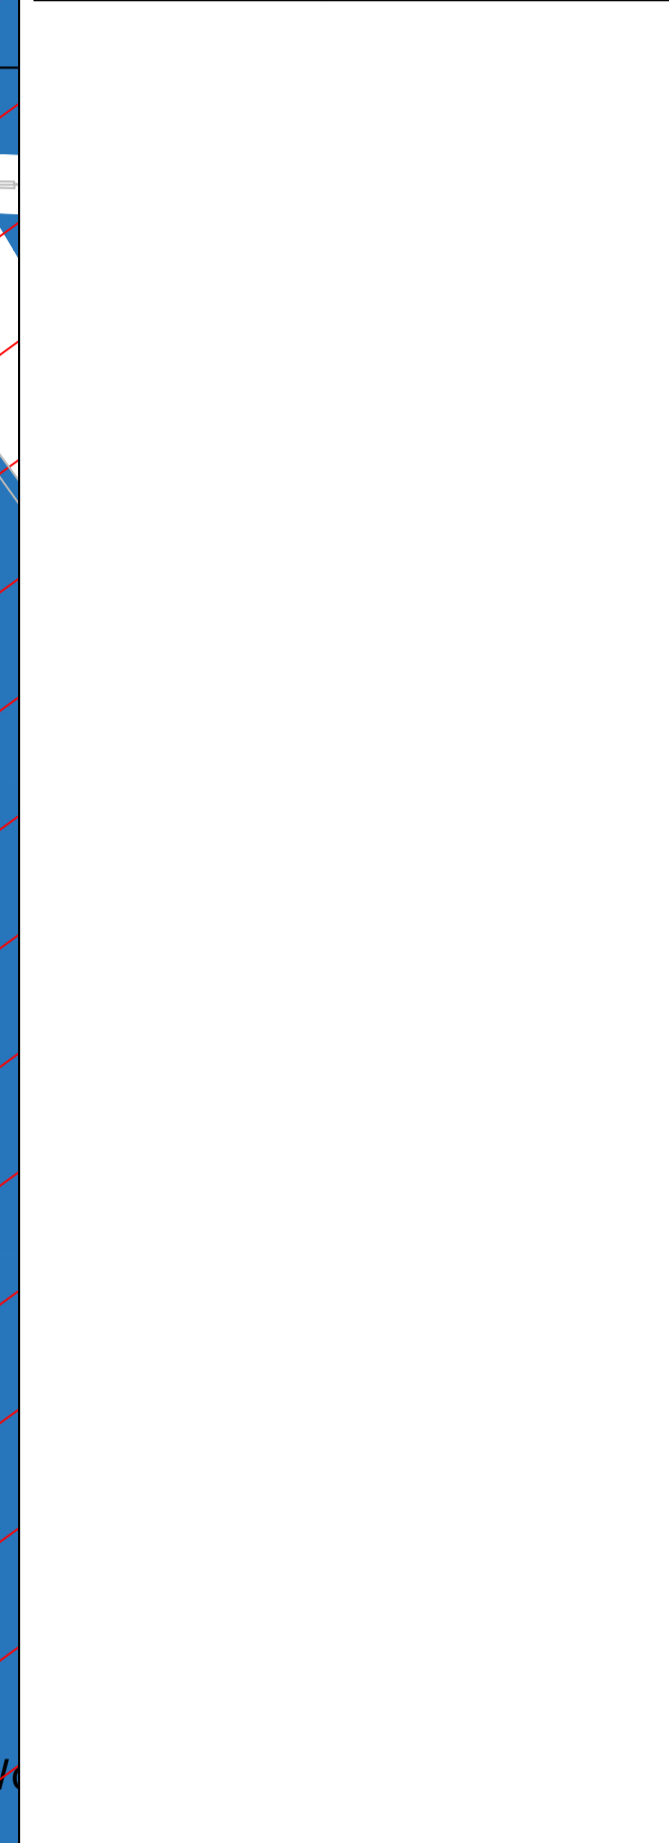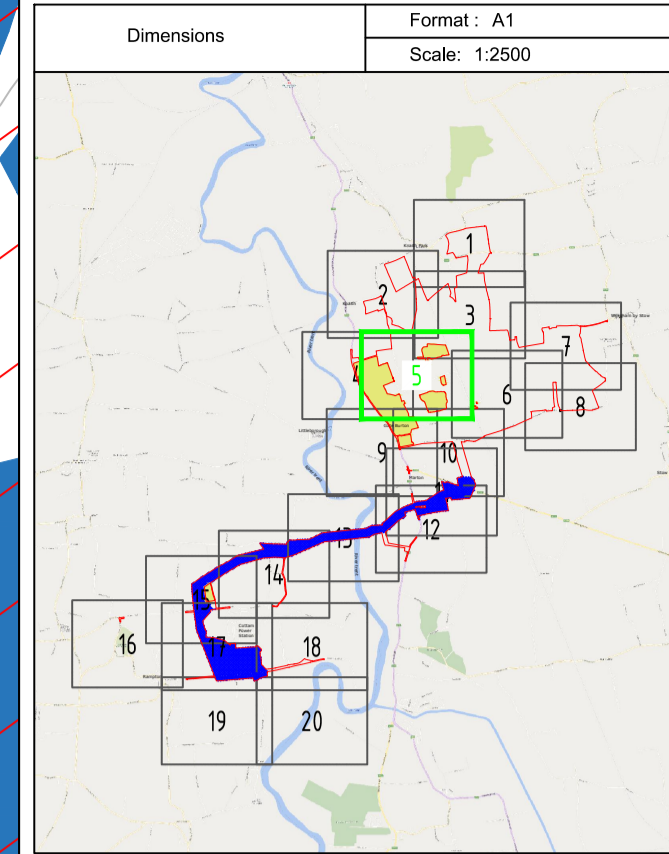




LEGEND

- Work No.1
- Work No.2
- Work No.3
- Work No.4a
- Work No.4b
- Work No.4c
- Work No.5
- Work No.6
- Work No.7
- Work No.8
- Work No.9
- Land not included in the Order limits

1. THIS DRAWING IS TO BE READ IN CONJUNCTION WITH ALL OTHER RELEVANT DOCUMENTATION.
2. WORKS MUST BE CONDUCTED IN ACCORDANCE WITH THE PRESCRIBED HEALTH AND SAFETY PROCEDURES AND PROTECTIVE REGULATIONS.
3. ALL OPERATIONS, CONSTRUCTION AND CONDUCTIONS ARE TO BE CONDUCTED IN ACCORDANCE WITH THE PRESCRIBED HEALTH AND SAFETY PROCEDURES AND PROTECTIVE REGULATIONS.
4. THE WORKS ARE SUBJECT TO CHANGE WITHOUT NOTICE AND ARE SUBJECT TO CHANGE THROUGH DETAILED DESIGN IN ACCORDANCE WITH THE TERMS OF THE DEVELOPMENT CONSENT ORDER.
5. THE WORKS ARE SUBJECT TO CHANGE WITHOUT NOTICE AND ARE SUBJECT TO CHANGE THROUGH DETAILED DESIGN IN ACCORDANCE WITH THE TERMS OF THE DEVELOPMENT CONSENT ORDER.

Index	Date	Changes	Writer	Checker
A	18/01/23	Original	ABO	GDA
B	07/03/23	S&I advice update	ABO	GDA
C	03/10/23	Update for Deadline	ABO	GDA

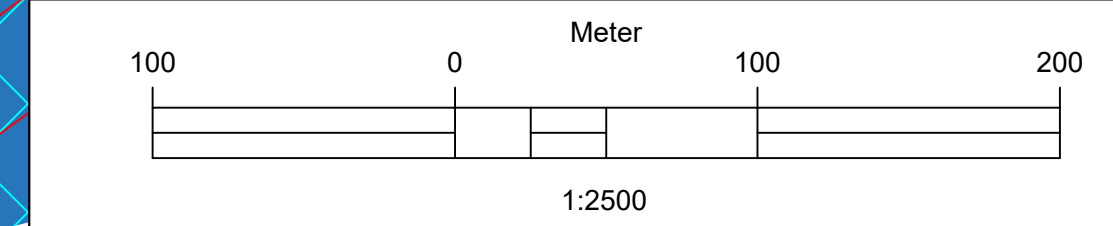

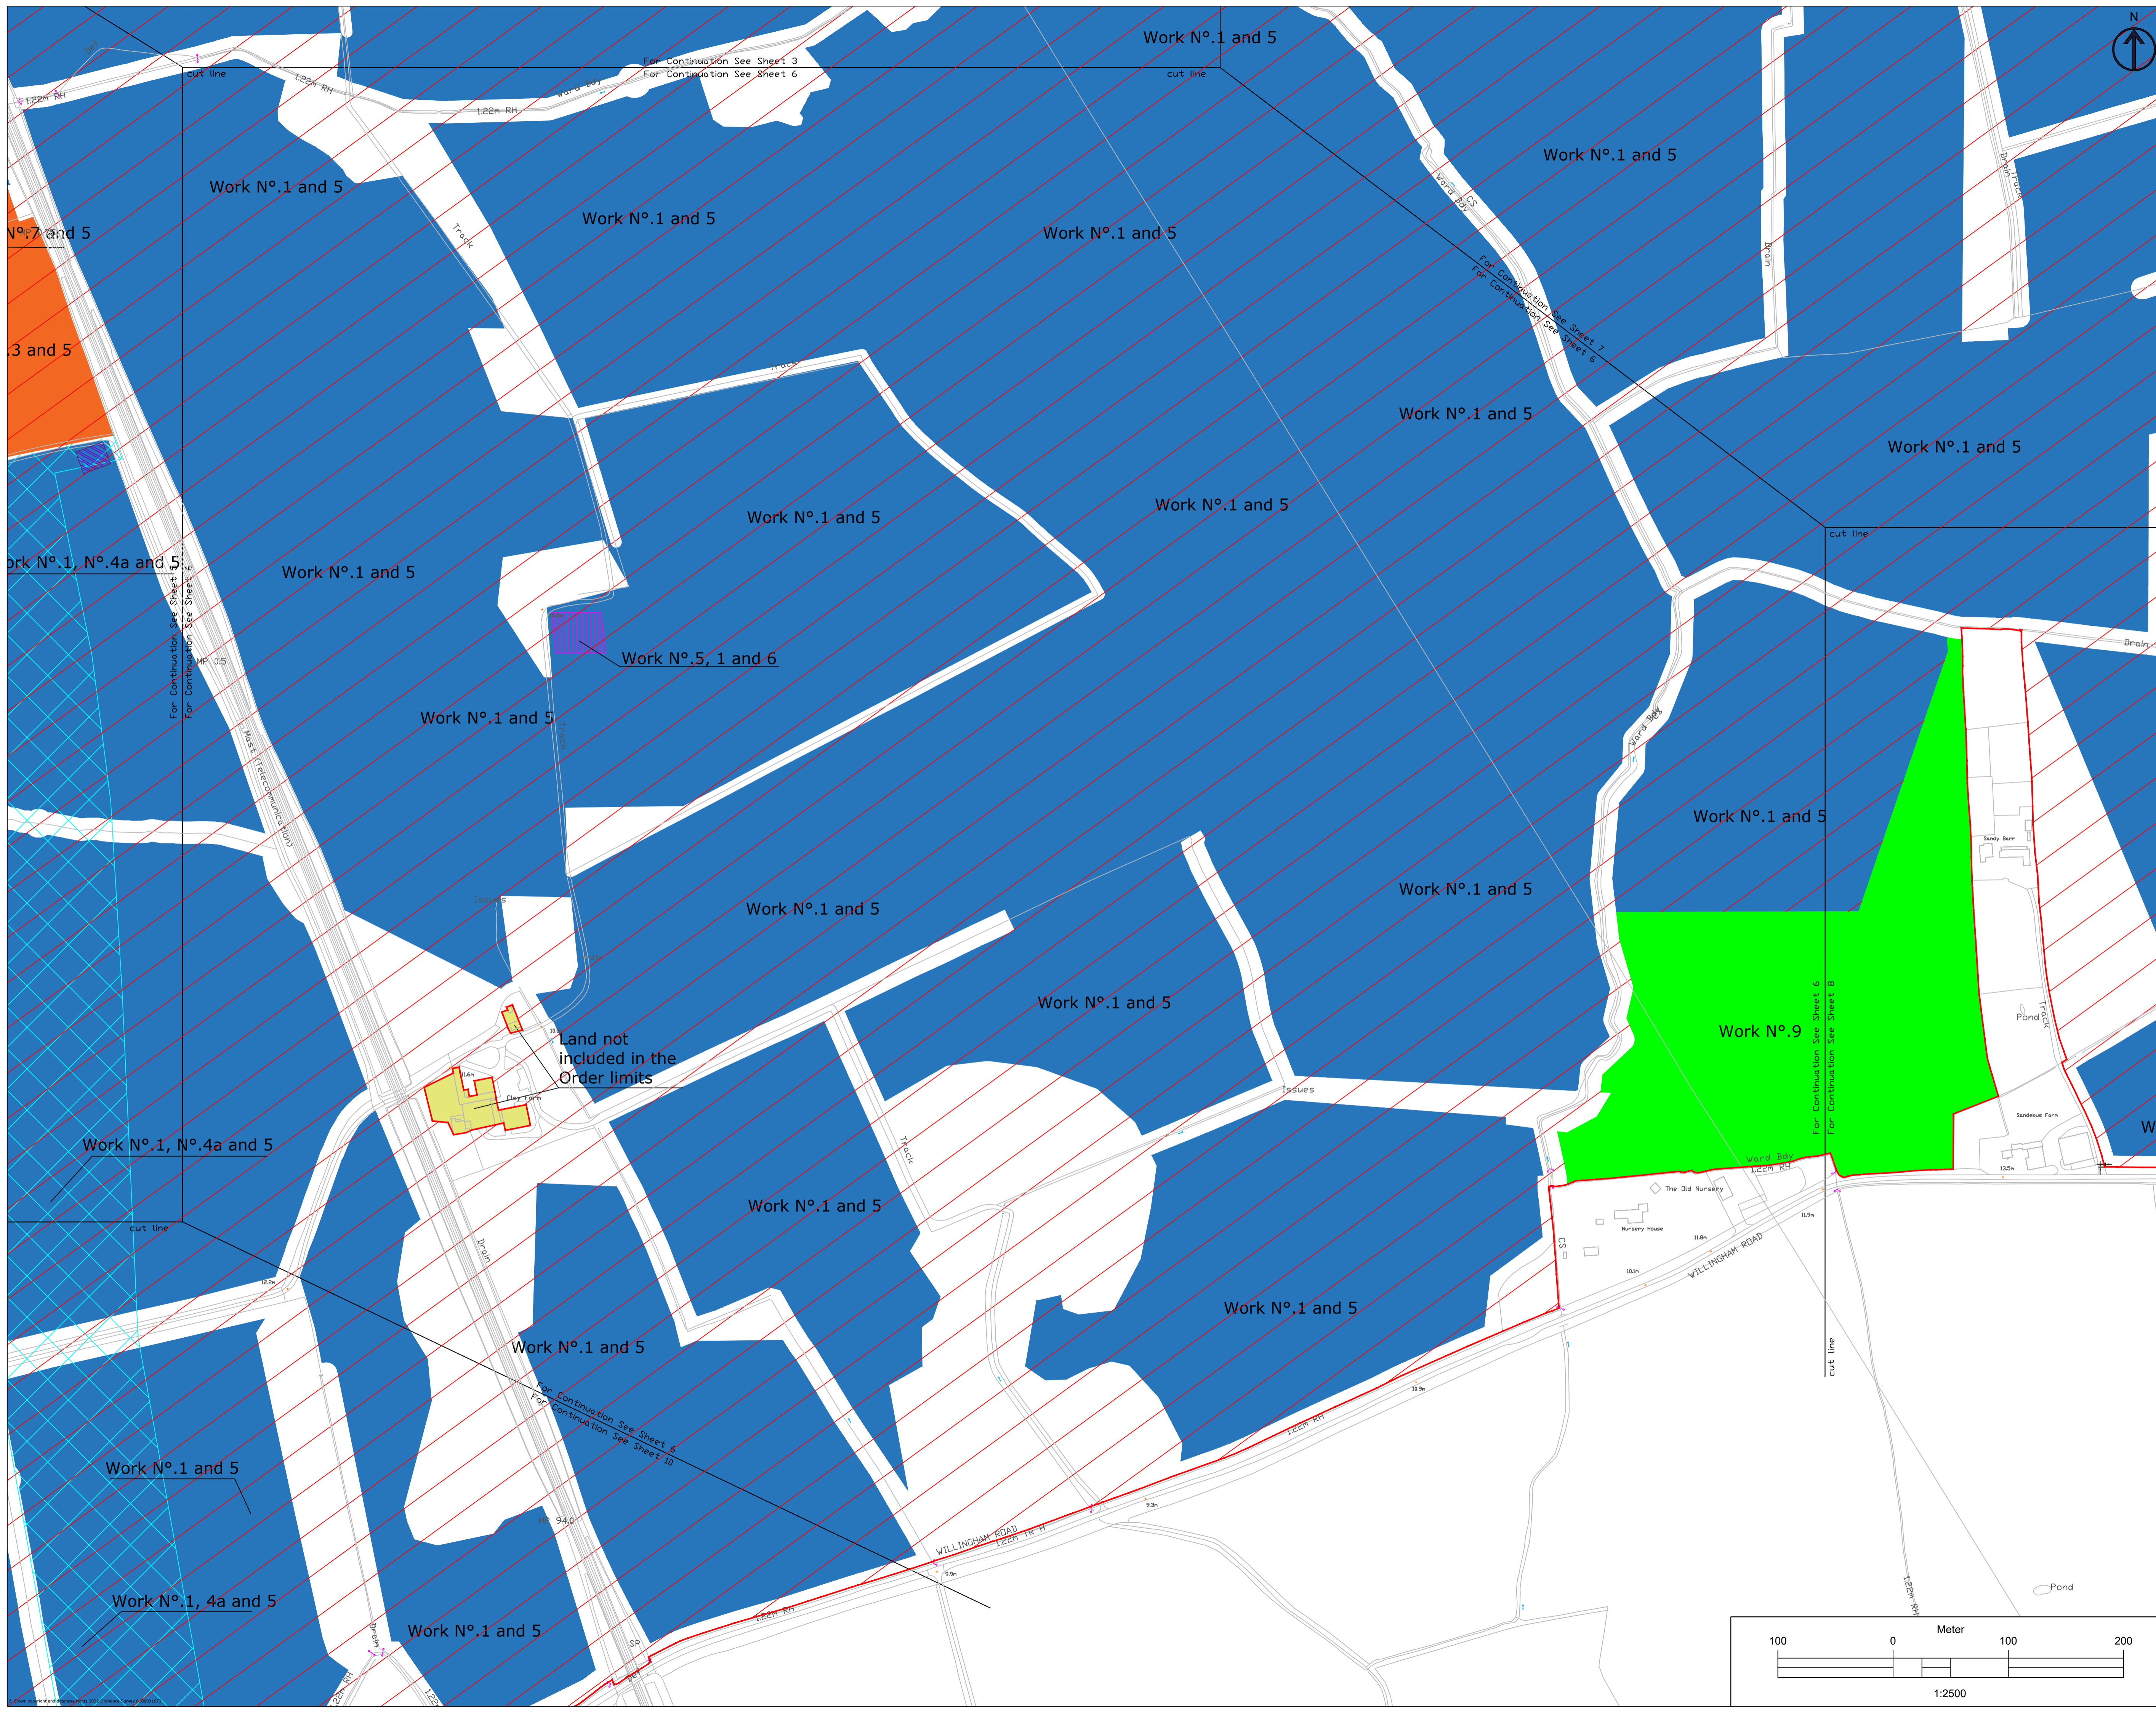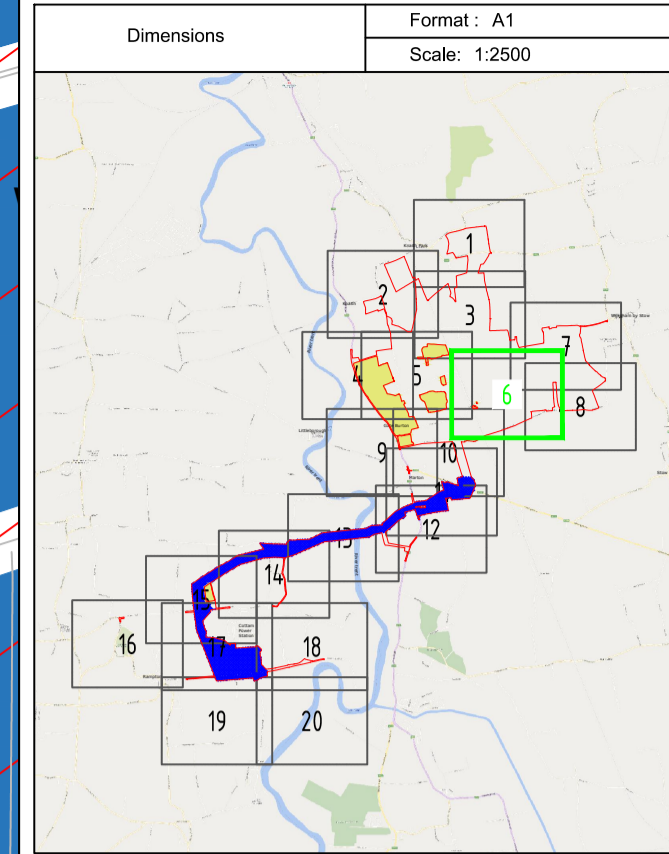



LEGEND

- Work No.1
- Work No.2
- Work No.3
- Work No.4a
- Work No.4b
- Work No.4c
- Work No.5
- Work No.6
- Work No.7
- Work No.8
- Work No.9
- Land not included in the Order limits

1. THIS DRAWING IS TO BE READ IN CONJUNCTION WITH ALL OTHER RELEVANT DOCUMENTATION.
2. WORKS SHALL BE CONDUCTED IN ACCORDANCE WITH THE REGULATIONS OF THE RELEVANT LOCAL AUTHORITY.
3. ALL DIMENSIONS, COORDINATES, LEVELS AND CONTROLS ARE IN METRES UNLESS OTHERWISE SPECIFIED.
4. THE WORKS ARE SUBJECT TO CHANGE THROUGH DETAILED DESIGN IN ACCORDANCE WITH THE TERMS OF THE DEVELOPER'S CONSULTANT ORDER.

Index	Date	Changes	Writer	Checker
A	18/01/23	Original	ABO	GDA
B	07/03/23	SS1 advice update	ABO	GDA
C	03/10/23	Update for Deadlined	ABO	GDA

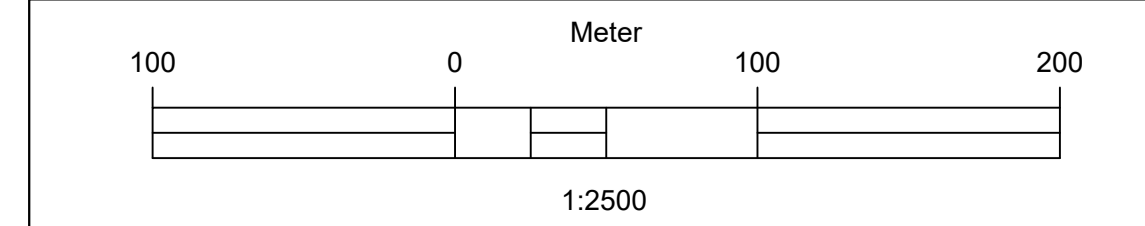


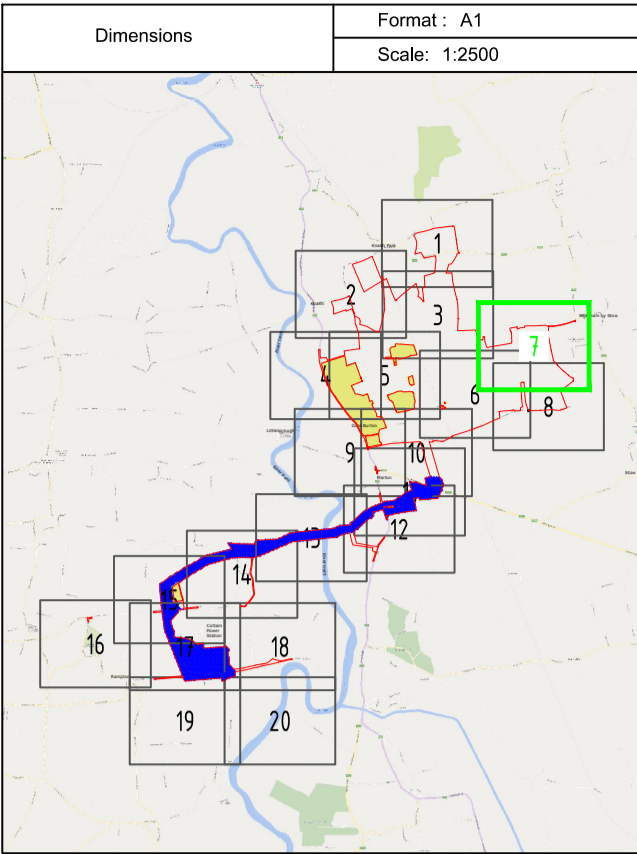



LEGEND

- Work No.1
- Work No.2
- Work No.3
- Work No.4a
- Work No.4b
- Work No.4c
- Work No.5
- Work No.6
- Work No.7
- Work No.8
- Work No.9
- Land not included in the Order limits

1. THIS DRAWING IS TO BE READ IN CONJUNCTION WITH ALL OTHER RELEVANT DOCUMENTATION.
2. WORKS ARE TO BE CONDUCTED IN ACCORDANCE WITH THE REGULATIONS OF THE RELEVANT LOCAL AUTHORITY.
3. ALL DIMENSIONS, COORDINATES, LEVELS AND CONTROLS ARE IN METRES UNLESS OTHERWISE SPECIFIED.
4. THE WORKS ARE TO BE CONDUCTED IN ACCORDANCE WITH THE REGULATIONS OF THE RELEVANT LOCAL AUTHORITY.
5. THE WORKS ARE TO BE CONDUCTED IN ACCORDANCE WITH THE REGULATIONS OF THE RELEVANT LOCAL AUTHORITY.
6. THE WORKS ARE TO BE CONDUCTED IN ACCORDANCE WITH THE REGULATIONS OF THE RELEVANT LOCAL AUTHORITY.
7. THE WORKS ARE TO BE CONDUCTED IN ACCORDANCE WITH THE REGULATIONS OF THE RELEVANT LOCAL AUTHORITY.
8. THE WORKS ARE TO BE CONDUCTED IN ACCORDANCE WITH THE REGULATIONS OF THE RELEVANT LOCAL AUTHORITY.
9. THE WORKS ARE TO BE CONDUCTED IN ACCORDANCE WITH THE REGULATIONS OF THE RELEVANT LOCAL AUTHORITY.

Index	Date	Changes	Writer	Checker
A	19/01/23	Original	ABO	GDA
B	07/03/23	SS1 advice update	ABO	GDA
C	03/10/23	Update for Deadline	ABO	GDA

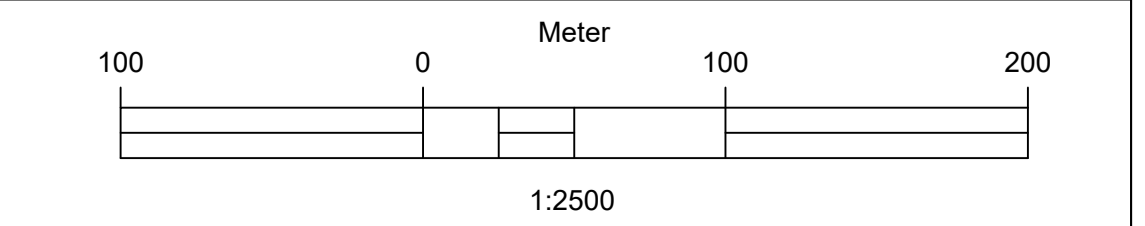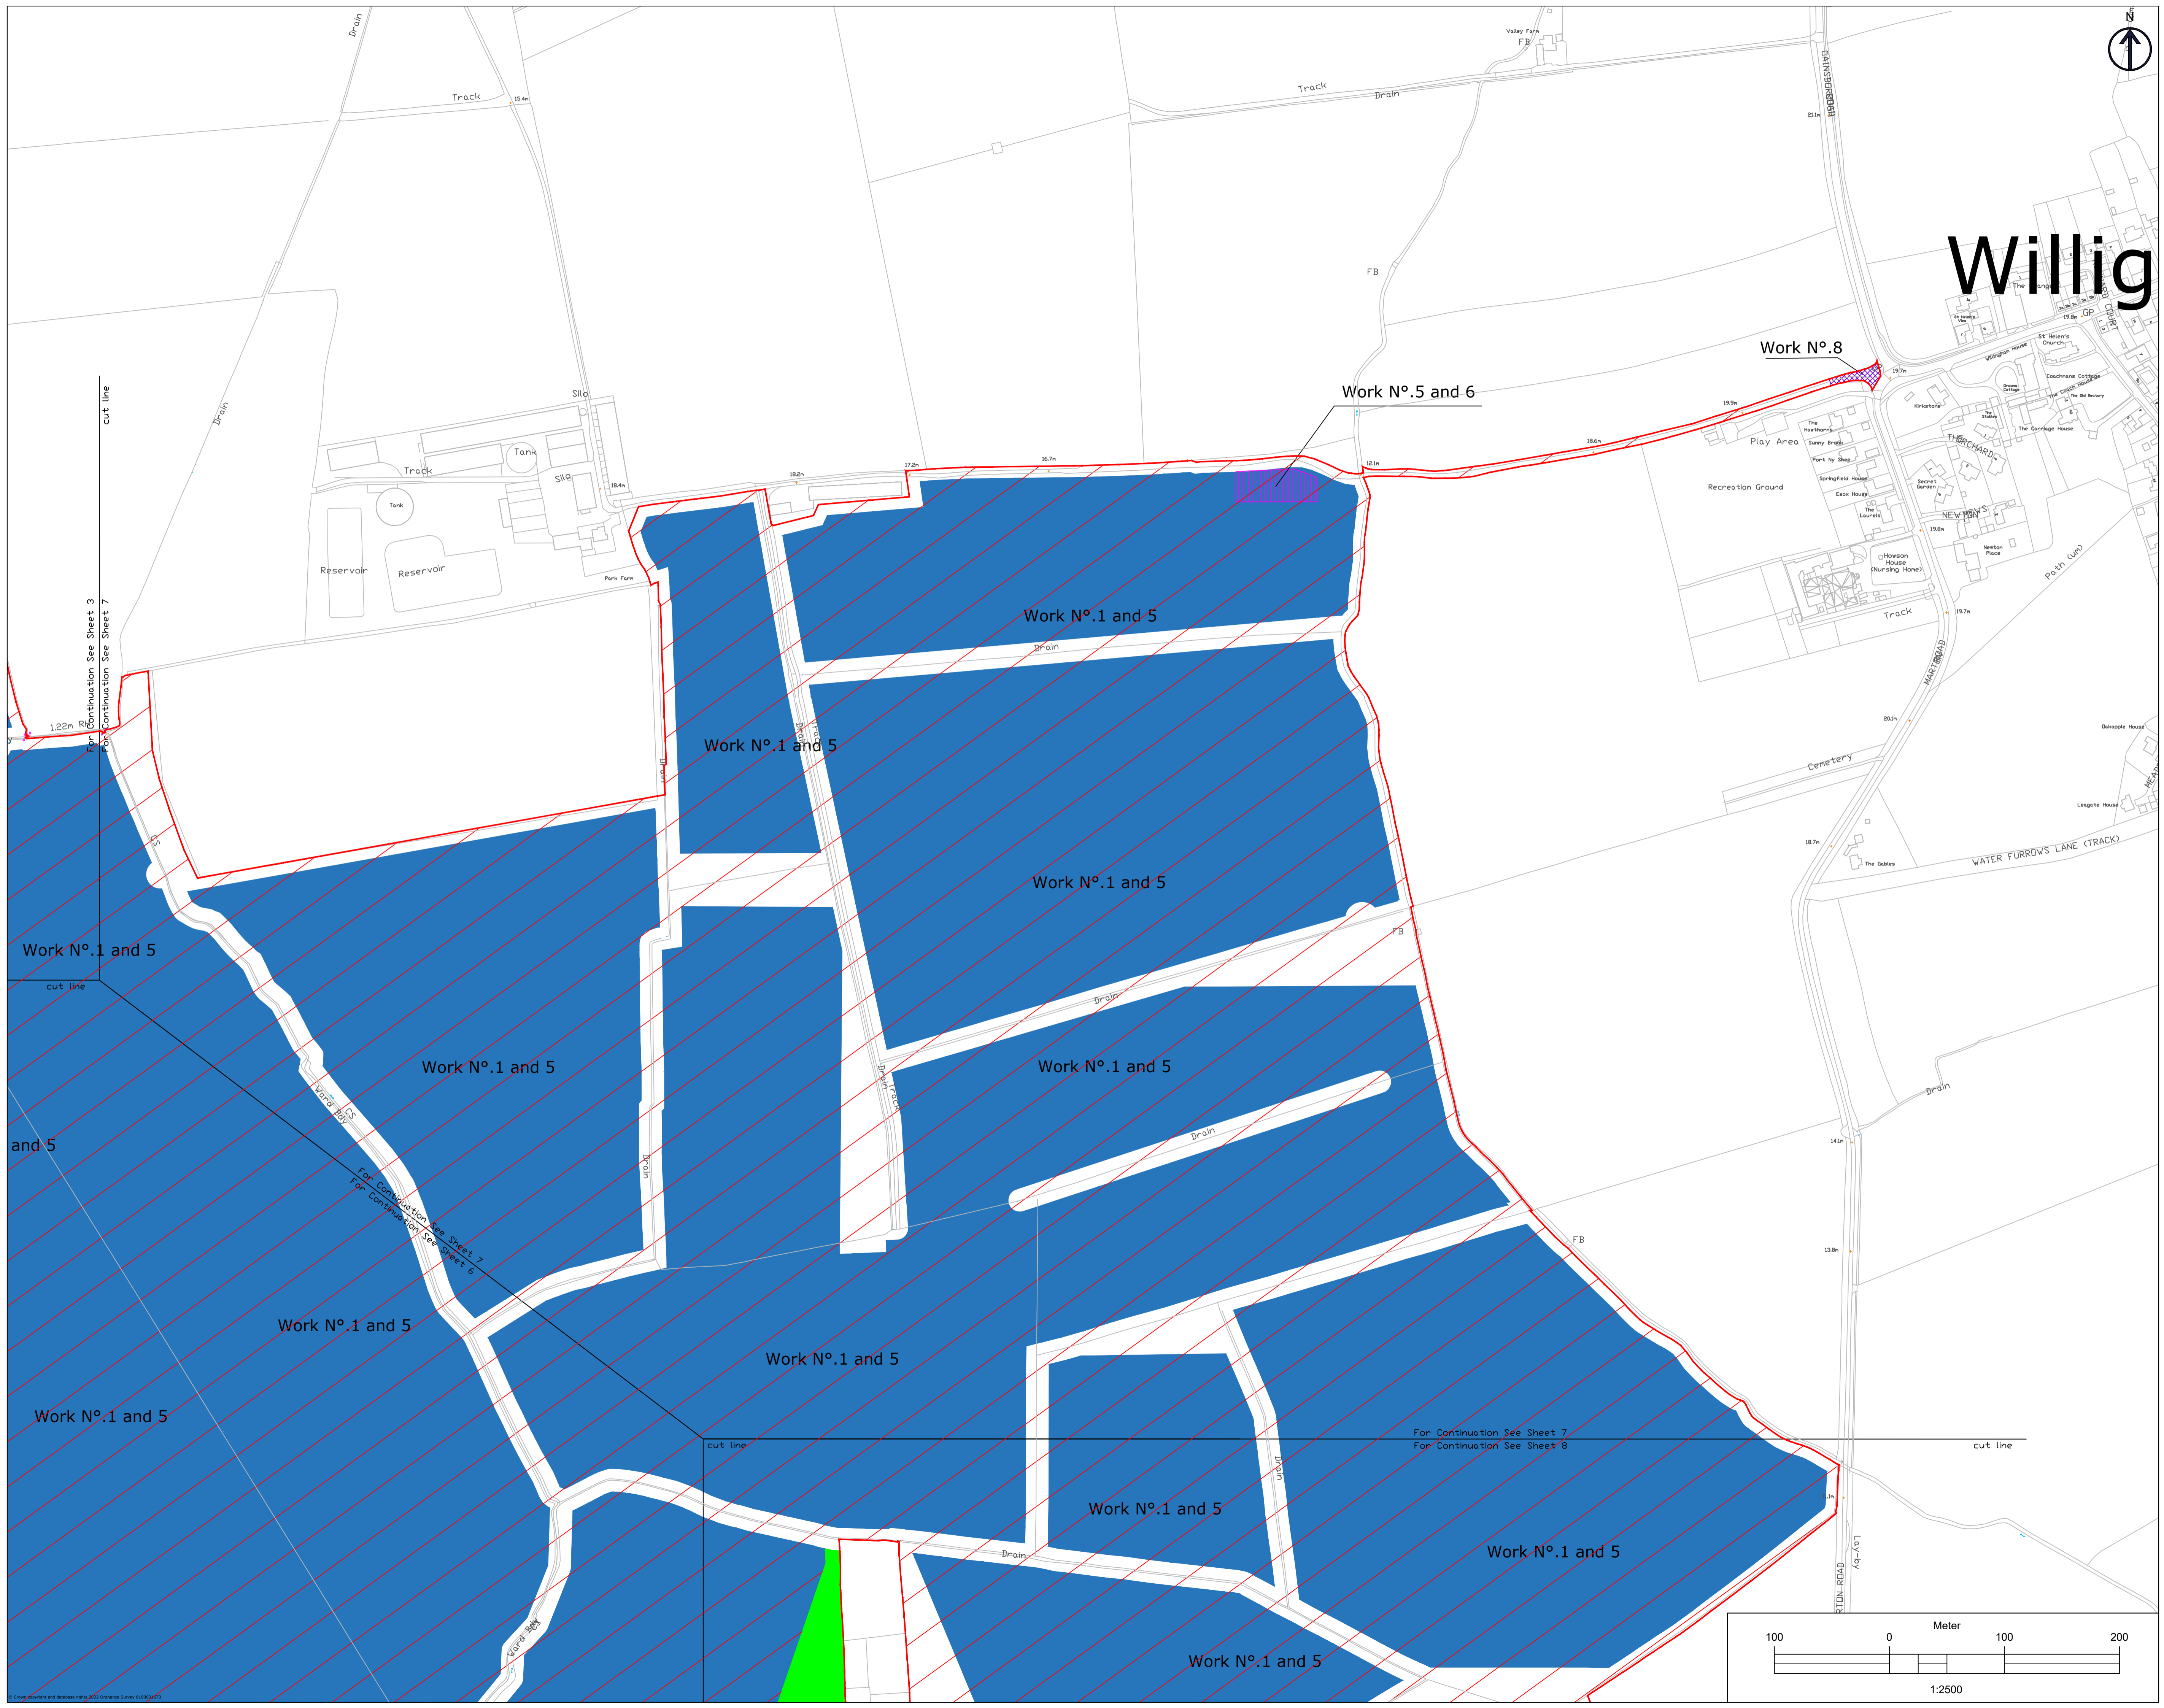

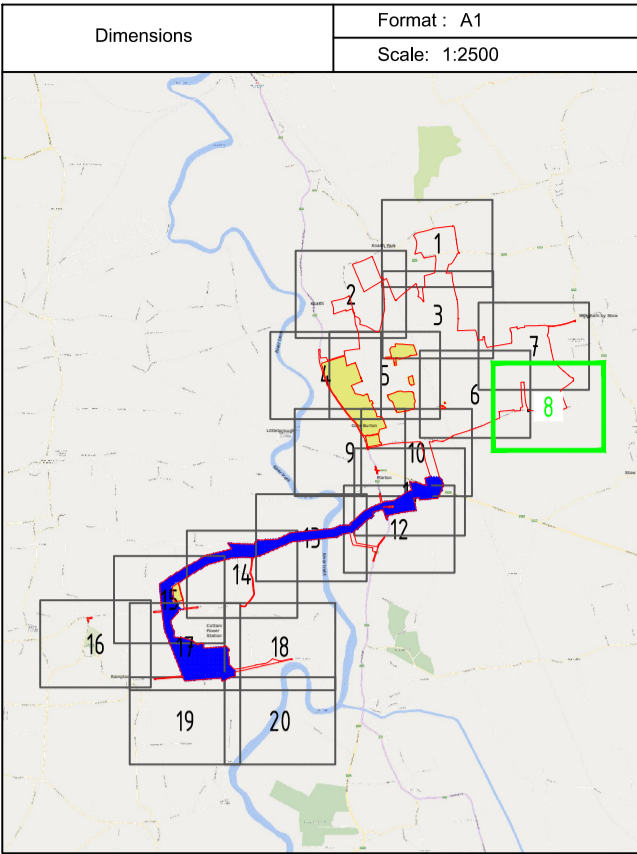



LEGEND

- Work No.1
- Work No.2
- Work No.3
- Work No.4a
- Work No.4b
- Work No.4c
- Work No.5
- Work No.6
- Work No.7
- Work No.8
- Work No.9
- Land not included in the Order limits

1. THIS DRAWING IS TO BE READ IN CONJUNCTION WITH ALL OTHER RELEVANT DOCUMENTATION.
 2. WORKS MUST BE IN ACCORDANCE WITH REGULATIONS AND ALL OTHER RELEVANT DOCUMENTATION.
 3. ALL DIMENSIONS, COORDINATES, LEVELS AND CONDIMENTS ARE IN METRES UNLESS OTHERWISE SPECIFIED.
 4. THE OWNER AND SPECIAL CONSULTANTS SHALL BE RESPONSIBLE FOR CHECKING ON SITE AND ANY DISCREPANCIES SHALL BE REPORTED IMMEDIATELY TO THE PROJECT MANAGER.
 5. THE OWNER AND SPECIAL CONSULTANTS SHALL BE RESPONSIBLE TO CHANGE THROUGH DETAILED DESIGN IN ACCORDANCE WITH THE TERMS OF THE DEVELOPMENT CONSENT ORDER.

Index	Date	Changes	Writer	Checker
A	18/01/23	Original	ABO	GDA
B	07/03/23	SS1 advice update	ABO	GDA
C	03/10/23	Update for Deadline	ABO	GDA

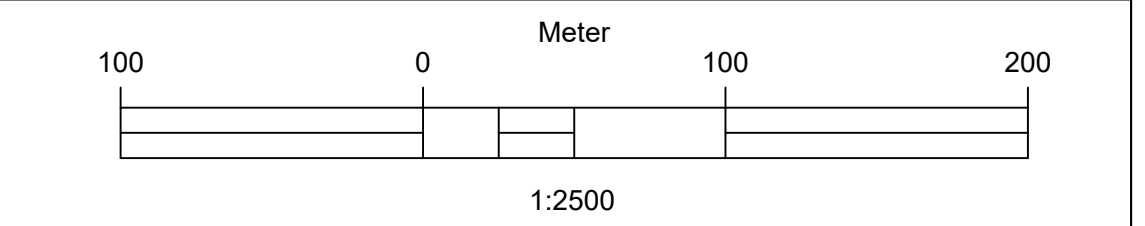

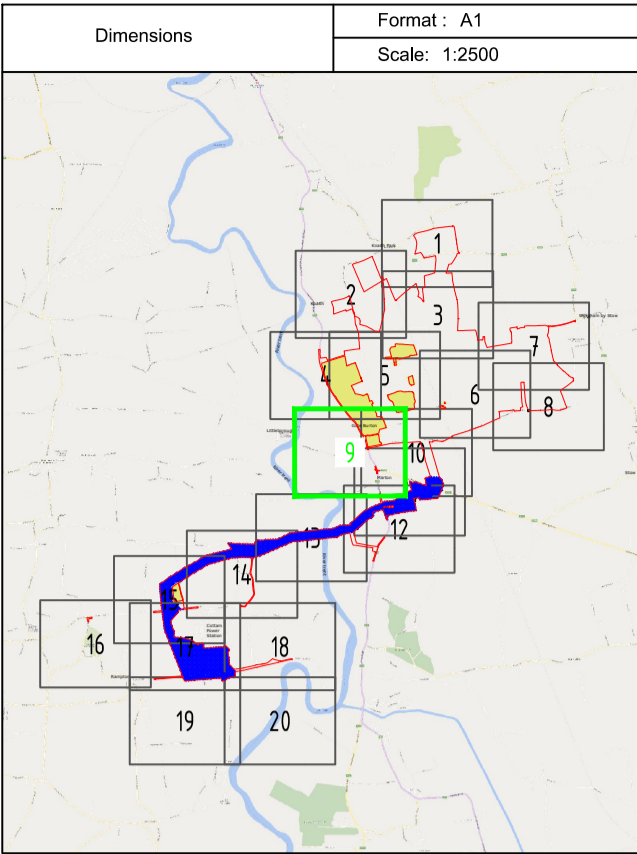



Dimensions: Format: A1 Scale: 1:2500



LEGEND

- Work No.1
- Work No.2
- Work No.3
- Work No.4a
- Work No.4b
- Work No.4c
- Work No.5
- Work No.6
- Work No.7
- Work No.8
- Work No.9
- Land not included in the Order limits

1. THIS DRAWING IS TO BE READ IN CONJUNCTION WITH ALL OTHER RELEVANT DOCUMENTATION.
2. WORKS MUST BE IN ACCORDANCE WITH REGULATIONS AND ALL OTHER RELEVANT DOCUMENTATION.
3. ALL OPERATIONS, CONSTRUCTION AND CONSTRUCTION ARE IN ACCORDANCE WITH THE RELEVANT REGULATIONS AND ALL OTHER RELEVANT DOCUMENTATION.
4. THE WORKS ARE SUBJECT TO CHANGE WITHOUT NOTICE TO THE CLIENT.
5. THE WORKS ARE SUBJECT TO CHANGE WITHOUT NOTICE TO THE CLIENT THROUGH DETAILED DESIGN IN ACCORDANCE WITH THE TERMS OF THE DEVELOPMENT CONSENT ORDER.

Index	Date	Changes	Writer	Checker
A	19/01/23	Original	ABO	GDA
B	07/03/23	SSI advice update	ABO	GDA
C	03/10/23	Update for Deadline	ABO	GDA

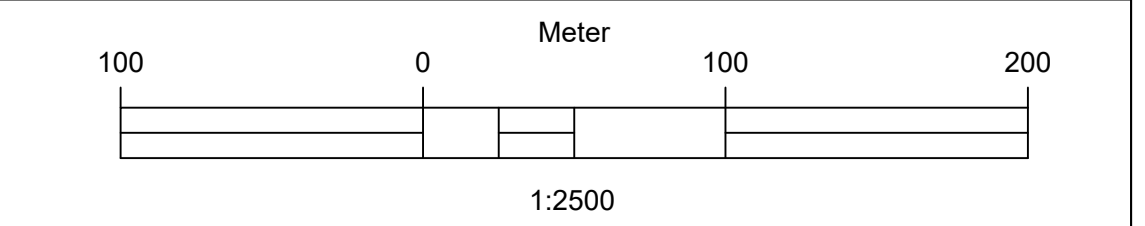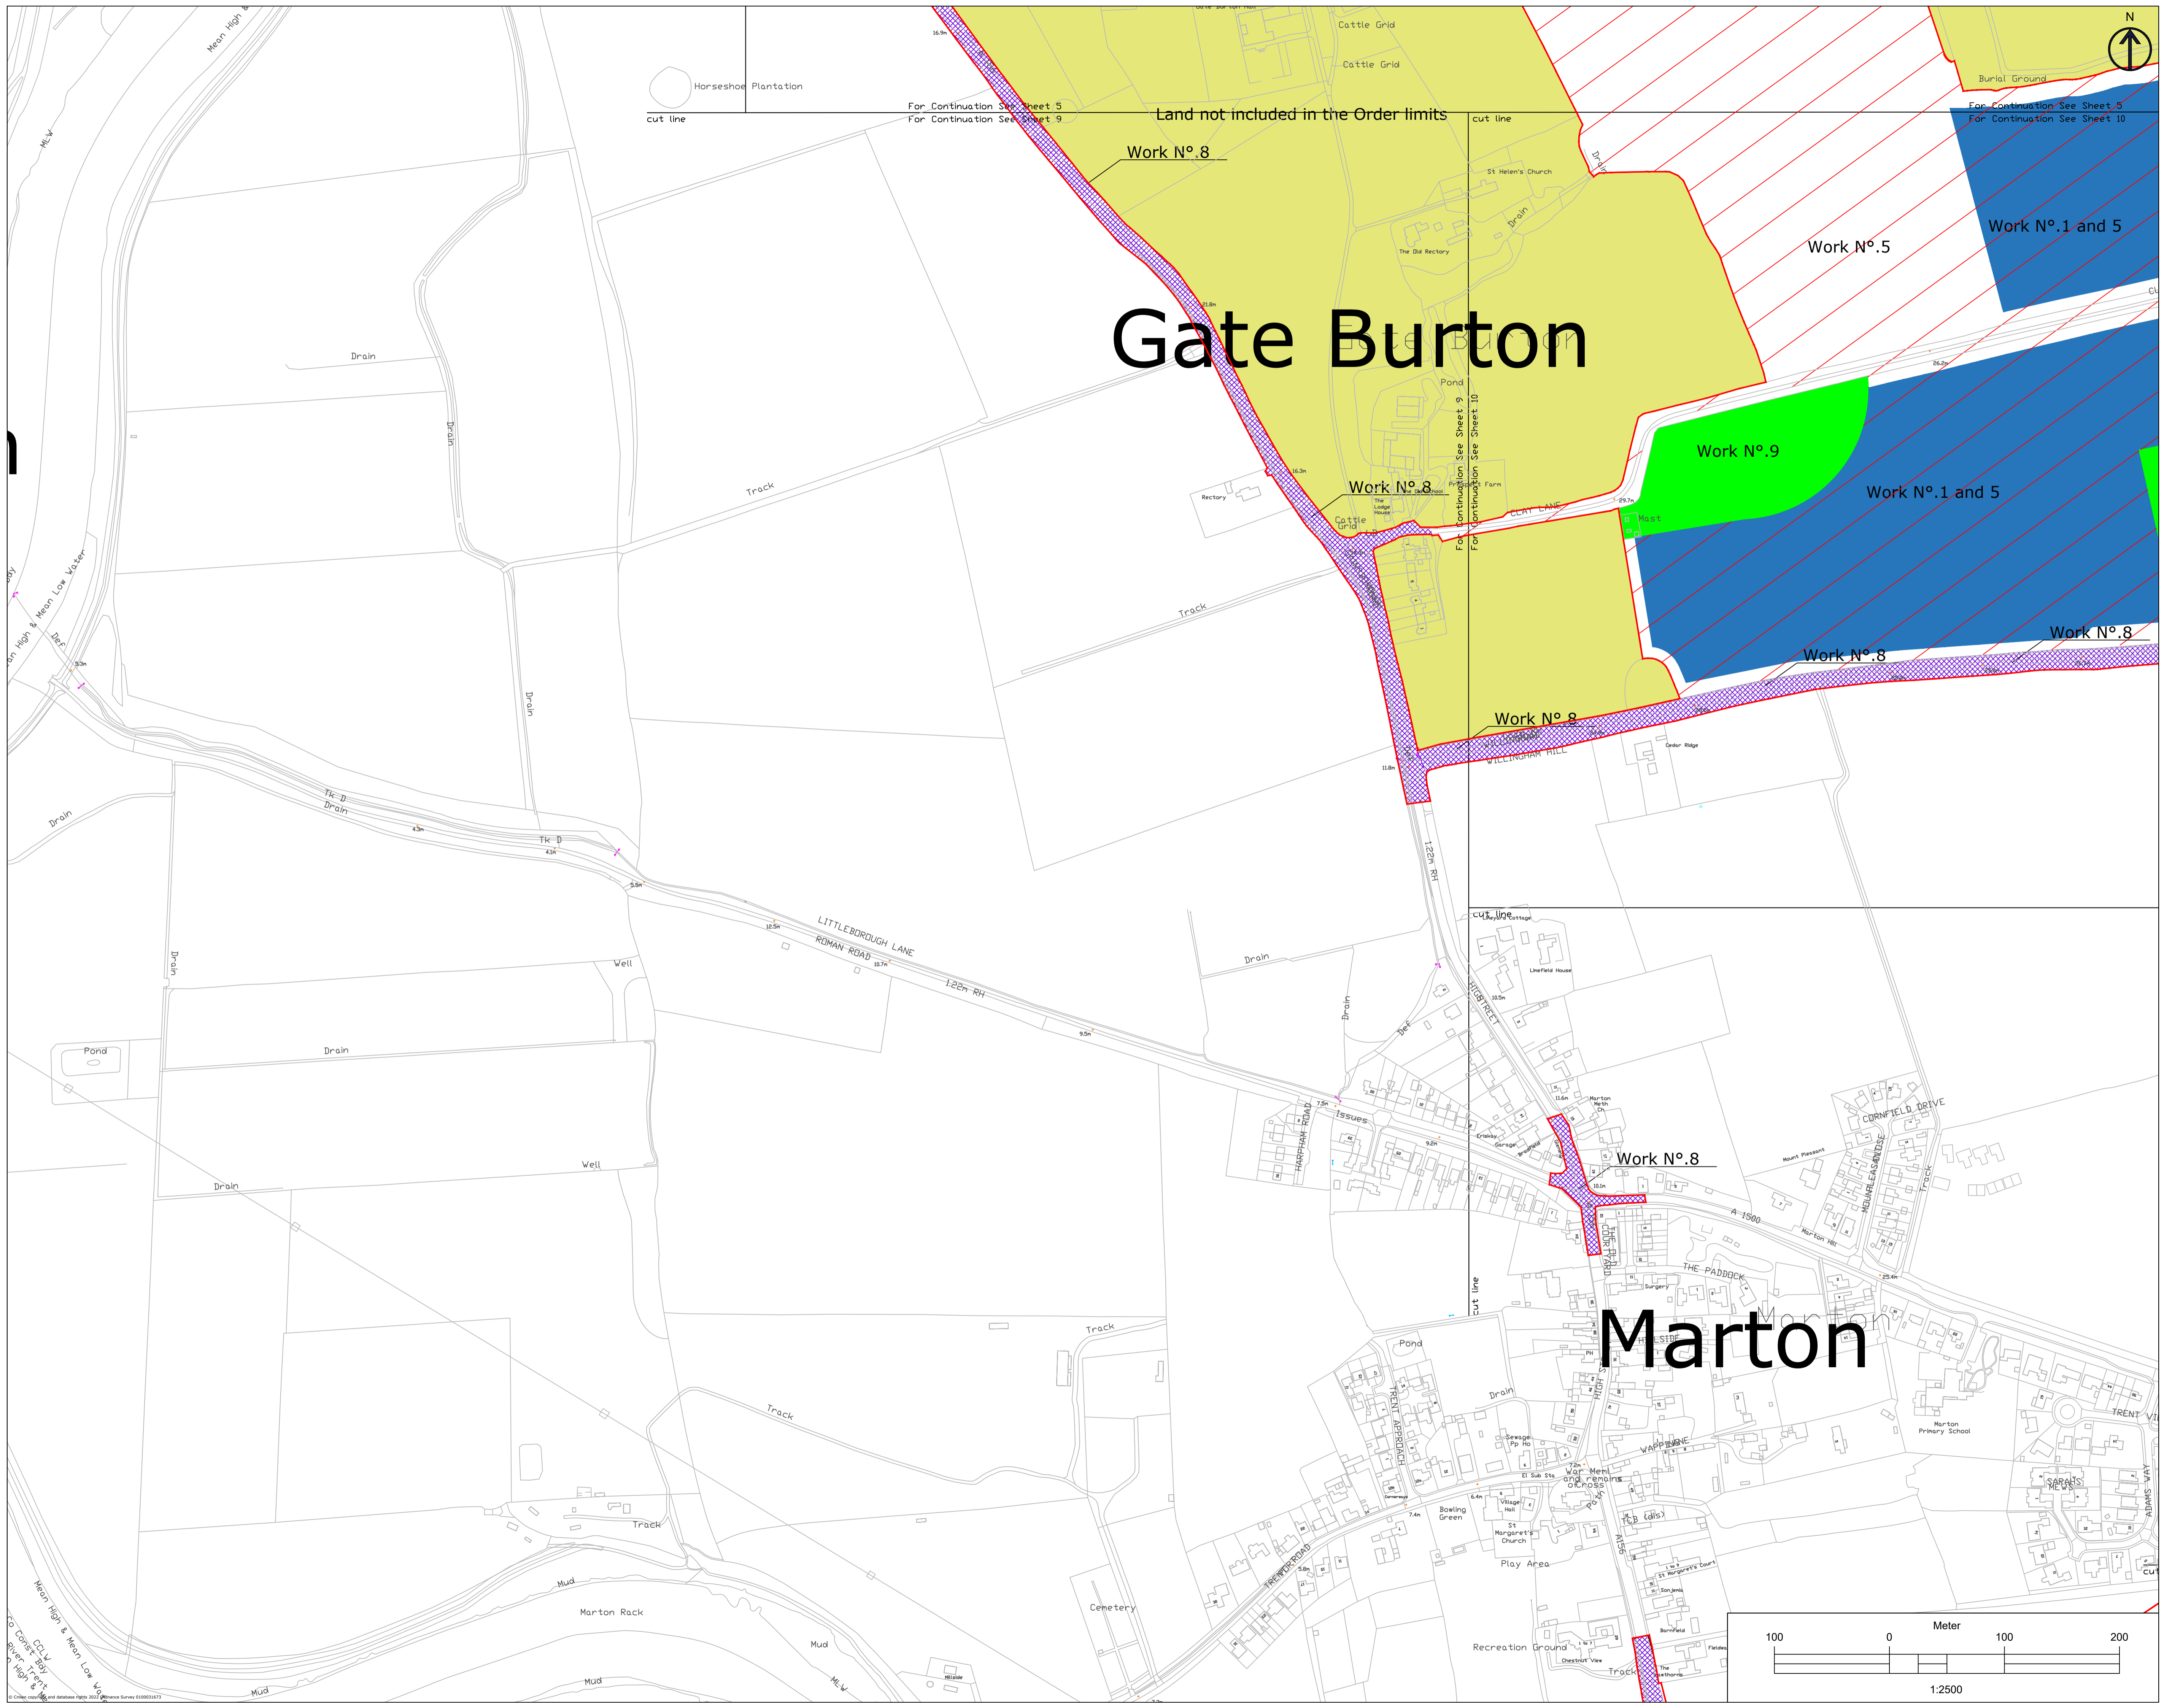

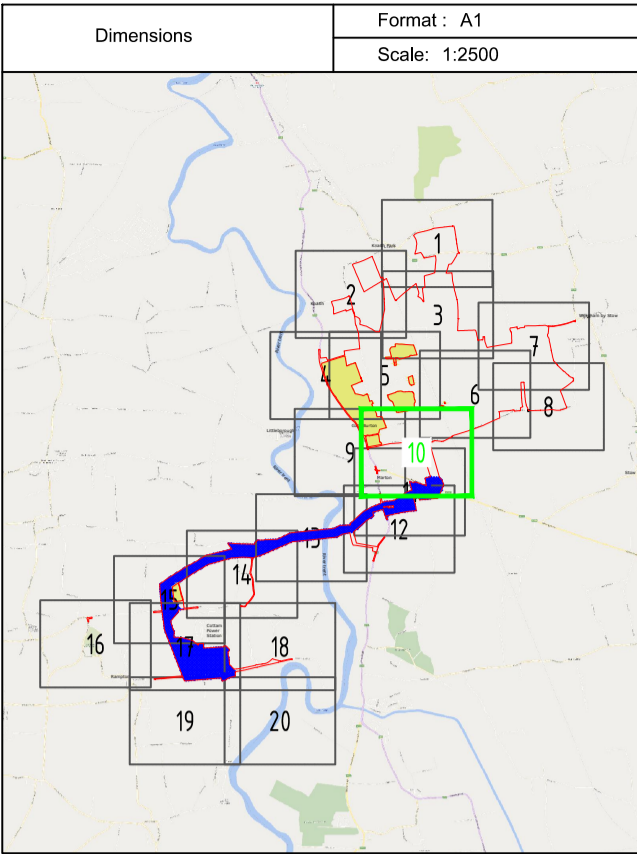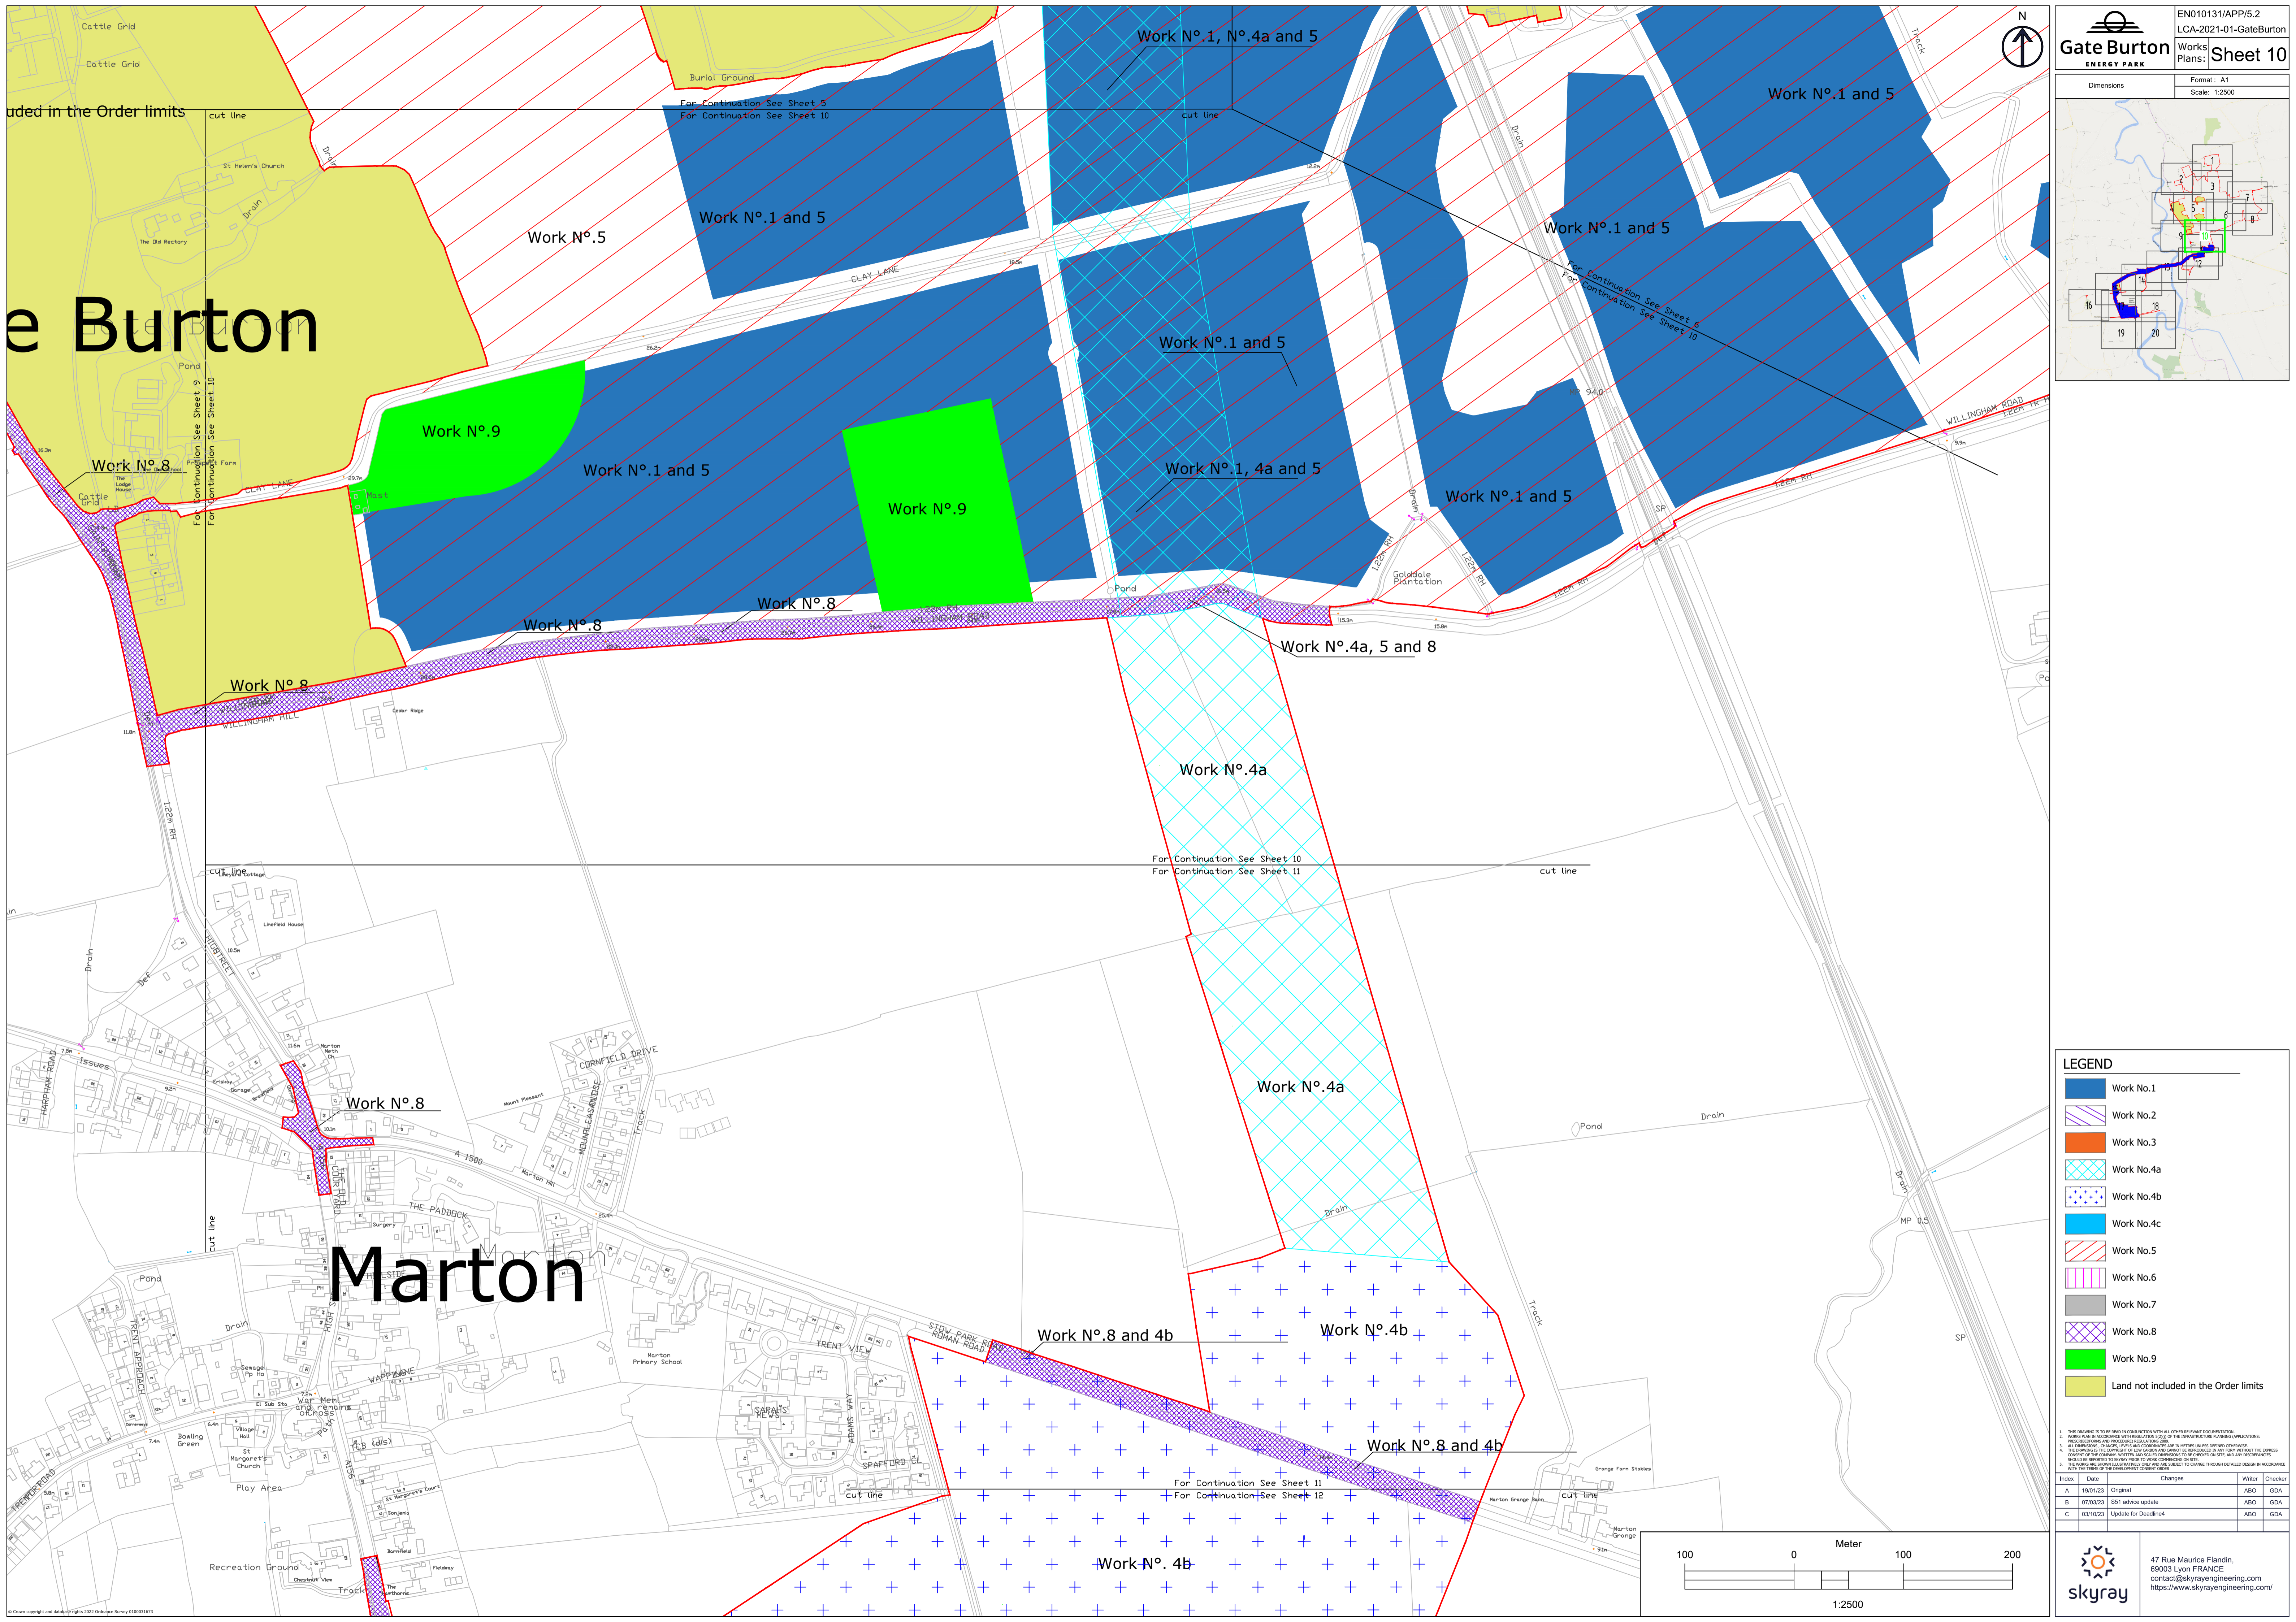





LEGEND

- Work No.1
- Work No.2
- Work No.3
- Work No.4a
- Work No.4b
- Work No.4c
- Work No.5
- Work No.6
- Work No.7
- Work No.8
- Work No.9
- Land not included in the Order limits

1. THIS DRAWING IS TO BE READ IN CONJUNCTION WITH ALL OTHER RELEVANT DOCUMENTATION.
2. WORKS SHALL BE IN ACCORDANCE WITH THE SPECIFICATIONS AND CONDITIONS OF THE CONTRACT AND THE PREVIOUS EDITIONS OF THE SPECIFICATIONS AND CONDITIONS.
3. ALL DIMENSIONS, COORDINATES, LEVELS AND CORRECTIONS ARE IN METRES UNLESS OTHERWISE STATED.
4. THE CONTRACTOR SHALL BE RESPONSIBLE FOR CHECKING ALL DIMENSIONS AND LEVELS ON SITE AND ANY DISCREPANCIES SHALL BE REPORTED TO THE ENGINEER PRIOR TO WORK COMMENCING ON SITE.
5. THE ENGINEER RESERVES THE RIGHT TO MAKE ANY CHANGES TO THIS DRAWING WITHOUT NOTICE AND WITHOUT LIABILITY TO THE CONTRACTOR.
6. THE CONTRACTOR SHALL BE RESPONSIBLE FOR OBTAINING ALL NECESSARY CONSENTS FROM THE LOCAL AUTHORITY AND OTHER RELEVANT AGENCIES.

Index	Date	Changes	Writer	Checker
A	18/01/23	Original	ABO	GDA
B	07/03/23	S&S advice update	ABO	GDA
C	03/10/23	Update for Deadline	ABO	GDA

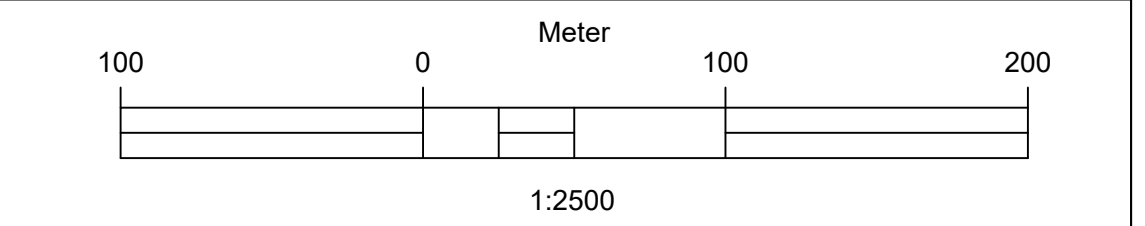

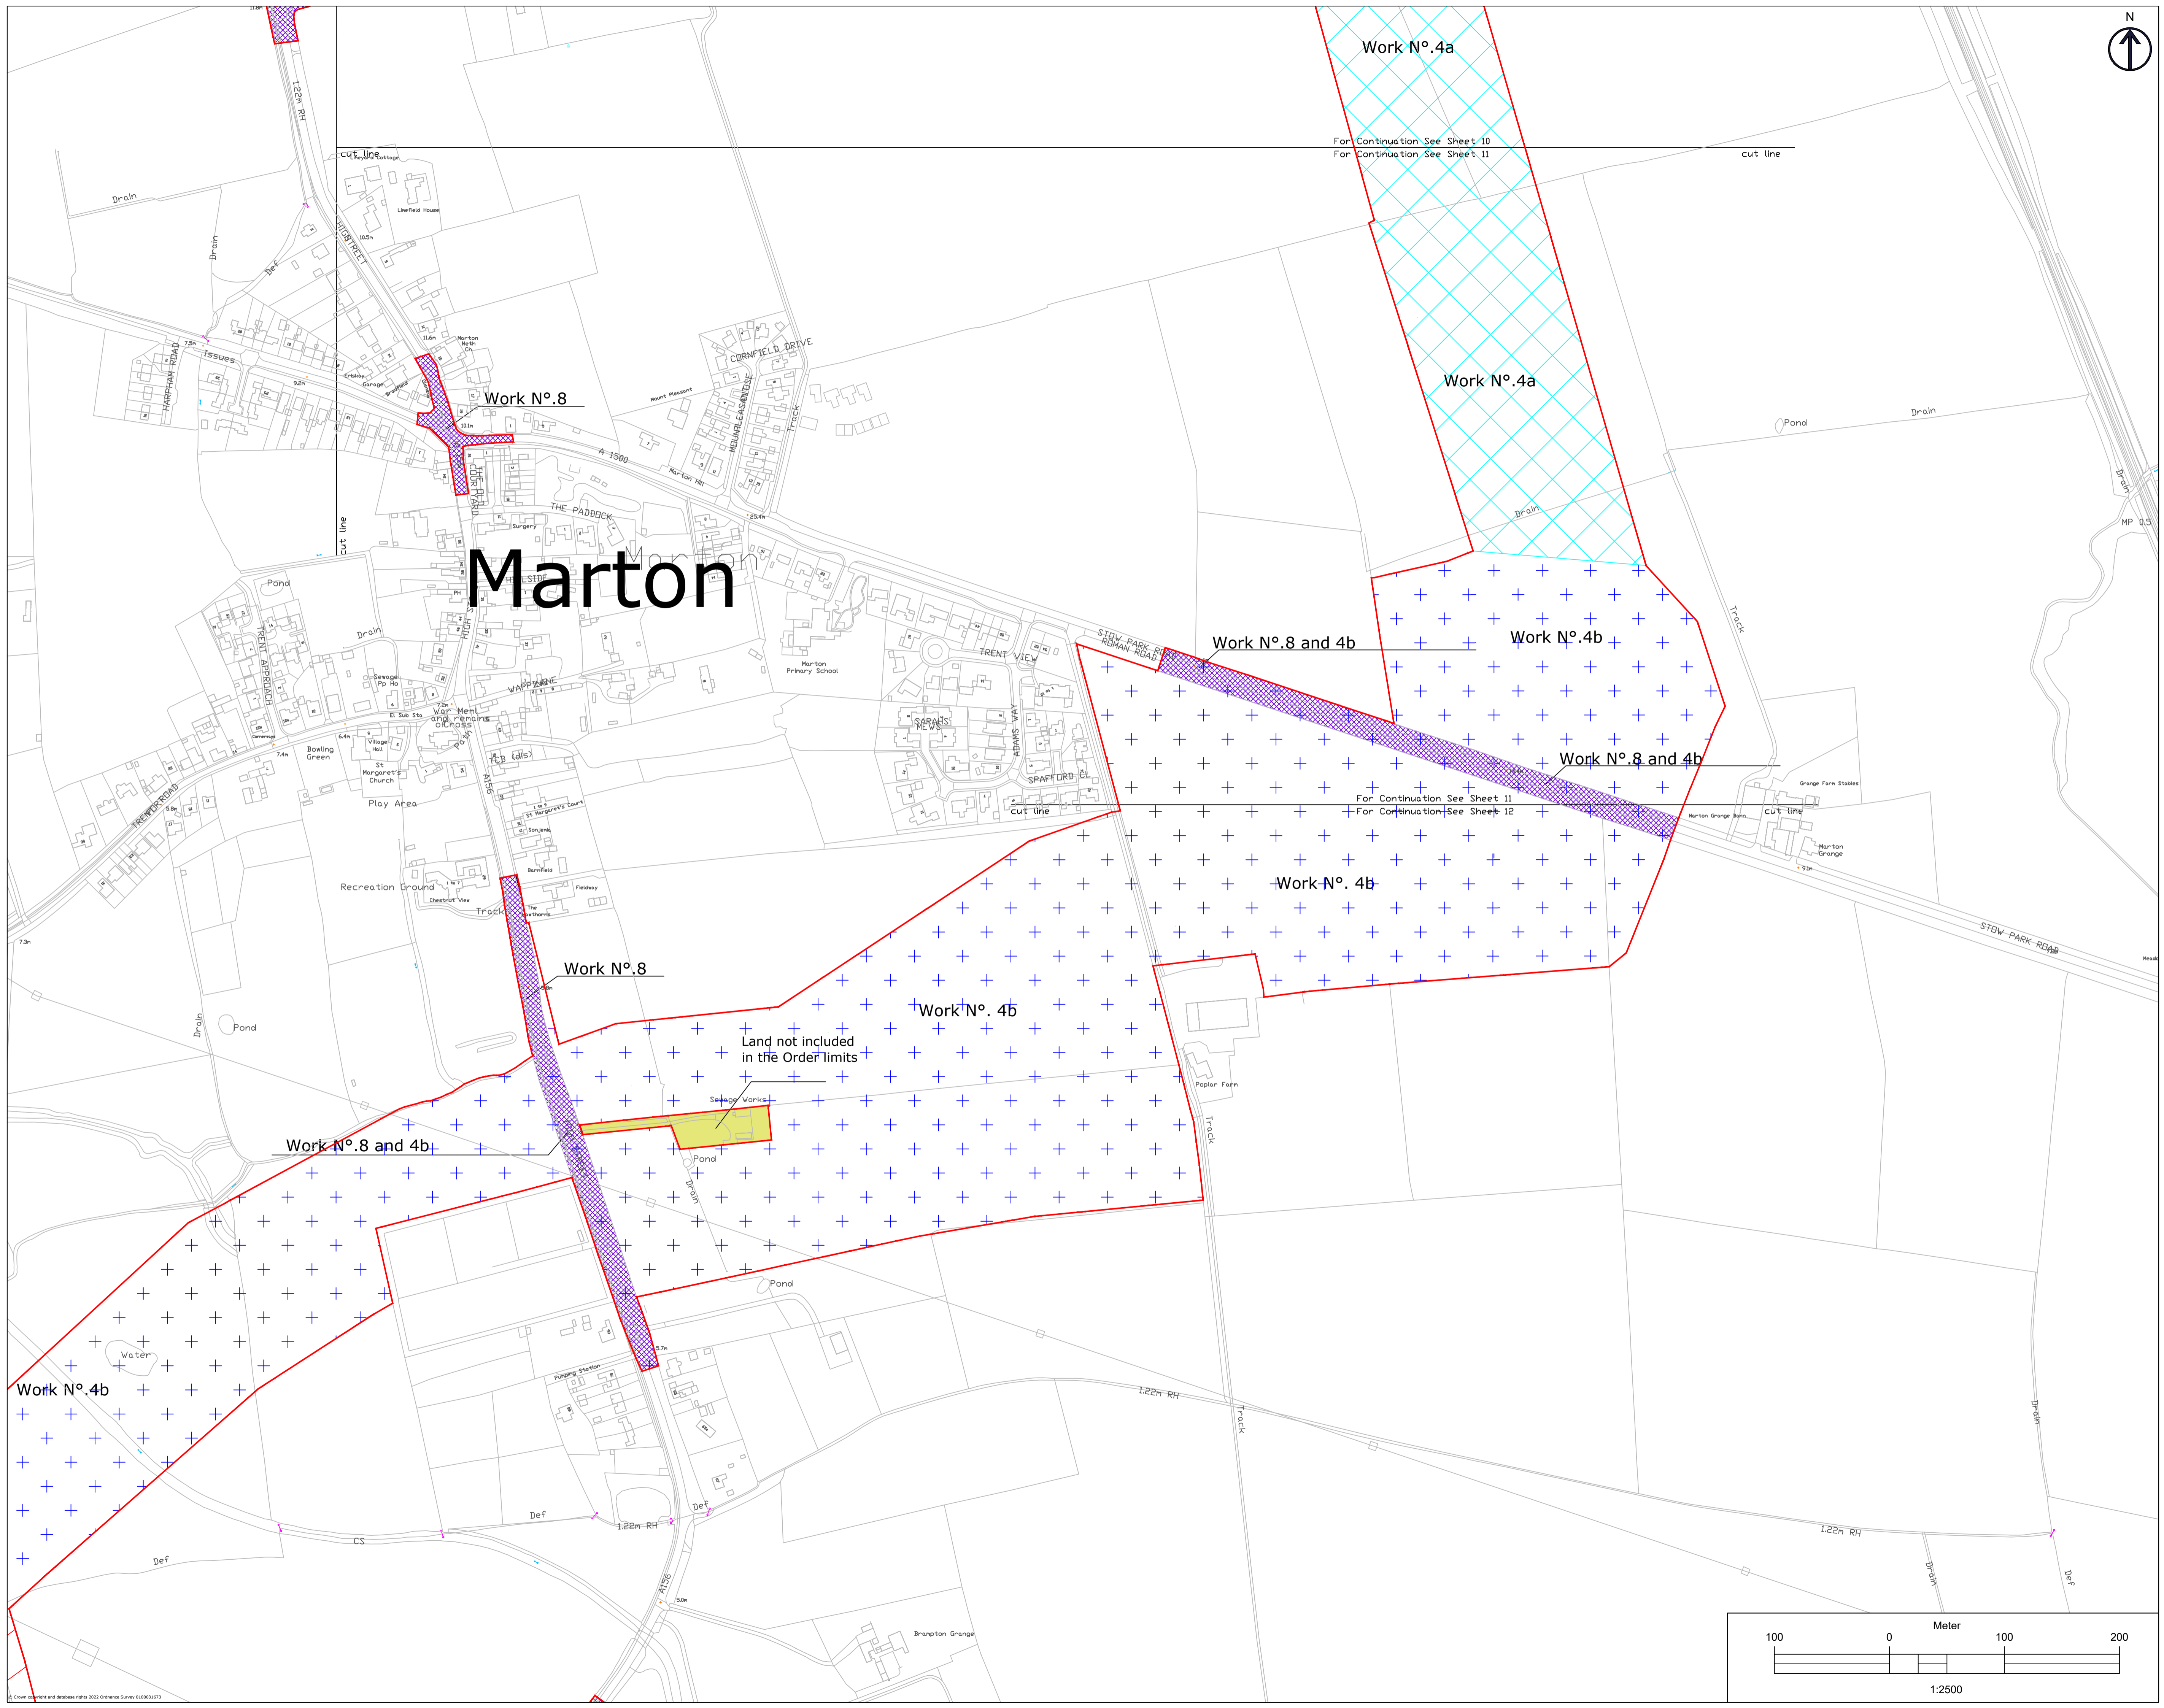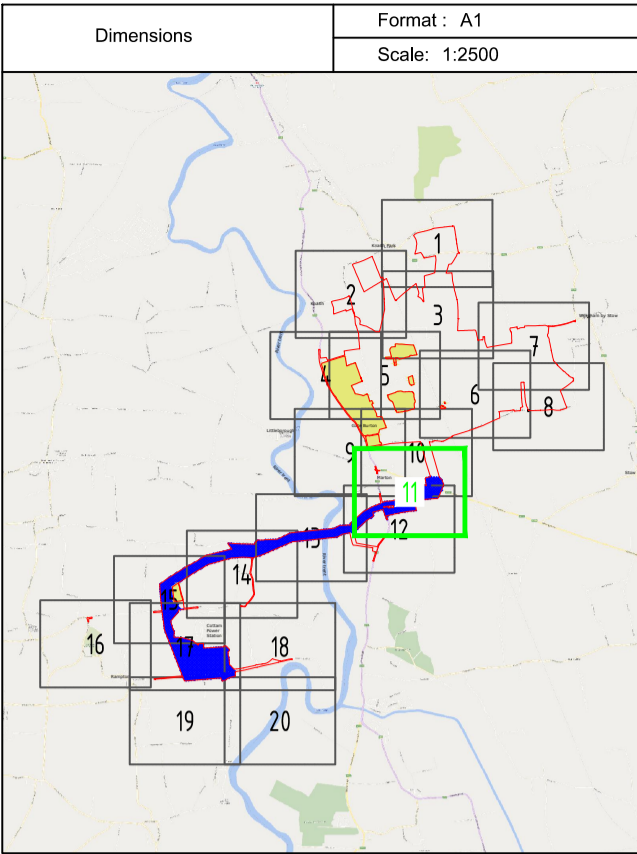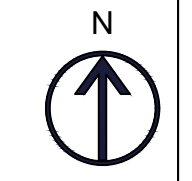


Marton



LEGEND

- Work No.1
- Work No.2
- Work No.3
- Work No.4a
- Work No.4b
- Work No.4c
- Work No.5
- Work No.6
- Work No.7
- Work No.8
- Work No.9
- Land not included in the Order limits

1. THIS DRAWING IS TO BE READ IN CONJUNCTION WITH ALL OTHER RELEVANT DOCUMENTATION.
2. WORKS MUST BE IN ACCORDANCE WITH THE SPECIFICATIONS OF THE RELEVANT PLANNING PERMISSIONS, PROCEDURES AND REGULATIONS.
3. ALL DIMENSIONS, COORDINATES, LEVELS AND CORNERINGS ARE IN METRES UNLESS SPECIFIC OTHERWISE.
4. THE OWNER AND SPECIAL CONSULTANTS SHALL BE RESPONSIBLE FOR CHECKING THE ACCURACY OF THE CONTENT OF THE COMPANY, WRITER AND SCALE CORRESPONDING TO THE CHECKED ON SITE, AND ANY DISCREPANCIES SHALL BE REPORTED TO THE PROJECT MANAGER TO BE CORRECTED ON SITE.
5. THE OWNER AND SPECIAL CONSULTANTS SHALL BE RESPONSIBLE TO CHANGE THROUGH DEVELOPED DESIGN IN ACCORDANCE WITH THE TERMS OF THE DEVELOPER'S CONSENT ORDER.

Index	Date	Changes	Writer	Checker
A	19/01/23	Original	ABO	GDA
B	07/03/23	SS1 advice update	ABO	GDA
C	03/10/23	Update for Deadline4	ABO	GDA

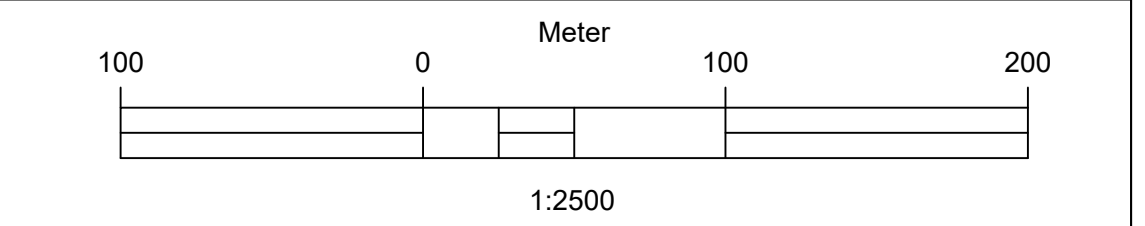

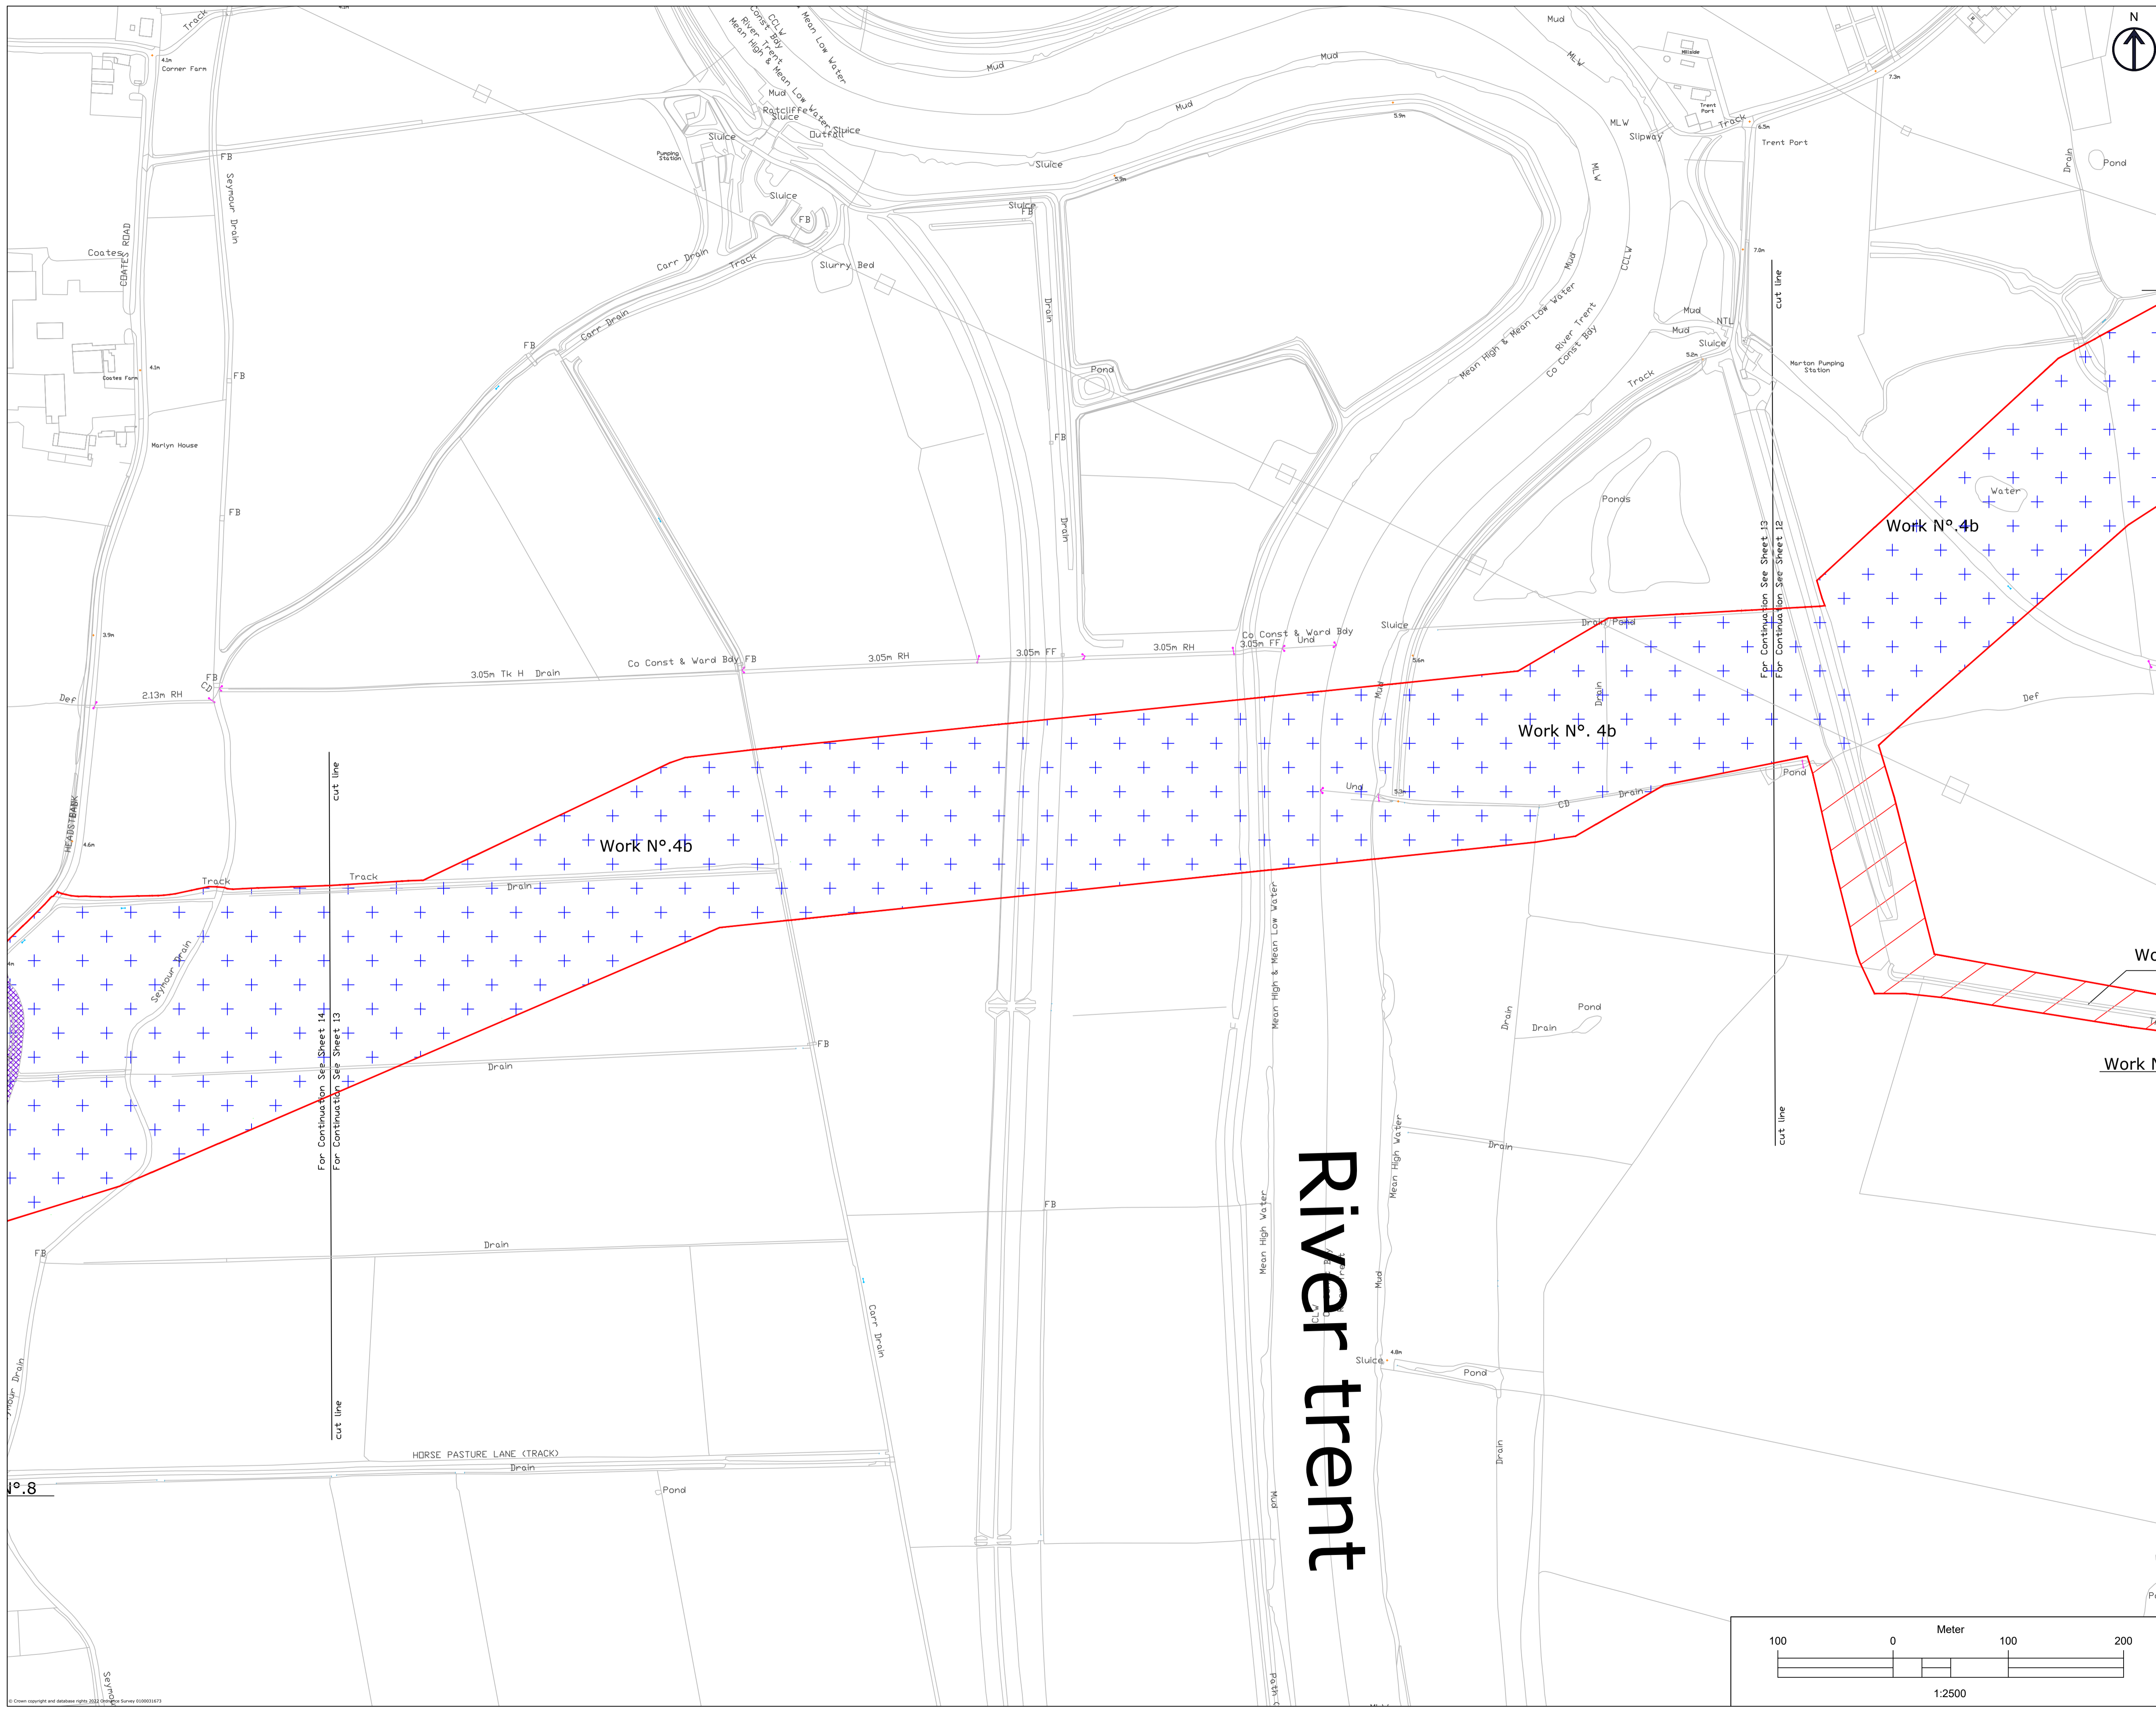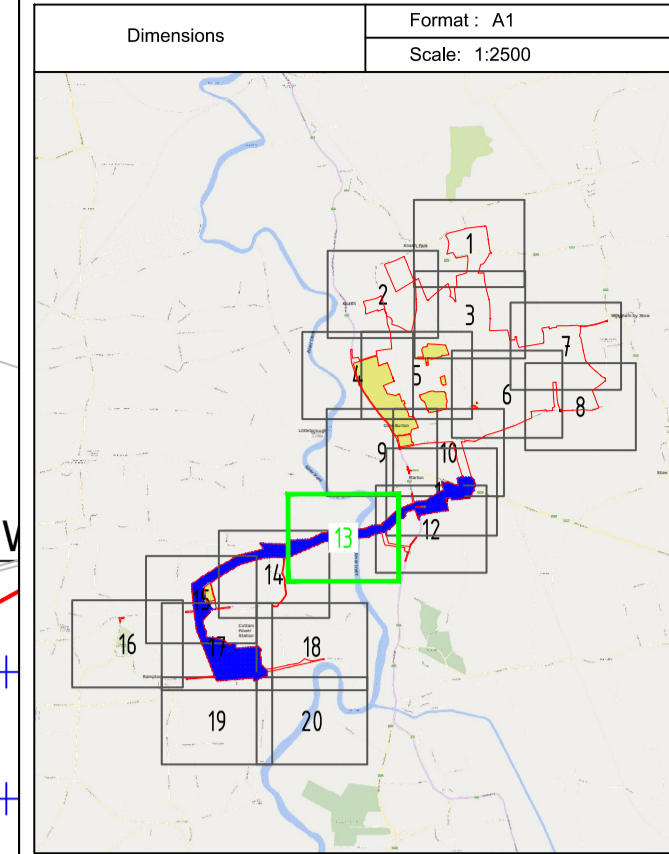




LEGEND

- Work No.1
- Work No.2
- Work No.3
- Work No.4a
- Work No.4b
- Work No.4c
- Work No.5
- Work No.6
- Work No.7
- Work No.8
- Work No.9
- Land not included in the Order limits

INDEX

Index	Date	Changes	Writer	Checker
A	19/01/23	Original	ABO	GDA
B	07/03/23	SS1 advice update	ABO	GDA
C	03/10/23	Update for Deadline4	ABO	GDA

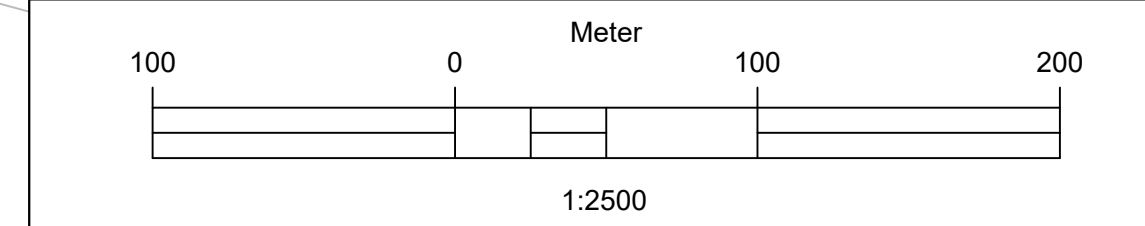

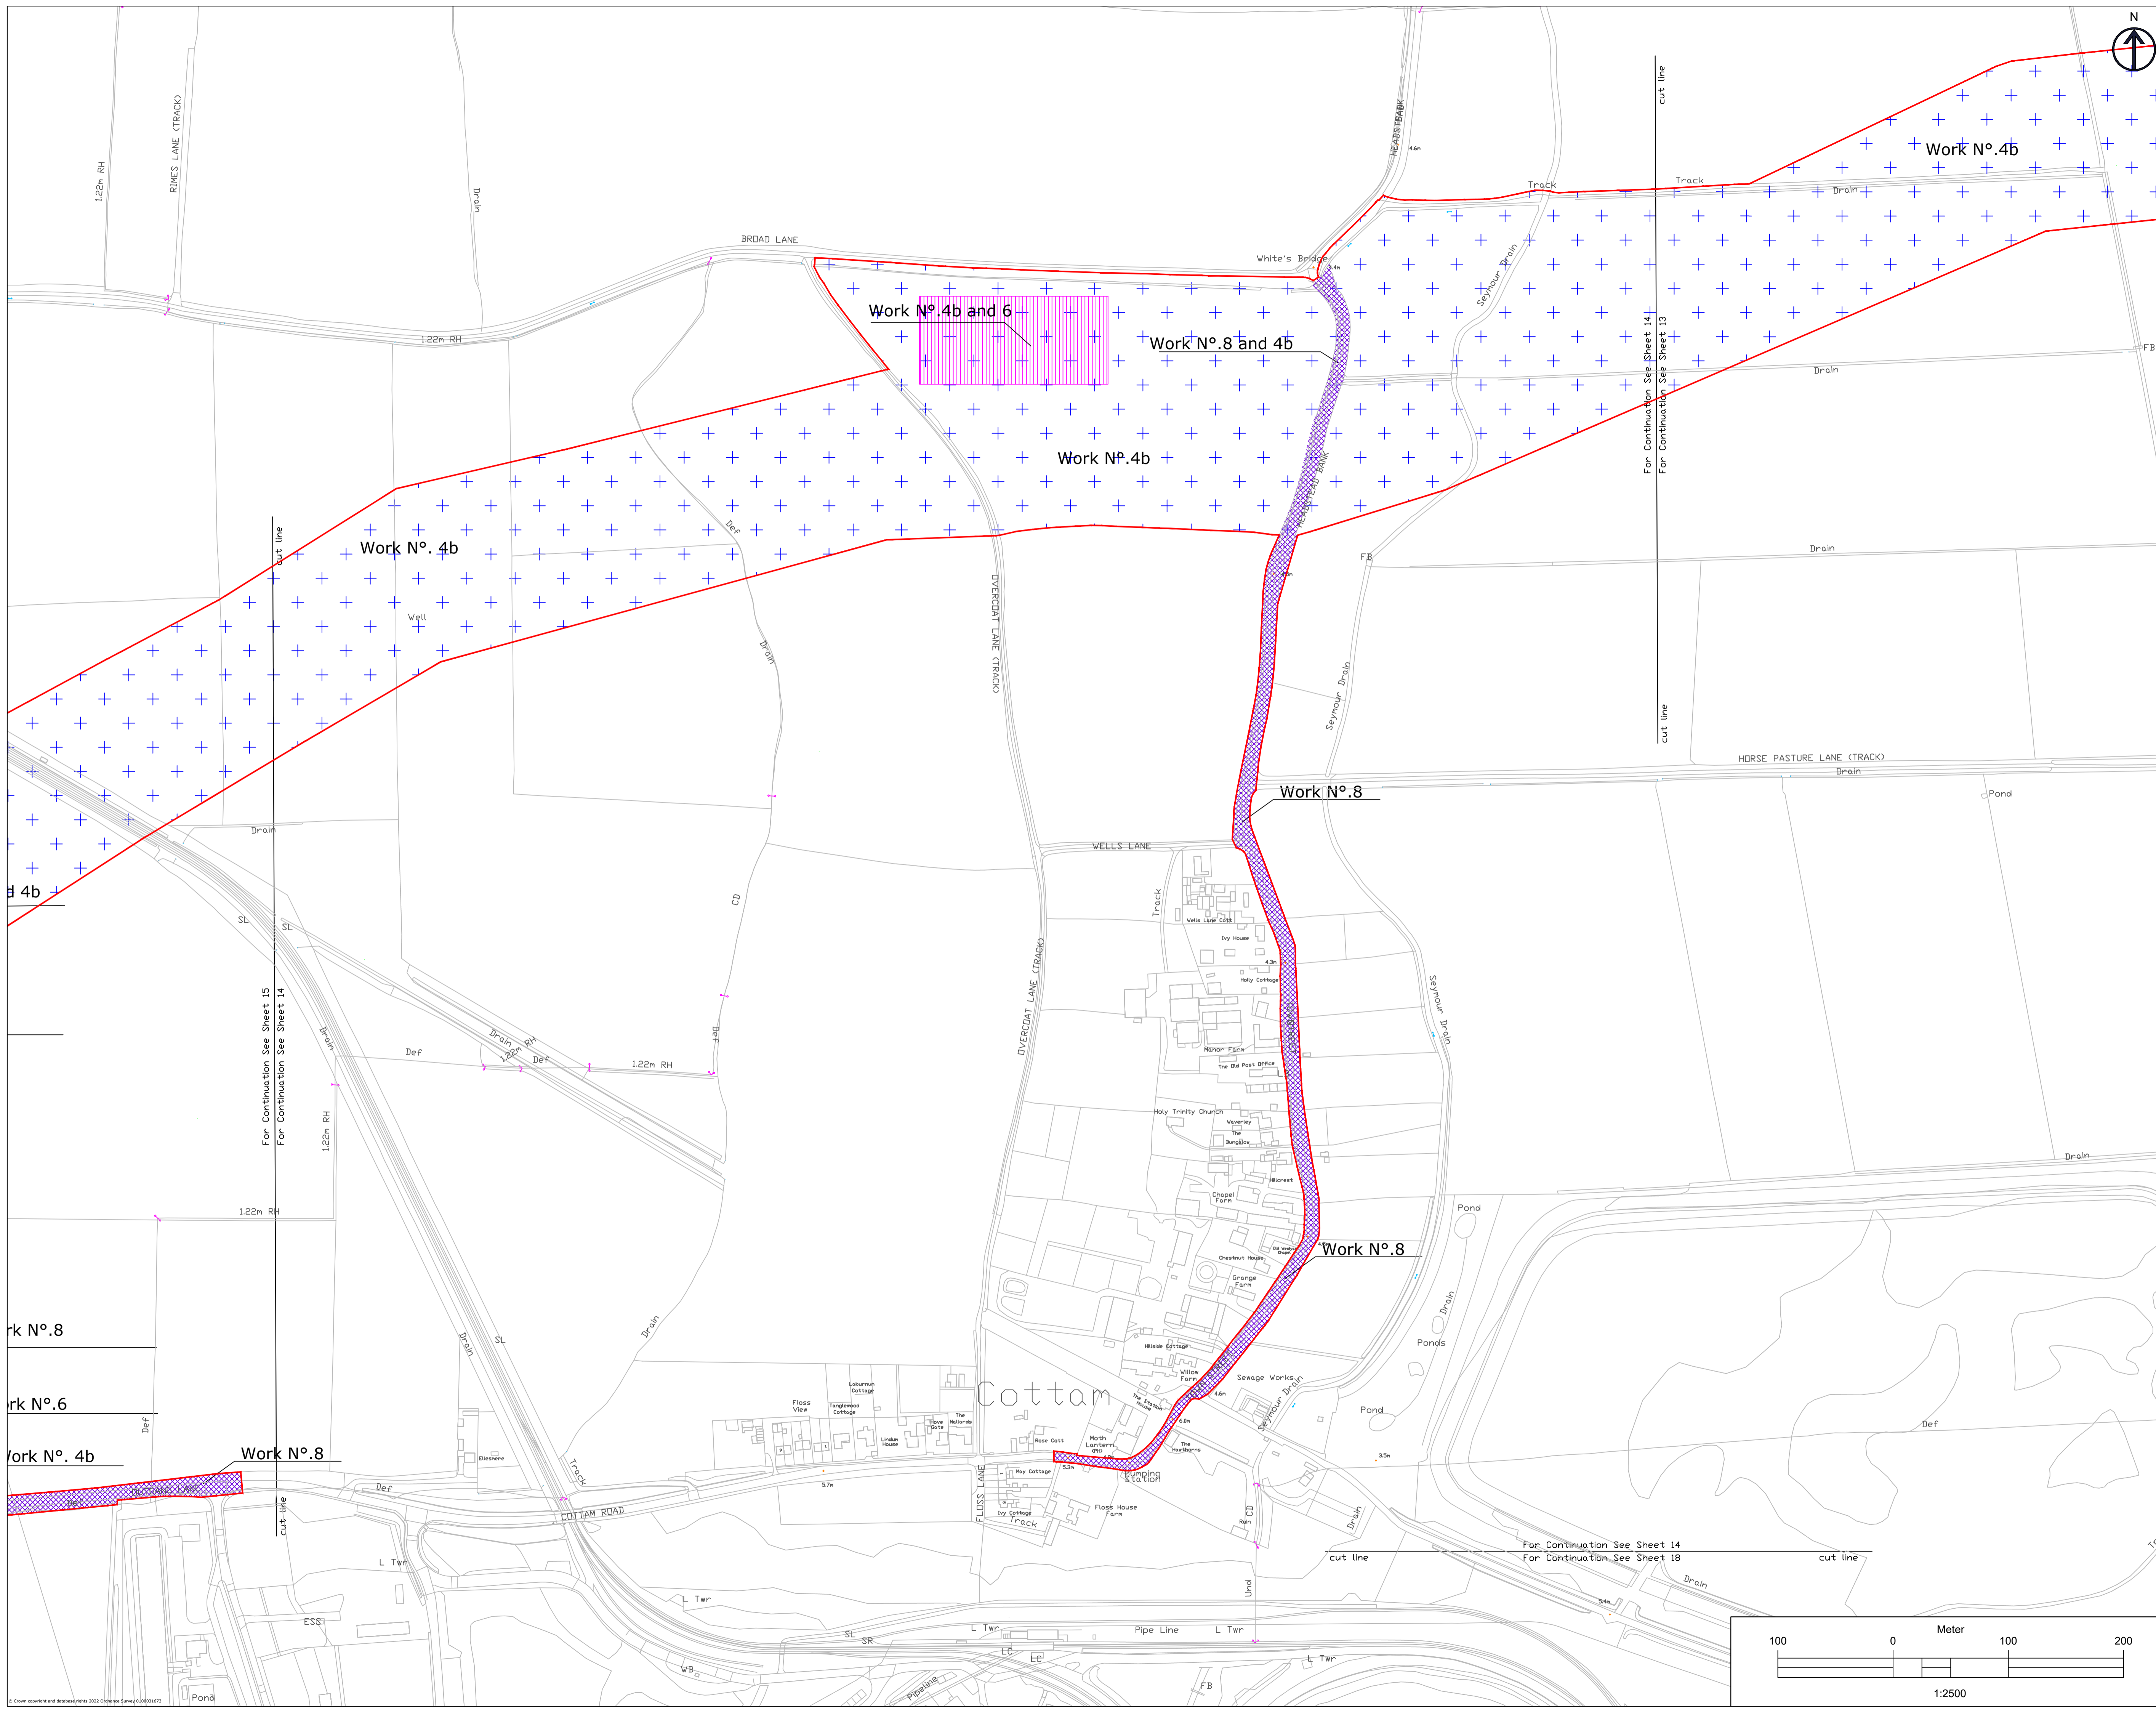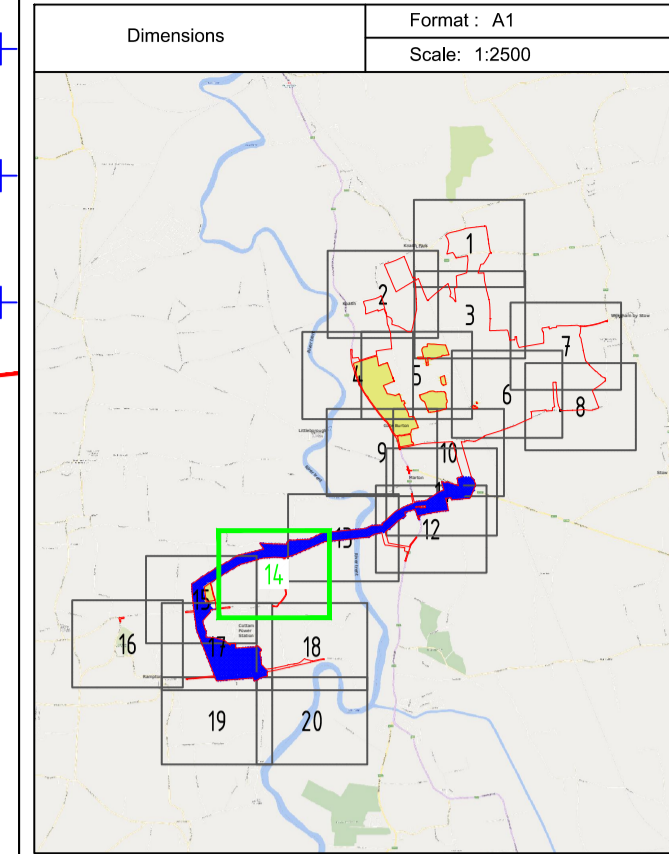




LEGEND

- Work No.1
- Work No.2
- Work No.3
- Work No.4a
- Work No.4b
- Work No.4c
- Work No.5
- Work No.6
- Work No.7
- Work No.8
- Work No.9
- Land not included in the Order limits

1. THIS DRAWING IS TO BE READ IN CONJUNCTION WITH ALL OTHER RELEVANT DOCUMENTATION.
2. WORKS MUST BE IN ACCORDANCE WITH REGULATIONS CONCERNING THE PROTECTION OF PLANNED OPERATIONS, PRECAUTIONS AND PROTECTIVE MEASURES.
3. ALL OPERATIONS, CONSTRUCTION AND CONSTRUCTION ARE IN METRES UNLESS OTHERWISE SPECIFIED.
4. THE WORKS ARE SUBJECT TO APPROVAL FROM THE LOCAL AUTHORITY AND ARE SUBJECT TO CHANGE THROUGH DETAILED DESIGN IN ACCORDANCE WITH THE TERMS OF THE DEVELOPMENT CONSENT ORDER.
5. THE WORKS ARE SUBJECT TO APPROVAL FROM THE LOCAL AUTHORITY AND ARE SUBJECT TO CHANGE THROUGH DETAILED DESIGN IN ACCORDANCE WITH THE TERMS OF THE DEVELOPMENT CONSENT ORDER.

Index	Date	Changes	Writer	Checker
A	19/01/23	Original	ABO	GDA
B	07/03/23	S51 advice update	ABO	GDA
C	03/10/23	Update for Deadline	ABO	GDA

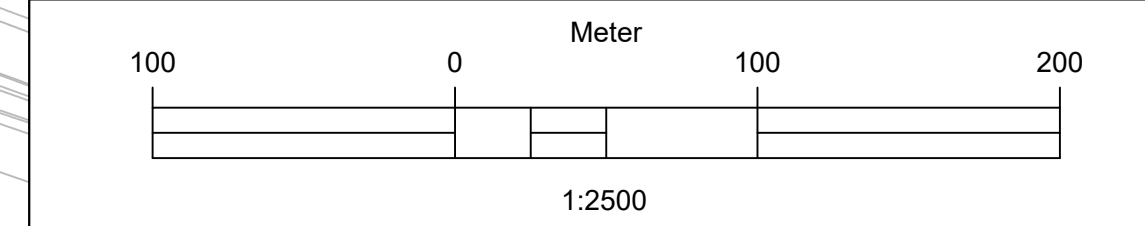

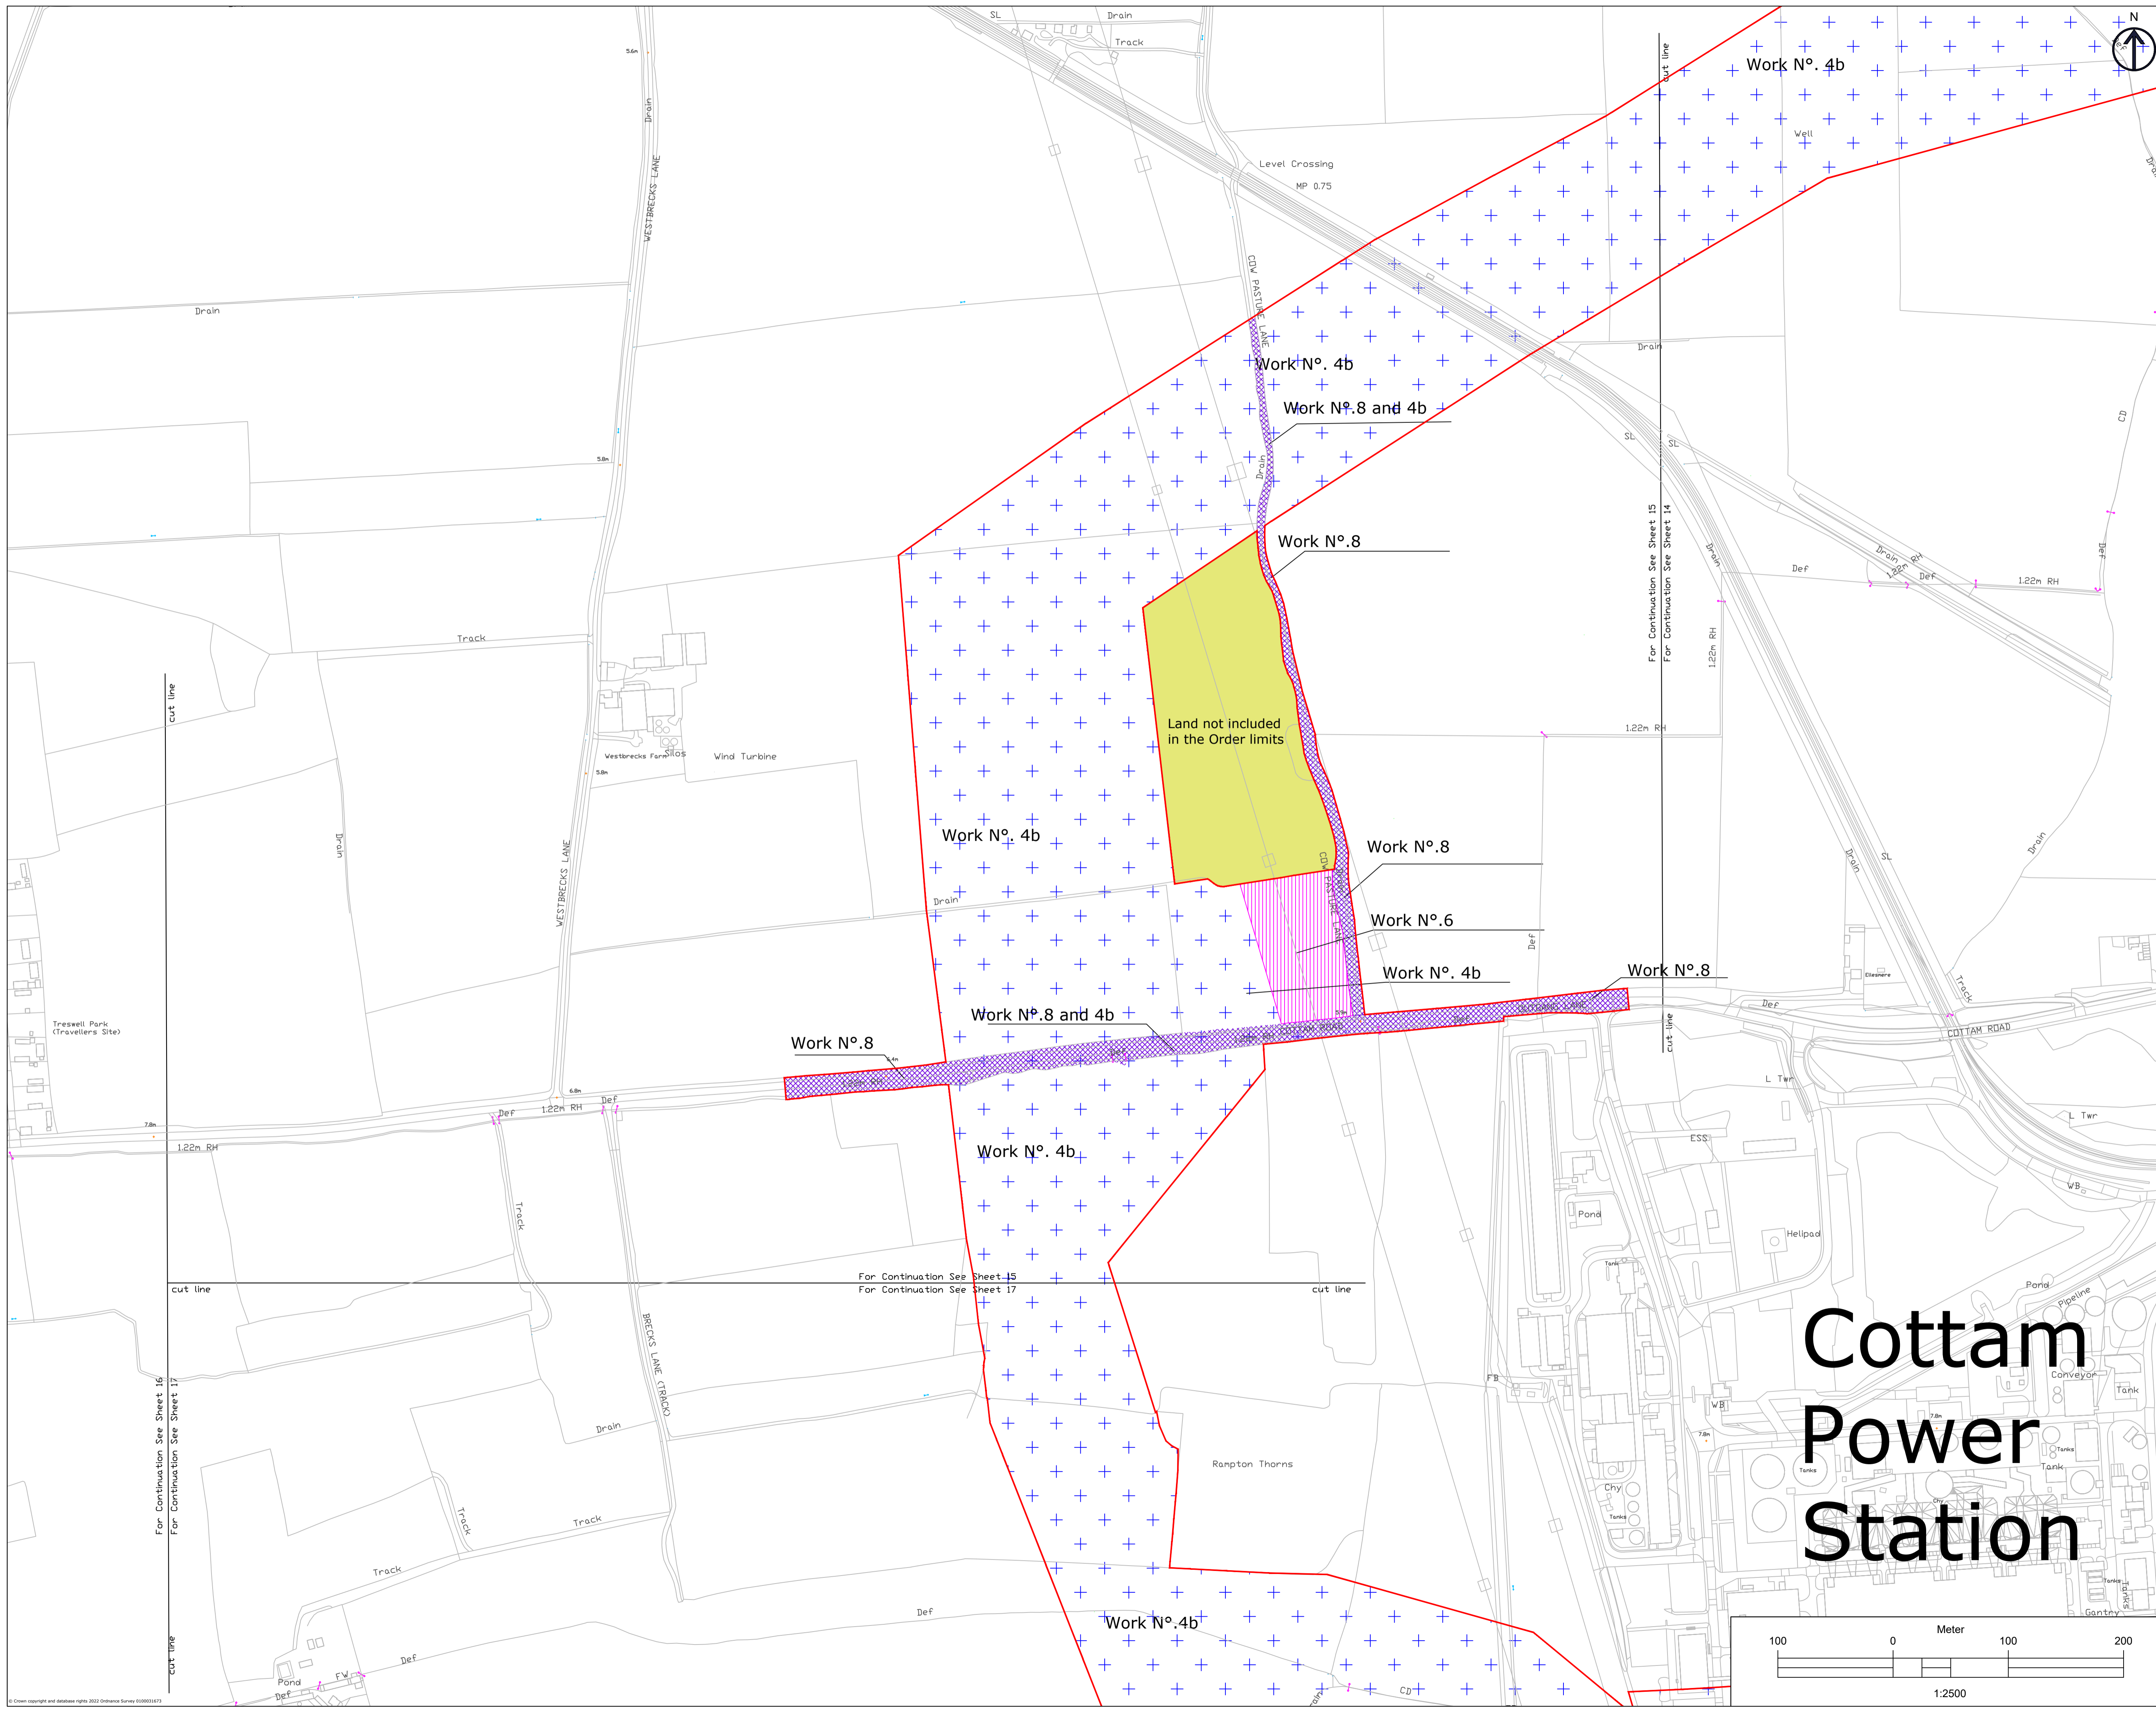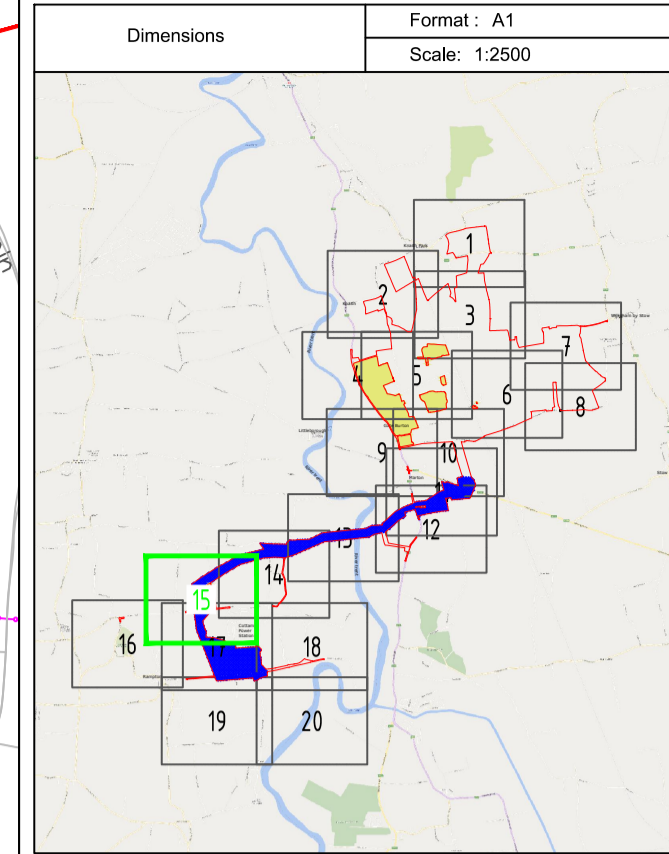


Cottam Power Station



LEGEND

- Work No.1
- Work No.2
- Work No.3
- Work No.4a
- Work No.4b
- Work No.4c
- Work No.5
- Work No.6
- Work No.7
- Work No.8
- Work No.9
- Land not included in the Order limits

1. THIS DRAWING IS TO BE READ IN CONJUNCTION WITH ALL OTHER RELEVANT DOCUMENTATION.
2. WORKS MUST BE IN ACCORDANCE WITH REGULATIONS AND THE INSTRUCTIONS IN THESE SPECIFICATIONS.
3. ALL DIMENSIONS, UNLESS OTHERWISE SPECIFIED, ARE IN METRES UNLESS OTHERWISE SPECIFIED.
4. ALL DIMENSIONS, CORNERS, LEVELS AND COORDINATES ARE TO BE CHECKED ON SITE, AND ANY DISCREPANCIES ARE TO BE REPORTED TO THE PROJECT MANAGER IMMEDIATELY.
5. THE WORKER IS RESPONSIBLE FOR CHECKING THE LOCATION OF ALL WORK POINTS TO BE MARKED ON SITE.
6. THE WORKER IS RESPONSIBLE FOR CHECKING THE LOCATION OF ALL WORK POINTS TO BE MARKED ON SITE.
7. THE WORKER IS RESPONSIBLE FOR CHECKING THE LOCATION OF ALL WORK POINTS TO BE MARKED ON SITE.

Index	Date	Changes	Writer	Checker
A	18/01/23	Original	ABO	GDA
B	07/03/23	SS1 advice update	ABO	GDA
C	03/10/23	Update for Deadline	ABO	GDA

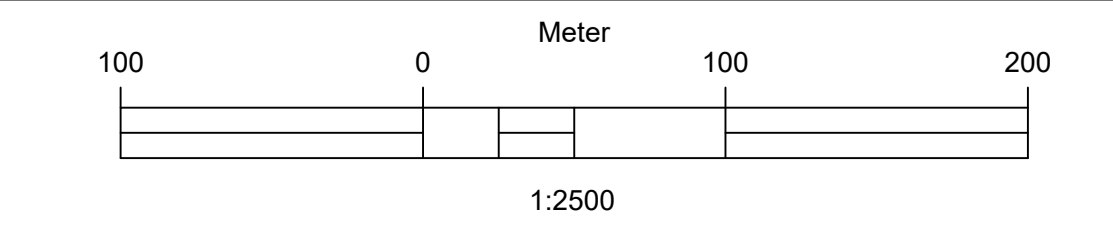

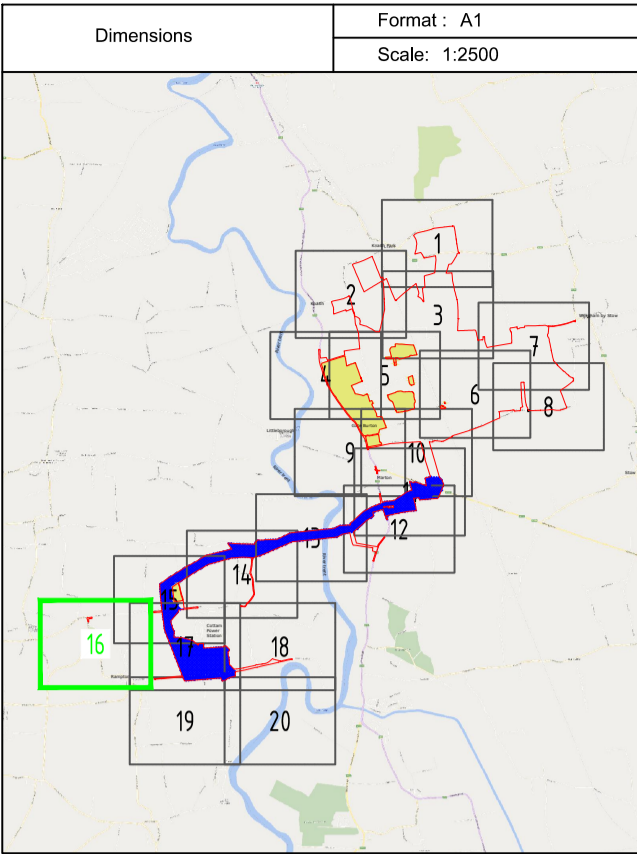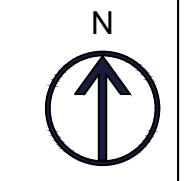


LEGEND



- Work No.1
- Work No.2
- Work No.3
- Work No.4a
- Work No.4b
- Work No.4c
- Work No.5
- Work No.6
- Work No.7
- Work No.8
- Work No.9
- Land not included in the Order limits

1. THIS DRAWING IS TO BE READ IN CONJUNCTION WITH ALL OTHER RELEVANT DOCUMENTATION.
 2. WORKS SHALL BE IN ACCORDANCE WITH THE SPECIFICATIONS AND PROCEDURES IN ALL APPLICABLE SPECIFICATIONS AND PROCEDURES AND REGULATIONS.
 3. ALL DIMENSIONS, COORDINATES, LEVELS AND CONTROLS ARE IN METRES UNLESS SPECIFICALLY STATED OTHERWISE.
 4. THE WORKER SHALL BE RESPONSIBLE FOR CHECKING ALL DIMENSIONS AND COORDINATES ON SITE AND ANY DISCREPANCIES SHALL BE REPORTED TO THE PROJECT MANAGER IMMEDIATELY.
 5. THE WORKER SHALL BE RESPONSIBLE FOR CHECKING ALL DIMENSIONS AND COORDINATES ON SITE AND ANY DISCREPANCIES SHALL BE REPORTED TO THE PROJECT MANAGER IMMEDIATELY.

Index	Date	Changes	Writer	Checker
A	19/01/23	Original	ABO	GDA
B	07/03/23	SS1 advice update	ABO	GDA
C	03/10/23	Update for Deadline	ABO	GDA

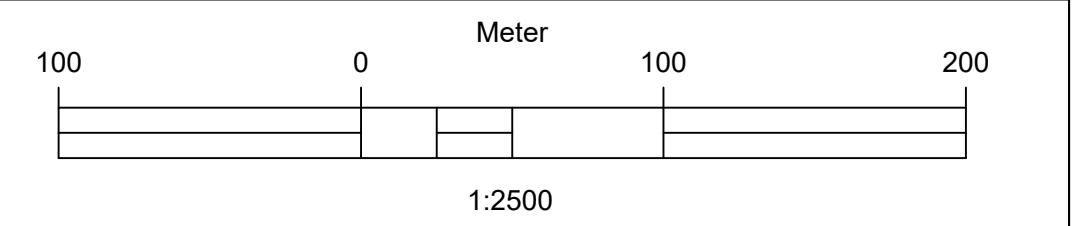

Rampton

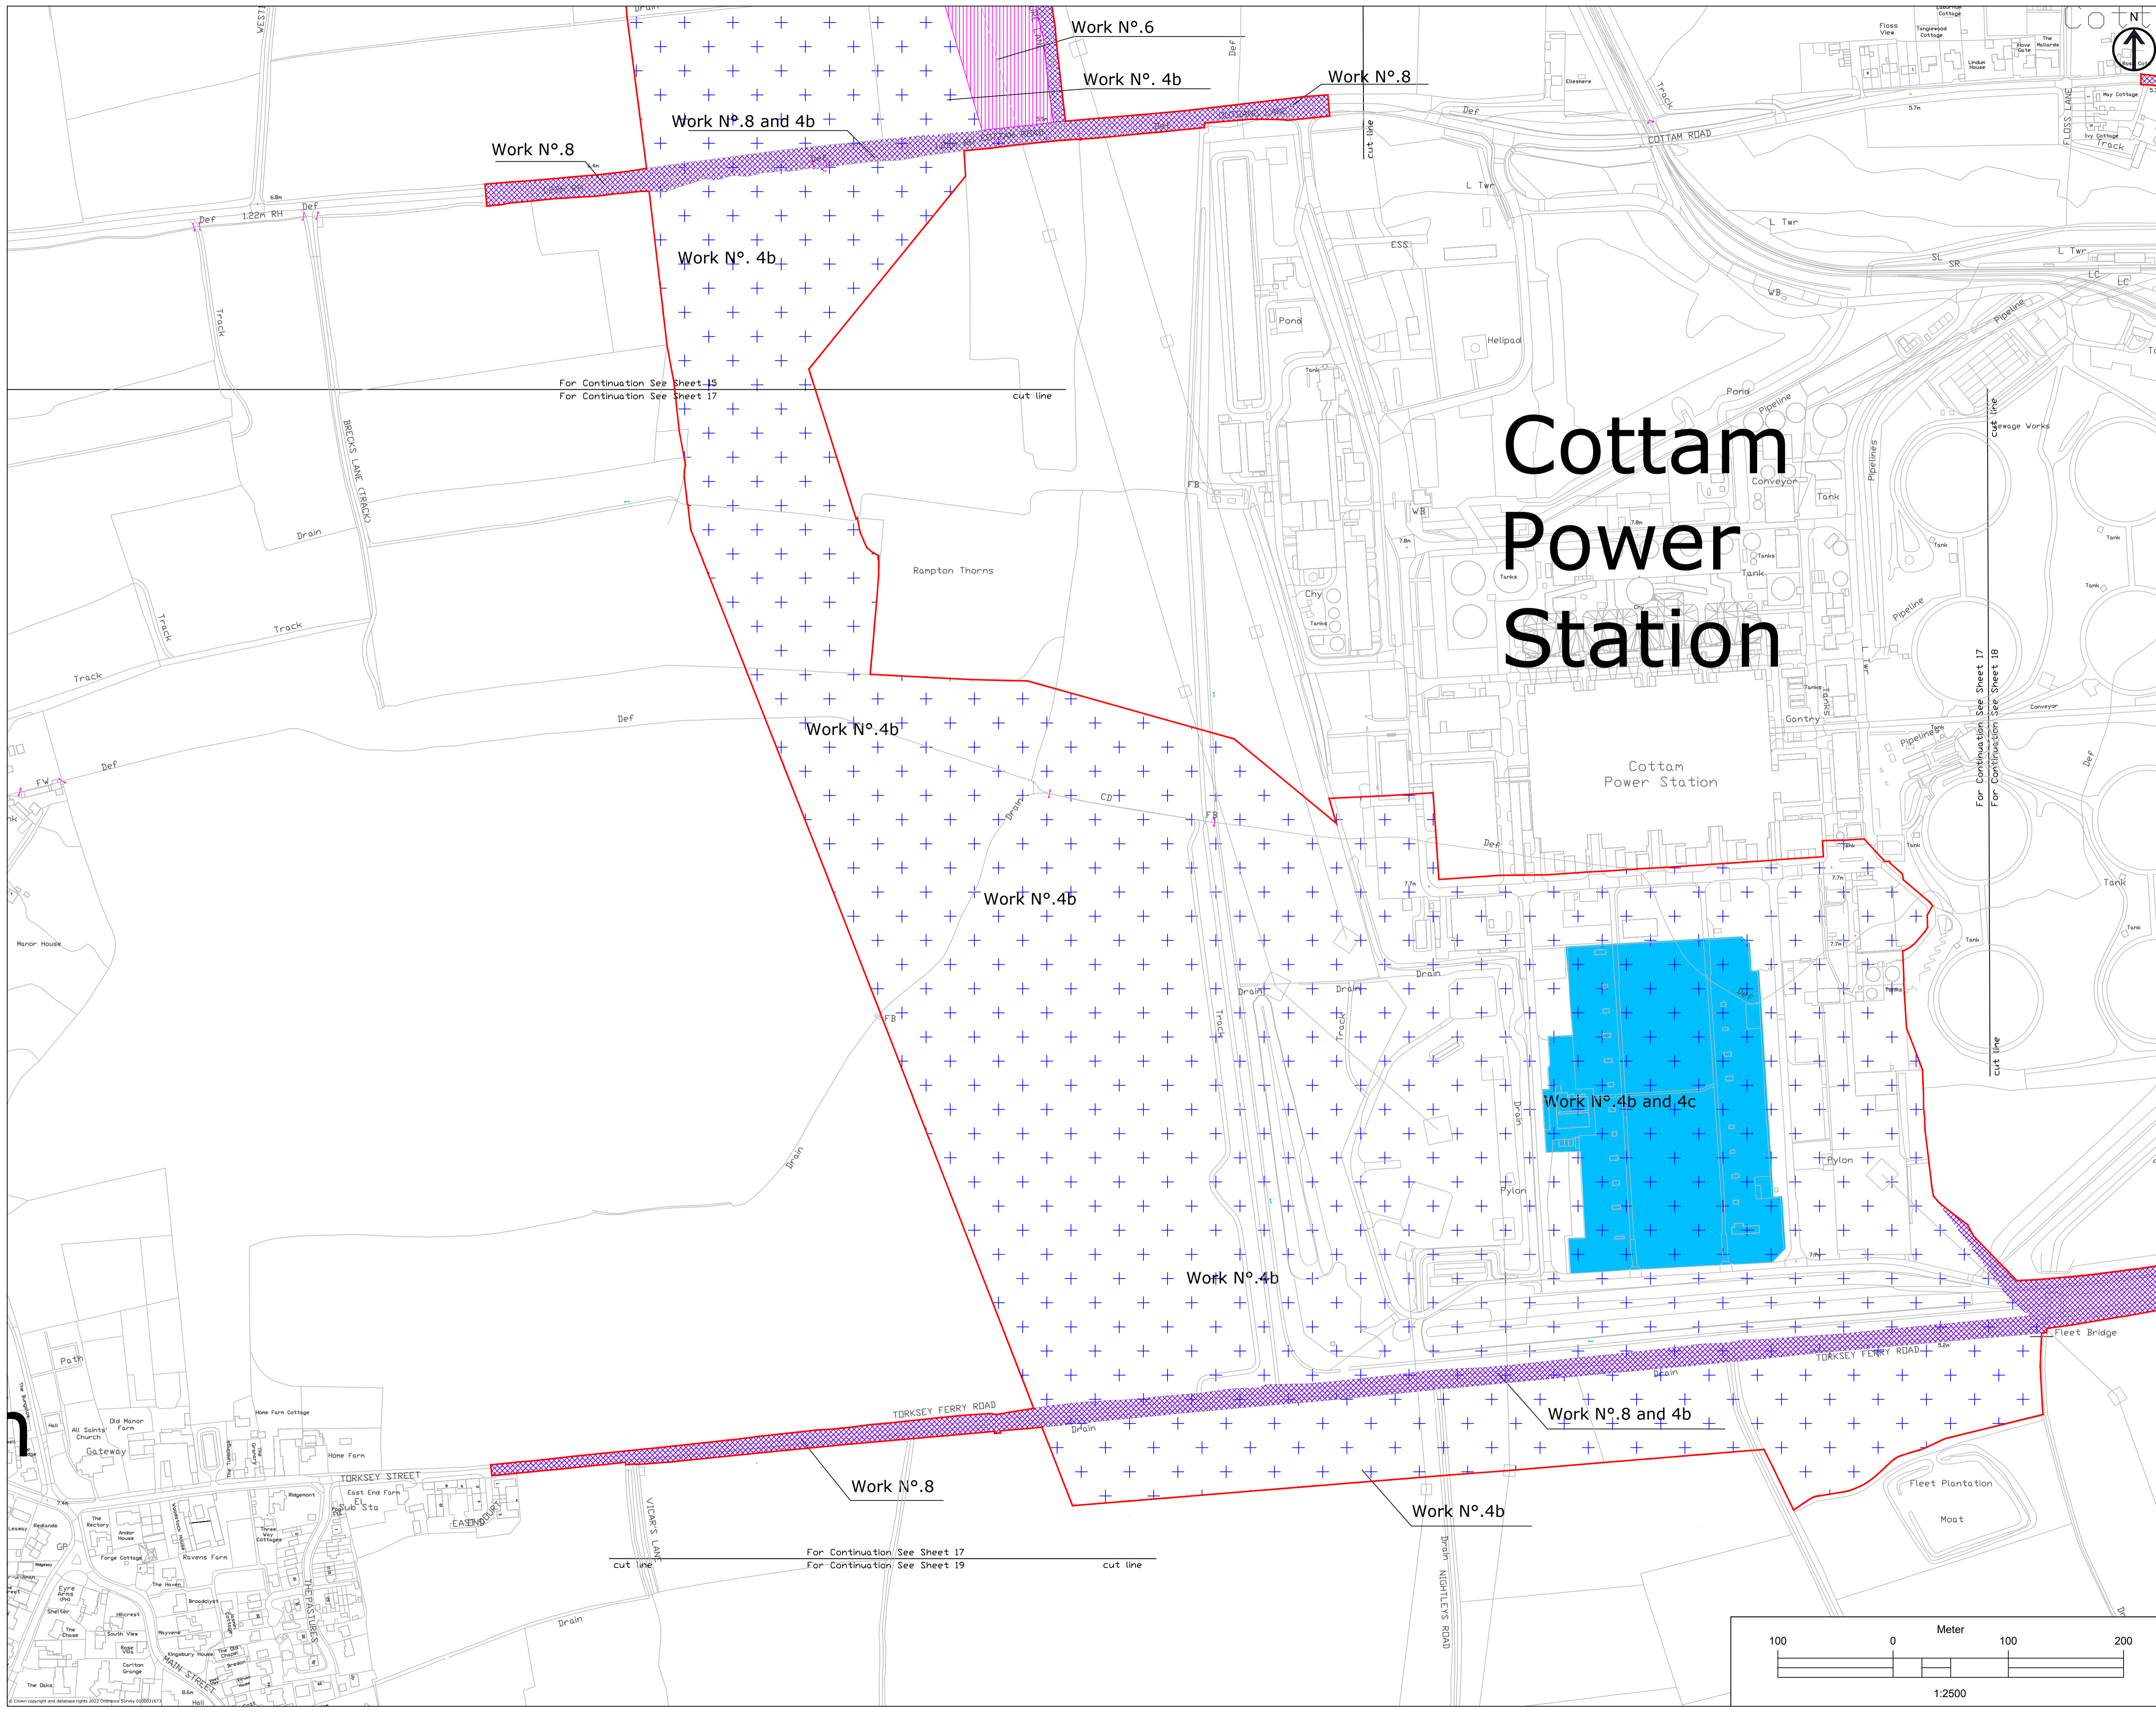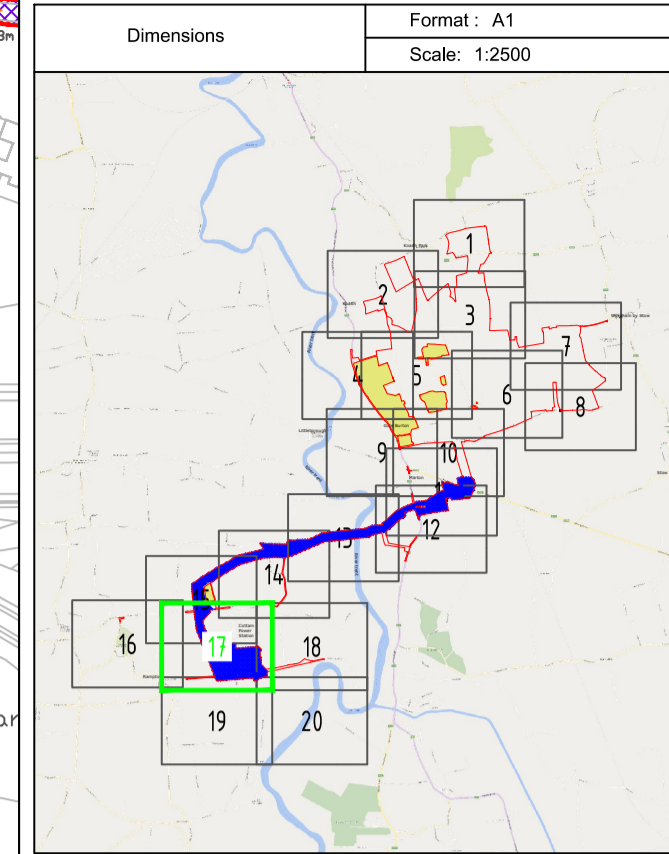


Cottam Power Station



LEGEND

- Work No.1
- Work No.2
- Work No.3
- Work No.4a
- Work No.4b
- Work No.4c
- Work No.5
- Work No.6
- Work No.7
- Work No.8
- Work No.9
- Land not included in the Order limits

1. THIS DRAWING IS TO BE READ IN CONJUNCTION WITH ALL OTHER RELEVANT DOCUMENTATION.
2. WORKS SHALL BE IN ACCORDANCE WITH THE SPECIFICATIONS AND REGULATIONS OF THE RELEVANT AUTHORITIES.
3. ALL DIMENSIONS, UNLESS OTHERWISE SPECIFIED, ARE IN METRES UNLESS OTHERWISE SPECIFIED.
4. ALL DIMENSIONS, CORNERS, LEVELS AND COORDINATES ARE TO BE CHECKED ON SITE, AND ANY DISCREPANCIES SHALL BE REPORTED IMMEDIATELY TO THE PROJECT MANAGER.
5. THE WORKS ARE SUBJECT TO CHANGE THROUGHOUT THE PROJECT TO ACCORDANCE WITH THE TERMS OF THE DEVELOPMENT CONSENT ORDER.

Index	Date	Changes	Writer	Checker
A	18/01/23	Original	ABO	GDA
B	07/03/23	S&I advice update	ABO	GDA
C	03/10/23	Update for Deadline	ABO	GDA

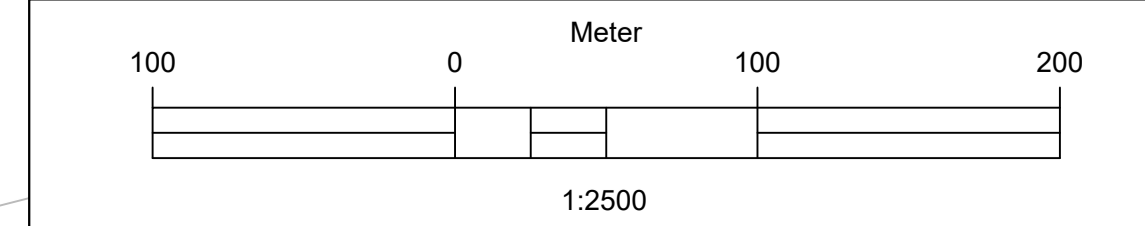

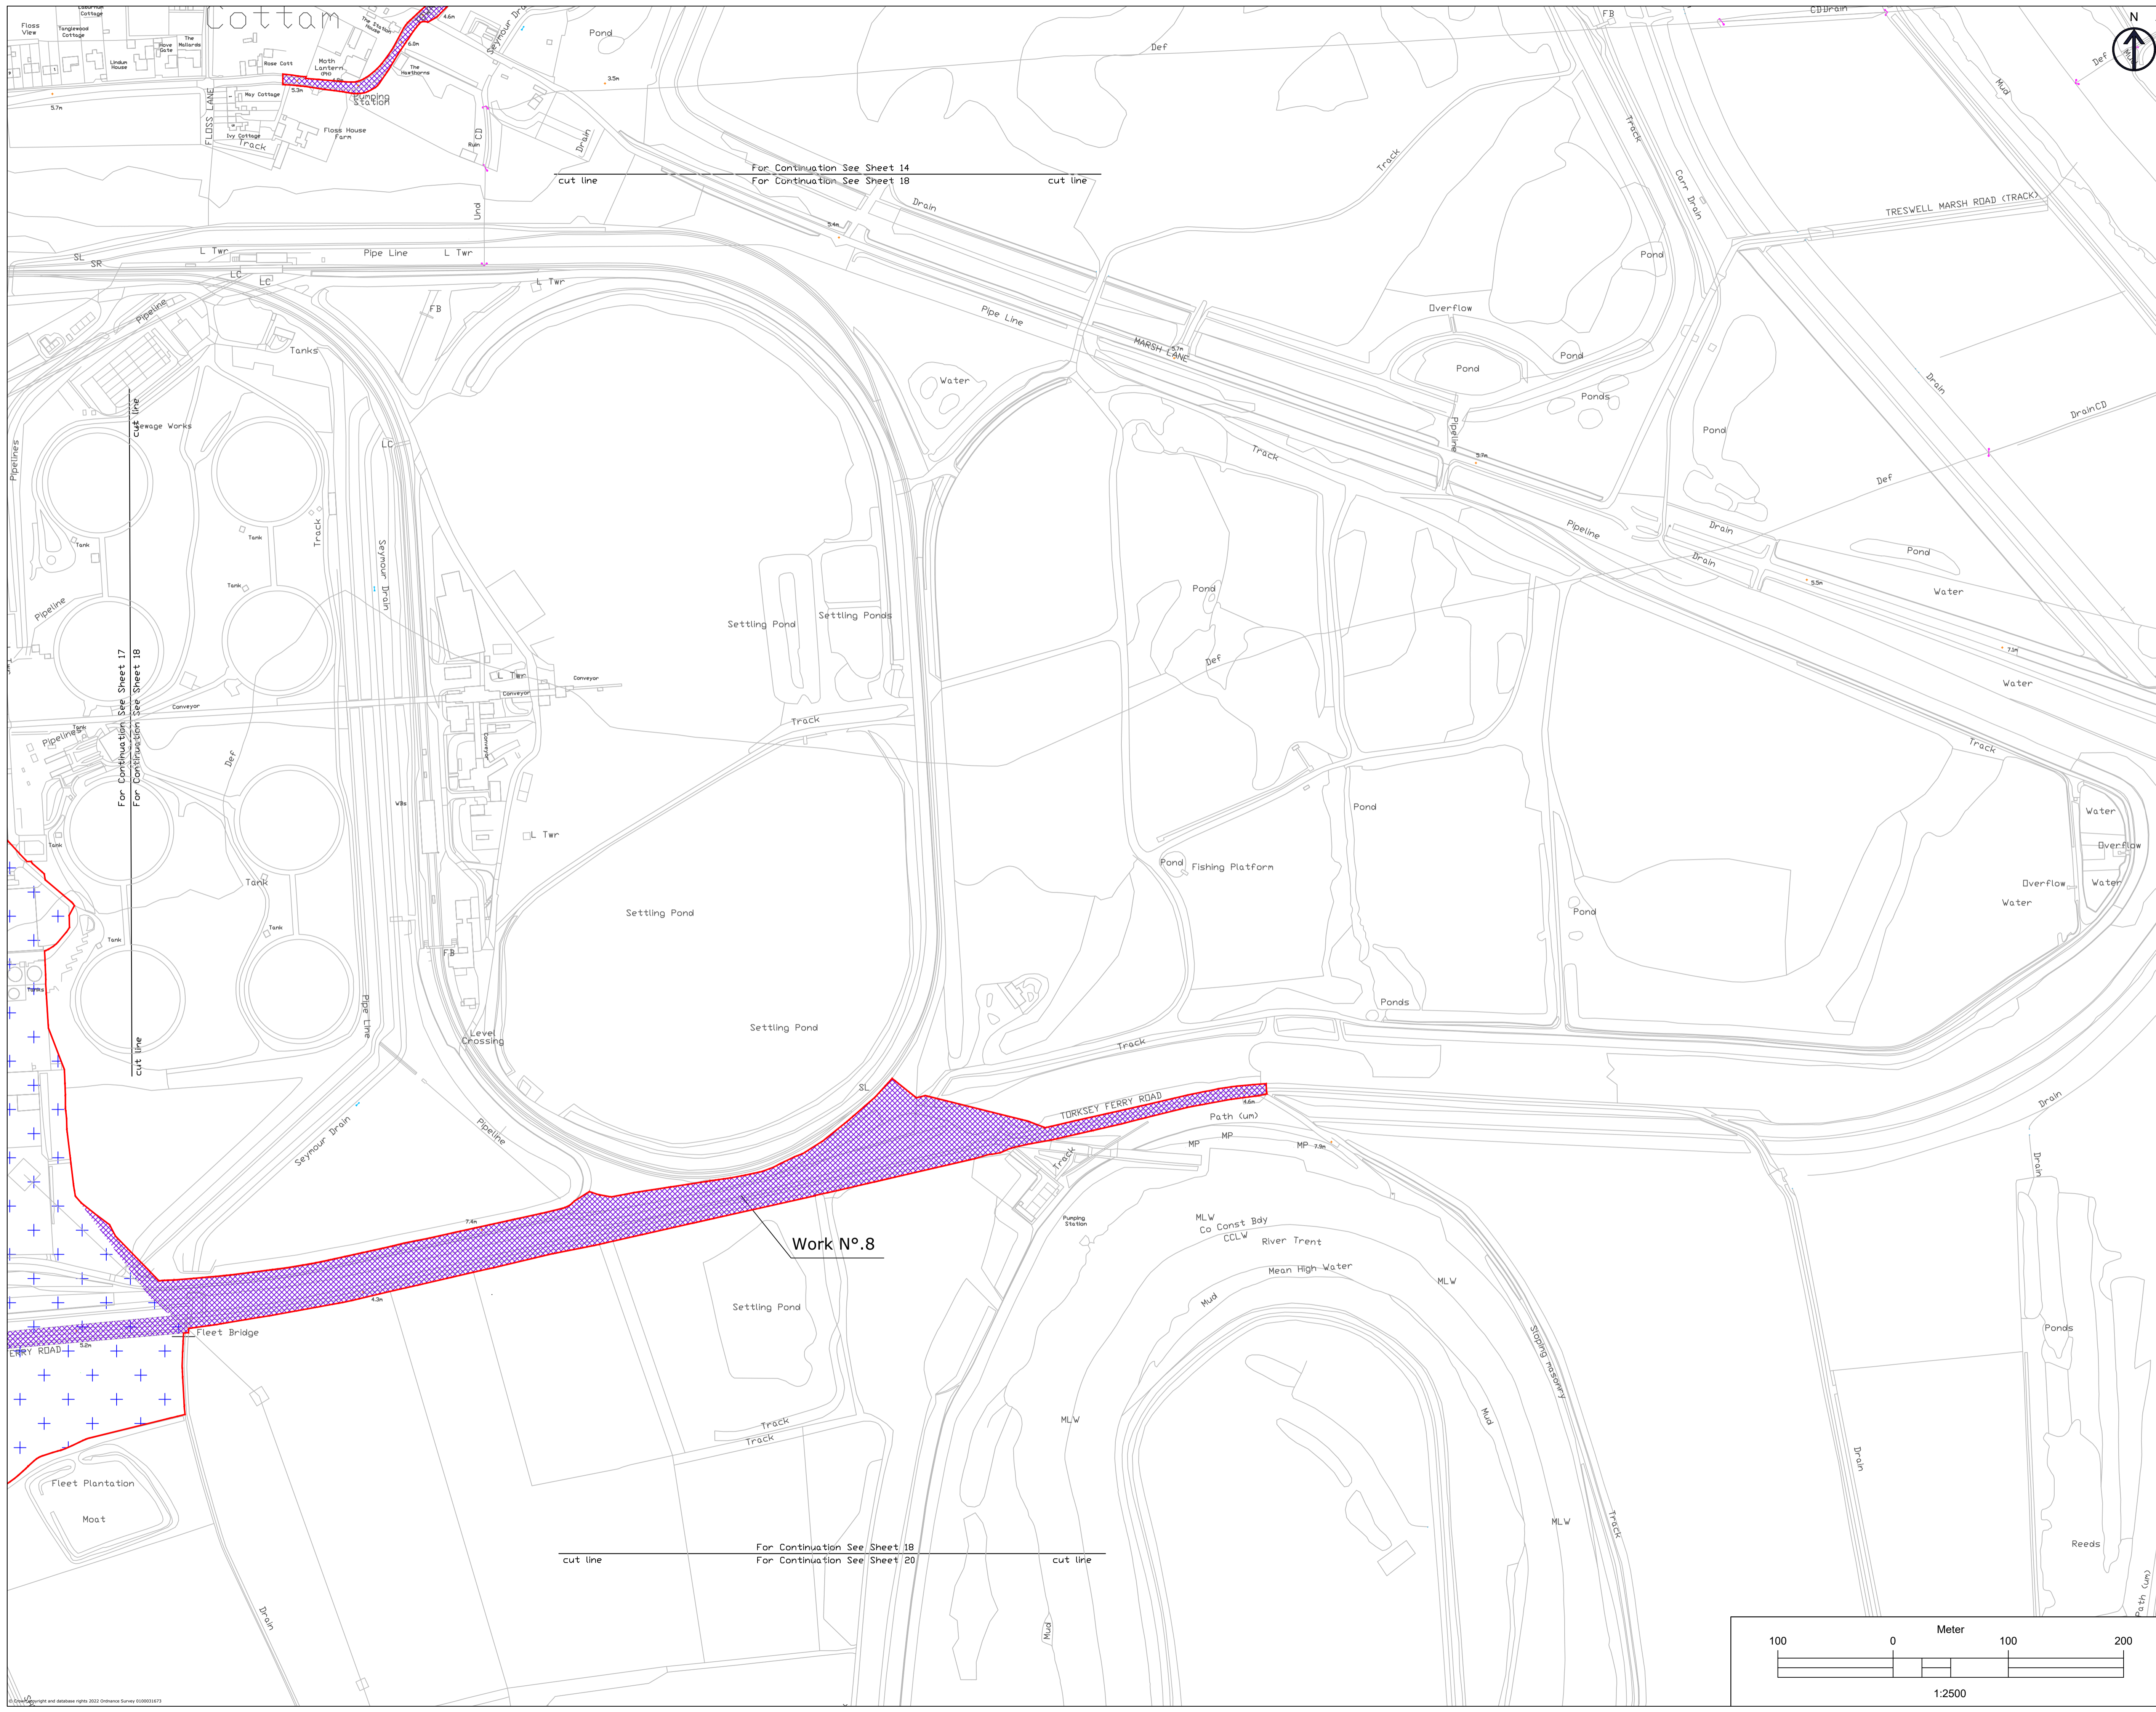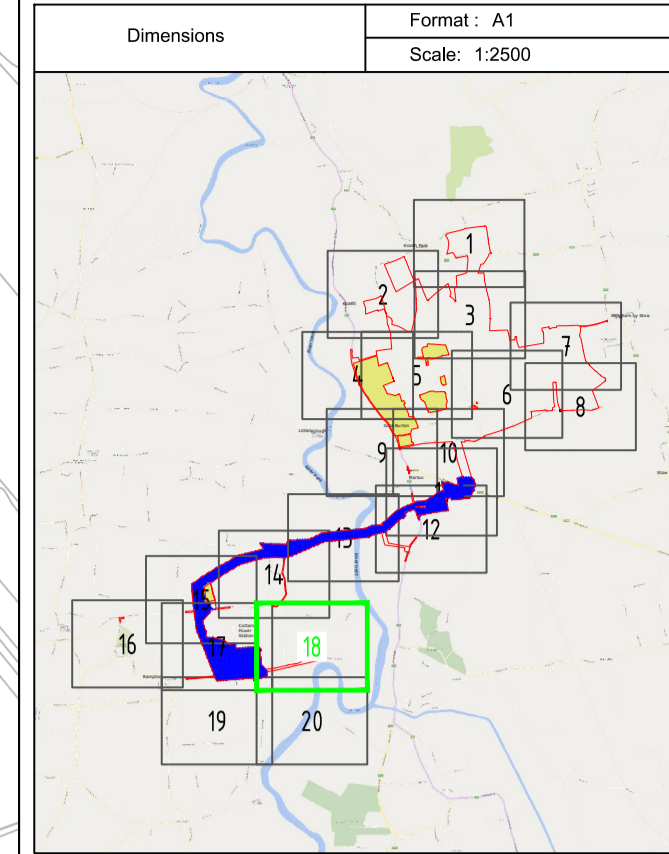


LEGEND

- Work No.1
- Work No.2
- Work No.3
- Work No.4a
- Work No.4b
- Work No.4c
- Work No.5
- Work No.6
- Work No.7
- Work No.8
- Work No.9
- Land not included in the Order limits

1. THIS DRAWING IS TO BE READ IN CONJUNCTION WITH ALL OTHER RELEVANT DOCUMENTATION.
 2. WORKS MUST BE IN ACCORDANCE WITH THE RELEVANT RULES OF THE PROFESSION IN ALL APPLICABLE JURISDICTIONS.
 3. ALL DIMENSIONS, COORDINATES, LEVELS AND CONFORMANCES ARE IN METRES UNLESS OTHERWISE SPECIFIED.
 4. THE OWNER AND DESIGNER ACCEPTS THAT THE DRAWING IS FOR INFORMATION ONLY AND IS NOT TO BE USED FOR CONSTRUCTION WITHOUT THE EXPRESS WRITTEN CONSENT OF THE COMPANY. WRITTEN AND SIGNED CONSENTS TO BE CHECKED ON SITE AND ANY DISCREPANCIES SPECIFICALLY REPORTED TO THE PROJECT MANAGER IMMEDIATELY.
 5. THE OWNER AND DESIGNER ACCEPTS THAT THE DRAWING IS SUBJECT TO CHANGE THROUGH DETAILED DESIGN IN ACCORDANCE WITH THE TERMS OF THE DEVELOPMENT CONSENT DECISION.

Index	Date	Changes	Writer	Checker
A	19/01/23	Original	ABO	GDA
B	07/03/23	SS1 advice update	ABO	GDA
C	03/10/23	Update for Deadlined	ABO	GDA

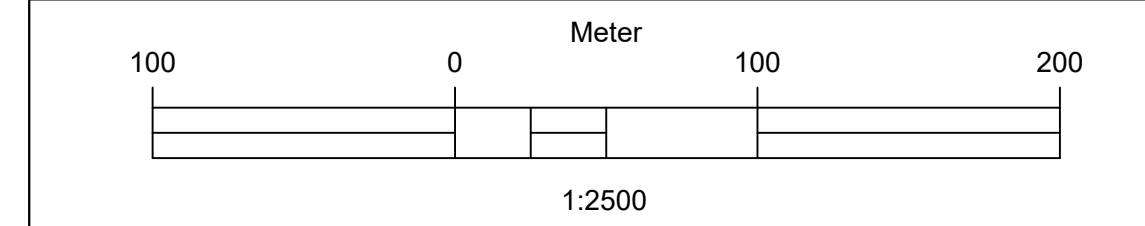




SHEET NOT USED AS PART
OF THIS DRAWING SERIES

Work N°.8

Work N°.4b

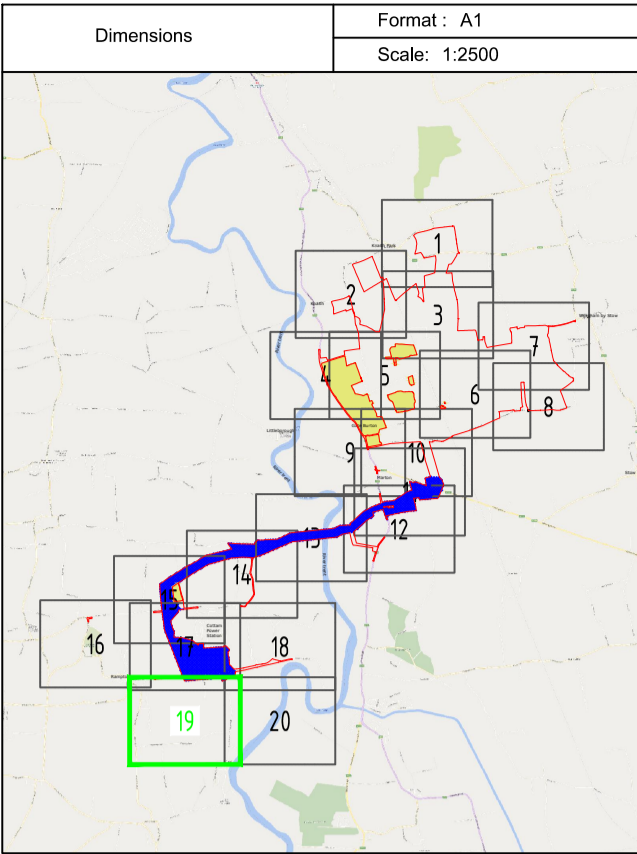

1. THIS DRAWING IS TO BE READ IN CONJUNCTION WITH ALL OTHER RELEVANT DOCUMENTATION.
 2. WORKS MUST BE IN ACCORDANCE WITH REGULATIONS AND THE INSTRUCTIONS IN THESE DRAWINGS.
 3. ALL DIMENSIONS, COORDINATES, LEVELS AND CORRECTIONS ARE IN METRES UNLESS OTHERWISE SPECIFIED.
 4. THE WORKER SHALL BE RESPONSIBLE FOR CHECKING THE DIMENSIONS AND LEVELS ON SITE AND ANY DISCREPANCIES SHALL BE REPORTED TO THE PROJECT MANAGER IMMEDIATELY.
 5. THE WORKER SHALL BE RESPONSIBLE FOR CHECKING THE DIMENSIONS AND LEVELS ON SITE AND ANY DISCREPANCIES SHALL BE REPORTED TO THE PROJECT MANAGER IMMEDIATELY.

Index	Date	Changes	Writer	Checker
A	19/01/23	Original	ABO	GDA
B	07/03/23	SS1 advice update	ABO	GDA
C	03/10/23	Update for Deadline	ABO	GDA

