



# Gate Burton Energy Park


 


 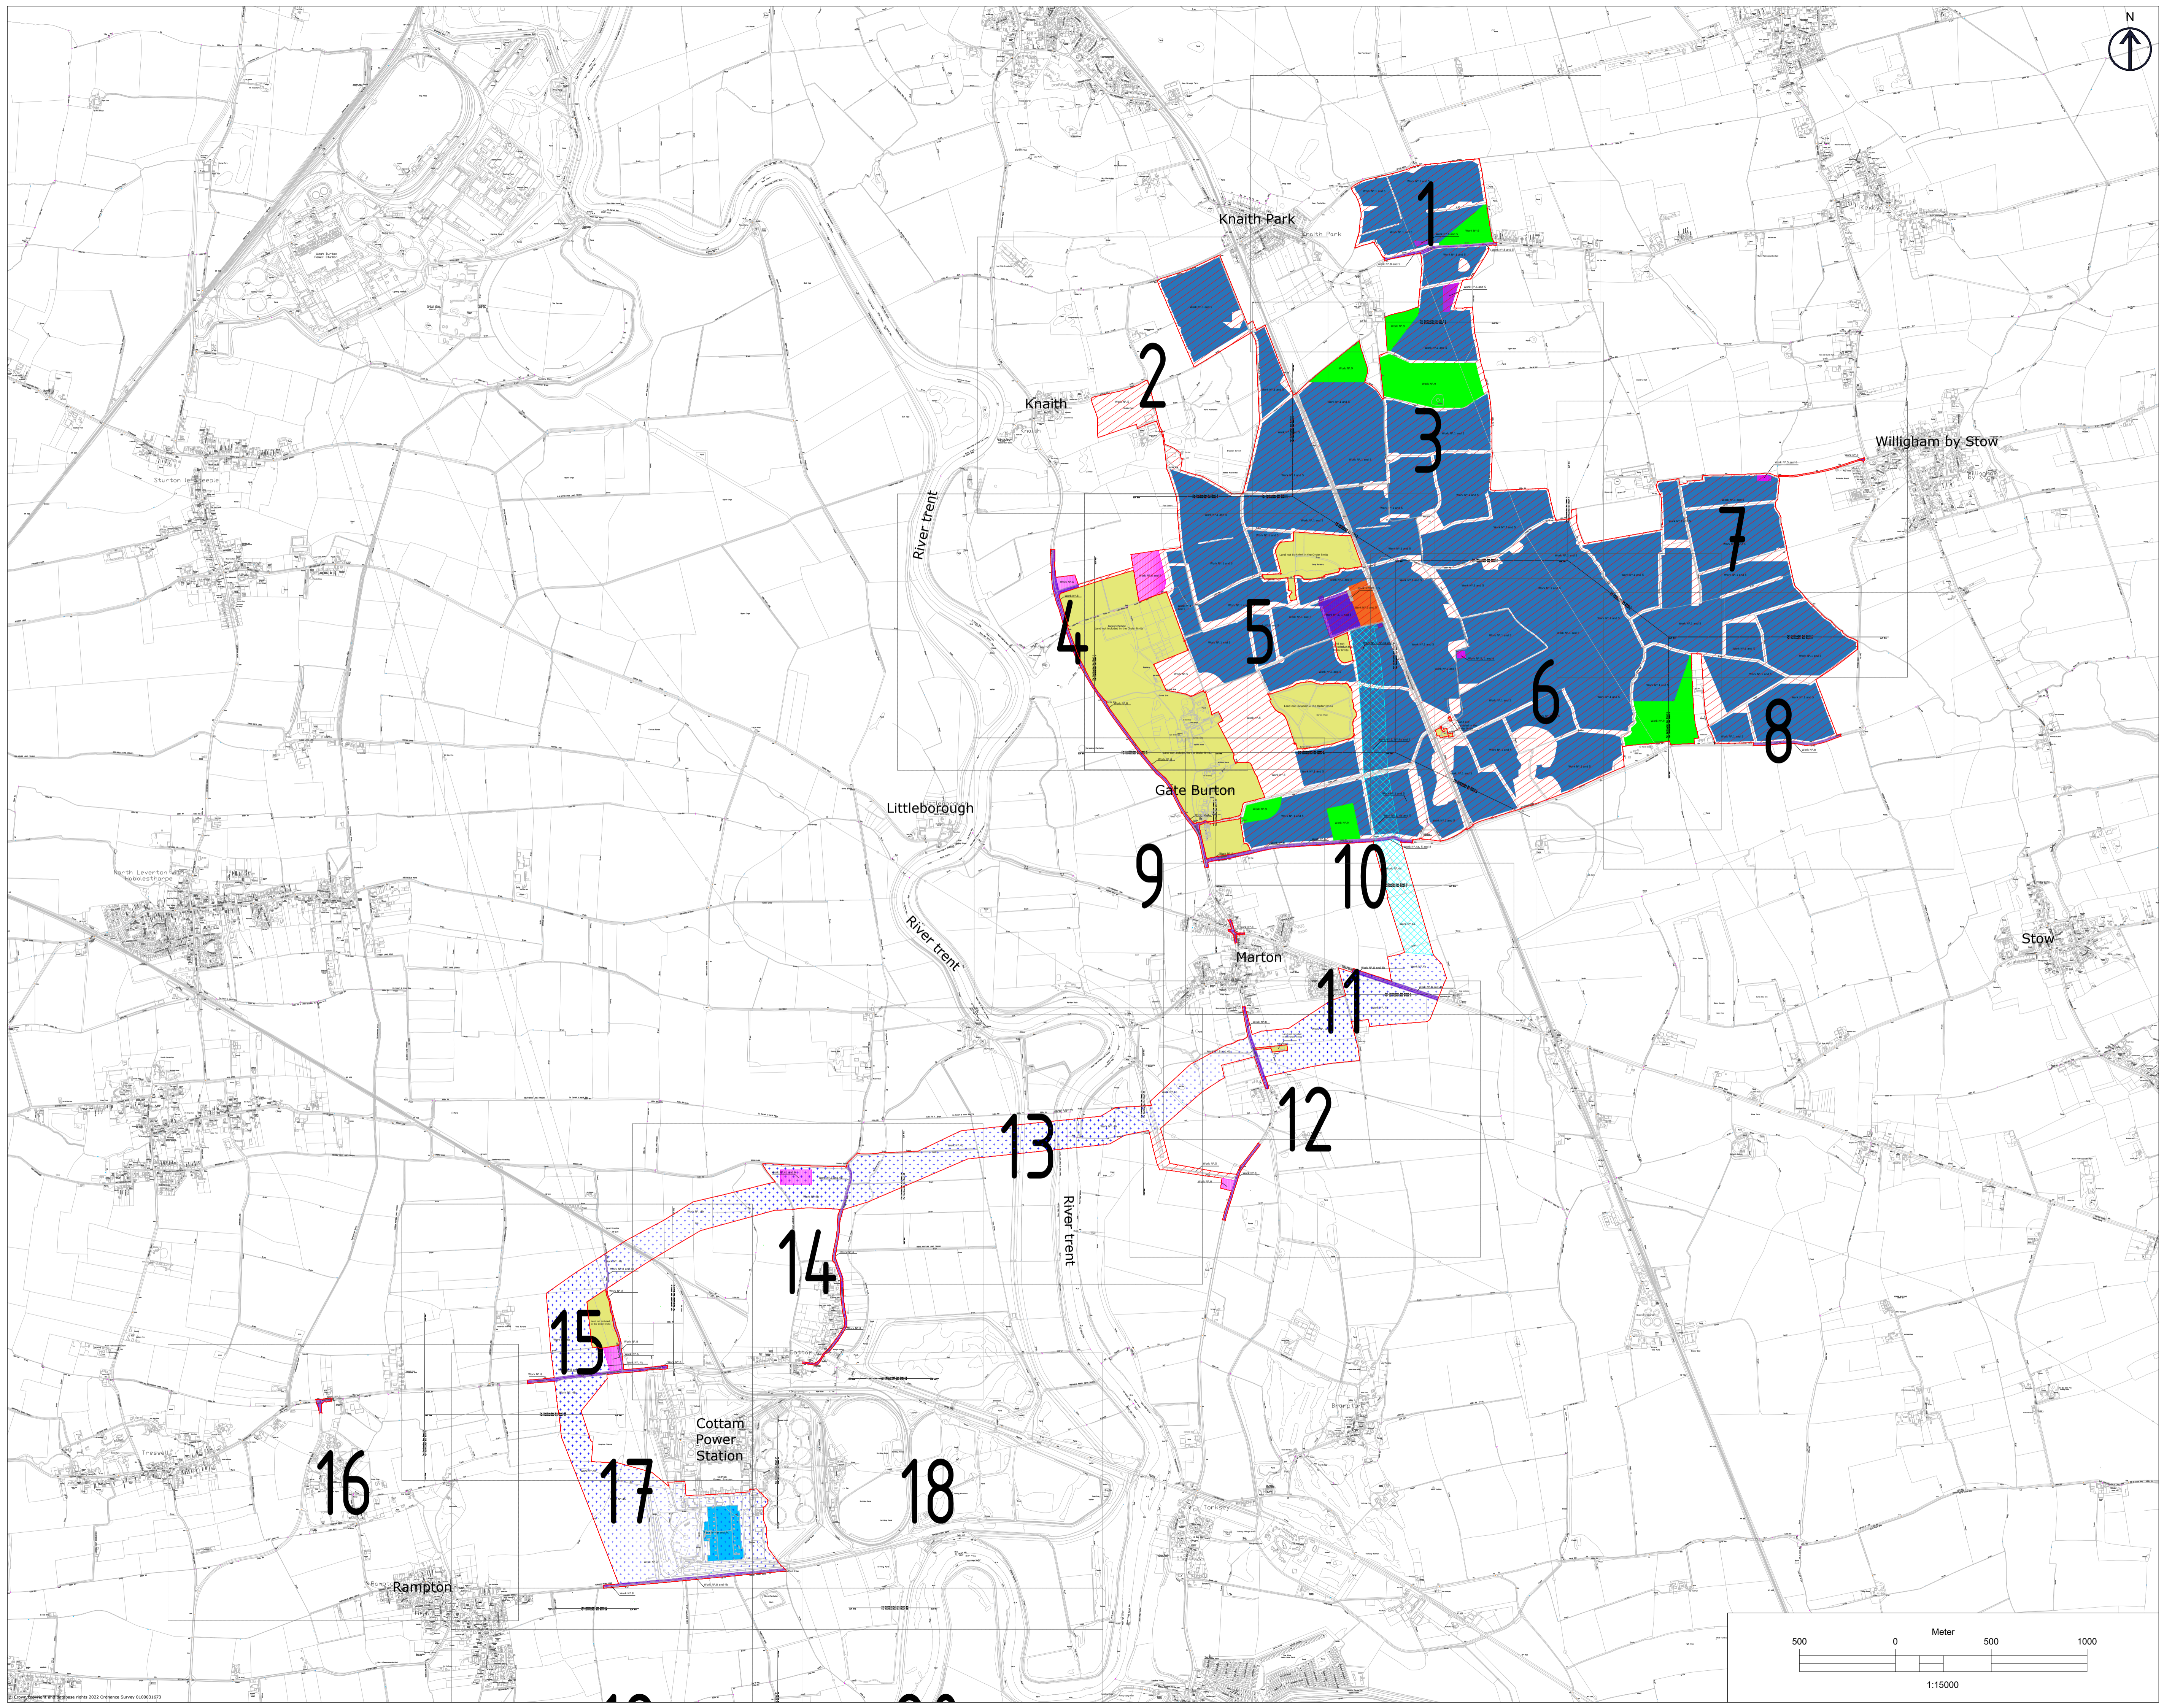


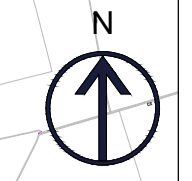


 

## EN010131

Works Plan Rev.3  
Document Reference: EN010131/APP/5.2  
October 2023

Regulation 5(j)  
Infrastructure Planning (Applications: Prescribed Forms and Procedure) Regulations 2009







**LEGEND**

-  Work No.1
-  Work No.2
-  Work No.3
-  Work No.4a
-  Work No.4b
-  Work No.4c
-  Work No.5
-  Work No.6
-  Work No.7
-  Work No.8
-  Work No.9
-  Land not included in the Order limits

1. THIS DRAWING IS TO BE READ IN CONJUNCTION WITH ALL OTHER RELEVANT DOCUMENTATION, PRELIMINARY AND PROVISIONAL REGULATIONS.
2. ALL OPERATIONS, CONSTRUCTION AND CONSTRUCTION ARE IN STRICT ACCORDANCE WITH THE CONTENT OF THE COMPANY, WRITTEN AND SIGNED CONDITIONS TO BE CHECKED ON SITE, AND ANY DISCREPANCIES SHOULD BE REPORTED TO THE PROJECT MANAGER IMMEDIATELY.
3. THE WORKS ARE SUBJECT TO CHANGE THROUGH DETAILED DESIGN IN ACCORDANCE WITH THE TERMS OF THE DEVELOPMENT CONSENT GRANT.

Index	Date	Changes	Writer	Checker
A	19/01/23	Original	ABO	GDA
B	07/03/23	S51 advice update	ABO	GDA
C	03/10/23	Update for Deadline4	ABO	GDA

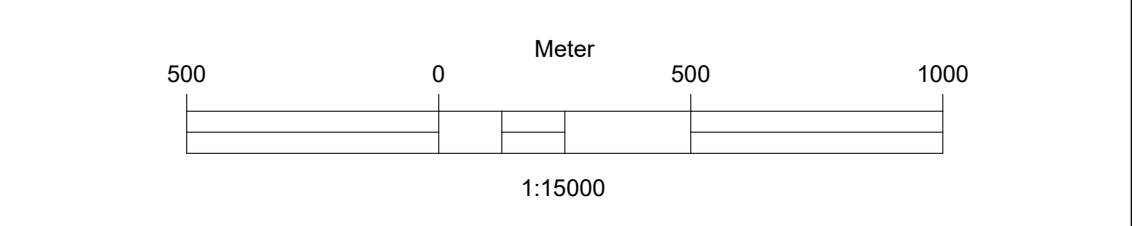

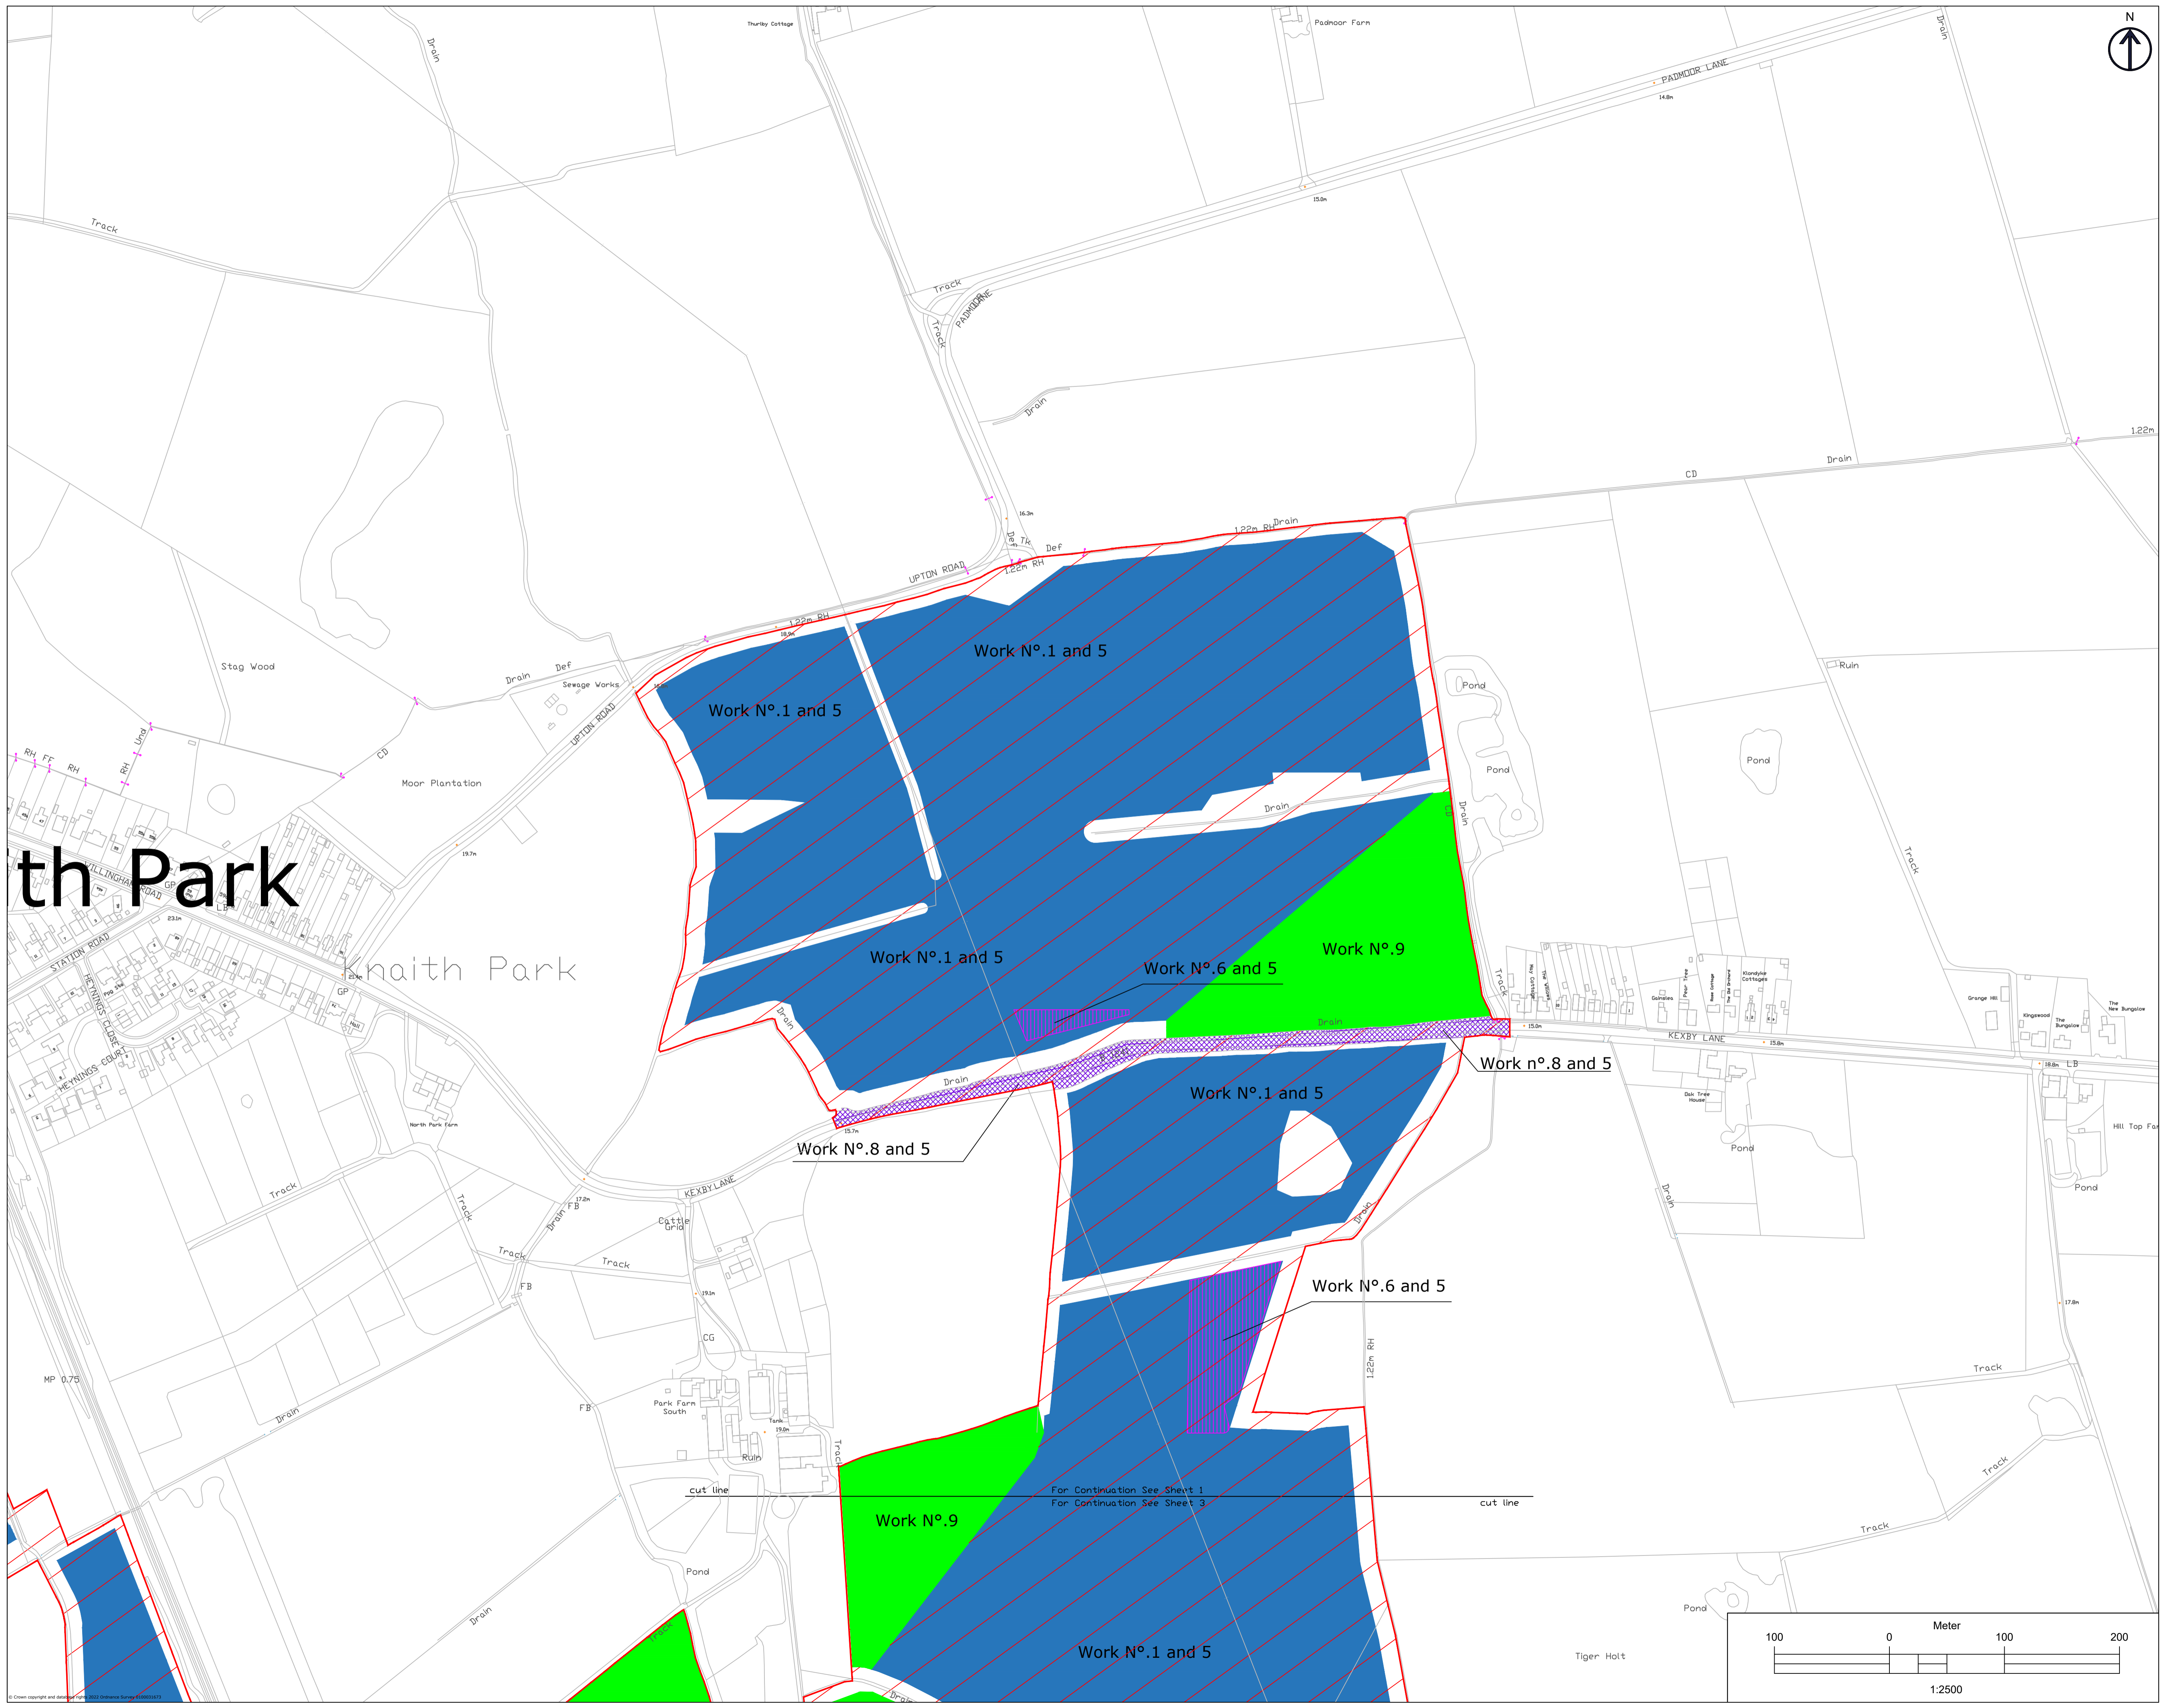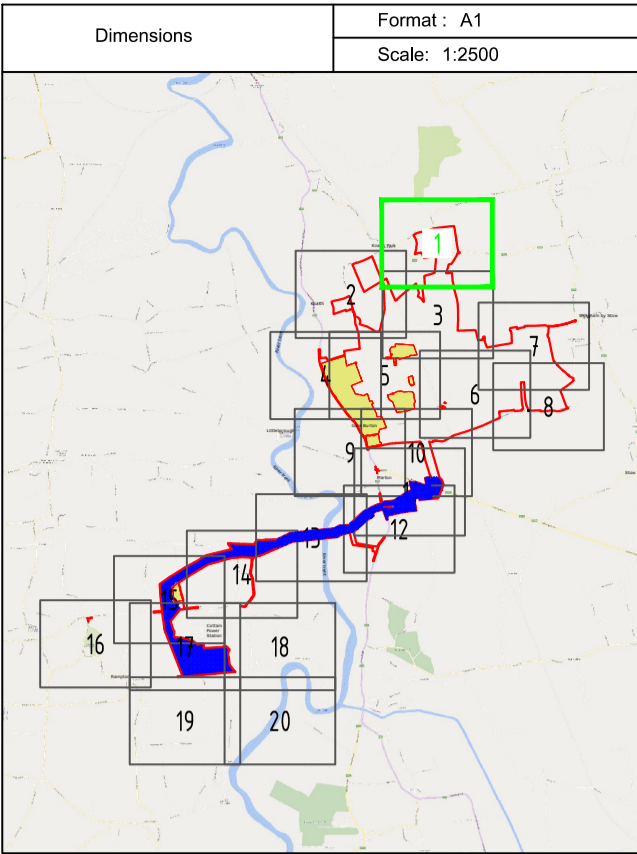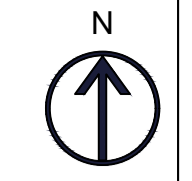


**LEGEND**



- Work No.1
- Work No.2
- Work No.3
- Work No.4a
- Work No.4b
- Work No.4c
- Work No.5
- Work No.6
- Work No.7
- Work No.8
- Work No.9
- Land not included in the Order limits

1. THIS DRAWING IS TO BE READ IN CONJUNCTION WITH ALL OTHER RELEVANT DOCUMENTATION.  
 2. WORKS SHALL BE CONDUCTED IN ACCORDANCE WITH THE INSTRUCTIONS IN ALL RELEVANT OPERATIONAL PROCEDURES AND PROTECTIVE REGULATIONS.  
 3. ALL OPERATIONS, CONSTRUCTION AND CONDUCTIONS ARE IN METRES UNLESS OTHERWISE SPECIFIED.  
 4. THE WORKER SHALL BE RESPONSIBLE FOR CHECKING THE DIMENSIONS AND LEVELS ON SITE AND ANY DISCREPANCIES SHALL BE REPORTED IMMEDIATELY TO THE SUPERVISOR.  
 5. THE WORKER SHALL BE RESPONSIBLE FOR CHECKING THE DIMENSIONS AND LEVELS ON SITE AND ANY DISCREPANCIES SHALL BE REPORTED IMMEDIATELY TO THE SUPERVISOR.

Index	Date	Changes	Writer	Checker
A	19/01/23	Original	ABO	GDA
B	07/03/23	SS1 advice update	ABO	GDA
C	03/10/23	Update for Deadlined	ABO	GDA

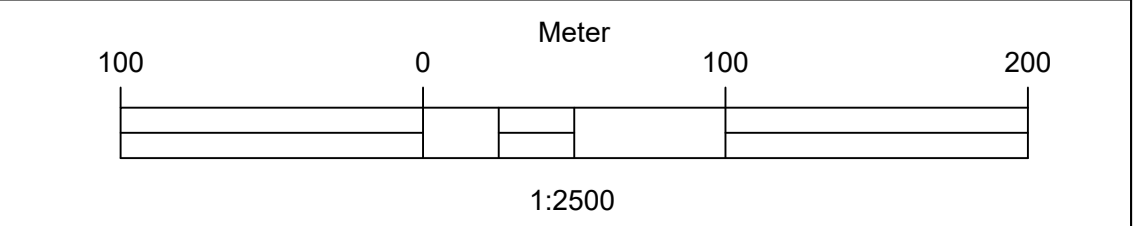



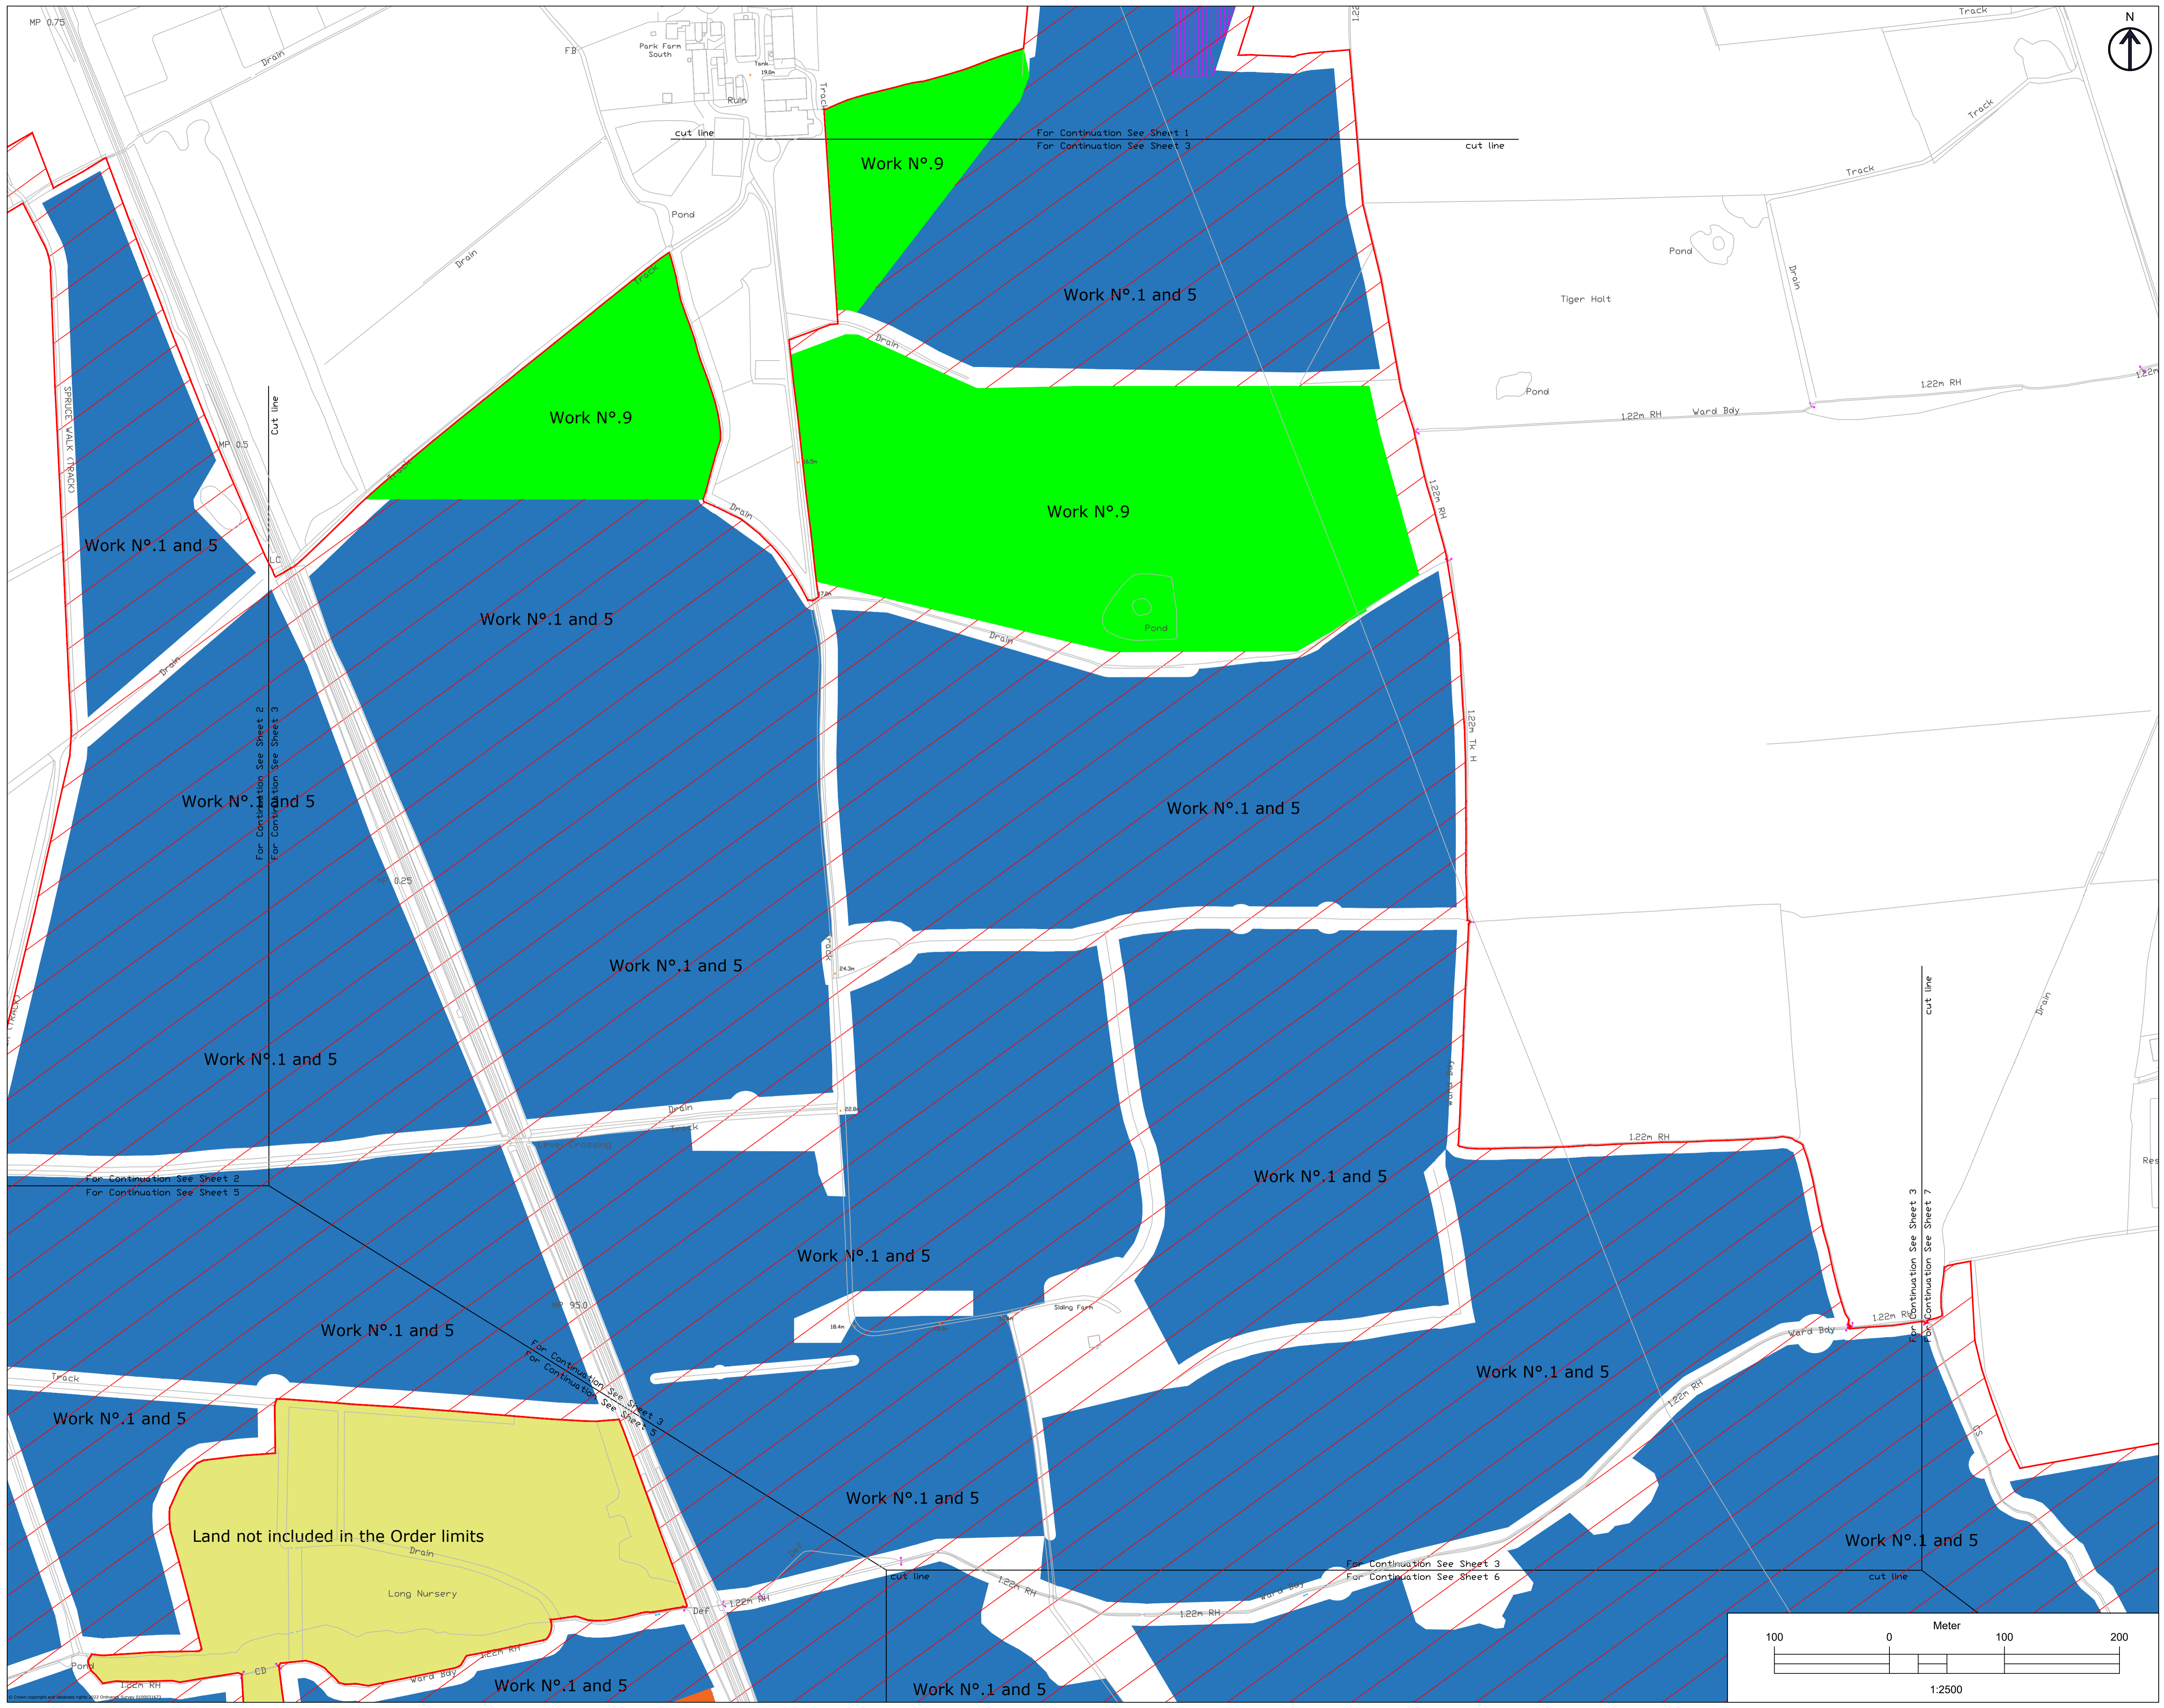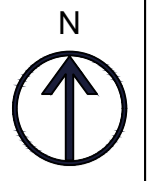


**LEGEND**

- Work No.1
- Work No.2
- Work No.3
- Work No.4a
- Work No.4b
- Work No.4c
- Work No.5
- Work No.6
- Work No.7
- Work No.8
- Work No.9
- Land not included in the Order limits

1. THIS DRAWING IS TO BE READ IN CONJUNCTION WITH ALL OTHER RELEVANT DOCUMENTATION.  
 2. WORKS MUST BE ACCORDANCE WITH REGULATIONS AND THE INSTRUCTIONS IN ANY RELEVANT DOCUMENTATION.  
 3. ALL OPERATIONS, CONSTRUCTION AND CONDITIONS ARE IN ACCORDANCE WITH THE INSTRUCTIONS IN ANY RELEVANT DOCUMENTATION.  
 4. THE WORKS ARE SUBJECT TO CHANGE THROUGH DETAILED DESIGN IN ACCORDANCE WITH THE TERMS OF THE DEVELOPMENT CONSENT ORDER.

Index	Date	Changes	Writer	Checker
A	18/01/23	Original	ABO	GDA
B	07/03/23	SSI advice update	ABO	GDA
C	03/10/23	Update for Deadline	ABO	GDA

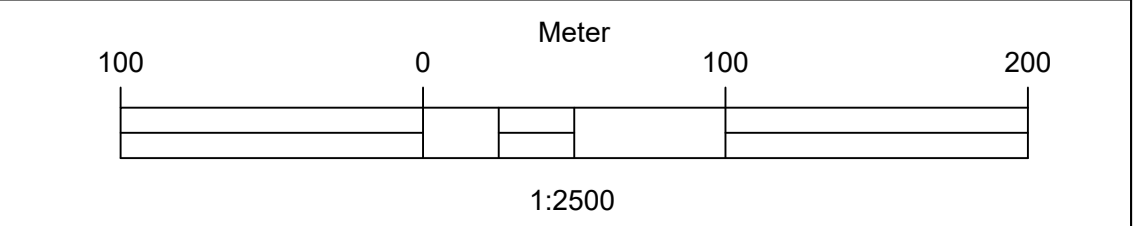


# River trent

EN010131/APP/5.2  
LCA-2021-01-GateBurton

**Gate Burton**  
ENERGY PARK

Works Plans: **Sheet 04**

Dimensions: Format: A1  
Scale: 1:2500

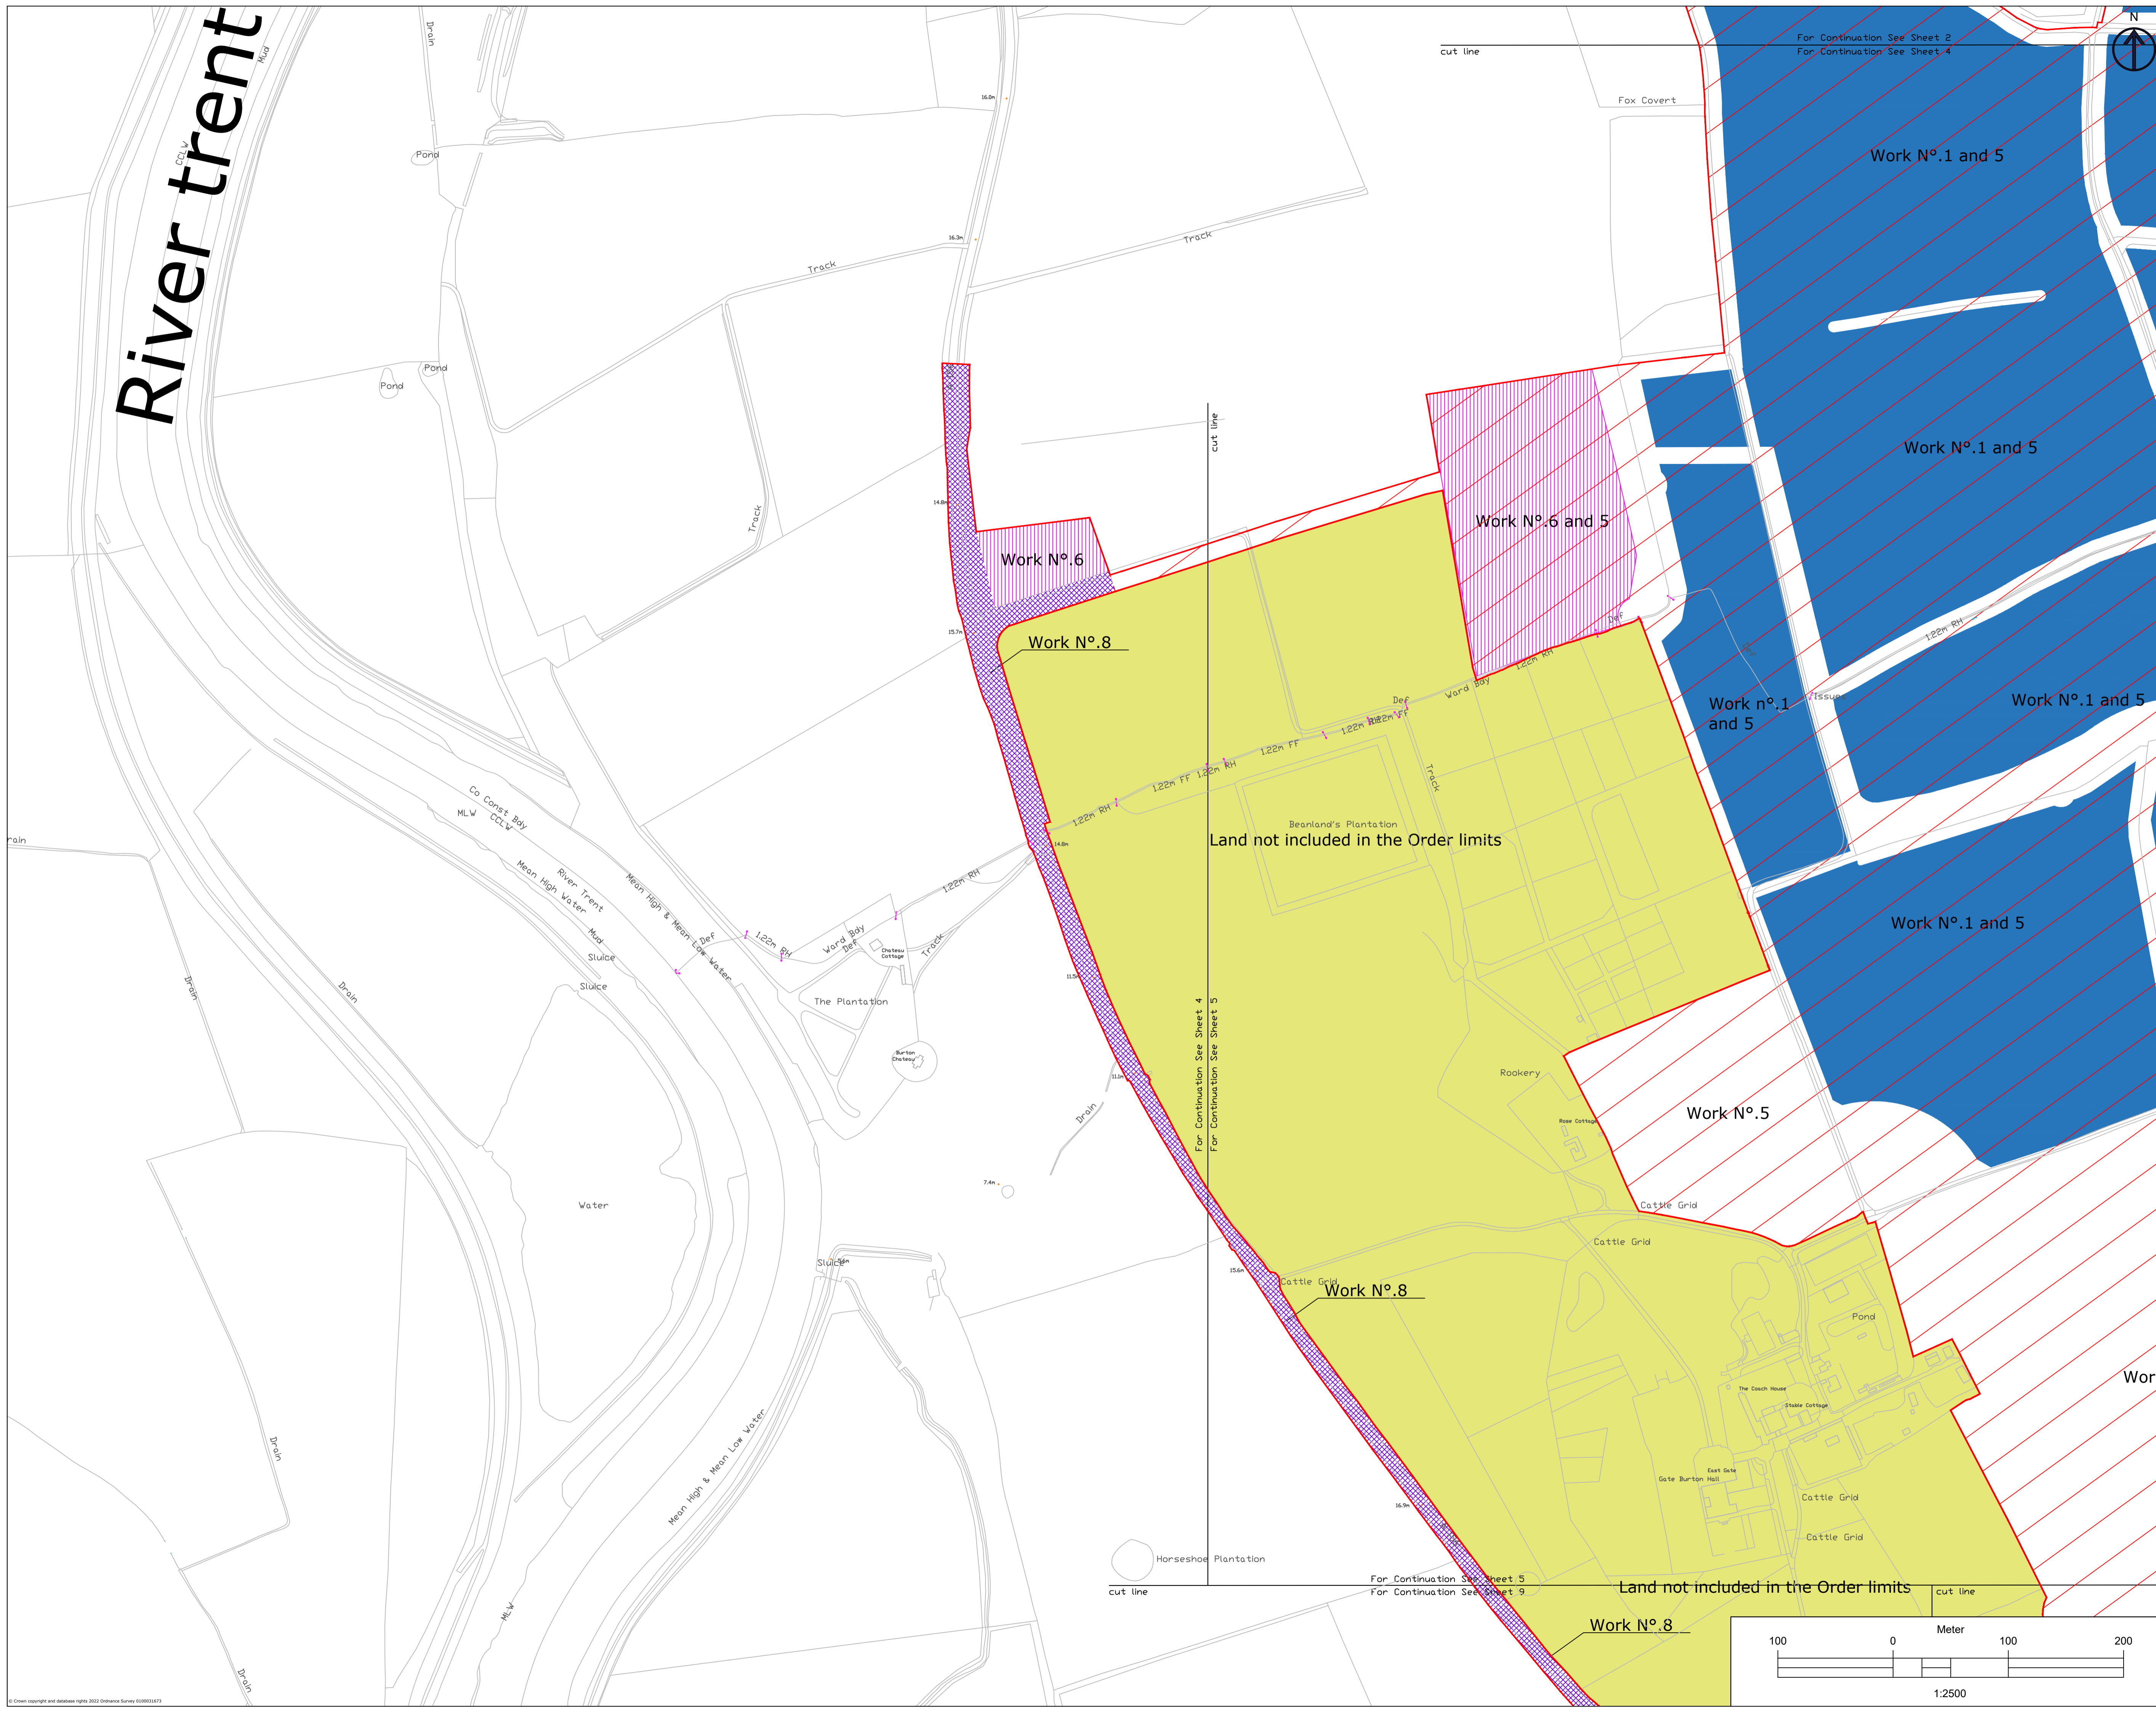

**LEGEND**

- Work No.1
- Work No.2
- Work No.3
- Work No.4a
- Work No.4b
- Work No.4c
- Work No.5
- Work No.6
- Work No.7
- Work No.8
- Work No.9
- Land not included in the Order limits

1. THIS DRAWING IS TO BE READ IN CONJUNCTION WITH ALL OTHER RELEVANT DOCUMENTATION.  
2. WORKS MUST BE CONDUCTED IN ACCORDANCE WITH THE SPECIFICATIONS AND PROCEDURES OF THE PROJECT CONTRACT AND ANY SUBSEQUENT VARIATIONS.  
3. ALL DIMENSIONS, COORDINATES, LEVELS AND CORRECTIONS ARE IN METRES UNLESS OTHERWISE SPECIFIED.  
4. THE WORKS ARE SUBJECT TO CHANGE WITHOUT NOTICE TO THE CONTRACTOR IN ACCORDANCE WITH THE TERMS OF THE DEVELOPMENT CONTRACT ORDER.  
5. THE WORKS ARE SUBJECT TO CHANGE WITHOUT NOTICE TO THE CONTRACTOR IN ACCORDANCE WITH THE TERMS OF THE DEVELOPMENT CONTRACT ORDER.



Index	Date	Changes	Writer	Checker
A	19/01/23	Original	ABO	GDA
B	07/03/23	S&I advice update	ABO	GDA
C	03/10/23	Update for Deadlined	ABO	GDA

100 0 100 200  
Meter  
1:2500

**skyray**

47 Rue Maurice Flandin,  
69003 Lyon FRANCE  
contact@skyrayengineering.com  
https://www.skrayengineering.com



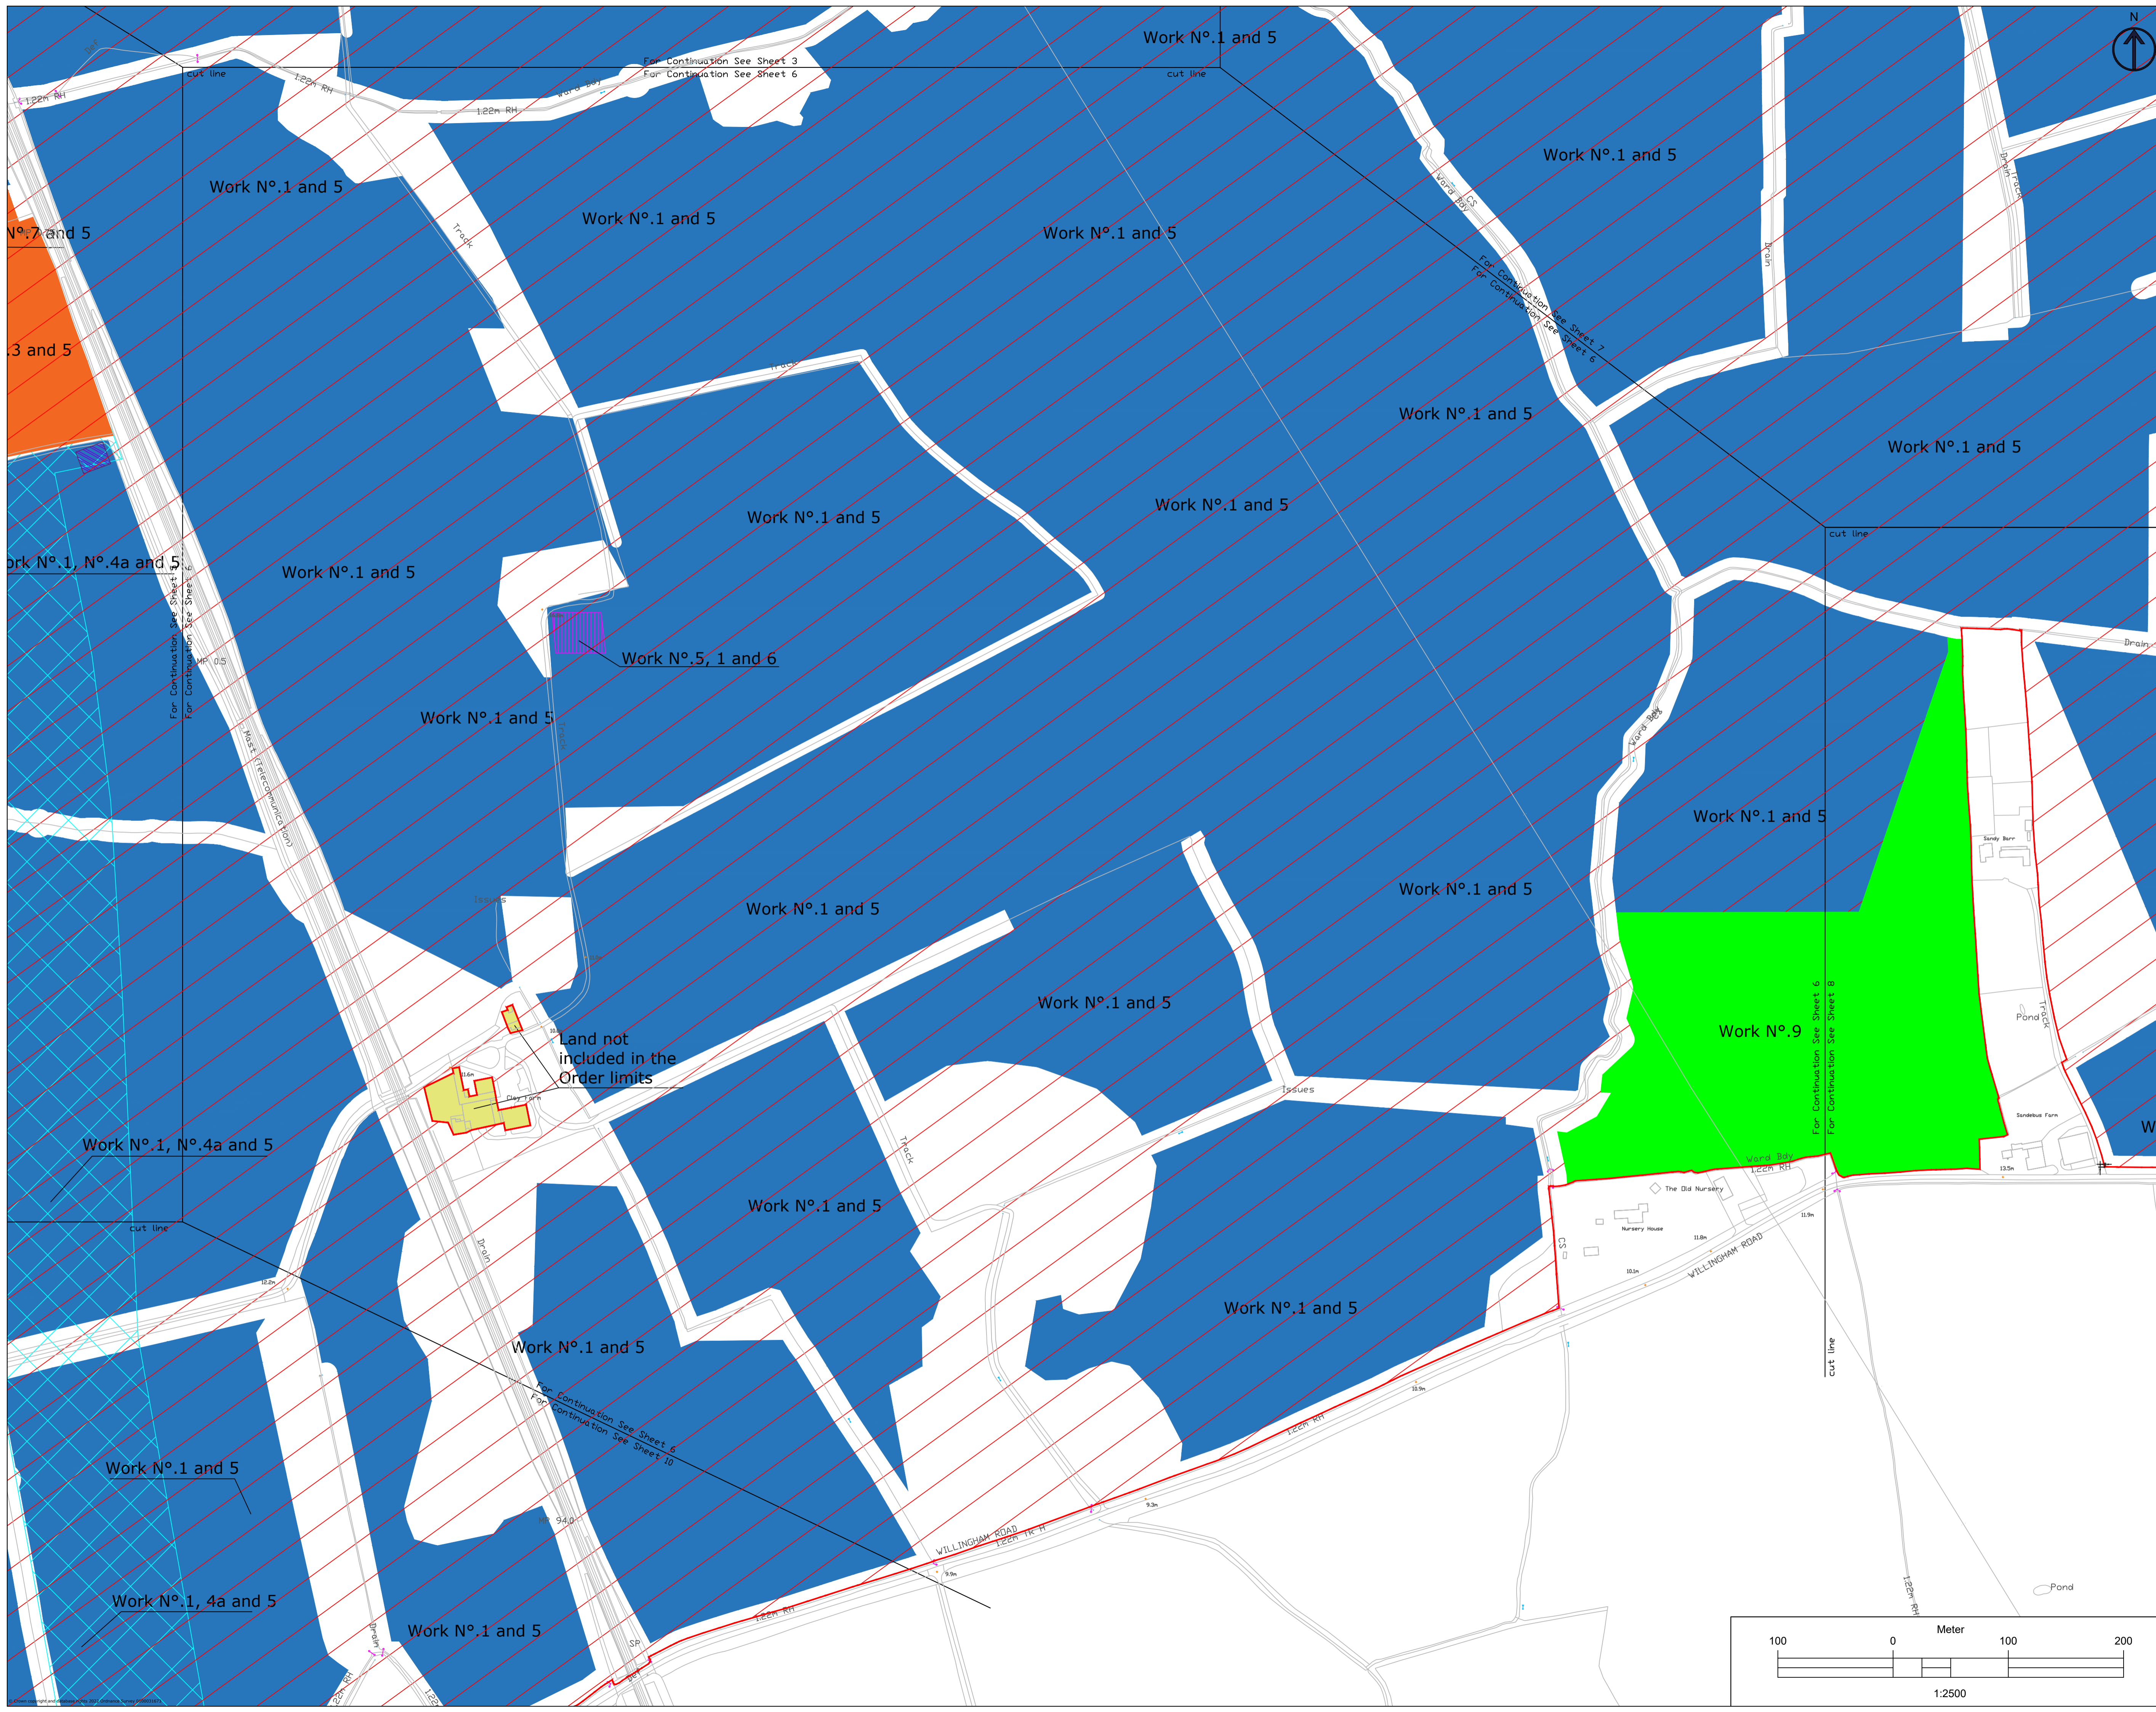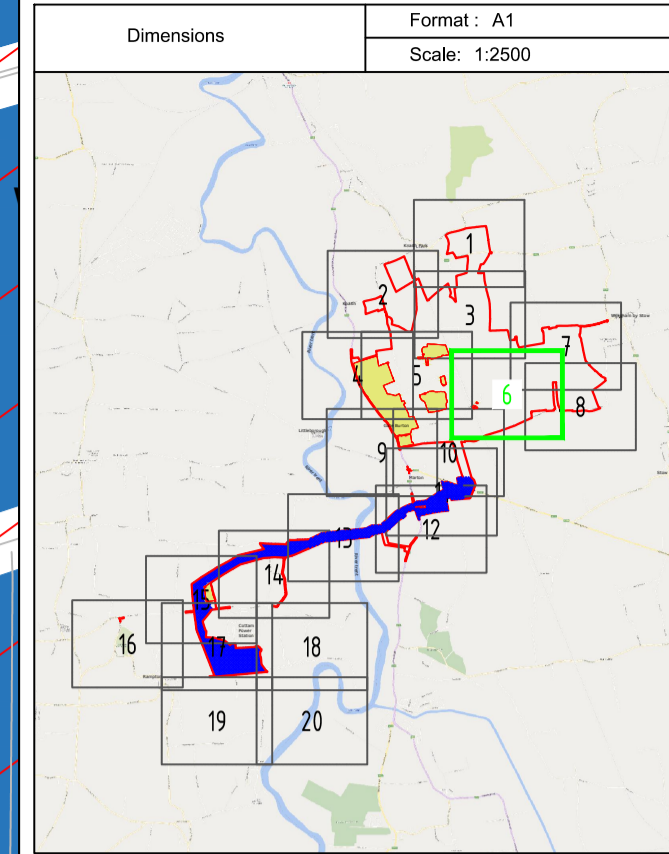


**LEGEND**


- Work No.1
- Work No.2
- Work No.3
- Work No.4a
- Work No.4b
- Work No.4c
- Work No.5
- Work No.6
- Work No.7
- Work No.8
- Work No.9
- Land not included in the Order limits

1. THIS DRAWING IS TO BE READ IN CONNECTION WITH ALL OTHER RELEVANT DOCUMENTATION.  
2. WORKS SHALL BE CONDUCTED IN ACCORDANCE WITH THE INSTRUCTIONS IN THESE DRAWINGS.  
3. ALL OPERATIONS AND PROCEDURES SHALL BE IN ACCORDANCE WITH THE INSTRUCTIONS IN THESE DRAWINGS.  
4. ALL OPERATIONS, CONSTRUCTION AND CONSTRUCTION ARE IN METRES UNLESS OTHERWISE SPECIFIED.  
5. THE OWNER AND SPECIAL CONTRACTOR SHALL BE RESPONSIBLE FOR CHECKING ON SITE AND ANY DISCREPANCIES SHALL BE REPORTED TO THE ENGINEER FOR CORRECTION ON SITE.  
6. THE OWNER AND SPECIAL CONTRACTOR SHALL BE RESPONSIBLE TO CHANGE THROUGH DETAILED DESIGN IN ACCORDANCE WITH THE TERMS OF THE DEVELOPMENT CONSENT ORDER.

Index	Date	Changes	Writer	Checker
A	19/01/23	Original	ABO	GDA
B	07/03/23	SSI advice update	ABO	GDA
C	03/10/23	Update for Deadlined	ABO	GDA

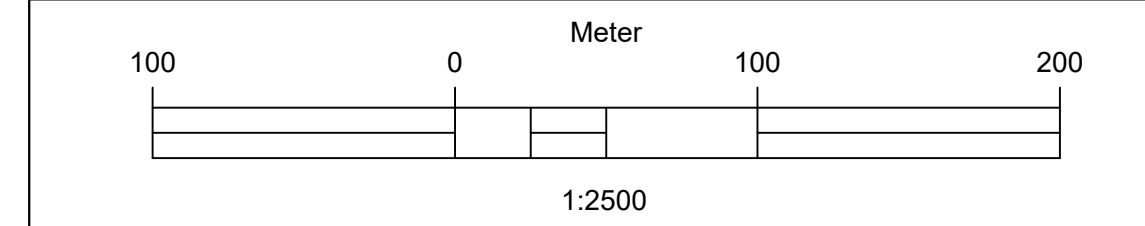



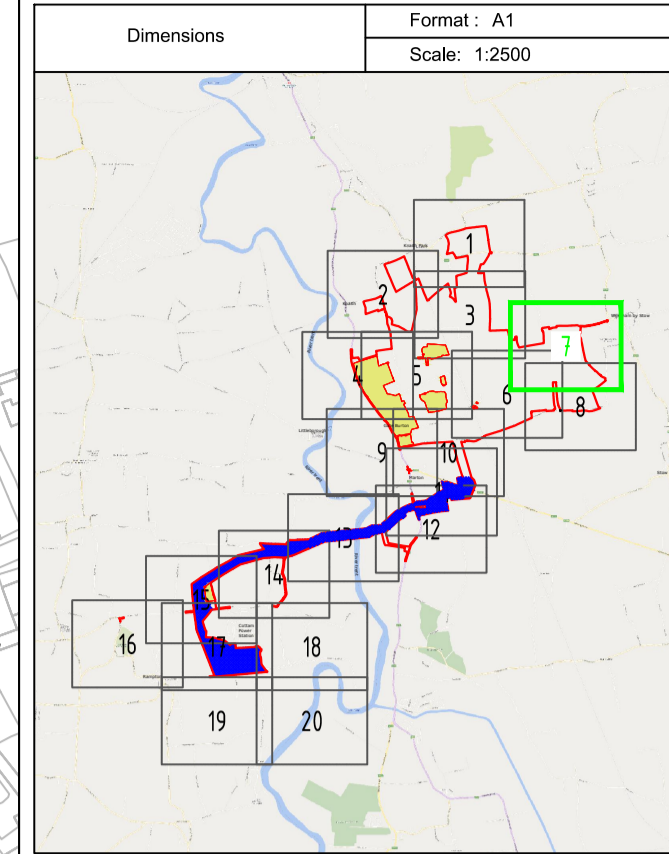

**GateBurton ENERGY PARK**

Dimensions: Format: A1 Scale: 1:2500


**LEGEND**


- Work No.1 (Blue diagonal lines)
- Work No.2 (Purple diagonal lines)
- Work No.3 (Orange diagonal lines)
- Work No.4a (Light blue diagonal lines)
- Work No.4b (Blue dotted pattern)
- Work No.4c (Light blue diagonal lines)
- Work No.5 (Red diagonal lines)
- Work No.6 (Pink diagonal lines)
- Work No.7 (Grey diagonal lines)
- Work No.8 (Purple cross-hatch pattern)
- Work No.9 (Green diagonal lines)
- Land not included in the Order limits (Yellow diagonal lines)

1. THIS DRAWING IS TO BE READ IN CONJUNCTION WITH ALL OTHER RELEVANT DOCUMENTATION.  
2. WORKS ARE TO BE CONSIDERED IN ACCORDANCE WITH THE REGULATIONS OF THE RELEVANT NATIONAL REGULATIONS.  
3. PRELIMINARY AND PROVISIONAL REGULATIONS.  
4. ALL DIMENSIONS, COORDINATES, LEVELS AND CONTROLS ARE IN METRES UNLESS OTHERWISE STATED.  
5. THE WORKS ARE TO BE CONSIDERED IN ACCORDANCE WITH THE REGULATIONS OF THE RELEVANT NATIONAL REGULATIONS.  
6. THE WORKS ARE TO BE CONSIDERED IN ACCORDANCE WITH THE REGULATIONS OF THE RELEVANT NATIONAL REGULATIONS.  
7. THE WORKS ARE TO BE CONSIDERED IN ACCORDANCE WITH THE REGULATIONS OF THE RELEVANT NATIONAL REGULATIONS.  
8. THE WORKS ARE TO BE CONSIDERED IN ACCORDANCE WITH THE REGULATIONS OF THE RELEVANT NATIONAL REGULATIONS.  
9. THE WORKS ARE TO BE CONSIDERED IN ACCORDANCE WITH THE REGULATIONS OF THE RELEVANT NATIONAL REGULATIONS.


Index	Date	Changes	Writer	Checker
A	19/01/23	Original	ABO	GDA
B	07/03/23	SS1 advice update	ABO	GDA
C	03/10/23	Update for Deadline	ABO	GDA

47 Rue Maurice Flandin,  
69003 Lyon FRANCE  
contact@skyrayengineering.com  
https://www.skyrayengineering.com

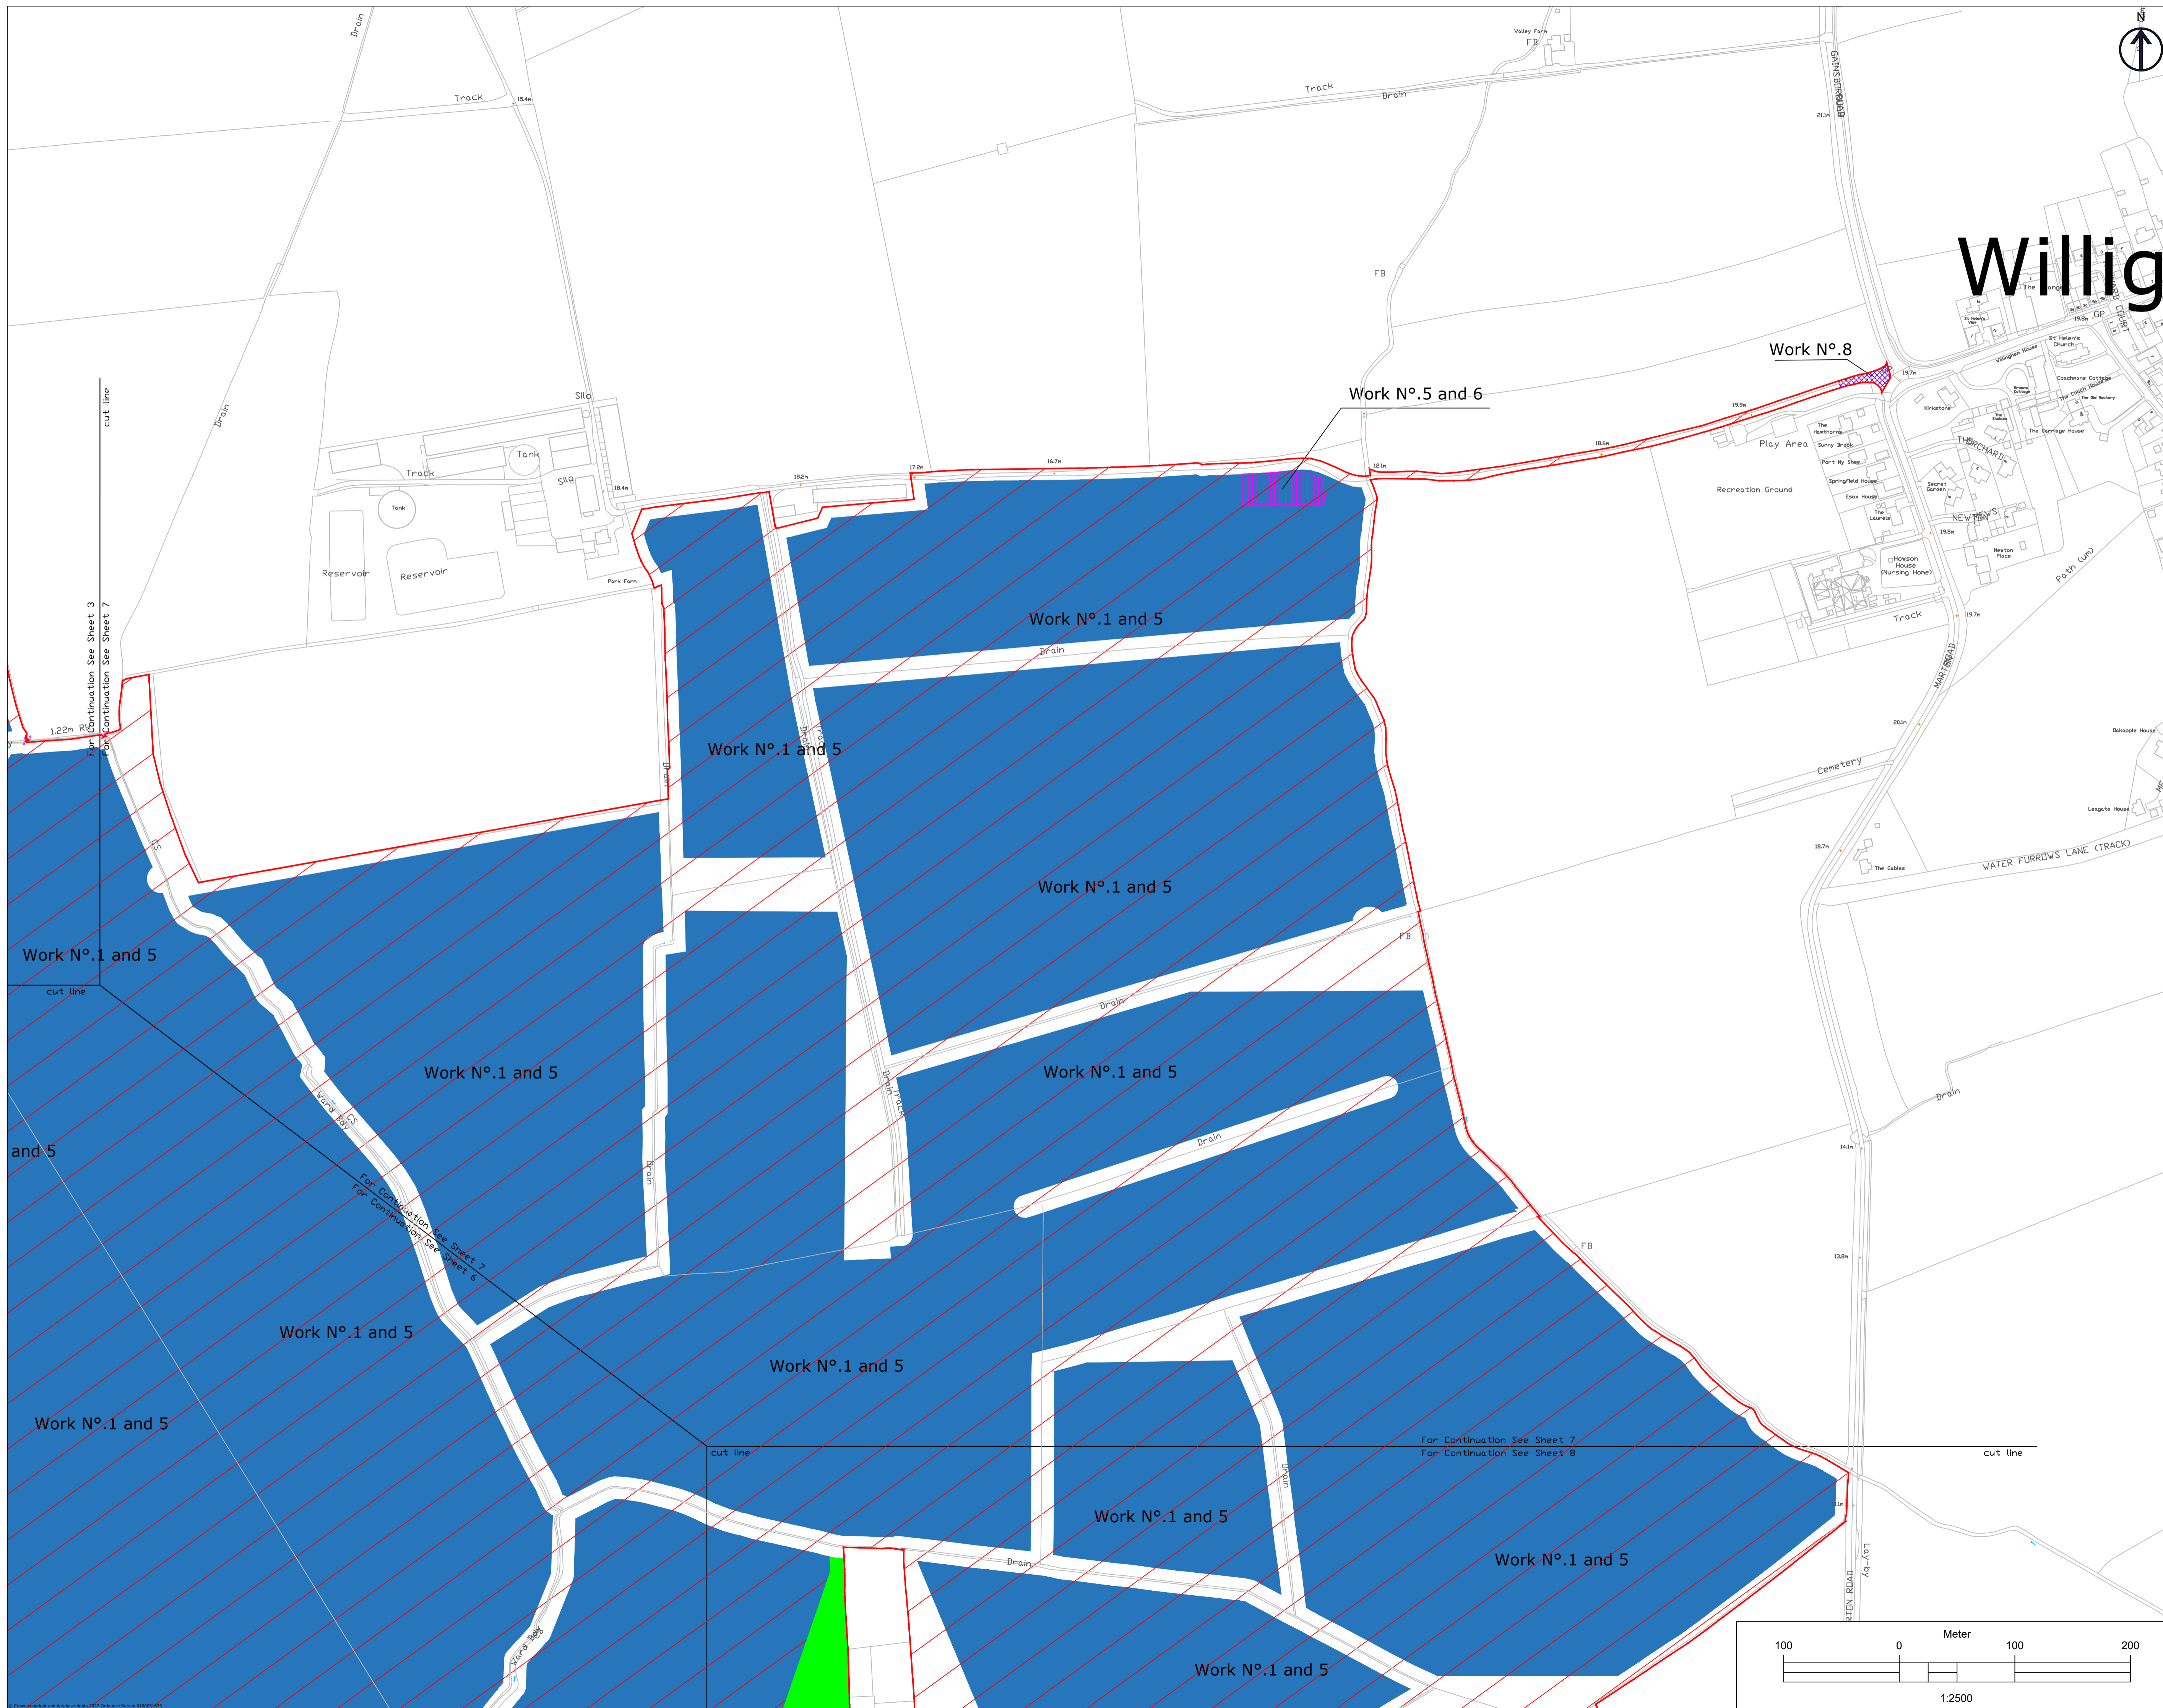

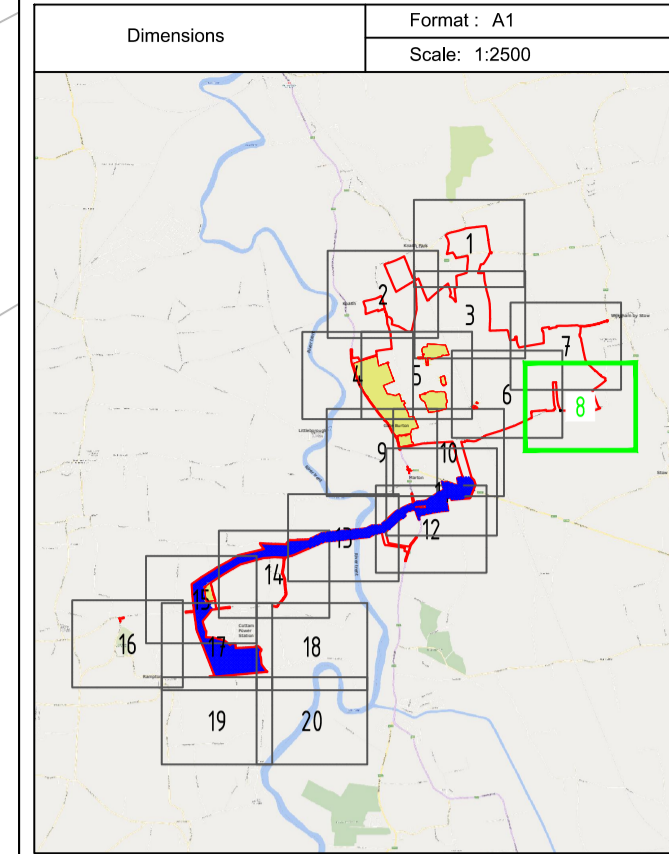

Dimensions	Format: A1
	Scale: 1:2500

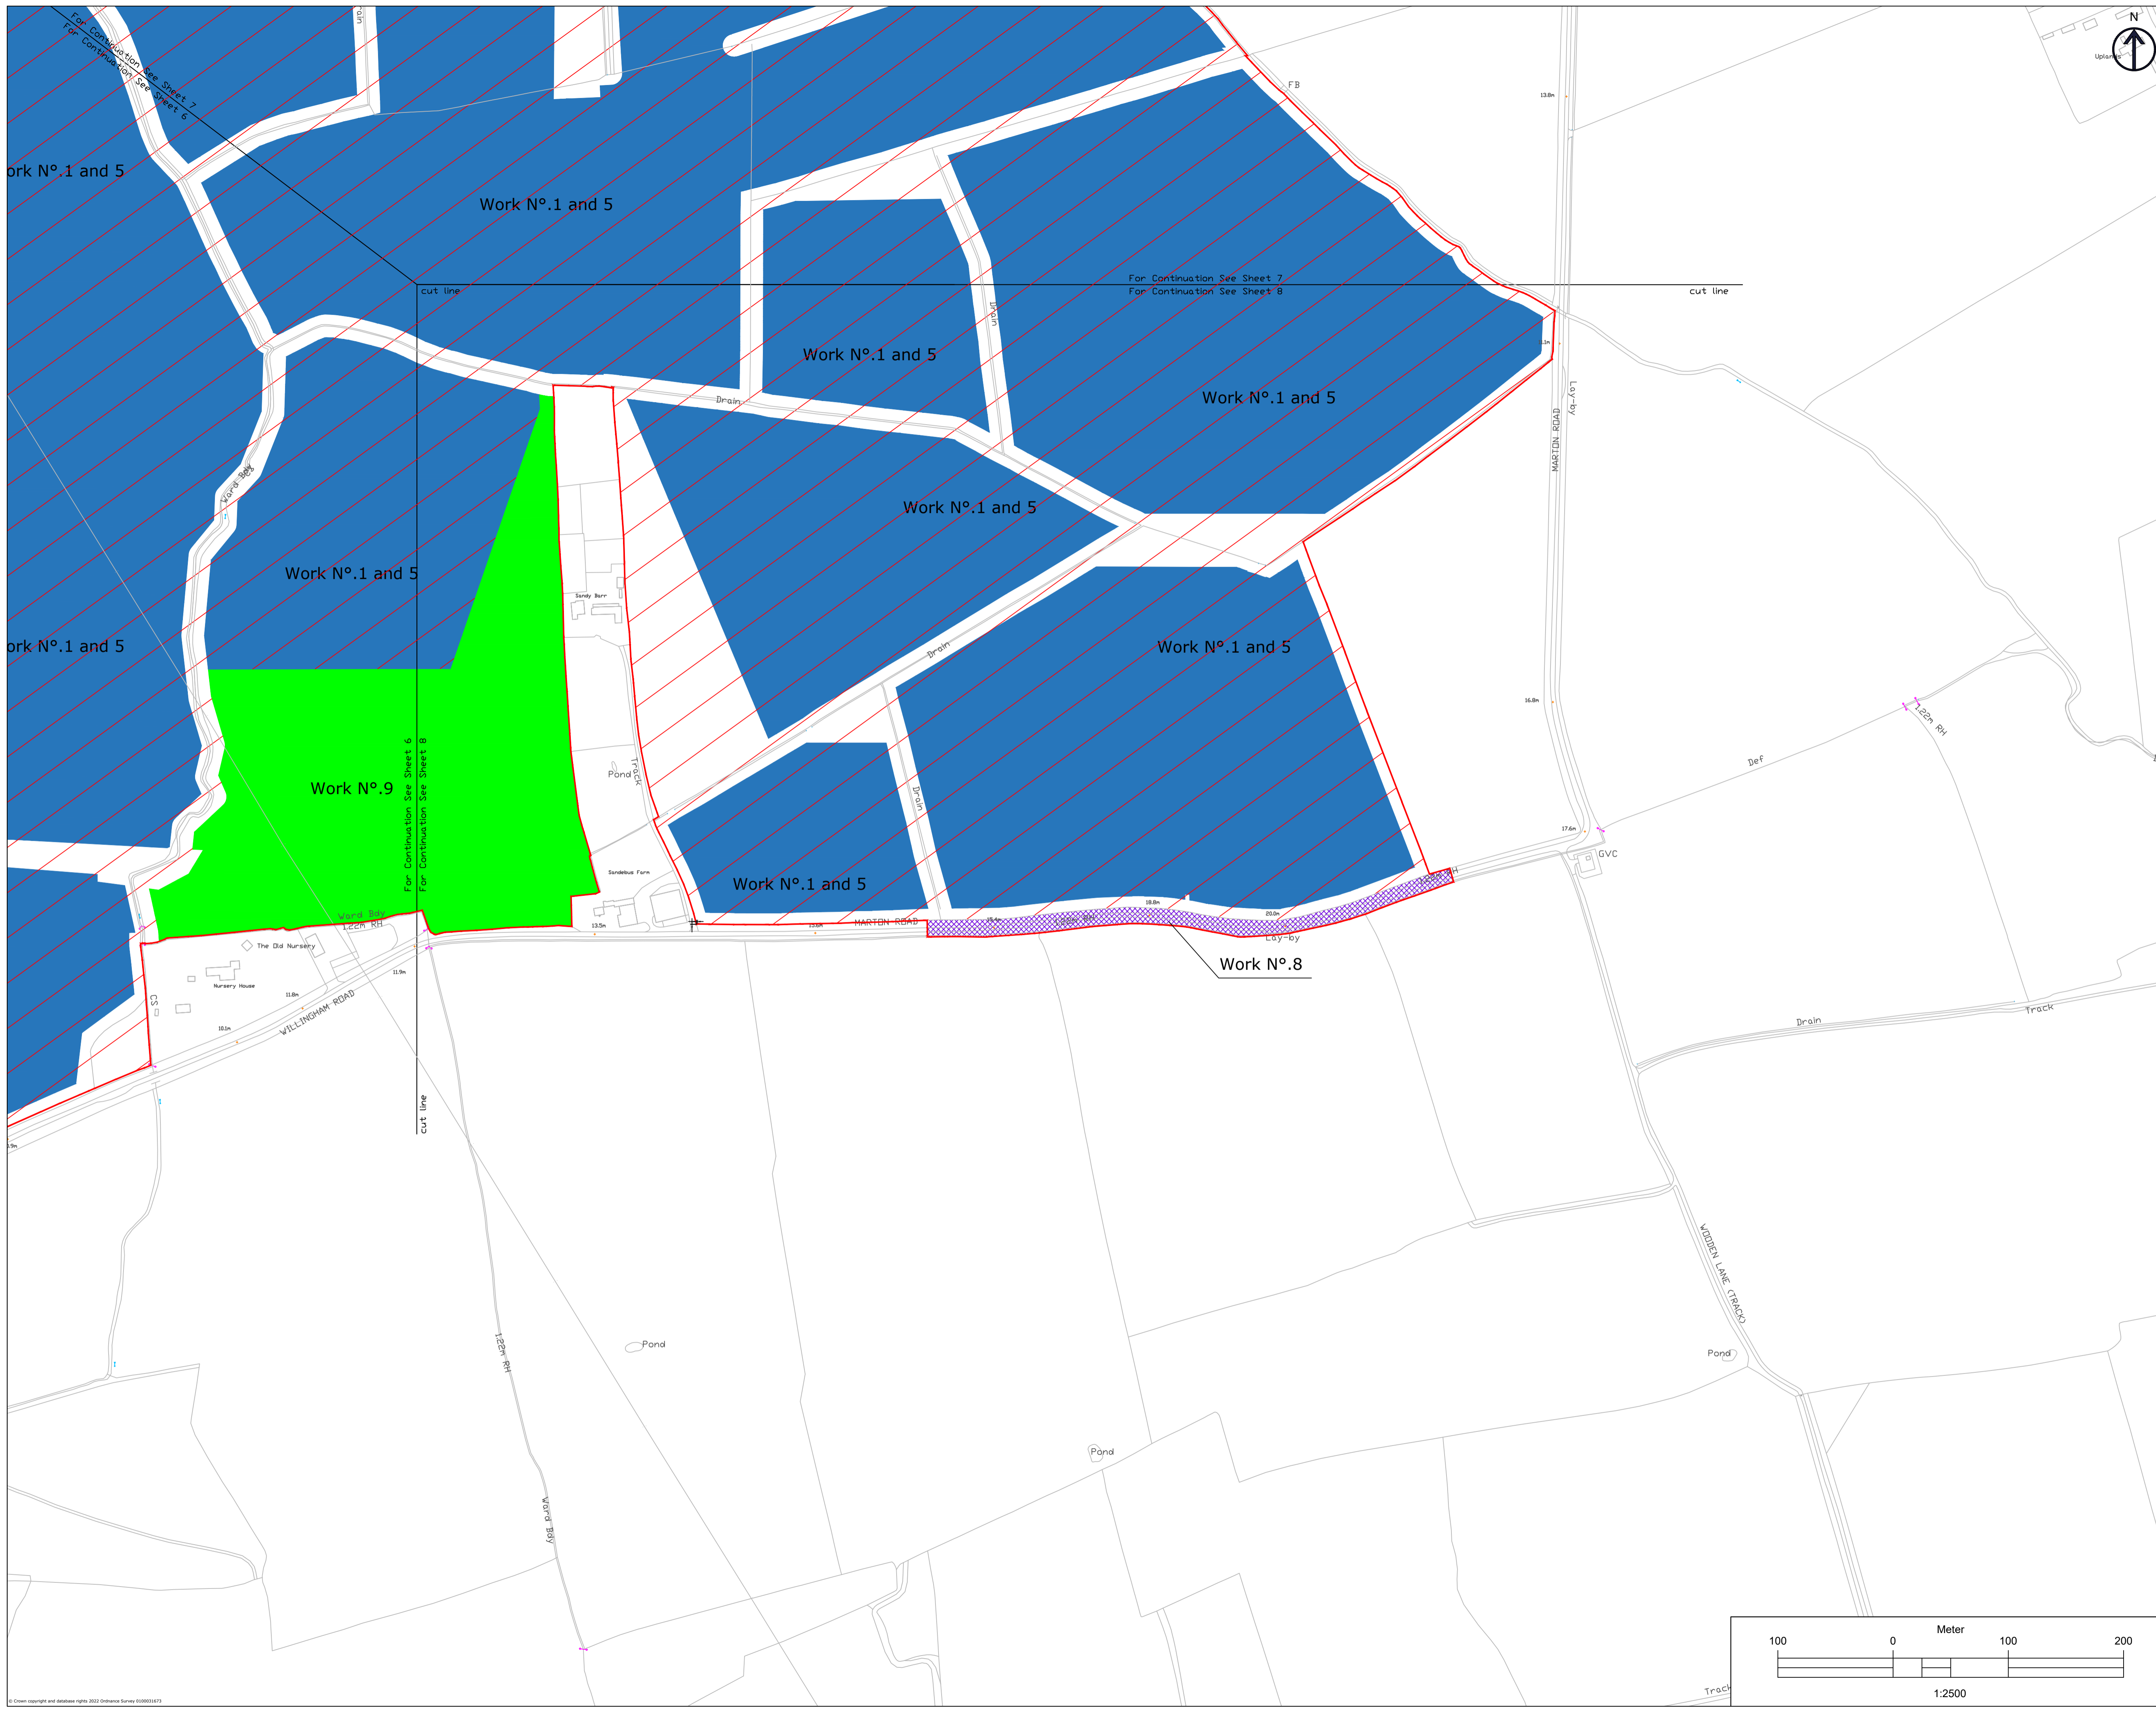




**LEGEND**

- Work No.1
- Work No.2
- Work No.3
- Work No.4a
- Work No.4b
- Work No.4c
- Work No.5
- Work No.6
- Work No.7
- Work No.8
- Work No.9
- Land not included in the Order limits

1. THIS DRAWING IS TO BE READ IN CONJUNCTION WITH ALL OTHER RELEVANT DOCUMENTATION.
2. WORKS MUST BE IN ACCORDANCE WITH REGULATIONS CONCERNING THE PROTECTION OF BURIED UTILITIES.
3. ALL OPERATIONS, CONSTRUCTION AND CONSTRUCTION ARE IN ACCORDANCE WITH THE REGULATIONS IN FORCE WITHOUT THE EXPRESS CONSENT OF THE COMPANY. WRITTEN AND SIGNED CONSENTS TO BE CHECKED ON SITE AND ANY DISCREPANCIES MUST BE REPORTED IMMEDIATELY TO THE PROJECT MANAGER.
4. THE WORKS ARE SUBJECT TO CHANGE THROUGH DETAILED DESIGN IN ACCORDANCE WITH THE TERMS OF THE DEVELOPMENT CONSENT ORDER.

Index	Date	Changes	Writer	Checker
A	19/01/23	Original	ABO	GDA
B	07/03/23	S51 advice update	ABO	GDA
C	03/10/23	Update for Deadline	ABO	GDA

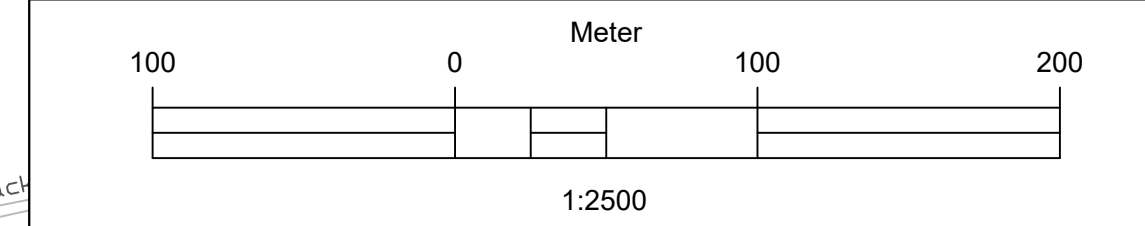

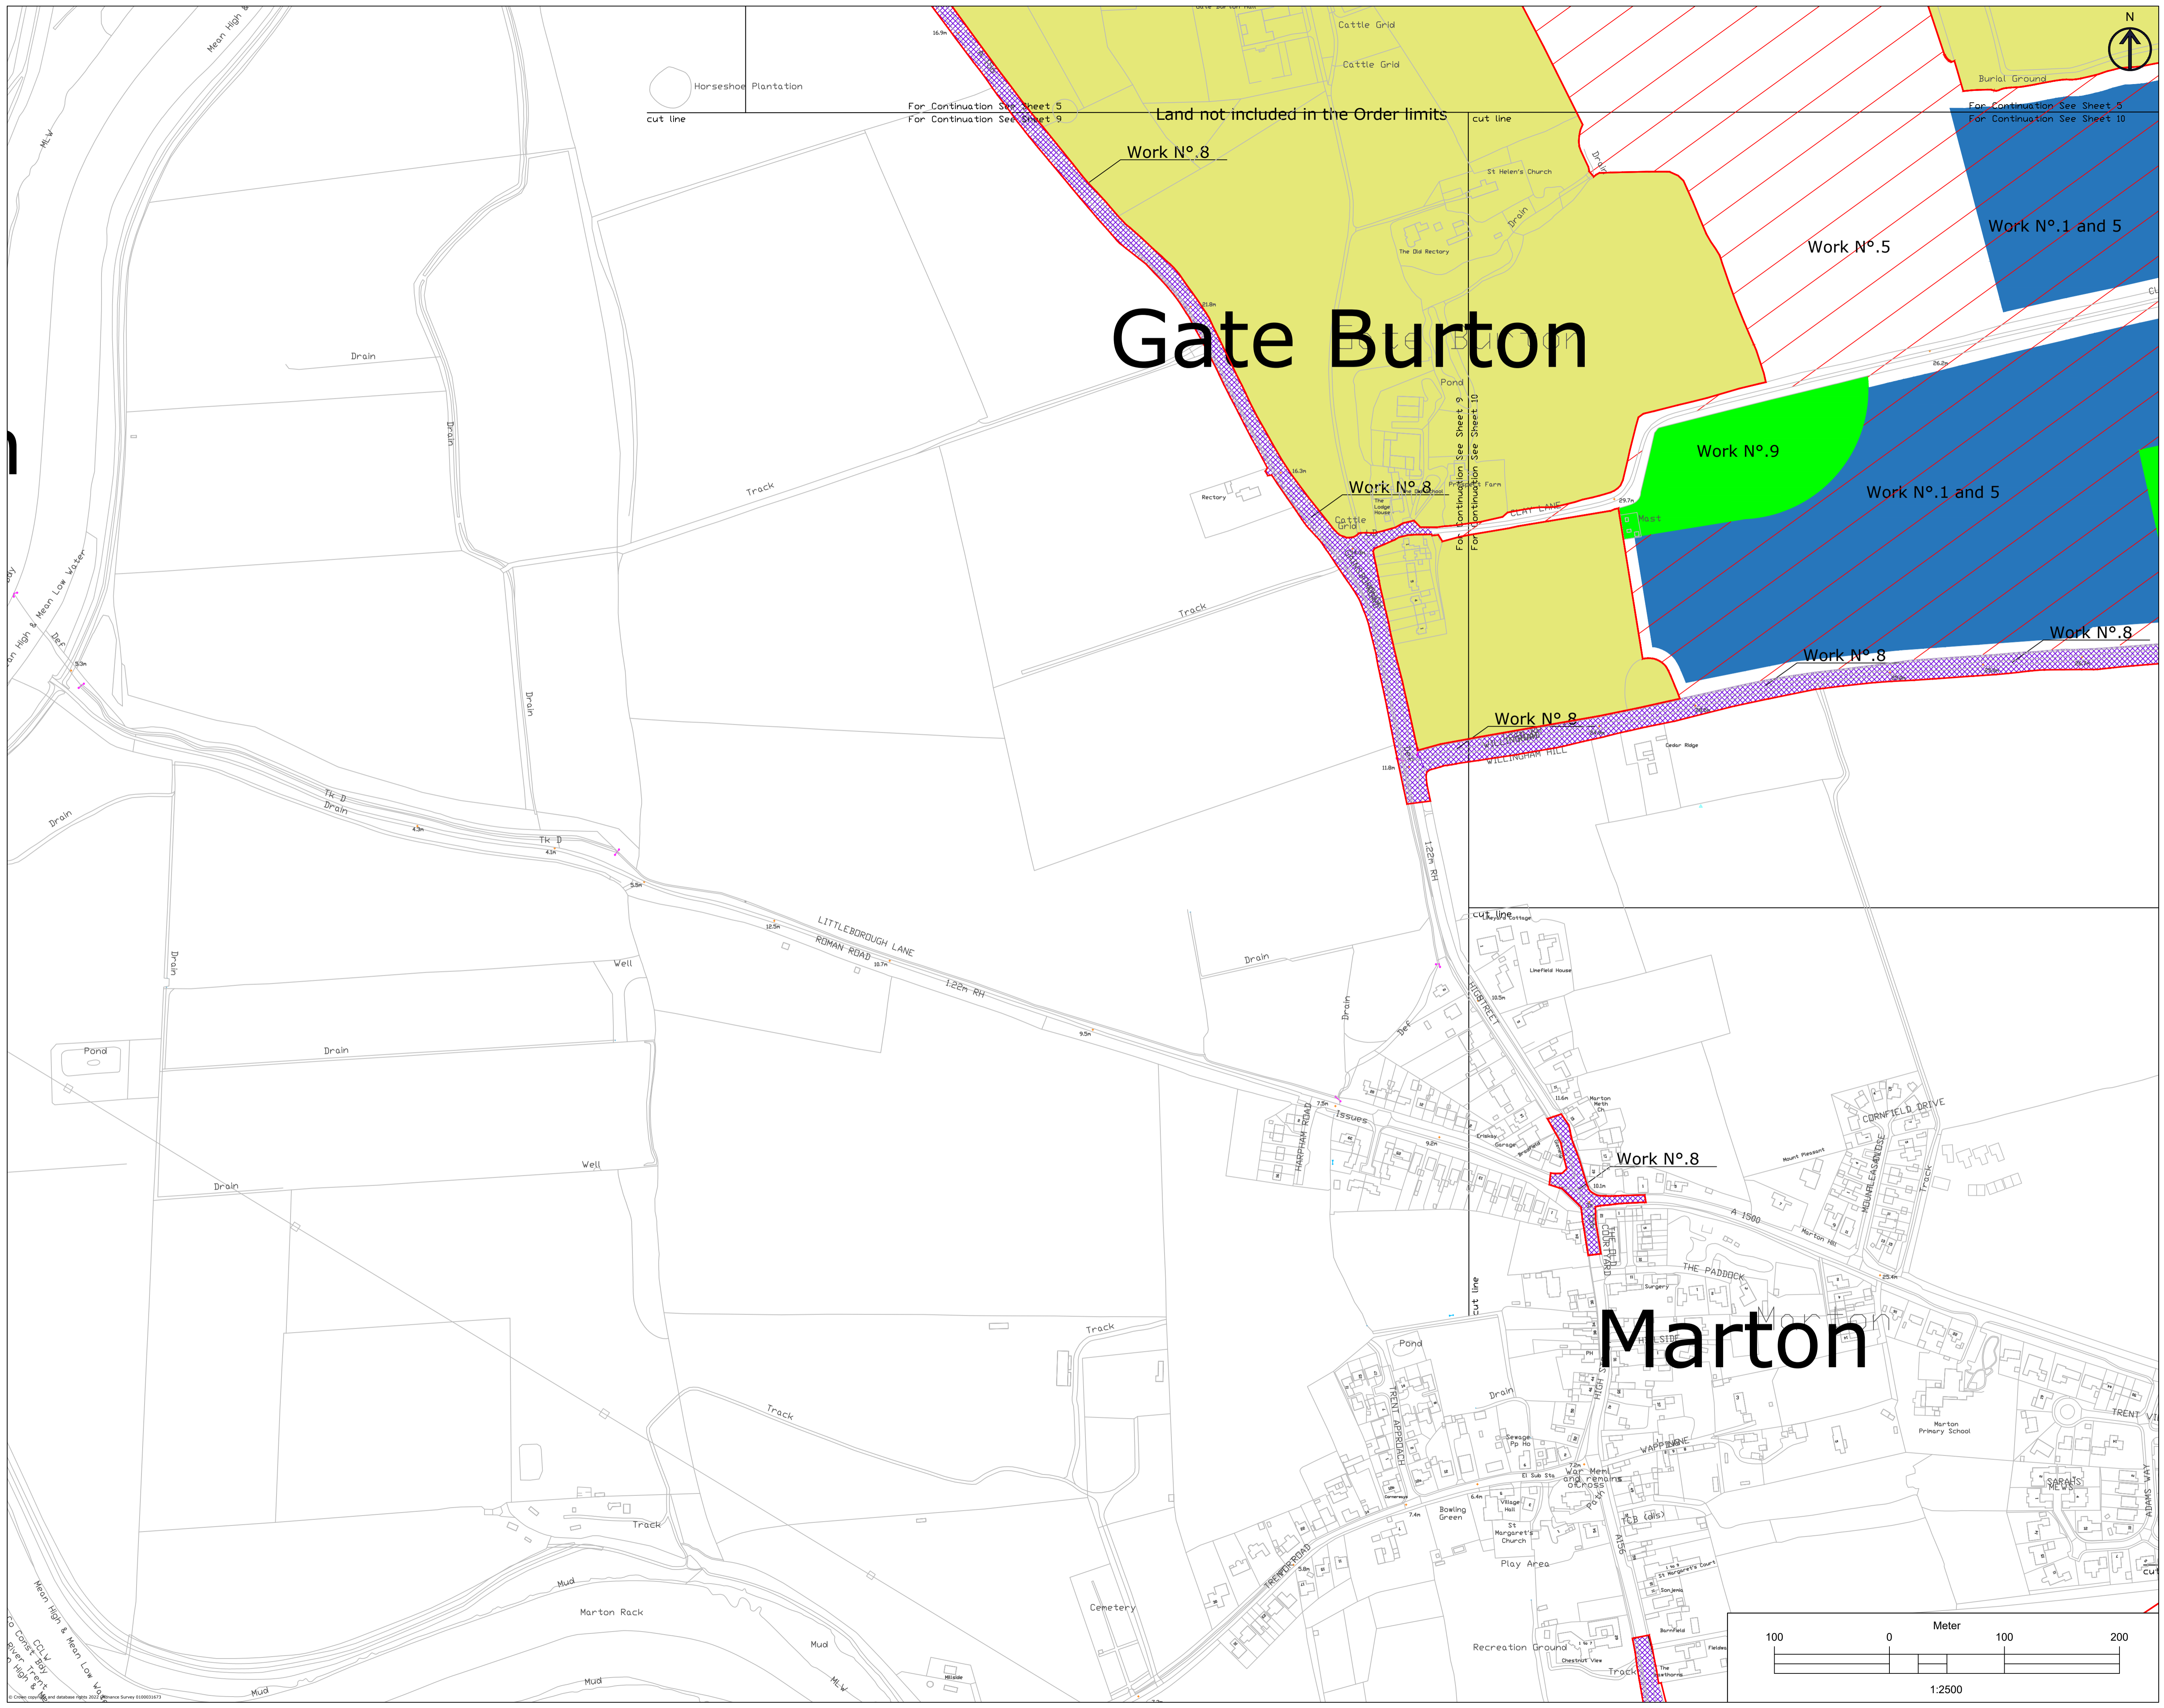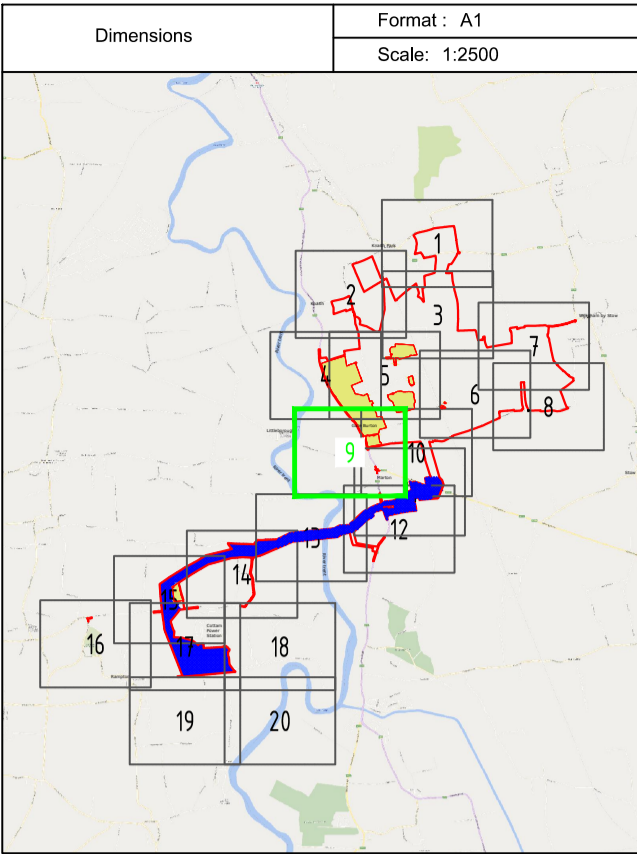



**LEGEND**

- Work No.1
- Work No.2
- Work No.3
- Work No.4a
- Work No.4b
- Work No.4c
- Work No.5
- Work No.6
- Work No.7
- Work No.8
- Work No.9
- Land not included in the Order limits



**Index**

Index	Date	Changes	Writer	Checker
A	19/01/23	Original	ABO	GDA
B	07/03/23	SSI advice update	ABO	GDA
C	03/10/23	Update for Deadline	ABO	GDA

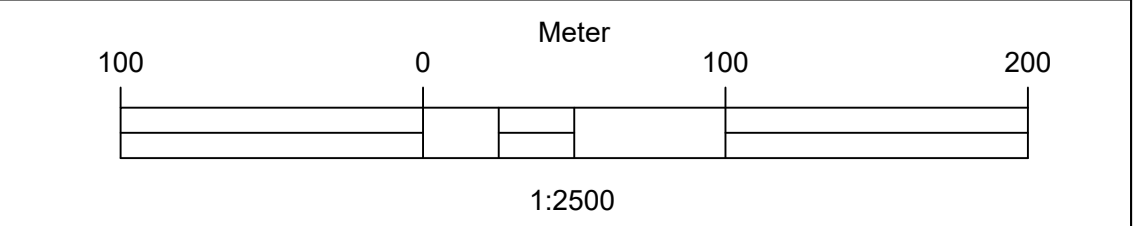

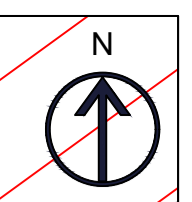

Dimensions	Format: A1
	Scale: 1:2500

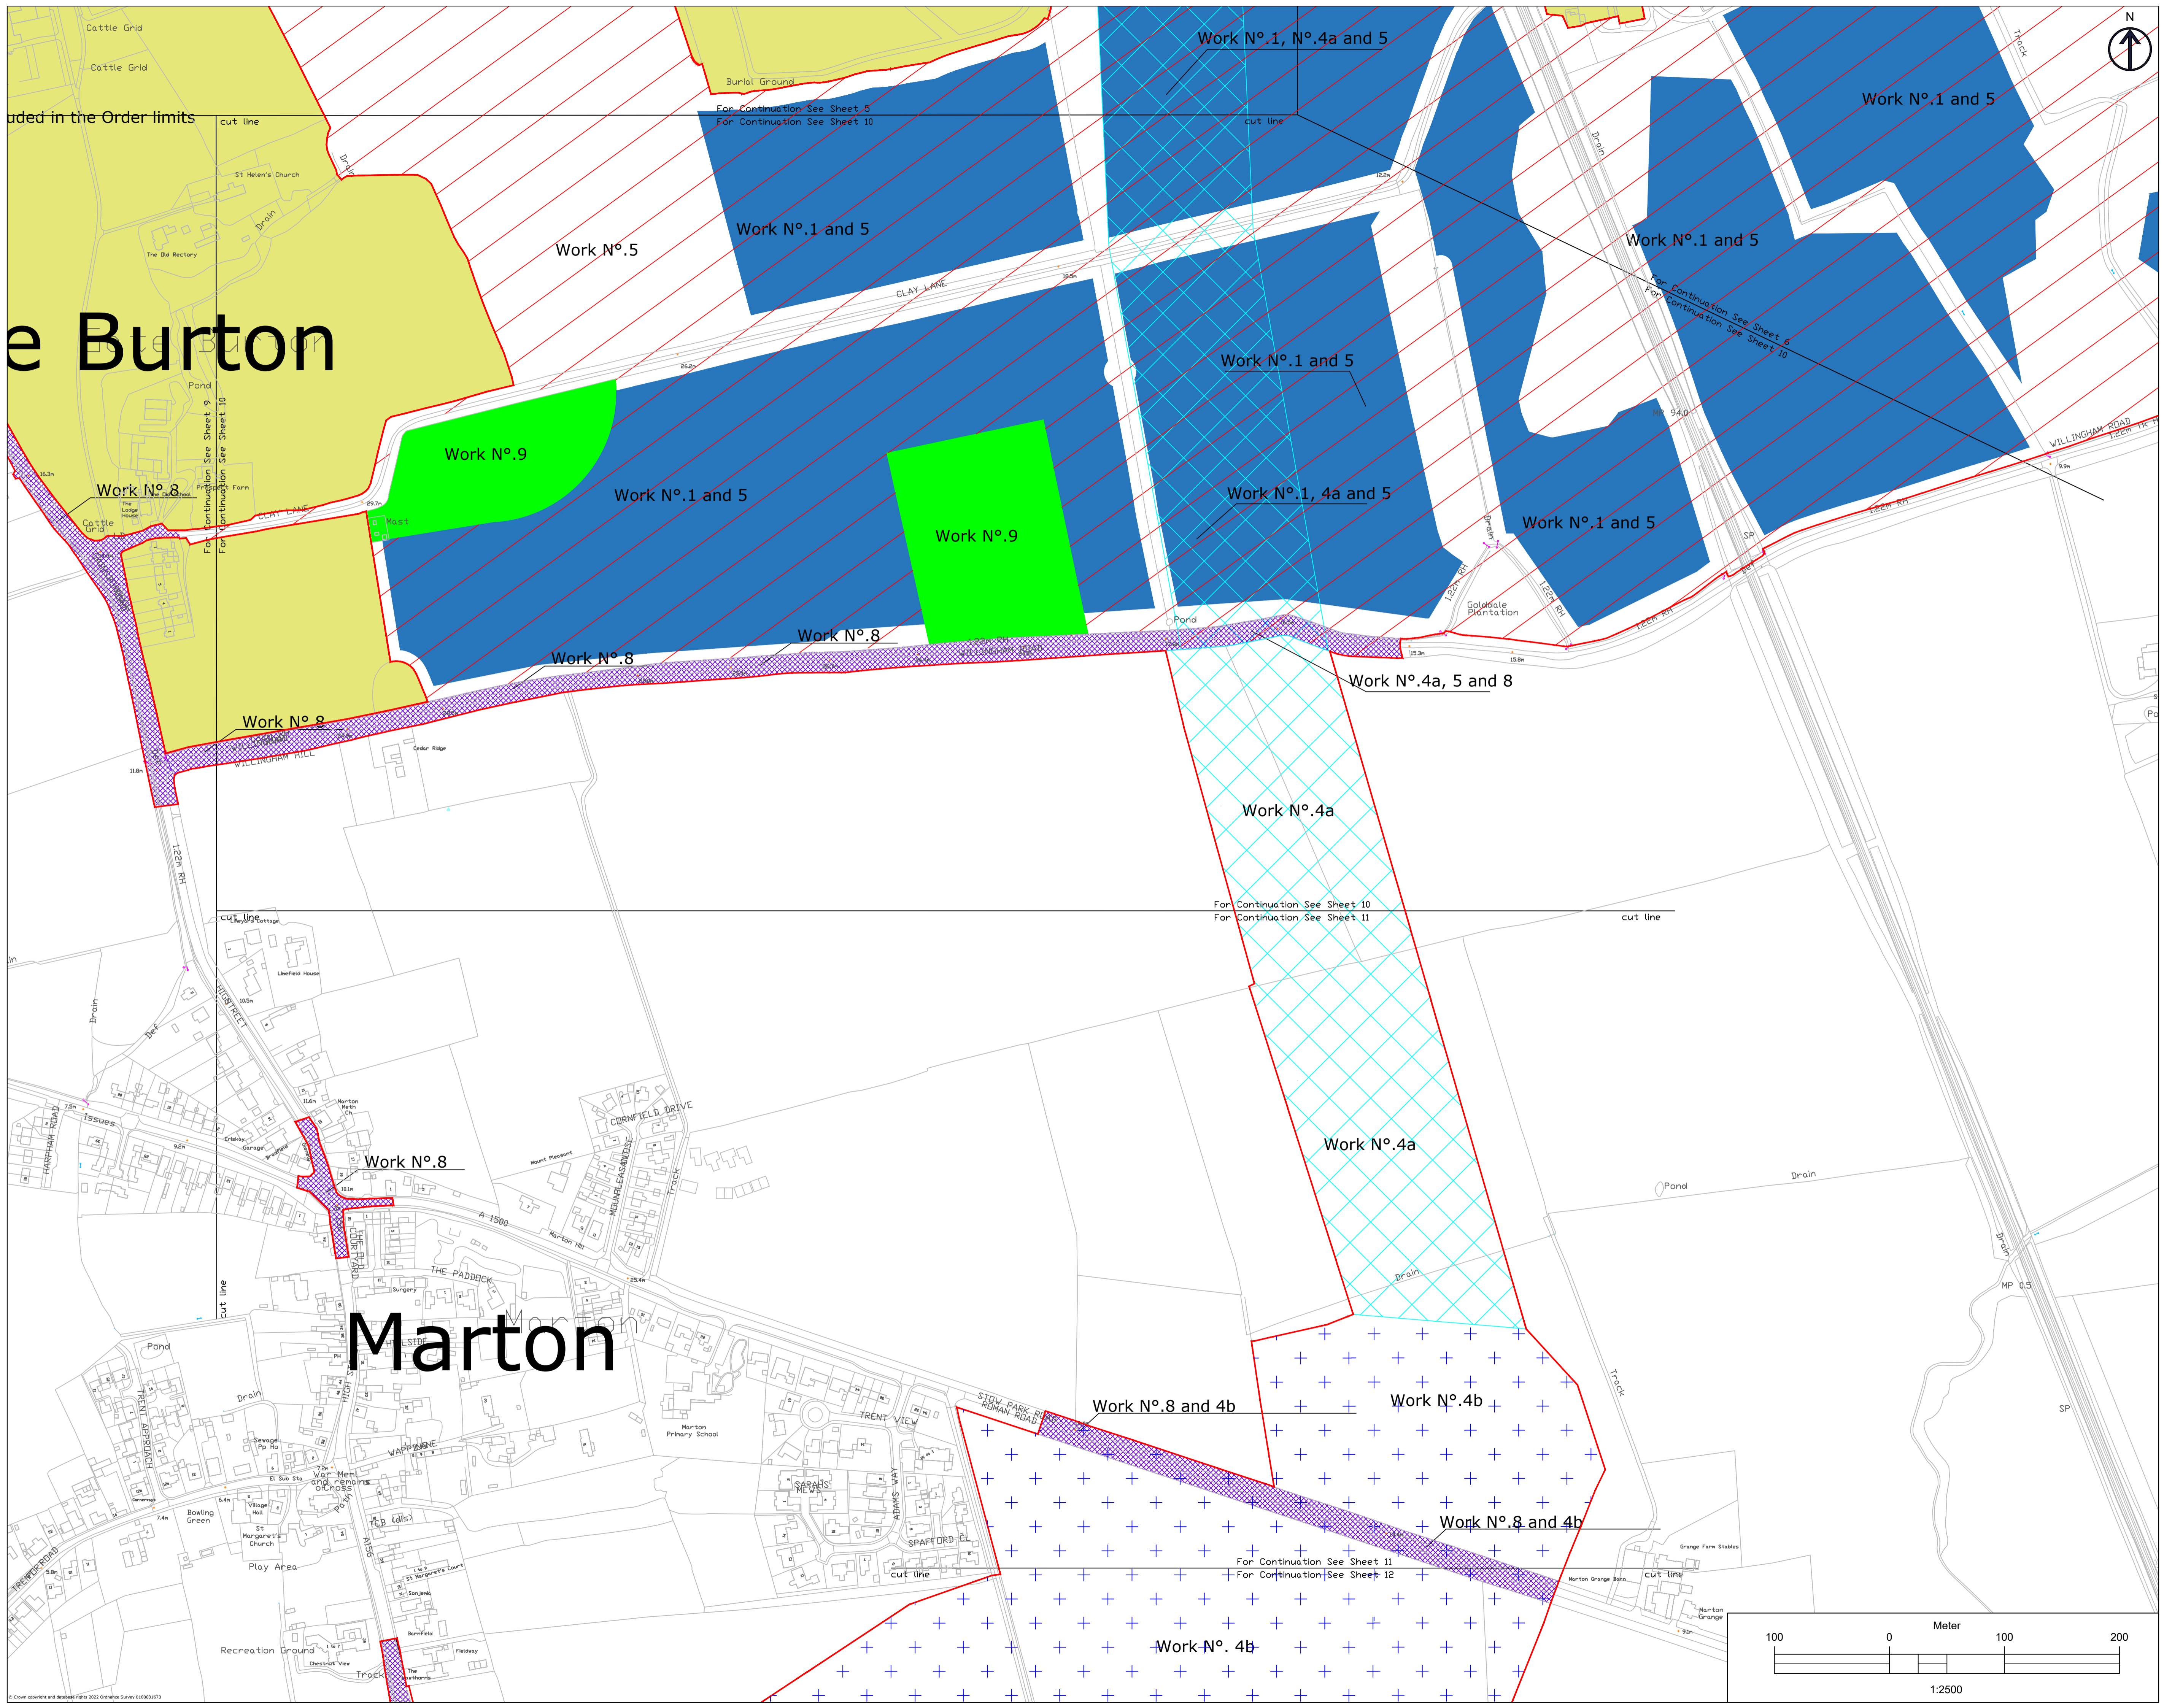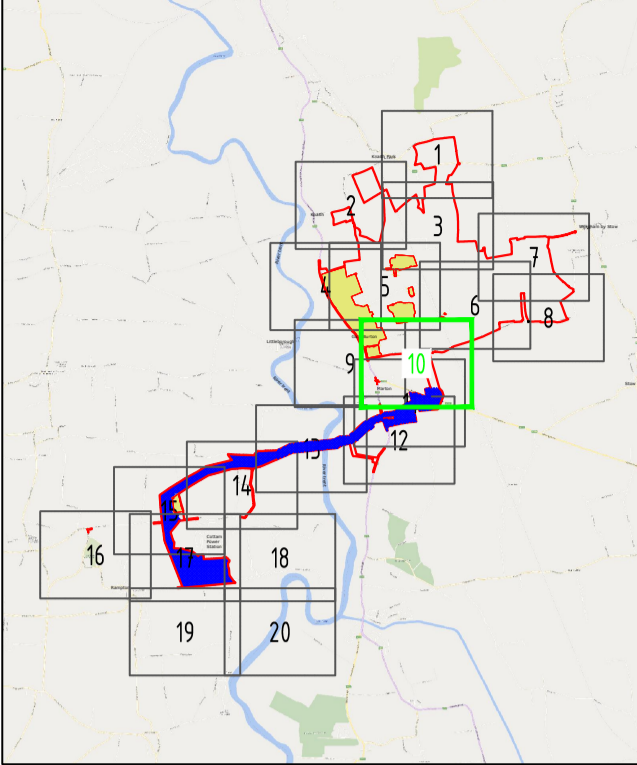





**LEGEND**

- Work No.1
- Work No.2
- Work No.3
- Work No.4a
- Work No.4b
- Work No.4c
- Work No.6
- Work No.7
- Work No.8
- Work No.9
- Land not included in the Order limits

1. THIS DRAWING IS TO BE READ IN CONJUNCTION WITH ALL OTHER RELEVANT DOCUMENTATION.  
2. WORKS SHALL BE CONDUCTED IN ACCORDANCE WITH THE SPECIFICATIONS AND REGULATIONS.  
3. ALL OPERATIONS SHALL BE CONDUCTED IN ACCORDANCE WITH THE SPECIFICATIONS AND REGULATIONS.  
4. THE WORKS ARE SUBJECT TO CHANGE THROUGH DETAILED DESIGN IN ACCORDANCE WITH THE TERMS OF THE DEVELOPER'S CONSENT ORDER.

Index	Date	Changes	Writer	Checker
A	18/01/23	Original	ABO	GDA
B	07/03/23	SSI advice update	ABO	GDA
C	03/10/23	Update for Deadline	ABO	GDA

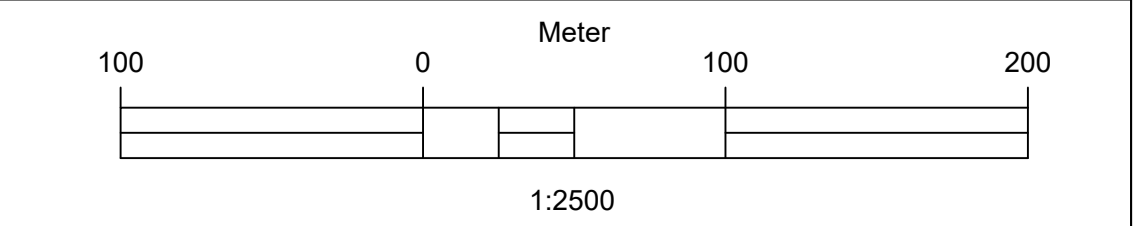

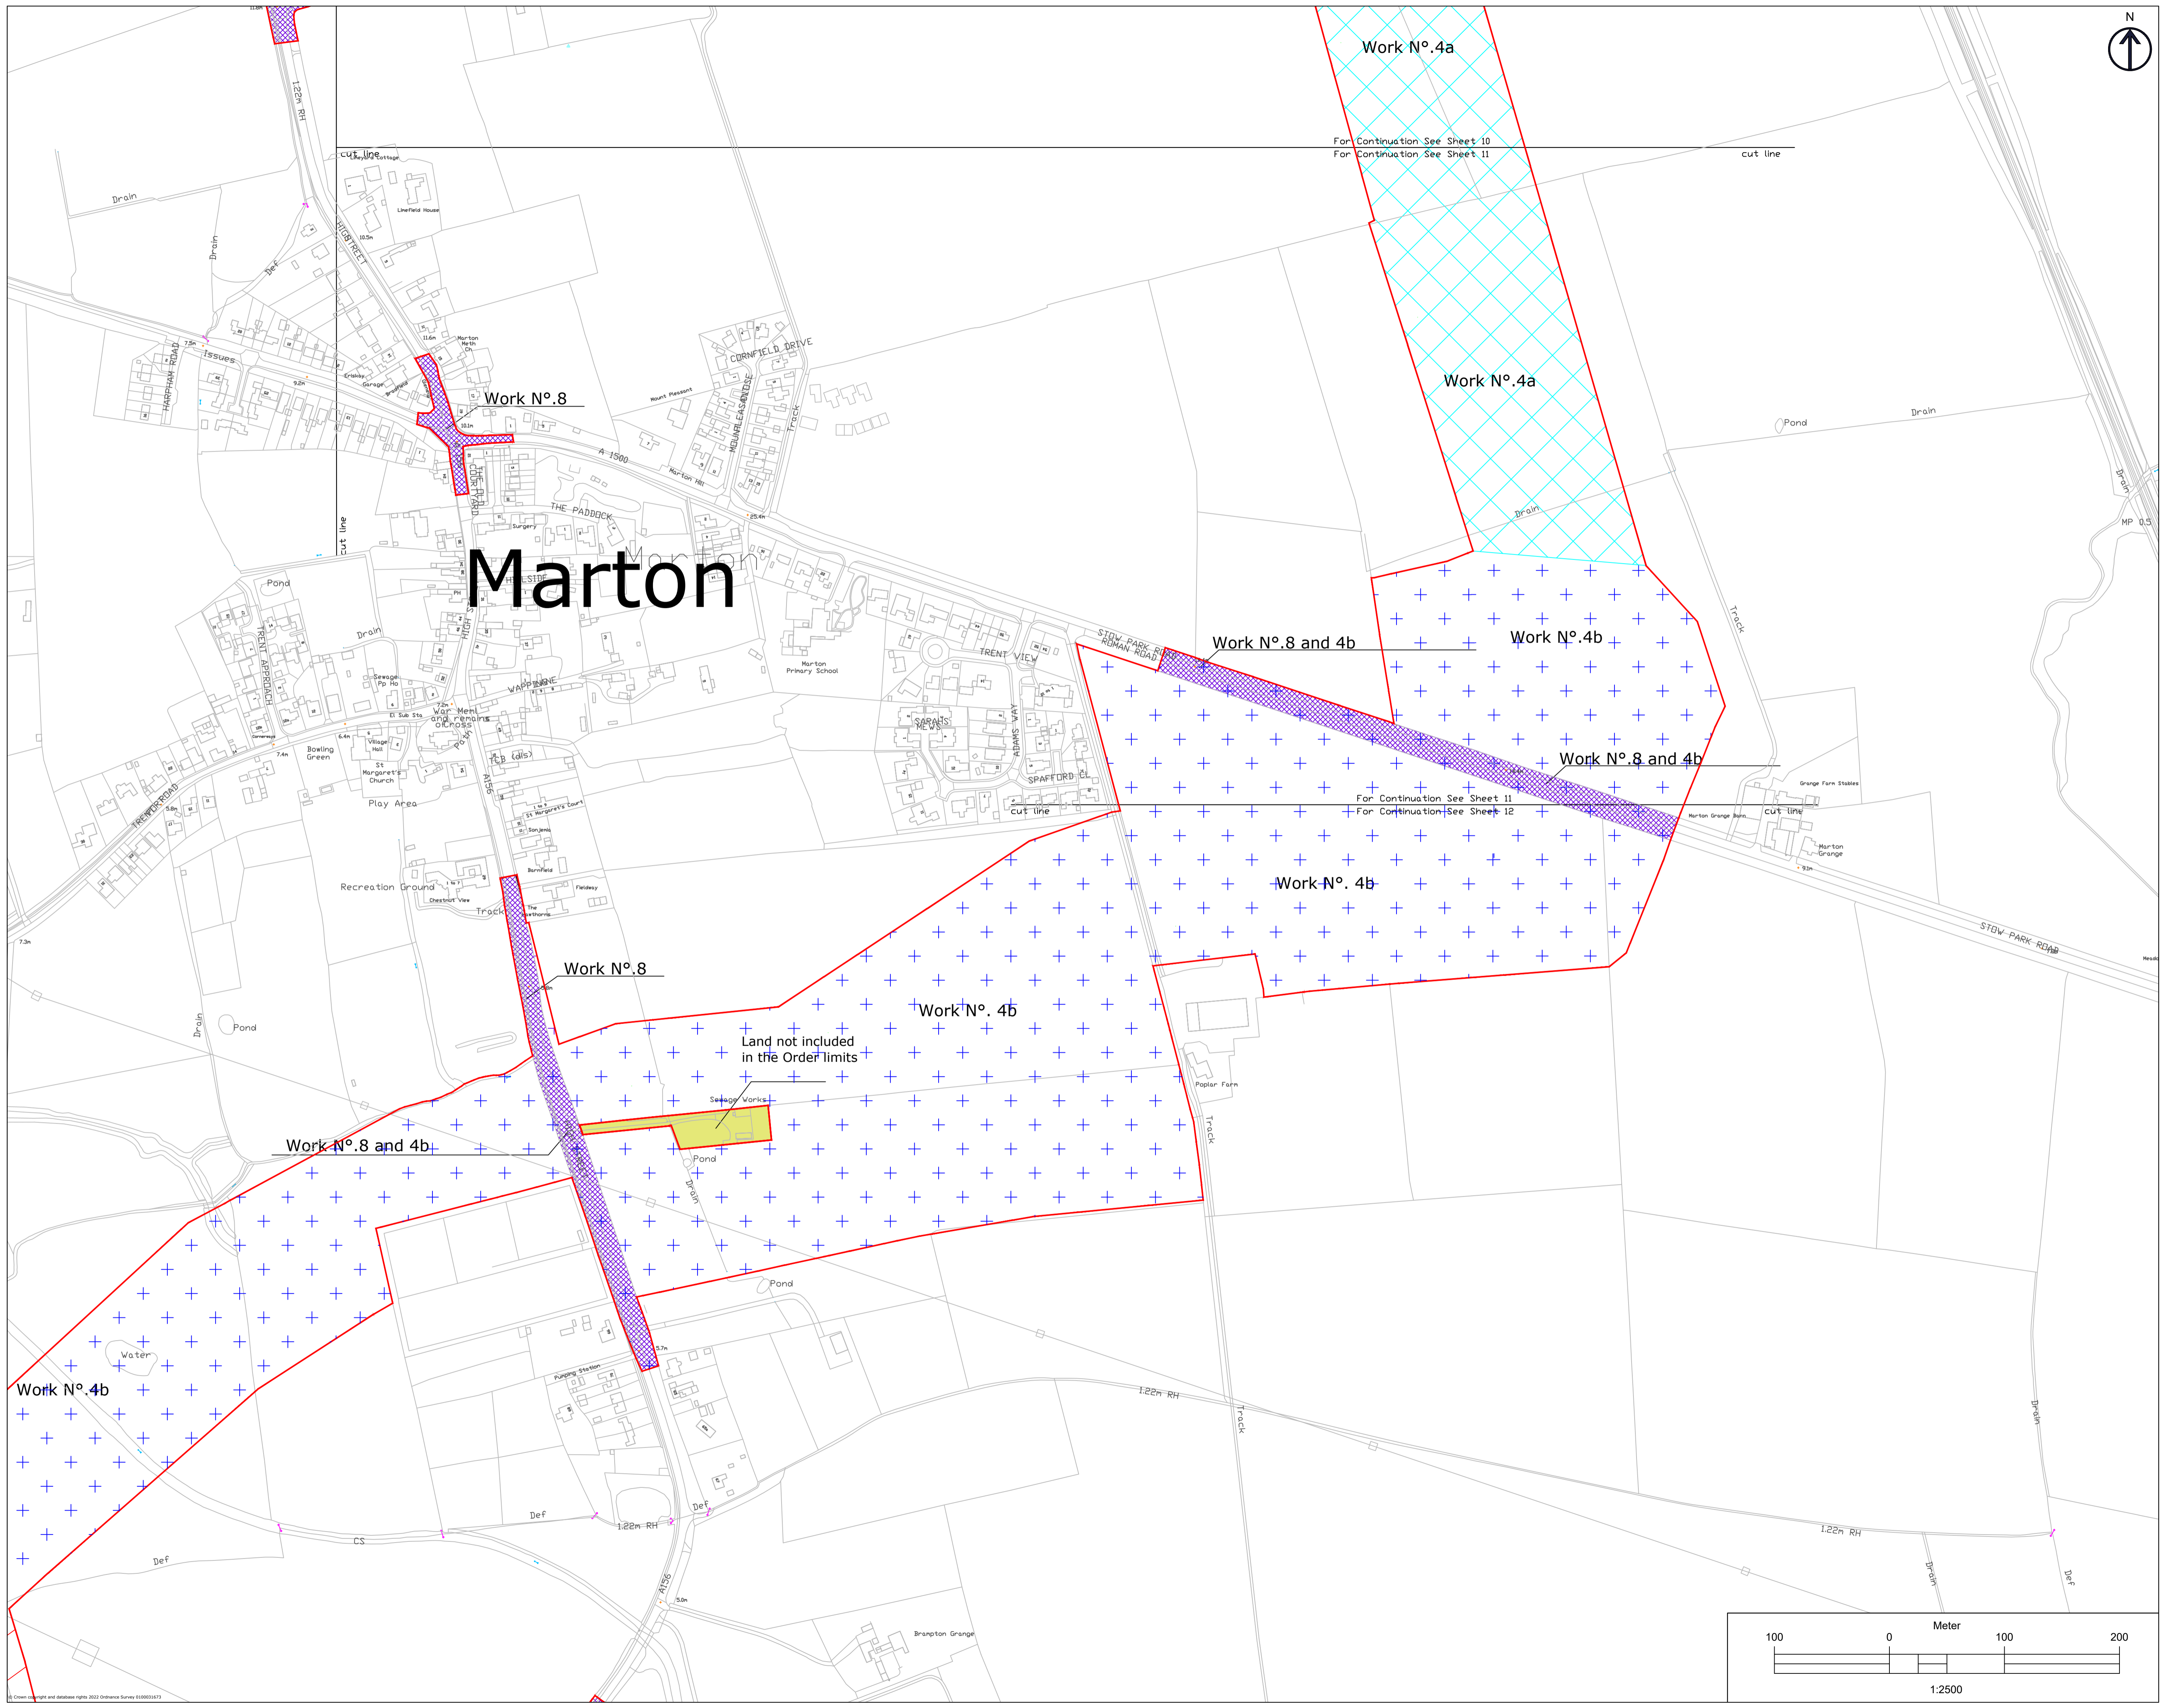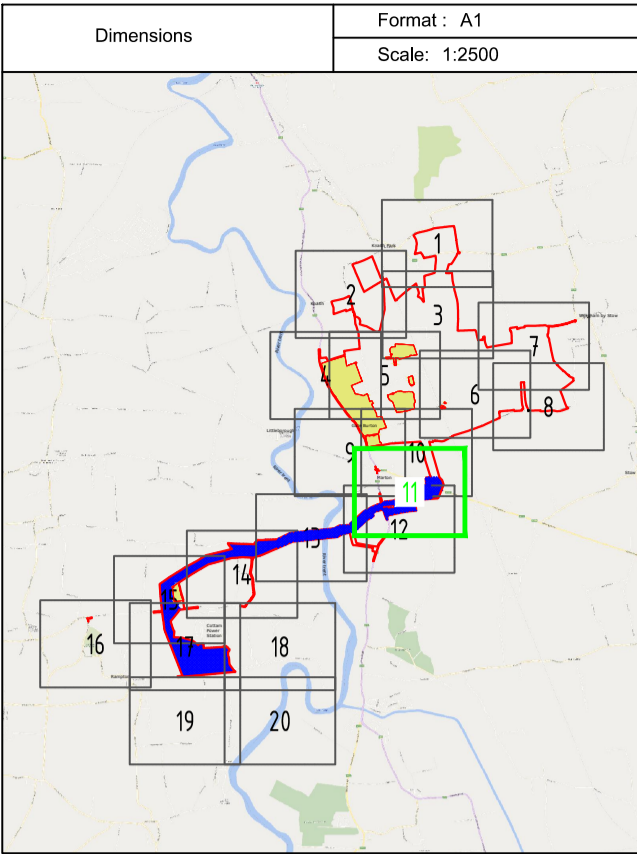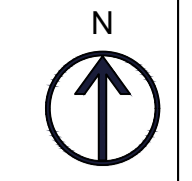


# Marton

**LEGEND**

- Work No.1
- Work No.2
- Work No.3
- Work No.4a
- Work No.4b
- Work No.4c
- Work No.5
- Work No.6
- Work No.7
- Work No.8
- Work No.9
- Land not included in the Order limits



1. THIS DRAWING IS TO BE READ IN CONJUNCTION WITH ALL OTHER RELEVANT DOCUMENTATION.  
2. WORKS MUST BE IN ACCORDANCE WITH THE SPECIFICATIONS OF THE RELEVANT PLANNING PERMISSIONS, PROCEDURES AND REGULATIONS.  
3. ALL DIMENSIONS, COORDINATES, LEVELS AND CORRECTIONS ARE IN METRES UNLESS OTHERWISE SPECIFIED.  
4. THE WORKS ARE SUBJECT TO CHANGE THROUGH DEVELOPER DESIGN IN ACCORDANCE WITH THE TERMS OF THE DEVELOPER'S CONTRACT.  
5. THE WORKS ARE SUBJECT TO CHANGE THROUGH DEVELOPER DESIGN IN ACCORDANCE WITH THE TERMS OF THE DEVELOPER'S CONTRACT.

Index	Date	Changes	Writer	Checker
A	19/01/23	Original	ABO	GDA
B	07/03/23	SS1 advice update	ABO	GDA
C	03/10/23	Update for Deadline	ABO	GDA

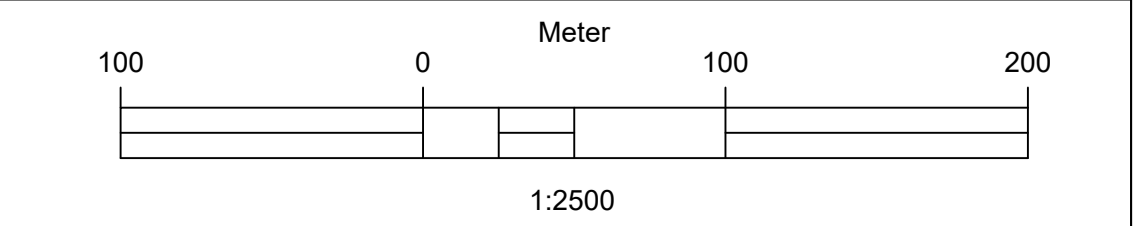





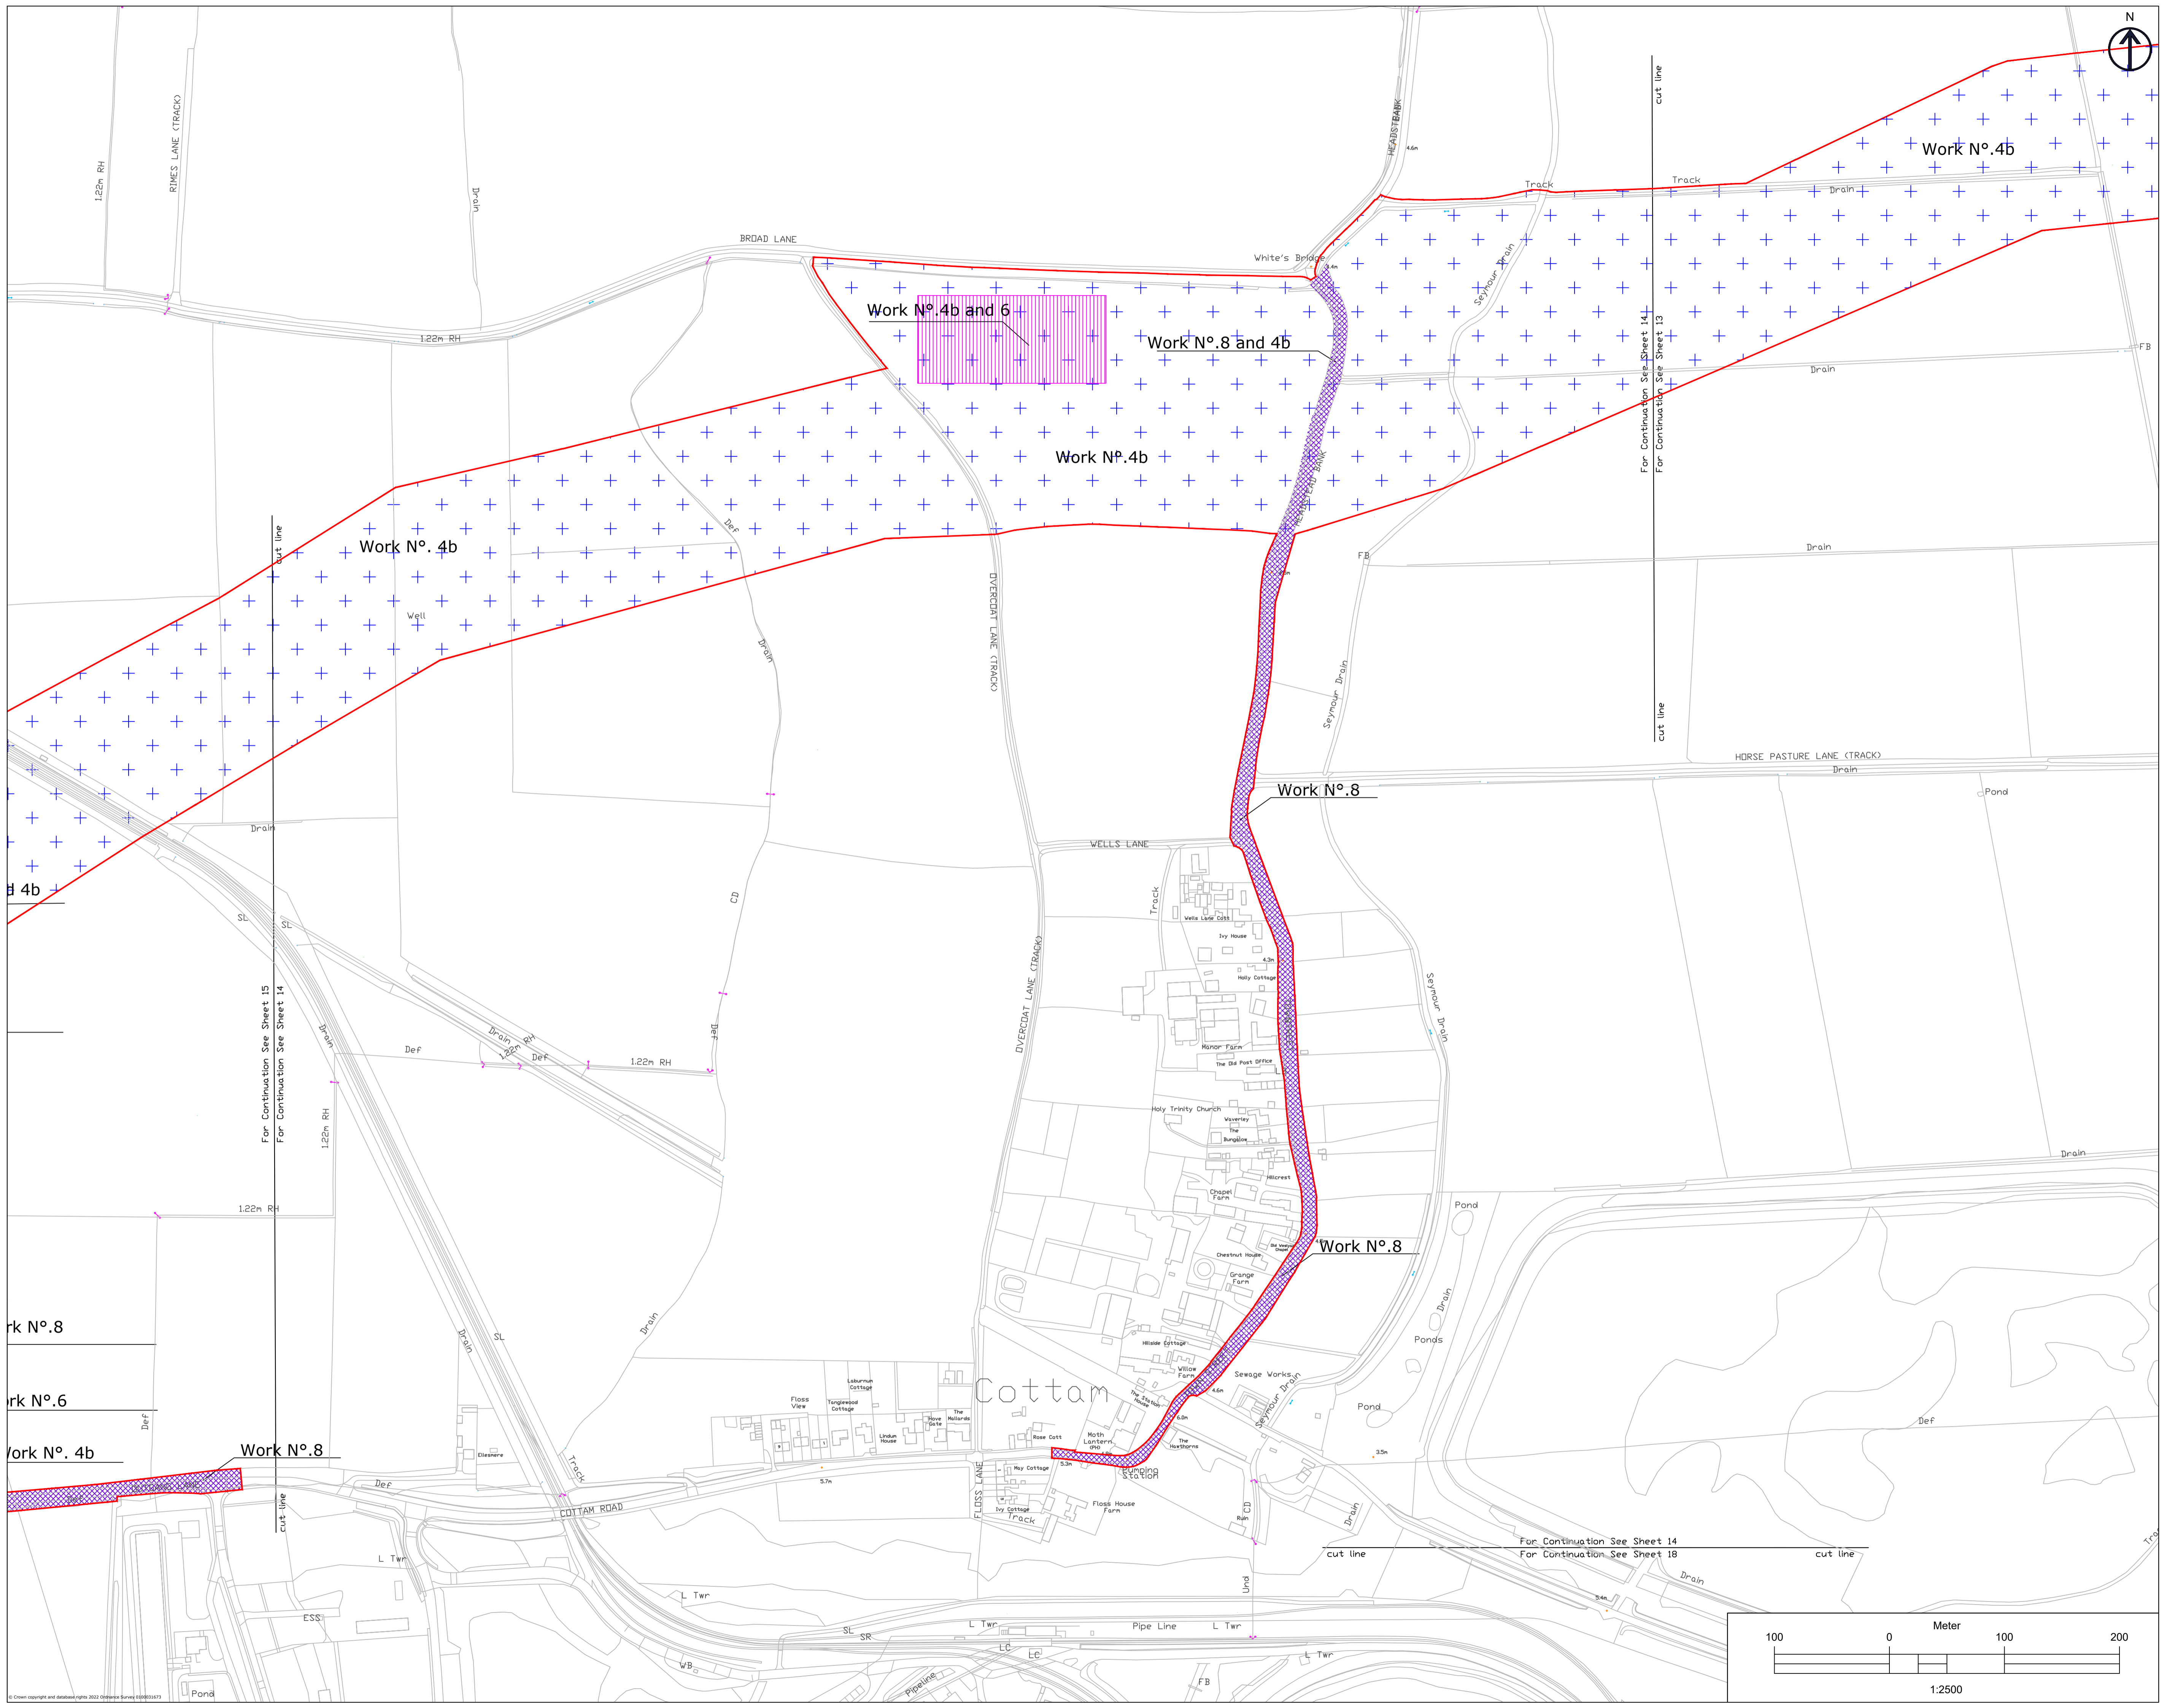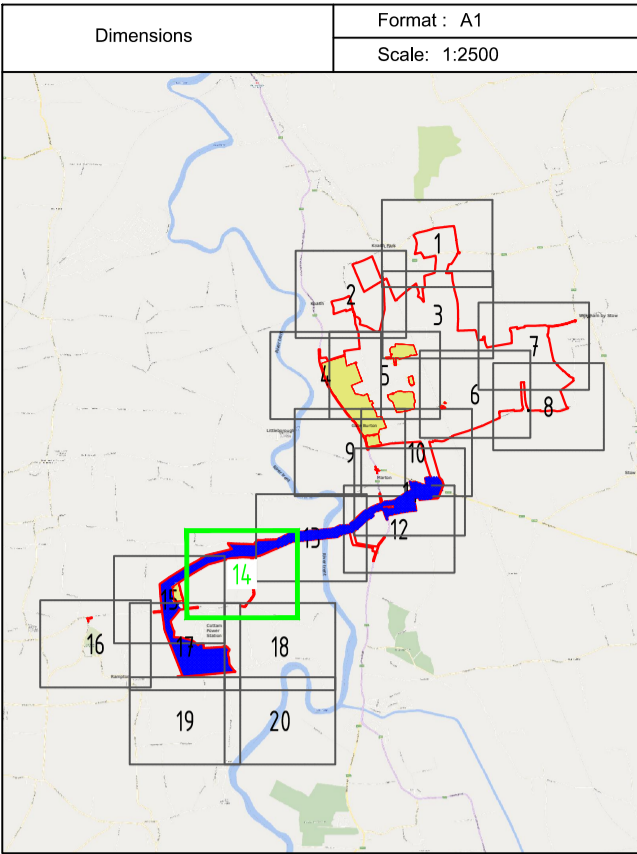


**LEGEND**



- Work No.1
- Work No.2
- Work No.3
- Work No.4a
- Work No.4b
- Work No.4c
- Work No.5
- Work No.6
- Work No.7
- Work No.8
- Work No.9
- Land not included in the Order limits

1. THIS DRAWING IS TO BE READ IN CONJUNCTION WITH ALL OTHER RELEVANT DOCUMENTATION.  
2. WORKS SHALL BE IN ACCORDANCE WITH THE SPECIFICATIONS AND CONDITIONS OF THE PARTICULARS AND PRELIMINARY PROPOSALS AND PROCEDURES AND REGULATIONS.  
3. ALL DIMENSIONS, COORDINATES, LEVELS AND CONDITIONS ARE IN METRES UNLESS OTHERWISE SPECIFIED.  
4. THE WORKER SHALL BE RESPONSIBLE FOR CHECKING THE POSITION OF ALL WORK POINTS TO BE CHECKED ON SITE, AND ANY DISCREPANCIES SHALL BE REPORTED TO THE PROJECT MANAGER IMMEDIATELY.  
5. THE WORKER SHALL BE RESPONSIBLE FOR CHECKING THE POSITION OF ALL WORK POINTS TO BE CHECKED ON SITE, AND ANY DISCREPANCIES SHALL BE REPORTED TO THE PROJECT MANAGER IMMEDIATELY.

Index	Date	Changes	Writer	Checker
A	19/01/23	Original	ABO	GDA
B	07/03/23	SS1 advice update	ABO	GDA
C	03/10/23	Update for Deadline	ABO	GDA

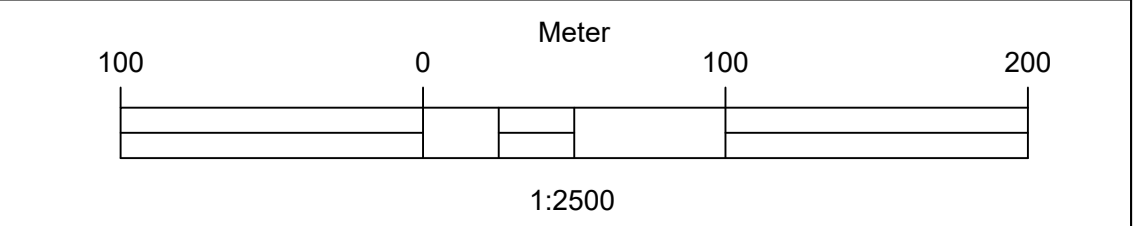



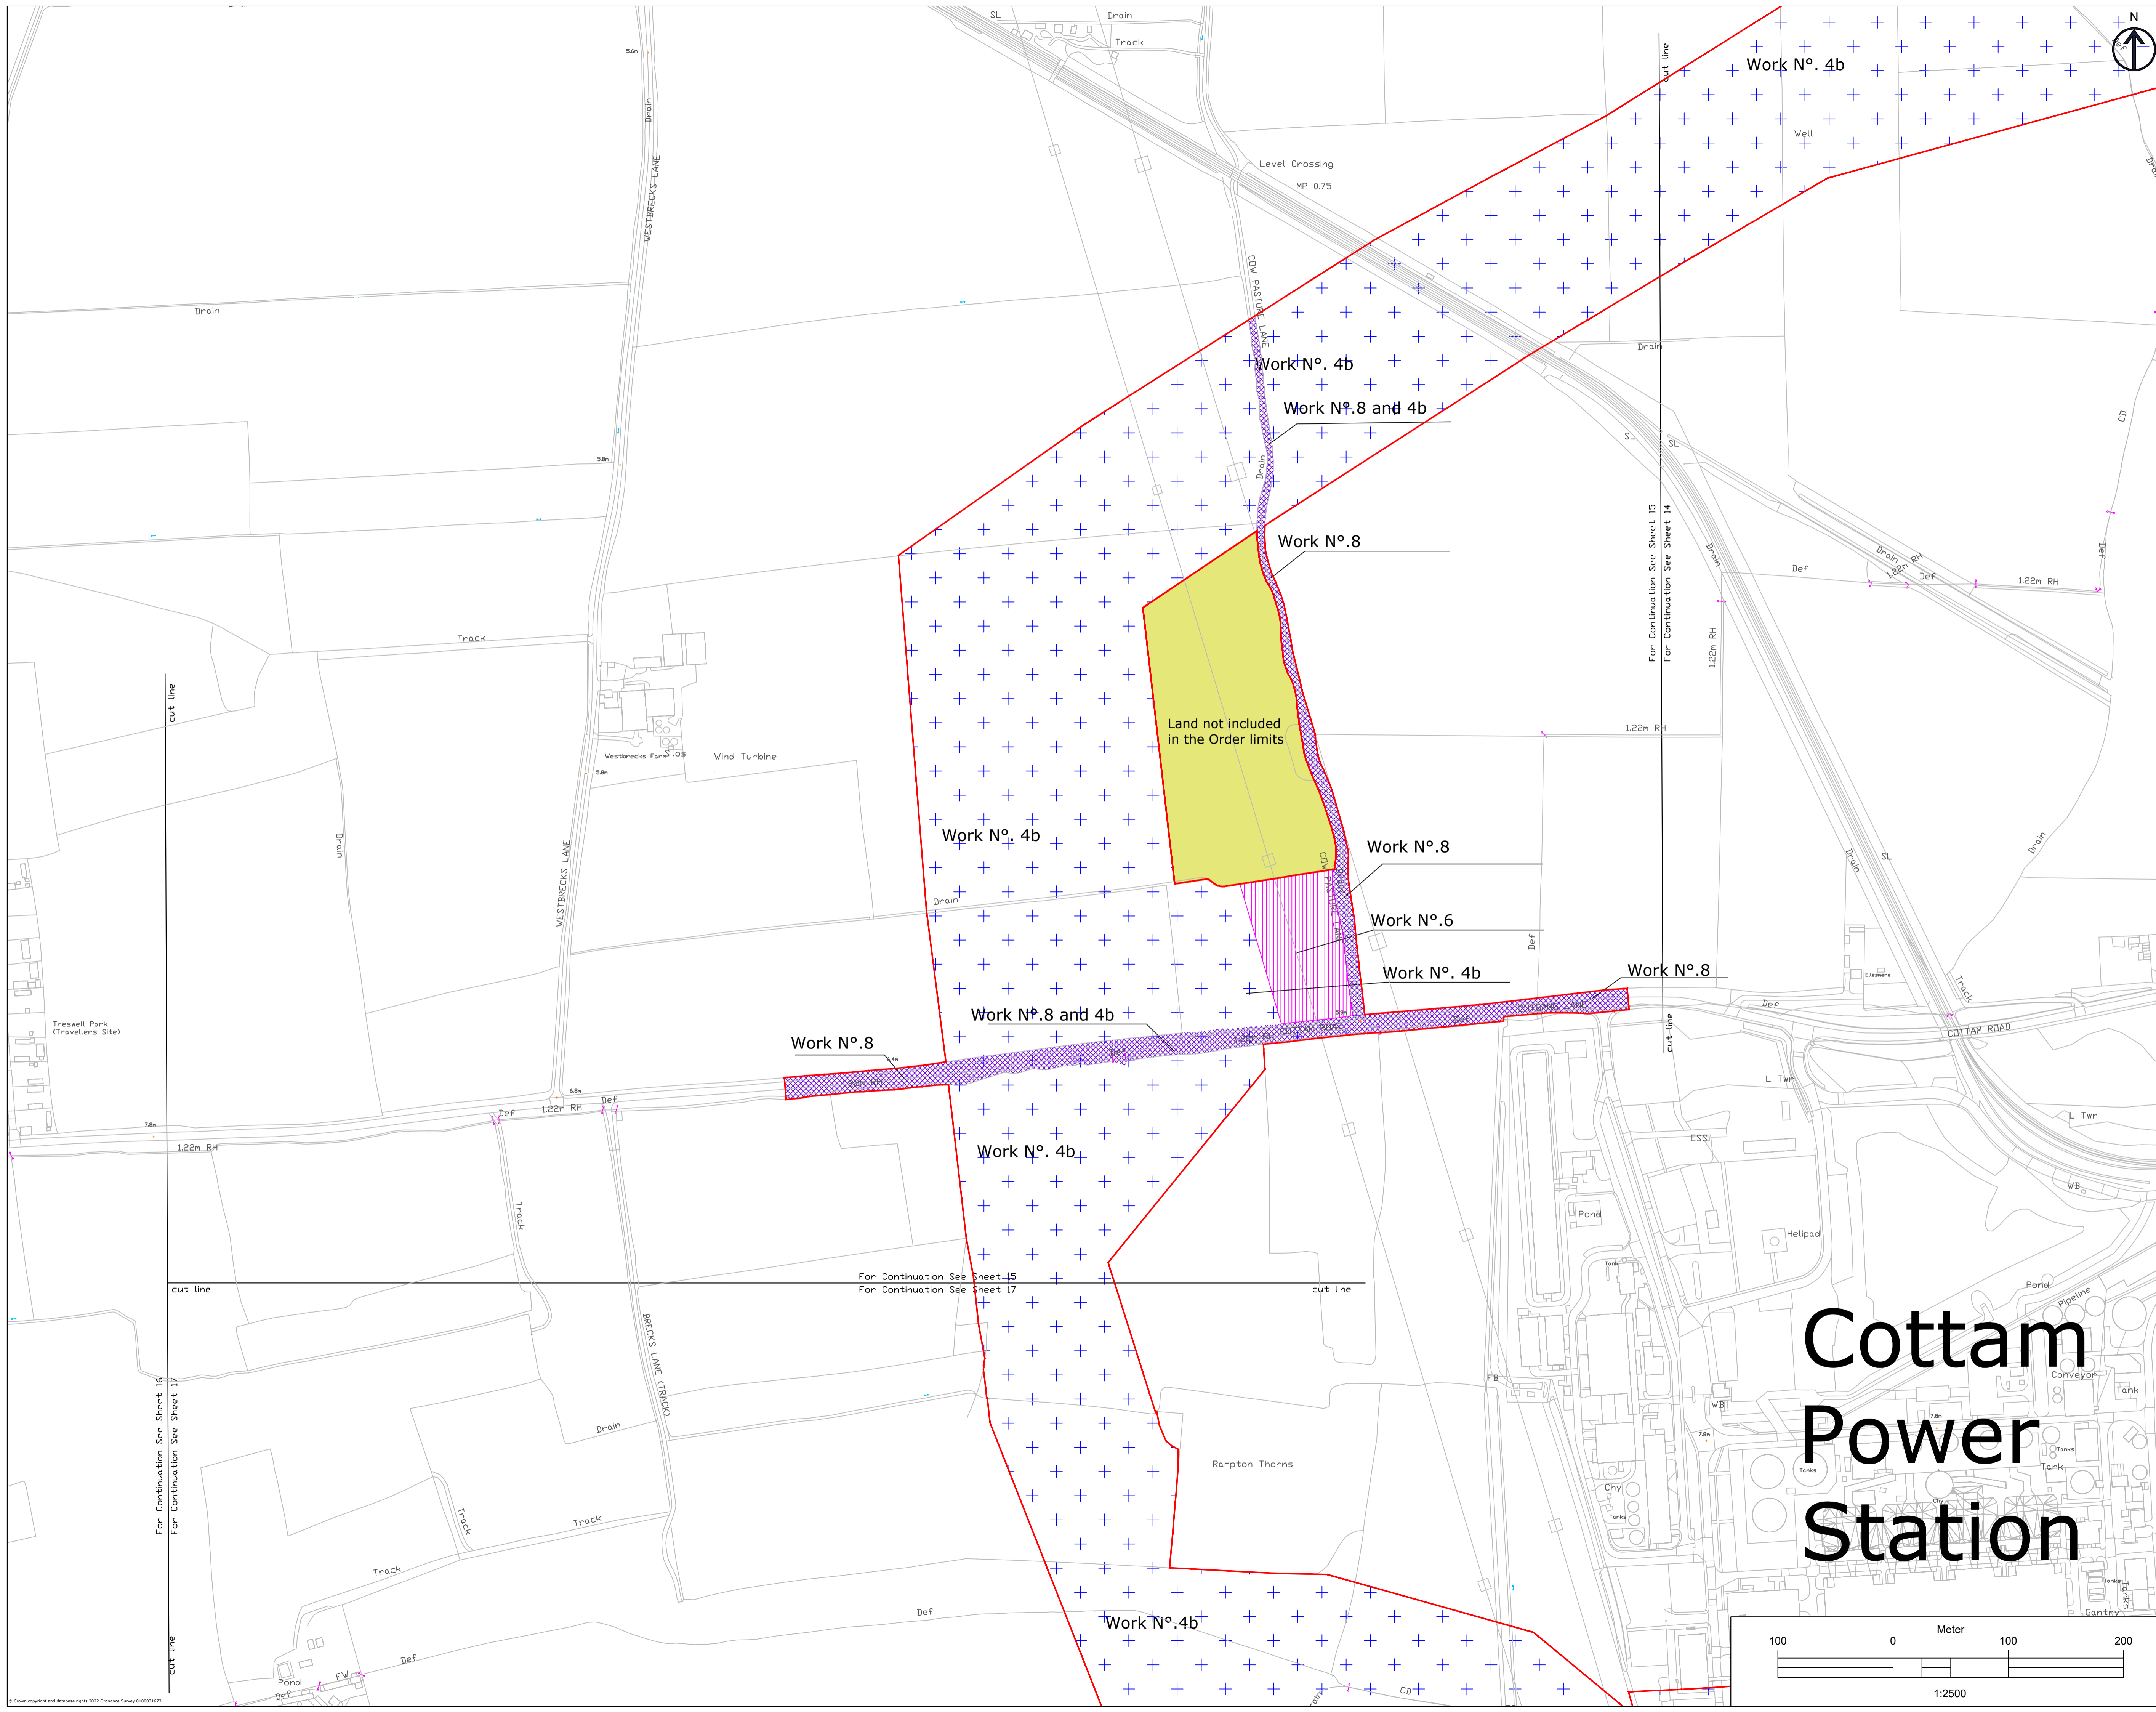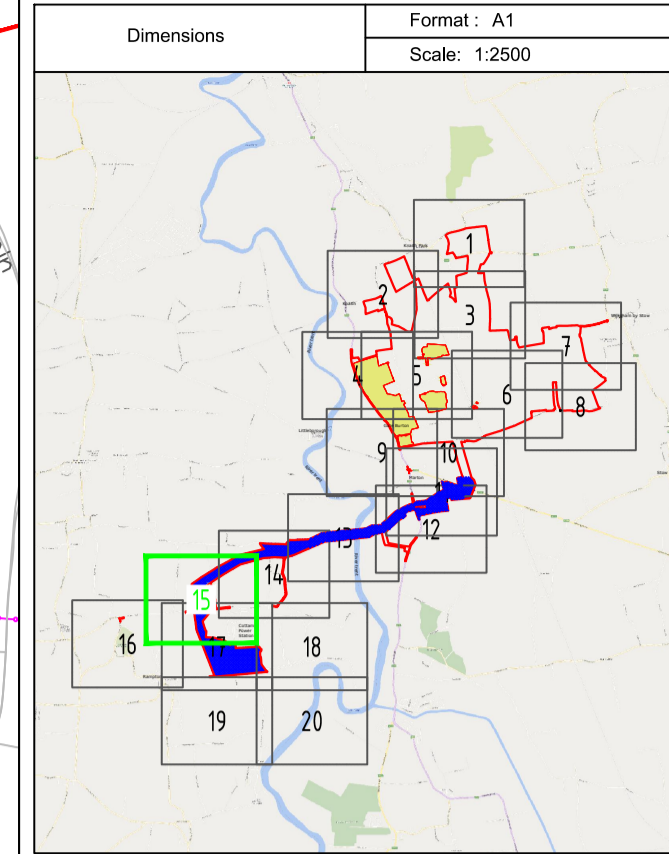




**LEGEND**

- Work No.1
- Work No.2
- Work No.3
- Work No.4a
- Work No.4b
- Work No.4c
- Work No.5
- Work No.6
- Work No.7
- Work No.8
- Work No.9
- Land not included in the Order limits

1. THIS DRAWING IS TO BE READ IN CONJUNCTION WITH ALL OTHER RELEVANT DOCUMENTATION.  
2. WORKS MUST BE IN ACCORDANCE WITH REGULATIONS AND THE INSTRUCTIONS IN THESE DRAWINGS.  
3. ALL DIMENSIONS, COORDINATES, LEVELS AND CONTOURS ARE IN METRES UNLESS OTHERWISE SPECIFIED.  
4. THE WORKER SHALL BE RESPONSIBLE FOR CHECKING THE POSITION OF ALL WORK POINTS ON SITE AND ANY DISCREPANCIES SHALL BE REPORTED TO THE PROJECT MANAGER IMMEDIATELY.  
5. THE WORKER SHALL BE RESPONSIBLE FOR CHECKING THE POSITION OF ALL WORK POINTS ON SITE AND ANY DISCREPANCIES SHALL BE REPORTED TO THE PROJECT MANAGER IMMEDIATELY.

Index	Date	Changes	Writer	Checker
A	18/01/23	Original	ABO	GDA
B	07/03/23	SS1 advice update	ABO	GDA
C	03/10/23	Update for Deadline	ABO	GDA

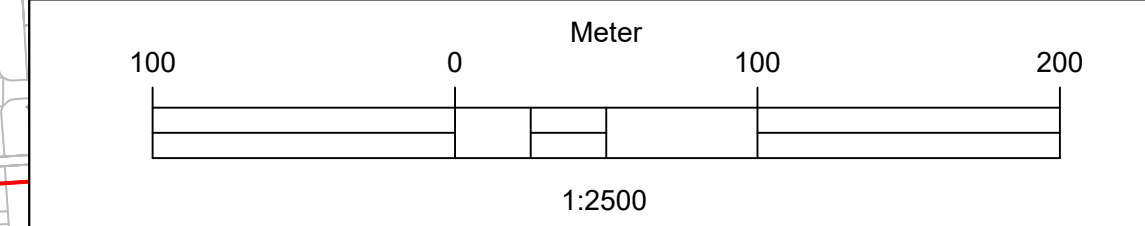

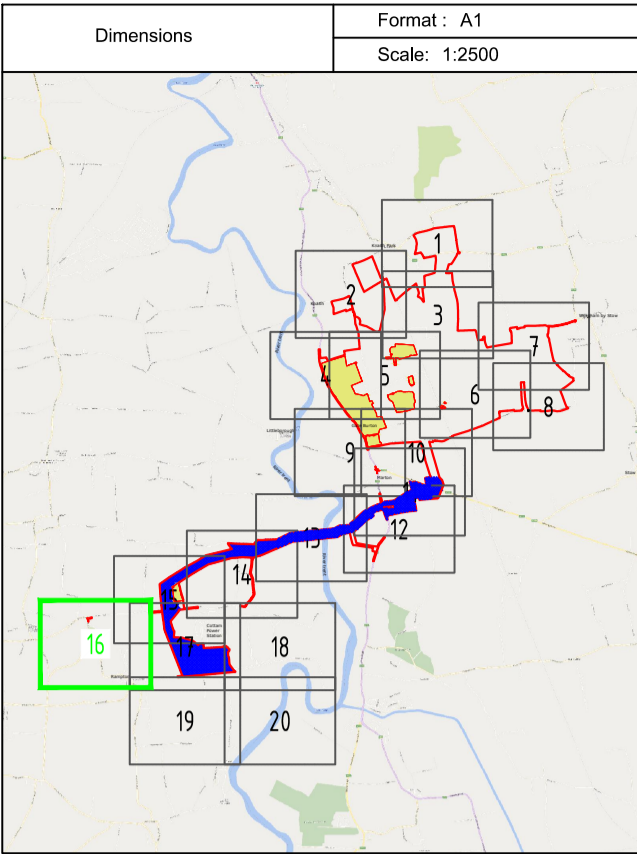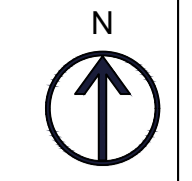


**LEGEND**



- Work No.1
- Work No.2
- Work No.3
- Work No.4a
- Work No.4b
- Work No.4c
- Work No.5
- Work No.6
- Work No.7
- Work No.8
- Work No.9
- Land not included in the Order limits

1. THIS DRAWING IS TO BE READ IN CONJUNCTION WITH ALL OTHER RELEVANT DOCUMENTATION.  
2. WORKS SHALL BE IN ACCORDANCE WITH THE SPECIFICATIONS AND PROCEDURES IN THE RELEVANT DOCUMENTATION.  
3. ALL DIMENSIONS, COORDINATES, LEVELS AND CONTROLS ARE IN METRES UNLESS SPECIFICALLY STATED OTHERWISE.  
4. THE OWNER AND DESIGNER ACCEPT RESPONSIBILITY FOR THE ACCURACY OF THE INFORMATION ON SITE, AND ANY DISCREPANCIES SHALL BE REPORTED TO THE DESIGNER IMMEDIATELY UPON DISCOVERY.  
5. THE OWNER AND DESIGNER ACCEPT RESPONSIBILITY FOR ANY AND ALL SUBJECT TO CHANGE THROUGH DETAILED DESIGN IN ACCORDANCE WITH THE TERMS OF THE DEVELOPER'S CONTRACT DOCUMENT.

Index	Date	Changes	Writer	Checker
A	19/01/23	Original	ABO	GDA
B	07/03/23	SS1 advice update	ABO	GDA
C	03/10/23	Update for Deadline	ABO	GDA

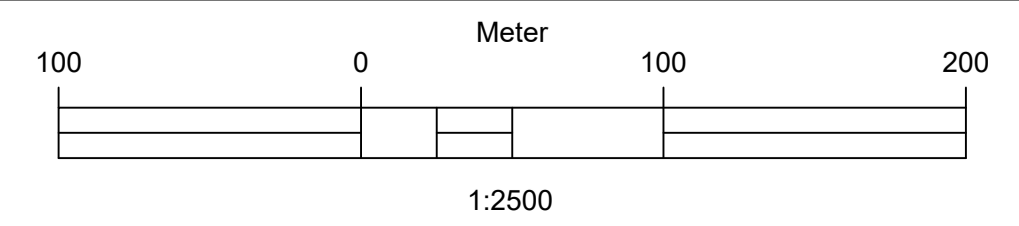

Rampton

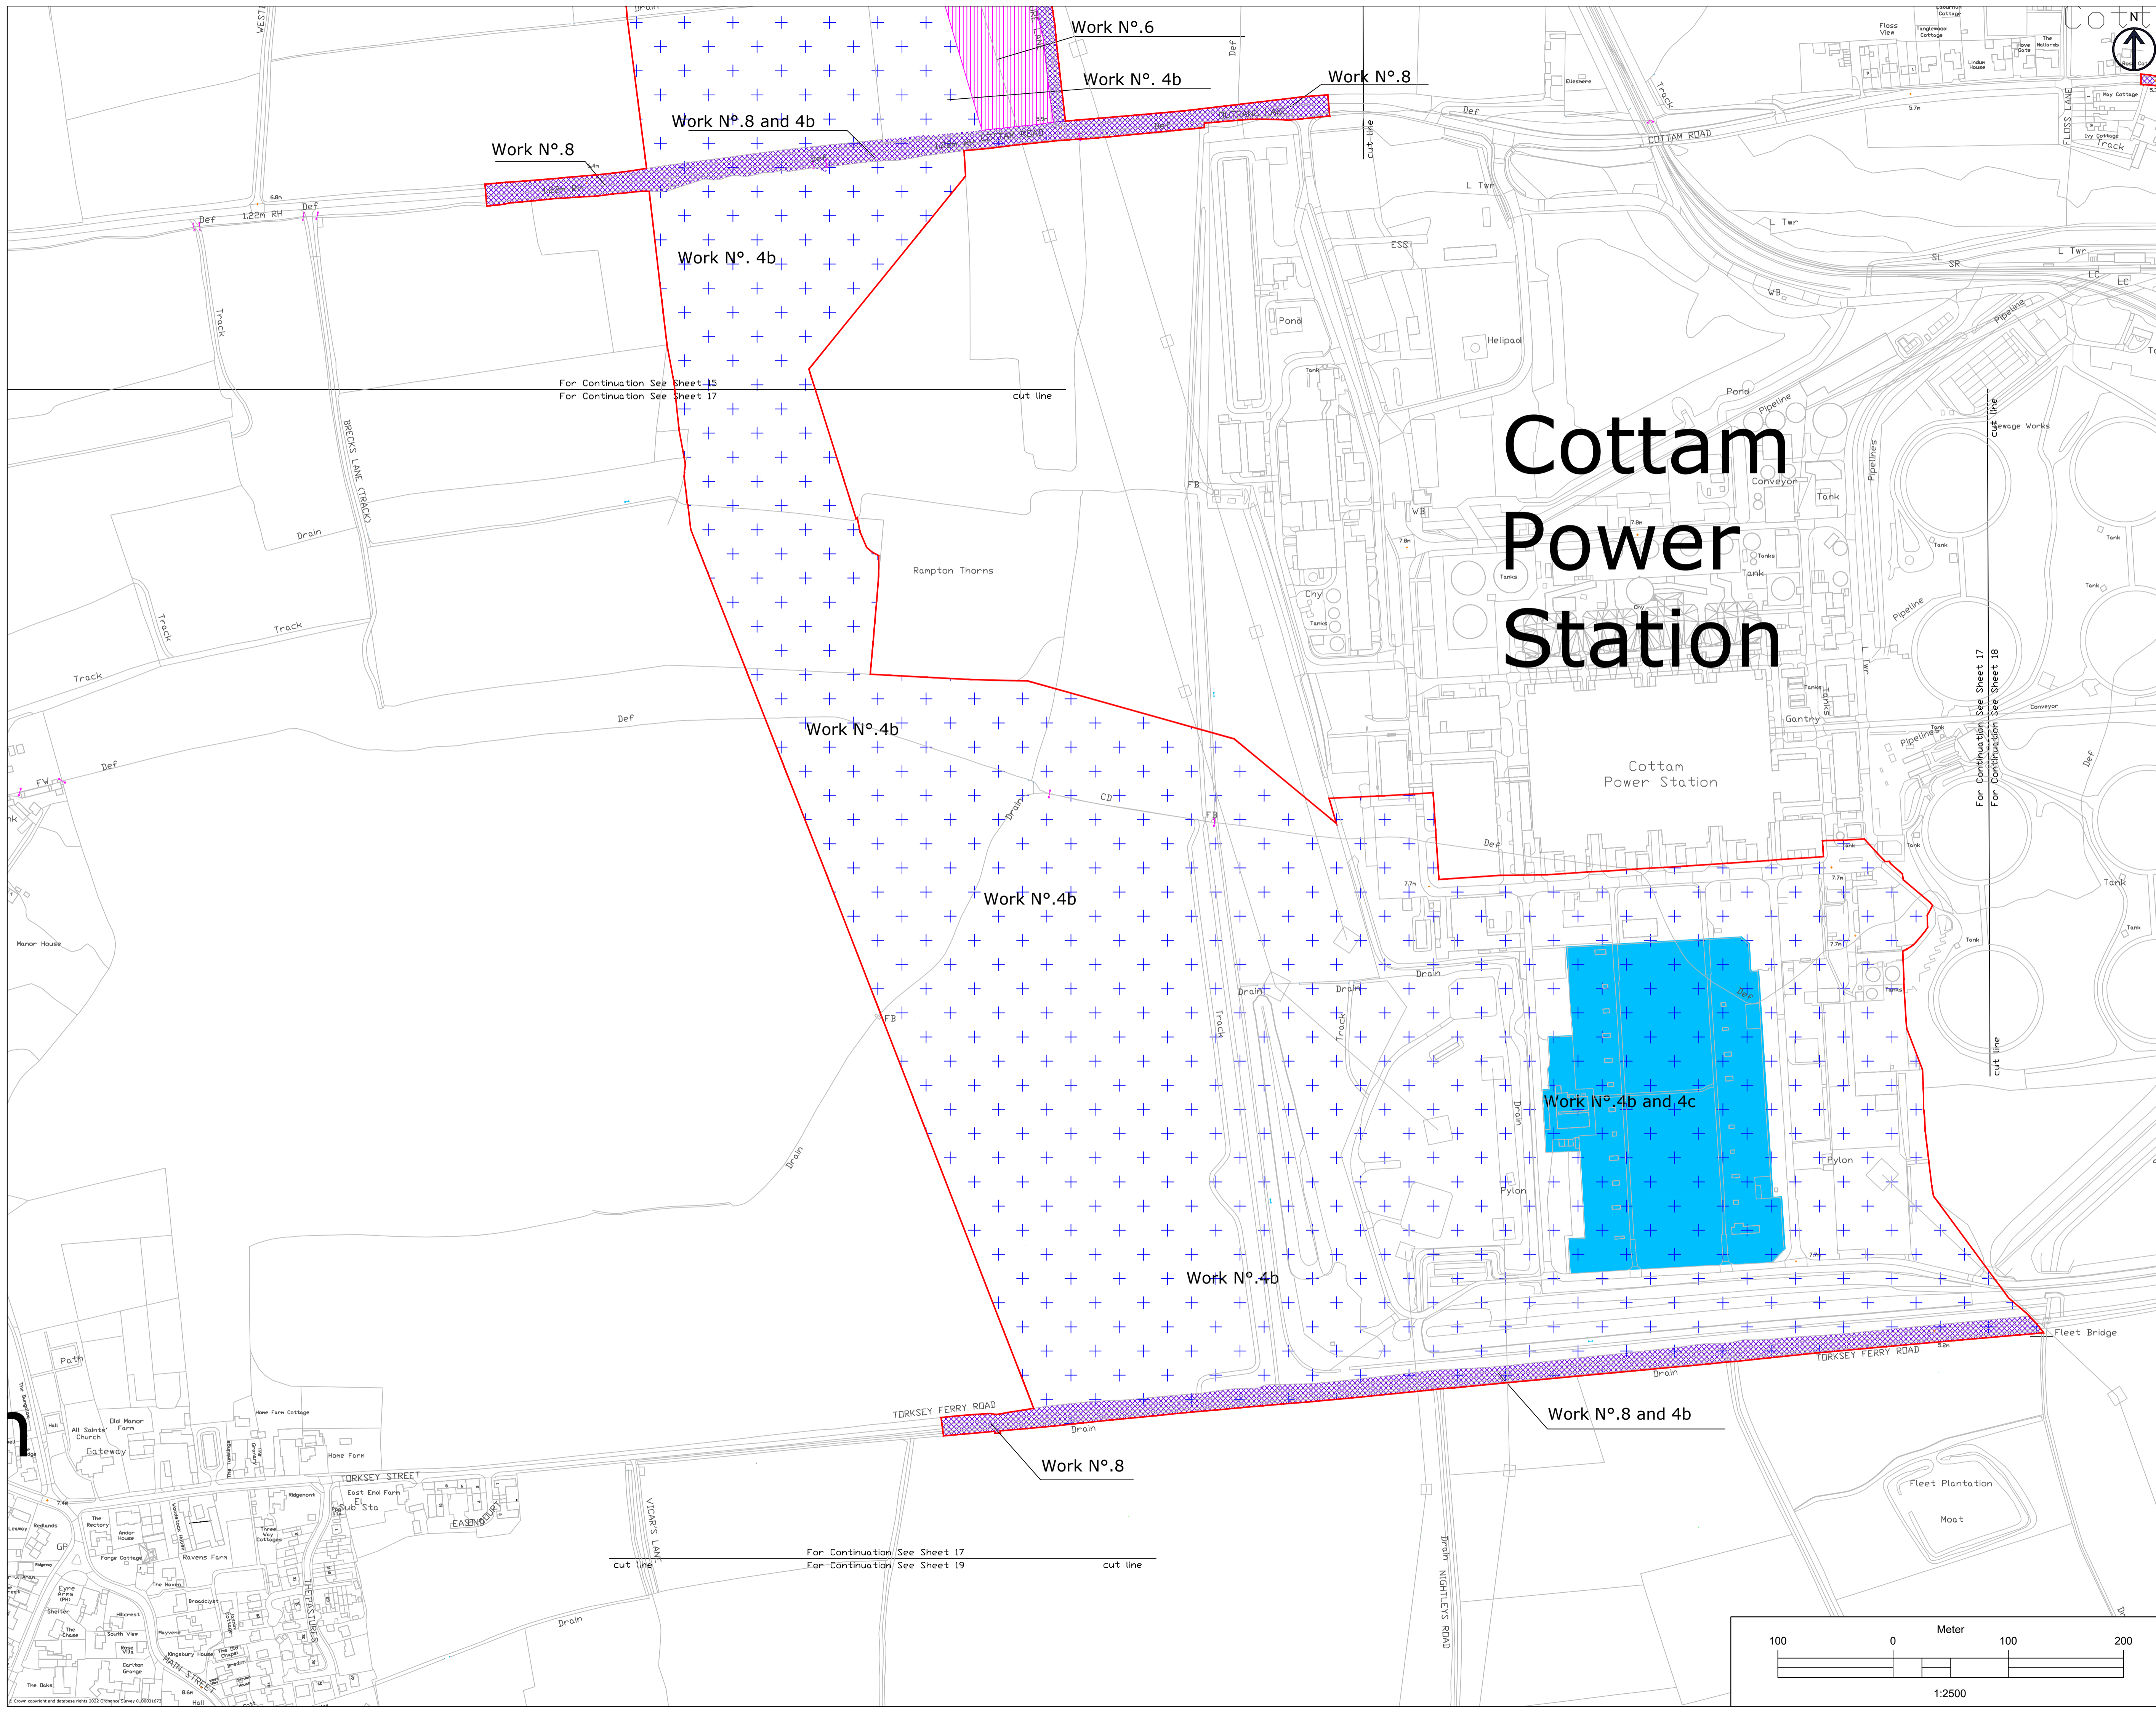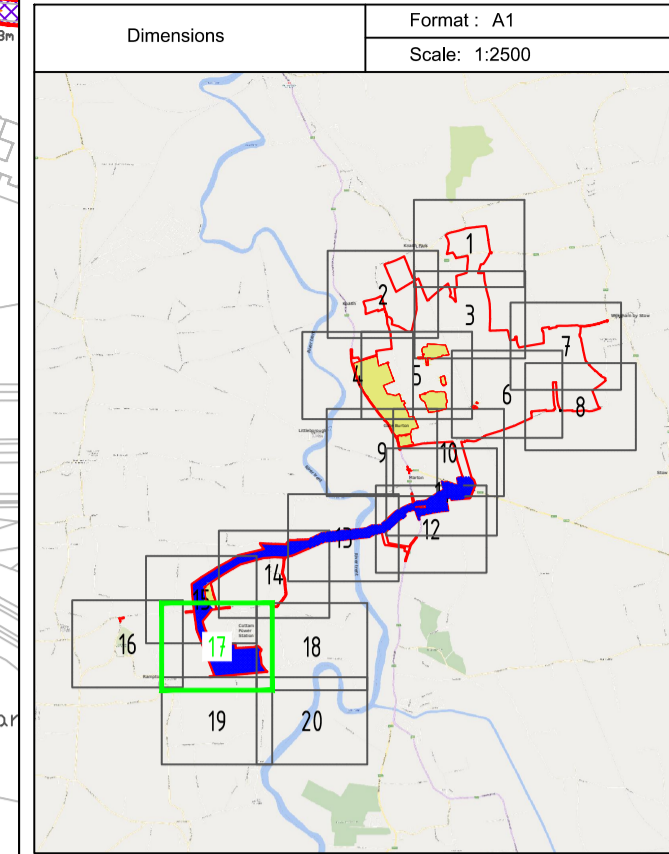


# Cottam Power Station



**LEGEND**

- Work No.1
- Work No.2
- Work No.3
- Work No.4a
- Work No.4b
- Work No.4c
- Work No.5
- Work No.6
- Work No.7
- Work No.8
- Work No.9
- Land not included in the Order limits

1. THIS DRAWING IS TO BE READ IN CONJUNCTION WITH ALL OTHER RELEVANT DOCUMENTATION.  
2. WORKS SHALL BE CONDUCTED IN ACCORDANCE WITH THE SPECIFICATIONS IN ALL APPLICABLE STANDARDS, REGULATIONS AND PROCEDURES.  
3. ALL DIMENSIONS, UNLESS OTHERWISE SPECIFIED, ARE IN METRES UNLESS OTHERWISE SPECIFIED.  
4. ALL DIMENSIONS, CORNERS, LEVELS AND COORDINATES ARE TO BE CHECKED ON SITE, AND ANY DISCREPANCIES REPORTED IMMEDIATELY TO THE PROJECT MANAGER.  
5. THE WORKS ARE SUBJECT TO CHANGE THROUGHOUT THE PROJECT IN ACCORDANCE WITH THE TERMS OF THE DEVELOPER'S CONTRACT AGREEMENT.

Index	Date	Changes	Writer	Checker
A	19/01/23	Original	ABO	GDA
B	07/03/23	S&I advice update	ABO	GDA
C	03/10/23	Update for Deadline	ABO	GDA

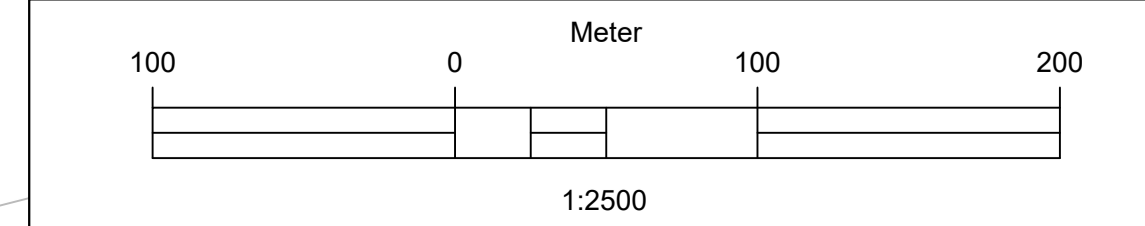

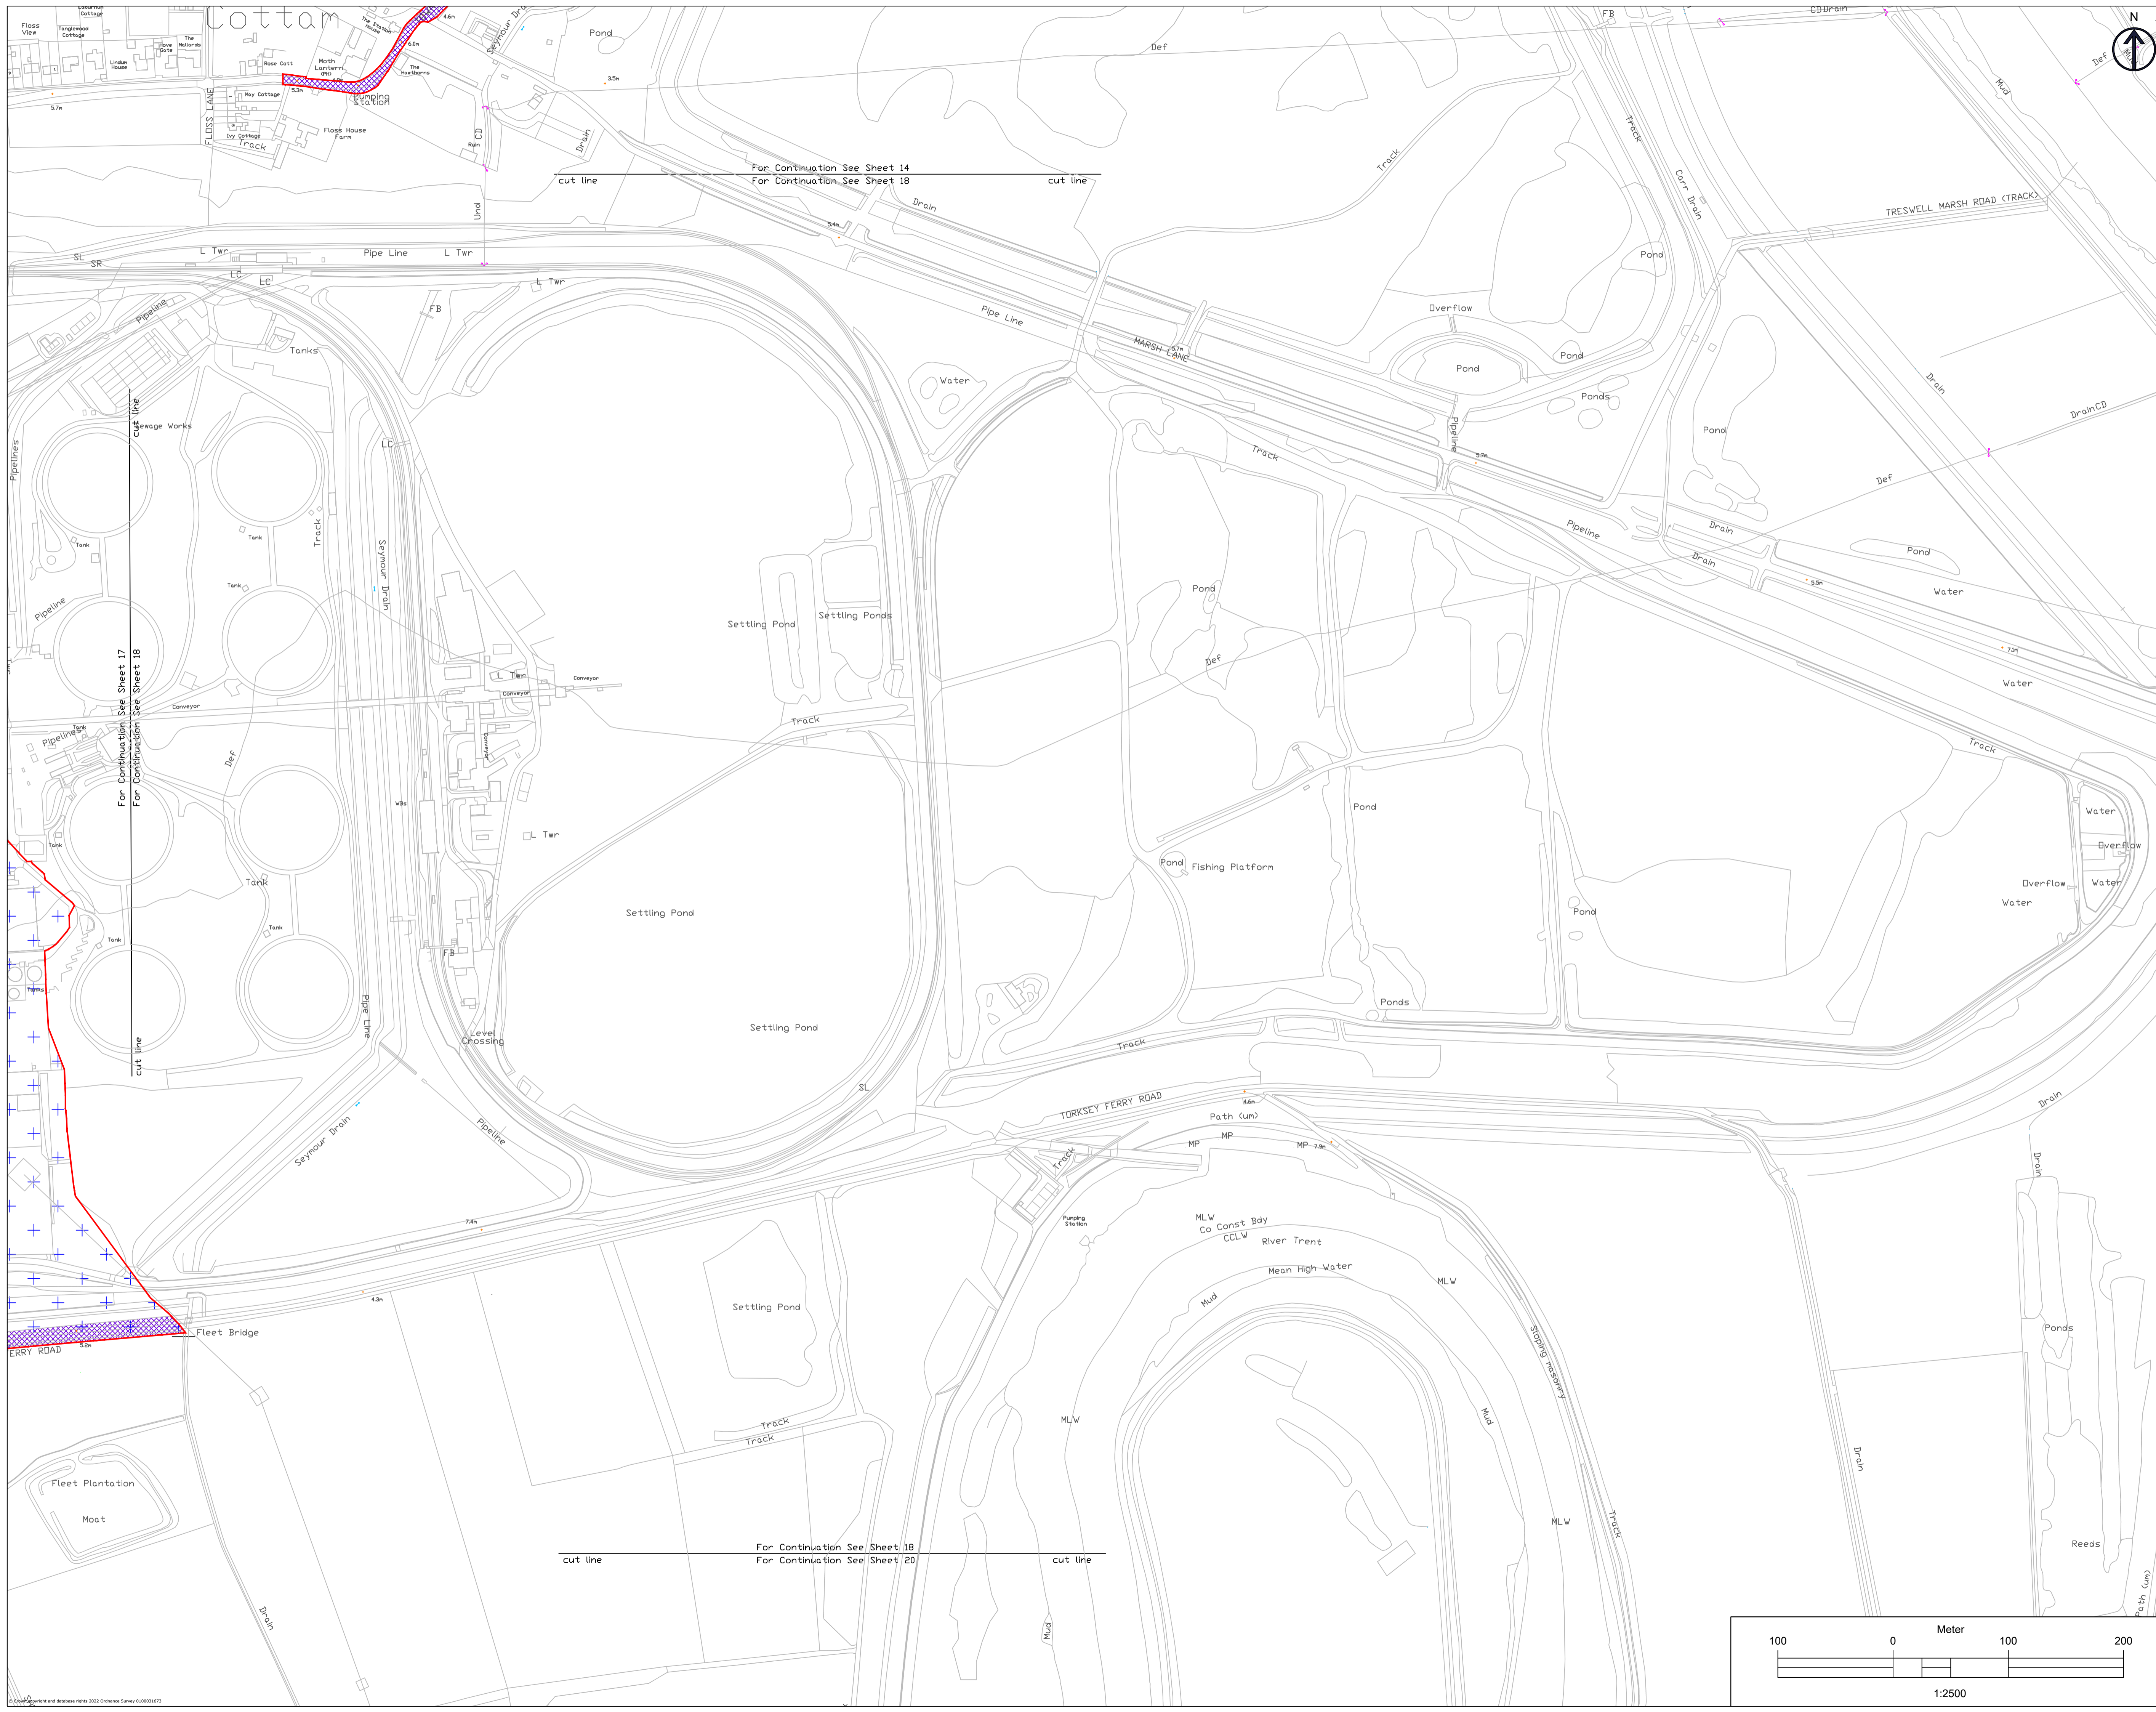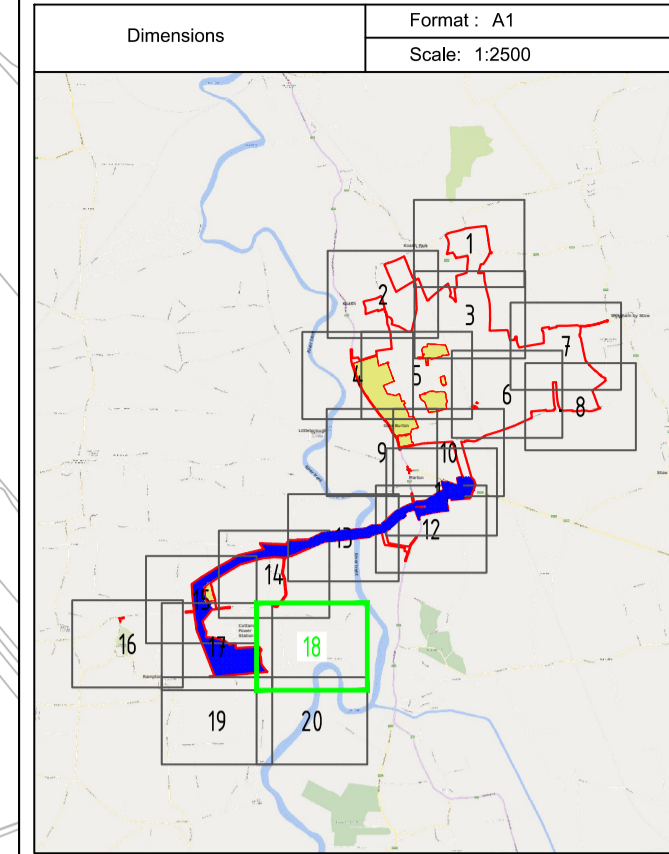




**LEGEND**

- Work No.1
- Work No.2
- Work No.3
- Work No.4a
- Work No.4b
- Work No.4c
- Work No.5
- Work No.6
- Work No.7
- Work No.8
- Work No.9
- Land not included in the Order limits

1. THIS DRAWING IS TO BE READ IN CONJUNCTION WITH ALL OTHER RELEVANT DOCUMENTATION.  
 2. WORKS MUST BE IN ACCORDANCE WITH REGULATORY REVISIONS OF THE RELEVANT PLANNING PERMISSIONS, PROCEDURES AND REGULATIONS.  
 3. ALL DIMENSIONS, COORDINATES, LEVELS AND CORRELATIONS ARE IN METRES UNLESS OTHERWISE STATED.  
 4. THE OWNER AND DESIGNER ACCEPTS RESPONSIBILITY FOR THE ACCURACY OF THE INFORMATION PROVIDED AND THE USER OF THIS DRAWING.  
 5. THE USER OF THIS DRAWING MUST CHECK THE INFORMATION PROVIDED TO THEM BY THE DESIGNER AND THE USER OF THIS DRAWING MUST CHECK THE INFORMATION PROVIDED TO THEM BY THE DESIGNER.  
 6. THE USER OF THIS DRAWING MUST CHECK THE INFORMATION PROVIDED TO THEM BY THE DESIGNER AND THE USER OF THIS DRAWING MUST CHECK THE INFORMATION PROVIDED TO THEM BY THE DESIGNER.

Index	Date	Changes	Writer	Checker
A	19/01/23	Original	ABO	GDA
B	07/03/23	SS1 advice update	ABO	GDA
C	03/10/23	Update for Deadlined	ABO	GDA

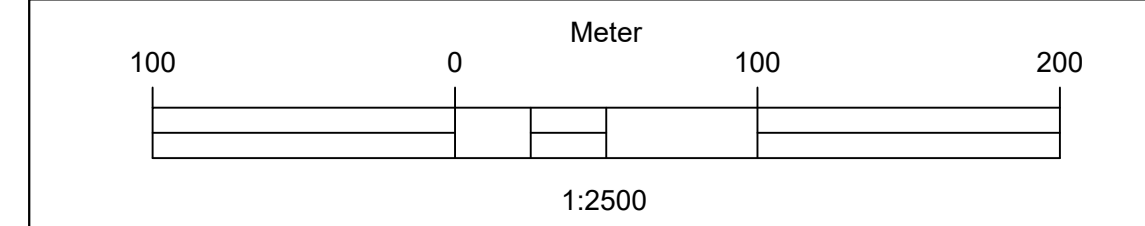

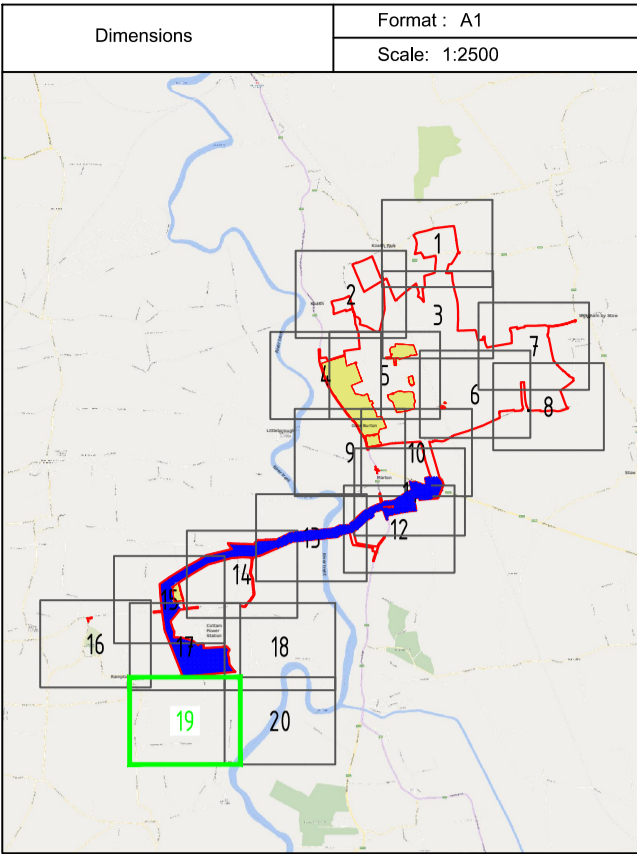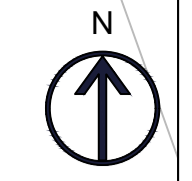


**SHEET NOT USED AS PART OF THIS DRAWING SERIES**


**LEGEND**

	Work No.1
	Work No.2
	Work No.3
	Work No.4a
	Work No.4b
	Work No.4c
	Work No.5
	Work No.6
	Work No.7
	Work No.8
	Work No.9
	Land not included in the Order limits

- This drawing is to be read in conjunction with all other relevant documentation.
- Works shall be in accordance with the specifications and standards of the relevant authorities.
- All dimensions, unless otherwise stated, shall be in metres unless otherwise specified.
- The works are shown as illustrative only and are subject to change through detailed design in accordance with the terms of the development consent order.

Index	Date	Changes	Writer	Checker
A	19/01/23	Original	ABO	GDA
B	07/03/23	SS1 advice update	ABO	GDA
C	03/10/23	Update for Deadline4	ABO	GDA

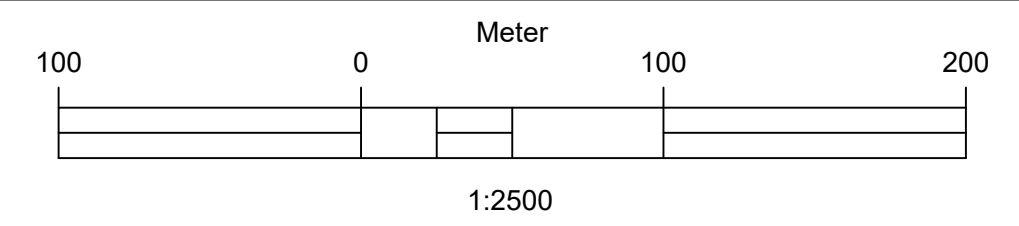

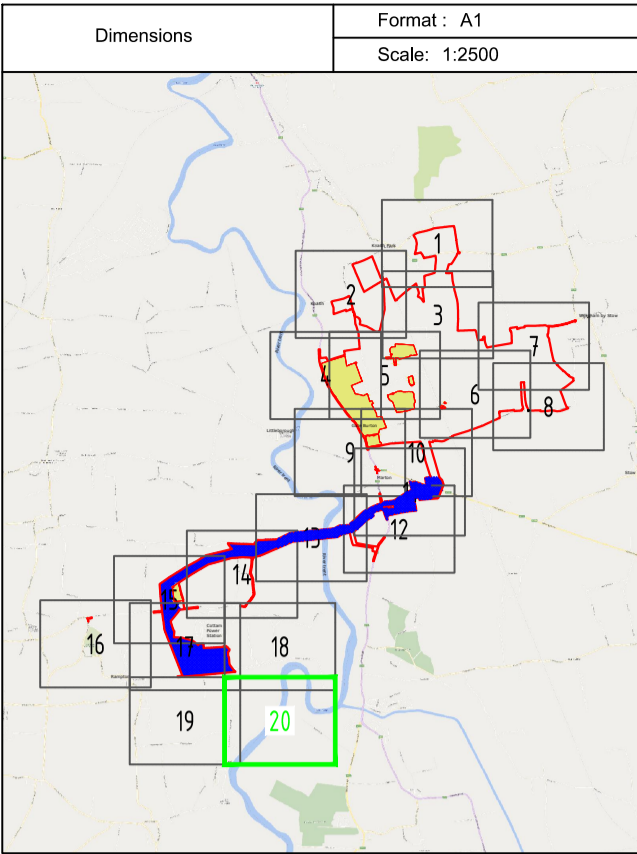

Dimensions	Format: A1
	Scale: 1:2500

cut line For Continuation See Sheet 18 For Continuation See Sheet 20 cut line

**SHEET NOT USED AS PART OF THIS DRAWING SERIES**

**LEGEND**

- Work No.1
- Work No.2
- Work No.3
- Work No.4a
- Work No.4b
- Work No.4c
- Work No.5
- Work No.6
- Work No.7
- Work No.8
- Work No.9
- Land not included in the Order limits

Index	Date	Changes	Writer	Checker
A	19/01/23	Original	ABO	GDA
B	07/03/23	SS1 advice update	ABO	GDA
C	03/10/23	Update for Deadline4	ABO	GDA

