

# Southampton to London Pipeline Project

## Volume 2

General Arrangement Plans (3 of 3)

Application Document: 2.6

Planning Inspectorate Reference Number: EN070005

APFP Regulation No. 5(2)(o)

Revision No. 1.0

May 2019



**(This page has been left intentionally blank)**





## Contents

B2325300-JAC-000-CIV-DRG-000501	- General Arrangement - Key Plan Sheet 1 of 2 Burley Green to Alton
B2325300-JAC-000-CIV-DRG-000502	- General Arrangement - Key Plan Sheet 2 of 2 - Alton To West London Terminal
B2325300-JAC-000-CIV-DRG-000511	- General Arrangement Sheet 1
B2325300-JAC-000-CIV-DRG-000512	- General Arrangement Sheet 2
B2325300-JAC-000-CIV-DRG-000513	- General Arrangement Sheet 3
B2325300-JAC-000-CIV-DRG-000514	- General Arrangement Sheet 4
B2325300-JAC-000-CIV-DRG-000515	- General Arrangement Sheet 5
B2325300-JAC-000-CIV-DRG-000516	- General Arrangement Sheet 6
B2325300-JAC-000-CIV-DRG-000517	- General Arrangement Sheet 7
B2325300-JAC-000-CIV-DRG-000518	- General Arrangement Sheet 8
B2325300-JAC-000-CIV-DRG-000519	- General Arrangement Sheet 9
B2325300-JAC-000-CIV-DRG-000520	- General Arrangement Sheet 10
B2325300-JAC-000-CIV-DRG-000521	- General Arrangement Sheet 11
B2325300-JAC-000-CIV-DRG-000522	- General Arrangement Sheet 12
B2325300-JAC-000-CIV-DRG-000523	- General Arrangement Sheet 13
B2325300-JAC-000-CIV-DRG-000524	- General Arrangement Sheet 14
B2325300-JAC-000-CIV-DRG-000525	- General Arrangement Sheet 15
B2325300-JAC-000-CIV-DRG-000526	- General Arrangement Sheet 16
B2325300-JAC-000-CIV-DRG-000527	- General Arrangement Sheet 17
B2325300-JAC-000-CIV-DRG-000528	- General Arrangement Sheet 18
B2325300-JAC-000-CIV-DRG-000529	- General Arrangement Sheet 19
B2325300-JAC-000-CIV-DRG-000530	- General Arrangement Sheet 20
B2325300-JAC-000-CIV-DRG-000531	- General Arrangement Sheet 21
B2325300-JAC-000-CIV-DRG-000532	- General Arrangement Sheet 22
B2325300-JAC-000-CIV-DRG-000533	- General Arrangement Sheet 23



- B2325300-JAC-000-CIV-DRG-000534 - General Arrangement Sheet 24
- B2325300-JAC-000-CIV-DRG-000535 - General Arrangement Sheet 25
- B2325300-JAC-000-CIV-DRG-000536 - General Arrangement Sheet 26
- B2325300-JAC-000-CIV-DRG-000537 - General Arrangement Sheet 27
- B2325300-JAC-000-CIV-DRG-000538 - General Arrangement Sheet 28
- B2325300-JAC-000-CIV-DRG-000539 - General Arrangement Sheet 29
- B2325300-JAC-000-CIV-DRG-000540 - General Arrangement Sheet 30
- B2325300-JAC-000-CIV-DRG-000541 - General Arrangement Sheet 31
- B2325300-JAC-000-CIV-DRG-000542 - General Arrangement Sheet 32
- B2325300-JAC-000-CIV-DRG-000543 - General Arrangement Sheet 33
- B2325300-JAC-000-CIV-DRG-000544 - General Arrangement Sheet 34
- B2325300-JAC-000-CIV-DRG-000545 - General Arrangement Sheet 35
- B2325300-JAC-000-CIV-DRG-000546 - General Arrangement Sheet 36
- B2325300-JAC-000-CIV-DRG-000547 - General Arrangement Sheet 37
- B2325300-JAC-000-CIV-DRG-000548 - General Arrangement Sheet 38
- B2325300-JAC-000-CIV-DRG-000549 - General Arrangement Sheet 39
- B2325300-JAC-000-CIV-DRG-000550 - General Arrangement Sheet 40
- B2325300-JAC-000-CIV-DRG-000551 - General Arrangement Sheet 41
- B2325300-JAC-000-CIV-DRG-000552 - General Arrangement Sheet 42
- B2325300-JAC-000-CIV-DRG-000553 - General Arrangement Sheet 43
- B2325300-JAC-000-CIV-DRG-000554 - General Arrangement Sheet 44
- B2325300-JAC-000-CIV-DRG-000555 - General Arrangement Sheet 45
- B2325300-JAC-000-CIV-DRG-000556 - General Arrangement Sheet 46
- B2325300-JAC-000-CIV-DRG-000557 - General Arrangement Sheet 47
- B2325300-JAC-000-CIV-DRG-000558 - General Arrangement Sheet 48
- B2325300-JAC-000-CIV-DRG-000559 - General Arrangement Sheet 49
- B2325300-JAC-000-CIV-DRG-000560 - General Arrangement Sheet 50



B2325300-JAC-000-CIV-DRG-000561 - General Arrangement Sheet 51  
B2325300-JAC-000-CIV-DRG-000562 - General Arrangement Sheet 52  
B2325300-JAC-000-CIV-DRG-000563 - General Arrangement Sheet 53  
B2325300-JAC-000-CIV-DRG-000564 - General Arrangement Sheet 54  
B2325300-JAC-000-CIV-DRG-000565 - General Arrangement Sheet 55  
B2325300-JAC-000-CIV-DRG-000566 - General Arrangement Sheet 56  
B2325300-JAC-000-CIV-DRG-000567 - General Arrangement Sheet 57  
B2325300-JAC-000-CIV-DRG-000568 - General Arrangement Sheet 58  
B2325300-JAC-000-CIV-DRG-000569 - General Arrangement Sheet 59  
B2325300-JAC-000-CIV-DRG-000601 - General Arrangement Sheet 101  
B2325300-JAC-000-CIV-DRG-000602 - General Arrangement Sheet 102  
B2325300-JAC-000-CIV-DRG-000603 - General Arrangement Sheet 103  
B2325300-JAC-000-CIV-DRG-000604 - General Arrangement Sheet 104  
B2325300-JAC-000-CIV-DRG-000605 - General Arrangement Sheet 105  
B2325300-JAC-000-CIV-DRG-000606 - General Arrangement Sheet 106  
B2325300-JAC-000-CIV-DRG-000607 - General Arrangement Sheet 107  
B2325300-JAC-000-CIV-DRG-000608 - General Arrangement Sheet 108  
B2325300-JAC-000-CIV-DRG-000609 - General Arrangement Sheet 109  
B2325300-JAC-000-CIV-DRG-000610 - General Arrangement Sheet 110  
B2325300-JAC-000-CIV-DRG-000611 - General Arrangement Sheet 111  
B2325300-JAC-000-CIV-DRG-000612 - General Arrangement Sheet 112  
B2325300-JAC-000-CIV-DRG-000613 - General Arrangement Sheet 113  
B2325300-JAC-000-CIV-DRG-000614 - General Arrangement Sheet 114  
B2325300-JAC-000-CIV-DRG-000615 - General Arrangement Sheet 115  
B2325300-JAC-000-CIV-DRG-000616 - General Arrangement Sheet 116  
B2325300-JAC-000-CIV-DRG-000617 - General Arrangement Sheet 117  
B2325300-JAC-000-CIV-DRG-000618 - General Arrangement Sheet 118



B2325300-JAC-000-CIV-DRG-000619 - General Arrangement Sheet 119


B2325300-JAC-000-CIV-DRG-000620 - General Arrangement Sheet 120

B2325300-JAC-000-CIV-DRG-000621 - General Arrangement Sheet 121

B2325300-JAC-000-CIV-DRG-000622 - General Arrangement Sheet 122

B2325300-JAC-000-CIV-DRG-000623 - General Arrangement Sheet 123

B2325300-JAC-000-CIV-DRG-000624 - General Arrangement Sheet 124

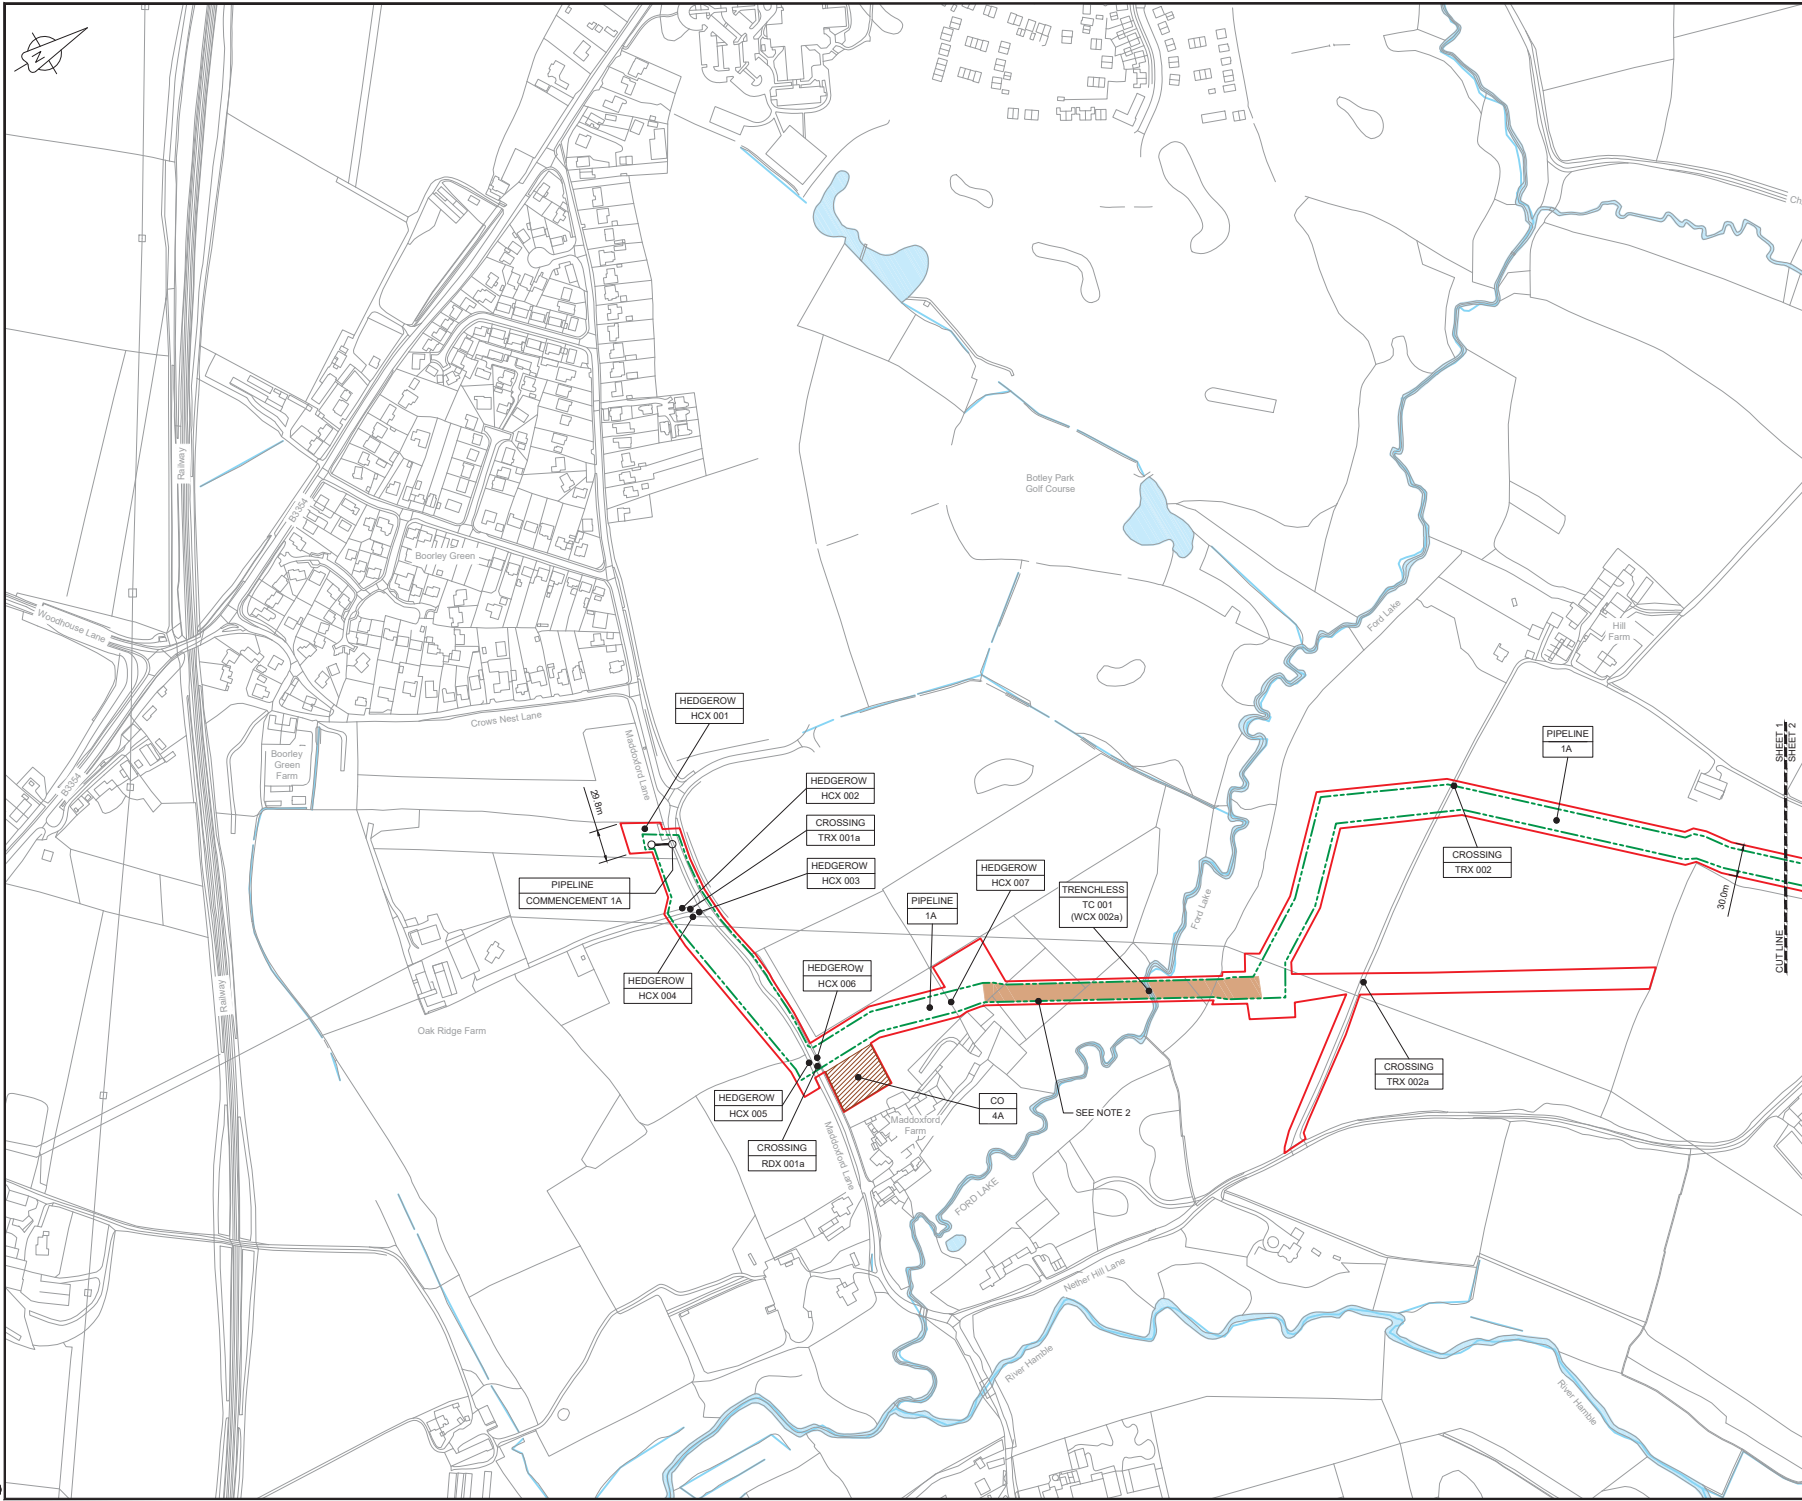

LOCATION PLAN  
SCALE 1:500,000


- NOTES**
- THIS DRAWING IS IN METRES UNLESS STATED OTHERWISE.
  - TRENCHLESS CROSSINGS ARE INDICATIVE ONLY.

**LEGEND**

 	ORDER LIMITS
	LIMITS OF DEVIATION
	NARROW WORKING AREA (NW)
	TRENCHLESS CROSSING (TC)
	WATER BODIES
	ABOVE GROUND INSTALLATION (AGI) / VALVE (VA) / PRESSURE TRANSDUCER (PT)
	COMPOUND (CO)
	TREE PRESERVATION ORDER (TPO)
	DESCRIPTION
	ID or WORK NUMBER (if applicable)
	COMMENCEMENT / TERMINATION OF WORKS (COMMENCEMENT = OPEN, TERMINATION = CLOSED)

Contains Ordnance Survey data © Crown copyright and database rights 2019.

© Crown copyright and database rights 2019 OS Licence Number AL10005237.



CSI	02/01/19	0001 SUBMISSION	PC	JA	SC	PH
Rev.	Rev. Date	Purpose of revision	Drawn	Checked	Rev'd	Approved



Client: Esso Petroleum Company, Limited  
Ermyn House,  
Ermyn Way,  
Leatherhead,  
Surrey,  
KT22 8UX




Project: Southampton to London Pipeline Project

Drawing title:  
**GENERAL ARRANGEMENT  
SHEET 1  
REGULATION 5 (2)(O)**

Drawing status: Fit for Stage Approval

Scale	1:2500	DO NOT SCALE
JACOBS No.	B2325300	Rev
Client no.		<b>CO1</b>
Drawing number	<b>B2325300-JAC-000-CIV-DRG-000511</b>	



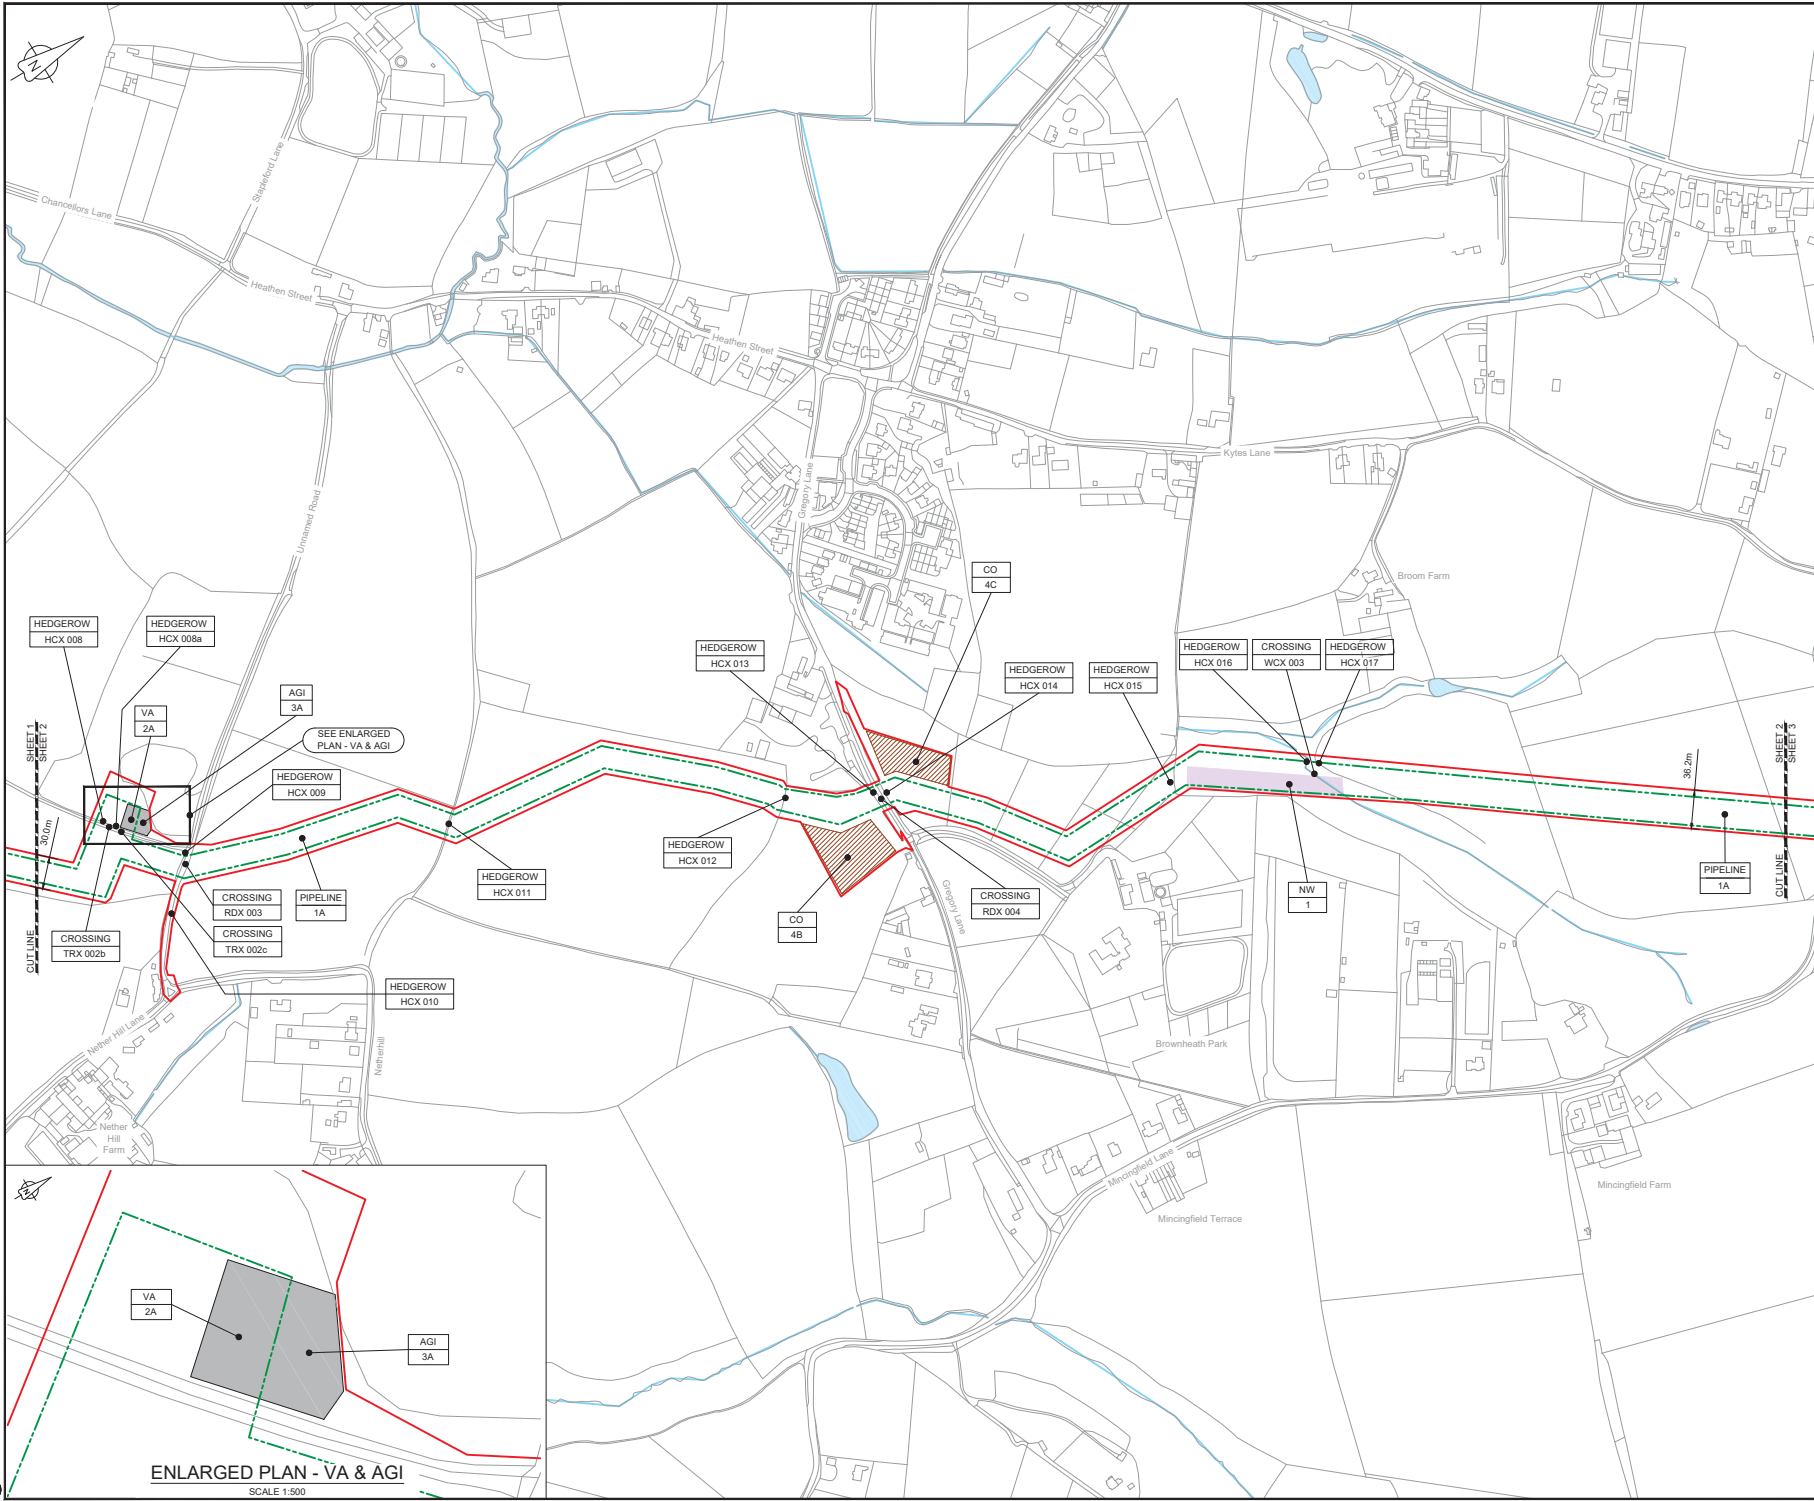

**NOTES**  
 1. THIS DRAWING IS IN METRES UNLESS STATED OTHERWISE.  
 2. TRENCHLESS CROSSINGS ARE INDICATIVE ONLY.

**LEGEND**

	ORDER LIMITS
	LIMITS OF DEVIATION
	NARROW WORKING AREA (NW)
	TRENCHLESS CROSSING (TC)
	WATER BODIES
	ABOVE GROUND INSTALLATION (AGI) / VALVE (VA) / PRESSURE TRANSDUCER (PT)
	COMPOUND (CO)
	TREE PRESERVATION ORDER (TPO)
	DESCRIPTION
	ID or WORK NUMBER (if applicable)
	COMMENCEMENT / TERMINATION OF WORKS (COMMENCEMENT = OPEN, TERMINATION = CLOSED)

Contains Ordnance Survey data © Crown copyright and database rights 2019.  
 © Crown copyright and database rights 2019  
 OS Licence Number AL10006237.



CSI	02/05/19	0001 SUBMISSION	PC	JA	SC	PH
Rev.	Rev. Date	Purpose of revision	Drawn	Checked	Rev'd	Approved

**JACOBS**  
 1180 Ewings Road, Winchester, Wokingham, RG41 5TU  
 Tel: +44(0)118 946 7000 • Fax: +44(0)118 946 7001  
 www.jacobs.com

Client: Esso Petroleum Company, Limited  
 Emryn House,  
 Emryn Way,  
 Leatherhead,  
 Surrey,  
 KT22 8UX

Project: Southampton to London Pipeline Project


Drawing title: **GENERAL ARRANGEMENT SHEET 2 REGULATION 5 (2)(O)**


Drawing status: **Fit for Stage Approval**

Scale	1:2500	DO NOT SCALE
Jacobs No.	B2325300	Rev
Client no.		<b>CO1</b>
Drawing number	<b>B2325300-JAC-000-CIV-DRG-000512</b>	

C:\pwworking\jacobs\_uk\_water\_utilities\_sas4\cheff\pma33511892325300-JAC-000-CIV-DRG-000512.dwg - 03/05/2019 07:55:01 - A1Frame - CreateP

**ENLARGED PLAN - VA & AGI**  
 SCALE 1:500

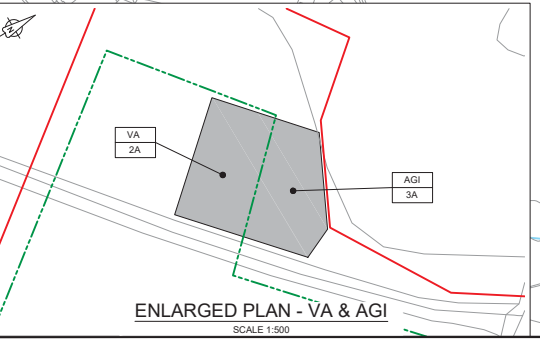

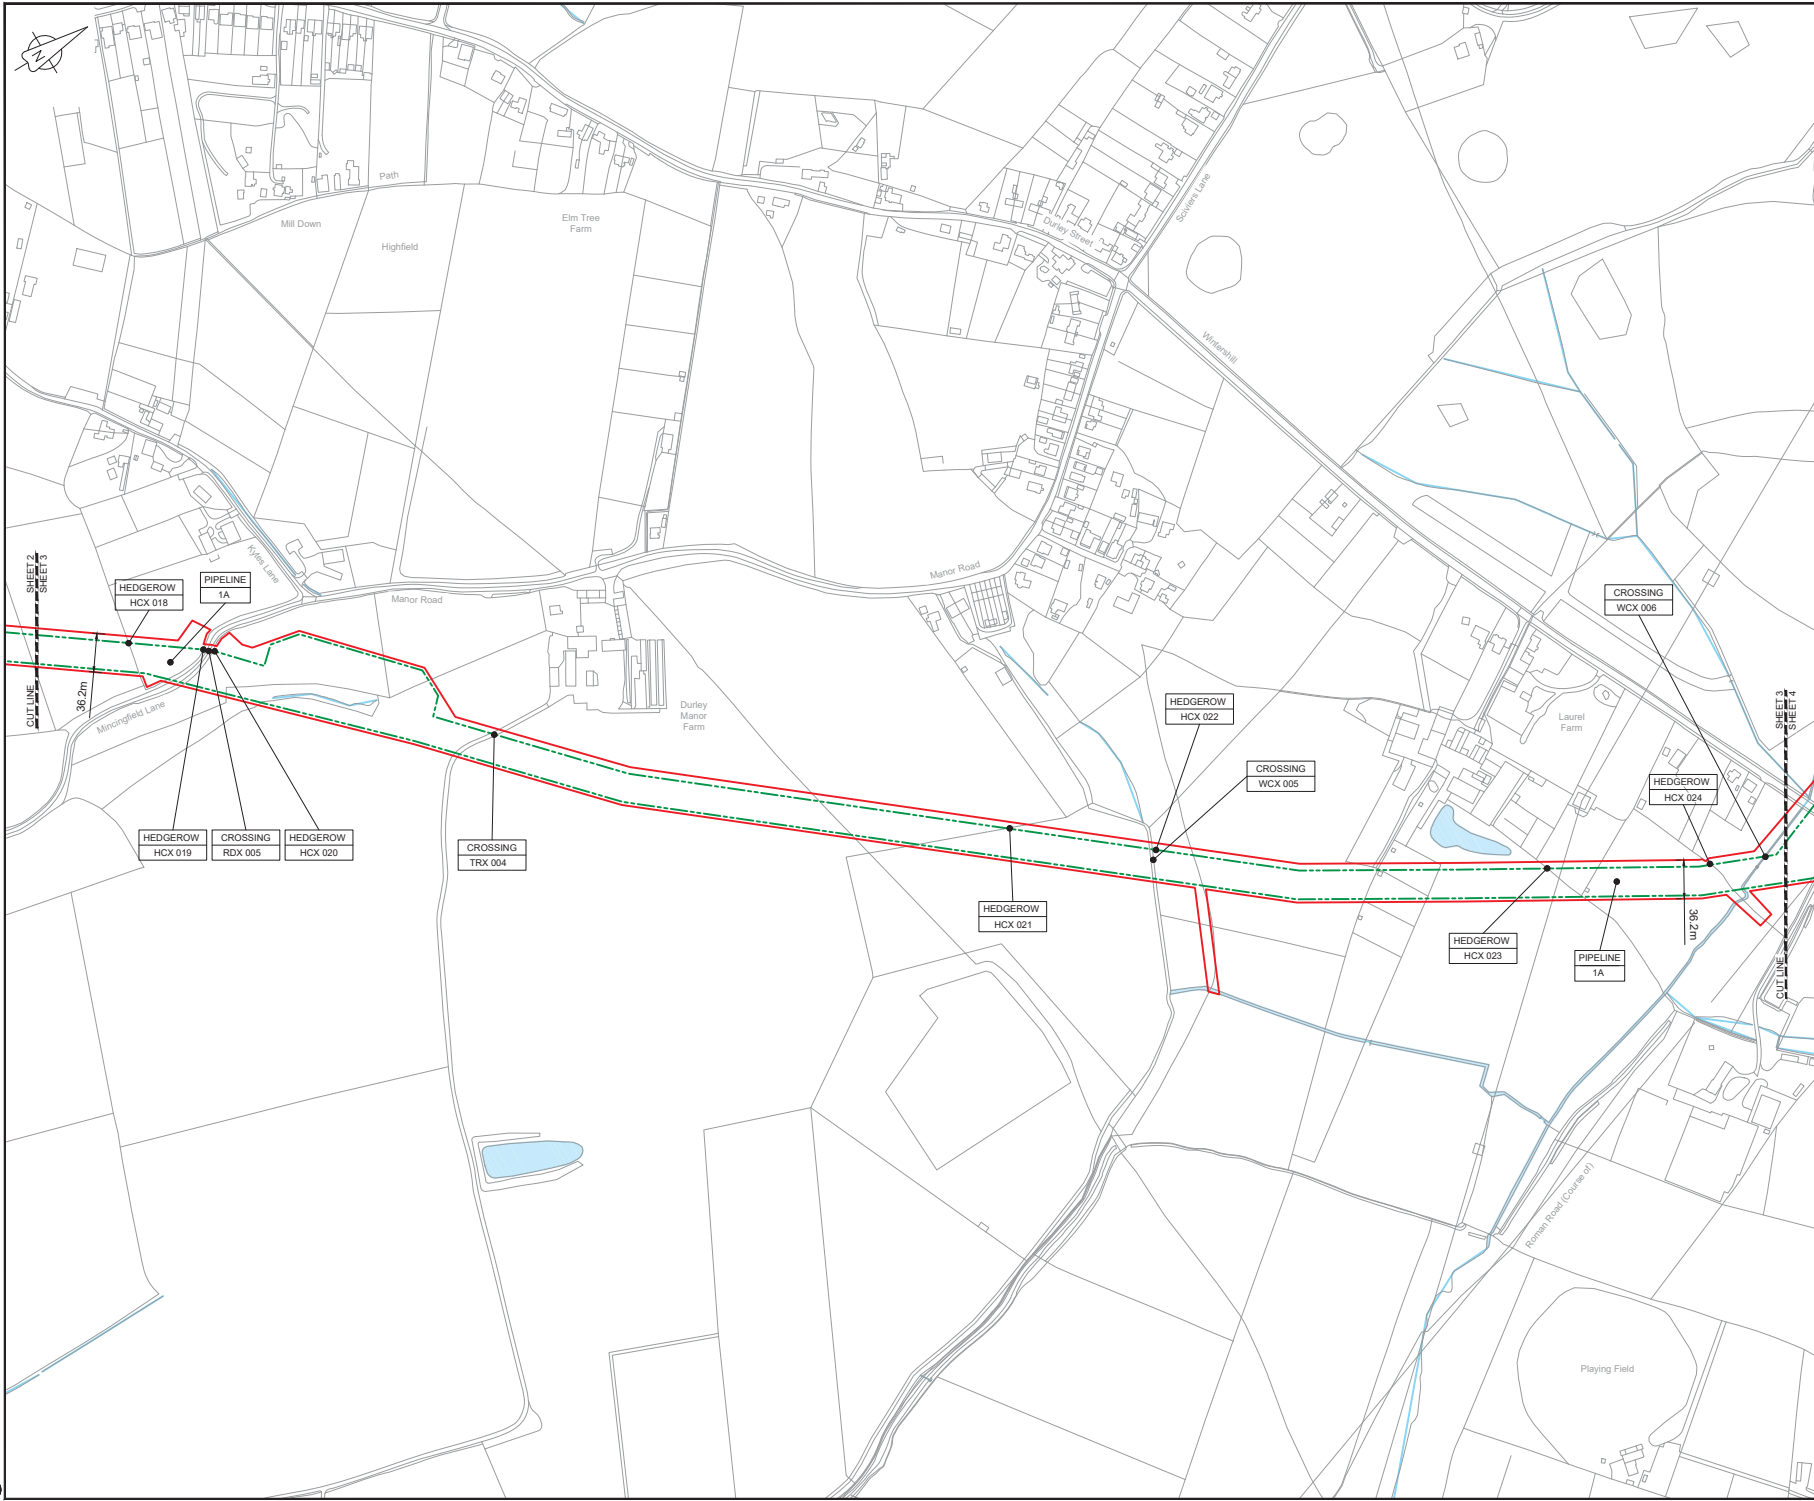

LOCATION PLAN  
SCALE 1:500,000


- NOTES**
1. THIS DRAWING IS IN METRES UNLESS STATED OTHERWISE.
  2. TRENCHLESS CROSSINGS ARE INDICATIVE ONLY.

**LEGEND**

 [Red line]	ORDER LIMITS
[Green dashed line]	LIMITS OF DEVIATION
[Purple shaded area]	NARROW WORKING AREA (NW)
[Orange shaded area]	TRENCHLESS CROSSING (TC)
[Blue area]	WATER BODIES
[Grey area]	ABOVE GROUND INSTALLATION (AGI) / VALVE (VA) / PRESSURE TRANSDUCER (PT)
[Hatched area]	COMPOUND (CO)
[Green circle]	TREE PRESERVATION ORDER (TPO)
[Black dot]	DESCRIPTION
[Black dot]	ID or WORK NUMBER (if applicable)
[Blue circle]	COMMENCEMENT / TERMINATION OF WORKS (COMMENCEMENT = OPEN, TERMINATION = CLOSED)

Contains Ordnance Survey data © Crown copyright and database rights 2019.

© Crown copyright and database rights 2019 OS Licence Number AL10005237.



CD	02/05/19	DDC SUBMISSION	PC	JA	SC	PH
Rev.	Rev. Date	Purpose of revision	Drawn	Checked	Rev'd	Approved

**JACOBS**  
1180 Ewings Road, Winchester, Hampshire, RG41 5TU  
Tel: +44(0)118 946 7000 • Fax: +44(0)118 946 7001  
www.jacobs.com

Client: Esso Petroleum Company, Limited  
Emlyn House,  
Emlyn Way,  
Leatherhead,  
Surrey,  
KT22 8UX




Project  
**GENERAL ARRANGEMENT  
SHEET 3  
REGULATION 5 (2)(O)**

Drawing title

Drawing status: **Fit for Stage Approval**

Scale	1:2500	DO NOT SCALE
Jacobs No.	B2325300	Rev
Client no.		CO1

Drawing number  
**B2325300-JAC-000-CIV-DRG-000513**

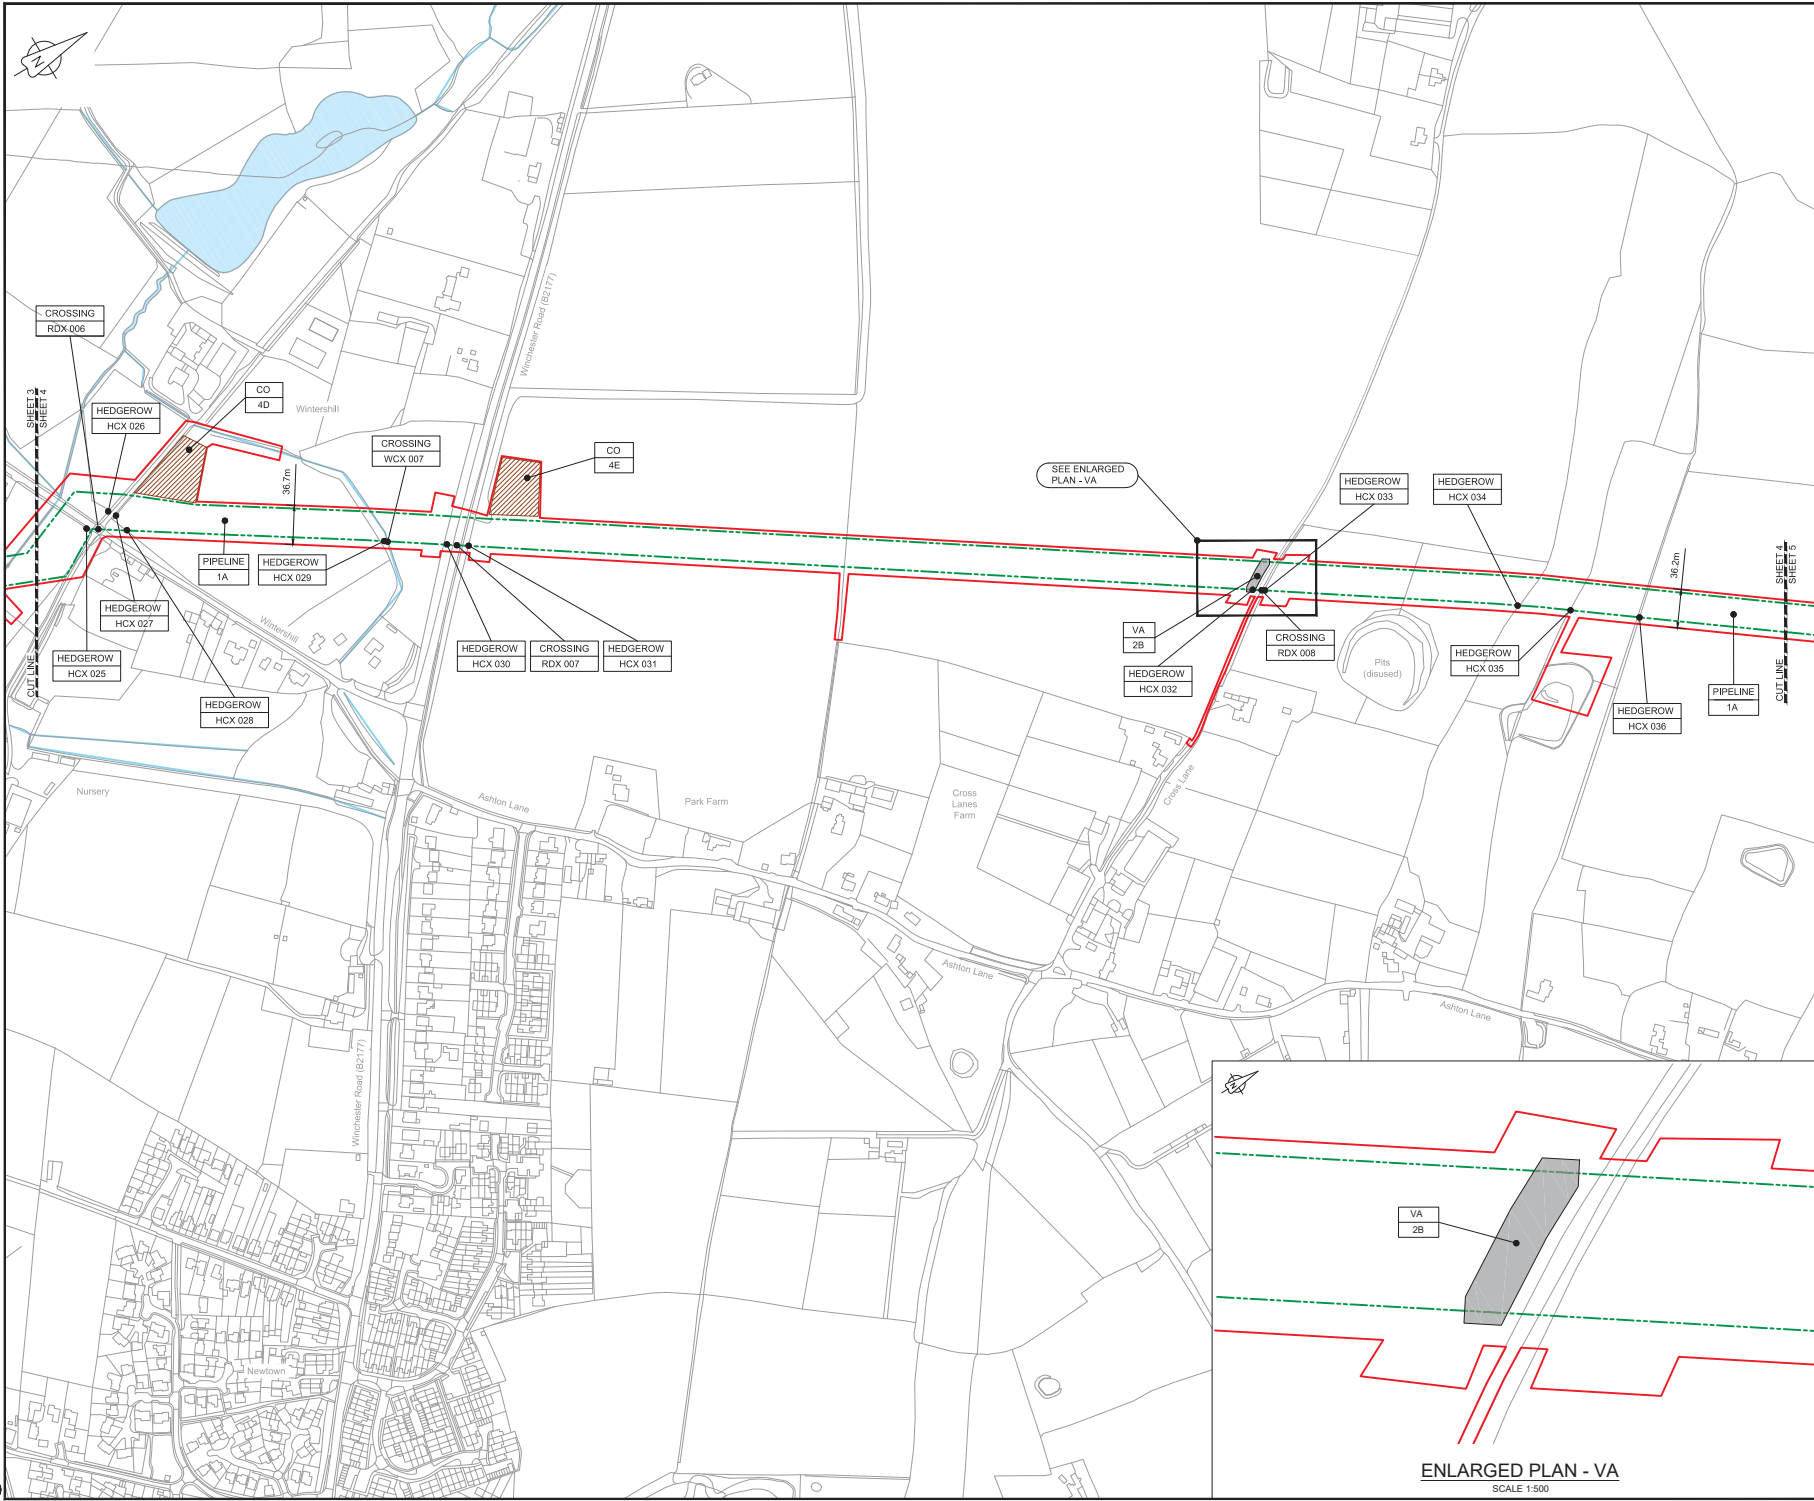

LOCATION PLAN  
SCALE 1:500,000

- NOTES**
- THIS DRAWING IS IN METRES UNLESS STATED OTHERWISE.
  - TRENCHLESS CROSSINGS ARE INDICATIVE ONLY.

**LEGEND**

	ORDER LIMITS
	LIMITS OF DEVIATION
	NARROW WORKING AREA (NW)
	TRENCHLESS CROSSING (TC)
	WATER BODIES
	ABOVE GROUND INSTALLATION (AGI) / VALVE (VA) / PRESSURE TRANSDUCER (PT)
	COMPOUND (CO)
	TREE PRESERVATION ORDER (TPO)
	DESCRIPTION
	ID or WORK NUMBER (if applicable)
	COMMENCEMENT / TERMINATION OF WORKS (COMMENCEMENT = OPEN, TERMINATION = CLOSED)

Contains Ordnance Survey data © Crown copyright and database rights 2019.  
© Crown copyright and database rights 2019 OS Licence Number AL100005237.



CSI	02/05/19	0003/00/00/00/00/00	PC	JA	SC	PH
Rev.	Rev. Date	Purpose of revision	Drawn	Checked	Rev'd	Approved

**JACOBS**  
1180 Ewks Rd, Wincobury, Wokingham, RG41 5TU  
Tel: +44(0)118 946 7000 • Fax: +44(0)118 946 7001  
www.jacobs.com

Client: Esso Petroleum Company, Limited  
Ermyn House,  
Ermyn Way,  
Leatherhead,  
Surrey,  
KT22 8UX


Project: Southampton to London Pipeline Project

Drawing title:  
**GENERAL ARRANGEMENT SHEET 4**  
**REGULATION 5 (2)(O)**

Drawing status: **Fit for Stage Approval**

Scale	1:2500	DO NOT SCALE
Jacobs No.	B2325300	Rev
Client no.		<b>C01</b>


Drawing number:  
**B2325300-JAC-000-CIV-DRG-000514**

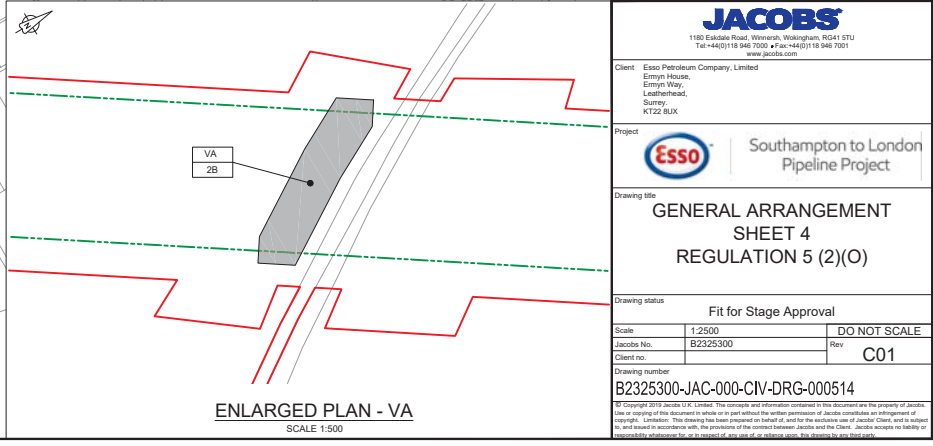

ENLARGED PLAN - VA  
SCALE 1:500

C:\pwworking\jacobs\_uk\_water\_utilities\_s4\tag\jms35193253000-JAC-000-CIV-DRG-000514.dwg - 03/05/2019 11:47:17 - A1Frame - Agalad



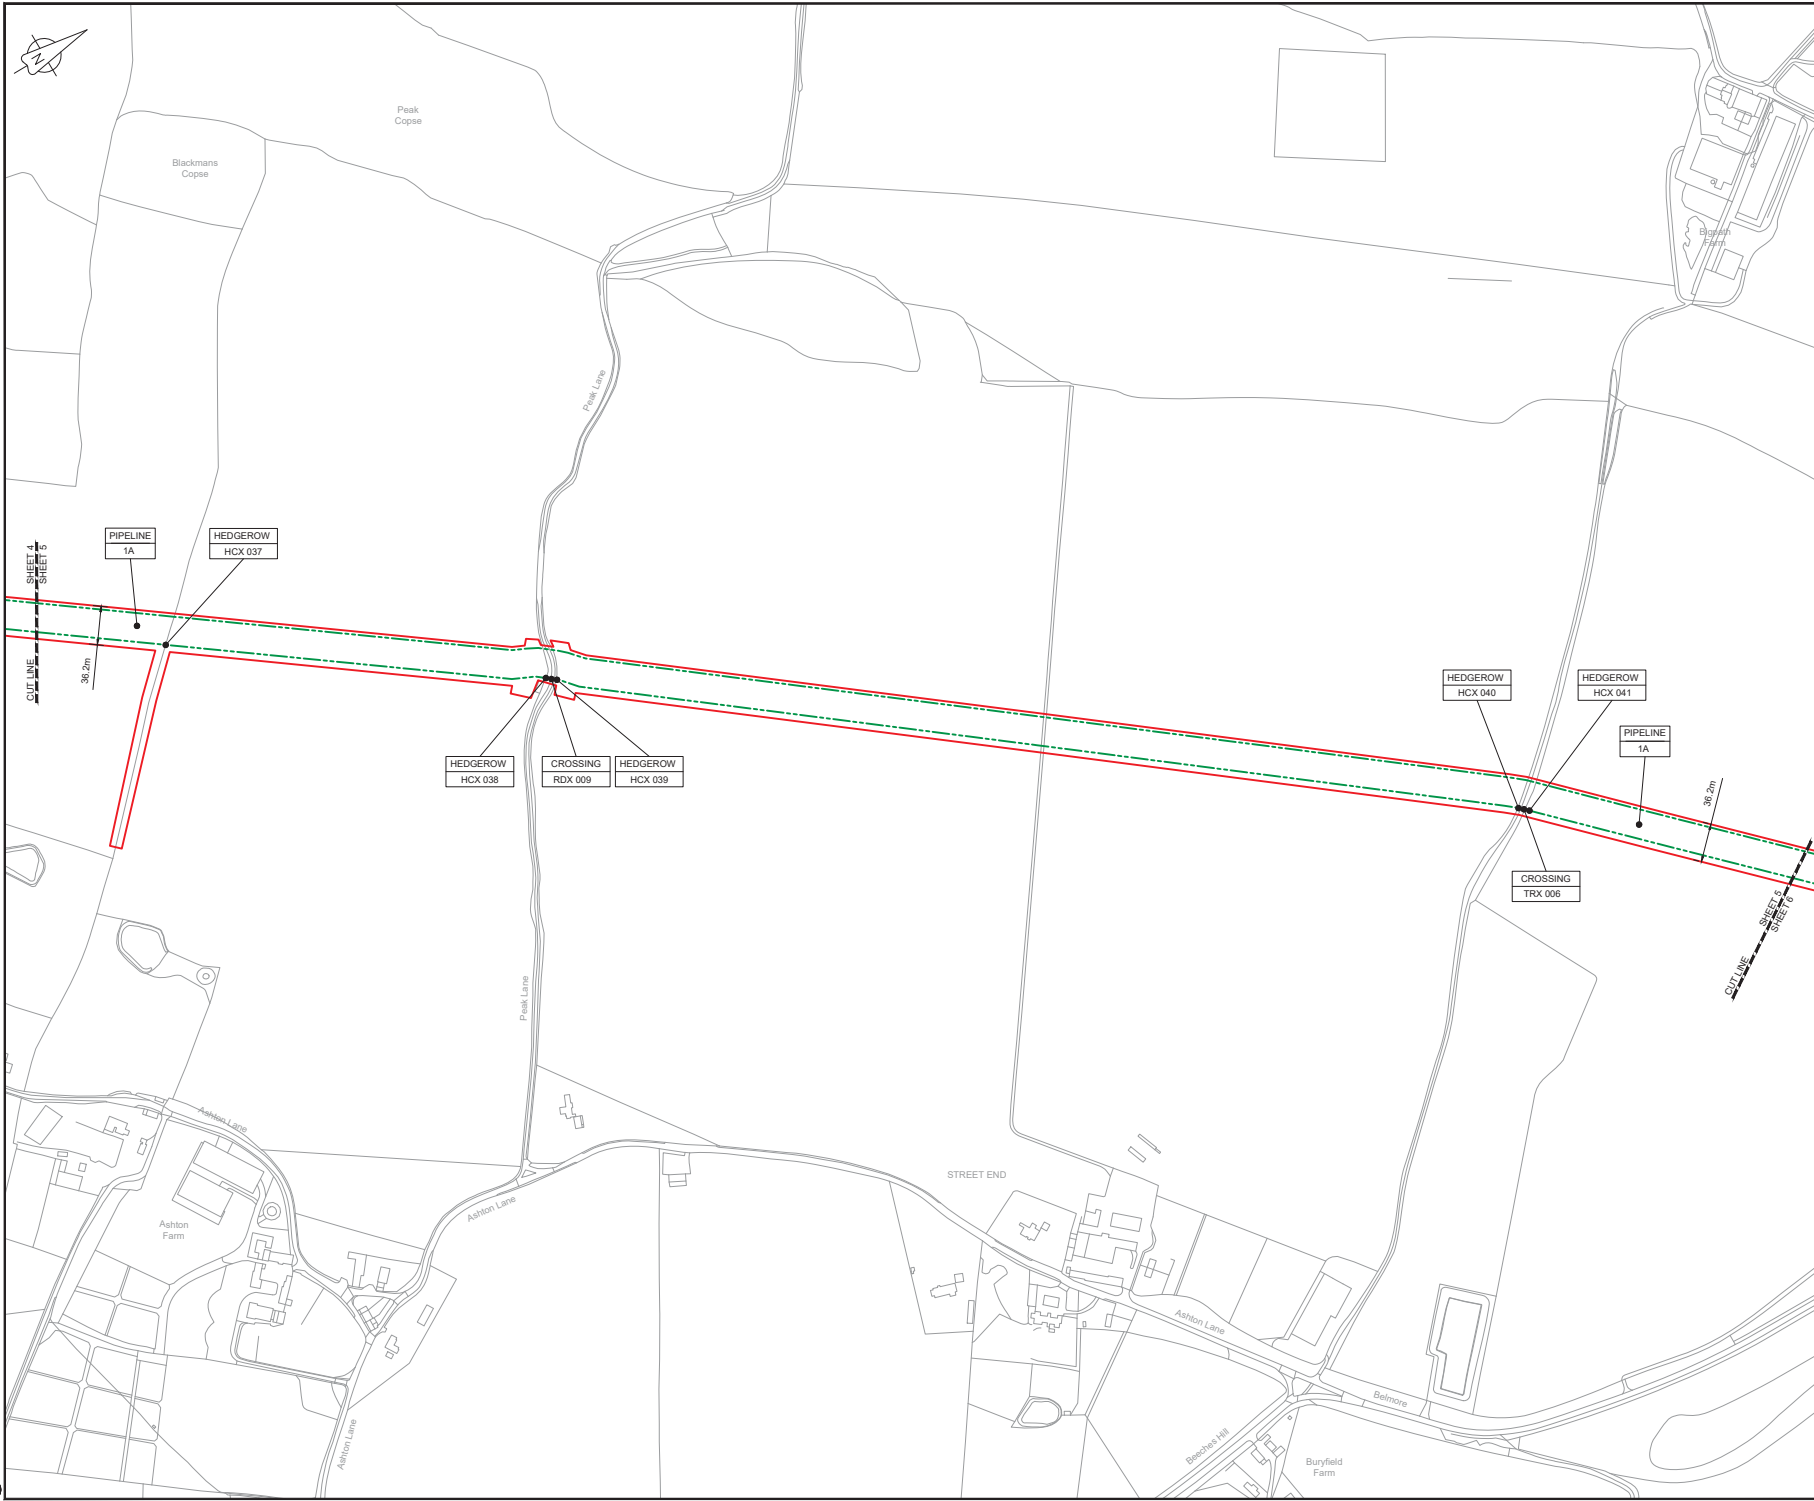

LOCATION PLAN  
SCALE 1:500,000

- NOTES**
1. THIS DRAWING IS IN METRES UNLESS STATED OTHERWISE.
  2. TRENCHLESS CROSSINGS ARE INDICATIVE ONLY.

- LEGEND**
- ORDER LIMITS
  - LIMITS OF DEVIATION
  - NARROW WORKING AREA (NW)
  - TRENCHLESS CROSSING (TC)
  - WATER BODIES
  - ABOVE GROUND INSTALLATION (AGI) / VALVE (VA) / PRESSURE TRANSDUCER (PT)
  - COMPOUND (CO)
  - TREE PRESERVATION ORDER (TPO)
  - DESCRIPTION
  - ID or WORK NUMBER (if applicable)
  - COMMENCEMENT / TERMINATION OF WORKS (COMMENCEMENT = OPEN, TERMINATION = CLOSED)

Contains Ordnance Survey data © Crown copyright and database rights 2019.

© Crown copyright and database rights 2019 OS Licence Number AL100005237.



CD1	02/05/19	0000 SUBMISSION	PC	JA	SC	PH
Rev.	Rev. Date	Purpose of revision	Drawn	Checked	Rev'd	Approved

**JACOBS**  
1180 Ewks Rd, Winchester, Hampshire, RG41 5TU  
Tel: +44(0)118 946 7000 • Fax: +44(0)118 946 7001  
www.jacobs.com

Client: Esso Petroleum Company, Limited  
Emryn House,  
Emryn Way,  
Leatherhead,  
Surrey,  
KT22 8UX

Project: Southampton to London Pipeline Project


Drawing title:  
**GENERAL ARRANGEMENT  
SHEET 5  
REGULATION 5 (2)(O)**

Drawing status: **Fit for Stage Approval**

Scale	1:2500	DO NOT SCALE
Jacobs No.	B2325300	Rev
Client no.		<b>CO1</b>

Drawing number:  
**B2325300-JAC-000-CIV-DRG-000515**

C:\pwworking\jacobs\_uk\_water\_utilities\_sas4\cbe\h\p\ms351182\2325300-JAC-000-CIV-DRG-000515.dwg - 03/05/2019 09:00:16 - A1Frame - CreateP

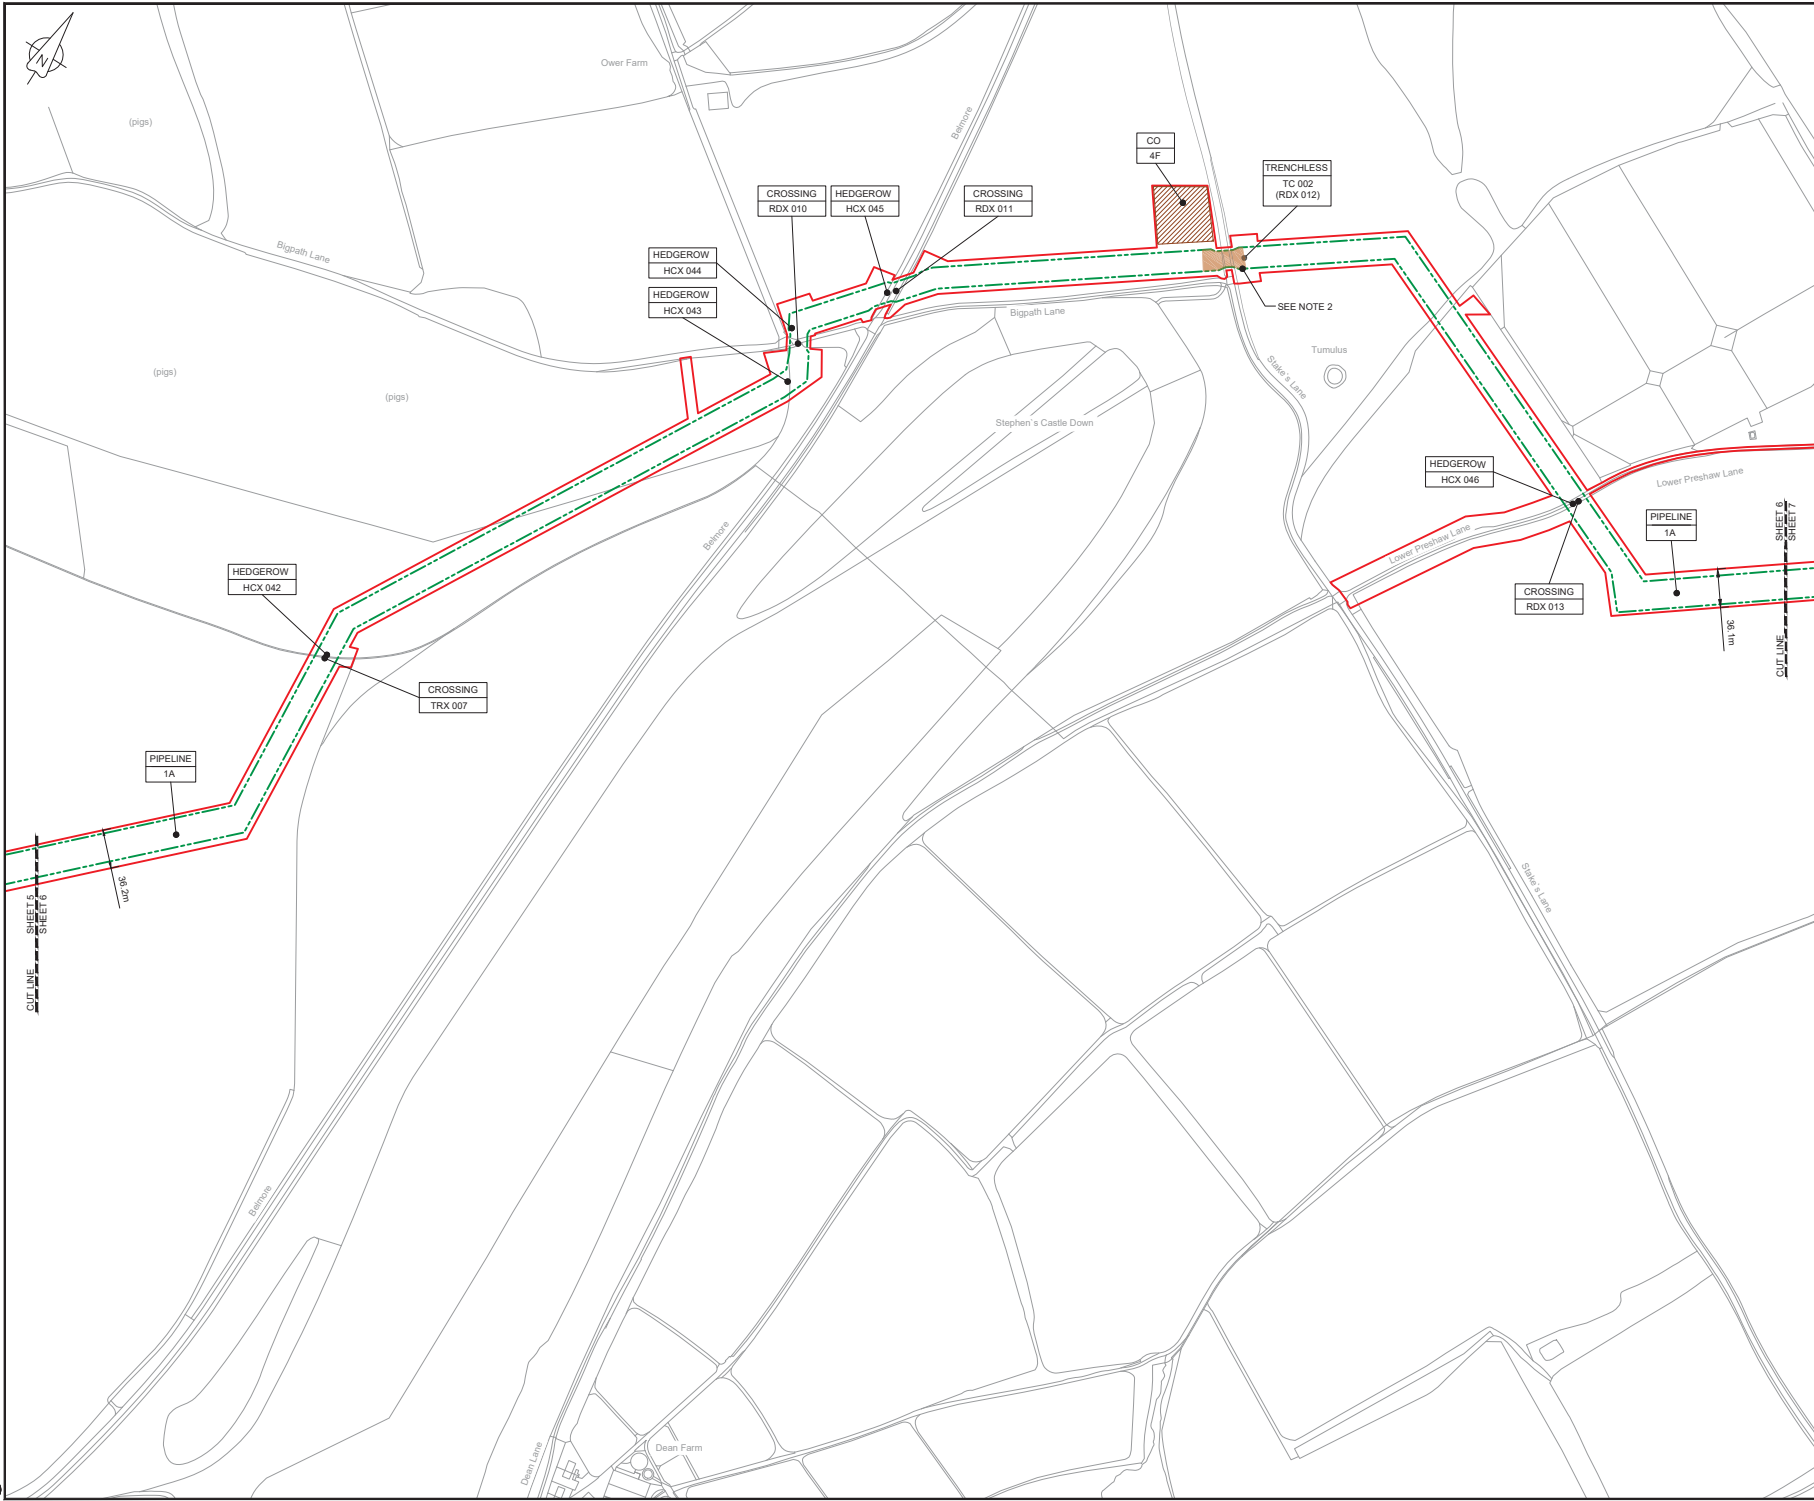

**LOCATION PLAN**  
SCALE 1:500,000

- NOTES**
1. THIS DRAWING IS IN METRES UNLESS STATED OTHERWISE.
  2. TRENCHLESS CROSSINGS ARE INDICATIVE ONLY.

- LEGEND**
- ORDER LIMITS
  - LIMITS OF DEVIATION
  - NARROW WORKING AREA (NW)
  - TRENCHLESS CROSSING (TC)
  - WATER BODIES
  - ABOVE GROUND INSTALLATION (AGI) / VALVE (VA) / PRESSURE TRANSDUCER (PT)
  - COMPOUND (CO)
  - TREE PRESERVATION ORDER (TPO)
  - DESCRIPTION
  - ID or WORK NUMBER (if applicable)
  - COMMENCEMENT / TERMINATION OF WORKS (COMMENCEMENT = OPEN, TERMINATION = CLOSED)

Contains Ordnance Survey data © Crown copyright and database rights 2019.  
© Crown copyright and database rights 2019 OS Licence Number AL10005237.



CDI	02/05/19	0001	0001	0001	0001	0001	0001
Rev.	Rev. Date	Purpose of revision	Drawn	Checked	Rev'd	Apprv'd	

**JACOBS**  
1180 Ewks Rd, Winchester, Hampshire, SO41 5TU  
Tel: +44(0)118 946 7000 • Fax: +44(0)118 946 7001  
www.jacobs.com

Client: Esso Petroleum Company, Limited  
Emryn House,  
Emryn Way,  
Leatherhead,  
Surrey,  
KT22 8UX


Project: Southampton to London Pipeline Project

Drawing title:  
**GENERAL ARRANGEMENT SHEET 6**  
**REGULATION 5 (2)(O)**

Drawing status: **Fit for Stage Approval**

Scale	1:2500	DO NOT SCALE
Jacobs No.	B2325300	Rev
Client no.		<b>CO1</b>

Drawing number:  
**B2325300-JAC-000-CIV-DRG-000516**

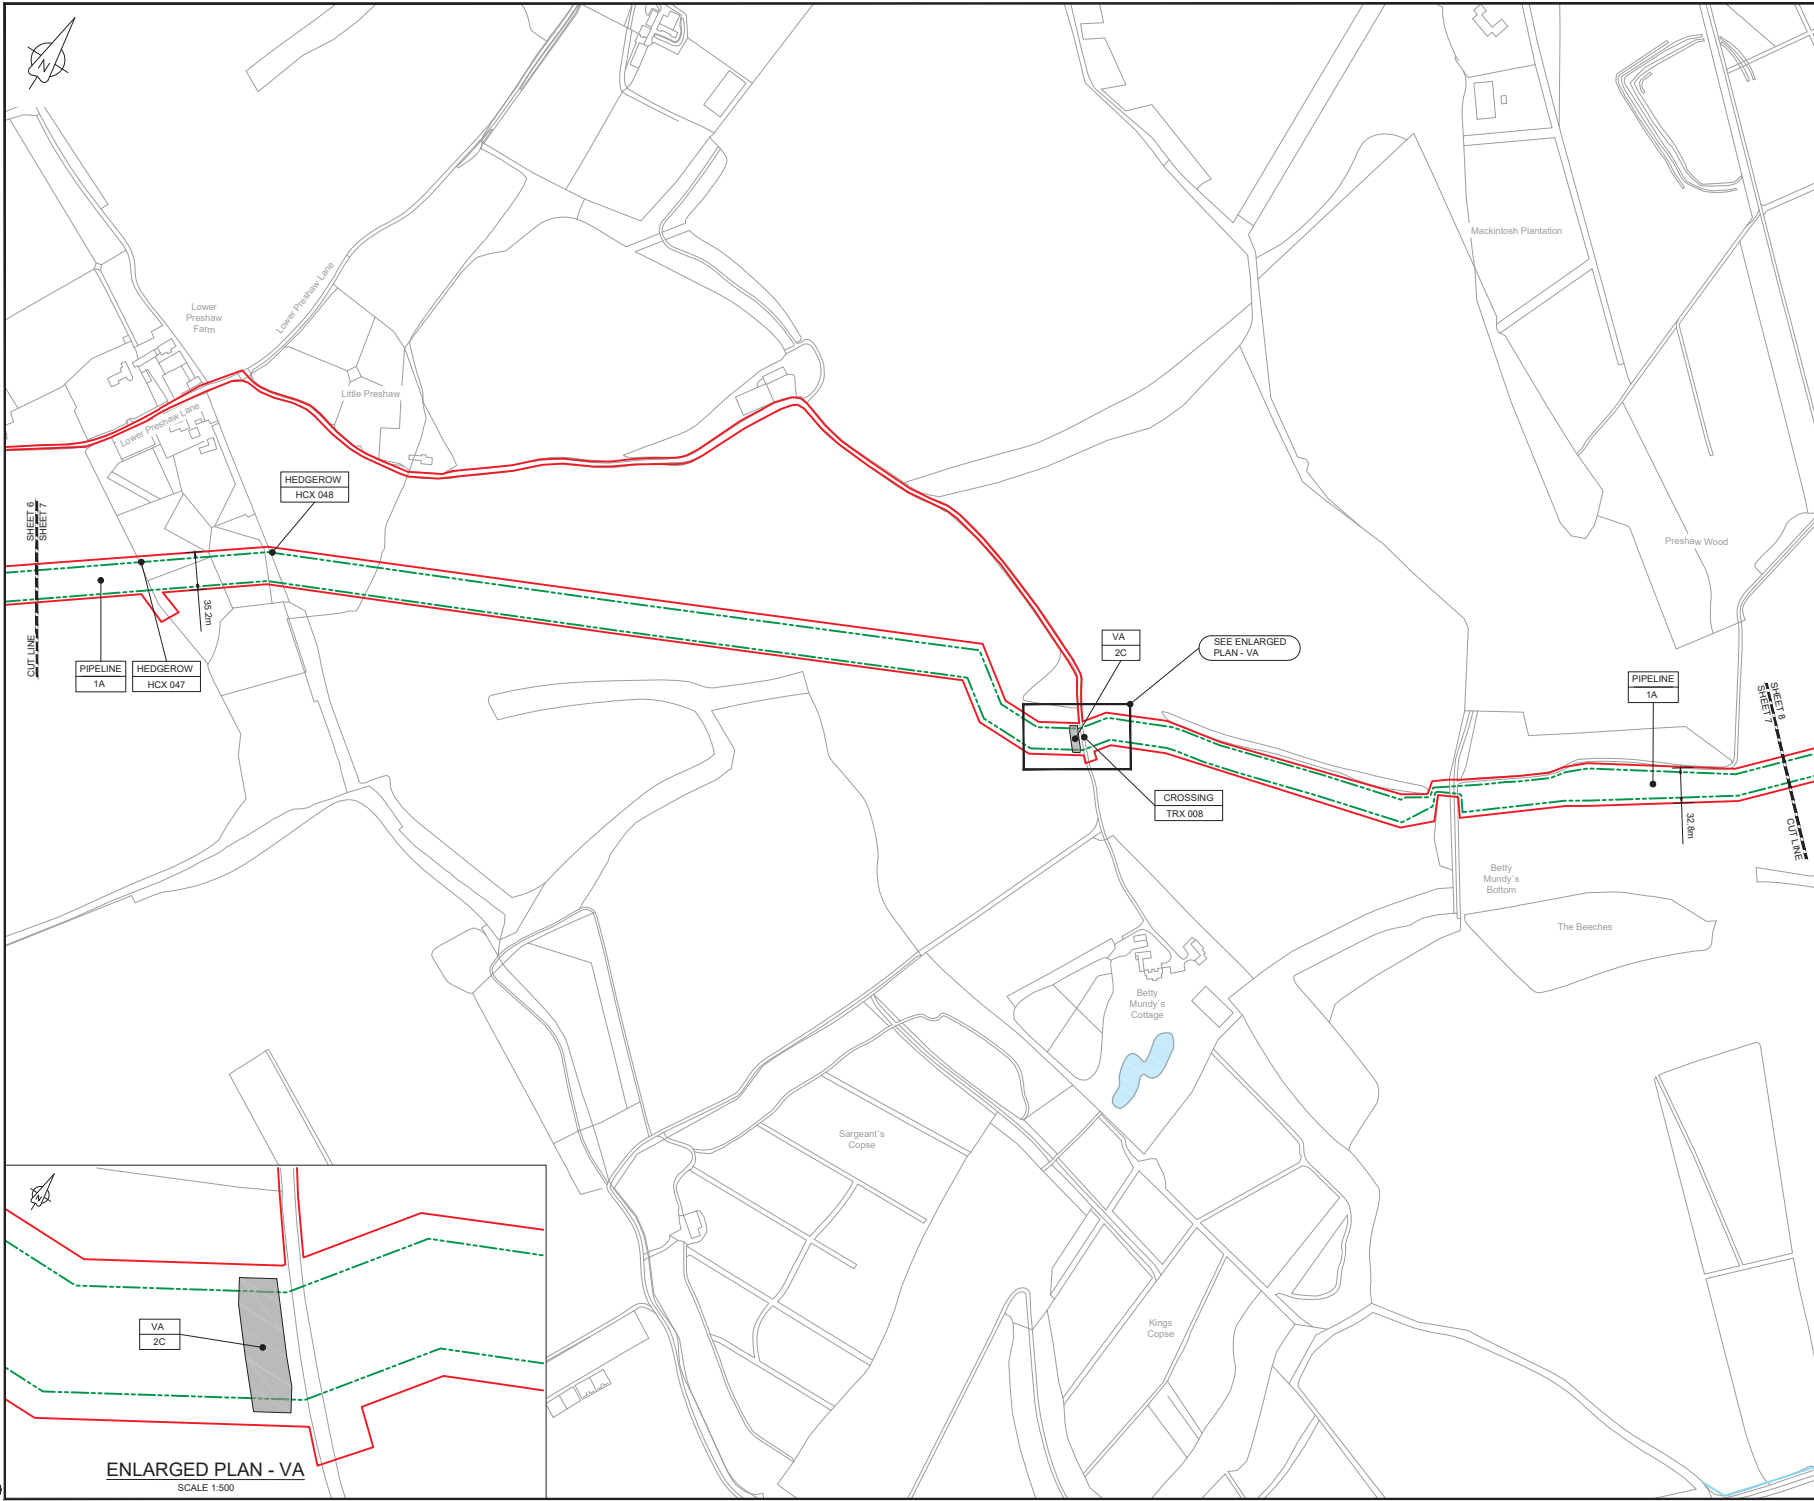

LOCATION PLAN  
SCALE 1:500,000

- NOTES**
1. THIS DRAWING IS IN METRES UNLESS STATED OTHERWISE.
  2. TRENCHLESS CROSSINGS ARE INDICATIVE ONLY.

- LEGEND**
- ORDER LIMITS
  - LIMITS OF DEVIATION
  - NARROW WORKING AREA (NW)
  - TRENCHLESS CROSSING (TC)
  - WATER BODIES
  - ABOVE GROUND INSTALLATION (AGI) / VALVE (VA) / PRESSURE TRANSDUCER (PT)
  - COMPOUND (CO)
  - TREE PRESERVATION ORDER (TPO)
  - DESCRIPTION
  - ID or WORK NUMBER (if applicable)
  - COMMENCEMENT / TERMINATION OF WORKS (COMMENCEMENT = OPEN, TERMINATION = CLOSED)

Contains Ordnance Survey data © Crown copyright and database rights 2019.  
© Crown copyright and database rights 2019 OS Licence Number AL10005237.



CD1	02/05/19	0000 SUBMISSION	PC	JA	SC	PH
Rev.	Rev. Date	Purpose of revision	Drawn	Checked	Rev'd	Approved

**JACOBS**  
1180 Ewks Road, Winchester, Wokingham, RG41 5TU  
Tel: +44(0)118 946 7000 • Fax: +44(0)118 946 7001  
www.jacobs.com

Client: Esso Petroleum Company, Limited  
Ermyn House,  
Ermyn Way,  
Leatherhead,  
Surrey,  
KT22 8UX

Project: Southampton to London Pipeline Project


Drawing title:  
**GENERAL ARRANGEMENT  
SHEET 7  
REGULATION 5 (2)(O)**

Drawing status: **Fit for Stage Approval**

Scale	1:2500	DO NOT SCALE
Jacobs No.	B2325300	Rev
Client no.		<b>C01</b>
Drawing number	<b>B2325300-JAC-000-CIV-DRG-000517</b>	

C:\pwworking\jacobs\_uk\_water\_utilities\_sas4\cheff\p\ma35511892325300-JAC-000-CIV-DRG-000517.dwg - 03/05/2019 09:03:40 - A1Frame - CreateP

**ENLARGED PLAN - VA**  
SCALE 1:500

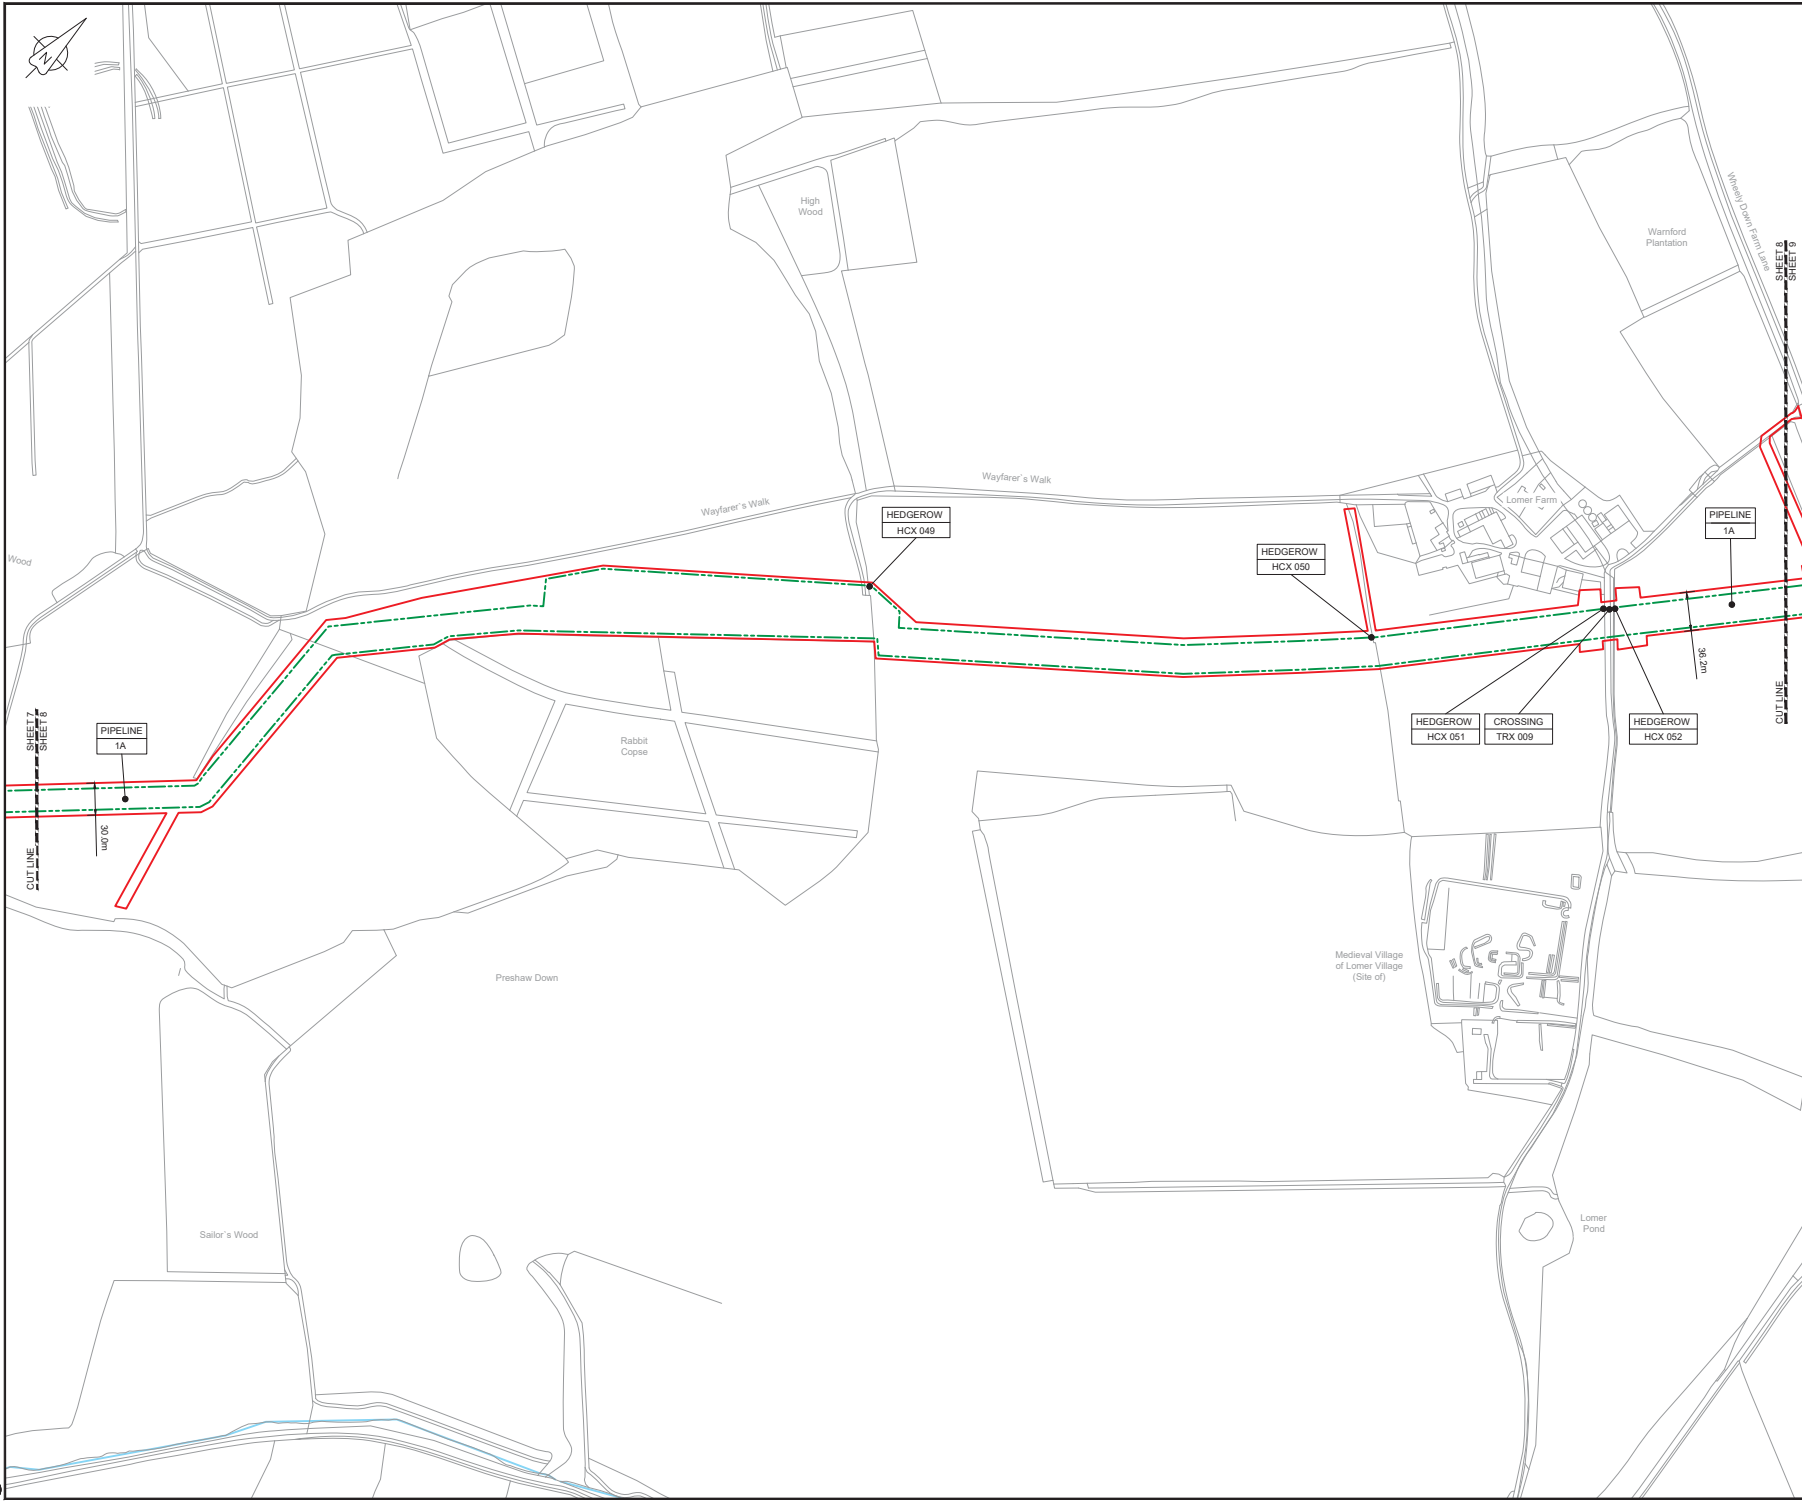

LOCATION PLAN  
SCALE 1:500,000


- NOTES**
1. THIS DRAWING IS IN METRES UNLESS STATED OTHERWISE.
  2. TRENCHLESS CROSSINGS ARE INDICATIVE ONLY.

**LEGEND**

 [Red line]	ORDER LIMITS
[Green dashed line]	LIMITS OF DEVIATION
[Purple shaded area]	NARROW WORKING AREA (NW)
[Brown shaded area]	TRENCHLESS CROSSING (TC)
[Blue shaded area]	WATER BODIES
[Grey shaded area]	ABOVE GROUND INSTALLATION (AGI) / VALVE (VA) / PRESSURE TRANSDUCER (PT)
[Hatched area]	COMPOUND (CO)
[Green dashed line with dots]	TREE PRESERVATION ORDER (TPO)
[Circle with dot]	DESCRIPTION
[Circle with dot]	ID or WORK NUMBER (if applicable)
[Circle with dot]	COMMENCEMENT / TERMINATION OF WORKS (COMMENCEMENT = OPEN, TERMINATION = CLOSED)

Contains Ordnance Survey data © Crown copyright and database rights 2019.

© Crown copyright and database rights 2019 OS Licence Number AL10005237.



CDI	02/05/19	DDC SUBMISSION	PC	JA	SC	PH
Rev.	Rev. Date	Purpose of revision	Drawn	Checked	Rev'd	Approved

**JACOBS**  
1180 Ewidge Road, Winchester, Wokingham, RG41 5TU  
Tel: +44(0)118 945 7000 • Fax: +44(0)118 945 7001  
www.jacobs.com

Client: Esso Petroleum Company, Limited  
Emlyn House,  
Emlyn Way,  
Leatherhead,  
Surrey,  
KT22 8UX

Project: Southampton to London Pipeline Project

Drawing title: **GENERAL ARRANGEMENT SHEET 8**  
**REGULATION 5 (2)(O)**


Drawing status: **Fit for Stage Approval**

Scale	1:2500	DO NOT SCALE
Jacobs No.	B2325300	Rev
Client no.		Rev
Drawing number		<b>C01</b>

B2325300-JAC-000-CIV-DRG-000518

Use or copying of this document in whole or in part without the written permission of Jacobs constitutes an infringement of copyright. Limitation: This drawing has been prepared on behalf of and for the exclusive use of Jacobs Client, and is subject to, and issued in accordance with, the provisions of the contract between Jacobs and the Client. Jacobs accepts no liability or responsibility whatsoever for its use in respect of any other use or reliance upon. This drawing is an A1 sized sheet.



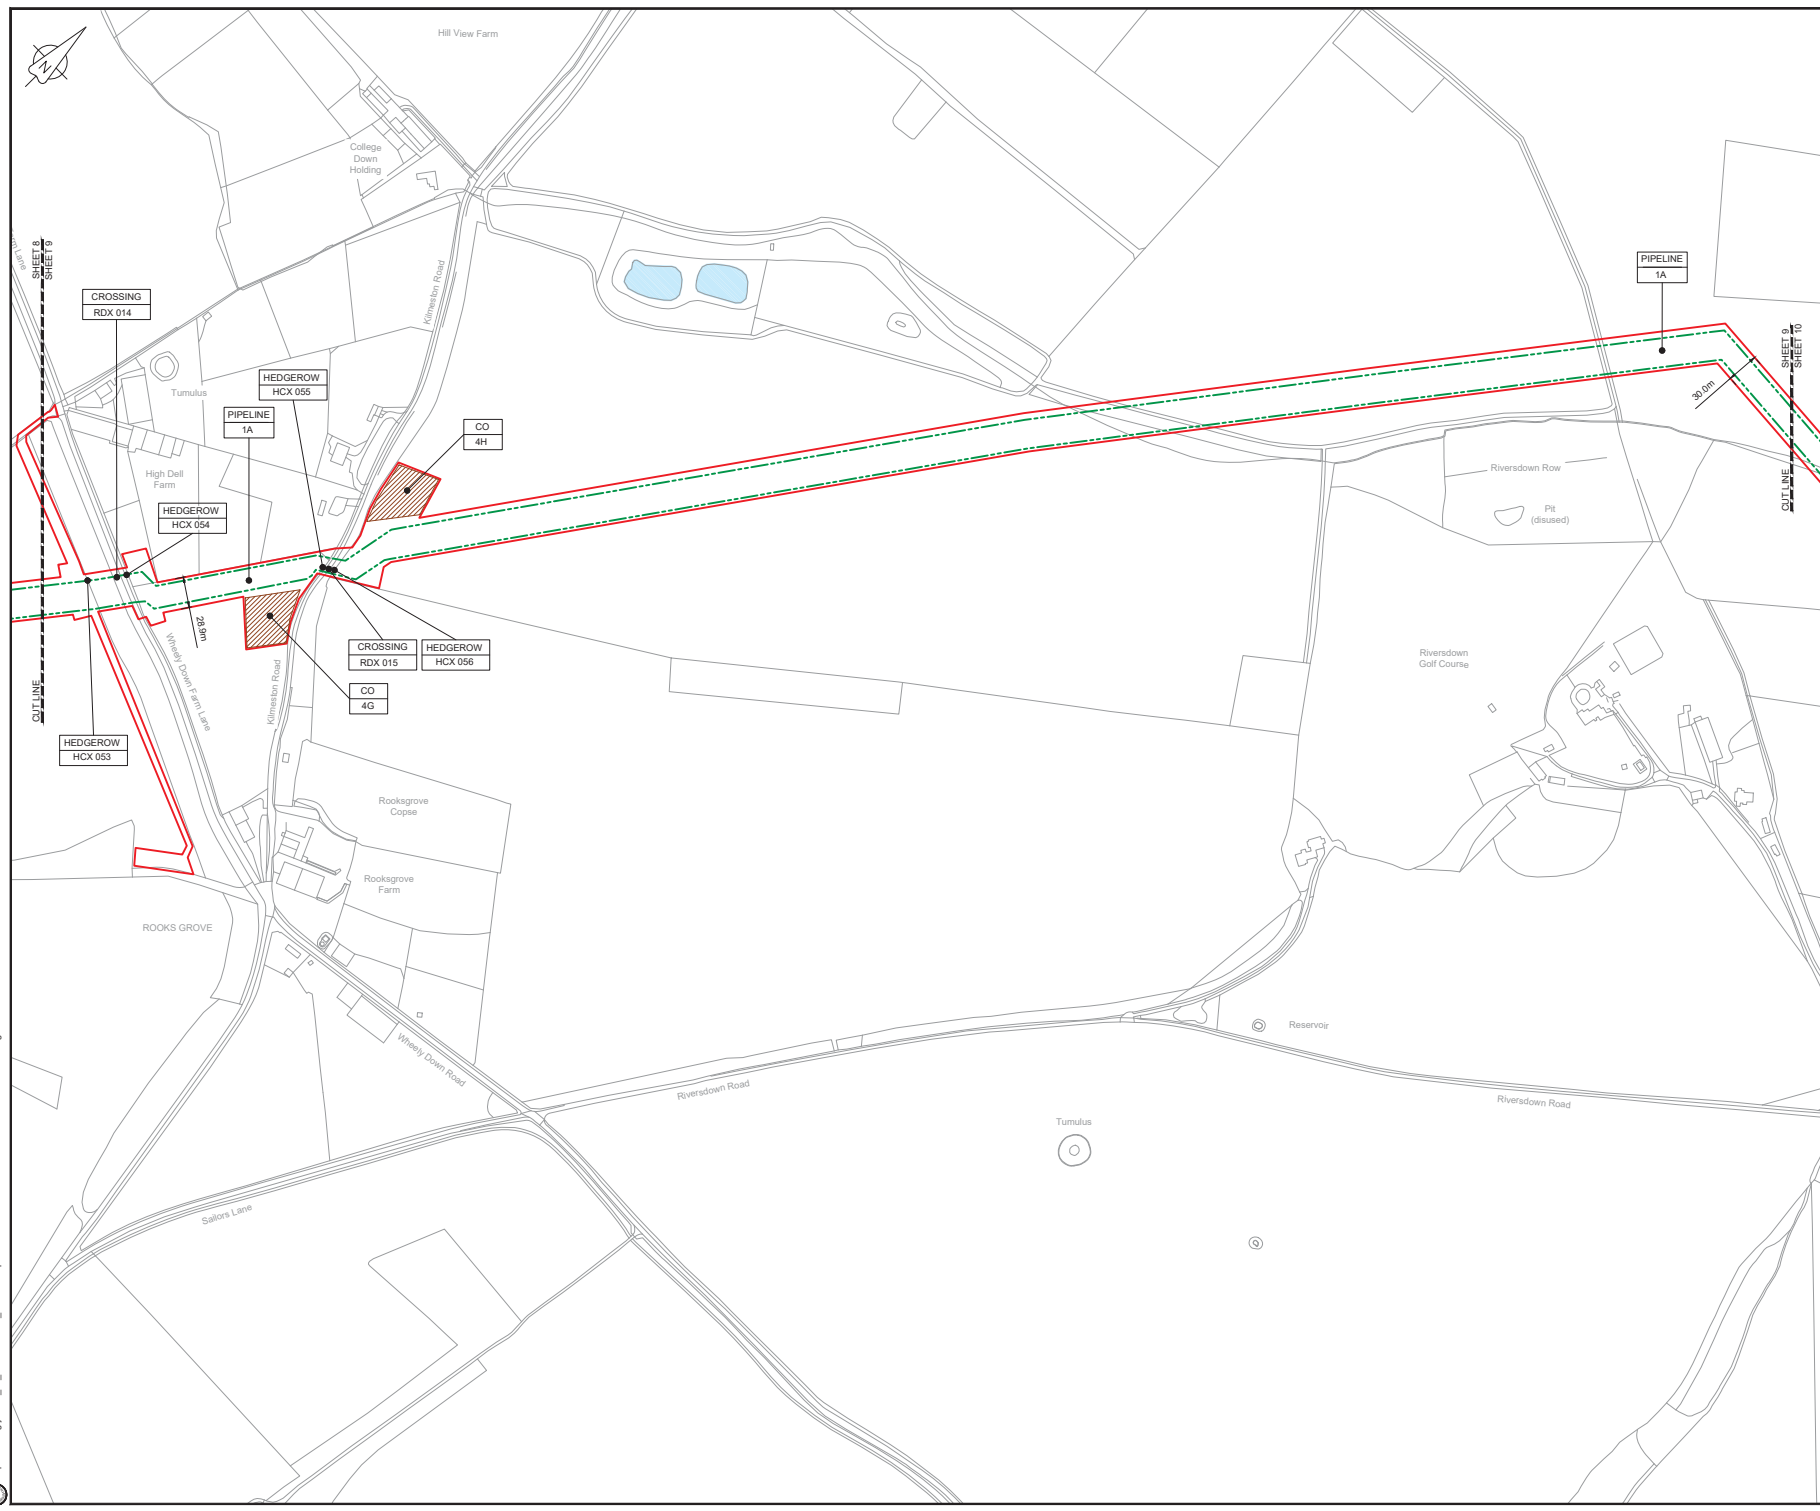


LOCATION PLAN  
SCALE 1:500,000

NOTES  
1. THIS DRAWING IS IN METRES UNLESS STATED OTHERWISE.  
2. TRENCHLESS CROSSINGS ARE INDICATIVE ONLY.

- LEGEND
- ORDER LIMITS
  - LIMITS OF DEVIATION
  - NARROW WORKING AREA (NW)
  - TRENCHLESS CROSSING (TC)
  - WATER BODIES
  - ABOVE GROUND INSTALLATION (AGI) / VALVE (VA) / PRESSURE TRANSDUCER (PT)
  - COMPOUND (CO)
  - TREE PRESERVATION ORDER (TPO)
- DESCRIPTION
- ID or WORK NUMBER (if applicable)
  - COMMENCEMENT / TERMINATION OF WORKS (COMMENCEMENT = OPEN, TERMINATION = CLOSED)

Contains Ordnance Survey data © Crown copyright and database rights 2019.

 © Crown copyright and database rights 2019 OS Licence Number AL100005237.



CSI	02/25/19	0001/00/00/00	PC	JL	SC	PH
Rev.	Rev. Date	Purpose of revision	Drawn	Checked	Rev'd	Approved

**JACOBS**  
1180 Etwash Road, Winchester, Wokingham, RG41 5TU  
Tel: +44(0)118 946 7000 • Fax: +44(0)118 946 7001  
www.jacobs.com

Client: Esso Petroleum Company, Limited  
Emryn House,  
Emryn Way,  
Leatherhead,  
Surrey,  
KT22 8UX

Project: Southampton to London Pipeline Project


Drawing title:  
**GENERAL ARRANGEMENT SHEET 9**  
**REGULATION 5 (2)(O)**

Drawing status: **Fit for Stage Approval**

Scale	1:2500	DO NOT SCALE
JACOBS No.	B2325300	Rev
Client no.		Rev <b>C01</b>

Drawing number: **B2325300-JAC-000-CIV-DRG-000519**

C:\pwworking\jacobs\_uk\_water\utilites\_sas4\cheff\hydms3351582325300-JAC-000-CIV-DRG-000519.dwg - 03/02/2019 10:08:10.46 - A1Frame - CleanTP

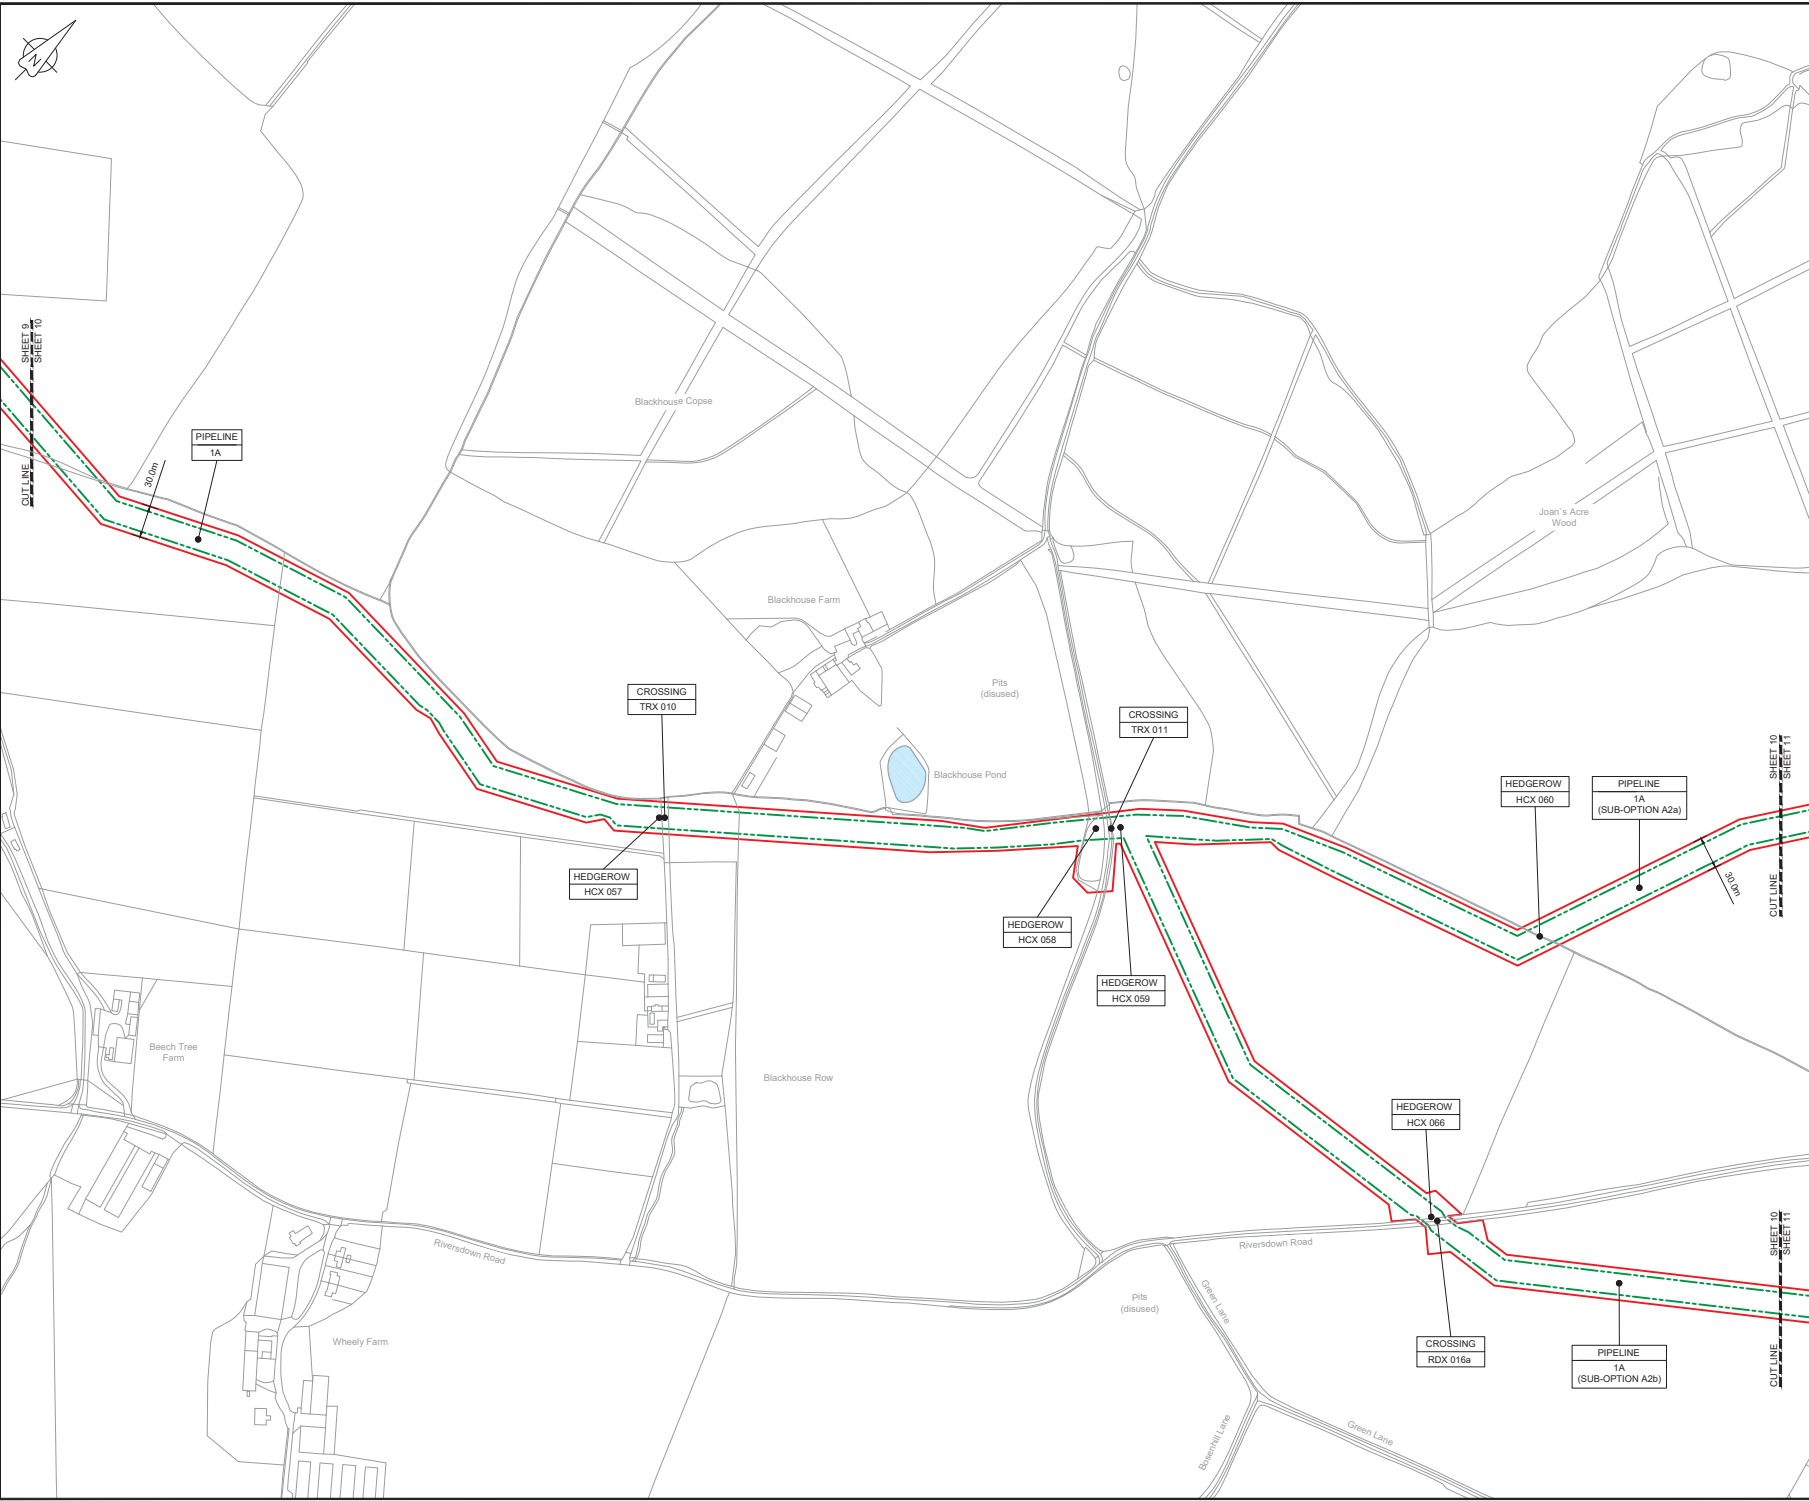


LOCATION PLAN  
SCALE 1:500,000

NOTES  
1. THIS DRAWING IS IN METRES UNLESS STATED OTHERWISE.  
2. TRENCHLESS CROSSINGS ARE INDICATIVE ONLY.

- LEGEND
- ORDER LIMITS
  - - - LIMITS OF DEVIATION
  - NARROW WORKING AREA (NW)
  - TRENCHLESS CROSSING (TC)
  - WATER BODIES
  - ABOVE GROUND INSTALLATION (AGI) / VALVE (VA) / PRESSURE TRANSDUCER (PT)
  - COMPOUND (CO)
  - TREE PRESERVATION ORDER (TPO)
  - DESCRIPTION
  - ID or WORK NUMBER (if applicable)
  - COMMENCEMENT / TERMINATION OF WORKS (COMMENCEMENT = OPEN, TERMINATION = CLOSED)

 Contains Ordnance Survey data © Crown copyright and database rights 2019.  
© Crown copyright and database rights 2019 OS Licence Number AL100005237.



CD	02/05/19	0000	PC	JA	SC	PH
Rev.	Rev. Date	Purpose of revision	Drawn	Checked	Rev'd	Approved



Client: Esso Petroleum Company, Limited  
Ermyn House,  
Ermyn Way,  
Leatherhead,  
Surrey,  
KT22 8UX



Project:  
**GENERAL ARRANGEMENT  
SHEET 10  
REGULATION 5 (2)(O)**


Drawing title: **GENERAL ARRANGEMENT SHEET 10 REGULATION 5 (2)(O)**

Drawing status: **Fit for Stage Approval**

Scale	1:2500	DO NOT SCALE
Jacobs No.	B2325300	Rev
Client no.		<b>C01</b>

Drawing number: **B2325300-JAC-000-CIV-DRG-000520**

Use of copyright or other material in this drawing is the responsibility of the client. The client warrants that it has obtained the necessary permissions for the use of such material. The client warrants that it has obtained the necessary permissions for the use of such material. The client warrants that it has obtained the necessary permissions for the use of such material.

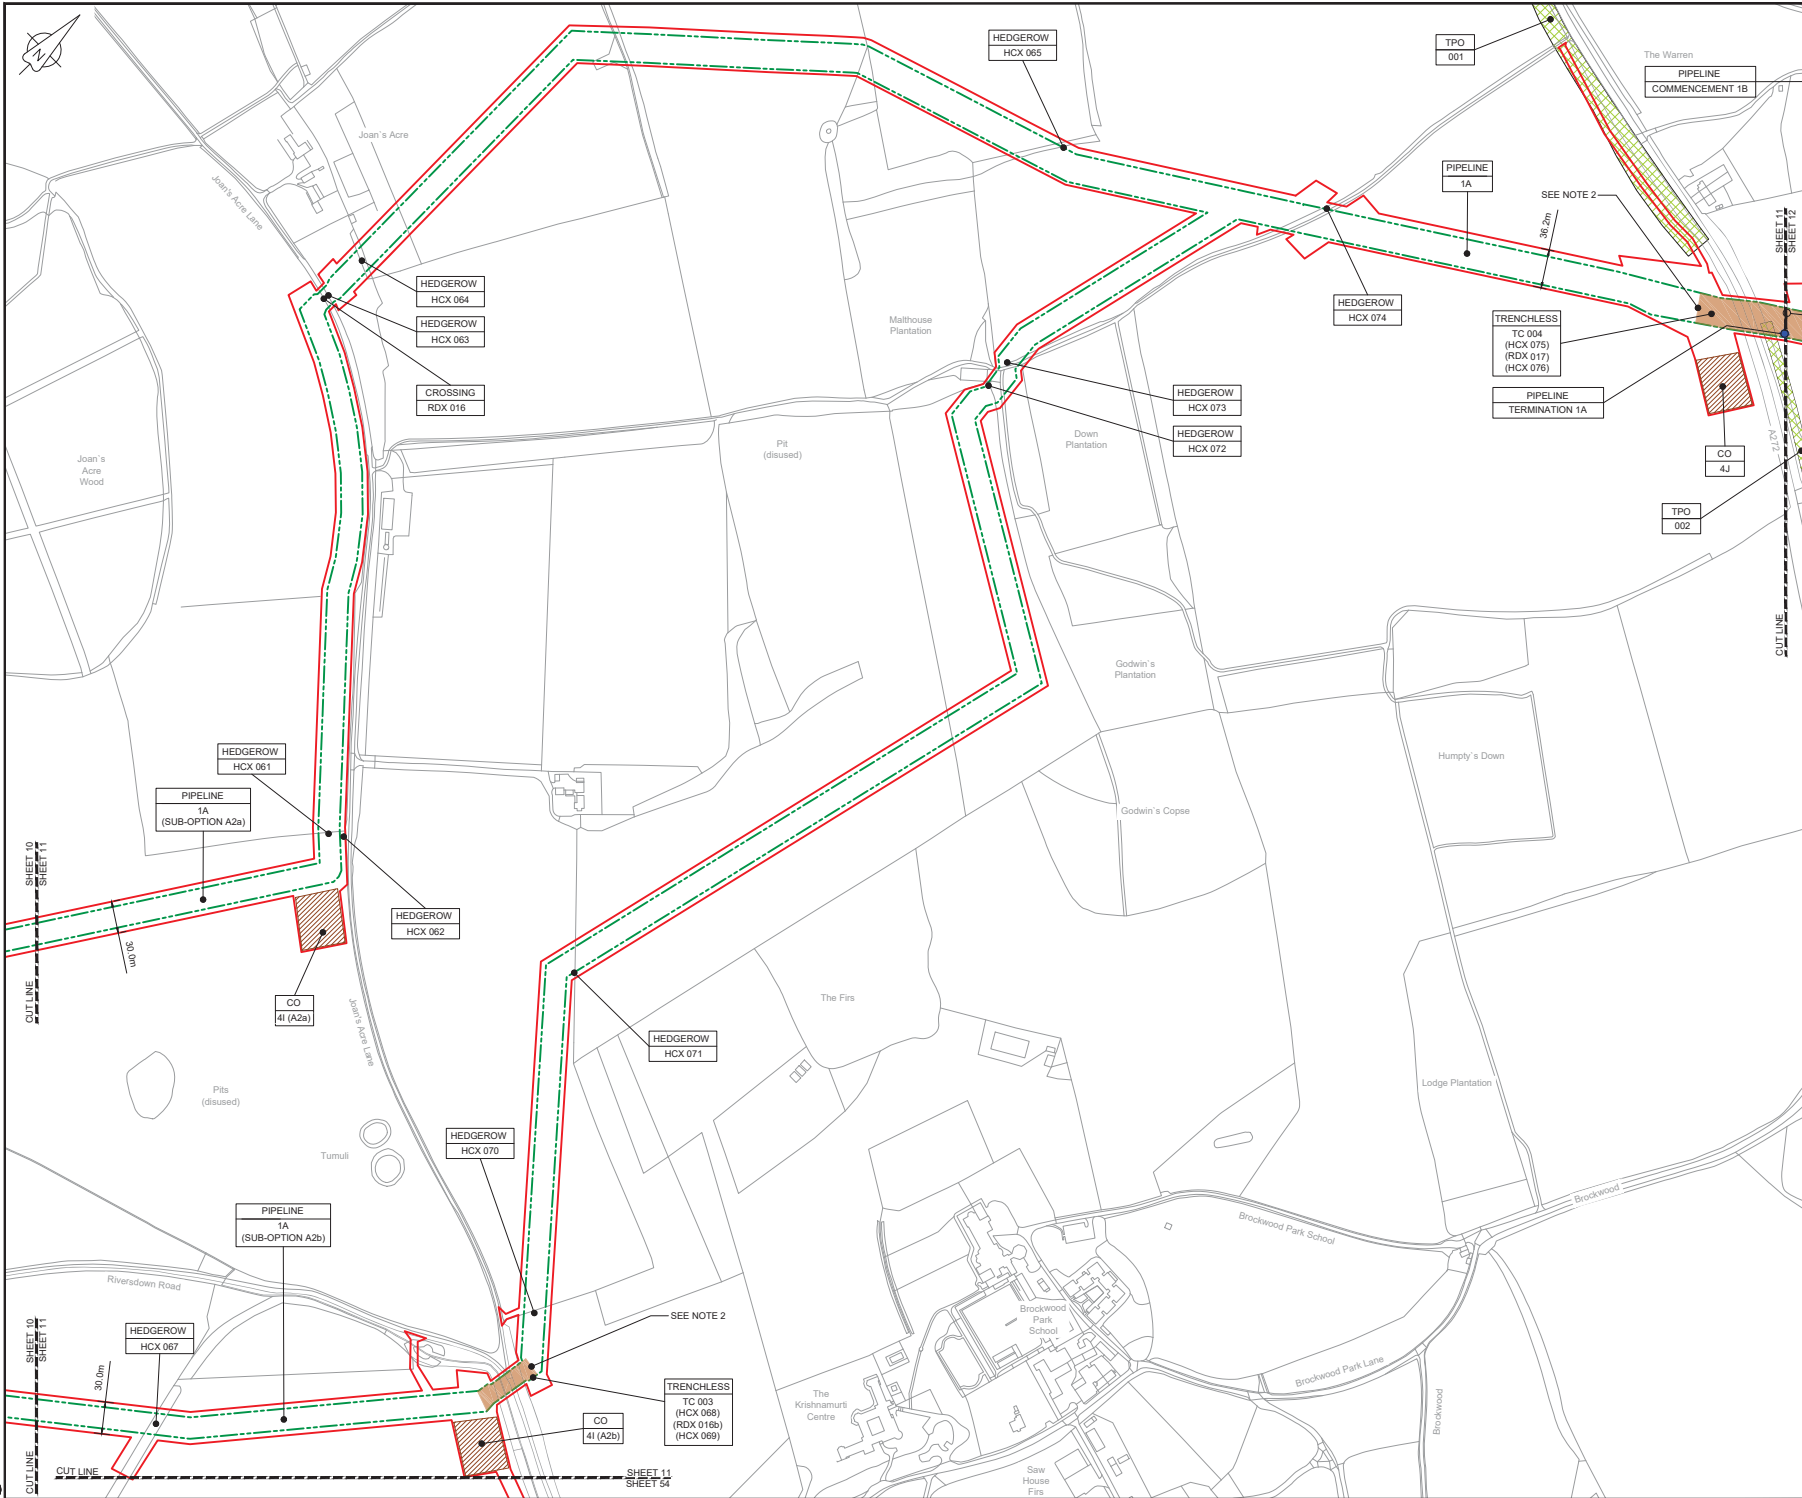


- NOTES**
- THIS DRAWING IS IN METRES UNLESS STATED OTHERWISE.
  - TRENCHLESS CROSSINGS ARE INDICATIVE ONLY.

**LEGEND**

 - ORDER LIMITS
- LIMITS OF DEVIATION
- NARROW WORKING AREA (NW)
- TRENCHLESS CROSSING (TC)
- WATER BODIES
- ABOVE GROUND INSTALLATION (AGI) / VALVE (VA) / PRESSURE TRANSDUCER (PT)
- COMPOUND (CO)
- TREE PRESERVATION ORDER (TPO)
- DESCRIPTION
- ID or WORK NUMBER (if applicable)
- COMMENCEMENT / TERMINATION OF WORKS (COMMENCEMENT = OPEN, TERMINATION = CLOSED)

Contains Ordnance Survey data © Crown copyright and database rights 2019.  
© Crown copyright and database rights 2019 OS Licence Number AL10005237.



CD	02/05/19	0001	PC	JA	SC	PH
Rev.	Rev. Date	Purpose of revision	Drawn	Checked	Rev'd	Approved

**JACOBS**  
1180 Ewks Rd, Winchester, Hampshire, SO41 5TU  
Tel: +44(0)118 946 7000 • Fax: +44(0)118 946 7001  
www.jacobs.com

Client: Esso Petroleum Company Limited  
Ermyth House,  
Ermyth Way,  
Leatherhead,  
Surrey,  
KT22 8UX

Project: **Esso** | Southampton to London Pipeline Project


Drawing title:  
**GENERAL ARRANGEMENT SHEET 11 REGULATION 5 (2)(O)**

Drawing status: **Fit for Stage Approval**

Scale	1:2500	DO NOT SCALE
Scale	1:2500	DO NOT SCALE
Jacobs No.	B2325300	Rev
Client no.	B2325300	CO1

Drawing number:  
**B2325300-JAC-000-CIV-DRG-000521**

C:\pwworking\jacobs\_uk\_water\utils\p\351182\2325300\JAC-000-CIV-DRG-000521.dwg - 03/05/2019 08:15:37 - A1Frame - CleanP

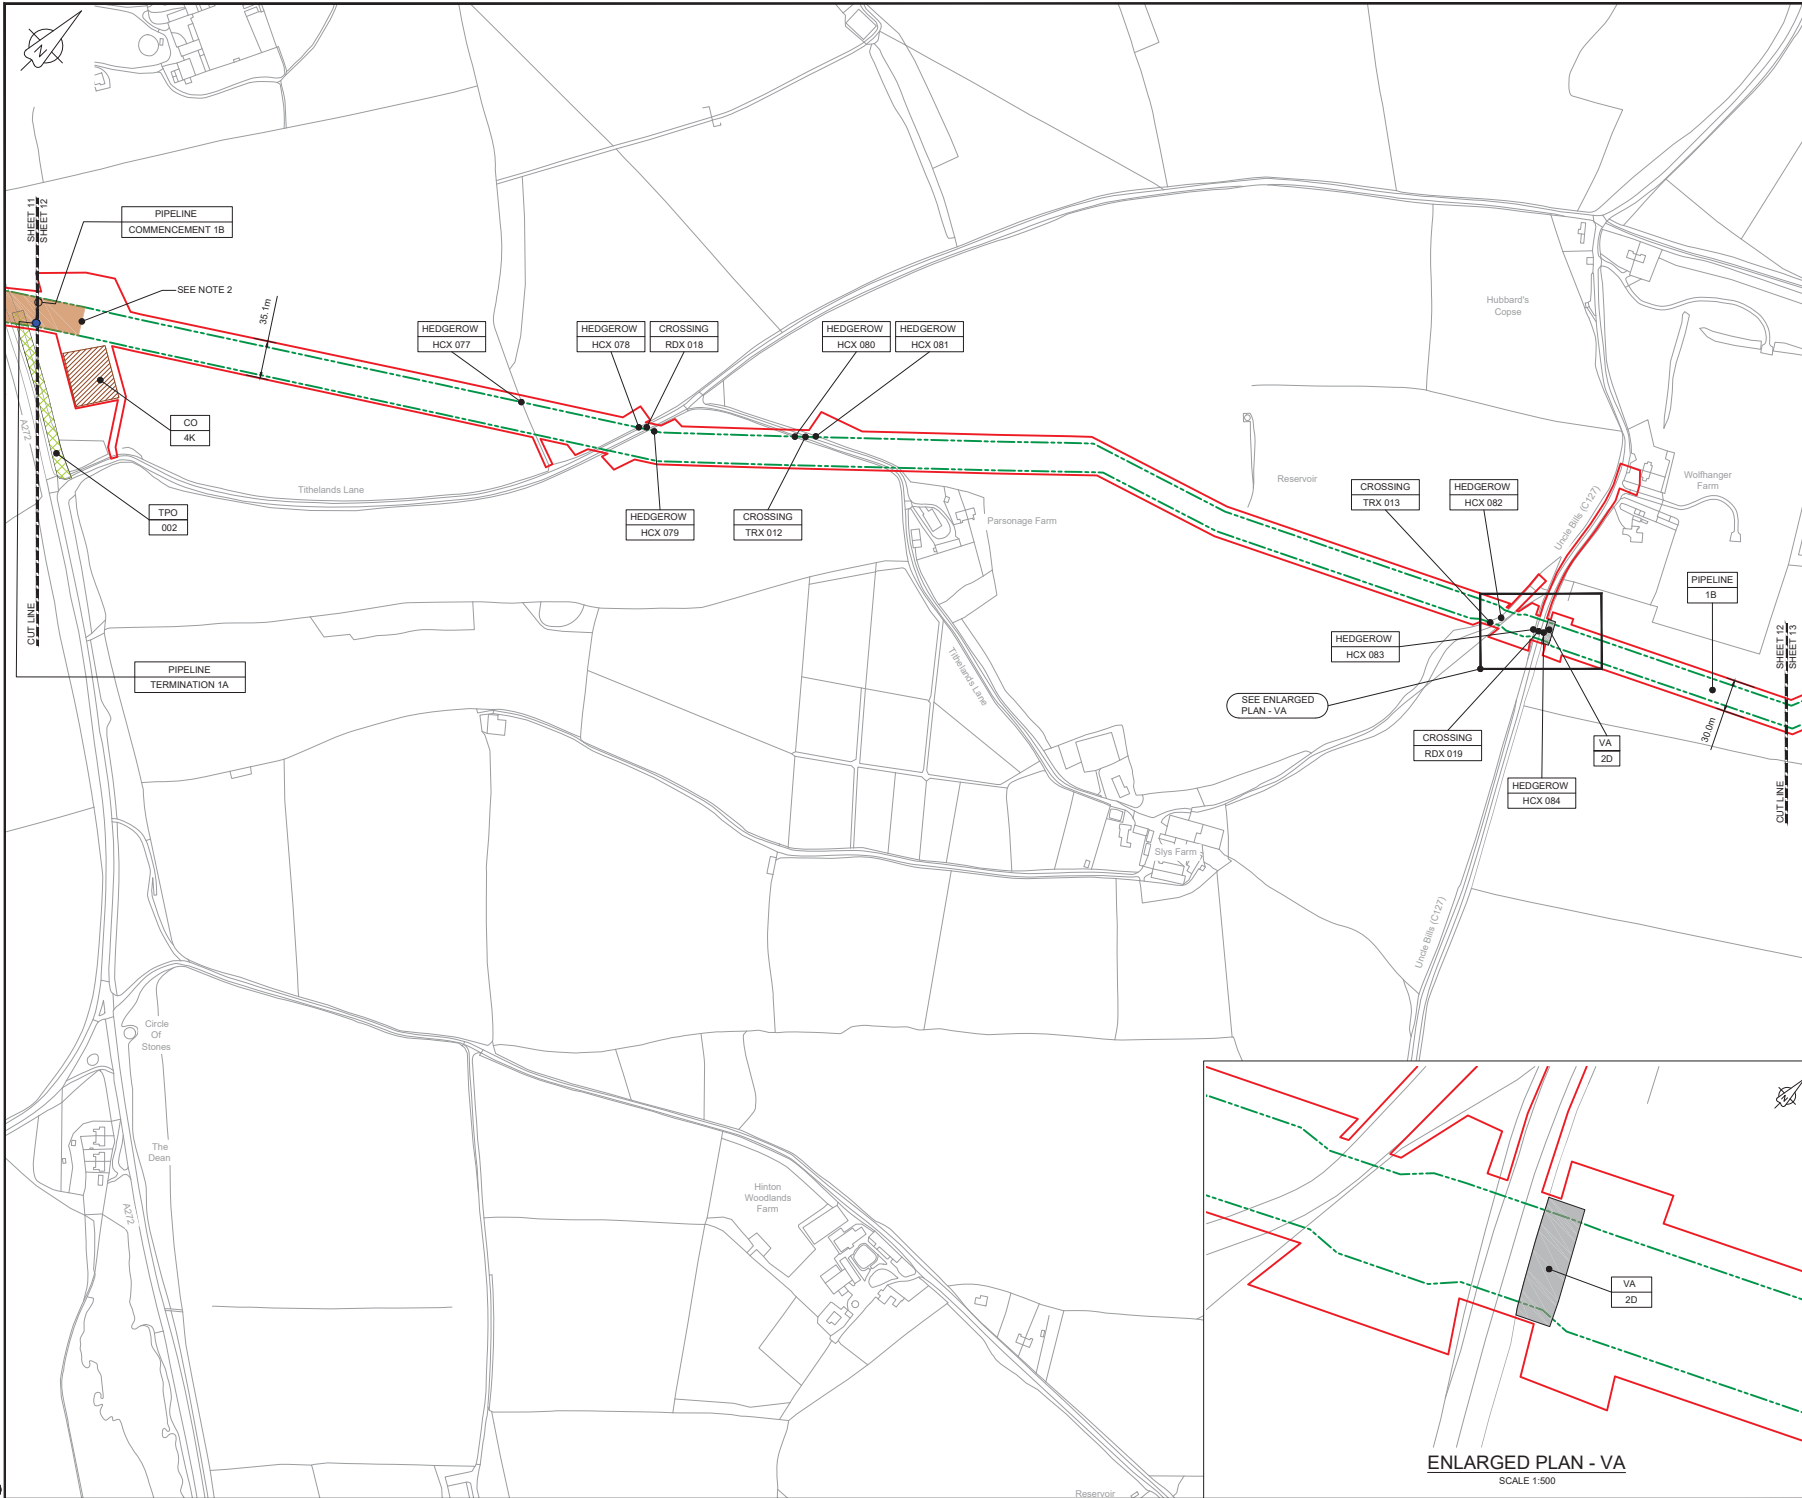

LOCATION PLAN  
SCALE 1:500,000


NOTES  
1. THIS DRAWING IS IN METRES UNLESS STATED OTHERWISE.  
2. TRENCHLESS CROSSINGS ARE INDICATIVE ONLY.

**LEGEND**

 [Red line]	ORDER LIMITS
[Green dashed line]	LIMITS OF DEVIATION
[Purple shaded area]	NARROW WORKING AREA (NW)
[Brown shaded area]	TRENCHLESS CROSSING (TC)
[Blue shaded area]	WATER BODIES
[Grey shaded area]	ABOVE GROUND INSTALLATION (AGI) / VALVE (VA) / PRESSURE TRANSDUCER (PT)
[Orange shaded area]	COMPOUND (CO)
[Green circle]	TREE PRESERVATION ORDER (TPO)
[Circle with dot]	DESCRIPTION ID or WORK NUMBER (if applicable)
[Blue circle]	COMMENCEMENT / TERMINATION OF WORKS (COMMENCEMENT = OPEN, TERMINATION = CLOSED)

Contains Ordnance Survey data © Crown copyright and database rights 2019.

© Crown copyright and database rights 2019 OS Licence Number AL100005237.



CD1	02/05/19	0000	0000	0000	0000	0000	0000	0000	0000
Rev.	Rev. Date	Purpose of revision			PC	JA	SC	PH	APPR

**JACOBS**  
1180 Ewings Road, Winchester, Wokingham, RG41 5TU  
Tel: +44(0)118 946 7000 • Fax: +44(0)118 946 7001  
www.jacobs.com


Client: Esso Petroleum Company, Limited  
Emlyn House,  
Emlyn Way,  
Leatherhead,  
Surrey,  
KT22 8UX

**Esso** | Southampton to London Pipeline Project

Project  
**GENERAL ARRANGEMENT  
SHEET 12  
REGULATION 5 (2)(O)**

Drawing status: **Fit for Stage Approval**


Scale	1:2500	DO NOT SCALE
Jacobs No.	B2325300	Rev
Client no.	B2325300	Rev
Drawing number	B2325300-JAC-000-CIV-DRG-000522	Rev
		CO1

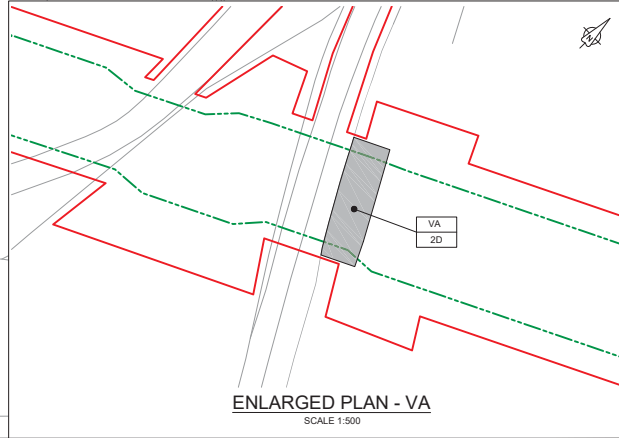

ENLARGED PLAN - VA  
SCALE 1:500

C:\pwworking\jacobs\_uk\_water\utilities\_sas4\chesh\hyma3351188\2325300-JAC-000-CIV-DRG-000522.dwg - 03/05/2019 08:16:54 - A1Frame - CleanP



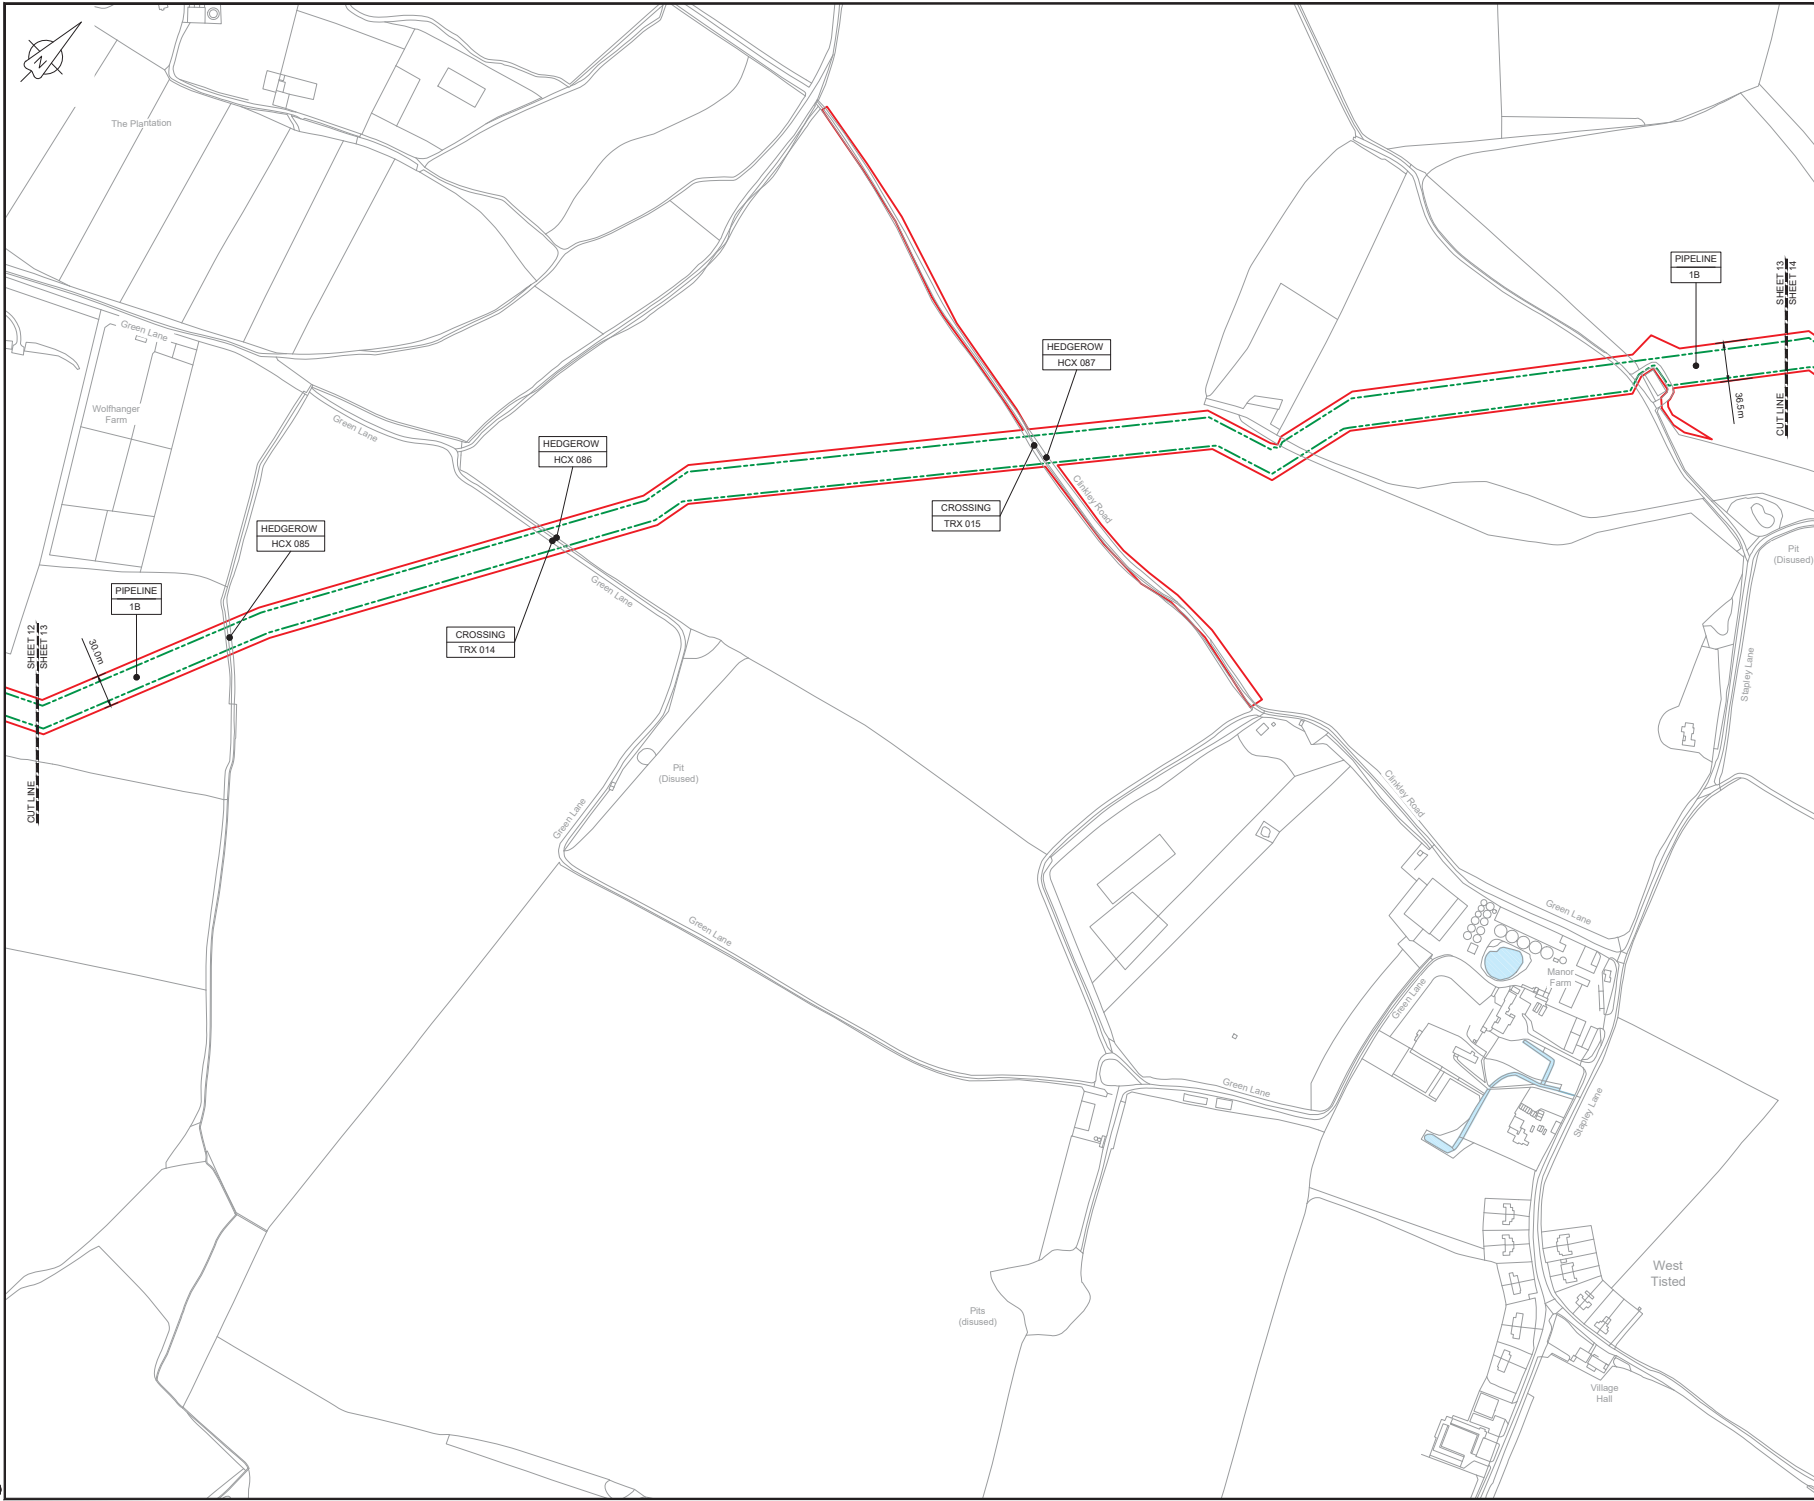


LOCATION PLAN  
SCALE 1:500,000

- NOTES**
1. THIS DRAWING IS IN METRES UNLESS STATED OTHERWISE.
  2. TRENCHLESS CROSSINGS ARE INDICATIVE ONLY.

**LEGEND**

 	ORDER LIMITS
	LIMITS OF DEVIATION
	NARROW WORKING AREA (NW)
	TRENCHLESS CROSSING (TC)
	WATER BODIES
	ABOVE GROUND INSTALLATION (AGI) / VALVE (VA) / PRESSURE TRANSDUCER (PT)
	COMPOUND (CO)
	TREE PRESERVATION ORDER (TPO)
	DESCRIPTION
	ID or WORK NUMBER (if applicable)
	COMMENCEMENT / TERMINATION OF WORKS (COMMENCEMENT = OPEN, TERMINATION = CLOSED)

Contains Ordnance Survey data © Crown copyright and database rights 2019.  
© Crown copyright and database rights 2019 OS Licence Number AL10005237.



CD1	02/05/19	0001 SUBMISSION	PC	JA	SC	PH
Rev.	Rev. Date	Purpose of revision	Drawn	Checked	Rev'd	Approved



Client: Esso Petroleum Company, Limited  
Ermyn House,  
Ermyn Way,  
Leatherhead,  
Surrey,  
KT22 8UX




Drawing title  
**GENERAL ARRANGEMENT  
SHEET 13  
REGULATION 5 (2)(O)**

Drawing status: **Fit for Stage Approval**

Scale	1:2500	DO NOT SCALE
Jacobs No.	B2325300	Rev
Client no.		<b>C01</b>

Drawing number  
**B2325300-JAC-000-CIV-DRG-000523**

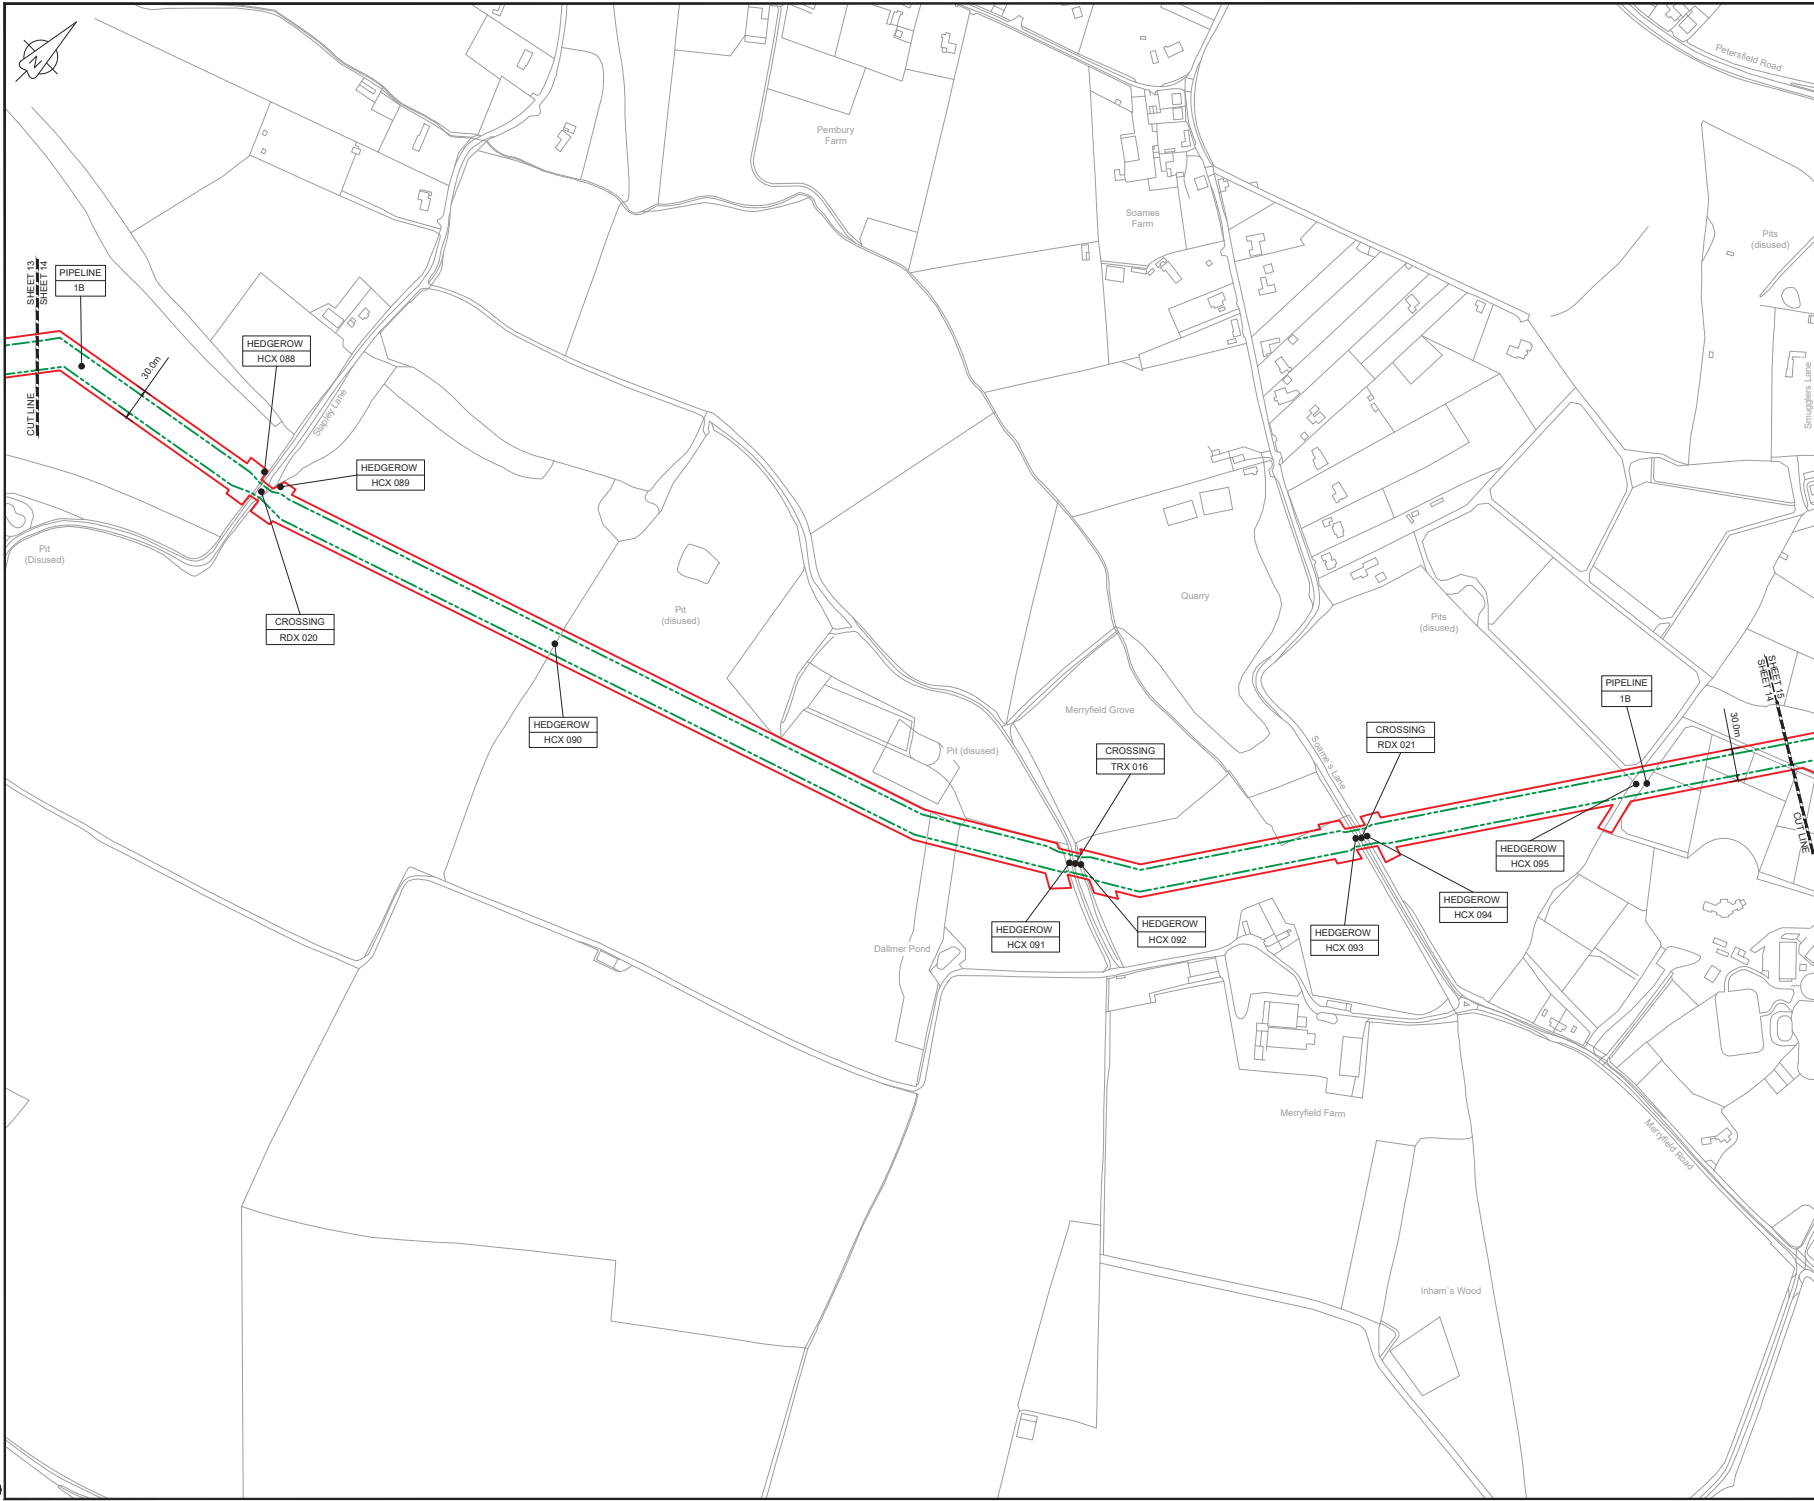


LOCATION PLAN  
SCALE 1:500,000

- NOTES**
1. THIS DRAWING IS IN METRES UNLESS STATED OTHERWISE.
  2. TRENCHLESS CROSSINGS ARE INDICATIVE ONLY.

**LEGEND**

 	ORDER LIMITS
	LIMITS OF DEVIATION
	NARROW WORKING AREA (NW)
	TRENCHLESS CROSSING (TC)
	WATER BODIES
	ABOVE GROUND INSTALLATION (AGI) / VALVE (VA) / PRESSURE TRANSDUCER (PT)
	COMPOUND (CO)
	TREE PRESERVATION ORDER (TPO)
	DESCRIPTION
	ID or WORK NUMBER (if applicable)
	COMMENCEMENT / TERMINATION OF WORKS (COMMENCEMENT = OPEN, TERMINATION = CLOSED)

Contains Ordnance Survey data © Crown copyright and database rights 2019.  
© Crown copyright and database rights 2019 OS Licence Number AL100005237.



CD1	02/05/19	0000 SUBMISSION	PC	JA	SC	PH
Rev.	Rev. Date	Purpose of revision	Drawn	Checked	Rev'd	Approved

**JACOBS**  
1180 Ewias Road, Winchester, Hampshire, RG41 5TU  
Tel: +44(0)118 946 7000 • Fax: +44(0)118 946 7001  
www.jacobs.com

Client: Esso Petroleum Company, Limited  
Ermyth House,  
Ermyth Way,  
Leatherhead,  
Surrey,  
KT22 8UX


Project: Southampton to London Pipeline Project

Drawing title:  
**GENERAL ARRANGEMENT  
SHEET 14  
REGULATION 5 (2)(O)**

Drawing status: **Fit for Stage Approval**

Scale	1:2500	DO NOT SCALE
Jacobs No.	B2325300	Rev
Client no.		<b>C01</b>

Drawing number:  
**B2325300-JAC-000-CIV-DRG-000524**

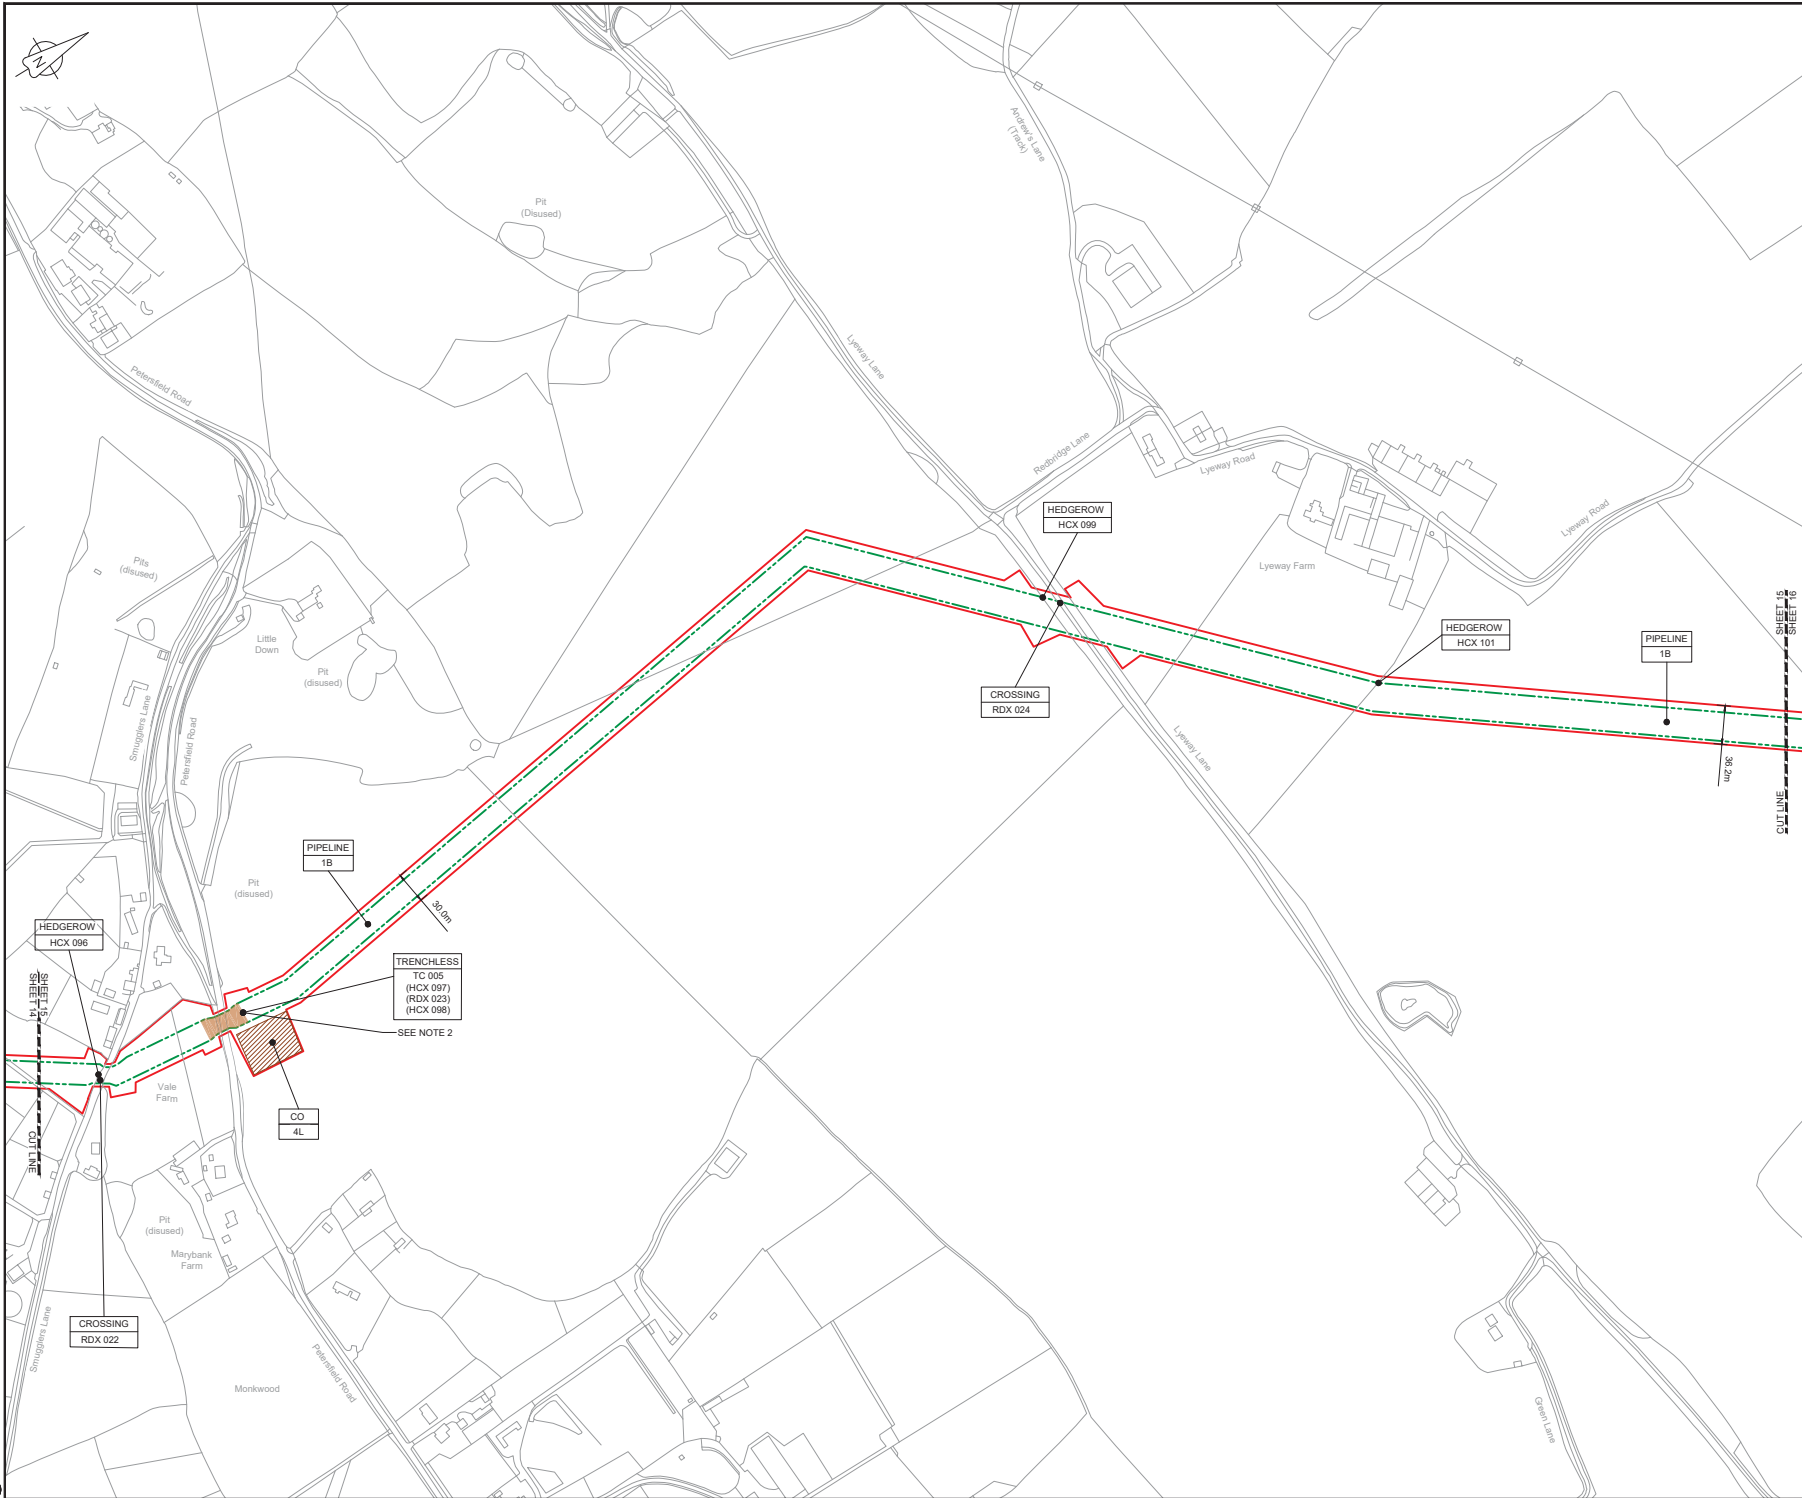

LOCATION PLAN  
SCALE 1:500,000

- NOTES**
1. THIS DRAWING IS IN METRES UNLESS STATED OTHERWISE.
  2. TRENCHLESS CROSSINGS ARE INDICATIVE ONLY.

- LEGEND**
- ORDER LIMITS
  - LIMITS OF DEVIATION
  - NARROW WORKING AREA (NW)
  - TRENCHLESS CROSSING (TC)
  - WATER BODIES
  - ABOVE GROUND INSTALLATION (AGI) / VALVE (VA) / PRESSURE TRANSDUCER (PT)
  - COMPOUND (CO)
  - TREE PRESERVATION ORDER (TPO)
  - DESCRIPTION
  - ID or WORK NUMBER (if applicable)
  - COMMENCEMENT / TERMINATION OF WORKS (COMMENCEMENT = OPEN, TERMINATION = CLOSED)

Contains Ordnance Survey data © Crown copyright and database rights 2019.

© Crown copyright and database rights 2019 OS Licence Number AL10005237.



CDI	02/01/19	0001 SUBMISSION	PC	JA	SC	PH
Rev.	Rev. Date	Purpose of revision	Drawn	Checked	Rev'd	Approved



Client: Esso Petroleum Company, Limited  
Emryn House,  
Emryn Way,  
Leatherhead,  
Surrey,  
KT22 8UX



Drawing title  
**GENERAL ARRANGEMENT  
SHEET 15  
REGULATION 5 (2)(O)**

Drawing status: **Fit for Stage Approval**


Scale	1:2500	DO NOT SCALE
Jacobs No.	B2325300	Rev
Client no.		Rev
Drawing number		<b>CO1</b>

B2325300-JAC-000-CIV-DRG-000525

C:\pwworking\jacobs\_uk\_water\_utilities\_sas4\csh\p\ma3351188\2325300-JAC-000-CIV-DRG-000525.dwg - 03/02/2019 09:21:05 - A1Frame - CleanPlt





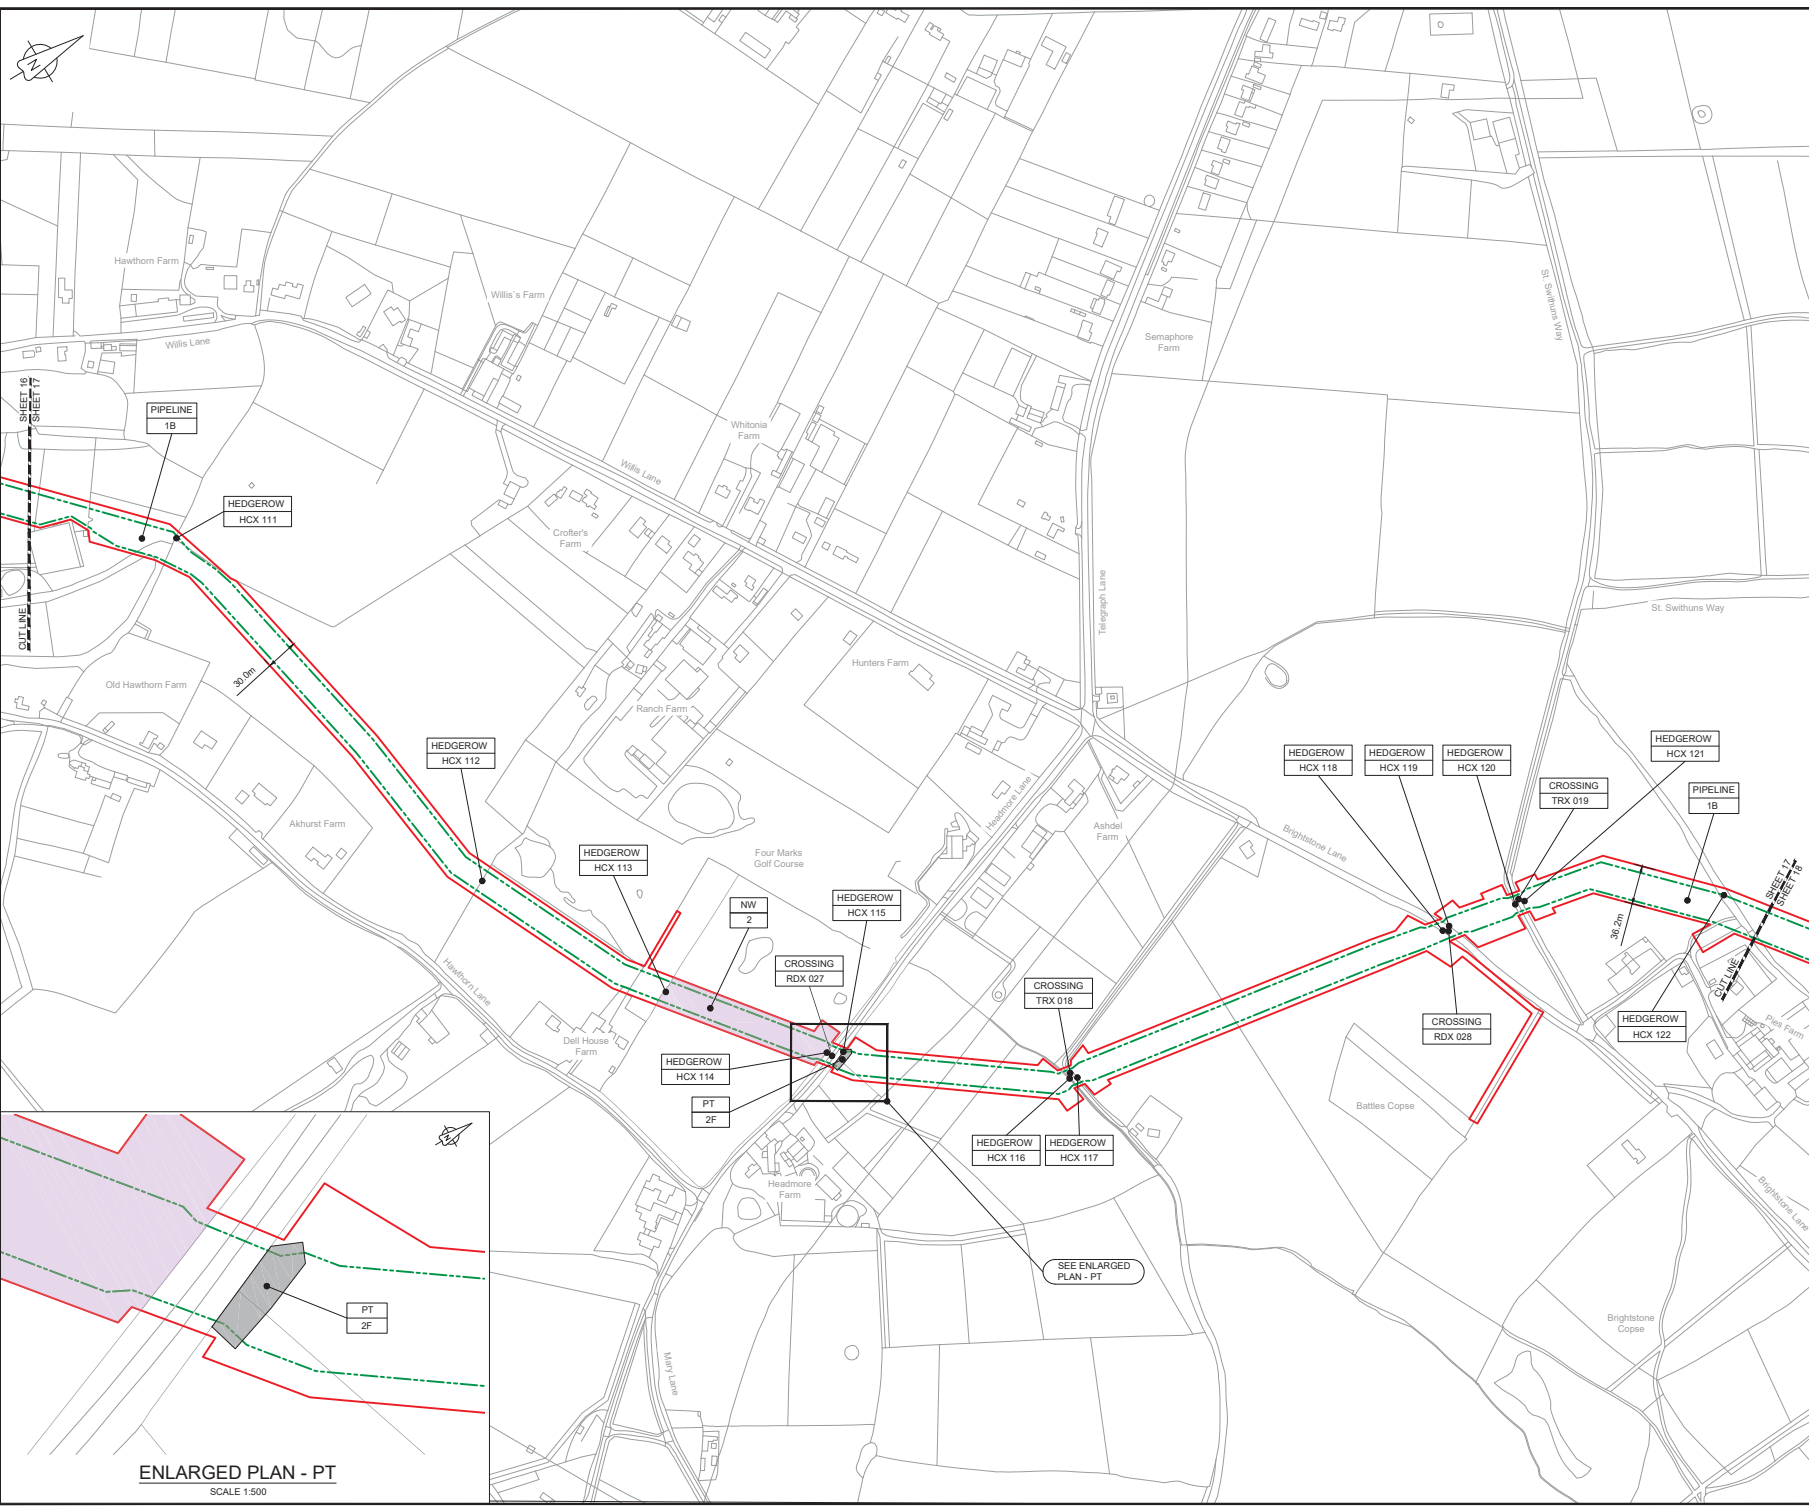

LOCATION PLAN  
SCALE 1:500,000


- NOTES**
1. THIS DRAWING IS IN METRES UNLESS STATED OTHERWISE.
  2. TRENCHLESS CROSSINGS ARE INDICATIVE ONLY.

**LEGEND**

 [Red line]	ORDER LIMITS
[Green dashed line]	LIMITS OF DEVIATION
[Purple shaded area]	NARROW WORKING AREA (NW)
[Orange shaded area]	TRENCHLESS CROSSING (TC)
[Blue shaded area]	WATER BODIES
[Orange box]	ABOVE GROUND INSTALLATION (AGI) / VALVE (VA) / PRESSURE TRANSDUCER (PT)
[Hatched box]	COMPOUND (CO)
[Green circle]	TREE PRESERVATION ORDER (TPO)
[Circle with dot]	DESCRIPTION
[Circle with line]	ID or WORK NUMBER (if applicable)
[Blue circle]	COMMENCEMENT / TERMINATION OF WORKS (COMMENCEMENT = OPEN, TERMINATION = CLOSED)

Contains Ordnance Survey data © Crown copyright and database rights 2019.

© Crown copyright and database rights 2019 OS Licence Number AL10005237.



CD1	02/05/19	0000 SUBMISSION	PC	JA	SC	PH
Rev.	Rev. Date	Purpose of revision	Drawn	Checked	Rev'd	Approved

**JACOBS**  
1180 Epsom Road, Winchester, Hampshire, RG41 5TU  
Tel: +44(0)118 946 7000 • Fax: +44(0)118 946 7001  
www.jacobs.com

Client: Esso Petroleum Company, Limited  
Emryn House,  
Emryn Way,  
Leatherhead,  
Surrey,  
KT22 8UX



Project:  
**GENERAL ARRANGEMENT  
SHEET 17  
REGULATION 5 (2)(O)**


Drawing status: **Fit for Stage Approval**

Scale	1:2500	DO NOT SCALE
Jacobs No.	B2325300	Rev
Client no.	B2325300	Rev
Drawing number	B2325300-JAC-000-CIV-DRG-000527	Rev
		<b>C01</b>

© Copyright 2019 Jacobs Ltd. All rights reserved. This document and its contents are the confidential and proprietary information of Jacobs. Use or copying of this document in whole or in part without the written permission of Jacobs constitutes an infringement of copyright. Limitation: This drawing has been prepared on behalf of and for the exclusive use of Jacobs Client, and is subject to and issued in accordance with the provisions of the contract between Jacobs and the Client. Jacobs accepts no liability or responsibility whatsoever for its use in respect of any other use or reliance upon. This drawing is not valid without the written permission of Jacobs.

C:\pwworking\jacobs\_uk\_water\_utilities\_sas4\cheff\p\ms351188\2325300-JAC-000-CIV-DRG-000527.dwg - 03/05/2019 09:24:14 - A1Frame - CreateHP

**ENLARGED PLAN - PT**  
SCALE 1:500

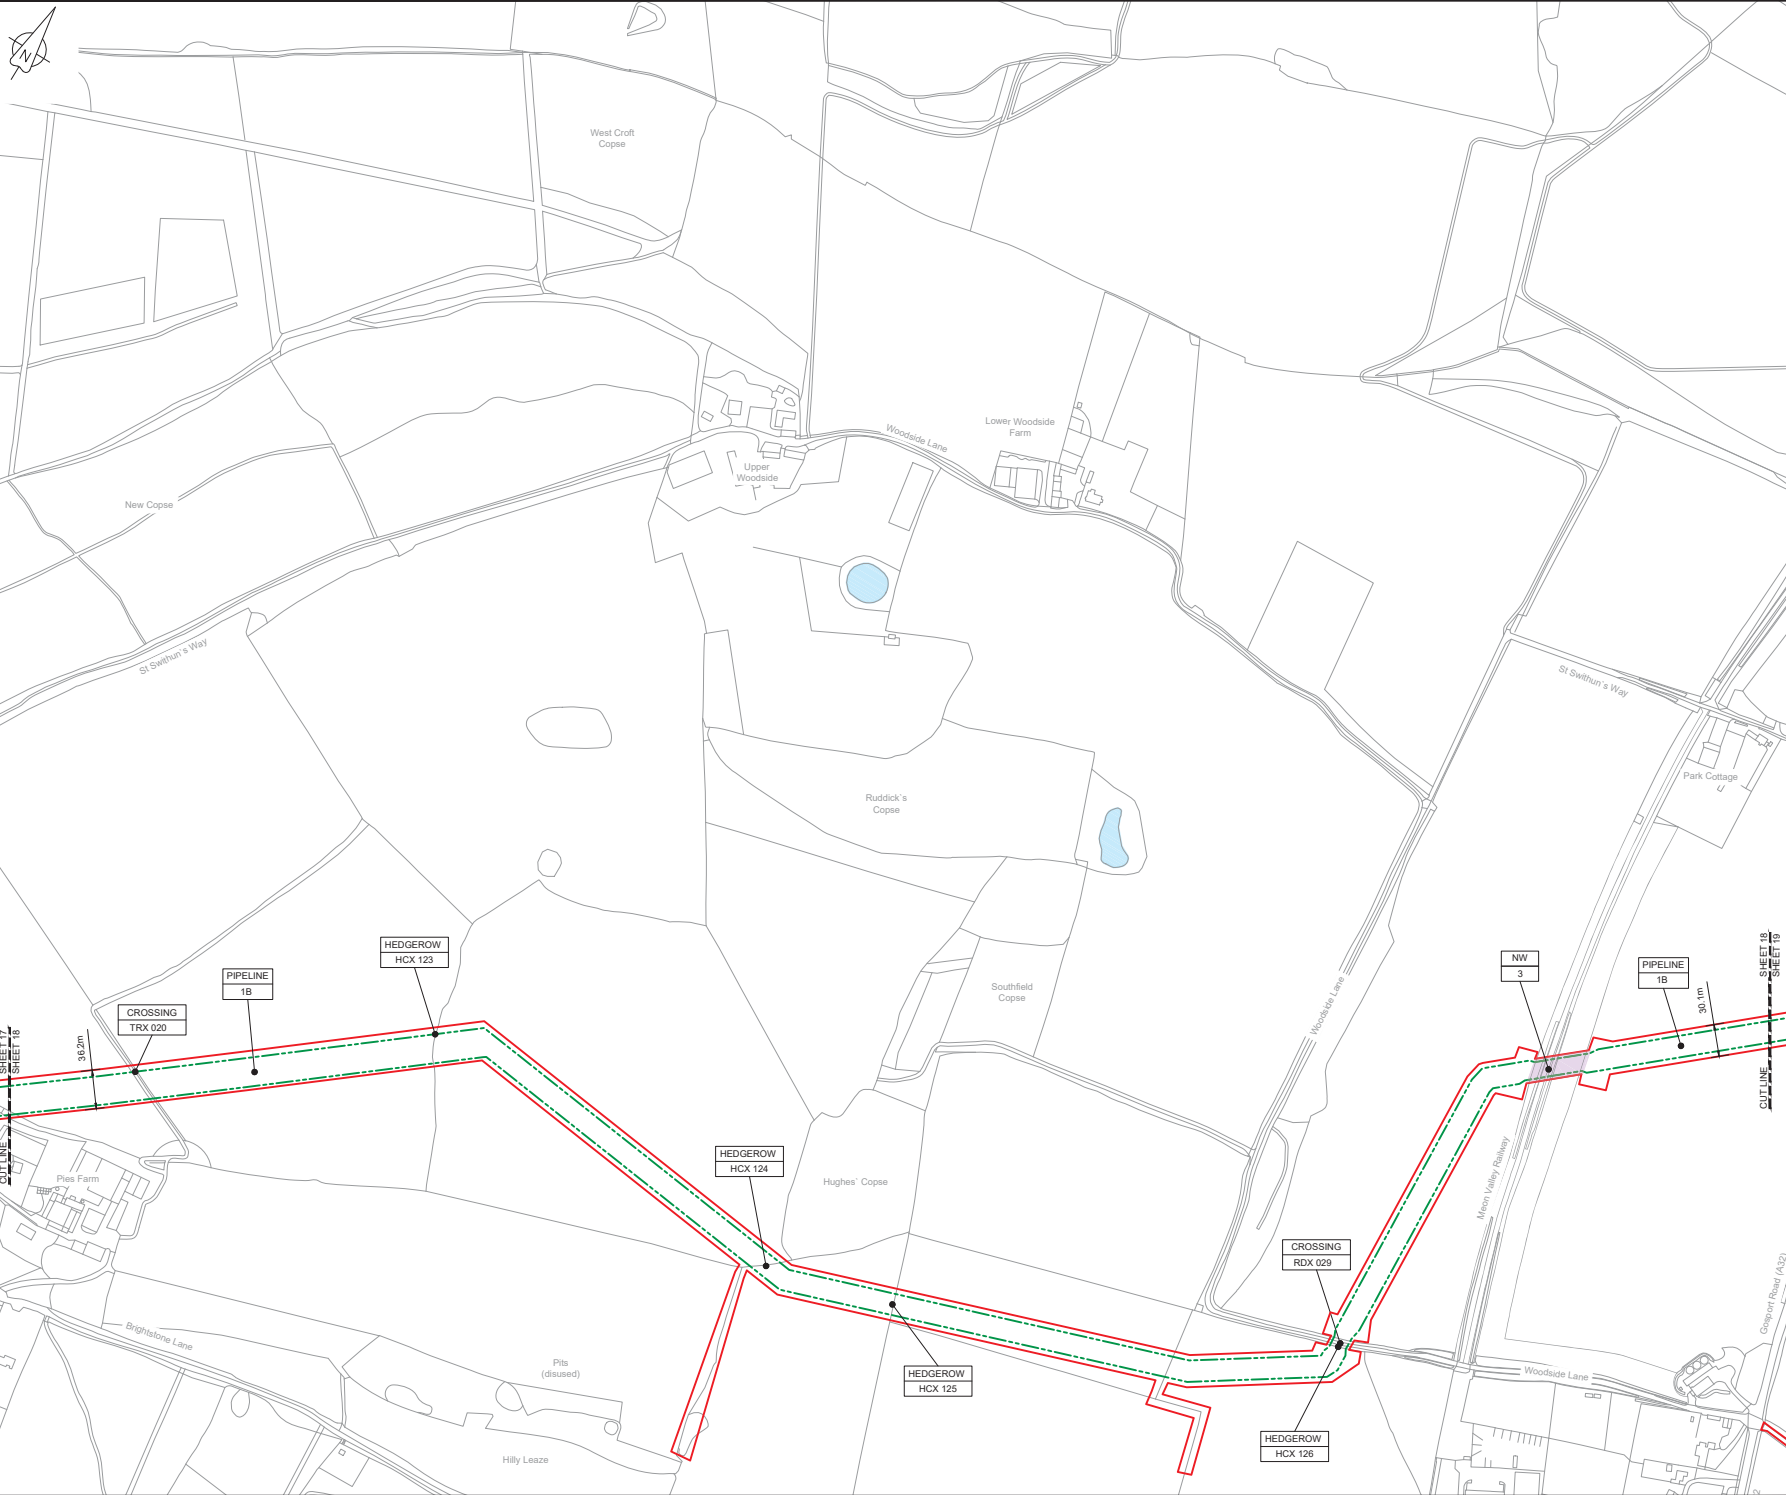

LOCATION PLAN  
SCALE 1:500,000

- NOTES**
1. THIS DRAWING IS IN METRES UNLESS STATED OTHERWISE.
  2. TRENCHLESS CROSSINGS ARE INDICATIVE ONLY.

**LEGEND**

 
- ORDER LIMITS
- - - LIMITS OF DEVIATION
- NARROW WORKING AREA (NW)
- TRENCHLESS CROSSING (TC)
- WATER BODIES
- ABOVE GROUND INSTALLATION (AGI) / VALVE (VA) / PRESSURE TRANSDUCER (PT)
- COMPOUND (CO)
- TREE PRESERVATION ORDER (TPO)

**DESCRIPTION**

- ID or WORK NUMBER (if applicable)
- COMMENCEMENT / TERMINATION OF WORKS (COMMENCEMENT = OPEN, TERMINATION = CLOSED)

Contains Ordnance Survey data © Crown copyright and database rights 2019.

© Crown copyright and database rights 2019 OS Licence Number AL100005237.



CD1	02/05/19	0000 SUBMISSION	PC	JA	SC	PH
Rev.	Rev. Date	Purpose of revision	Drawn	Checked	Rev'd	Approved



Client: Esso Petroleum Company, Limited  
Emryn House,  
Emryn Way,  
Leatherhead,  
Surrey,  
KT22 8UX




Project  
**GENERAL ARRANGEMENT  
SHEET 18  
REGULATION 5 (2)(O)**

Drawing title  
**Fit for Stage Approval**

Scale	1:2500	DO NOT SCALE
Jacobs No.	B2325300	Rev
Client no.		CO1

Drawing number  
**B2325300-JAC-000-CIV-DRG-000528**



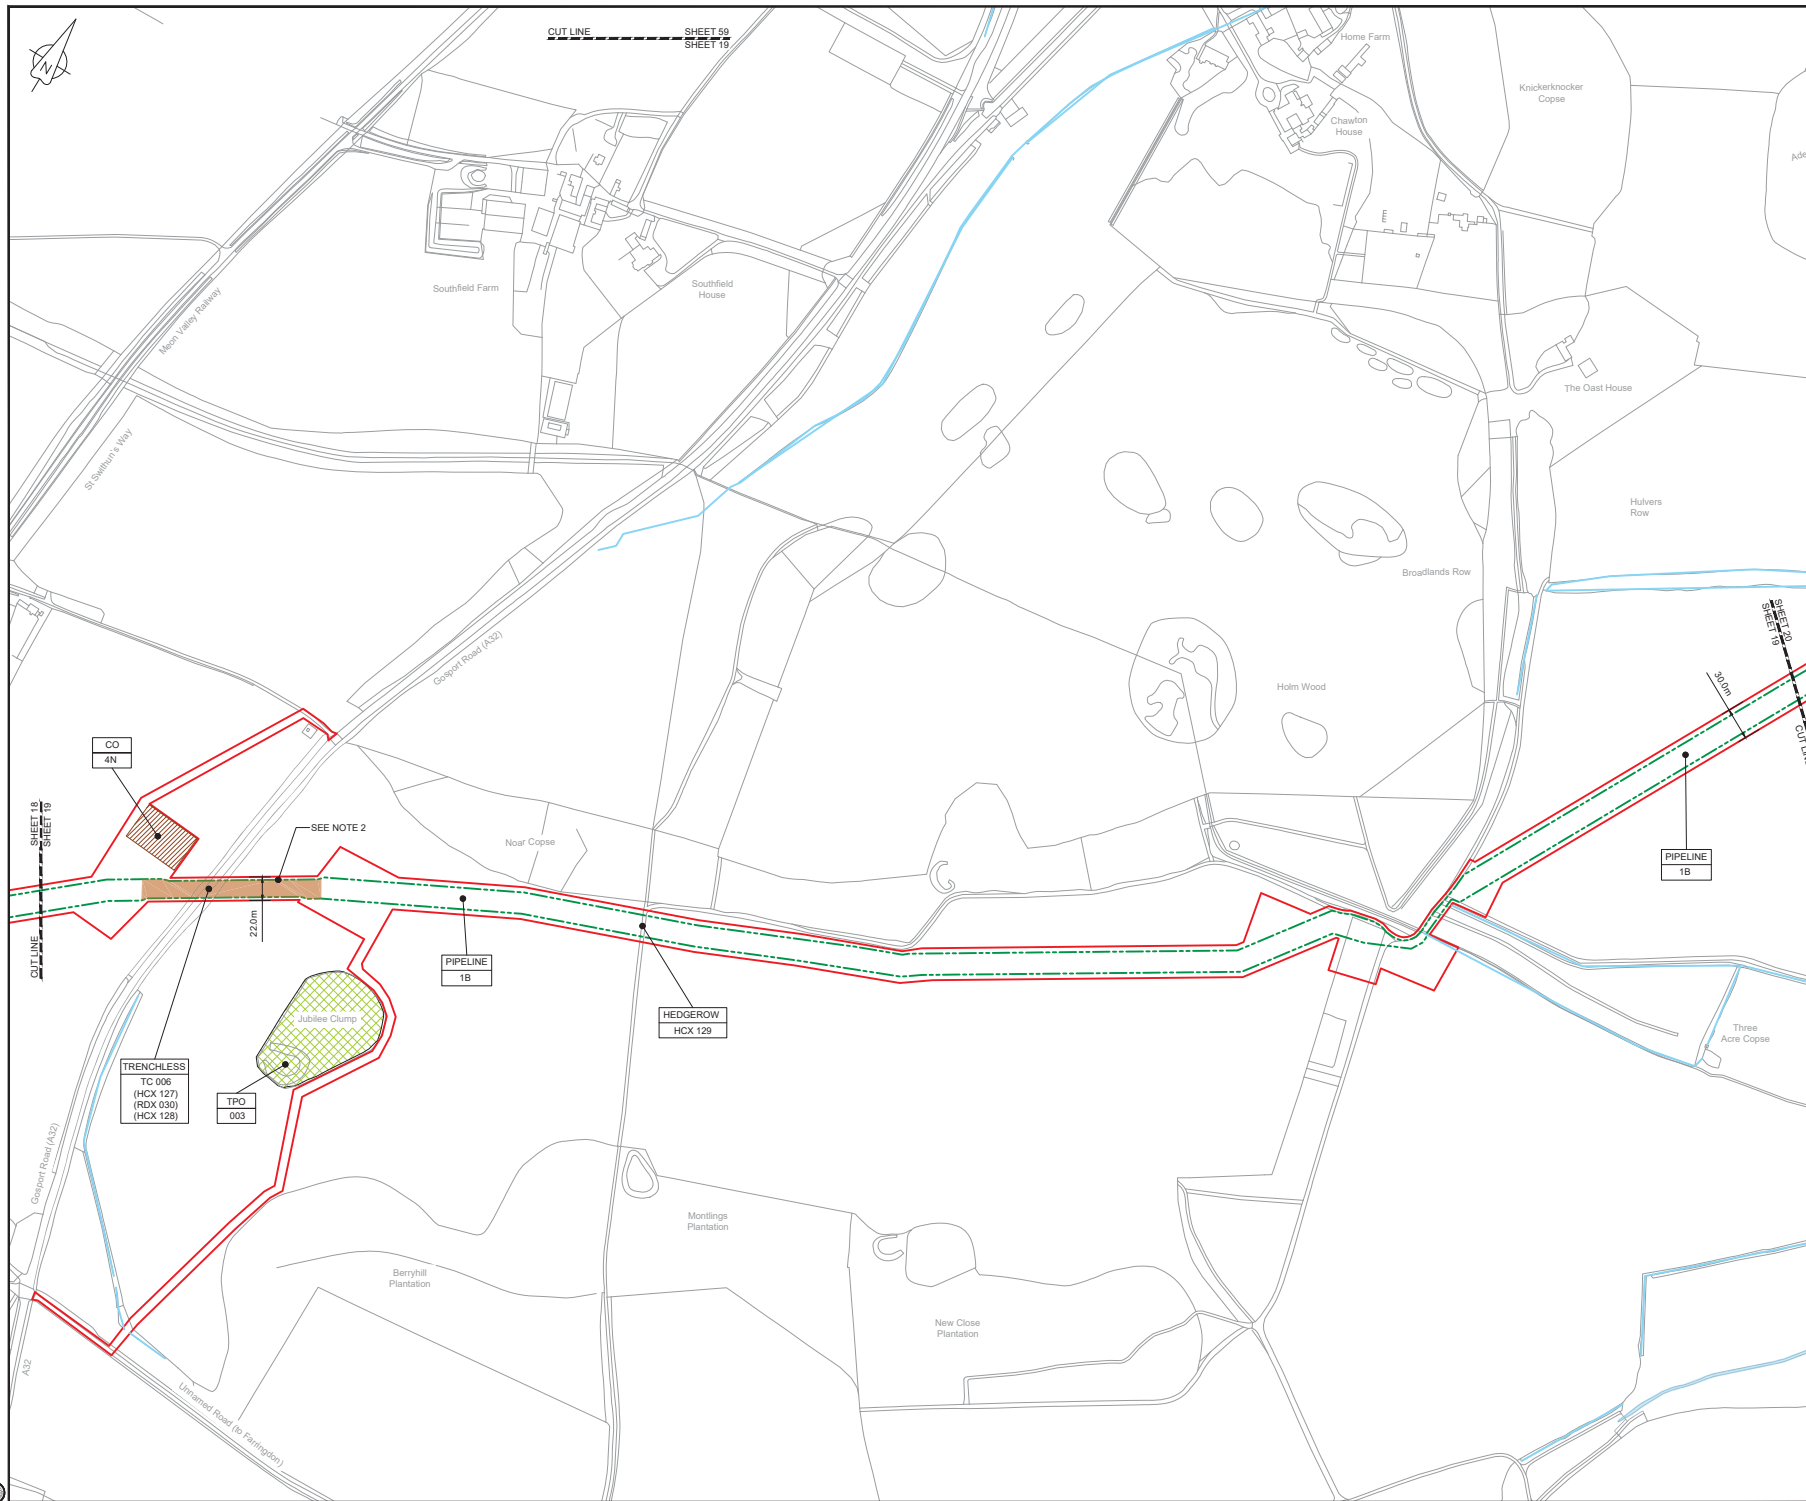

- NOTES**
1. THIS DRAWING IS IN METRES UNLESS STATED OTHERWISE.
  2. TRENCHLESS CROSSINGS ARE INDICATIVE ONLY.
- LEGEND**
- ORDER LIMITS
  - LIMITS OF DEVIATION
  - NARROW WORKING AREA (NW)
  - TRENCHLESS CROSSING (TC)
  - WATER BODIES
  - ABOVE GROUND INSTALLATION (AGI) / VALVE (VA) / PRESSURE TRANSDUCER (PT)
  - COMPOUND (CO)
  - TREE PRESERVATION ORDER (TPO)
  - DESCRIPTION
  - ID or WORK NUMBER (if applicable)
  - COMMENCEMENT / TERMINATION OF WORKS (COMMENCEMENT = OPEN, TERMINATION = CLOSED)

Contains Ordnance Survey data © Crown copyright and database rights 2019.

© Crown copyright and database rights 2019 OS Licence Number AL100005237.

0 50 100 150 200 250 m

SCALE 1:2500 @ A1

CD	02/05/19	0001 SUBMISSION	PC	JA	SC	PH
Rev.	Rev. Date	Purpose of revision	Drawn	Checked	Rev'd	Approved

**JACOBS**  
1180 Ewkside Road, Wokingham, Wokingham, RG41 5TU  
Tel: +44(0)118 946 7000 • Fax: +44(0)118 946 7001  
www.jacobs.com


Client: Esso Petroleum Company, Limited  
Ermyn House,  
Ermyn Way,  
Leatherhead,  
Surrey,  
KT22 8UX

Project: Southampton to London Pipeline Project

Drawing title: **GENERAL ARRANGEMENT SHEET 19 REGULATION 5 (2)(O)**

Drawing status: **Fit for Stage Approval**

Scale	1:2500	DO NOT SCALE
Jacobs No.	B2325300	Rev
Client no.		Rev
Drawing number	B2325300-JAC-000-CIV-DRG-000529	CO1

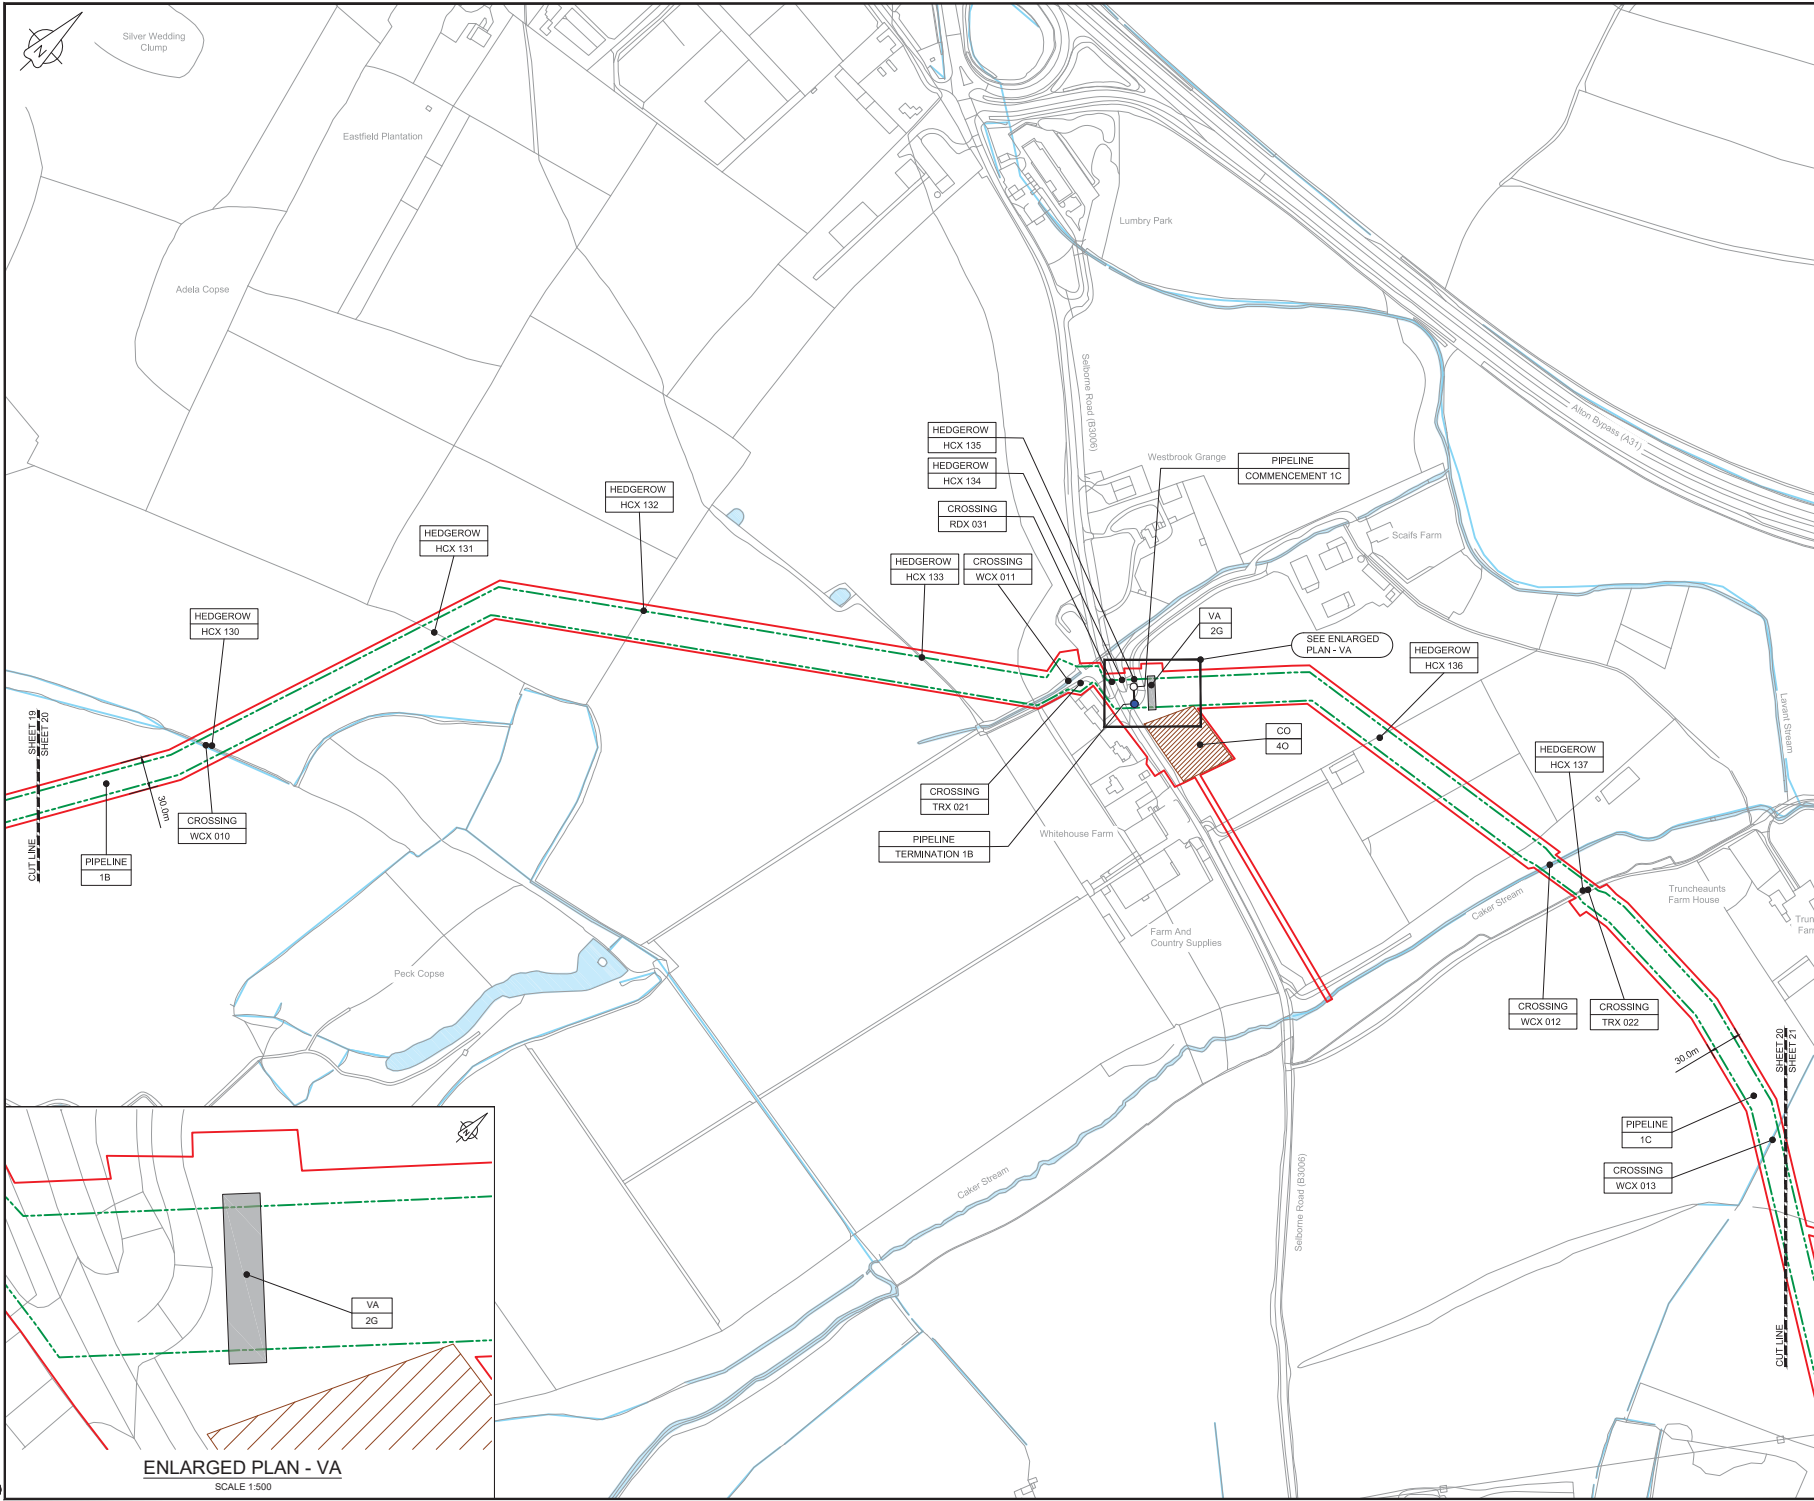


LOCATION PLAN  
SCALE 1:500,000

- NOTES**
- THIS DRAWING IS IN METRES UNLESS STATED OTHERWISE.
  - TRENCHLESS CROSSINGS ARE INDICATIVE ONLY.

- LEGEND**
- ORDER LIMITS
  - LIMITS OF DEVIATION
  - NARROW WORKING AREA (NW)
  - TRENCHLESS CROSSING (TC)
  - WATER BODIES
  - ABOVE GROUND INSTALLATION (AGI) / VALVE (VA) / PRESSURE TRANSDUCER (PT)
  - COMPOUND (CO)
  - TREE PRESERVATION ORDER (TPO)
  - DESCRIPTION
  - ID or WORK NUMBER (if applicable)
  - COMMENCEMENT / TERMINATION OF WORKS (COMMENCEMENT = OPEN, TERMINATION = CLOSED)

Contains Ordnance Survey data © Crown copyright and database rights 2019.

 © Crown copyright and database rights 2019 OS Licence Number AL10005237.



CSI	02/26/19	0000000000	PC	JA	SC	PH
Rev.	Rev. Date	Purpose of revision	Drawn	Checked	Rev'd	Approved



Client: Esso Petroleum Company, Limited  
Esso House,  
Esplanade,  
Leatherhead,  
Surrey,  
KT22 8UX



Drawing title  
**GENERAL ARRANGEMENT  
SHEET 20  
REGULATION 5 (2)(O)**

Drawing status: **Fit for Stage Approval**


Scale	1:2500	DO NOT SCALE
Jacobs No.	B2325300	Rev
Drawing number	C01	

Drawing number  
**B2325300-JAC-000-CIV-DRG-000530**

C:\pwworking\jacobs\_uk\_water\_utilities\_sas\tag\jms351932523000-JAC-000-CIV-DRG-000530.dwg - 03/05/2019 11:02:15 - A1Frame - Agial

**ENLARGED PLAN - VA**  
SCALE 1:500



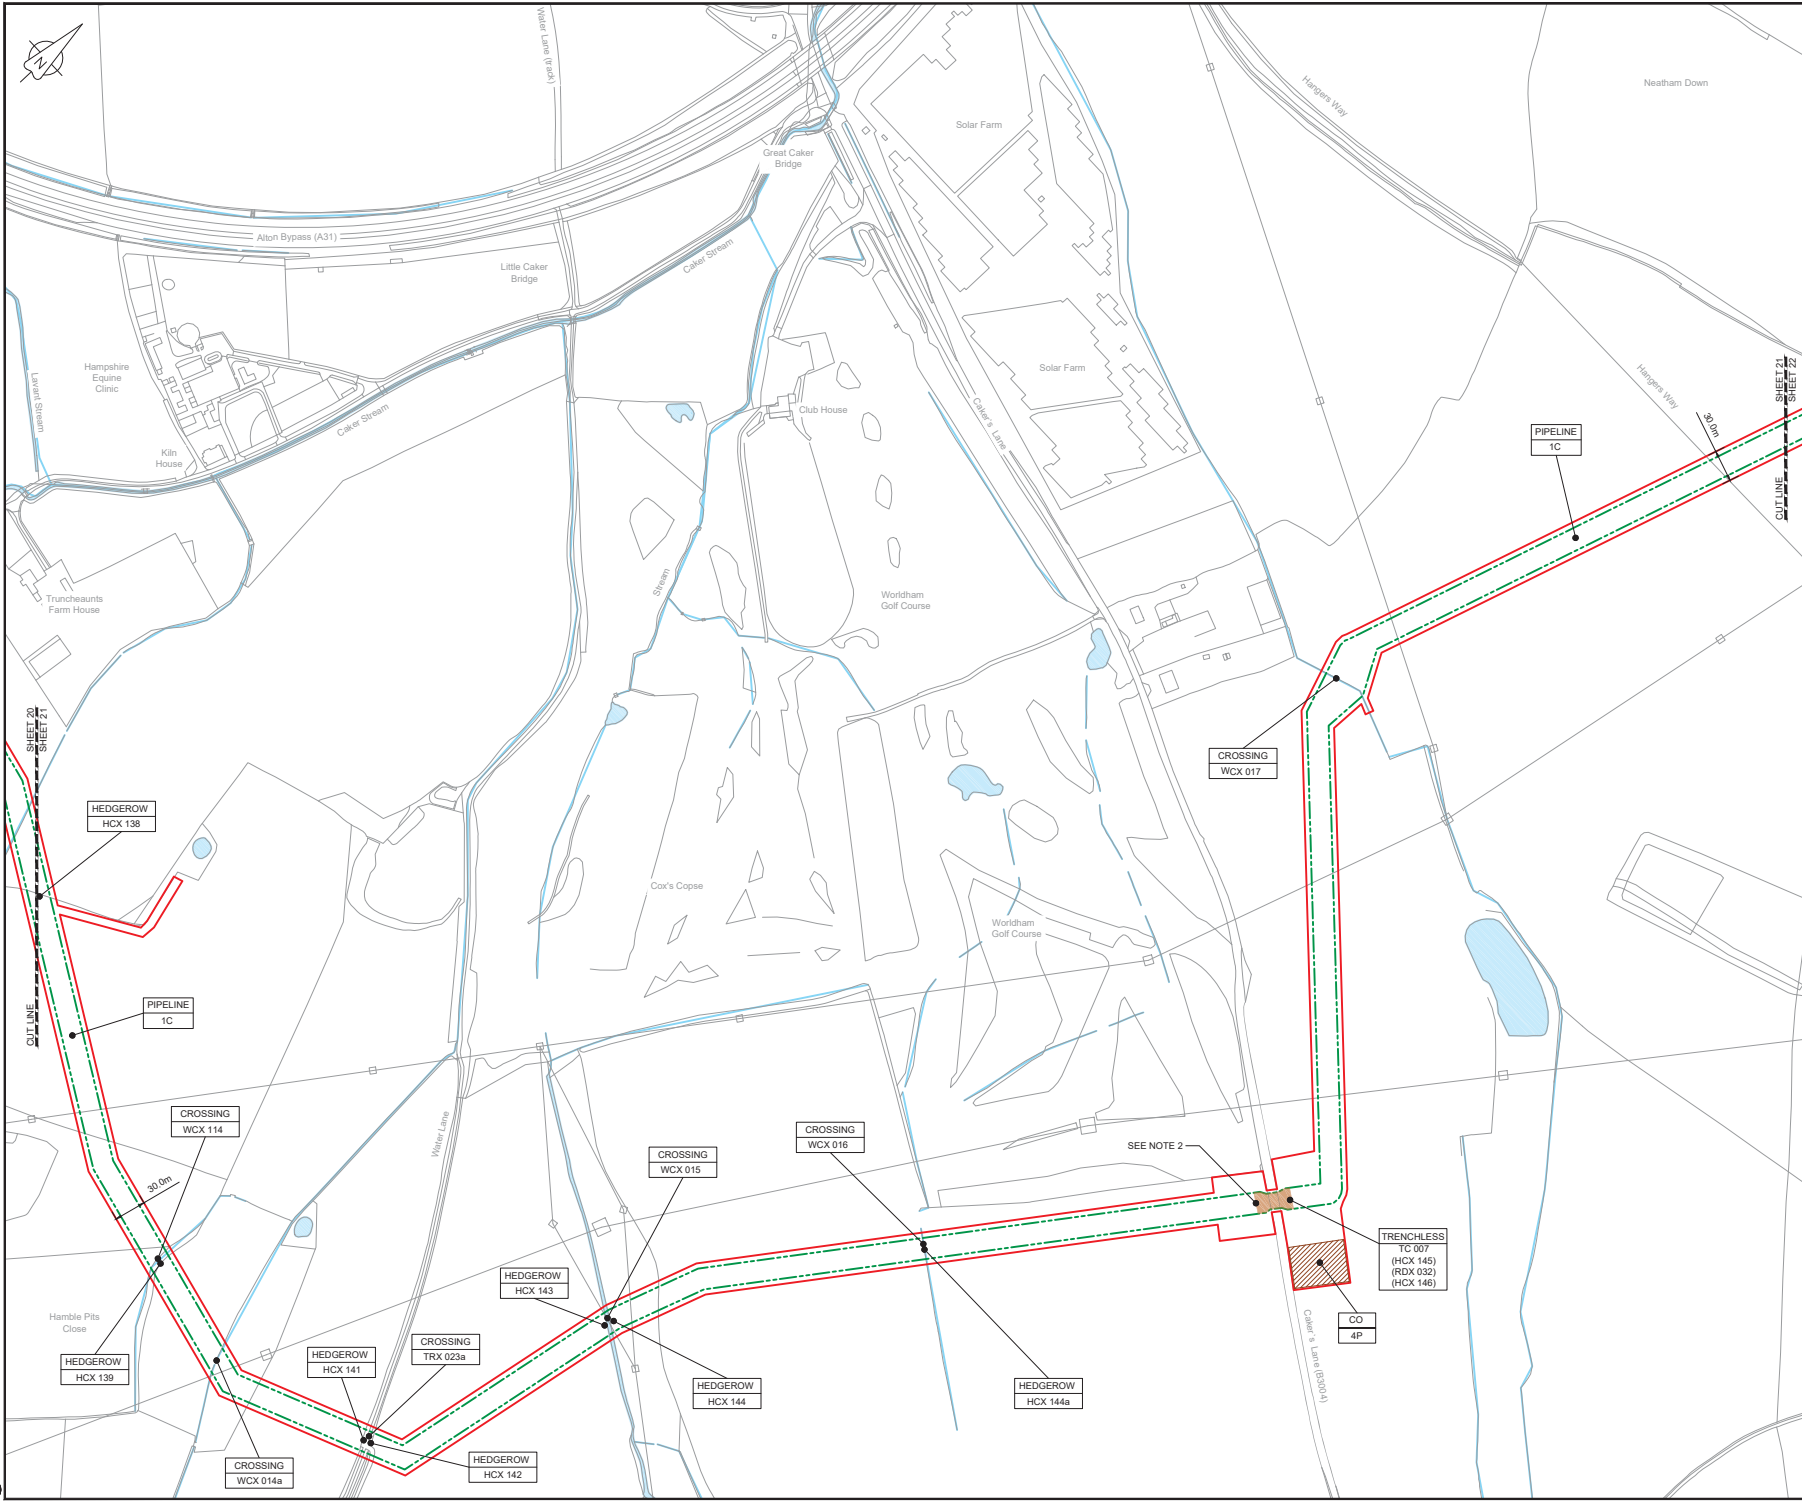

**NOTES**

- THIS DRAWING IS IN METRES UNLESS STATED OTHERWISE.
- TRENCHLESS CROSSINGS ARE INDICATIVE ONLY.

**LEGEND**

- ORDER LIMITS
- LIMITS OF DEVIATION
- NARROW WORKING AREA (NW)
- TRENCHLESS CROSSING (TC)
- WATER BODIES
- ABOVE GROUND INSTALLATION (AGI) / VALVE (VA) / PRESSURE TRANSDUCER (PT)
- COMPOUND (CO)
- TREE PRESERVATION ORDER (TPO)
- DESCRIPTION
- ID or WORK NUMBER (if applicable)
- COMMENCEMENT / TERMINATION OF WORKS (COMMENCEMENT = OPEN, TERMINATION = CLOSED)

Contains Ordnance Survey data © Crown copyright and database rights 2019.

© Crown copyright and database rights 2019 OS Licence Number AL10005237.

0 50 100 150 200 250 m

SCALE 1:2500 @ A1

Rev.	Rev. Date	Purpose of revision	PC	JA	SC	PH
C01	02/05/19	ISSUE FOR SUBMISSION				

**JACOBS**  
1180 Epsom Road, Winchester, Hampshire, RG41 5TU  
Tel: +44(0)118 946 7000 • Fax: +44(0)118 946 7001  
www.jacobs.com

Client: Esso Petroleum Company, Limited  
Emryn House,  
Emryn Way,  
Leatherhead,  
Surrey,  
KT22 8UX


Project: Southampton to London Pipeline Project

Drawing title:  
**GENERAL ARRANGEMENT SHEET 21**  
**REGULATION 5 (2)(O)**

Drawing status: **Fit for Stage Approval**

Scale	1:2500	DO NOT SCALE
Client No.	B2325300	Rev
Client no.		Rev
Drawing number	<b>B2325300-JAC-000-CIV-DRG-000531</b>	

C:\pwworking\jacobs\_uk\_water\_utilities\_sas4\cheff\pma3351188\2325300-JAC-000-CIV-DRG-000531.dwg - 03/05/2019 09:53:148 - A1Frame - CleanHP

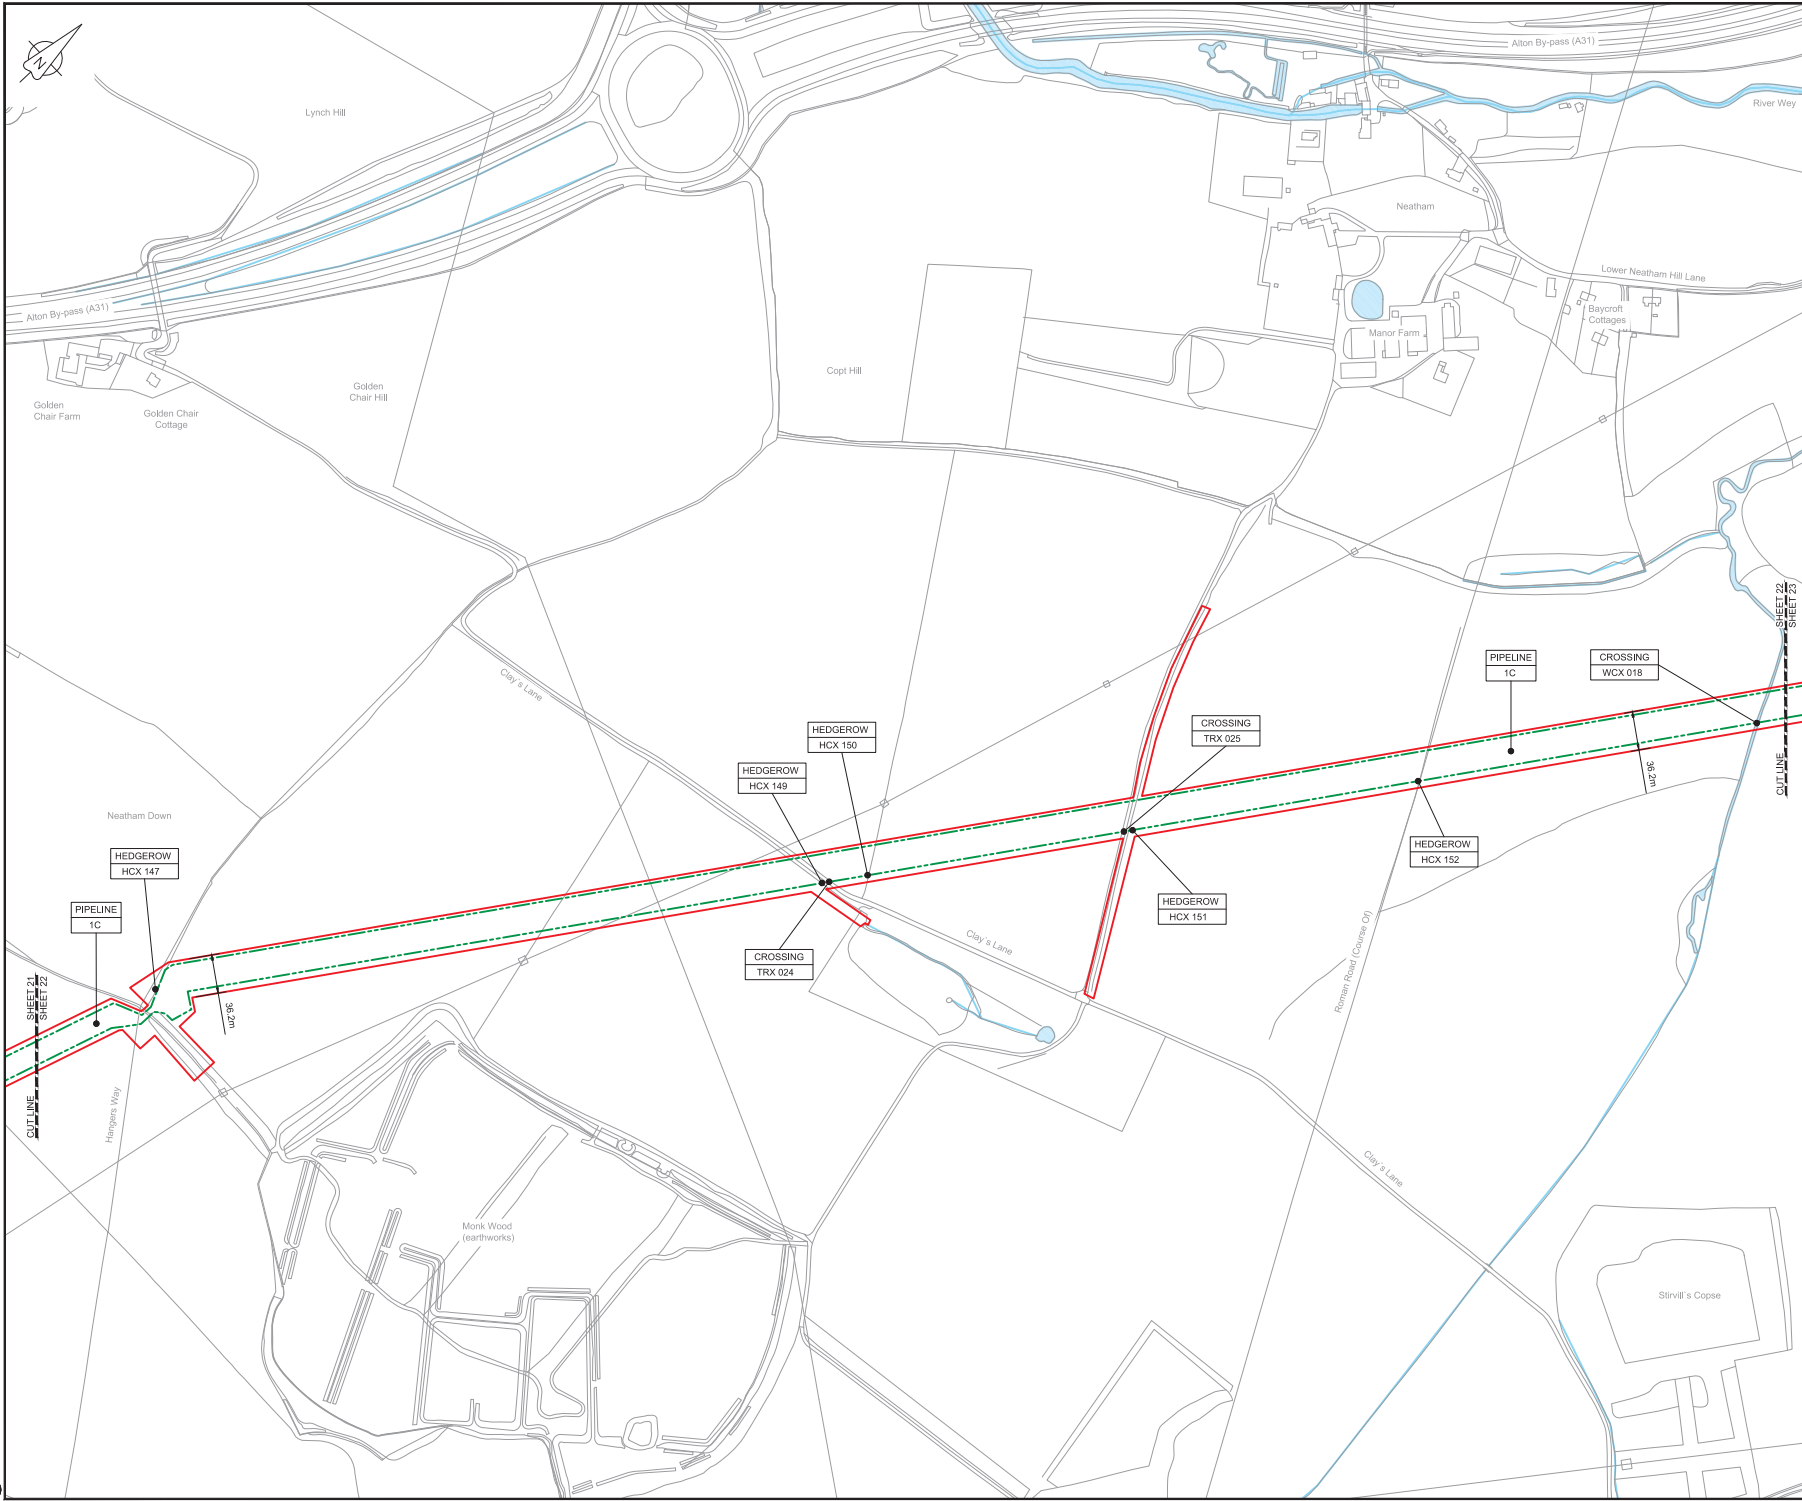

LOCATION PLAN  
SCALE 1:500,000

- NOTES**
- THIS DRAWING IS IN METRES UNLESS STATED OTHERWISE.
  - TRENCHLESS CROSSINGS ARE INDICATIVE ONLY.

**LEGEND**

	ORDER LIMITS
	LIMITS OF DEVIATION
	NARROW WORKING AREA (NW)
	TRENCHLESS CROSSING (TC)
	WATER BODIES
	ABOVE GROUND INSTALLATION (AGI) / VALVE (VA) / PRESSURE TRANSDUCER (PT)
	COMPOUND (CO)
	TREE PRESERVATION ORDER (TPO)
	DESCRIPTION
	ID or WORK NUMBER (if applicable)
	COMMENCEMENT / TERMINATION OF WORKS (COMMENCEMENT = OPEN, TERMINATION = CLOSED)

Contains Ordnance Survey data © Crown copyright and database rights 2019.  
© Crown copyright and database rights 2019 OS Licence Number AL100005237.



CSI	02/25/19	0001 SUBMISSION	PC	JA	SC	PH
Rev.	Rev. Date	Purpose of revision	Drawn	Checked	Rev'd	Approved



Client: Esso Petroleum Company, Limited  
Ermyn House,  
Ermyn Way,  
Leatherhead,  
Surrey,  
KT22 8UX




Project  
**GENERAL ARRANGEMENT  
SHEET 22  
REGULATION 5 (2)(O)**

Drawing title: Fit for Stage Approval

Scale	1:2500	DO NOT SCALE
Jacobs No.	B2325300	Rev
Client no.		C01

Drawing number: **B2325300-JAC-000-CIV-DRG-000532**

Use or copying of this document in whole or in part without the written permission of Jacobs constitutes an infringement of copyright. Limitation: This drawing has been prepared on behalf of and for the exclusive use of Jacobs Client, and is not to be used in accordance with the provisions of the contract between Jacobs and the Client. Jacobs accepts no liability or responsibility whatsoever for its use in respect of any other project or reference. This drawing is not valid without the signature of the Jacobs Engineer.

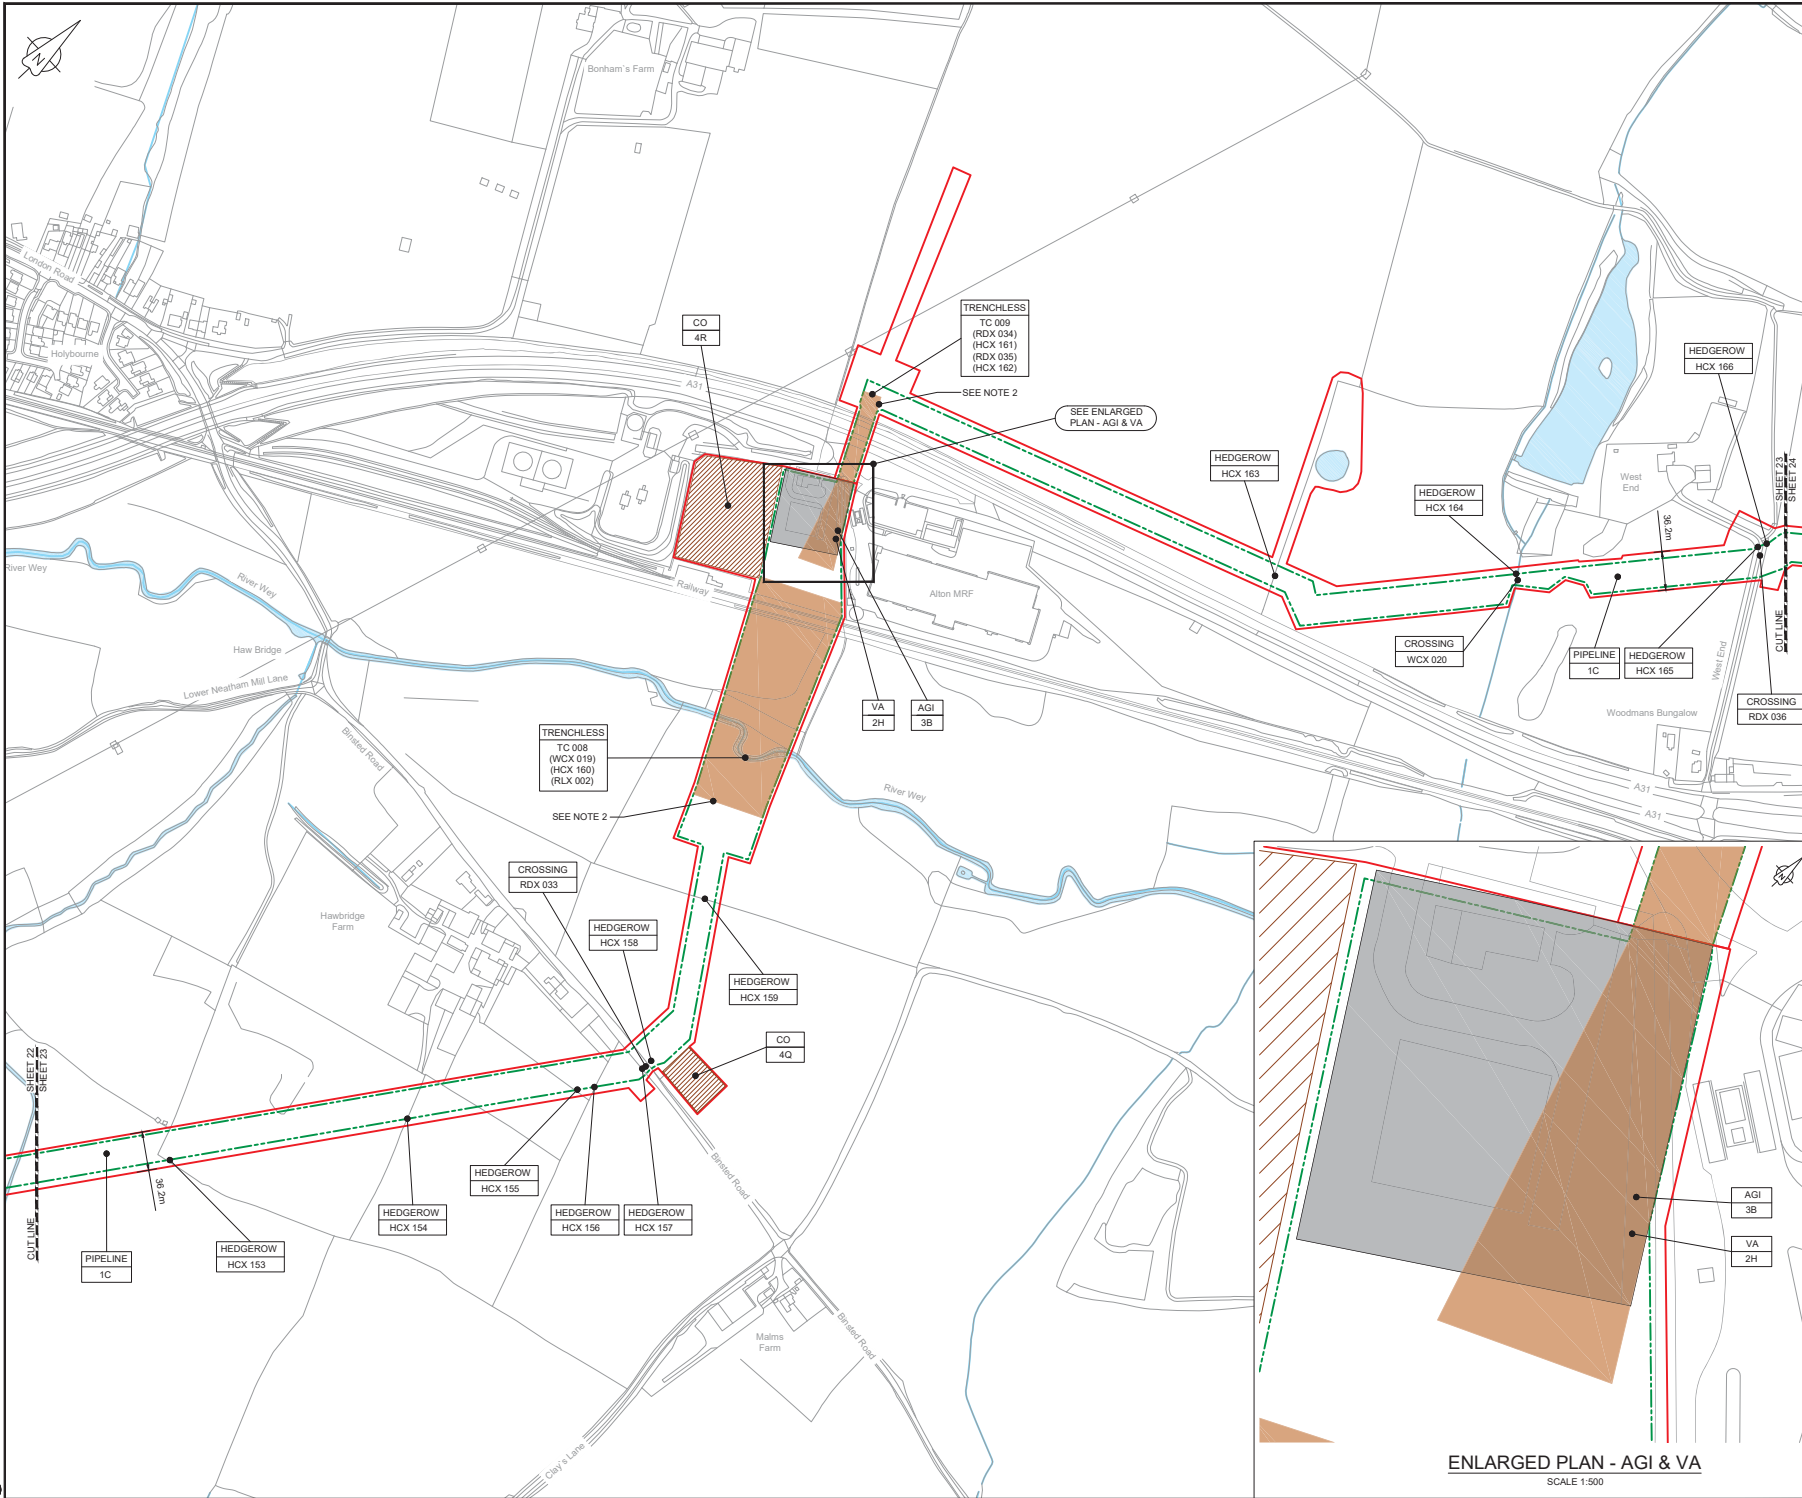


LOCATION PLAN  
SCALE 1:500,000

- NOTES**
1. THIS DRAWING IS IN METRES UNLESS STATED OTHERWISE.
  2. TRENCHLESS CROSSINGS ARE INDICATIVE ONLY.

- LEGEND**
- ORDER LIMITS
  - LIMITS OF DEVIATION
  - NARROW WORKING AREA (NW)
  - TRENCHLESS CROSSING (TC)
  - WATER BODIES
  - ABOVE GROUND INSTALLATION (AGI) / VALVE (VA) / PRESSURE TRANSDUCER (PT)
  - COMPOUND (CO)
  - TREE PRESERVATION ORDER (TPO)
  - DESCRIPTION
  - ID or WORK NUMBER (if applicable)
  - COMMENCEMENT / TERMINATION OF WORKS (COMMENCEMENT = OPEN, TERMINATION = CLOSED)

 Contains Ordnance Survey data © Crown copyright and database rights 2019.  
© Crown copyright and database rights 2019 OS Licence Number AL10005237.



CD	03/05/19	0001 SUBMISSION	PC	JA	SC	PH
Rev.	Rev. Date	Purpose of revision	Drawn	Checked	Rev'd	Approved

**JACOBS**  
1180 Epsom Road, Winchester, Wokingham, RG41 5TU  
Tel: +44(0)118 946 7000 • Fax: +44(0)118 946 7001  
www.jacobs.com

Client: Esso Petroleum Company, Limited  
Ermyn House,  
Ermyn Way,  
Leatherhead,  
Surrey,  
KT22 8UX

Project: Southampton to London Pipeline Project

Drawing title:  
**GENERAL ARRANGEMENT  
SHEET 23  
REGULATION 5 (2)(O)**

Drawing status: **Fit for Stage Approval**


Scale	1:2500	DO NOT SCALE
Jacobs No.	B2325300	Rev
Client no.		Rev
Drawing number		Rev

B2325300-JAC-000-CIV-DRG-000533

ENLARGED PLAN - AGI & VA  
SCALE 1:500

C:\pwworking\jacobs\_uk\_water\_utilities\_s44\byrdms\3513\B2325300-JAC-000-CIV-DRG-000533.dwg - 03/05/2019 10:52:56 - A1Frame - BTaylor



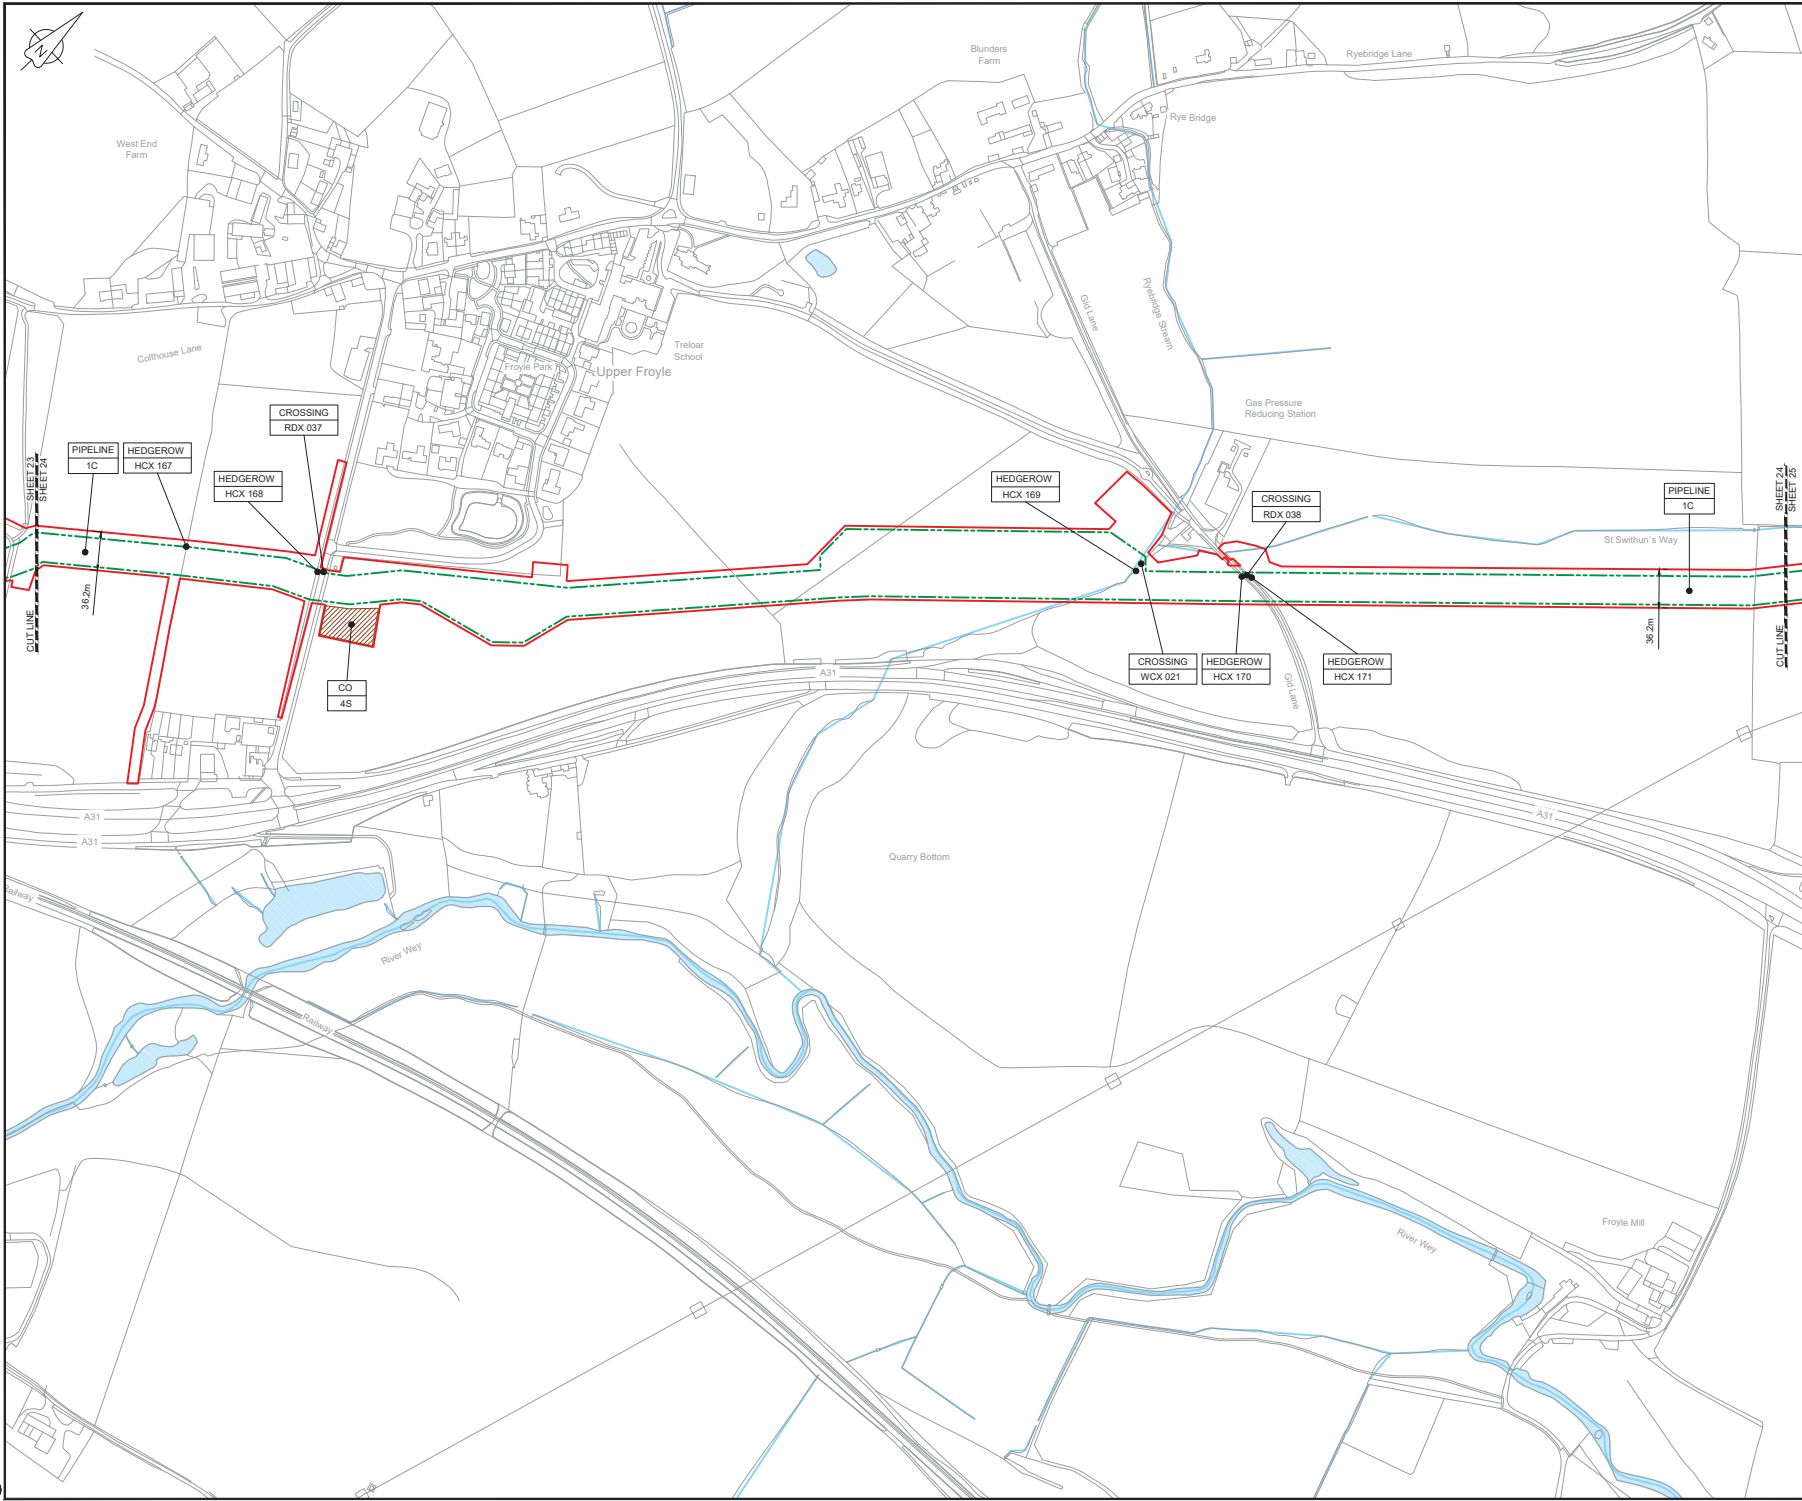


- NOTES**
1. THIS DRAWING IS IN METRES UNLESS STATED OTHERWISE.
  2. TRENCHLESS CROSSINGS ARE INDICATIVE ONLY.

- LEGEND**
- ORDER LIMITS
  - LIMITS OF DEVIATION
  - NARROW WORKING AREA (NW)
  - TRENCHLESS CROSSING (TC)
  - WATER BODIES
  - ABOVE GROUND INSTALLATION (AGI) / VALVE (VA) / PRESSURE TRANSDUCER (PT)
  - COMPOUND (CO)
  - TREE PRESERVATION ORDER (TPO)
  - DESCRIPTION
  - ID or WORK NUMBER (if applicable)
  - COMMENCEMENT / TERMINATION OF WORKS (COMMENCEMENT = OPEN, TERMINATION = CLOSED)

Contains Ordnance Survey data © Crown copyright and database rights 2019.

 © Crown copyright and database rights 2019 OS Licence Number AL100005237.



CD	03/05/19	0001	0001	PC	JA	SC	PH
Rev.	Rev. Date	Purpose of revision		Drawn	Checked	Rev'd	Approved

**JACOBS**  
1180 Ewbank Road, Winchester, Hampshire, RG41 5TU  
Tel: +44(0)118 946 7000 • Fax: +44(0)118 946 7001  
www.jacobs.com

Client: Esso Petroleum Company, Limited  
Emryn House,  
Emryn Way,  
Leatherhead,  
Surrey,  
KT22 8UX




Project  
**GENERAL ARRANGEMENT  
SHEET 24  
REGULATION 5 (2)(O)**

Drawing status: **Fit for Stage Approval**

Scale	1:2500	DO NOT SCALE
Jacobs No.	B2325300	Rev
Client no.	B2325300	Rev
Drawing number	C01	

Drawing number  
**B2325300-JAC-000-CIV-DRG-000534**

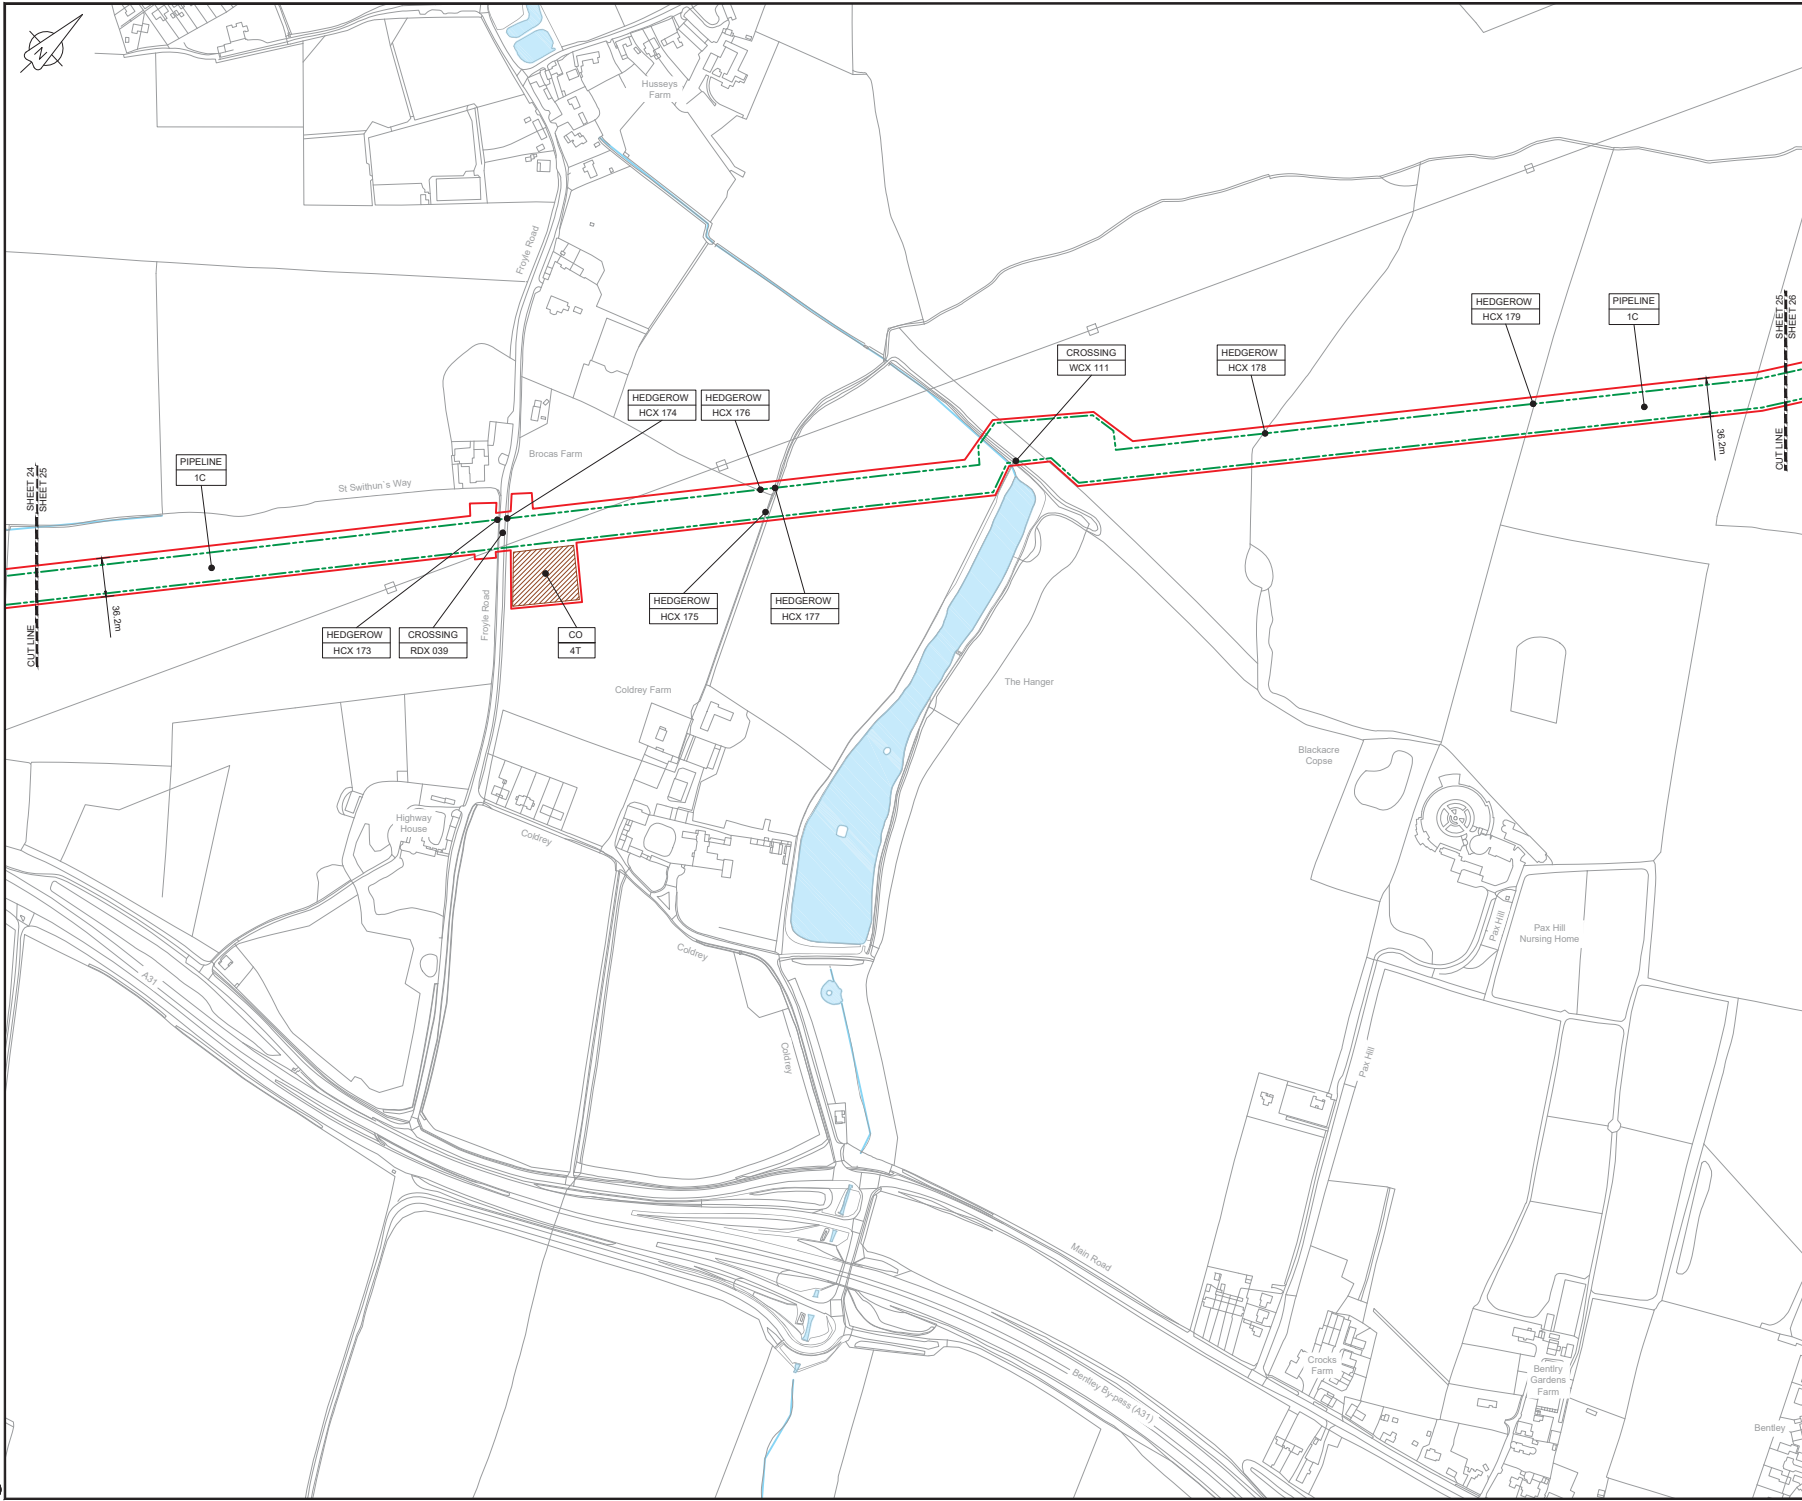

LOCATION PLAN  
SCALE 1:500,000

- NOTES**
1. THIS DRAWING IS IN METRES UNLESS STATED OTHERWISE.
  2. TRENCHLESS CROSSINGS ARE INDICATIVE ONLY.

- LEGEND**
- ORDER LIMITS
  - LIMITS OF DEVIATION
  - NARROW WORKING AREA (NW)
  - TRENCHLESS CROSSING (TC)
  - WATER BODIES
  - ABOVE GROUND INSTALLATION (AGI) / VALVE (VA) / PRESSURE TRANSDUCER (PT)
  - COMPOUND (CO)
  - TREE PRESERVATION ORDER (TPO)
  - DESCRIPTION
  - ID or WORK NUMBER (if applicable)
  - COMMENCEMENT / TERMINATION OF WORKS  
(COMMENCEMENT = OPEN, TERMINATION = CLOSED)

Contains Ordnance Survey data © Crown copyright and database rights 2019.  
© Crown copyright and database rights 2019 OS Licence Number AL10005237.



CDI	03/05/19	DDC SUBMISSION	PC	JA	SC	PH
Rev.	Rev. Date	Purpose of revision	Drawn	Checked	Rev'd	Approved

**JACOBS**  
1180 Epsom Road, Winchester, Wokingham, RG41 5TU  
Tel: +44(0)118 945 7000 • Fax: +44(0)118 945 7001  
www.jacobs.com

Client: Esso Petroleum Company, Limited  
Emlyn Way,  
Leatherhead,  
Surrey,  
KT22 8UX

Project: Southampton to London Pipeline Project


Drawing title:  
**GENERAL ARRANGEMENT  
SHEET 25  
REGULATION 5 (2)(O)**

Drawing status: **Fit for Stage Approval**

Scale	1:2500	DO NOT SCALE
Jacobs No.	B2325300	Rev
Client no.		<b>CO1</b>

Drawing number: **B2325300-JAC-000-CIV-DRG-000535**

C:\pwworking\jacobs\_uk\_water\utilities\_southampton\3551382325300\_JAC-000-CIV-DRG-000535.dwg - 03/05/2019 10:58:14 - A1Frame - BTaylor

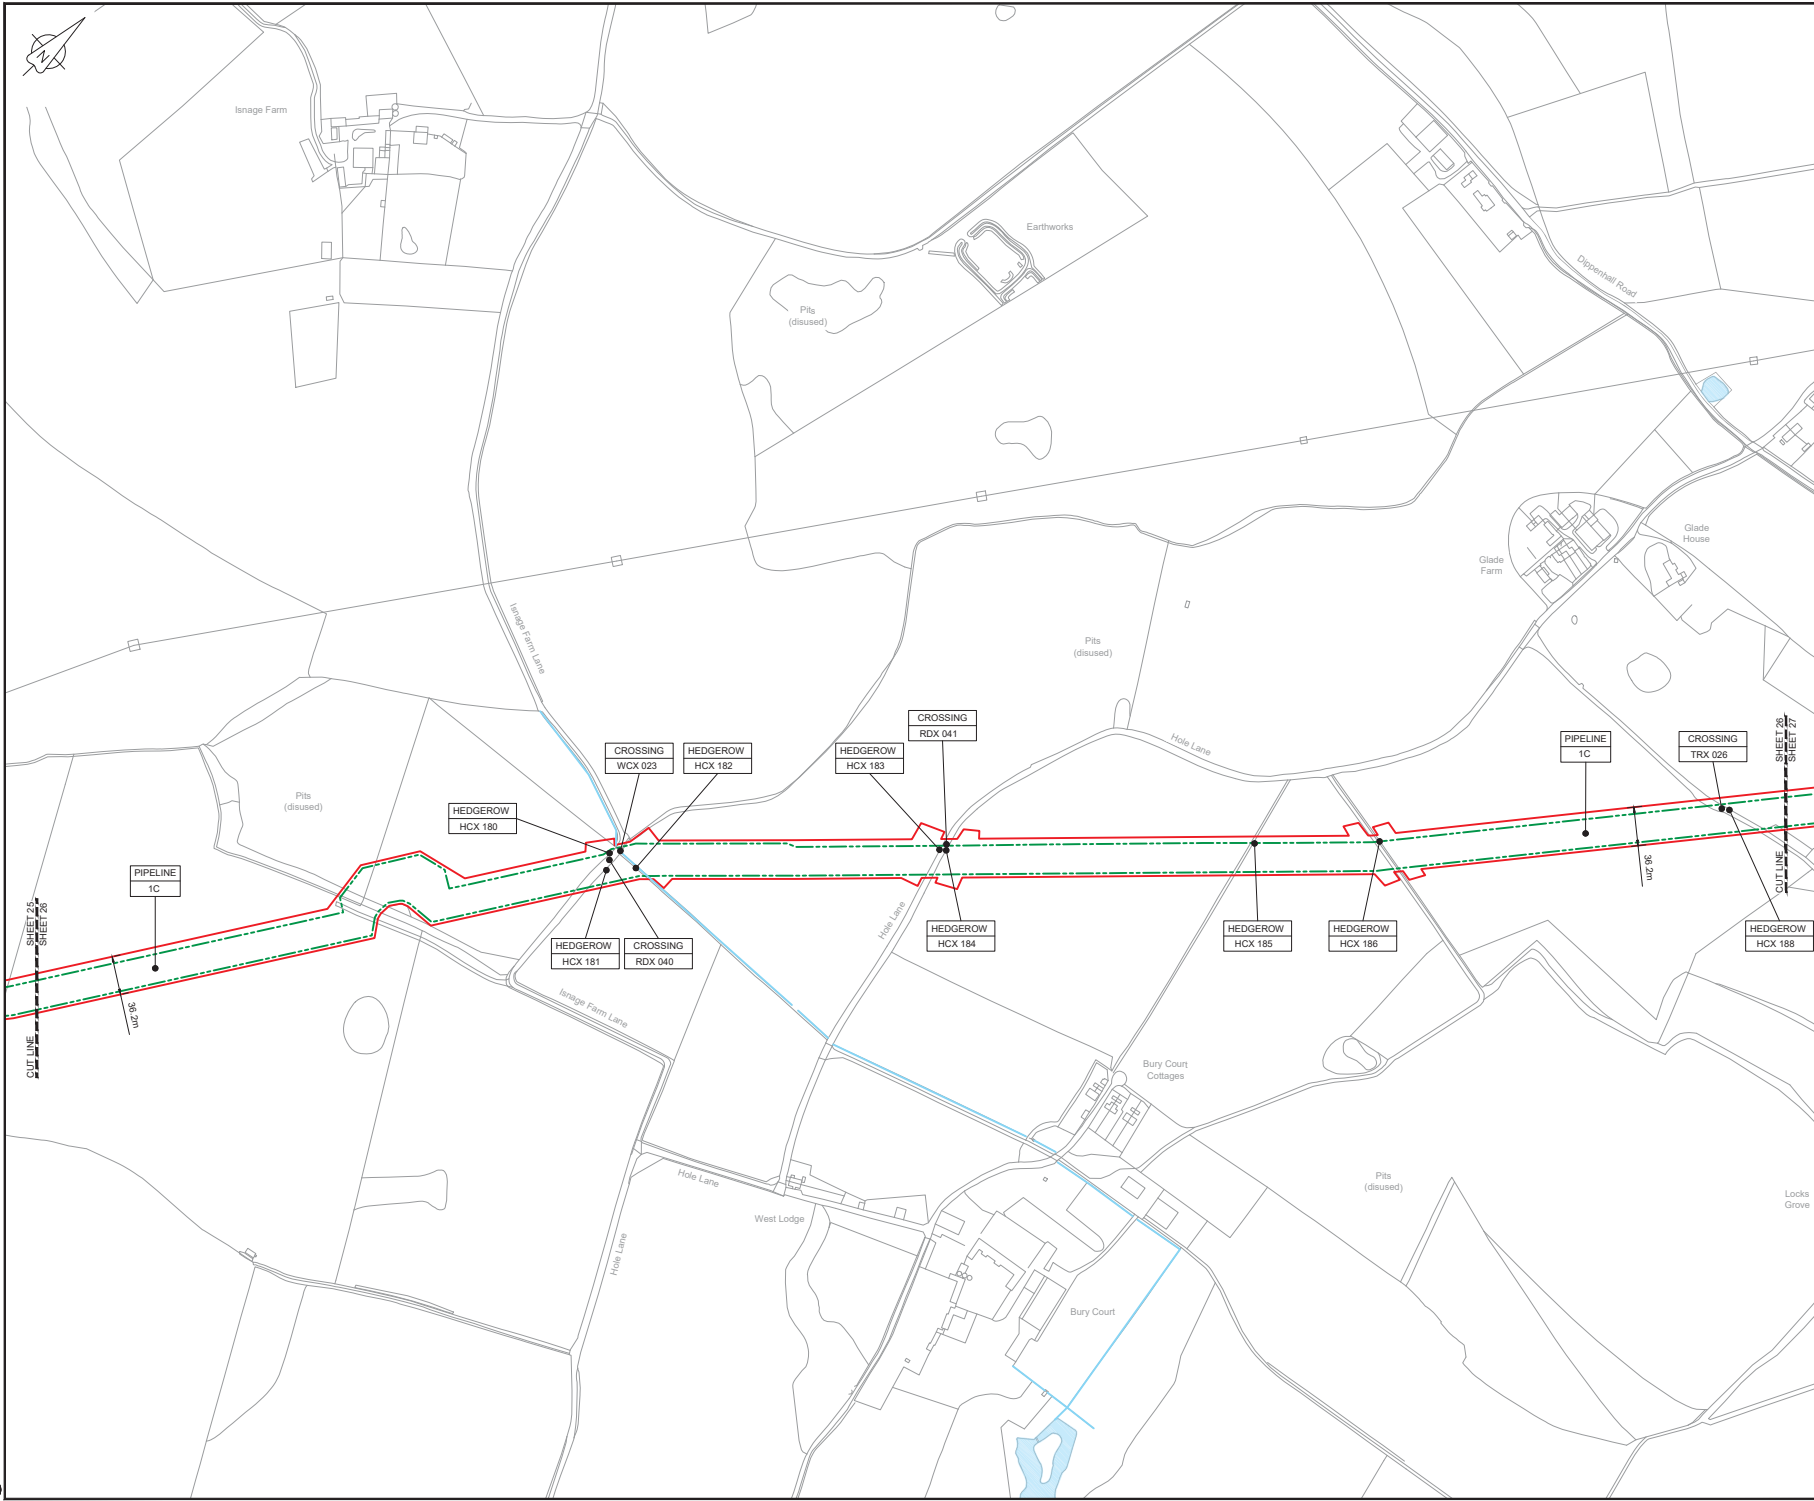


LOCATION PLAN  
SCALE 1:500,000

- NOTES**
1. THIS DRAWING IS IN METRES UNLESS STATED OTHERWISE.
  2. TRENCHLESS CROSSINGS ARE INDICATIVE ONLY.

- LEGEND**
- ORDER LIMITS
  - LIMITS OF DEVIATION
  - NARROW WORKING AREA (NW)
  - TRENCHLESS CROSSING (TC)
  - WATER BODIES
  - ABOVE GROUND INSTALLATION (AGI) / VALVE (VA) / PRESSURE TRANSDUCER (PT)
  - COMPOUND (CO)
  - TREE PRESERVATION ORDER (TPO)
  - DESCRIPTION
  - ID or WORK NUMBER (if applicable)
  - COMMENCEMENT / TERMINATION OF WORKS (COMMENCEMENT = OPEN, TERMINATION = CLOSED)

 Contains Ordnance Survey data © Crown copyright and database rights 2019.  
© Crown copyright and database rights 2019 OS Licence Number AL10005237.



CSI	03/05/19	DESCRIPTION	PC	JA	SC	PH
Rev.	Rev. Date	Purpose of revision	Drawn	Checked	Rev'd	Approved

**JACOBS**  
1180 Ewkside Road, Wokingham, Wokingham, RG41 5TU  
Tel: +44(0)118 946 7000 • Fax: +44(0)118 946 7001  
www.jacobs.com

Client: Esso Petroleum Company, Limited  
Ermyn House,  
Ermyn Way,  
Leatherhead,  
Surrey,  
KT22 8UX

Project: Southampton to London Pipeline Project

Drawing title:  
**GENERAL ARRANGEMENT  
SHEET 26  
REGULATION 5 (2)(O)**


Drawing status: **Fit for Stage Approval**

Scale	1:2500	DO NOT SCALE
Jacobs No.	B2325300	Rev
Client no.		Rev
Drawing number		<b>C01</b>

B2325300-JAC-000-CIV-DRG-000536

© Copyright 2019 Jacobs U.K. Limited. This document and all information contained herein are the property of Jacobs U.K. Limited. This drawing has been prepared on behalf of and for the exclusive use of Jacobs Client, and is not to be used in accordance with the provisions of the contract between Jacobs and the Client. Jacobs accepts no liability or responsibility whatsoever for its use in respect of any other use or reliance upon. This drawing is not valid without the signature of the author.



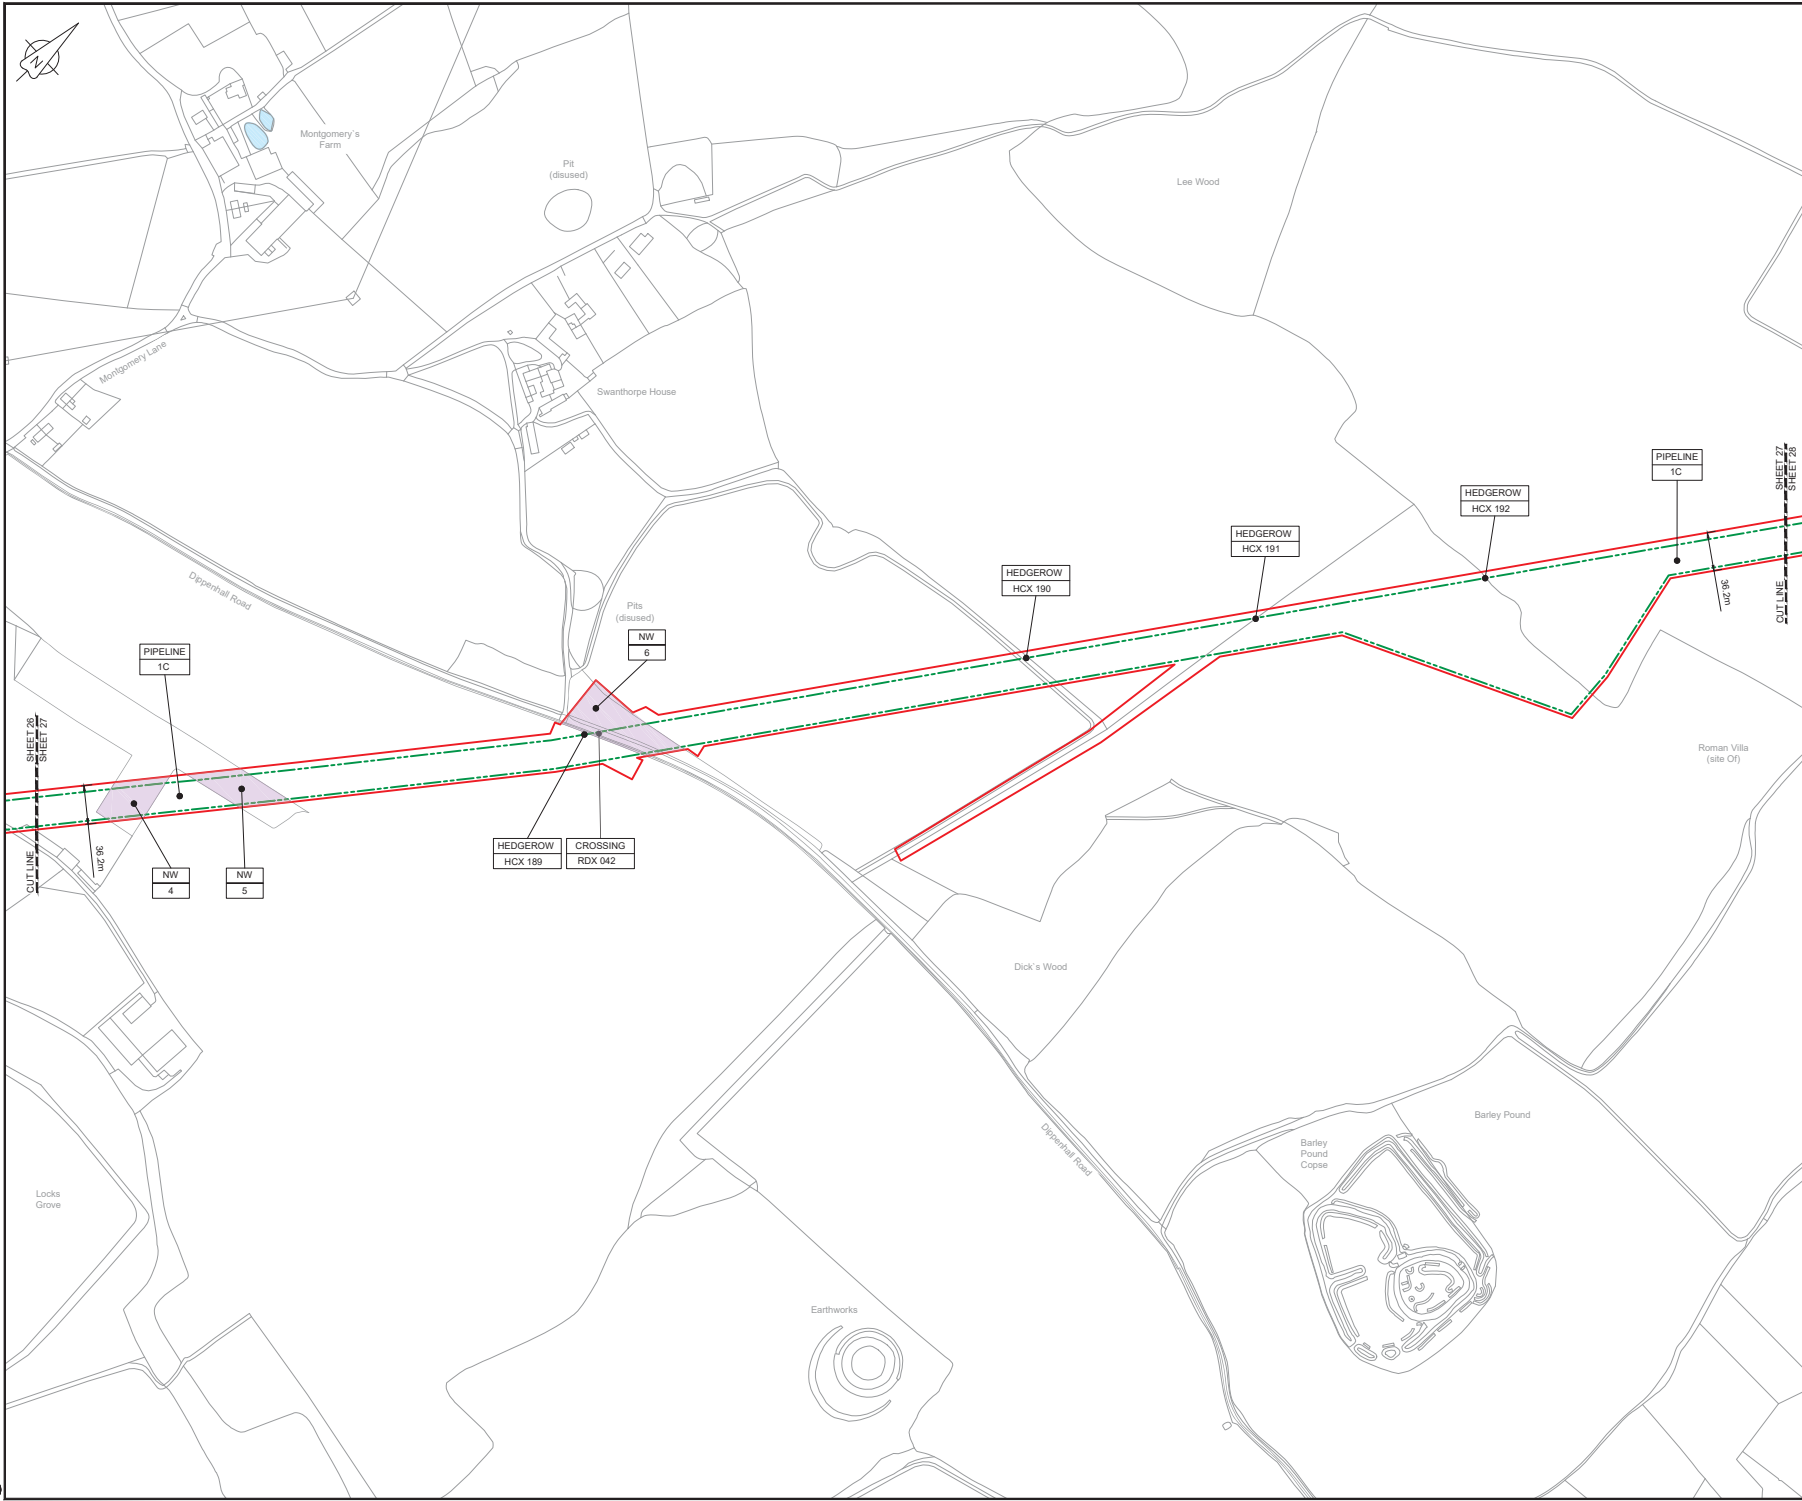

LOCATION PLAN  
SCALE 1:500,000

- NOTES**
1. THIS DRAWING IS IN METRES UNLESS STATED OTHERWISE.
  2. TRENCHLESS CROSSINGS ARE INDICATIVE ONLY.

- LEGEND**
- ORDER LIMITS
  - LIMITS OF DEVIATION
  - NARROW WORKING AREA (NW)
  - TRENCHLESS CROSSING (TC)
  - WATER BODIES
  - ABOVE GROUND INSTALLATION (AGI) / VALVE (VA) / PRESSURE TRANSDUCER (PT)
  - COMPOUND (CO)
  - TREE PRESERVATION ORDER (TPO)
  - DESCRIPTION
  - ID or WORK NUMBER (if applicable)
  - COMMENCEMENT / TERMINATION OF WORKS (COMMENCEMENT = OPEN, TERMINATION = CLOSED)

Contains Ordnance Survey data © Crown copyright and database rights 2019.

© Crown copyright and database rights 2019 OS Licence Number AL100005237.



CD1	03/05/19	0000 SUBMISSION	PC	JA	SC	PH
Rev.	Rev. Date	Purpose of revision	Drawn	Checked	Rev'd	Approved

**JACOBS**  
1180 Ewings Road, Winchester, Hampshire, RG41 5TU  
Tel: +44(0)118 946 7000 • Fax: +44(0)118 946 7001  
www.jacobs.com

Client: Esso Petroleum Company, Limited  
Emryn House,  
Emryn Way,  
Leatherhead,  
Surrey,  
KT22 8UX

Project: Southampton to London Pipeline Project


Drawing title:  
**GENERAL ARRANGEMENT  
SHEET 27  
REGULATION 5 (2)(O)**

Drawing status: **Fit for Stage Approval**

Scale	1:2500	DO NOT SCALE
Jacobs No.	B2325300	Rev
Client no.		<b>CO1</b>

Drawing number:  
**B2325300-JAC-000-CIV-DRG-000537**

C:\pwworking\jacobs\_uk\_water\_utilities\_sas4\bjayor\dms\B2325300-JAC-000-CIV-DRG-000537.dwg - 03/05/2019 11:02:44 - A1Frame - B1aylor

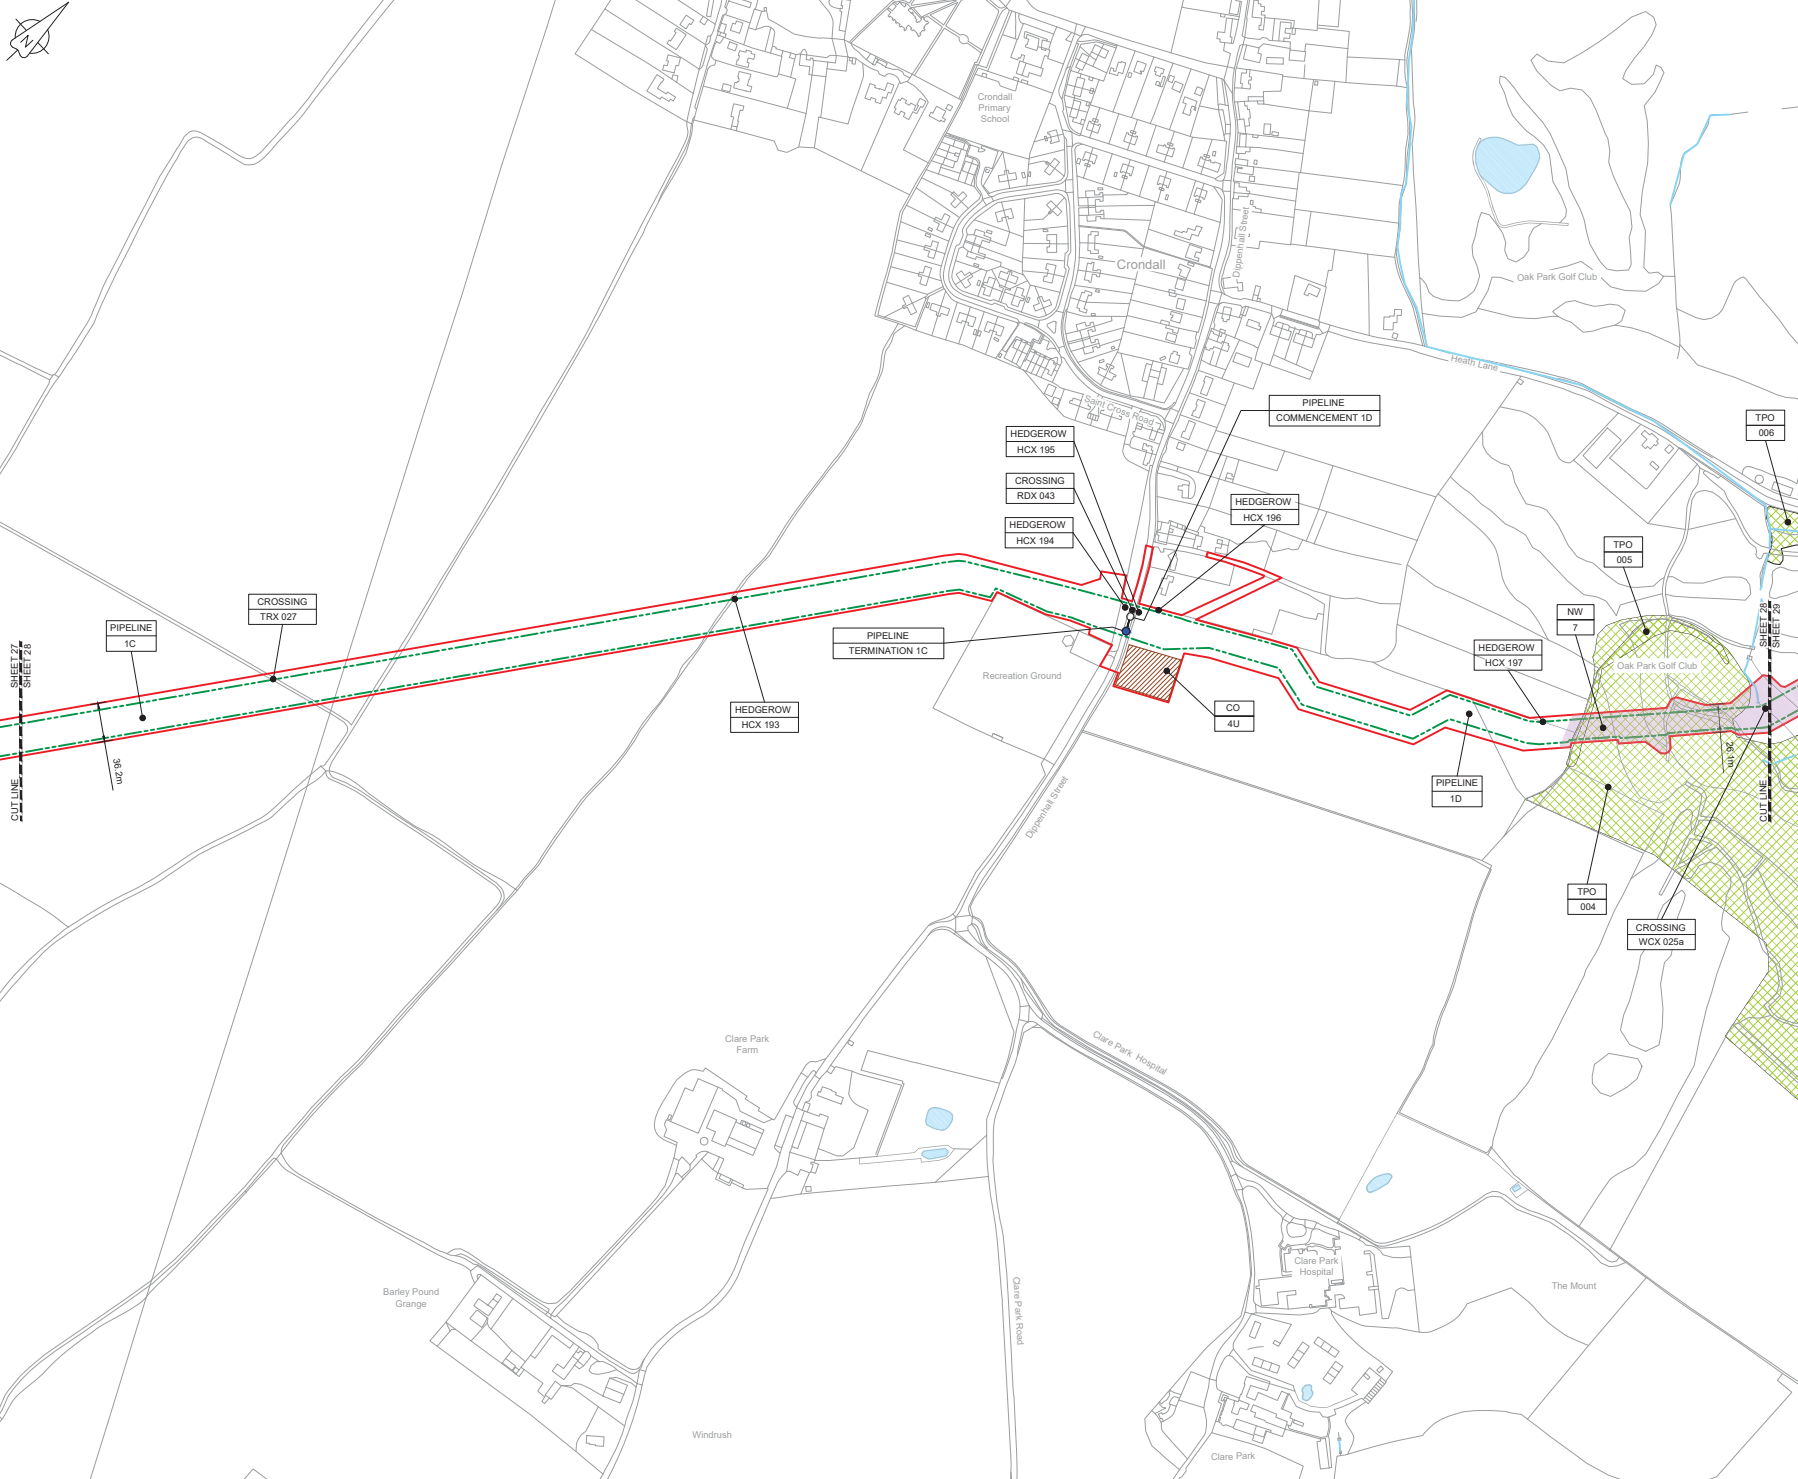


LOCATION PLAN  
SCALE 1:500,000

- NOTES**
1. THIS DRAWING IS IN METRES UNLESS STATED OTHERWISE.
  2. TRENCHLESS CROSSINGS ARE INDICATIVE ONLY.

- LEGEND**
- ORDER LIMITS
  - LIMITS OF DEVIATION
  - NARROW WORKING AREA (NW)
  - TRENCHLESS CROSSING (TC)
  - WATER BODIES
  - ABOVE GROUND INSTALLATION (AGI) / VALVE (VA) / PRESSURE TRANSDUCER (PT)
  - COMPOUND (CO)
  - TREE PRESERVATION ORDER (TPO)
  - DESCRIPTION
  - ID or WORK NUMBER (if applicable)
  - COMMENCEMENT / TERMINATION OF WORKS (COMMENCEMENT = OPEN, TERMINATION = CLOSED)

Contains Ordnance Survey data © Crown copyright and database rights 2019.

 © Crown copyright and database rights 2019 OS Licence Number AL100005237.



CD1	03/05/19	0001 SUBMISSION	PC	JA	SC	PH
Rev.	Rev. Date	Purpose of revision	Drawn	Checked	Rev'd	Approved

**JACOBS**  
1180 Ewks Rd, Wokingham, Wokingham, RG41 5TU  
Tel: +44(0)118 946 7000 • Fax: +44(0)118 946 7001  
www.jacobs.com

Client: Esso Petroleum Company, Limited  
Ermyn House,  
Ermyn Way,  
Leatherhead,  
Surrey,  
KT22 8UX

Project: Southampton to London Pipeline Project

Drawing title:  
**GENERAL ARRANGEMENT  
SHEET 28  
REGULATION 5 (2)(O)**


Drawing status: **Fit for Stage Approval**

Scale	1:2500	DO NOT SCALE
Jacobs No.	B2325300	Rev
Client no.		Rev
Drawing number		<b>CO1</b>

B2325300-JAC-000-CIV-DRG-000538

C:\pwworking\jacobs\_uk\_water\_utilities\_s44\byor\dm\3513\B2325300-JAC-000-CIV-DRG-000538.dwg - 03/05/2019 11:05:17 - A1Frame - BTaylor



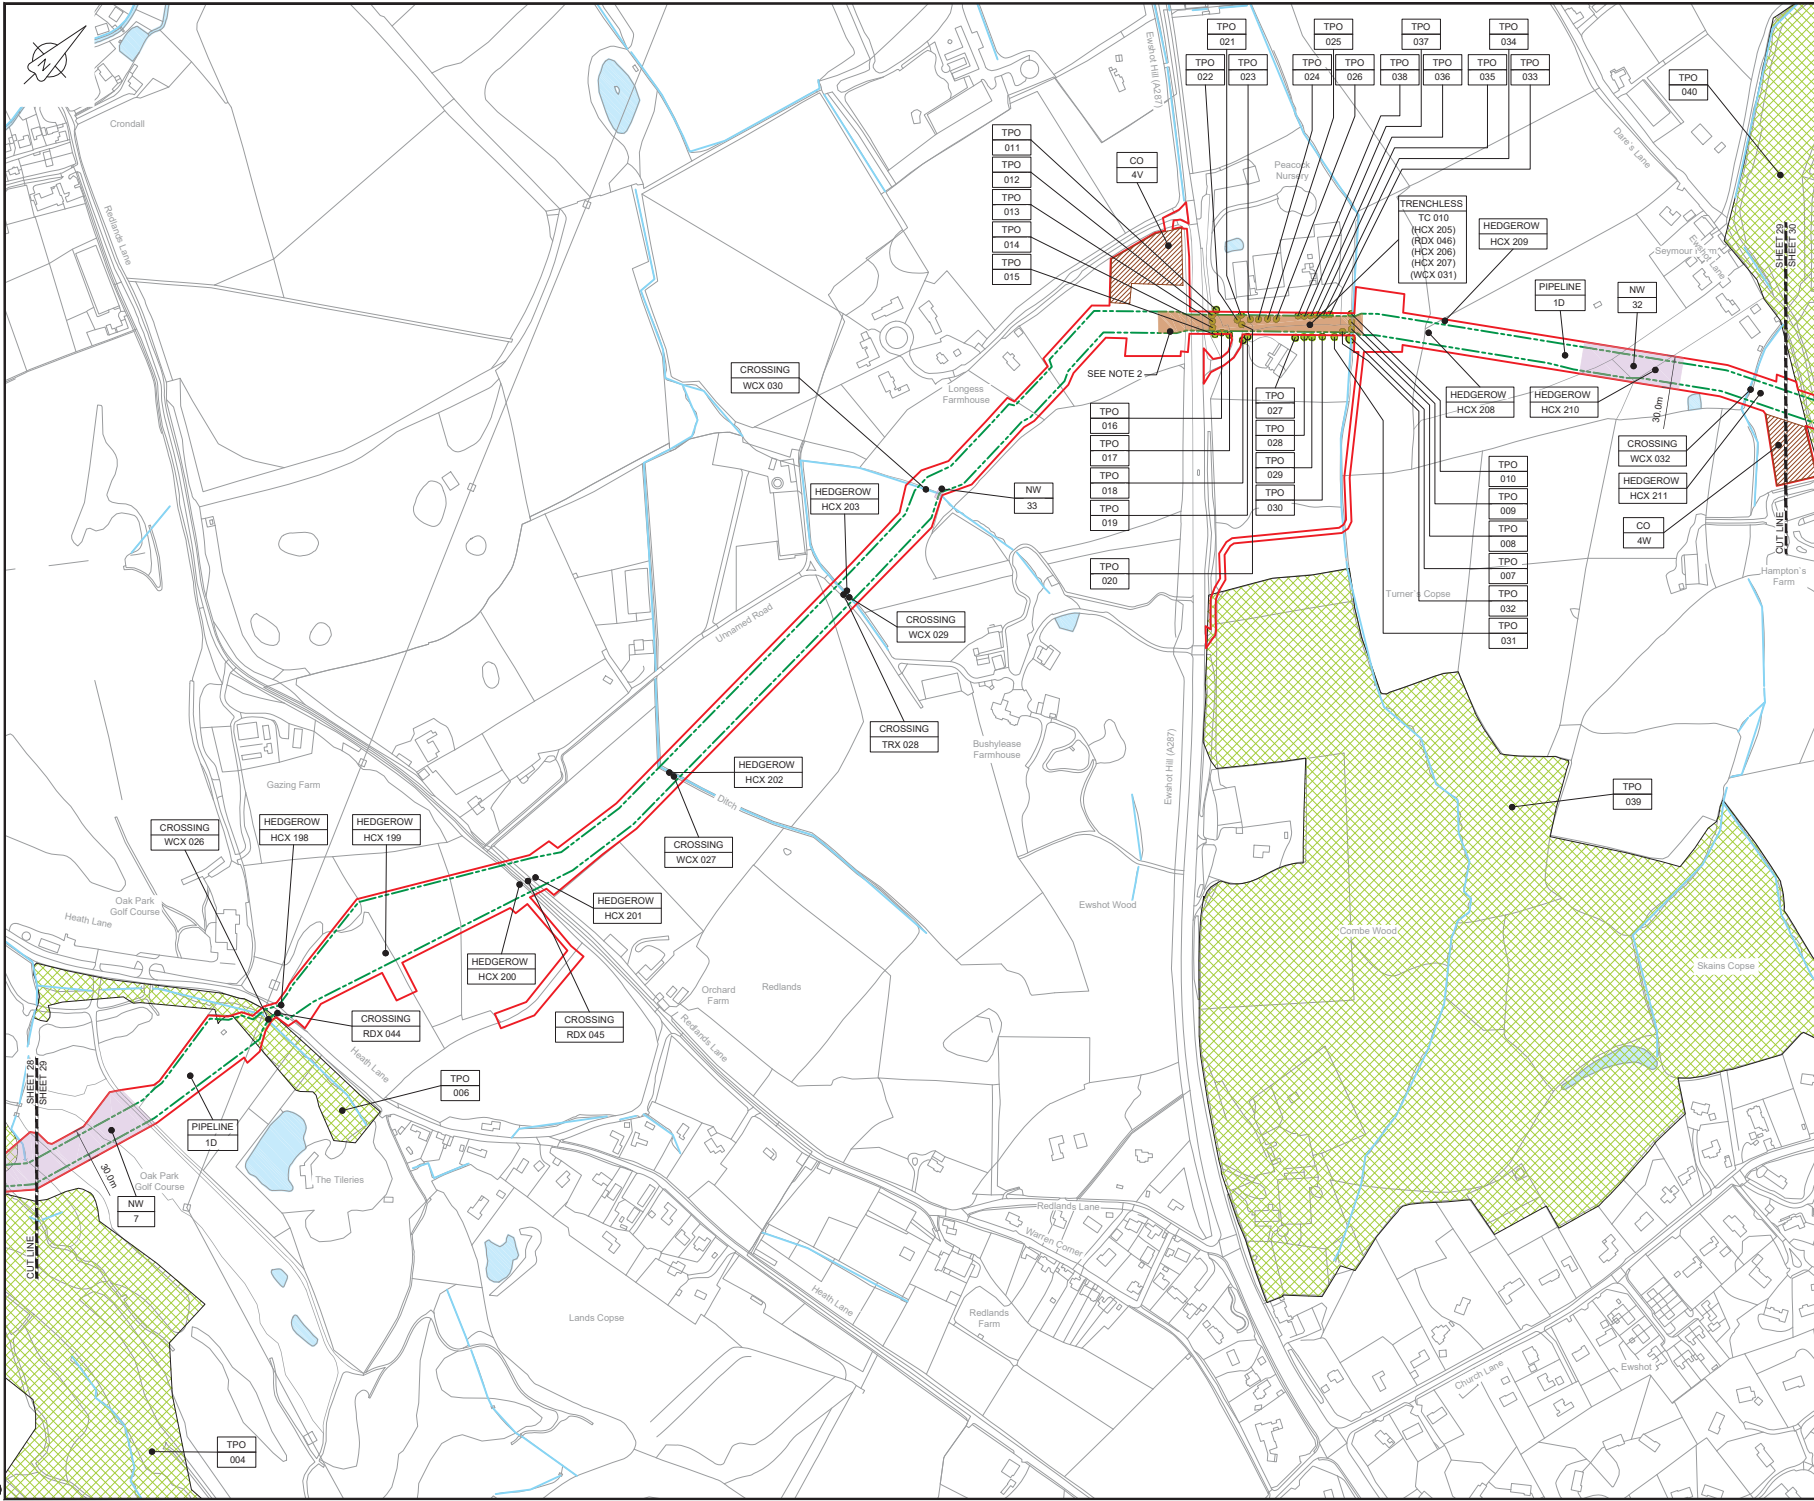

- NOTES**
- THIS DRAWING IS IN METRES UNLESS STATED OTHERWISE.
  - TRENCHLESS CROSSINGS ARE INDICATIVE ONLY.

**LEGEND**

	ORDER LIMITS
	LIMITS OF DEVIATION
	NARROW WORKING AREA (NW)
	TRENCHLESS CROSSING (TC)
	WATER BODIES
	ABOVE GROUND INSTALLATION (AGI) / VALVE (VA) / PRESSURE TRANSDUCER (PT)
	COMPOUND (CO)
	TREE PRESERVATION ORDER (TPO)
	DESCRIPTION
	ID or WORK NUMBER (if applicable)
	COMMENCEMENT / TERMINATION OF WORKS (COMMENCEMENT = OPEN, TERMINATION = CLOSED)

Contains Ordnance Survey data © Crown copyright and database rights 2019.

© Crown copyright and database rights 2019 OS Licence Number AL10005237.

0 50 100 150 200 250 m

SCALE 1:2500 @ A1

CSI	03/01/19	0001 SUBMISSION	PC	JA	SC	PH
Rev.	Rev. Date	Purpose of revision	Drawn	Checked	Rev'd	Approved

**JACOBS**  
1180 Ewshade Road, Winchester, Hampshire, RG41 5TU  
Tel: +44(0)118 946 7000 • Fax: +44(0)118 946 7001  
www.jacobs.com

Client: Esso Petroleum Company, Limited  
Ermyn House,  
Ermyn Way,  
Leatherhead,  
Surrey,  
KT22 8UX

Project: Southampton to London Pipeline Project


Drawing title:  
**GENERAL ARRANGEMENT  
SHEET 29  
REGULATION 5 (2)(O)**

Drawing status: **Fit for Stage Approval**

Scale	1:2500	DO NOT SCALE
Jacobs No.	B2325300	Rev
Client no.	B2325300	Rev
Drawing number	B2325300-JAC-000-CIV-DRG-000539	CO1

C:\pwworking\jacobs\_uk\_water\utilities\_sas4\bjay\tdms\3513\B2325300-JAC-000-CIV-DRG-000539.dwg - 03/02/2019 14:44:16 - A1Frame - BTaylor



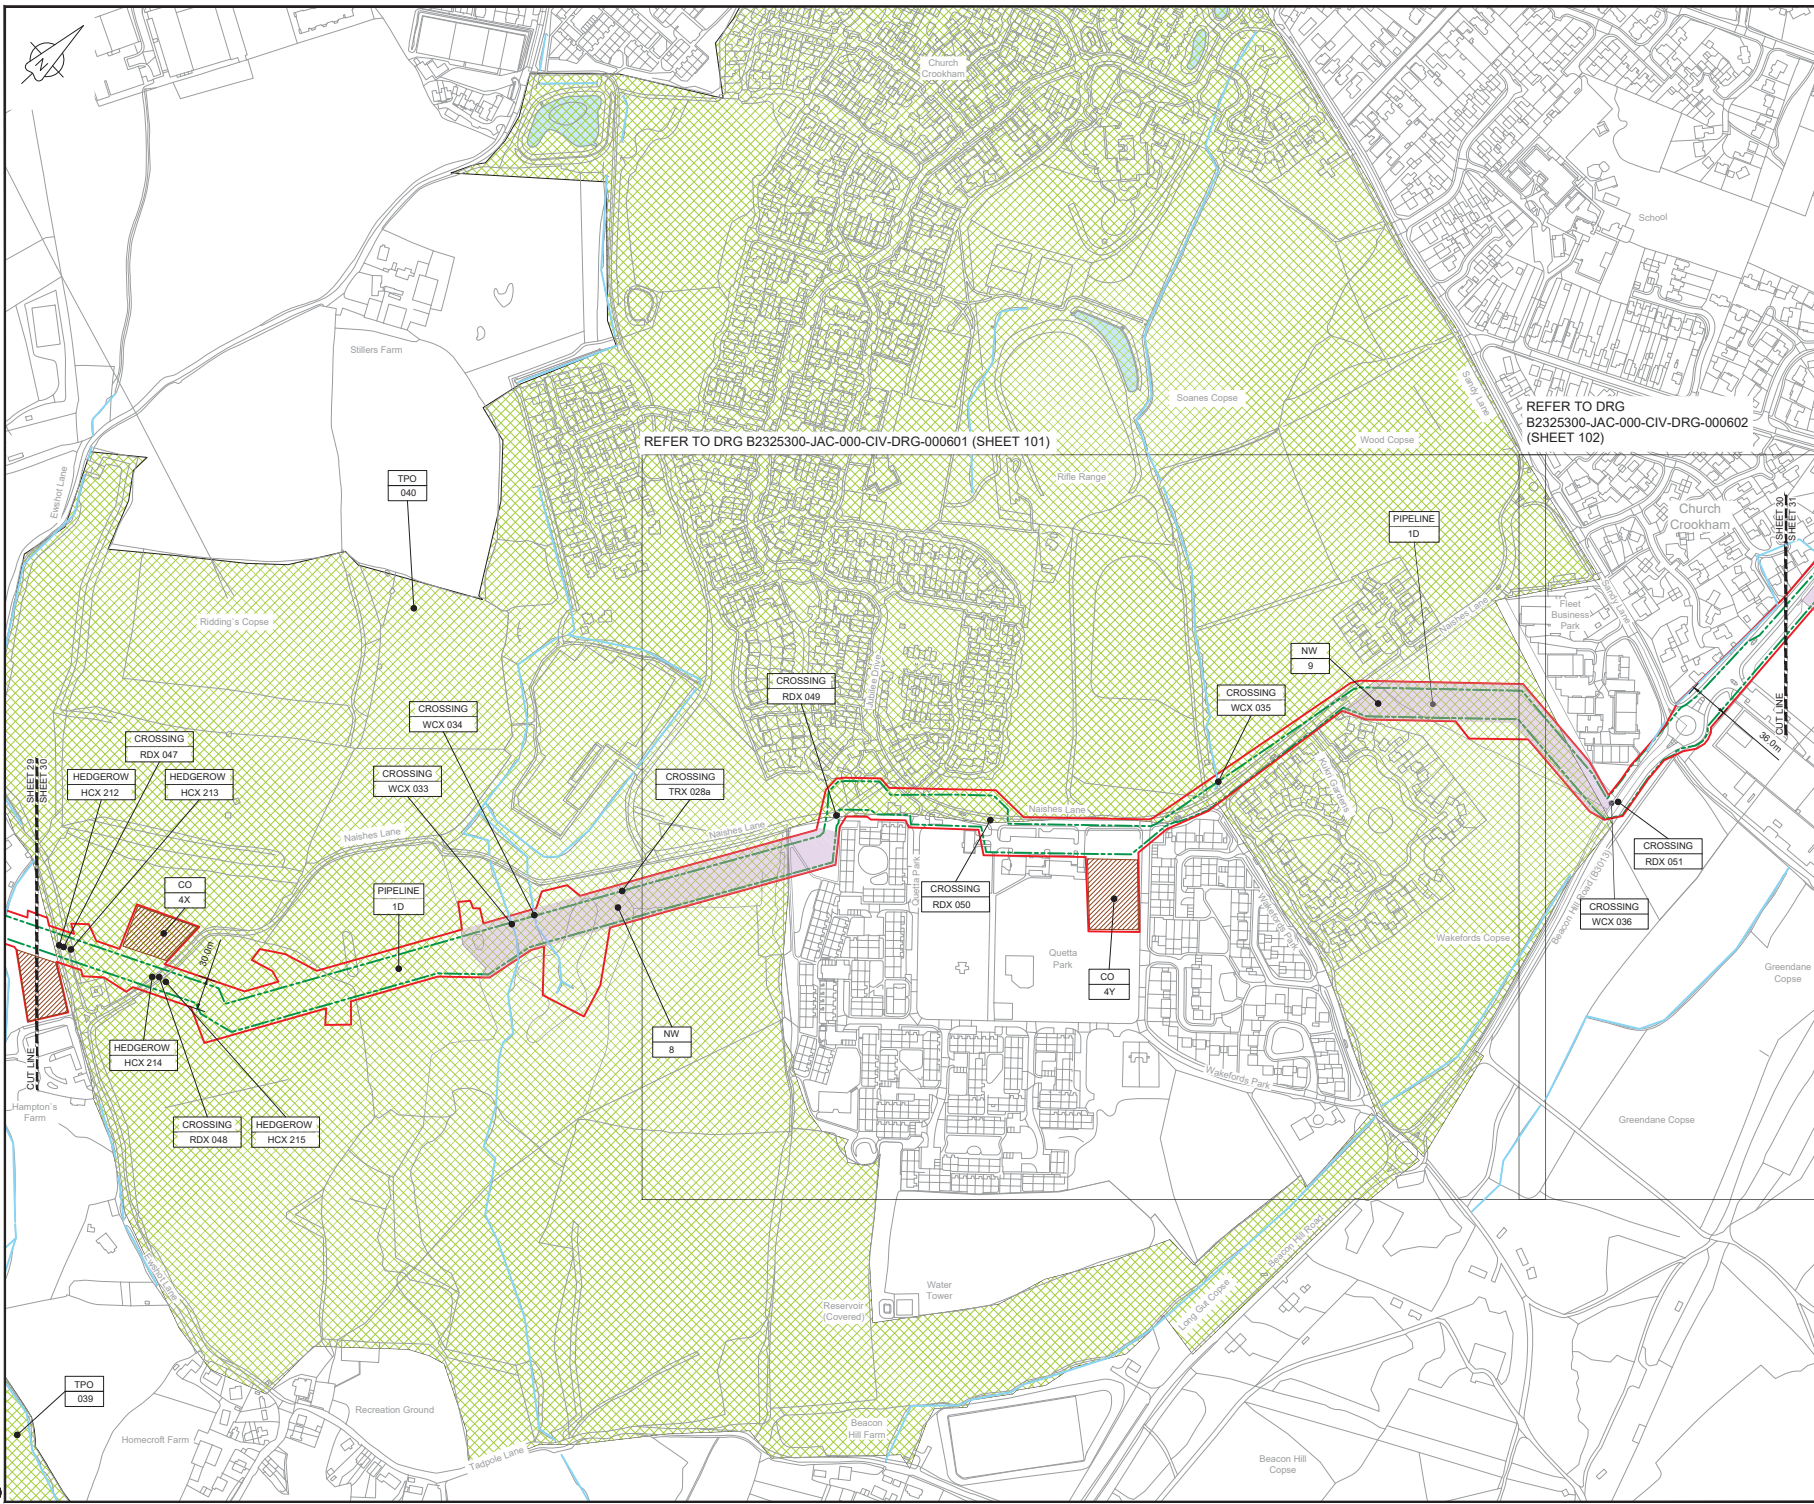

**NOTES**  
 1. THIS DRAWING IS IN METRES UNLESS STATED OTHERWISE.  
 2. TRENCHLESS CROSSINGS ARE INDICATIVE ONLY.

- LEGEND**
- ORDER LIMITS
  - - - LIMITS OF DEVIATION
  - NARROW WORKING AREA (NW)
  - TRENCHLESS CROSSING (TC)
  - WATER BODIES
  - ABOVE GROUND INSTALLATION (AGI) / VALVE (VA) / PRESSURE TRANSDUCER (PT)
  - COMPOUND (CO)
  - TREE PRESERVATION ORDER (TPO)
  - DESCRIPTION
  - ID or WORK NUMBER (if applicable)
  - ⬇ COMMENCEMENT / TERMINATION OF WORKS (COMMENCEMENT = OPEN, TERMINATION = CLOSED)

Contains Ordnance Survey data © Crown copyright and database rights 2019.  
 © Crown copyright and database rights 2019 OS Licence Number AL100065237.



CDI	03/05/19	0000	PERMISSION	PC	JA	SC	PH
Rev.	Rev. Date		Purpose of revision	Drawn	Checked	Rev'd	Approved

**JACOBS**  
 1180 Ewidge Road, Wokingham, Wokingham, RG41 5TU  
 Tel: +44(0)118 946 7000 • Fax: +44(0)118 946 7001  
 www.jacobs.com

Client: Esso Petroleum Company Limited  
 Emlyn House,  
 Emlyn Way,  
 Leatherhead,  
 Surrey,  
 KT22 8UX

Project: Southampton to London Pipeline Project


Drawing title:  
**GENERAL ARRANGEMENT SHEET 30**  
**REGULATION 5 (2)(O)**

Drawing status: **Fit for Stage Approval**

Scale	1:2500	DO NOT SCALE
Jacobs No.	B2325300	Rev
Client no.	B2325300	Rev
Drawing number	B2325300-JAC-000-CIV-DRG-000540	Rev
		<b>CO1</b>

C:\pwworking\jacobs\_uk\_water\utilities\_saf\obj\work\m351382325300\_JAC-000-CIV-DRG-000540.dwg - 03/05/2019 11:11:26 - A1Frame - BTaylor



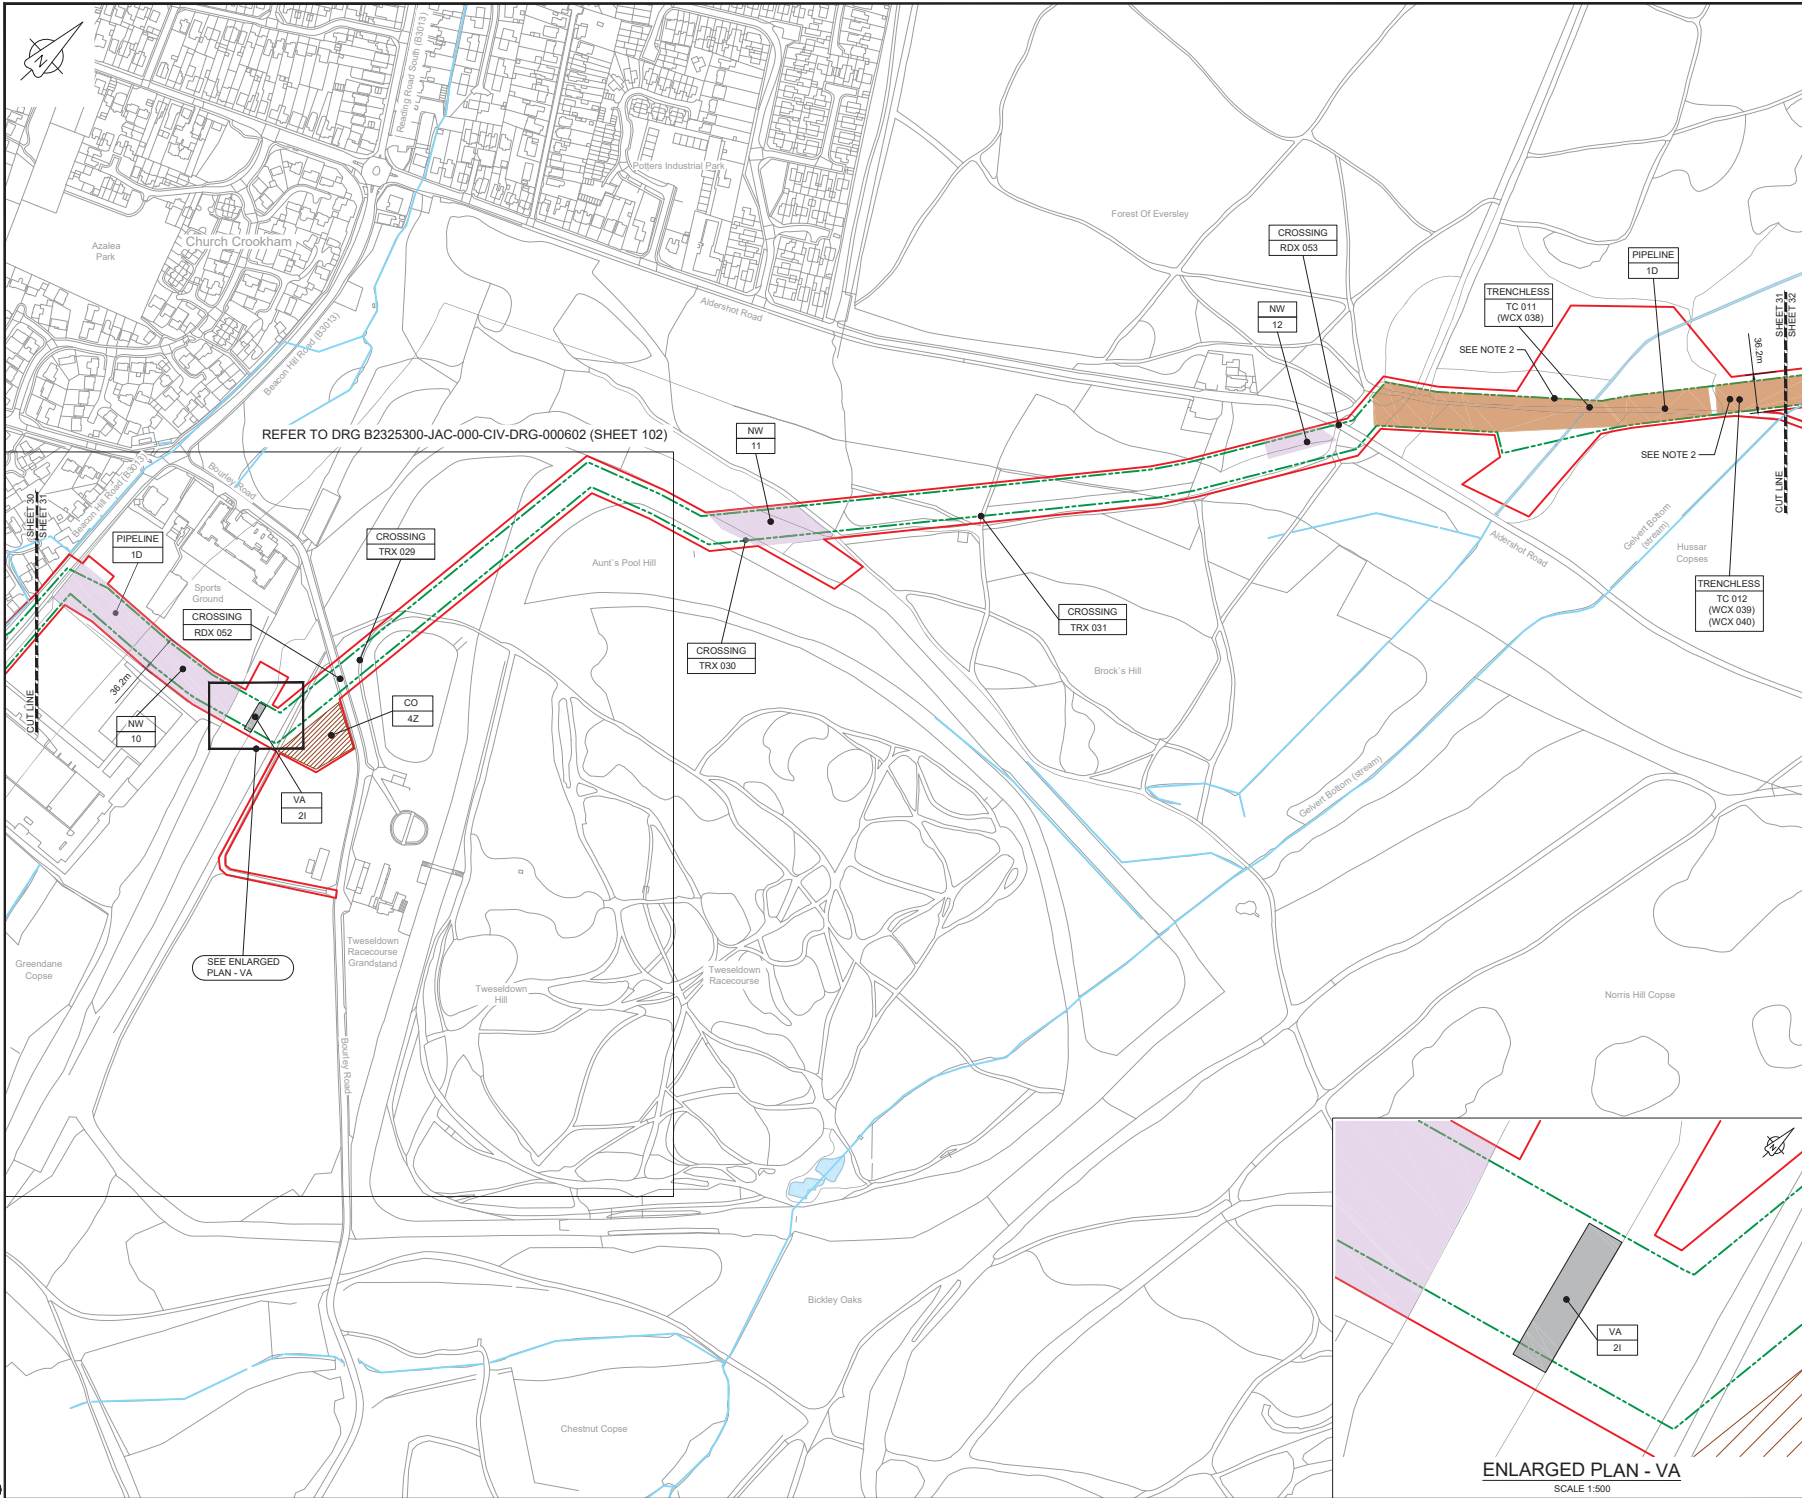

LOCATION PLAN  
SCALE 1:500,000

- NOTES**
- THIS DRAWING IS IN METRES UNLESS STATED OTHERWISE.
  - TRENCHLESS CROSSINGS ARE INDICATIVE ONLY.

- LEGEND**
- ORDER LIMITS
  - LIMITS OF DEVIATION
  - NARROW WORKING AREA (NW)
  - TRENCHLESS CROSSING (TC)
  - WATER BODIES
  - ABOVE GROUND INSTALLATION (AGI) / VALVE (VA) / PRESSURE TRANSDUCER (PT)
  - COMPOUND (CO)
  - TREE PRESERVATION ORDER (TPO)
  - DESCRIPTION
  - ID or WORK NUMBER (if applicable)
  - COMMENCEMENT / TERMINATION OF WORKS (COMMENCEMENT = OPEN, TERMINATION = CLOSED)

Contains Ordnance Survey data © Crown copyright and database rights 2019.

© Crown copyright and database rights 2019 OS Licence Number AL100005237.



CD	03/05/19	0000	0000	PC	JA	SC	PH
Rev.	Rev. Date	Purpose of revision		Drawn	Checked	Rev'd	Approved

**JACOBS**  
1180 Ewings Road, Winchester, Wokingham, RG41 5TU  
Tel +44(0)118 946 7000 • Fax +44(0)118 946 7001  
www.jacobs.com

Client: Esso Petroleum Company, Limited  
Emryn House,  
Emryn Way,  
Leatherhead,  
Surrey,  
KT22 8UX




Project  
**GENERAL ARRANGEMENT SHEET 31**  
**REGULATION 5 (2)(O)**

Drawing status: **Fit for Stage Approval**


Scale	1:2500	DO NOT SCALE
Jacobs No.	B2325300	Rev
Client no.		CO1

Drawing number  
**B2325300-JAC-000-CIV-DRG-000541**

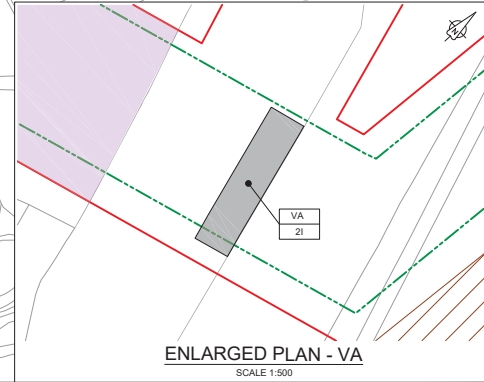

ENLARGED PLAN - VA  
SCALE 1:500

C:\pwworking\jacobs\_uk\_water\utilities\_sa4\byrd\m3513\B2325300-JAC-000-CIV-DRG-000541.dwg - 03/05/2019 11:14:28 - A1Frame - BTaylor

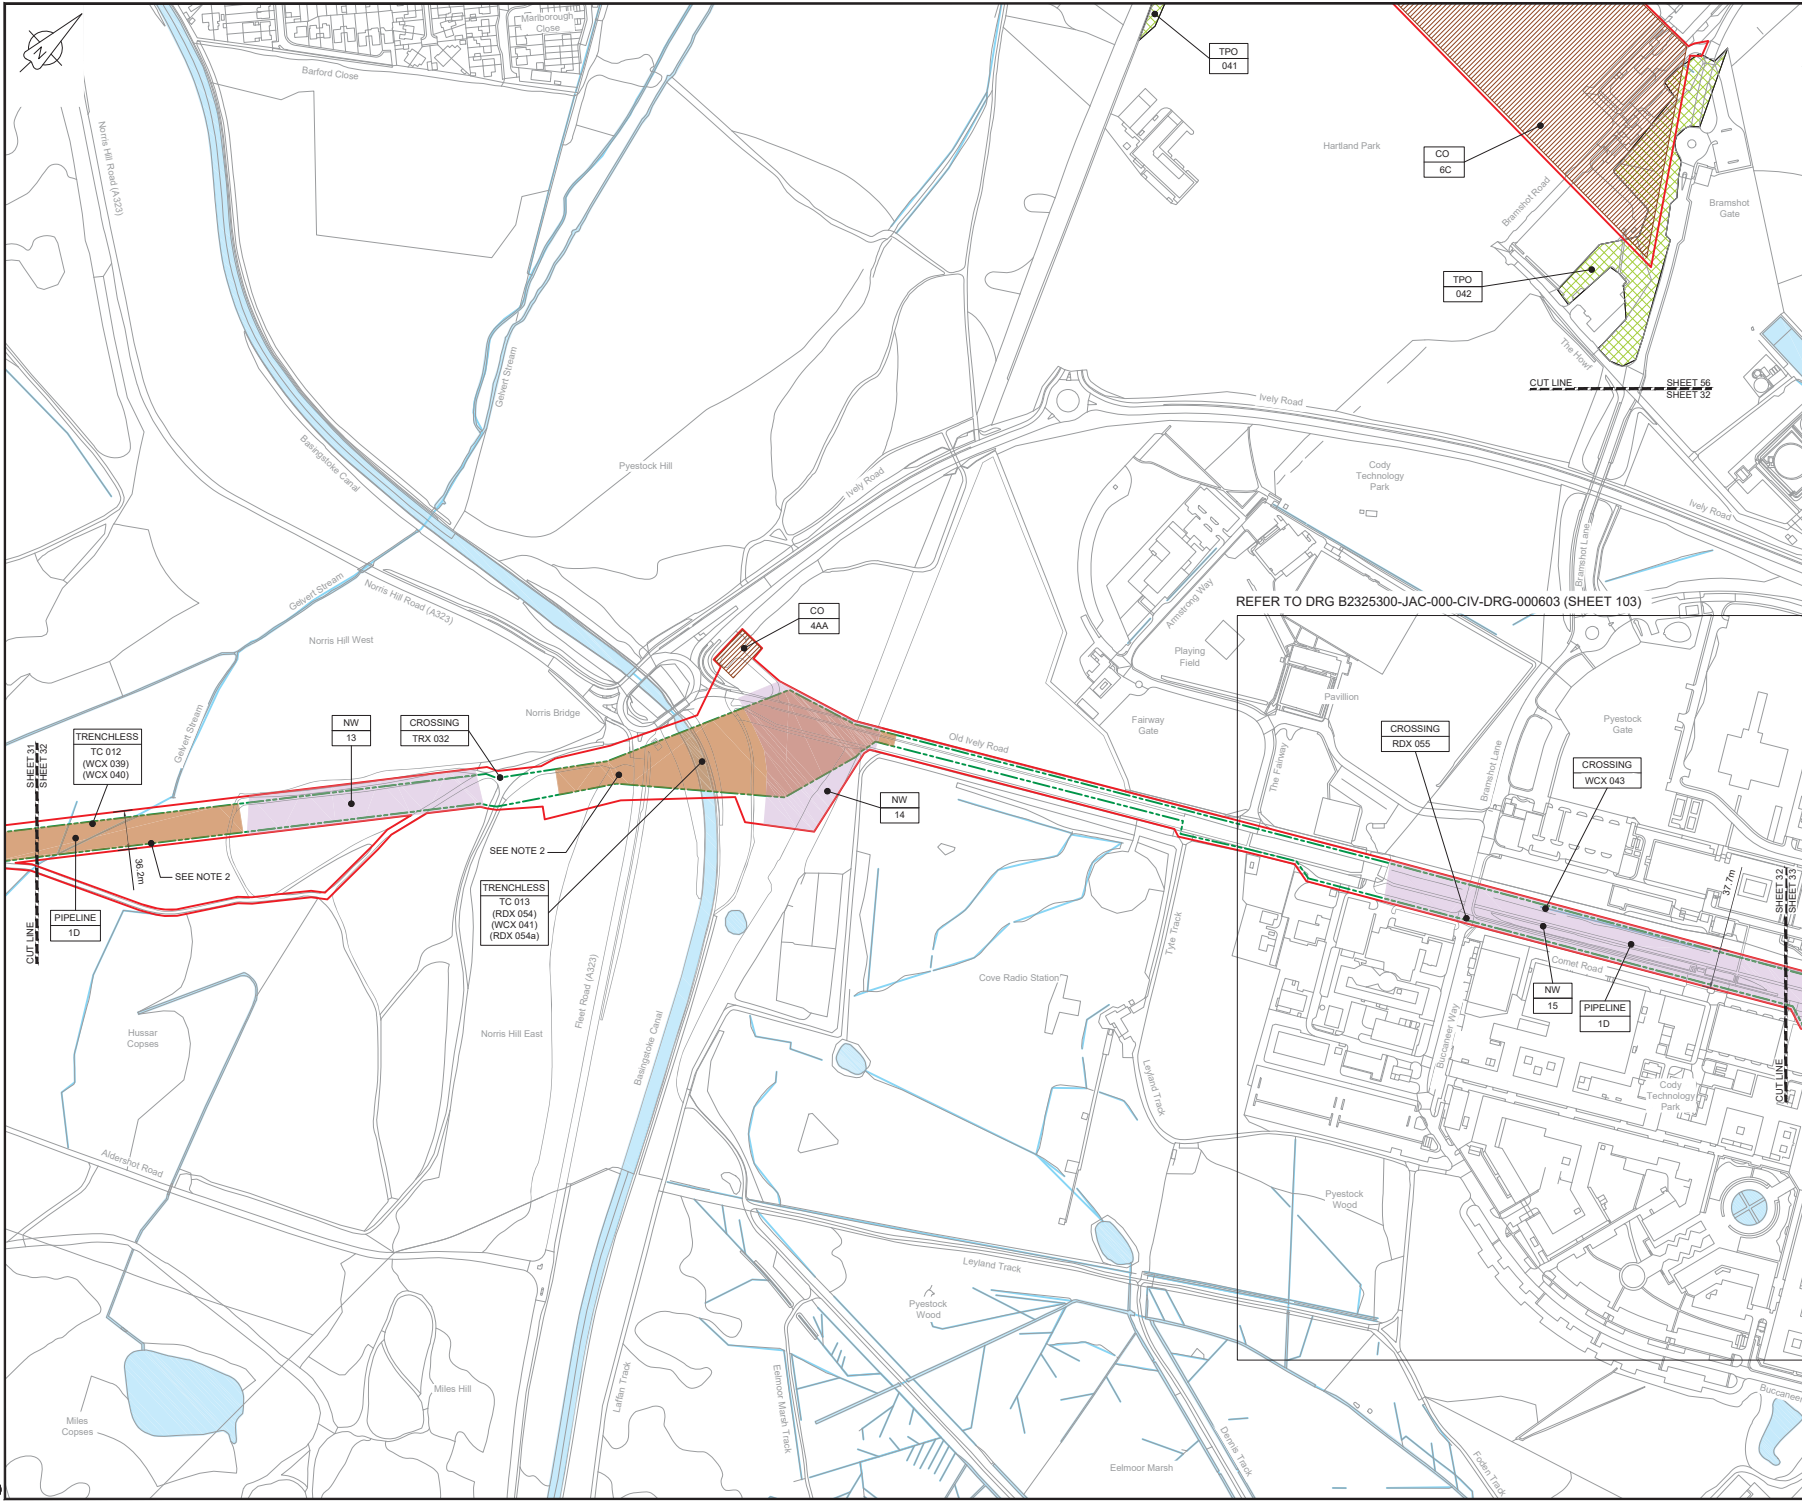

LOCATION PLAN  
SCALE 1:500,000

- NOTES**
1. THIS DRAWING IS IN METRES UNLESS STATED OTHERWISE.
  2. TRENCHLESS CROSSINGS ARE INDICATIVE ONLY.

- LEGEND**
- ORDER LIMITS
  - LIMITS OF DEVIATION
  - NARROW WORKING AREA (NW)
  - TRENCHLESS CROSSING (TC)
  - WATER BODIES
  - ABOVE GROUND INSTALLATION (AGI) / VALVE (VA) / PRESSURE TRANSDUCER (PT)
  - COMPOUND (CO)
  - TREE PRESERVATION ORDER (TPO)
  - DESCRIPTION
  - ID or WORK NUMBER (if applicable)
  - COMMENCEMENT / TERMINATION OF WORKS (COMMENCEMENT = OPEN, TERMINATION = CLOSED)

Contains Ordnance Survey data © Crown copyright and database rights 2019  
© Crown copyright and database rights 2019 OS Licence Number AL10006237.



CD	03/06/19	ISSUE/REVISION	PC	JA	SC	PH
Rev.	Rev. Date	Purpose of revision	Drawn	Checked	Rev'd	Approved

**JACOBS**  
1180 Ewells Road, Windsor, Wokingham, RG41 5TU  
Tel: +44(0)118 945 7000 • Fax: +44(0)118 945 7001  
www.jacobs.com

Client: Esso Petroleum Company, Limited  
Ermen House,  
Ermen Way,  
Leatherhead,  
Surrey,  
KT22 8UX

Project: Southampton to London Pipeline Project

Drawing title: **GENERAL ARRANGEMENT SHEET 32 REGULATION 5 (2)(O)**


Drawing status: **Fit for Stage Approval**

Scale	1:2500	DO NOT SCALE
Jacobs No.	B2325300	Rev
Client no.		CO1

Drawing number: **B2325300-JAC-000-CIV-DRG-000542**

C:\pwworking\jacobs\_uk\_water\utilities\_s44\byrd\m3513\B2325300-JAC-000-CIV-DRG-000542.dwg - 03/06/2019 11:22:57 - A1Frame - BTaylor



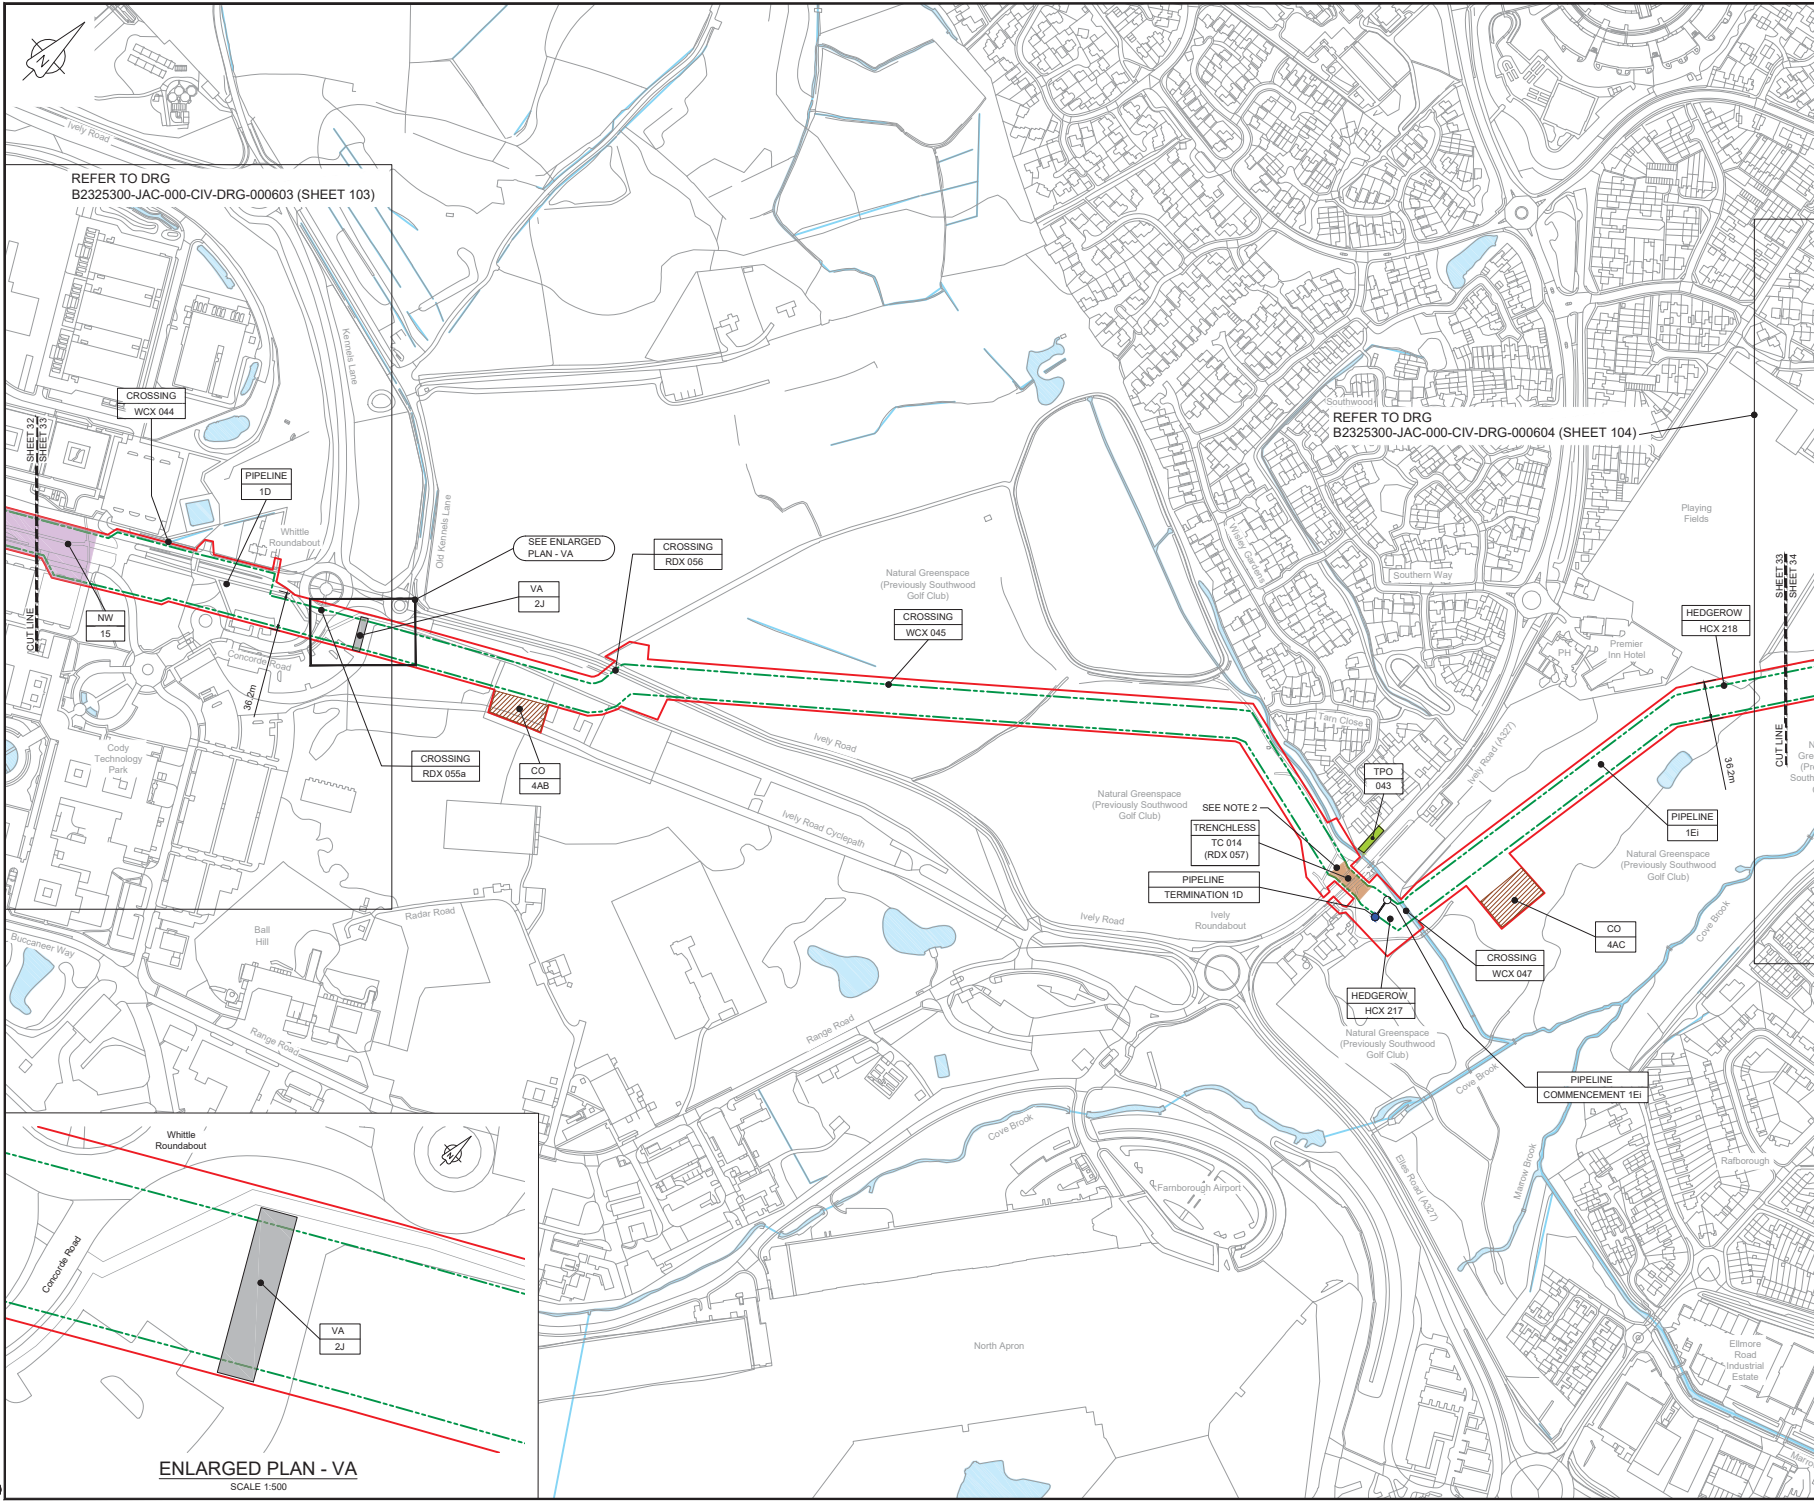

LOCATION PLAN  
SCALE 1:500,000

- NOTES**
- THIS DRAWING IS IN METRES UNLESS STATED OTHERWISE.
  - TRENCHLESS CROSSINGS ARE INDICATIVE ONLY.

- LEGEND**
- ORDER LIMITS
  - LIMITS OF DEVIATION
  - NARROW WORKING AREA (NW)
  - TRENCHLESS CROSSING (TC)
  - WATER BODIES
  - ABOVE GROUND INSTALLATION (AGI) / VALVE (VA) / PRESSURE TRANSDUCER (PT)
  - COMPOUND (CO)
  - TREE PRESERVATION ORDER (TPO)
  - DESCRIPTION
  - ID or WORK NUMBER (if applicable)
  - COMMENCEMENT / TERMINATION OF WORKS (COMMENCEMENT = OPEN, TERMINATION = CLOSED)

Contains Ordnance Survey data © Crown copyright and database rights 2019.  
© Crown copyright and database rights 2019 OS Licence Number AL100005237.



CD	03/2019	ISSUE/REVISION	PC	JA	SC	PH
Rev.	Rev. Date	Purpose of revision	Drawn	Checked	Rev'd	Approved

**JACOBS**  
1180 Epsom Road, Wokingham, Wokingham, RG41 5TU  
Tel: +44(0)118 946 7000 • Fax: +44(0)118 946 7001  
www.jacobs.com

Client: Esso Petroleum Company, Limited  
Emryn House,  
Emryn Way,  
Leatherhead,  
Surrey,  
KT22 8UX

Project: Southampton to London Pipeline Project

Drawing title: **GENERAL ARRANGEMENT SHEET 33 REGULATION 5 (2)(O)**

Drawing status: **Fit for Stage Approval**

Scale	1:2500	DO NOT SCALE
Jacobs No.	B2325300	Rev
Client no.		<b>CO1</b>

Drawing number: **B2325300-JAC-000-CIV-DRG-000543**


REFER TO DRG B2325300-JAC-000-CIV-DRG-000603 (SHEET 103)

REFER TO DRG B2325300-JAC-000-CIV-DRG-000604 (SHEET 104)

**ENLARGED PLAN - VA**  
SCALE 1:500

C:\pwworking\jacobs\_uk\_water\utilities\_s44\bjayfor\mms13513\B2325300-JAC-000-CIV-DRG-000543.dwg - 03/05/2019 11:34:46 - A1Frame - B1aylor



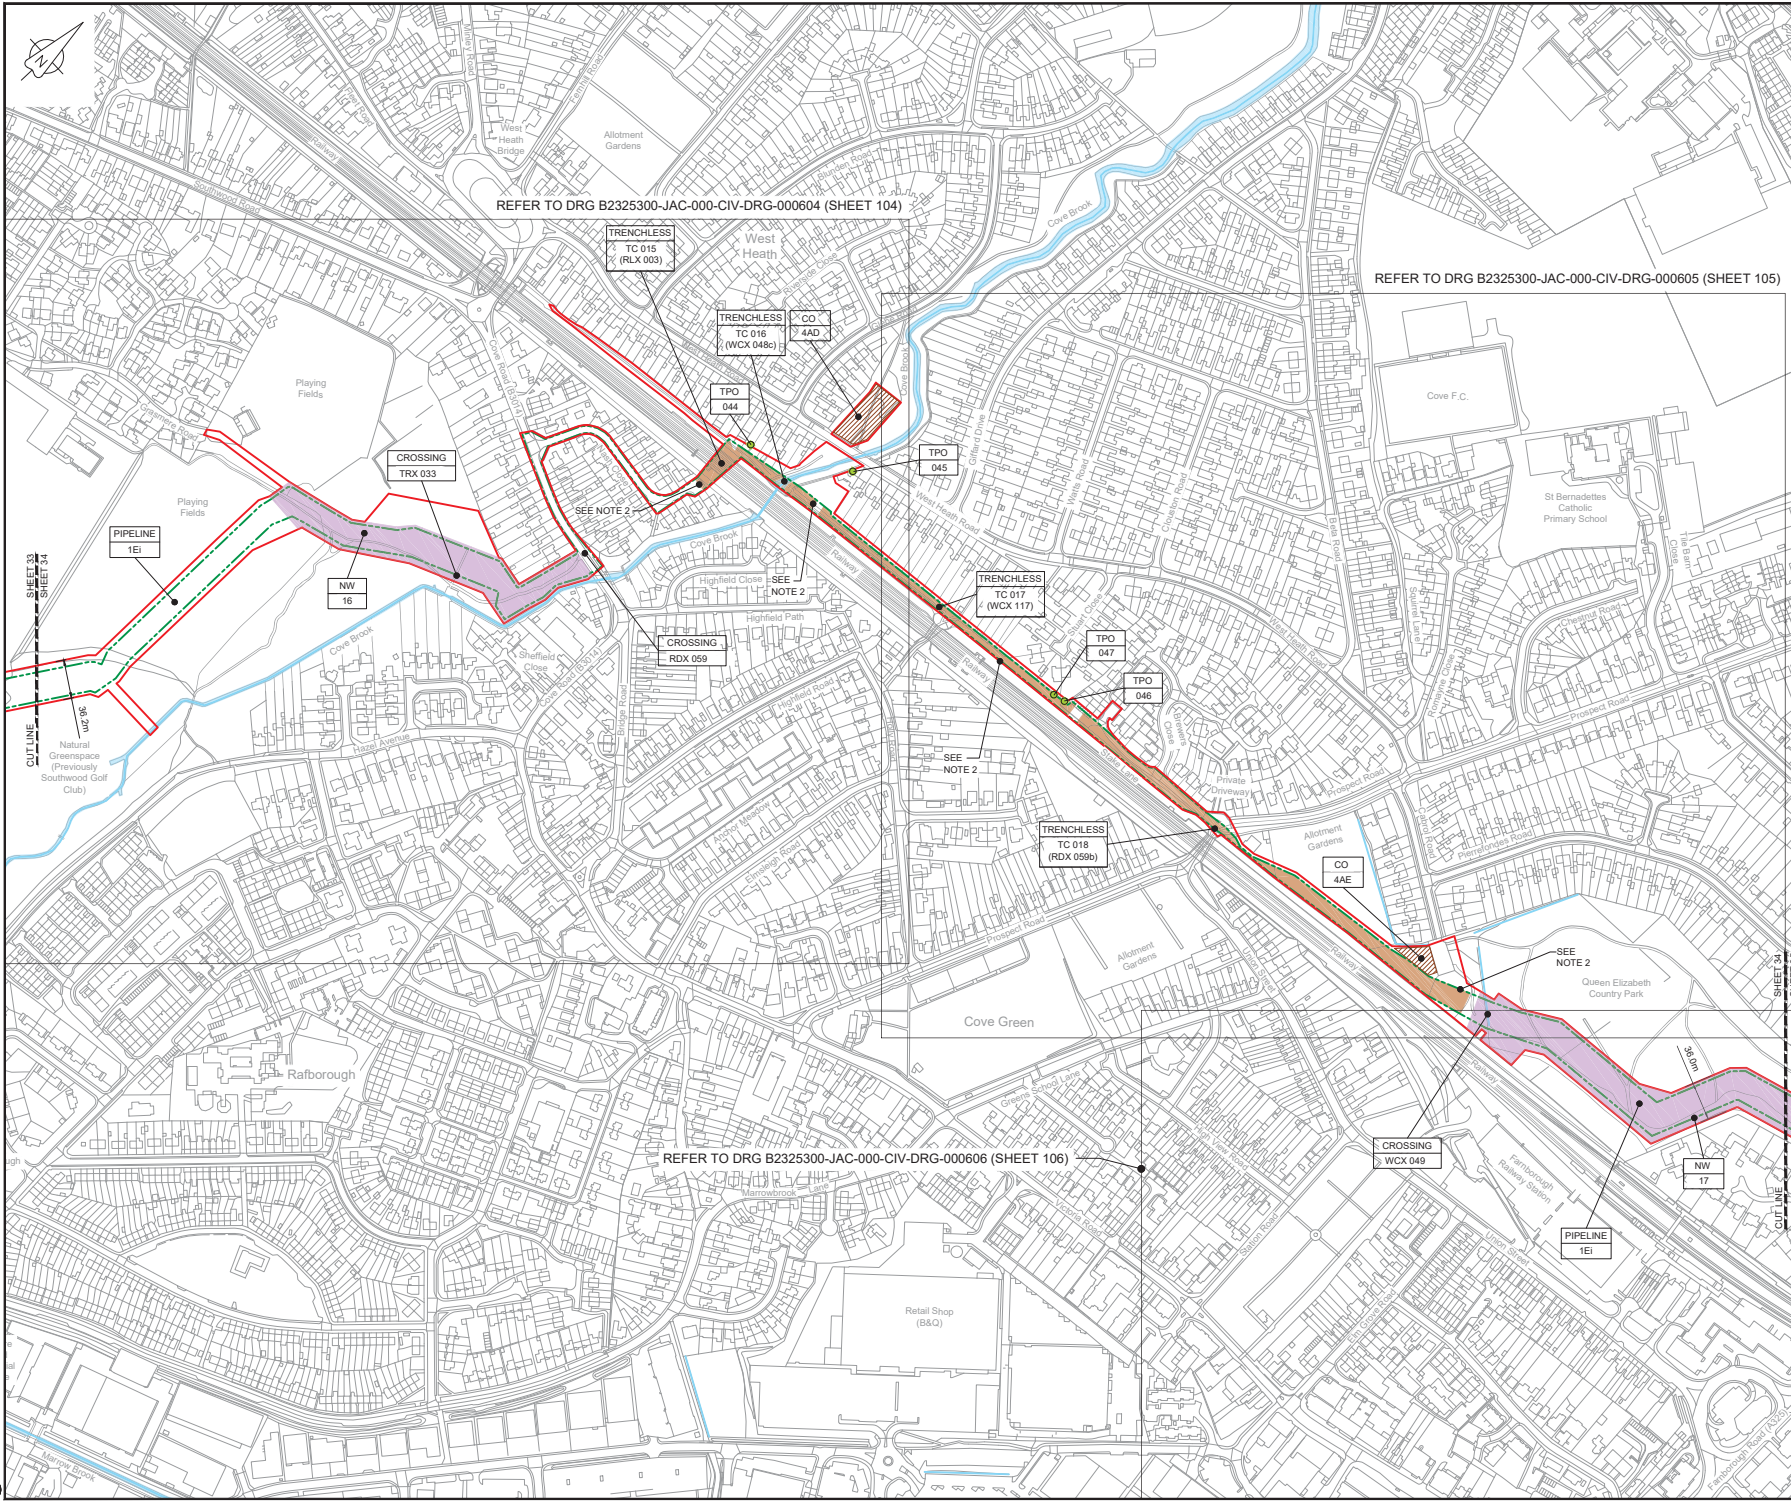

REFER TO DRG B2325300-JAC-000-CIV-DRG-000604 (SHEET 104)

REFER TO DRG B2325300-JAC-000-CIV-DRG-000605 (SHEET 105)

REFER TO DRG B2325300-JAC-000-CIV-DRG-000606 (SHEET 106)



LOCATION PLAN  
SCALE 1:500,000

- NOTES**
- THIS DRAWING IS IN METRES UNLESS STATED OTHERWISE.
  - TRENCHLESS CROSSINGS ARE INDICATIVE ONLY.

- LEGEND**
- ORDER LIMITS
  - LIMITS OF DEVIATION
  - NARROW WORKING AREA (NW)
  - TRENCHLESS CROSSING (TC)
  - WATER BODIES
  - ABOVE GROUND INSTALLATION (AGI) / VALVE (VA) / PRESSURE TRANSDUCER (PT)
  - COMPOUND (CO)
  - TREE PRESERVATION ORDER (TPO)
  - DESCRIPTION
  - ID or WORK NUMBER (if applicable)
  - COMMENCEMENT / TERMINATION OF WORKS (COMMENCEMENT = OPEN, TERMINATION = CLOSED)

Contains Ordnance Survey data © Crown copyright and database rights 2019.

© Crown copyright and database rights 2019 OS Licence Number AL10005237.



CD1	03/05/19	0001 SUBMISSION	PC	JA	SC	PH
Rev.	Rev. Date	Purpose of revision	Drawn	Checked	Rev'd	Approved

**JACOBS**  
1180 Epsom Road, Wokingham, Wokingham, RG41 5TU  
Tel: +44(0)118 946 7000 • Fax: +44(0)118 946 7001  
www.jacobs.com

Client: Esso Petroleum Company Limited  
Ermyn House,  
Ermyn Way,  
Leatherhead,  
Surrey,  
KT22 8UX



Drawing title  
**GENERAL ARRANGEMENT  
SHEET 34  
REGULATION 5 (2)(O)**

Drawing status: **Fit for Stage Approval**


Scale	1:2500	DO NOT SCALE
Jacobs No.	B2325300	Rev
Client no.		CO1

Drawing number  
**B2325300-JAC-000-CIV-DRG-000544**

© Copyright 2019 Jacobs U.K. Limited. This drawing and all other documents contained herein are the property of Jacobs. Use or copying of this document in whole or in part without the written permission of Jacobs constitutes an infringement of copyright. Limitation: This drawing has been prepared in behalf of and for the exclusive use of Jacobs Client, and is not to be used in accordance with the provisions of the contract between Jacobs and the Client. Jacobs accepts no liability or responsibility whatsoever for its use in respect of any other or subsequent project. Its terms apply to this drawing only.

C:\pwworking\jacobs\_uk\_water\dwg\15313\B2325300-JAC-000-CIV-DRG-000544.dwg - 03/05/2019 15:50:26 - A1Frame - BTaylor



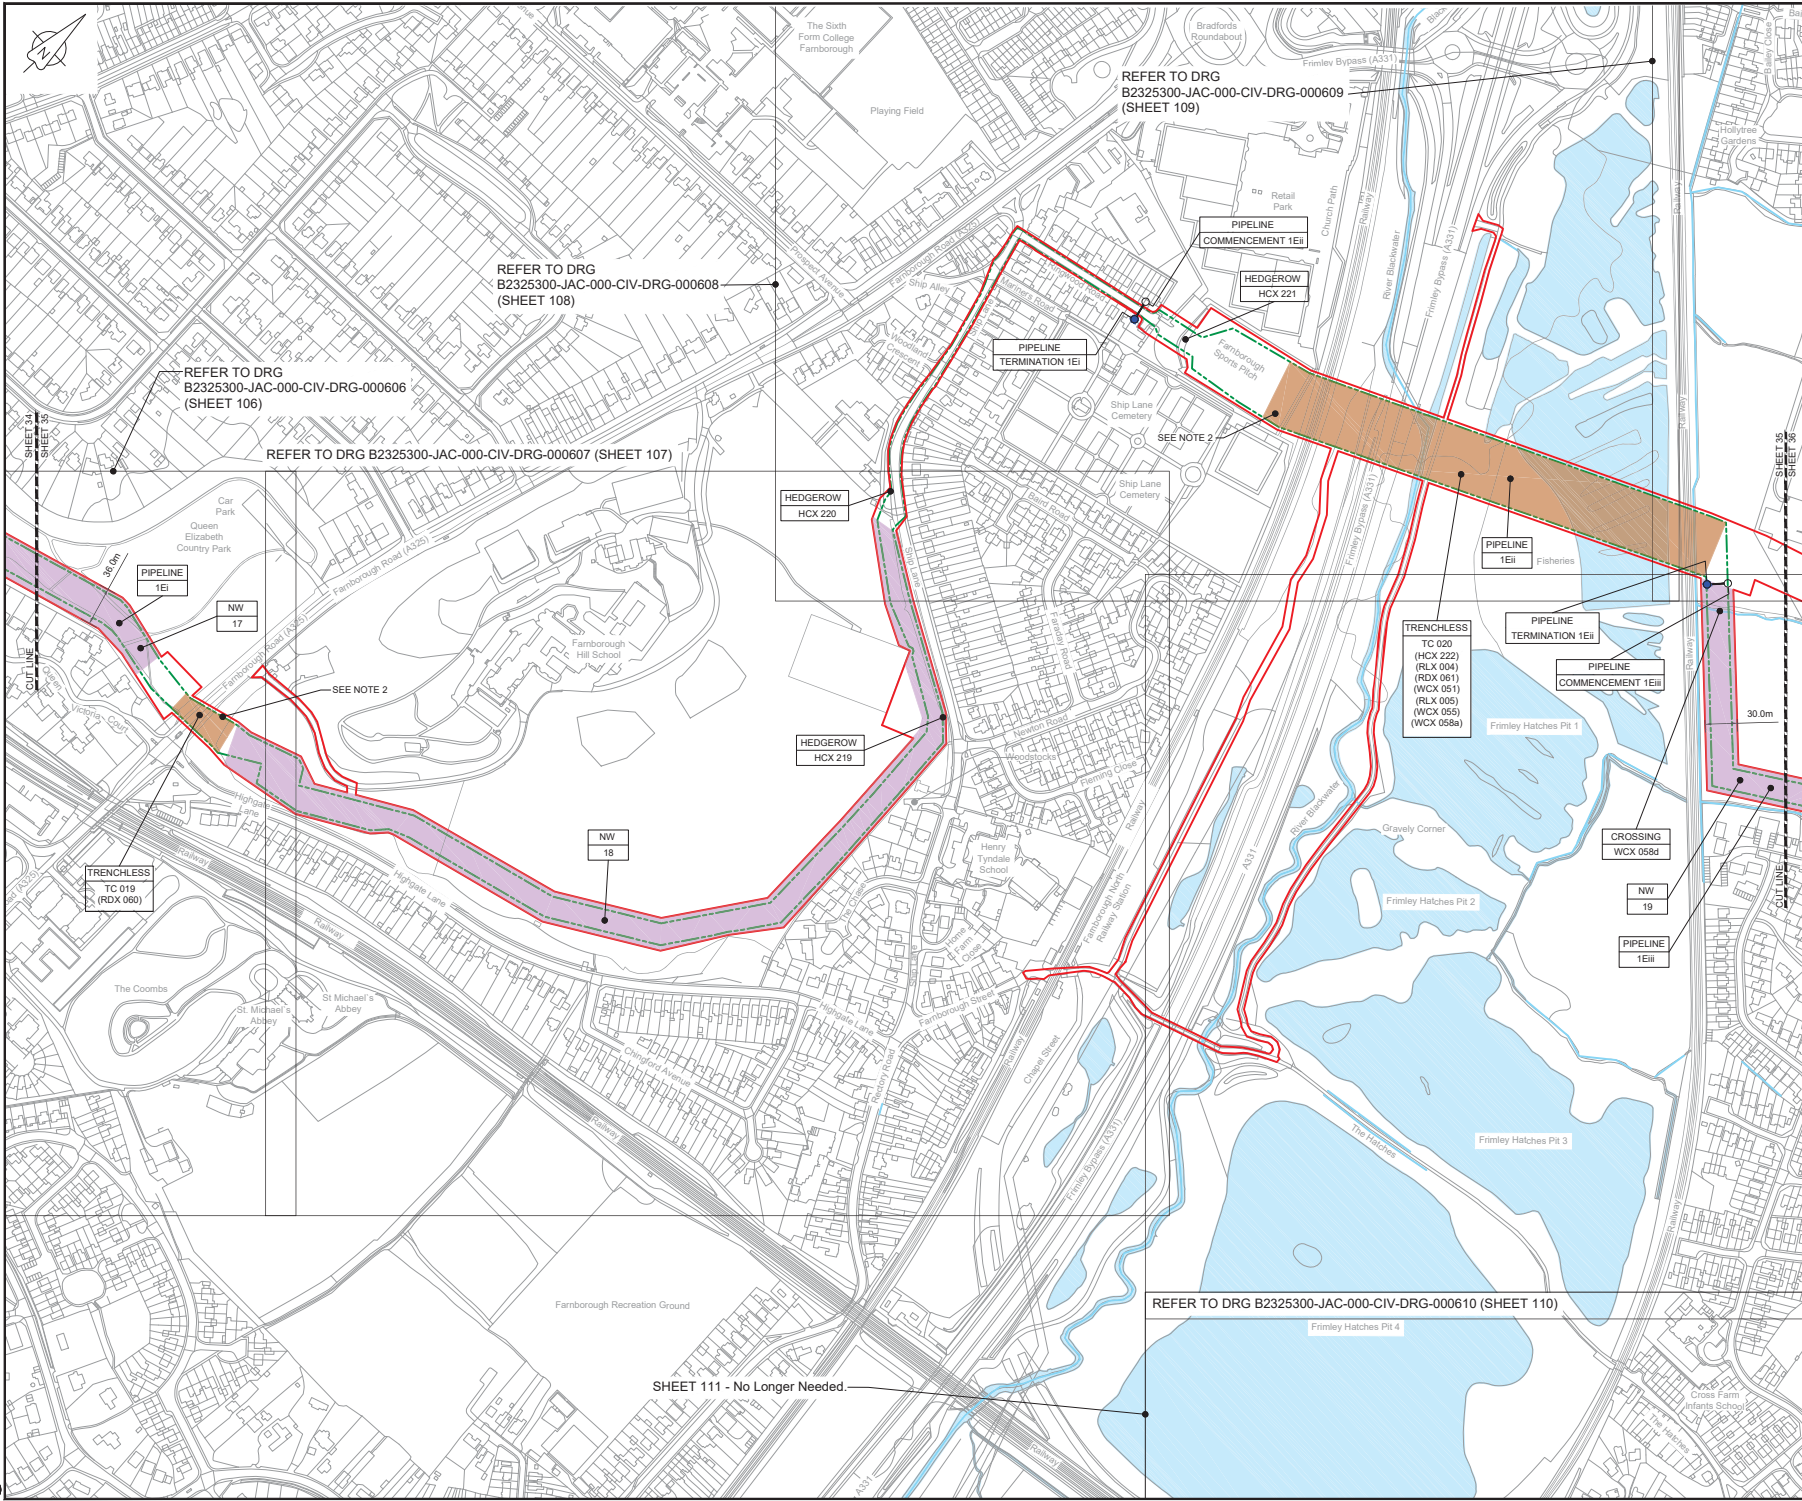


LOCATION PLAN  
SCALE 1:500,000

- NOTES**
- THIS DRAWING IS IN METRES UNLESS STATED OTHERWISE.
  - TRENCHLESS CROSSINGS ARE INDICATIVE ONLY.

- LEGEND**
- ORDER LIMITS
  - LIMITS OF DEVIATION
  - NARROW WORKING AREA (NW)
  - TRENCHLESS CROSSING (TC)
  - WATER BODIES
  - ABOVE GROUND INSTALLATION (AGI) / VALVE (VA) / PRESSURE TRANSDUCER (PT)
  - COMPOUND (CO)
  - TREE PRESERVATION ORDER (TPO)
  - DESCRIPTION
  - ID or WORK NUMBER (if applicable)
  - COMMENCEMENT / TERMINATION OF WORKS (COMMENCEMENT = OPEN, TERMINATION = CLOSED)

Contains Ordnance Survey data © Crown copyright and database rights 2019.

© Crown copyright and database rights 2019 OS Licence Number AL10005237.

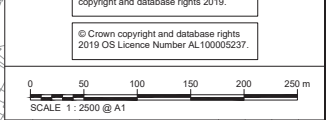

CD	03/05/19	0001/0001/0001	PC	JA	SC	PH
Rev.	Rev. Date	Purpose of revision	Drawn	Checked	Rev'd	Approved

**JACOBS**  
1180 Ewlish Road, Winchester, Hampshire, RG41 5TU  
Tel: +44(0)118 946 7000 • Fax: +44(0)118 946 7001  
www.jacobs.com

Client: Esso Petroleum Company, Limited  
Emryn House,  
Emryn Way,  
Leatherhead,  
Surrey,  
KT22 8UX

Project: Southampton to London Pipeline Project

Drawing title: **GENERAL ARRANGEMENT SHEET 35 REGULATION 5 (2)(O)**


Drawing status: **Fit for Stage Approval**

Scale	1:2500	DO NOT SCALE
Scale	1:2500	DO NOT SCALE
Jacobs No.	B2325300	Rev
Client no.	B2325300	Rev
Drawing number	B2325300-JAC-000-CIV-DRG-000545	Rev
		CO1

B2325300-JAC-000-CIV-DRG-000545

C:\pwworking\jacobs\_uk\_water\utilities\_s44\byproj\drms\3513\B2325300-JAC-000-CIV-DRG-000545.dwg - 03/05/2019 11:42:38 - A\Francis - B Taylor



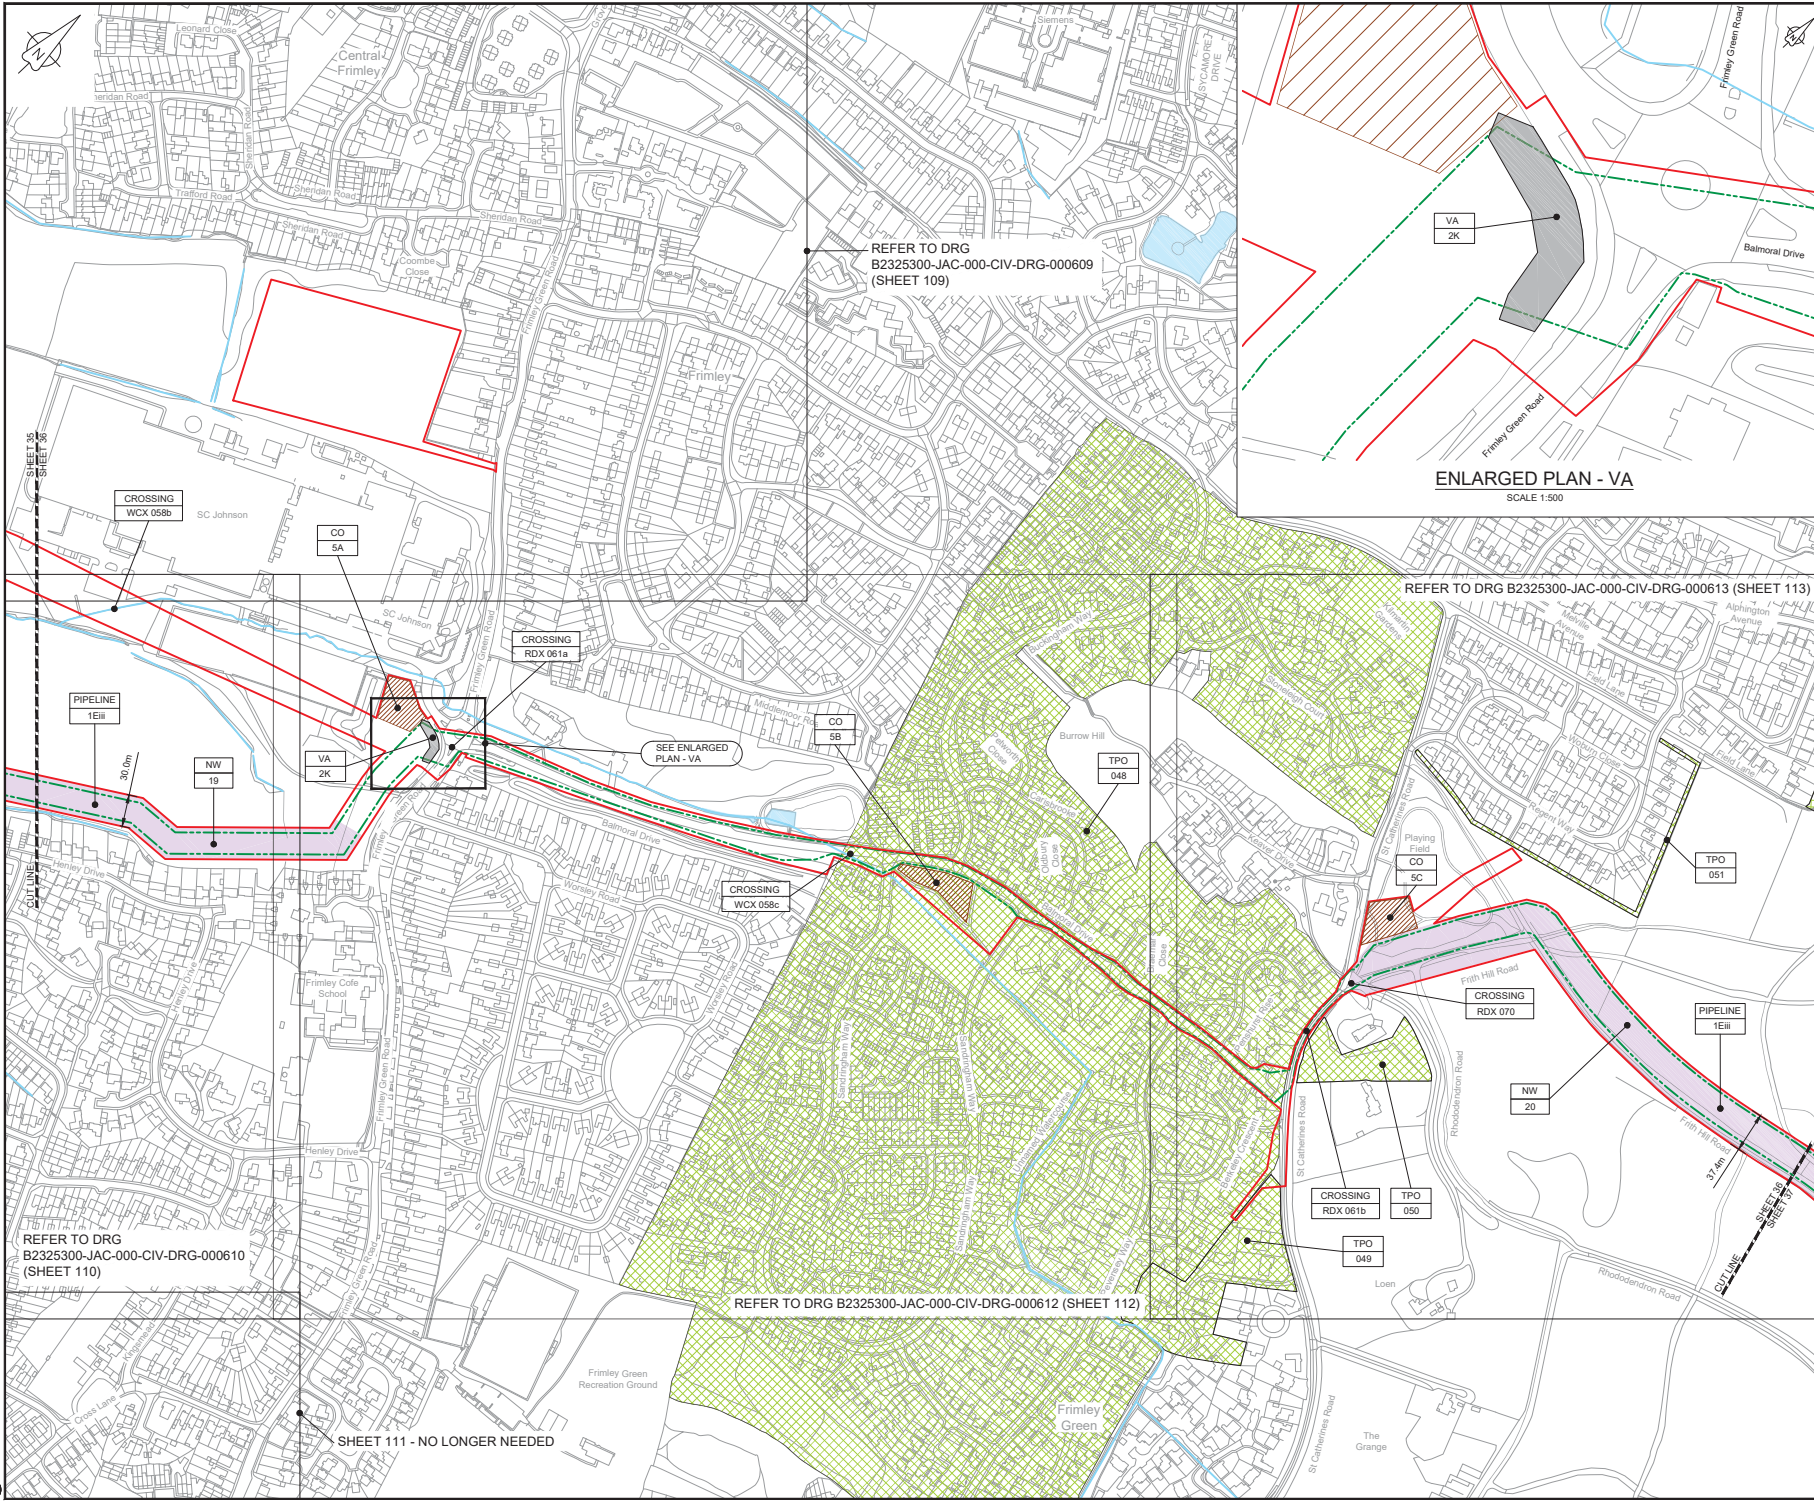


LOCATION PLAN  
SCALE 1:500,000

- NOTES
1. THIS DRAWING IS IN METRES UNLESS STATED OTHERWISE.
  2. TRENCHLESS CROSSINGS ARE INDICATIVE ONLY.

- LEGEND
- ORDER LIMITS
  - LIMITS OF DEVIATION
  - NARROW WORKING AREA (NW)
  - TRENCHLESS CROSSING (TC)
  - WATER BODIES
  - ABOVE GROUND INSTALLATION (AGI) / VALVE (VA) / PRESSURE TRANSDUCER (PT)
  - COMPOUND (CO)
  - TREE PRESERVATION ORDER (TPO)
  - DESCRIPTION
  - ID or WORK NUMBER (if applicable)
  - COMMENCEMENT / TERMINATION OF WORKS (COMMENCEMENT = OPEN, TERMINATION = CLOSED)

 Contains Ordnance Survey data © Crown copyright and database rights 2019.  
© Crown copyright and database rights 2019 OS Licence Number AL10005237.



CDI	03/05/19	0000 SUBMISSION	PC	JA	SC	PH
Rev.	Rev. Date	Purpose of revision	Drawn	Checked	Rev'd	Approved

**JACOBS**  
1180 Ewlish Road, Winchester, Hampshire, SO41 5TU  
Tel: +44(0)118 945 7000 • Fax: +44(0)118 945 7001  
www.jacobs.com

Client: Esso Petroleum Company Limited  
Emlyn House,  
Emlyn Way,  
Leatherhead,  
Surrey,  
KT22 8UX

Project: Southampton to London Pipeline Project

Drawing title: **GENERAL ARRANGEMENT SHEET 36**  
**REGULATION 5 (2)(O)**

Drawing status: **Fit for Stage Approval**

Scale	1:2500	DO NOT SCALE
Jacobs No.	B2325300	Rev
Client no.		CO1

Drawing number: **B2325300-JAC-000-CIV-DRG-000546**

C:\pwworking\jacobs\_uk\_water\utilities\_s44\byproj\drms\3513\B2325300-JAC-000-CIV-DRG-000546.dwg - 03/05/2019 14:45:50 - A\Framo - B Taylor

SHEET 36  
SHEET 35

REFER TO DRG  
B2325300-JAC-000-CIV-DRG-000610  
(SHEET 110)


REFER TO DRG B2325300-JAC-000-CIV-DRG-000613 (SHEET 113)

REFER TO DRG B2325300-JAC-000-CIV-DRG-000612 (SHEET 112)

SHEET 111 - NO LONGER NEEDED

REFER TO DRG  
B2325300-JAC-000-CIV-DRG-000609  
(SHEET 109)



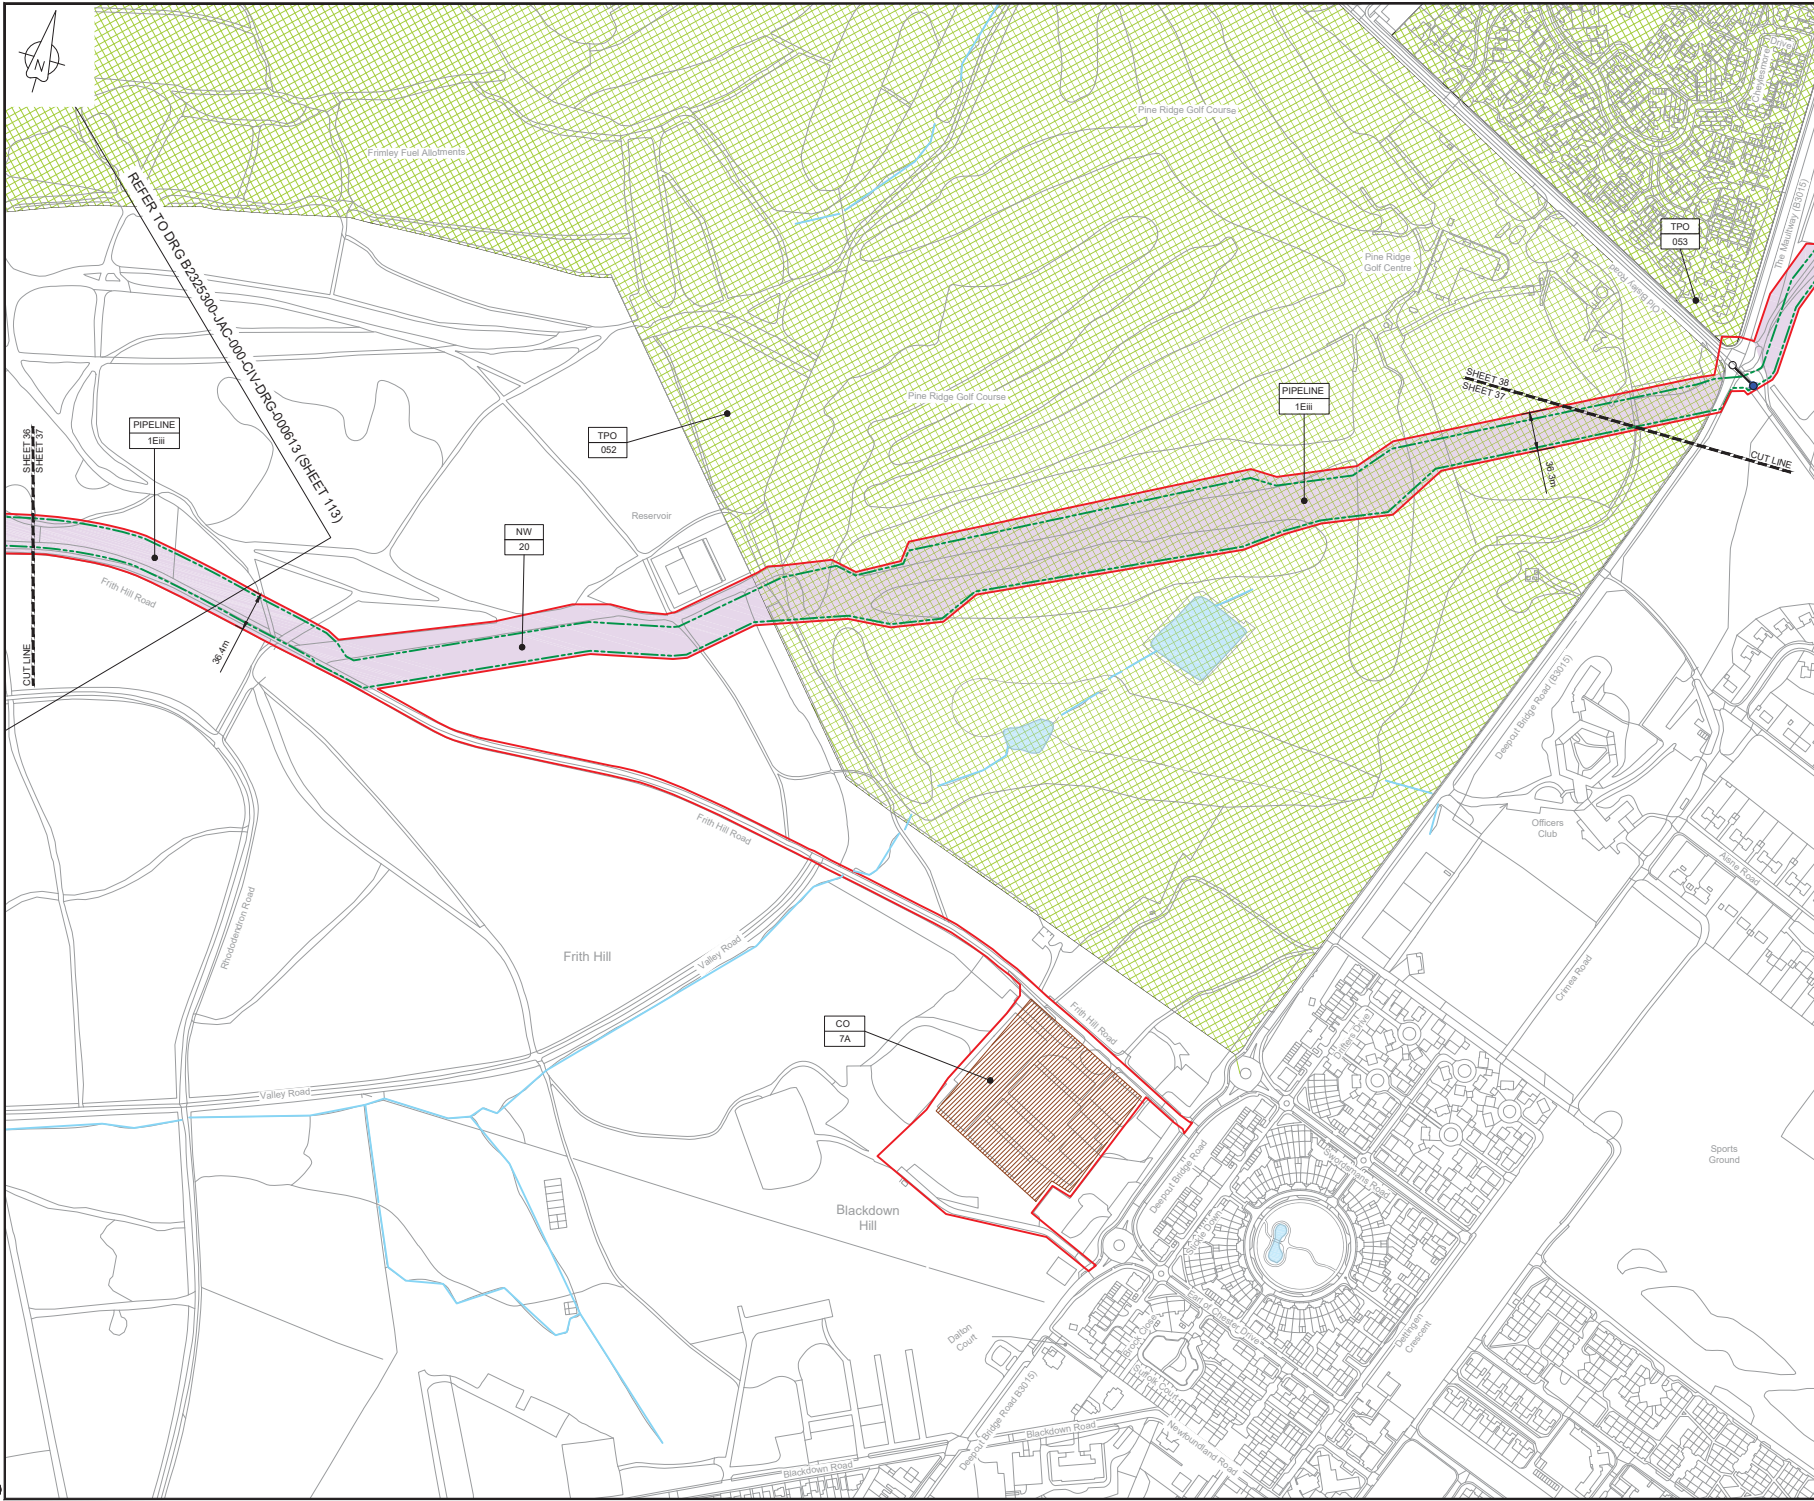

LOCATION PLAN  
SCALE 1:500,000

- NOTES**
- THIS DRAWING IS IN METRES UNLESS STATED OTHERWISE.
  - TRENCHLESS CROSSINGS ARE INDICATIVE ONLY.

- LEGEND**
- ORDER LIMITS
  - LIMITS OF DEVIATION
  - NARROW WORKING AREA (NW)
  - TRENCHLESS CROSSING (TC)
  - WATER BODIES
  - ABOVE GROUND INSTALLATION (AGI) / VALVE (VA) / PRESSURE TRANSDUCER (PT)
  - COMPOUND (CO)
  - TREE PRESERVATION ORDER (TPO)
- DESCRIPTION**
- ID or WORK NUMBER (if applicable)
  - COMMENCEMENT / TERMINATION OF WORKS  
(COMMENCEMENT = OPEN, TERMINATION = CLOSED)

Contains Ordnance Survey data © Crown copyright and database rights 2019.

© Crown copyright and database rights 2019 OS Licence Number AL10005237.



CSI	03/05/19	0001 SUBMISSION	PC	JA	SC	PH
Rev.	Rev. Date	Purpose of revision	Drawn	Checked	Rev'd	Approved

**JACOBS**  
1180 Epsom Road, Winchester, Hampshire, RG41 5TU  
Tel: +44(0)118 946 7000 • Fax: +44(0)118 946 7001  
www.jacobs.com

Client: Esso Petroleum Company, Limited  
Emlyn House,  
Emlyn Way,  
Leatherhead,  
Surrey,  
KT22 8UX

Project: Southampton to London Pipeline Project


Drawing title:  
**GENERAL ARRANGEMENT  
SHEET 37  
REGULATION 5 (2)(O)**

Drawing status: **Fit for Stage Approval**

Scale	1:2500	DO NOT SCALE
Jacobs No.	B2325300	Rev
Client no.		CO1

Drawing number: **B2325300-JAC-000-CIV-DRG-000547**



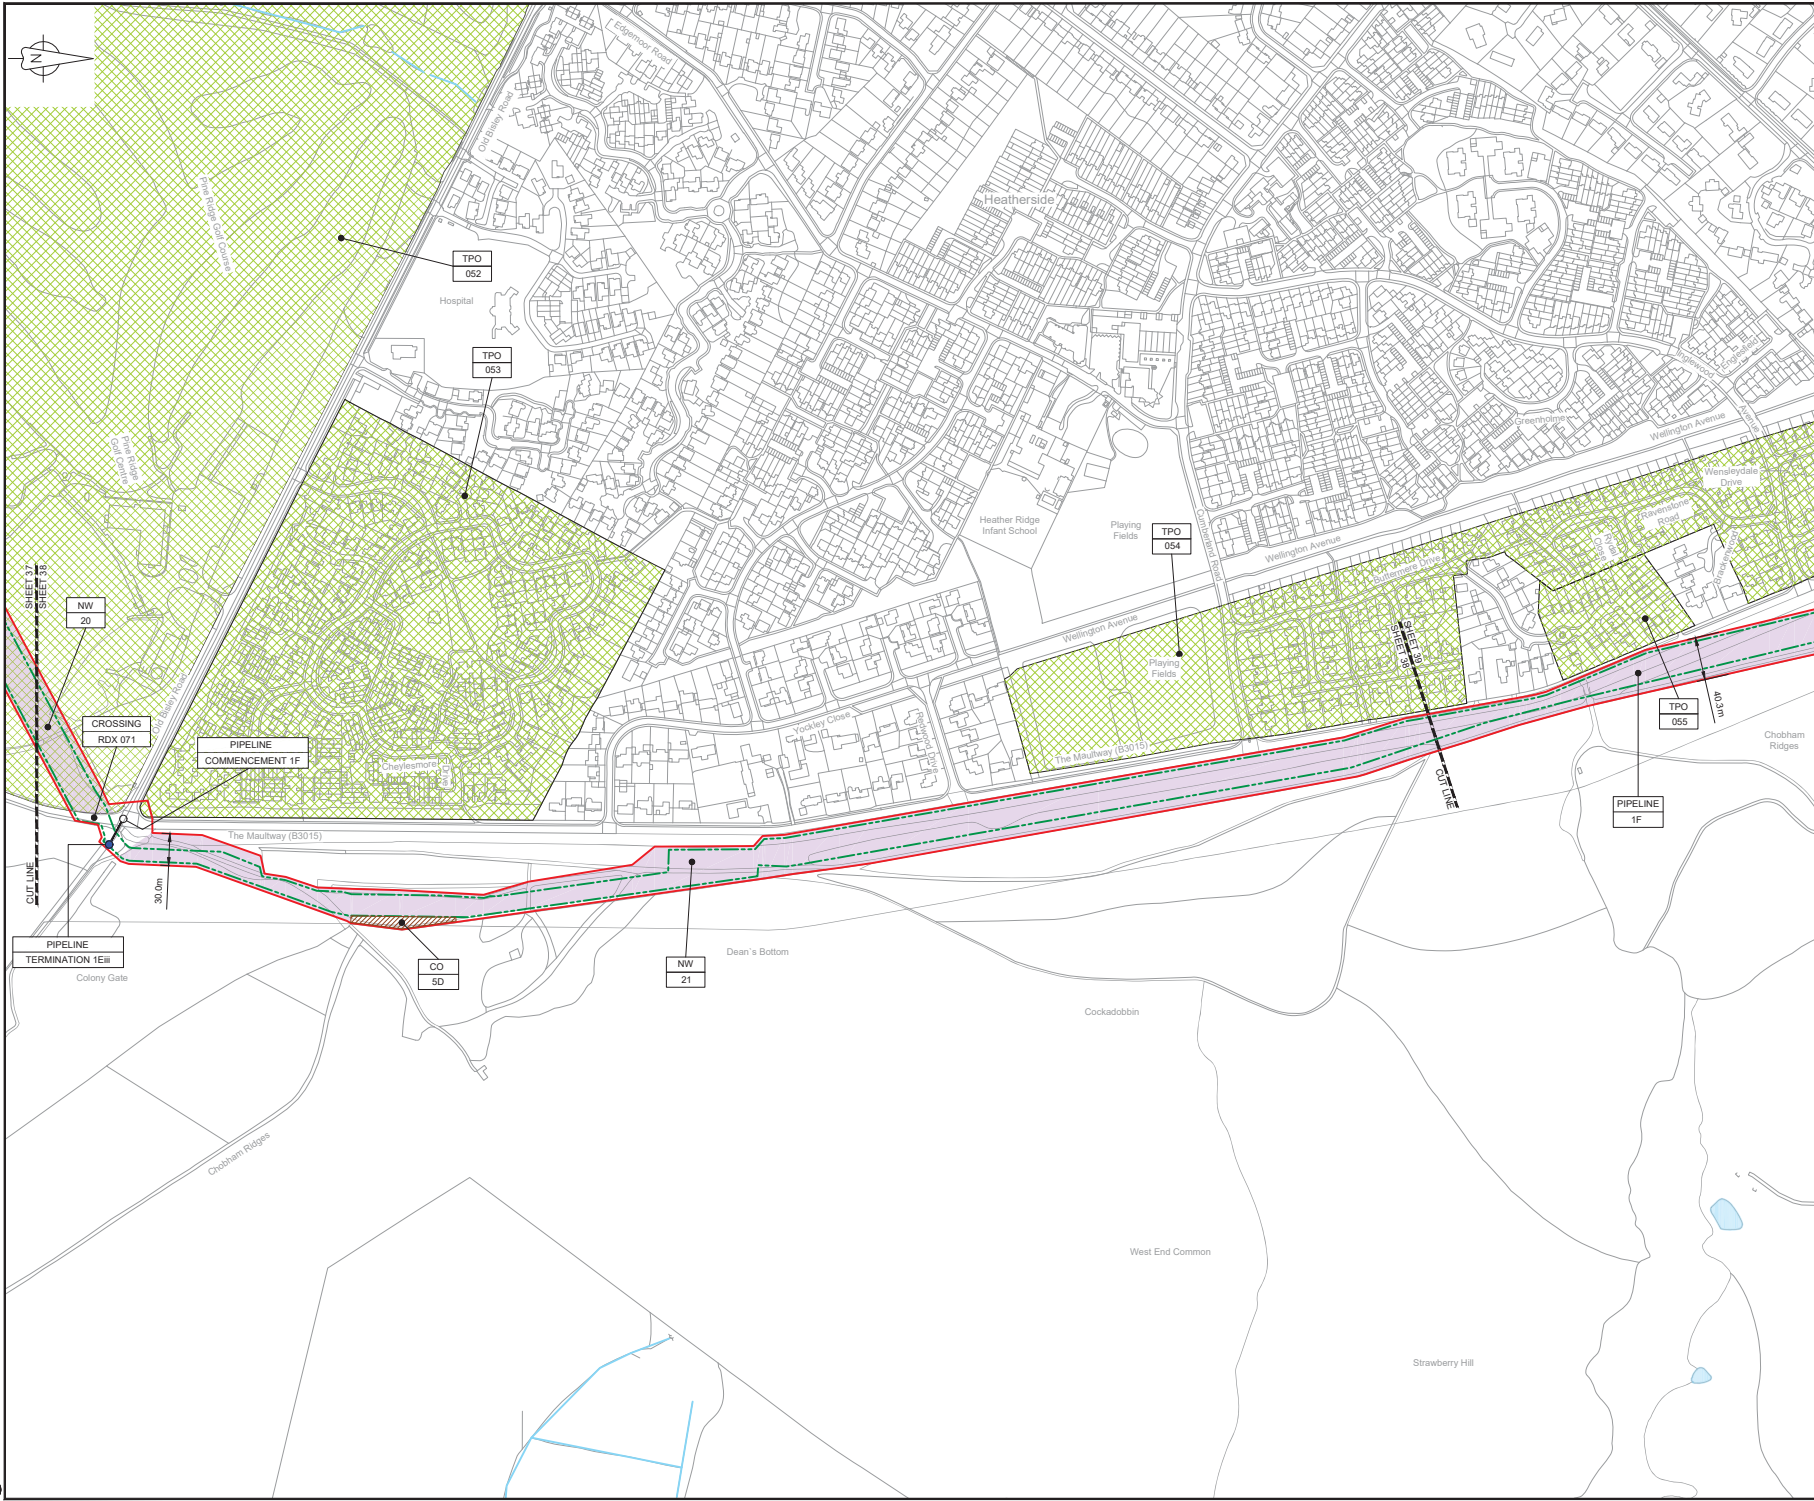


LOCATION PLAN  
SCALE 1:500,000

- NOTES**
1. THIS DRAWING IS IN METRES UNLESS STATED OTHERWISE.
  2. TRENCHLESS CROSSINGS ARE INDICATIVE ONLY.

- LEGEND**
- ORDER LIMITS
  - LIMITS OF DEVIATION
  - NARROW WORKING AREA (NW)
  - TRENCHLESS CROSSING (TC)
  - WATER BODIES
  - ABOVE GROUND INSTALLATION (AGI) / VALVE (VA) / PRESSURE TRANSDUCER (PT)
  - COMPOUND (CO)
  - TREE PRESERVATION ORDER (TPO)
  - DESCRIPTION
  - ID or WORK NUMBER (if applicable)
  - COMMENCEMENT / TERMINATION OF WORKS (COMMENCEMENT = OPEN, TERMINATION = CLOSED)

 Contains Ordnance Survey data © Crown copyright and database rights 2019.  
© Crown copyright and database rights 2019 OS Licence Number AL10005237.



CD	Rev	Date	DESCRIPTION	PC	JA	SC	PH
C01	03/05/19						

**JACOBS**  
1180 Ewks Rd, Wokingham, Wokingham, RG41 5TU  
Tel: +44(0)118 946 7000 • Fax: +44(0)118 946 7001  
www.jacobs.com

Client: Esso Petroleum Company, Limited  
Emryn House,  
Emryn Way,  
Leatherhead,  
Surrey,  
KT22 8UX

Project: Southampton to London Pipeline Project


Drawing title:  
**GENERAL ARRANGEMENT  
SHEET 38  
REGULATION 5 (2)(O)**

Drawing status: **Fit for Stage Approval**

Scale	1:2500	DO NOT SCALE
Jacobs No.	B2325300	Rev
Client no.		Rev
Drawing number		<b>C01</b>

Drawing number: **B2325300-JAC-000-CIV-DRG-000548**



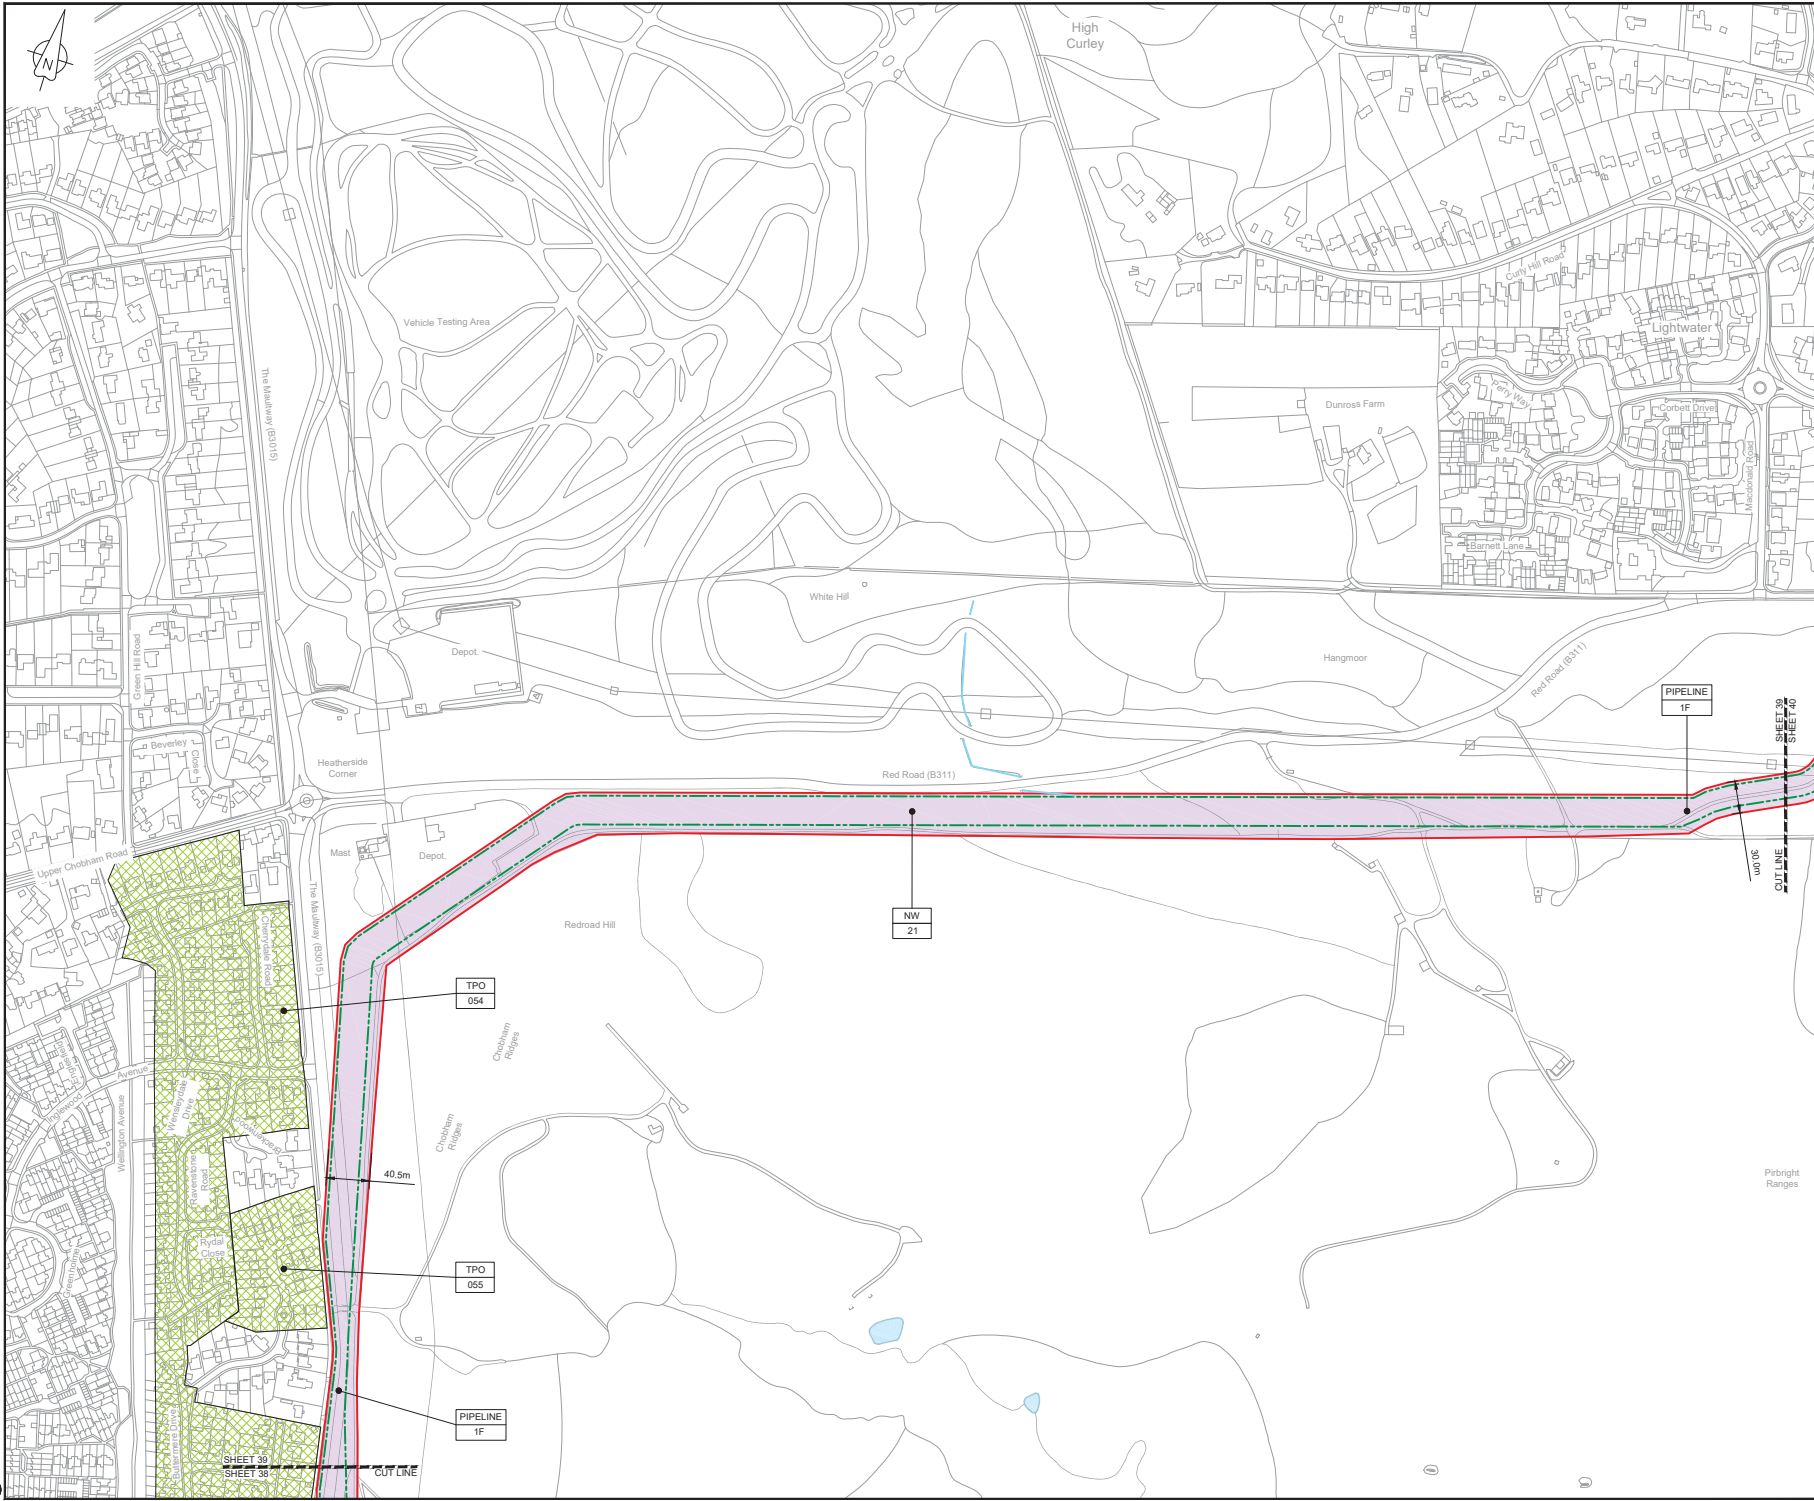

LOCATION PLAN  
SCALE 1:500,000

- NOTES**
- THIS DRAWING IS IN METRES UNLESS STATED OTHERWISE.
  - TRENCHLESS CROSSINGS ARE INDICATIVE ONLY.

- LEGEND**
- ORDER LIMITS
  - LIMITS OF DEVIATION
  - NARROW WORKING AREA (NW)
  - TRENCHLESS CROSSING (TC)
  - WATER BODIES
  - ABOVE GROUND INSTALLATION (AGI) / VALVE (VA) / PRESSURE TRANSDUCER (PT)
  - COMPOUND (CO)
  - TREE PRESERVATION ORDER (TPO)
  - DESCRIPTION
  - ID or WORK NUMBER (if applicable)
  - COMMENCEMENT / TERMINATION OF WORKS (COMMENCEMENT = OPEN, TERMINATION = CLOSED)

Contains Ordnance Survey data © Crown copyright and database rights 2019.  
© Crown copyright and database rights 2019 OS Licence Number AL100005237.



Rev.	Rev. Date	Purpose of revision	PC	JA	SC	PH
C01	03/05/19	ISSUE FOR SUBMISSION				



Client: Esso Petroleum Company, Limited  
Emlyn House,  
Emlyn Way,  
Leatherhead,  
Surrey,  
KT22 8UX




Drawing title  
**GENERAL ARRANGEMENT  
SHEET 39  
REGULATION 5 (2)(O)**

Drawing status: **Fit for Stage Approval**

Scale	1:2500	DO NOT SCALE
Jacobs No.	B2325300	Rev
Client no.	B2325300	Rev
Drawing number	C01	

B2325300-JAC-000-CIV-DRG-000549

C:\working\jacobs\_uk\_water\utilities\_s44\byproj\drms\B2325300-JAC-000-CIV-DRG-000549.dwg - 03/05/2019 13:45:10 - A1Frame - BTaylor

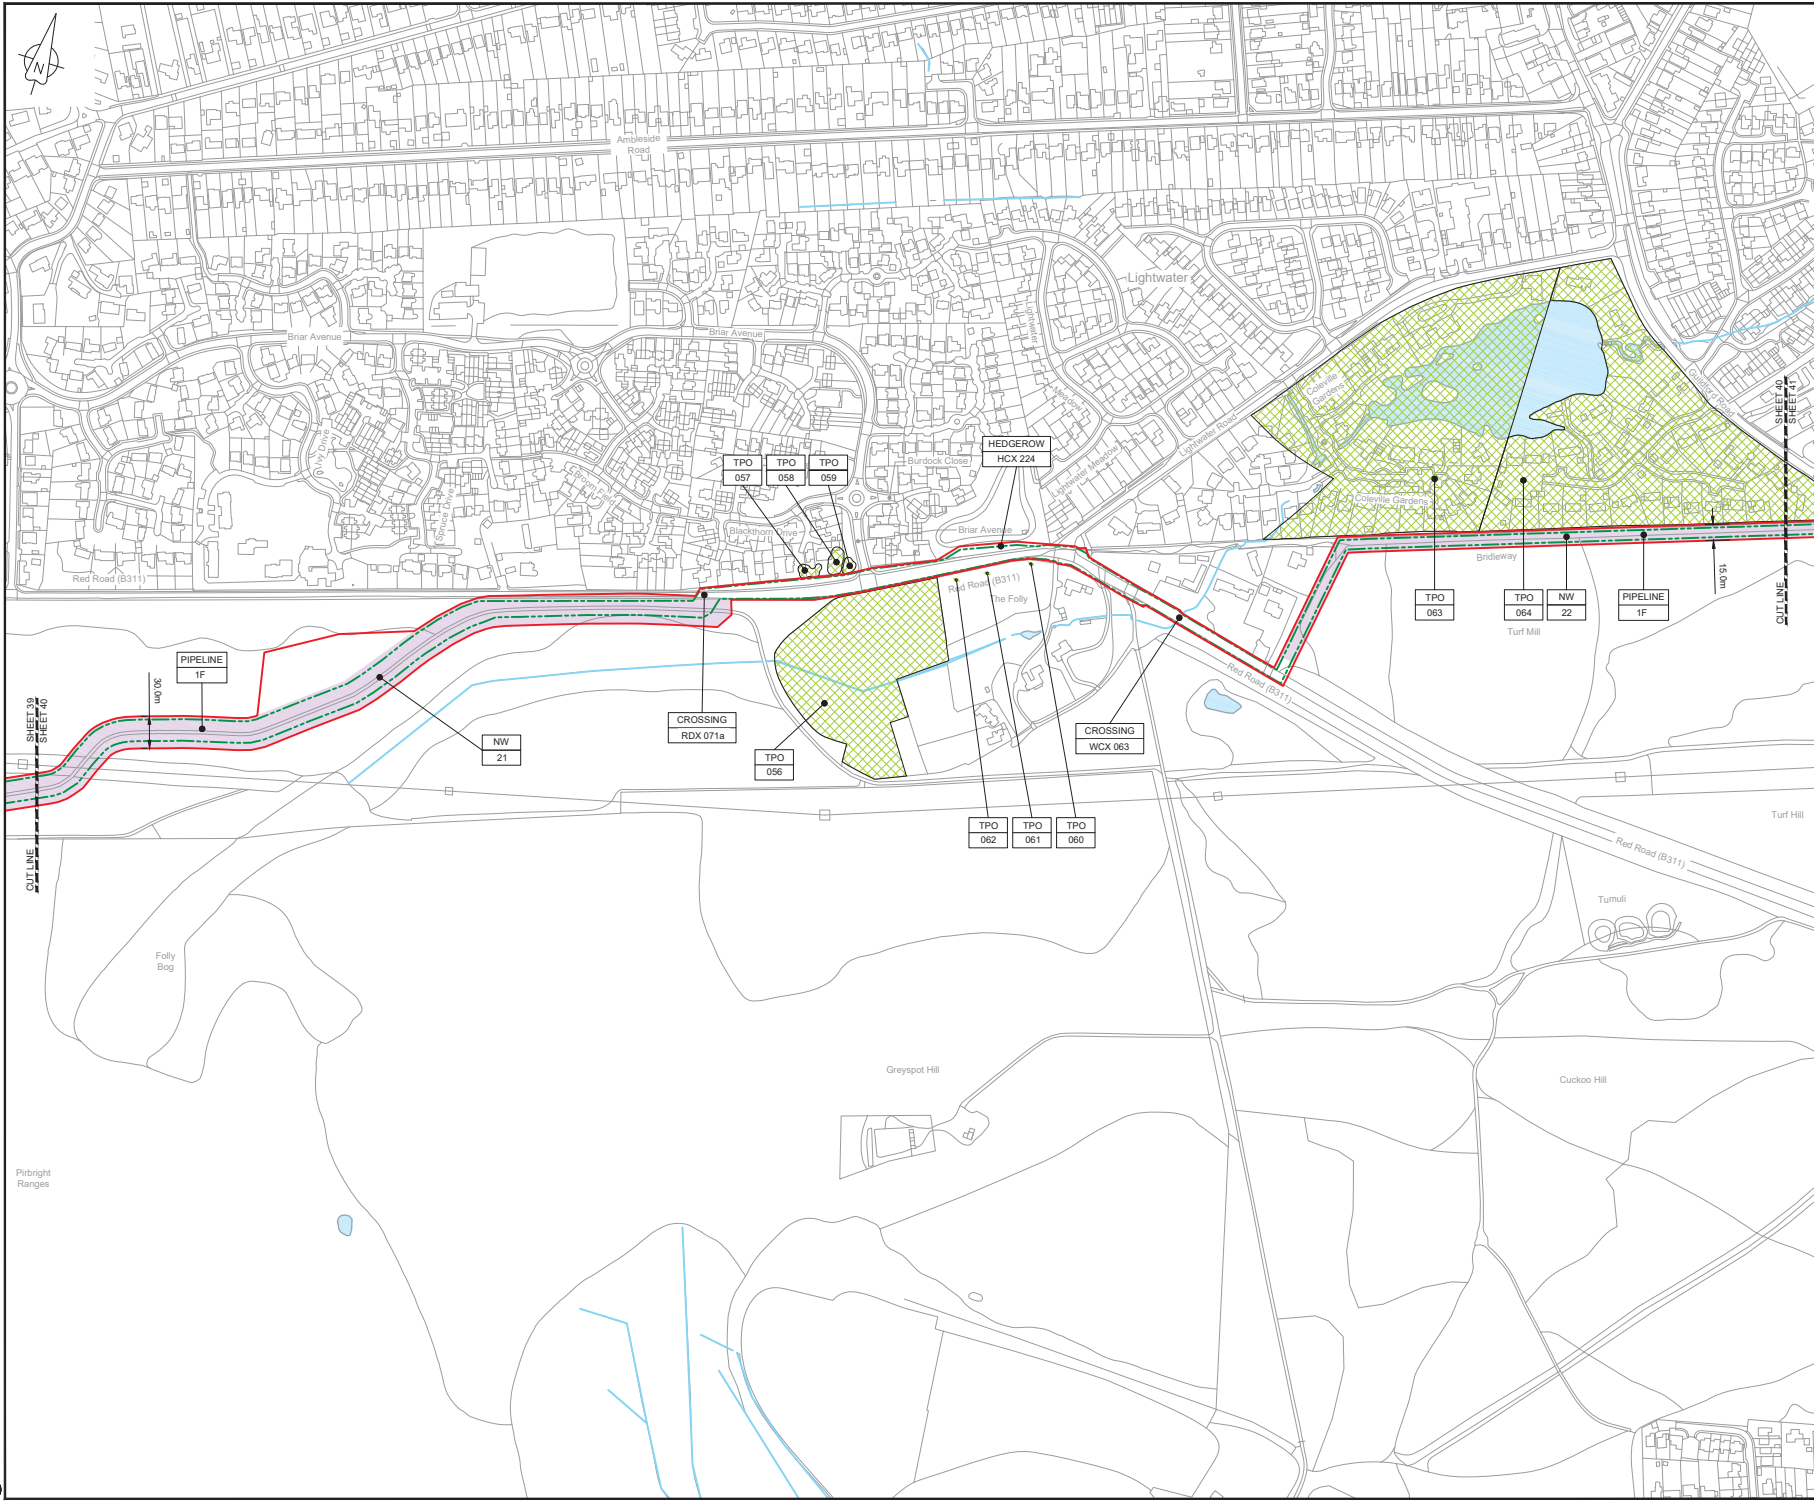

LOCATION PLAN  
SCALE 1:500,000

- NOTES**
- THIS DRAWING IS IN METRES UNLESS STATED OTHERWISE.
  - TRENCHLESS CROSSINGS ARE INDICATIVE ONLY.

- LEGEND**
- ORDER LIMITS
  - LIMITS OF DEVIATION
  - NARROW WORKING AREA (NW)
  - TRENCHLESS CROSSING (TC)
  - WATER BODIES
  - ABOVE GROUND INSTALLATION (AGI) / VALVE (VA) / PRESSURE TRANSDUCER (PT)
  - COMPOUND (CO)
  - TREE PRESERVATION ORDER (TPO)
  - DESCRIPTION
  - ID or WORK NUMBER (if applicable)
  - COMMENCEMENT / TERMINATION OF WORKS (COMMENCEMENT = OPEN, TERMINATION = CLOSED)

Contains Ordnance Survey data © Crown copyright and database rights 2019.  
© Crown copyright and database rights 2019 OS Licence Number AL10005237.



CDI	03/05/19	0003/0000000000	PC	JA	SC	PH
Rev.	Rev. Date	Purpose of revision	Drawn	Checked	Rev'd	Approved

**JACOBS**  
1180 Ewks Rd, Winchester, Hampshire, RG41 5TU  
Tel: +44(0)118 945 7000 • Fax: +44(0)118 945 7001  
www.jacobs.com

Client: Esso Petroleum Company, Limited  
Emlyn House,  
Emlyn Way,  
Leatherhead,  
Surrey,  
KT22 8UX

Project: Southampton to London Pipeline Project


Drawing title:  
**GENERAL ARRANGEMENT  
SHEET 40  
REGULATION 5 (2)(O)**

Drawing status: **Fit for Stage Approval**

Scale	1:2500	DO NOT SCALE
Jacobs No.	B2325300	Rev
Client no.		Rev

Drawing number:  
**B2325300-JAC-000-CIV-DRG-000550**



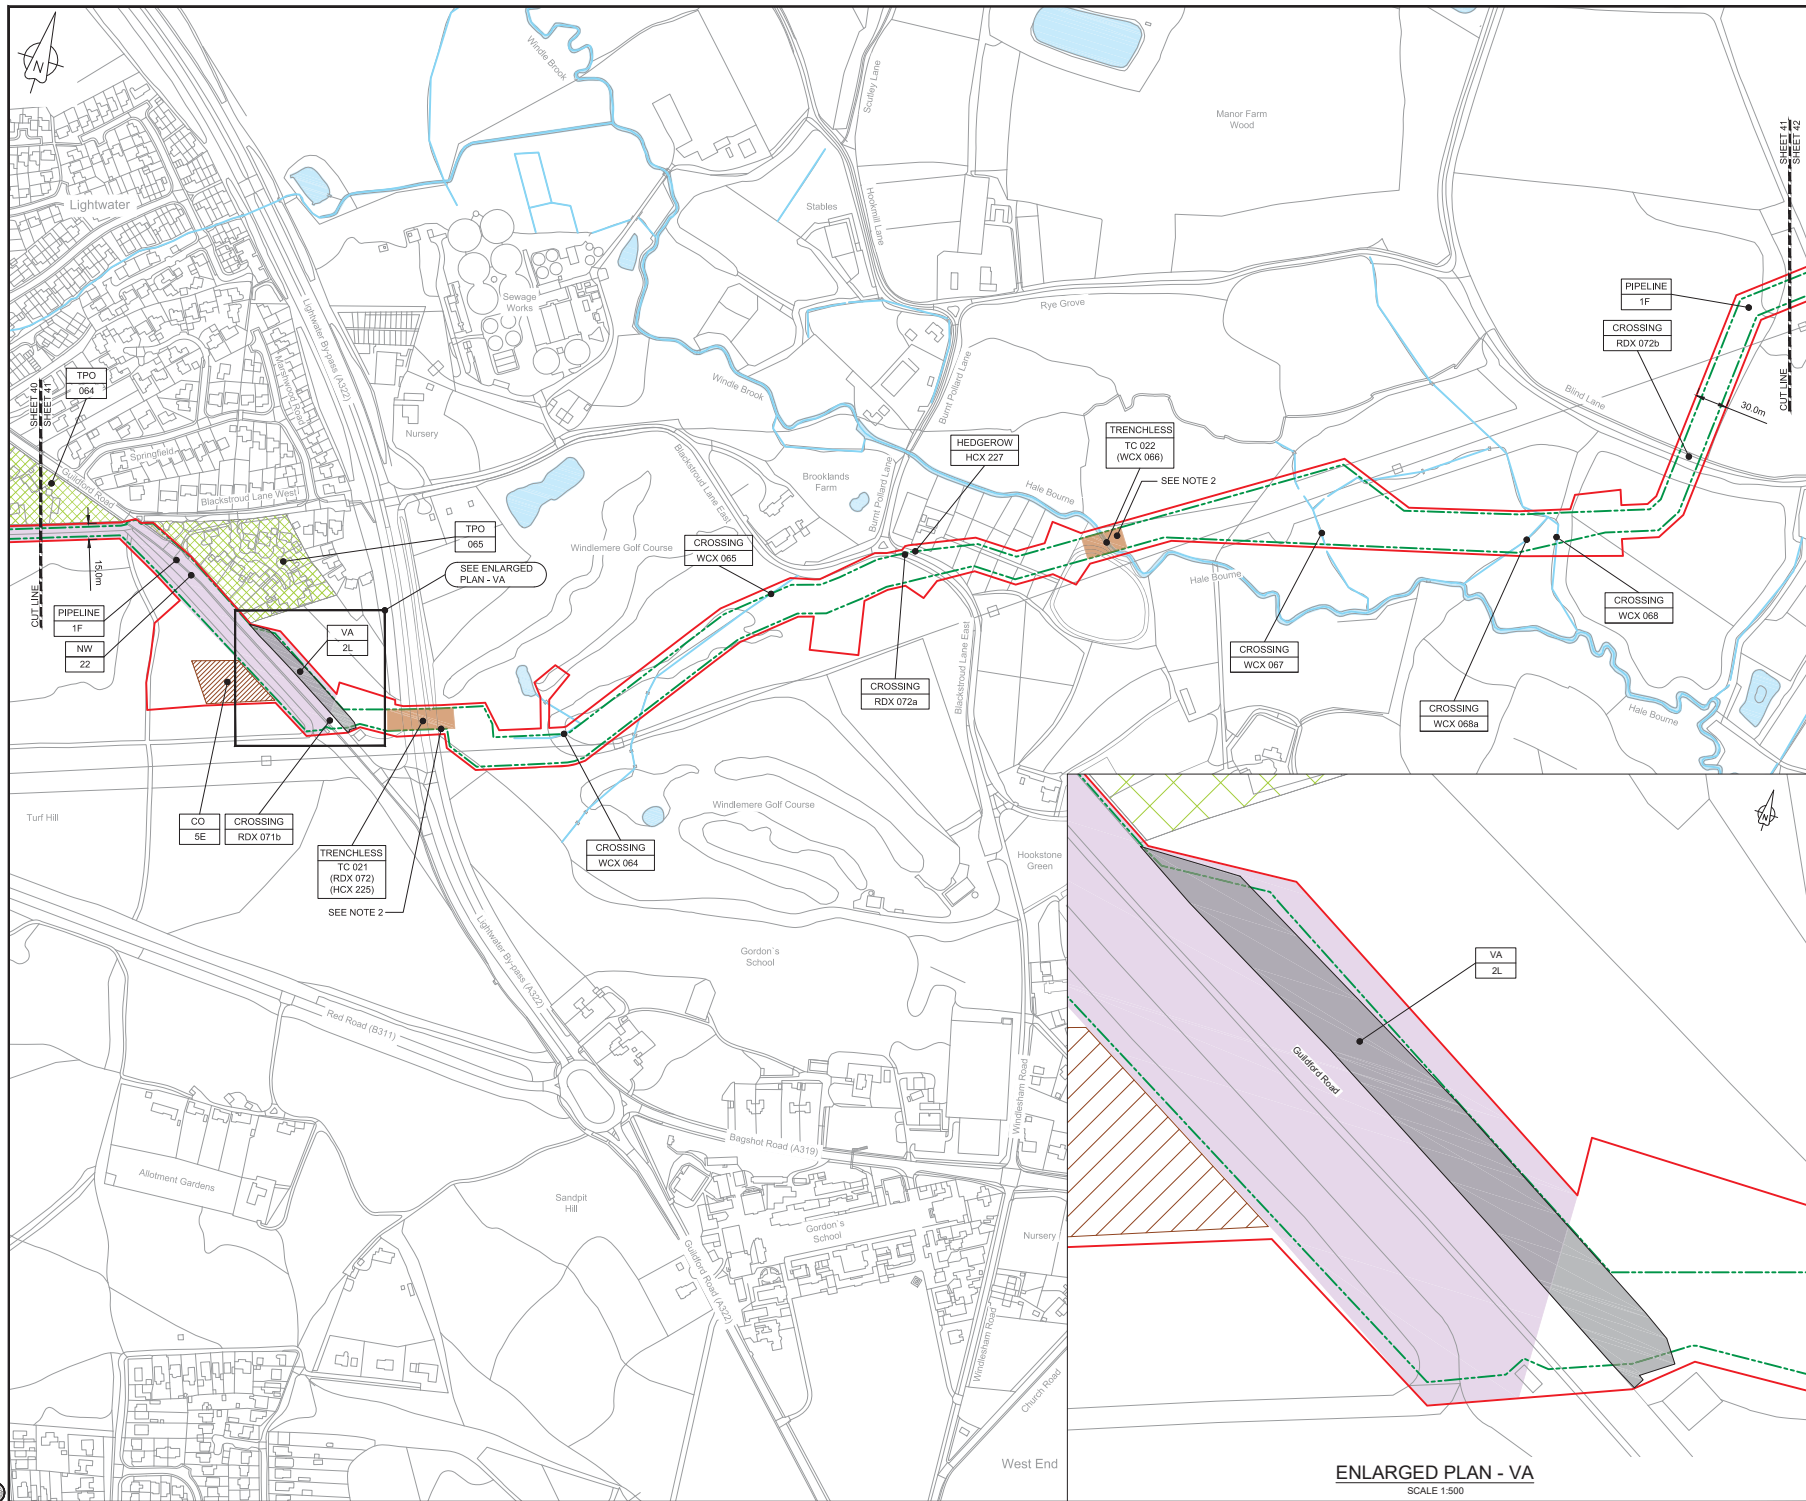


LOCATION PLAN  
SCALE 1:500,000

- NOTES**
1. THIS DRAWING IS IN METRES UNLESS STATED OTHERWISE.
  2. TRENCHLESS CROSSINGS ARE INDICATIVE ONLY.

- LEGEND**
- ORDER LIMITS
  - LIMITS OF DEVIATION
  - NARROW WORKING AREA (NW)
  - TRENCHLESS CROSSING (TC)
  - WATER BODIES
  - ABOVE GROUND INSTALLATION (AGI) / VALVE (VA) / PRESSURE TRANSDUCER (PT)
  - COMPOUND (CO)
  - TREE PRESERVATION ORDER (TPO)
  - DESCRIPTION
  - ID or WORK NUMBER (if applicable)
  - COMMENCEMENT / TERMINATION OF WORKS (COMMENCEMENT = OPEN, TERMINATION = CLOSED)

Contains Ordnance Survey data © Crown copyright and database rights 2019.

© Crown copyright and database rights 2019 OS Licence Number AL10005237.

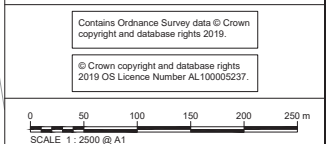

CD	03/05/19	0001 SUBMISSION	PC	JA	SC	PH
Rev.	Rev. Date	Purpose of revision	Drawn	Checked	Rev'd	Approved

**JACOBS**  
1180 Epsom Road, Wokingham, Wokingham, RG41 5TU  
Tel: +44(0)118 946 7000 • Fax: +44(0)118 946 7001  
www.jacobs.com

Client: Esso Petroleum Company, Limited  
Emryn House,  
Emryn Way,  
Leatherhead,  
Surrey,  
KT22 8UX

Project: Southampton to London Pipeline Project


Drawing title:  
**GENERAL ARRANGEMENT  
SHEET 41  
REGULATION 5 (2)(O)**

Drawing status: **Fit for Stage Approval**

Scale	1:2500	DO NOT SCALE
Scale	1:2500	DO NOT SCALE
Jacobs No.	B2325300	Rev
Client no.	B2325300	Rev
Drawing number	B2325300-JAC-000-CIV-DRG-000551	Rev
		<b>CO1</b>

**ENLARGED PLAN - VA**  
SCALE 1:500

C:\pwworking\jacobs\_uk\_water\utilities\_s41\agis\jms35193253000-JAC-000-CIV-DRG-000551.dwg - 03/05/2019 14:23:36 - A1 Frame - Agis.dwg

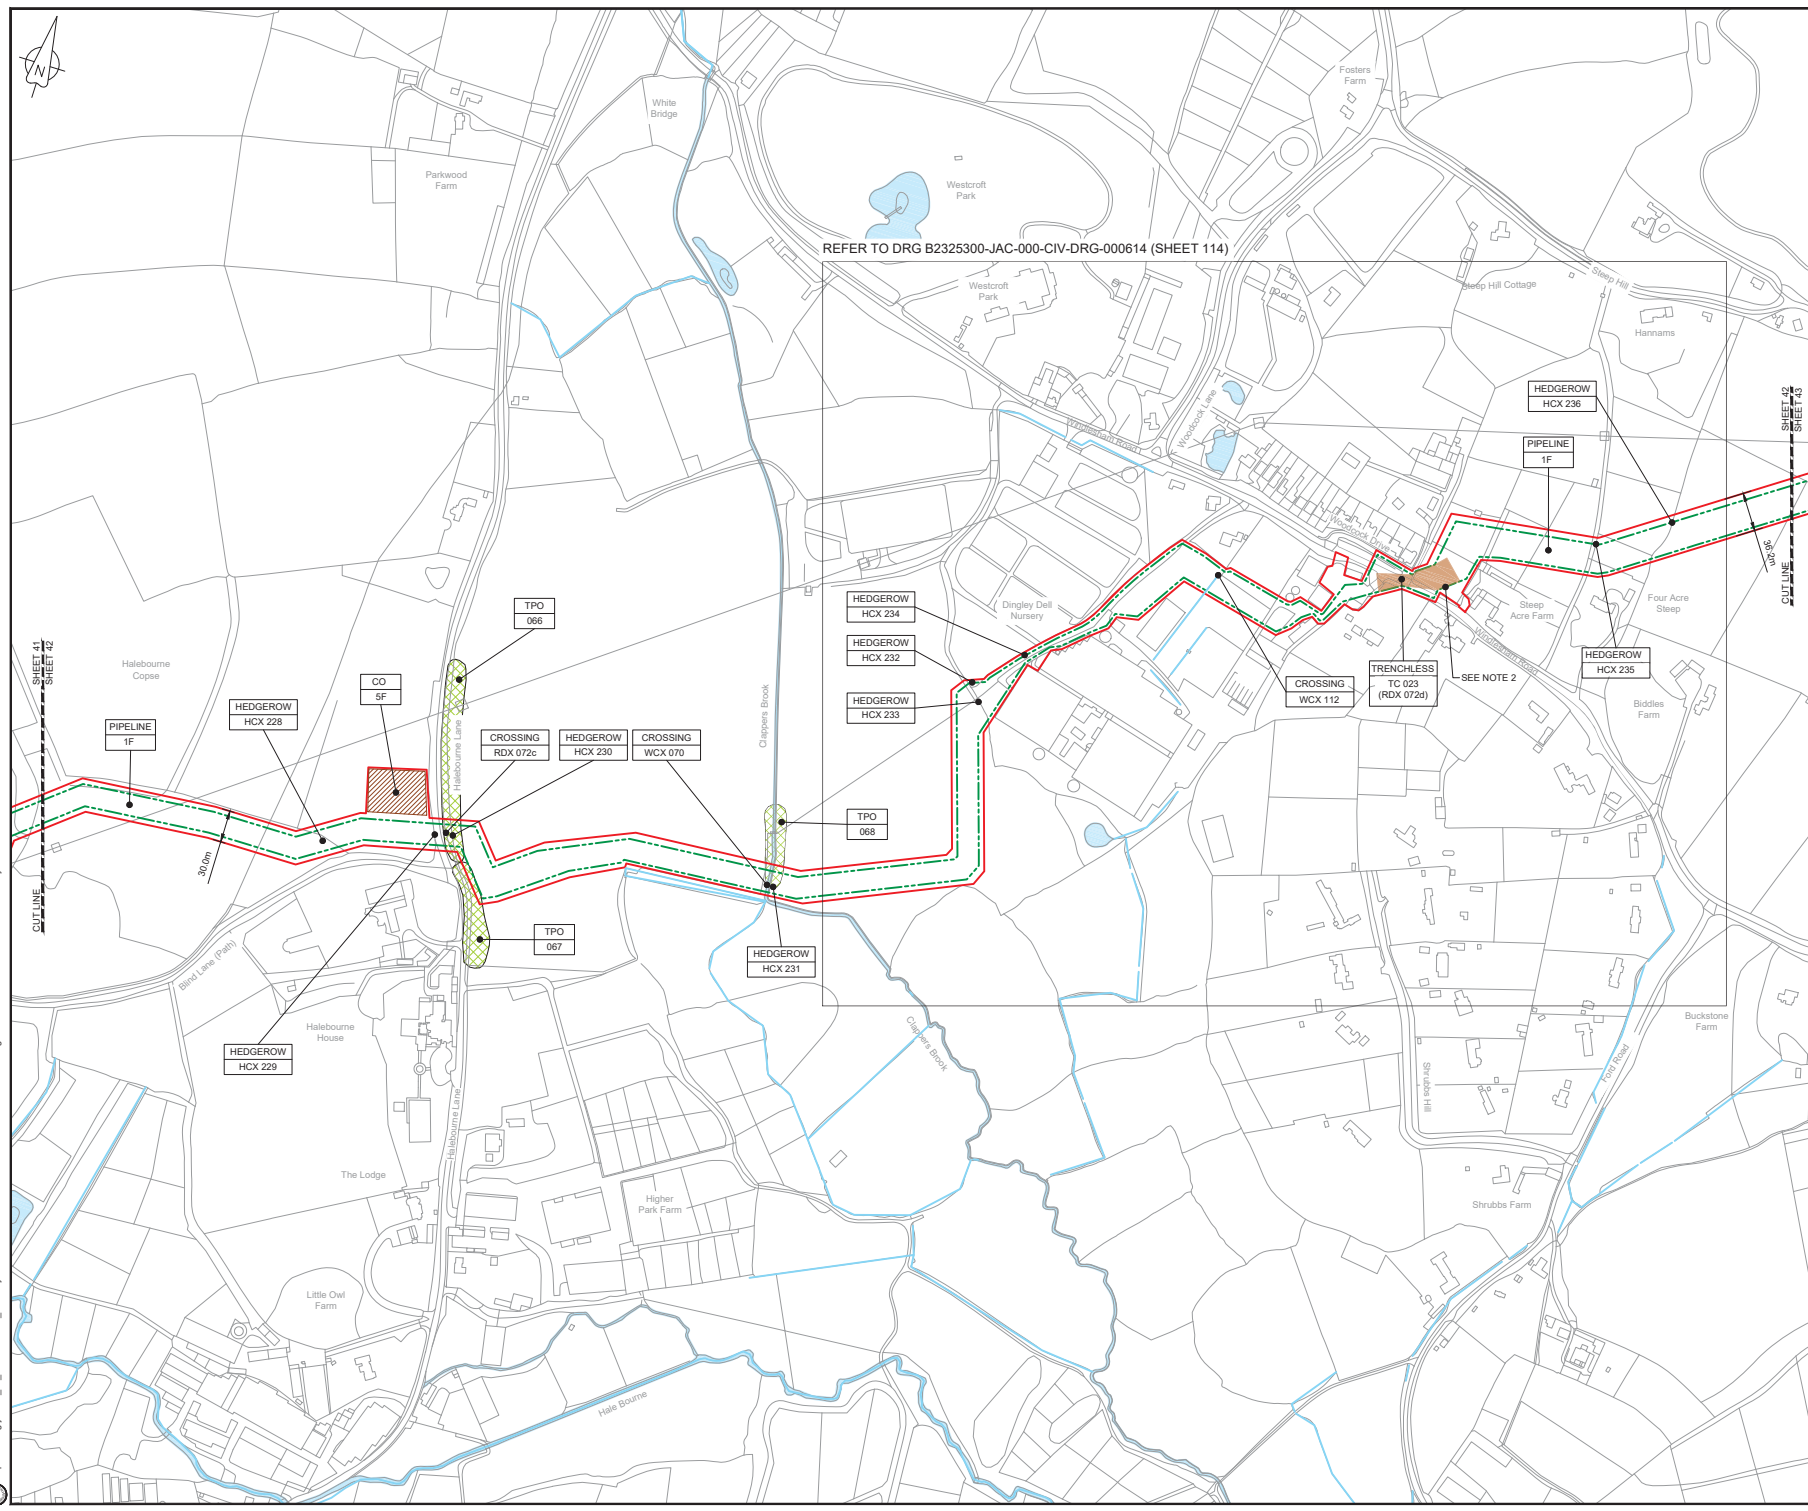

REFER TO DRG B2325300-JAC-000-CIV-DRG-000614 (SHEET 114)



LOCATION PLAN  
SCALE 1:500,000

- NOTES**
- THIS DRAWING IS IN METRES UNLESS STATED OTHERWISE.
  - TRENCHLESS CROSSINGS ARE INDICATIVE ONLY.

**LEGEND**

<span style="color:red">—</span>	ORDER LIMITS
<span style="color:green">- - -</span>	LIMITS OF DEVIATION
<span style="border: 1px solid purple; width: 20px; height: 10px; display: inline-block;"></span>	NARROW WORKING AREA (NW)
<span style="background-color: #f4a460; width: 20px; height: 10px; display: inline-block;"></span>	TRENCHLESS CROSSING (TC)
<span style="color:blue">—</span>	WATER BODIES
<span style="background-color: #cccccc; width: 20px; height: 10px; display: inline-block;"></span>	ABOVE GROUND INSTALLATION (AGI) / VALVE (VA) / PRESSURE TRANSDUCER (PT)
<span style="background-color: #ffcc00; width: 20px; height: 10px; display: inline-block;"></span>	COMPOUND (CO)
<span style="border: 1px dashed green; width: 20px; height: 10px; display: inline-block;"></span>	TREE PRESERVATION ORDER (TPO)
<span style="border: 1px solid black; width: 20px; height: 10px; display: inline-block;"></span>	DESCRIPTION
<span style="border: 1px solid black; width: 20px; height: 10px; display: inline-block;"></span>	ID or WORK NUMBER (if applicable)
<span style="color:blue">●</span>	COMMENCEMENT / TERMINATION OF WORKS (COMMENCEMENT = OPEN, TERMINATION = CLOSED)

Contains Ordnance Survey data © Crown copyright and database rights 2019.

© Crown copyright and database rights 2019 OS Licence Number AL10005237.



CD	03/25/19	0000	0000	PC	JA	SC	PH
Rev.	Rev. Date	Purpose of revision		Drawn	Checked	Rev'd	Approved

**JACOBS**  
1180 Epsom Road, Wokingham, Wokingham, RG41 5TU  
Tel: +44(0)118 946 7000 • Fax: +44(0)118 946 7001  
www.jacobs.com

Client: Esso Petroleum Company, Limited  
Ermyn House,  
Ermyn Way,  
Leatherhead,  
Surrey,  
KT22 8UX

Project: **Esso** | Southampton to London Pipeline Project


Drawing title:  
**GENERAL ARRANGEMENT  
SHEET 42  
REGULATION 5 (2)(O)**

Drawing status: **Fit for Stage Approval**

Scale	1:2500	DO NOT SCALE
Jacobs No.	B2325300	Rev
Client no.		<b>CO1</b>
Drawing number	<b>B2325300-JAC-000-CIV-DRG-000552</b>	

C:\pwworking\jacobs\_uk\_water\utilities\_sas4\tdp\tdms\3513\B2325300-JAC-000-CIV-DRG-000552.dwg - 03/05/2019 12:43:21 - A1Frame - BTaylor



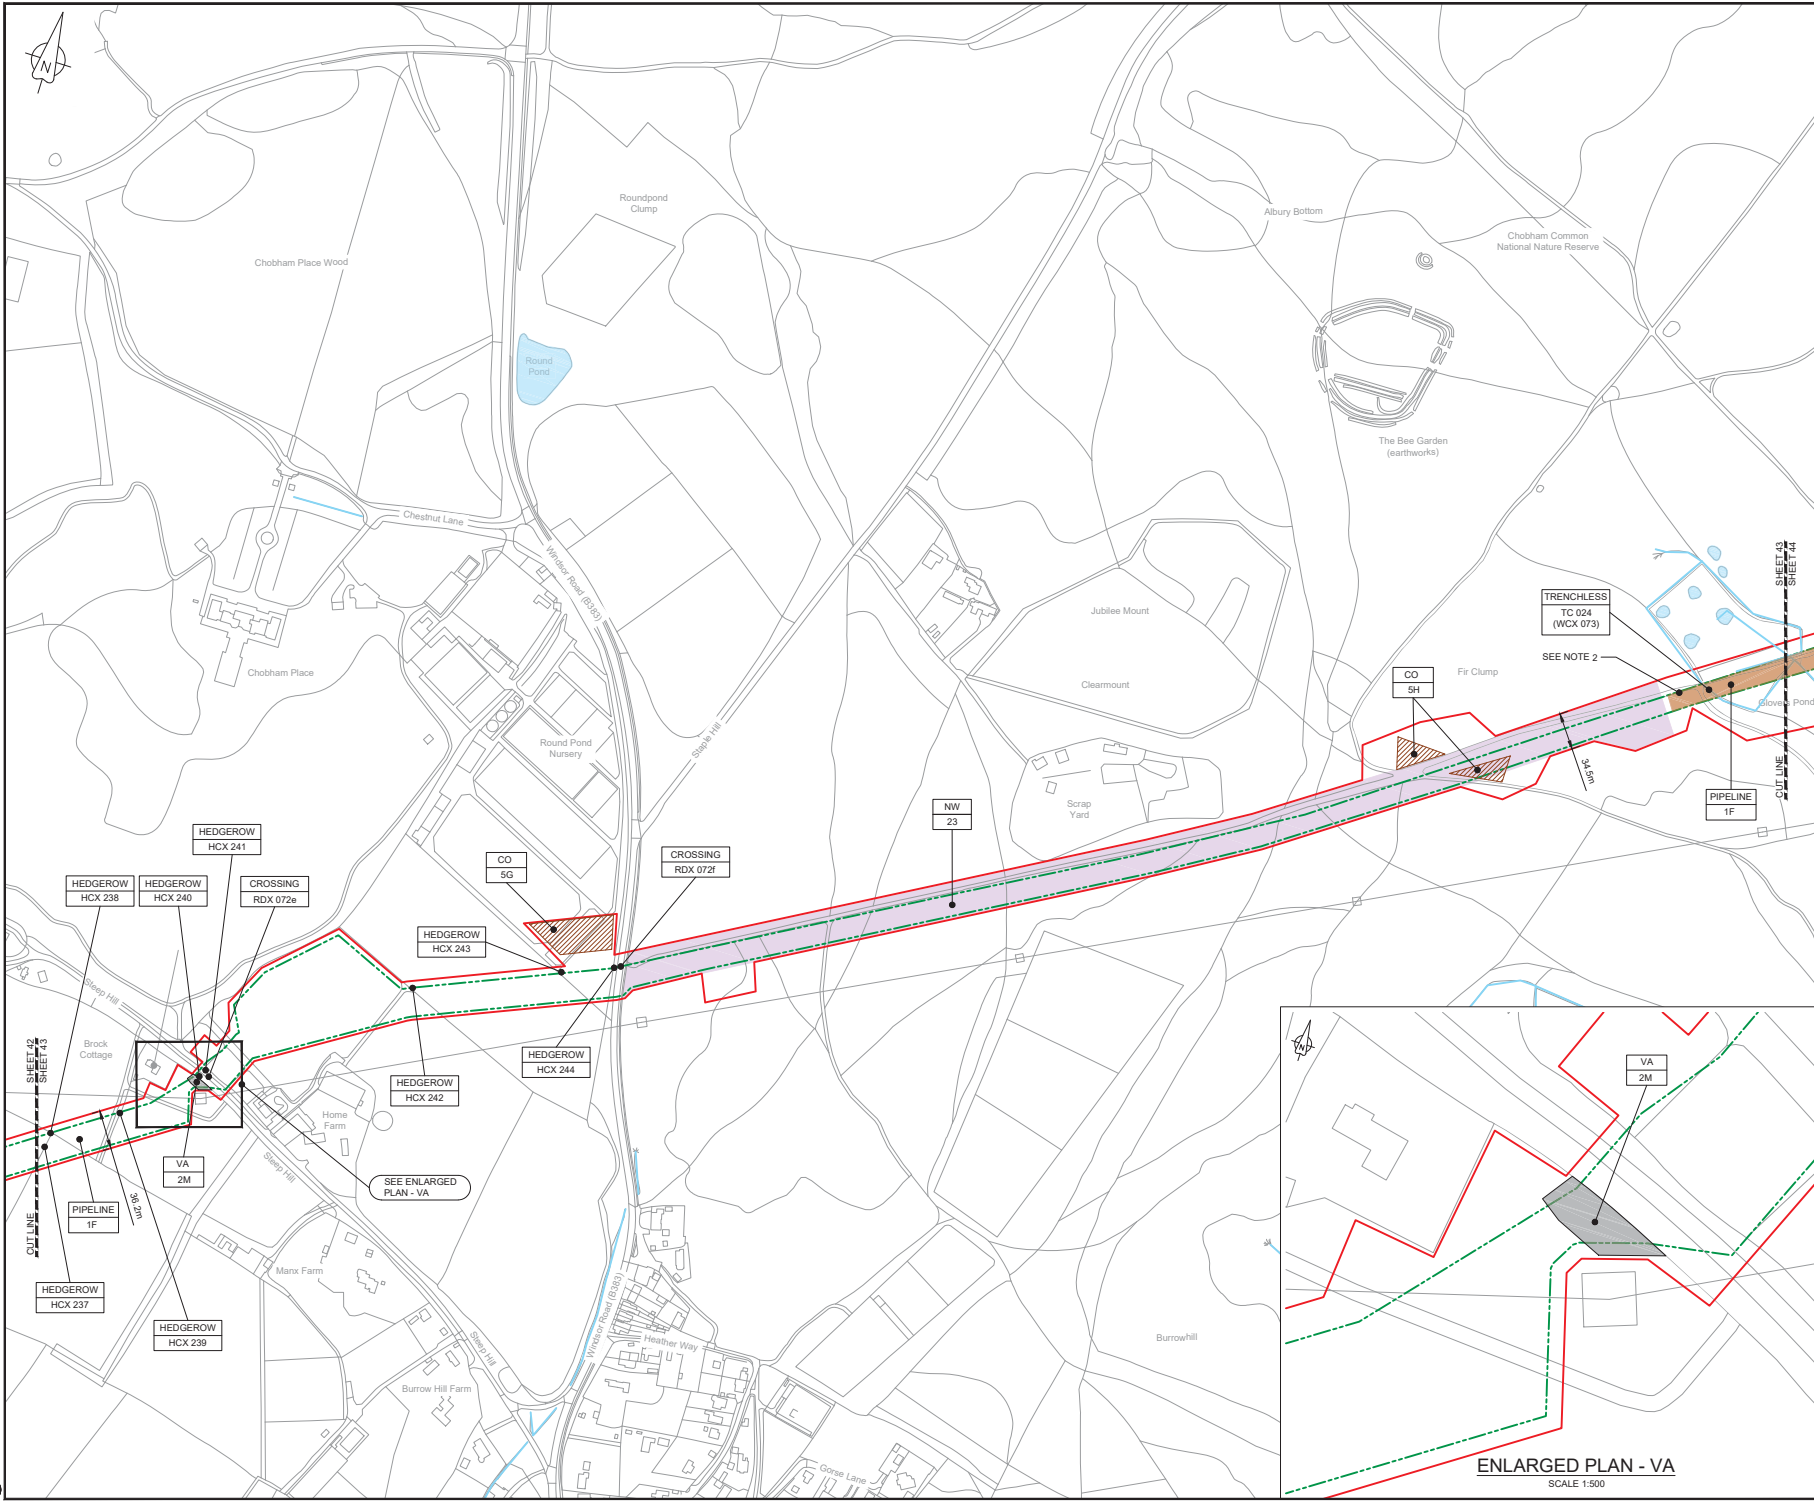

LOCATION PLAN  
SCALE 1:500,000

- NOTES**
- THIS DRAWING IS IN METRES UNLESS STATED OTHERWISE.
  - TRENCHLESS CROSSINGS ARE INDICATIVE ONLY.

- LEGEND**
- ORDER LIMITS
  - LIMITS OF DEVIATION
  - NARROW WORKING AREA (NW)
  - TRENCHLESS CROSSING (TC)
  - WATER BODIES
  - ABOVE GROUND INSTALLATION (AGI) / VALVE (VA) / PRESSURE TRANSDUCER (PT)
  - COMPOUND (CO)
  - TREE PRESERVATION ORDER (TPO)
  - DESCRIPTION
  - ID or WORK NUMBER (if applicable)
  - COMMENCEMENT / TERMINATION OF WORKS (COMMENCEMENT = OPEN, TERMINATION = CLOSED)

Contains Ordnance Survey data © Crown copyright and database rights 2019.  
© Crown copyright and database rights 2019 OS Licence Number AL10005237.



SCALE 1:2500 @ A1

CSI	030519	0001SUBMISSION	PC	JA	SC	PH
Rev.	Rev. Date	Purpose of revision	Drawn	Checked	Rev'd	Approved

**JACOBS**  
1180 Ewlish Road, Winchester, Wokingham, RG41 5TU  
Tel: +44(0)118 946 7000 • Fax: +44(0)118 946 7001  
www.jacobs.com


Client: Esso Petroleum Company, Limited  
Emlyn House,  
Emlyn Way,  
Leatherhead,  
Surrey,  
KT22 8UX

Project: Southampton to London Pipeline Project

Drawing title: **GENERAL ARRANGEMENT SHEET 43 REGULATION 5 (2)(O)**


Drawing status: **Fit for Stage Approval**

Scale	1:2500	DO NOT SCALE
Jacobs No.	B2325300	Rev
Client no.	B2325300	Rev
Drawing number	B2325300-JAC-000-CIV-DRG-000553	Rev
		<b>CO1</b>

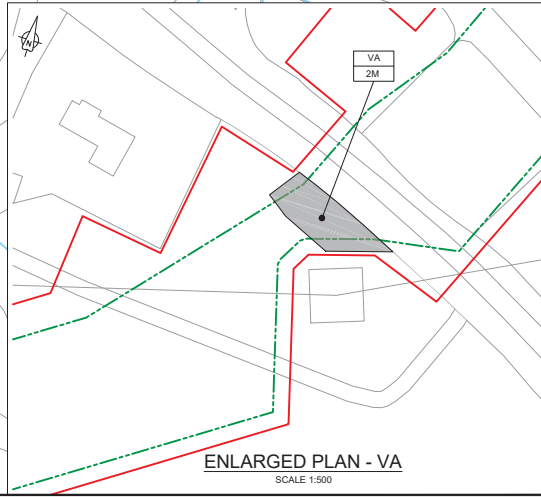

ENLARGED PLAN - VA  
SCALE 1:500

C:\pwworking\jacobs\_uk\_water\utilities\_s44\byproj\dm3513182325300-JAC-000-CIV-DRG-000553.dwg - 03/05/2019 12:46:16 - A1Frame - BTaylor

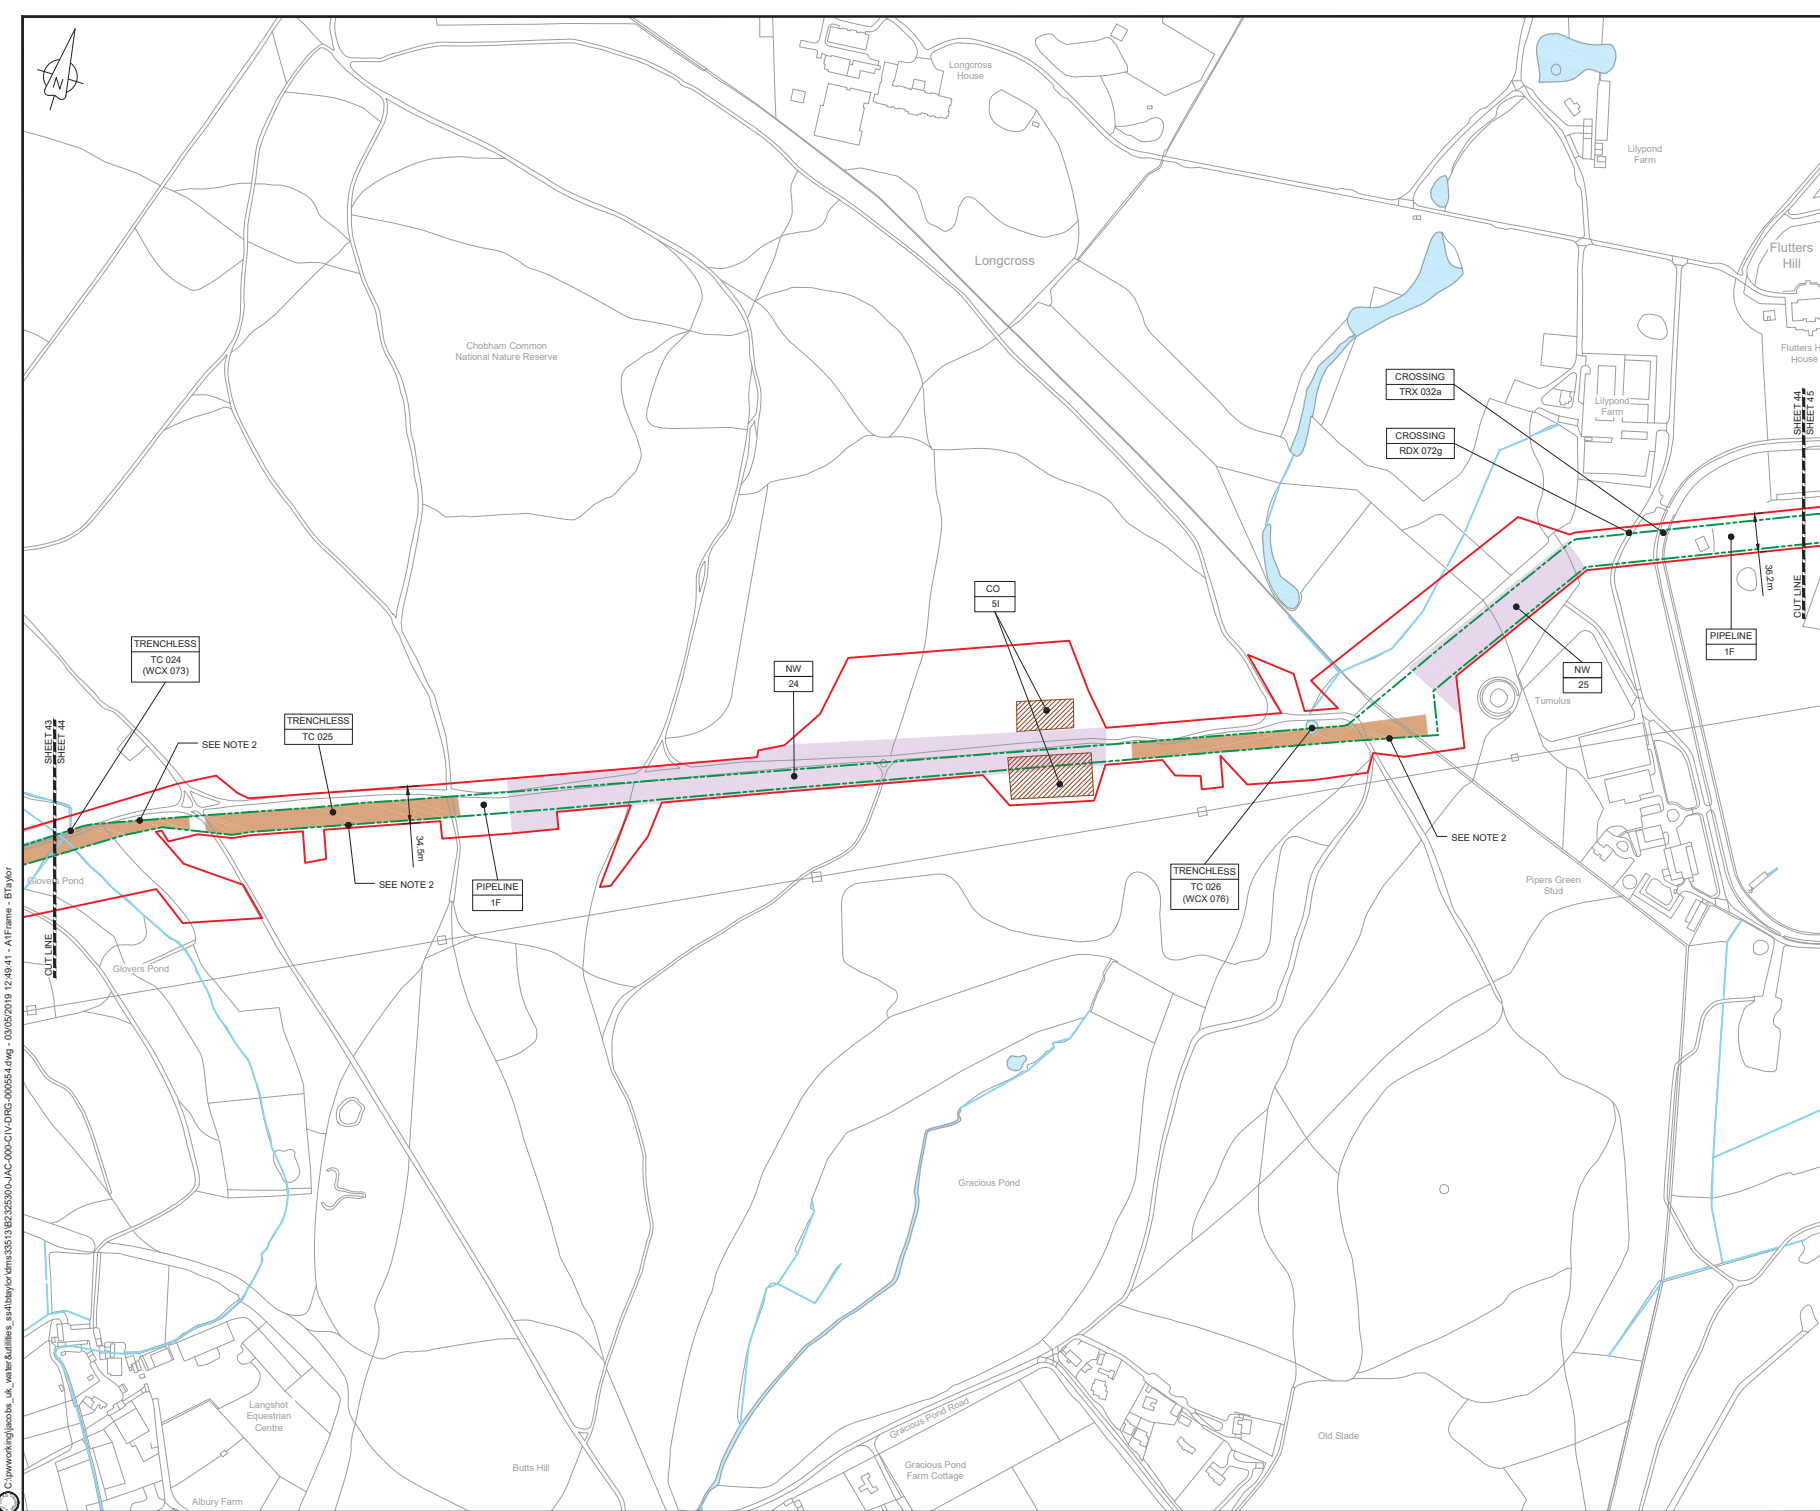


LOCATION PLAN  
SCALE 1:500,000

- NOTES**
1. THIS DRAWING IS IN METRES UNLESS STATED OTHERWISE.
  2. TRENCHLESS CROSSINGS ARE INDICATIVE ONLY.

- LEGEND**
- ORDER LIMITS
  - LIMITS OF DEVIATION
  - NARROW WORKING AREA (NW)
  - TRENCHLESS CROSSING (TC)
  - WATER BODIES
  - ABOVE GROUND INSTALLATION (AGI) / VALVE (VA) / PRESSURE TRANSDUCER (PT)
  - COMPOUND (CO)
  - TREE PRESERVATION ORDER (TPO)
  - DESCRIPTION
  - ID or WORK NUMBER (if applicable)
  - COMMENCEMENT / TERMINATION OF WORKS (COMMENCEMENT = OPEN, TERMINATION = CLOSED)

Contains Ordnance Survey data © Crown copyright and database rights 2019.

 © Crown copyright and database rights 2019 OS Licence Number AL10005237.



CD	Rev	Date	Purpose of revision	PC	JA	SC	PH
CO1	03/05/19						

**JACOBS**  
1180 Epsom Road, Wokingham, Wokingham, RG41 5TU  
Tel: +44(0)118 946 7000 • Fax: +44(0)118 946 7001  
www.jacobs.com

Client: Esso Petroleum Company, Limited  
Emlyn House,  
Emlyn Way,  
Leatherhead,  
Surrey,  
KT22 8UX



Project  
**GENERAL ARRANGEMENT  
SHEET 44  
REGULATION 5 (2)(O)**



Drawing status: **Fit for Stage Approval**

Scale	1:2500	DO NOT SCALE
Jacobs No.	B2325300	Rev
Client no.		CO1

Drawing number  
**B2325300-JAC-000-CIV-DRG-00054**

C:\pwworking\jacobs\_uk\_water\_utilities\_s44\byrdms3513\B2325300-JAC-000-CIV-DRG-00054.dwg - 03/05/2019 12:49:41 - A1Frame - BTaylor



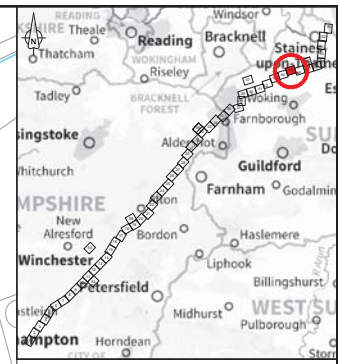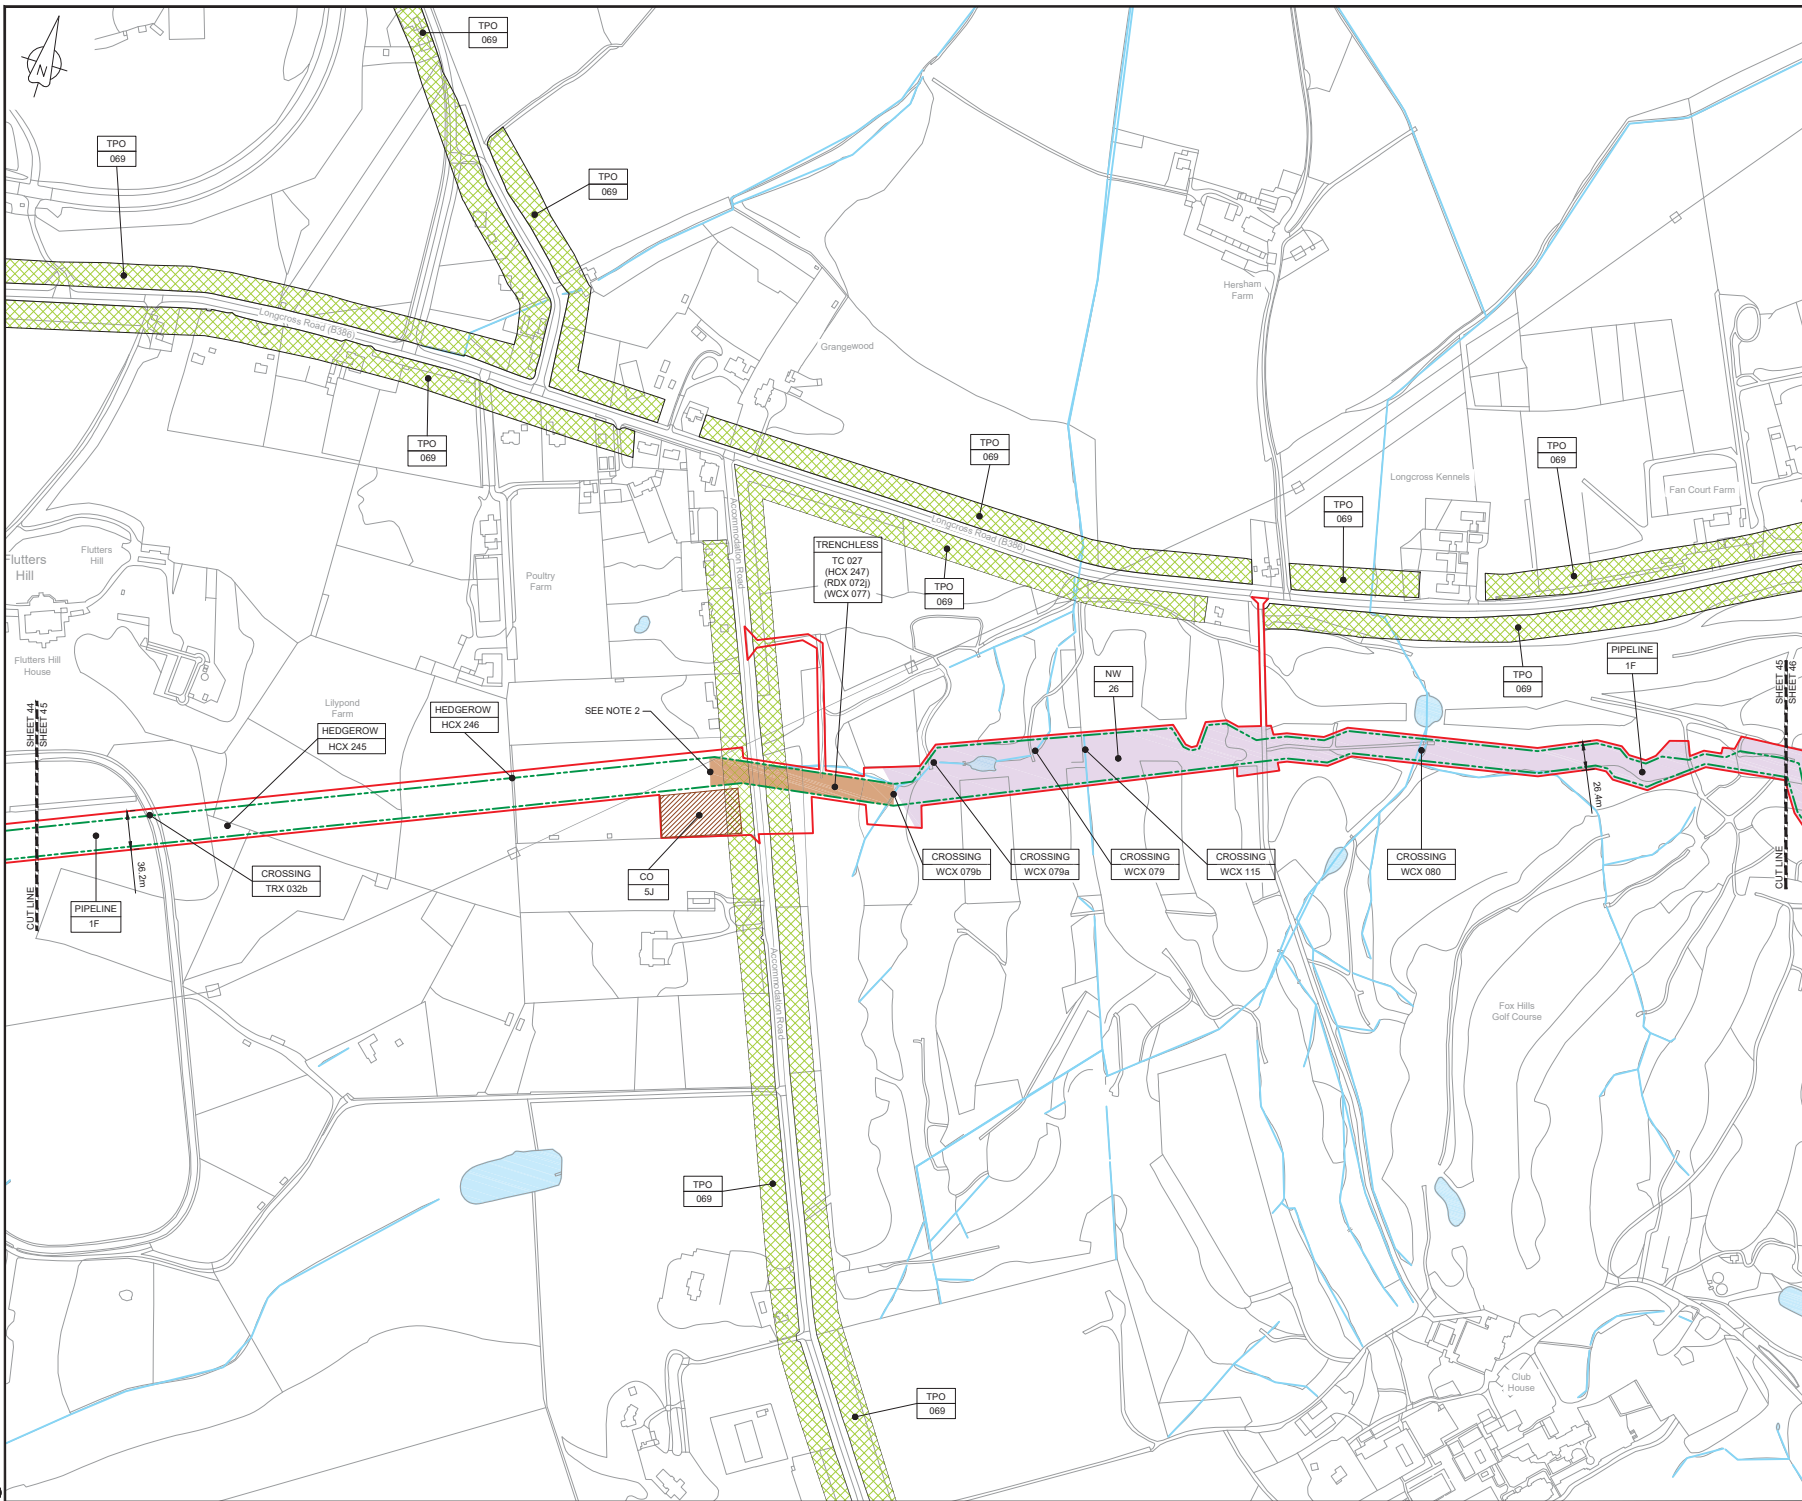


LOCATION PLAN  
SCALE 1:500,000

- NOTES**
- THIS DRAWING IS IN METRES UNLESS STATED OTHERWISE.
  - TRENCHLESS CROSSINGS ARE INDICATIVE ONLY.

- LEGEND**
- ORDER LIMITS
  - LIMITS OF DEVIATION
  - NARROW WORKING AREA (NW)
  - TRENCHLESS CROSSING (TC)
  - WATER BODIES
  - ABOVE GROUND INSTALLATION (AGI) / VALVE (VA) / PRESSURE TRANSDUCER (PT)
  - COMPOUND (CO)
  - TREE PRESERVATION ORDER (TPO)
  - DESCRIPTION
  - ID or WORK NUMBER (if applicable)
  - COMMENCEMENT / TERMINATION OF WORKS (COMMENCEMENT = OPEN, TERMINATION = CLOSED)

 Contains Ordnance Survey data © Crown copyright and database rights 2019.  
© Crown copyright and database rights 2019 OS Licence Number AL10005237.



CDI	03/05/19	DOC SUBMISSION	PC	JA	SC	PH
Rev.	Rev. Date	Purpose of revision	Drawn	Checked	Rev'd	Approved

**JACOBS**  
1180 Ewkside Road, Wokingham, Wokingham, RG41 5TU  
Tel: +44(0)118 946 7000 • Fax: +44(0)118 946 7001  
www.jacobs.com

Client: Esso Petroleum Company Limited  
Emlyn House,  
Emlyn Way,  
Leatherhead,  
Surrey,  
KT22 8UX

Project: Southampton to London Pipeline Project


Drawing title:  
**GENERAL ARRANGEMENT  
SHEET 45  
REGULATION 5 (2)(O)**

Drawing status: **Fit for Stage Approval**

Scale	1:2500	DO NOT SCALE
Jacobs No.	B2325300	Rev
Client no.		Rev

Drawing number: **B2325300-JAC-000-CIV-DRG-000555**

C:\pwworking\jacobs\_uk\_water\facilities\_southampton\B2325300-JAC-000-CIV-DRG-000555.dwg - 03/05/2019 12:54:00 - A1Frame - BTaylor

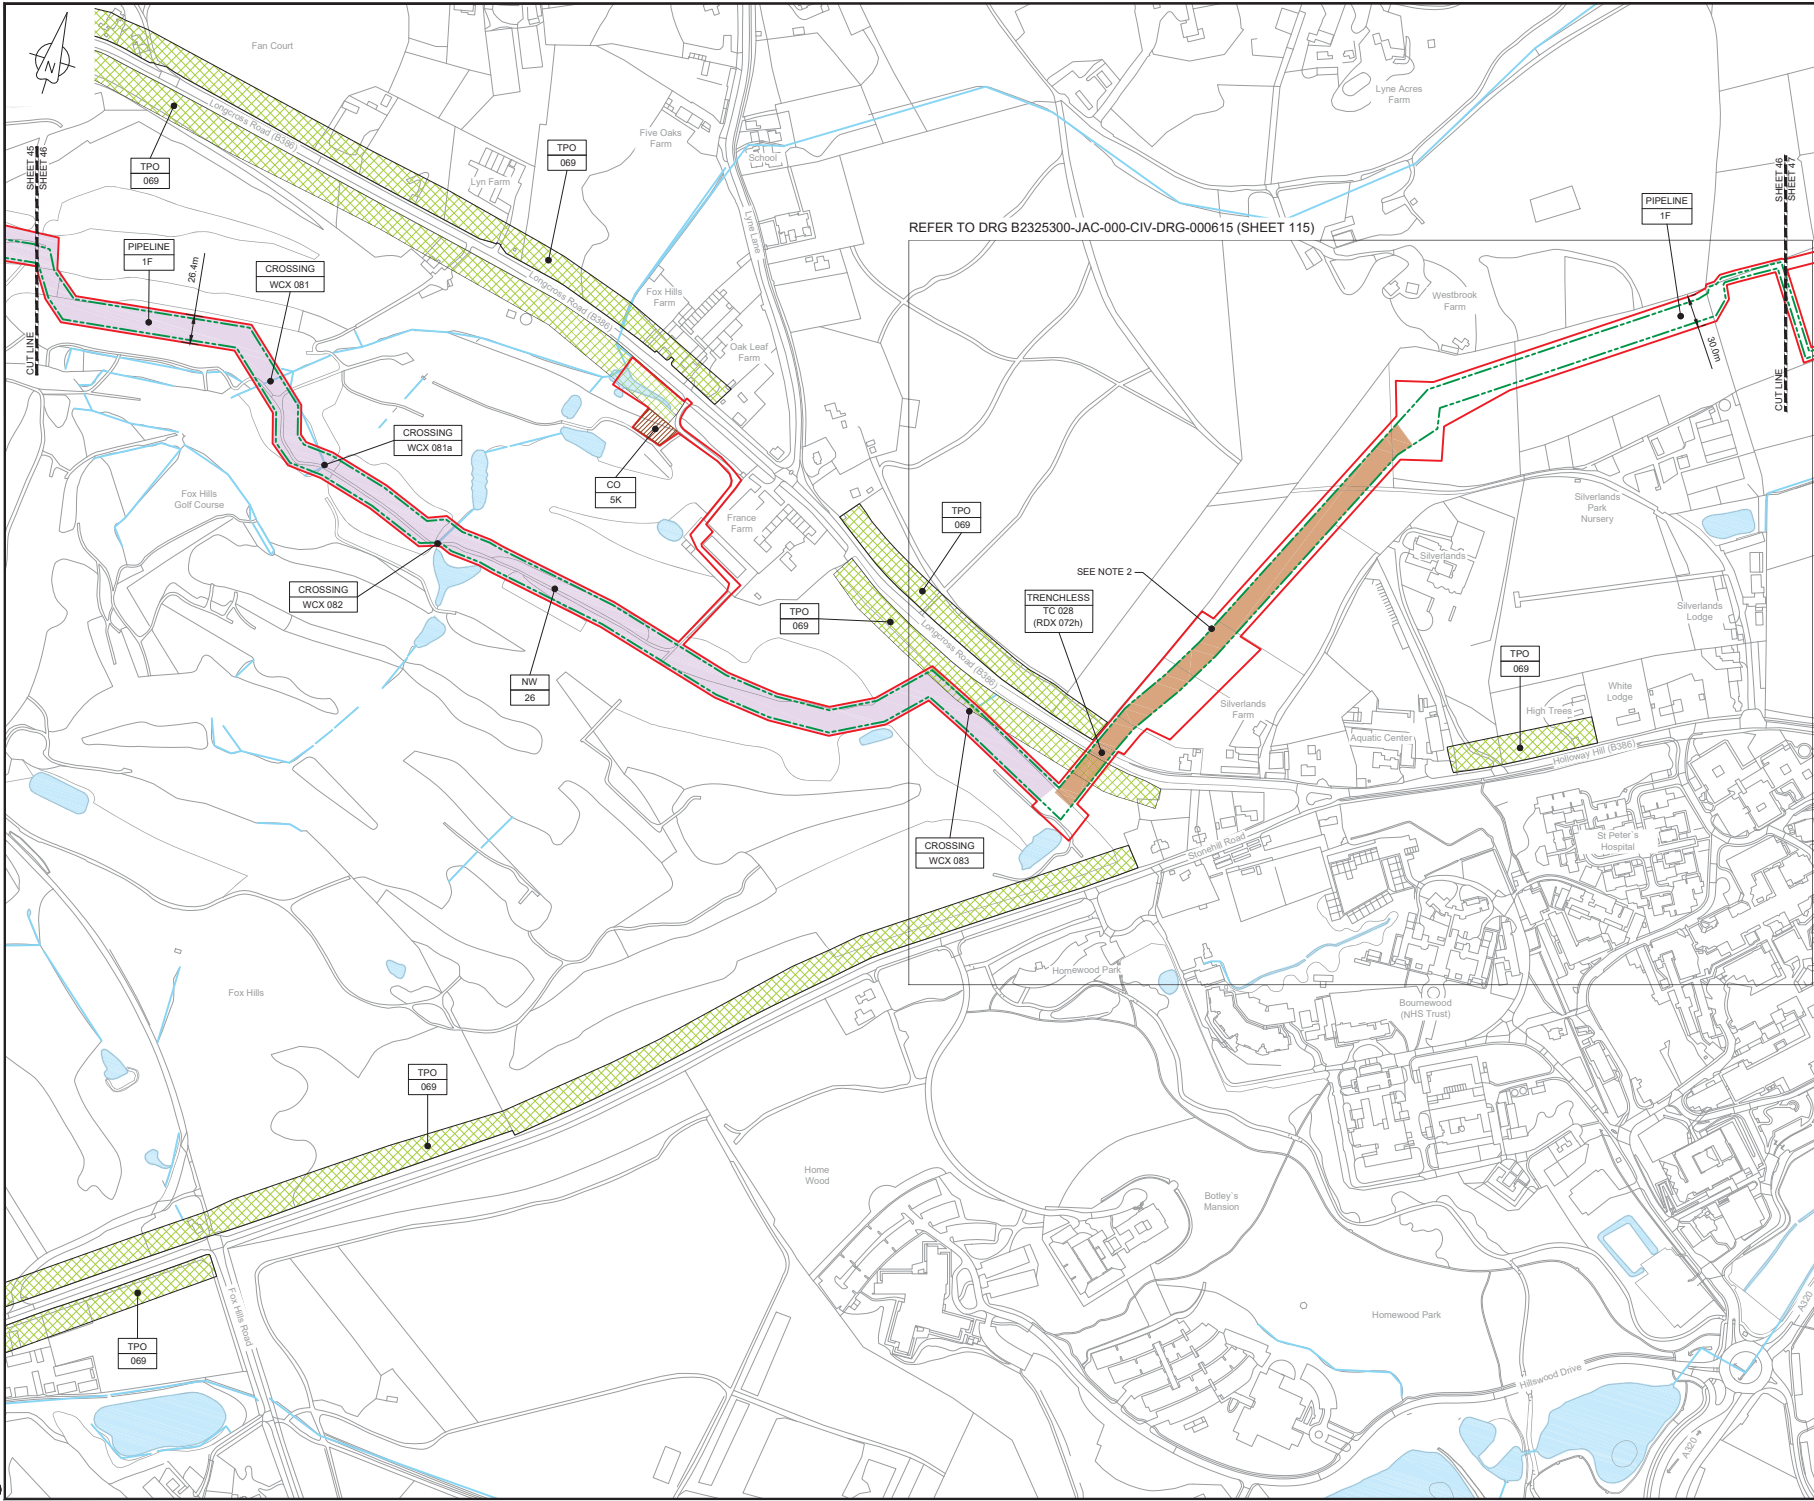


LOCATION PLAN  
SCALE 1:500,000

- NOTES**
1. THIS DRAWING IS IN METRES UNLESS STATED OTHERWISE.
  2. TRENCHLESS CROSSINGS ARE INDICATIVE ONLY.

- LEGEND**
- ORDER LIMITS
  - LIMITS OF DEVIATION
  - NARROW WORKING AREA (NW)
  - TRENCHLESS CROSSING (TC)
  - WATER BODIES
  - ABOVE GROUND INSTALLATION (AGI) / VALVE (VA) / PRESSURE TRANSDUCER (PT)
  - COMPOUND (CO)
  - TREE PRESERVATION ORDER (TPO)
  - DESCRIPTION
  - ID or WORK NUMBER (if applicable)
  - COMMENCEMENT / TERMINATION OF WORKS (COMMENCEMENT = OPEN, TERMINATION = CLOSED)

Contains Ordnance Survey data © Crown copyright and database rights 2019.

 © Crown copyright and database rights 2019 OS Licence Number AL10005237.



CD	03/05/19	0000 SUBMISSION	PC	JA	SC	PH
Rev.	Rev. Date	Purpose of revision	Drawn	Checked	Rev'd	Approved

**JACOBS**  
1180 Emswell Road, Winchester, Wokingham, RG41 5TU  
Tel: +44(0)118 946 7000 • Fax: +44(0)118 946 7001  
www.jacobs.com

Client: Esso Petroleum Company, Limited  
Ermyn House,  
Ermyn Way,  
Leatherhead,  
Surrey,  
KT22 8UX

Project: Southampton to London Pipeline Project

Drawing title: **GENERAL ARRANGEMENT SHEET 46 REGULATION 5 (2)(O)**


Drawing status: **Fit for Stage Approval**

Scale	1:2500	DO NOT SCALE
Jacobs No.	B2325300	Rev
Client no.		CO1

Drawing number: **B2325300-JAC-000-CIV-DRG-000556**

C:\pwworking\jacobs\_uk\_water\utilities\_s44\byrdms\3513\B2325300-JAC-000-CIV-DRG-000556.dwg - 03/05/2019 13:00:41 - A1Frame - BTaylor



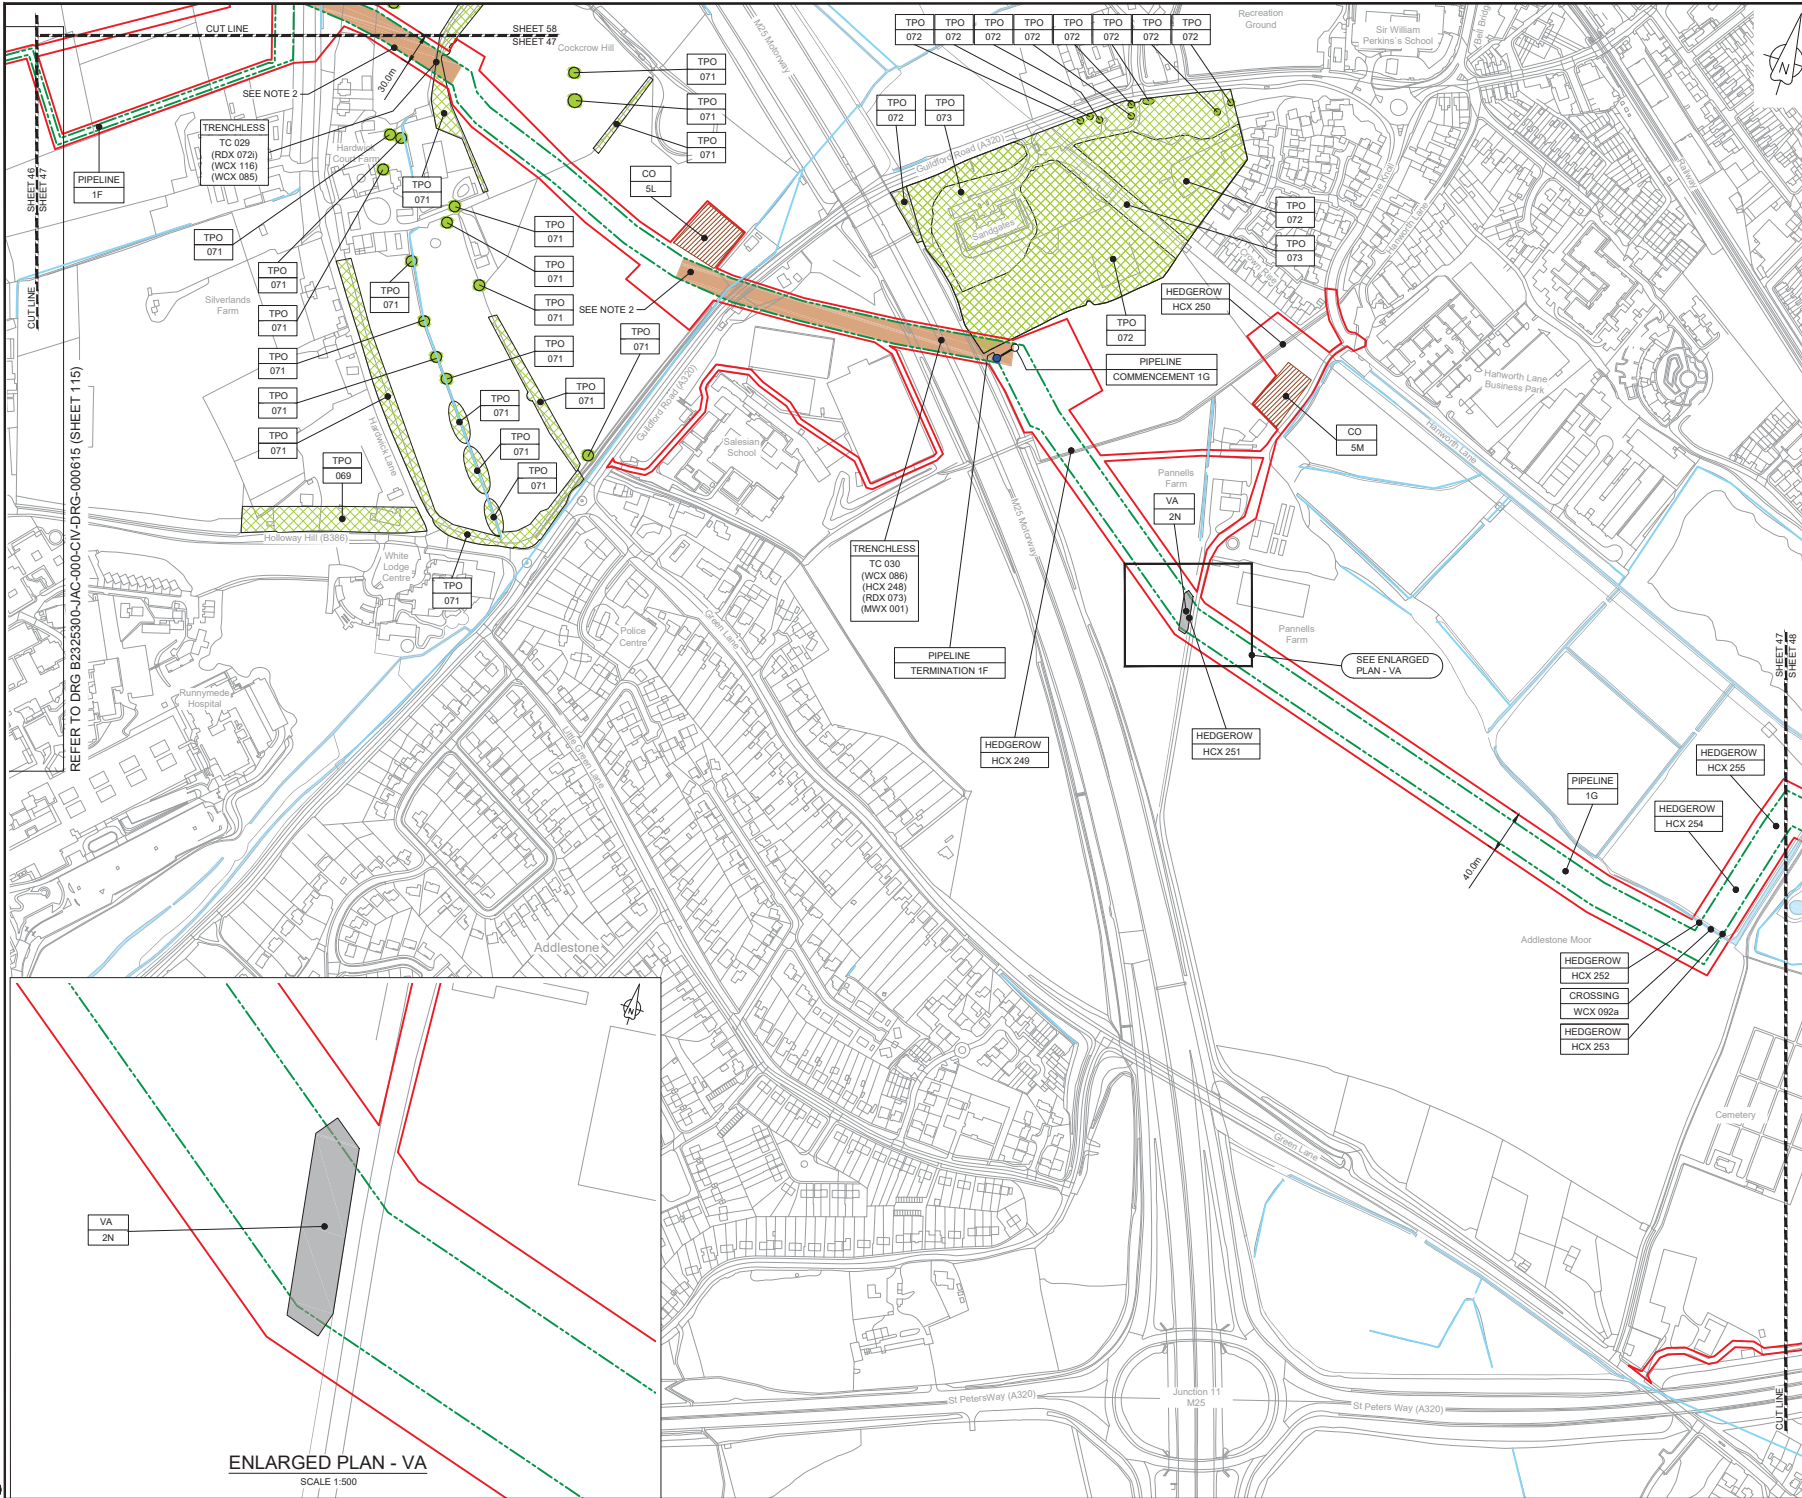

LOCATION PLAN  
SCALE 1:500,000

- NOTES
1. THIS DRAWING IS IN METRES UNLESS STATED OTHERWISE.
  2. TRENCHLESS CROSSINGS ARE INDICATIVE ONLY.

- LEGEND
- ORDER LIMITS
  - LIMITS OF DEVIATION
  - NARROW WORKING AREA (NW)
  - TRENCHLESS CROSSING (TC)
  - WATER BODIES
  - ABOVE GROUND INSTALLATION (AGI) / VALVE (VA) / PRESSURE TRANSDUCER (PT)
  - COMPOUND (CO)
  - TREE PRESERVATION ORDER (TPO)
  - DESCRIPTION
  - ID or WORK NUMBER (if applicable)
  - COMMENCEMENT / TERMINATION OF WORKS (COMMENCEMENT = OPEN, TERMINATION = CLOSED)

Contains Ordnance Survey data © Crown copyright and database rights 2019.  
© Crown copyright and database rights 2019 OS Licence Number AL10005237.



CDI	03/05/19	0001 SUBMISSION	PC	JA	SC	PH
Rev.	Rev. Date	Purpose of revision	Drawn	Checked	Rev'd	Approved

**JACOBS**  
1180 Ewlish Road, Winchester, Wokingham, RG41 5TU  
Tel: +44(0)118 946 7000 • Fax: +44(0)118 946 7001  
www.jacobs.com

Client: Esso Petroleum Company, Limited  
Ermyn House,  
Ermyn Way,  
Leatherhead,  
Surrey,  
KT22 8UX

Project: Southampton to London Pipeline Project


Drawing title:  
**GENERAL ARRANGEMENT  
SHEET 47  
REGULATION 5 (2)(O)**

Drawing status:	Fit for Stage Approval	DO NOT SCALE
Scale:	1:2500	Rev
Jacobs No:	B2325300	Rev
Client no:		CO1

Drawing number:  
**B2325300-JAC-000-CIV-DRG-000557**


REFER TO DRG B2325300-JAC-000-CIV-DRG-000615 (SHEET 115)

C:\pwworking\jacobs\_uk\_water\utilities\_s44\byproj\dm3513\B2325300-JAC-000-CIV-DRG-000557.dwg - 03/05/2019 13:02:21 - A1Frame - BTaylor

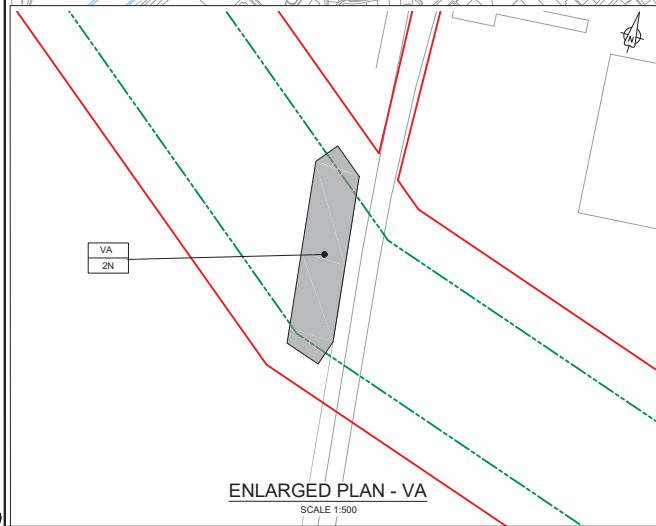

ENLARGED PLAN - VA  
SCALE 1:500



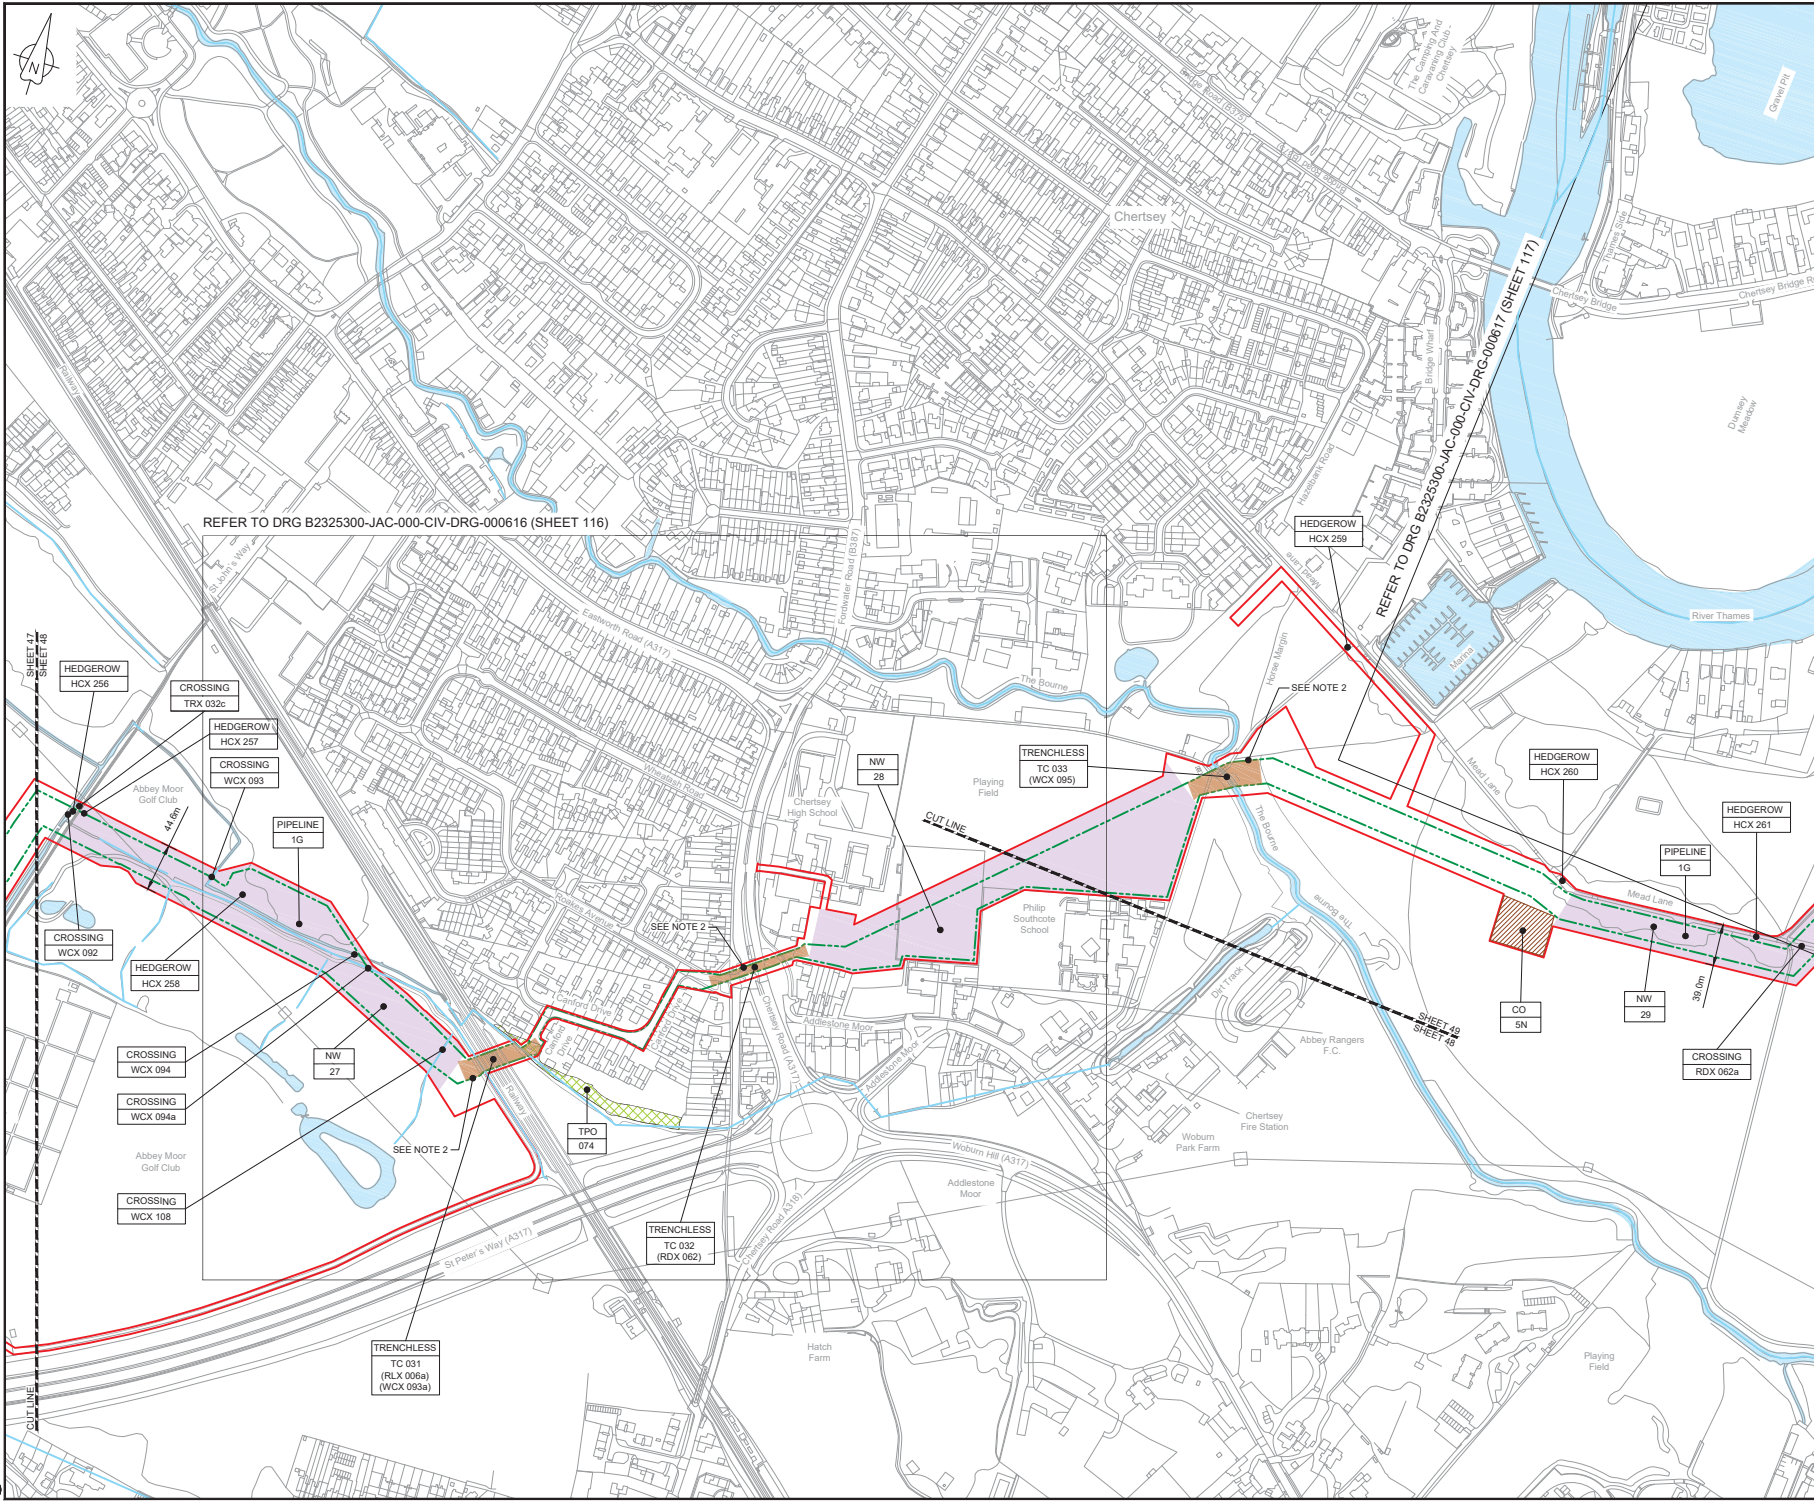


LOCATION PLAN  
SCALE 1:500,000

NOTES  
 1. THIS DRAWING IS IN METRES UNLESS STATED OTHERWISE.  
 2. TRENCHLESS CROSSINGS ARE INDICATIVE ONLY.

**LEGEND**

 - ORDER LIMITS
- - - LIMITS OF DEVIATION
- NARROW WORKING AREA (NW)
- TRENCHLESS CROSSING (TC)
- WATER BODIES
- ABOVE GROUND INSTALLATION (AGI) / VALVE (VA) / PRESSURE TRANSDUCER (PT)
- COMPOUND (CO)
- TREE PRESERVATION ORDER (TPO)
- DESCRIPTION
- ID or WORK NUMBER (if applicable)
- COMMENCEMENT / TERMINATION OF WORKS (COMMENCEMENT = OPEN, TERMINATION = CLOSED)

Contains Ordnance Survey data © Crown copyright and database rights 2019.  
 © Crown copyright and database rights 2019 OS Licence Number AL100005237.



CD	03/05/19	0001 SUBMISSION	PC	JA	SC	PH
Rev.	Rev. Date	Purpose of revision	Drawn	Checked	Rev'd	Approved

**JACOBS**  
 1180 Ewks Rd, Wokingham, Wokingham, RG41 5TU  
 Tel: +44(0)118 946 7000 • Fax: +44(0)118 946 7001  
 www.jacobs.com

Client: Esso Petroleum Company Limited  
 Ermen House,  
 Ermen Way,  
 Leatherhead,  
 Surrey,  
 KT22 8UX

Project: Southampton to London Pipeline Project

Drawing title:  
**GENERAL ARRANGEMENT  
 SHEET 48  
 REGULATION 5 (2)(O)**


Drawing status: **Fit for Stage Approval**

Scale	1:2500	DO NOT SCALE
Jacobs No.	B2325300	Rev
Client no.		Rev
Drawing number		<b>CO1</b>

B2325300-JAC-000-CIV-DRG-000558

C:\pwworking\jacobs\_uk\_water\utilities\_s44\byproj\dlms13182325300-JAC-000-CIV-DRG-000558.dwg - 03/05/2019 13:05:50 - A1Frame - BTaylor



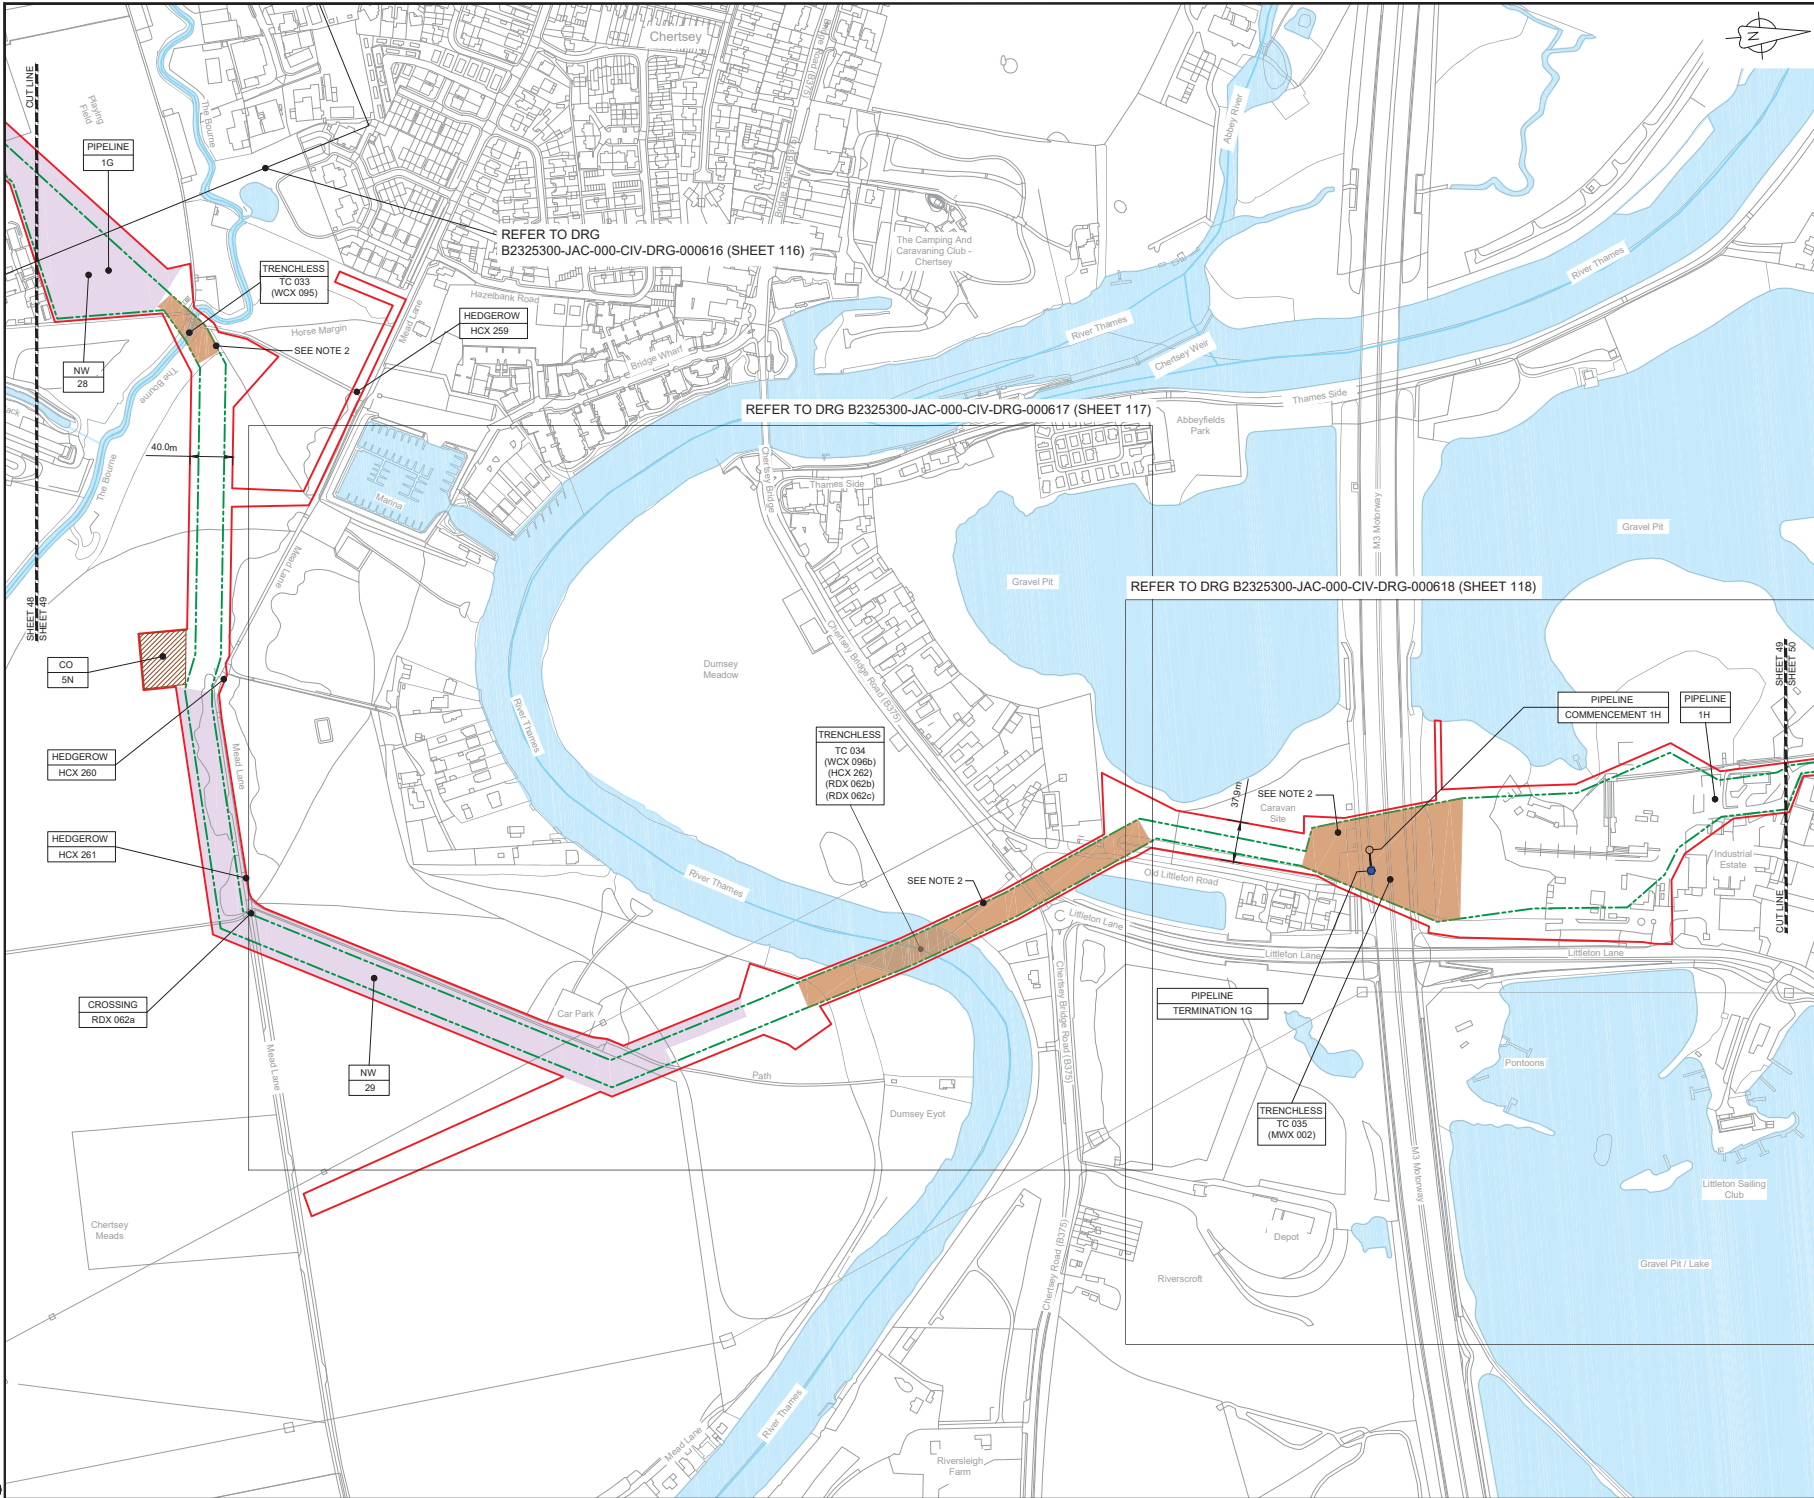

- NOTES**
1. THIS DRAWING IS IN METRES UNLESS STATED OTHERWISE.
  2. TRENCHLESS CROSSINGS ARE INDICATIVE ONLY.

**LEGEND**

- ORDER LIMITS
- LIMITS OF DEVIATION
- NARROW WORKING AREA (NW)
- TRENCHLESS CROSSING (TC)
- WATER BODIES
- ABOVE GROUND INSTALLATION (AGI) / VALVE (VA) / PRESSURE TRANSDUCER (PT)
- COMPOUND (CO)
- TREE PRESERVATION ORDER (TPO)
- DESCRIPTION
- ID or WORK NUMBER (if applicable)
- COMMENCEMENT / TERMINATION OF WORKS  
(COMMENCEMENT = OPEN, TERMINATION = CLOSED)

Contains Ordnance Survey data © Crown copyright and database rights 2019.

© Crown copyright and database rights 2019 OS Licence Number AL10005237.

SCALE 1:2500 @ A1

CD	03/05/19	0003/0003/0003	PC	JA	SC	PH
Rev.	Rev. Date	Purpose of revision	Drawn	Checked	Rev'd	Approved

**JACOBS**  
1180 Epsom Road, Winkfield, Wokingham, RG41 5TU  
Tel: +44(0)118 946 7000 • Fax: +44(0)118 946 7001  
www.jacobs.com

Client: Esso Petroleum Company, Limited  
Ermyn House,  
Ermyn Way,  
Leatherhead,  
Surrey,  
KT22 8UX

Project: Southampton to London Pipeline Project


Drawing title:  
**GENERAL ARRANGEMENT  
SHEET 49  
REGULATION 5 (2)(O)**

Drawing status: **Fit for Stage Approval**

Scale	1:2500	DO NOT SCALE
Jacobs No.	B2325300	Rev
Client no.		CO1

Drawing number: **B2325300-JAC-000-CIV-DRG-000559**

C:\pwworking\jacobs\_uk\_water\utilities\_sa4\byproj\dms13182\2325300-JAC-000-CIV-DRG-000559.dwg - 03/05/2019 13:02:26 - A1Frame - BTaylor

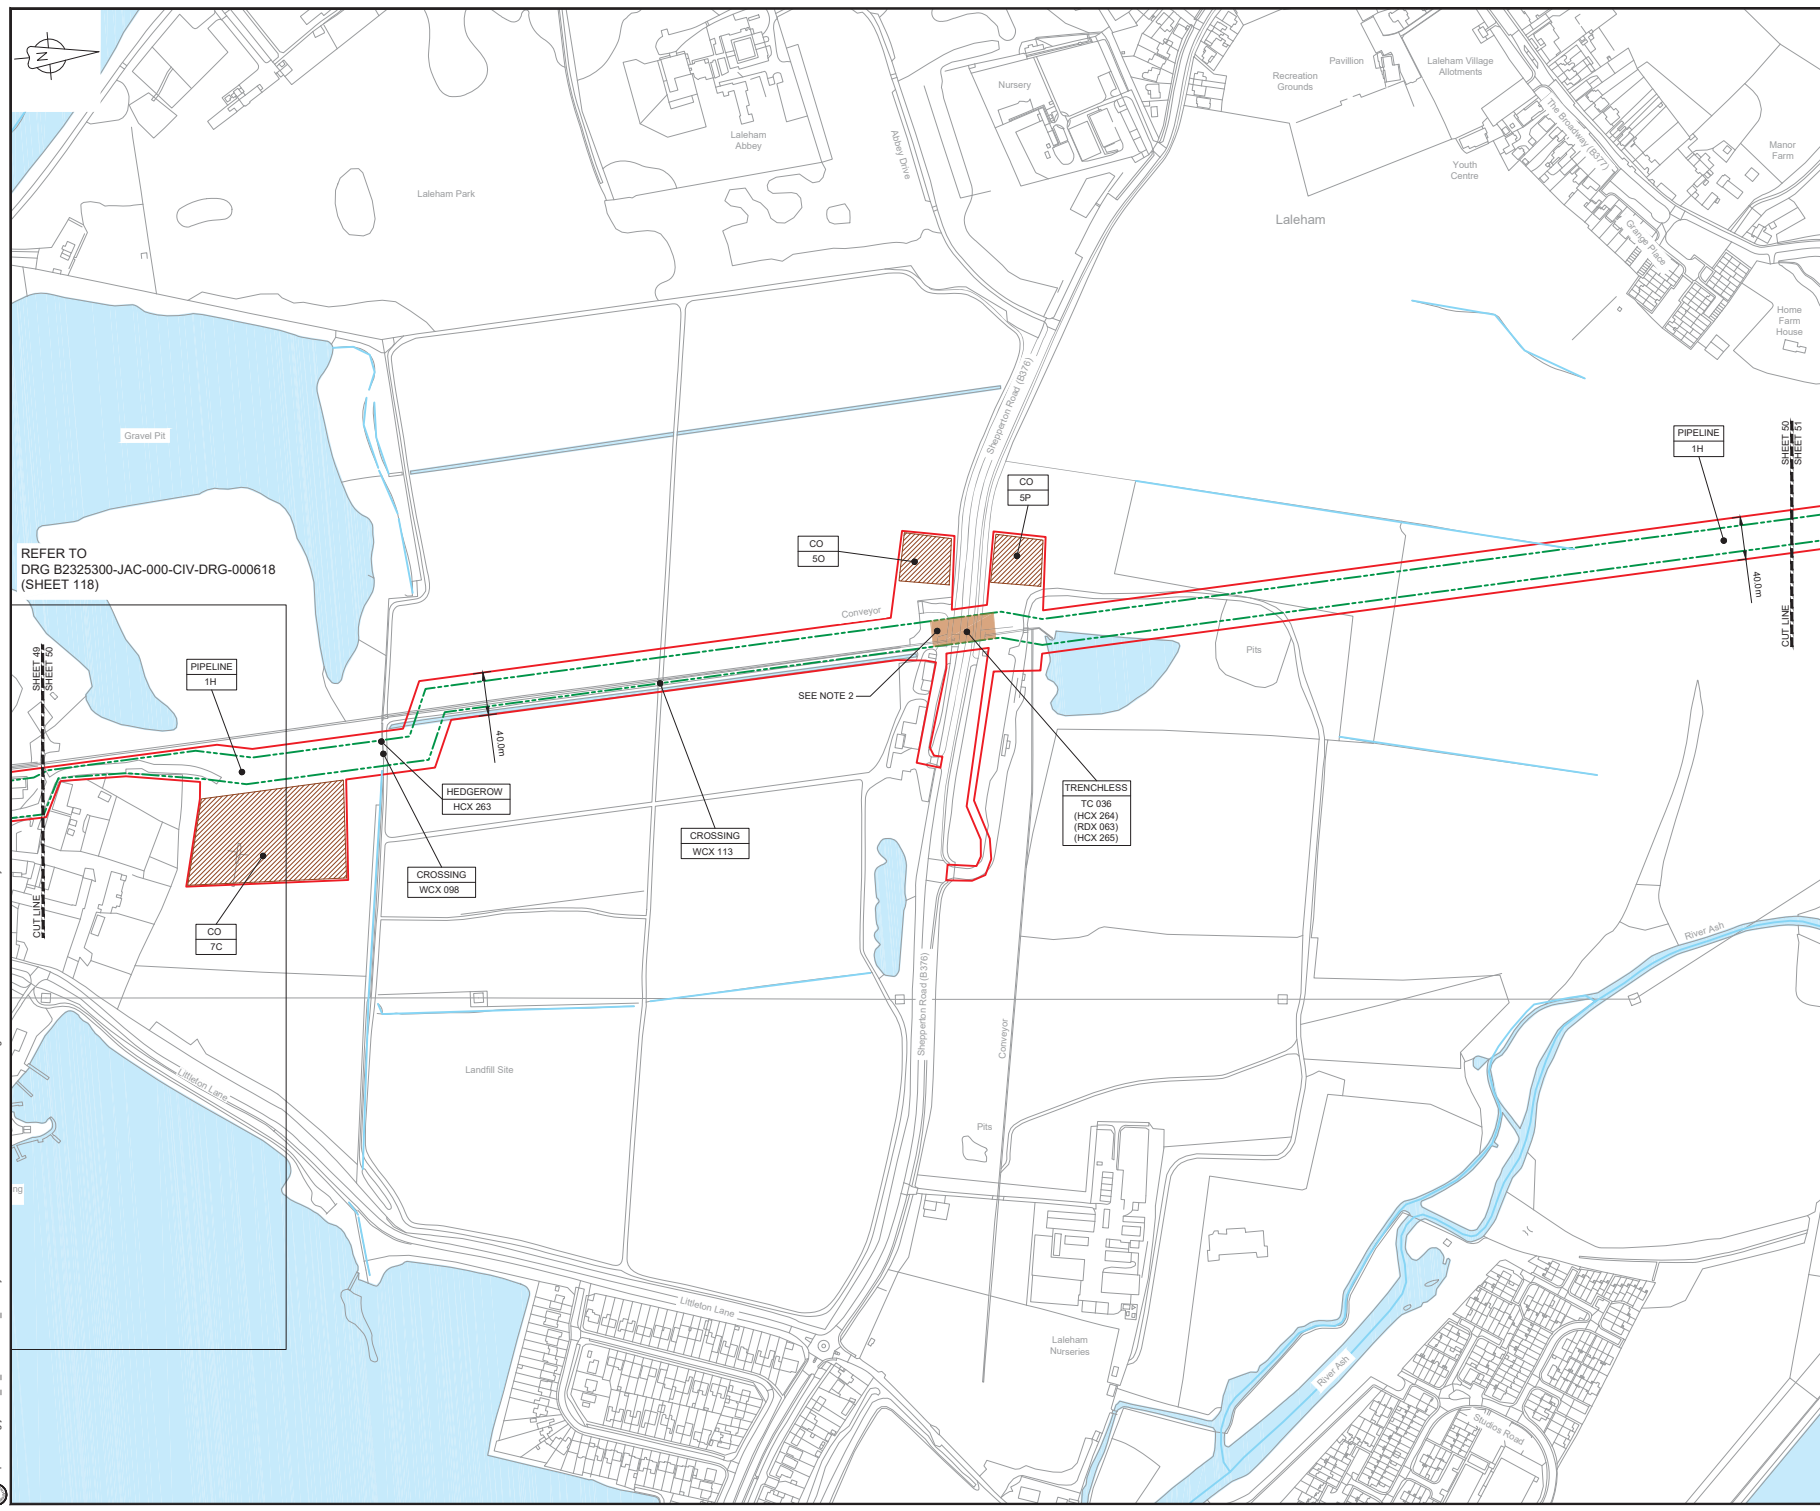

- NOTES**
1. THIS DRAWING IS IN METRES UNLESS STATED OTHERWISE.
  2. TRENCHLESS CROSSINGS ARE INDICATIVE ONLY.
- LEGEND**
- ORDER LIMITS
  - LIMITS OF DEVIATION
  - NARROW WORKING AREA (NW)
  - TRENCHLESS CROSSING (TC)
  - WATER BODIES
  - ABOVE GROUND INSTALLATION (AGI) / VALVE (VA) / PRESSURE TRANSDUCER (PT)
  - COMPOUND (CO)
  - TREE PRESERVATION ORDER (TPO)
  - DESCRIPTION
  - ID or WORK NUMBER (if applicable)
  - COMMENCEMENT / TERMINATION OF WORKS (COMMENCEMENT = OPEN, TERMINATION = CLOSED)

Contains Ordnance Survey data © Crown copyright and database rights 2019.

© Crown copyright and database rights 2019 OS Licence Number AL10005237.

0 50 100 150 200 250 m  
SCALE 1:2500 @ A1

CD	03/05/19	ISSUE/REVISION	PC	JA	SC	PH
Rev.	Rev. Date	Purpose of revision	Drawn	Checked	Rev'd	Approved

**JACOBS**  
1180 Ewings Road, Winchester, Hampshire, RG41 5TU  
Tel: +44(0)118 946 7000 • Fax: +44(0)118 946 7001  
www.jacobs.com

Client: Esso Petroleum Company, Limited  
Emryn House,  
Emryn Way,  
Leatherhead,  
Surrey,  
KT22 8UX


Project: **Esso** Southampton to London Pipeline Project

Drawing title: **GENERAL ARRANGEMENT SHEET 50 REGULATION 5 (2)(O)**

Drawing status: **Fit for Stage Approval**

Scale	1:2500	DO NOT SCALE
Jacobs No.	B2325300	Rev
Client no.		CO1
Drawing number	<b>B2325300-JAC-000-CIV-DRG-000560</b>	



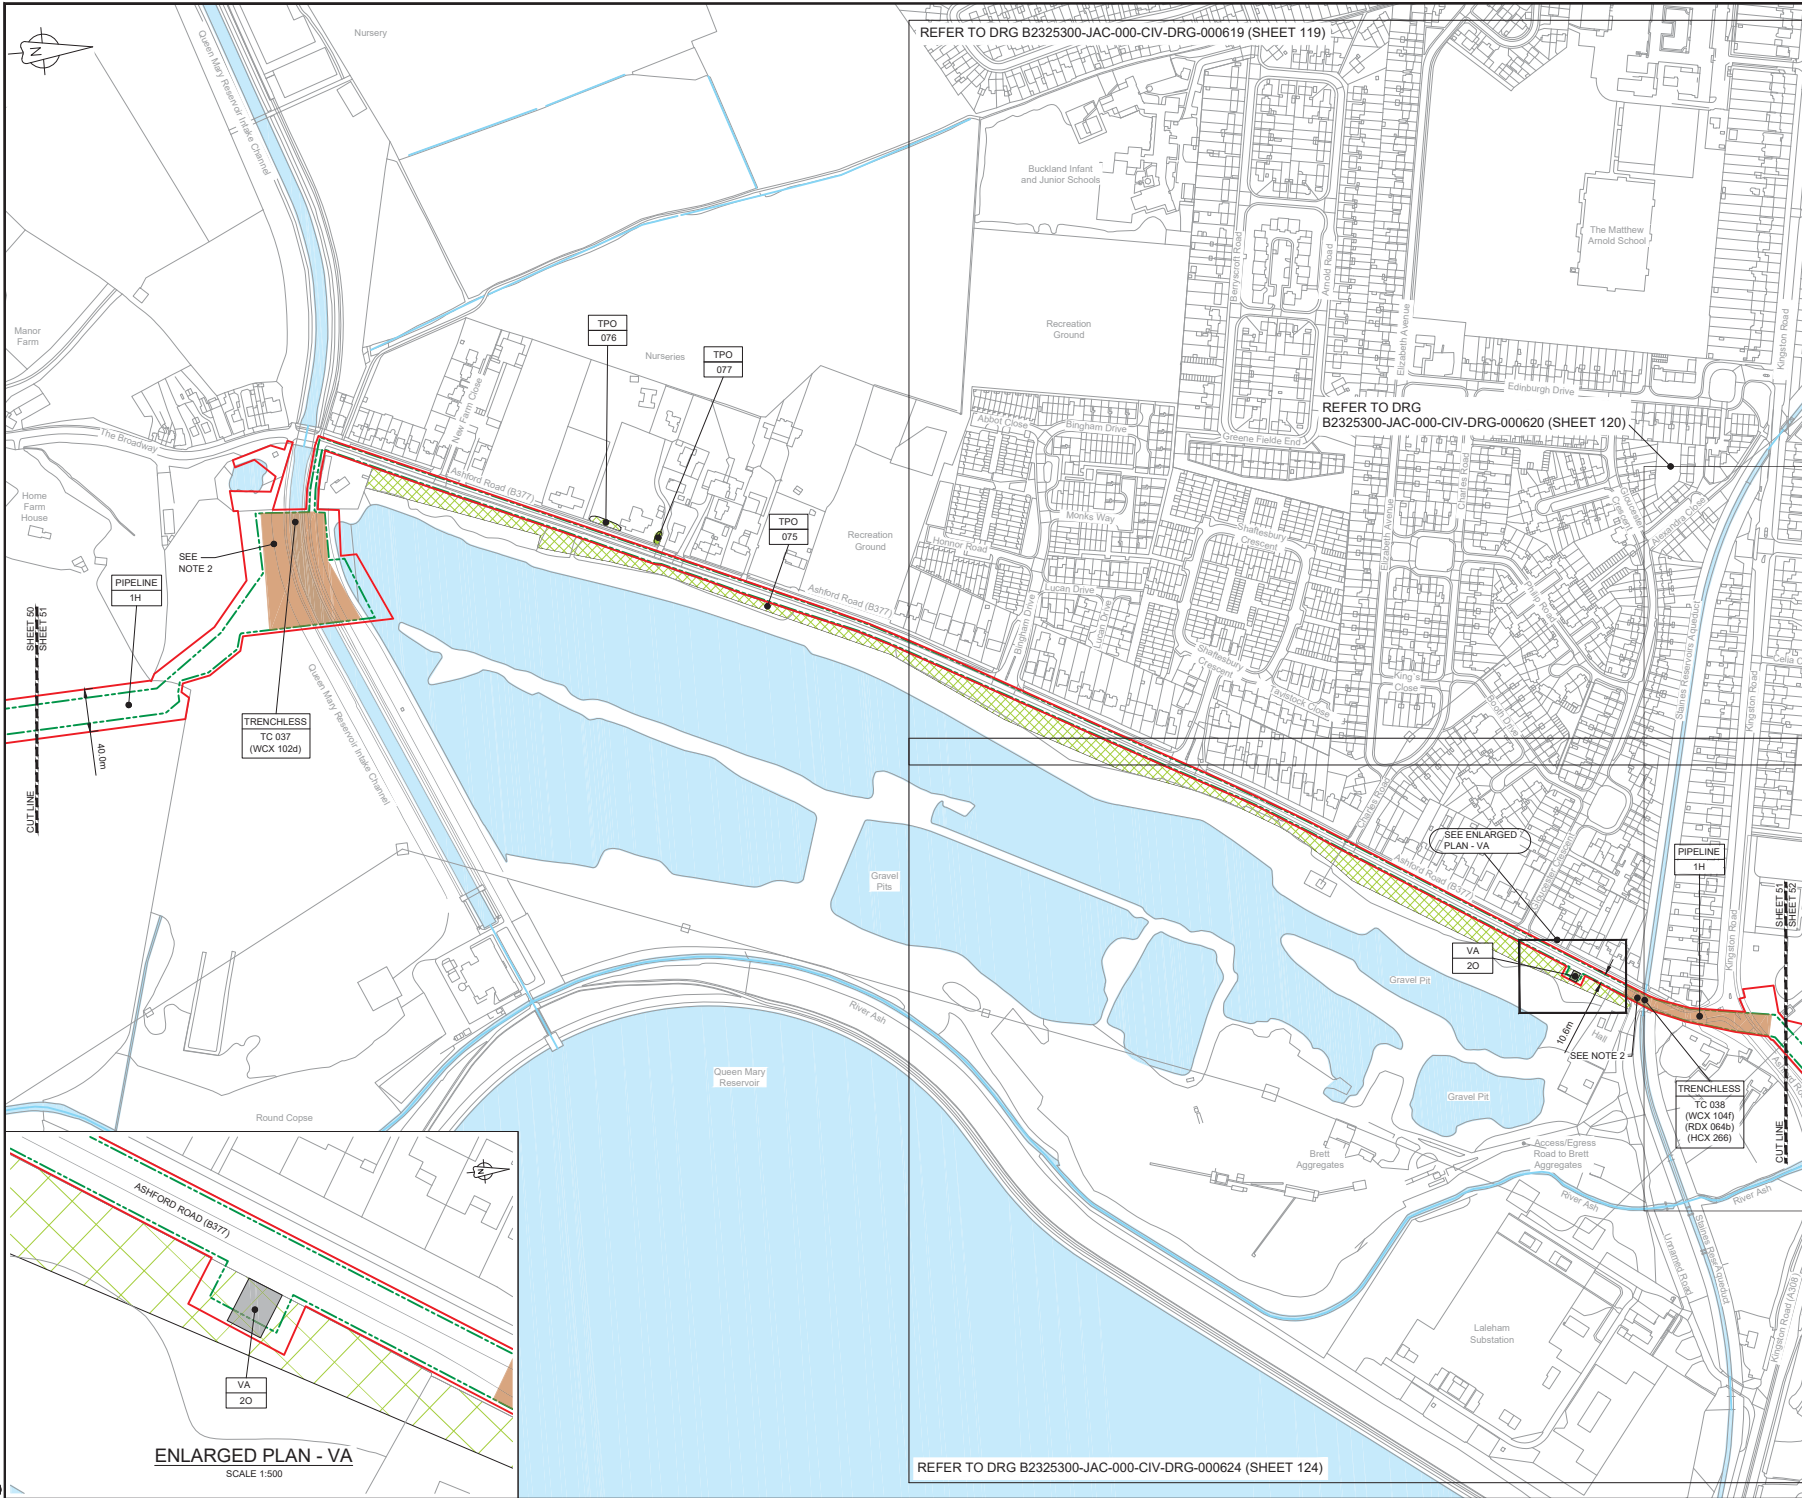

REFER TO DRG B2325300-JAC-000-CIV-DRG-000619 (SHEET 119)

REFER TO DRG B2325300-JAC-000-CIV-DRG-000620 (SHEET 120)

REFER TO DRG B2325300-JAC-000-CIV-DRG-000624 (SHEET 124)



 
LOCATION PLAN  
SCALE 1:500,000

- NOTES**
1. THIS DRAWING IS IN METRES UNLESS STATED OTHERWISE.
  2. TRENCHLESS CROSSINGS ARE INDICATIVE ONLY.

- LEGEND**
- ORDER LIMITS
  - LIMITS OF DEVIATION
  - NARROW WORKING AREA (NW)
  - TRENCHLESS CROSSING (TC)
  - WATER BODIES
  - ABOVE GROUND INSTALLATION (AGI) / VALVE (VA) / PRESSURE TRANSDUCER (PT)
  - COMPOUND (CO)
  - TREE PRESERVATION ORDER (TPO)
  - DESCRIPTION
  - ID or WORK NUMBER (if applicable)
  - COMMENCEMENT / TERMINATION OF WORKS (COMMENCEMENT = OPEN, TERMINATION = CLOSED)

Contains Ordnance Survey data © Crown copyright and database rights 2019.

© Crown copyright and database rights 2019 OS Licence Number AL10005237.



Rev.	Rev. Date	DESCRIPTION	PC	JA	SC	PH
CO1	03/05/19	ISSUE FOR SUBMISSION				

**JACOBS**  
1180 Ewkside Road, Winchester, Hampshire, SO41 5TU  
Tel: +44(0)118 946 7000 • Fax: +44(0)118 946 7001  
www.jacobs.com

Client: Esso Petroleum Company, Limited  
Emryn House,  
Emryn Way,  
Leatherhead,  
Surrey,  
KT22 8UX

Project: Southampton to London Pipeline Project

Drawing title:  
**GENERAL ARRANGEMENT  
SHEET 51  
REGULATION 5 (2)(O)**

Drawing status: **Fit for Stage Approval**

Scale	1:2500	DO NOT SCALE
Jacobs No.	B2325300	Rev
Client no.		Rev
Drawing number		CO1


B2325300-JAC-000-CIV-DRG-000561

© Copyright 2019 Jacobs U.K. Jacobs' services and intellectual property are provided under the provisions of Jacobs' Use or copying of this document in whole or in part without the written permission of Jacobs constitutes an infringement of copyright. Limitation: This drawing has been prepared on behalf of and for the exclusive use of Jacobs' Client, and is subject to and issued in accordance with the provisions of the contract between Jacobs and the Client. Jacobs accepts no liability or responsibility whatsoever for its use in respect of any other project or reference. This drawing is an A1 sized drawing.

C:\pwworking\jacobs\_uk\_water\utilities\_sas4\bjp\rdms\3513\B2325300-JAC-000-CIV-DRG-000561.dwg - 03/05/2019 13:19:05 - A1Frame - BTaylor

**ENLARGED PLAN - VA**  
SCALE 1:500



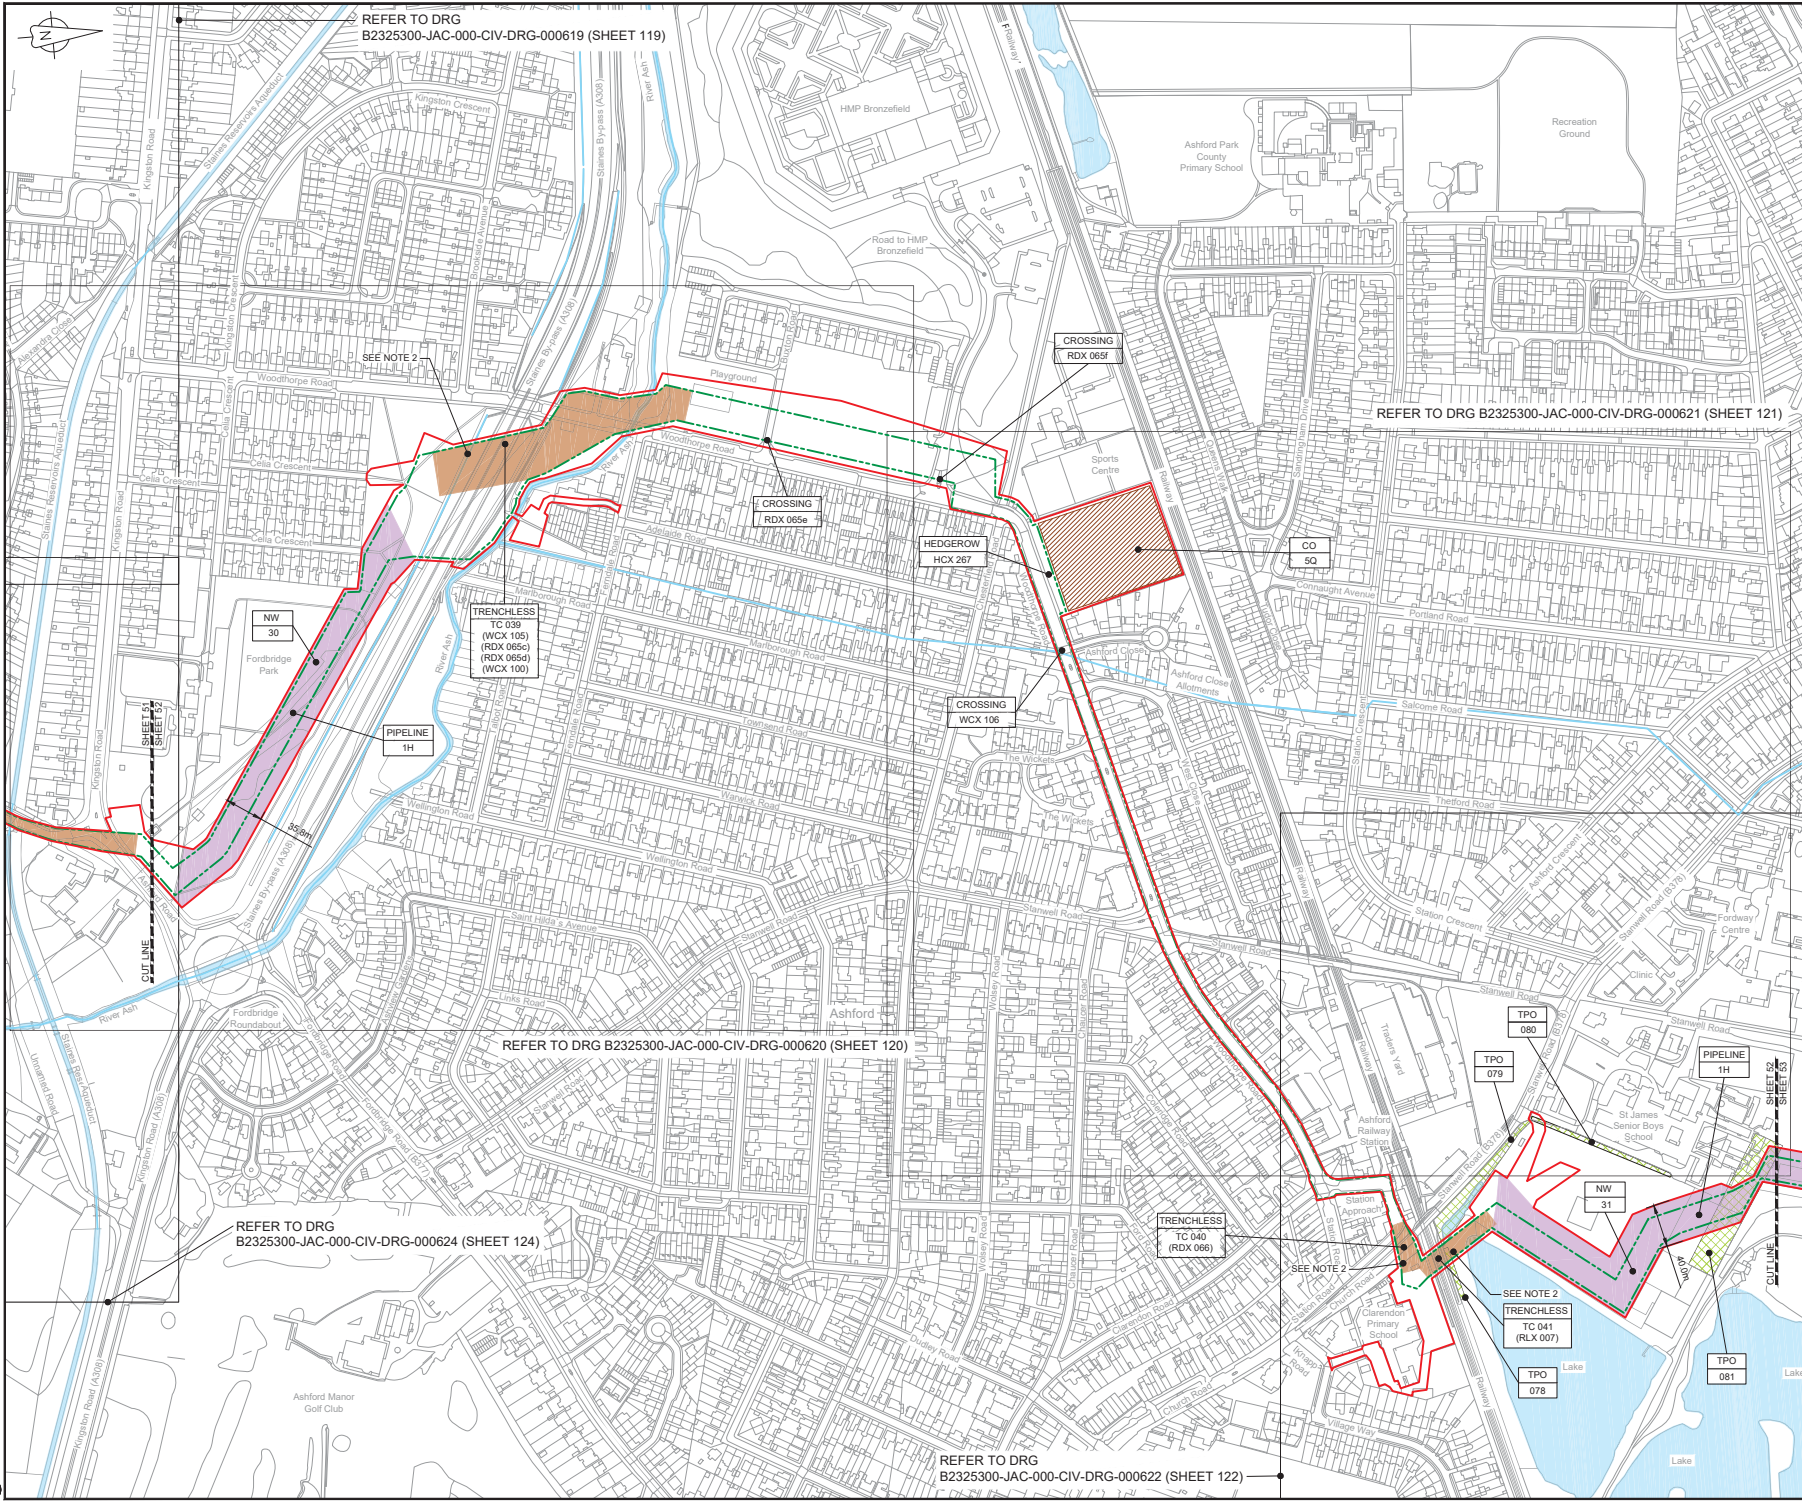


LOCATION PLAN  
SCALE 1:500,000

- NOTES**
1. THIS DRAWING IS IN METRES UNLESS STATED OTHERWISE.
  2. TRENCHLESS CROSSINGS ARE INDICATIVE ONLY.

- LEGEND**
- ORDER LIMITS
  - LIMITS OF DEVIATION
  - NARROW WORKING AREA (NW)
  - TRENCHLESS CROSSING (TC)
  - WATER BODIES
  - ABOVE GROUND INSTALLATION (AGI) / VALVE (VA) / PRESSURE TRANSDUCER (PT)
  - COMPOUND (CO)
  - TREE PRESERVATION ORDER (TPO)
  - DESCRIPTION
  - ID or WORK NUMBER (if applicable)
  - COMMENCEMENT / TERMINATION OF WORKS (COMMENCEMENT = OPEN, TERMINATION = CLOSED)

Contains Ordnance Survey data © Crown copyright and database rights 2019.

 © Crown copyright and database rights 2019 OS Licence Number AL10005237.



CD1	03/05/19	003/SUBMISSION	PC	JA	SC	PH
Rev.	Rev. Date	Purpose of revision	Drawn	Checked	Rev'd	Approved

**JACOBS**  
1180 Ewlish Road, Winchester, Wokingham, RG41 5TU  
Tel: +44(0)118 946 7000 • Fax: +44(0)118 946 7001  
www.jacobs.com

Client: Esso Petroleum Company, Limited  
Emryn House,  
Emryn Way,  
Leatherhead,  
Surrey,  
KT22 8UX

Project: **Esso** Southampton to London Pipeline Project

Drawing title: **GENERAL ARRANGEMENT SHEET 52 REGULATION 5 (2)(O)**


Drawing status: **Fit for Stage Approval**

Scale	1:2500	DO NOT SCALE
Client No.	B2325300	Rev
Client ref.		Rev
Drawing number		CO1

Drawing number: **B2325300-JAC-000-CIV-DRG-000562**

C:\pwworking\jacobs\_uk\_water\utilities\_s44\tdaylor\dms13513\B2325300-JAC-000-CIV-DRG-000562.dwg - 03/05/2019 13:23:16 - A1Frame - BTaylor



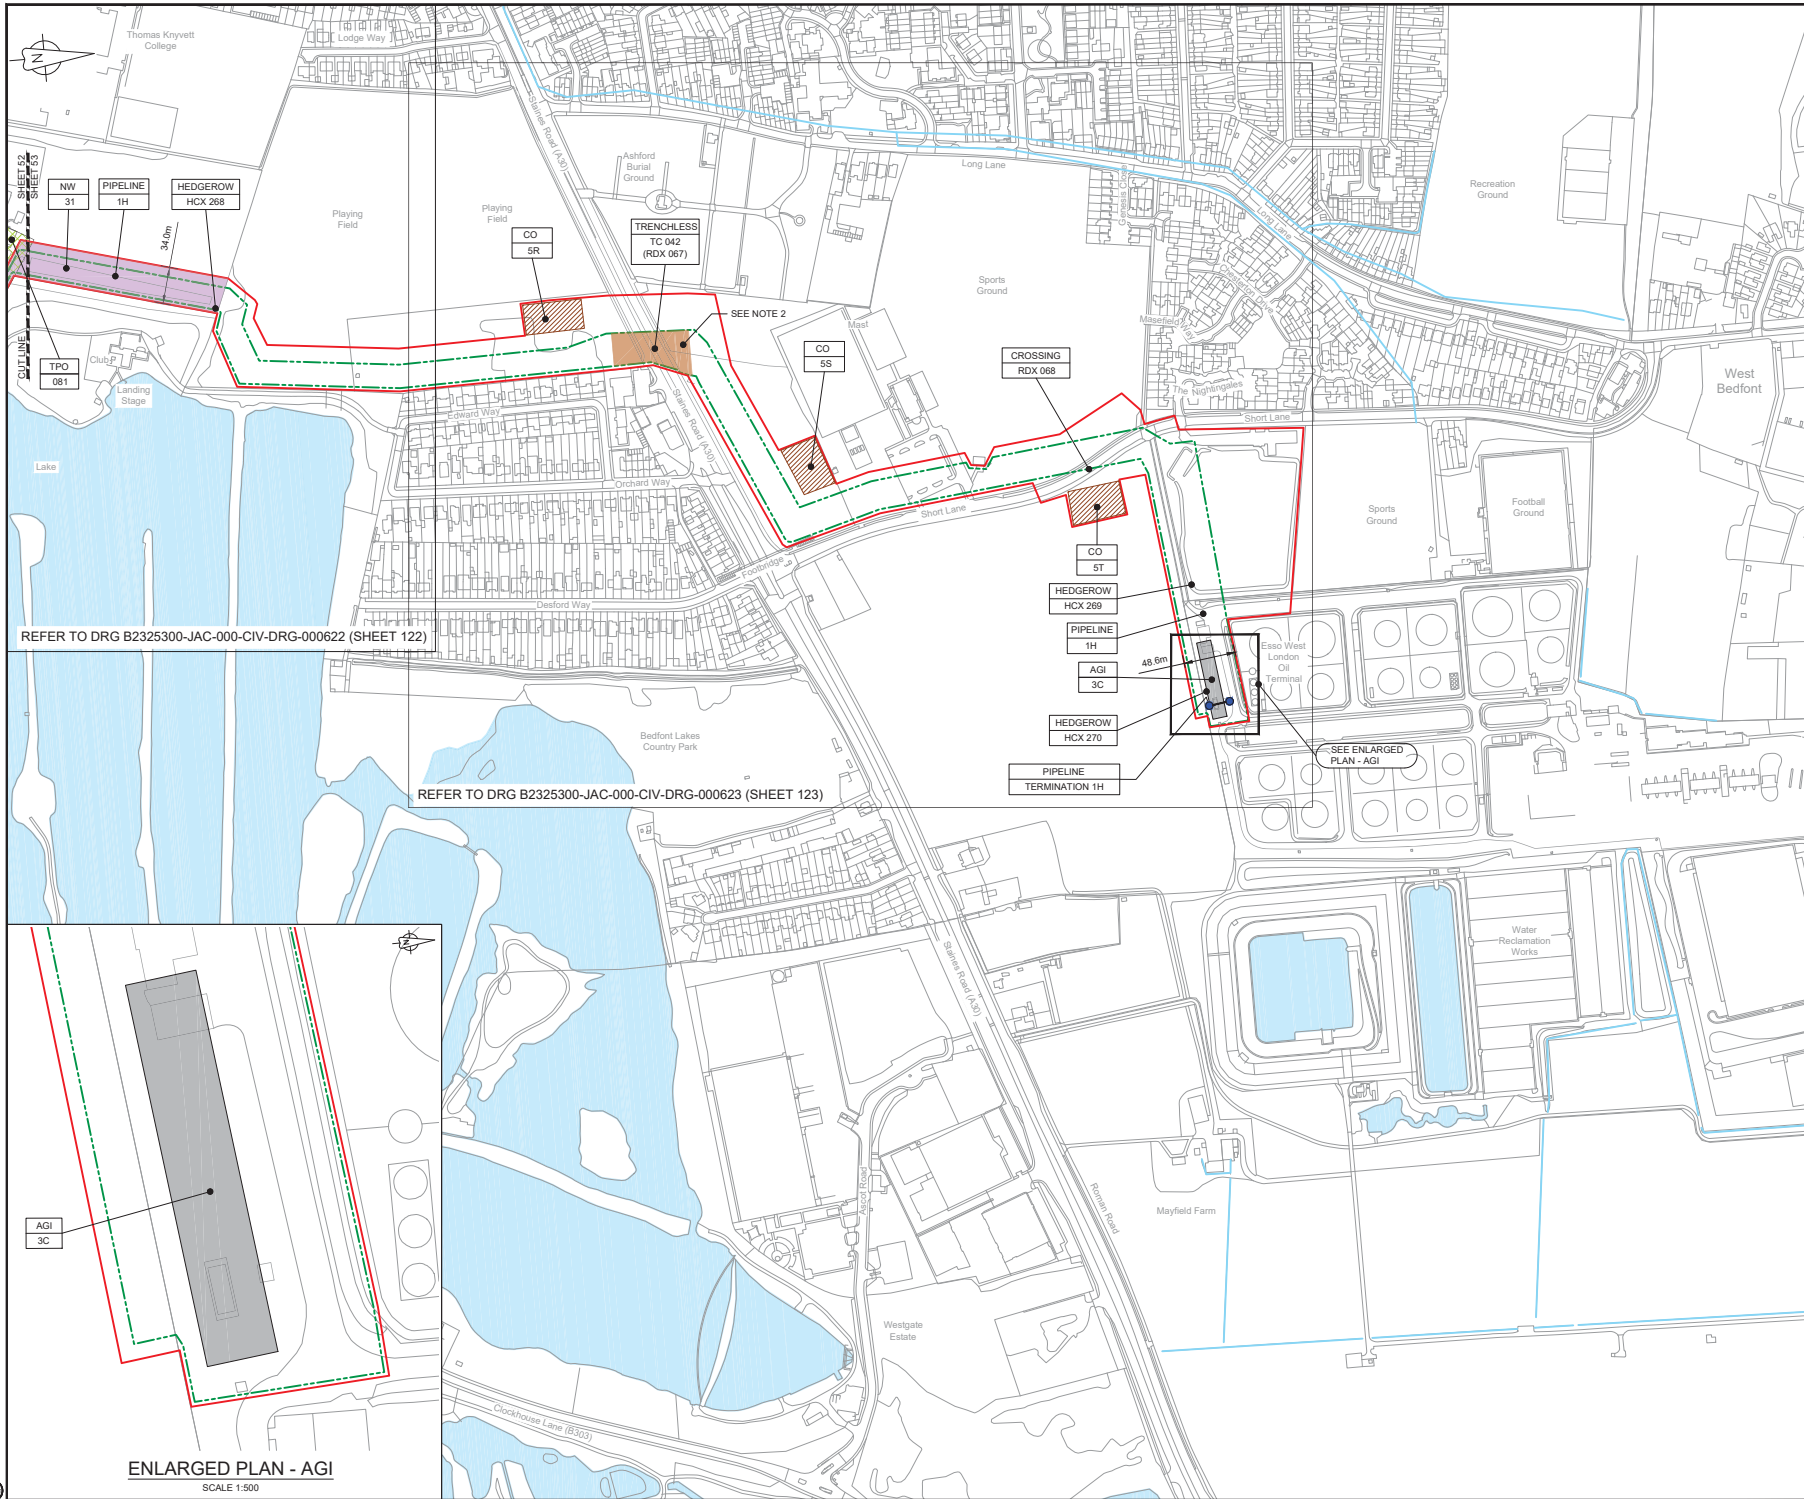

**NOTES**

- THIS DRAWING IS IN METRES UNLESS STATED OTHERWISE.
- TRENCHLESS CROSSINGS ARE INDICATIVE ONLY.

**LEGEND**

	ORDER LIMITS
	LIMITS OF DEVIATION
	NARROW WORKING AREA (NW)
	TRENCHLESS CROSSING (TC)
	WATER BODIES
	ABOVE GROUND INSTALLATION (AGI) / VALVE (VA) / PRESSURE TRANSDUCER (PT)
	COMPOUND (CO)
	TREE PRESERVATION ORDER (TPO)
	DESCRIPTION
	ID or WORK NUMBER (if applicable)
	COMMENCEMENT / TERMINATION OF WORKS (COMMENCEMENT = OPEN, TERMINATION = CLOSED)

Contains Ordnance Survey data © Crown copyright and database rights 2019.

© Crown copyright and database rights 2019 OS Licence Number AL10005237.



CD1	03/05/19	0001 SUBMISSION	PC	JA	SC	PH
Rev.	Rev. Date	Purpose of revision	Drawn	Checked	Rev'd	Approved

**JACOBS**  
1180 Epsom Road, Winchester, Hampshire, RG41 5TU  
Tel: +44(0)118 946 7000 • Fax: +44(0)118 946 7001  
www.jacobs.com

Client: Esso Petroleum Company Limited  
Ermin House,  
Ermin Way,  
Leatherhead,  
Surrey,  
KT22 8UX

Project: Southampton to London Pipeline Project

Drawing title: **GENERAL ARRANGEMENT SHEET 53 REGULATION 5 (2)(O)**


Drawing status: **Fit for Stage Approval**

Scale	1:2500	DO NOT SCALE
Jacobs No.	B2325300	Rev
Client no.		CO1
Drawing number	B2325300-JAC-000-CIV-DRG-000563	

C:\pwworking\jacobs\_uk\_water\_utilities\_s44\byrd\m3513\B2325300-JAC-000-CIV-DRG-000563.dwg - 03/05/2019 14:22:43 - A1Frame - BTaylor

**ENLARGED PLAN - AGI**  
SCALE 1:500



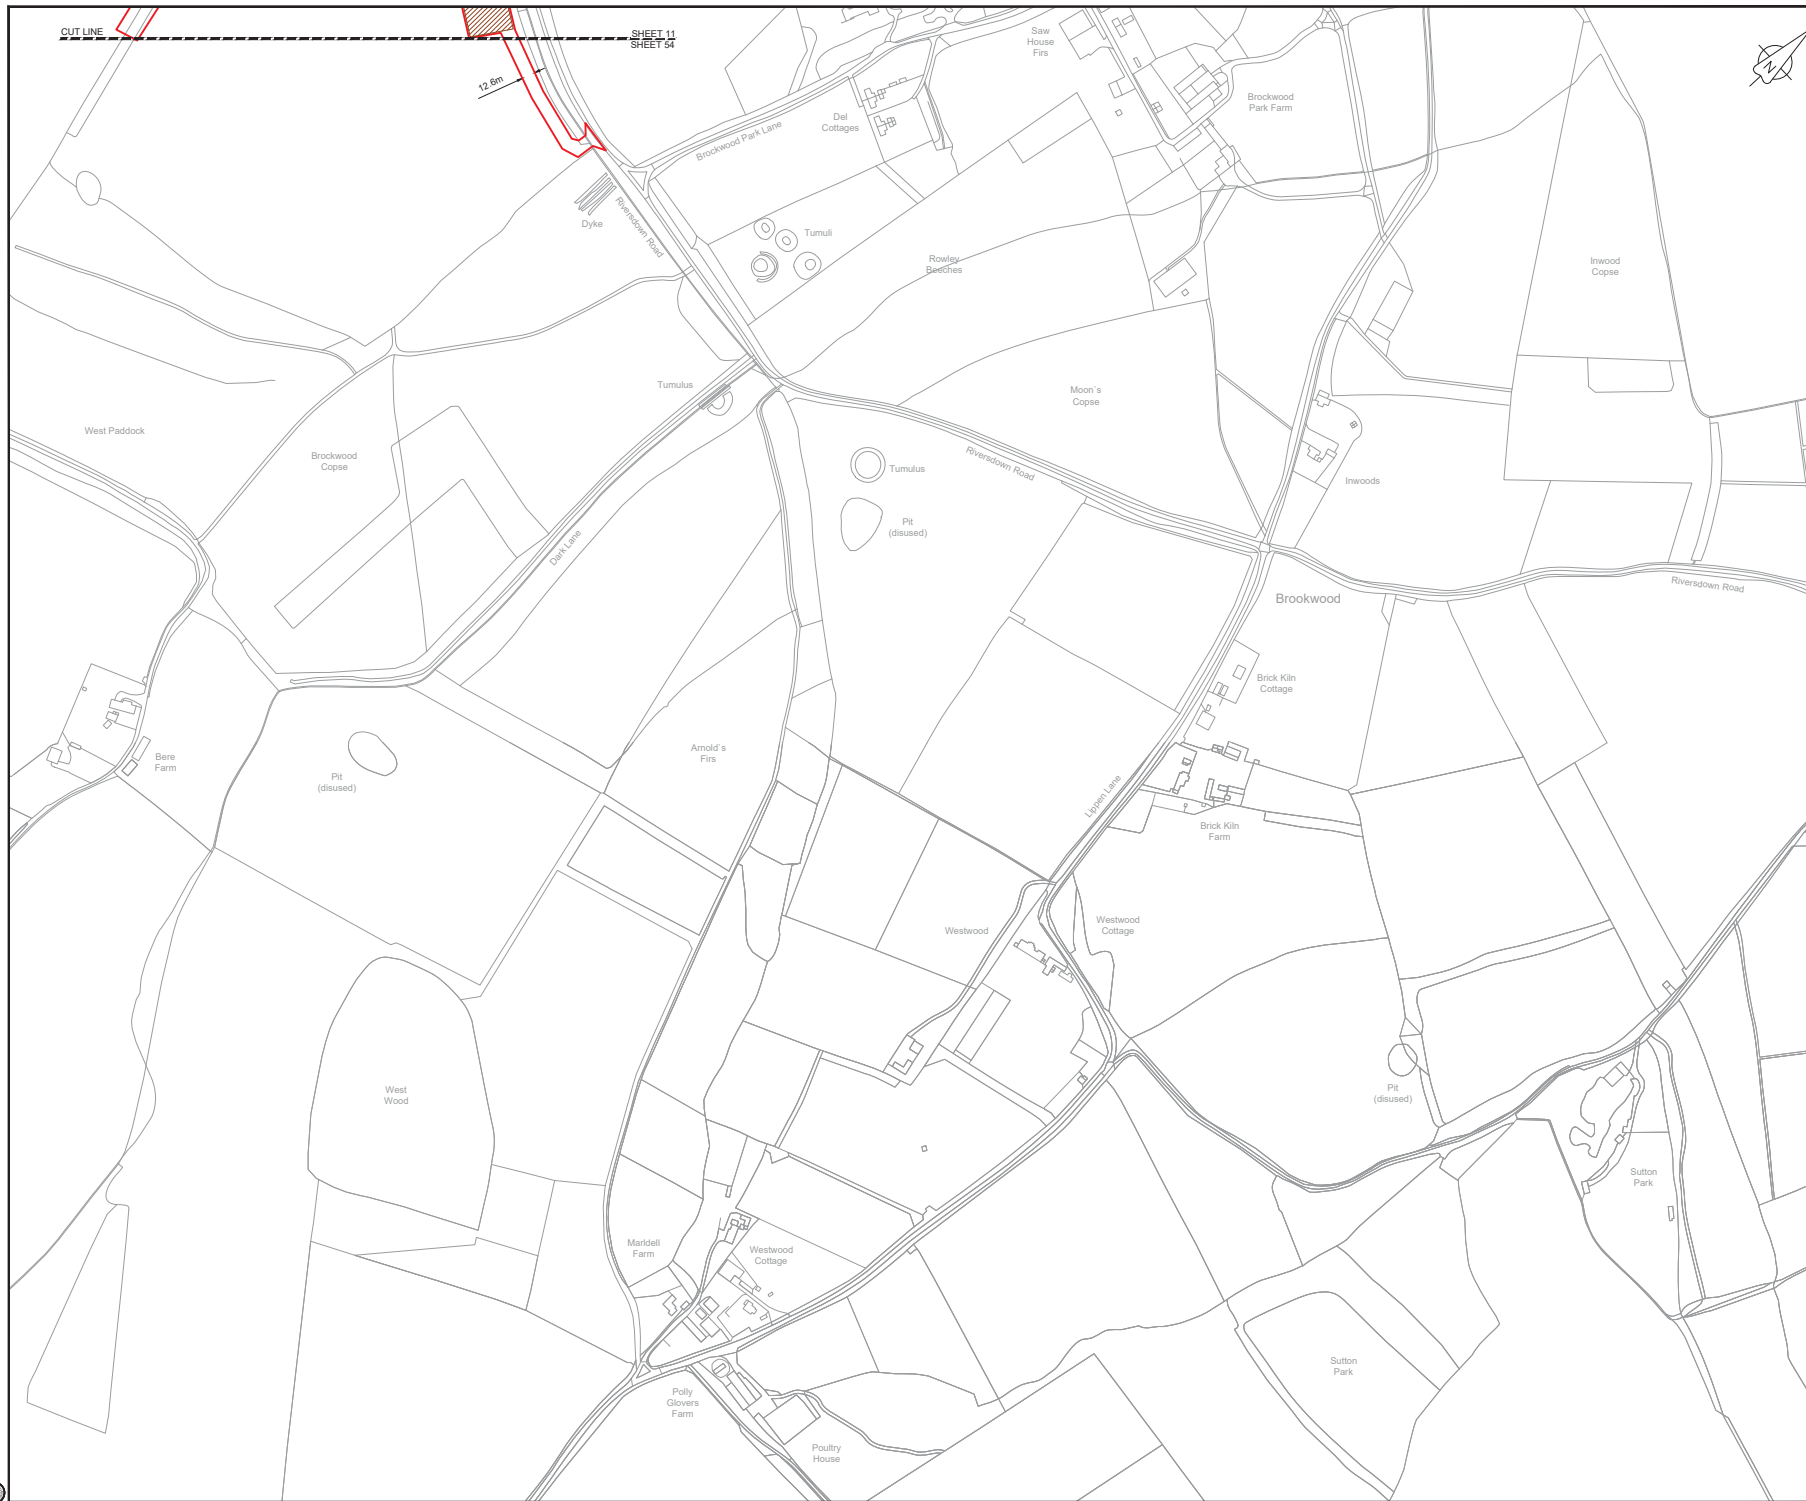

LOCATION PLAN  
SCALE 1:500,000


- NOTES**
1. THIS DRAWING IS IN METRES UNLESS STATED OTHERWISE.
  2. TRENCHLESS CROSSINGS ARE INDICATIVE ONLY.

**LEGEND**

 - ORDER LIMITS
- - - LIMITS OF DEVIATION
- NARROW WORKING AREA (NW)
- TRENCHLESS CROSSING (TC)
- WATER BODIES
- ABOVE GROUND INSTALLATION (AGI) / VALVE (VA) / PRESSURE TRANSDUCER (PT)
- COMPOUND (CO)
- TREE PRESERVATION ORDER (TPO)
- DESCRIPTION
- ID or WORK NUMBER (if applicable)
- COMMENCEMENT / TERMINATION OF WORKS (COMMENCEMENT = OPEN, TERMINATION = CLOSED)

Contains Ordnance Survey data © Crown copyright and database rights 2019.

© Crown copyright and database rights 2019 OS Licence Number AL10005237.



CD1	03/05/19	0003/00/00/0000	PC	JA	SC	PH
Rev.	Rev. Date	Purpose of revision	Drawn	Checked	Rev'd	Approved




Client: Esso Petroleum Company, Limited  
Emryn House,  
Emryn Way,  
Leatherhead,  
Surrey,  
KT22 8UX



Drawing title  
**GENERAL ARRANGEMENT  
SHEET 54  
REGULATION 5 (2)(O)**

Drawing status: **Fit for Stage Approval**

Scale	1:2500	DO NOT SCALE
Jacobs No.	B2325300	Rev
Client no.		<b>C01</b>
Drawing number	<b>B2325300-JAC-000-CIV-DRG-000564</b>	

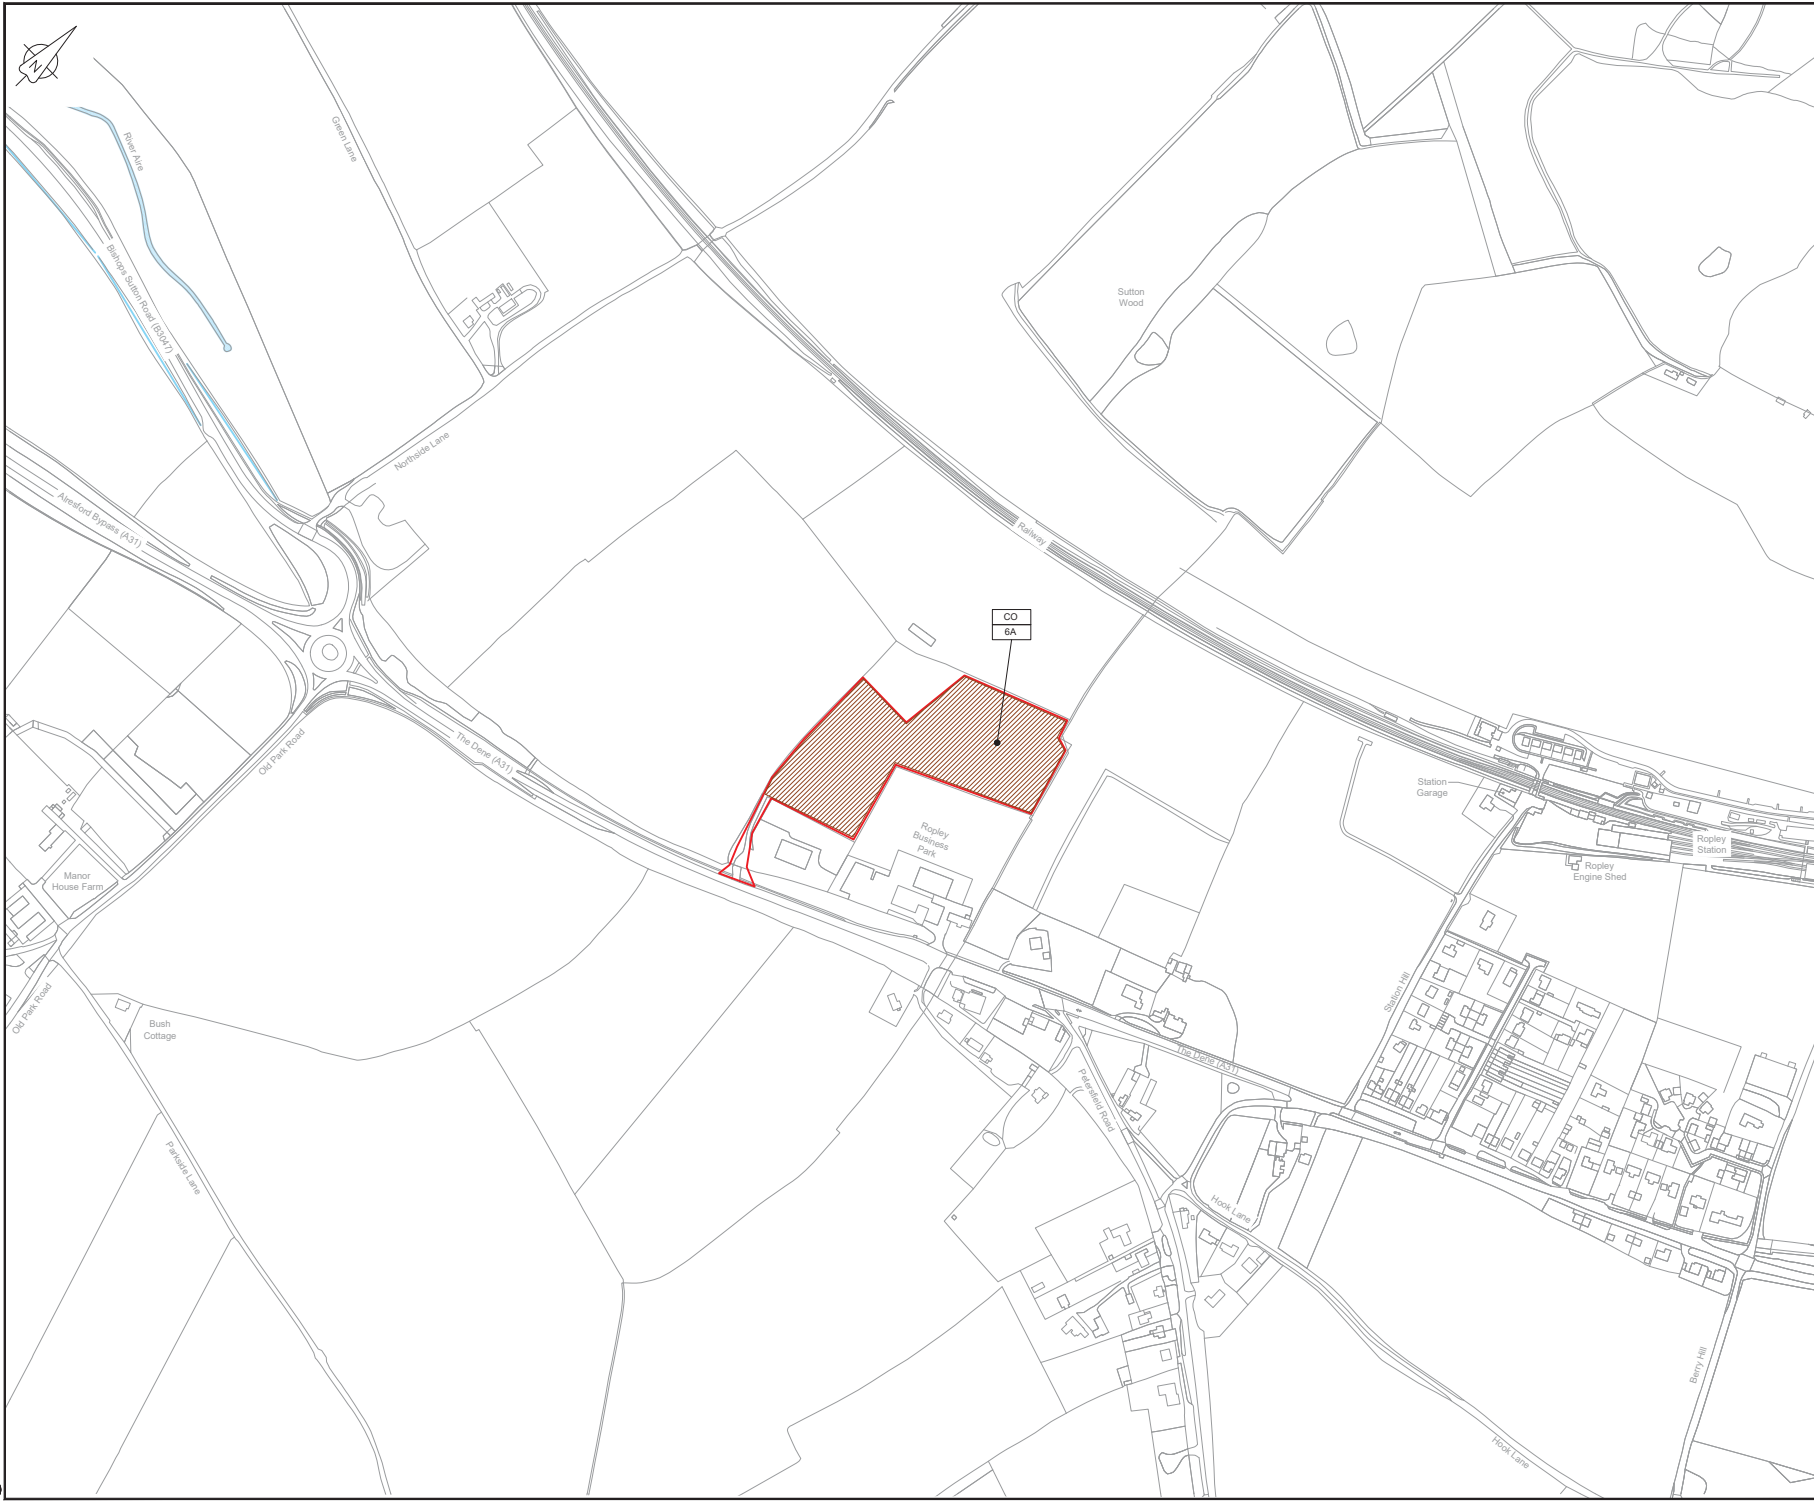


LOCATION PLAN  
SCALE 1:500,000

- NOTES**
1. THIS DRAWING IS IN METRES UNLESS STATED OTHERWISE.
  2. TRENCHLESS CROSSINGS ARE INDICATIVE ONLY.

- LEGEND**
- ORDER LIMITS
  - LIMITS OF DEVIATION
  - NARROW WORKING AREA (NW)
  - TRENCHLESS CROSSING (TC)
  - WATER BODIES
  - ABOVE GROUND INSTALLATION (AGI) / VALVE (VA) / PRESSURE TRANSDUCER (PT)
  - COMPOUND (CO)
  - TREE PRESERVATION ORDER (TPO)
  - DESCRIPTION
  - ID or WORK NUMBER (if applicable)
  - COMMENCEMENT / TERMINATION OF WORKS  
(COMMENCEMENT = OPEN, TERMINATION = CLOSED)

Contains Ordnance Survey data © Crown copyright and database rights 2019.

 © Crown copyright and database rights 2019 OS Licence Number AL10005237.



CD1	03/05/19	0001 SUBMISSION	PC	JA	SC	PH
Rev.	Rev. Date	Purpose of revision	Drawn	Checked	Rev'd	Approved

**JACOBS**  
1180 Epsom Road, Wokingham, Wokingham, RG41 5TU  
Tel: +44(0)118 946 7000 • Fax: +44(0)118 946 7001  
www.jacobs.com

Client: Esso Petroleum Company, Limited  
Emlyn House,  
Emlyn Way,  
Leatherhead,  
Surrey,  
KT22 8UX

Project: Southampton to London Pipeline Project


Drawing title:  
**GENERAL ARRANGEMENT  
SHEET 55  
REGULATION 5 (2)(O)**

Drawing status: **Fit for Stage Approval**

Scale	1:2500	DO NOT SCALE
Jacobs No.	B2325300	Rev
Client no.		<b>CO1</b>

Drawing number:  
**B2325300-JAC-000-CIV-DRG-000565**



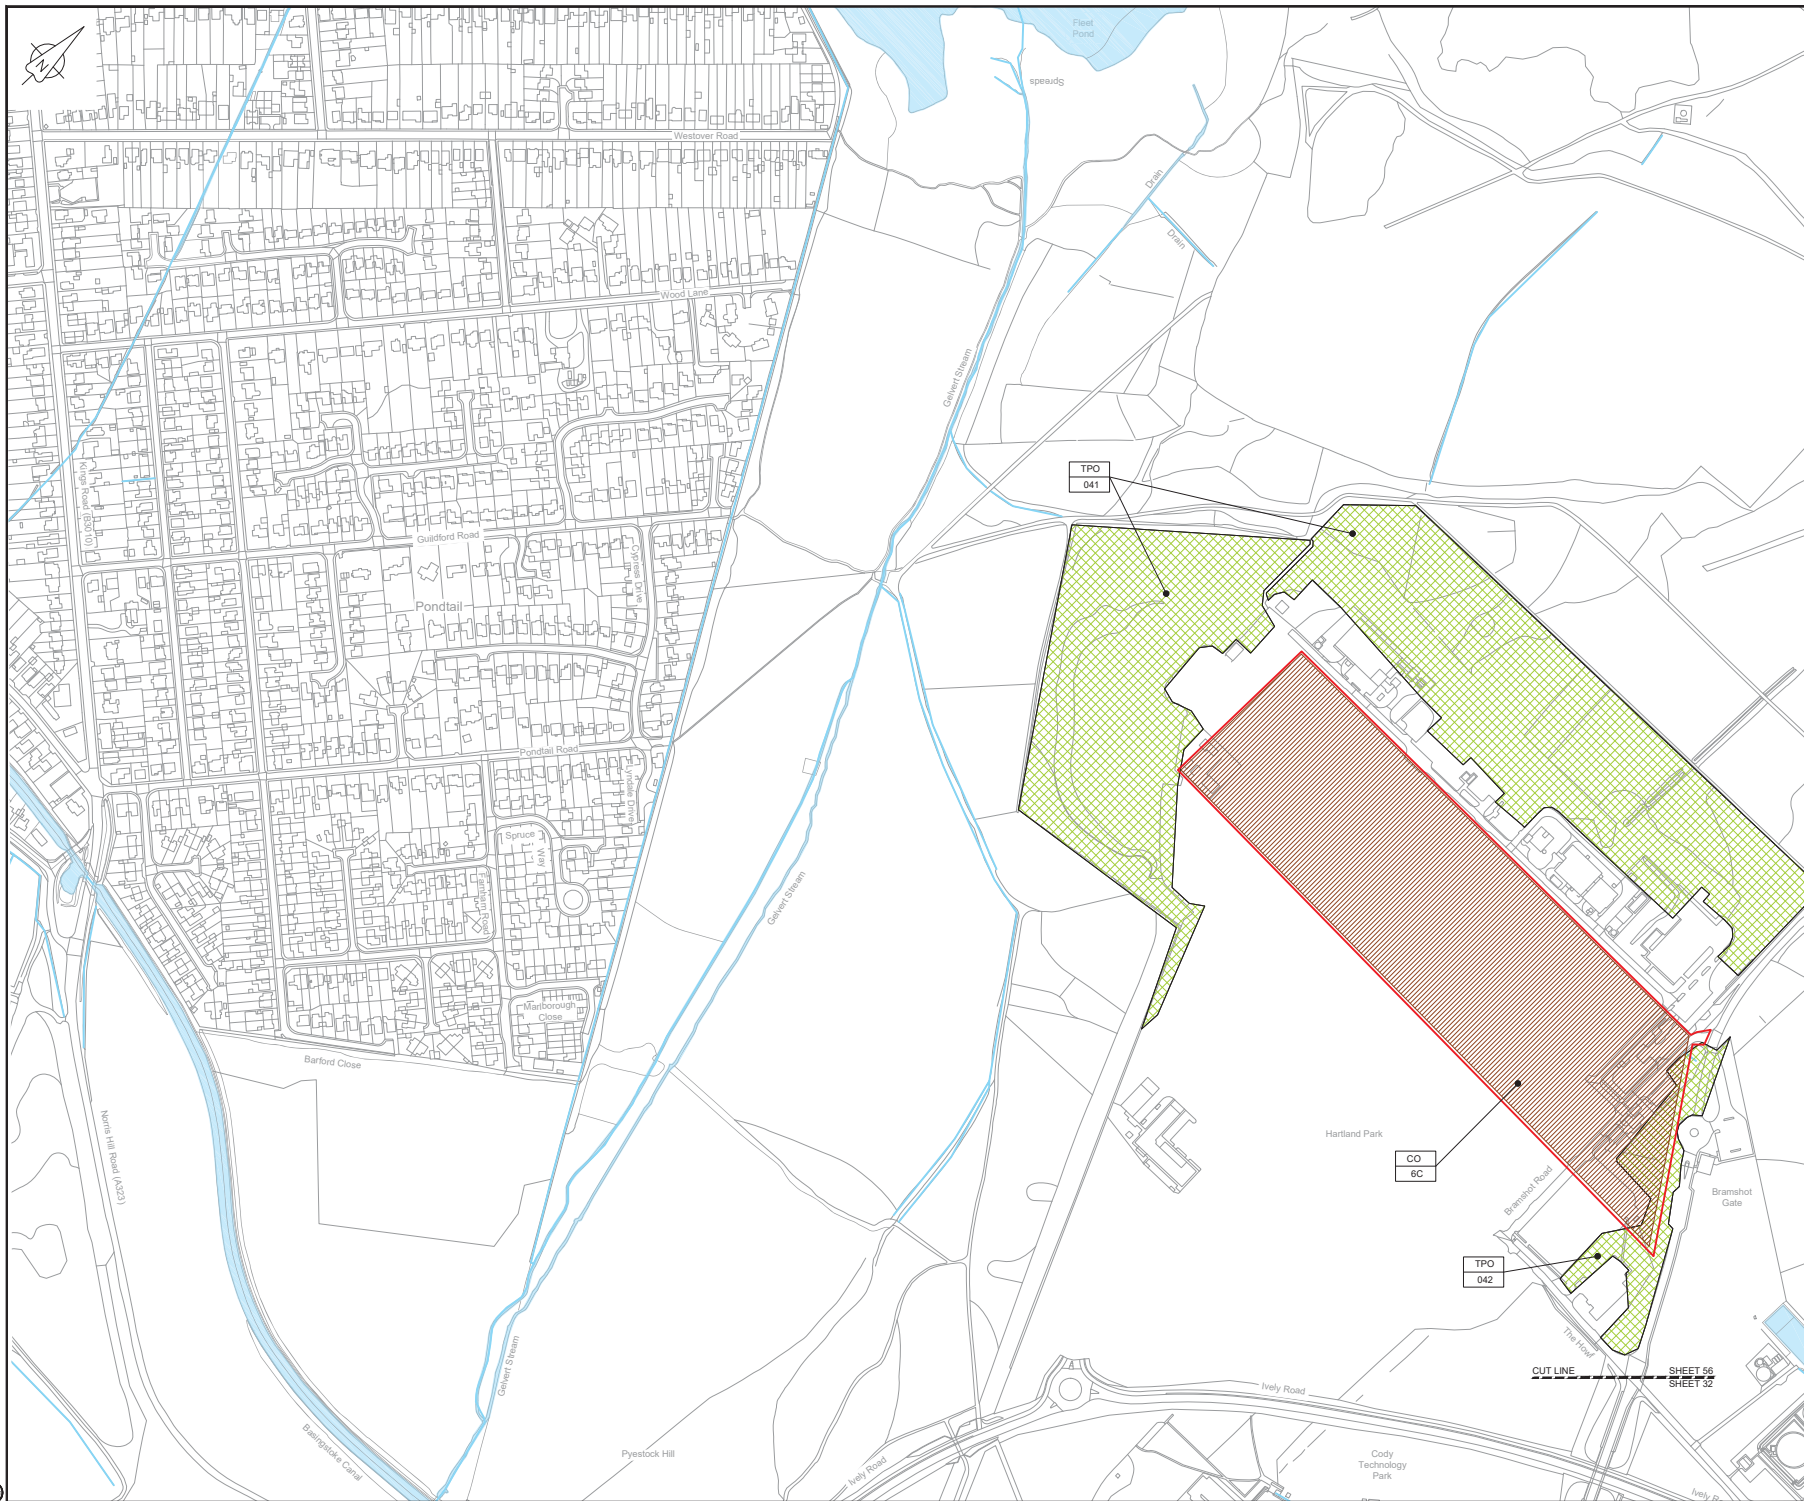

LOCATION PLAN  
SCALE 1:500,000

**NOTES**  
 1. THIS DRAWING IS IN METRES UNLESS STATED OTHERWISE.  
 2. TRENCHLESS CROSSINGS ARE INDICATIVE ONLY.

**LEGEND**

	ORDER LIMITS
	LIMITS OF DEVIATION
	NARROW WORKING AREA (NW)
	TRENCHLESS CROSSING (TC)
	WATER BODIES
	ABOVE GROUND INSTALLATION (AGI) / VALVE (VA) / PRESSURE TRANSDUCER (PT)
	COMPOUND (CO)
	TREE PRESERVATION ORDER (TPO)
	DESCRIPTION
	ID or WORK NUMBER (if applicable)
	COMMENCEMENT / TERMINATION OF WORKS (COMMENCEMENT = OPEN, TERMINATION = CLOSED)

Contains Ordnance Survey data © Crown copyright and database rights 2019.

© Crown copyright and database rights 2019 OS Licence Number AL10005237.



CD1	03/02/19	0001/0001/0001	PC	JA	SC	PH
Rev.	Rev. Date	Purpose of revision	Drawn	Checked	Rev'd	Approved

**JACOBS**  
 1180 Ewloe Road, Winchester, Hampshire, RG41 5TU  
 Tel: +44(0)118 946 7000 • Fax: +44(0)118 946 7001  
 www.jacobs.com

Client: Esso Petroleum Company, Limited  
 Emryn House,  
 Emryn Way,  
 Leatherhead,  
 Surrey,  
 KT22 8UX

Project: Southampton to London Pipeline Project

Drawing title:  
**GENERAL ARRANGEMENT  
 SHEET 56  
 REGULATION 5 (2)(O)**


Drawing status: **Fit for Stage Approval**

Scale	1:2500	DO NOT SCALE
Jacobs No.	B2325300	Rev
Client no.	B2325300	Rev
Drawing number		<b>CO1</b>

B2325300-JAC-000-CIV-DRG-000566

© Copyright 2019 Jacobs U.K. Limited. This drawing and all other documents contained herein are the property of Jacobs U.K. Limited. No part of this document may be reproduced, stored in a retrieval system, or transmitted in any form or by any means, electronic, mechanical, photocopying, recording, or by any information storage and retrieval system, without the prior written permission of Jacobs U.K. Limited. This drawing has been prepared in the best of good faith and to the best of our knowledge and belief. It is intended for use as a reference only. It is not intended to be used as a contract document. It is not intended to be used as a contract document. It is not intended to be used as a contract document.



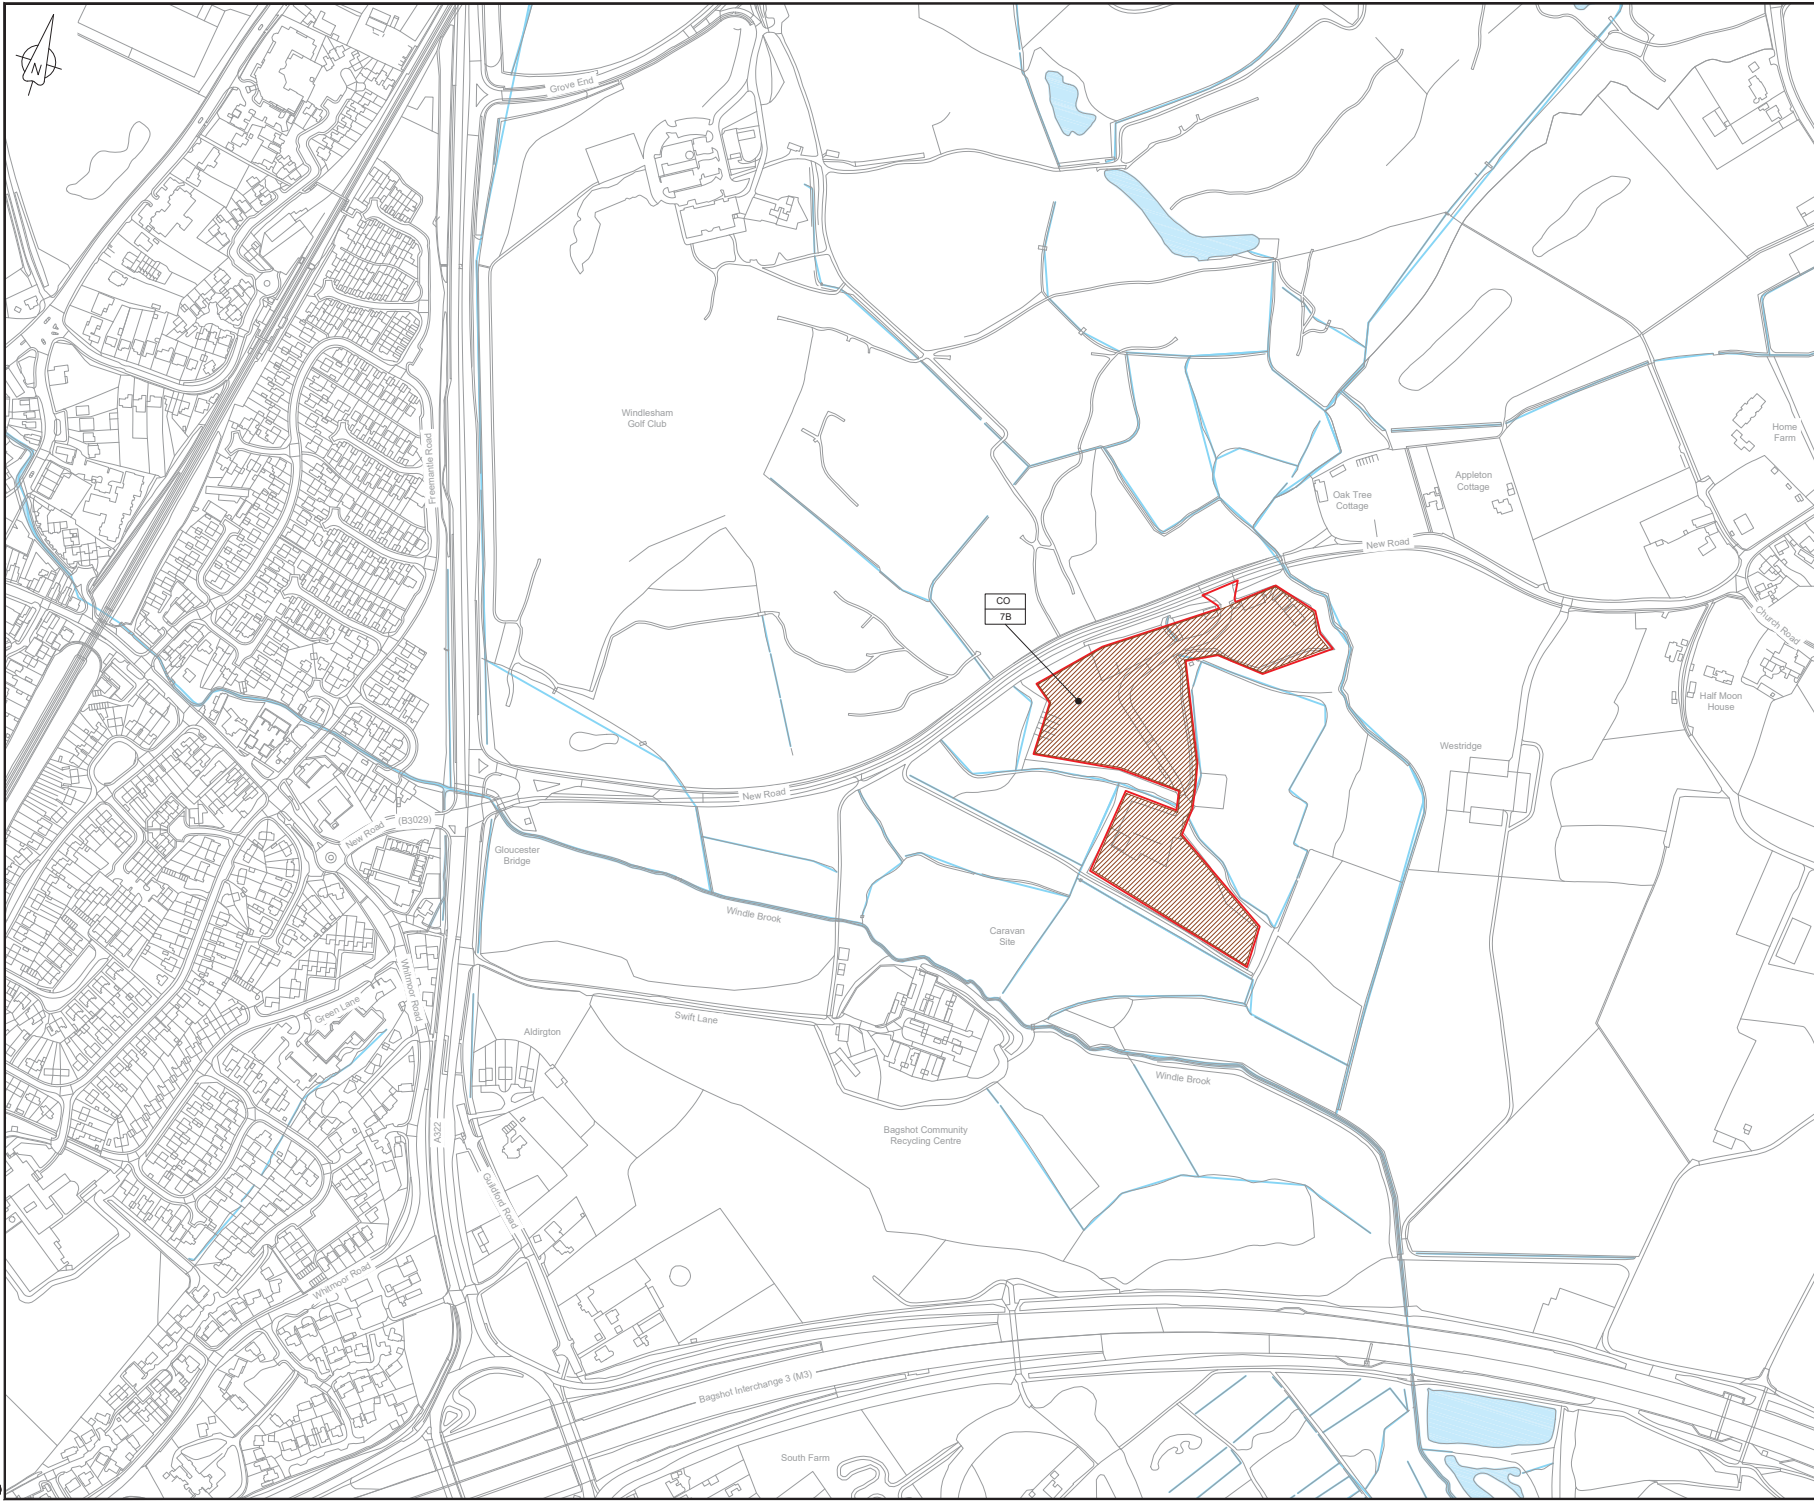

LOCATION PLAN  
SCALE 1:500,000


- NOTES**
1. THIS DRAWING IS IN METRES UNLESS STATED OTHERWISE.
  2. TRENCHLESS CROSSINGS ARE INDICATIVE ONLY.

**LEGEND**

 	ORDER LIMITS
	LIMITS OF DEVIATION
	NARROW WORKING AREA (NW)
	TRENCHLESS CROSSING (TC)
	WATER BODIES
	ABOVE GROUND INSTALLATION (AGI) / VALVE (VA) / PRESSURE TRANSDUCER (PT)
	COMPOUND (CO)
	TREE PRESERVATION ORDER (TPO)
	DESCRIPTION
	ID or WORK NUMBER (if applicable)
	COMMENCEMENT / TERMINATION OF WORKS (COMMENCEMENT = OPEN, TERMINATION = CLOSED)

Contains Ordnance Survey data © Crown copyright and database rights 2019.

© Crown copyright and database rights 2019 OS Licence Number AL10005237.



CD	Rev.	Date	DESCRIPTION	PC	JA	SC	PH
CO1	03/05/19						

**JACOBS**  
1180 Ewks Rd, Wokingham, Wokingham, RG41 5TU  
Tel: +44(0)118 946 7000 • Fax: +44(0)118 946 7001  
www.jacobs.com

Client: Esso Petroleum Company, Limited  
Emlyn House,  
Emlyn Way,  
Leatherhead,  
Surrey,  
KT22 8UX



Project: **GENERAL ARRANGEMENT SHEET 57 REGULATION 5 (2)(O)**


Drawing status: **Fit for Stage Approval**

Scale	1:2500	DO NOT SCALE
Jacobs No.	B2325300	Rev
Client no.		CO1

Drawing number: **B2325300-JAC-000-CIV-DRG-000567**

C:\pwworking\jacobs\_uk\_water\utilities\_sas4\tdp\tdms\B2325300-JAC-000-CIV-DRG-000567.dwg - 03/05/2019 13:35:02 - A1Frame - BTaylor



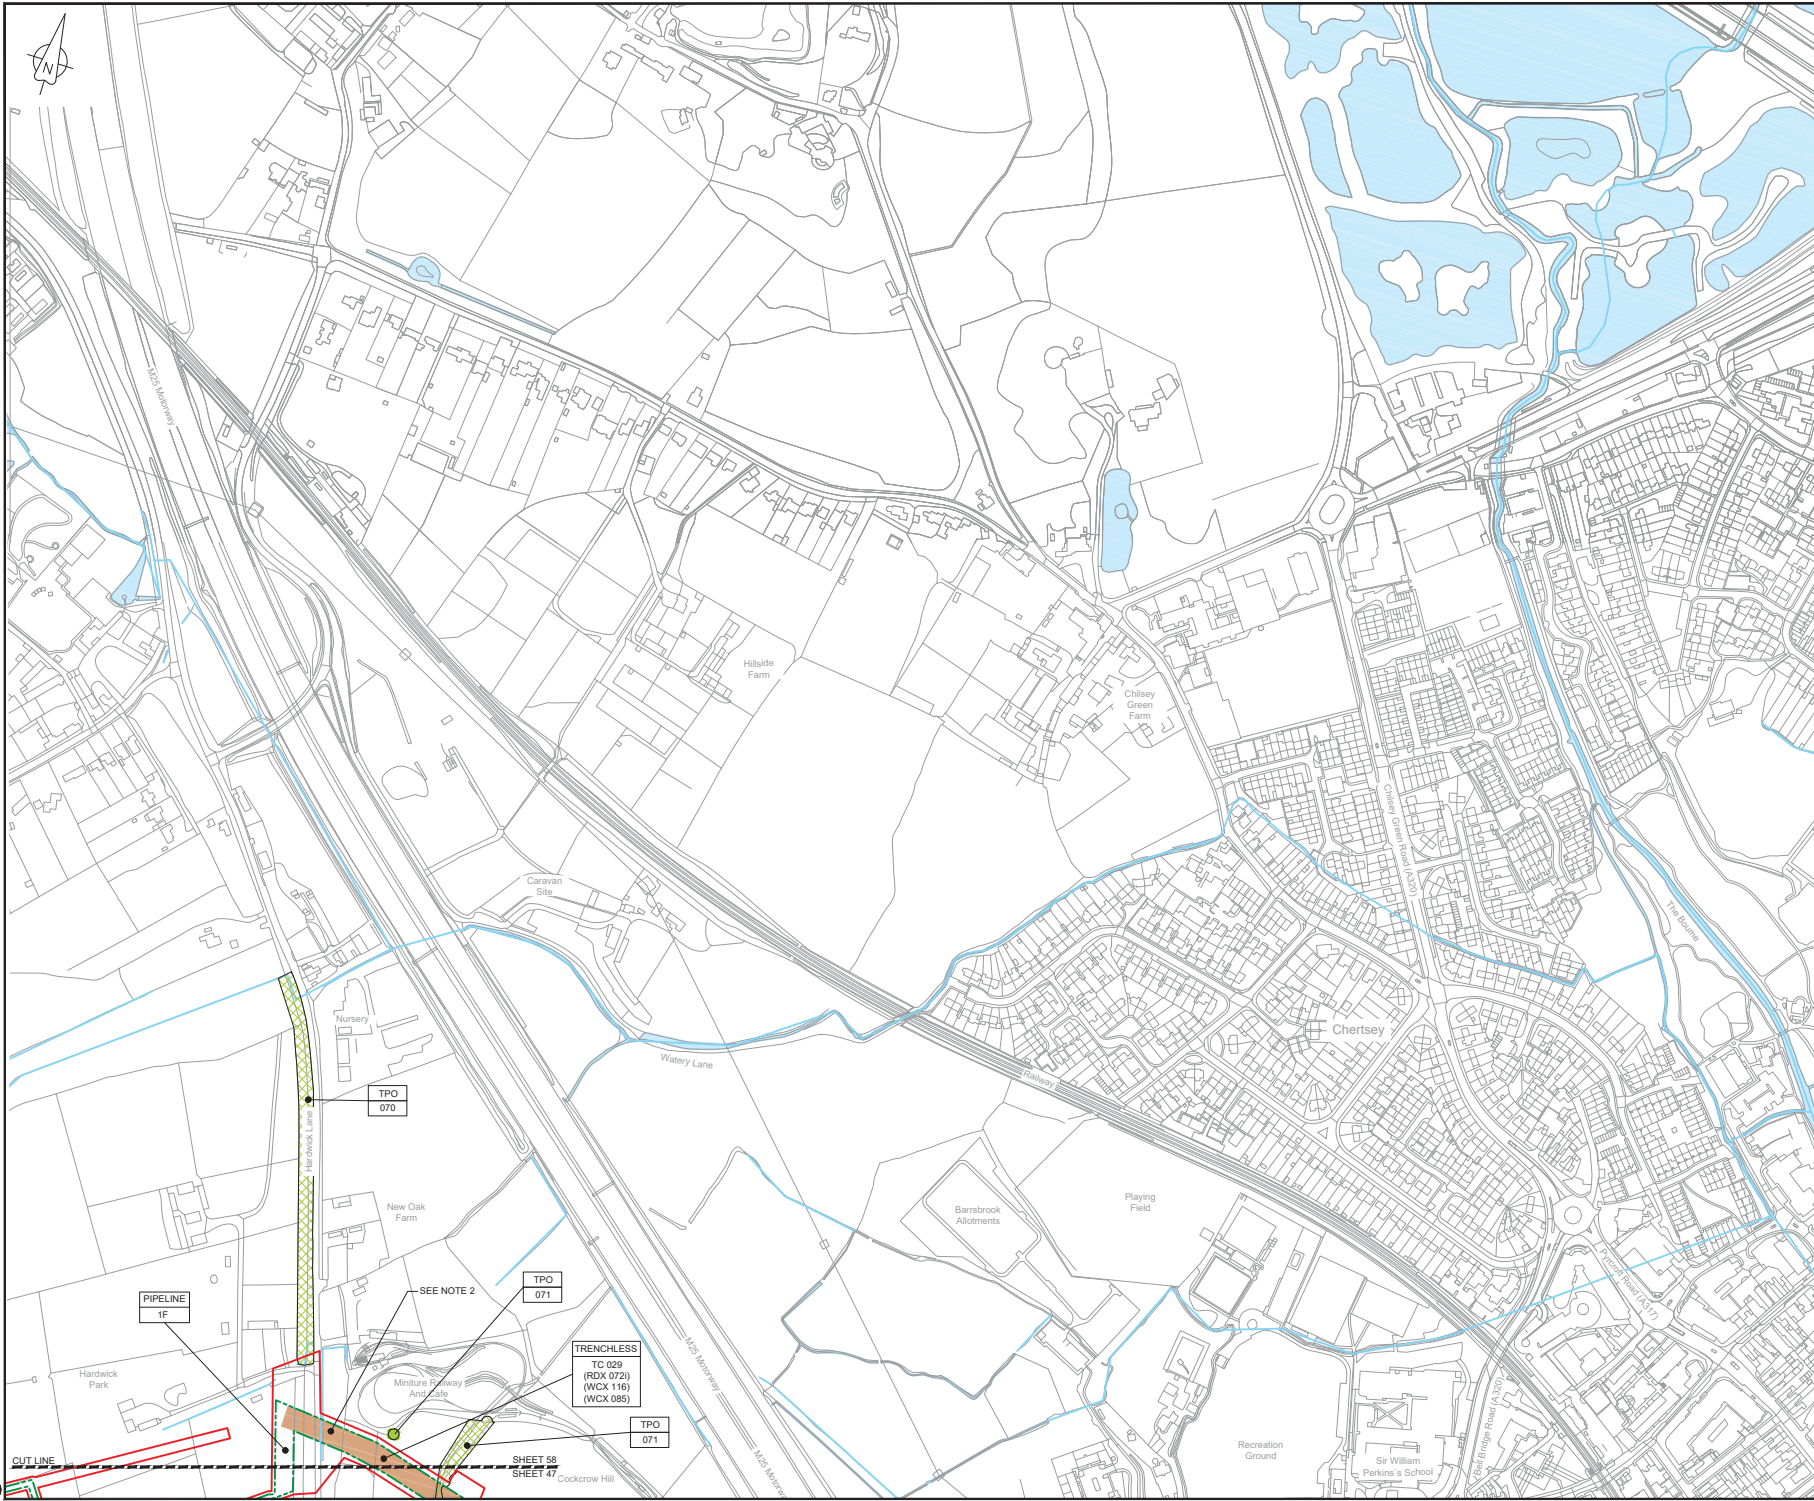


LOCATION PLAN  
SCALE 1:500,000

- NOTES**
1. THIS DRAWING IS IN METRES UNLESS STATED OTHERWISE.
  2. TRENCHLESS CROSSINGS ARE INDICATIVE ONLY.

- LEGEND**
- ORDER LIMITS
  - LIMITS OF DEVIATION
  - NARROW WORKING AREA (NW)
  - TRENCHLESS CROSSING (TC)
  - WATER BODIES
  - ABOVE GROUND INSTALLATION (AGI) / VALVE (VA) / PRESSURE TRANSDUCER (PT)
  - COMPOUND (CO)
  - TREE PRESERVATION ORDER (TPO)
  - DESCRIPTION
  - ID or WORK NUMBER (if applicable)
  - COMMENCEMENT / TERMINATION OF WORKS (COMMENCEMENT = OPEN, TERMINATION = CLOSED)

Contains Ordnance Survey data © Crown copyright and database rights 2019.

 © Crown copyright and database rights 2019 OS Licence Number AL10005237.



CD	03/05/19	0001 SUBMISSION	PC	JA	SC	PH
Rev.	Rev. Date	Purpose of revision	Drawn	Checked	Rev'd	Approved

**JACOBS**  
1180 Epsom Road, Wokingham, Wokingham, RG41 5TU  
Tel: +44(0)118 946 7000 • Fax: +44(0)118 946 7001  
www.jacobs.com

Client: Esso Petroleum Company Limited  
Ermyn House,  
Ermyn Way,  
Leatherhead,  
Surrey,  
KT22 8UX


Project: Southampton to London Pipeline Project

Drawing title:  
**GENERAL ARRANGEMENT  
SHEET 58  
REGULATION 5 (2)(O)**

Drawing status: **Fit for Stage Approval**

Scale	1:2500	DO NOT SCALE
Jacobs No.	B2325300	Rev
Client no.		CO1

Drawing number: **B2325300-JAC-000-CIV-DRG-000568**

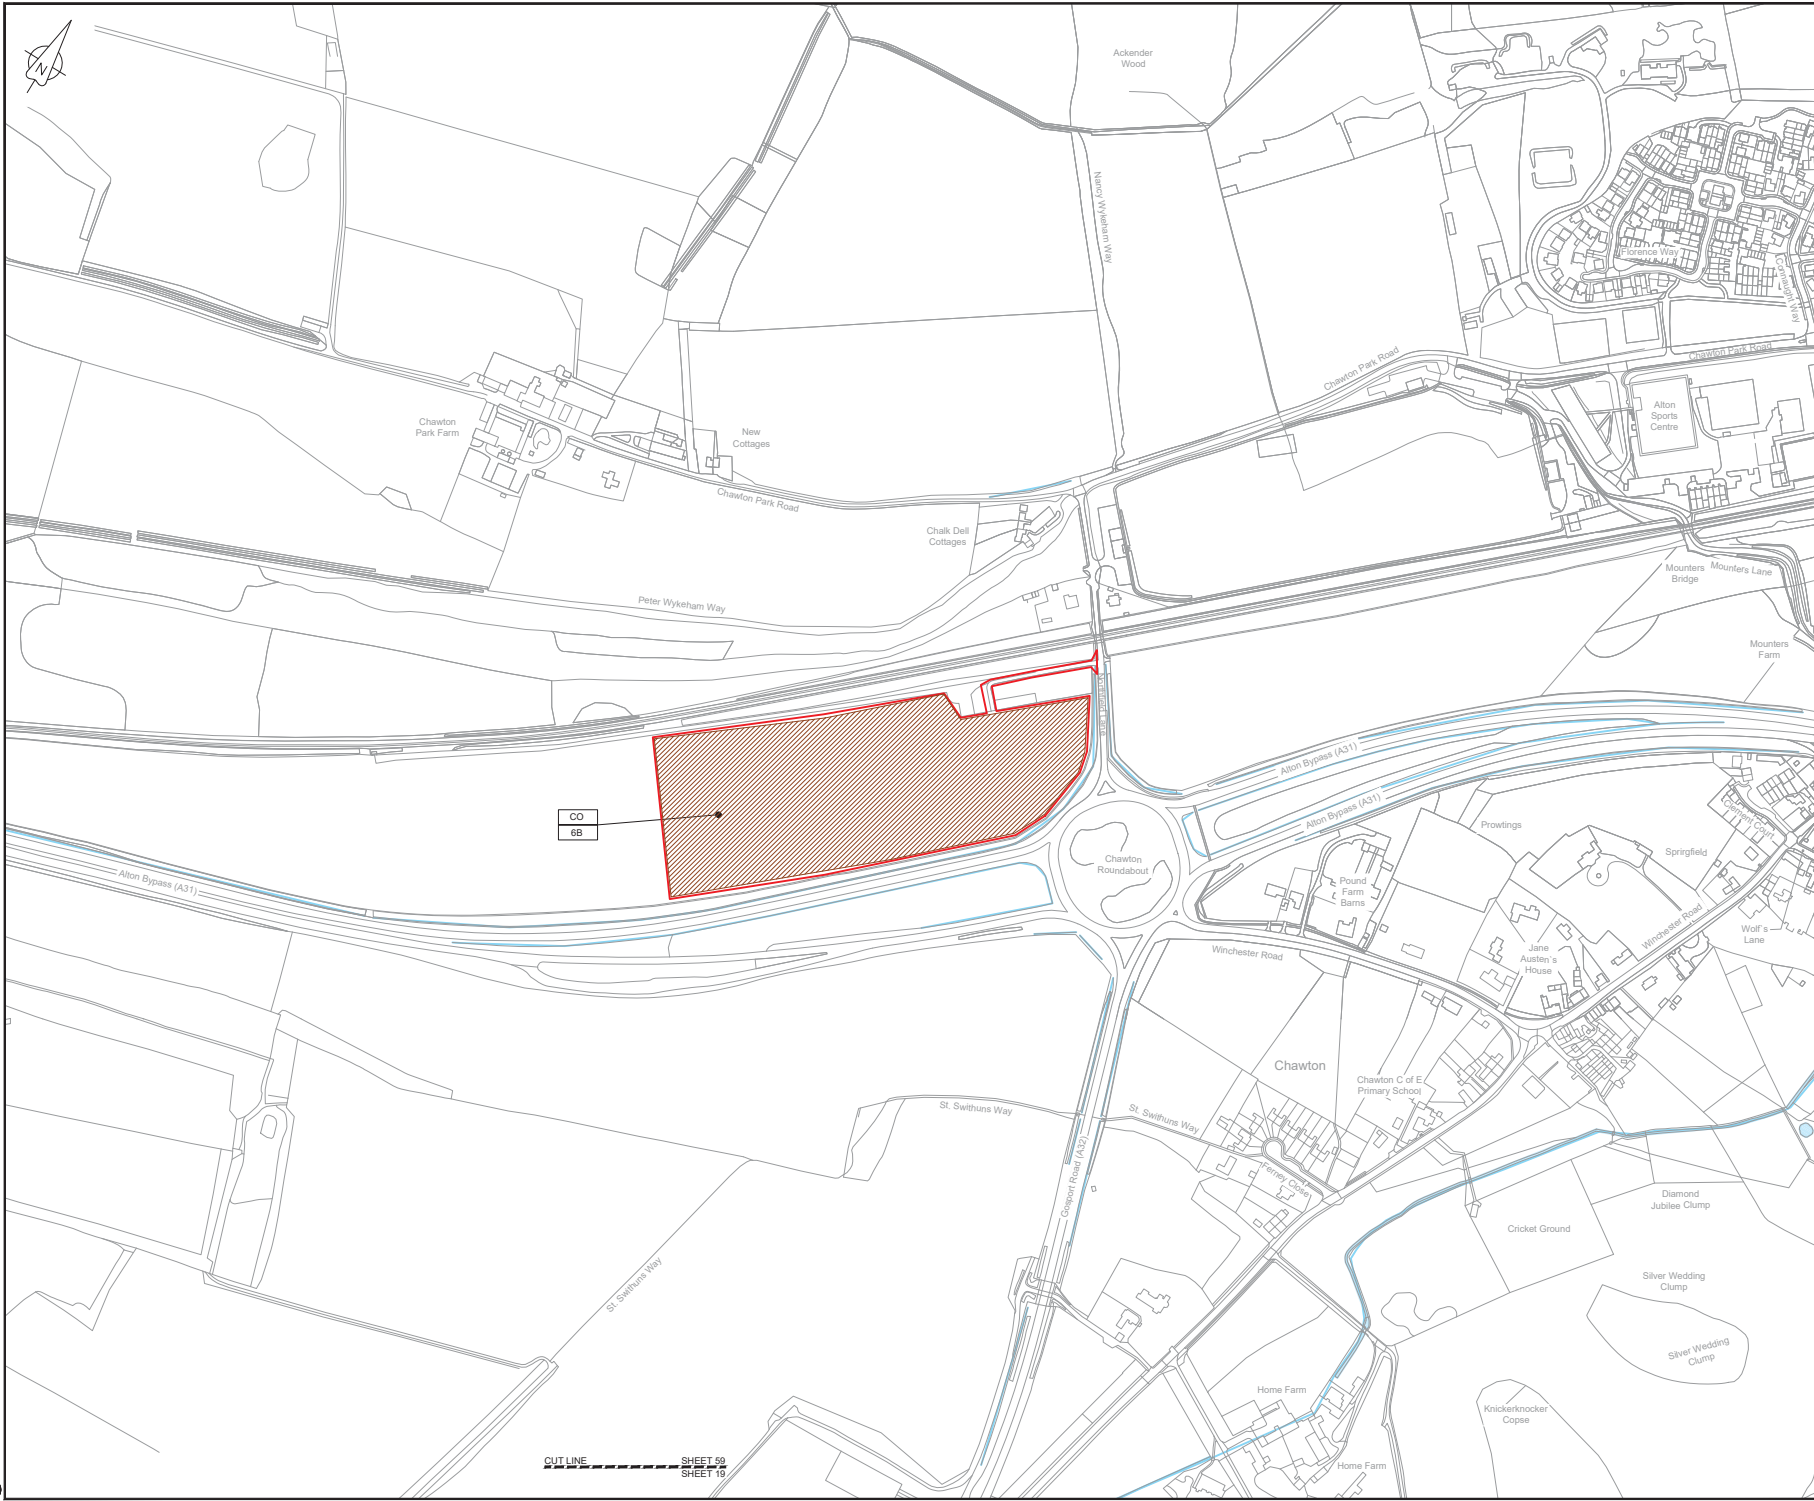

LOCATION PLAN  
SCALE 1:500,000

- NOTES**
1. THIS DRAWING IS IN METRES UNLESS STATED OTHERWISE.
  2. TRENCHLESS CROSSINGS ARE INDICATIVE ONLY.

**LEGEND**

	ORDER LIMITS
	LIMITS OF DEVIATION
	NARROW WORKING AREA (NW)
	TRENCHLESS CROSSING (TC)
	WATER BODIES
	ABOVE GROUND INSTALLATION (AGI) / VALVE (VA) / PRESSURE TRANSDUCER (PT)
	COMPOUND (CO)
	TREE PRESERVATION ORDER (TPO)
	DESCRIPTION
	ID or WORK NUMBER (if applicable)
	COMMENCEMENT / TERMINATION OF WORKS (COMMENCEMENT = OPEN, TERMINATION = CLOSED)

Contains Ordnance Survey data © Crown copyright and database rights 2019.  
© Crown copyright and database rights 2019 OS Licence Number AL100005237.



CD	03/05/19	0000 SUBMISSION	PC	JA	SC	PH
Rev.	Rev. Date	Purpose of revision	Drawn	Checked	Rev'd	Approved

**JACOBS**  
180 Exshaw Road, Winchester, Wokingham, RG41 5TU  
Tel: +44(0)118 946 7000 • Fax: +44(0)118 946 7001  
www.jacobs.com

Client: Esso Petroleum Company, Limited  
Ermyth House,  
Ermyth Way,  
Leatherhead,  
Surrey,  
KT22 8UX

Project: Southampton to London Pipeline Project

Drawing title:  
**GENERAL ARRANGEMENT  
SHEET 59  
REGULATION 5 (2)(O)**

Drawing status: **Fit for Stage Approval**

Scale	1:2500	DO NOT SCALE
Jacobs No.	B2325300	Rev
Client no.		CO1


Drawing number: **B2325300-JAC-000-CIV-DRG-000569**

© Copyright 2019 Jacobs U.K. Limited. This document and all rights contained herein are the property of Jacobs U.K. Limited. No part of this document may be reproduced, stored in a retrieval system, or transmitted in any form or by any means, electronic, mechanical, photocopying, recording, or by any information storage and retrieval system, without the prior written permission of Jacobs U.K. Limited. This drawing has been prepared in behalf of and for the exclusive use of Jacobs Client, and is not to be used in accordance with the provisions of the contract between Jacobs and the Client. Jacobs accepts no liability or responsibility whatsoever for its use in respect of any other project, or for any other use.

C:\pwworking\jacobs\_uk\_wester\dutils\sa4\blayfor\lms\B2325300-JAC-000-CIV-DRG-000569.dwg - 03/05/2019 13:41:04 - A1Frame - BTaylor

CUT LINE SHEET 59 SHEET 19



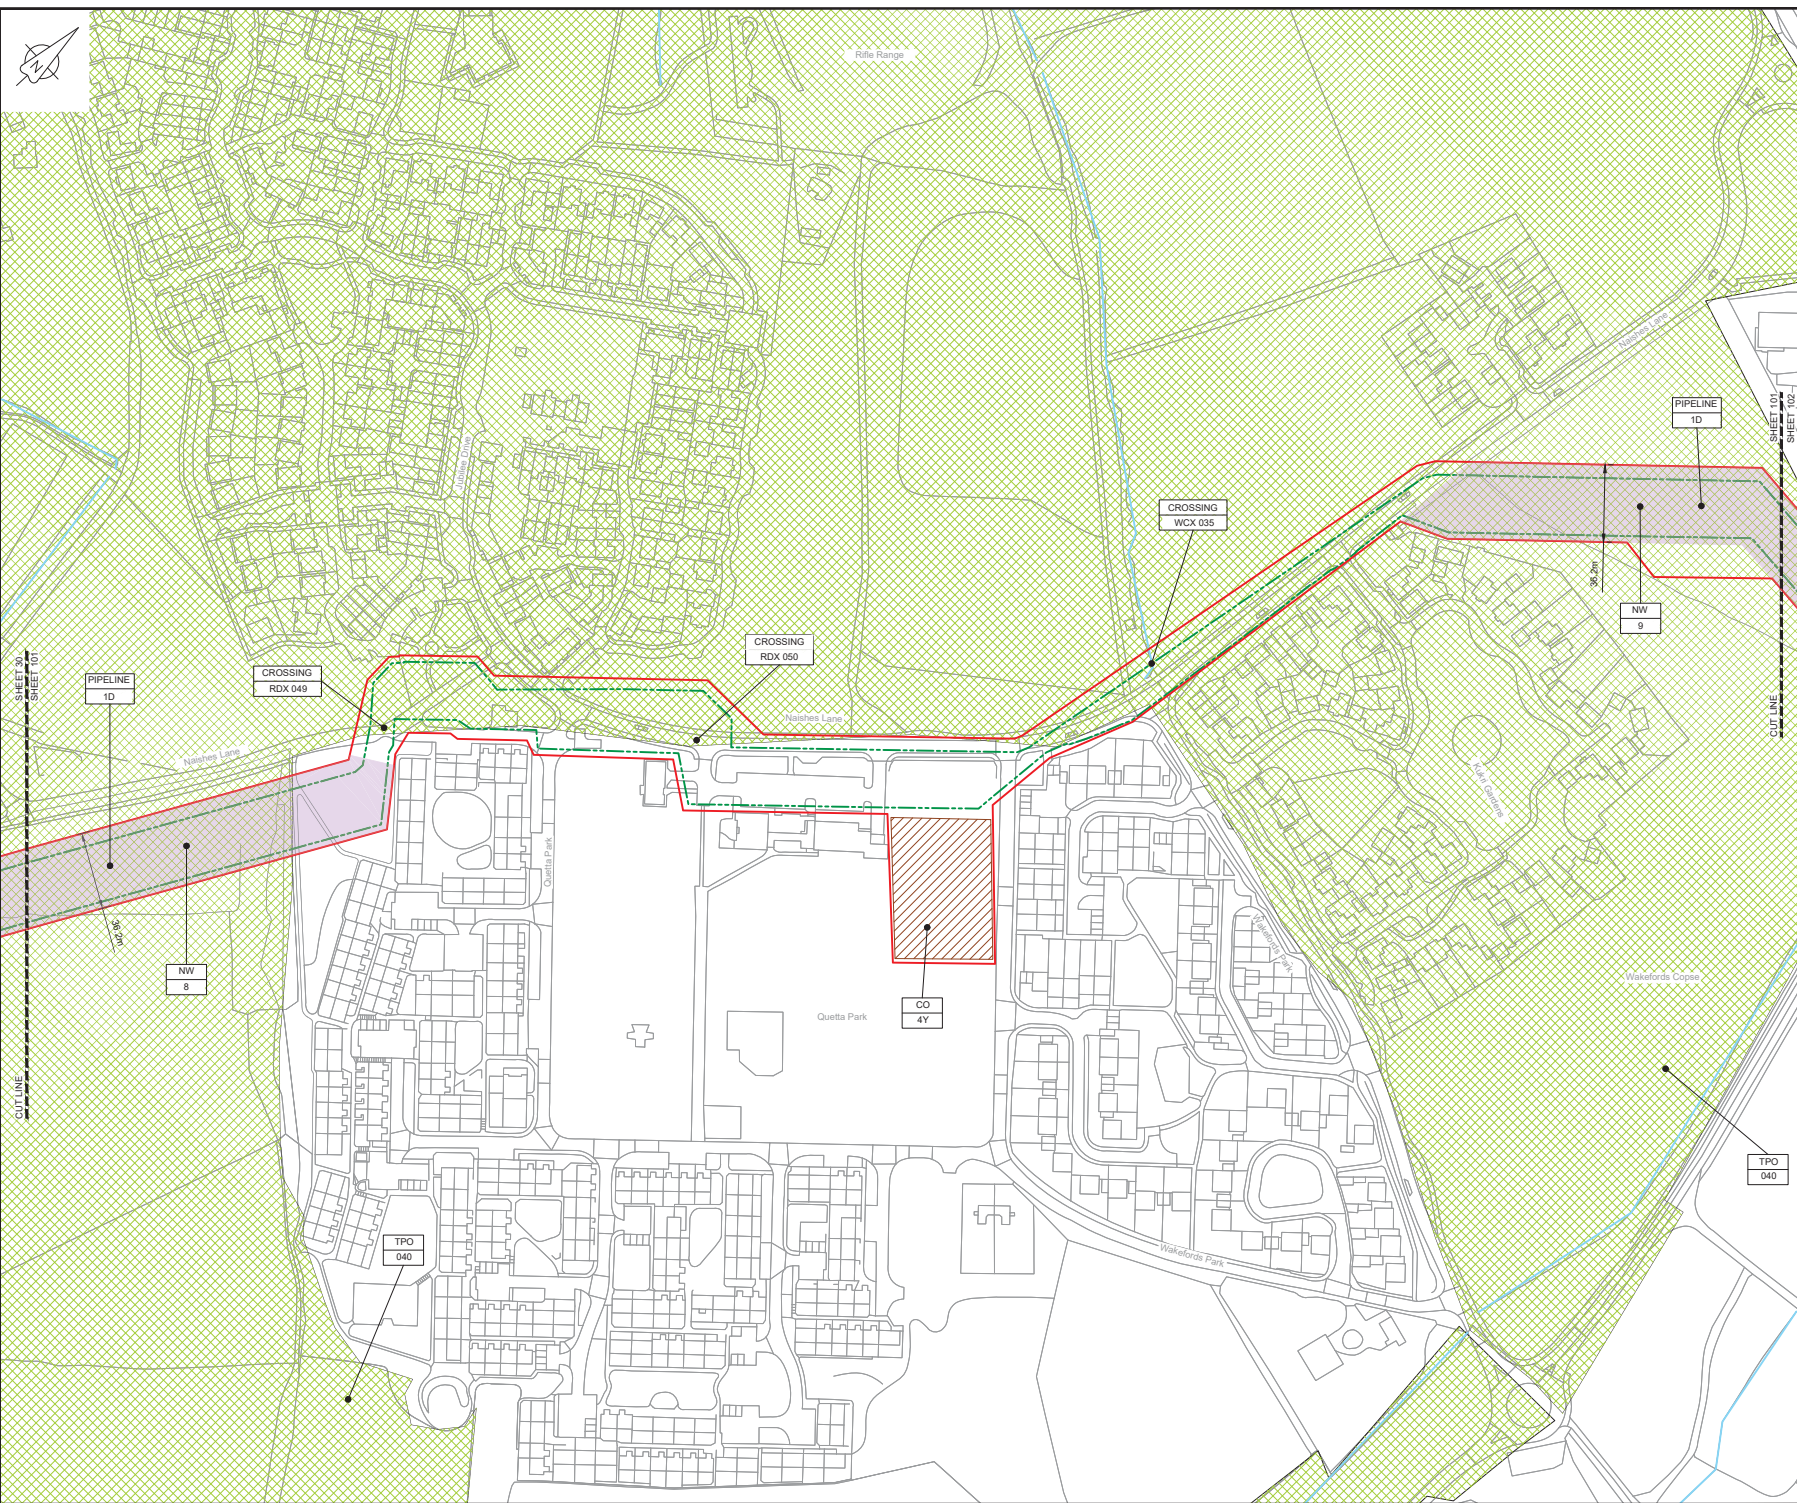

LOCATION PLAN  
SCALE 1:500,000

- NOTES**
1. THIS DRAWING IS IN METRES UNLESS STATED OTHERWISE.
  2. TRENCHLESS CROSSINGS ARE INDICATIVE ONLY.

- LEGEND**
- ORDER LIMITS
  - LIMITS OF DEVIATION
  - NARROW WORKING AREA (NW)
  - TRENCHLESS CROSSING (TC)
  - WATER BODIES
  - ABOVE GROUND INSTALLATION (AGI) / VALVE (VA) / PRESSURE TRANSDUCER (PT)
  - COMPOUND (CO)
  - TREE PRESERVATION ORDER (TPO)
  - DESCRIPTION
  - ID or WORK NUMBER (if applicable)
  - COMMENCEMENT / TERMINATION OF WORKS  
(COMMENCEMENT = OPEN, TERMINATION = CLOSED)

Contains Ordnance Survey data © Crown copyright and database rights 2019.

© Crown copyright and database rights 2019 OS Licence Number AL100005237.



CD	03/05/19	DDC SUBMISSION	PC	JA	SC	PH
Rev.	Rev. Date	Purpose of revision	Drawn	Checked	Rev'd	Approved

**JACOBS**  
1180 Ewks Rd, Winchester, Hampshire, SO41 5TU  
Tel: +44(0)118 946 7000 • Fax: +44(0)118 946 7001  
www.jacobs.com

Client: Esso Petroleum Company, Limited  
Ermyn House,  
Ermyn Way,  
Leatherhead,  
Surrey,  
KT22 8UX

Project: Southampton to London Pipeline Project

Drawing title:  
**GENERAL ARRANGEMENT  
SHEET 101  
REGULATION 5 (2)(O)**


Drawing status: **Fit for Stage Approval**

Scale	1:1250	DO NOT SCALE
Jacobs No.	B2325300	Rev
Client no.		<b>CO1</b>

Drawing number:  
**B2325300-JAC-000-CIV-DRG-000601**

C:\pwworking\jacobs\_uk\_water\utilities\_s44\byr\dms\3513\B2325300-JAC-000-CIV-DRG-000601.dwg - 03/05/2019 15:31:45 - A1Frame - BTaylor



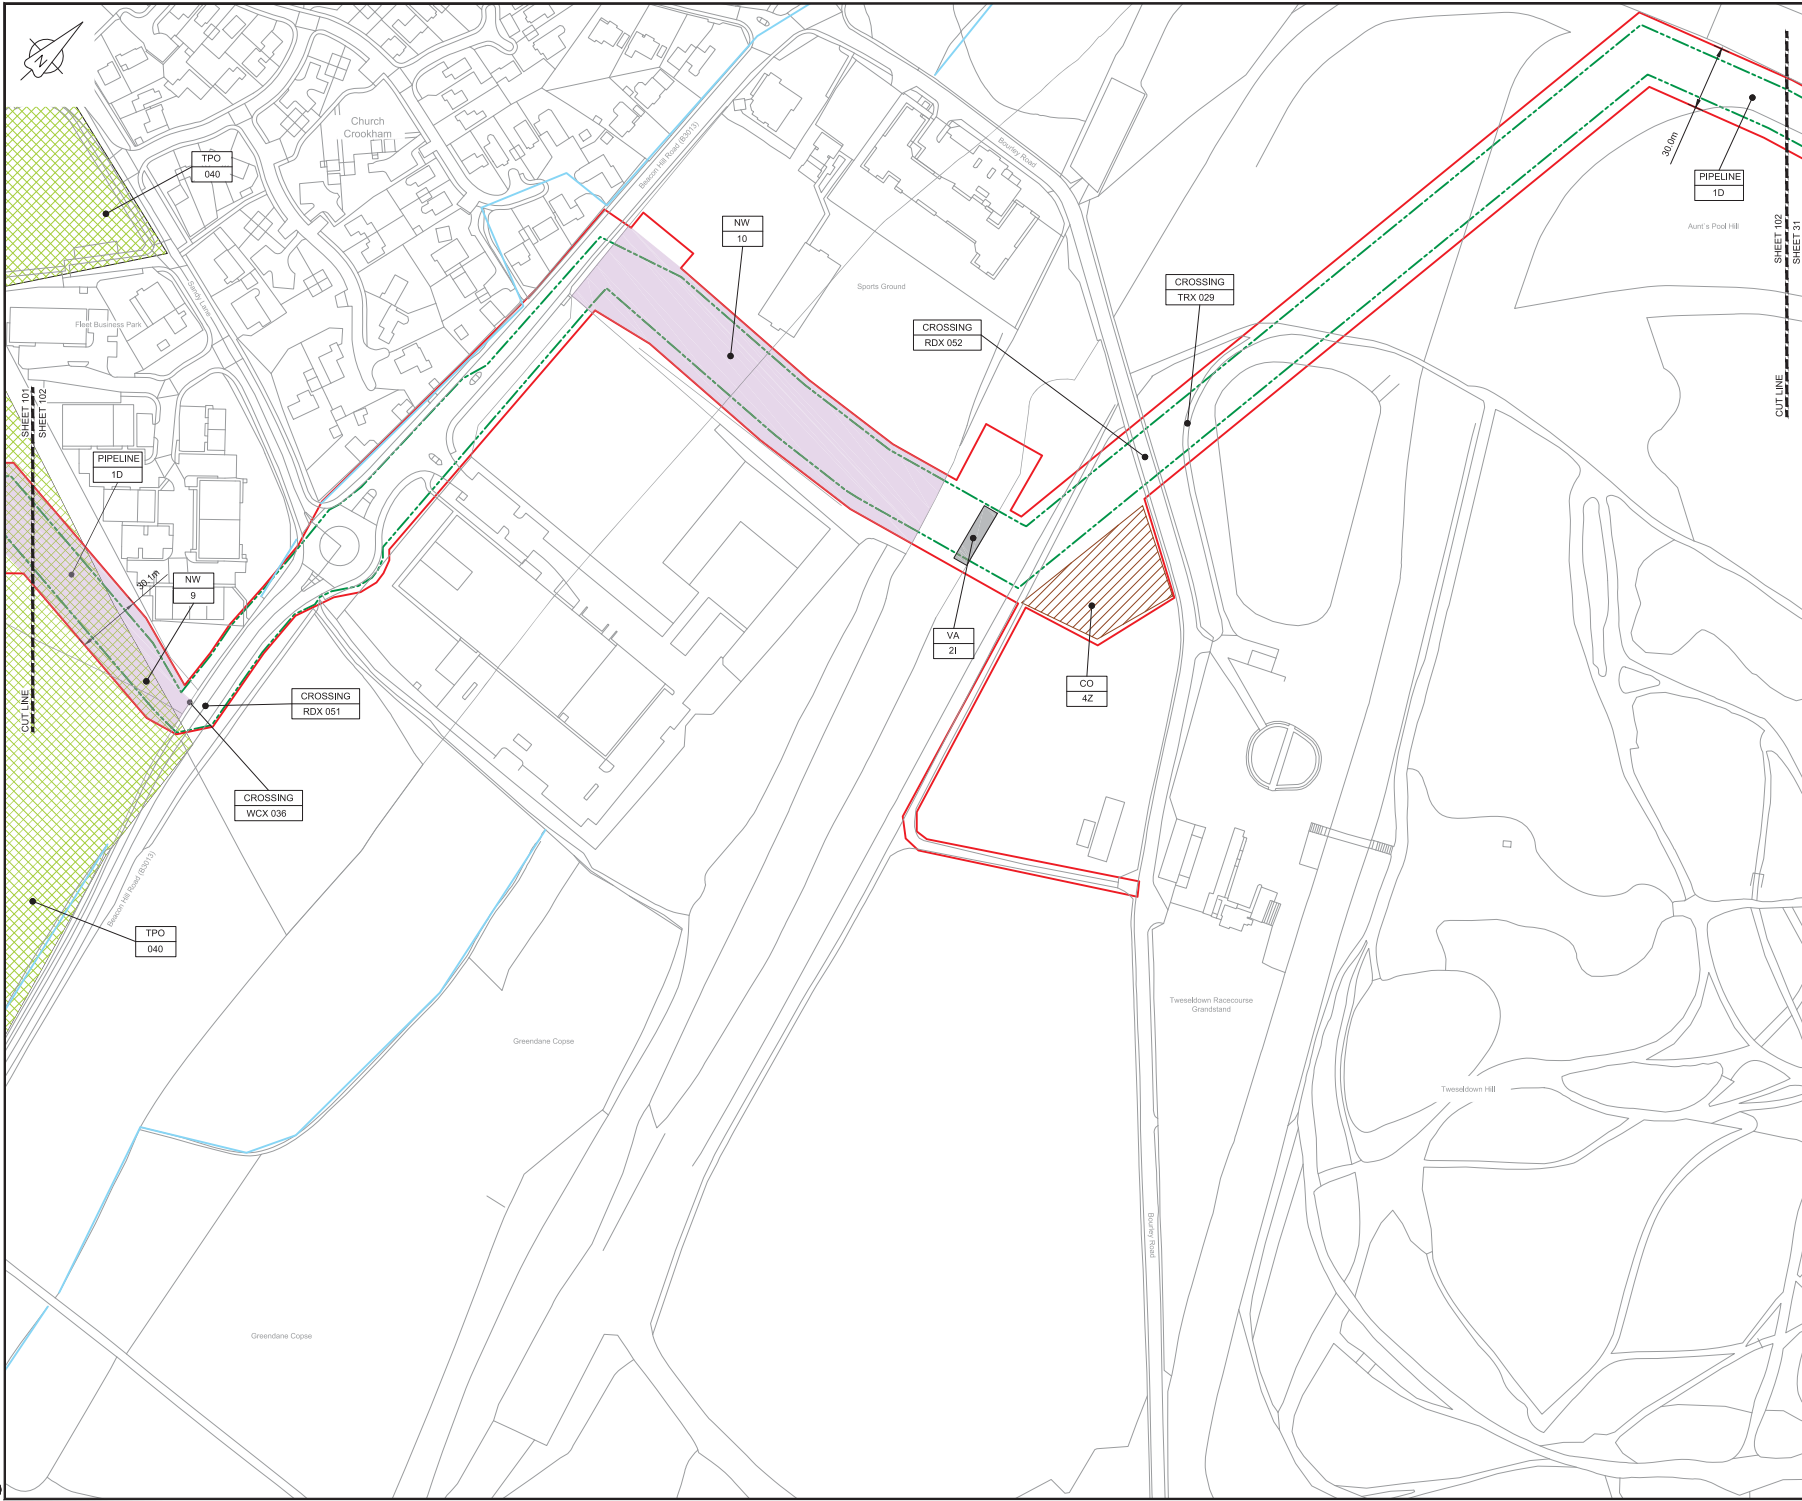

LOCATION PLAN  
SCALE 1:500,000

- NOTES**
1. THIS DRAWING IS IN METRES UNLESS STATED OTHERWISE.
  2. TRENCHLESS CROSSINGS ARE INDICATIVE ONLY.

**LEGEND**

	ORDER LIMITS
	LIMITS OF DEVIATION
	NARROW WORKING AREA (NW)
	TRENCHLESS CROSSING (TC)
	WATER BODIES
	ABOVE GROUND INSTALLATION (AGI) / VALVE (VA) / PRESSURE TRANSDUCER (PT)
	COMPOUND (CO)
	TREE PRESERVATION ORDER (TPO)
	DESCRIPTION
	ID or WORK NUMBER (if applicable)
	COMMENCEMENT / TERMINATION OF WORKS (COMMENCEMENT = OPEN, TERMINATION = CLOSED)

Contains Ordnance Survey data © Crown copyright and database rights 2019.  
© Crown copyright and database rights 2019 OS Licence Number AL100005237.



CSI	03/05/19	DDC SUBMISSION	PC	JA	SC	PH
Rev.	Rev. Date	Purpose of revision	Drawn	Checked	Rev'd	Approved

**JACOBS**  
1180 Epsom Road, Wokingham, Wokingham, RG41 5TU  
Tel: +44(0)118 946 7000 • Fax: +44(0)118 946 7001  
www.jacobs.com

Client: Esso Petroleum Company, Limited  
Ermyn House,  
Ermyn Way,  
Leatherhead,  
Surrey,  
KT22 8UX

Project: Southampton to London Pipeline Project

Drawing title:  
**GENERAL ARRANGEMENT  
SHEET 102  
REGULATION 5 (2)(O)**


Drawing status: **Fit for Stage Approval**

Scale	1:1250	DO NOT SCALE
Jacobs No.	B2325300	Rev
Client no.		<b>CO1</b>

Drawing number:  
**B2325300-JAC-000-CIV-DRG-000602**

C:\pwworking\jacobs\_uk\_water\_utilities\_s44\agis\jms3519325300-JAC000-CIV-DRG-000602.dwg - 03/05/2019 17:11:24 - A1 Frame - Agis



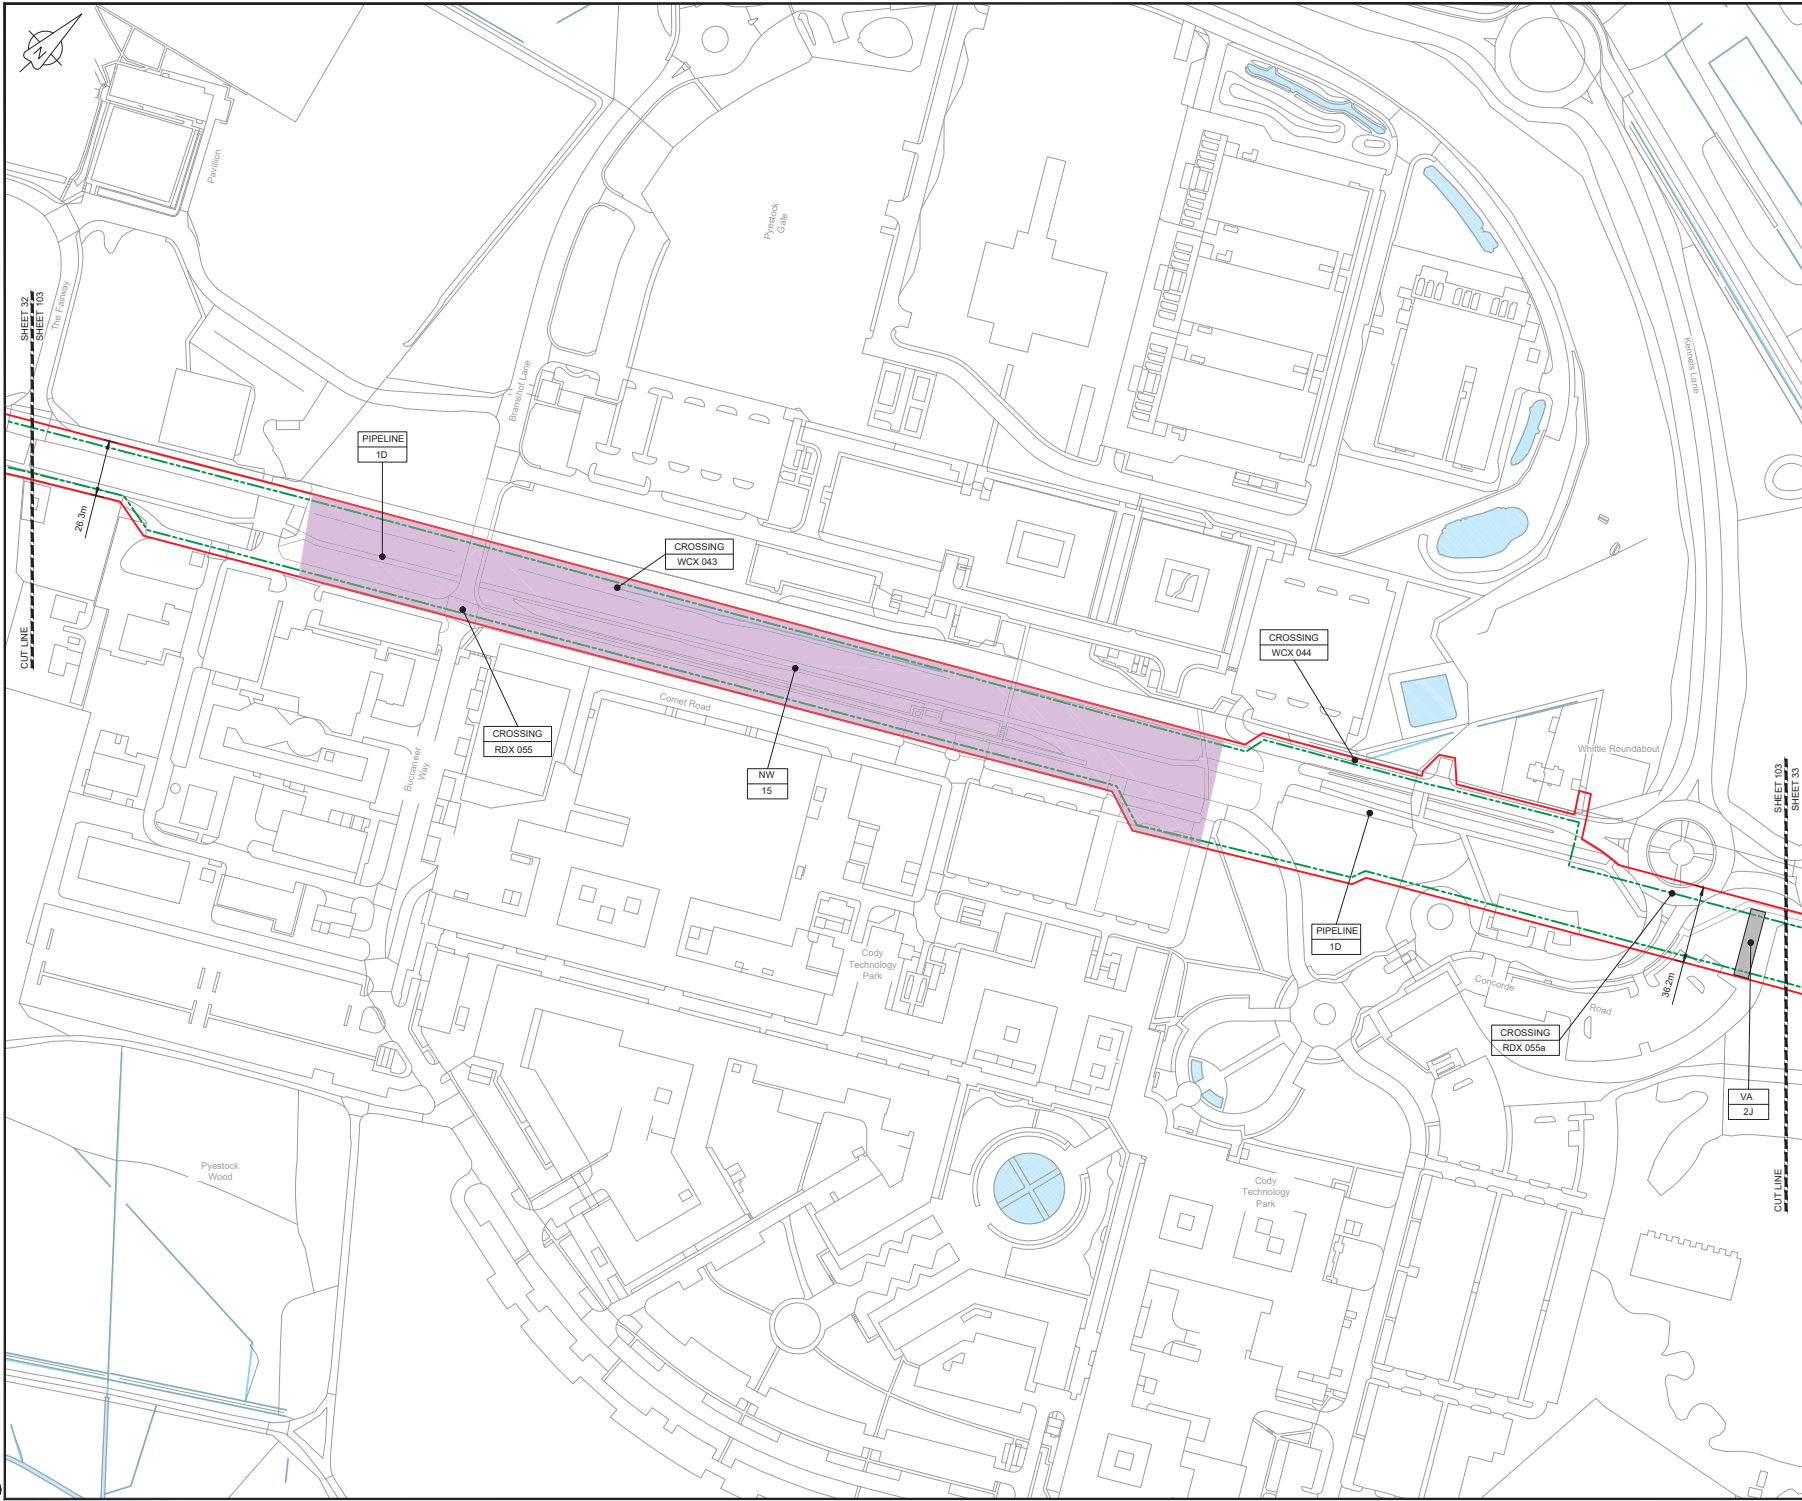

**LOCATION PLAN**  
SCALE 1:500,000

- NOTES**
1. THIS DRAWING IS IN METRES UNLESS STATED OTHERWISE.
  2. TRENCHLESS CROSSINGS ARE INDICATIVE ONLY.

**LEGEND**

	ORDER LIMITS
	LIMITS OF DEVIATION
	NARROW WORKING AREA (NW)
	TRENCHLESS CROSSING (TC)
	WATER BODIES
	ABOVE GROUND INSTALLATION (AGI) / VALVE (VA) / PRESSURE TRANSDUCER (PT)
	COMPOUND (CO)
	TREE PRESERVATION ORDER (TPO)
	DESCRIPTION
	ID or WORK NUMBER (if applicable)
	COMMENCEMENT / TERMINATION OF WORKS (COMMENCEMENT = OPEN, TERMINATION = CLOSED)

Contains Ordnance Survey data © Crown copyright and database rights 2019.

© Crown copyright and database rights 2019 OS Licence Number AL10005237.



CD1	03/05/19	DOC SUBMISSION	PC	JA	SC	PH
Rev.	Rev. Date	Purpose of revision	Drawn	Checked	Rev'd	Approved

**JACOBS**  
1180 Epsom Road, Wokingham, Wokingham, RG41 5TU  
Tel: +44(0)118 946 7000 • Fax: +44(0)118 946 7001  
www.jacobs.com

Client: Esso Petroleum Company, Limited  
Ermyn House,  
Ermyn Way,  
Leatherhead,  
Surrey,  
KT22 8UX




Project  
**GENERAL ARRANGEMENT SHEET 103 REGULATION 5 (2)(O)**

Drawing title

Drawing status: **Fit for Stage Approval**

Scale	1:1250	DO NOT SCALE
Jacobs No.	B2325300	Rev
Client no.	B2325300	Rev
Drawing number	B2325300-JAC-000-CIV-DRG-000603	Rev

Use or copying of this document in whole or in part without the written permission of Jacobs constitutes an infringement of copyright. Limitation: This drawing has been prepared on behalf of and for the exclusive use of Jacobs Client, and is subject to and issued in accordance with the provisions of the contract between Jacobs and the Client. Jacobs accepts no liability or responsibility whatsoever for its use in respect of any other project or reference. This drawing is not for third party use.

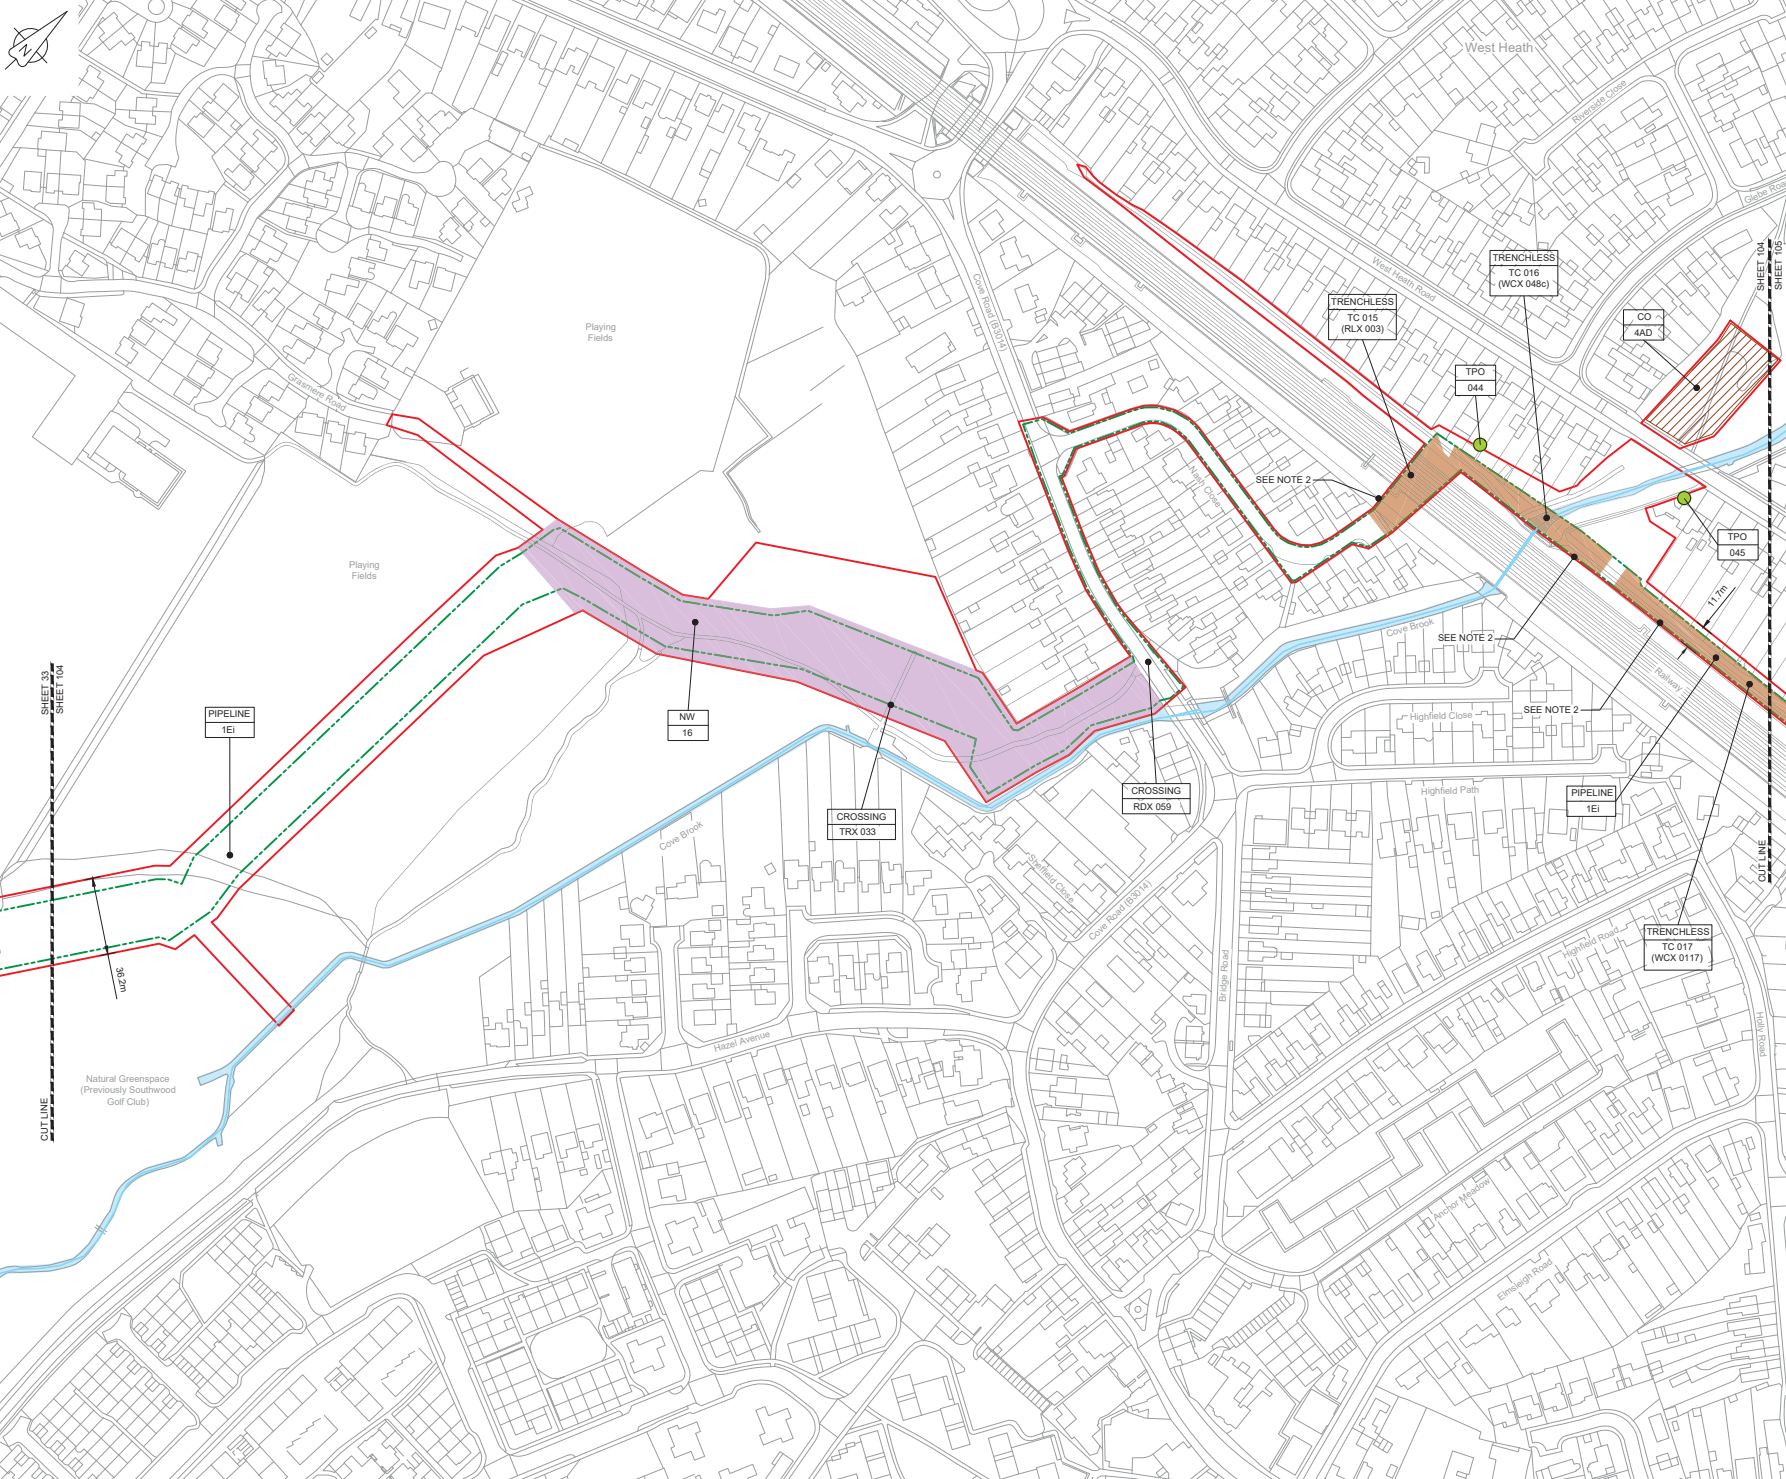

LOCATION PLAN  
SCALE 1:500,000

- NOTES
1. THIS DRAWING IS IN METRES UNLESS STATED OTHERWISE.
  2. TRENCHLESS CROSSINGS ARE INDICATIVE ONLY.

LEGEND

	ORDER LIMITS
	LIMITS OF DEVIATION
	NARROW WORKING AREA (NW)
	TRENCHLESS CROSSING (TC)
	WATER BODIES
	ABOVE GROUND INSTALLATION (AGI) / VALVE (VA) / PRESSURE TRANSDUCER (PT)
	COMPOUND (CO)
	TREE PRESERVATION ORDER (TPO)
	DESCRIPTION
	ID or WORK NUMBER (if applicable)
	COMMENCEMENT / TERMINATION OF WORKS (COMMENCEMENT = OPEN, TERMINATION = CLOSED)

Contains Ordnance Survey data © Crown copyright and database rights 2019.

© Crown copyright and database rights 2019 OS Licence Number AL100005237.



CD1	03/09/19	DDC SUBMISSION	PC	JA	SC	PH
Rev.	Rev. Date	Purpose of revision	Drawn	Checked	Rev'd	Approved

**JACOBS**  
1180 Emslack Road, Winchester, Hampshire, RG41 5TU  
Tel: +44(0)118 946 7000 • Fax: +44(0)118 946 7001  
www.jacobs.com

Client: Esso Petroleum Company, Limited  
Ermyn House,  
Ermyn Way,  
Leatherhead,  
Surrey,  
KT22 8UX

Project: Southampton to London Pipeline Project

Drawing title:  
**GENERAL ARRANGEMENT  
SHEET 104  
REGULATION 5 (2)(O)**

Drawing status: **Fit for Stage Approval**

Scale	1:1250	DO NOT SCALE
Jacobs No.	B2325300	Rev
Client no.		Rev
Drawing number	C01	

B2325300-JAC-000-CIV-DRG-000604





LOCATION PLAN  
SCALE 1:500,000

- NOTES**
- THIS DRAWING IS IN METRES UNLESS STATED OTHERWISE.
  - TRENCHLESS CROSSINGS ARE INDICATIVE ONLY.

- LEGEND**
- ORDER LIMITS
  - LIMITS OF DEVIATION
  - NARROW WORKING AREA (NW)
  - TRENCHLESS CROSSING (TC)
  - WATER BODIES
  - ABOVE GROUND INSTALLATION (AGI) / VALVE (VA) / PRESSURE TRANSDUCER (PT)
  - COMPOUND (CO)
  - TREE PRESERVATION ORDER (TPO)
  - DESCRIPTION
  - ID or WORK NUMBER (if applicable)
  - COMMENCEMENT / TERMINATION OF WORKS (COMMENCEMENT = OPEN, TERMINATION = CLOSED)

Contains Ordnance Survey data © Crown copyright and database rights 2019.

© Crown copyright and database rights 2019 OS Licence Number AL10005237.



CD	03/05/19	DOC SUBMISSION	PC	JA	SC	PH
Rev.	Rev. Date	Purpose of revision	Drawn	Checked	Rev'd	Approved

**JACOBS**  
1180 Ewings Road, Wokingham, Wokingham, RG41 5TU  
Tel +44(0)118 946 7000 • Fax +44(0)118 946 7001  
www.jacobs.com

Client: Esso Petroleum Company, Limited  
Ermyn House,  
Ermyn Way,  
Leatherhead,  
Surrey,  
KT22 8UX

Project: Southampton to London Pipeline Project

Drawing title:  
**GENERAL ARRANGEMENT SHEET 105**  
**REGULATION 5 (2)(O)**


Drawing status: **Fit for Stage Approval**

Scale	1:1250	DO NOT SCALE
Scale	1:1250	DO NOT SCALE
Jacobs No.	B2325300	Rev
Client no.	B2325300	Rev
Drawing number	C01	

B2325300-JAC-000-CIV-DRG-006005

Use or copying of this document in whole or in part without the written permission of Jacobs constitutes an infringement of copyright. Limitation: This drawing has been prepared on behalf of and for the exclusive use of Jacobs Client, and is not to be used in accordance with the provisions of the contract between Jacobs and the Client. Jacobs accepts no liability or responsibility whatsoever for its use in respect of any other project, for any other client, or for any other purpose.



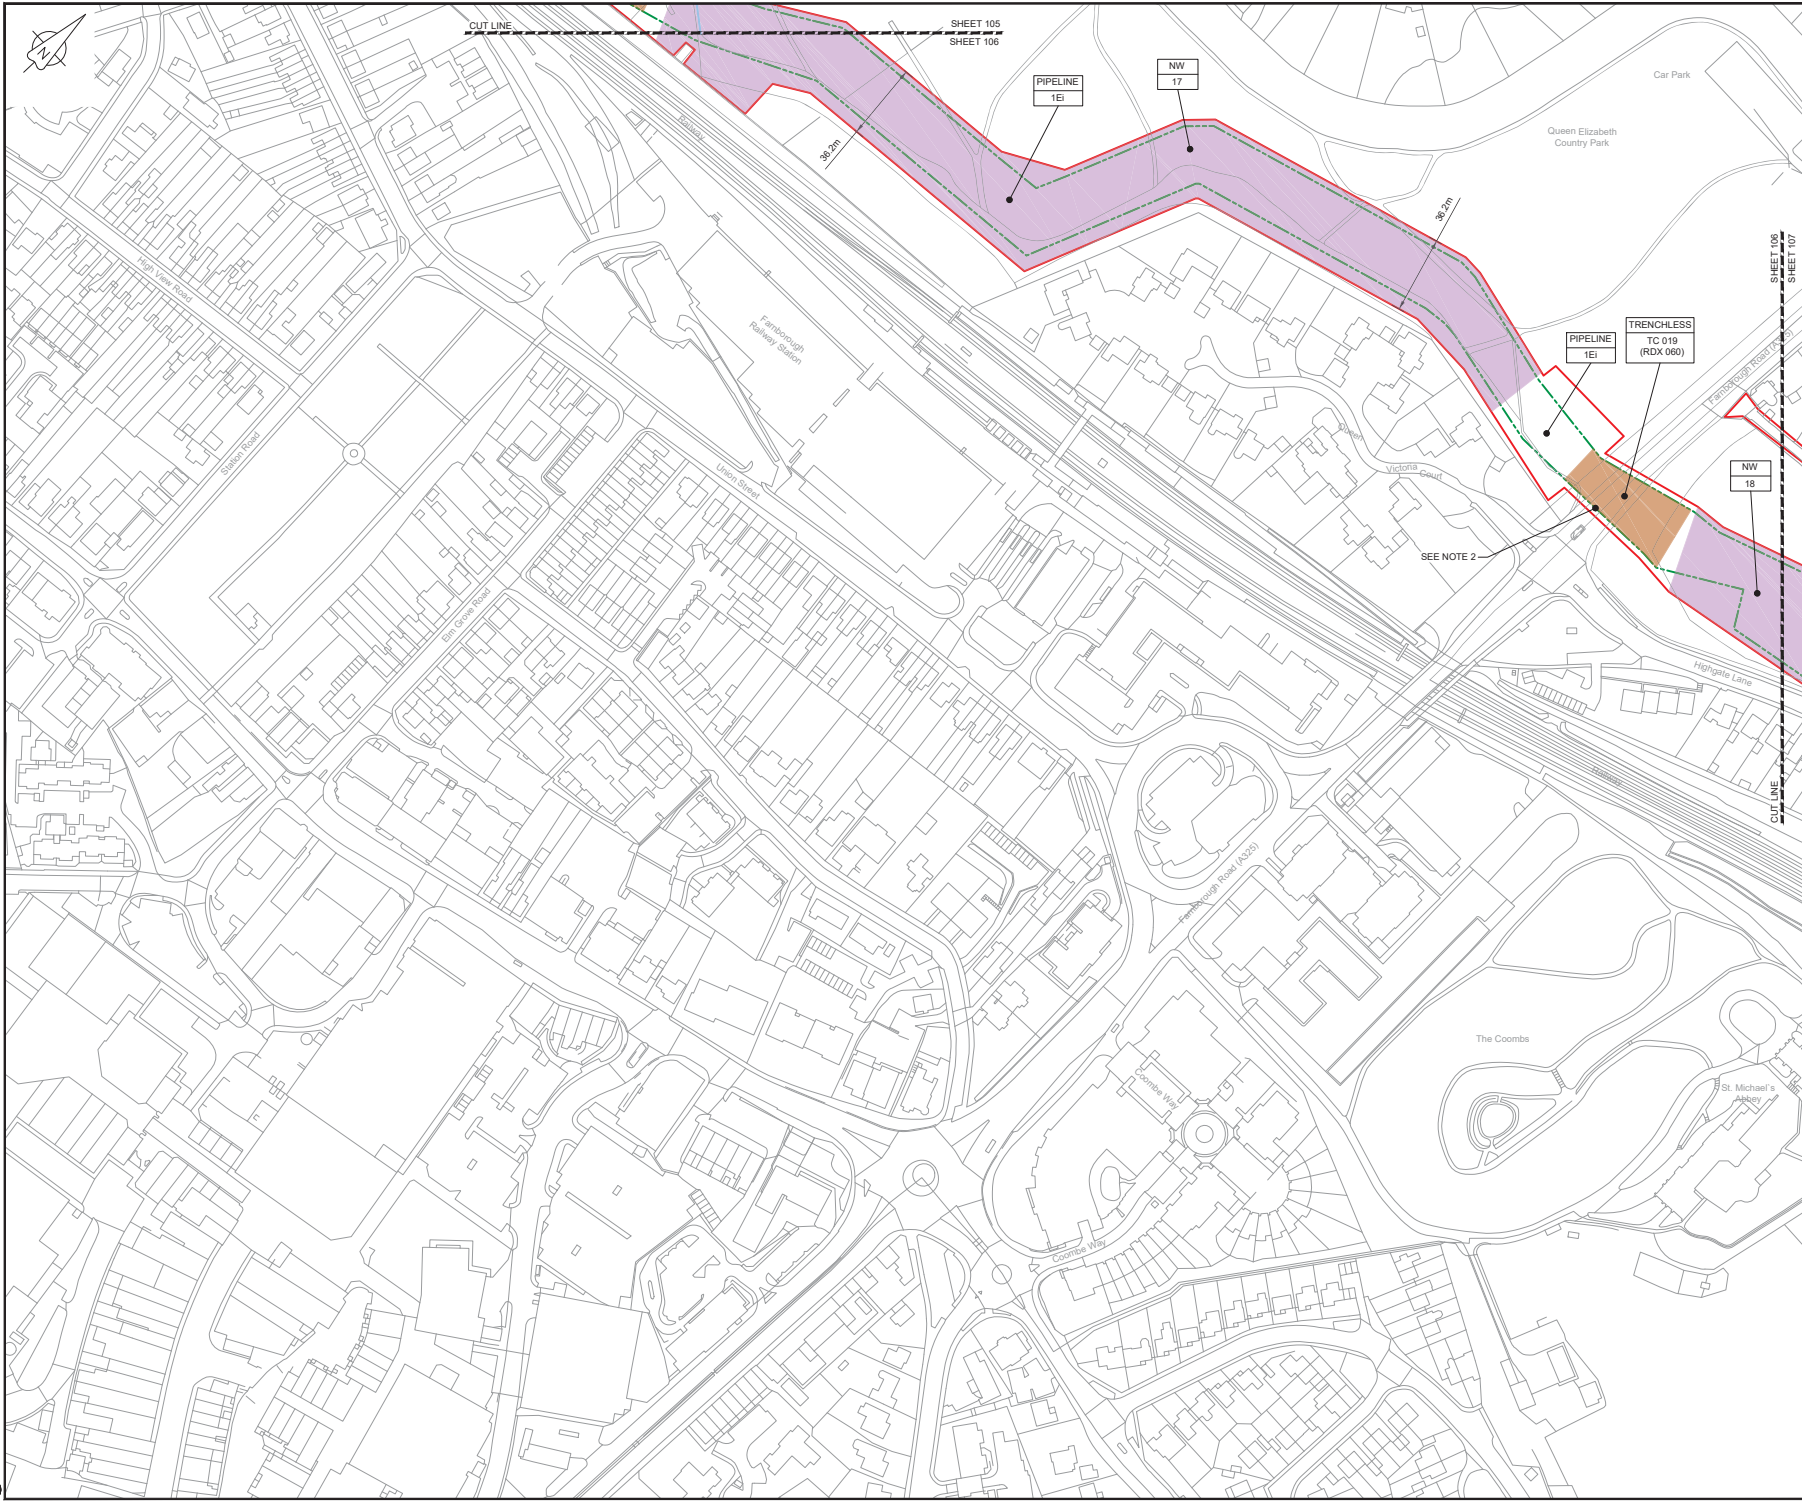

LOCATION PLAN  
SCALE 1:500,000

- NOTES**
- THIS DRAWING IS IN METRES UNLESS STATED OTHERWISE.
  - TRENCHLESS CROSSINGS ARE INDICATIVE ONLY.

**LEGEND**

	ORDER LIMITS
	LIMITS OF DEVIATION
	NARROW WORKING AREA (NW)
	TRENCHLESS CROSSING (TC)
	WATER BODIES
	ABOVE GROUND INSTALLATION (AGI) / VALVE (VA) / PRESSURE TRANSDUCER (PT)
	COMPOUND (CO)
	TREE PRESERVATION ORDER (TPO)
	DESCRIPTION
	ID or WORK NUMBER (if applicable)
	COMMENCEMENT / TERMINATION OF WORKS (COMMENCEMENT = OPEN, TERMINATION = CLOSED)

Contains Ordnance Survey data © Crown copyright and database rights 2019.

© Crown copyright and database rights 2019 OS Licence Number AL10005237.



CDI	03/05/19	DDC SUBMISSION	PC	JA	SC	PH
Rev.	Rev. Date	Purpose of revision	Drawn	Checked	Rev'd	Approved

**JACOBS**  
1180 Ewings Road, Winchester, Hampshire, RG41 5TU  
Tel: +44(0)118 946 7000 • Fax: +44(0)118 946 7001  
www.jacobs.com

Client: Esso Petroleum Company, Limited  
Emlyn House,  
Emlyn Way,  
Leatherhead,  
Surrey,  
KT22 8UX




Drawing title  
**GENERAL ARRANGEMENT  
SHEET 106  
REGULATION 5 (2)(O)**

Drawing status: **Fit for Stage Approval**

Scale	1:1250	DO NOT SCALE
Jacobs No.	B2325300	Rev
Client no.		CO1
Drawing number	B2325300-JAC-000-CIV-DRG-000606	



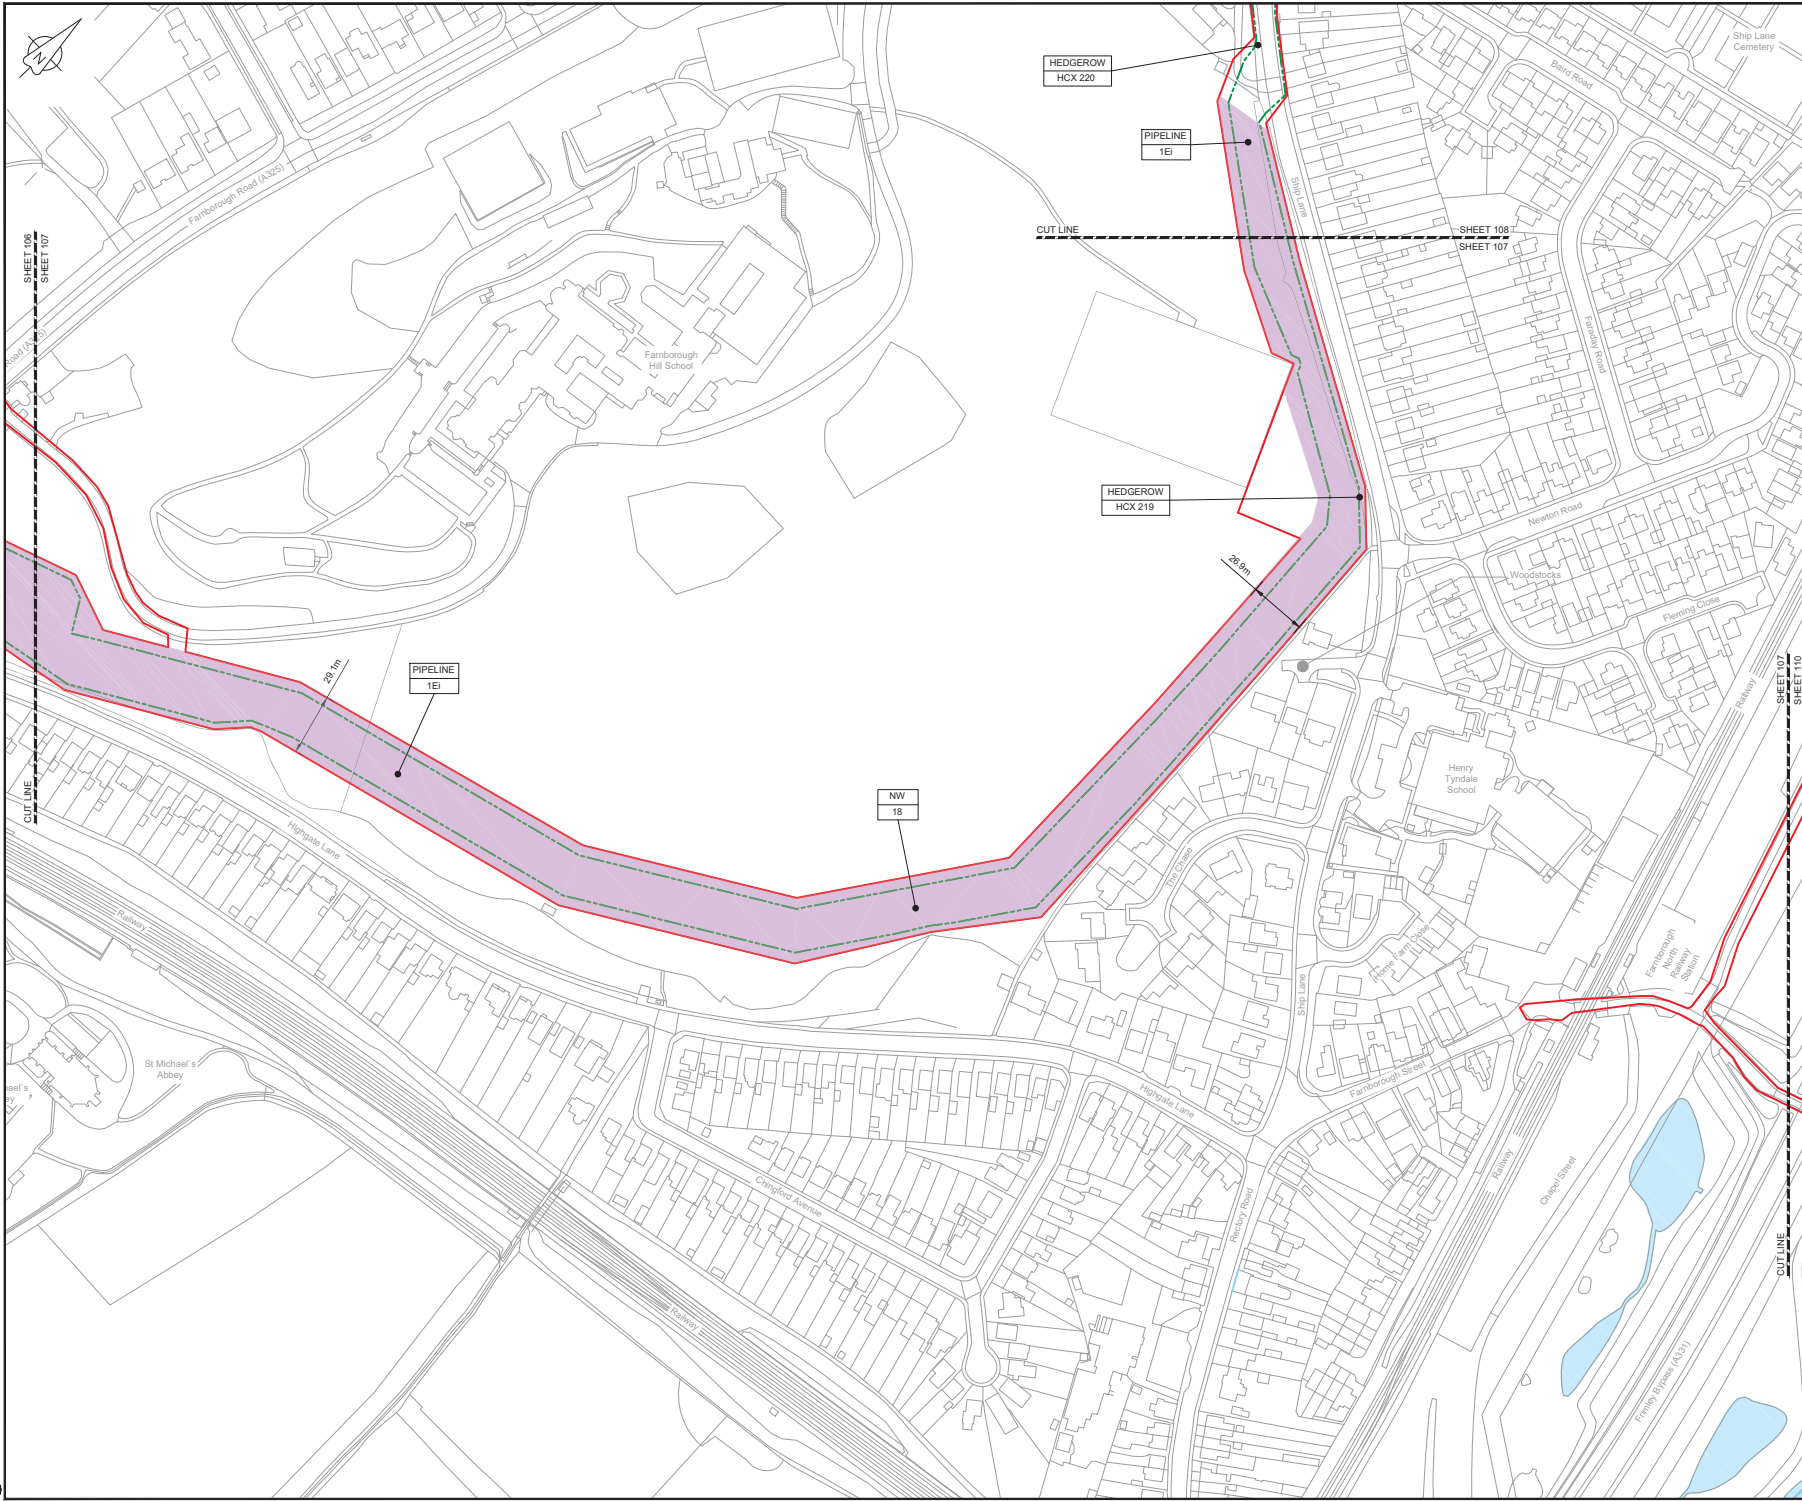


**LOCATION PLAN**  
SCALE 1:500,000

- NOTES**
1. THIS DRAWING IS IN METRES UNLESS STATED OTHERWISE.
  2. TRENCHLESS CROSSINGS ARE INDICATIVE ONLY.

- LEGEND**
- ORDER LIMITS
  - LIMITS OF DEVIATION
  - NARROW WORKING AREA (NW)
  - TRENCHLESS CROSSING (TC)
  - WATER BODIES
  - ABOVE GROUND INSTALLATION (AGI) / VALVE (VA) / PRESSURE TRANSDUCER (PT)
  - COMPOUND (CO)
  - TREE PRESERVATION ORDER (TPO)
  - DESCRIPTION
  - ID or WORK NUMBER (if applicable)
  - COMMENCEMENT / TERMINATION OF WORKS  
(COMMENCEMENT = OPEN, TERMINATION = CLOSED)

Contains Ordnance Survey data © Crown copyright and database rights 2019.

 © Crown copyright and database rights 2019 OS Licence Number AL10006237.



CD	03/05/19	DDC/SUBMISSION	PC	JA	SC	RH
Rev.	Rev. Date	Purpose of revision	Drawn	Checked	Rev'd	Approved

**JACOBS**  
1180 Emsdale Road, Winchester, Hampshire, RG41 5TU  
Tel: +44(0)118 946 7000 • Fax: +44(0)118 946 7001  
www.jacobs.com

Client: Esso Petroleum Company, Limited  
Ermyn House,  
Ermyn Way,  
Leatherhead,  
Surrey,  
KT22 8UX



Drawing title  
**GENERAL ARRANGEMENT  
SHEET 107  
REGULATION 5 (2)(O)**


Drawing status: **Fit for Stage Approval**

Scale	1:1250	DO NOT SCALE
Jacobs No.	B2325300	Rev
Client no.		Rev
Drawing number		<b>CO1</b>

**B2325300-JAC-000-CIV-DRG-000607**

Use or copying of this document in whole or in part without the written permission of Jacobs constitutes an infringement of copyright. Limitation: This drawing has been prepared on behalf of and for the exclusive use of Jacobs Client, and is subject to and issued in accordance with the provisions of the contract between Jacobs and the Client. Jacobs accepts no liability or responsibility whatsoever for its use in excess of its intended application. This drawing is not valid without the signature of the responsible Jacobs engineer.



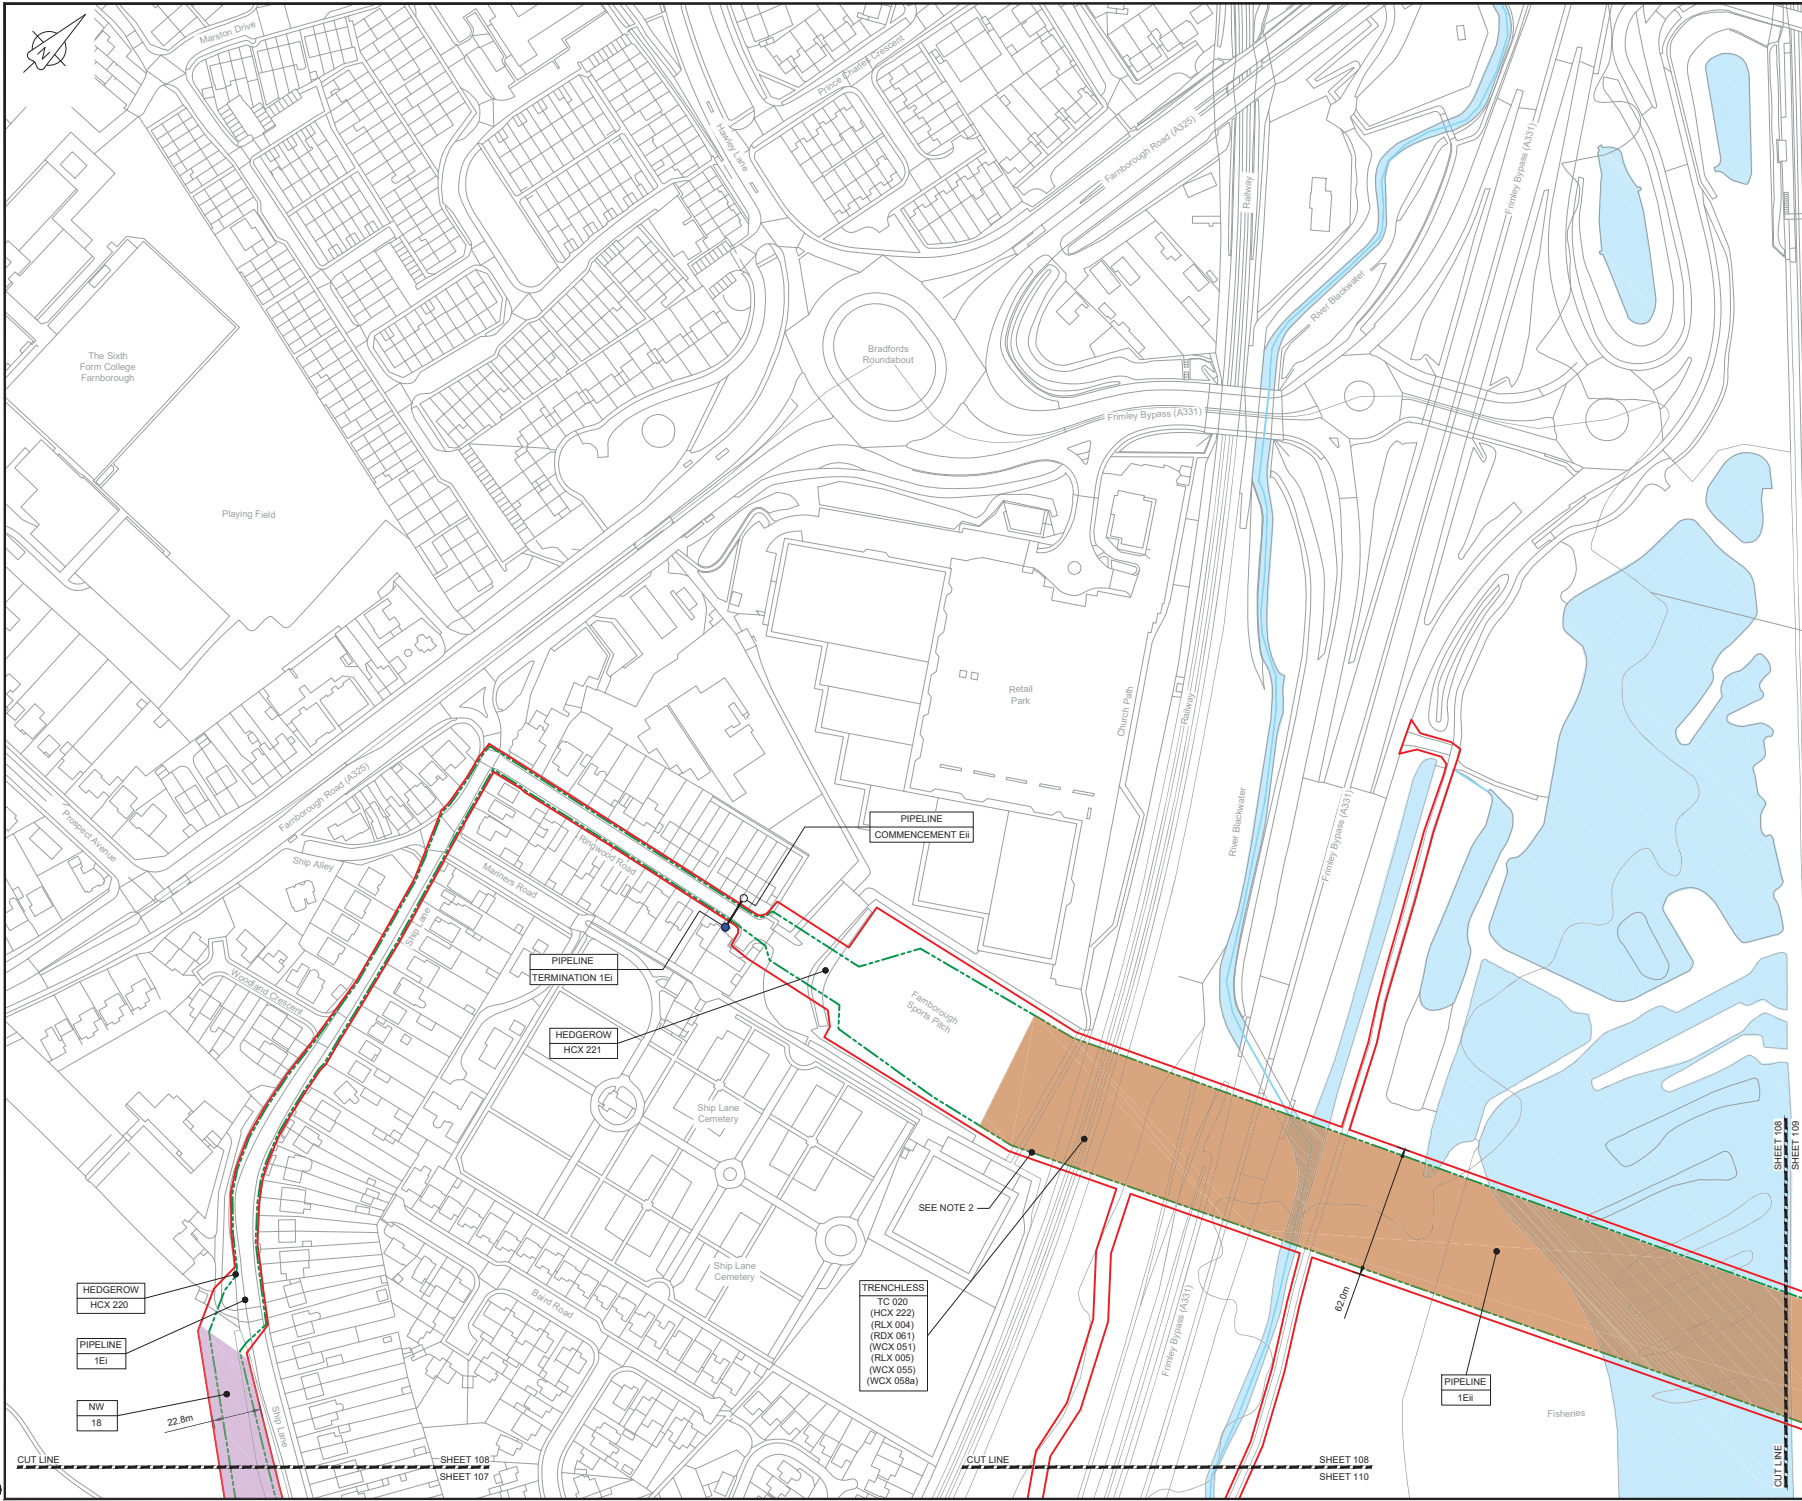

**LOCATION PLAN**  
SCALE 1:500,000

- NOTES**
- THIS DRAWING IS IN METRES UNLESS STATED OTHERWISE.
  - TRENCHLESS CROSSINGS ARE INDICATIVE ONLY.

- LEGEND**
- ORDER LIMITS
  - LIMITS OF DEVIATION
  - NARROW WORKING AREA (NW)
  - TRENCHLESS CROSSING (TC)
  - WATER BODIES
  - ABOVE GROUND INSTALLATION (AGI) / VALVE (VA) / PRESSURE TRANSDUCER (PT)
  - COMPOUND (CO)
  - TREE PRESERVATION ORDER (TPO)
  - DESCRIPTION
  - ID or WORK NUMBER (if applicable)
  - COMMENCEMENT / TERMINATION OF WORKS (COMMENCEMENT = OPEN, TERMINATION = CLOSED)

Contains Ordnance Survey data © Crown copyright and database rights 2019.

© Crown copyright and database rights 2019 OS Licence Number AL10006237.



CD	03/05/19	DDC SUBMISSION	PC	JA	SC	PH
Rev.	Rev. Date	Purpose of revision	Drawn	Checked	Rev'd	Approved

**JACOBS**  
1180 Epsom Road, Wokingham, Wokingham, RG41 5TU  
Tel: +44(0)118 946 7000 • Fax: +44(0)118 946 7001  
www.jacobs.com

Client: Esso Petroleum Company, Limited  
Ermyn House,  
Ermyn Way,  
Leatherhead,  
Surrey,  
KT22 8UX

Project: Southampton to London Pipeline Project

Drawing title:  
**GENERAL ARRANGEMENT  
SHEET 108  
REGULATION 5 (2)(O)**

Drawing status: **Fit for Stage Approval**


Scale	1:1250	DO NOT SCALE
Jacobs No.	B2325300	Rev
Client no.		Rev
Drawing number		<b>CO1</b>

B2325300-JAC-000-CIV-DRG-006/008

Use or copying of this document in whole or in part without the written permission of Jacobs constitutes an infringement of copyright. Limitation: This drawing has been prepared on behalf of and for the exclusive use of Jacobs Client, and is not to be used in accordance with the provisions of the contract between Jacobs and the Client. Jacobs accepts no liability or responsibility whatsoever for its use in respect of any site or in reliance upon. This drawing is not valid.

C:\working\jacobs\_uk\_water\utilities\_s44\civ\drg\h2ma3351188\2325300-JAC-000-CIV-DRG-006/008.dwg - 03/05/2019 12:01:13 - A1Frame - CreateP



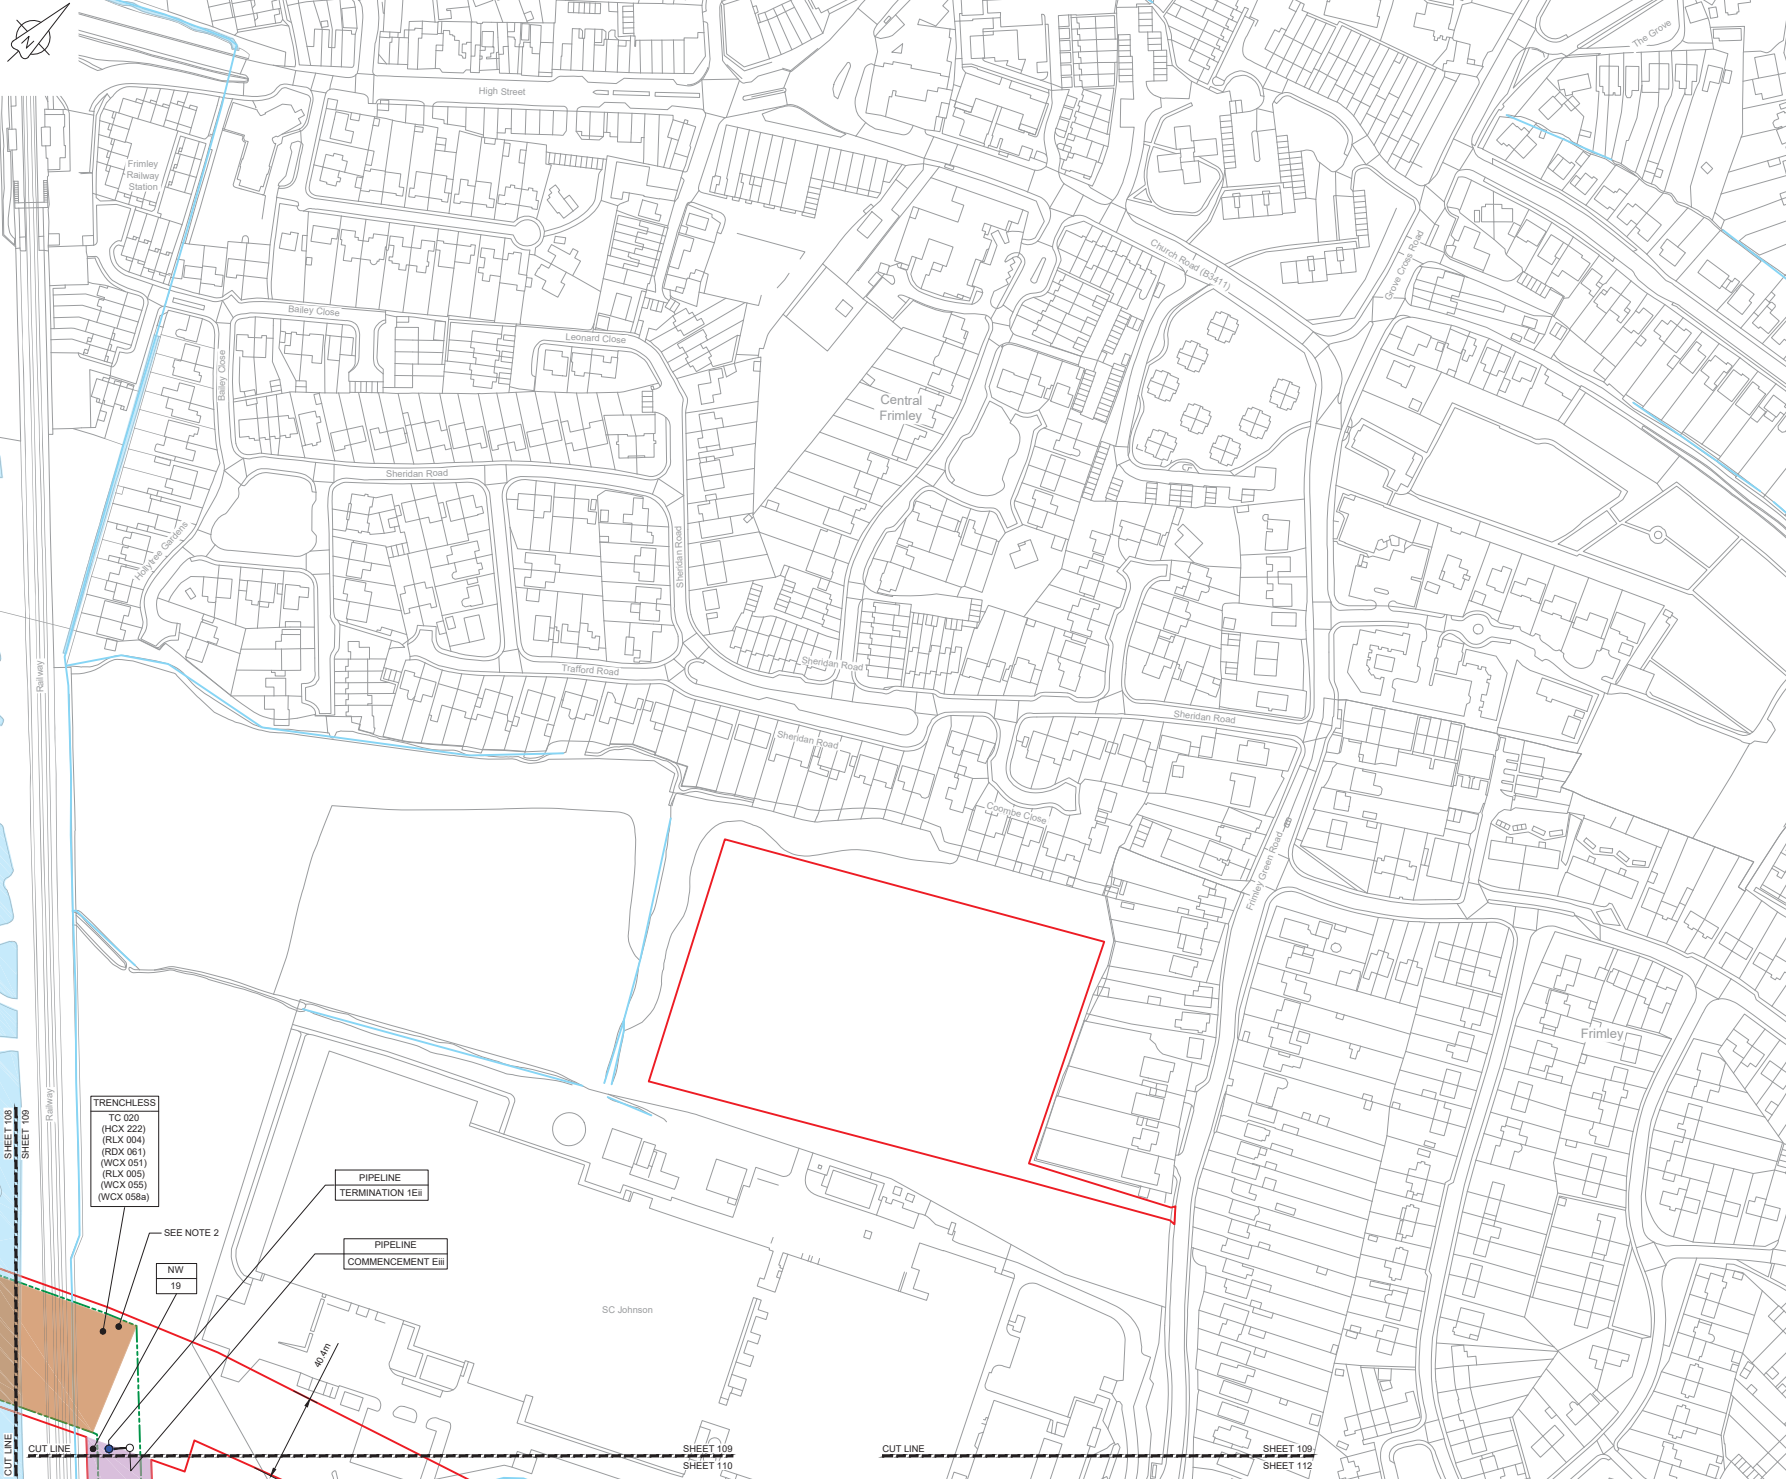

LOCATION PLAN  
SCALE 1:500,000

- NOTES**
1. THIS DRAWING IS IN METRES UNLESS STATED OTHERWISE.
  2. TRENCHLESS CROSSINGS ARE INDICATIVE ONLY.

- LEGEND**
- ORDER LIMITS
  - LIMITS OF DEVIATION
  - NARROW WORKING AREA (NW)
  - TRENCHLESS CROSSING (TC)
  - WATER BODIES
  - ABOVE GROUND INSTALLATION (AGI) / VALVE (VA) / PRESSURE TRANSDUCER (PT)
  - COMPOUND (CO)
  - TREE PRESERVATION ORDER (TPO)
  - DESCRIPTION
  - ID or WORK NUMBER (if applicable)
  - COMMENCEMENT / TERMINATION OF WORKS (COMMENCEMENT = OPEN, TERMINATION = CLOSED)

Contains Ordnance Survey data © Crown copyright and database rights 2019.

© Crown copyright and database rights 2019 OS Licence Number AL100005237.



CD1	03/2019	DDC SUBMISSION	PC	JA	SC	PH
Rev.	Rev. Date	Purpose of revision	Drawn	Checked	Rev'd	Approved

**JACOBS**  
1180 Ewlish Road, Wokingham, Wokingham, RG41 5TU  
Tel: +44(0)118 946 7000 • Fax: +44(0)118 946 7001  
www.jacobs.com

Client: Esso Petroleum Company, Limited  
Ermyn House,  
Ermyn Way,  
Leatherhead,  
Surrey,  
KT22 8UX



Project:  
**GENERAL ARRANGEMENT  
SHEET 109  
REGULATION 5 (2)(O)**

Drawing status: **Fit for Stage Approval**

Scale	1:1250	DO NOT SCALE
Jacobs No.	B2325300	Rev
Client no.		CO1

Drawing number: **B2325300-JAC-000-CIV-DRG-000609**

© Copyright 2019 Jacobs U.K. Limited. This drawing and all other contents of this document are the property of Jacobs. Use or copying of this document in whole or in part without the written permission of Jacobs constitutes an infringement of copyright. Limitation: This drawing has been prepared on behalf of and for the exclusive use of Jacobs Client, and is subject to and issued in accordance with the provisions of the contract between Jacobs and the Client. Jacobs accepts no liability or responsibility whatsoever for its use in respect of any site or in reliance upon. This drawing is not valid without.

C:\pwworking\jacobs\_uk\_water\_utilities\_sas4\cbe\h\p\ma3351188\2325300-JAC-000-CIV-DRG-000609.dwg - 03/05/2019 12:03:01 - A1Frame - CleanP1

- TRENCHLESS**
- TC 020 (HCX 222)
  - (RLX 004)
  - (RDJ 001)
  - (WCX 051)
  - (RLX 005)
  - (WCX 055)
  - (WCX 058A)

SEE NOTE 2

NW  
19


PIPELINE  
TERMINATION 1EII

PIPELINE  
COMMENCEMENT 5EII

80 km

SHEET 109  
SHEET 110

SHEET 109  
SHEET 112

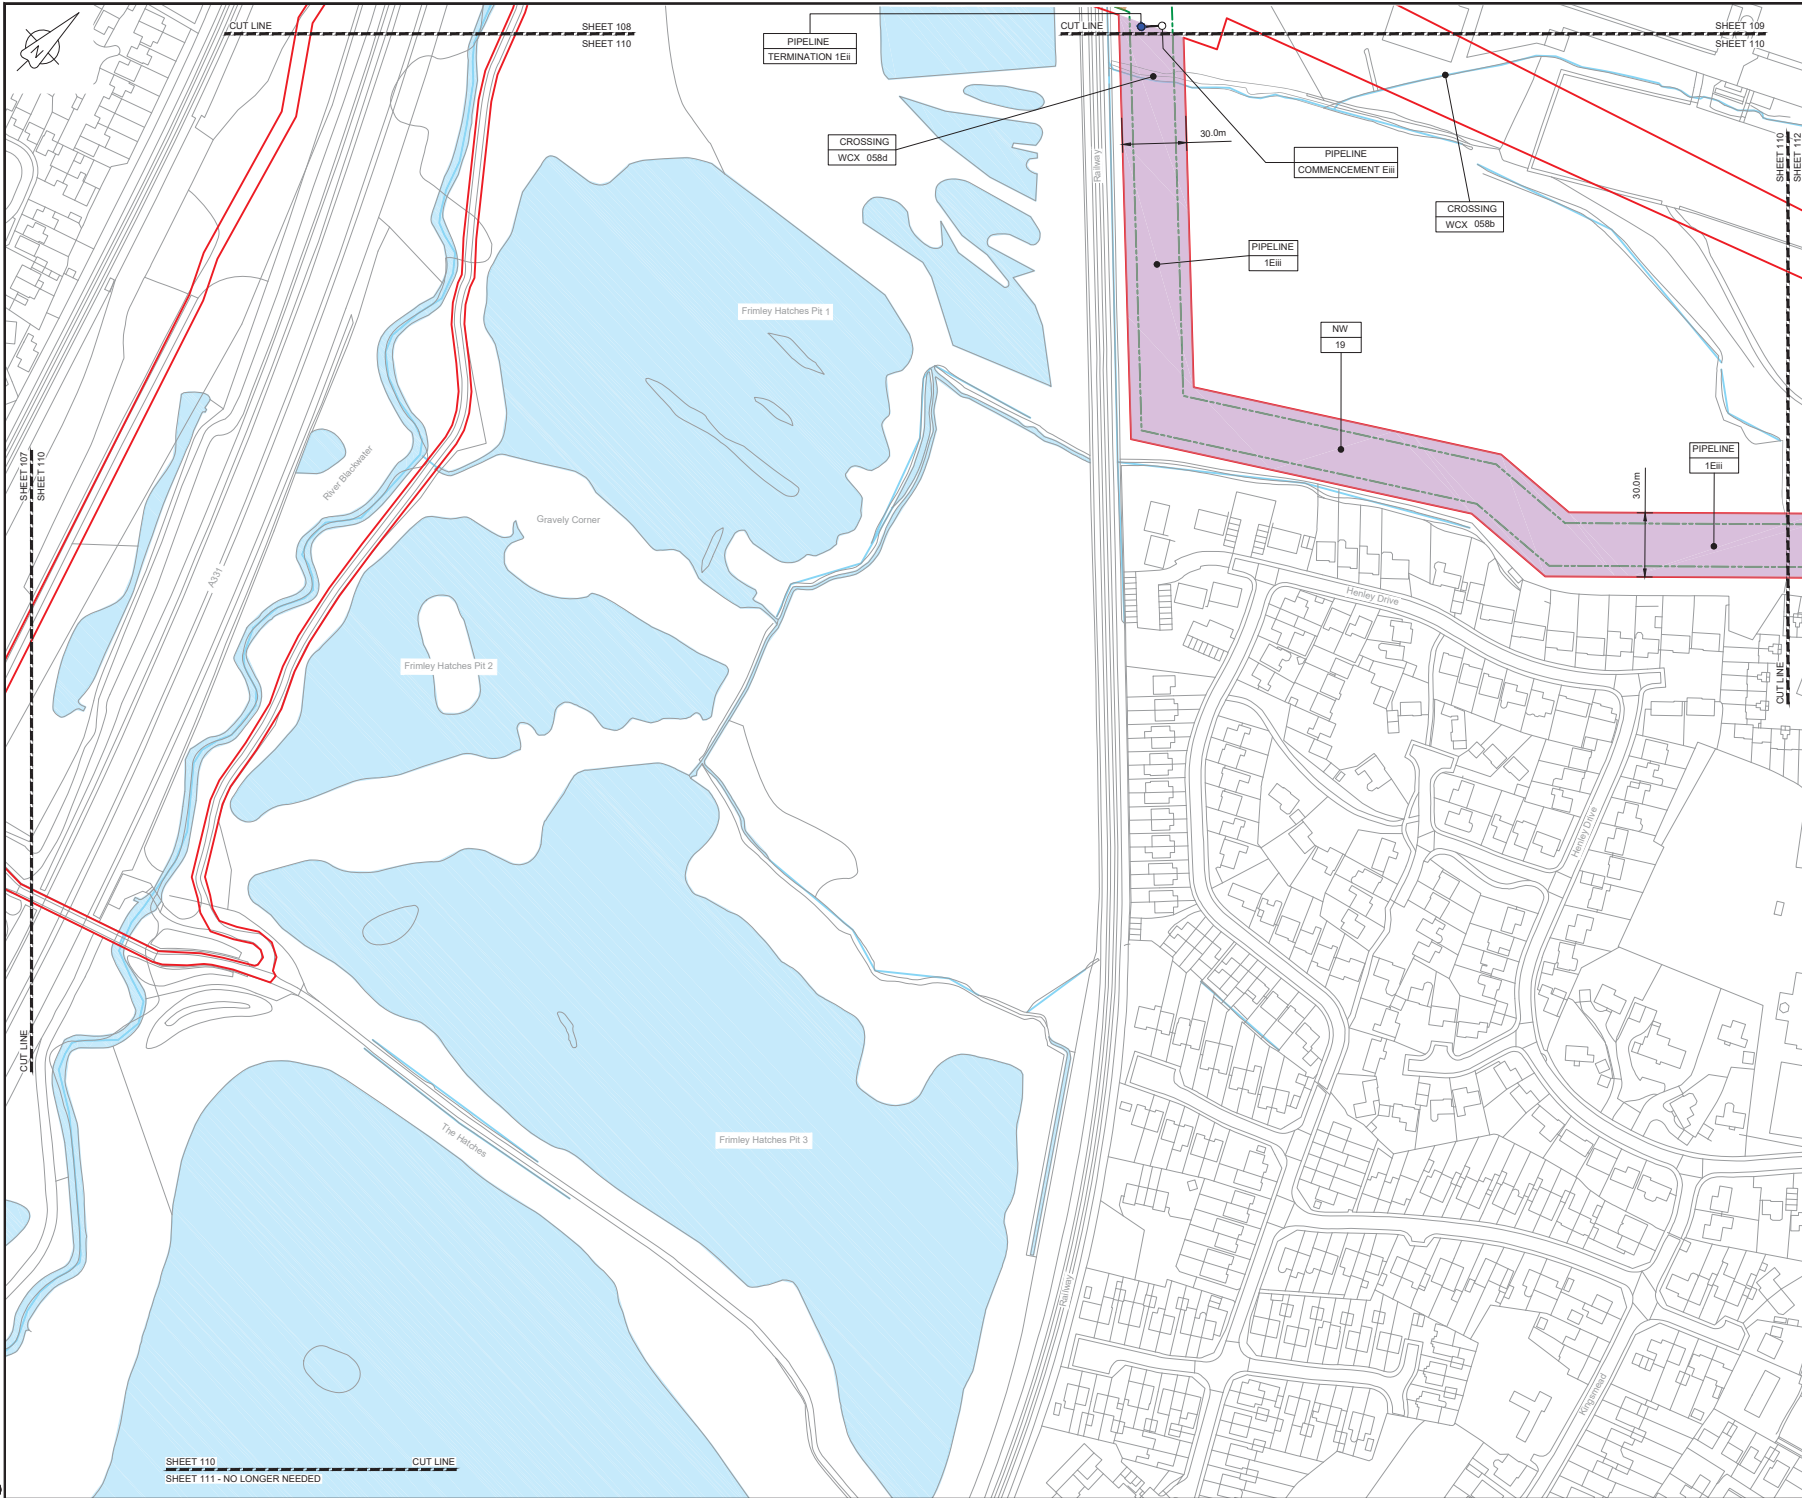

LOCATION PLAN  
SCALE 1:500,000

NOTES  
 1. THIS DRAWING IS IN METRES UNLESS STATED OTHERWISE.  
 2. TRENCHLESS CROSSINGS ARE INDICATIVE ONLY.

**LEGEND**

	ORDER LIMITS
	LIMITS OF DEVIATION
	NARROW WORKING AREA (NW)
	TRENCHLESS CROSSING (TC)
	WATER BODIES
	ABOVE GROUND INSTALLATION (AGI) / VALVE (VA) / PRESSURE TRANSDUCER (PT)
	COMPOUND (CO)
	TREE PRESERVATION ORDER (TPO)
	DESCRIPTION
	ID or WORK NUMBER (if applicable)
	COMMENCEMENT / TERMINATION OF WORKS (COMMENCEMENT = OPEN, TERMINATION = CLOSED)

Contains Ordnance Survey data © Crown copyright and database rights 2019.

© Crown copyright and database rights 2019 OS Licence Number AL10005237.



CD	03/05/19	0000 SUBMISSION	PC	JA	SC	PH
Rev.	Rev. Date	Purpose of revision	Drawn	Checked	Rev'd	Approved

**JACOBS**  
 1180 Epsom Road, Winchester, Hampshire, RG41 5TU  
 Tel +44(0)118 946 7000 • Fax +44(0)118 946 7001  
 www.jacobs.com

Client: Esso Petroleum Company, Limited  
 Ermyn House,  
 Ermyn Way,  
 Leatherhead,  
 Surrey,  
 KT22 8UX

Project: Southampton to London Pipeline Project

Drawing title: **GENERAL ARRANGEMENT SHEET 110 REGULATION 5 (2)(O)**

Drawing status: **Fit for Stage Approval**

Scale	1:1250	DO NOT SCALE
Jacobs No.	B2325300	Rev
Client no.		<b>CO1</b>

Drawing number: **B2325300-JAC-000-CIV-DRG-000610**

© Copyright 2019 Jacobs U.K. Limited. This document and all contents hereof are the property of Jacobs. Use or copying of this document in whole or in part without the written permission of Jacobs constitutes an infringement of copyright. Limitation: This drawing has been prepared on behalf of and for the exclusive use of Jacobs Client, and is subject to and issued in accordance with the provisions of the contract between Jacobs and the Client. Jacobs accepts no liability or responsibility whatsoever for use in excess of any stated or implied scope. This drawing is not valid without the signature of the responsible engineer.

C:\pwworking\jacobs\_uk\_water\_utilities\_sas4\cbe\h\p\ma335113872025300-JAC-000-CIV-DRG-000610.dwg - 03/05/2019 12:04:59 - A1Frame - CleanHP

SHEET 110  
 SHEET 111 - NO LONGER NEEDED



SHEET 111 - NO LONGER NEEDED



LOCATION PLAN  
SCALE 1:500,000

- NOTES**
1. THIS DRAWING IS IN METRES UNLESS STATED OTHERWISE.
  2. TRENCHLESS CROSSINGS ARE INDICATIVE ONLY.

**LEGEND**

- ORDER LIMITS
- LIMITS OF DEVIATION
- NARROW WORKING AREA (NW)
- TRENCHLESS CROSSING (TC)
- WATER BODIES
- ABOVE GROUND INSTALLATION (AGI) / VALVE (VA) / PRESSURE TRANSDUCER (PT)
- COMPOUND (CO)
- TREE PRESERVATION ORDER (TPO)
- DESCRIPTION
- ID or WORK NUMBER (if applicable)
- COMMENCEMENT / TERMINATION OF WORKS (COMMENCEMENT = OPEN, TERMINATION = CLOSED)

Contains Ordnance Survey data © Crown copyright and database rights 2019.

© Crown copyright and database rights 2019 OS Licence Number AL10005237.



CD1	03/05/19	DDC SUBMISSION	PC	JA	SC	RH
Rev.	Rev. Date	Purpose of revision	Drawn	Checked	Rev'd	Approved

**JACOBS**  
1180 Epsom Road, Wokingham, Wokingham, RG41 5TU  
Tel: +44(0)118 946 7000 • Fax: +44(0)118 946 7001  
www.jacobs.com

Client: Esso Petroleum Company, Limited  
Emlyn House,  
Emlyn Way,  
Leatherhead,  
Surrey,  
KT22 8UX

Project: Southampton to London Pipeline Project

Drawing title:  
**GENERAL ARRANGEMENT  
SHEET 111  
REGULATION 5 (2)(O)**


Drawing status: **Fit for Stage Approval**

Scale	1:1250	DO NOT SCALE
Jacobs No.	B2325300	Rev
Client no.		<b>C01</b>

Drawing number:  
**B2325300-JAC-000-CIV-DRG-000611**

© Copyright 2019 Jacobs U.K. Limited. This document and its contents are the confidential and proprietary information of Jacobs U.K. Limited. This drawing has been prepared on behalf of and for the exclusive use of Jacobs Client, and is not to be used in accordance with the provisions of the contract between Jacobs and the Client. Jacobs accepts no liability or responsibility whatsoever for any loss or damage arising from the use of this drawing.



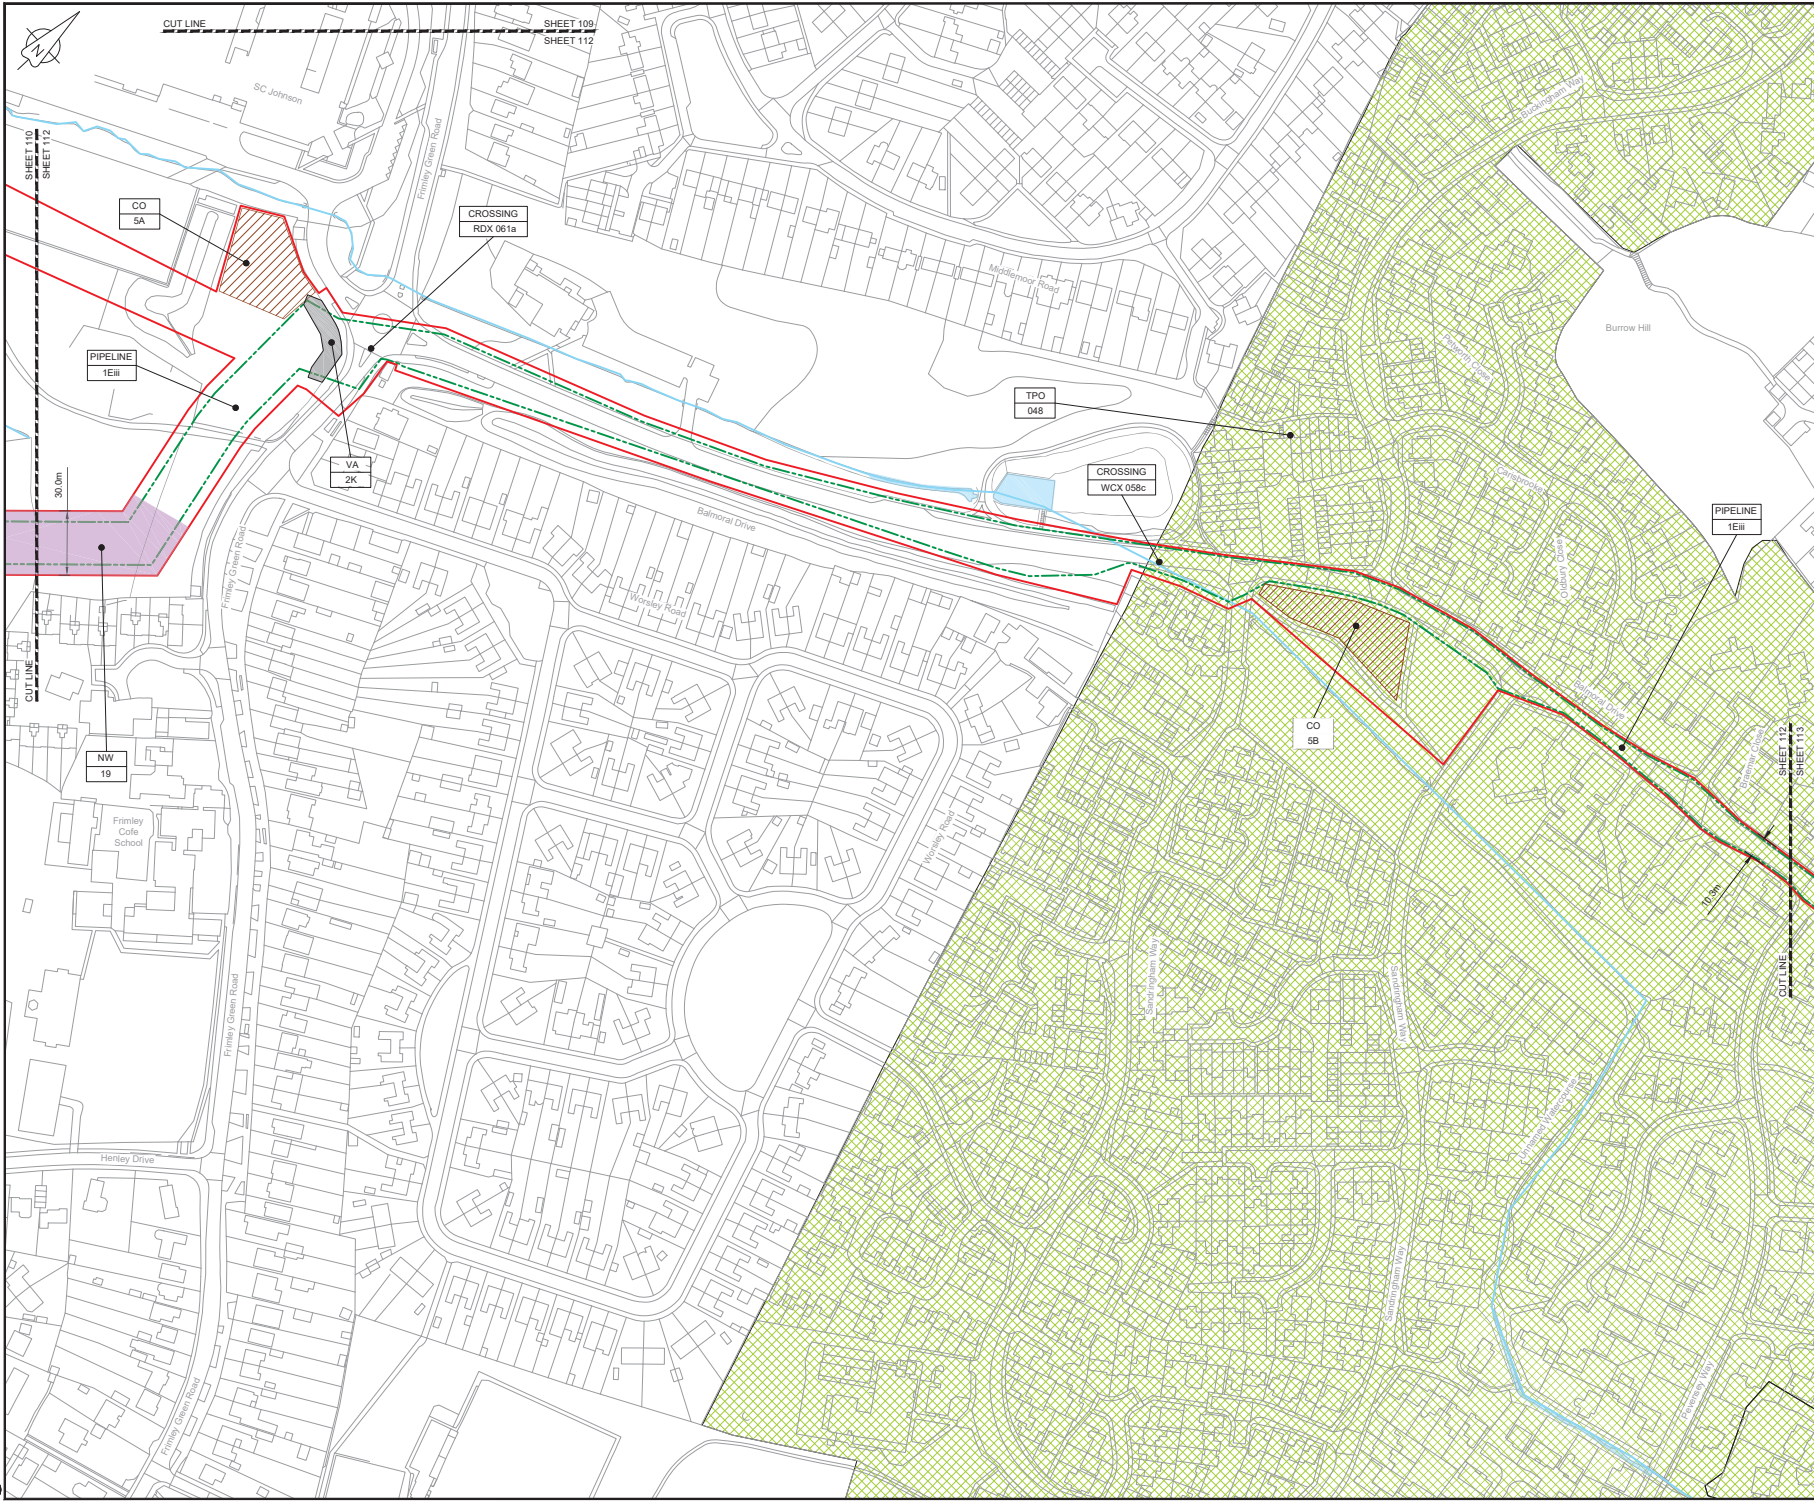

LOCATION PLAN  
SCALE 1:500,000

- NOTES**
- THIS DRAWING IS IN METRES UNLESS STATED OTHERWISE.
  - TRENCHLESS CROSSINGS ARE INDICATIVE ONLY.

- LEGEND**
- ORDER LIMITS
  - LIMITS OF DEVIATION
  - NARROW WORKING AREA (NW)
  - TRENCHLESS CROSSING (TC)
  - WATER BODIES
  - ABOVE GROUND INSTALLATION (AGI) / VALVE (VA) / PRESSURE TRANSDUCER (PT)
  - COMPOUND (CO)
  - TREE PRESERVATION ORDER (TPO)
  - DESCRIPTION
  - ID or WORK NUMBER (if applicable)
  - COMMENCEMENT / TERMINATION OF WORKS (COMMENCEMENT = OPEN, TERMINATION = CLOSED)

Contains Ordnance Survey data © Crown copyright and database rights 2019.

© Crown copyright and database rights 2019 OS Licence Number AL100005237.



SCALE 1: 1250 @ A1

CD	03/05/19	DDC SUBMISSION	PC	JA	SC	PH
Rev.	Rev. Date	Purpose of revision	Drawn	Checked	Rev'd	Approved



Client: Esso Petroleum Company, Limited  
Ermyn House,  
Ermyn Way,  
Leatherhead,  
Surrey,  
KT22 8UX




Drawing title  
**GENERAL ARRANGEMENT  
SHEET 112  
REGULATION 5 (2)(O)**

Drawing status: **Fit for Stage Approval**

Scale	1:1250	DO NOT SCALE
Jacobs No.	B2325300	Rev
Client no.		CO1

Drawing number  
**B2325300-JAC-000-CIV-DRG-000612**



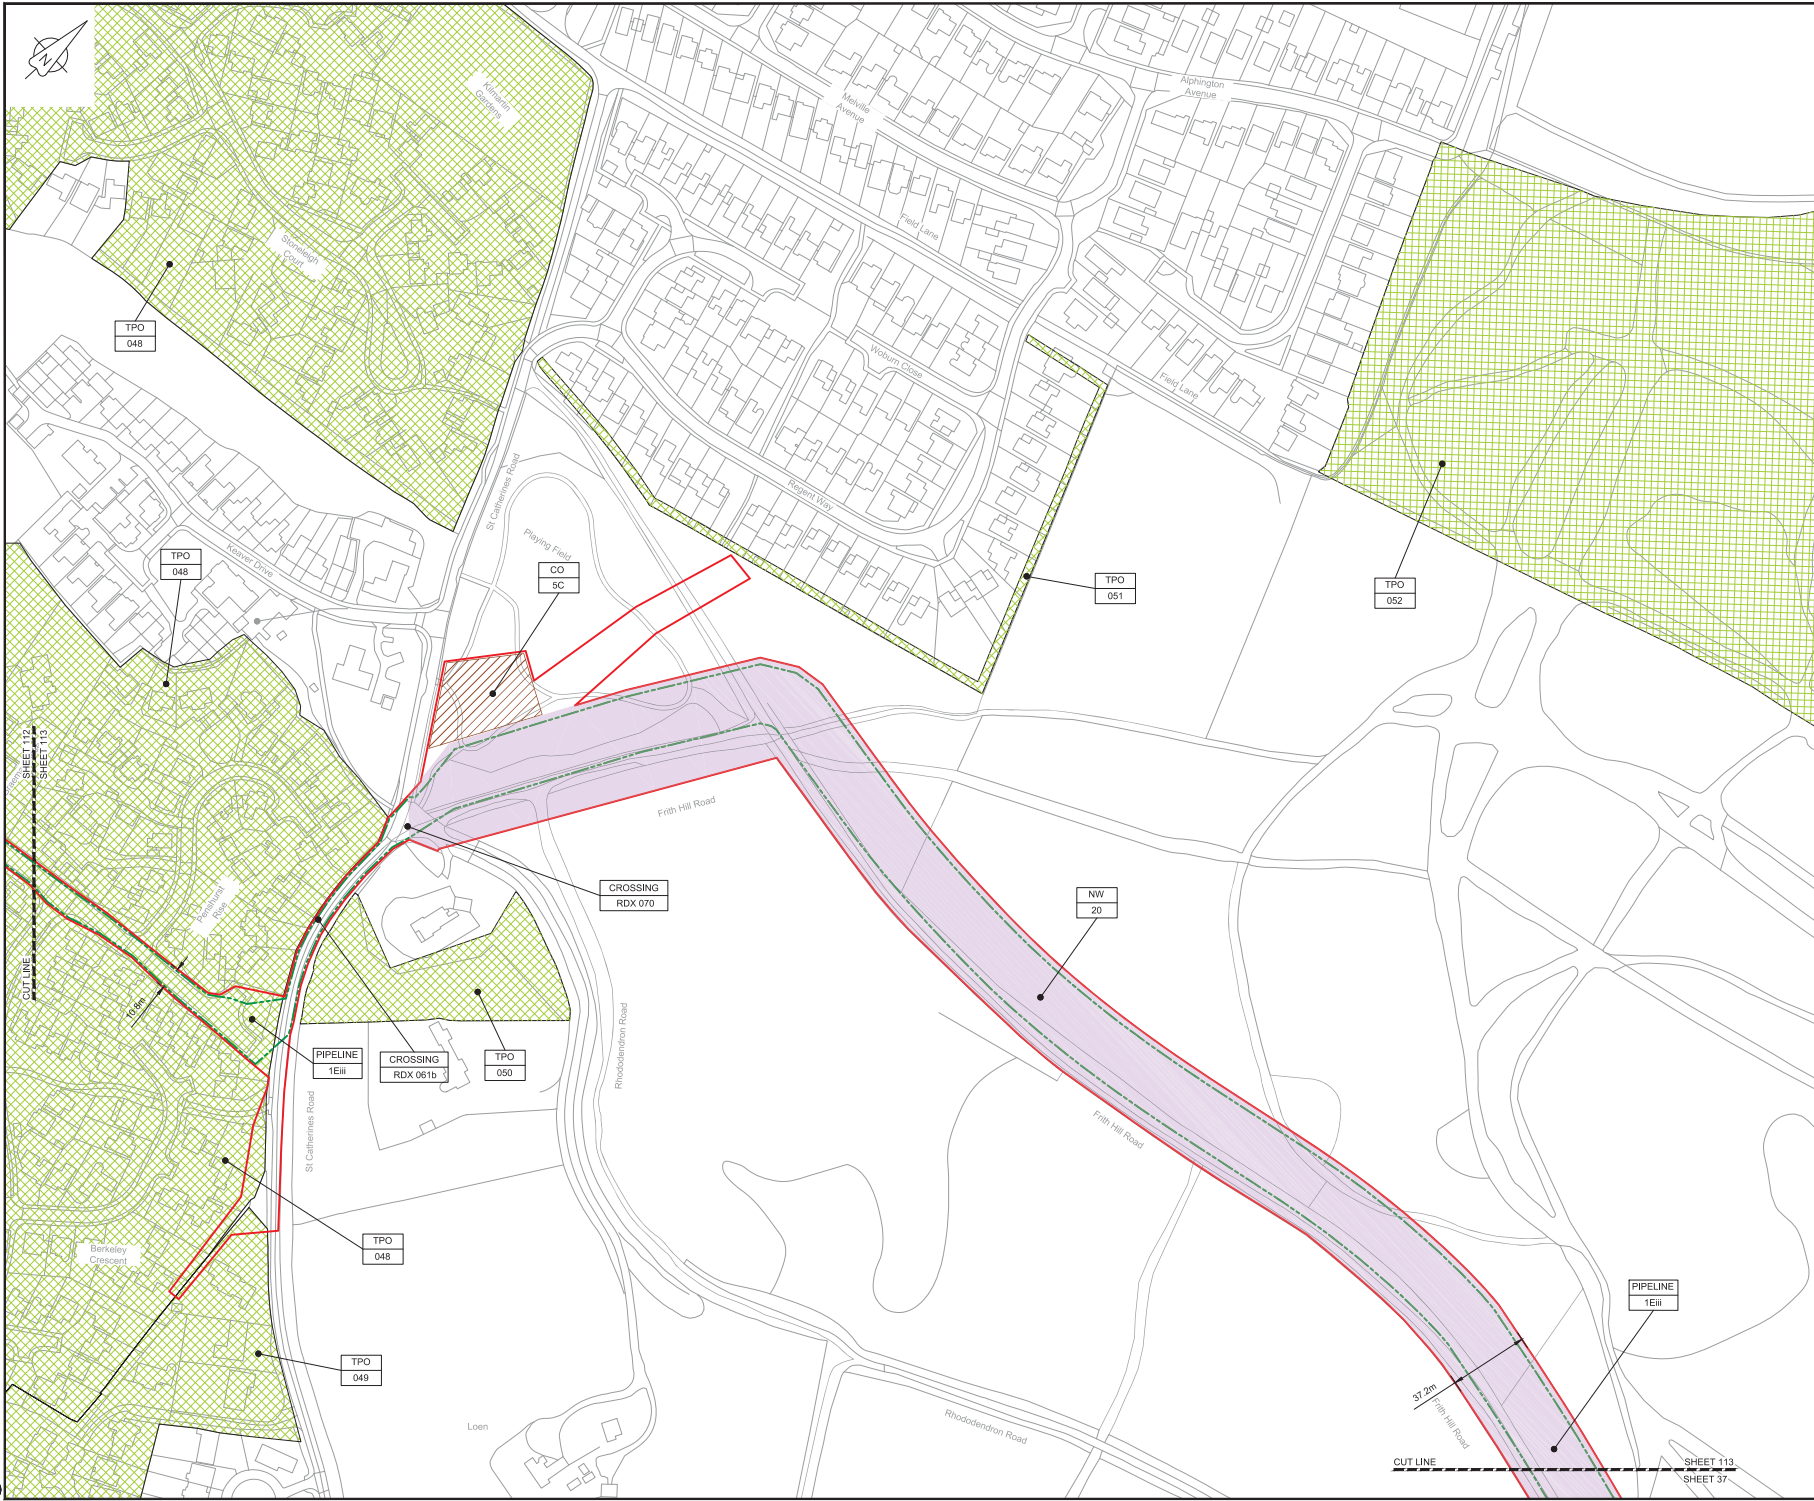

LOCATION PLAN  
SCALE 1:500,000

- NOTES**
- THIS DRAWING IS IN METRES UNLESS STATED OTHERWISE.
  - TRENCHLESS CROSSINGS ARE INDICATIVE ONLY.

- LEGEND**
- ORDER LIMITS
  - LIMITS OF DEVIATION
  - NARROW WORKING AREA (NW)
  - TRENCHLESS CROSSING (TC)
  - WATER BODIES
  - ABOVE GROUND INSTALLATION (AGI) / VALVE (VA) / PRESSURE TRANSDUCER (PT)
  - COMPOUND (CO)
  - TREE PRESERVATION ORDER (TPO)
  - DESCRIPTION
  - ID or WORK NUMBER (if applicable)
  - COMMENCEMENT / TERMINATION OF WORKS (COMMENCEMENT = OPEN, TERMINATION = CLOSED)

Contains Ordnance Survey data © Crown copyright and database rights 2019.  
© Crown copyright and database rights 2019 OS Licence Number AL10005237.



CD1	03/05/19	DDC SUBMISSION	PC	JA	SC	PH
Rev.	Rev. Date	Purpose of revision	Drawn	Checked	Rev'd	Approved

**JACOBS**  
1180 Ewks Rd, Wokingham, RG41 1TU  
Tel: +44(0)118 946 7000 • Fax: +44(0)118 946 7001  
www.jacobs.com

Client: Esso Petroleum Company, Limited  
Ermyn House,  
Ermyn Way,  
Leatherhead,  
Surrey,  
KT22 8UX

Project: **Esso** | Southampton to London Pipeline Project

Drawing title:  
**GENERAL ARRANGEMENT SHEET 113 REGULATION 5 (2)(O)**


Drawing status: **Fit for Stage Approval**

Scale	1:1250	DO NOT SCALE
Client No.	B2325300	Rev
Client no.		Rev
Drawing number		C01

B2325300-JAC-000-CIV-DRG-00613

Use of copyright 2019 Jacobs Ltd. is hereby acknowledged. This drawing and all other documents contained herein are the property of Jacobs Ltd. or its parent company. No part of this document may be reproduced, stored in a retrieval system, or transmitted in any form or by any means, electronic, mechanical, photocopying, recording, or by any information storage and retrieval system, without the prior written permission of Jacobs Ltd. Jacobs Ltd. is not responsible for any errors or omissions in this drawing. The drawings are for information only and do not constitute an offer of any services or products. The drawings are for information only and do not constitute an offer of any services or products.

C:\pwworking\jacobs\_uk\_water\_utilities\_s44\agis\jms3519\B2325300-JAC-000-CIV-DRG-00613.dwg - 03/05/2019 17:05:46 - A1 Frame - Agisul

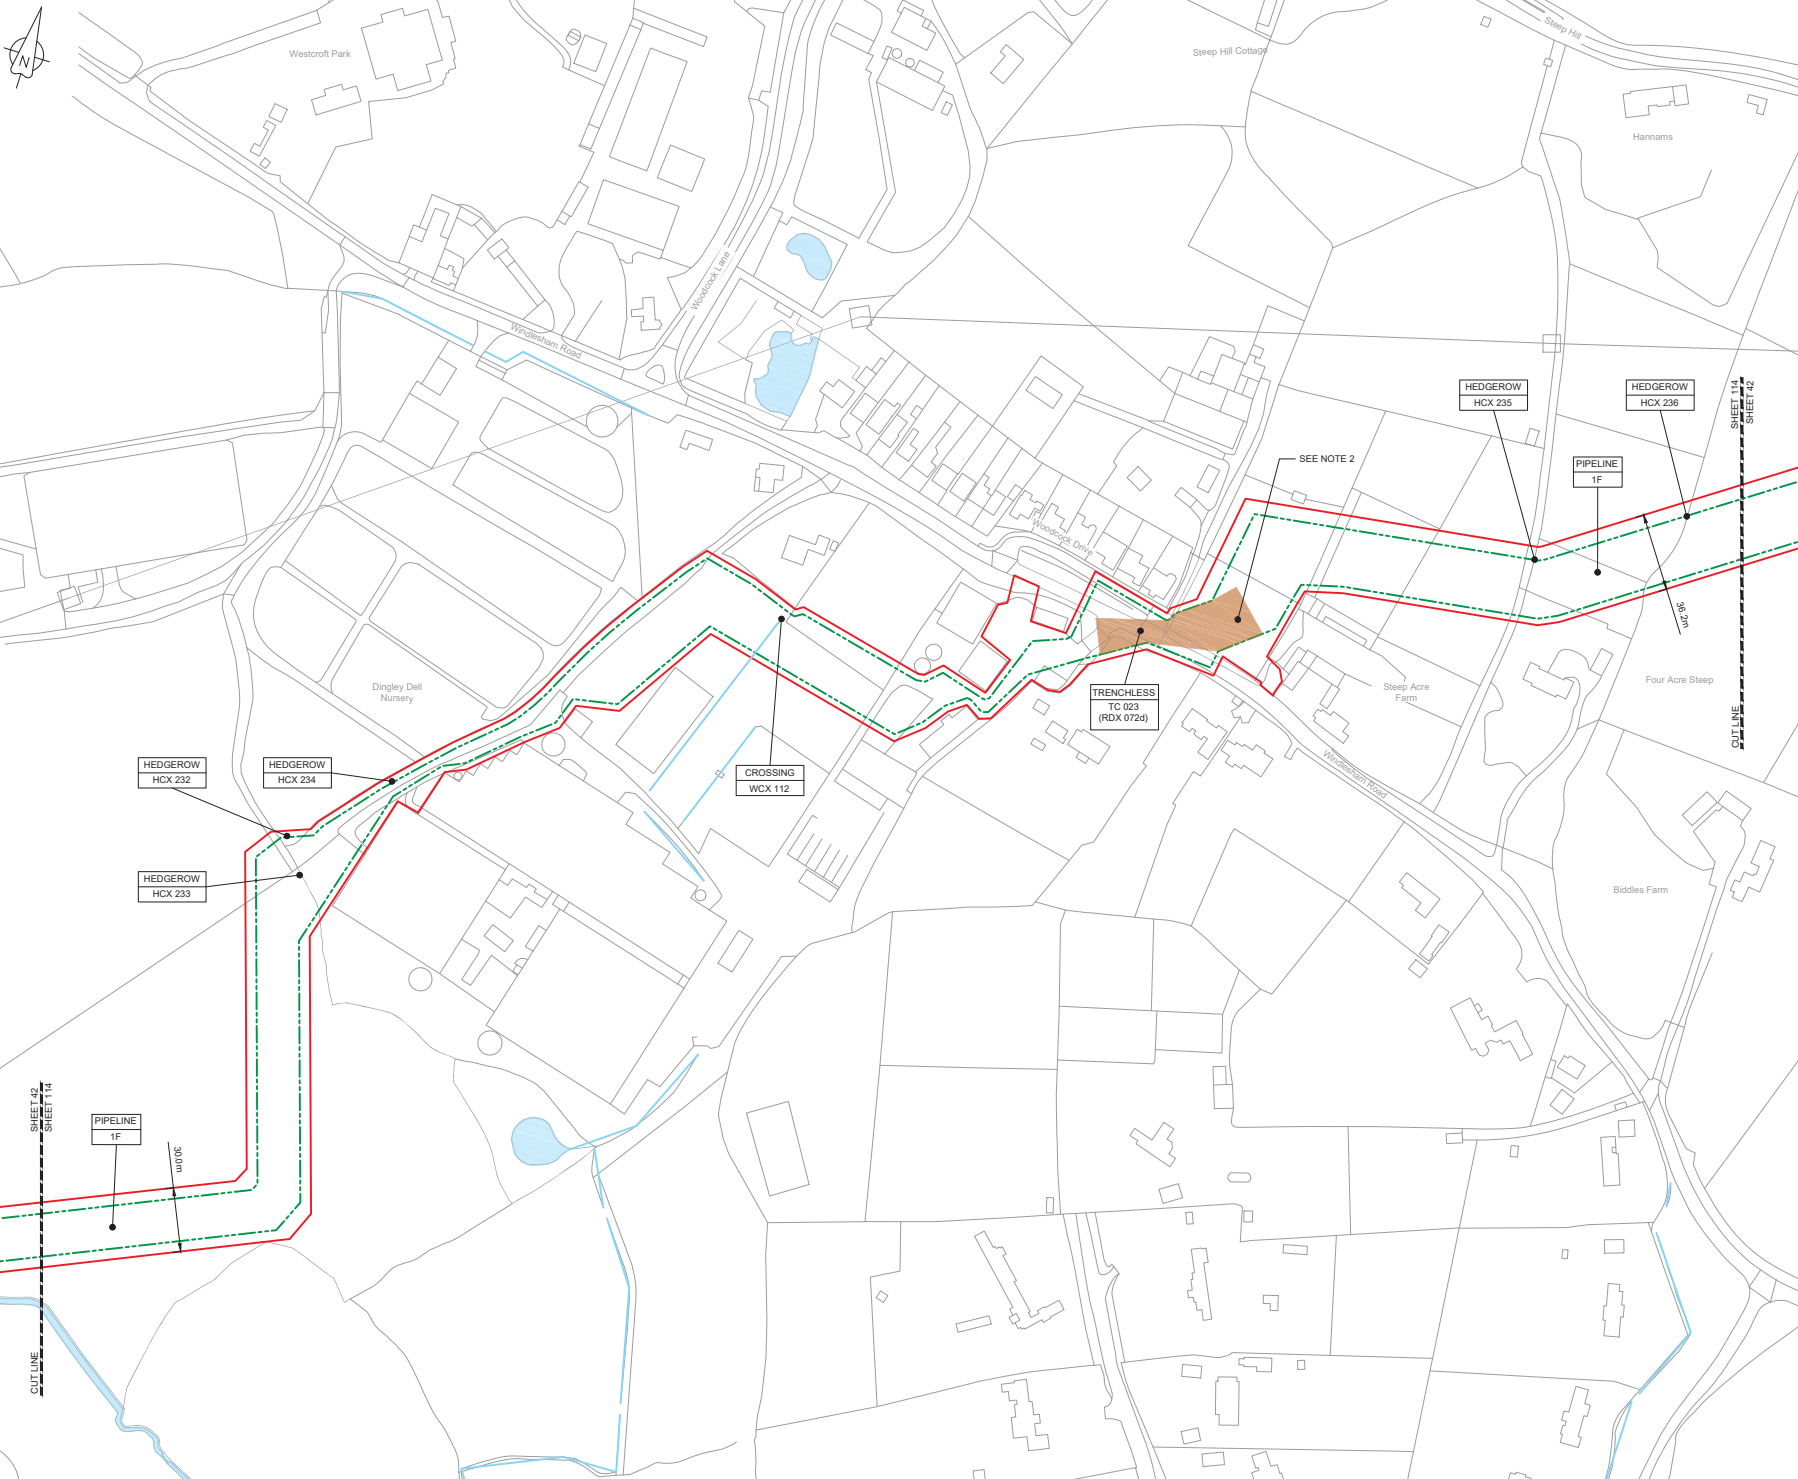

**NOTES**

- THIS DRAWING IS IN METRES UNLESS STATED OTHERWISE.
- TRENCHLESS CROSSINGS ARE INDICATIVE ONLY.

**LEGEND**

	ORDER LIMITS
	LIMITS OF DEVIATION
	NARROW WORKING AREA (NW)
	TRENCHLESS CROSSING (TC)
	WATER BODIES
	ABOVE GROUND INSTALLATION (AGI) / VALVE (VA) / PRESSURE TRANSDUCER (PT)
	COMPOUND (CO)
	TREE PRESERVATION ORDER (TPO)
	DESCRIPTION
	ID or WORK NUMBER (if applicable)
	COMMENCEMENT / TERMINATION OF WORKS (COMMENCEMENT = OPEN, TERMINATION = CLOSED)

Contains Ordnance Survey data © Crown copyright and database rights 2019.

© Crown copyright and database rights 2019 OS Licence Number AL100005237.



CD	03/2019	DDC SUBMISSION	PC	JA	SC	PH
Rev.	Rev. Date	Purpose of revision	Drawn	Checked	Rev'd	Approved

**JACOBS**  
1180 Epsom Road, Wokingham, Wokingham, RG41 5TU  
Tel: +44(0)118 946 7000 • Fax: +44(0)118 946 7001  
www.jacobs.com

Client: Esso Petroleum Company, Limited  
Emryn House,  
Emryn Way,  
Leatherhead,  
Surrey,  
KT22 8UX

Project: Southampton to London Pipeline Project

Drawing title:  
**GENERAL ARRANGEMENT  
SHEET 114  
REGULATION 5 (2)(O)**


Drawing status: **Fit for Stage Approval**

Scale	1:1250	DO NOT SCALE
Jacobs No.	B2325300	Rev
Client no.		<b>CO1</b>

Drawing number:  
**B2325300-JAC-000-CIV-DRG-000614**

C:\pwworking\jacobs\_uk\_water\_utilities\_sas4\cheff\p\mas351188\2325300-JAC-000-CIV-DRG-000614.dwg - 03/02/2019 12:13:59 - A1Frame - CreateP



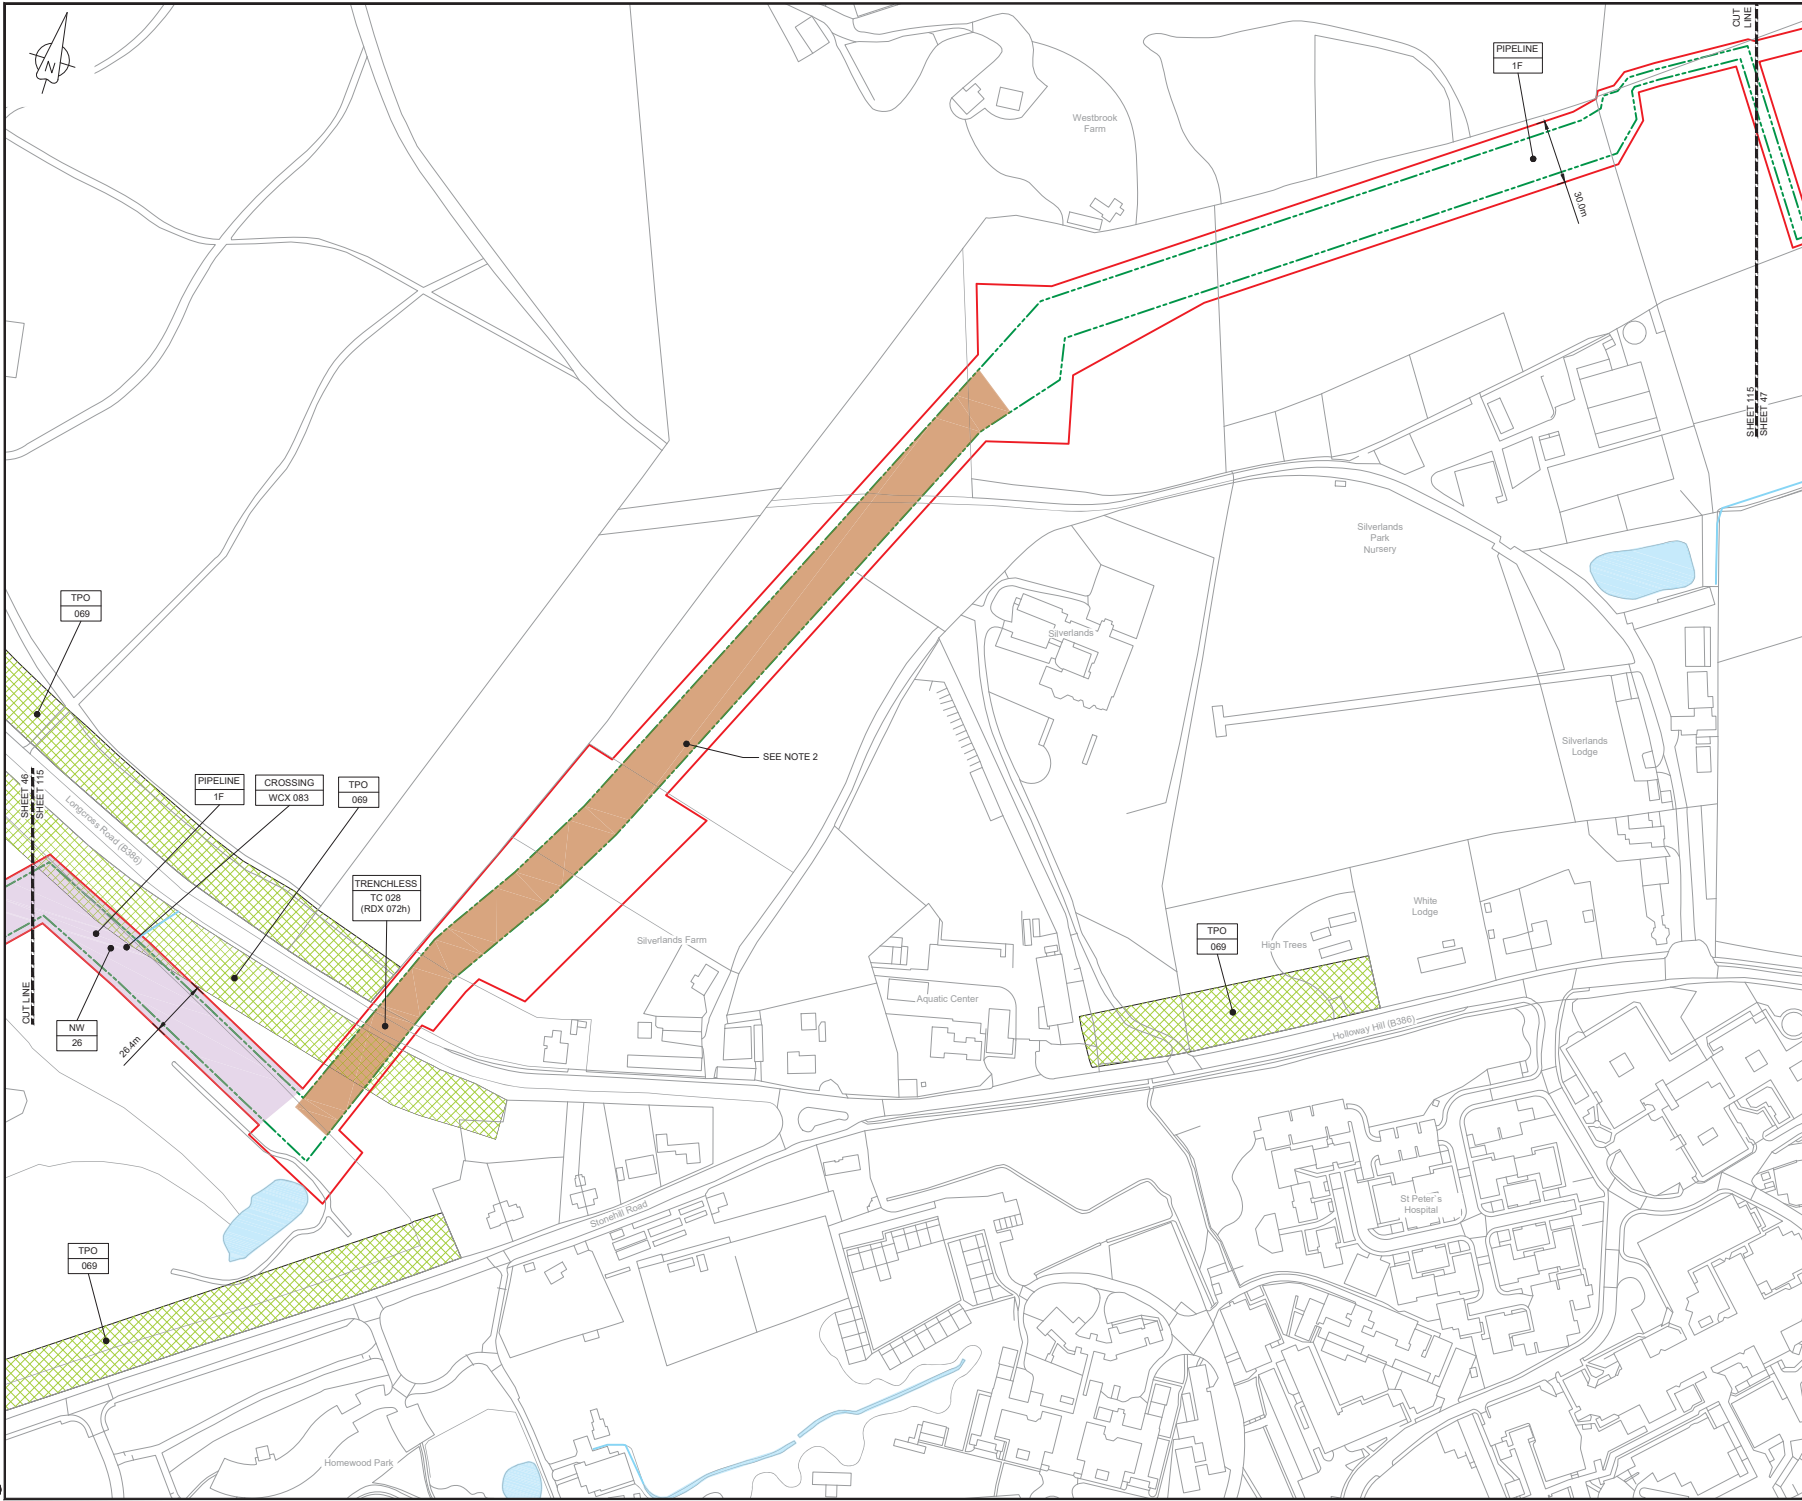

LOCATION PLAN  
SCALE 1:500,000

- NOTES**
1. THIS DRAWING IS IN METRES UNLESS STATED OTHERWISE.
  2. TRENCHLESS CROSSINGS ARE INDICATIVE ONLY.

- LEGEND**
- ORDER LIMITS
  - - - LIMITS OF DEVIATION
  - NARROW WORKING AREA (NW)
  - TRENCHLESS CROSSING (TC)
  - WATER BODIES
  - ABOVE GROUND INSTALLATION (AGI) / VALVE (VA) / PRESSURE TRANSDUCER (PT)
  - COMPOUND (CO)
  - TREE PRESERVATION ORDER (TPO)
  - DESCRIPTION
  - ID or WORK NUMBER (if applicable)
  - COMMENCEMENT / TERMINATION OF WORKS (COMMENCEMENT = OPEN, TERMINATION = CLOSED)

Contains Ordnance Survey data © Crown copyright and database rights 2019.

© Crown copyright and database rights 2019 OS Licence Number AL10005237.



SCALE 1:1250 @ A1

CD	03/05/19	DDC SUBMISSION	PC	JA	SC	PH
Rev.	Rev. Date	Purpose of revision	Drawn	Checked	Rev'd	Approved

**JACOBS**  
1180 Epsom Road, Wokingham, Wokingham, RG41 5TU  
Tel: +44(0)118 946 7000 • Fax: +44(0)118 946 7001  
www.jacobs.com

Client: Esso Petroleum Company, Limited  
Emryn House,  
Emryn Way,  
Leatherhead,  
Surrey,  
KT22 8UX

Project: Southampton to London Pipeline Project

Drawing title: **GENERAL ARRANGEMENT SHEET 115 REGULATION 5 (2)(O)**


Drawing status: **Fit for Stage Approval**

Scale	1:1250	DO NOT SCALE
Jacobs No.	B2325300	Rev
Client no.		Rev
Drawing number		<b>CO1</b>

B2325300-JAC-000-CIV-DRG-000615

© Copyright 2019 Jacobs U.K. Limited. This document and its contents are the confidential property of Jacobs and the property of Jacobs. Use or copying of this document in whole or in part without the written permission of Jacobs constitutes an infringement of copyright. Limitation: This drawing has been prepared on behalf of and for the exclusive use of Jacobs Client, and is subject to and issued in accordance with the provisions of the contract between Jacobs and the Client. Jacobs accepts no liability or responsibility whatsoever for its use in connection with any other project, or for any consequences arising from its use.

C:\pwworking\jacobs\_uk\_water\utilities\_sas4\cheff\pma3351188\2325300-JAC-000-CIV-DRG-000615.dwg - 03/05/2019 12:18:17 - A1Frame - CleanPl

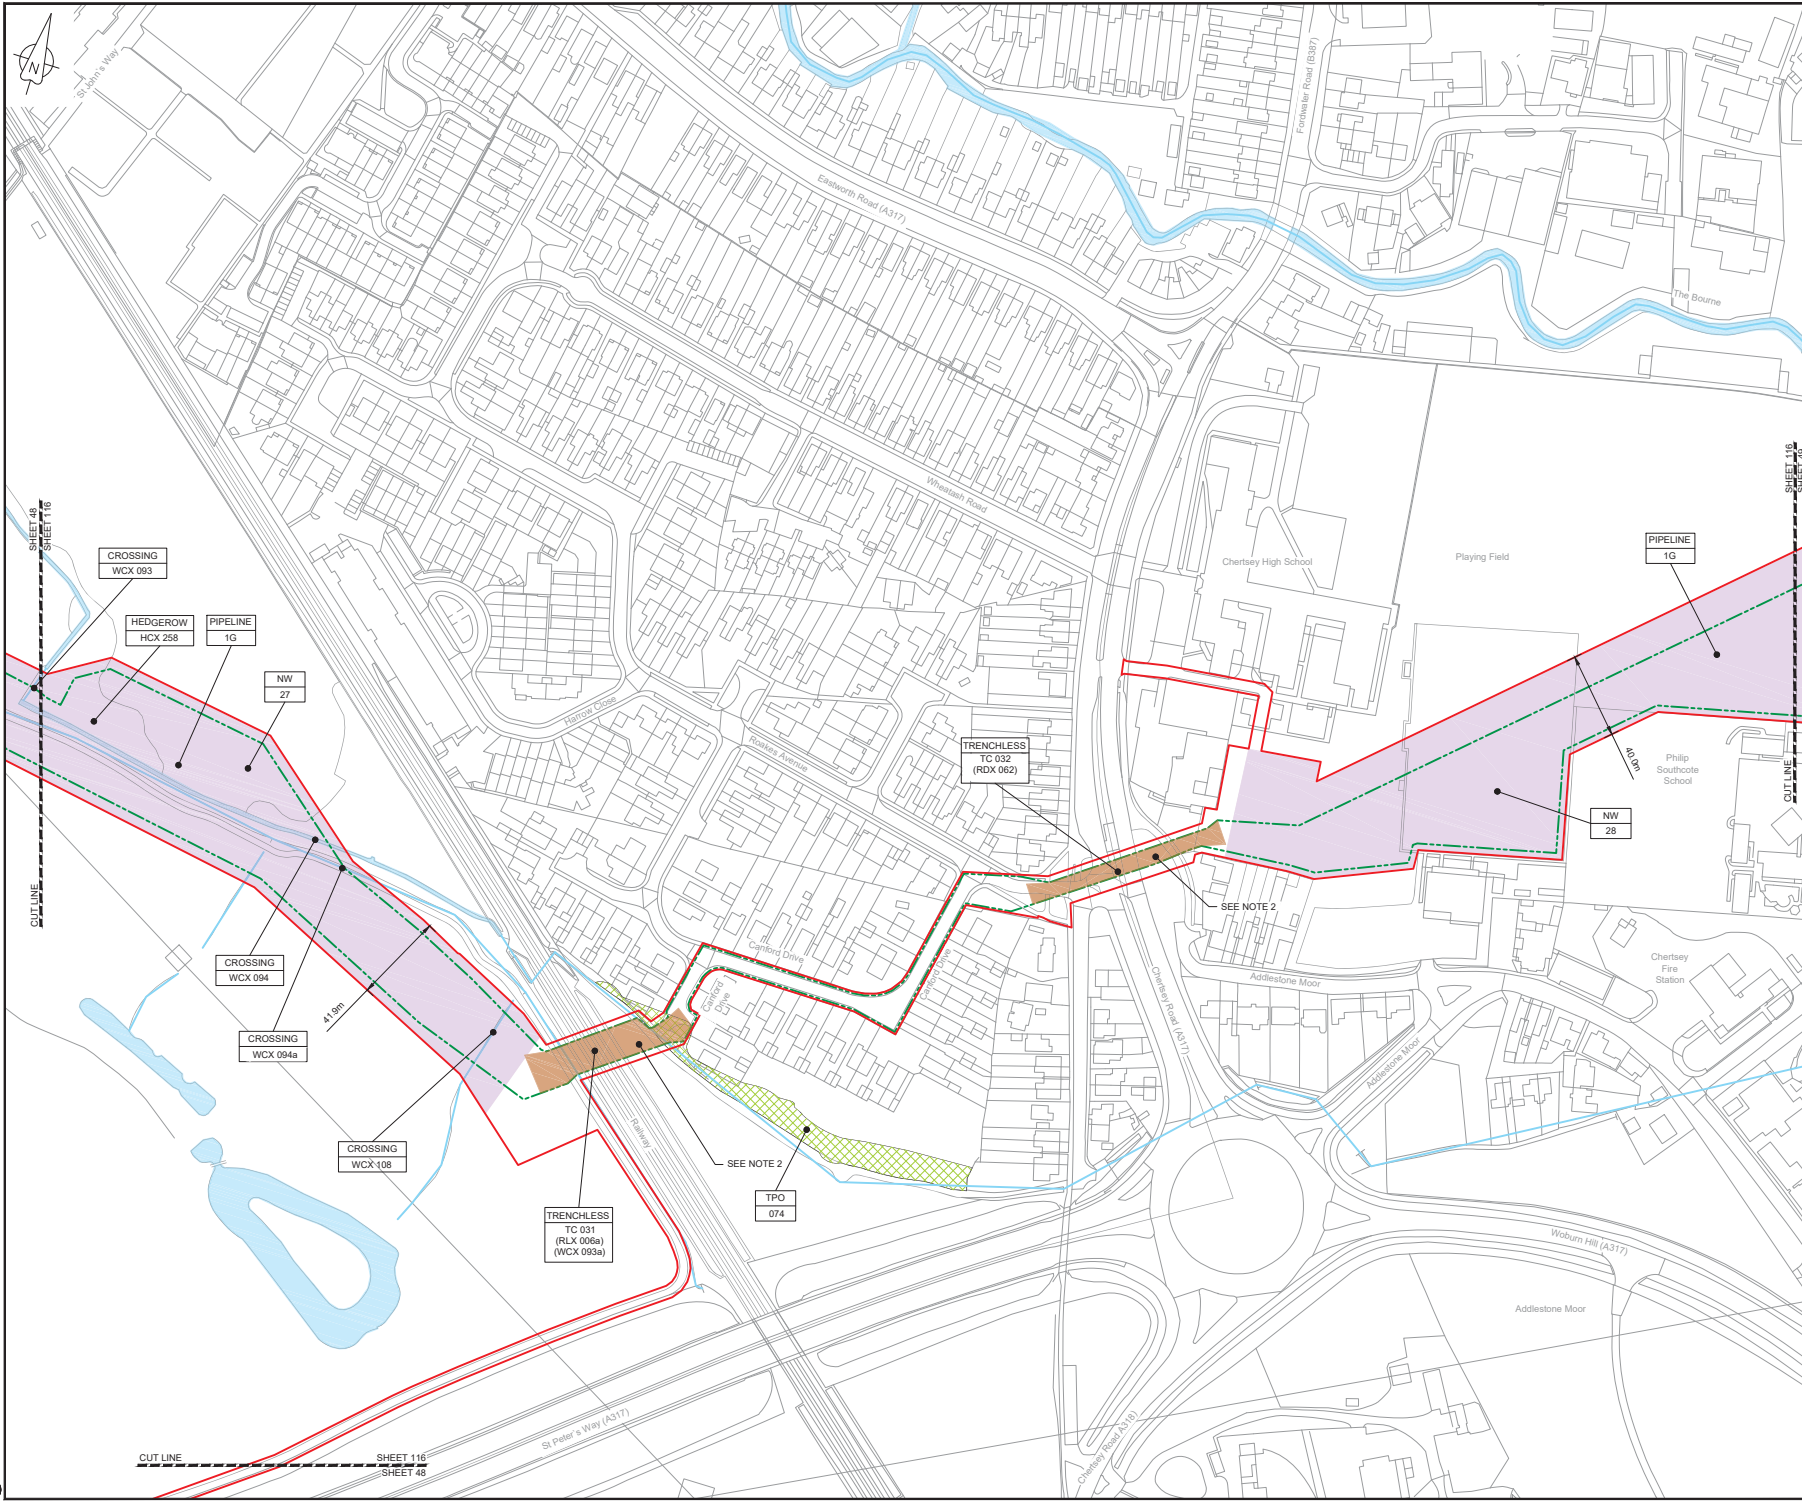

LOCATION PLAN  
SCALE 1:500,000

- NOTES**
1. THIS DRAWING IS IN METRES UNLESS STATED OTHERWISE.
  2. TRENCHLESS CROSSINGS ARE INDICATIVE ONLY.

**LEGEND**

	ORDER LIMITS
	LIMITS OF DEVIATION
	NARROW WORKING AREA (NW)
	TRENCHLESS CROSSING (TC)
	WATER BODIES
	ABOVE GROUND INSTALLATION (AGI) / VALVE (VA) / PRESSURE TRANSDUCER (PT)
	COMPOUND (CO)
	TREE PRESERVATION ORDER (TPO)
	DESCRIPTION
	ID or WORK NUMBER (if applicable)
	COMMENCEMENT / TERMINATION OF WORKS (COMMENCEMENT = OPEN, TERMINATION = CLOSED)

Contains Ordnance Survey data © Crown copyright and database rights 2019.

© Crown copyright and database rights 2019 OS Licence Number AL100005237.



SCALE 1 : 1250 @ A1

CD	03/05/19	DDC SUBMISSION	PC	JA	SC	RH
Rev.	Rev. Date	Purpose of revision	Drawn	Checked	Rev'd	Approved

**JACOBS**  
1180 Emslack Road, Winchester, Hampshire, RG41 5TU  
Tel: +44(0)118 946 7000 • Fax: +44(0)118 946 7001  
www.jacobs.com

Client: Esso Petroleum Company, Limited  
Ermyn House,  
Ermyn Way,  
Leatherhead,  
Surrey,  
KT22 8UX




Drawing title  
**GENERAL ARRANGEMENT  
SHEET 116  
REGULATION 5 (2)(O)**

Drawing status: **Fit for Stage Approval**

Scale	1:1250	DO NOT SCALE
Jacobs No.	B2325300	Rev
Client no.		<b>CO1</b>

Drawing number  
**B2325300-JAC-000-CIV-DRG-000616**



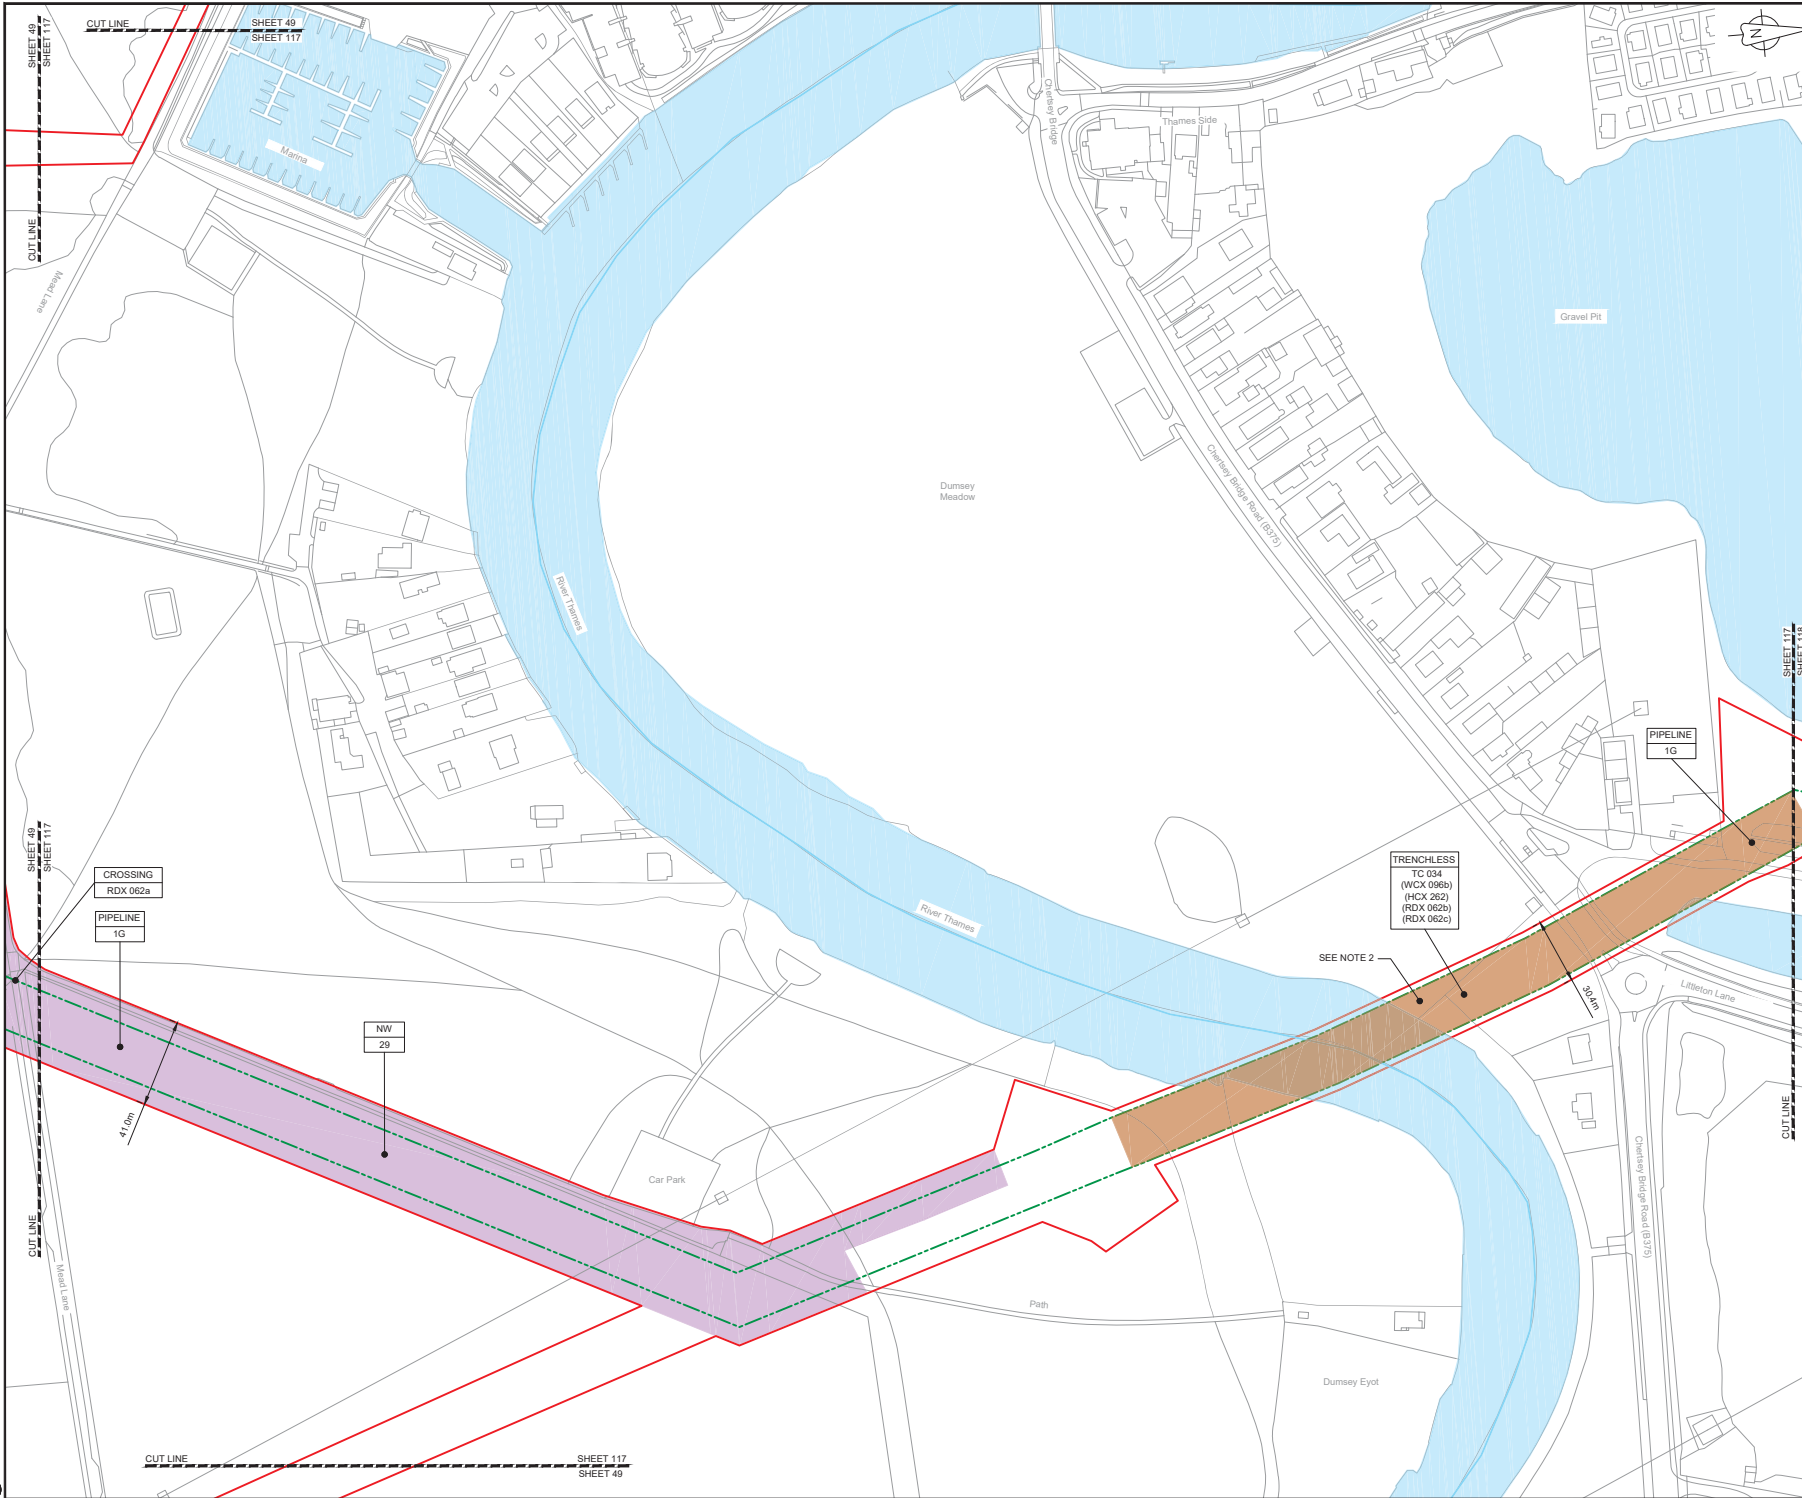

LOCATION PLAN  
SCALE 1:500,000

- NOTES**
1. THIS DRAWING IS IN METRES UNLESS STATED OTHERWISE.
  2. TRENCHLESS CROSSINGS ARE INDICATIVE ONLY.

- LEGEND**
- ORDER LIMITS
  - LIMITS OF DEVIATION
  - NARROW WORKING AREA (NW)
  - TRENCHLESS CROSSING (TC)
  - WATER BODIES
  - ABOVE GROUND INSTALLATION (AGI) / VALVE (VA) / PRESSURE TRANSDUCER (PT)
  - COMPOUND (CO)
  - TREE PRESERVATION ORDER (TPO)
  - DESCRIPTION
  - ID or WORK NUMBER (if applicable)
  - COMMENCEMENT / TERMINATION OF WORKS (COMMENCEMENT = OPEN, TERMINATION = CLOSED)

Contains Ordnance Survey data © Crown copyright and database rights 2019.

© Crown copyright and database rights 2019 OS Licence Number AL10005237.



SCALE 1 : 1250 @ A1

CDI	03/05/19	DDC SUBMISSION	PC	JA	SC	PH
Rev.	Rev. Date	Purpose of revision	Drawn	Checked	Rev'd	Approved

**JACOBS**  
1180 Ewks Rd, Wokingham, Wokingham, RG41 5TU  
Tel: +44(0)118 945 7000 • Fax: +44(0)118 945 7001  
www.jacobs.com

Client: Esso Petroleum Company, Limited  
Ermyn House,  
Ermyn Way,  
Leatherhead,  
Surrey,  
KT22 8UX


Project: **Esso** | Southampton to London Pipeline Project

Drawing title:  
**GENERAL ARRANGEMENT SHEET 117 REGULATION 5 (2)(O)**

Drawing status: **Fit for Stage Approval**

Scale	1:1250	DO NOT SCALE
Jacobs No.	B2325300	Rev
Client no.		Rev
Drawing number		<b>C01</b>

B2325300-JAC-000-CIV-DRG-000617

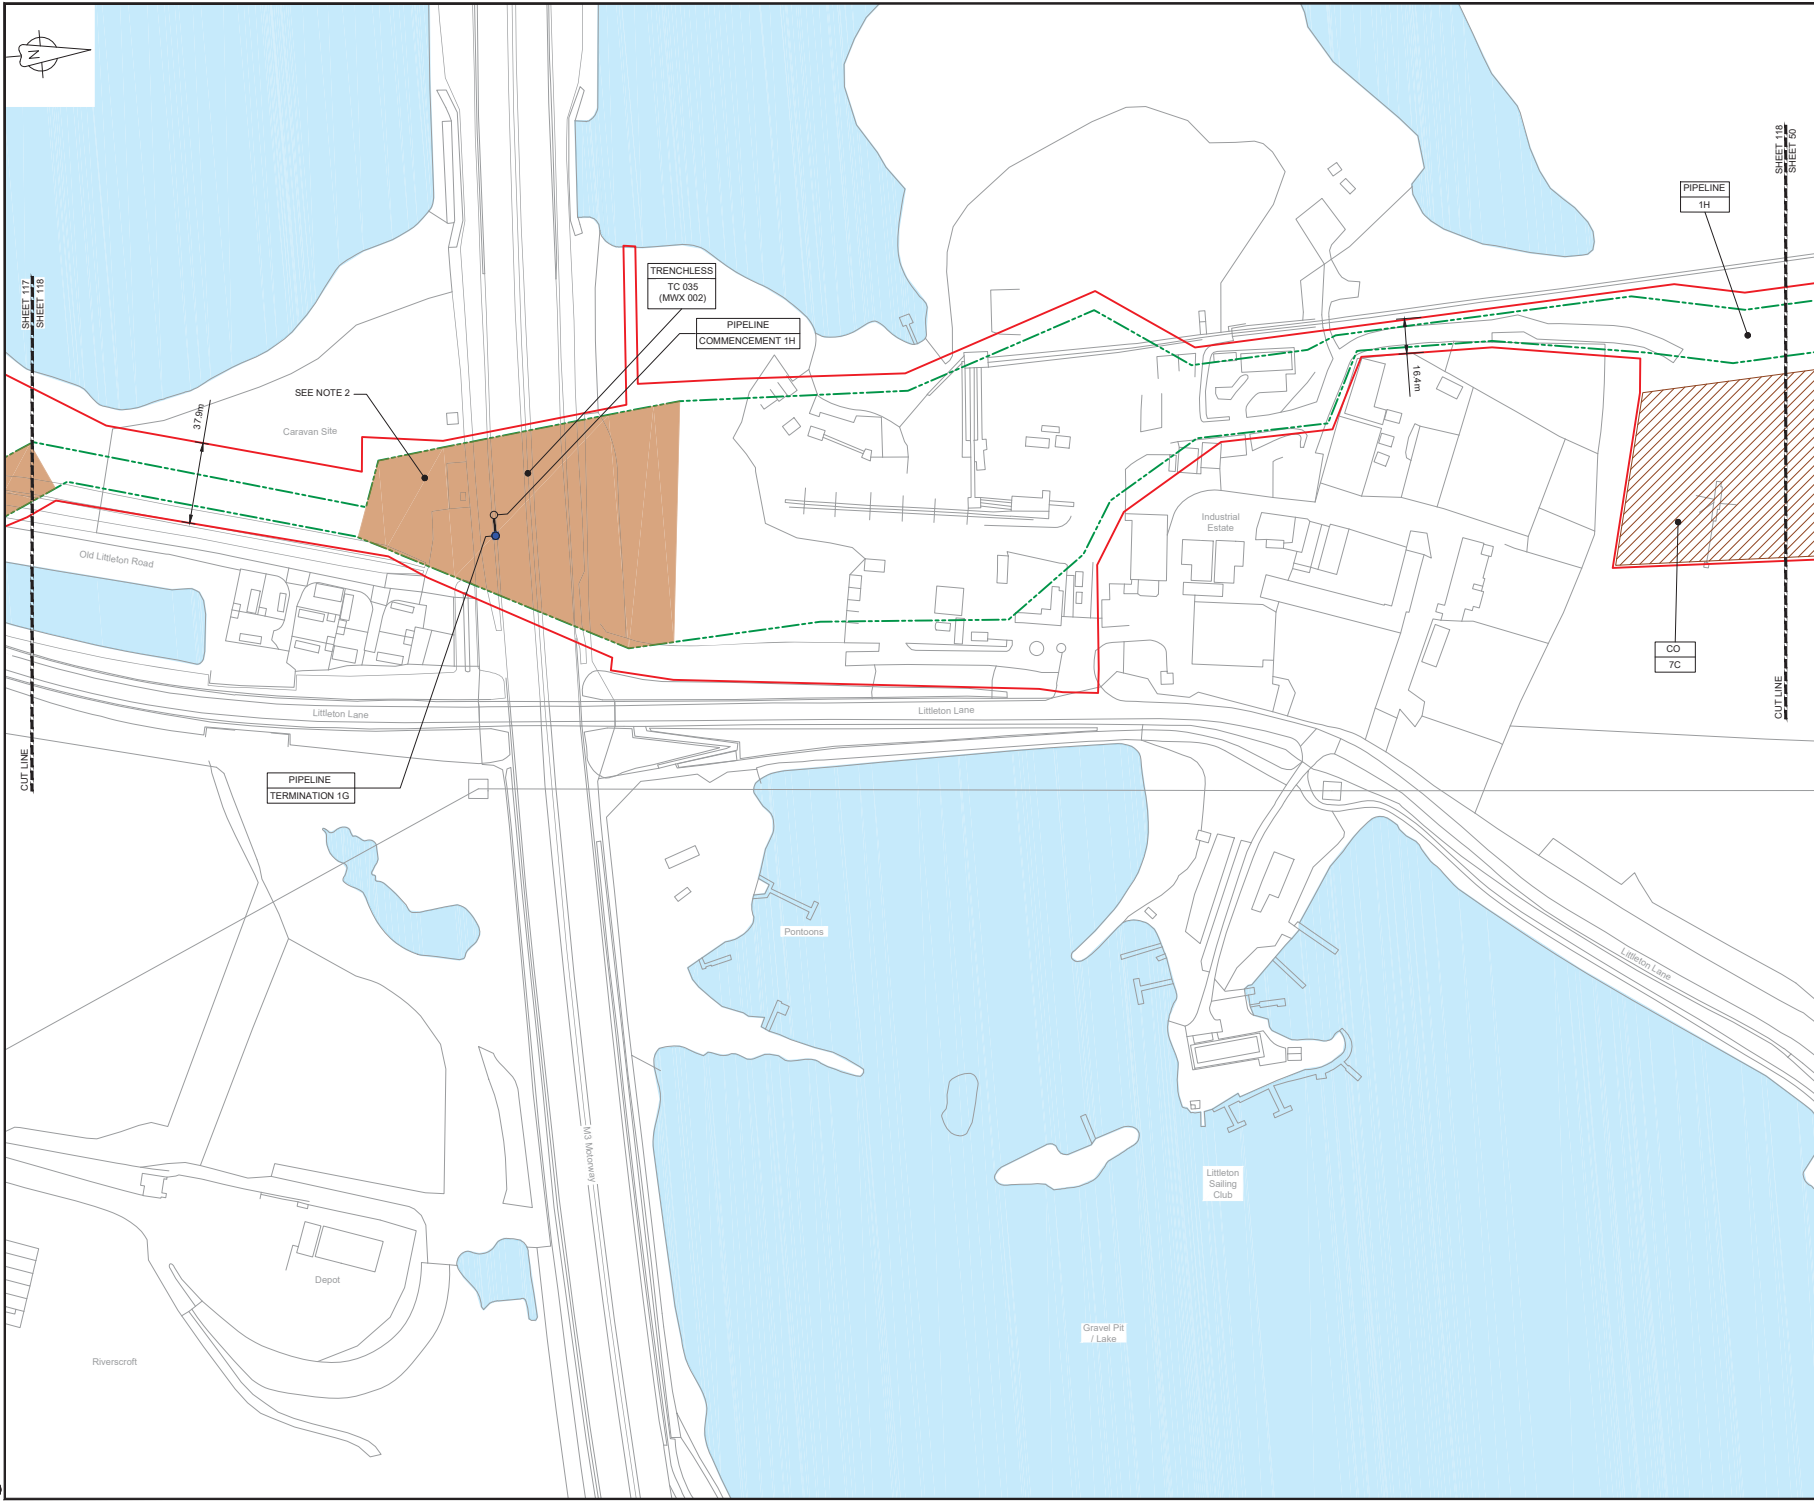

- NOTES**
- THIS DRAWING IS IN METRES UNLESS STATED OTHERWISE.
  - TRENCHLESS CROSSINGS ARE INDICATIVE ONLY.
- LEGEND**
- ORDER LIMITS
  - LIMITS OF DEVIATION
  - NARROW WORKING AREA (NW)
  - TRENCHLESS CROSSING (TC)
  - WATER BODIES
  - ABOVE GROUND INSTALLATION (AGI) / VALVE (VA) / PRESSURE TRANSDUCER (PT)
  - COMPOUND (CO)
  - TREE PRESERVATION ORDER (TPO)
  - DESCRIPTION
  - ID or WORK NUMBER (if applicable)
  - COMMENCEMENT / TERMINATION OF WORKS (COMMENCEMENT = OPEN, TERMINATION = CLOSED)

Contains Ordnance Survey data © Crown copyright and database rights 2019.

© Crown copyright and database rights 2019 OS Licence Number AL100005237.

SCALE 1: 1250 @ A1

CD	03/05/19	DDC SUBMISSION	PC	JA	SC	RH
Rev.	Rev. Date	Purpose of revision	Drawn	Checked	Rev'd	Approved

**JACOBS**  
1180 Epsom Road, Wokingham, Wokingham, RG41 5TU  
Tel: +44(0)118 946 7000 • Fax: +44(0)118 946 7001  
www.jacobs.com

Client: Esso Petroleum Company, Limited  
Emryn House,  
Emryn Way,  
Leatherhead,  
Surrey,  
KT22 8UX

Project: Southampton to London Pipeline Project

Drawing title:  
**GENERAL ARRANGEMENT  
SHEET 118  
REGULATION 5 (2)(O)**

Drawing status: **Fit for Stage Approval**

Scale	1:1250	DO NOT SCALE
Jacobs No.	B2325300	Rev
Client no.		<b>C01</b>
Drawing number	<b>B2325300-JAC-000-CIV-DRG-000618</b>	





LOCATION PLAN  
SCALE 1:500,000

- NOTES**
1. THIS DRAWING IS IN METRES UNLESS STATED OTHERWISE.
  2. TRENCHLESS CROSSINGS ARE INDICATIVE ONLY.

**LEGEND**

- ORDER LIMITS
- LIMITS OF DEVIATION
- NARROW WORKING AREA (NW)
- TRENCHLESS CROSSING (TC)
- WATER BODIES
- ABOVE GROUND INSTALLATION (AGI) / VALVE (VA) / PRESSURE TRANSDUCER (PT)
- COMPOUND (CO)
- TREE PRESERVATION ORDER (TPO)

DESCRIPTION

- ID or WORK NUMBER (if applicable)
- COMMENCEMENT / TERMINATION OF WORKS (COMMENCEMENT = OPEN, TERMINATION = CLOSED)

Contains Ordnance Survey data © Crown copyright and database rights 2019.

© Crown copyright and database rights 2019  
OS Licence Number AL100005237.



CD	Rev. Date	Rev. Description	PC	JA	SC	PH
CD1	03/05/19	ISSUE FOR SUBMISSION				

**JACOBS**  
1180 Emslack Road, Winchester, Wokingham, RG41 5TU  
Tel: +44(0)118 946 7000 • Fax: +44(0)118 946 7001  
www.jacobs.com

Client: Esso Petroleum Company, Limited  
Emryn House,  
Emryn Way,  
Leatherhead,  
Surrey,  
KT22 8UX

Project: Southampton to London Pipeline Project

Drawing title: **GENERAL ARRANGEMENT SHEET 119 REGULATION 5 (2)(O)**

Drawing status: **Fit for Stage Approval**

Scale	1:1250	DO NOT SCALE
Jacobs No.	B2325300	Rev
Client no.		Rev
Drawing number		<b>CO1</b>


B2325300-JAC-000-CIV-DRG-000619

© Copyright 2019 Jacobs U.K. Limited. This document and all materials contained herein are the property of Jacobs. Use or copying of this document in whole or in part without the written permission of Jacobs constitutes an infringement of copyright. Limitation: This drawing has been prepared on behalf of and for the exclusive use of Jacobs Client, and is subject to and issued in accordance with the provisions of the contract between Jacobs and the Client. Jacobs accepts no liability or responsibility whatsoever for its use in respect of any other site or reference source. This drawing is for information only.

C:\pwworking\jacobs\_uk\_water\_utilities\_s44\cbe\h\p\ma355138\2325300-JAC-000-CIV-DRG-000619.dwg - 03/05/2019 11:22:56 - A1Frame - CreateP



C:\pwworking\jacobs\_uk\_water\_utilities\_sas4\civ\h\p\351138\2325300-JAC-000-CIV-DRG-000620.dwg - 03/05/2019 12:28:38 - A1Frame - CreateP

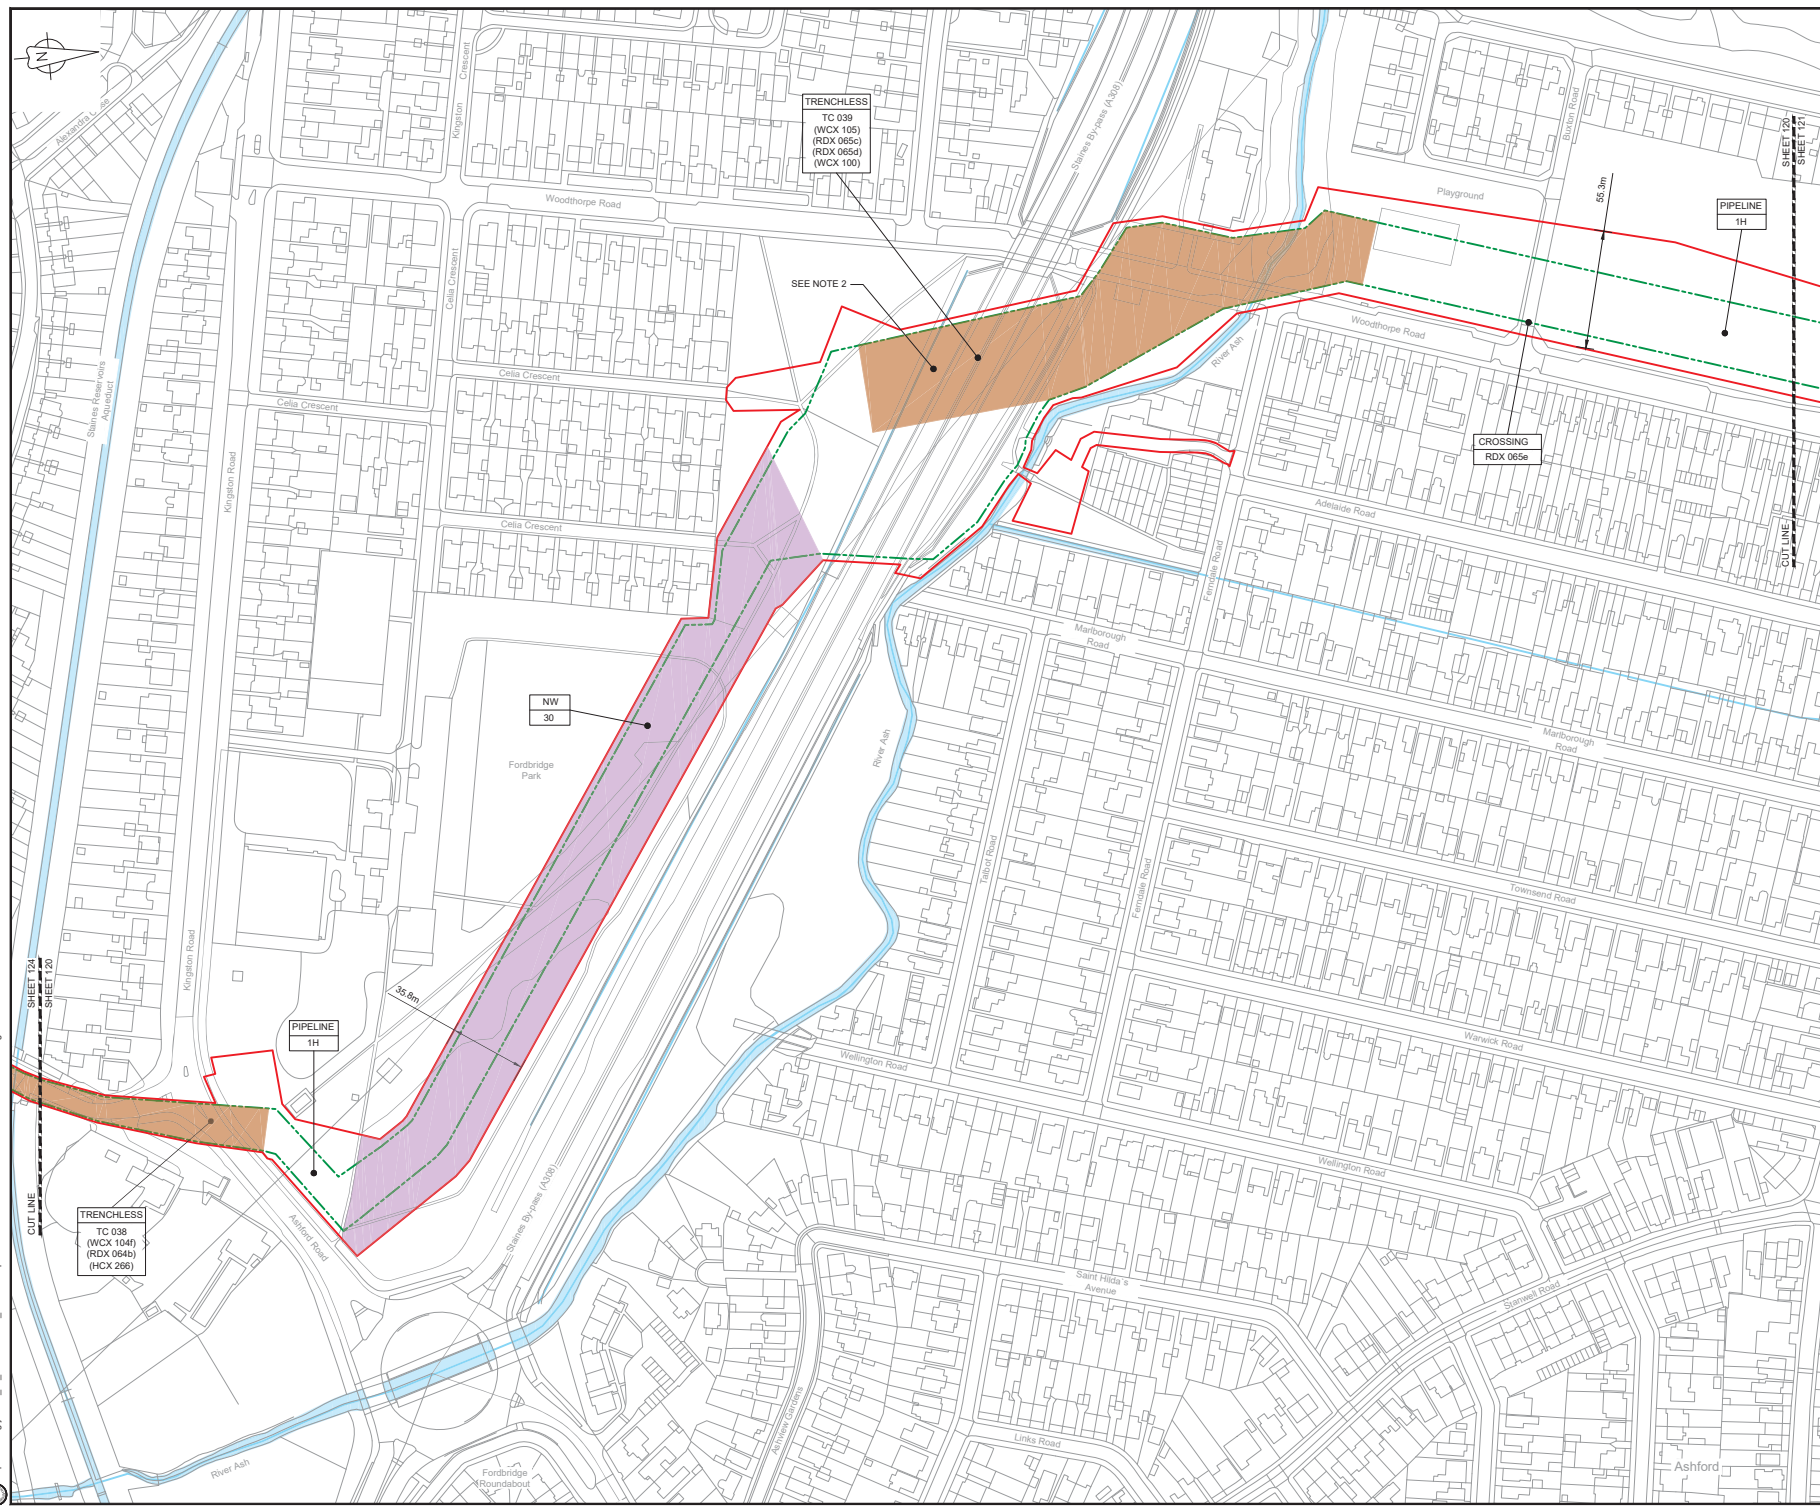


LOCATION PLAN  
SCALE 1:500,000

- NOTES**
1. THIS DRAWING IS IN METRES UNLESS STATED OTHERWISE.
  2. TRENCHLESS CROSSINGS ARE INDICATIVE ONLY.

- LEGEND**
- ORDER LIMITS
  - LIMITS OF DEVIATION
  - NARROW WORKING AREA (NW)
  - TRENCHLESS CROSSING (TC)
  - WATER BODIES
  - ABOVE GROUND INSTALLATION (AGI) / VALVE (VA) / PRESSURE TRANSDUCER (PT)
  - COMPOUND (CO)
  - TREE PRESERVATION ORDER (TPO)
  - DESCRIPTION
  - ID or WORK NUMBER (if applicable)
  - COMMENCEMENT / TERMINATION OF WORKS (COMMENCEMENT = OPEN, TERMINATION = CLOSED)

Contains Ordnance Survey data © Crown copyright and database rights 2019.

 © Crown copyright and database rights 2019 OS Licence Number AL100005237.



CD	03/05/19	DDC SUBMISSION	PC	JA	SC	PH
Rev.	Rev. Date	Purpose of revision	Drawn	Checked	Rev'd	Approved

**JACOBS**  
1180 Epsom Road, Wokingham, Wokingham, RG41 5TU  
Tel: +44(0)118 946 7000 • Fax: +44(0)118 946 7001  
www.jacobs.com

Client: Esso Petroleum Company, Limited  
Ermyn House,  
Ermyn Way,  
Leatherhead,  
Surrey,  
KT22 8UX

Project: Southampton to London Pipeline Project

Drawing title:  
**GENERAL ARRANGEMENT  
SHEET 120  
REGULATION 5 (2)(O)**

Drawing status: **Fit for Stage Approval**


Scale	1:1250	DO NOT SCALE
Jacobs No.	B2325300	Rev
Client no.		Rev
Drawing number		<b>CO1</b>

B2325300-JAC-000-CIV-DRG-000620

© Copyright 2019 Jacobs U.K. Limited. This document and its contents are the confidential and proprietary information of Jacobs U.K. Limited. This drawing has been prepared on behalf of and for the exclusive use of Jacobs Client, and is subject to and issued in accordance with the provisions of the contract between Jacobs and the Client. Jacobs accepts no liability or responsibility whatsoever for its use in respect of any other or reference uses. This drawing is not for third party use.



C:\pwworking\jacobs\_uk\_water\_utilities\_sas4\cde\h\pma3351188\2525300-JAC-000-CIV-DRG-00621.dwg - 03/05/2019 12:30:51 - A1Frame - CleanHP

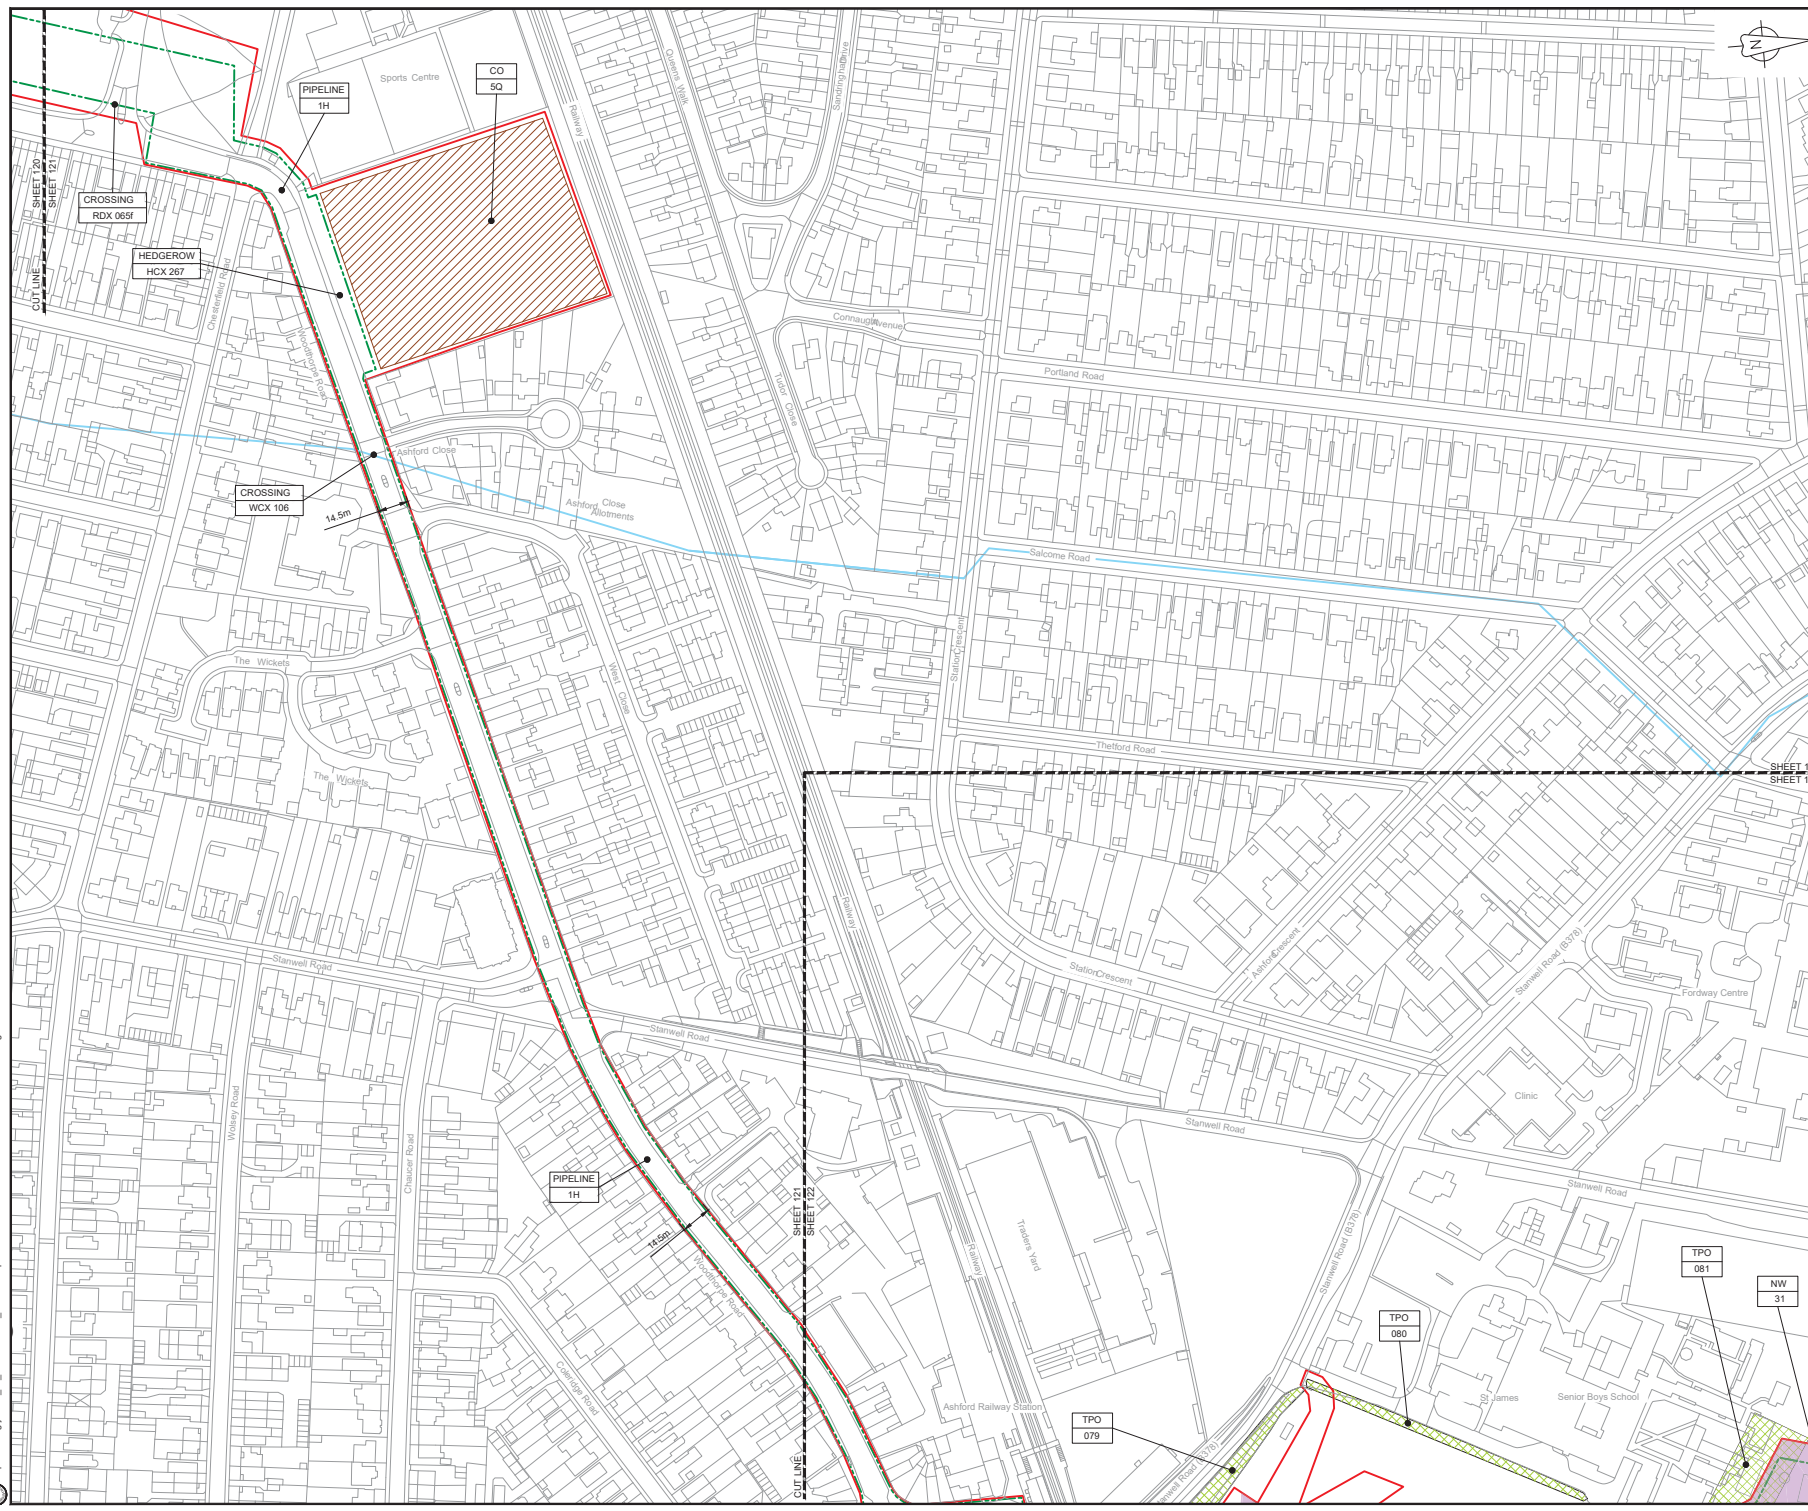

LOCATION PLAN  
SCALE 1:500,000

- NOTES**
1. THIS DRAWING IS IN METRES UNLESS STATED OTHERWISE.
  2. TRENCHLESS CROSSINGS ARE INDICATIVE ONLY.

- LEGEND**
- ORDER LIMITS
  - LIMITS OF DEVIATION
  - NARROW WORKING AREA (NW)
  - TRENCHLESS CROSSING (TC)
  - WATER BODIES
  - ABOVE GROUND INSTALLATION (AGI) / VALVE (VA) / PRESSURE TRANSDUCER (PT)
  - COMPOUND (CO)
  - TREE PRESERVATION ORDER (TPO)
  - DESCRIPTION
  - ID or WORK NUMBER (if applicable)
  - COMMENCEMENT / TERMINATION OF WORKS (COMMENCEMENT = OPEN, TERMINATION = CLOSED)

Contains Ordnance Survey data © Crown copyright and database rights 2019.

© Crown copyright and database rights 2019 OS Licence Number AL10006237.



SCALE 1: 1250 @ A1

CD	03/05/19	DOC SUBMISSION	PC	JA	SC	PH
Rev.	Rev. Date	Purpose of revision	Drawn	Checked	Rev'd	Approved

**JACOBS**  
1180 Emslack Road, Winchester, Hampshire, RG41 5TU  
Tel: +44(0)118 946 7000 • Fax: +44(0)118 946 7001  
www.jacobs.com

Client: Esso Petroleum Company, Limited  
Emryn House,  
Emryn Way,  
Leatherhead,  
Surrey,  
KT22 8UX

Project: Southampton to London Pipeline Project

Drawing title:  
**GENERAL ARRANGEMENT SHEET 121**  
**REGULATION 5 (2)(O)**


Drawing status: **Fit for Stage Approval**

Scale	1:1250	DO NOT SCALE
Scale	1:1250	DO NOT SCALE
Jacobs No.	B2325300	Rev
Client no.	B2325300	Rev
Drawing number		<b>CO1</b>

B2325300-JAC-000-CIV-DRG-00621

© Copyright 2019 Jacobs U.K. Limited. This document and its contents are the confidential and proprietary of Jacobs. Use or copying of this document in whole or in part without the written permission of Jacobs constitutes an infringement of copyright. Limitation: This drawing has been prepared on behalf of and for the exclusive use of Jacobs Client, and is subject to and issued in accordance with the provisions of the contract between Jacobs and the Client. Jacobs accepts no liability or responsibility whatsoever for its use in excess of any such contract. The drawings do not constitute a contract.



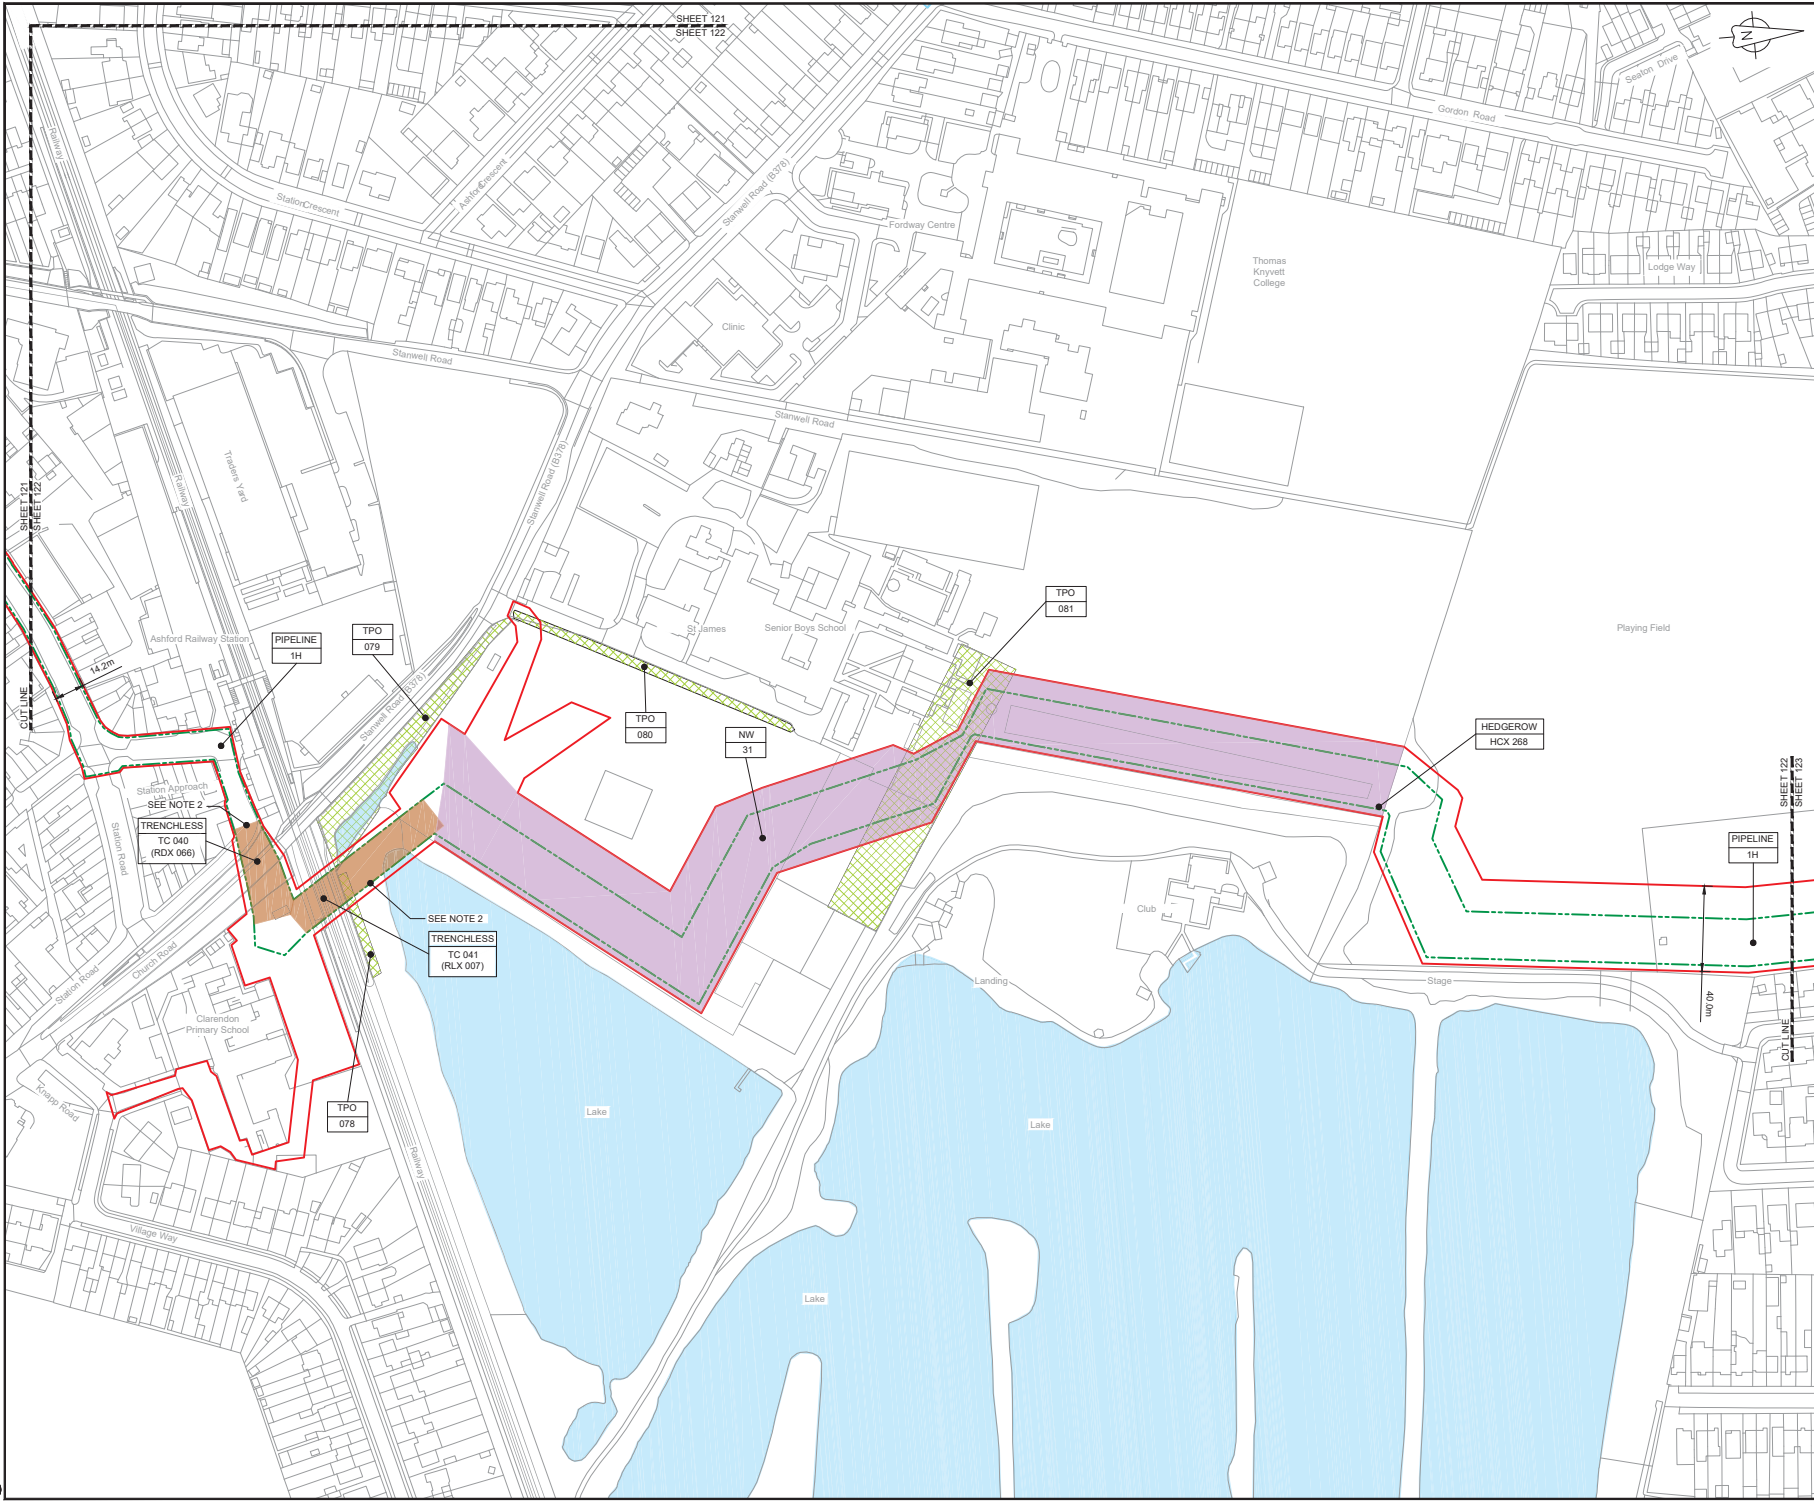

LOCATION PLAN  
SCALE 1:500,000

- NOTES**
1. THIS DRAWING IS IN METRES UNLESS STATED OTHERWISE.
  2. TRENCHLESS CROSSINGS ARE INDICATIVE ONLY.

- LEGEND**
- ORDER LIMITS
  - LIMITS OF DEVIATION
  - NARROW WORKING AREA (NW)
  - TRENCHLESS CROSSING (TC)
  - WATER BODIES
  - ABOVE GROUND INSTALLATION (AGI) / VALVE (VA) / PRESSURE TRANSDUCER (PT)
  - COMPOUND (CO)
  - TREE PRESERVATION ORDER (TPO)
  - DESCRIPTION
  - ID or WORK NUMBER (if applicable)
  - COMMENCEMENT / TERMINATION OF WORKS (COMMENCEMENT = OPEN, TERMINATION = CLOSED)

Contains Ordnance Survey data © Crown copyright and database rights 2019.

© Crown copyright and database rights 2019 OS Licence Number AL100005237.



CD	03/05/19	DDC SUBMISSION	PC	JA	SC	PH
Rev.	Rev. Date	Purpose of revision	Drawn	Checked	Rev'd	Approved

**JACOBS**  
1180 Ewias Road, Winchester, Wokingham, RG41 5TU  
Tel: +44(0)118 946 7000 • Fax: +44(0)118 946 7001  
www.jacobs.com

Client: Esso Petroleum Company, Limited  
Ermyn House,  
Ermyn Way,  
Leatherhead,  
Surrey,  
KT22 8UX

Project: Southampton to London Pipeline Project


Drawing title: **GENERAL ARRANGEMENT SHEET 122 REGULATION 5 (2)(O)**

Drawing status: **Fit for Stage Approval**

Scale	1:1250	DO NOT SCALE
Jacobs No.	B2325300	Rev
Client no.		<b>CO1</b>

Drawing number: **B2325300-JAC-000-CIV-DRG-000622**



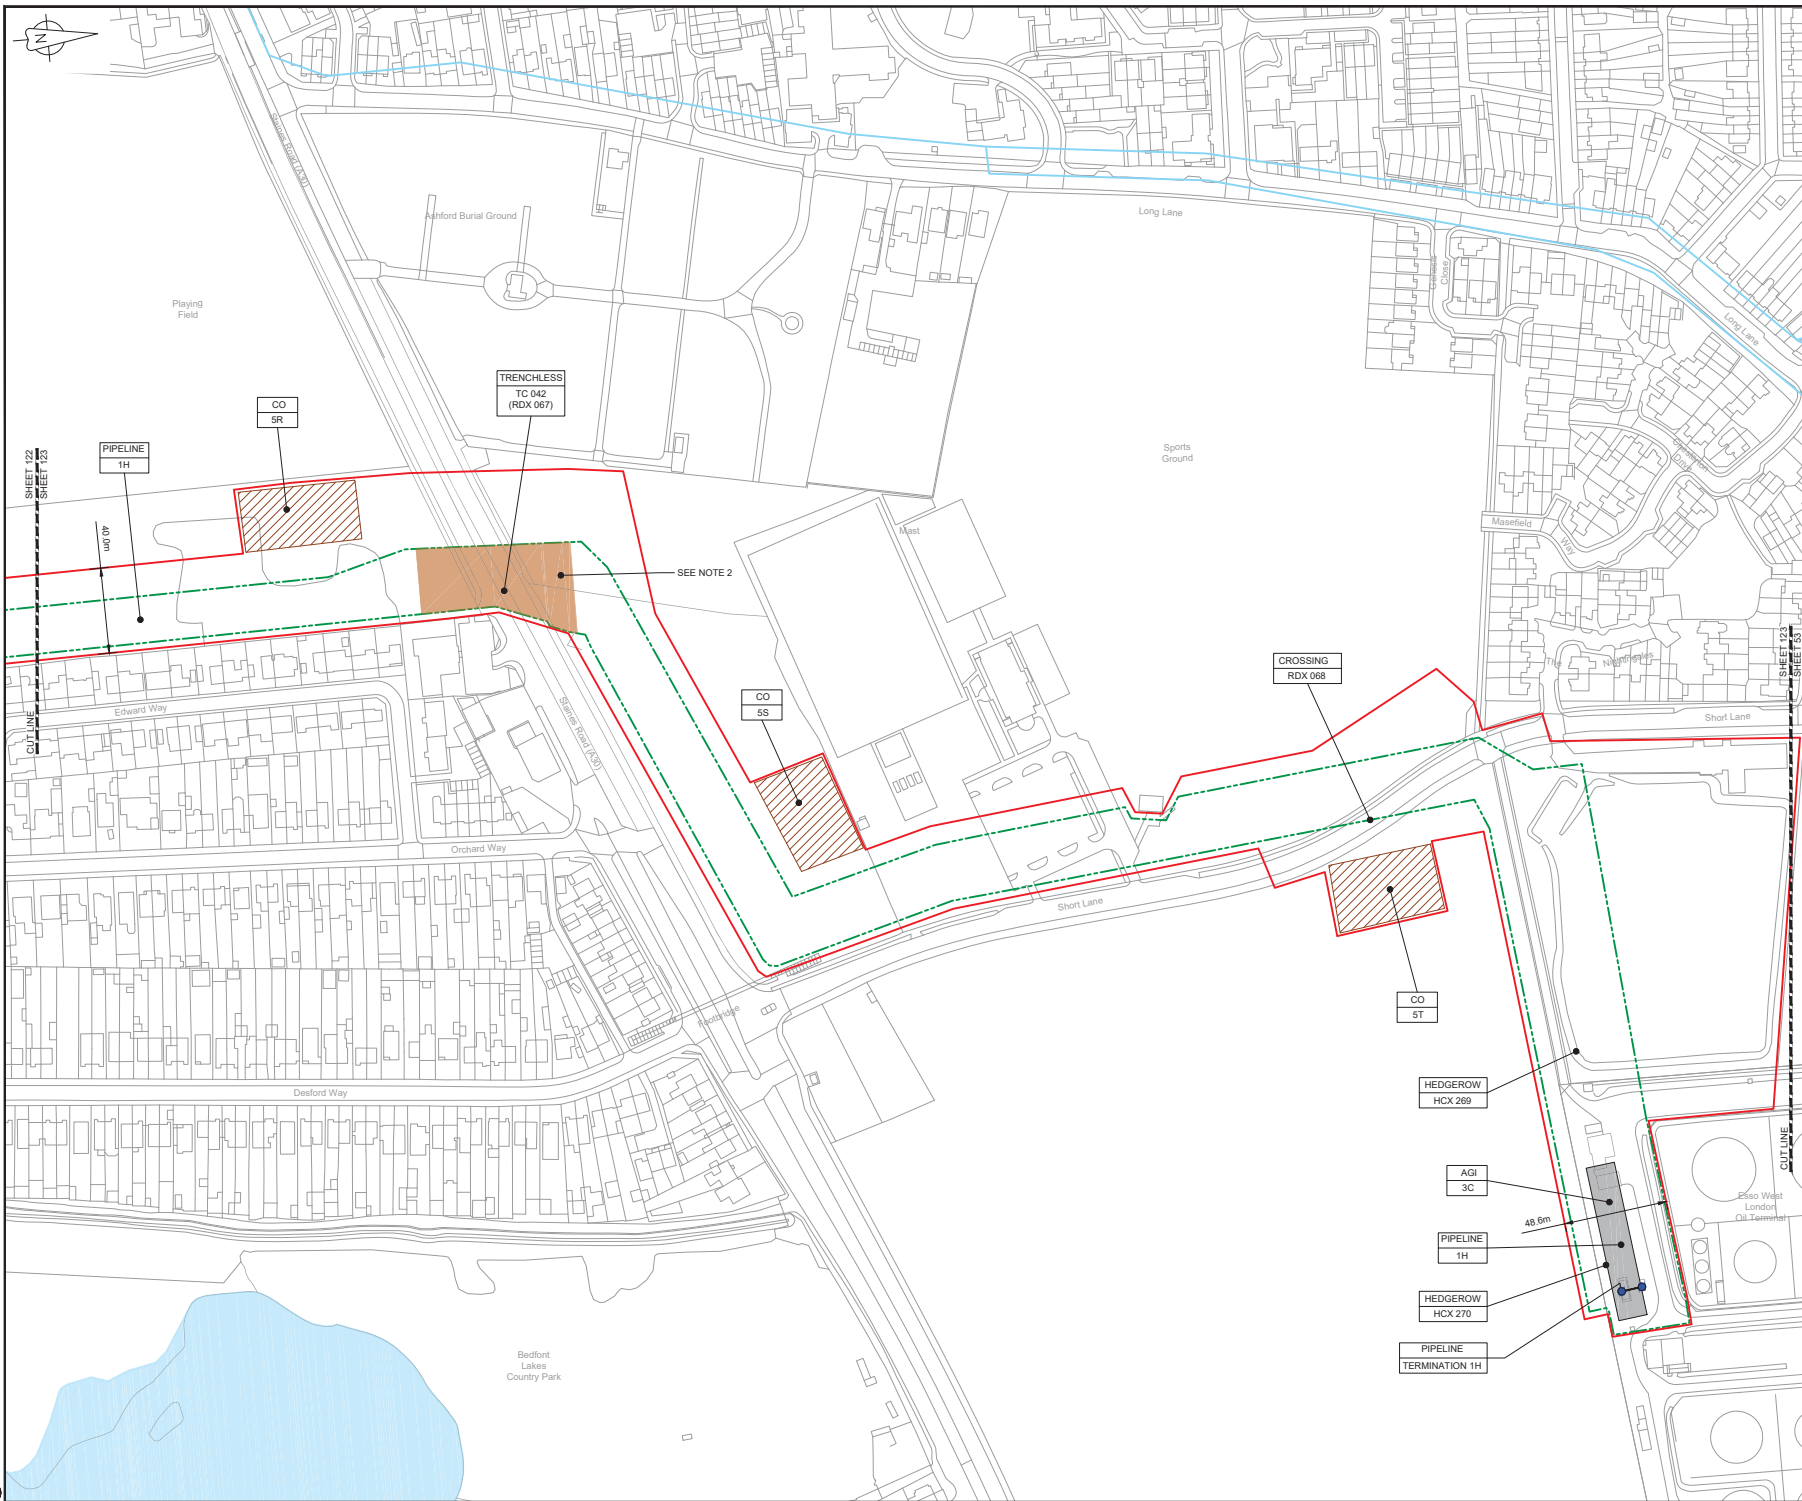

LOCATION PLAN  
SCALE 1:500,000

- NOTES**
1. THIS DRAWING IS IN METRES UNLESS STATED OTHERWISE.
  2. TRENCHLESS CROSSINGS ARE INDICATIVE ONLY.

- LEGEND**
- ORDER LIMITS
  - LIMITS OF DEVIATION
  - NARROW WORKING AREA (NW)
  - TRENCHLESS CROSSING (TC)
  - WATER BODIES
  - ABOVE GROUND INSTALLATION (AGI) / VALVE (VA) / PRESSURE TRANSDUCER (PT)
  - COMPOUND (CO)
  - TREE PRESERVATION ORDER (TPO)
  - DESCRIPTION
  - ID or WORK NUMBER (if applicable)
  - COMMENCEMENT / TERMINATION OF WORKS (COMMENCEMENT = OPEN, TERMINATION = CLOSED)

Contains Ordnance Survey data © Crown copyright and database rights 2019.

© Crown copyright and database rights 2019 OS Licence Number AL10005237.



CD	03/05/19	DDC SUBMISSION	PC	JA	SC	PH
Rev.	Rev. Date	Purpose of revision	Drawn	Checked	Rev'd	Approved

**JACOBS**  
1180 Epsom Road, Wokingham, Wokingham, RG41 5TU  
Tel: +44(0)118 946 7000 • Fax: +44(0)118 946 7001  
www.jacobs.com

Client: Esso Petroleum Company, Limited  
Ermyn House,  
Ermyn Way,  
Leatherhead,  
Surrey,  
KT22 8UX

Project: Southampton to London Pipeline Project

Drawing title:  
**GENERAL ARRANGEMENT SHEET 123**  
**REGULATION 5 (2)(O)**

Drawing status: **Fit for Stage Approval**

Scale	1:1250	DO NOT SCALE
Jacobs No.	B2325300	Rev
Client no.		Rev
Drawing number		<b>C01</b>

B2325300-JAC-000-CIV-DRG-000623

C:\pwworking\jacobs\_uk\_water\_utilities\_sas4\csh\p\ms351188\2325300-JAC-000-CIV-DRG-000623.dwg - 03/05/2019 12:38:02 - A1Frame - CreateP




**NOTES**  
 1. THIS DRAWING IS IN METRES UNLESS STATED OTHERWISE.  
 2. TRENCHLESS CROSSINGS ARE INDICATIVE ONLY.

**LEGEND**

 [Red dashed line]	ORDER LIMITS
[Green dashed line]	LIMITS OF DEVIATION
[Purple hatched area]	NARROW WORKING AREA (NW)
[Brown hatched area]	TRENCHLESS CROSSING (TC)
[Blue area]	WATER BODIES
[Grey hatched area]	ABOVE GROUND INSTALLATION (AGI) / VALVE (VA) / PRESSURE TRANSDUCER (PT)
[Orange hatched area]	COMPOUND (CO)
[Green hatched area]	TREE PRESERVATION ORDER (TPO)
[Line with dots]	DESCRIPTION
[Line with dots]	ID or WORK NUMBER (if applicable)
[Circle with dot]	COMMENCEMENT / TERMINATION OF WORKS (COMMENCEMENT = OPEN, TERMINATION = CLOSED)

Contains Ordnance Survey data © Crown copyright and database rights 2019.  
 © Crown copyright and database rights 2019 OS Licence Number AL100005237.



CD	Rev	Date	Purpose of revision	PC	JA	SC	PH
001	03/05/19		ISSUE FOR SUBMISSION				

**JACOBS**  
 1180 Epsom Road, Winchester, Wokingham, RG41 5TU  
 Tel: +44(0)118 946 7000 • Fax: +44(0)118 946 7001  
 www.jacobs.com

Client: Esso Petroleum Company, Limited  
 Emryn House,  
 Emryn Way,  
 Leatherhead,  
 Surrey,  
 KT22 8UX



Project: **GENERAL ARRANGEMENT SHEET 124 REGULATION 5 (2)(O)**

Drawing title: **GENERAL ARRANGEMENT SHEET 124 REGULATION 5 (2)(O)**

Drawing status: **Fit for Stage Approval**

Scale	1:1250	DO NOT SCALE
Jacobs No.	B2325300	Rev
Client no.		C01

Drawing number: **B2325300-JAC-000-CIV-DRG-000624**



(This page is intentionally left blank)