

Southampton to London Pipeline Project

Volume 2

Works Plans (1 of 3)

Application Document: 2.2


Planning Inspectorate Reference Number: EN070005

APFP Regulation No. 5(2)(j)

Revision No. 2.0

June 2019



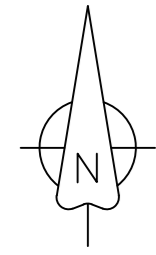

NOTES

1. THIS DRAWING IS IN METRES UNLESS STATED OTHERWISE.
2. THIS DRAWING IS TO BE READ IN CONJUNCTION WITH DRAWING B2325300-JAC-000-CIV-DRG-000002 - WORKS PLANS - KEY PLAN SHEET 2 OF 2 - ALTON TO WEST LONDON TERMINAL.

REFERENCES

B2325300-JAC-000-CIV-DRG-000002 - WORKS PLANS - KEY PLAN SHEET 2 OF 2 - ALTON TO WEST LONDON TERMINAL

PIPELINE WORKS PLANS


- B2325300-JAC-000-CIV-DRG-000011 - WORKS PLAN SHEET 1
- B2325300-JAC-000-CIV-DRG-000012 - WORKS PLAN SHEET 2
- B2325300-JAC-000-CIV-DRG-000013 - WORKS PLAN SHEET 3
- B2325300-JAC-000-CIV-DRG-000014 - WORKS PLAN SHEET 4
- B2325300-JAC-000-CIV-DRG-000015 - WORKS PLAN SHEET 5
- B2325300-JAC-000-CIV-DRG-000016 - WORKS PLAN SHEET 6
- B2325300-JAC-000-CIV-DRG-000017 - WORKS PLAN SHEET 7
- B2325300-JAC-000-CIV-DRG-000018 - WORKS PLAN SHEET 8
- B2325300-JAC-000-CIV-DRG-000019 - WORKS PLAN SHEET 9
- B2325300-JAC-000-CIV-DRG-000020 - WORKS PLAN SHEET 10
- B2325300-JAC-000-CIV-DRG-000021 - WORKS PLAN SHEET 11
- B2325300-JAC-000-CIV-DRG-000022 - WORKS PLAN SHEET 12
- B2325300-JAC-000-CIV-DRG-000023 - WORKS PLAN SHEET 13
- B2325300-JAC-000-CIV-DRG-000024 - WORKS PLAN SHEET 14
- B2325300-JAC-000-CIV-DRG-000025 - WORKS PLAN SHEET 15
- B2325300-JAC-000-CIV-DRG-000026 - WORKS PLAN SHEET 16
- B2325300-JAC-000-CIV-DRG-000027 - WORKS PLAN SHEET 17
- B2325300-JAC-000-CIV-DRG-000028 - WORKS PLAN SHEET 18
- B2325300-JAC-000-CIV-DRG-000029 - WORKS PLAN SHEET 19
- B2325300-JAC-000-CIV-DRG-000030 - WORKS PLAN SHEET 20
- B2325300-JAC-000-CIV-DRG-000031 - WORKS PLAN SHEET 21
- B2325300-JAC-000-CIV-DRG-000032 - WORKS PLAN SHEET 22
- B2325300-JAC-000-CIV-DRG-000033 - WORKS PLAN SHEET 23
- B2325300-JAC-000-CIV-DRG-000064 - WORKS PLAN SHEET 54
- B2325300-JAC-000-CIV-DRG-000065 - WORKS PLAN SHEET 55
- B2325300-JAC-000-CIV-DRG-000069 - WORKS PLAN SHEET 59

LEGEND

ORDER LIMITS

Contains Ordnance Survey data © Crown copyright and database rights 2019.

© Crown copyright and database rights 2019 OS Licence Number AL100005237.

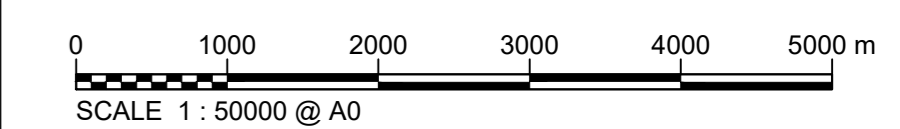

SCALE 1:5000 @ A0

COI	24/04/19	DCP SUBMISSION	BT	JA	ND	PH
CO2	19/06/19	SHEETS 5 AND 109 REVISED FOLLOWING SSI ADVICE	SH	JA	ND	PH
Rev.	Rev. Date	Purpose of revision	Drawn	Checked	Rev'd	Approved

JACOBS
 1180 Epsom Road, Woking, Wokingham, RG41 1TU
 Tel: +44(0)118 946 7000 Fax: +44(0)118 946 7001
 www.jacobs.com

Client: Esso Petroleum Company, Limited
 Esmyn House,
 Esmyn Way,
 Liphinst, Suffolk,
 IP22 8UX

Project: Southampton to London Pipeline Project

Drawing title: **WORKS PLANS - KEY PLAN SHEET 1 OF 2 BOORLEY GREEN TO ALTON REGULATION 5 (2)(J)**

Drawing status: **Fit for Stage Approval**

Scale	1:50000	DO NOT SCALE
Jacobs No.	B2325300	Rev
Client no.		C02

Drawing number: **B2325300-JAC-000-CIV-DRG-000001**

© Crown copyright and database rights 2019 OS Licence Number AL100005237. Jacobs Engineering Group Inc. 1180 Epsom Road, Woking, Surrey, GU24 0DF, UK. Tel: +44(0)118 946 7000. Fax: +44(0)118 946 7001. www.jacobs.com