

Southampton to London Pipeline Project

Volume 2

Works Plans (2 of 3)

Application Document: 2.2



Planning Inspectorate Reference Number: EN070005

APFP Regulation No. 5(2)(j)

Revision No. 2.0

June 2019



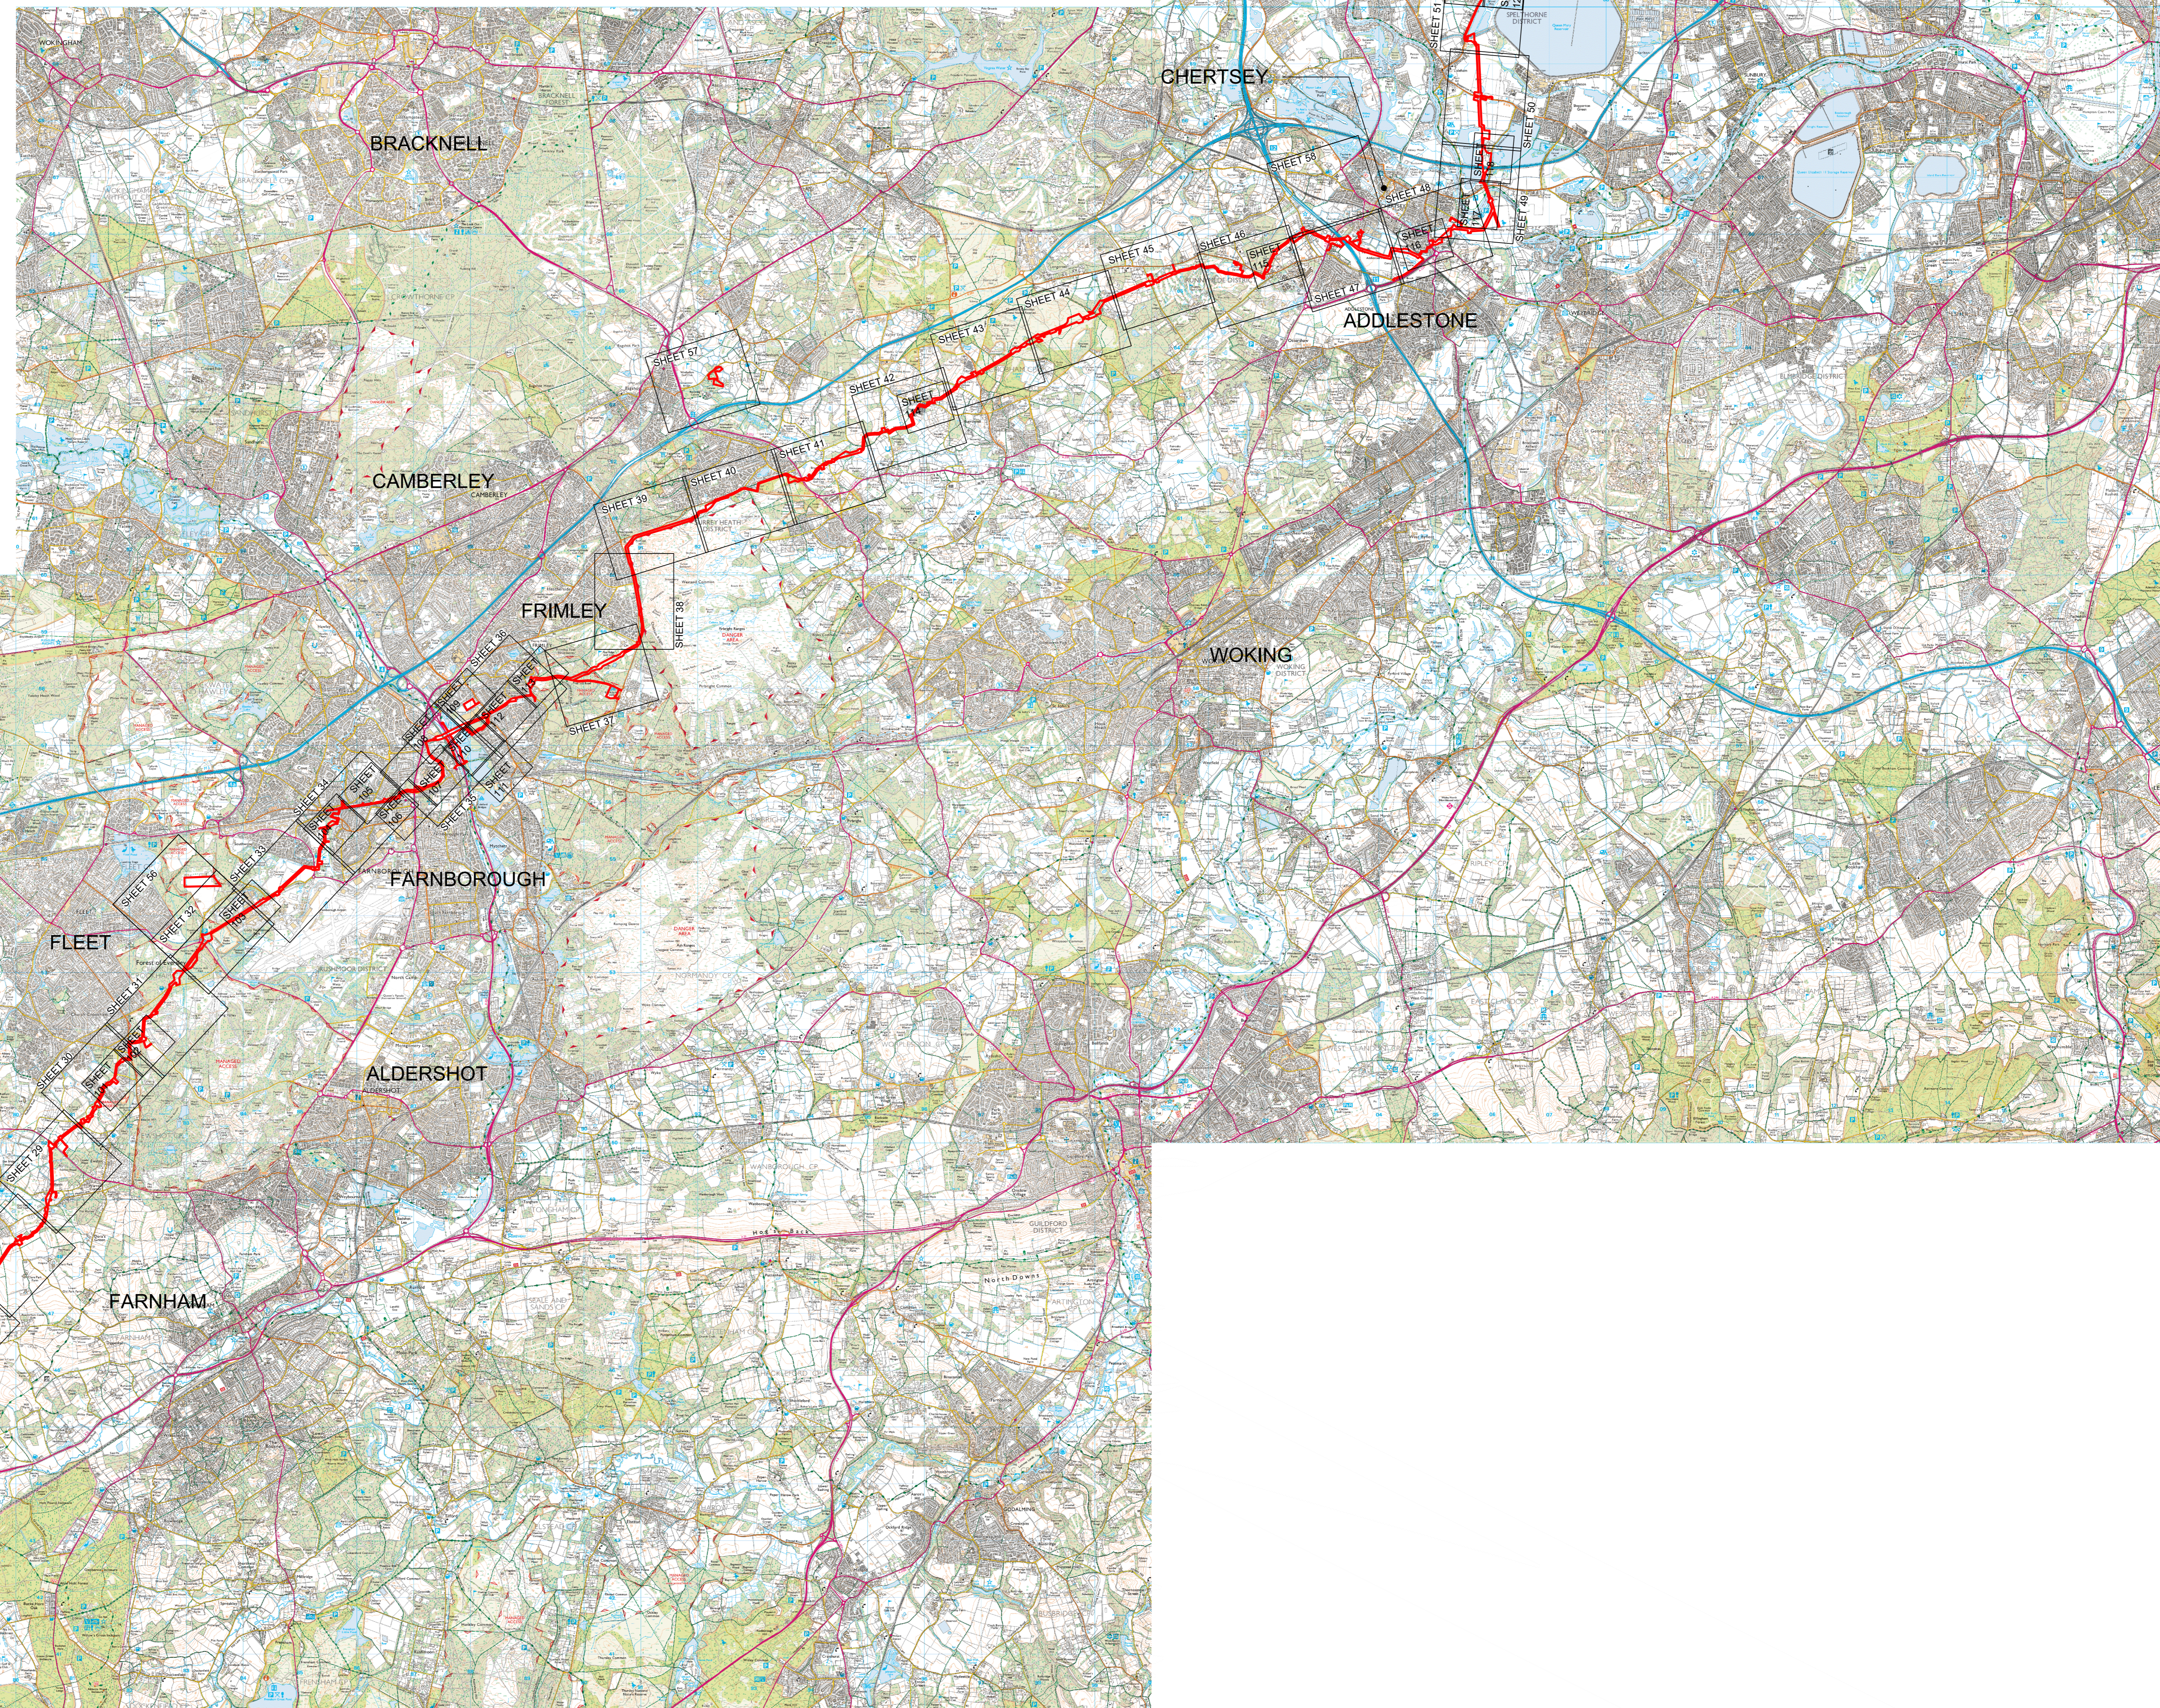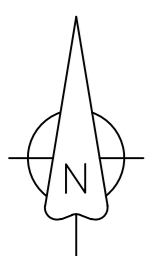


- NOTES**
- THIS DRAWING IS IN METRES UNLESS STATED OTHERWISE.
 - THIS DRAWING IS TO BE READ IN CONJUNCTION WITH DRAWING B2325300-JAC-000-CIV-DRG-000001 - WORKS PLANS - KEY PLAN SHEET 1 OF 2 - BOORLEY GREEN TO ALTON
- REFERENCES**
- B2325300-JAC-000-CIV-DRG-000001 - WORKS PLANS - KEY PLAN SHEET 1 OF 2 - BOORLEY GREEN TO ALTON
- PIPELINE WORKS PLANS**
- B2325300-JAC-000-CIV-DRG-000033 - WORKS PLAN SHEET 23
 - B2325300-JAC-000-CIV-DRG-000034 - WORKS PLAN SHEET 24
 - B2325300-JAC-000-CIV-DRG-000035 - WORKS PLAN SHEET 25
 - B2325300-JAC-000-CIV-DRG-000036 - WORKS PLAN SHEET 26
 - B2325300-JAC-000-CIV-DRG-000037 - WORKS PLAN SHEET 27
 - B2325300-JAC-000-CIV-DRG-000038 - WORKS PLAN SHEET 28
 - B2325300-JAC-000-CIV-DRG-000039 - WORKS PLAN SHEET 29
 - B2325300-JAC-000-CIV-DRG-000040 - WORKS PLAN SHEET 30
 - B2325300-JAC-000-CIV-DRG-000041 - WORKS PLAN SHEET 31
 - B2325300-JAC-000-CIV-DRG-000042 - WORKS PLAN SHEET 32
 - B2325300-JAC-000-CIV-DRG-000043 - WORKS PLAN SHEET 33
 - B2325300-JAC-000-CIV-DRG-000044 - WORKS PLAN SHEET 34
 - B2325300-JAC-000-CIV-DRG-000045 - WORKS PLAN SHEET 35
 - B2325300-JAC-000-CIV-DRG-000046 - WORKS PLAN SHEET 36
 - B2325300-JAC-000-CIV-DRG-000047 - WORKS PLAN SHEET 37
 - B2325300-JAC-000-CIV-DRG-000048 - WORKS PLAN SHEET 38
 - B2325300-JAC-000-CIV-DRG-000049 - WORKS PLAN SHEET 39
 - B2325300-JAC-000-CIV-DRG-000050 - WORKS PLAN SHEET 40
 - B2325300-JAC-000-CIV-DRG-000051 - WORKS PLAN SHEET 41
 - B2325300-JAC-000-CIV-DRG-000052 - WORKS PLAN SHEET 42
 - B2325300-JAC-000-CIV-DRG-000053 - WORKS PLAN SHEET 43
 - B2325300-JAC-000-CIV-DRG-000054 - WORKS PLAN SHEET 44
 - B2325300-JAC-000-CIV-DRG-000055 - WORKS PLAN SHEET 45
 - B2325300-JAC-000-CIV-DRG-000056 - WORKS PLAN SHEET 46
 - B2325300-JAC-000-CIV-DRG-000057 - WORKS PLAN SHEET 47
 - B2325300-JAC-000-CIV-DRG-000058 - WORKS PLAN SHEET 48
 - B2325300-JAC-000-CIV-DRG-000059 - WORKS PLAN SHEET 49
 - B2325300-JAC-000-CIV-DRG-000060 - WORKS PLAN SHEET 50
 - B2325300-JAC-000-CIV-DRG-000061 - WORKS PLAN SHEET 51
 - B2325300-JAC-000-CIV-DRG-000062 - WORKS PLAN SHEET 52
 - B2325300-JAC-000-CIV-DRG-000063 - WORKS PLAN SHEET 53
 - B2325300-JAC-000-CIV-DRG-000066 - WORKS PLAN SHEET 56
 - B2325300-JAC-000-CIV-DRG-000067 - WORKS PLAN SHEET 57
 - B2325300-JAC-000-CIV-DRG-000068 - WORKS PLAN SHEET 58
- B2325300-JAC-000-CIV-DRG-000101 - WORKS PLAN SHEET 101
- B2325300-JAC-000-CIV-DRG-000102 - WORKS PLAN SHEET 102
- B2325300-JAC-000-CIV-DRG-000103 - WORKS PLAN SHEET 103
- B2325300-JAC-000-CIV-DRG-000104 - WORKS PLAN SHEET 104
- B2325300-JAC-000-CIV-DRG-000105 - WORKS PLAN SHEET 105
- B2325300-JAC-000-CIV-DRG-000106 - WORKS PLAN SHEET 106
- B2325300-JAC-000-CIV-DRG-000107 - WORKS PLAN SHEET 107
- B2325300-JAC-000-CIV-DRG-000108 - WORKS PLAN SHEET 108
- B2325300-JAC-000-CIV-DRG-000109 - WORKS PLAN SHEET 109
- B2325300-JAC-000-CIV-DRG-000110 - WORKS PLAN SHEET 110
- B2325300-JAC-000-CIV-DRG-000111 - WORKS PLAN SHEET 111 (NO LONGER NEEDED)
- B2325300-JAC-000-CIV-DRG-000112 - WORKS PLAN SHEET 112
- B2325300-JAC-000-CIV-DRG-000113 - WORKS PLAN SHEET 113
- B2325300-JAC-000-CIV-DRG-000114 - WORKS PLAN SHEET 114
- B2325300-JAC-000-CIV-DRG-000115 - WORKS PLAN SHEET 115
- B2325300-JAC-000-CIV-DRG-000116 - WORKS PLAN SHEET 116
- B2325300-JAC-000-CIV-DRG-000117 - WORKS PLAN SHEET 117
- B2325300-JAC-000-CIV-DRG-000118 - WORKS PLAN SHEET 118
- B2325300-JAC-000-CIV-DRG-000119 - WORKS PLAN SHEET 119
- B2325300-JAC-000-CIV-DRG-000120 - WORKS PLAN SHEET 120
- B2325300-JAC-000-CIV-DRG-000121 - WORKS PLAN SHEET 121
- B2325300-JAC-000-CIV-DRG-000122 - WORKS PLAN SHEET 122
- B2325300-JAC-000-CIV-DRG-000123 - WORKS PLAN SHEET 123
- B2325300-JAC-000-CIV-DRG-000124 - WORKS PLAN SHEET 124

LEGEND

ORDER LIMITS

Contains Ordnance Survey data © Crown copyright and database rights 2019.

© Crown copyright and database rights 2019 OS Licence Number AL100005237.

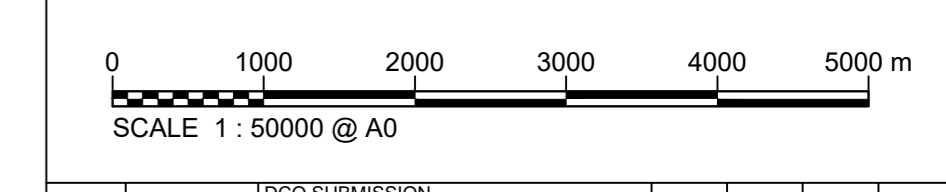

Rev	Rev. Date	Purpose of revision	Drawn	Checked	Rev'd	Apprv'd
C01	24/04/19	DCP SUBMISSION	BT	JA	ND	PH
C02	19/06/19	SHEETS 5 AND 109 REVISED FOLLOWING SSI ADVICE	SM	JA	ND	PH

JACOBS
 1180 Emsley Road, Woking, Wokingham, RG41 1TU
 Tel: +44(0)118 946 7000 Fax: +44(0)118 946 7001
 www.jacobs.com

Client: Esso Petroleum Company, Limited
 Emsley House,
 Emsley Way,
 Leatherhead,
 Surrey,
 KT22 8UX

Project: Southampton to London Pipeline Project

Drawing title: **WORKS PLANS - KEY PLAN SHEET 2 OF 2 - ALTON TO WEST LONDON TERMINAL REGULATION 5 (2)(J)**

Drawing status: **Fit for Stage Approval**

Scale: 1:50000 **DO NOT SCALE**

Jacobs No: B2325300 Rev: **C02**

Client no.:

Drawing number: **B2325300-JAC-000-CIV-DRG-000002**

© Crown copyright and database rights 2019 OS Licence Number AL100005237. Jacobs Engineering Group Inc. 1180 Emsley Road, Woking, Surrey, UK. B2325300-JAC-000-CIV-DRG-000002.dwg - 19/06/2019 11:41:03 - A0/Frame - Michas