

# Southampton to London Pipeline Project

## Volume 2

Works Plans (3 of 3)

Application Document: 2.2

Planning Inspectorate Reference Number: EN070005

APFP Regulation No. 5(2)(j)

Revision No. 3.0

September 2019



(This page is intentionally left blank)



## Contents

B2325300-JAC-000-CIV-DRG-000001 - Works Plans - Key Plan Sheet 1 of 2 Boorley Green To Alton

B2325300-JAC-000-CIV-DRG-000002 - Works Plans - Key Plan Sheet 2 of 2 - Alton To West London Terminal

B2325300-JAC-000-CIV-DRG-000011 - Works Plan Sheet 1

B2325300-JAC-000-CIV-DRG-000012 - Works Plan Sheet 2

B2325300-JAC-000-CIV-DRG-000013 - Works Plan Sheet 3

B2325300-JAC-000-CIV-DRG-000014 - Works Plan Sheet 4

B2325300-JAC-000-CIV-DRG-000015 - Works Plan Sheet 5

B2325300-JAC-000-CIV-DRG-000016 - Works Plan Sheet 6

B2325300-JAC-000-CIV-DRG-000017 - Works Plan Sheet 7

B2325300-JAC-000-CIV-DRG-000018 - Works Plan Sheet 8

B2325300-JAC-000-CIV-DRG-000019 - Works Plan Sheet 9

B2325300-JAC-000-CIV-DRG-000020 - Works Plan Sheet 10

B2325300-JAC-000-CIV-DRG-000021 - Works Plan Sheet 11

B2325300-JAC-000-CIV-DRG-000022 - Works Plan Sheet 12

B2325300-JAC-000-CIV-DRG-000023 - Works Plan Sheet 13

B2325300-JAC-000-CIV-DRG-000024 - Works Plan Sheet 14

B2325300-JAC-000-CIV-DRG-000025 - Works Plan Sheet 15

B2325300-JAC-000-CIV-DRG-000026 - Works Plan Sheet 16

B2325300-JAC-000-CIV-DRG-000027 - Works Plan Sheet 17

B2325300-JAC-000-CIV-DRG-000028 - Works Plan Sheet 18

B2325300-JAC-000-CIV-DRG-000029 - Works Plan Sheet 19

B2325300-JAC-000-CIV-DRG-000030 - Works Plan Sheet 20

B2325300-JAC-000-CIV-DRG-000031 - Works Plan Sheet 21

B2325300-JAC-000-CIV-DRG-000032 - Works Plan Sheet 22

B2325300-JAC-000-CIV-DRG-000033 - Works Plan Sheet 23



- B2325300-JAC-000-CIV-DRG-000034 - Works Plan Sheet 24
- B2325300-JAC-000-CIV-DRG-000035 - Works Plan Sheet 25
- B2325300-JAC-000-CIV-DRG-000036 - Works Plan Sheet 26
- B2325300-JAC-000-CIV-DRG-000037 - Works Plan Sheet 27
- B2325300-JAC-000-CIV-DRG-000038 - Works Plan Sheet 28
- B2325300-JAC-000-CIV-DRG-000039 - Works Plan Sheet 29
- B2325300-JAC-000-CIV-DRG-000040 - Works Plan Sheet 30
- B2325300-JAC-000-CIV-DRG-000041 - Works Plan Sheet 31
- B2325300-JAC-000-CIV-DRG-000042 - Works Plan Sheet 32
- B2325300-JAC-000-CIV-DRG-000043 - Works Plan Sheet 33
- B2325300-JAC-000-CIV-DRG-000044 - Works Plan Sheet 34
- B2325300-JAC-000-CIV-DRG-000045 - Works Plan Sheet 35
- B2325300-JAC-000-CIV-DRG-000046 - Works Plan Sheet 36
- B2325300-JAC-000-CIV-DRG-000047 - Works Plan Sheet 37
- B2325300-JAC-000-CIV-DRG-000048 - Works Plan Sheet 38
- B2325300-JAC-000-CIV-DRG-000049 - Works Plan Sheet 39
- B2325300-JAC-000-CIV-DRG-000050 - Works Plan Sheet 40
- B2325300-JAC-000-CIV-DRG-000051 - Works Plan Sheet 41
- B2325300-JAC-000-CIV-DRG-000052 - Works Plan Sheet 42
- B2325300-JAC-000-CIV-DRG-000053 - Works Plan Sheet 43
- B2325300-JAC-000-CIV-DRG-000054 - Works Plan Sheet 44
- B2325300-JAC-000-CIV-DRG-000055 - Works Plan Sheet 45
- B2325300-JAC-000-CIV-DRG-000056 - Works Plan Sheet 46
- B2325300-JAC-000-CIV-DRG-000057 - Works Plan Sheet 47
- B2325300-JAC-000-CIV-DRG-000058 - Works Plan Sheet 48
- B2325300-JAC-000-CIV-DRG-000059 - Works Plan Sheet 49
- B2325300-JAC-000-CIV-DRG-000060 - Works Plan Sheet 50



- B2325300-JAC-000-CIV-DRG-000061 - Works Plan Sheet 51
- B2325300-JAC-000-CIV-DRG-000062 - Works Plan Sheet 52
- B2325300-JAC-000-CIV-DRG-000063 - Works Plan Sheet 53
- B2325300-JAC-000-CIV-DRG-000064 - Works Plan Sheet 54
- B2325300-JAC-000-CIV-DRG-000065 - Works Plan Sheet 55
- B2325300-JAC-000-CIV-DRG-000066 - Works Plan Sheet 56
- B2325300-JAC-000-CIV-DRG-000067 - Works Plan Sheet 57
- B2325300-JAC-000-CIV-DRG-000068 - Works Plan Sheet 58
- B2325300-JAC-000-CIV-DRG-000069 - Works Plan Sheet 59
- B2325300-JAC-000-CIV-DRG-000101 - Works Plan Sheet 101
- B2325300-JAC-000-CIV-DRG-000102 - Works Plan Sheet 102
- B2325300-JAC-000-CIV-DRG-000103 - Works Plan Sheet 103
- B2325300-JAC-000-CIV-DRG-000104 - Works Plan Sheet 104
- B2325300-JAC-000-CIV-DRG-000105 - Works Plan Sheet 105
- B2325300-JAC-000-CIV-DRG-000106 - Works Plan Sheet 106
- B2325300-JAC-000-CIV-DRG-000107 - Works Plan Sheet 107
- B2325300-JAC-000-CIV-DRG-000108 - Works Plan Sheet 108
- B2325300-JAC-000-CIV-DRG-000109 - Works Plan Sheet 109
- B2325300-JAC-000-CIV-DRG-000110 - Works Plan Sheet 110
- B2325300-JAC-000-CIV-DRG-000111 - Works Plan Sheet 111
- B2325300-JAC-000-CIV-DRG-000112 - Works Plan Sheet 112
- B2325300-JAC-000-CIV-DRG-000113 - Works Plan Sheet 113
- B2325300-JAC-000-CIV-DRG-000114 - Works Plan Sheet 114
- B2325300-JAC-000-CIV-DRG-000115 - Works Plan Sheet 115
- B2325300-JAC-000-CIV-DRG-000116 - Works Plan Sheet 116
- B2325300-JAC-000-CIV-DRG-000117 - Works Plan Sheet 117
- B2325300-JAC-000-CIV-DRG-000118 - Works Plan Sheet 118



B2325300-JAC-000-CIV-DRG-000119 - Works Plan Sheet 119

B2325300-JAC-000-CIV-DRG-000120 - Works Plan Sheet 120


B2325300-JAC-000-CIV-DRG-000121 - Works Plan Sheet 121

B2325300-JAC-000-CIV-DRG-000122 - Works Plan Sheet 122

B2325300-JAC-000-CIV-DRG-000123 - Works Plan Sheet 123

B2325300-JAC-000-CIV-DRG-000124 - Works Plan Sheet 124

(This page is intentionally left blank)

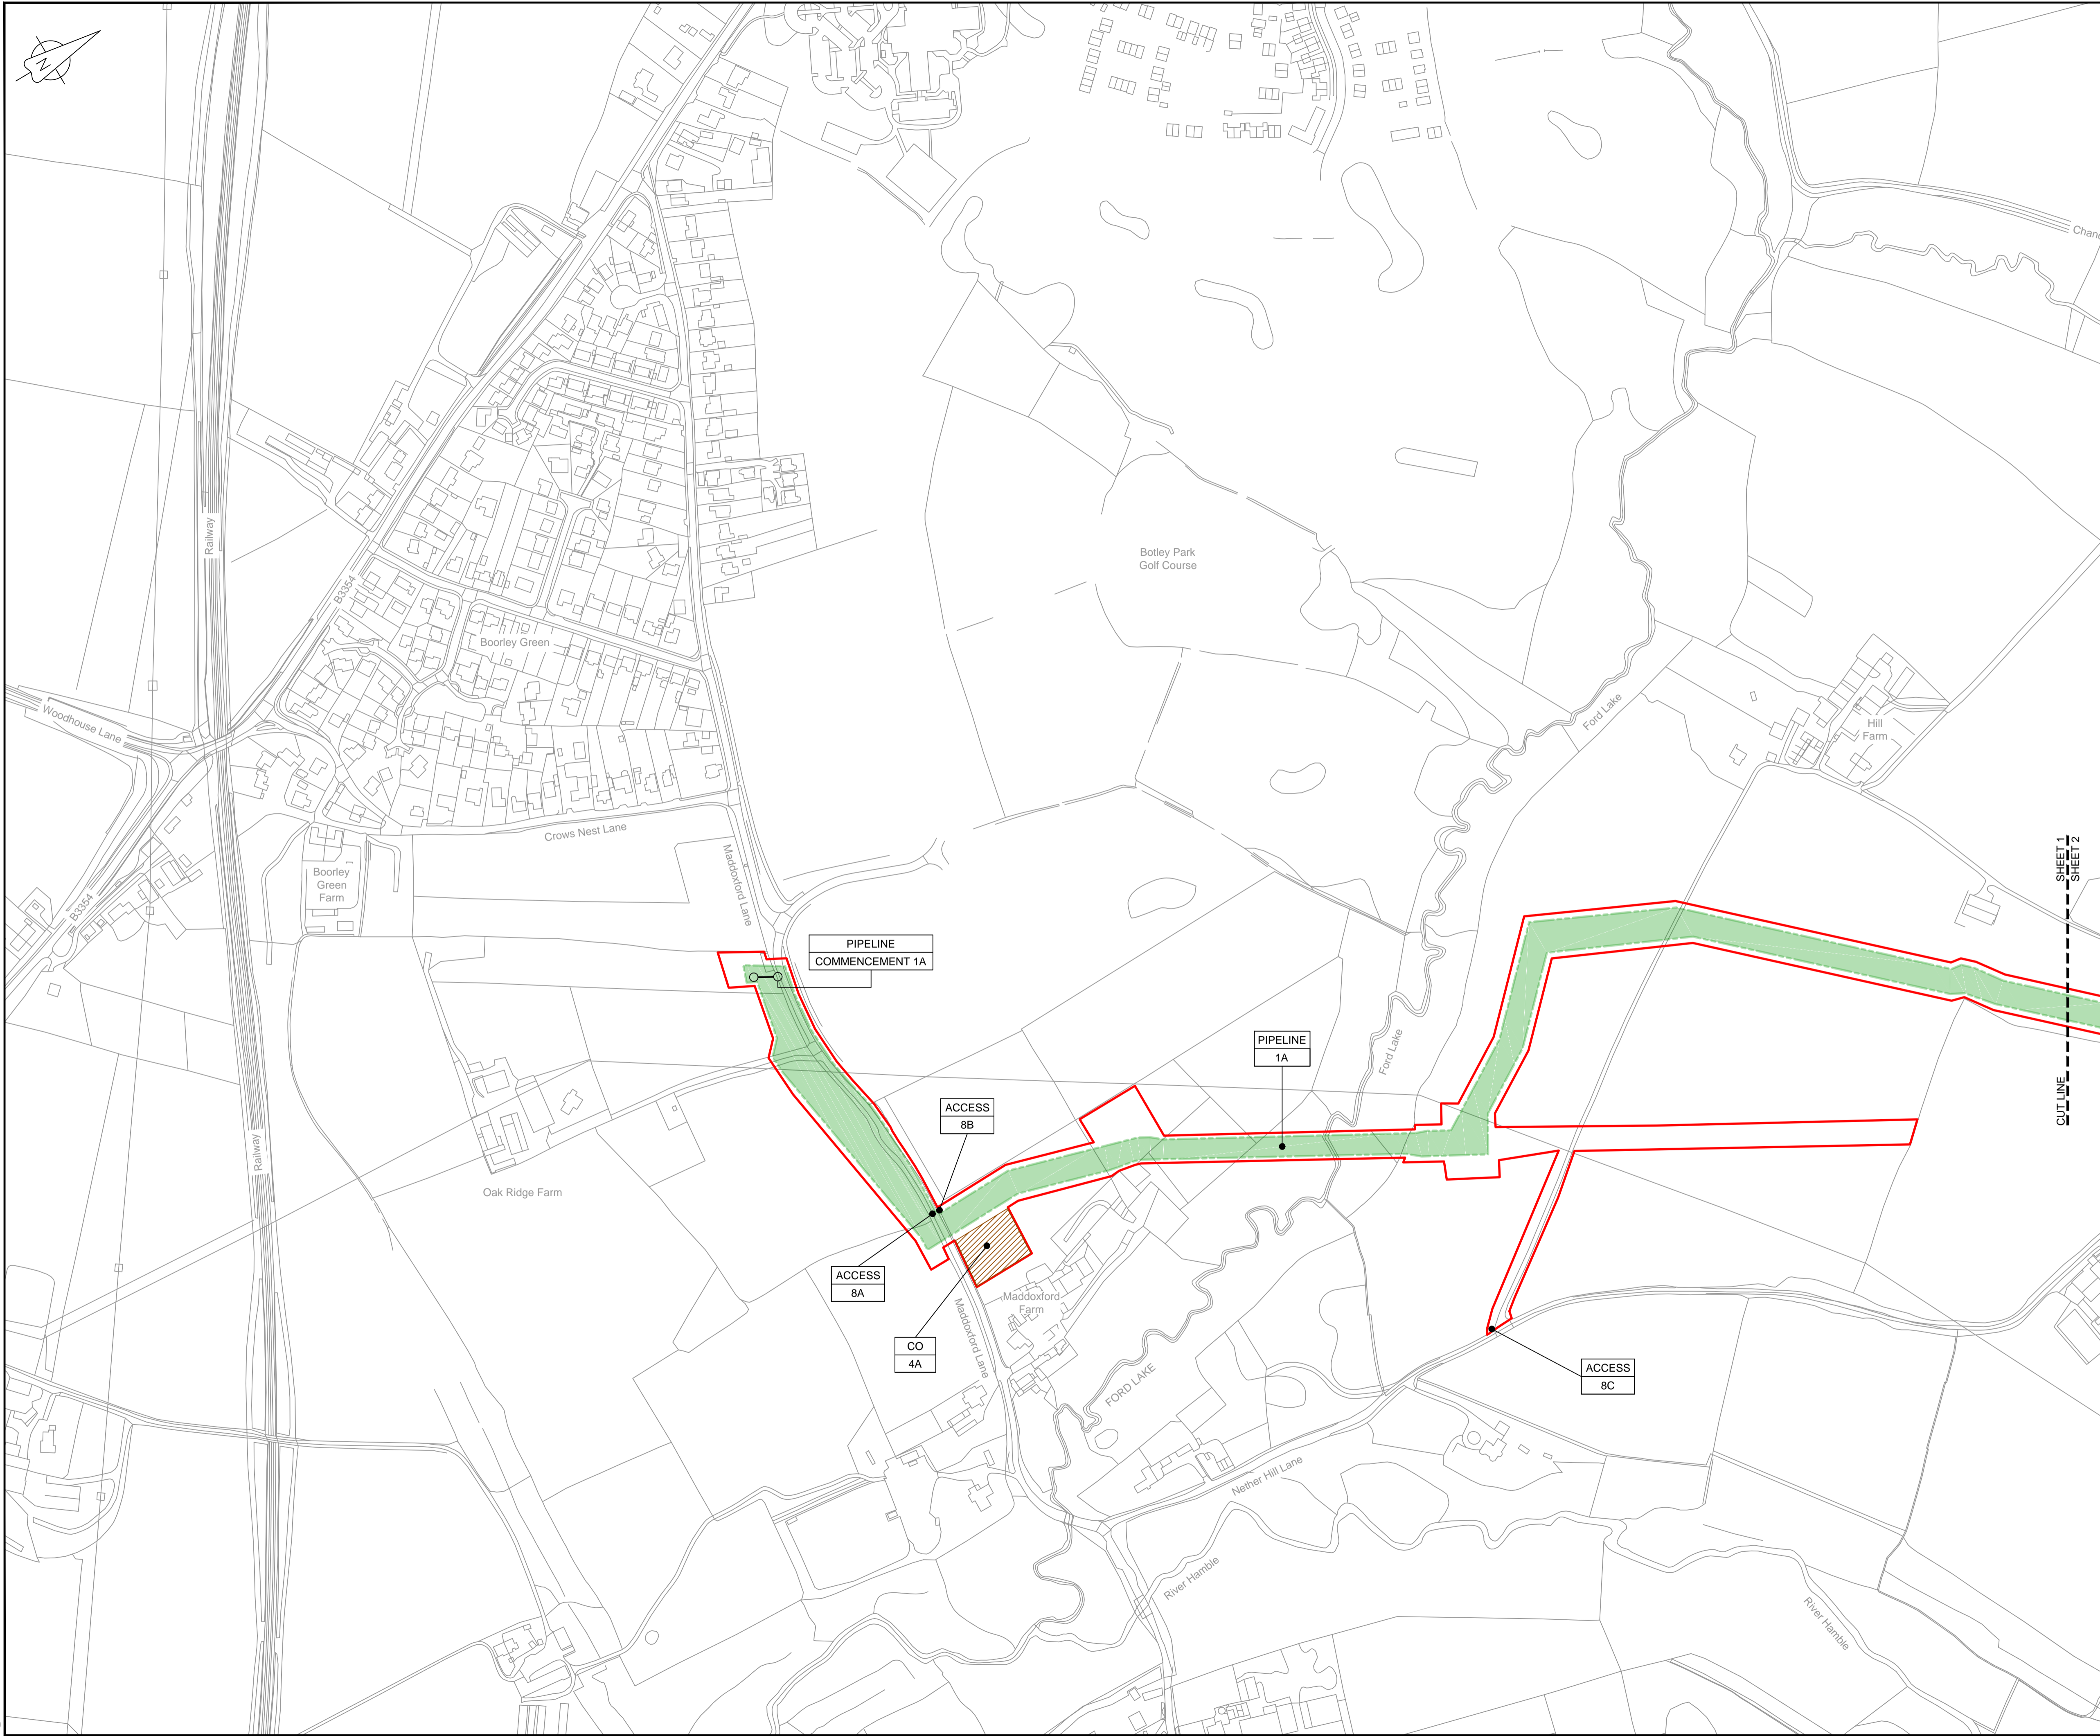

LOCATION PLAN  
SCALE 1:500,000

**NOTES**  
1. THIS DRAWING IS IN METRES UNLESS STATED OTHERWISE.

**LEGEND**

	ORDER LIMITS
	LIMITS OF DEVIATION
	COMPOUND (CO)
	ENVIRONMENTAL MITIGATION AREA (EM)
	ABOVE GROUND INSTALLATION (AGI) / VALVE (VA) / PRESSURE TRANSDUCER (PT)
	DESCRIPTION
	ID or WORK NUMBER (if applicable)
	ACCESS
	TEMPORARY CONSTRUCTION ACCESS
	P-ACCESS
	PERMANENT ACCESS
	COMMENCEMENT / TERMINATION OF WORKS (COMMENCEMENT = OPEN, TERMINATION = CLOSED)

Contains Ordnance Survey data © Crown copyright and database rights 2019.  
© Crown copyright and database rights 2019 OS Licence Number AL10005237.



C02	19/06/19	SHEETS 35 AND 109 REVISED FOLLOWING SSI ADVICE	SH	JA	ND	PH
C03	09/09/19	SHEETS 10, 11 AND 54 REVISED TO WITHDRAW A2b SUB-OPTION	BT	JA	ND	AD
Rev	Rev. Date	Purpose of revision	Drawn	Checked	Rev'd	Appr'd

**JACOBS**  
1180 Eskdale Road, Wokingham, Wokingham, RG41 5TU  
Tel:+44(0)118 946 7000 Fax:+44(0)118 946 7001  
www.jacobs.com

Client: Esso Petroleum Company, Limited  
Emryn House,  
Emryn Way,  
Leatherhead,  
Surrey,  
KT22 8UX

Project: Southampton to London Pipeline Project

Drawing title: **WORKS PLAN  
SHEET 1  
REGULATION 5 (2)(J)**


Drawing status: **Fit for Stage Approval**

Scale: 1:2500 DO NOT SCALE  
Jacobs No. B2325300 Rev  
Client no. C03

Drawing number: **B2325300-JAC-000-CIV-DRG-000011**

© Copyright 2019 Jacobs U.K. Limited. The concepts and information contained in this document are the property of Jacobs. Use or copying of this document in whole or in part without the written permission of Jacobs constitutes an infringement of copyright. Limitation: This drawing has been prepared on behalf of, and for the exclusive use of, the Client, and is subject to, and issued in accordance with, the provisions of the contract between Jacobs and the Client. Jacobs accepts no liability or responsibility whatsoever for, or in respect of, any use of, or reliance upon, this drawing by any third party.



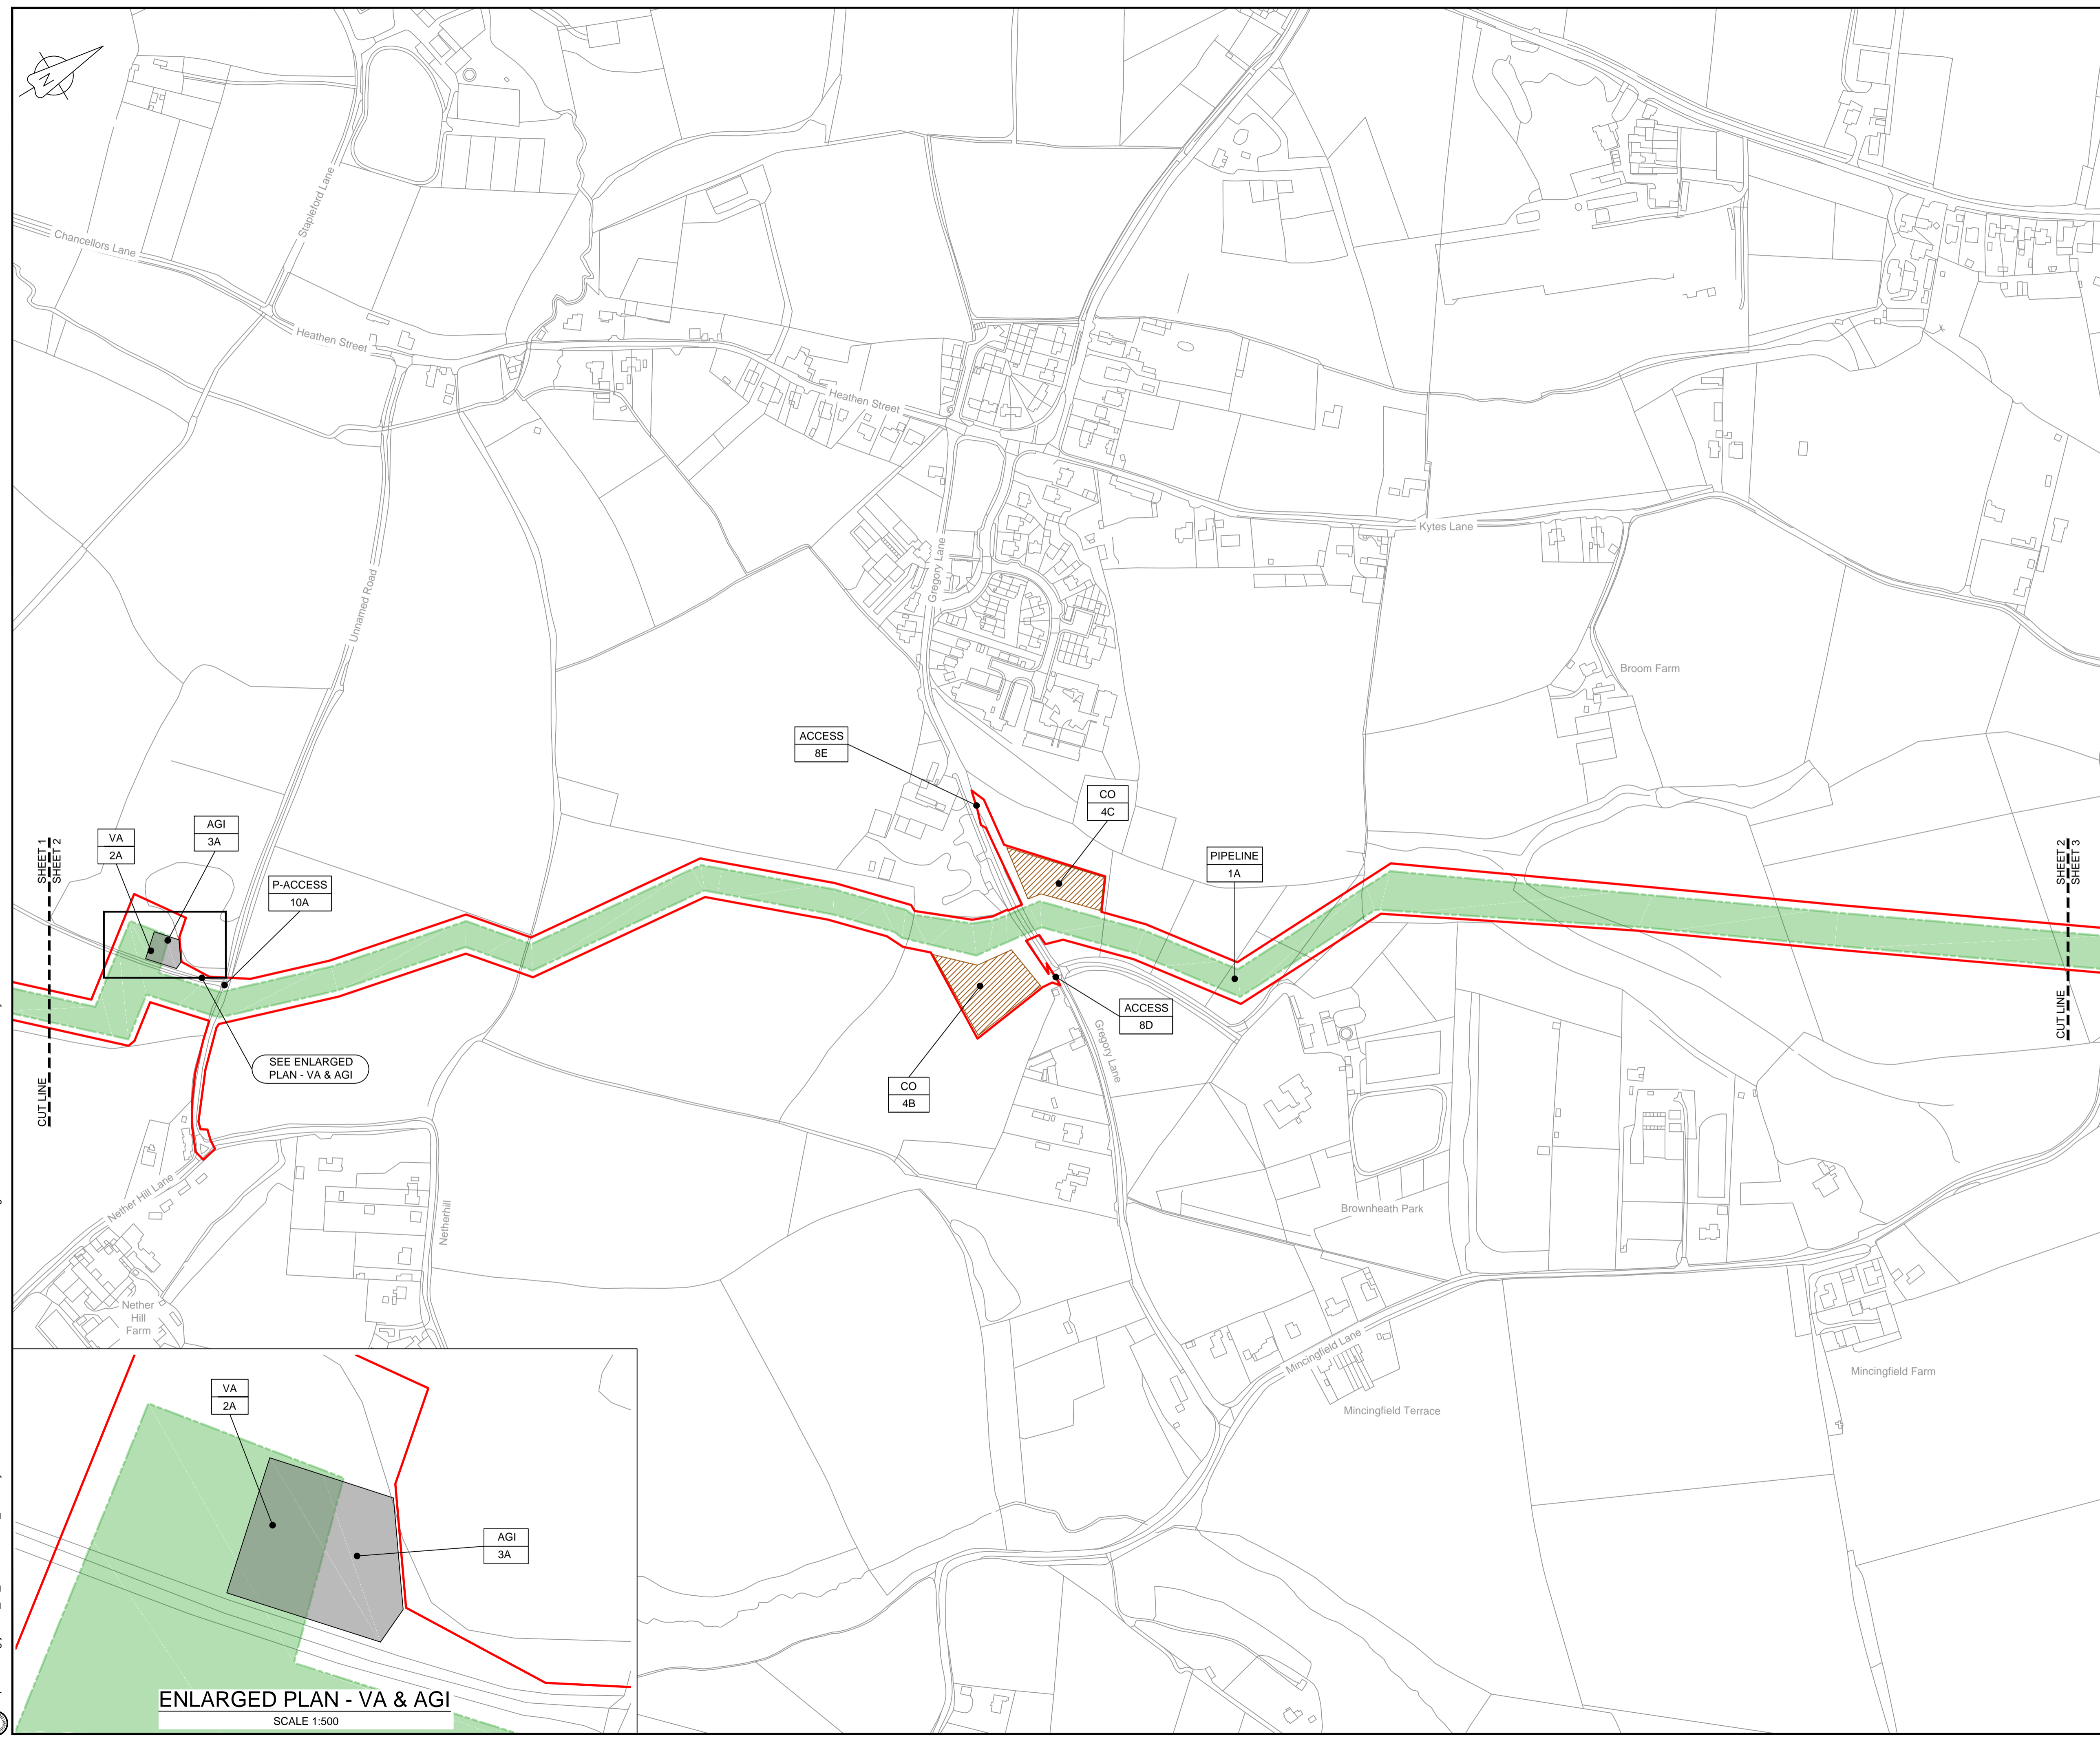

LOCATION PLAN  
SCALE 1:500,000

**NOTES**  
1. THIS DRAWING IS IN METRES UNLESS STATED OTHERWISE.

**LEGEND**

	ORDER LIMITS
	LIMITS OF DEVIATION
	COMPOUND (CO)
	ENVIRONMENTAL MITIGATION AREA (EM)
	ABOVE GROUND INSTALLATION (AGI) / VALVE (VA) / PRESSURE TRANSDUCER (PT)
	DESCRIPTION
	ID or WORK NUMBER (if applicable)
	ACCESS TEMPORARY CONSTRUCTION ACCESS
	P-ACCESS PERMANENT ACCESS
	COMMENCEMENT / TERMINATION OF WORKS (COMMENCEMENT = OPEN, TERMINATION = CLOSED)

Contains Ordnance Survey data © Crown copyright and database rights 2019.  
© Crown copyright and database rights 2019 OS Licence Number AL100005237.



C02	19/06/19	SHEETS 36 AND 109 REVISED FOLLOWING SSI ADVICE	SH	JA	ND	PH
C03	09/09/19	SHEETS 10, 11 AND 54 REVISED TO WITHDRAW A2b SUB-OPTION	BT	JA	ND	AD
Rev	Rev. Date	Purpose of revision	Drawn	Checked	Rev'd	Appr'd

**JACOBS**

1180 Eskdale Road, Wokingham, Wokingham, RG41 5TU  
Tel: +44(0)118 946 7000 Fax: +44(0)118 946 7001  
www.jacobs.com

Client: Esso Petroleum Company, Limited  
Emryn House,  
Emryn Way,  
Leatherhead,  
Surrey,  
KT22 8UX

Project: Southampton to London Pipeline Project

Drawing title: **WORKS PLAN SHEET 2 REGULATION 5 (2)(J)**


Drawing status: **Fit for Stage Approval**

Scale	1:2500	DO NOT SCALE
Jacobs No.	B2325300	Rev
Client no.		<b>C03</b>


Drawing number: **B2325300-JAC-000-CIV-DRG-000012**

© Copyright 2019 Jacobs U.K. Limited. The concepts and information contained in this document are the property of Jacobs. Use or copying of this document in whole or in part without the written permission of Jacobs constitutes an infringement of copyright. Limitation. This drawing has been prepared on behalf of and for the exclusive use of Jacobs' Client, and is subject to, and issued in accordance with, the provisions of the contract between Jacobs and the Client. Jacobs accepts no liability or responsibility whatsoever for, or in respect of, any use of, or reliance upon, this drawing by any third party.

C:\pwworking\jacobs\_uk\_water&utilities\_ssf\lba\london\33519\B2325300-JAC-000-CIV-DRG-000012.dwg - 10/09/2019 10:44:03 - A1Frame - BTaylor

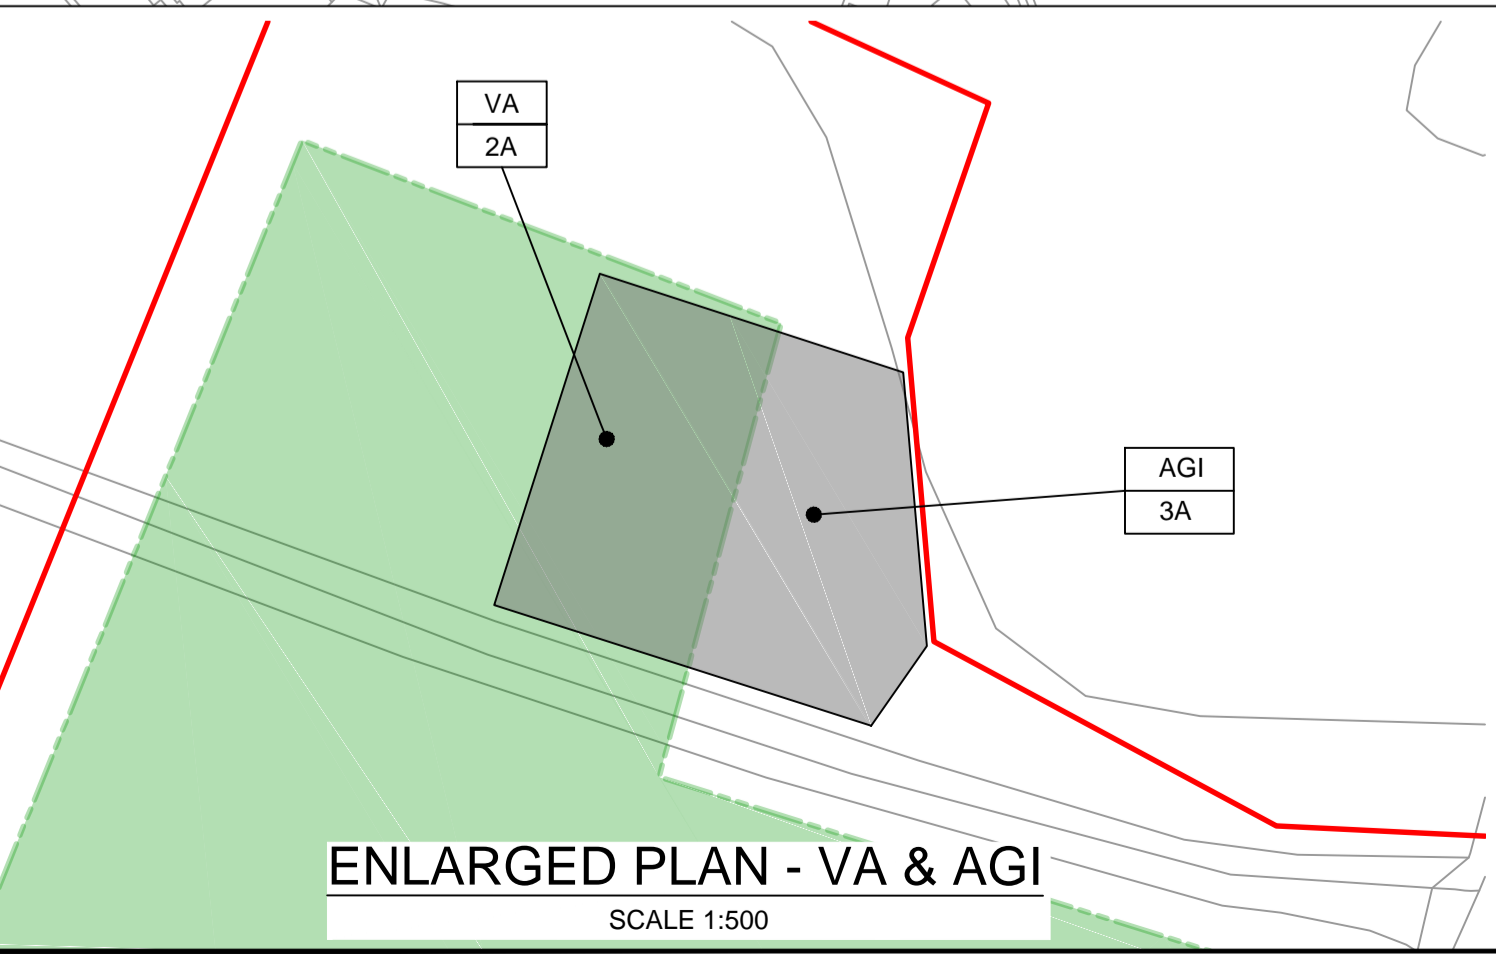

ENLARGED PLAN - VA & AGI  
SCALE 1:500

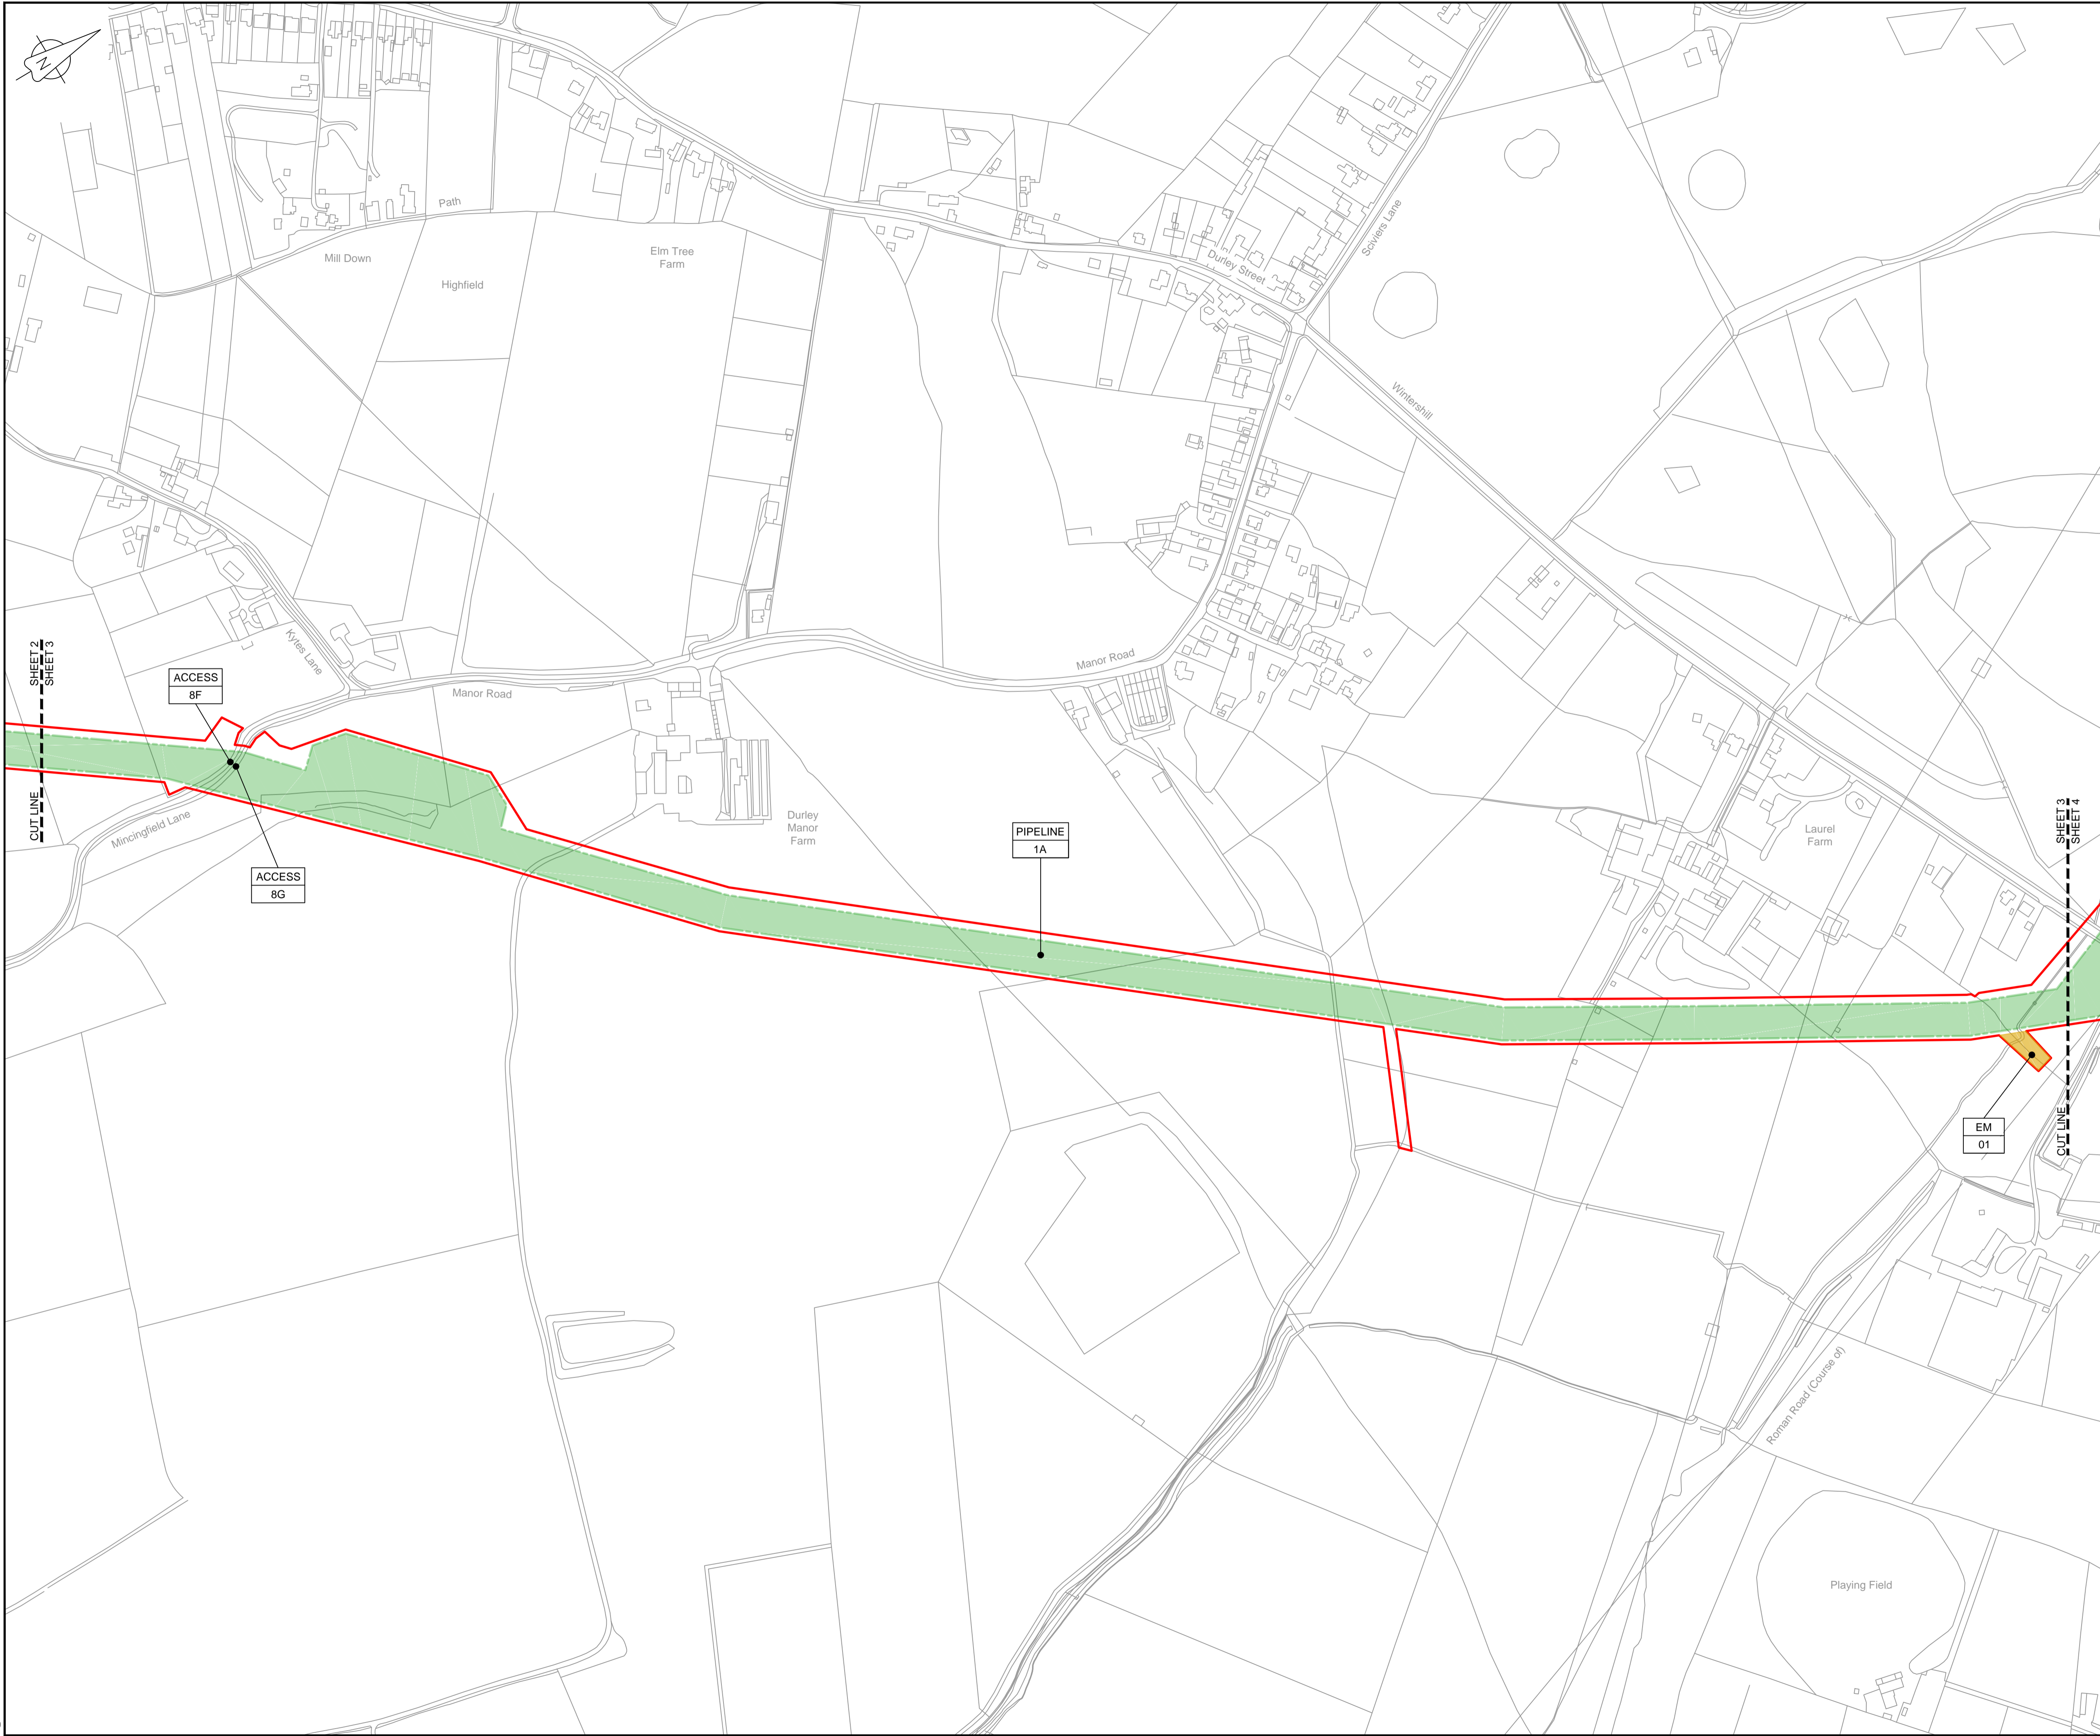

LOCATION PLAN  
SCALE 1:500,000

NOTES  
1. THIS DRAWING IS IN METRES UNLESS STATED OTHERWISE.

- LEGEND
- ORDER LIMITS
  - LIMITS OF DEVIATION
  - COMPOUND (CO)
  - ENVIRONMENTAL MITIGATION AREA (EM)
  - ABOVE GROUND INSTALLATION (AGI) / VALVE (VA) / PRESSURE TRANSDUCER (PT)
  - DESCRIPTION
  - ID or WORK NUMBER (if applicable)
  - ACCESS TEMPORARY CONSTRUCTION ACCESS
  - P-ACCESS PERMANENT ACCESS
  - COMMENCEMENT / TERMINATION OF WORKS (COMMENCEMENT = OPEN, TERMINATION = CLOSED)

Contains Ordnance Survey data © Crown copyright and database rights 2019.  
© Crown copyright and database rights 2019 OS Licence Number AL100005237.



Rev	Rev. Date	Purpose of revision	Drawn	Checked	Rev'd	Appr'd
C02	19/06/19	SHEETS 35 AND 109 REVISED FOLLOWING SSI ADVICE	SH	JA	ND	PH
C03	09/09/19	SHEETS 10, 11 AND 54 REVISED TO WITHDRAW A2B SUB-OPTION	BT	JA	ND	AD

**JACOBS**

1180 Eskdale Road, Winnersh, Wokingham, RG41 5TU  
Tel: +44(0)118 946 7000 Fax: +44(0)118 946 7001  
www.jacobs.com

Client: Esso Petroleum Company, Limited  
Emryn House,  
Emryn Way,  
Leatherhead,  
Surrey,  
KT22 8UX

Project: Southampton to London Pipeline Project


Drawing title: **WORKS PLAN  
SHEET 3  
REGULATION 5 (2)(J)**

Drawing status: **Fit for Stage Approval**

Scale	1:2500	DO NOT SCALE
Jacobs No.	B2325300	Rev
Client no.		<b>C03</b>

Drawing number: **B2325300-JAC-000-CIV-DRG-000013**

© Copyright 2019 Jacobs U.K. Limited. The concepts and information contained in this document are the property of Jacobs. Use or copying of this document in whole or in part without the written permission of Jacobs constitutes an infringement of copyright. Limitation: This drawing has been prepared on behalf of, and for the exclusive use of, the Client. Jacobs accepts no liability or responsibility whatsoever for, or in respect of, any use of, or reliance upon, this drawing by any third party.

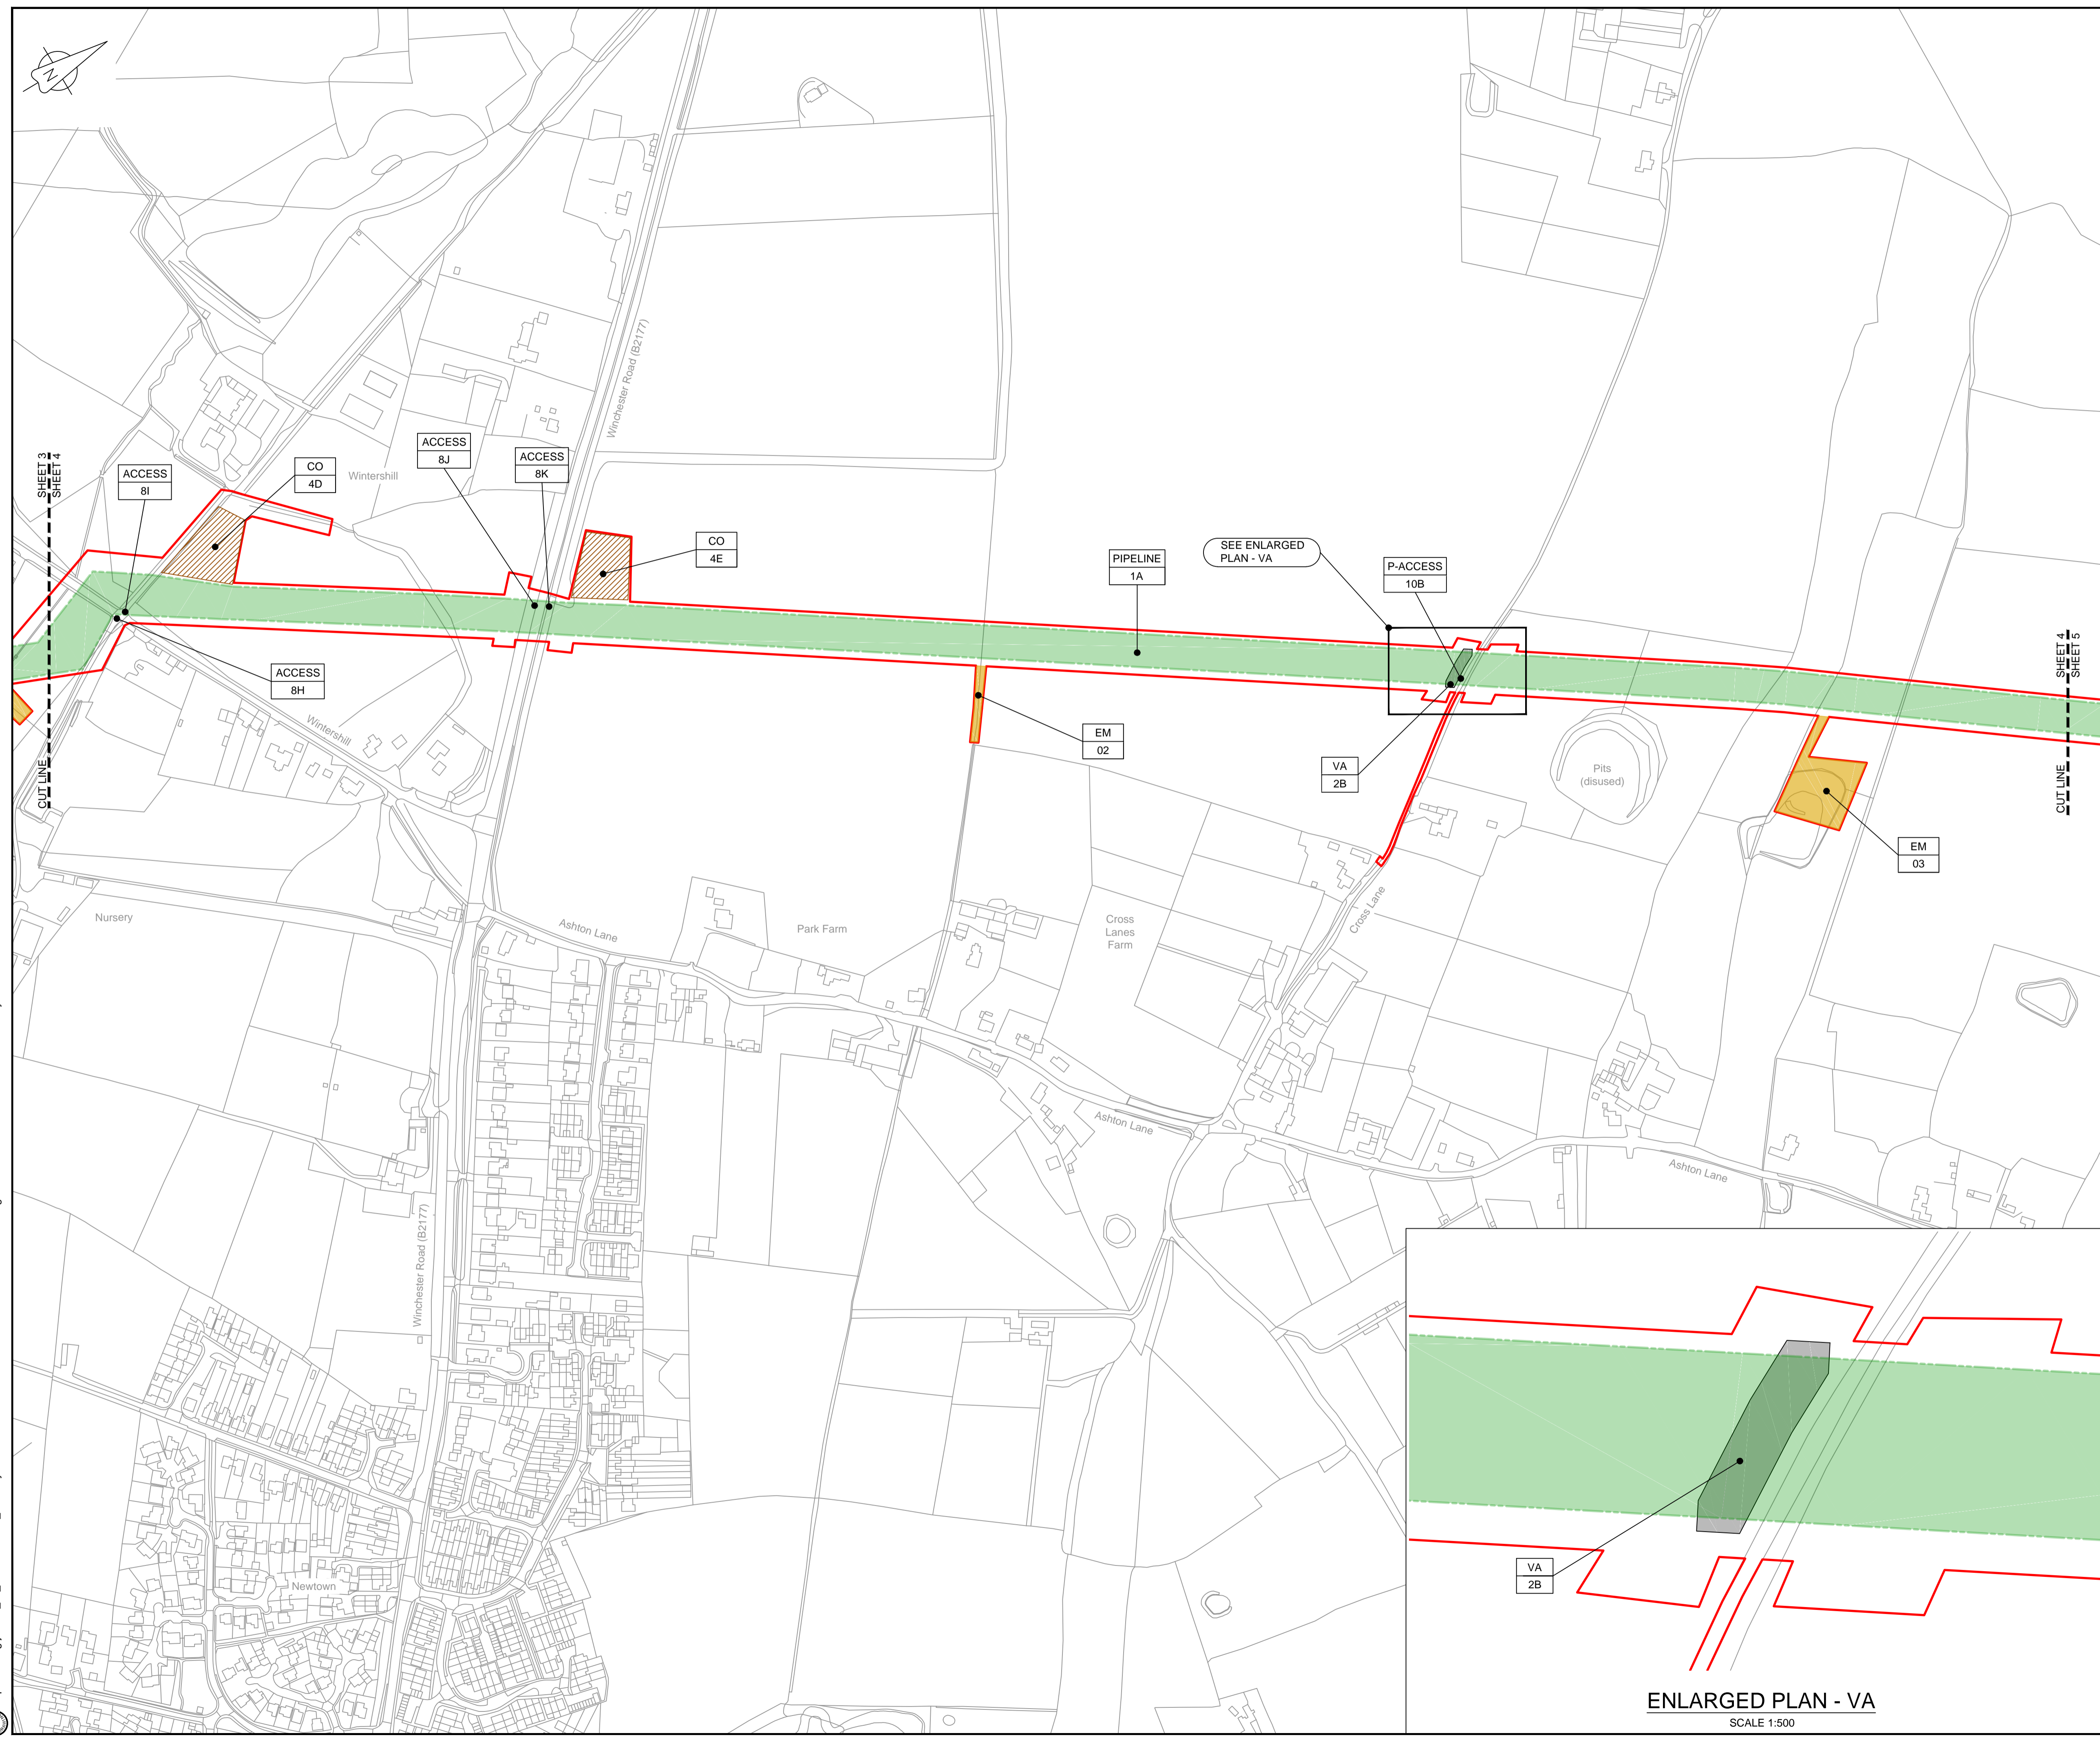

**LOCATION PLAN**  
SCALE 1:500,000

**NOTES**  
1. THIS DRAWING IS IN METRES UNLESS STATED OTHERWISE.

**LEGEND**

	ORDER LIMITS
	LIMITS OF DEVIATION
	COMPOUND (CO)
	ENVIRONMENTAL MITIGATION AREA (EM)
	ABOVE GROUND INSTALLATION (AGI) / VALVE (VA) / PRESSURE TRANSDUCER (PT)
	DESCRIPTION
	ID or WORK NUMBER (if applicable)
	ACCESS TEMPORARY CONSTRUCTION ACCESS
	P-ACCESS PERMANENT ACCESS
	COMMENCEMENT / TERMINATION OF WORKS (COMMENCEMENT = OPEN, TERMINATION = CLOSED)

Contains Ordnance Survey data © Crown copyright and database rights 2019.  
© Crown copyright and database rights 2019 OS Licence Number AL100005237.



Rev	Rev. Date	Purpose of revision	Drawn	Checked	Rev'd	Appr'd
C02	19/06/19	SHEETS 36 AND 109 REVISED FOLLOWING SSI ADVICE	SH	JA	ND	PH
C03	09/09/19	SHEETS 10, 11 AND 54 REVISED TO WITHDRAW A2b SUB-OPTION	BT	JA	ND	AD

**JACOBS**  
1180 Eskdale Road, Wokingham, Wokingham, RG41 5TU  
Tel: +44(0)118 946 7000 Fax: +44(0)118 946 7001  
www.jacobs.com

Client: Esso Petroleum Company, Limited  
Emryn House,  
Leatherhead,  
Surrey,  
KT22 8UX


Project: Southampton to London Pipeline Project

Drawing title: **WORKS PLAN SHEET 4 REGULATION 5 (2)(J)**

Drawing status: **Fit for Stage Approval**

Scale	1:2500	DO NOT SCALE
Jacobs No.	B2325300	Rev
Client no.		<b>C03</b>

Drawing number: **B2325300-JAC-000-CIV-DRG-000014**

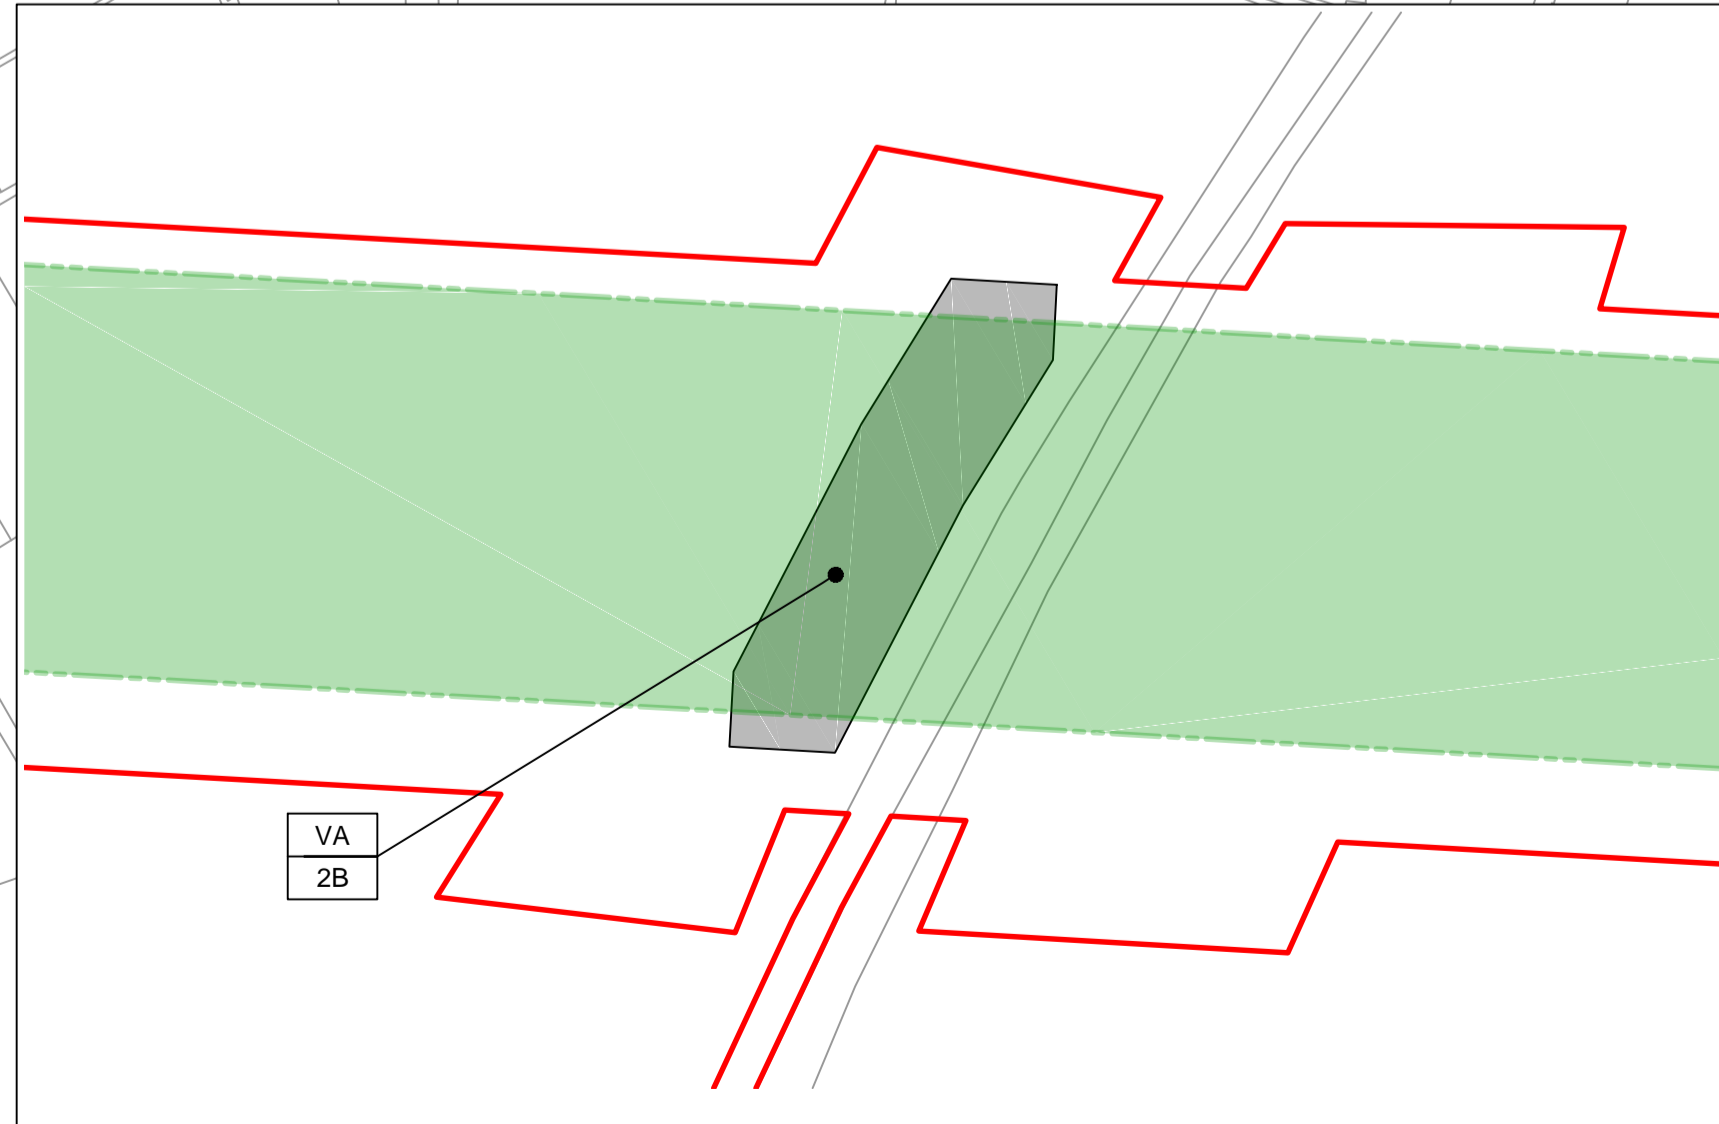

**ENLARGED PLAN - VA**  
SCALE 1:500

C:\pwworking\jacobs\_uk\_water&utilities\_ssf\by\ordms33513\B2325300-JAC-000-CIV-DRG-000014.dwg - 10/09/2019 10:47:09 - A1Frame - BTaylor



**LOCATION PLAN**  
SCALE 1:500,000

**NOTES**  
1. THIS DRAWING IS IN METRES UNLESS STATED OTHERWISE.

**LEGEND**

	ORDER LIMITS
	LIMITS OF DEVIATION
	COMPOUND (CO)
	ENVIRONMENTAL MITIGATION AREA (EM)
	ABOVE GROUND INSTALLATION (AGI) / VALVE (VA) / PRESSURE TRANSDUCER (PT)
	DESCRIPTION
	ID or WORK NUMBER (if applicable)
	ACCESS
	TEMPORARY CONSTRUCTION ACCESS
	PERMANENT ACCESS
	COMMENCEMENT / TERMINATION OF WORKS (COMMENCEMENT = OPEN, TERMINATION = CLOSED)

Contains Ordnance Survey data © Crown copyright and database rights 2019.  
© Crown copyright and database rights 2019 OS Licence Number AL100005237.



Rev	Rev. Date	Purpose of revision	Drawn	Checked	Rev'd	Appr'd
C02	19/06/19	SHEETS 36 AND 109 REVISED FOLLOWING SSI ADVICE	SH	JA	ND	PH
C03	09/09/19	SHEETS 10, 11 AND 54 REVISED TO WITHDRAW A2b SUB-OPTION	BT	JA	ND	AD



1180 Eskdale Road, Winnersh, Wokingham, RG41 5TU  
Tel:+44(0)118 946 7000 Fax:+44(0)118 946 7001  
www.jacobs.com

Client: Esso Petroleum Company, Limited  
Emryn House,  
Emryn Way,  
Leatherhead,  
Surrey,  
KT22 8UX



Drawing title: **WORKS PLAN SHEET 5 REGULATION 5 (2)(J)**


Drawing status: **Fit for Stage Approval**

Scale	1:2500	DO NOT SCALE
Jacobs No.	B2325300	Rev
Client no.		<b>C03</b>

Drawing number: **B2325300-JAC-000-CIV-DRG-000015**

© Copyright 2019 Jacobs U.K. Limited. The concepts and information contained in this document are the property of Jacobs. Use or copying of this document in whole or in part without the written permission of Jacobs constitutes an infringement of copyright. Limitation. This drawing has been prepared on behalf of, and for the exclusive use of, the Client. Jacobs accepts no liability or responsibility whatsoever for, or in respect of, any use of, or reliance upon, this drawing by any third party.

C:\pwworking\jacobs\_uk\_water&utilities\_ssf\byondms335131B2325300-JAC-000-CIV-DRG-000015.dwg - 10/09/2019 10:49:06 - A1Frame - BTaylor

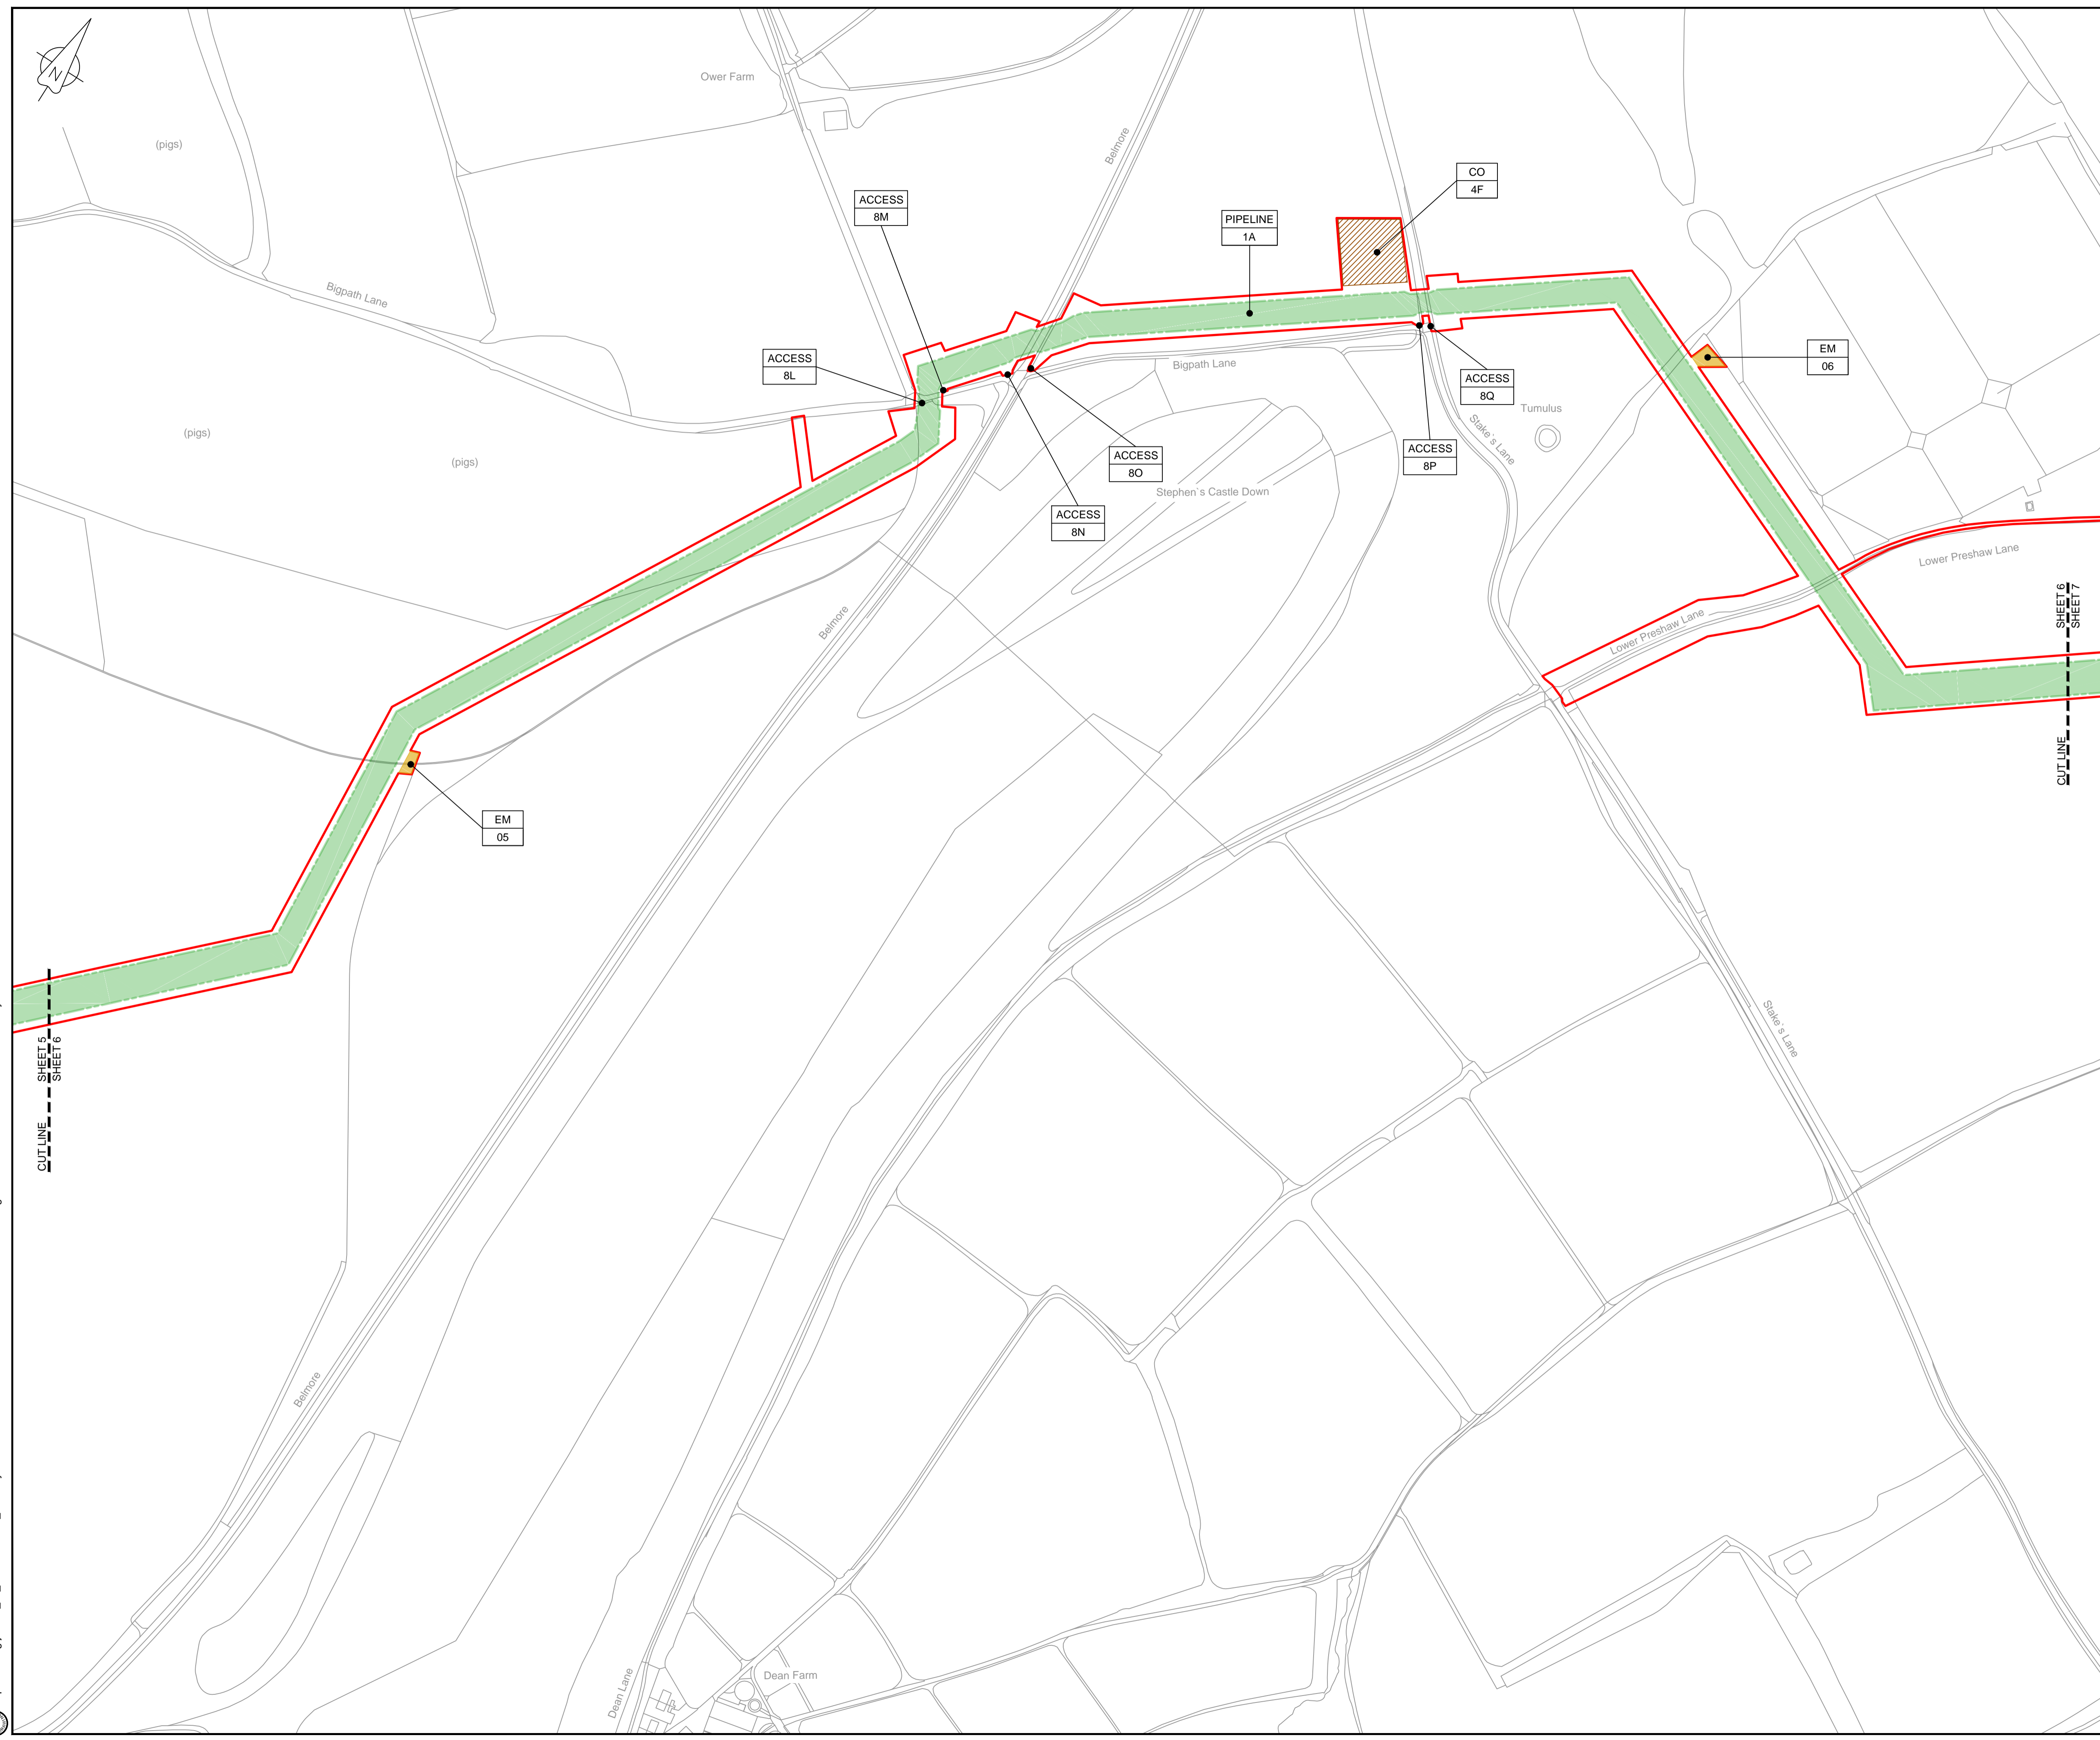

**LOCATION PLAN**  
SCALE 1:500,000

**NOTES**  
1. THIS DRAWING IS IN METRES UNLESS STATED OTHERWISE.

**LEGEND**

	ORDER LIMITS
	LIMITS OF DEVIATION
	COMPOUND (CO)
	ENVIRONMENTAL MITIGATION AREA (EM)
	ABOVE GROUND INSTALLATION (AGI) / VALVE (VA) / PRESSURE TRANSDUCER (PT)
	DESCRIPTION
	ID or WORK NUMBER (if applicable)
	ACCESS TEMPORARY CONSTRUCTION ACCESS
	P-ACCESS PERMANENT ACCESS
	COMMENCEMENT / TERMINATION OF WORKS (COMMENCEMENT = OPEN, TERMINATION = CLOSED)

Contains Ordnance Survey data © Crown copyright and database rights 2019.  
© Crown copyright and database rights 2019 OS Licence Number AL100005237.



C02	19/06/19	SHEETS 36 AND 109 REVISED FOLLOWING SSI ADVICE	SH	JA	ND	PH
C03	09/09/19	SHEETS 10, 11 AND 54 REVISED TO WITHDRAW A2B SUB-OPTION	BT	JA	ND	AD
Rev	Rev. Date	Purpose of revision	Drawn	Checked	Rev'd	Appr'd

**JACOBS**  
1180 Eskdale Road, Winnersh, Wokingham, RG41 5TU  
Tel:+44(0)118 946 7000 Fax:+44(0)118 946 7001  
www.jacobs.com

Client: Esso Petroleum Company, Limited  
Emryn House,  
Emryn Way,  
Leatherhead,  
Surrey,  
KT22 8UX

Project: Southampton to London Pipeline Project


Drawing title: **WORKS PLAN SHEET 6 REGULATION 5 (2)(J)**

Drawing status: **Fit for Stage Approval**

Scale	1:2500	DO NOT SCALE
Jacobs No.	B2325300	Rev
Client no.		<b>C03</b>

Drawing number: **B2325300-JAC-000-CIV-DRG-000016**

© Copyright 2019 Jacobs U.K. Limited. The concepts and information contained in this document are the property of Jacobs. Use or copying of this document in whole or in part without the written permission of Jacobs constitutes an infringement of copyright. Limitation: This drawing has been prepared on behalf of, and for the exclusive use of, the Client, and is subject to, and issued in accordance with, the provisions of the contract between Jacobs and the Client. Jacobs accepts no liability or responsibility whatsoever for, or in respect of, any use of, or reliance upon, this drawing by any third party.

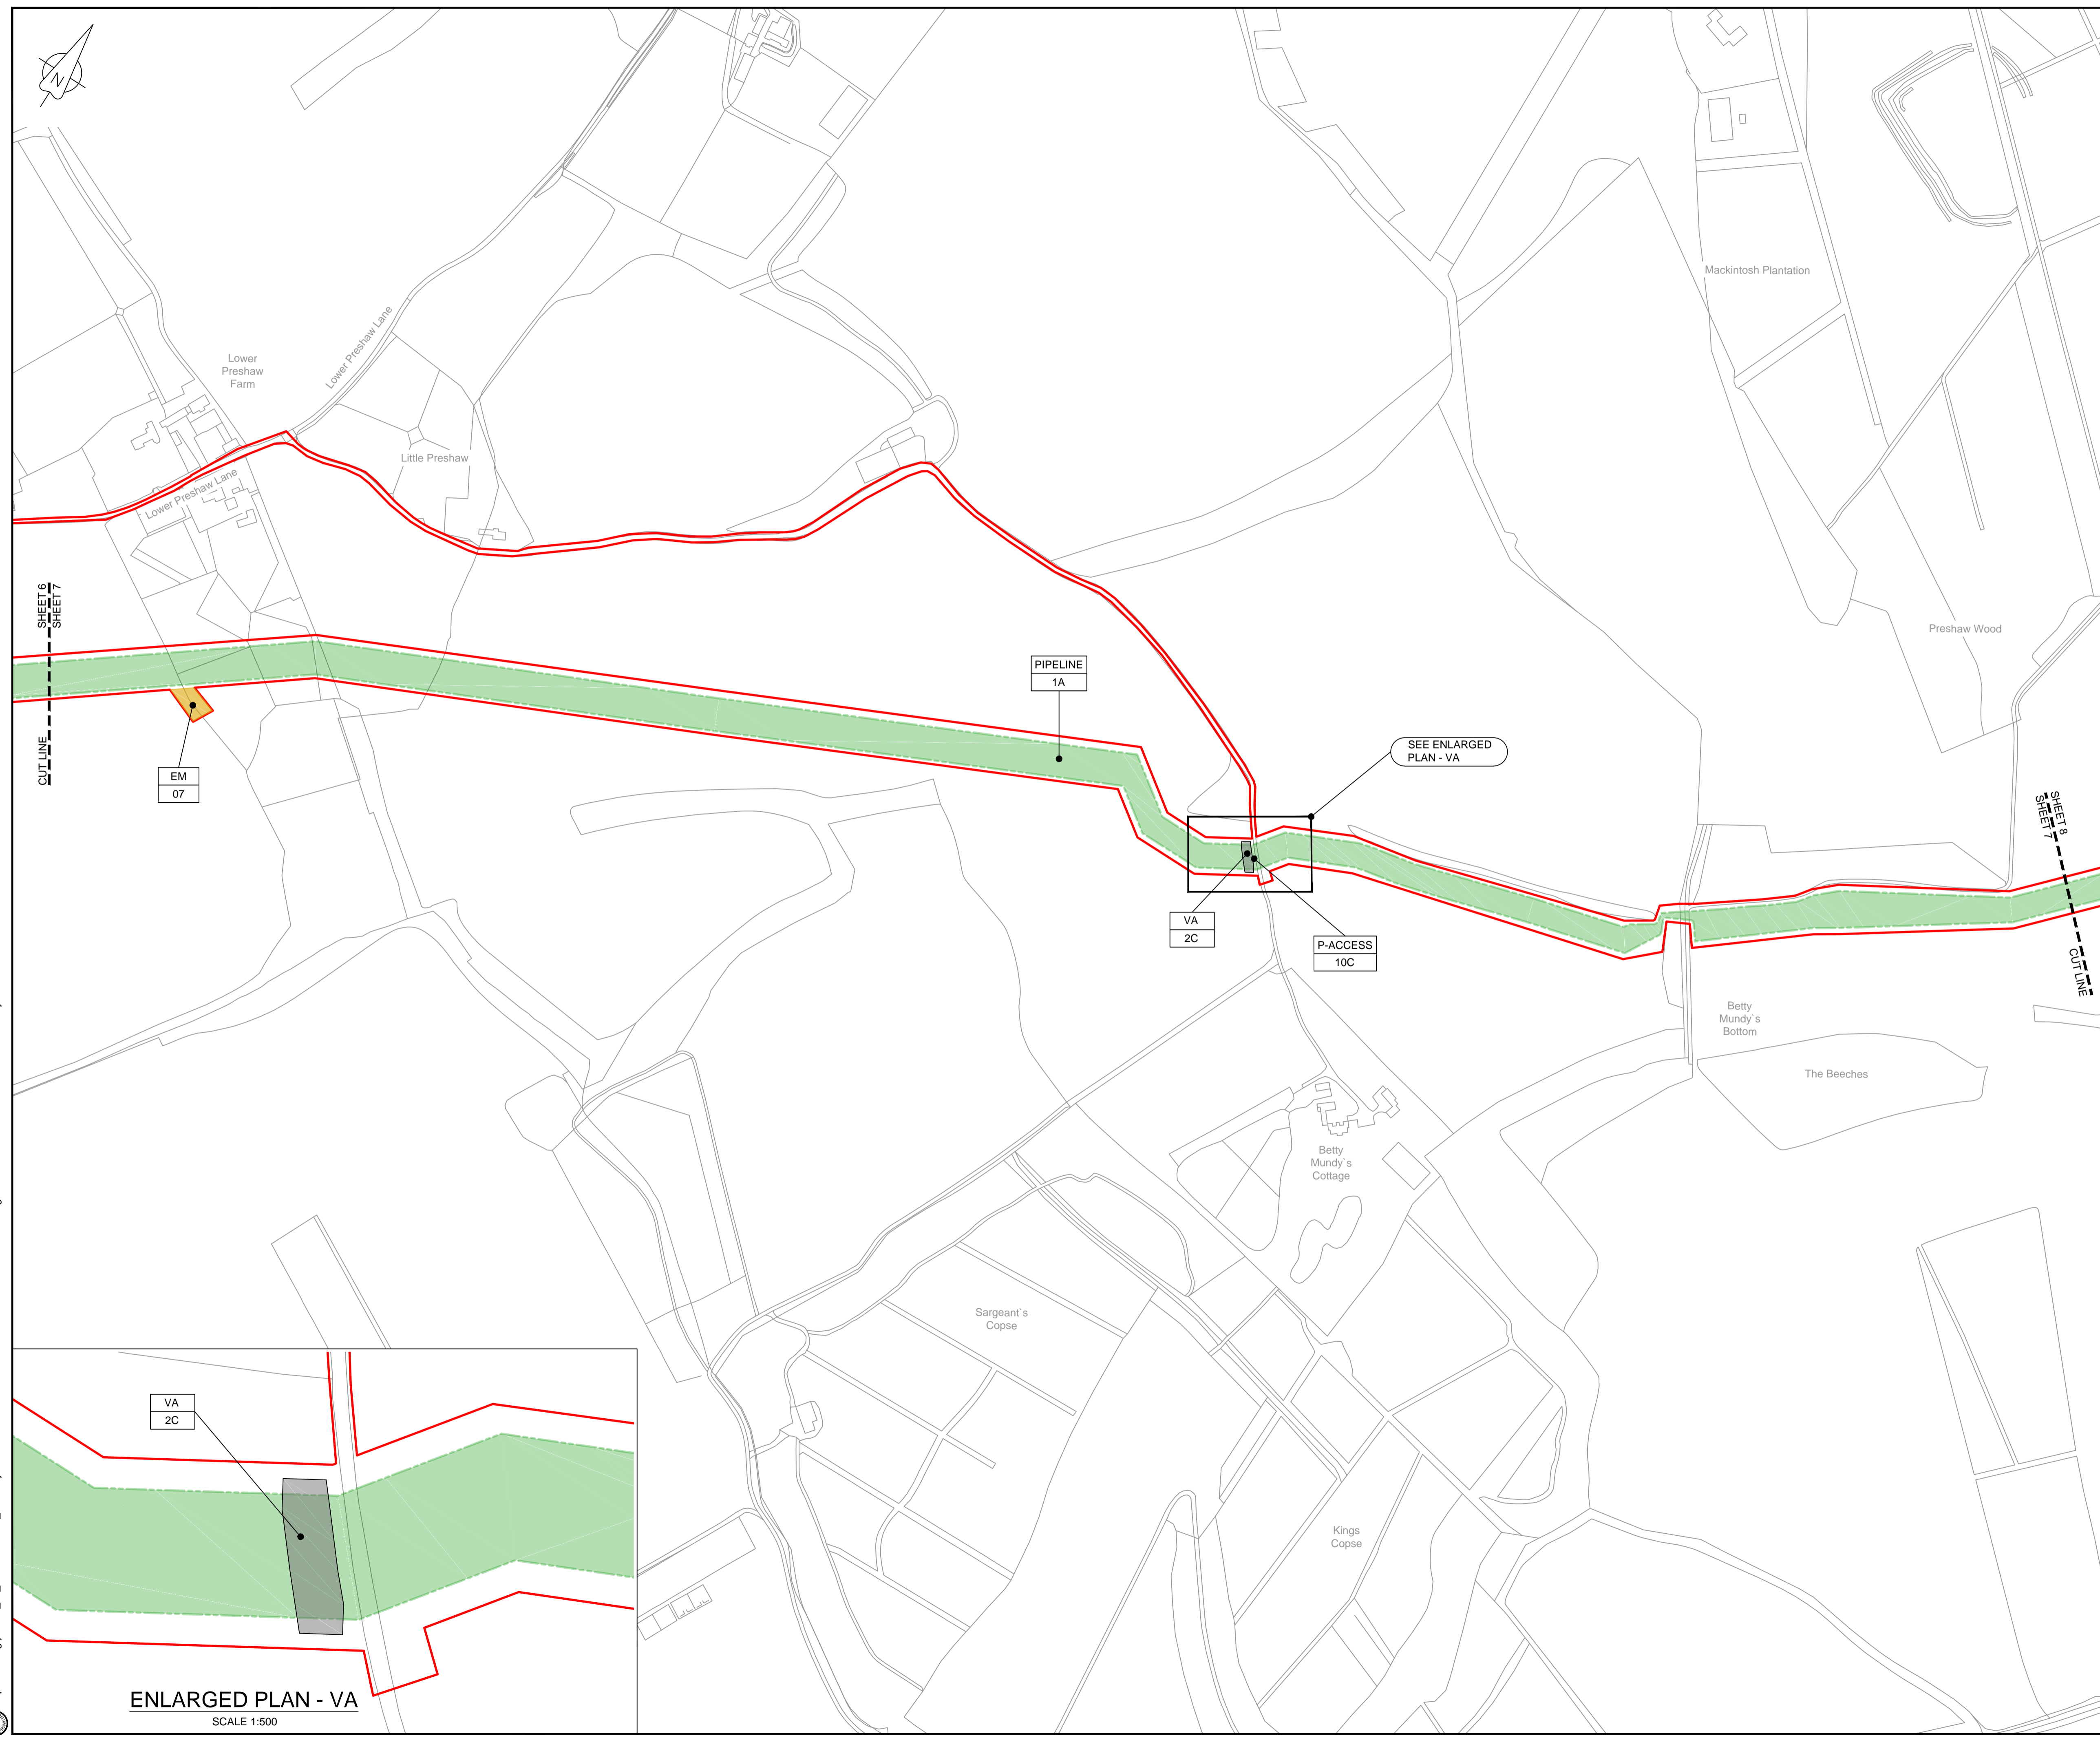


**LOCATION PLAN**  
SCALE 1:500,000

**NOTES**  
1. THIS DRAWING IS IN METRES UNLESS STATED OTHERWISE.

**LEGEND**

[Red line]	ORDER LIMITS
[Green shaded area]	LIMITS OF DEVIATION
[Hatched area]	COMPOUND (CO)
[Yellow shaded area]	ENVIRONMENTAL MITIGATION AREA (EM)
[Grey shaded area]	ABOVE GROUND INSTALLATION (AGI) / VALVE (VA) / PRESSURE TRANSDUCER (PT)
[Symbol]	DESCRIPTION
[Symbol]	ID or WORK NUMBER (if applicable)
[Symbol]	ACCESS
[Symbol]	TEMPORARY CONSTRUCTION ACCESS
[Symbol]	P-ACCESS
[Symbol]	PERMANENT ACCESS
[Symbol]	COMMENCEMENT / TERMINATION OF WORKS (COMMENCEMENT = OPEN, TERMINATION = CLOSED)

Contains Ordnance Survey data © Crown copyright and database rights 2019.  
© Crown copyright and database rights 2019 OS Licence Number AL10005237.

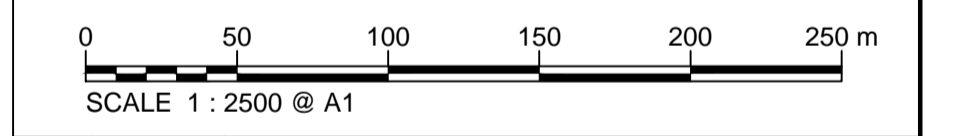

C02	19/06/19	SHEETS 36 AND 109 REVISED FOLLOWING SSI ADVICE	SH	JA	ND	PH
C03	09/09/19	SHEETS 10, 11 AND 54 REVISED TO WITHDRAW A2B SUB-OPTION	BT	JA	ND	AD
Rev	Rev. Date	Purpose of revision	Drawn	Checked	Rev'd	Appr'd

**JACOBS**  
1180 Eskdale Road, Winnersh, Wokingham, RG41 5TU  
Tel: +44(0)118 946 7000 Fax: +44(0)118 946 7001  
www.jacobs.com

Client: Esso Petroleum Company, Limited  
Ermyn House,  
Ermyn Way,  
Leatherhead,  
Surrey,  
KT22 8UX

Project: Southampton to London Pipeline Project

Drawing title: **WORKS PLAN SHEET 7 REGULATION 5 (2)(J)**

Drawing status: **Fit for Stage Approval**


Scale	1:2500	DO NOT SCALE
Jacobs No.	B2325300	Rev
Client no.		<b>C03</b>



Drawing number: **B2325300-JAC-000-CIV-DRG-000017**

© Copyright 2019 Jacobs U.K. Limited. The concepts and information contained in this document are the property of Jacobs. Use or copying of this document in whole or in part without the written permission of Jacobs constitutes an infringement of copyright. Limitation: This drawing has been prepared on behalf of, and for the exclusive use of, the Client, and is subject to, and issued in accordance with, the provisions of the contract between Jacobs and the Client. Jacobs accepts no liability or responsibility whatsoever for, or in respect of, any use of, or reliance upon, this drawing by any third party.

C:\pwworking\jacobs\_uk\_water\utilities\_ssf\lba\londms33519\B2325300-JAC-000-CIV-DRG-000017.dwg - 10/09/2019 10:51:40 - A1Frame - BTaylor

**ENLARGED PLAN - VA**  
SCALE 1:500

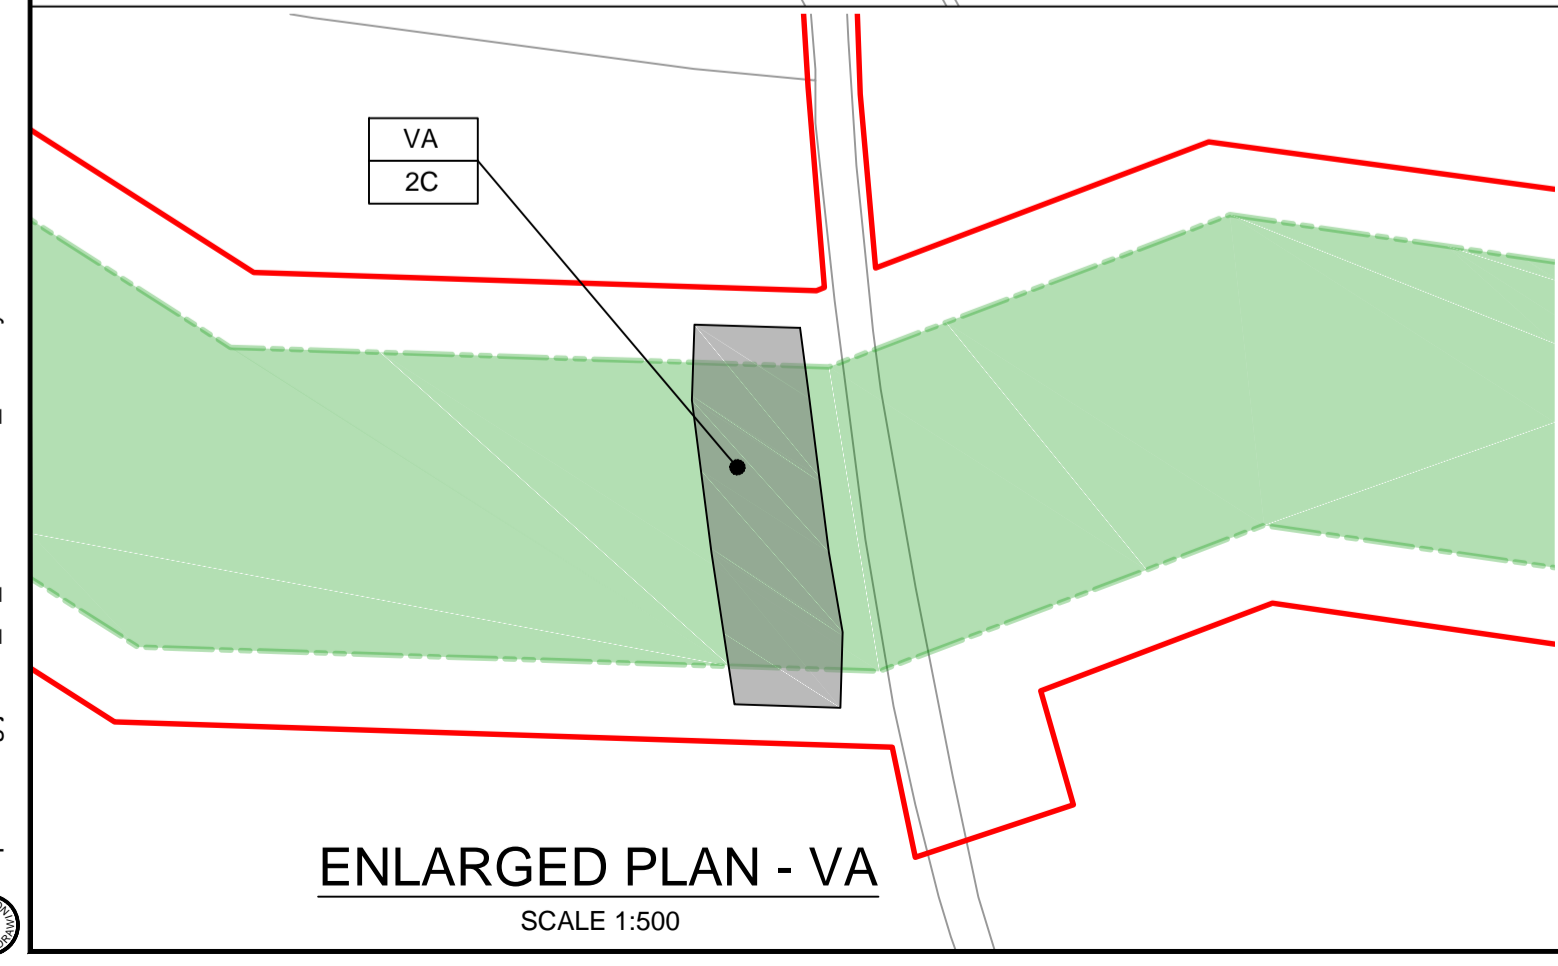

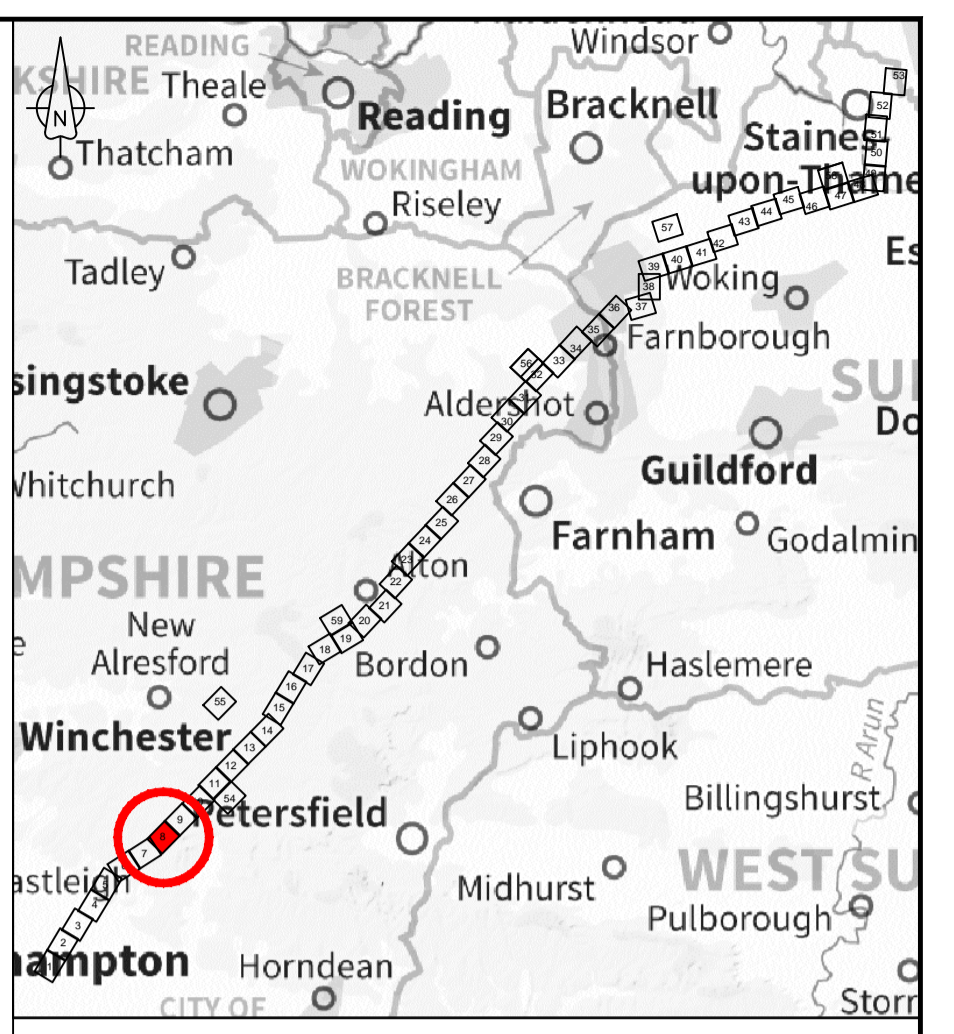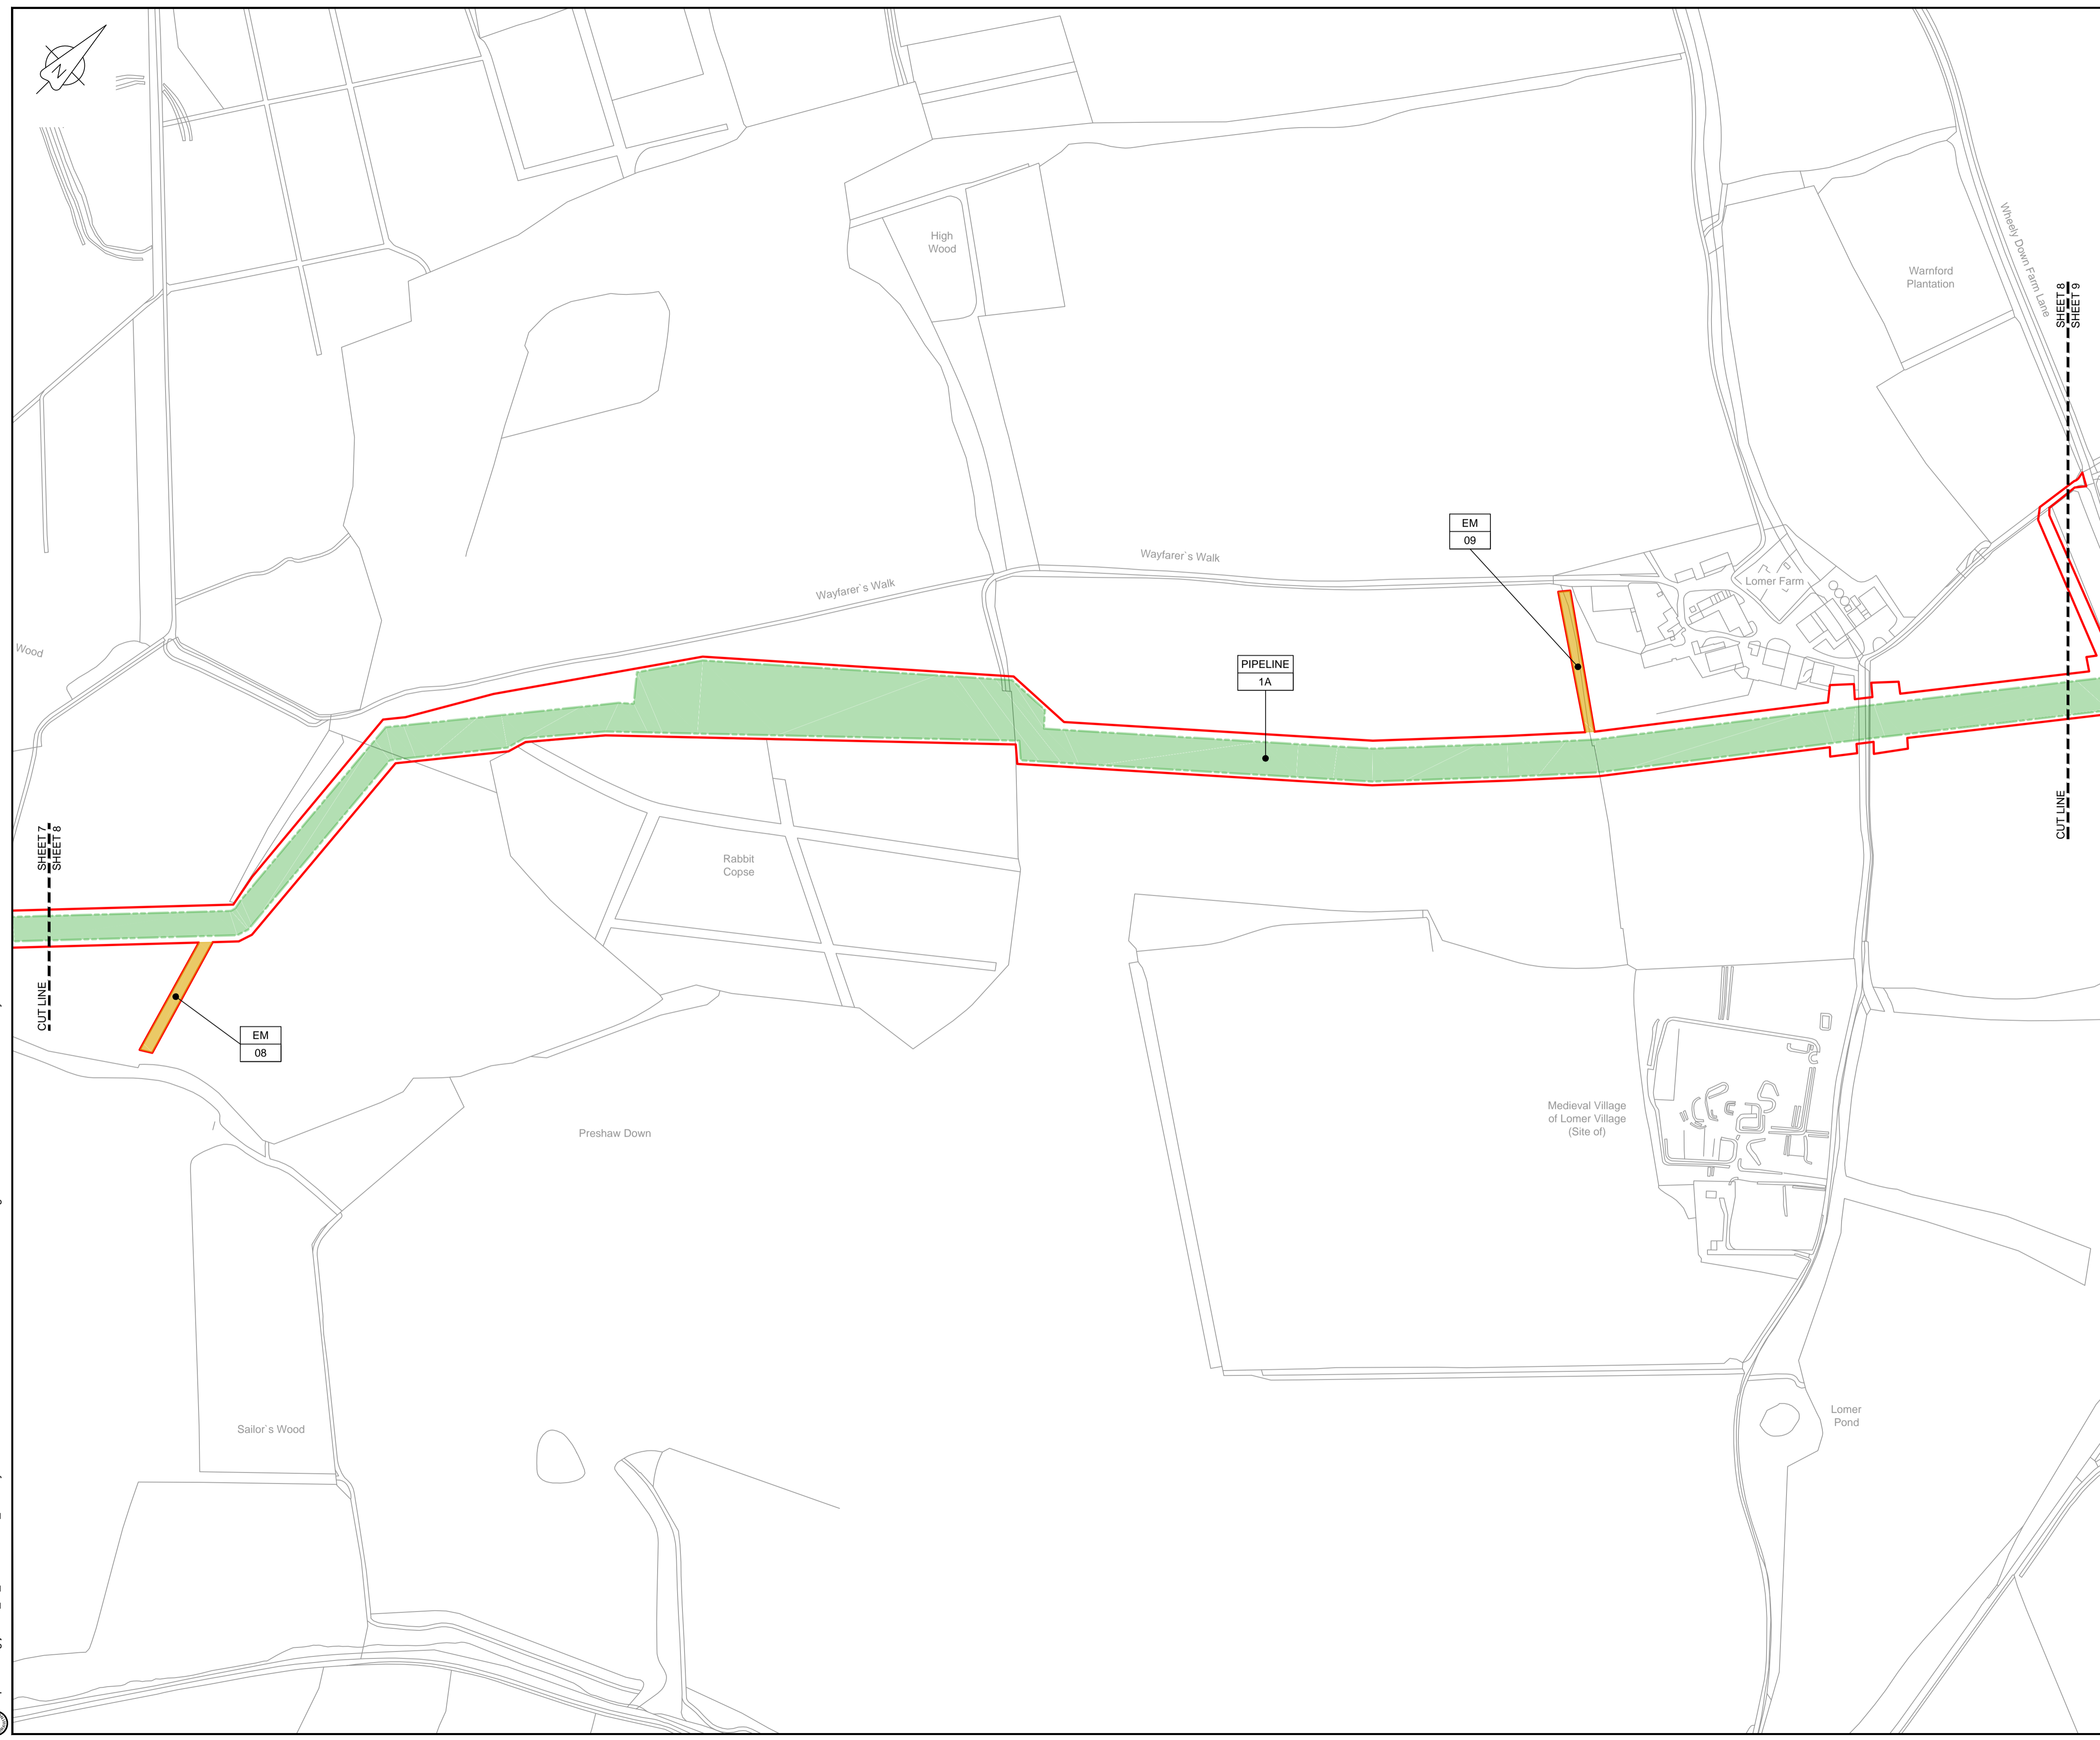

**LOCATION PLAN**  
SCALE 1:500,000

**NOTES**  
1. THIS DRAWING IS IN METRES UNLESS STATED OTHERWISE.

**LEGEND**

	ORDER LIMITS
	LIMITS OF DEVIATION
	COMPOUND (CO)
	ENVIRONMENTAL MITIGATION AREA (EM)
	ABOVE GROUND INSTALLATION (AGI) / VALVE (VA) / PRESSURE TRANSDUCER (PT)
	DESCRIPTION
	ID or WORK NUMBER (if applicable)
	ACCESS
	TEMPORARY CONSTRUCTION ACCESS
	PERMANENT ACCESS
	COMMENCEMENT / TERMINATION OF WORKS (COMMENCEMENT = OPEN, TERMINATION = CLOSED)

Contains Ordnance Survey data © Crown copyright and database rights 2019.  
© Crown copyright and database rights 2019 OS Licence Number AL100005237.



C02	19/06/19	SHEETS 36 AND 109 REVISED FOLLOWING SSI ADVICE	SH	JA	ND	PH
C03	09/09/19	SHEETS 10, 11 AND 54 REVISED TO WITHDRAW A2b SUB-OPTION	BT	JA	ND	AD
Rev	Rev. Date	Purpose of revision	Drawn	Checked	Rev'd	Appr'd



Client: Esso Petroleum Company, Limited  
Emryn House,  
Emryn Way,  
Leatherhead,  
Surrey,  
KT22 8UX




Drawing title  
**WORKS PLAN  
SHEET 8  
REGULATION 5 (2)(J)**

Drawing status  
**Fit for Stage Approval**

Scale	1:2500	DO NOT SCALE
Jacobs No.	B2325300	Rev
Client no.		<b>C03</b>

Drawing number  
**B2325300-JAC-000-CIV-DRG-000018**

© Copyright 2019 Jacobs U.K. Limited. The concepts and information contained in this document are the property of Jacobs. Use or copying of this document in whole or in part without the written permission of Jacobs constitutes an infringement of copyright. Limitation: This drawing has been prepared on behalf of, and for the exclusive use of, the Client, and is subject to, and issued in accordance with, the provisions of the contract between Jacobs and the Client. Jacobs accepts no liability or responsibility whatsoever for, or in respect of, any use of, or reliance upon, this drawing by any third party.

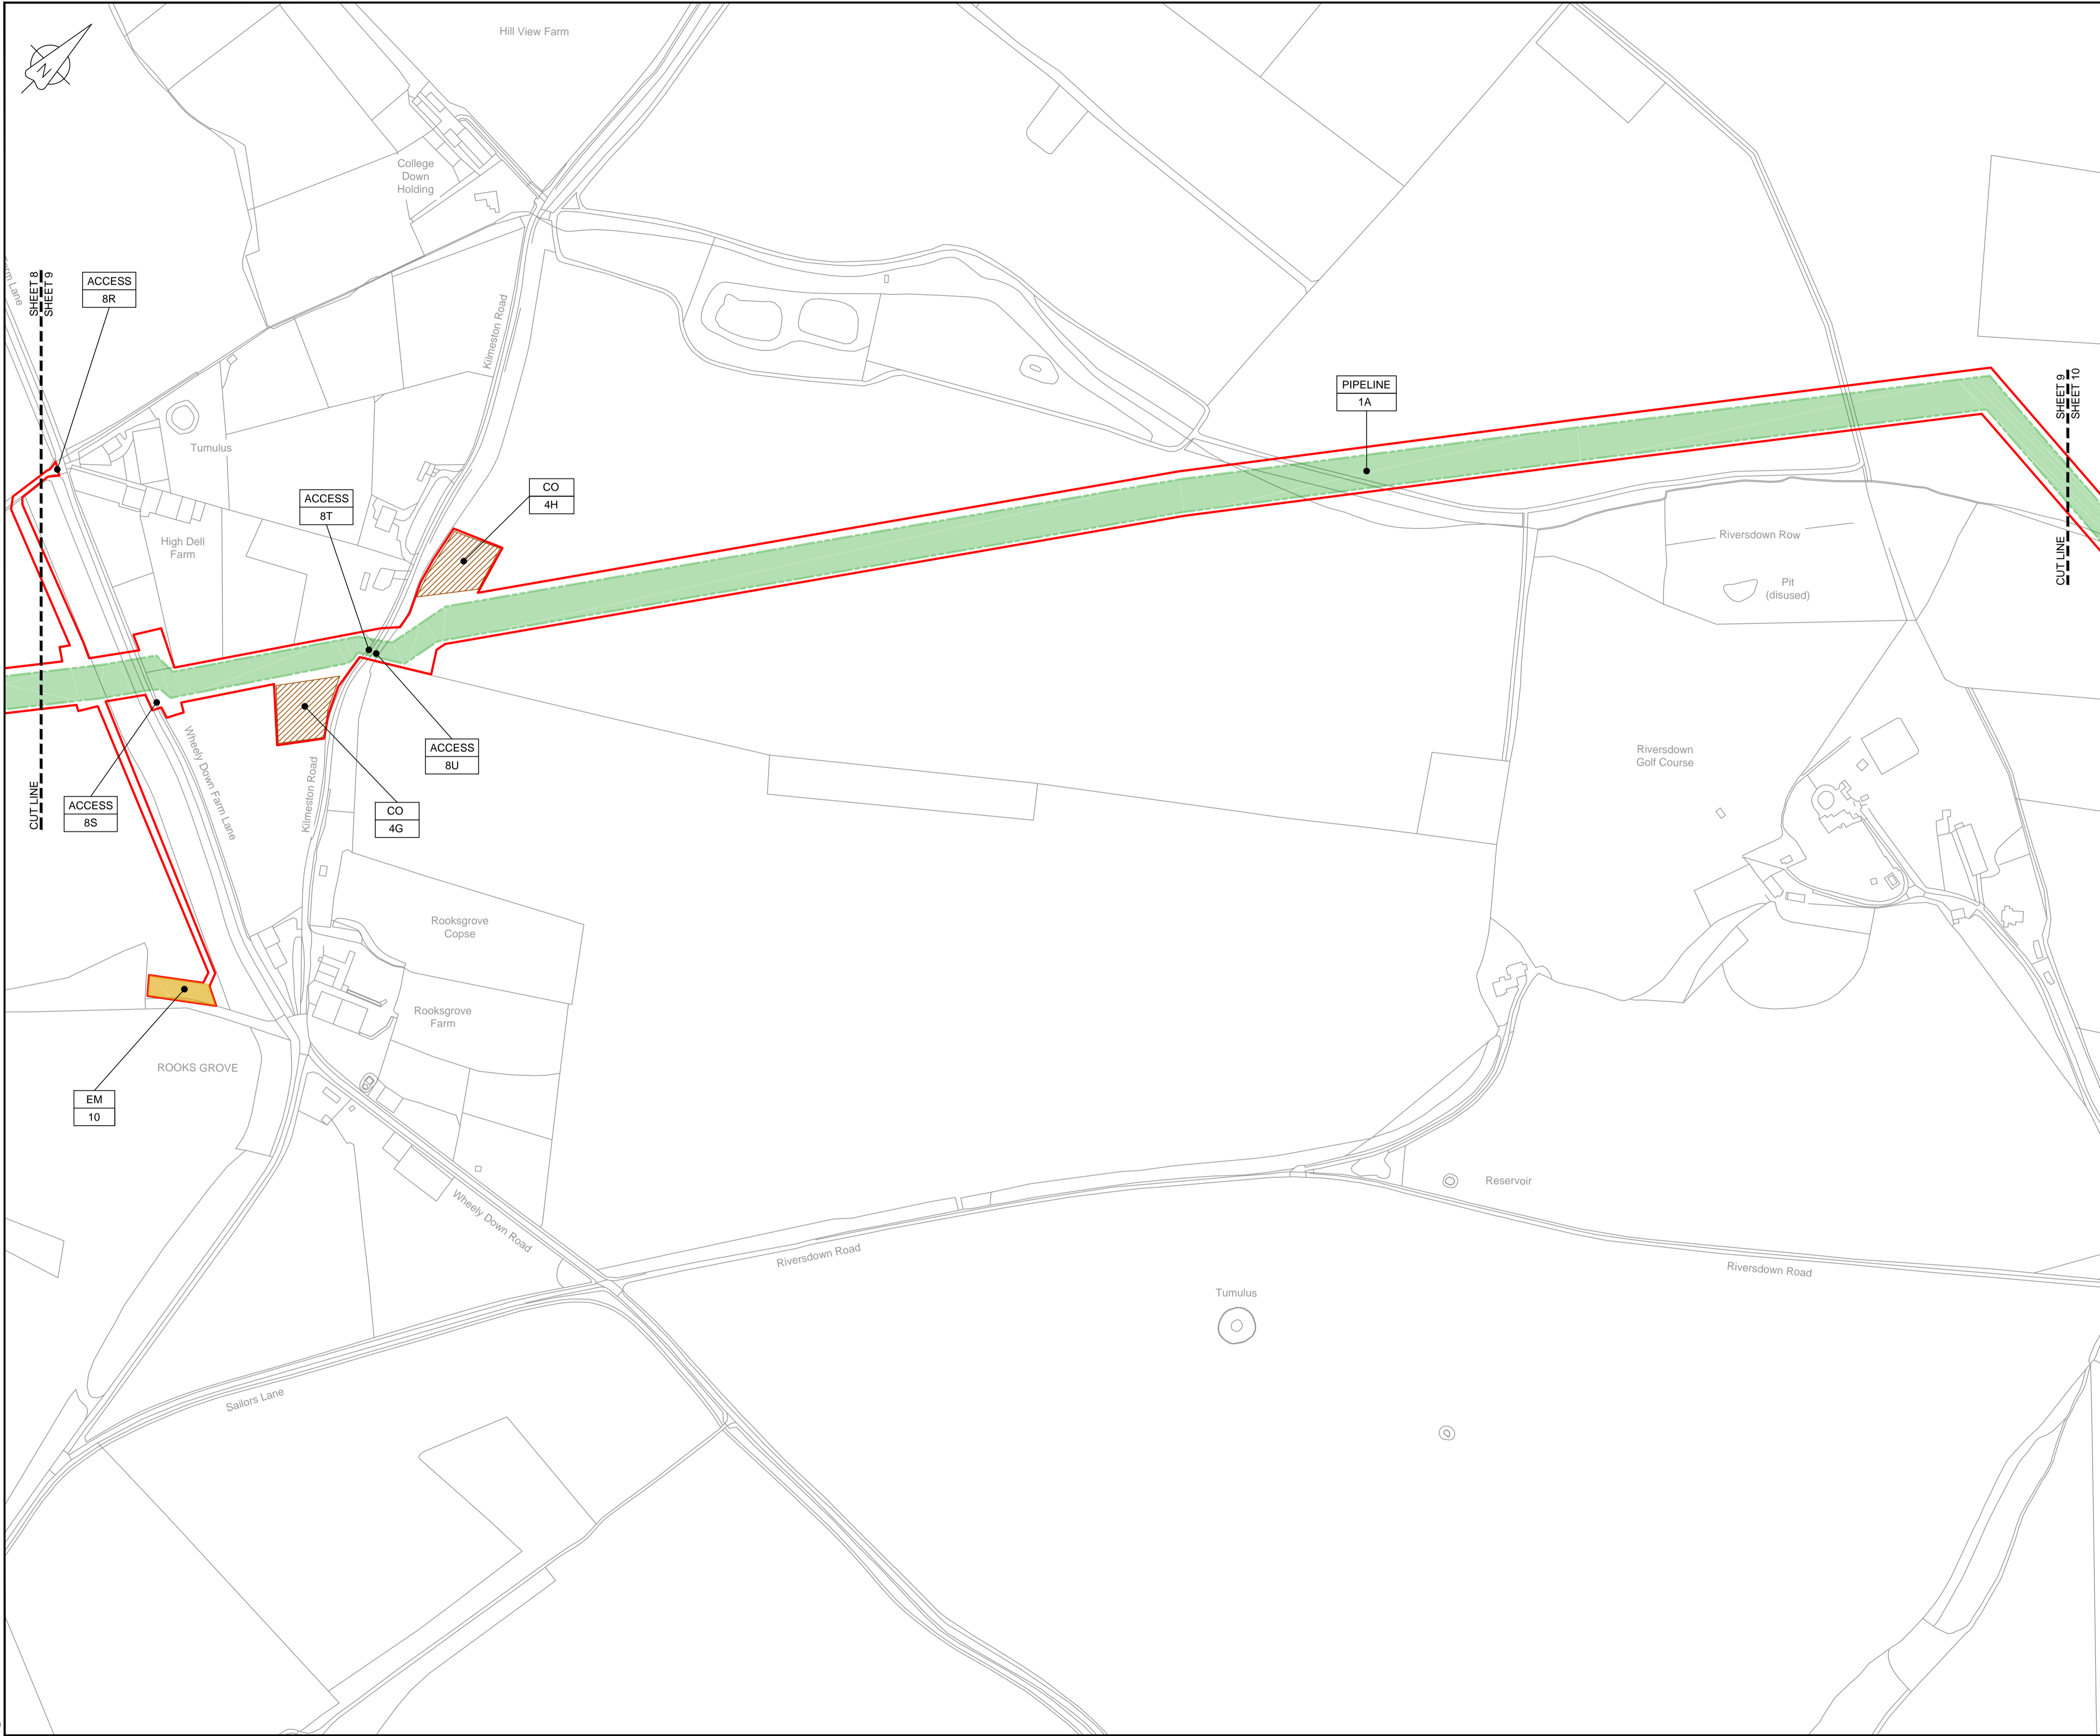

LOCATION PLAN  
SCALE 1:500,000

NOTES  
1. THIS DRAWING IS IN METRES UNLESS STATED OTHERWISE.

**LEGEND**

- ORDER LIMITS
- LIMITS OF DEVIATION
- COMPOUND (CO)
- ENVIRONMENTAL MITIGATION AREA (EM)
- ABOVE GROUND INSTALLATION (AGI) / VALVE (VA) / PRESSURE TRANSDUCER (PT)
- DESCRIPTION
- ID or WORK NUMBER (if applicable)
- ACCESS TEMPORARY CONSTRUCTION ACCESS
- P-ACCESS PERMANENT ACCESS
- COMMENCEMENT / TERMINATION OF WORKS (COMMENCEMENT = OPEN, TERMINATION = CLOSED)

Contains Ordnance Survey data © Crown copyright and database rights 2019.  
© Crown copyright and database rights 2019 OS Licence Number AL100005237.



C02	19/06/19	SHEETS 36 AND 109 REVISED FOLLOWING SSI ADVICE	SH	JA	ND	PH
C03	09/09/19	SHEETS 10, 11 AND 54 REVISED TO WITHDRAW A2b SUB-OPTION	BT	JA	ND	AD
Rev	Rev. Date	Purpose of revision	Drawn	Checked	Rev'd	Appr'd

**JACOBS**

1180 Eskdale Road, Winnersh, Wokingham, RG41 5TU  
Tel: +44(0)118 946 7000 Fax: +44(0)118 946 7001  
www.jacobs.com

Client: Esso Petroleum Company, Limited  
Emryn House,  
Emryn Way,  
Leatherhead,  
Surrey,  
KT22 8UX

Project: Southampton to London Pipeline Project

Drawing title: **WORKS PLAN  
SHEET 9  
REGULATION 5 (2)(J)**


Drawing status: **Fit for Stage Approval**

Scale	1:2500	DO NOT SCALE
Jacobs No.	B2325300	Rev
Client no.		<b>C03</b>

Drawing number: **B2325300-JAC-000-CIV-DRG-000019**

© Copyright 2019 Jacobs U.K. Limited. The concepts and information contained in this document are the property of Jacobs. Use or copying of this document in whole or in part without the written permission of Jacobs constitutes an infringement of copyright. Limitation. This drawing has been prepared on behalf of, and for the exclusive use of, the Client, and is subject to, and issued in accordance with, the provisions of the contract between Jacobs and the Client. Jacobs accepts no liability or responsibility whatsoever for, or in respect of, any use of, or reliance upon, this drawing by any third party.



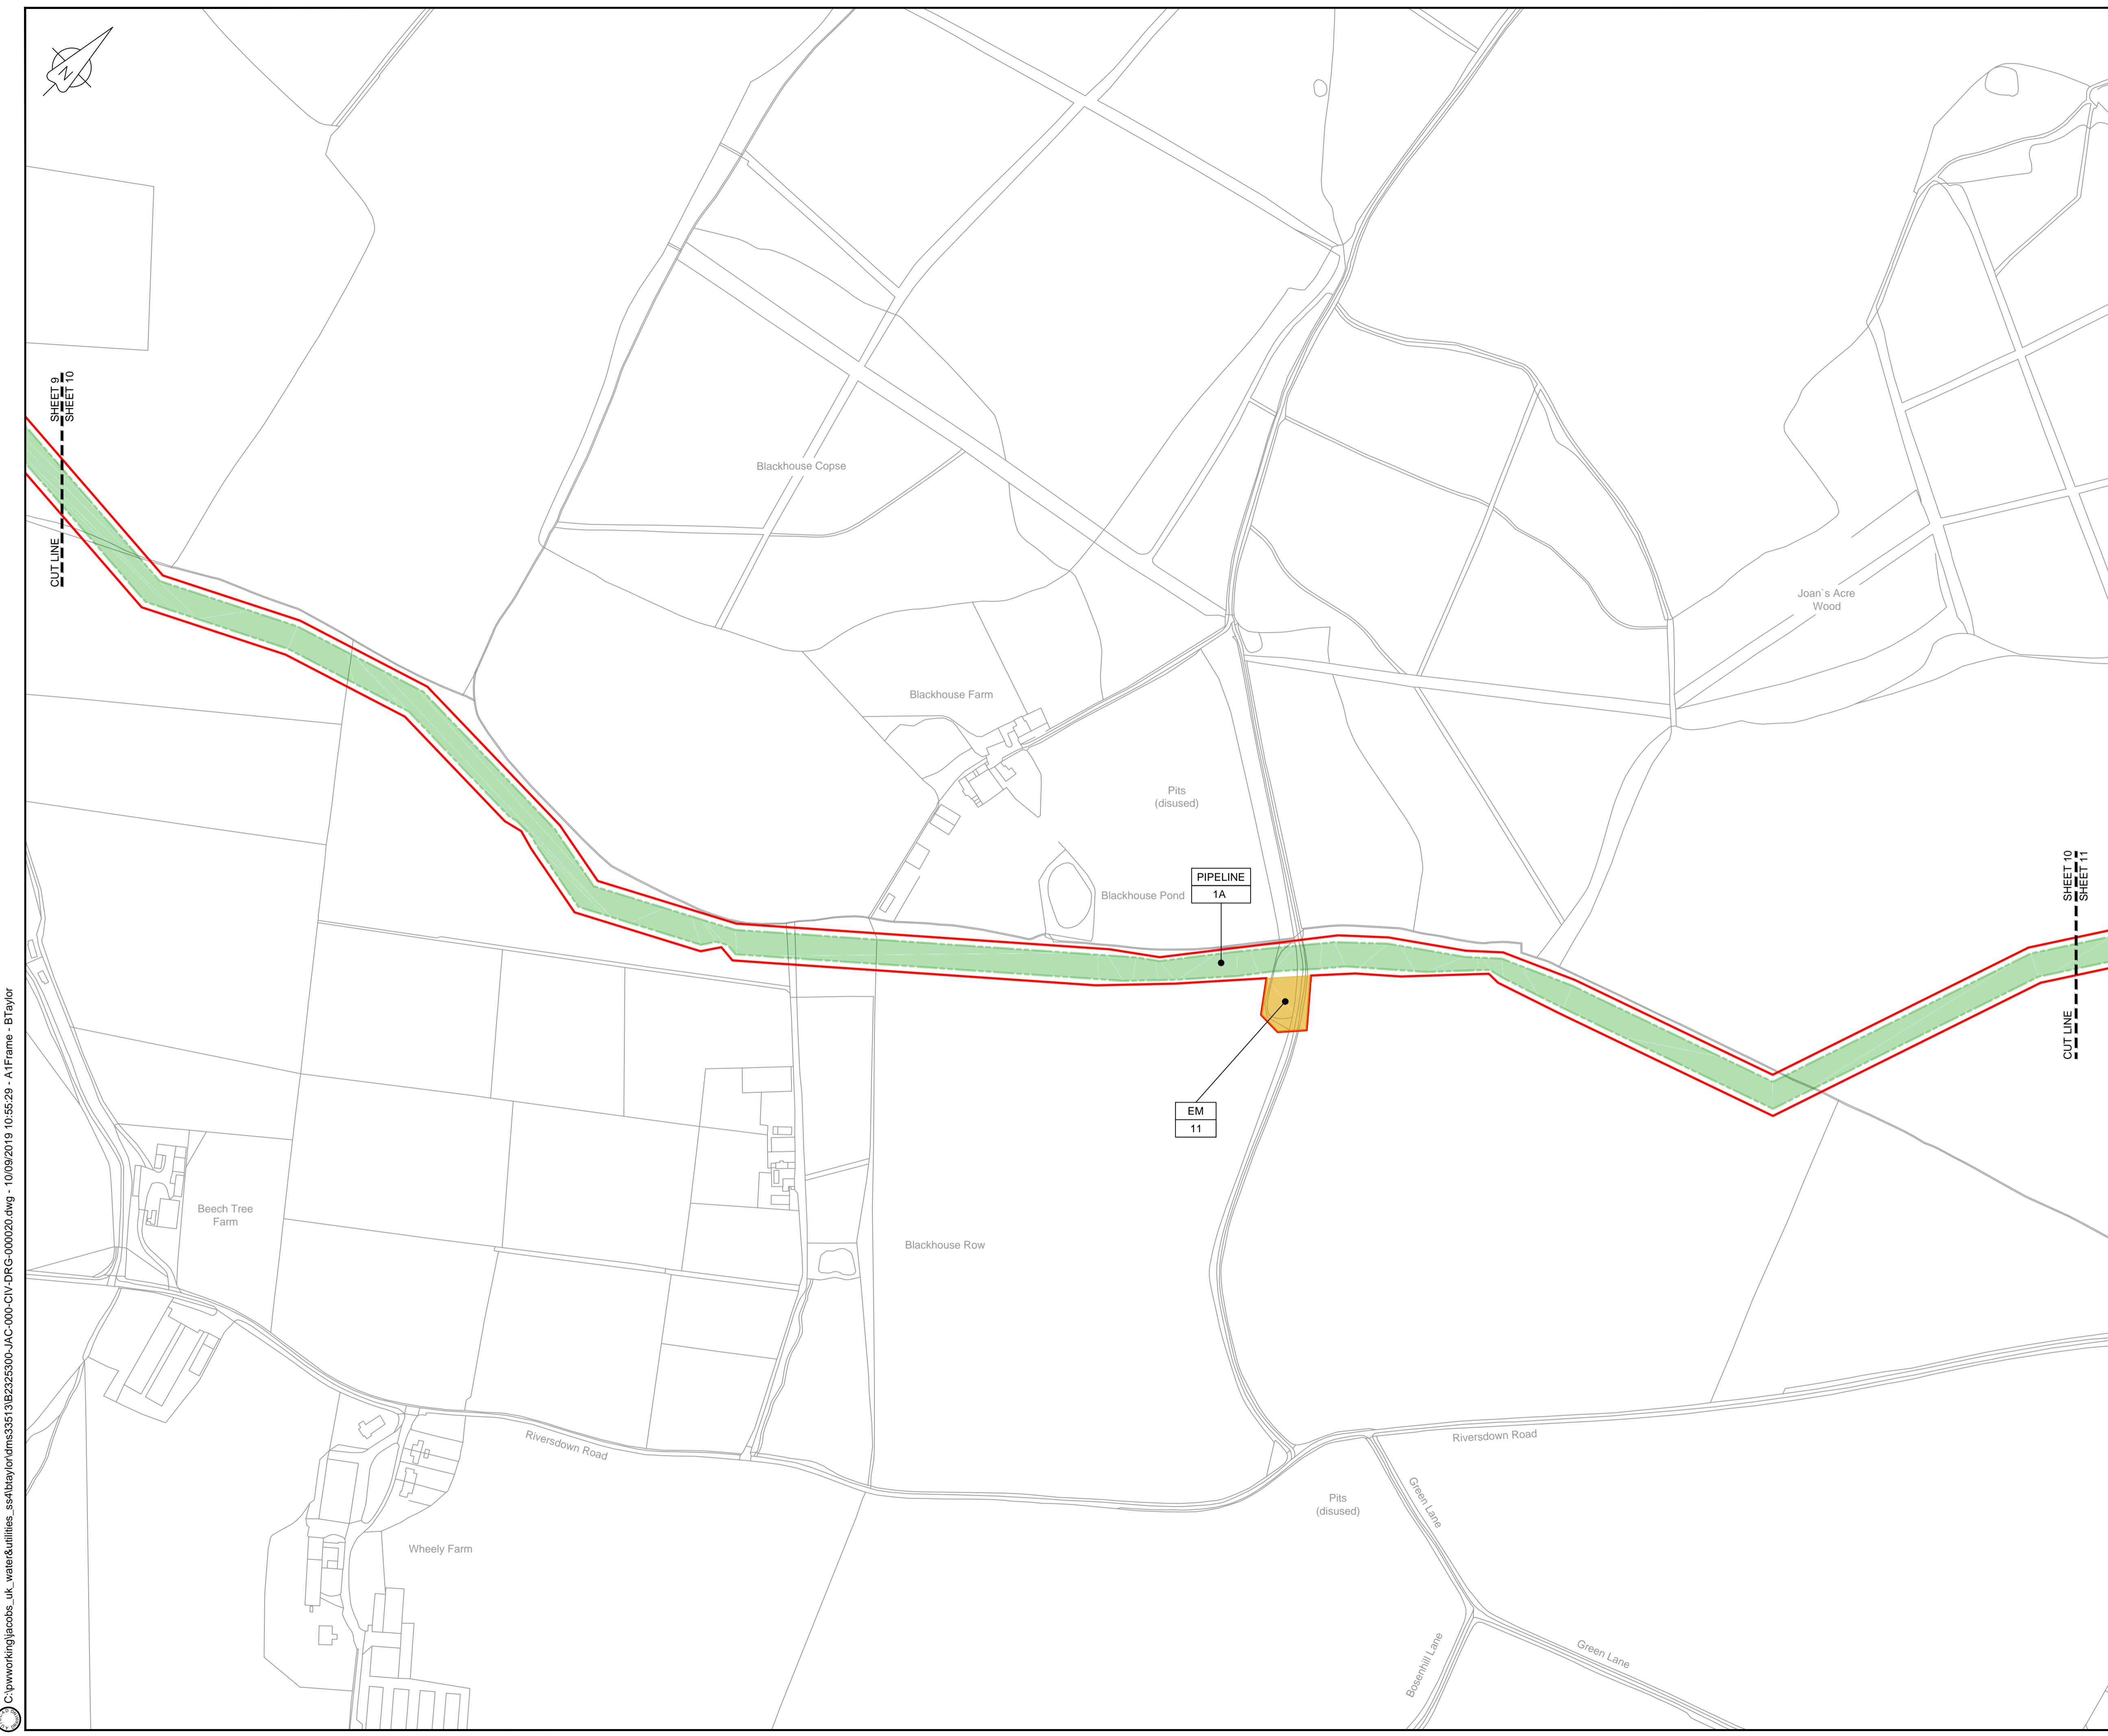

**LOCATION PLAN**  
SCALE 1:500,000

**NOTES**  
1. THIS DRAWING IS IN METRES UNLESS STATED OTHERWISE.

**LEGEND**

	ORDER LIMITS
	LIMITS OF DEVIATION
	COMPOUND (CO)
	ENVIRONMENTAL MITIGATION AREA (EM)
	ABOVE GROUND INSTALLATION (AGI) / VALVE (VA) / PRESSURE TRANSDUCER (PT)
	DESCRIPTION
	ID or WORK NUMBER (if applicable)
	ACCESS
	TEMPORARY CONSTRUCTION ACCESS
	P-ACCESS
	PERMANENT ACCESS
	COMMENCEMENT / TERMINATION OF WORKS
	(COMMENCEMENT = OPEN, TERMINATION = CLOSED)

Contains Ordnance Survey data © Crown copyright and database rights 2019.  
© Crown copyright and database rights 2019 OS Licence Number AL100005237.



C02	19/06/19	SHEETS 36 AND 109 REVISED FOLLOWING SSI ADVICE	SH	JA	ND	PH
C03	09/09/19	SHEETS 10, 11 AND 54 REVISED TO WITHDRAW A2B SUB-OPTION	BT	JA	ND	NJ
Rev	Rev. Date	Purpose of revision	Drawn	Checked	Rev'd	Appr'd



1180 Eskdale Road, Winnersh, Wokingham, RG41 5TU  
Tel:+44(0)118 946 7000 Fax:+44(0)118 946 7001  
www.jacobs.com

Client: Esso Petroleum Company, Limited  
Emryn House,  
Emryn Way,  
Leatherhead,  
Surrey,  
KT22 8UX





Drawing title  
**WORKS PLAN  
SHEET 10  
REGULATION 5 (2)(J)**

Drawing status  
**Fit for Stage Approval**

Scale	1:2500	DO NOT SCALE
Jacobs No.	B2325300	Rev
Client no.		<b>C03</b>

Drawing number  
**B2325300-JAC-000-CIV-DRG-000020**

© Copyright 2019 Jacobs U.K. Limited. The concepts and information contained in this document are the property of Jacobs. Use or copying of this document in whole or in part without the written permission of Jacobs constitutes an infringement of copyright. Limitation. This drawing has been prepared on behalf of, and for the exclusive use of, the Client, and is subject to, and issued in accordance with, the provisions of the contract between Jacobs and the Client. Jacobs accepts no liability or responsibility whatsoever for, or in respect of, any use of, or reliance upon, this drawing by any third party.

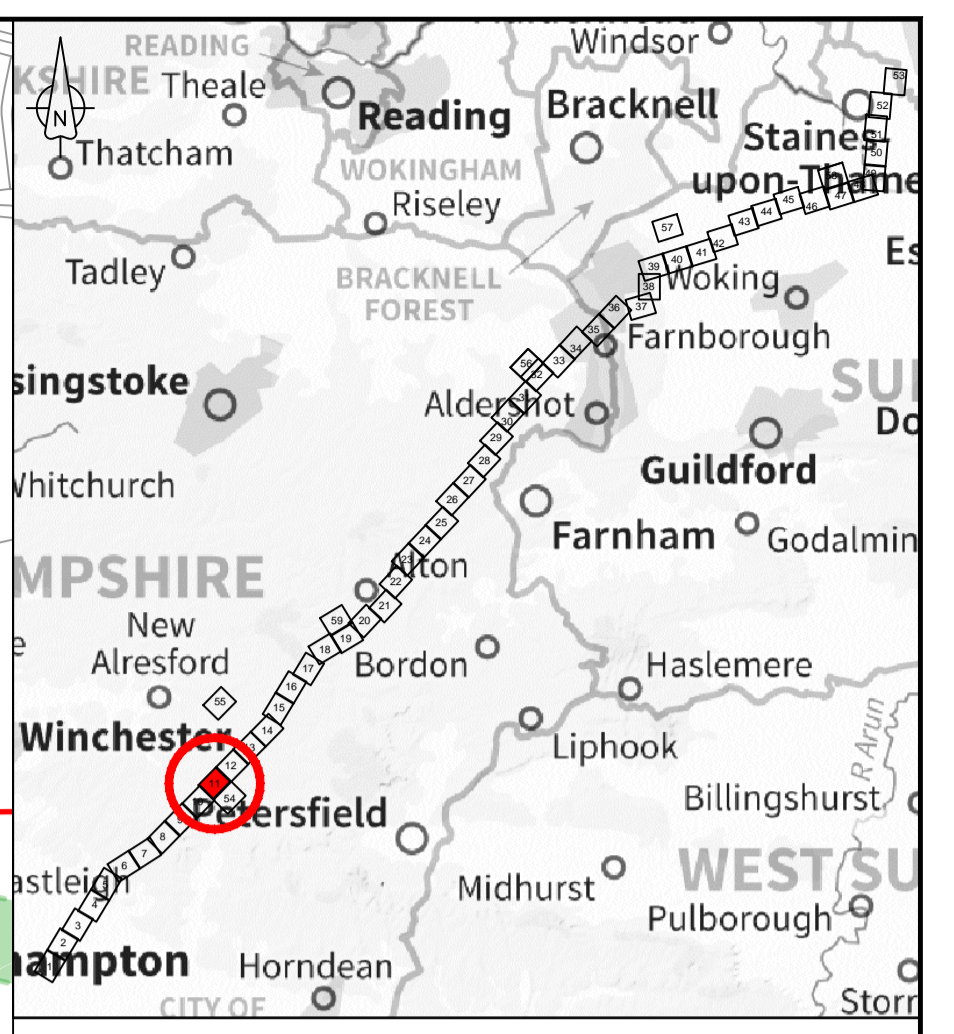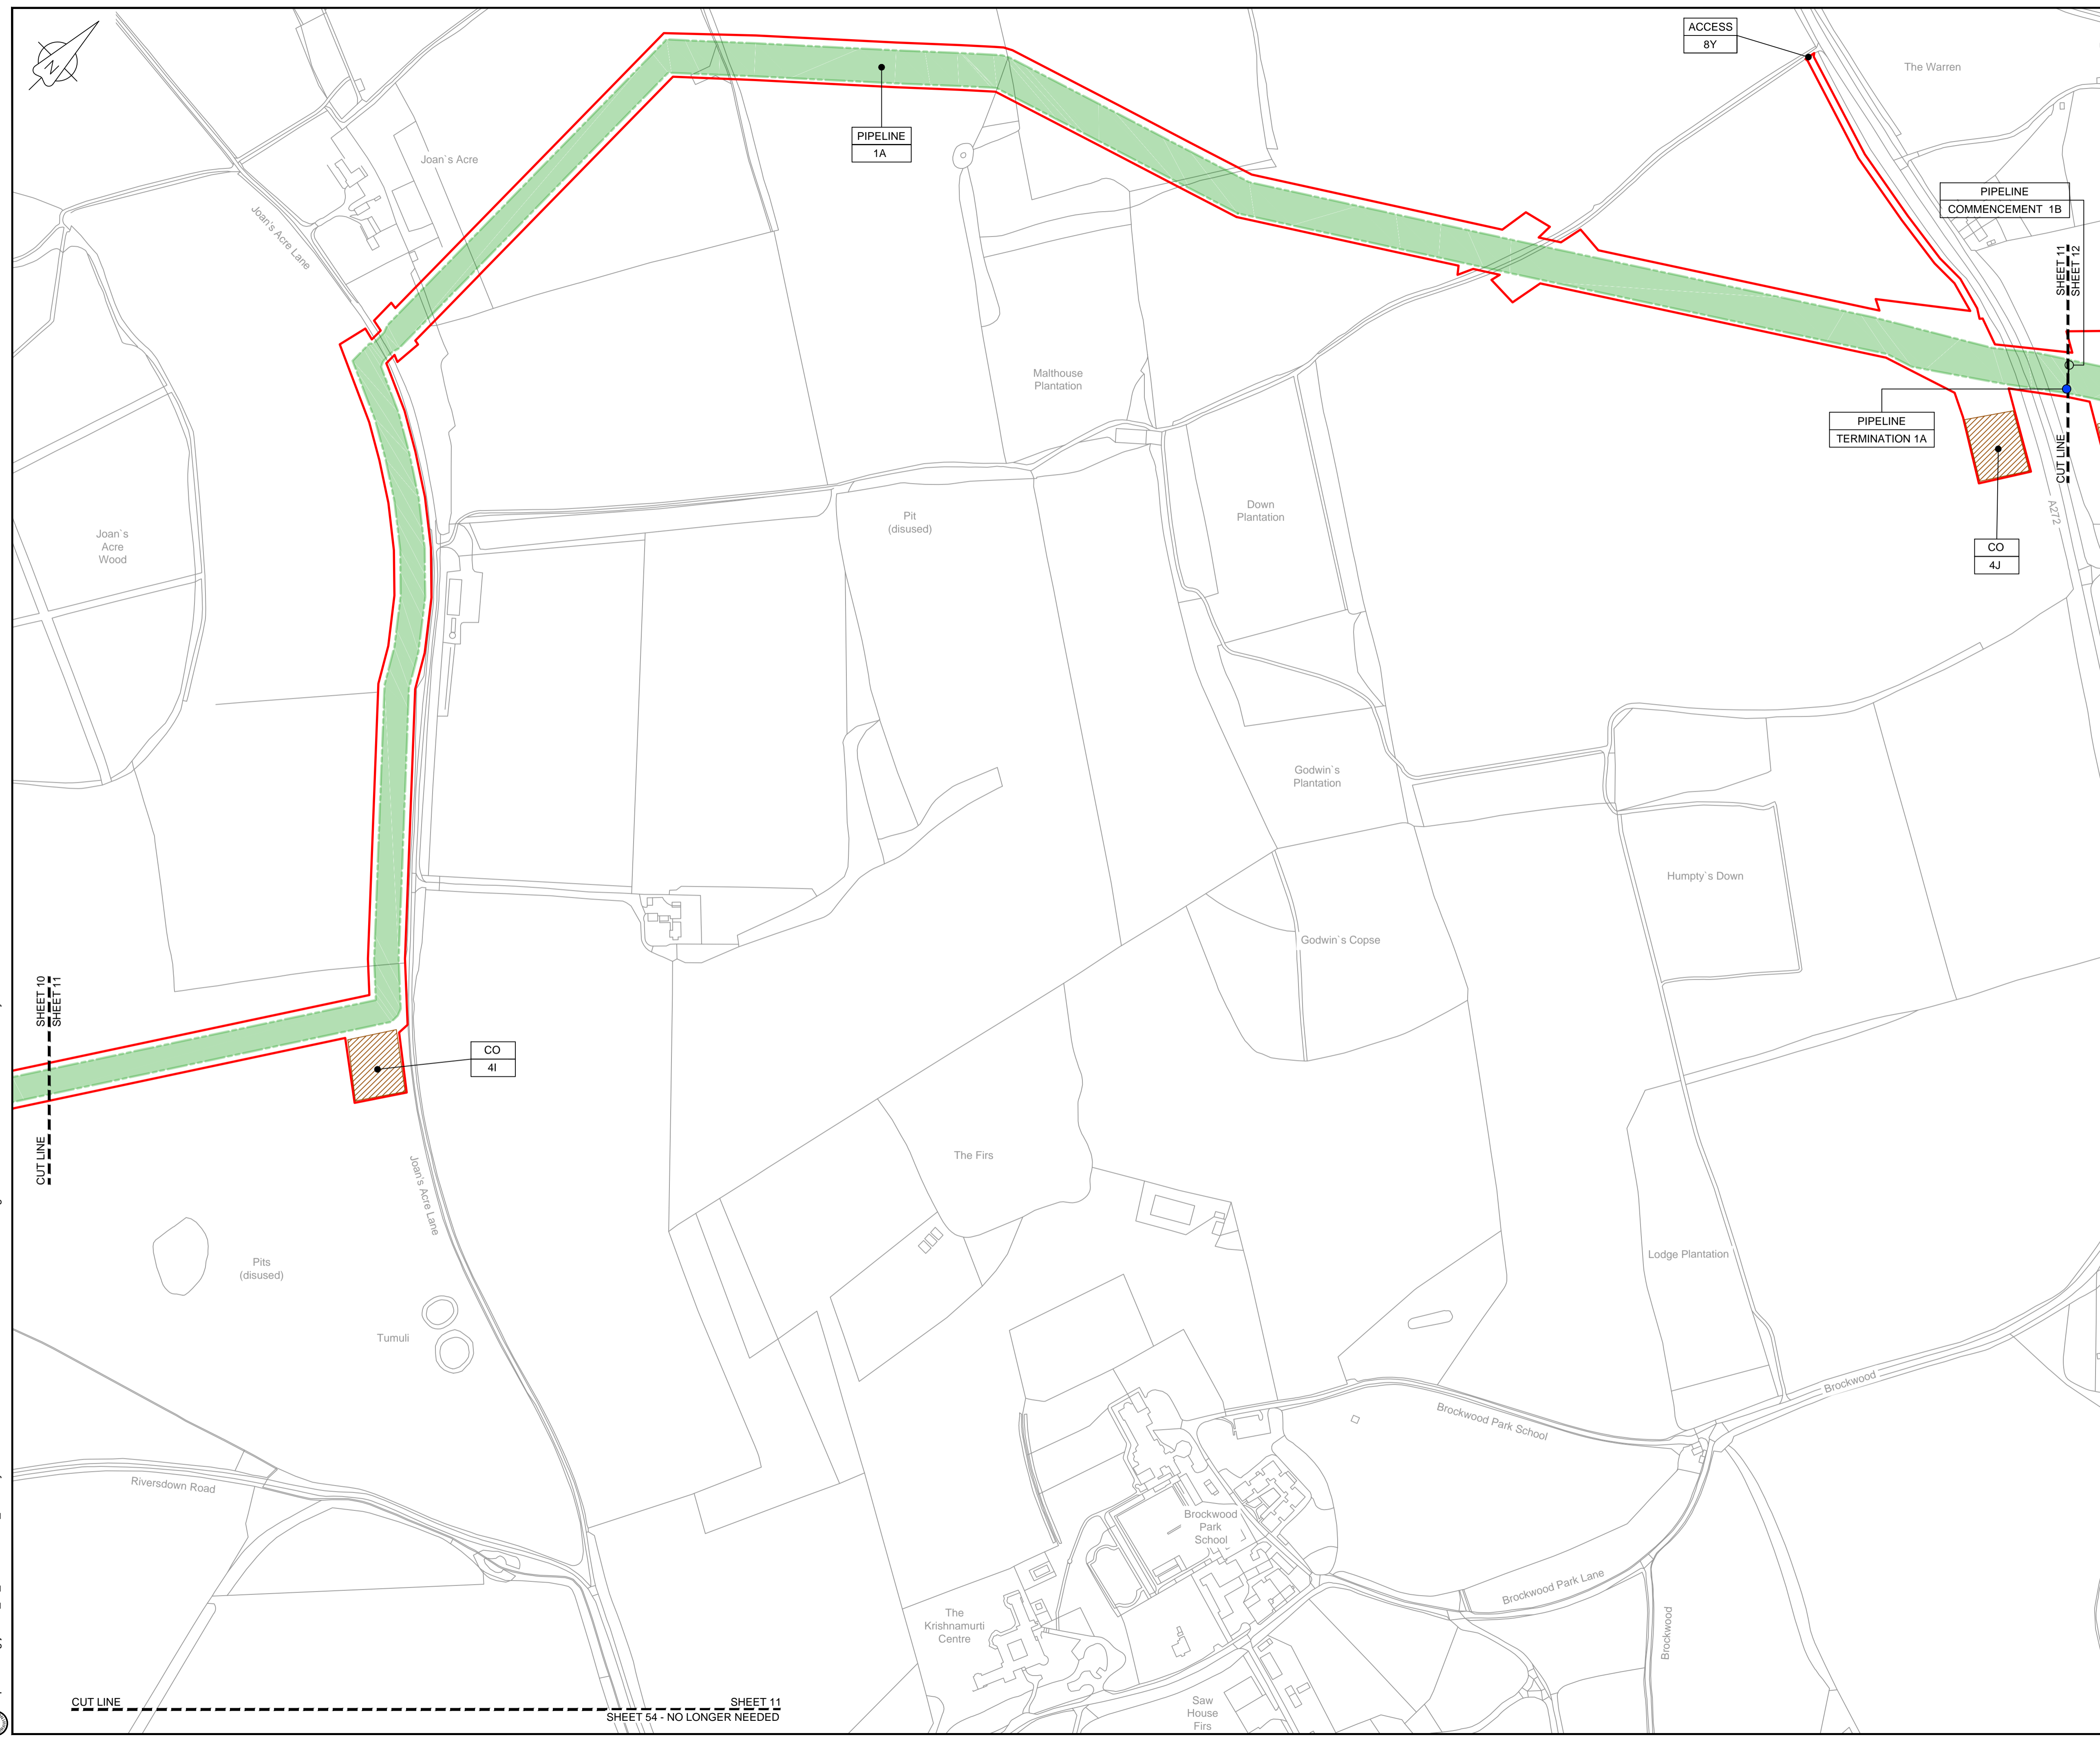

LOCATION PLAN  
SCALE 1:500,000


NOTES  
1. THIS DRAWING IS IN METRES UNLESS STATED OTHERWISE.

LEGEND

	ORDER LIMITS
	LIMITS OF DEVIATION
	COMPOUND (CO)
	ENVIRONMENTAL MITIGATION AREA (EM)
	ABOVE GROUND INSTALLATION (AGI) / VALVE (VA) / PRESSURE TRANSDUCER (PT)
	DESCRIPTION
	ID or WORK NUMBER (if applicable)
	ACCESS
	TEMPORARY CONSTRUCTION ACCESS
	P-ACCESS
	PERMANENT ACCESS
	COMMENCEMENT / TERMINATION OF WORKS (COMMENCEMENT = OPEN, TERMINATION = CLOSED)

Contains Ordnance Survey data © Crown copyright and database rights 2019.

© Crown copyright and database rights 2019 OS Licence Number AL10005237.

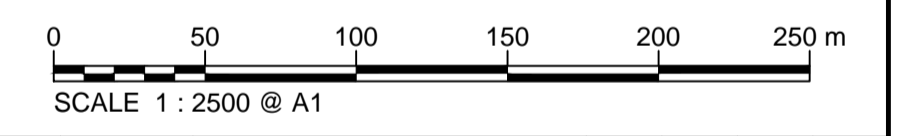

C02	19/06/19	SHEETS 36 AND 109 REVISED FOLLOWING SSI ADVICE	SH	JA	ND	PH
C03	09/09/19	SHEETS 10, 11 AND 54 REVISED TO WITHDRAW A2b SUB-OPTION	BT	JA	ND	NJ
Rev	Rev. Date	Purpose of revision	Drawn	Checked	Rev'd	Appr'd

**JACOBS**

1180 Eskdale Road, Wokingham, Wokingham, RG41 5TU  
Tel:+44(0)118 946 7000 Fax:+44(0)118 946 7001  
www.jacobs.com

Client: Esso Petroleum Company, Limited  
Emryn House,  
Emryn Way,  
Leatherhead,  
Surrey,  
KT22 8UX

Project: Southampton to London Pipeline Project


Drawing title: **WORKS PLAN SHEET 11 REGULATION 5 (2)(J)**

Drawing status: **Fit for Stage Approval**

Scale	1:2500	DO NOT SCALE
Jacobs No.	B2325300	Rev
Client no.		<b>C03</b>

Drawing number: **B2325300-JAC-000-CIV-DRG-000021**

© Copyright 2019 Jacobs U.K. Limited. The concepts and information contained in this document are the property of Jacobs. Use or copying of this document in whole or in part without the written permission of Jacobs constitutes an infringement of copyright. Limitation: This drawing has been prepared on behalf of, and for the exclusive use of, Jacobs' Client, and is subject to, and issued in accordance with, the provisions of the contract between Jacobs and the Client. Jacobs accepts no liability or responsibility whatsoever for, or in respect of, any use of, or reliance upon, this drawing by any third party.

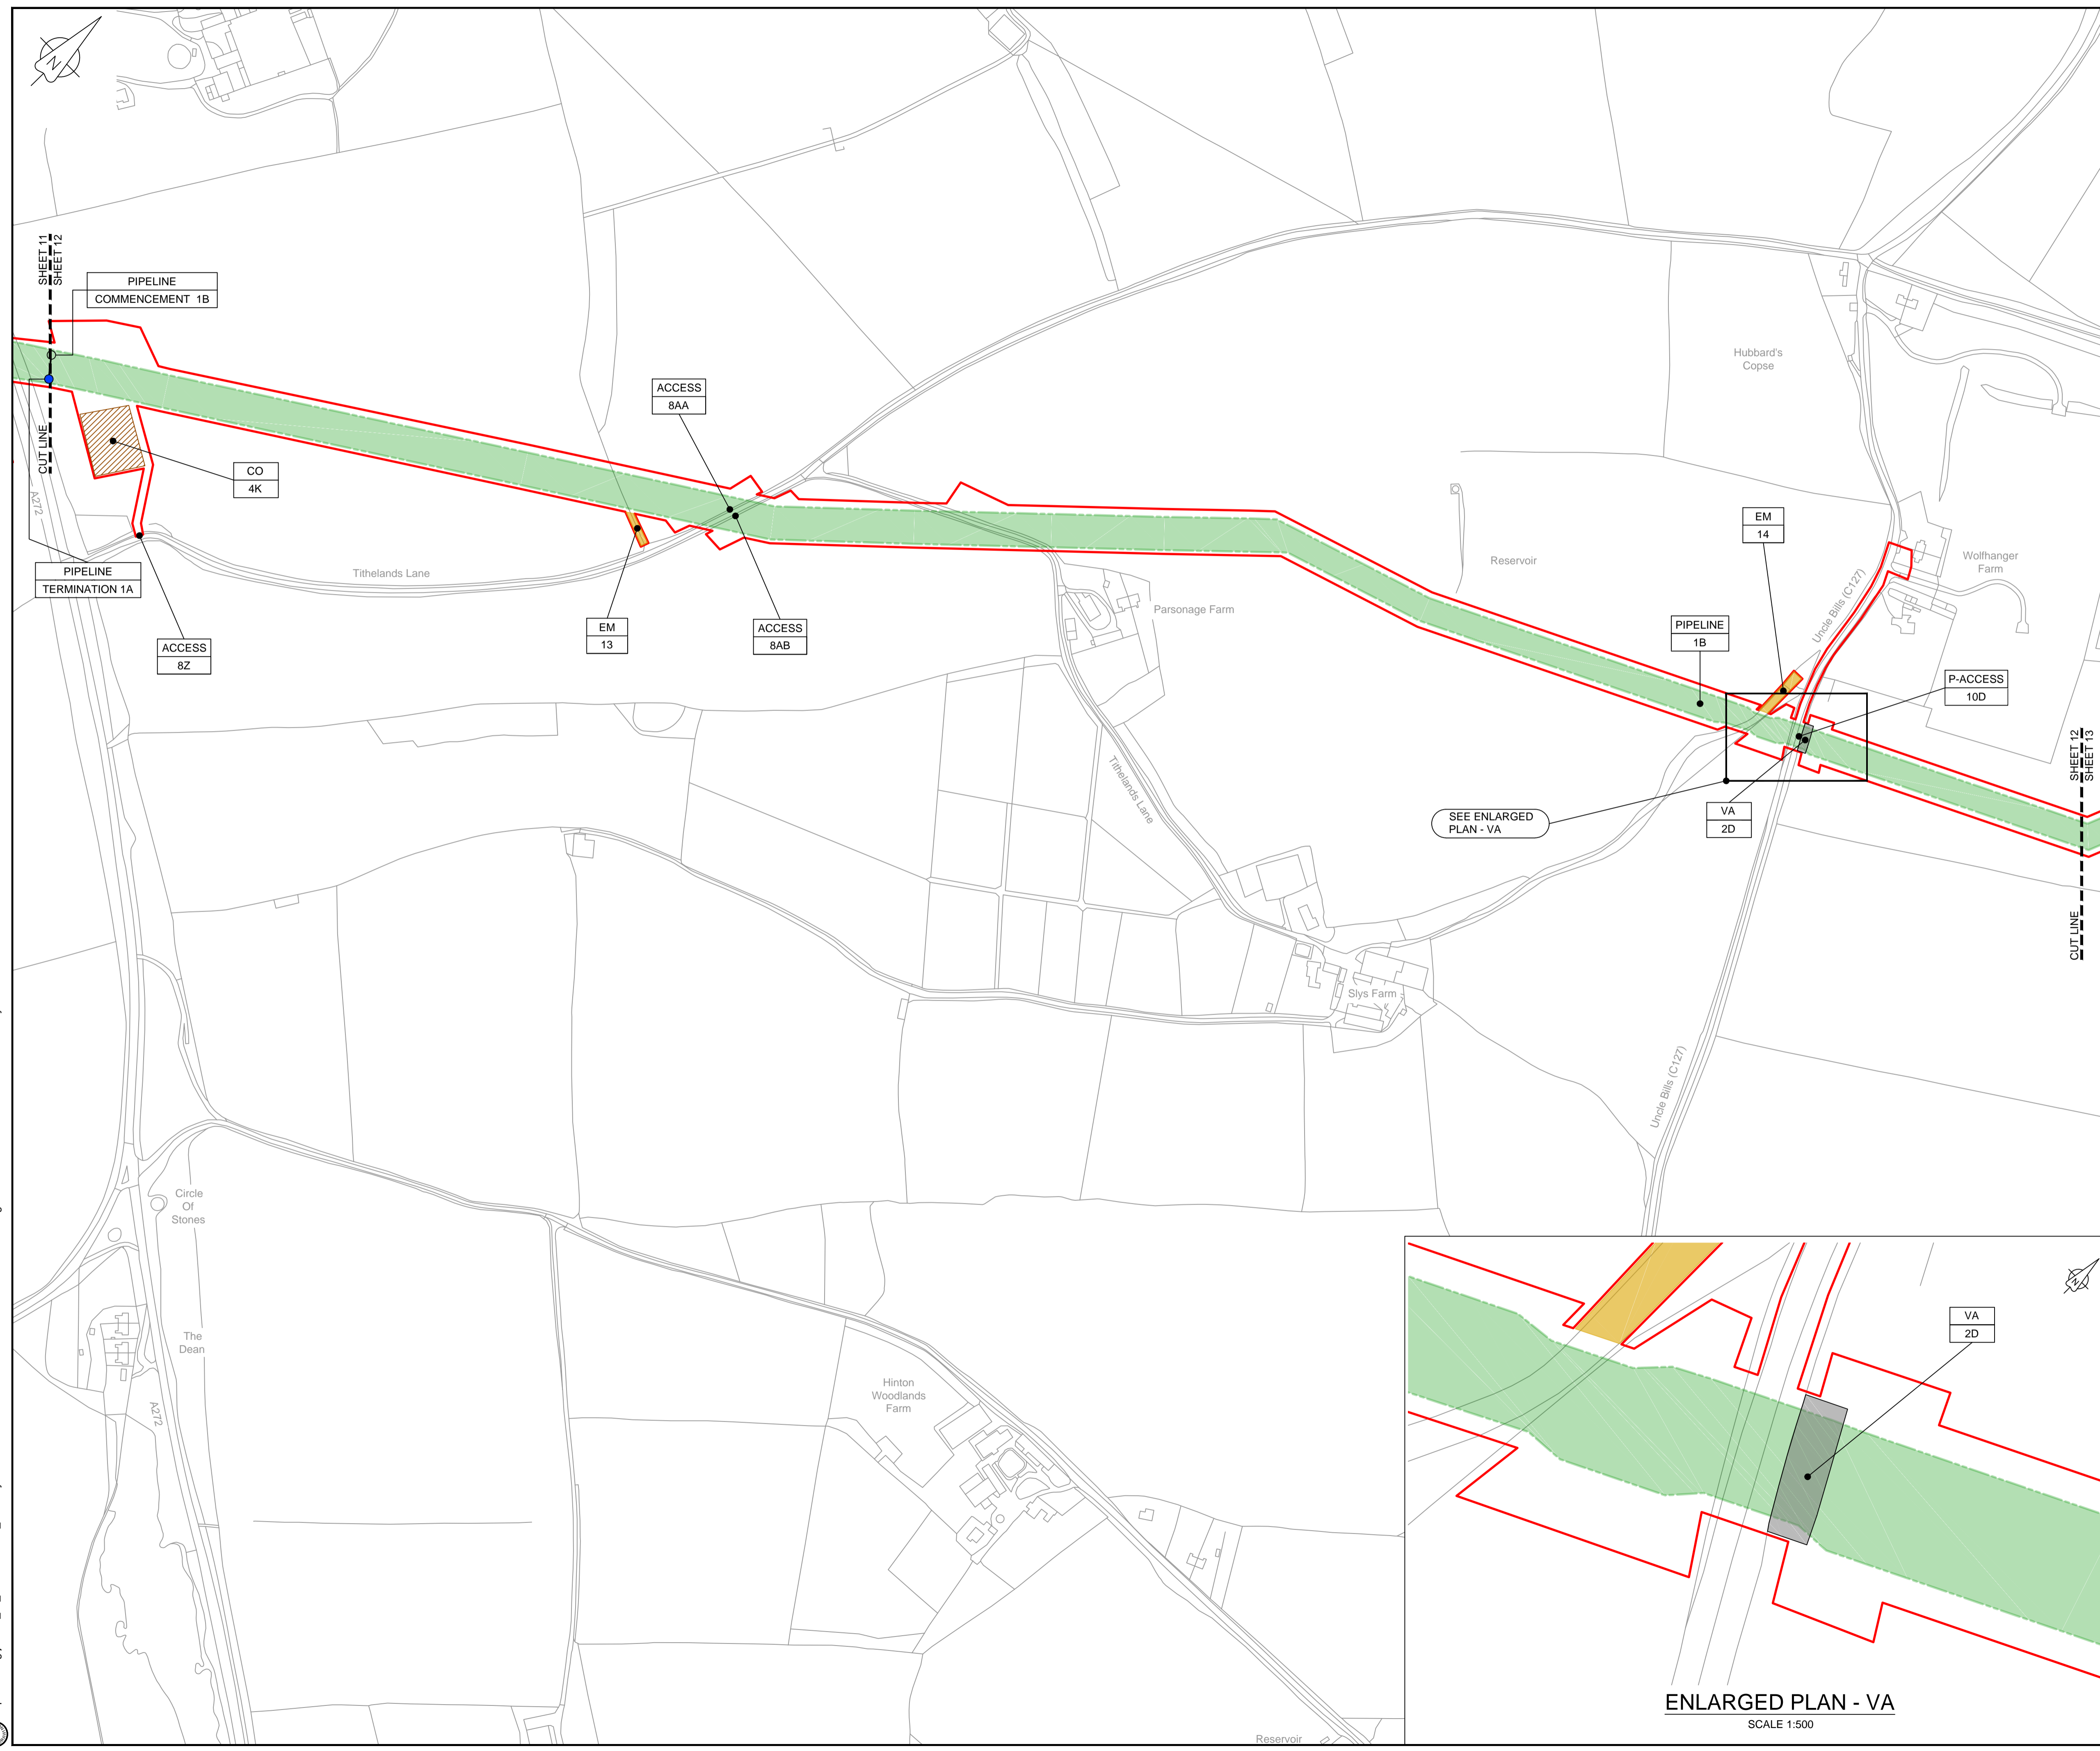

LOCATION PLAN  
SCALE 1:500,000

NOTES  
1. THIS DRAWING IS IN METRES UNLESS STATED OTHERWISE.


LEGEND

[Red line]	ORDER LIMITS
[Green shaded area]	LIMITS OF DEVIATION
[White box]	COMPOUND (CO)
[Yellow hatched area]	ENVIRONMENTAL MITIGATION AREA (EM)
[Grey shaded area]	ABOVE GROUND INSTALLATION (AGI) / VALVE (VA) / PRESSURE TRANSDUCER (PT)
[Black dot]	DESCRIPTION
[Black dot]	ID or WORK NUMBER (if applicable)
[Dashed line]	ACCESS
[Dashed line]	TEMPORARY CONSTRUCTION ACCESS
[Dashed line]	P-ACCESS
[Blue circle]	COMMENCEMENT / TERMINATION OF WORKS (COMMENCEMENT = OPEN, TERMINATION = CLOSED)

Contains Ordnance Survey data © Crown copyright and database rights 2019.  
© Crown copyright and database rights 2019 OS Licence Number AL100005237.



C02	19/06/19	SHEETS 36 AND 109 REVISED FOLLOWING SSI ADVICE	SH	JA	ND	PH
C03	09/09/19	SHEETS 10, 11 AND 54 REVISED TO WITHDRAW A2b SUB-OPTION	BT	JA	ND	NJ
Rev	Rev. Date	Purpose of revision	Drawn	Checked	Rev'd	Appr'd

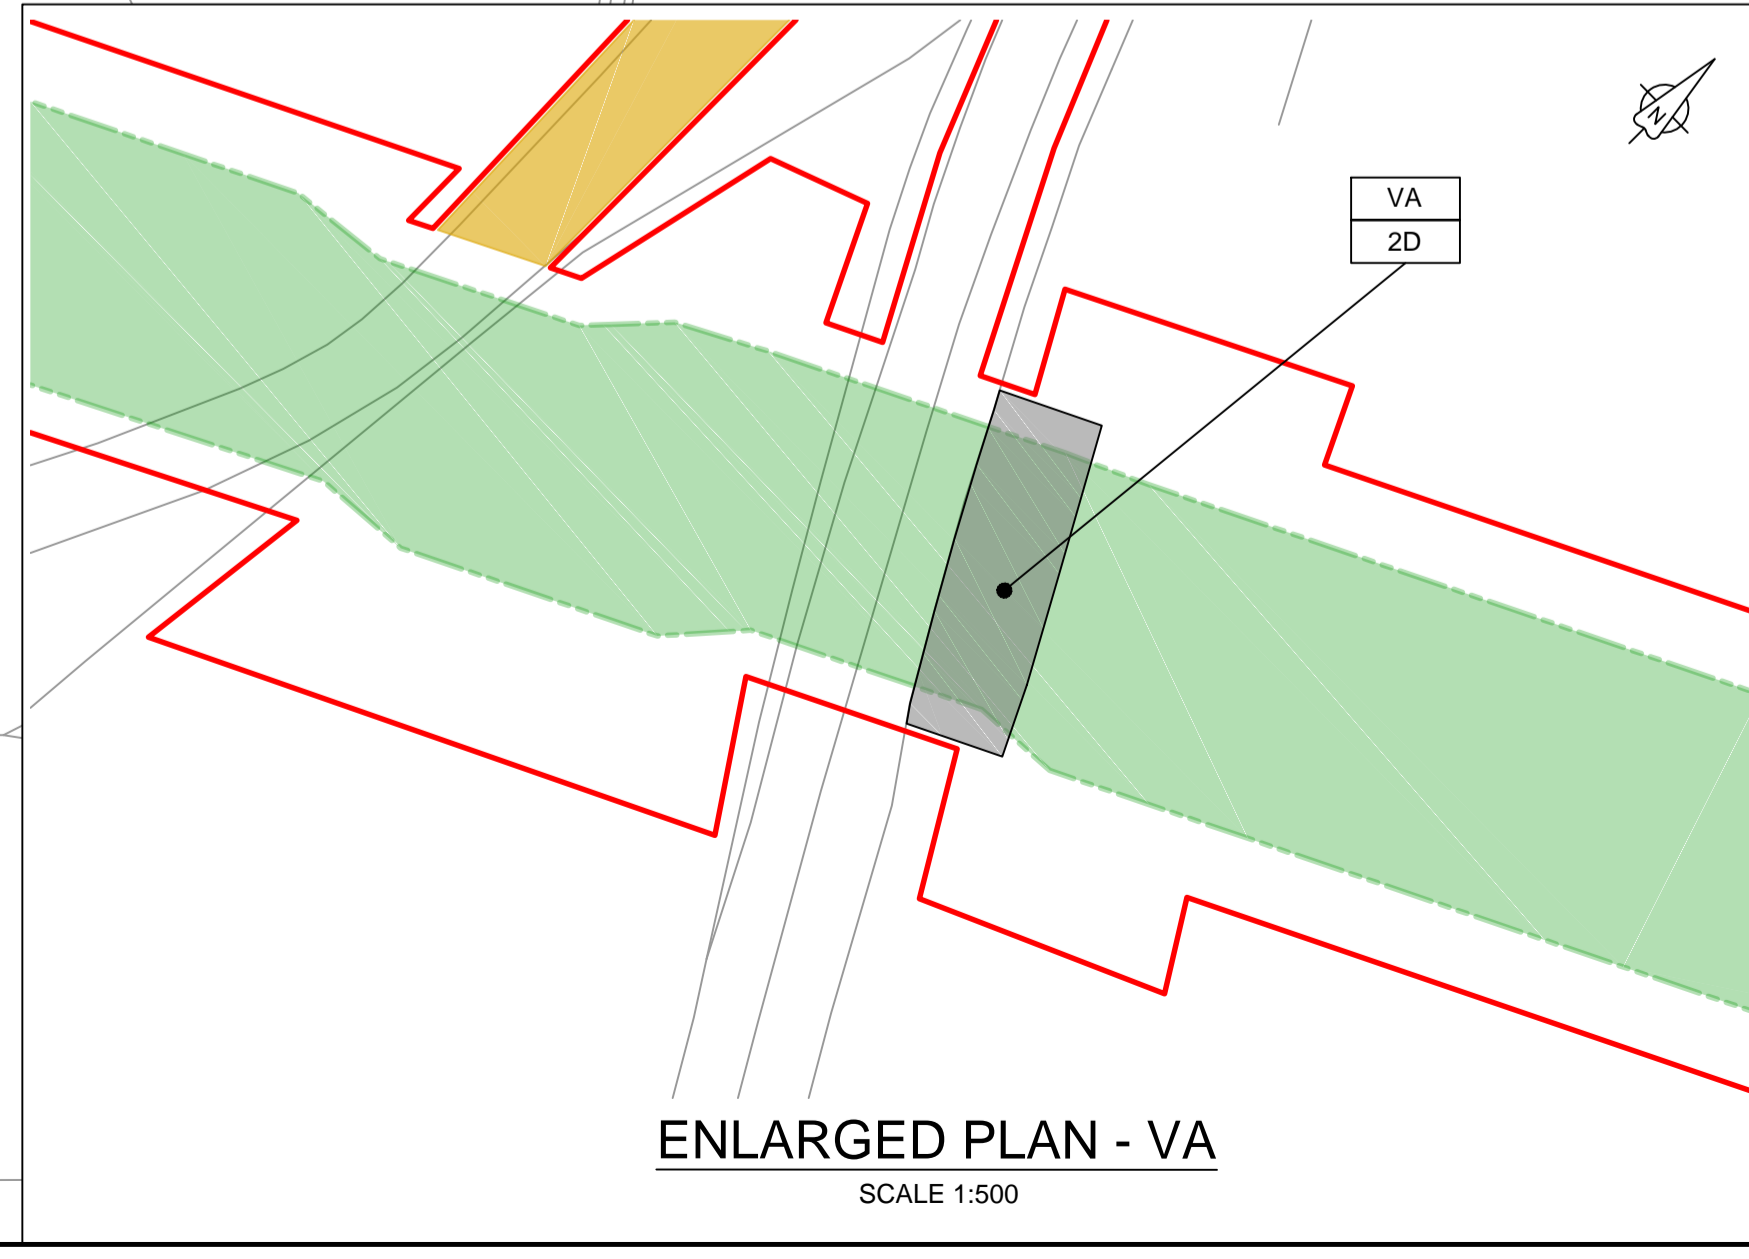

ENLARGED PLAN - VA  
SCALE 1:500

**JACOBS**  
1180 Eskdale Road, Wokingham, Wokingham, RG41 5TU  
Tel: +44(0)118 946 7000 Fax: +44(0)118 946 7001  
www.jacobs.com

Client: Esso Petroleum Company, Limited  
Emryn House,  
Emryn Way,  
Leatherhead,  
Surrey,  
KT22 8UX

Project: Southampton to London Pipeline Project


Drawing title: **WORKS PLAN SHEET 12 REGULATION 5 (2)(J)**

Drawing status: **Fit for Stage Approval**

Scale	1:2500	DO NOT SCALE
Jacobs No.	B2325300	Rev
Client no.		<b>C03</b>

Drawing number: **B2325300-JAC-000-CIV-DRG-000022**

© Copyright 2019 Jacobs U.K. Limited. The concepts and information contained in this document are the property of Jacobs. Use or copying of this document in whole or in part without the written permission of Jacobs constitutes an infringement of copyright. Limitation: This drawing has been prepared on behalf of, and for the exclusive use of, the Client, and is subject to, and issued in accordance with, the provisions of the contract between Jacobs and the Client. Jacobs accepts no liability or responsibility whatsoever for, or in respect of, any use of, or reliance upon, this drawing by any third party.

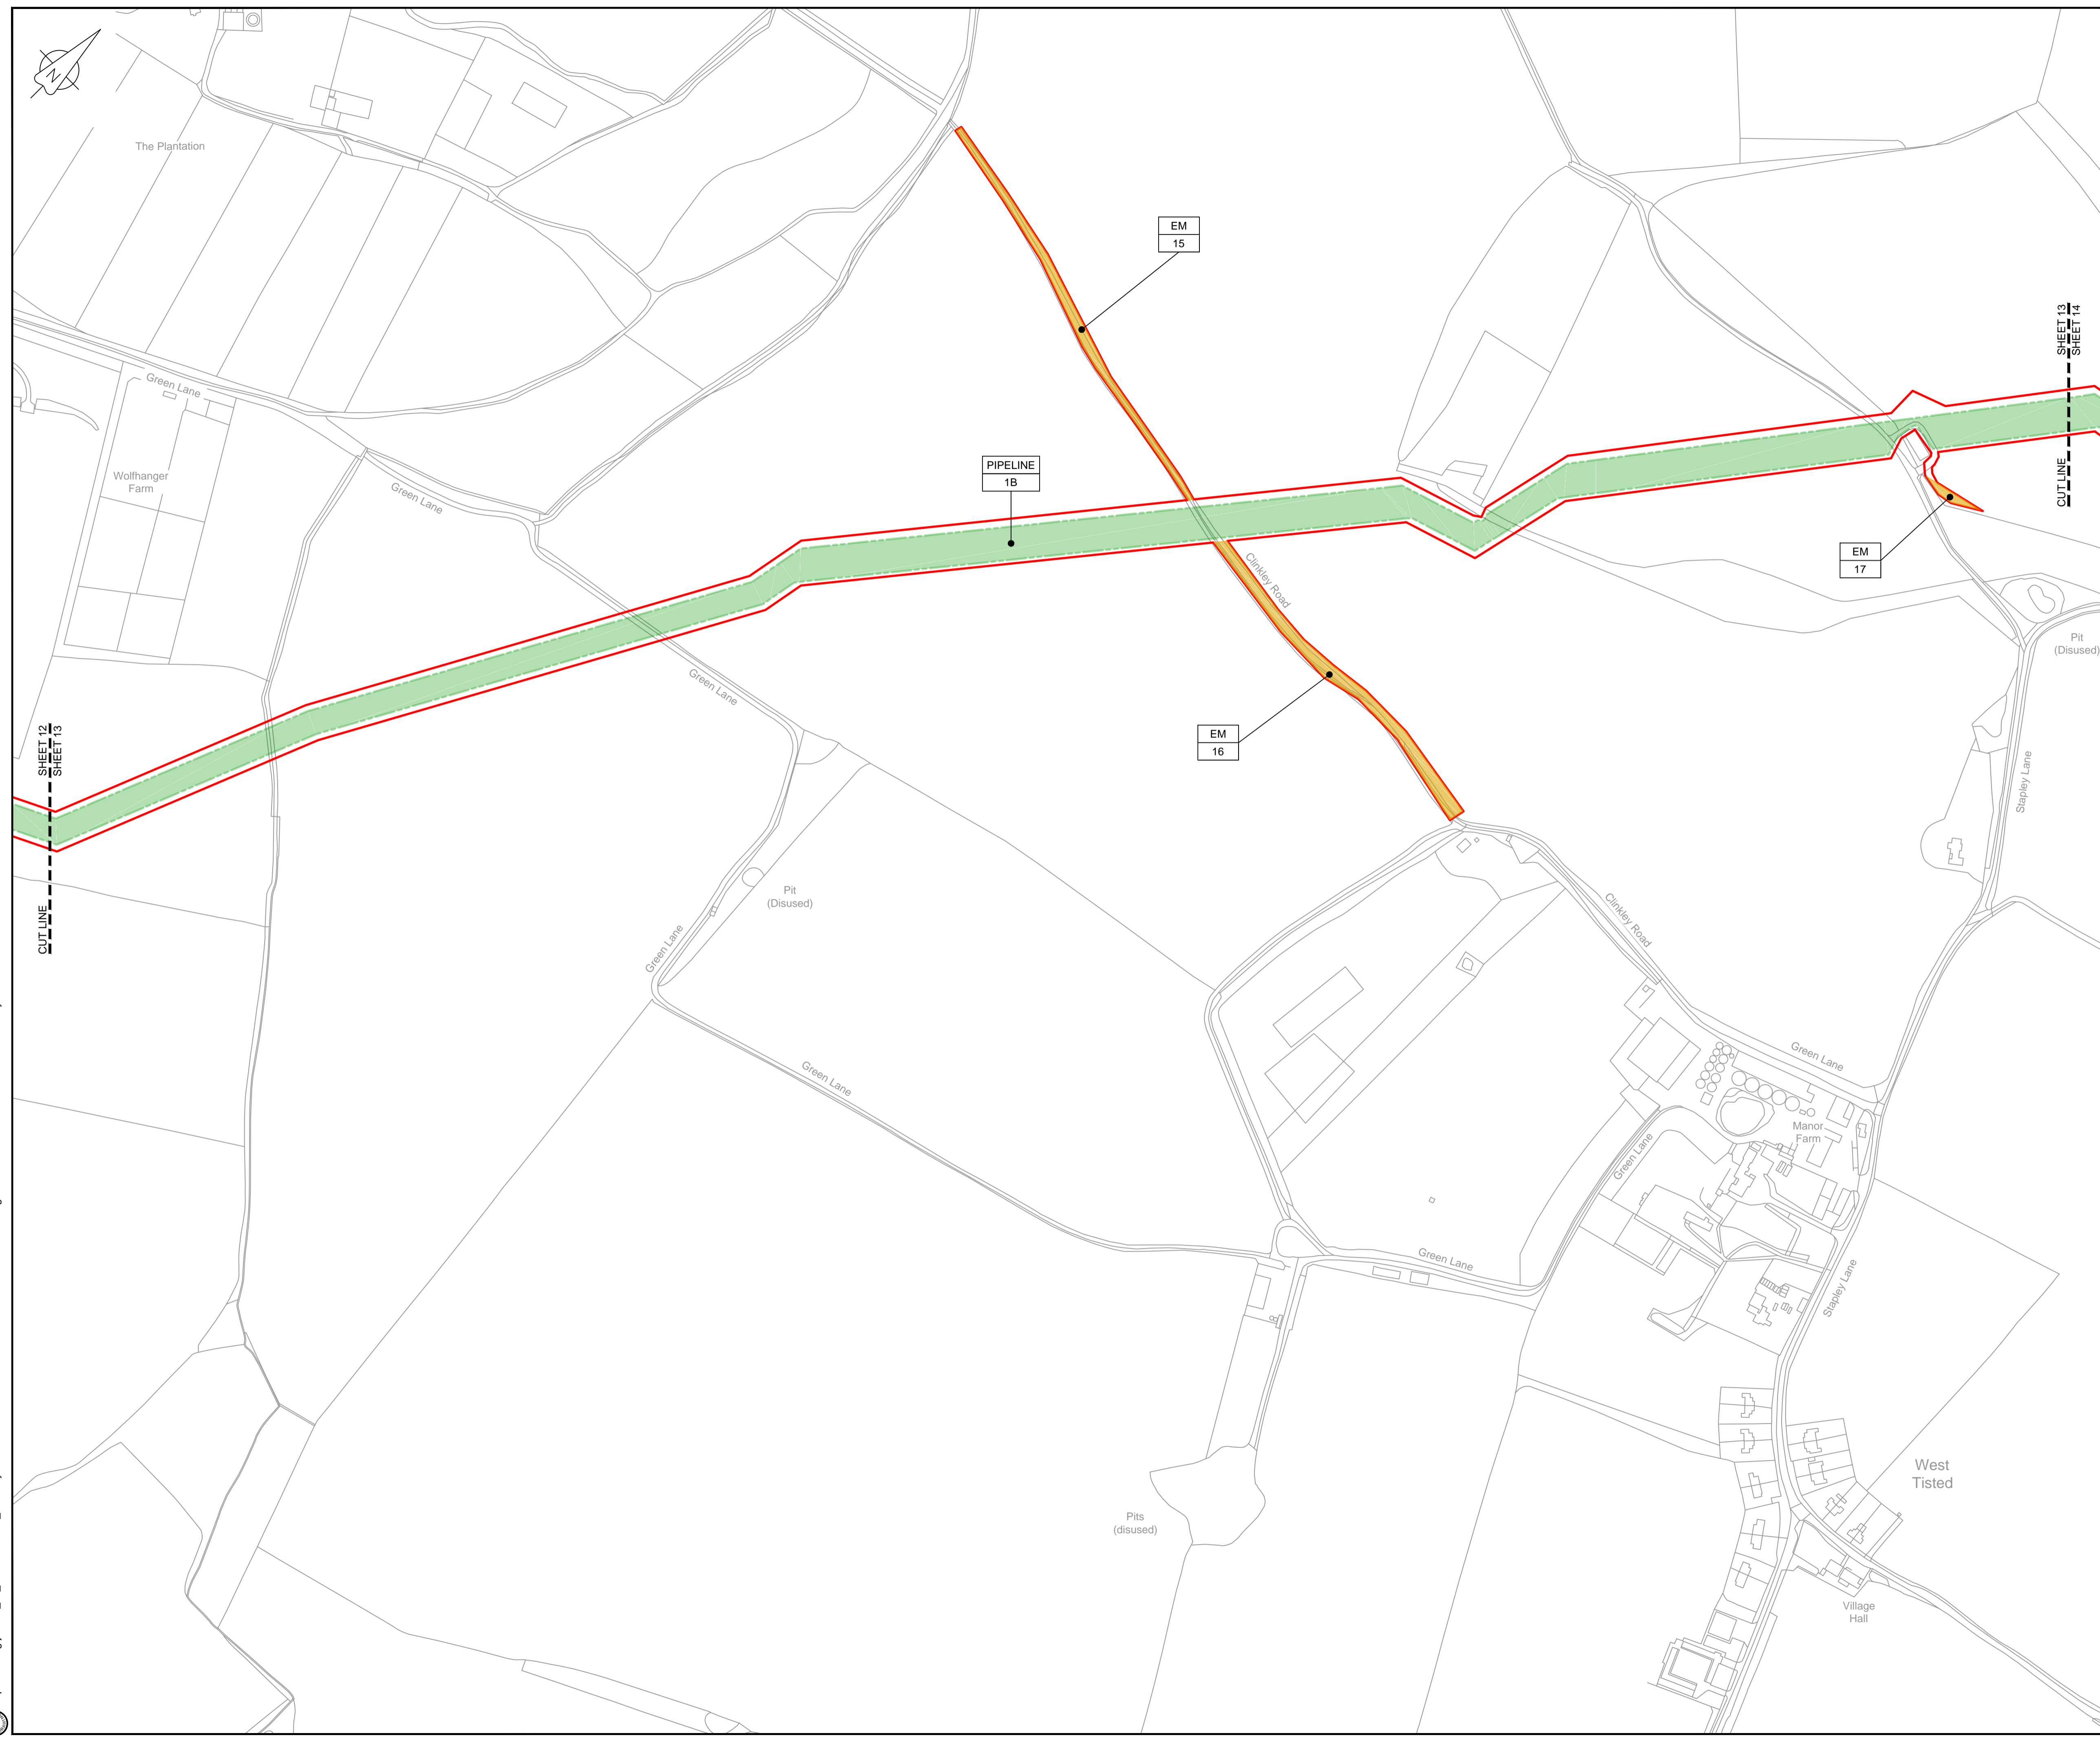


**LOCATION PLAN**  
SCALE 1:500,000

**NOTES**  
1. THIS DRAWING IS IN METRES UNLESS STATED OTHERWISE.

**LEGEND**

	ORDER LIMITS
	LIMITS OF DEVIATION
	COMPOUND (CO)
	ENVIRONMENTAL MITIGATION AREA (EM)
	ABOVE GROUND INSTALLATION (AGI) / VALVE (VA) / PRESSURE TRANSDUCER (PT)
	DESCRIPTION
	ID or WORK NUMBER (if applicable)
	ACCESS TEMPORARY CONSTRUCTION ACCESS
	P-ACCESS PERMANENT ACCESS
	COMMENCEMENT / TERMINATION OF WORKS (COMMENCEMENT = OPEN, TERMINATION = CLOSED)

Contains Ordnance Survey data © Crown copyright and database rights 2019.  
© Crown copyright and database rights 2019 OS Licence Number AL10005237.

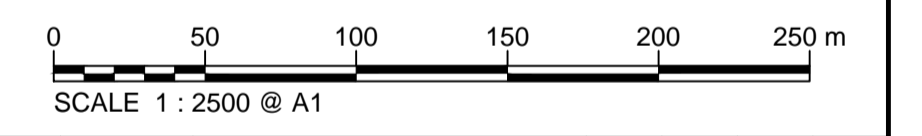

Rev	Rev. Date	Purpose of revision	Drawn	Checked	Rev'd	Appr'd
C02	19/06/19	SHEETS 36 AND 109 REVISED FOLLOWING SSI ADVICE	SH	JA	ND	PH
C03	09/09/19	SHEETS 10, 11 AND 54 REVISED TO WITHDRAW A2b SUB-OPTION	BT	JA	ND	NJ



Client: Esso Petroleum Company, Limited  
Emryn House,  
Emryn Way,  
Leatherhead,  
Surrey,  
KT22 8UX




Drawing title  
**WORKS PLAN  
SHEET 13  
REGULATION 5 (2)(J)**

Drawing status  
**Fit for Stage Approval**

Scale: 1:2500 DO NOT SCALE  
Jacobs No. B2325300 Rev. C03  
Client no.

Drawing number  
**B2325300-JAC-000-CIV-DRG-000023**

© Copyright 2019 Jacobs U.K. Limited. The concepts and information contained in this document are the property of Jacobs. Use or copying of this document in whole or in part without the written permission of Jacobs constitutes an infringement of copyright. Limitation: This drawing has been prepared on behalf of, and for the exclusive use of, the Client, and is subject to, and issued in accordance with, the provisions of the contract between Jacobs and the Client. Jacobs accepts no liability or responsibility whatsoever for, or in respect of, any use of, or reliance upon, this drawing by any third party.

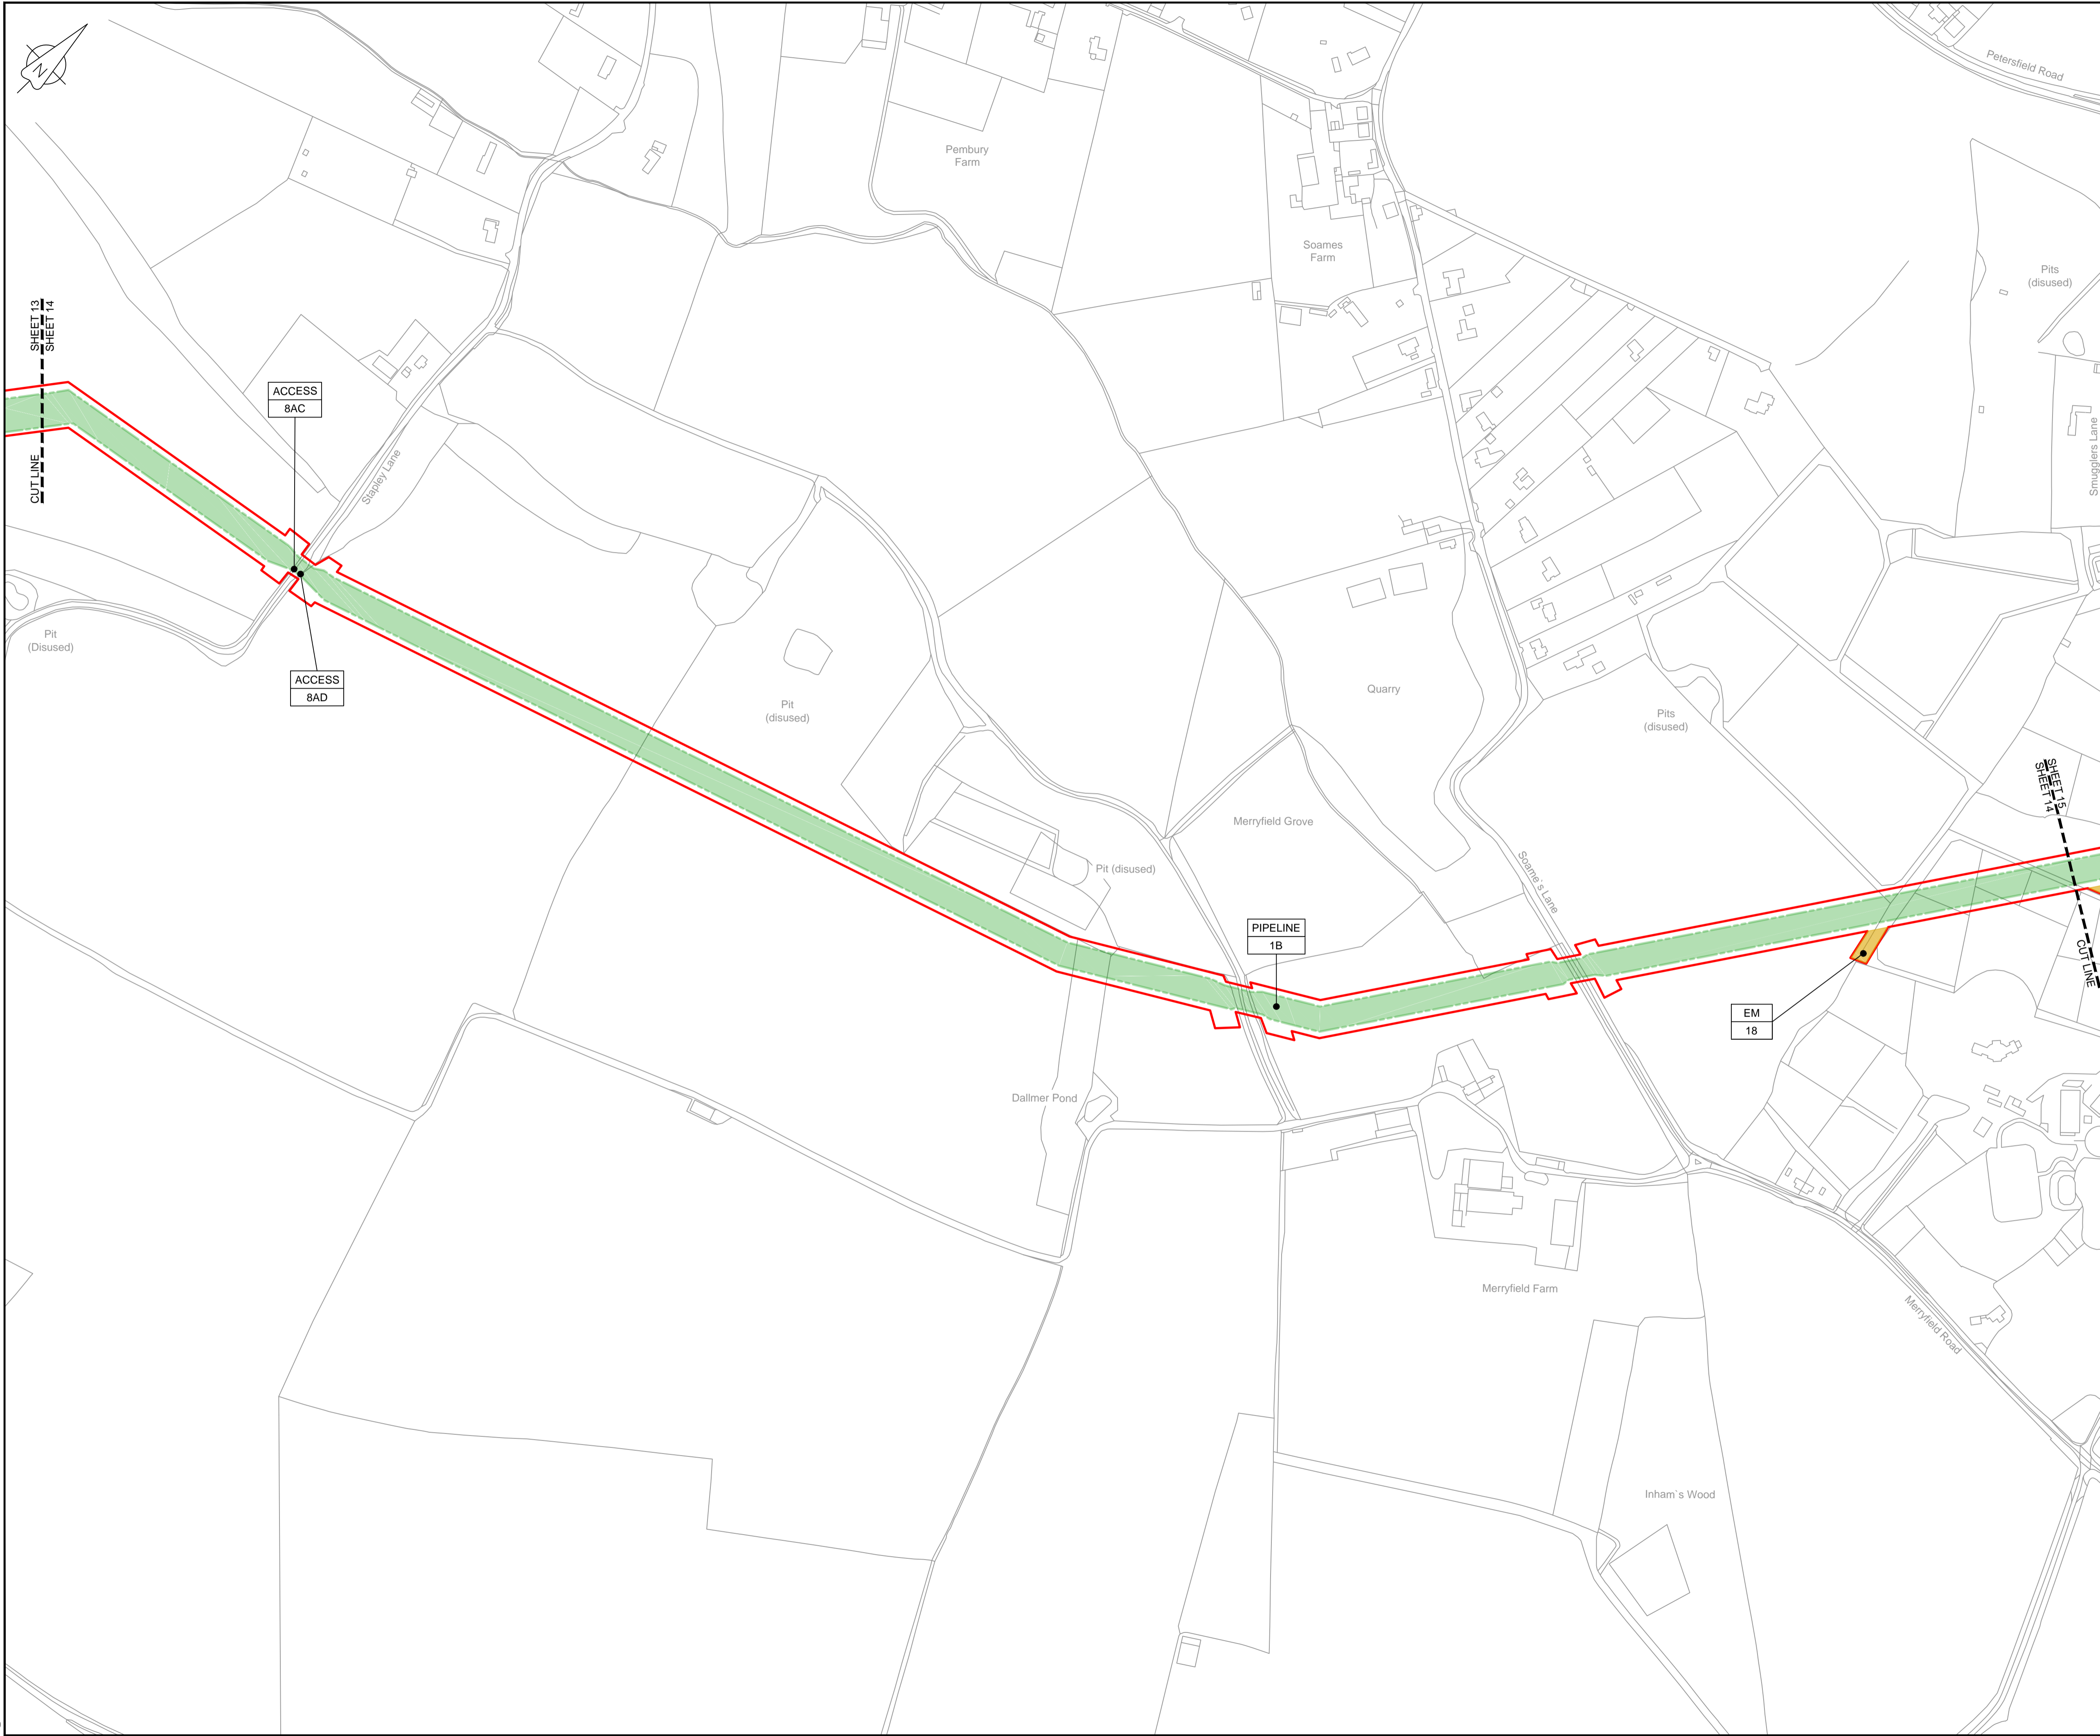


**LOCATION PLAN**  
SCALE 1:500,000

**NOTES**  
1. THIS DRAWING IS IN METRES UNLESS STATED OTHERWISE.

**LEGEND**

	ORDER LIMITS
	LIMITS OF DEVIATION
	COMPOUND (CO)
	ENVIRONMENTAL MITIGATION AREA (EM)
	ABOVE GROUND INSTALLATION (AGI) / VALVE (VA) / PRESSURE TRANSDUCER (PT)
	DESCRIPTION
	ID or WORK NUMBER (if applicable)
	ACCESS
	TEMPORARY CONSTRUCTION ACCESS
	P-ACCESS PERMANENT ACCESS
	COMMENCEMENT / TERMINATION OF WORKS (COMMENCEMENT = OPEN, TERMINATION = CLOSED)

Contains Ordnance Survey data © Crown copyright and database rights 2019.  
© Crown copyright and database rights 2019 OS Licence Number AL10005237.

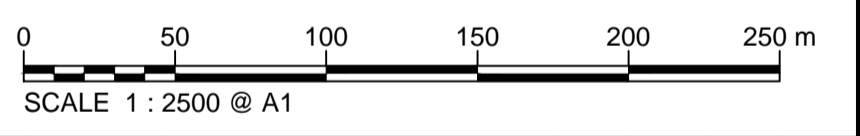

C02	19/06/19	SHEETS 36 AND 109 REVISED FOLLOWING SSI ADVICE	SH	JA	ND	PH
C03	09/09/19	SHEETS 10, 11 AND 54 REVISED TO WITHDRAW A2B SUB-OPTION	BT	JA	ND	NJ
Rev	Rev. Date	Purpose of revision	Drawn	Checked	Rev'd	Appr'd



1180 Eskdale Road, Winnersh, Wokingham, RG41 5TU  
Tel: +44(0)118 946 7000 Fax: +44(0)118 946 7001  
www.jacobs.com

Client: Esso Petroleum Company, Limited  
Emryn House,  
Emryn Way,  
Leatherhead,  
Surrey,  
KT22 8UX



Drawing title  
**WORKS PLAN  
SHEET 14  
REGULATION 5 (2)(J)**

Drawing status  
**Fit for Stage Approval**

Scale	1:2500	DO NOT SCALE
Jacobs No.	B2325300	Rev
Client no.		<b>C03</b>

Drawing number  
**B2325300-JAC-000-CIV-DRG-000024**

© Copyright 2019 Jacobs U.K. Limited. The concepts and information contained in this document are the property of Jacobs. Use or copying of this document in whole or in part without the written permission of Jacobs constitutes an infringement of copyright. Limitation: This drawing has been prepared on behalf of, and for the exclusive use of, the Client, and is subject to, and issued in accordance with, the provisions of the contract between Jacobs and the Client. Jacobs accepts no liability or responsibility whatsoever for, or in respect of, any use of, or reliance upon, this drawing by any third party.



**LOCATION PLAN**  
SCALE 1:500,000

**NOTES**  
1. THIS DRAWING IS IN METRES UNLESS STATED OTHERWISE.

**LEGEND**

	ORDER LIMITS
	LIMITS OF DEVIATION
	COMPOUND (CO)
	ENVIRONMENTAL MITIGATION AREA (EM)
	ABOVE GROUND INSTALLATION (AGI) / VALVE (VA) / PRESSURE TRANSDUCER (PT)
	DESCRIPTION
	ID or WORK NUMBER (if applicable)
	ACCESS
	TEMPORARY CONSTRUCTION ACCESS
	P-ACCESS
	PERMANENT ACCESS
	COMMENCEMENT / TERMINATION OF WORKS (COMMENCEMENT = OPEN, TERMINATION = CLOSED)

Contains Ordnance Survey data © Crown copyright and database rights 2019.  
© Crown copyright and database rights 2019 OS Licence Number AL100005237.



C02	19/06/19	SHEETS 36 AND 109 REVISED FOLLOWING SSI ADVICE	SH	JA	ND	PH
C03	09/09/19	SHEETS 10, 11 AND 54 REVISED TO WITHDRAW A2b SUB-OPTION	BT	JA	ND	NJ
Rev	Rev. Date	Purpose of revision	Drawn	Checked	Rev'd	Appr'd



1180 Eskdale Road, Winnersh, Wokingham, RG41 5TU  
Tel:+44(0)118 946 7000 Fax:+44(0)118 946 7001  
www.jacobs.com

Client: Esso Petroleum Company, Limited  
Ermyn House,  
Ermyn Way,  
Leatherhead,  
Surrey,  
KT22 8UX




Drawing title  
**WORKS PLAN  
SHEET 15  
REGULATION 5 (2)(J)**

Drawing status  
**Fit for Stage Approval**

Scale	1:2500	DO NOT SCALE
Jacobs No.	B2325300	Rev
Client no.		<b>C03</b>

Drawing number  
**B2325300-JAC-000-CIV-DRG-000025**

© Copyright 2019 Jacobs U.K. Limited. The concepts and information contained in this document are the property of Jacobs. Use or copying of this document in whole or in part without the written permission of Jacobs constitutes an infringement of copyright. Limitation: This drawing has been prepared on behalf of, and for the exclusive use of, the Client, and is subject to, and issued in accordance with, the provisions of the contract between Jacobs and the Client. Jacobs accepts no liability or responsibility whatsoever for, or in respect of, any use of, or reliance upon, this drawing by any third party.

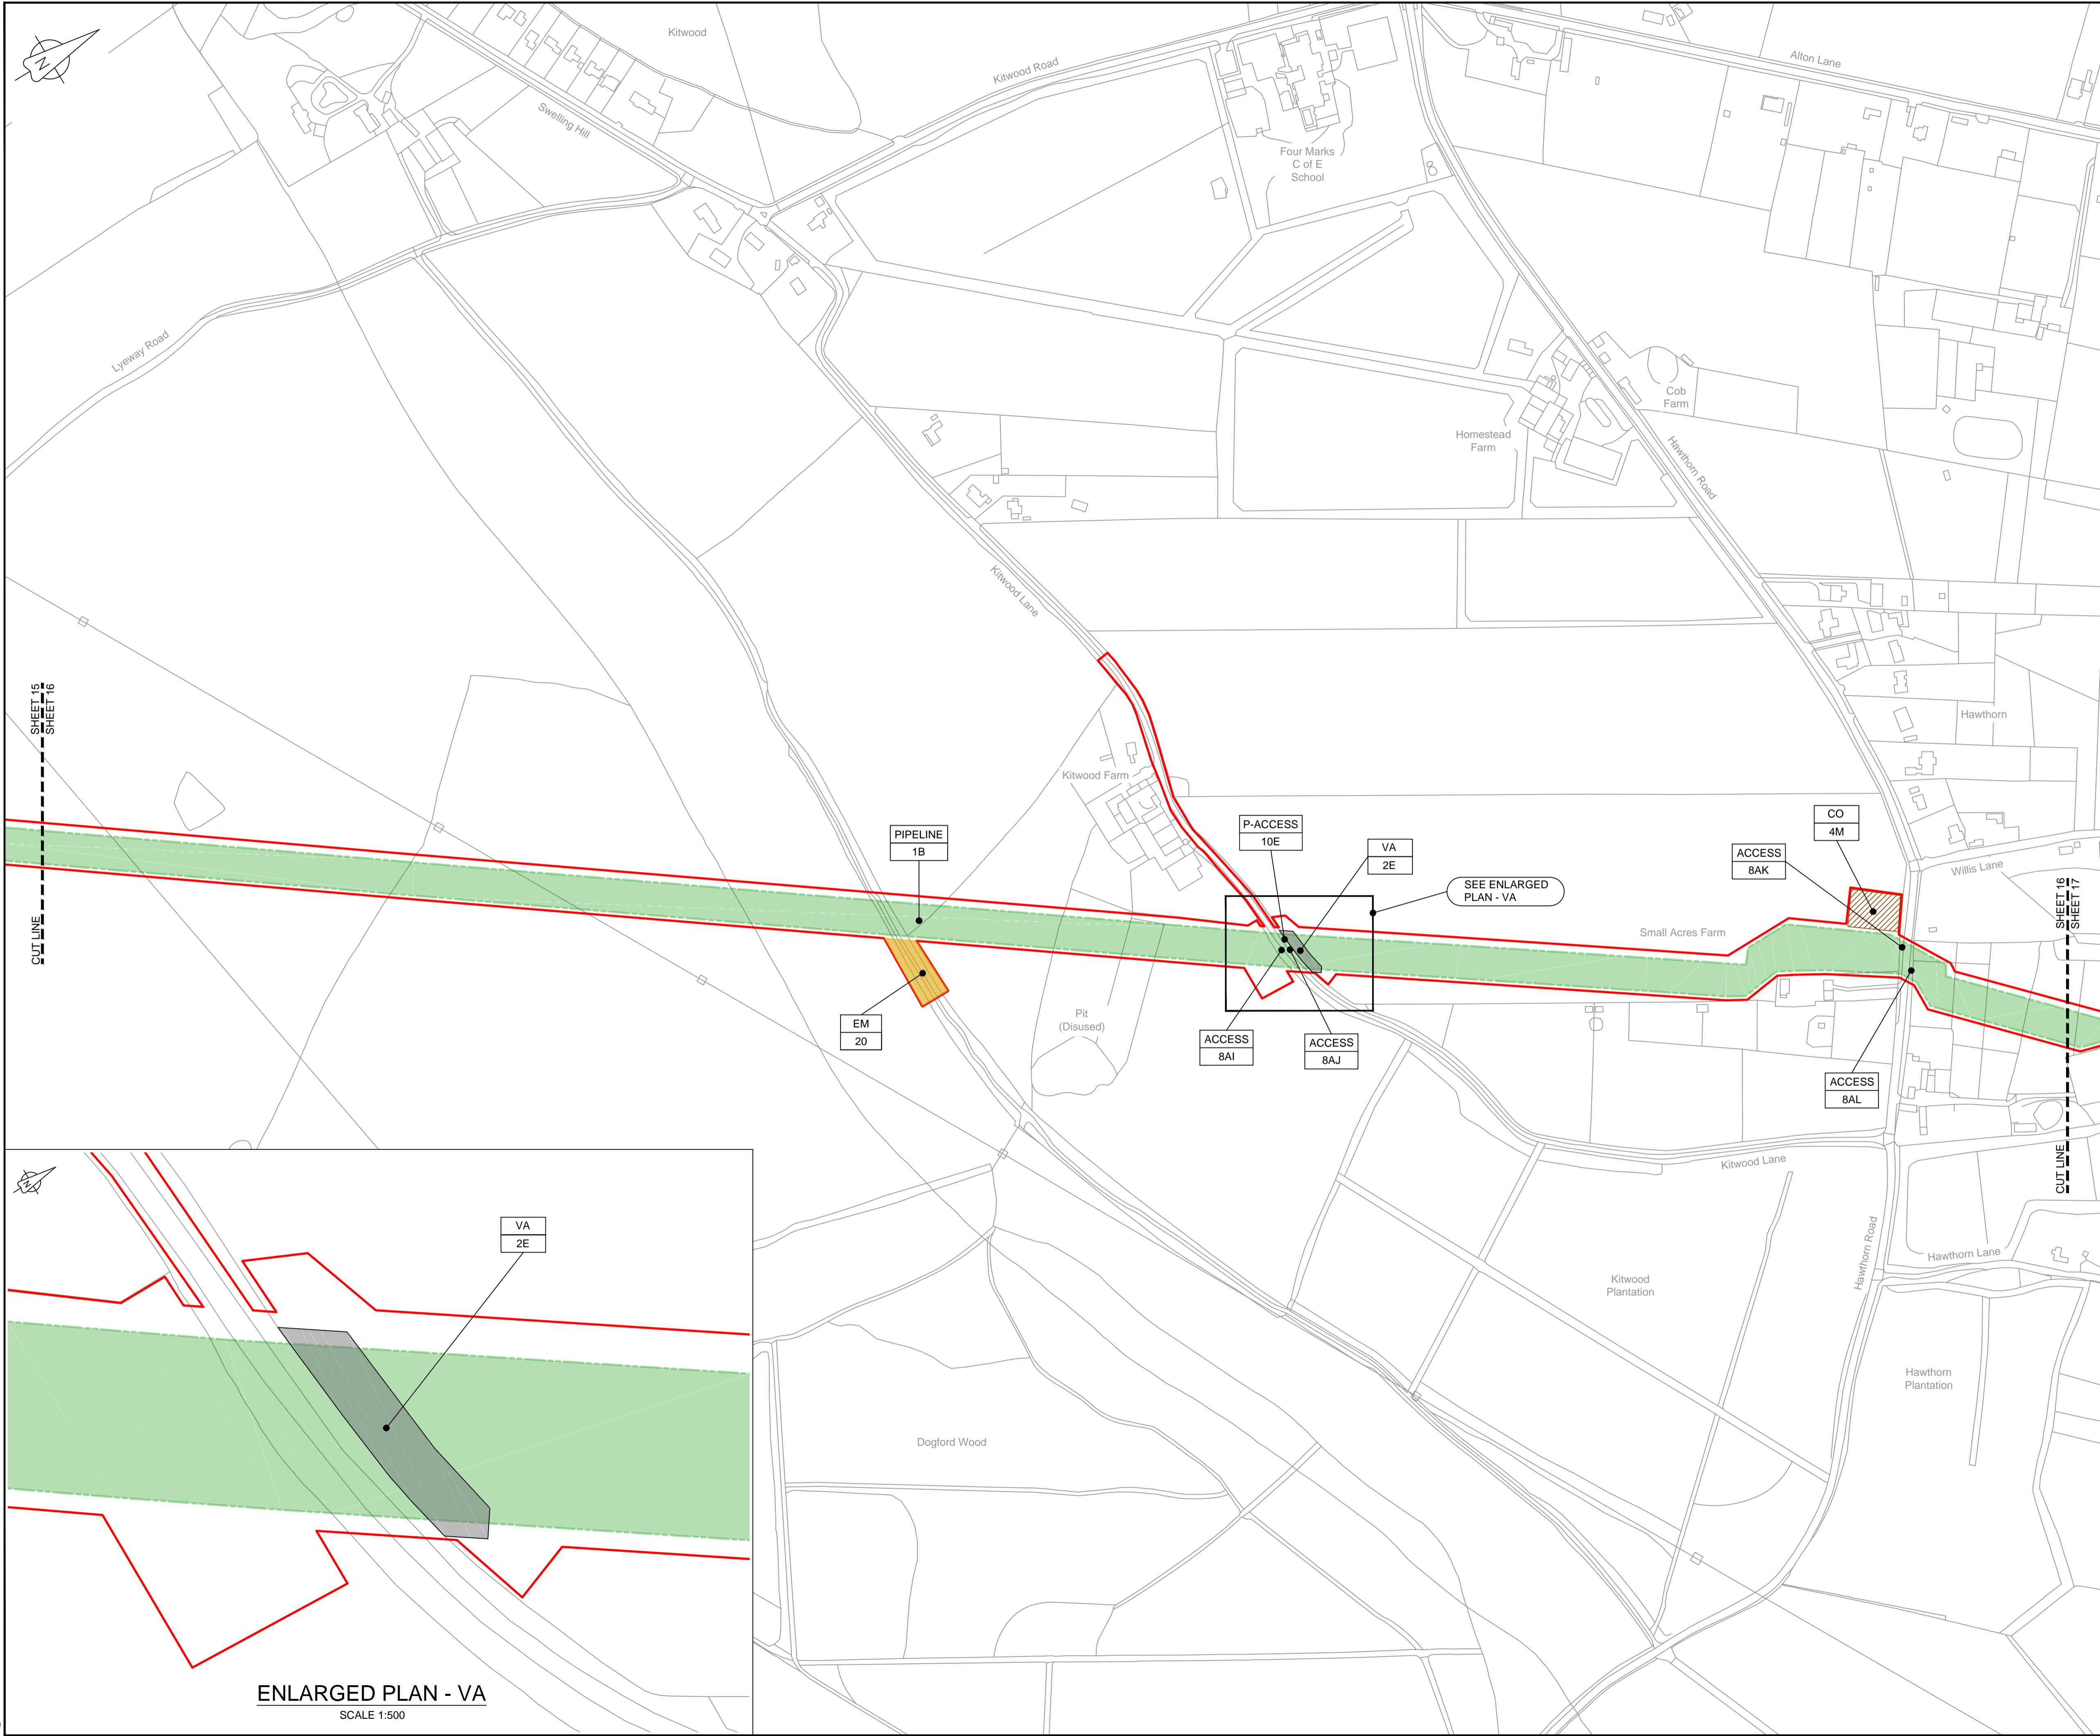

LOCATION PLAN  
SCALE 1:500,000

**NOTES**  
1. THIS DRAWING IS IN METRES UNLESS STATED OTHERWISE.

**LEGEND**

[Red line]	ORDER LIMITS
[Green shaded area]	LIMITS OF DEVIATION
[Hatched area]	COMPOUND (CO)
[Yellow shaded area]	ENVIRONMENTAL MITIGATION AREA (EM)
[Grey shaded area]	ABOVE GROUND INSTALLATION (AGI) / VALVE (VA) / PRESSURE TRANSDUCER (PT)
[Symbol]	DESCRIPTION
[Symbol]	ID or WORK NUMBER (if applicable)
[Symbol]	ACCESS
[Symbol]	TEMPORARY CONSTRUCTION ACCESS
[Symbol]	PERMANENT ACCESS
[Symbol]	COMMENCEMENT / TERMINATION OF WORKS (COMMENCEMENT = OPEN, TERMINATION = CLOSED)

Contains Ordnance Survey data © Crown copyright and database rights 2019.  
© Crown copyright and database rights 2019 OS Licence Number AL100005237.



C02	19/06/19	SHEETS 36 AND 109 REVISED FOLLOWING SSI ADVICE	SH	JA	ND	PH
C03	09/09/19	SHEETS 10, 11 AND 54 REVISED TO WITHDRAW A2b SUB-OPTION	BT	JA	ND	NJ
Rev	Rev. Date	Purpose of revision	Drawn	Checked	Rev'd	Appr'd

**JACOBS**  
1180 Eskdale Road, Wokingham, Wokingham, RG41 5TU  
Tel: +44(0)118 946 7000 Fax: +44(0)118 946 7001  
www.jacobs.com

Client: Esso Petroleum Company, Limited  
Emryn House,  
Emryn Way,  
Leatherhead,  
Surrey,  
KT22 8UX

Project: Southampton to London Pipeline Project

Drawing title: **WORKS PLAN SHEET 16 REGULATION 5 (2)(J)**

Drawing status: **Fit for Stage Approval**


Scale	1:2500	DO NOT SCALE
Jacobs No.	B2325300	Rev
Client no.		<b>C03</b>

Drawing number: **B2325300-JAC-000-CIV-DRG-000026**

© Copyright 2019 Jacobs U.K. Limited. The concepts and information contained in this document are the property of Jacobs. Use or copying of this document in whole or in part without the written permission of Jacobs constitutes an infringement of copyright. Limitation. This drawing has been prepared on behalf of, and for the exclusive use of, the Client, and is subject to, and issued in accordance with, the provisions of the contract between Jacobs and the Client. Jacobs accepts no liability or responsibility whatsoever for, or in respect of, any use of, or reliance upon, this drawing by any third party.

C:\pwworking\jacobs\_uk\_water&utilities\_ssf\libray\ordms33519\B2325300-JAC-000-CIV-DRG-000026.dwg - 10/09/2019 11:07:17 - A1Frame - BTaylor

ENLARGED PLAN - VA  
SCALE 1:500

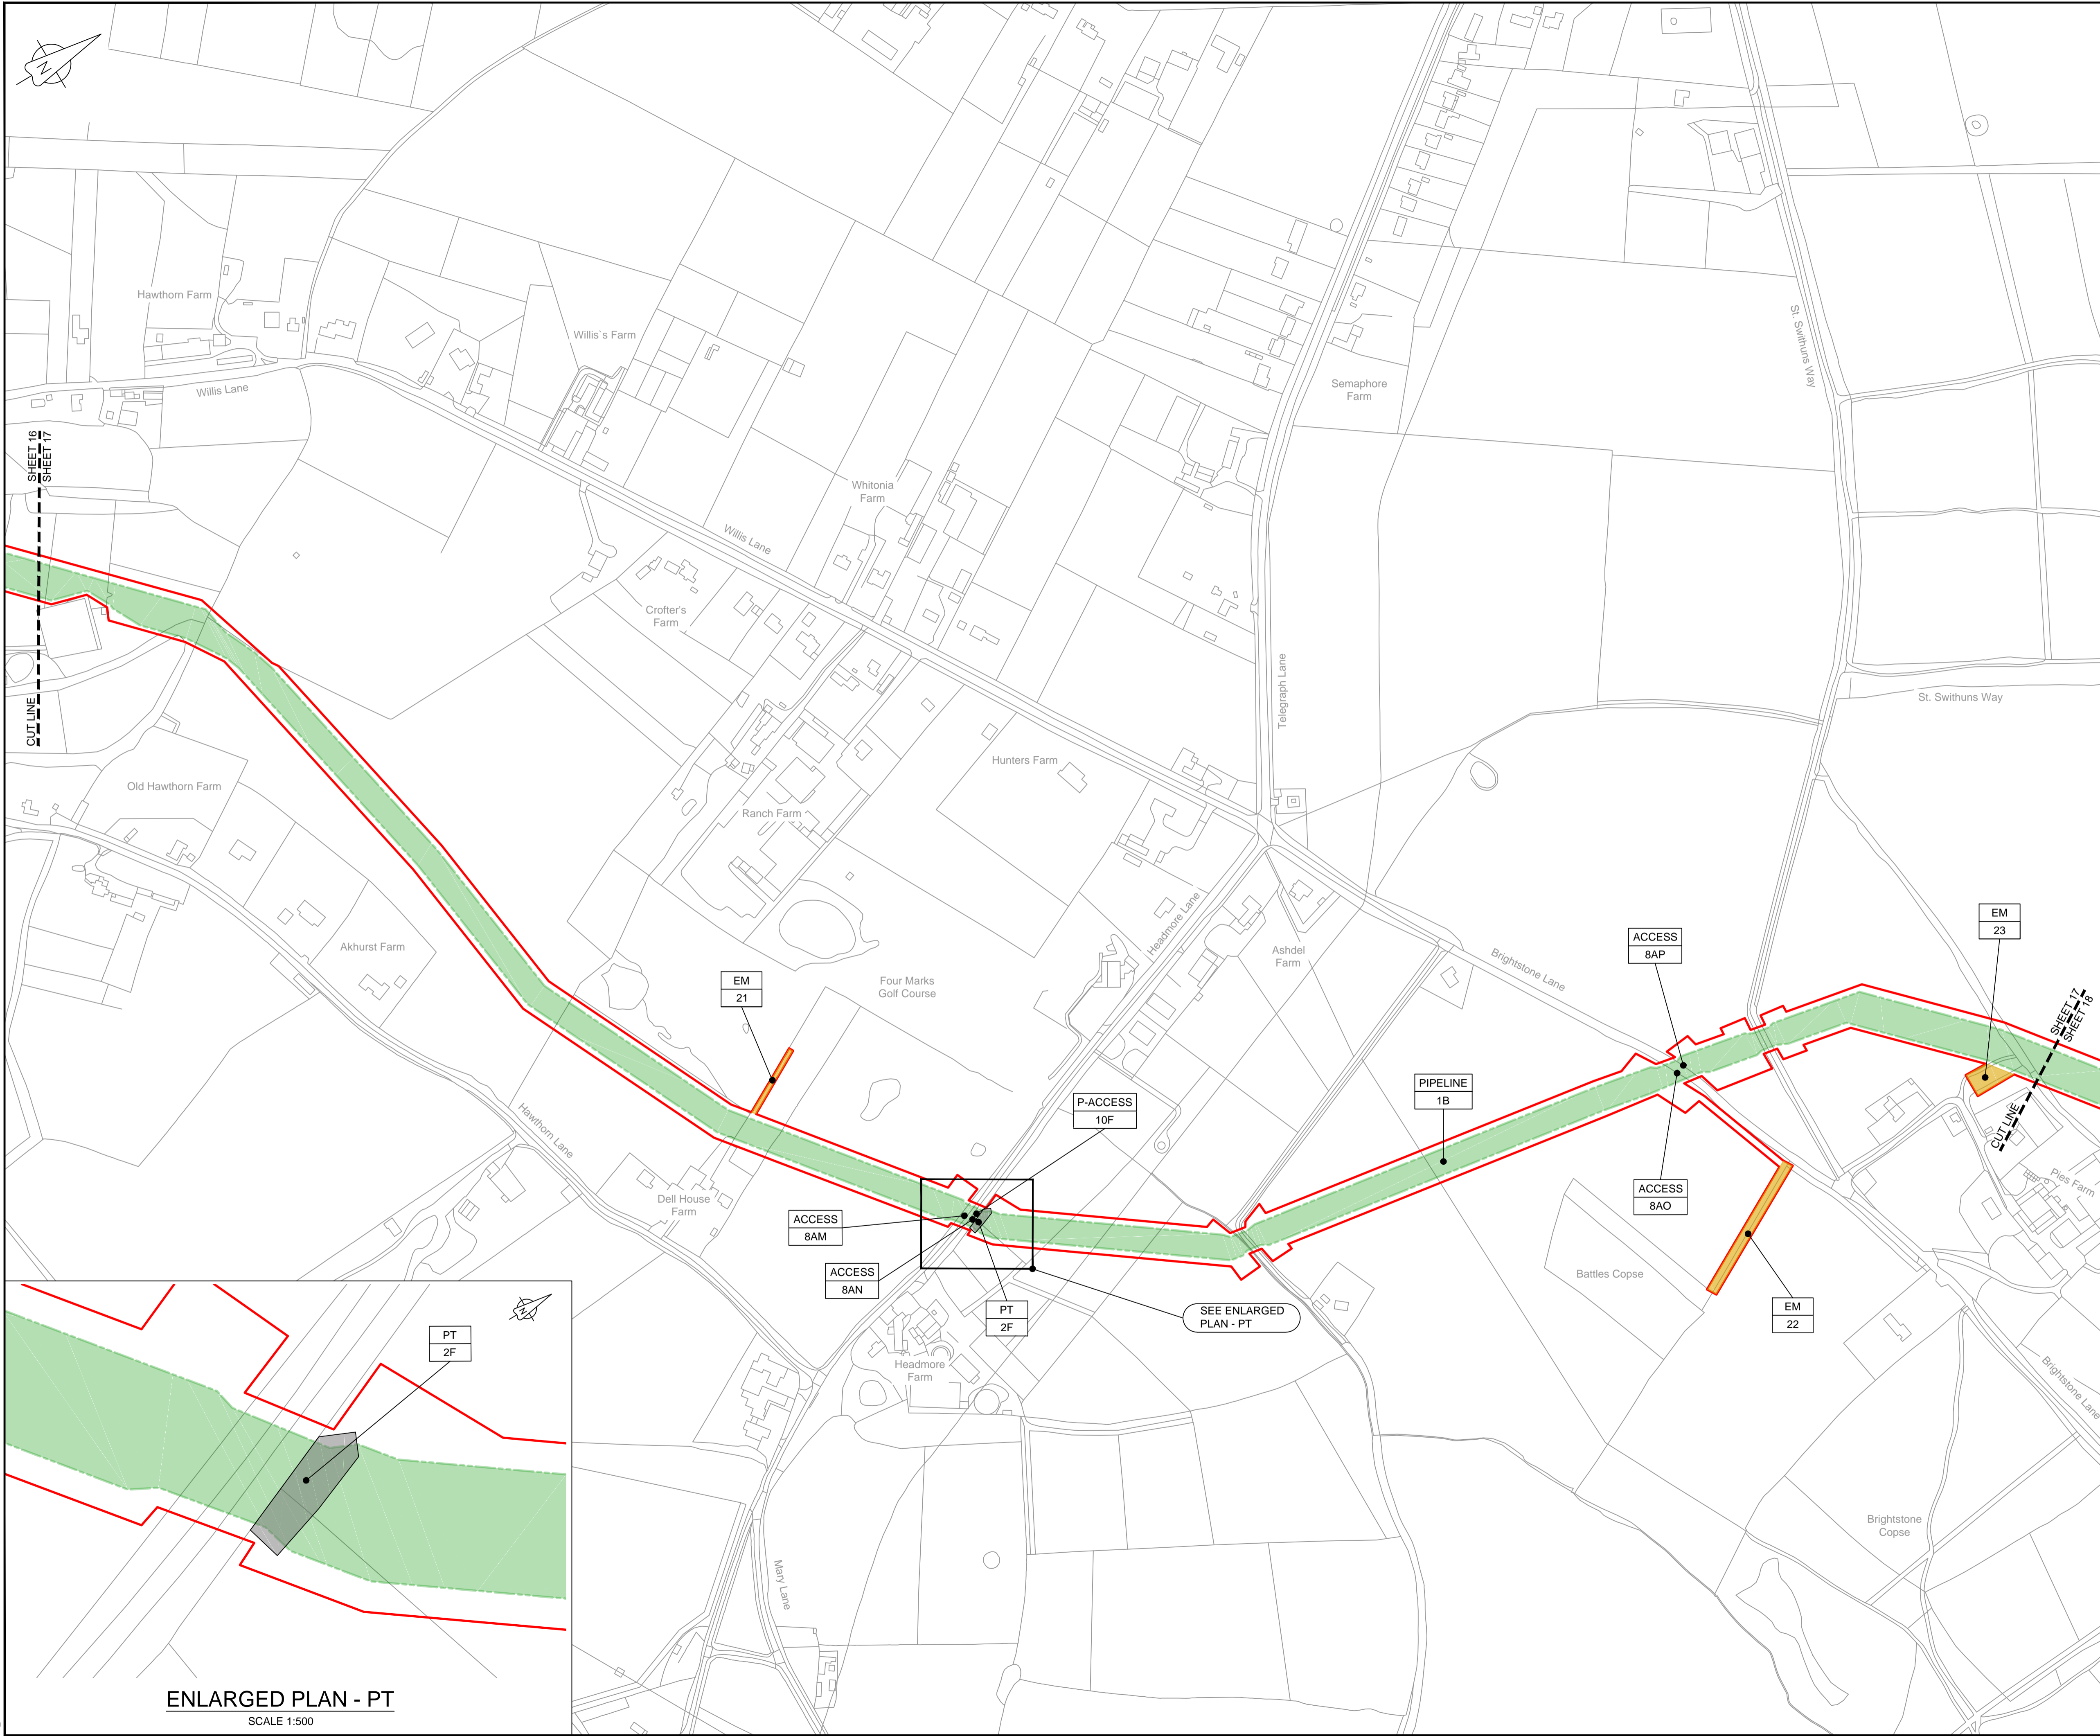


**LOCATION PLAN**  
SCALE 1:500,000

**NOTES**  
1. THIS DRAWING IS IN METRES UNLESS STATED OTHERWISE.

**LEGEND**

	ORDER LIMITS
	LIMITS OF DEVIATION
	COMPOUND (CO)
	ENVIRONMENTAL MITIGATION AREA (EM)
	ABOVE GROUND INSTALLATION (AGI) / VALVE (VA) / PRESSURE TRANSDUCER (PT)
	DESCRIPTION
	ID or WORK NUMBER (if applicable)
	ACCESS TEMPORARY CONSTRUCTION ACCESS
	P-ACCESS PERMANENT ACCESS
	COMMENCEMENT / TERMINATION OF WORKS (COMMENCEMENT = OPEN, TERMINATION = CLOSED)

Contains Ordnance Survey data © Crown copyright and database rights 2019.  
© Crown copyright and database rights 2019 OS Licence Number AL10005237.

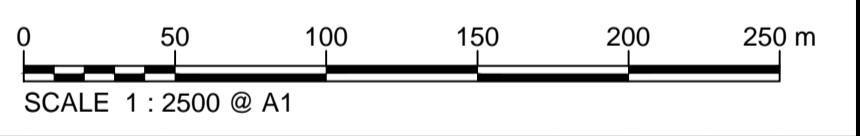

Rev	Rev. Date	Purpose of revision	Drawn	Checked	Rev'd	Appr'd
C02	19/06/19	SHEETS 35 AND 109 REVISED FOLLOWING SSI ADVICE	SH	JA	ND	PH
C03	09/09/19	SHEETS 10, 11 AND 54 REVISED TO WITHDRAW A2B SUB-OPTION	BT	JA	ND	NJ

**JACOBS**

1180 Eskdale Road, Winnersh, Wokingham, RG41 5TU  
Tel: +44(0)118 946 7000 Fax: +44(0)118 946 7001  
www.jacobs.com

Client: Esso Petroleum Company, Limited  
Emryn House,  
Emryn Way,  
Leatherhead,  
Surrey,  
KT22 8UX

Project: Southampton to London Pipeline Project

Drawing title: **WORKS PLAN SHEET 17 REGULATION 5 (2)(J)**

Drawing status: **Fit for Stage Approval**

Scale	1:2500	DO NOT SCALE
Jacobs No.	B2325300	Rev
Client no.		<b>C03</b>


Drawing number: **B2325300-JAC-000-CIV-DRG-000027**

© Copyright 2019 Jacobs U.K. Limited. The concepts and information contained in this document are the property of Jacobs. Use or copying of this document in whole or in part without the written permission of Jacobs constitutes an infringement of copyright. Limitation: This drawing has been prepared on behalf of, and for the exclusive use of, the Client. Jacobs accepts no liability or responsibility whatsoever for, or in respect of, any use of, or reliance upon, this drawing by any third party.

C:\pwworking\jacobs\_uk\_water\utilities\_ssf\lby\ordms33519\B2325300-JAC-000-CIV-DRG-000027.dwg - 10/09/2019 11:08:43 - A1Frame - BTaylor

**ENLARGED PLAN - PT**  
SCALE 1:500



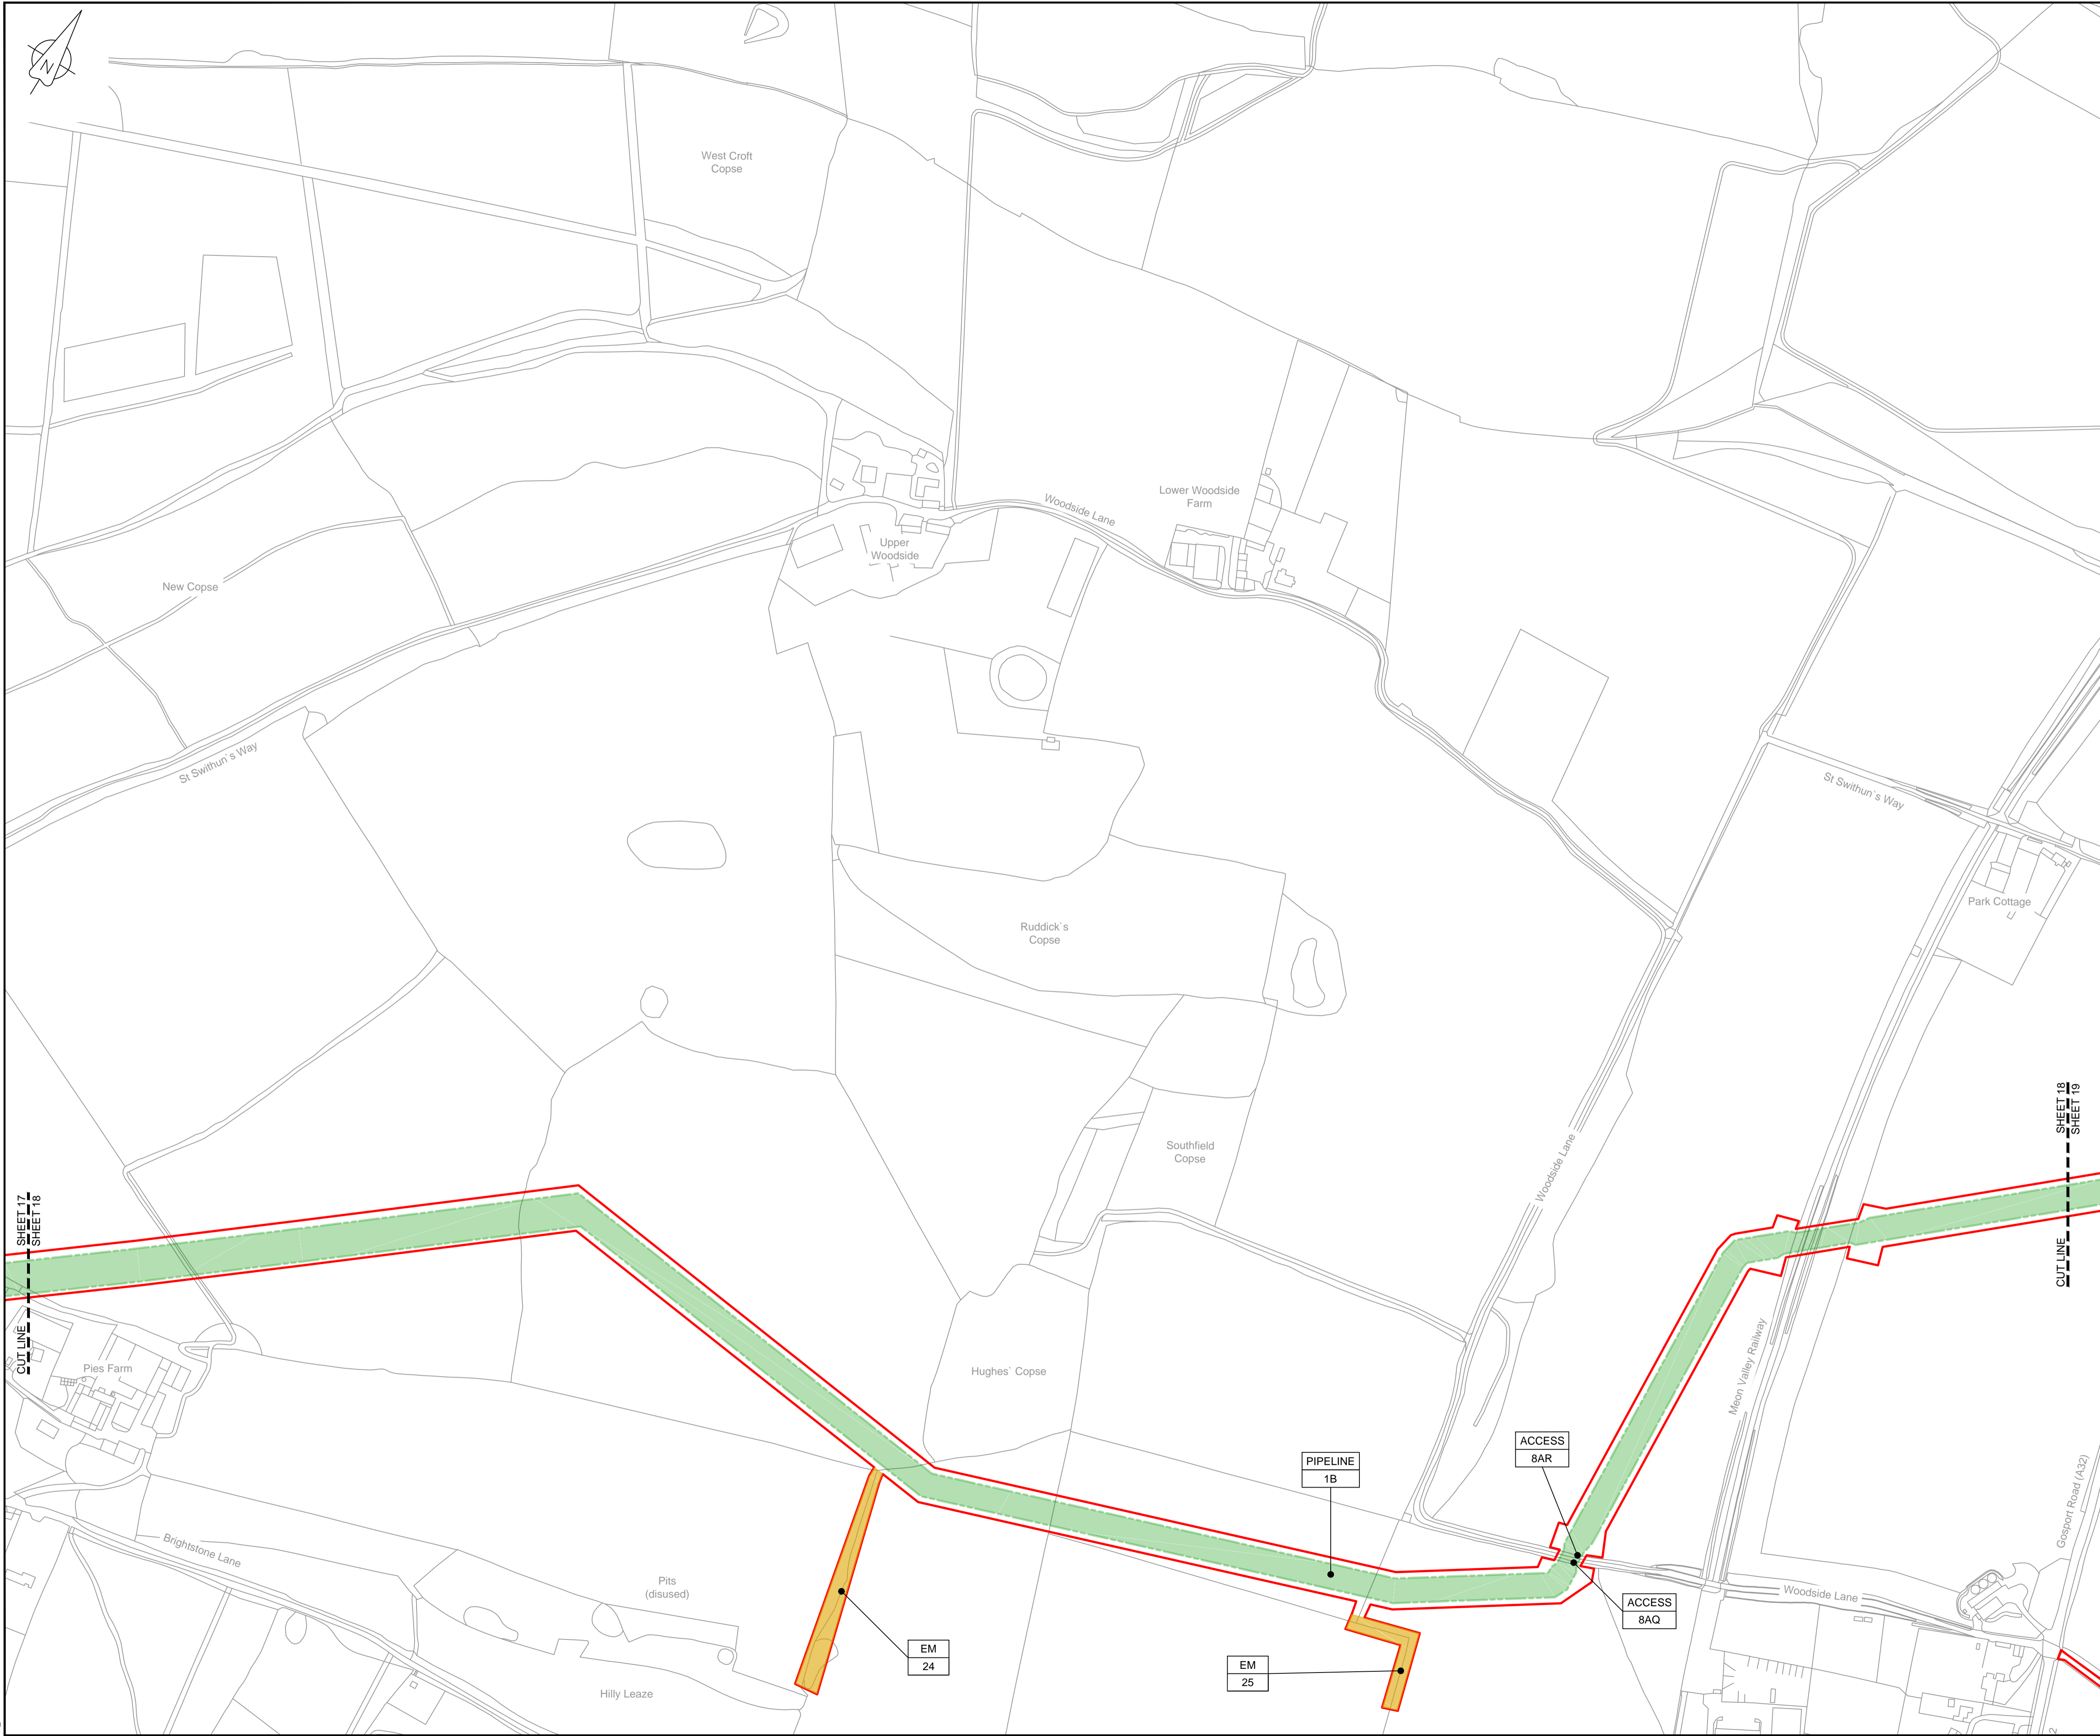

**LOCATION PLAN**  
SCALE 1:500,000

**NOTES**  
1. THIS DRAWING IS IN METRES UNLESS STATED OTHERWISE.

**LEGEND**

	ORDER LIMITS
	LIMITS OF DEVIATION
	COMPOUND (CO)
	ENVIRONMENTAL MITIGATION AREA (EM)
	ABOVE GROUND INSTALLATION (AGI) / VALVE (VA) / PRESSURE TRANSDUCER (PT)
	DESCRIPTION
	ID or WORK NUMBER (if applicable)
	ACCESS
	TEMPORARY CONSTRUCTION ACCESS
	P-ACCESS
	PERMANENT ACCESS
	COMMENCEMENT / TERMINATION OF WORKS (COMMENCEMENT = OPEN, TERMINATION = CLOSED)

Contains Ordnance Survey data © Crown copyright and database rights 2019.  
© Crown copyright and database rights 2019 OS Licence Number AL10005237.



C02	19/06/19	SHEETS 36 AND 109 REVISED FOLLOWING SSI ADVICE	SH	JA	ND	PH
C03	09/09/19	SHEETS 10, 11 AND 54 REVISED TO WITHDRAW A2b SUB-OPTION	BT	JA	ND	NJ
Rev	Rev. Date	Purpose of revision	Drawn	Checked	Rev'd	Appr'd

**JACOBS**

1180 Eskdale Road, Wokingham, Wokingham, RG41 5TU  
Tel:+44(0)118 946 7000 Fax:+44(0)118 946 7001  
www.jacobs.com

Client: Esso Petroleum Company, Limited  
Emryn House,  
Emryn Way,  
Leatherhead,  
Surrey,  
KT22 8UX

Project: Southampton to London Pipeline Project

Drawing title: **WORKS PLAN SHEET 18 REGULATION 5 (2)(J)**


Drawing status: **Fit for Stage Approval**

Scale: 1:2500 DO NOT SCALE  
Jacobs No. B2325300 Rev C03  
Client no.

Drawing number: **B2325300-JAC-000-CIV-DRG-000028**

C:\pwworking\jacobs\_uk\_water\utilities\_ssf\bray\ordms33519B2325300-JAC-000-CIV-DRG-000028.dwg - 10/09/2019 11:09:56 - A1Frame - BTaylor

© Copyright 2019 Jacobs U.K. Limited. The concepts and information contained in this document are the property of Jacobs. Use or copying of this document in whole or in part without the written permission of Jacobs constitutes an infringement of copyright. Limitation. This drawing has been prepared on behalf of, and for the exclusive use of, the Client, and is subject to, and issued in accordance with, the provisions of the contract between Jacobs and the Client. Jacobs accepts no liability or responsibility whatsoever for, or in respect of, any use of, or reliance upon, this drawing by any third party.

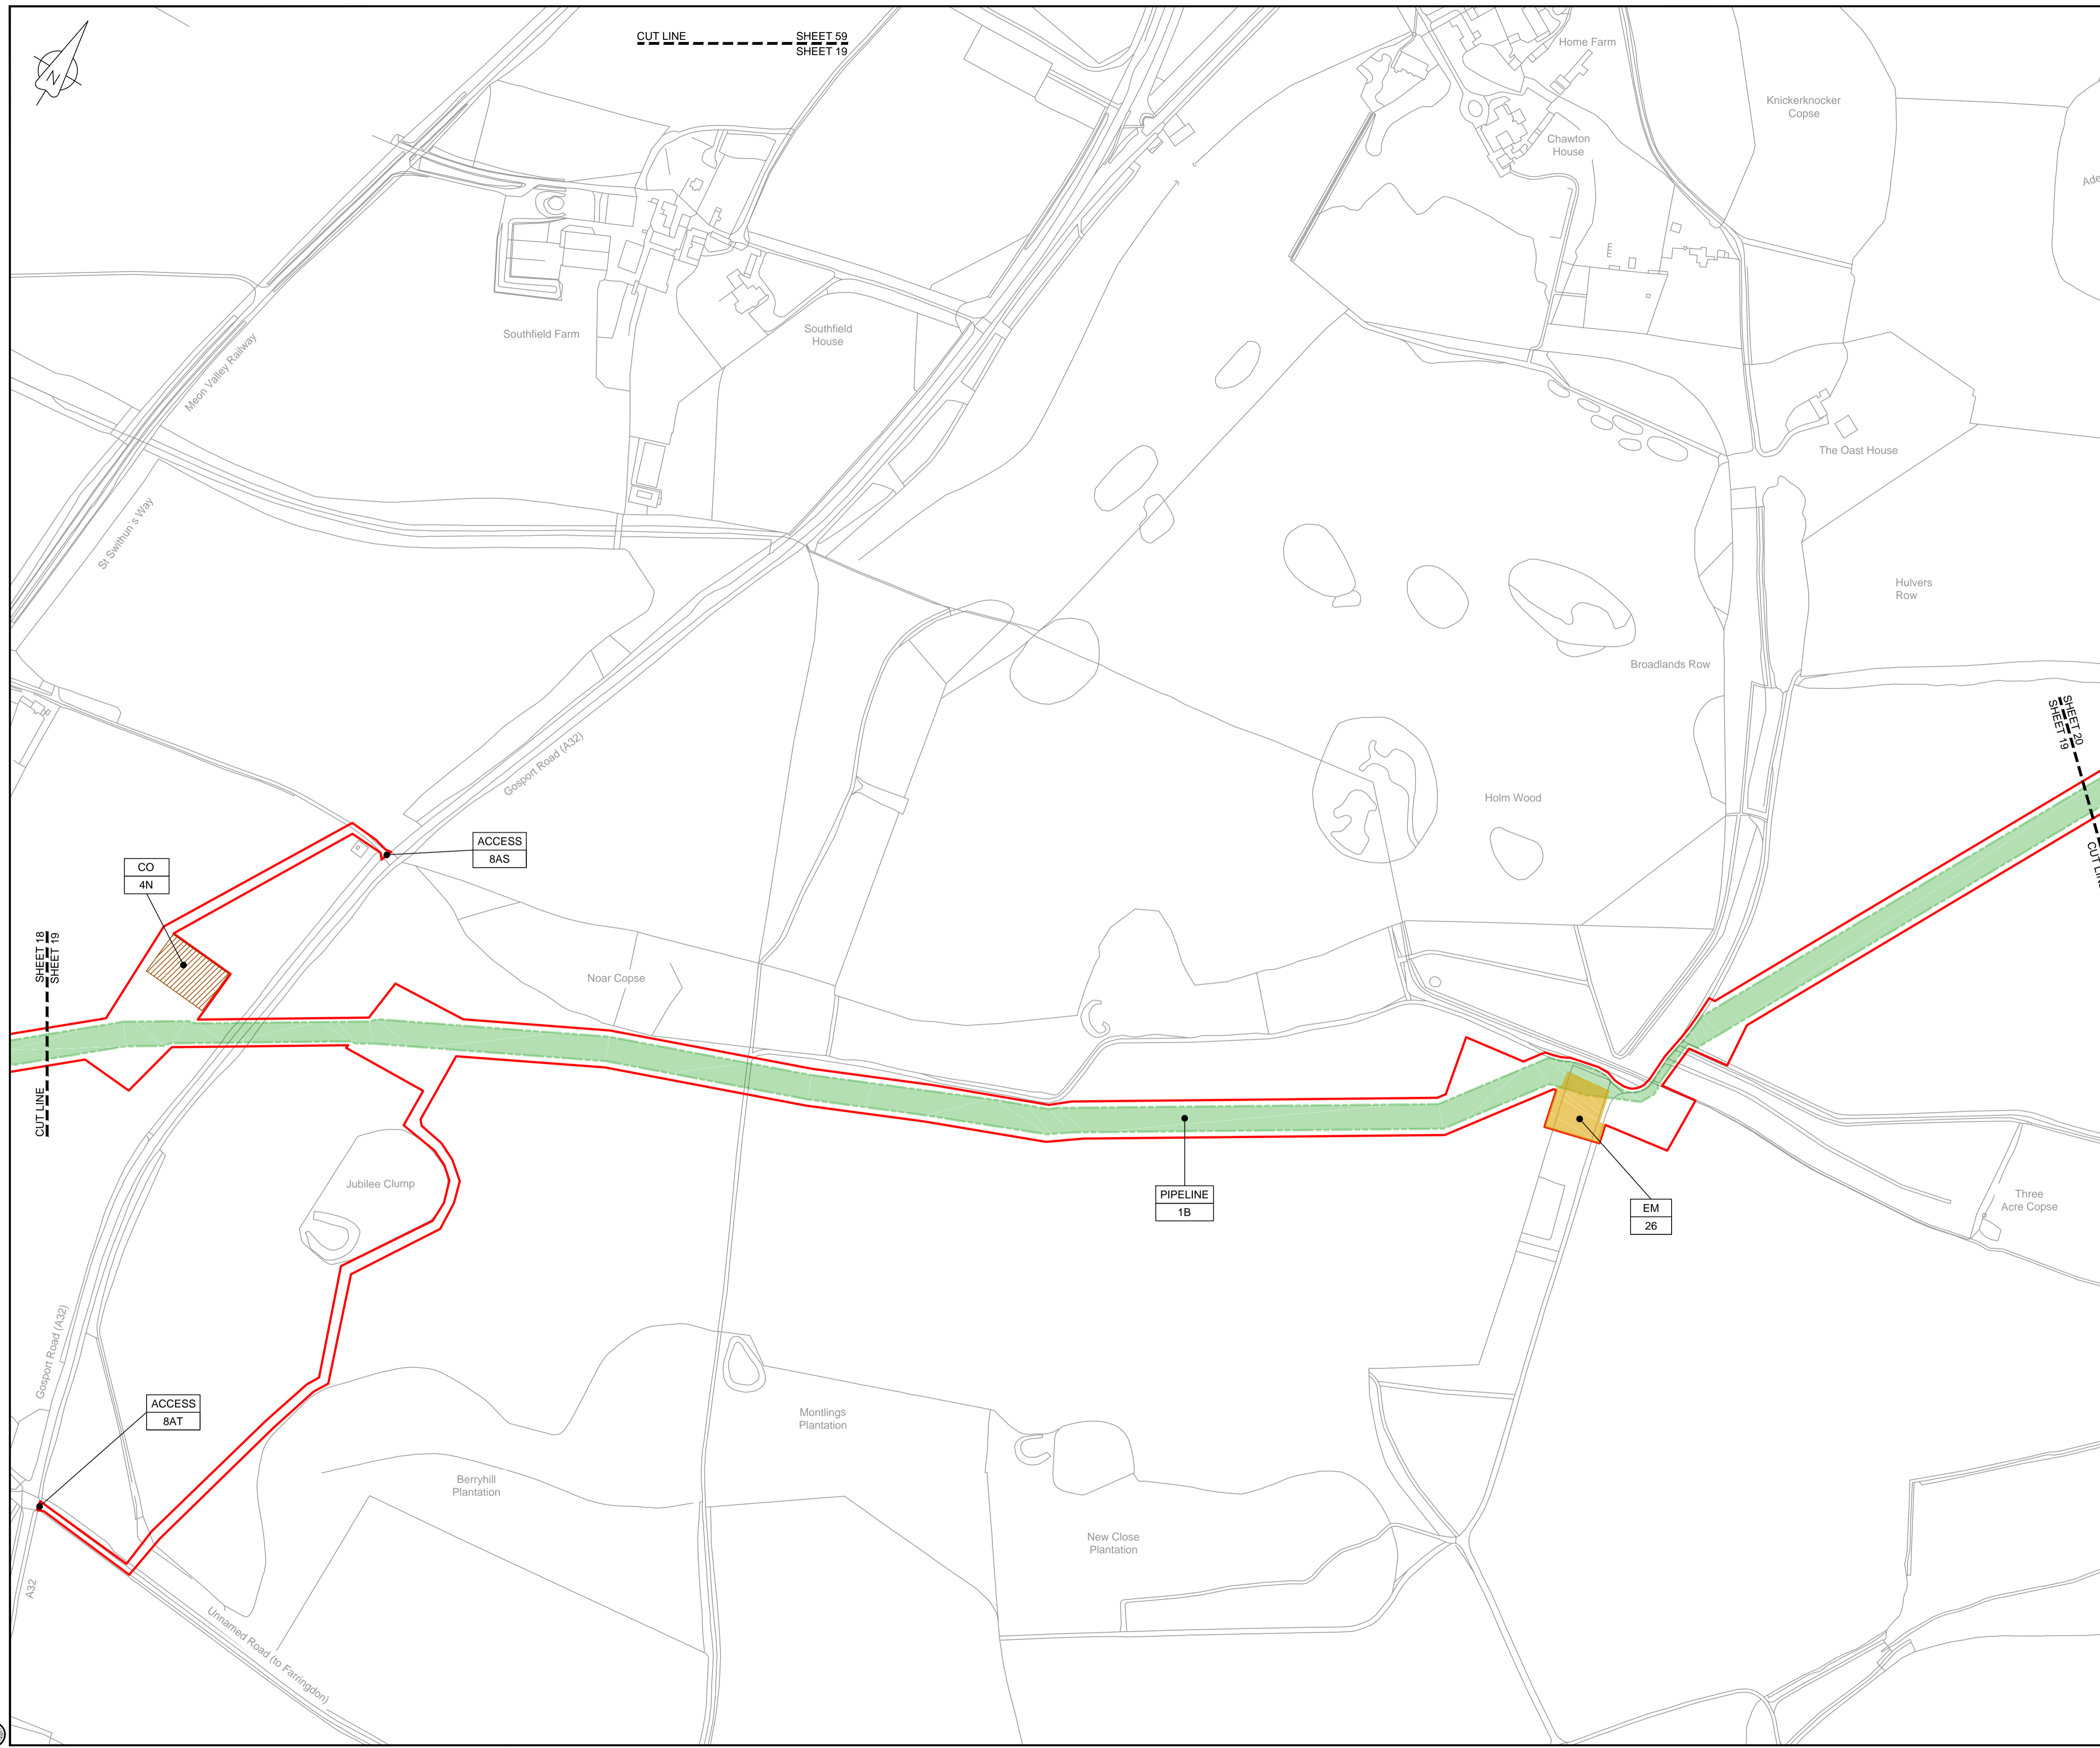


**LOCATION PLAN**  
SCALE 1:500,000

**NOTES**  
1. THIS DRAWING IS IN METRES UNLESS STATED OTHERWISE.

**LEGEND**

	ORDER LIMITS
	LIMITS OF DEVIATION
	COMPOUND (CO)
	ENVIRONMENTAL MITIGATION AREA (EM)
	ABOVE GROUND INSTALLATION (AGI) / VALVE (VA) / PRESSURE TRANSDUCER (PT)
	DESCRIPTION
	ID or WORK NUMBER (if applicable)
	ACCESS TEMPORARY CONSTRUCTION ACCESS
	P-ACCESS PERMANENT ACCESS
	COMMENCEMENT / TERMINATION OF WORKS (COMMENCEMENT = OPEN, TERMINATION = CLOSED)

Contains Ordnance Survey data © Crown copyright and database rights 2019.  
© Crown copyright and database rights 2019 OS Licence Number AL100005237.

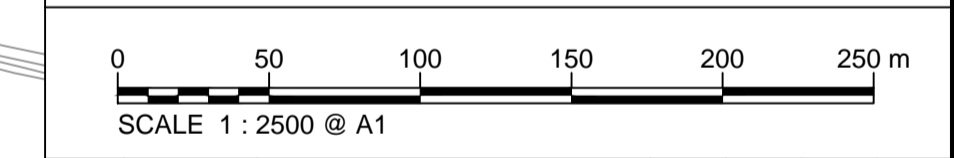

C02	19/06/19	SHEETS 36 AND 109 REVISED FOLLOWING SSI ADVICE	SH	JA	ND	PH
C03	09/09/19	SHEETS 10, 11 AND 54 REVISED TO WITHDRAW A2B SUB-OPTION	BT	JA	ND	NJ
Rev	Rev. Date	Purpose of revision	Drawn	Checked	Rev'd	Appr'd

**JACOBS**  
1180 Eskdale Road, Winnersh, Wokingham, RG41 5TU  
Tel:+44(0)118 946 7000 Fax:+44(0)118 946 7001  
www.jacobs.com

Client: Esso Petroleum Company, Limited  
Emryn House,  
Emryn Way,  
Leatherhead,  
Surrey,  
KT22 8UX

Project: Southampton to London Pipeline Project

Drawing title: **WORKS PLAN SHEET 19 REGULATION 5 (2)(J)**



Drawing status: **Fit for Stage Approval**

Scale	1:2500	DO NOT SCALE
Jacobs No.	B2325300	Rev
Client no.		<b>C03</b>

Drawing number: **B2325300-JAC-000-CIV-DRG-000029**

© Copyright 2019 Jacobs U.K. Limited. The concepts and information contained in this document are the property of Jacobs. Use or copying of this document in whole or in part without the written permission of Jacobs constitutes an infringement of copyright. Limitation. This drawing has been prepared on behalf of, and for the exclusive use of, the Client. Jacobs accepts no liability or responsibility whatsoever for, or in respect of, any use of, or reliance upon, this drawing by any third party.

C:\pwworking\jacobs\_uk\_water&utilities\_ssf\by\ordms33519B2325300-JAC-000-CIV-DRG-000029.dwg - 10/09/2019 11:11:07 - A1Frame - BTaylor

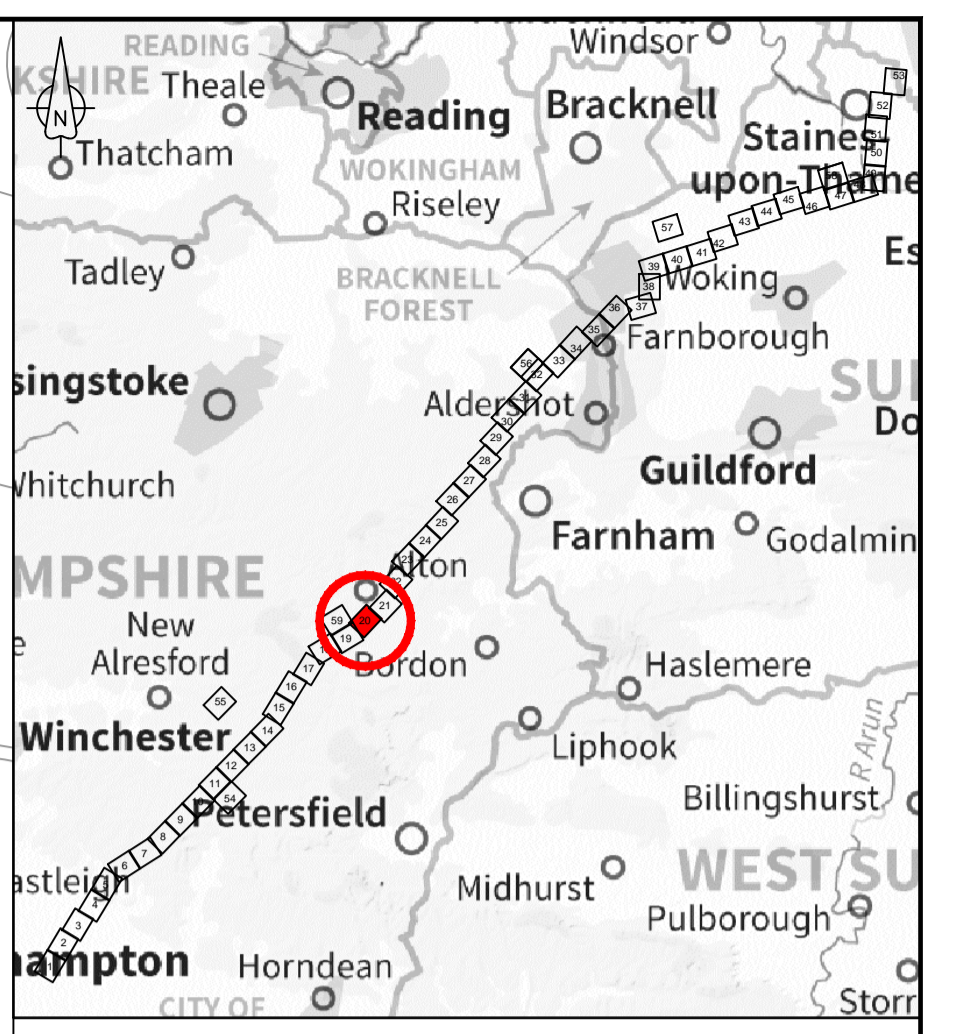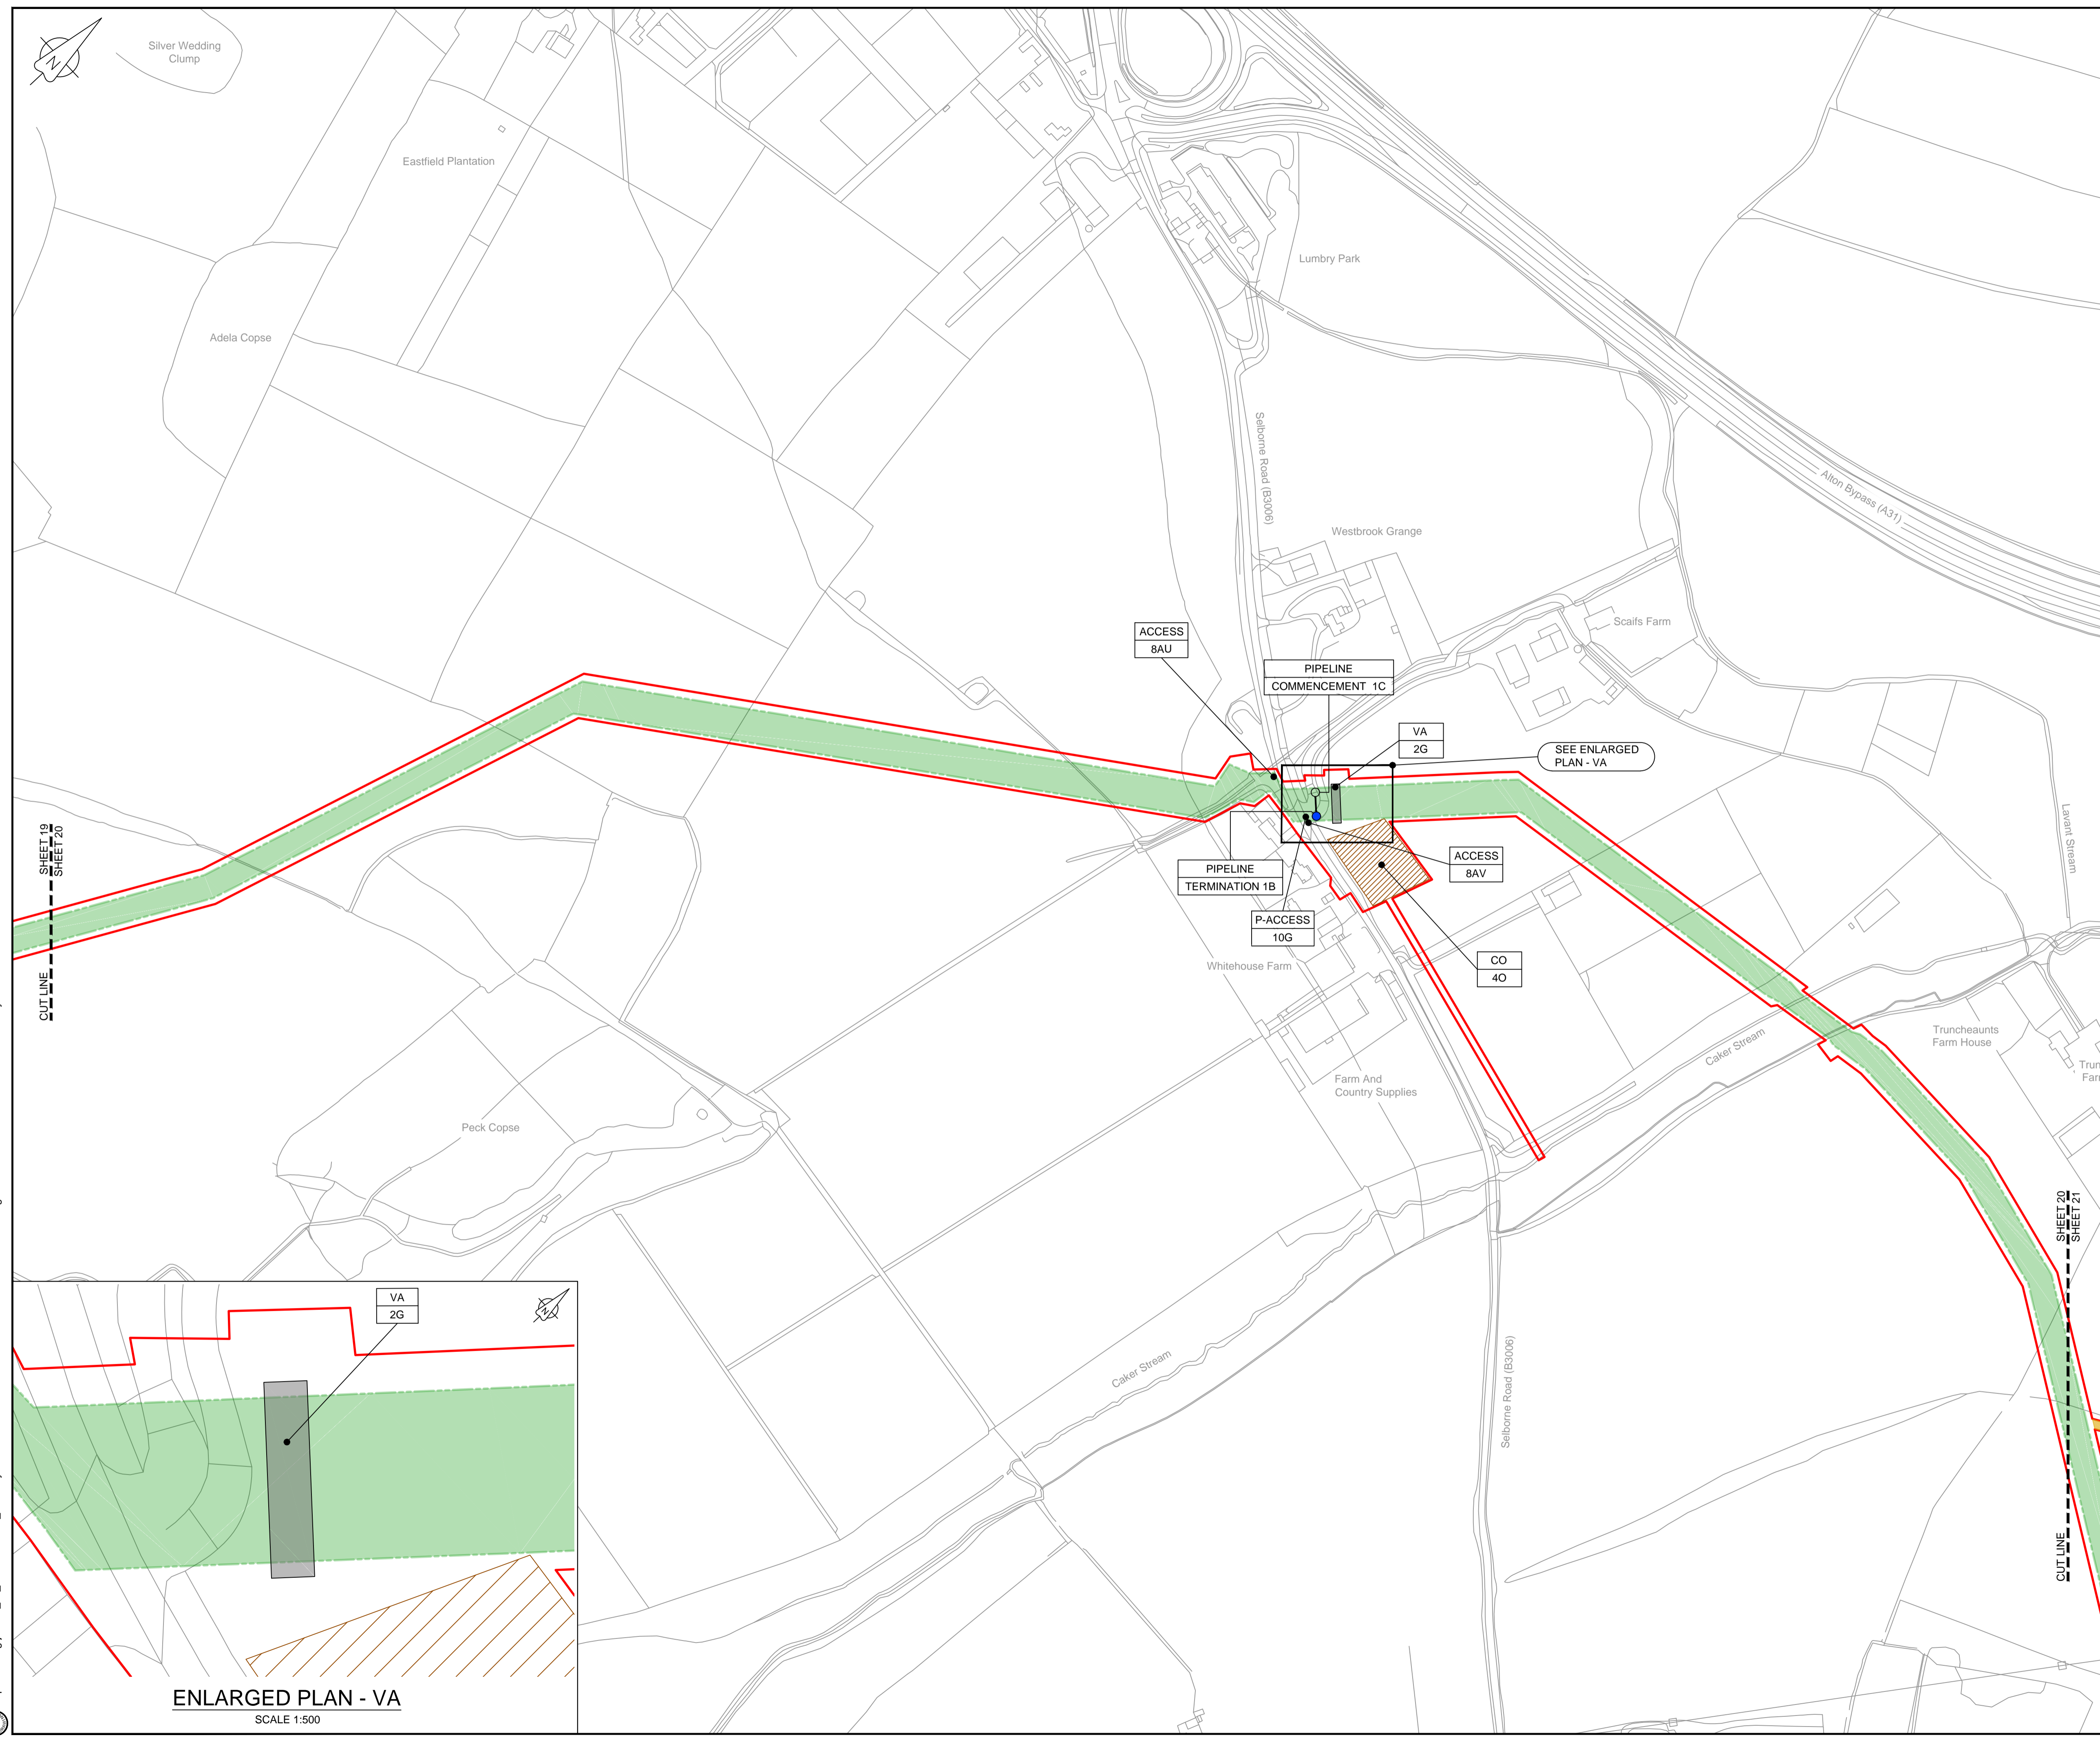


**LOCATION PLAN**  
SCALE 1:500,000

**NOTES**  
1. THIS DRAWING IS IN METRES UNLESS STATED OTHERWISE.

**LEGEND**

[Red line]	ORDER LIMITS
[Green shaded area]	LIMITS OF DEVIATION
[Hatched area]	COMPOUND (CO)
[Yellow shaded area]	ENVIRONMENTAL MITIGATION AREA (EM)
[Grey shaded area]	ABOVE GROUND INSTALLATION (AGI) / VALVE (VA) / PRESSURE TRANSDUCER (PT)
[Symbol]	DESCRIPTION
[Symbol]	ID or WORK NUMBER (if applicable)
[Symbol]	ACCESS
[Symbol]	TEMPORARY CONSTRUCTION ACCESS
[Symbol]	P-ACCESS
[Symbol]	PERMANENT ACCESS
[Symbol]	COMMENCEMENT / TERMINATION OF WORKS (COMMENCEMENT = OPEN, TERMINATION = CLOSED)

Contains Ordnance Survey data © Crown copyright and database rights 2019.  
© Crown copyright and database rights 2019 OS Licence Number AL100005237.

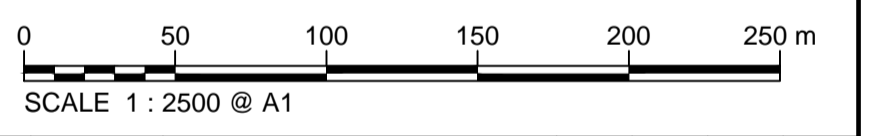

Rev	Rev. Date	Purpose of revision	Drawn	Checked	Rev'd	Appr'd
C02	19/06/19	SHEETS 36 AND 108 REVISED FOLLOWING SSI ADVICE	SH	JA	ND	PH
C03	09/09/19	SHEETS 10, 11 AND 54 REVISED TO WITHDRAW A2b SUB-OPTION	BT	JA	ND	NJ



1180 Eskdale Road, Winnersh, Wokingham, RG41 5TU  
Tel:+44(0)118 946 7000 Fax:+44(0)118 946 7001  
www.jacobs.com

Client: Esso Petroleum Company, Limited  
Emryn House,  
Emryn Way,  
Leatherhead,  
Surrey,  
KT22 8UX




Drawing title: **WORKS PLAN SHEET 20 REGULATION 5 (2)(J)**

Drawing status: **Fit for Stage Approval**


Scale	1:2500	DO NOT SCALE
Jacobs No.	B2325300	Rev
Client no.		<b>C03</b>

Drawing number: **B2325300-JAC-000-CIV-DRG-000030**

C:\pwworking\jacobs\_uk\_water&utilities\_ssr\london\dms33519\B2325300-JAC-000-CIV-DRG-000030.dwg - 10/09/2019 11:12:27 - A1Frame - BTaylor

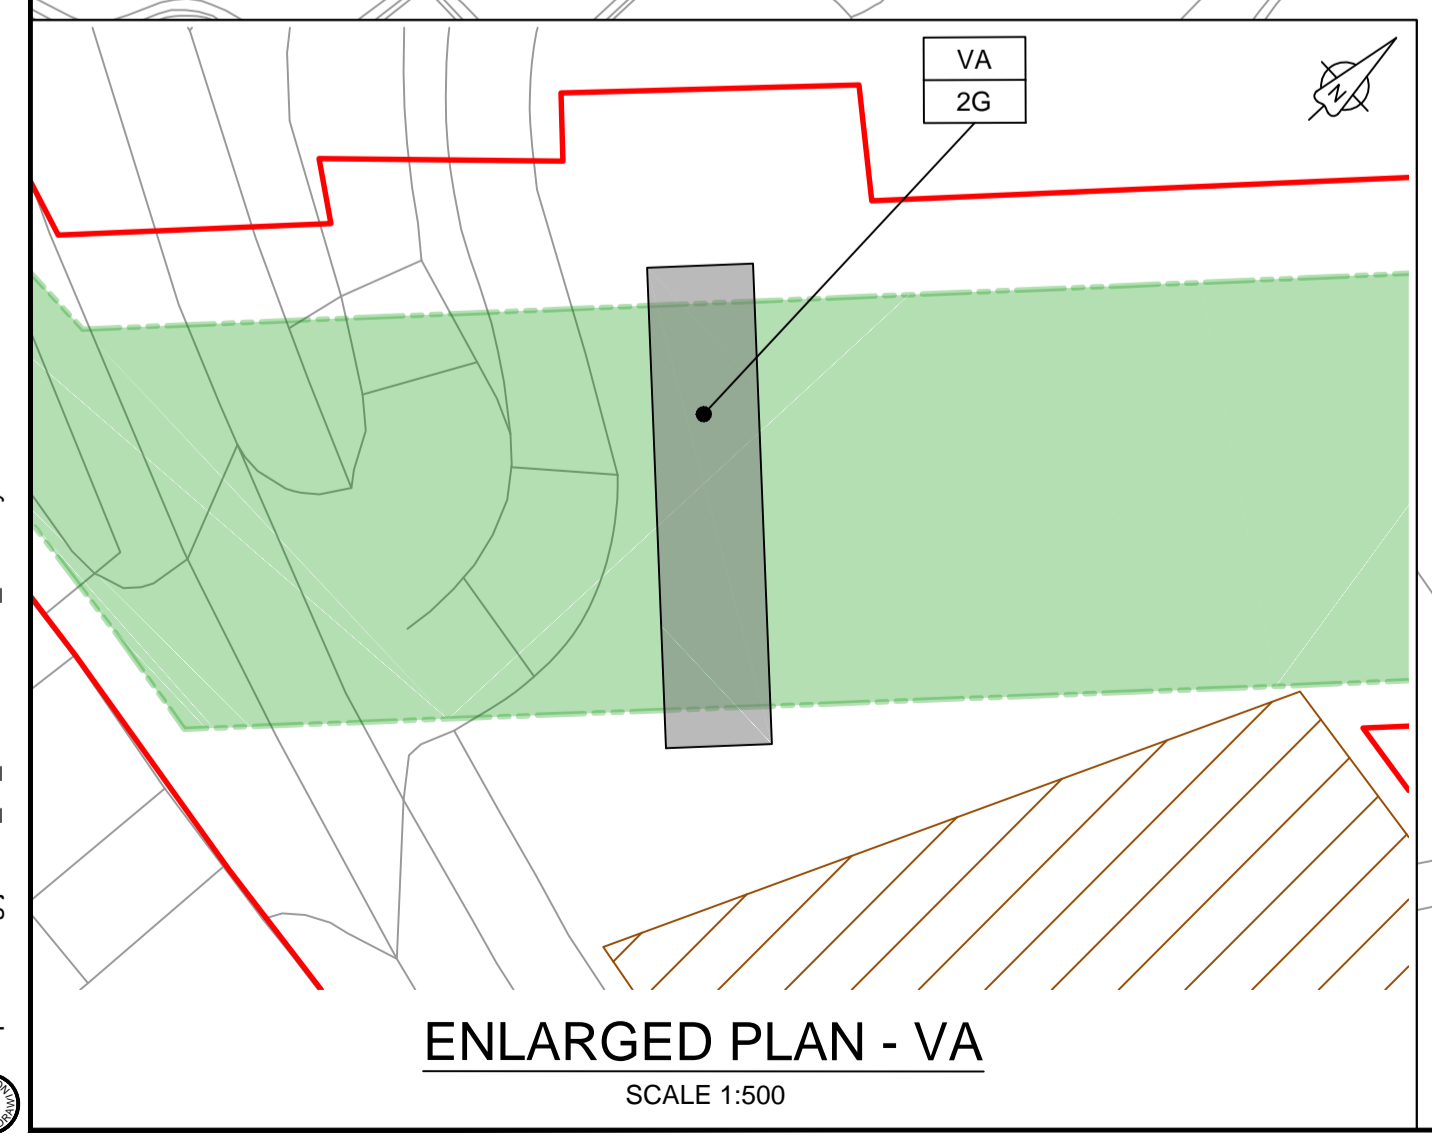

**ENLARGED PLAN - VA**  
SCALE 1:500

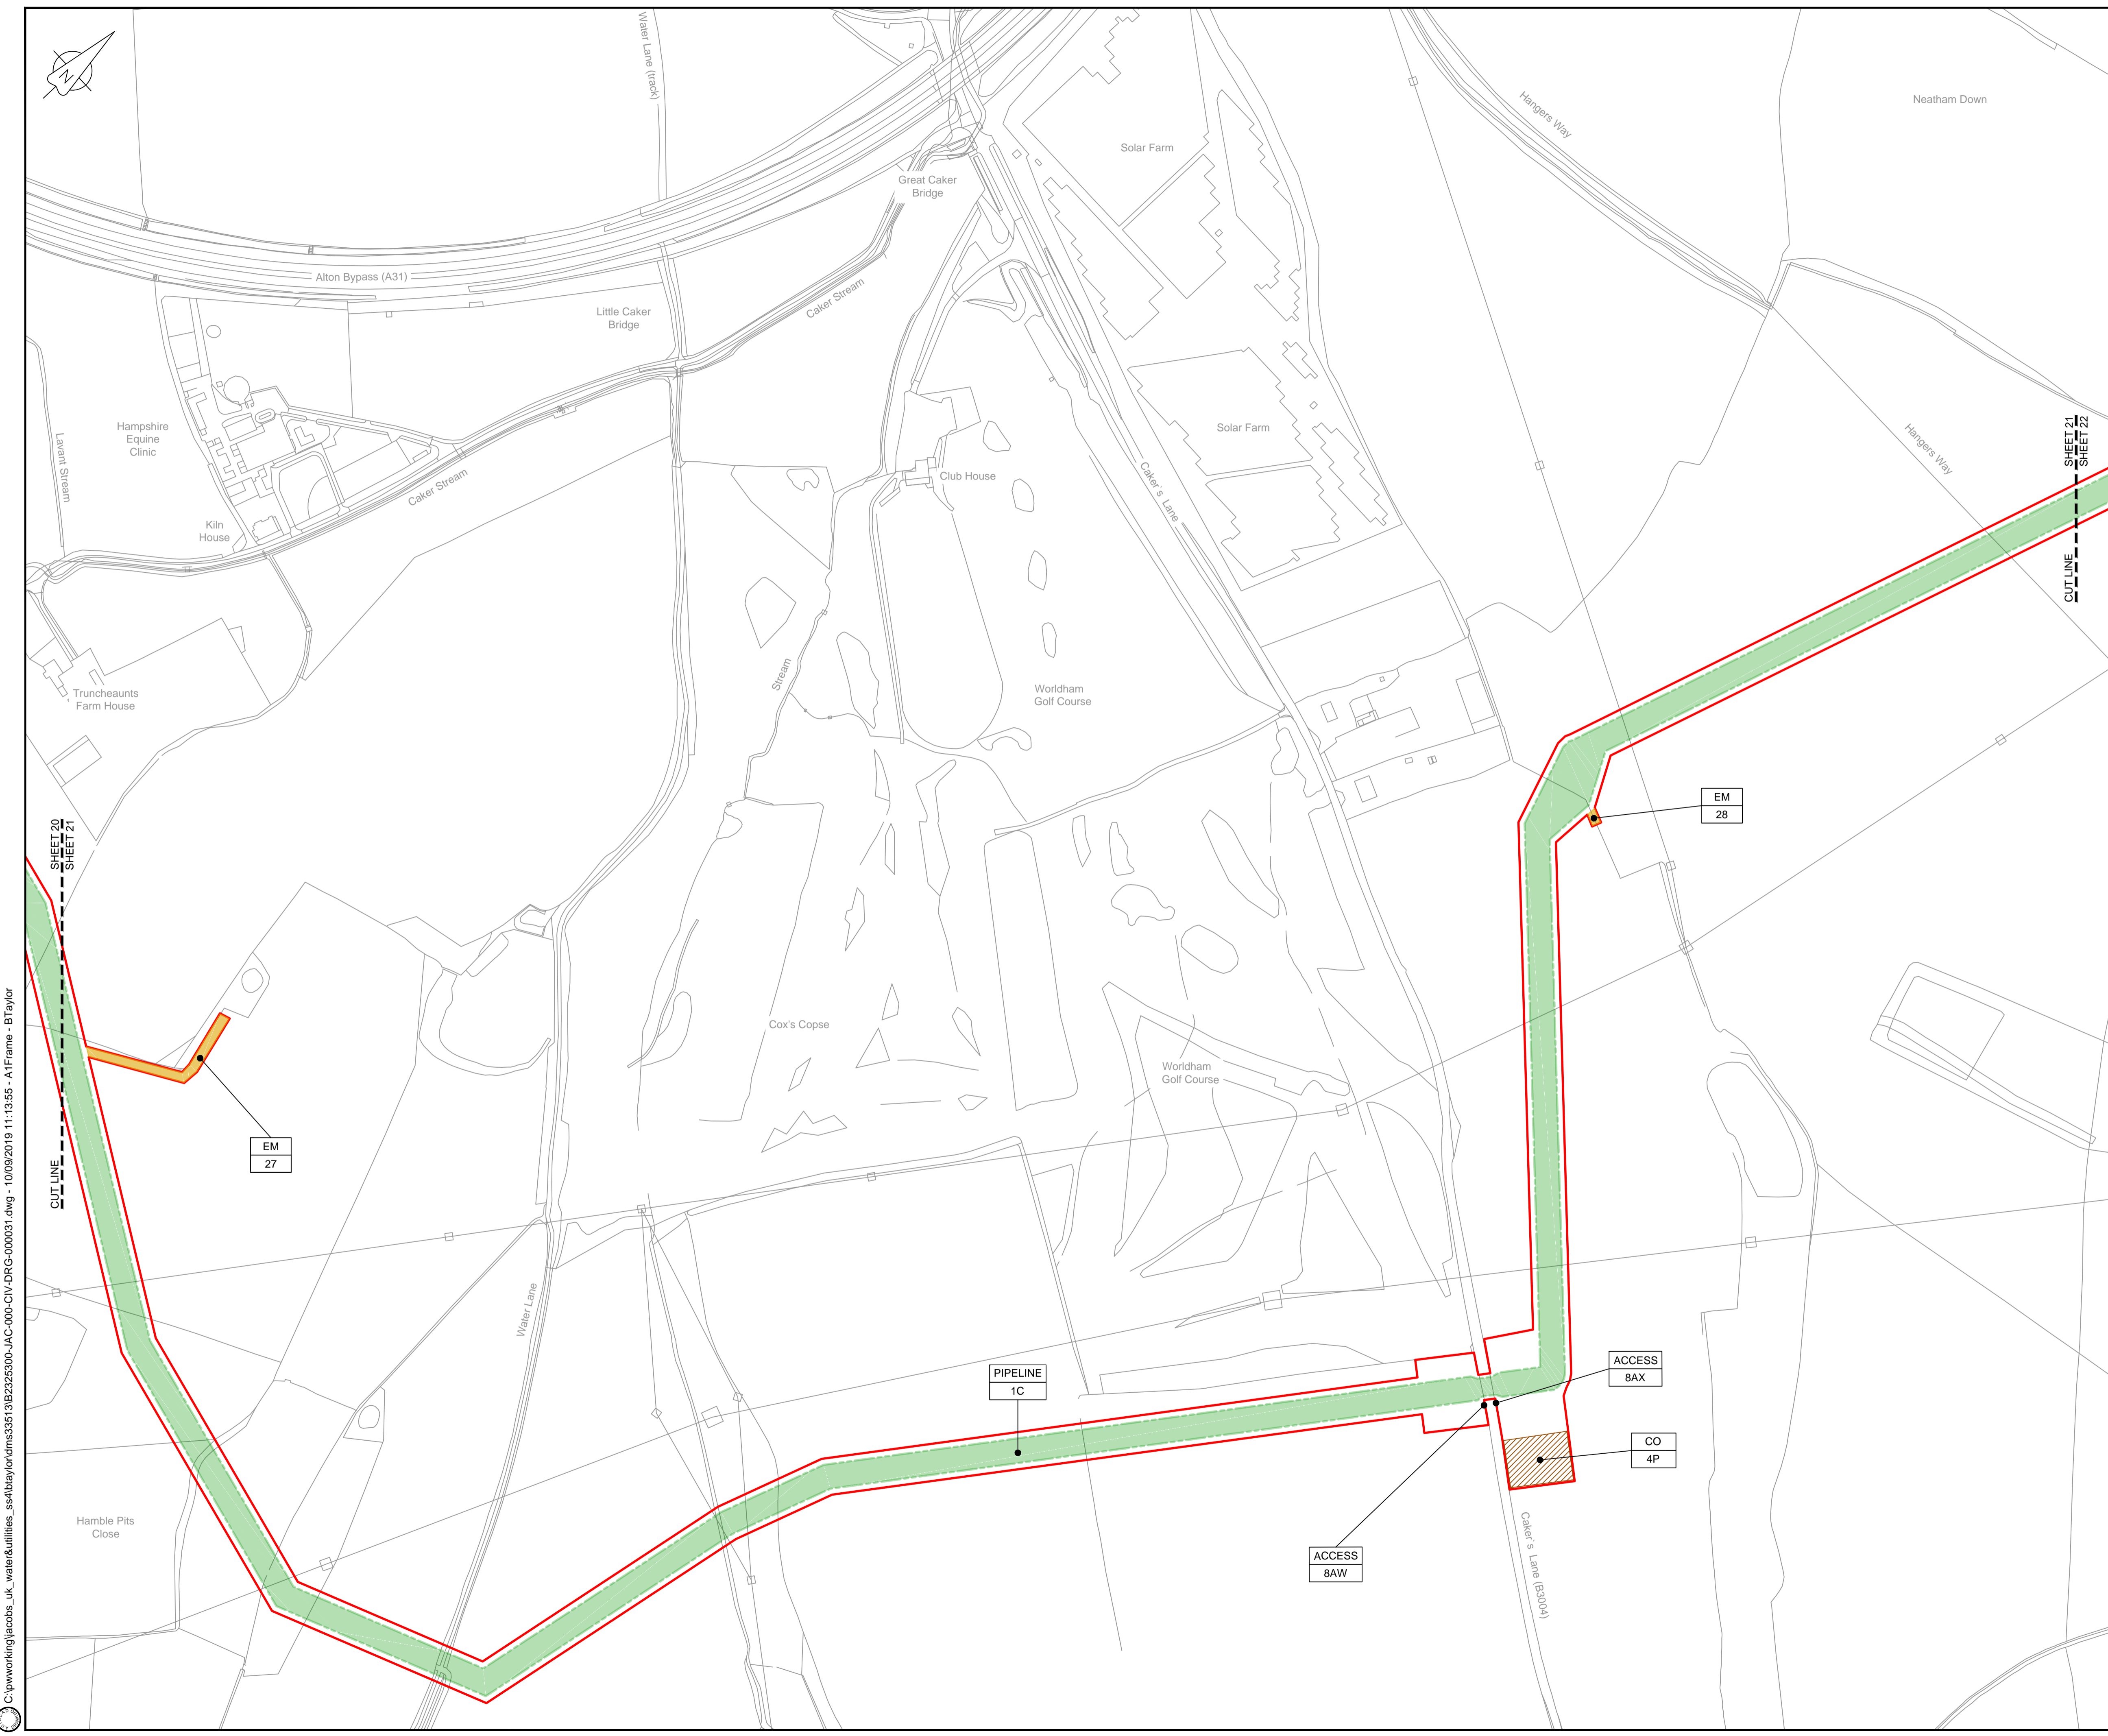

**LOCATION PLAN**  
SCALE 1:500,000

**NOTES**

1. THIS DRAWING IS IN METRES UNLESS STATED OTHERWISE.

**LEGEND**

- ORDER LIMITS
- LIMITS OF DEVIATION
- COMPOUND (CO)
- ENVIRONMENTAL MITIGATION AREA (EM)
- ABOVE GROUND INSTALLATION (AGI) / VALVE (VA) / PRESSURE TRANSDUCER (PT)
- DESCRIPTION
- ID or WORK NUMBER (if applicable)
- ACCESS TEMPORARY CONSTRUCTION ACCESS
- P-ACCESS PERMANENT ACCESS
- COMMENCEMENT / TERMINATION OF WORKS (COMMENCEMENT = OPEN, TERMINATION = CLOSED)

Contains Ordnance Survey data © Crown copyright and database rights 2019.

© Crown copyright and database rights 2019 OS Licence Number AL100005237.



C02	19/06/19	SHEETS 35 AND 109 REVISED FOLLOWING SSI ADVICE	SH	JA	ND	PH
C03	09/09/19	SHEETS 10, 11 AND 54 REVISED TO WITHDRAW A2B SUB-OPTION	BT	JA	ND	NJ
Rev	Rev. Date	Purpose of revision	Drawn	Checked	Rev'd	Appr'd



1180 Eskdale Road, Winnersh, Wokingham, RG41 5TU  
Tel: +44(0)118 946 7000 Fax: +44(0)118 946 7001  
www.jacobs.com

Client: Esso Petroleum Company, Limited  
Emryn House,  
Emryn Way,  
Leatherhead,  
Surrey,  
KT22 8UX



Southampton to London Pipeline Project

**WORKS PLAN  
SHEET 21  
REGULATION 5 (2)(J)**


Drawing status: **Fit for Stage Approval**

Scale	1:2500	DO NOT SCALE
Jacobs No.	B2325300	Rev
Client no.		<b>C03</b>

Drawing number: **B2325300-JAC-000-CIV-DRG-000031**

© Copyright 2019 Jacobs U.K. Limited. The concepts and information contained in this document are the property of Jacobs. Use or copying of this document in whole or in part without the written permission of Jacobs constitutes an infringement of copyright. Limitation: This drawing has been prepared on behalf of, and for the exclusive use of, the Client. It is subject to, and issued in accordance with, the provisions of the contract between Jacobs and the Client. Jacobs accepts no liability or responsibility whatsoever for, or in respect of, any use of, or reliance upon, this drawing by any third party.

C:\pwworking\jacobs\_uk\_water&utilities\_ssf\by\ordms33519B2325300-JAC-000-CIV-DRG-000031.dwg - 10/09/2019 11:13:55 - A1Frame - BTaylor

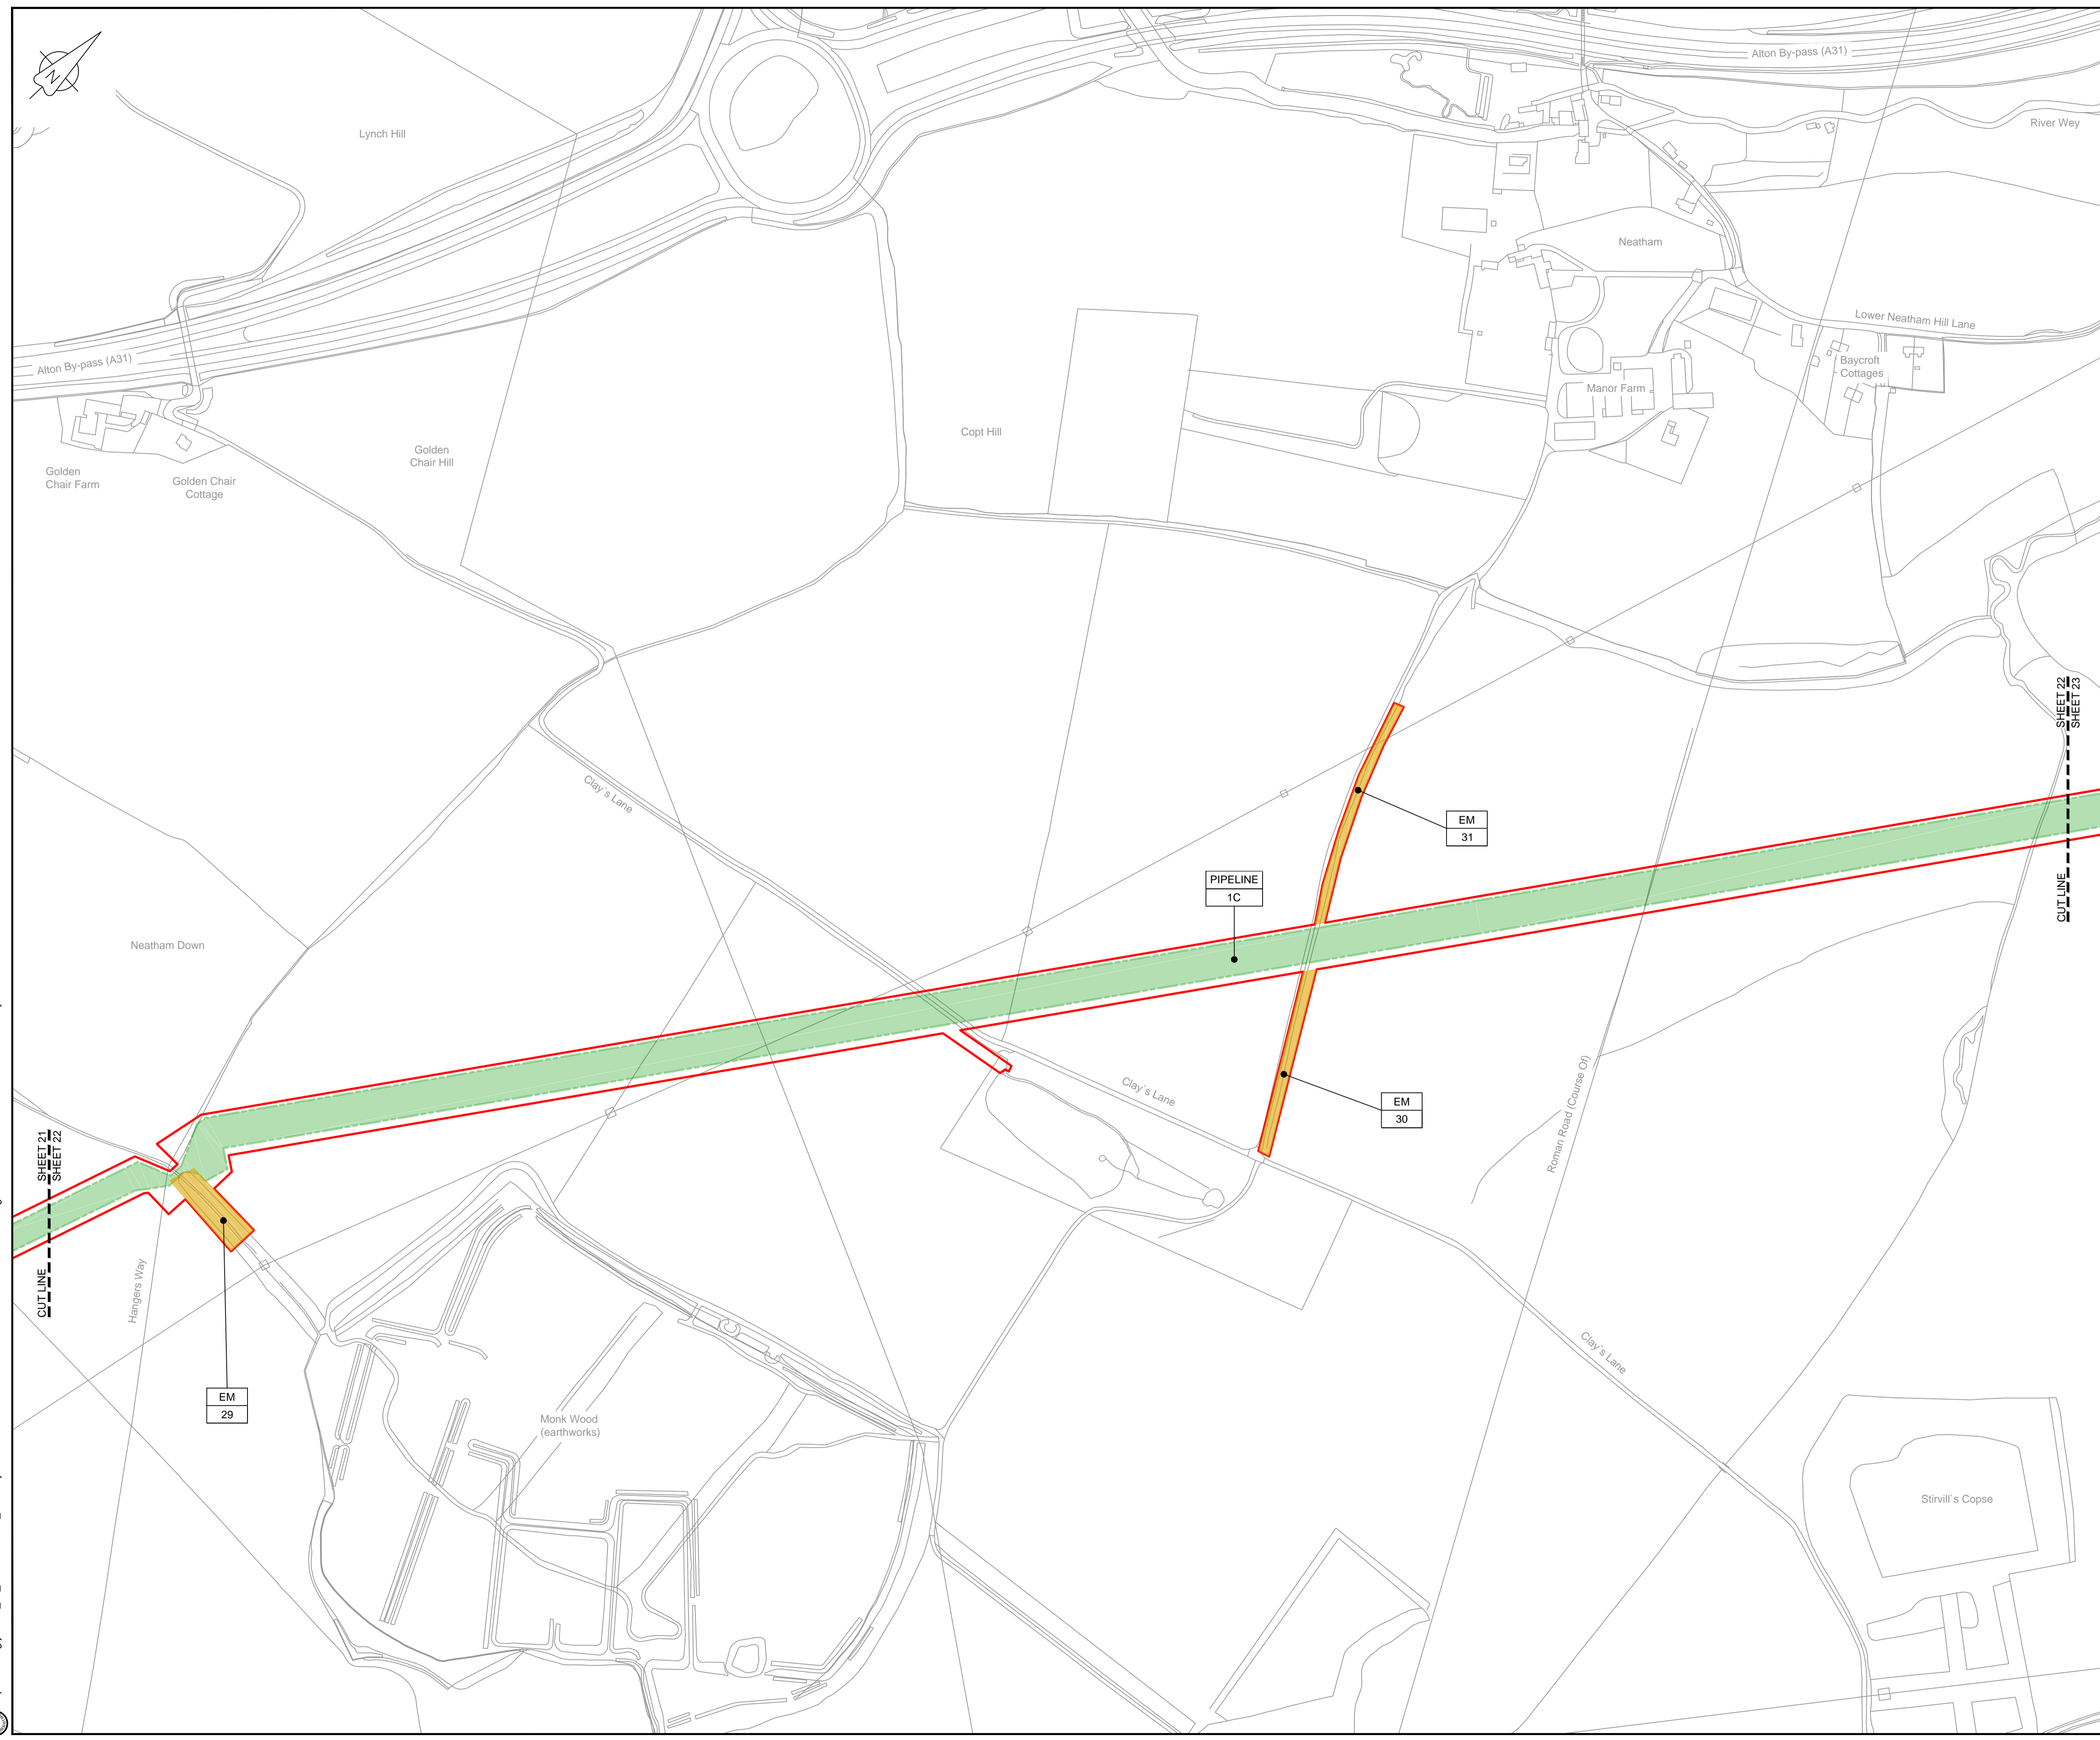

**LOCATION PLAN**  
SCALE 1:500,000

**NOTES**  
1. THIS DRAWING IS IN METRES UNLESS STATED OTHERWISE.

**LEGEND**

	ORDER LIMITS
	LIMITS OF DEVIATION
	COMPOUND (CO)
	ENVIRONMENTAL MITIGATION AREA (EM)
	ABOVE GROUND INSTALLATION (AGI) / VALVE (VA) / PRESSURE TRANSDUCER (PT)
	DESCRIPTION
	ID or WORK NUMBER (if applicable)
	ACCESS TEMPORARY CONSTRUCTION ACCESS
	P-ACCESS PERMANENT ACCESS
	COMMENCEMENT / TERMINATION OF WORKS (COMMENCEMENT = OPEN, TERMINATION = CLOSED)

Contains Ordnance Survey data © Crown copyright and database rights 2019.  
© Crown copyright and database rights 2019 OS Licence Number AL100005237.



C02	19/06/19	SHEETS 35 AND 109 REVISED FOLLOWING SSI ADVICE	SH	JA	ND	PH
C03	09/09/19	SHEETS 10, 11 AND 54 REVISED TO WITHDRAW A2b SUB-OPTION	BT	JA	ND	NJ
Rev	Rev. Date	Purpose of revision	Drawn	Checked	Rev'd	Appr'd



1180 Eskdale Road, Wokingham, Wokingham, RG41 5TU  
Tel:+44(0)118 946 7000 Fax:+44(0)118 946 7001  
www.jacobs.com

Client: Esso Petroleum Company, Limited  
Emryn House,  
Emryn Way,  
Leatherhead,  
Surrey,  
KT22 8UX




Drawing title  
**WORKS PLAN  
SHEET 22  
REGULATION 5 (2)(J)**

Drawing status  
**Fit for Stage Approval**

Scale	1:2500	DO NOT SCALE
Jacobs No.	B2325300	Rev
Client no.		<b>C03</b>

Drawing number  
**B2325300-JAC-000-CIV-DRG-000032**

© Copyright 2019 Jacobs U.K. Limited. The concepts and information contained in this document are the property of Jacobs. Use or copying of this document in whole or in part without the written permission of Jacobs constitutes an infringement of copyright. Limitation: This drawing has been prepared on behalf of, and for the exclusive use of, the Client, and is subject to, and issued in accordance with, the provisions of the contract between Jacobs and the Client. Jacobs accepts no liability or responsibility whatsoever for, or in respect of, any use of, or reliance upon, this drawing by any third party.

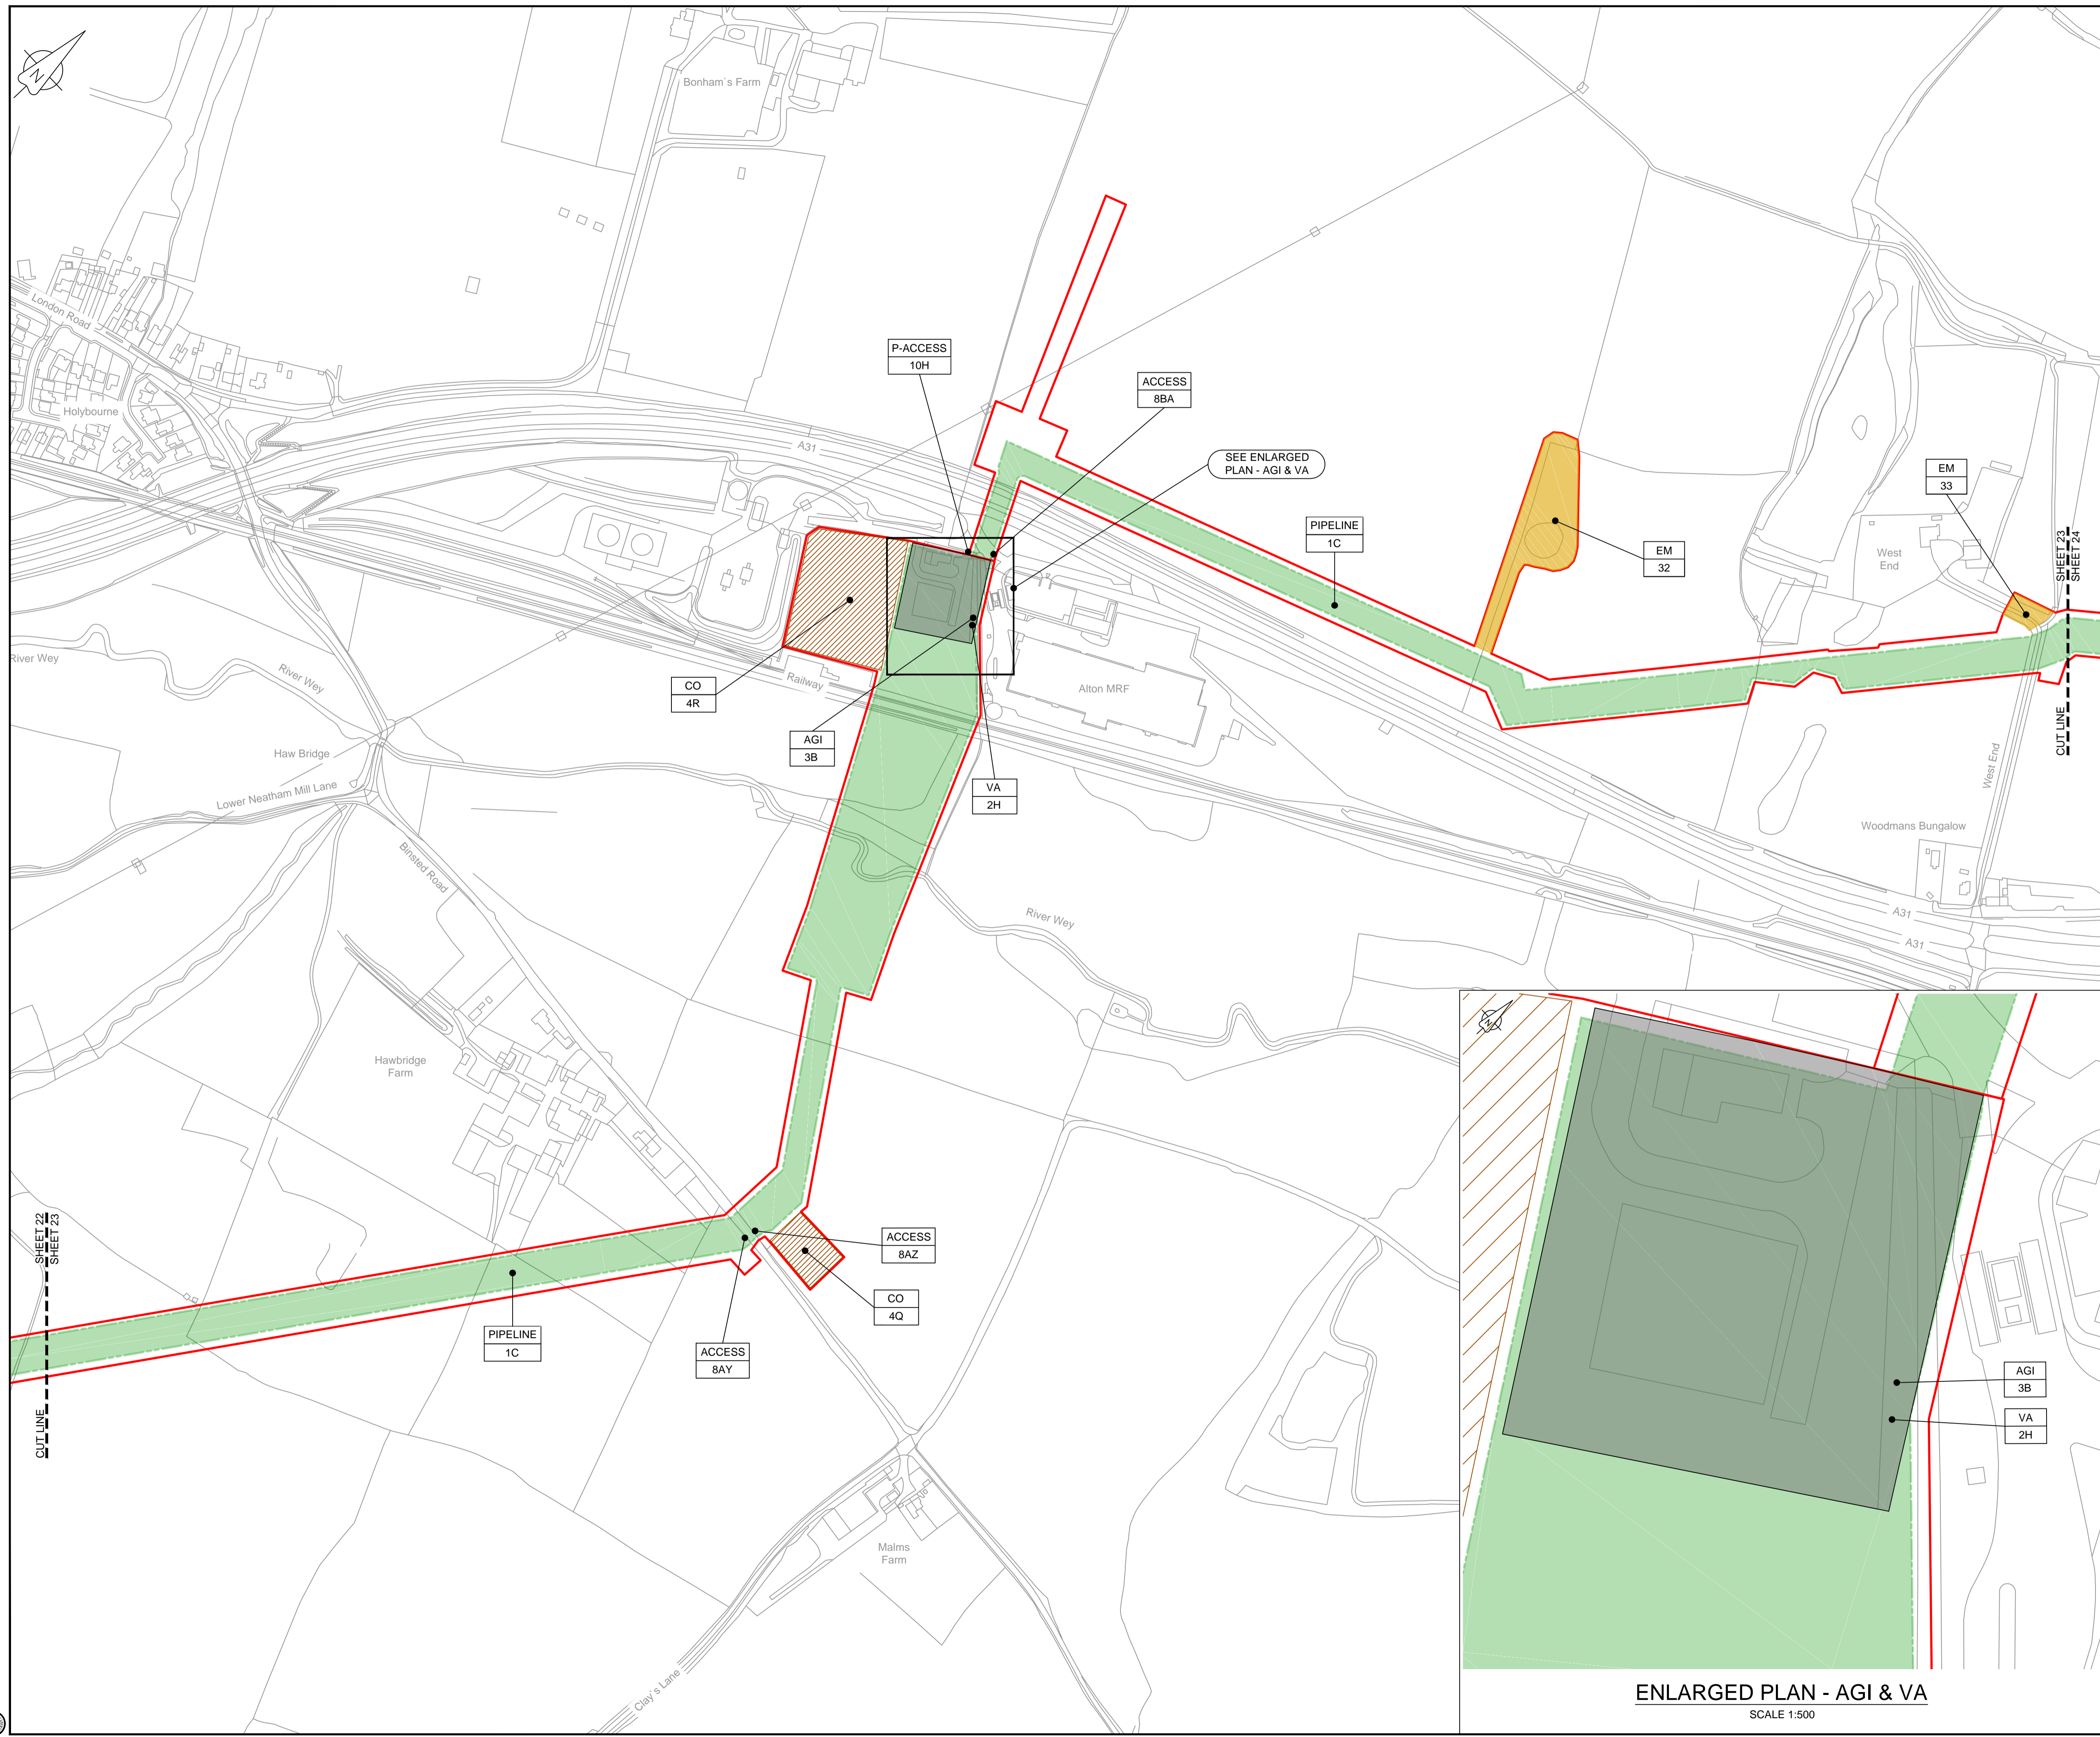


LOCATION PLAN  
SCALE 1:500,000

NOTES  
1. THIS DRAWING IS IN METRES UNLESS STATED OTHERWISE.

LEGEND

[Red line]	ORDER LIMITS
[Green shaded area]	LIMITS OF DEVIATION
[Hatched area]	COMPOUND (CO)
[Yellow shaded area]	ENVIRONMENTAL MITIGATION AREA (EM)
[Grey shaded area]	ABOVE GROUND INSTALLATION (AGI) / VALVE (VA) / PRESSURE TRANSDUCER (PT)
[Symbol]	DESCRIPTION
[Symbol]	ID or WORK NUMBER (if applicable)
[Symbol]	ACCESS
[Symbol]	TEMPORARY CONSTRUCTION ACCESS
[Symbol]	PERMANENT ACCESS
[Symbol]	COMMENCEMENT / TERMINATION OF WORKS (COMMENCEMENT = OPEN, TERMINATION = CLOSED)

Contains Ordnance Survey data © Crown copyright and database rights 2019.  
© Crown copyright and database rights 2019 OS Licence Number AL10005237.

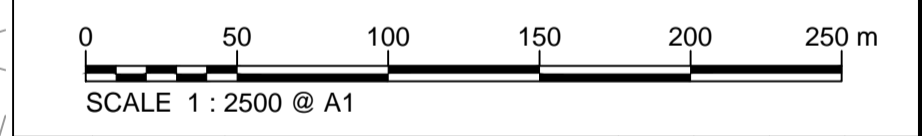

C02	19/06/19	SHEETS 36 AND 109 REVISED FOLLOWING SSI ADVICE	SH	JA	ND	PH
C03	09/09/19	SHEETS 10, 11 AND 54 REVISED TO WITHDRAW A2B SUB-OPTION	BT	JA	ND	NJ
Rev	Rev. Date	Purpose of revision	Drawn	Checked	Rev'd	Appr'd

**JACOBS**  
1180 Eskdale Road, Wokingham, Wokingham, RG41 5TU  
Tel:+44(0)118 946 7000 Fax:+44(0)118 946 7001  
www.jacobs.com

Client: Esso Petroleum Company, Limited  
Emryn House,  
Emryn Way,  
Leatherhead,  
Surrey,  
KT22 8UX


Project: Southampton to London Pipeline Project

Drawing title: **WORKS PLAN SHEET 23 REGULATION 5 (2)(J)**


Drawing status: **Fit for Stage Approval**

Scale	1:2500	DO NOT SCALE
Jacobs No.	B2325300	Rev
Client no.		<b>C03</b>

Drawing number: **B2325300-JAC-000-CIV-DRG-000033**

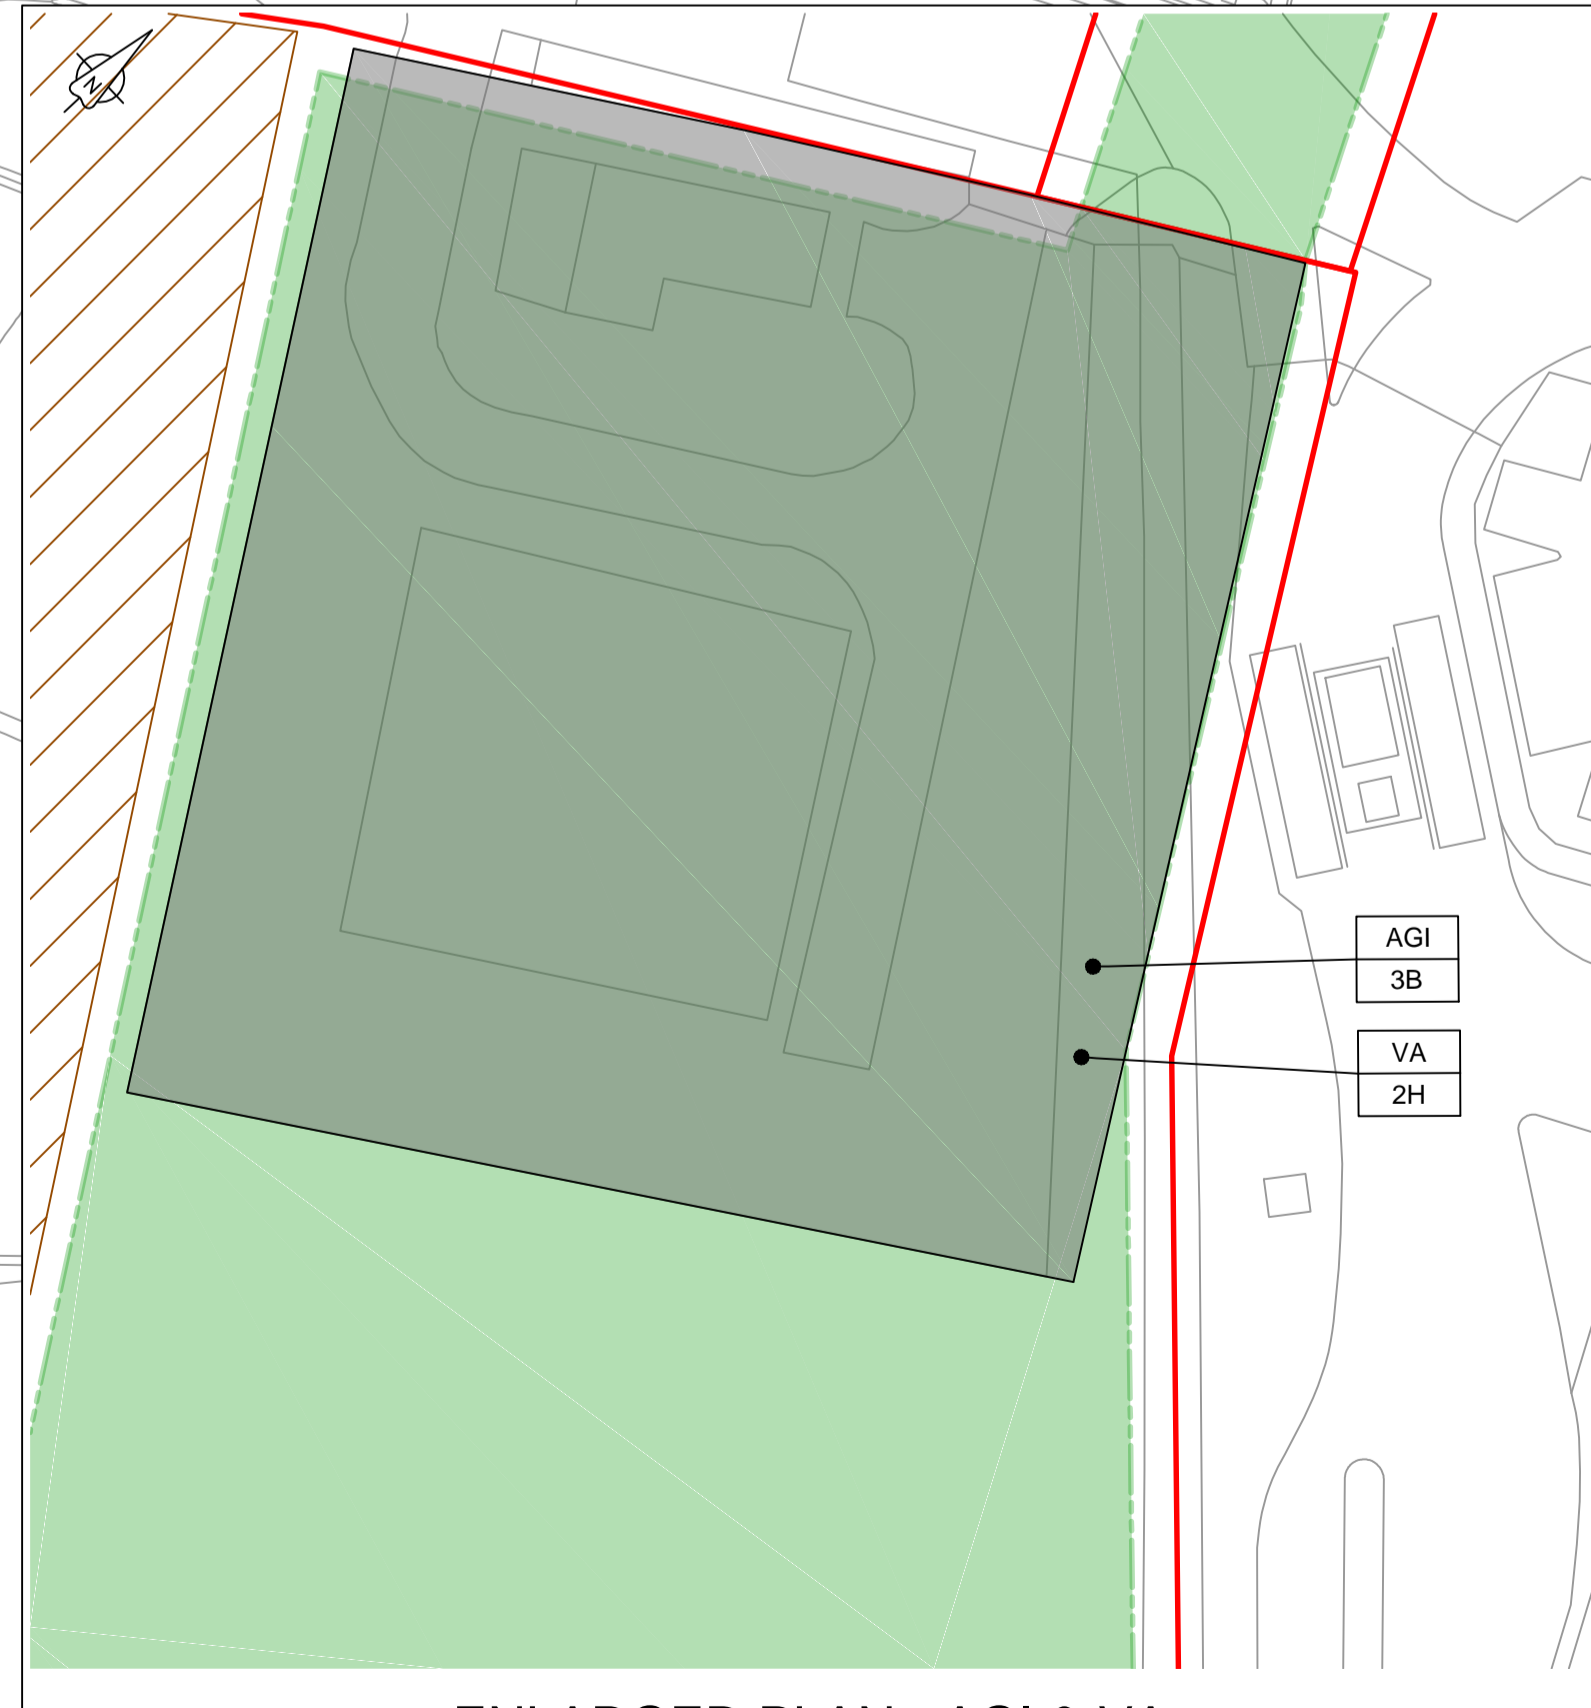

ENLARGED PLAN - AGI & VA  
SCALE 1:500

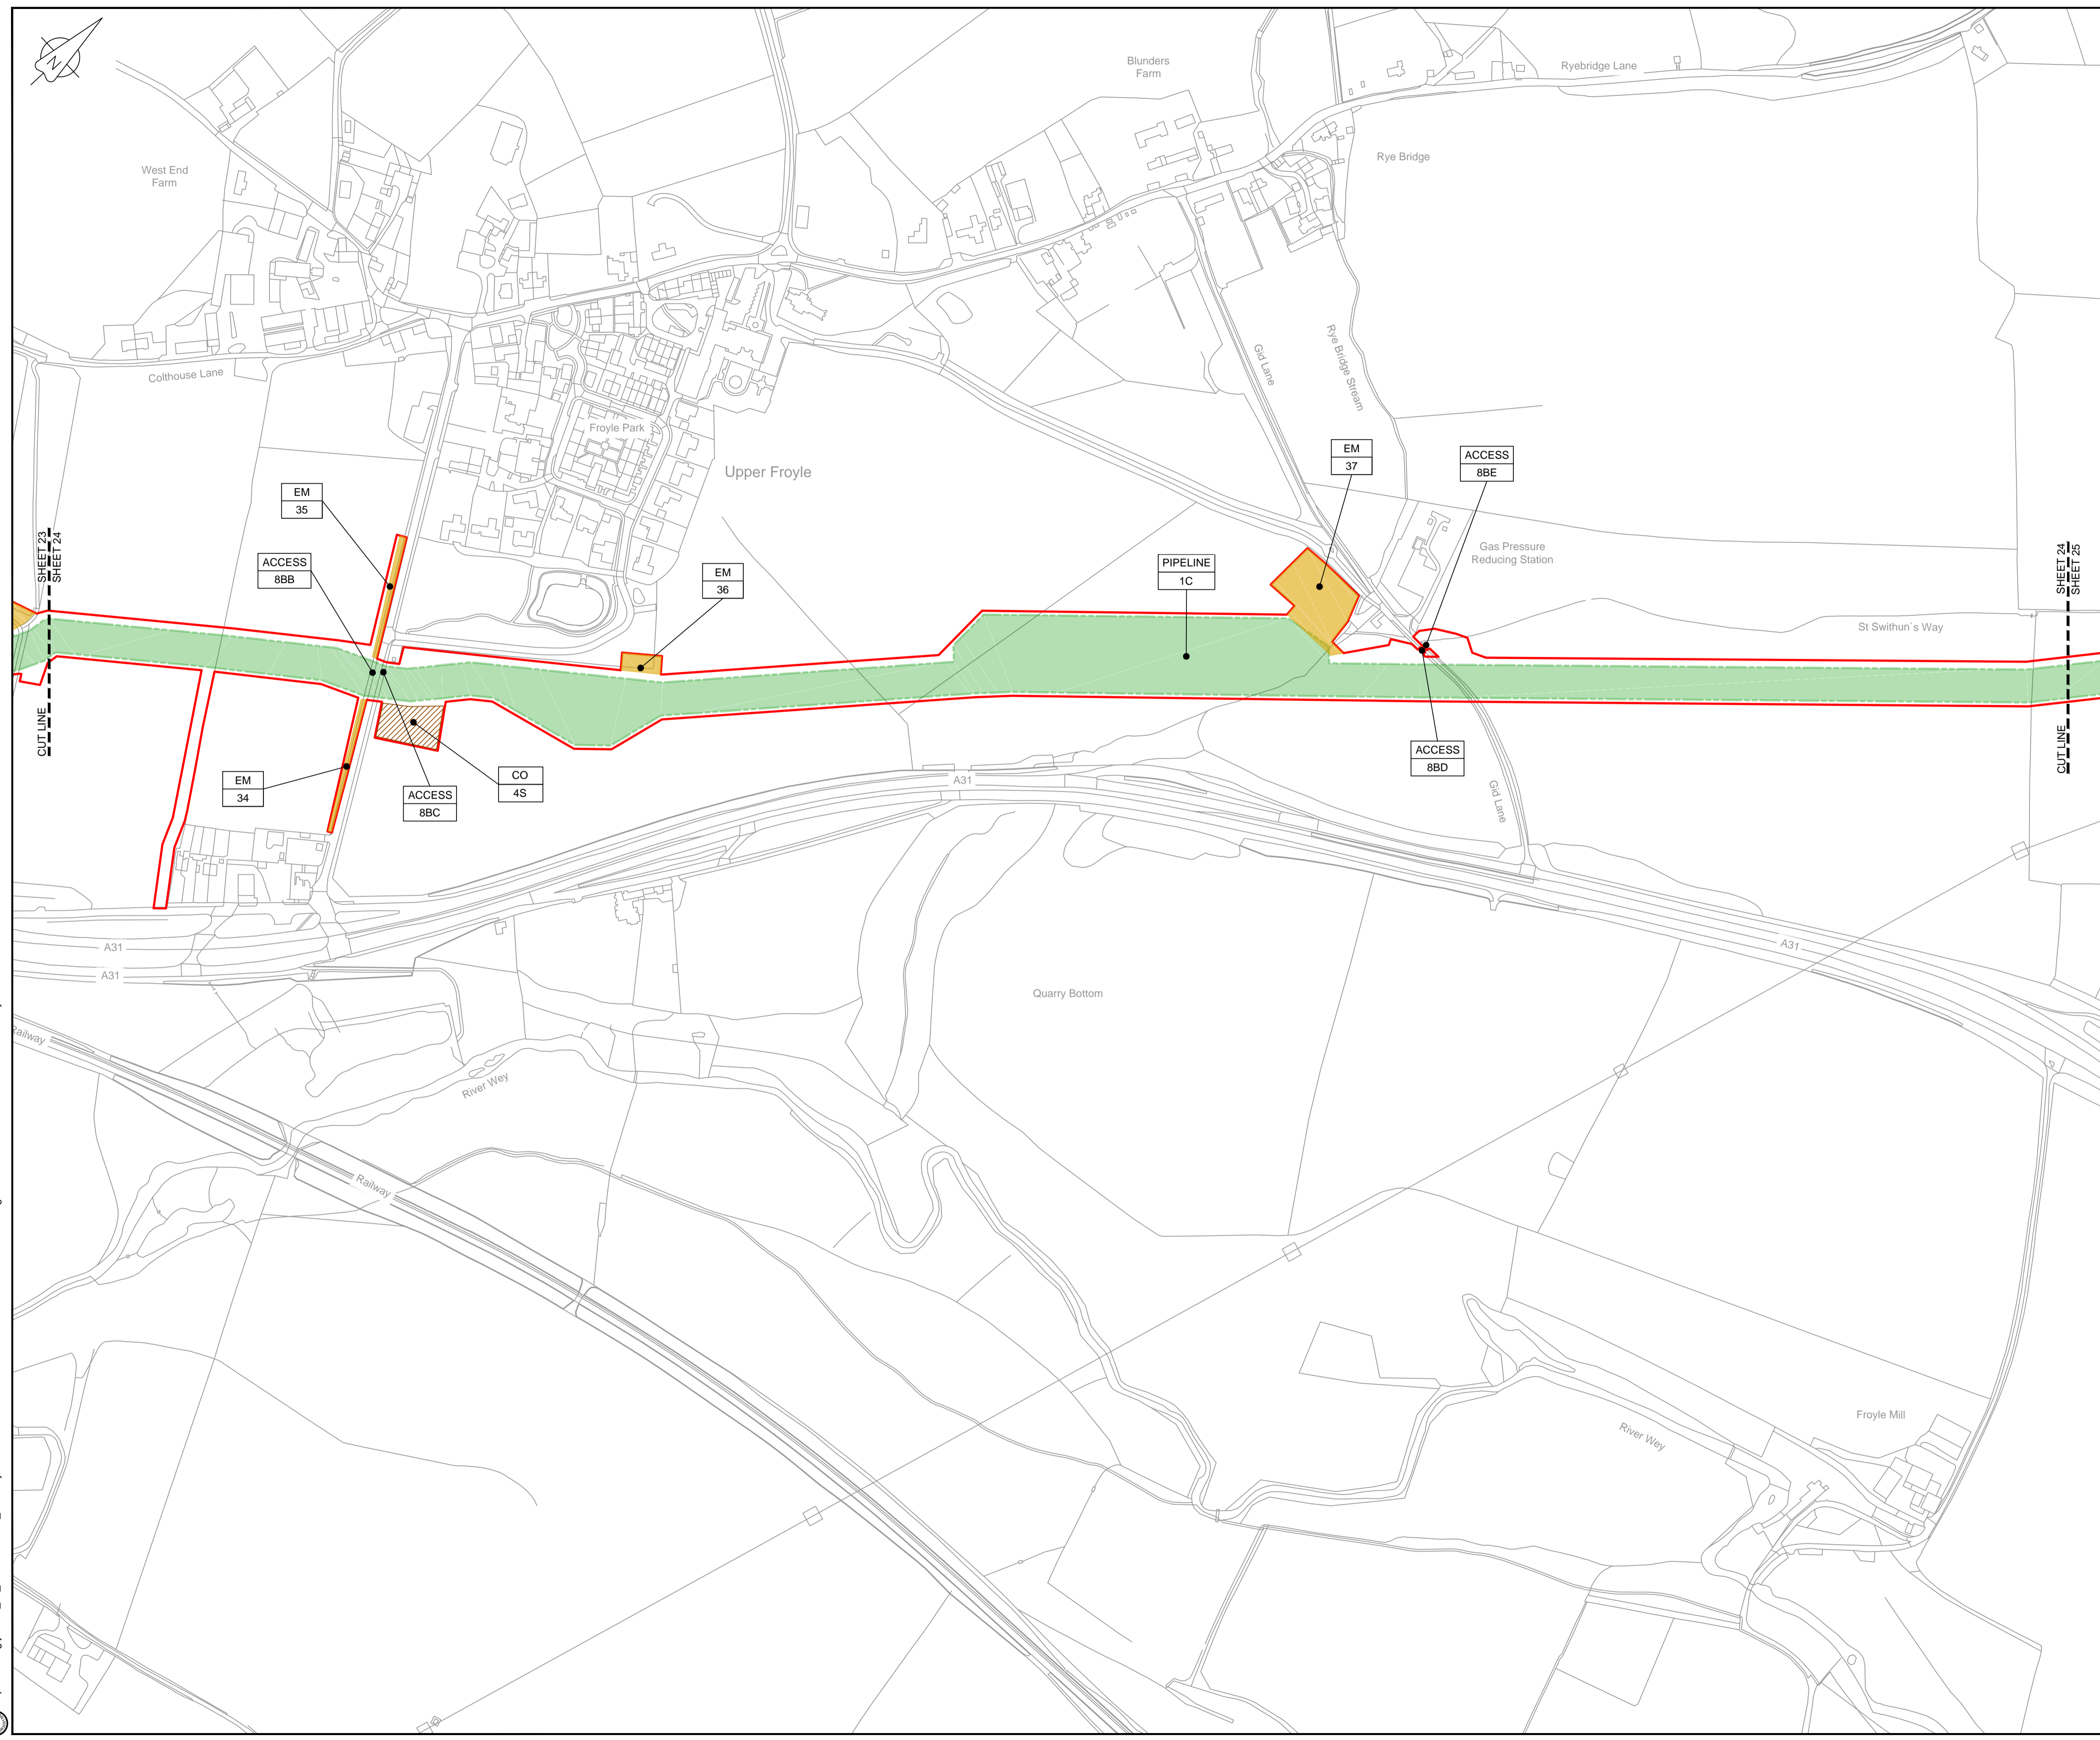

LOCATION PLAN  
SCALE 1:500,000

NOTES  
1. THIS DRAWING IS IN METRES UNLESS STATED OTHERWISE.

**LEGEND**

	ORDER LIMITS
	LIMITS OF DEVIATION
	COMPOUND (CO)
	ENVIRONMENTAL MITIGATION AREA (EM)
	ABOVE GROUND INSTALLATION (AGI) / VALVE (VA) / PRESSURE TRANSDUCER (PT)
	DESCRIPTION
	ID or WORK NUMBER (if applicable)
	ACCESS
	TEMPORARY CONSTRUCTION ACCESS
	P-ACCESS PERMANENT ACCESS
	COMMENCEMENT / TERMINATION OF WORKS (COMMENCEMENT = OPEN, TERMINATION = CLOSED)

Contains Ordnance Survey data © Crown copyright and database rights 2019.  
© Crown copyright and database rights 2019 OS Licence Number AL100005237.



C02	19/06/19	SHEETS 35 AND 109 REVISED FOLLOWING SSI ADVICE	SH	JA	ND	PH
C03	09/09/19	SHEETS 10, 11 AND 54 REVISED TO WITHDRAW A2b SUB-OPTION	BT	JA	ND	NJ
Rev	Rev. Date	Purpose of revision	Drawn	Checked	Rev'd	Appr'd

**JACOBS**

1180 Eskdale Road, Wokingham, Wokingham, RG41 5TU  
Tel:+44(0)118 946 7000 Fax:+44(0)118 946 7001  
www.jacobs.com

Client: Esso Petroleum Company, Limited  
Emryn House,  
Emryn Way,  
Leatherhead,  
Surrey,  
KT22 8UX

Project: Southampton to London Pipeline Project


Drawing title: **WORKS PLAN  
SHEET 24  
REGULATION 5 (2)(J)**

Drawing status: **Fit for Stage Approval**

Scale	1:2500	DO NOT SCALE
Jacobs No.	B2325300	Rev
Client no.		<b>C03</b>

Drawing number: **B2325300-JAC-000-CIV-DRG-000034**

© Copyright 2019 Jacobs U.K. Limited. The concepts and information contained in this document are the property of Jacobs. Use or copying of this document in whole or in part without the written permission of Jacobs constitutes an infringement of copyright. Limitation. This drawing has been prepared on behalf of, and for the exclusive use of, the Client, and is subject to, and issued in accordance with, the provisions of the contract between Jacobs and the Client. Jacobs accepts no liability or responsibility whatsoever for, or in respect of, any use of, or reliance upon, this drawing by any third party.

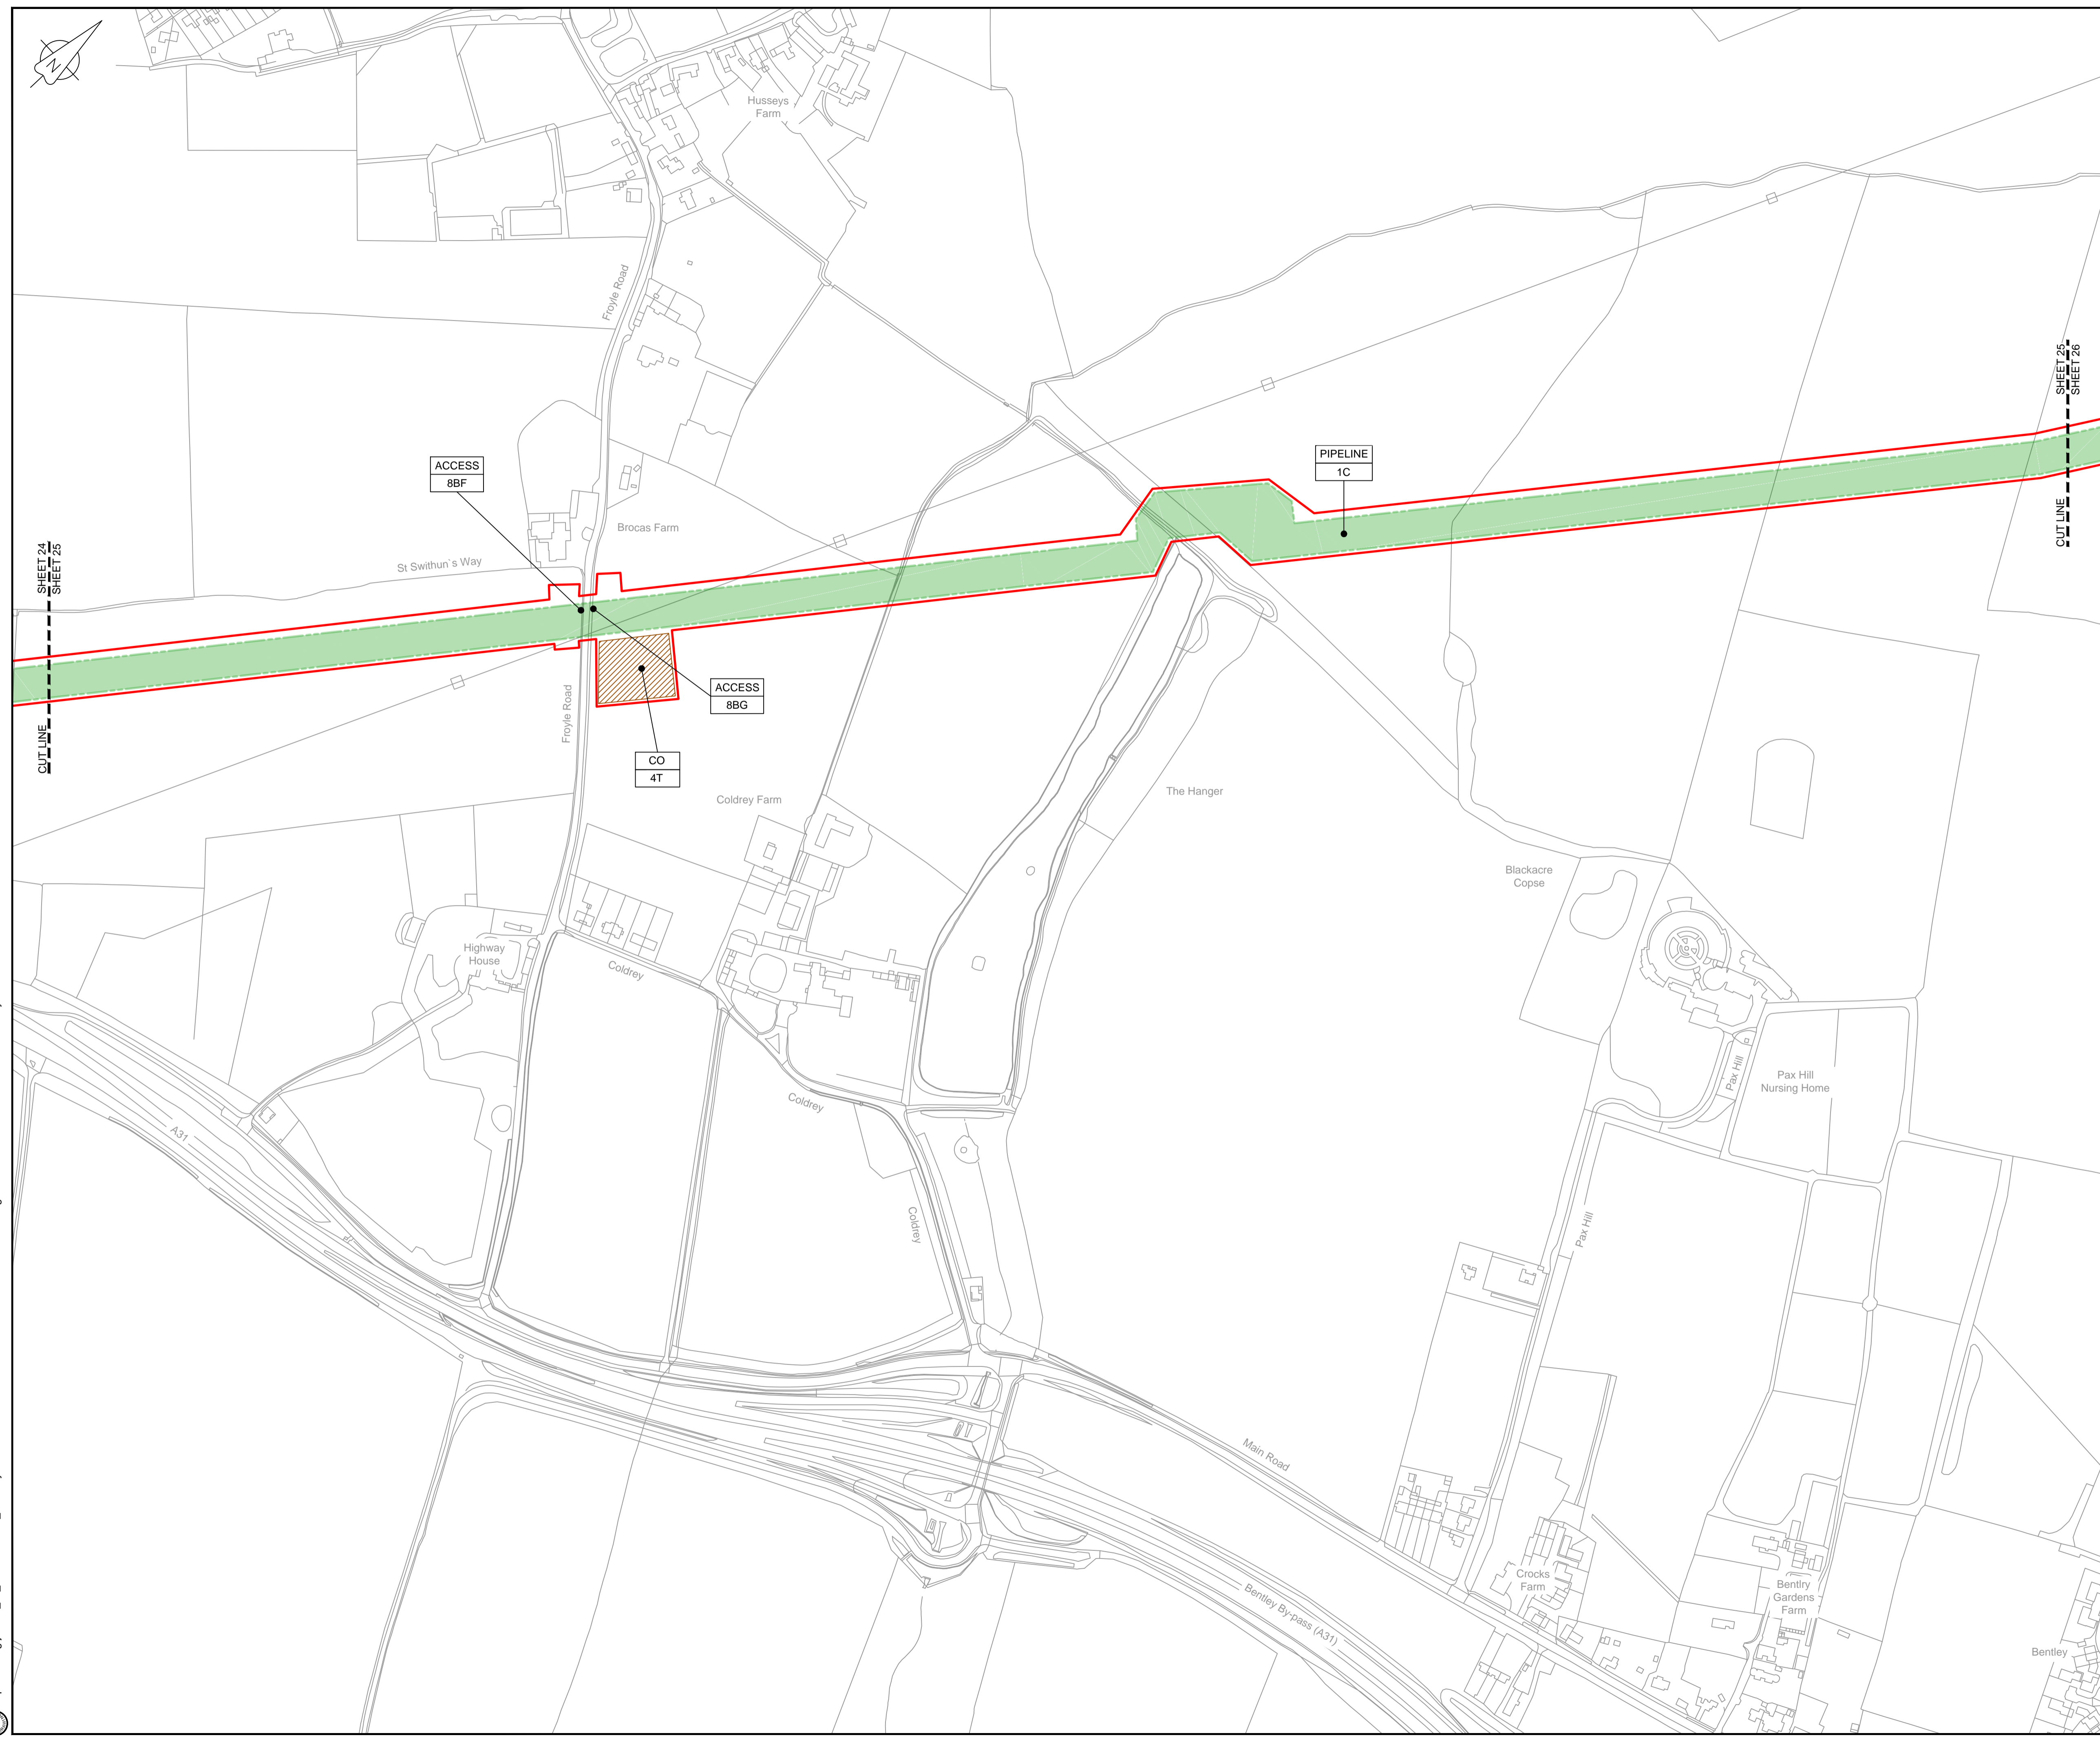

**LOCATION PLAN**  
SCALE 1:500,000

**NOTES**  
1. THIS DRAWING IS IN METRES UNLESS STATED OTHERWISE.

**LEGEND**

	ORDER LIMITS
	LIMITS OF DEVIATION
	COMPOUND (CO)
	ENVIRONMENTAL MITIGATION AREA (EM)
	ABOVE GROUND INSTALLATION (AGI) / VALVE (VA) / PRESSURE TRANSDUCER (PT)
	DESCRIPTION
	ID or WORK NUMBER (if applicable)
	ACCESS
	P-ACCESS
	COMMENCEMENT / TERMINATION OF WORKS (COMMENCEMENT = OPEN, TERMINATION = CLOSED)

Contains Ordnance Survey data © Crown copyright and database rights 2019.  
© Crown copyright and database rights 2019 OS Licence Number AL100005237.



C02	19/06/19	SHEETS 36 AND 109 REVISED FOLLOWING SSI ADVICE	SH	JA	ND	PH
C03	09/09/19	SHEETS 10, 11 AND 54 REVISED TO WITHDRAW A2b SUB-OPTION	BT	JA	ND	NJ
Rev	Rev. Date	Purpose of revision	Drawn	Checked	Rev'd	Appr'd



Client: Esso Petroleum Company, Limited  
Ermyn House,  
Ermyn Way,  
Leatherhead,  
Surrey,  
KT22 8UX



Drawing title  
**WORKS PLAN  
SHEET 25  
REGULATION 5 (2)(J)**


Drawing status  
**Fit for Stage Approval**

Scale	1:2500	DO NOT SCALE
Jacobs No.	B2325300	Rev
Client no.		<b>C03</b>

Drawing number  
**B2325300-JAC-000-CIV-DRG-000035**

© Copyright 2019 Jacobs U.K. Limited. The concepts and information contained in this document are the property of Jacobs. Use or copying of this document in whole or in part without the written permission of Jacobs constitutes an infringement of copyright. Limitation: This drawing has been prepared on behalf of, and for the exclusive use of, the Client, and is subject to, and issued in accordance with, the provisions of the contract between Jacobs and the Client. Jacobs accepts no liability or responsibility whatsoever for, or in respect of, any use of, or reliance upon, this drawing by any third party.



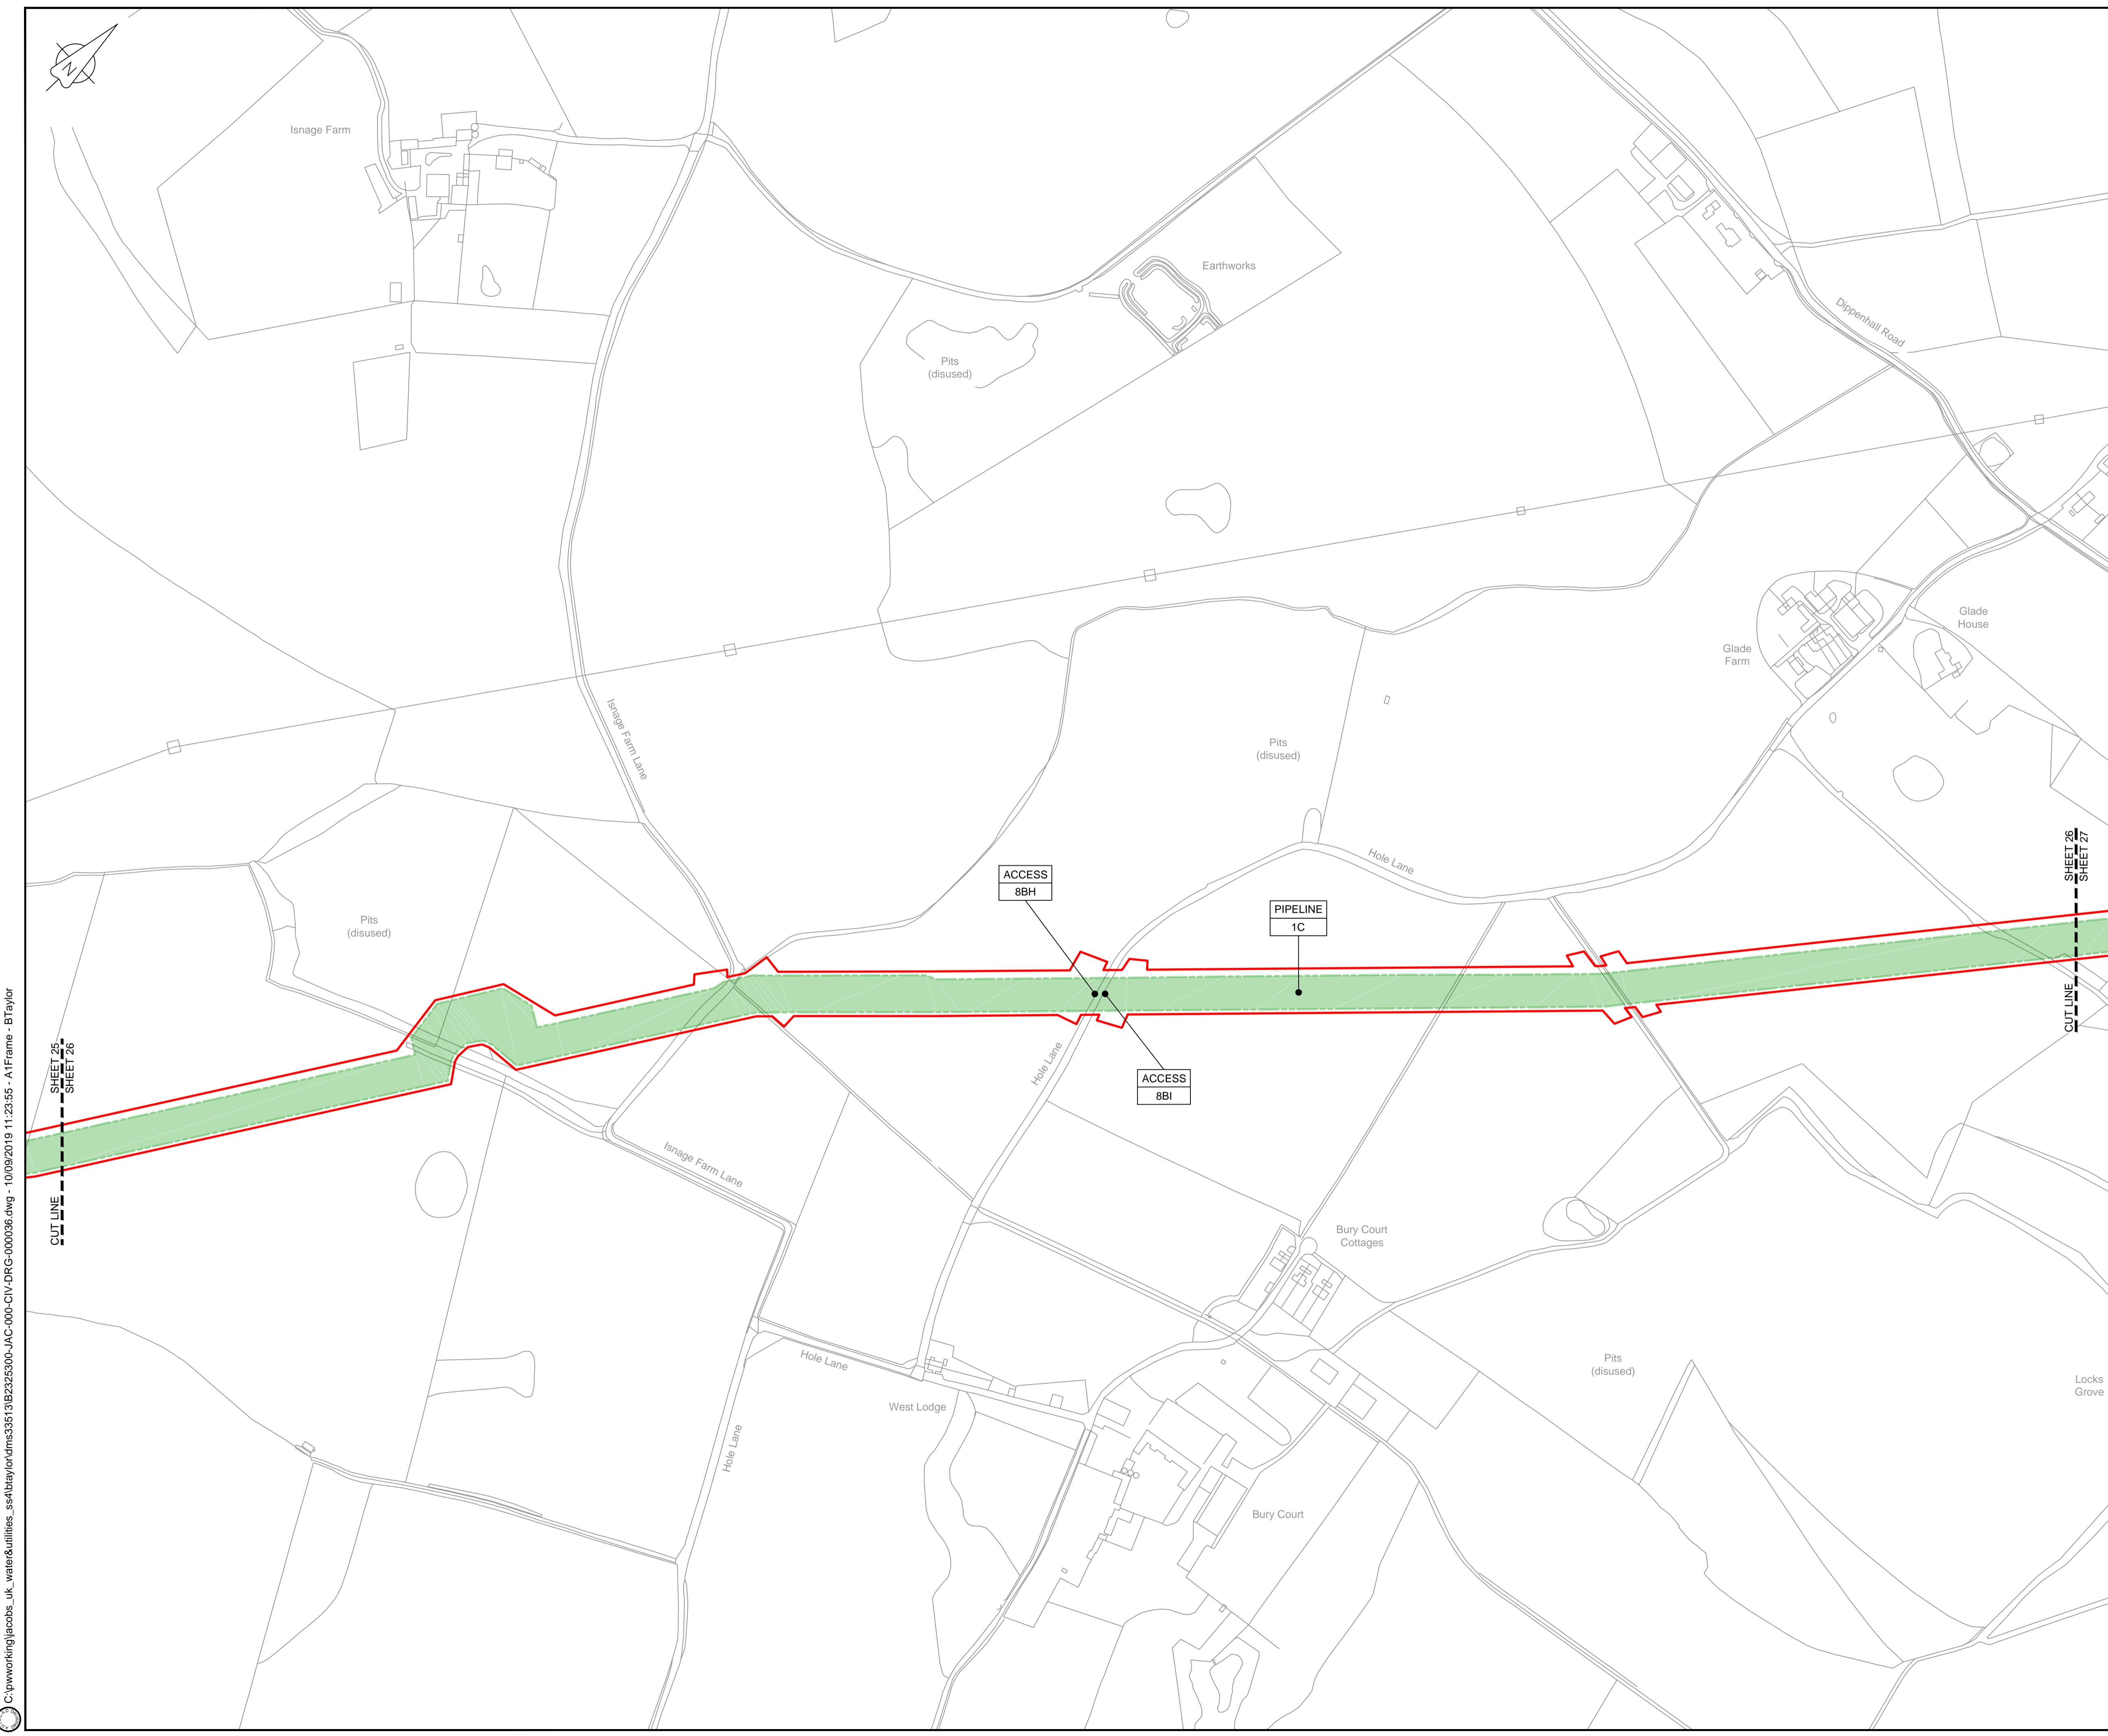

**LOCATION PLAN**  
SCALE 1:500,000

**NOTES**

1. THIS DRAWING IS IN METRES UNLESS STATED OTHERWISE.

**LEGEND**

- ORDER LIMITS
- LIMITS OF DEVIATION
- COMPOUND (CO)
- ENVIRONMENTAL MITIGATION AREA (EM)
- ABOVE GROUND INSTALLATION (AGI) / VALVE (VA) / PRESSURE TRANSDUCER (PT)
- DESCRIPTION
- ID or WORK NUMBER (if applicable)
- ACCESS
- TEMPORARY CONSTRUCTION ACCESS
- P-ACCESS
- PERMANENT ACCESS
- COMMENCEMENT / TERMINATION OF WORKS (COMMENCEMENT = OPEN, TERMINATION = CLOSED)

Contains Ordnance Survey data © Crown copyright and database rights 2019.

© Crown copyright and database rights 2019 OS Licence Number AL100005237.



C02	19/06/19	SHEETS 36 AND 109 REVISED FOLLOWING SSI ADVICE	SH	JA	ND	PH
C03	09/09/19	SHEETS 10, 11 AND 54 REVISED TO WITHDRAW A2b SUB-OPTION	BT	JA	ND	NJ
Rev	Rev. Date	Purpose of revision	Drawn	Checked	Rev'd	Appr'd



1180 Eskdale Road, Winnersh, Wokingham, RG41 5TU  
Tel:+44(0)118 946 7000 Fax:+44(0)118 946 7001  
www.jacobs.com

Client: Esso Petroleum Company, Limited  
Ermyn House,  
Ermyn Way,  
Leatherhead,  
Surrey,  
KT22 8UX



Drawing title  
**WORKS PLAN  
SHEET 26  
REGULATION 5 (2)(J)**

Drawing status  
**Fit for Stage Approval**

Scale	1:2500	DO NOT SCALE
Jacobs No.	B2325300	Rev
Client no.		<b>C03</b>

Drawing number  
**B2325300-JAC-000-CIV-DRG-000036**

© Copyright 2019 Jacobs U.K. Limited. The concepts and information contained in this document are the property of Jacobs. Use or copying of this document in whole or in part without the written permission of Jacobs constitutes an infringement of copyright. Limitation: This drawing has been prepared on behalf of, and for the exclusive use of, the Client, and is subject to, and issued in accordance with, the provisions of the contract between Jacobs and the Client. Jacobs accepts no liability or responsibility whatsoever for, or in respect of, any use of, or reliance upon, this drawing by any third party.



**NOTES**  
1. THIS DRAWING IS IN METRES UNLESS STATED OTHERWISE.

**LEGEND**

	ORDER LIMITS
	LIMITS OF DEVIATION
	COMPOUND (CO)
	ENVIRONMENTAL MITIGATION AREA (EM)
	ABOVE GROUND INSTALLATION (AGI) / VALVE (VA) / PRESSURE TRANSDUCER (PT)
	DESCRIPTION
	ID or WORK NUMBER (if applicable)
	ACCESS
	TEMPORARY CONSTRUCTION ACCESS
	P-ACCESS
	PERMANENT ACCESS
	COMMENCEMENT / TERMINATION OF WORKS (COMMENCEMENT = OPEN, TERMINATION = CLOSED)

Contains Ordnance Survey data © Crown copyright and database rights 2019.  
© Crown copyright and database rights 2019 OS Licence Number AL100005237.



C02	19/06/19	SHEETS 38 AND 109 REVISED FOLLOWING SSI ADVICE	SH	JA	ND	PH
C03	09/09/19	SHEETS 10, 11 AND 54 REVISED TO WITHDRAW A2b SUB-OPTION	BT	JA	ND	NJ
Rev	Rev. Date	Purpose of revision	Drawn	Checked	Rev'd	Appr'd

**JACOBS**  
1180 Eskdale Road, Wokingham, Wokingham, RG41 5TU  
Tel:+44(0)118 946 7000 Fax:+44(0)118 946 7001  
www.jacobs.com

Client: Esso Petroleum Company, Limited  
Emryn House,  
Emryn Way,  
Leatherhead,  
Surrey,  
KT22 8UX

Project: Southampton to London Pipeline Project




Drawing title: **WORKS PLAN SHEET 27 REGULATION 5 (2)(J)**

Drawing status: **Fit for Stage Approval**

Scale	1:2500	DO NOT SCALE
Jacobs No.	B2325300	Rev
Client no.		<b>C03</b>

Drawing number: **B2325300-JAC-000-CIV-DRG-000037**

© Copyright 2019 Jacobs U.K. Limited. The concepts and information contained in this document are the property of Jacobs. Use or copying of this document in whole or in part without the written permission of Jacobs constitutes an infringement of copyright. Limitation: This drawing has been prepared on behalf of, and for the exclusive use of, the Client, and is subject to, and issued in accordance with, the provisions of the contract between Jacobs and the Client. Jacobs accepts no liability or responsibility whatsoever for, or in respect of, any use of, or reliance upon, this drawing by any third party.

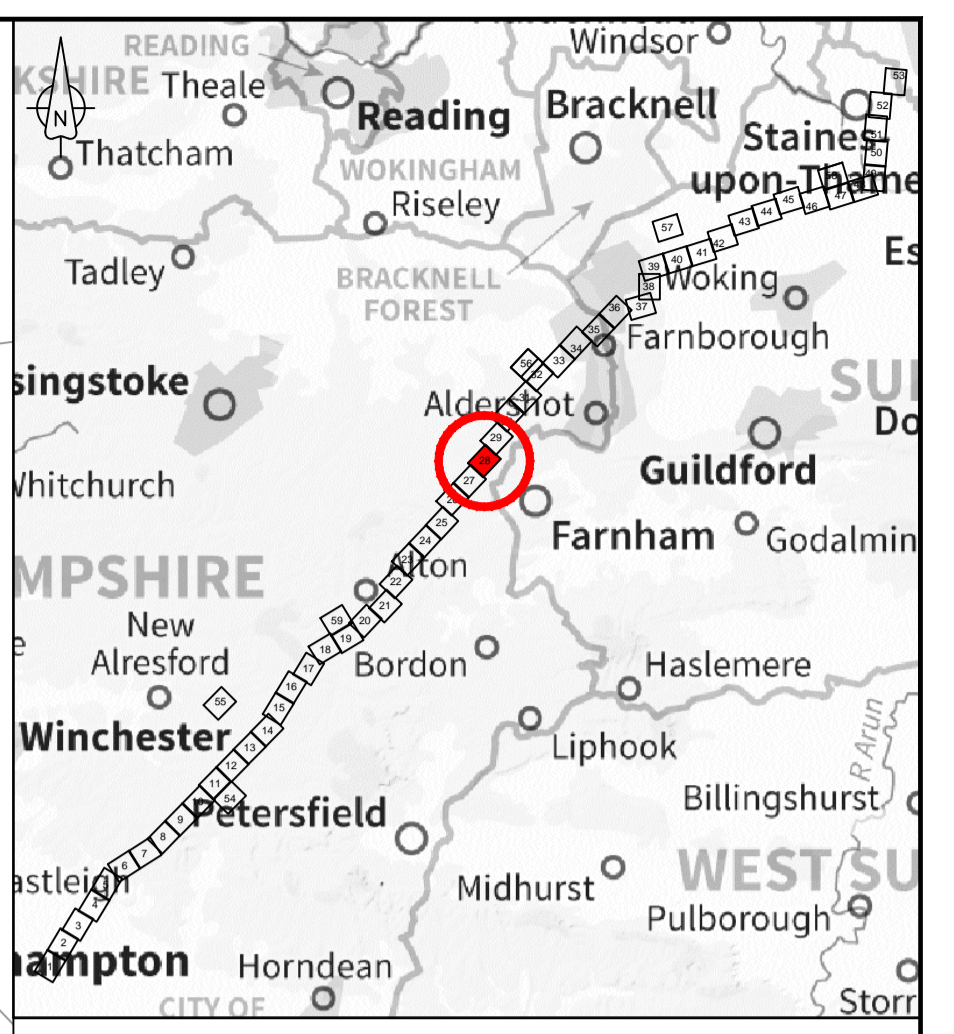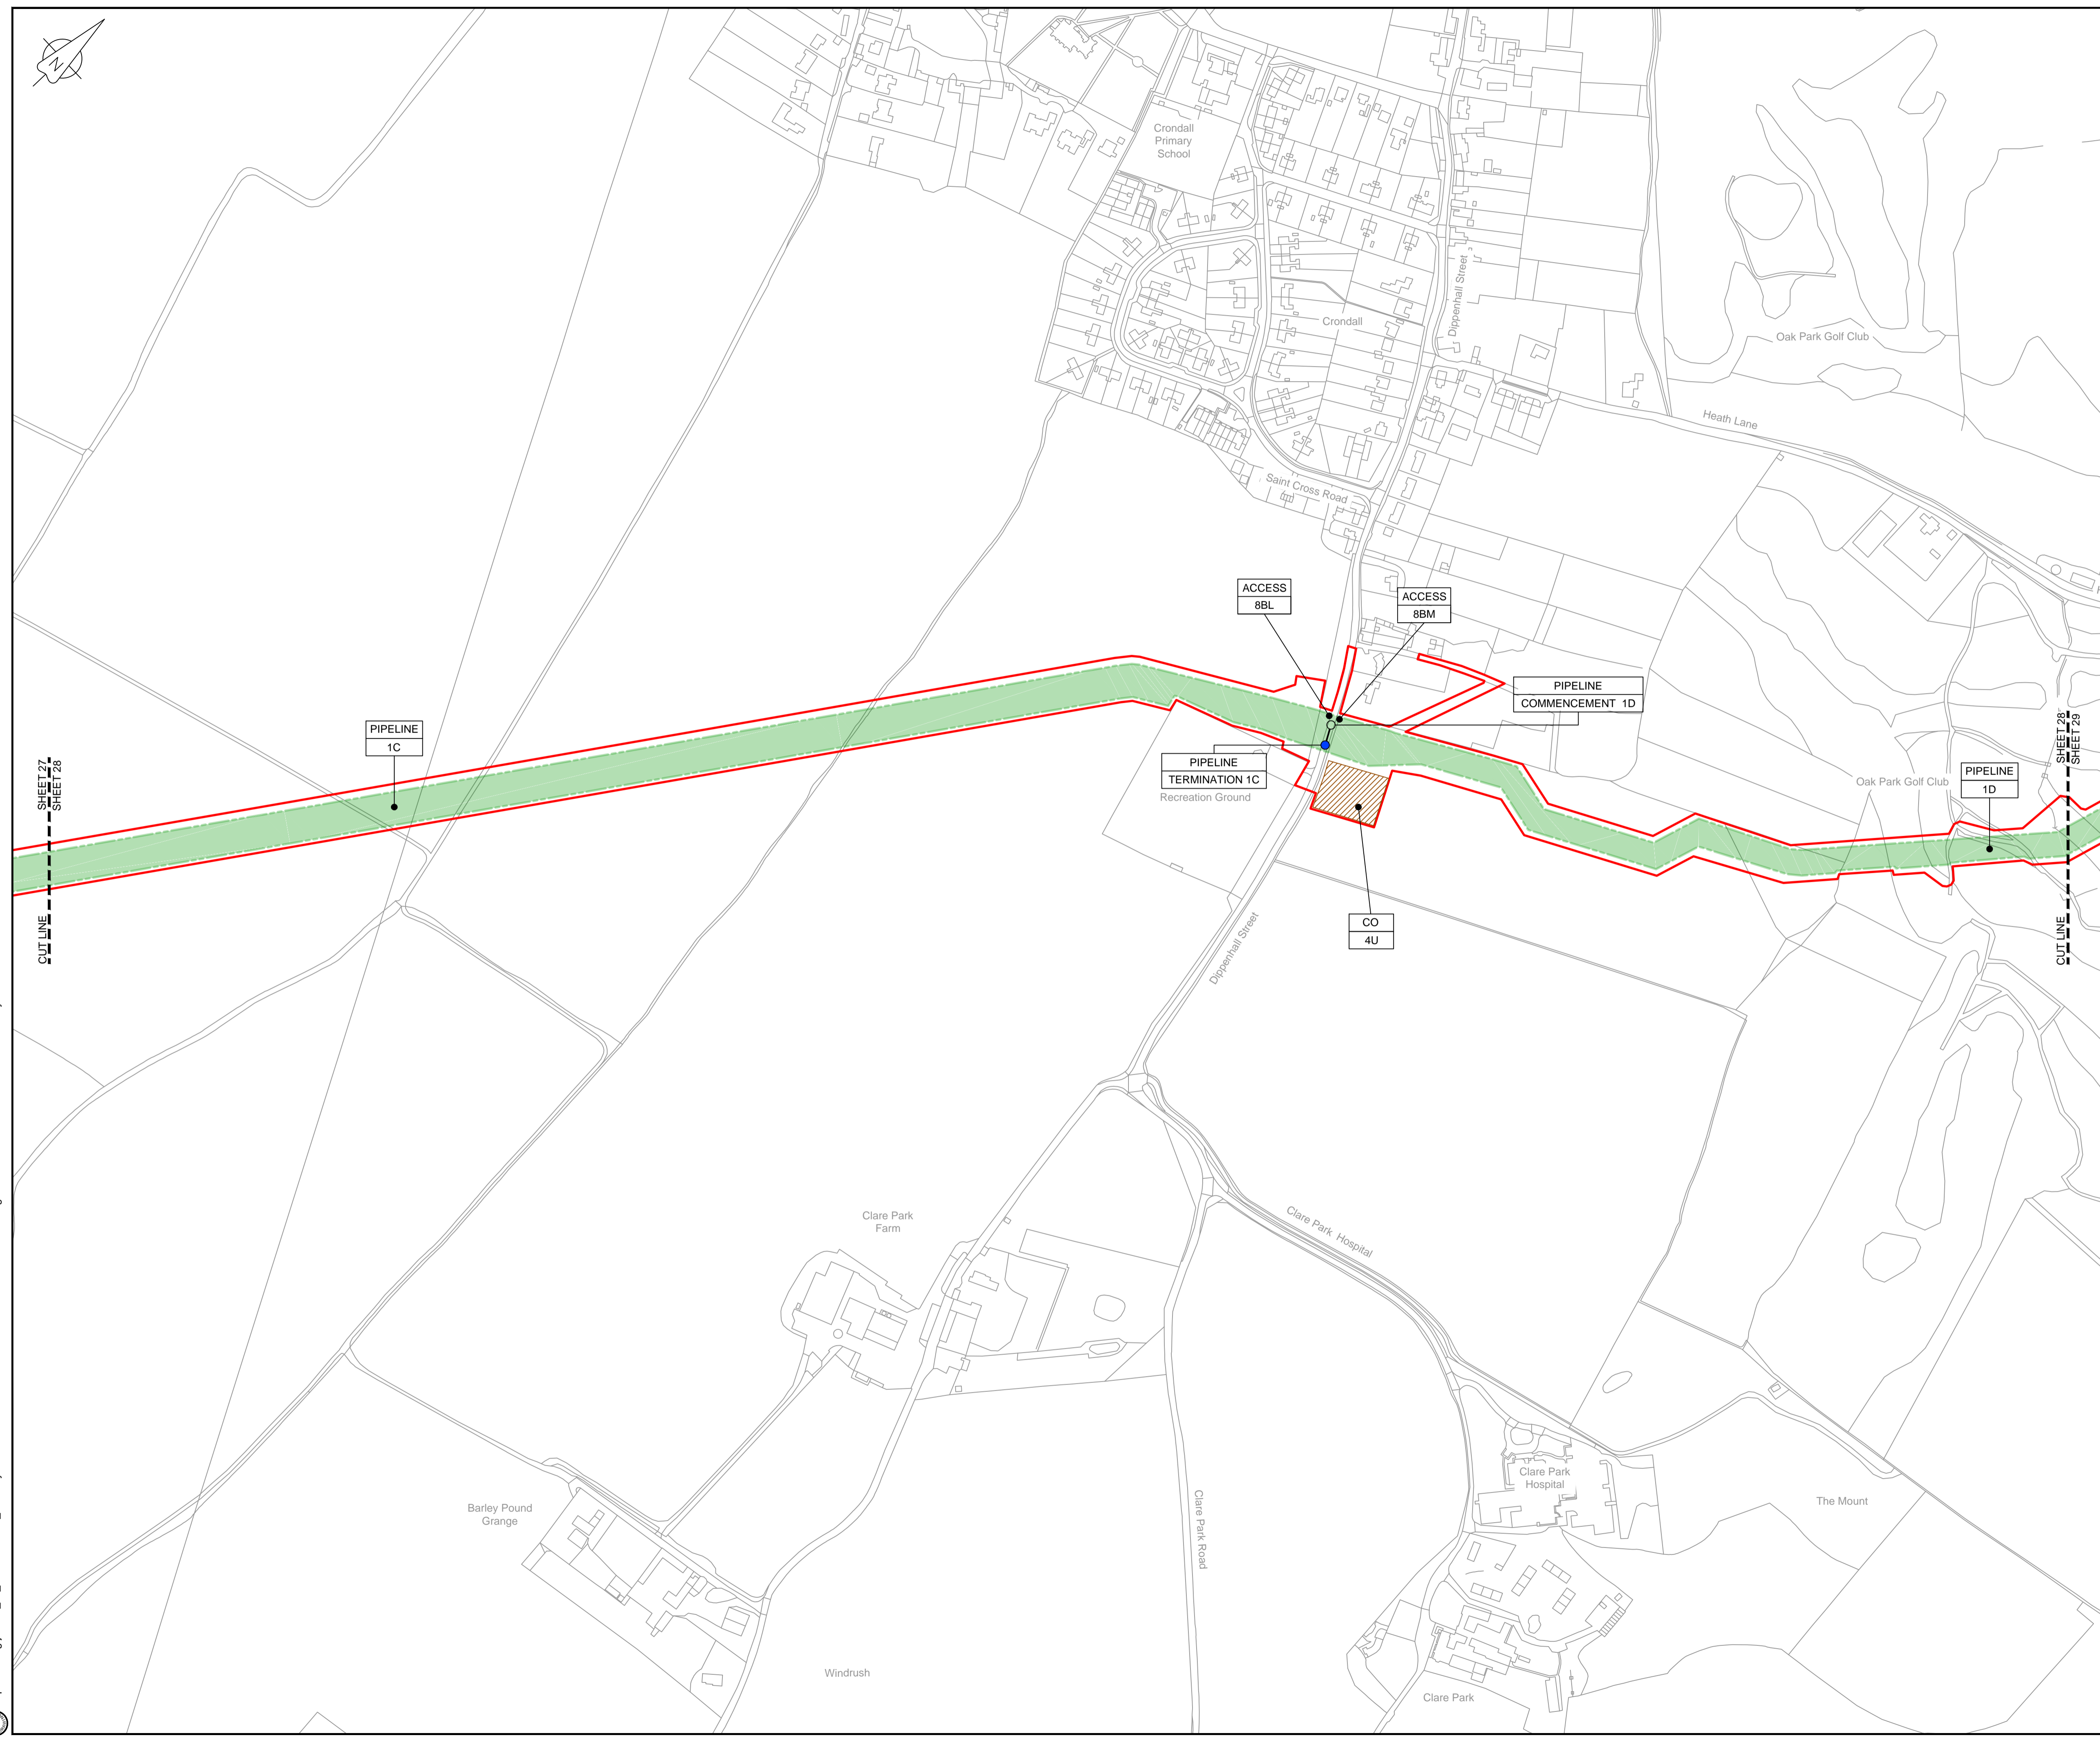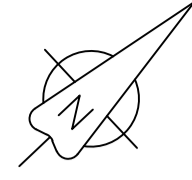

LOCATION PLAN  
SCALE 1:500,000

NOTES


1. THIS DRAWING IS IN METRES UNLESS STATED OTHERWISE.

LEGEND

- ORDER LIMITS
- LIMITS OF DEVIATION
- COMPOUND (CO)
- ENVIRONMENTAL MITIGATION AREA (EM)
- ABOVE GROUND INSTALLATION (AGI) / VALVE (VA) / PRESSURE TRANSDUCER (PT)
- DESCRIPTION
- ID or WORK NUMBER (if applicable)
- ACCESS
- P-ACCESS
- COMMENCEMENT / TERMINATION OF WORKS (COMMENCEMENT = OPEN, TERMINATION = CLOSED)

Contains Ordnance Survey data © Crown copyright and database rights 2019.

© Crown copyright and database rights 2019 OS Licence Number AL10005237.

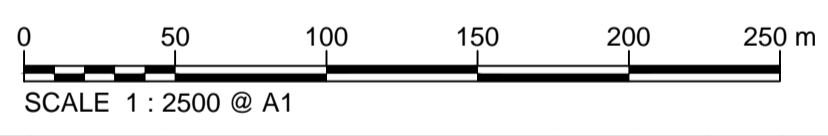

C02	19/06/19	SHEETS 35 AND 109 REVISED FOLLOWING SSI ADVICE	SH	JA	ND	PH
C03	09/09/19	SHEETS 10, 11 AND 54 REVISED TO WITHDRAW A2b SUB-OPTION	BT	JA	ND	NJ
Rev	Rev. Date	Purpose of revision	Drawn	Checked	Rev'd	Appr'd



1180 Eskdale Road, Winnersh, Wokingham, RG41 5TU  
Tel: +44(0)118 946 7000 Fax: +44(0)118 946 7001  
www.jacobs.com

Client: Esso Petroleum Company, Limited  
Emryn House,  
Emryn Way,  
Leatherhead,  
Surrey,  
KT22 8UX



Southampton to London  
Pipeline Project


Drawing title  
**WORKS PLAN  
SHEET 28  
REGULATION 5 (2)(J)**

Drawing status  
**Fit for Stage Approval**

Scale	1:2500	DO NOT SCALE
Jacobs No.	B2325300	Rev
Client no.		<b>C03</b>

Drawing number  
**B2325300-JAC-000-CIV-DRG-000038**

© Copyright 2019 Jacobs U.K. Limited. The concepts and information contained in this document are the property of Jacobs. Use or copying of this document in whole or in part without the written permission of Jacobs constitutes an infringement of copyright. Limitation: This drawing has been prepared on behalf of, and for the exclusive use of, the Client, and is subject to, and issued in accordance with, the provisions of the contract between Jacobs and the Client. Jacobs accepts no liability or responsibility whatsoever for, or in respect of, any use of, or reliance upon, this drawing by any third party.

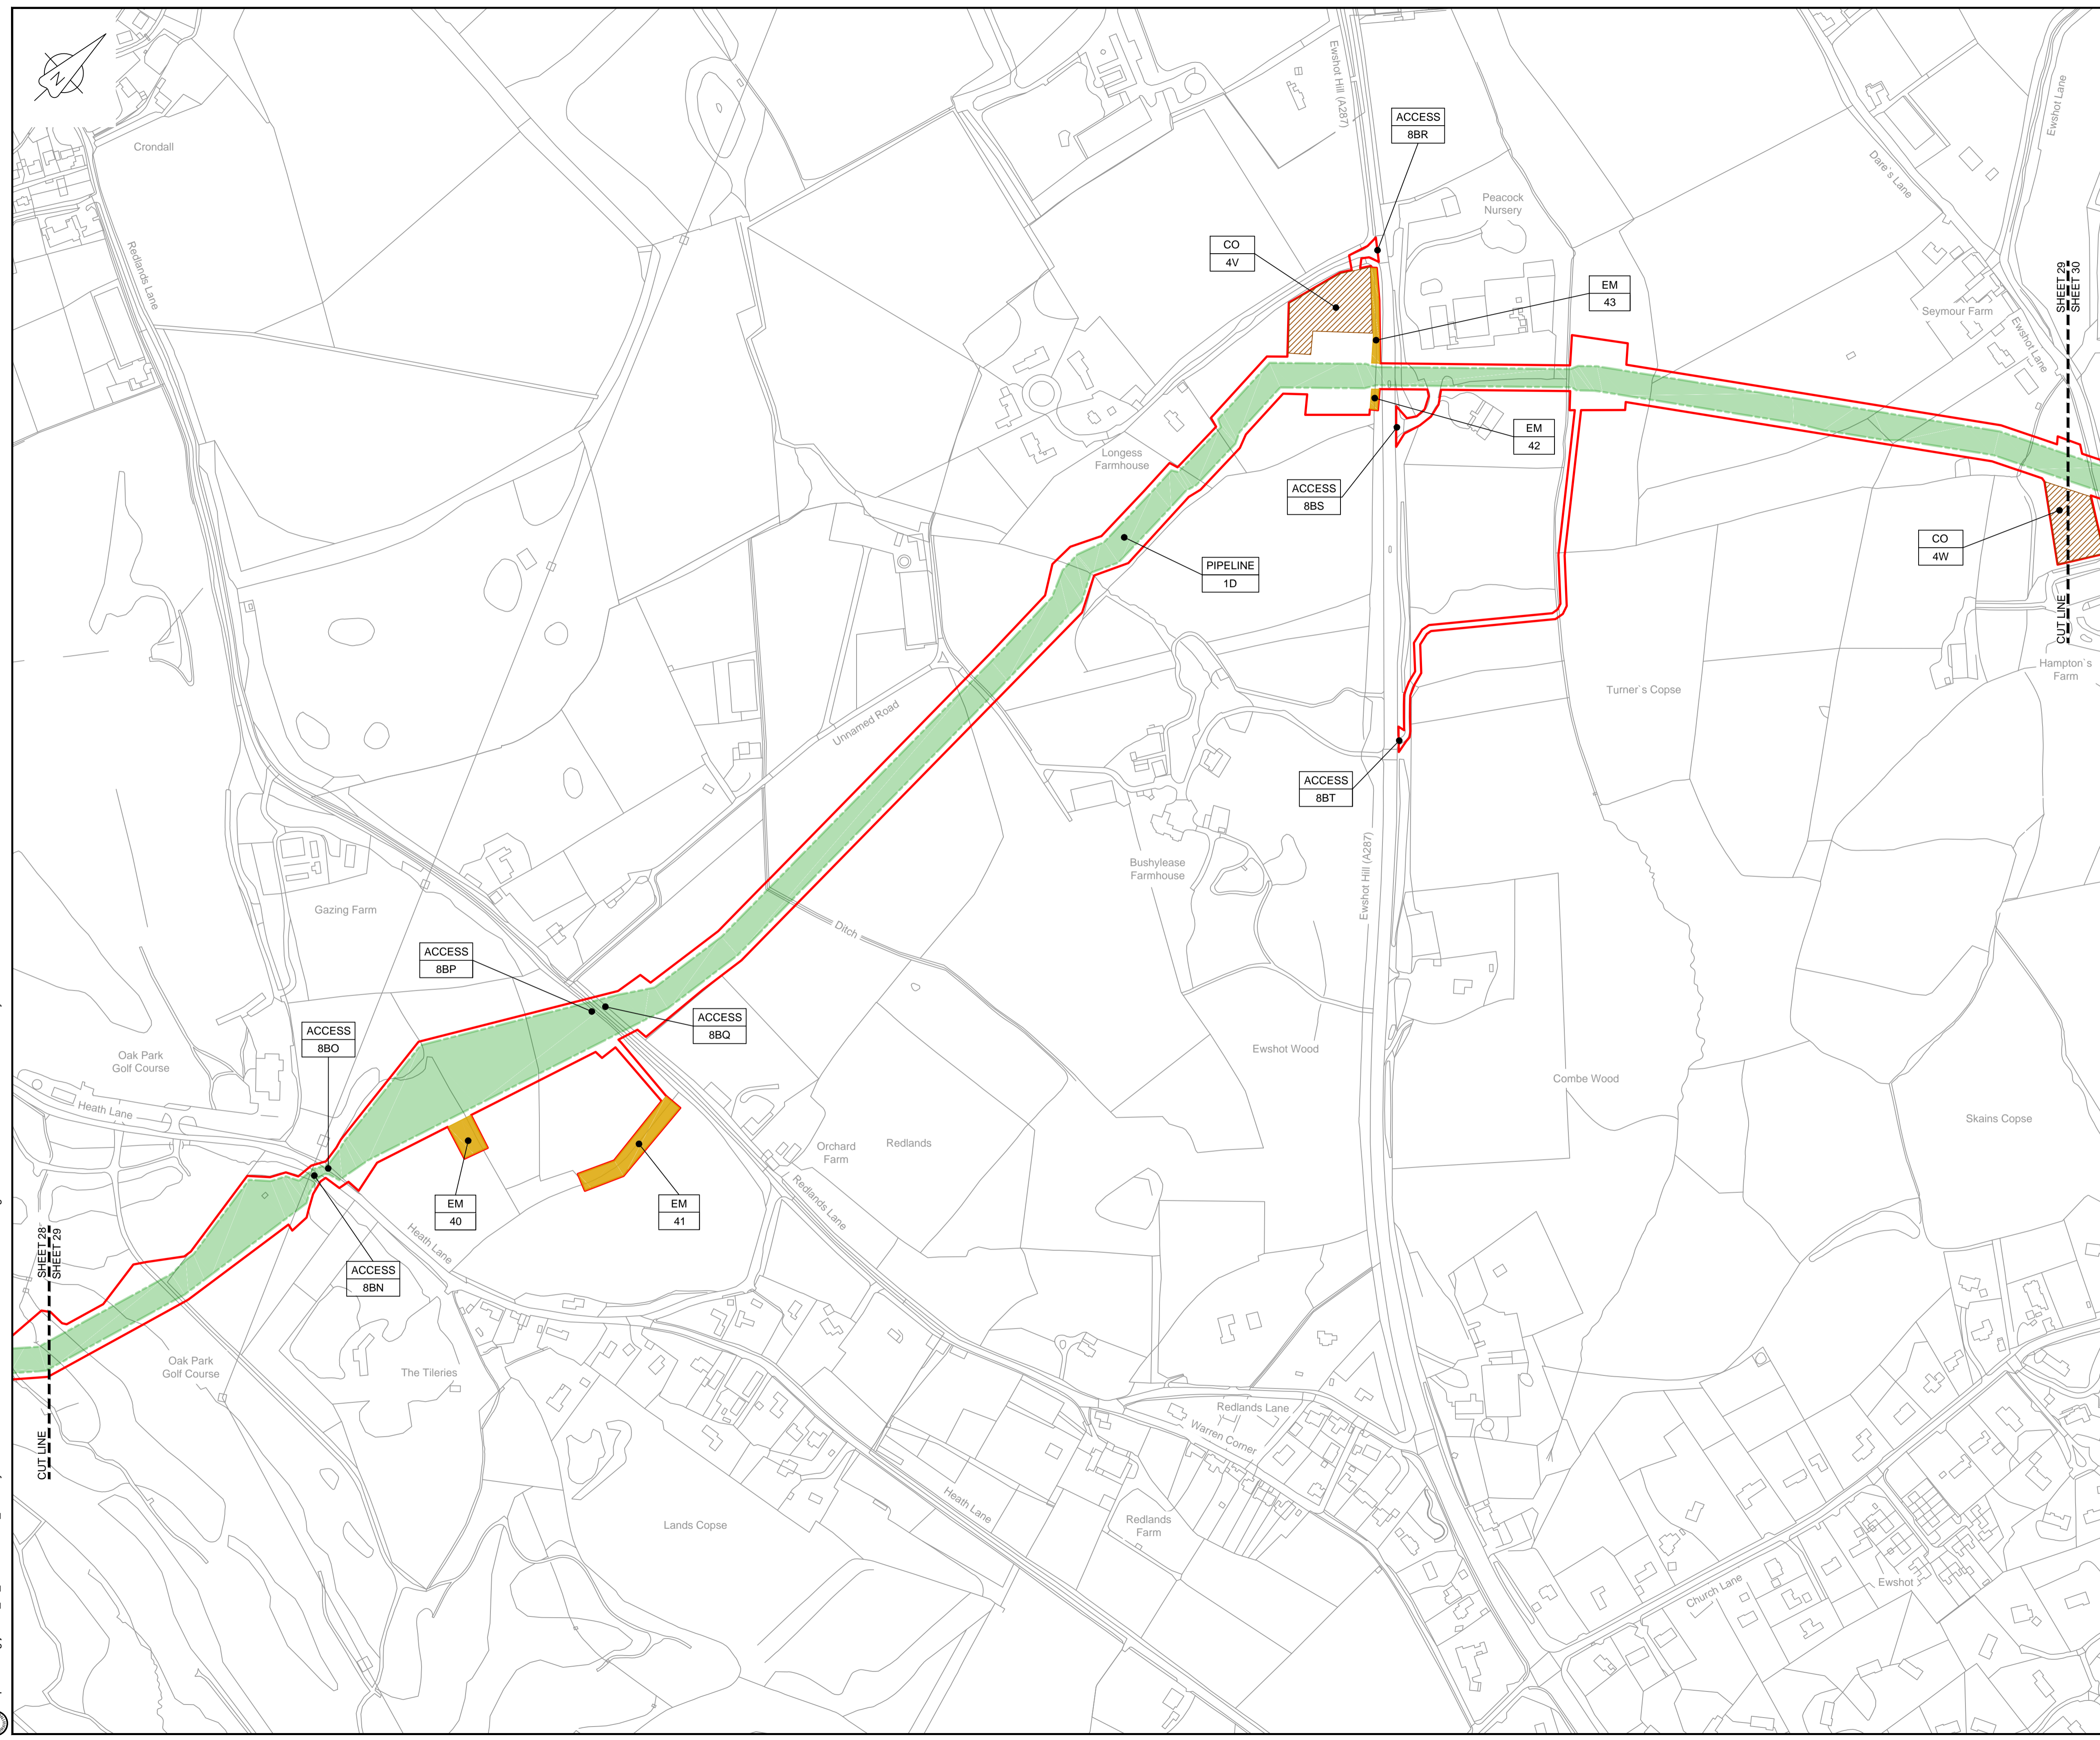

**LOCATION PLAN**  
SCALE 1:500,000

**NOTES**  
1. THIS DRAWING IS IN METRES UNLESS STATED OTHERWISE.

**LEGEND**

- ORDER LIMITS
- LIMITS OF DEVIATION
- COMPOUND (CO)
- ENVIRONMENTAL MITIGATION AREA (EM)
- ABOVE GROUND INSTALLATION (AGI) / VALVE (VA) / PRESSURE TRANSDUCER (PT)
- DESCRIPTION
- ID or WORK NUMBER (if applicable)
- ACCESS TEMPORARY CONSTRUCTION ACCESS
- P-ACCESS PERMANENT ACCESS
- COMMENCEMENT / TERMINATION OF WORKS (COMMENCEMENT = OPEN, TERMINATION = CLOSED)

Contains Ordnance Survey data © Crown copyright and database rights 2019.  
© Crown copyright and database rights 2019 OS Licence Number AL10005237.



C02	19/06/19	SHEETS 35 AND 109 REVISED FOLLOWING SSI ADVICE	SH	JA	ND	PH
C03	09/09/19	SHEETS 10, 11 AND 54 REVISED TO WITHDRAW A2B SUB-OPTION	BT	JA	ND	NJ
Rev	Rev. Date	Purpose of revision	Drawn	Checked	Rev'd	Appr'd

**JACOBS**  
1180 Eskdale Road, Winnersh, Wokingham, RG41 5TU  
Tel: +44(0)118 946 7000 Fax: +44(0)118 946 7001  
www.jacobs.com

Client: Esso Petroleum Company, Limited  
Emryn House,  
Emryn Way,  
Leatherhead,  
Surrey,  
KT22 8UX

Project: Southampton to London Pipeline Project


Drawing title: **WORKS PLAN SHEET 29 REGULATION 5 (2)(J)**

Drawing status: **Fit for Stage Approval**

Scale	1:2500	DO NOT SCALE
Jacobs No.	B2325300	Rev
Client no.		<b>C03</b>

Drawing number: **B2325300-JAC-000-CIV-DRG-000039**

© Copyright 2019 Jacobs U.K. Limited. The concepts and information contained in this document are the property of Jacobs. Use or copying of this document in whole or in part without the written permission of Jacobs constitutes an infringement of copyright. Limitation: This drawing has been prepared on behalf of, and for the exclusive use of, the Client, and is subject to, and issued in accordance with, the provisions of the contract between Jacobs and the Client. Jacobs accepts no liability or responsibility whatsoever for, or in respect of, any use of, or reliance upon, this drawing by any third party.

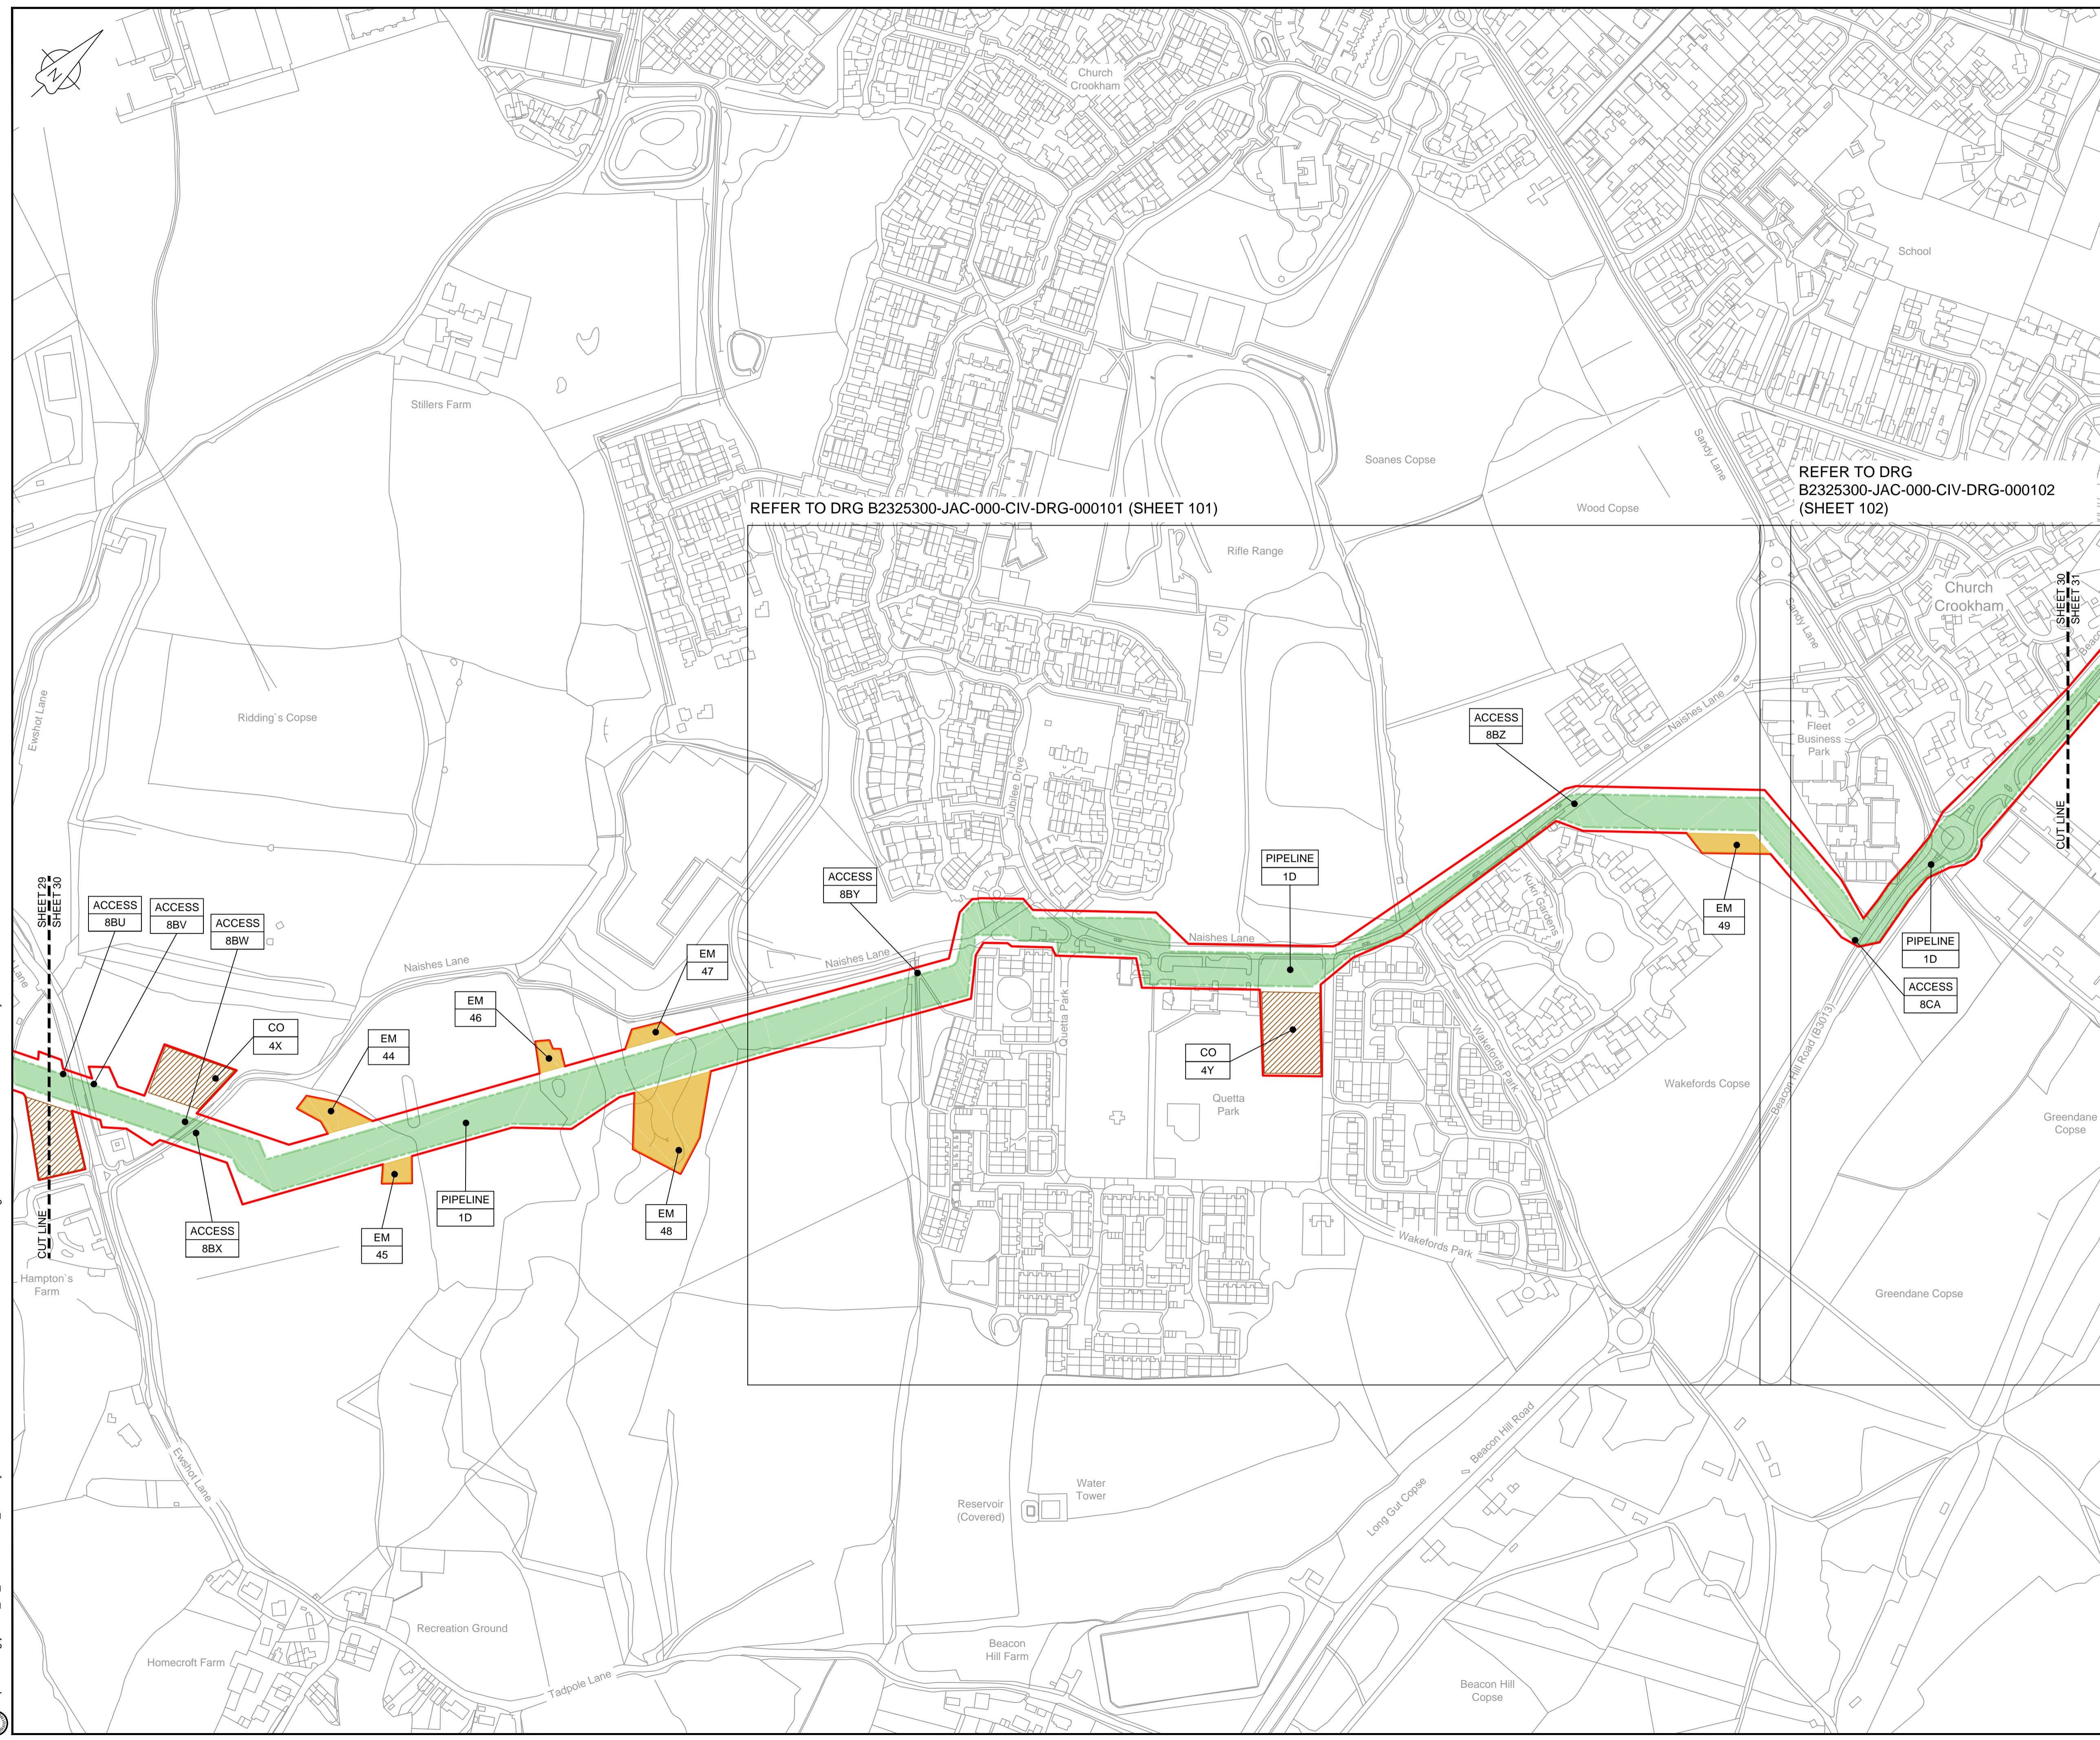

**LOCATION PLAN**  
SCALE 1:500,000

**NOTES**  
1. THIS DRAWING IS IN METRES UNLESS STATED OTHERWISE.

**LEGEND**

	ORDER LIMITS
	LIMITS OF DEVIATION
	COMPOUND (CO)
	ENVIRONMENTAL MITIGATION AREA (EM)
	ABOVE GROUND INSTALLATION (AGI) / VALVE (VA) / PRESSURE TRANSDUCER (PT)
	DESCRIPTION
	ID or WORK NUMBER (if applicable)
	ACCESS
	TEMPORARY CONSTRUCTION ACCESS
	P-ACCESS
	PERMANENT ACCESS
	COMMENCEMENT / TERMINATION OF WORKS
	(COMMENCEMENT = OPEN, TERMINATION = CLOSED)

Contains Ordnance Survey data © Crown copyright and database rights 2019.  
© Crown copyright and database rights 2019 OS Licence Number AL100005237.



Rev	Rev. Date	Purpose of revision	Drawn	Checked	Rev'd	Appr'd
C02	19/06/19	SHEETS 35 AND 109 REVISED FOLLOWING SSI ADVICE	SH	JA	ND	PH
C03	09/09/19	SHEETS 10, 11 AND 54 REVISED TO WITHDRAW A2b SUB-OPTION	BT	JA	ND	NJ

**JACOBS**  
1180 Eskdale Road, Wokingham, Wokingham, RG41 5TU  
Tel: +44(0)118 946 7000 Fax: +44(0)118 946 7001  
www.jacobs.com

Client: Esso Petroleum Company, Limited  
Emryn House,  
Emryn Way,  
Leatherhead,  
Surrey,  
KT22 8UX

**Esso** | Southampton to London Pipeline Project


Drawing title  
**WORKS PLAN  
SHEET 30  
REGULATION 5 (2)(J)**

Drawing status: **Fit for Stage Approval**

Scale	1:2500	DO NOT SCALE
Jacobs No.	B2325300	Rev
Client no.		<b>C03</b>

Drawing number  
**B2325300-JAC-000-CIV-DRG-000040**

© Copyright 2019 Jacobs U.K. Limited. The concepts and information contained in this document are the property of Jacobs. Use or copying of this document in whole or in part without the written permission of Jacobs constitutes an infringement of copyright. Limitation. This drawing has been prepared on behalf of, and for the exclusive use of, the Client, and is subject to, and issued in accordance with, the provisions of the contract between Jacobs and the Client. Jacobs accepts no liability or responsibility whatsoever for, or in respect of, any use of, or reliance upon, this drawing by any third party.

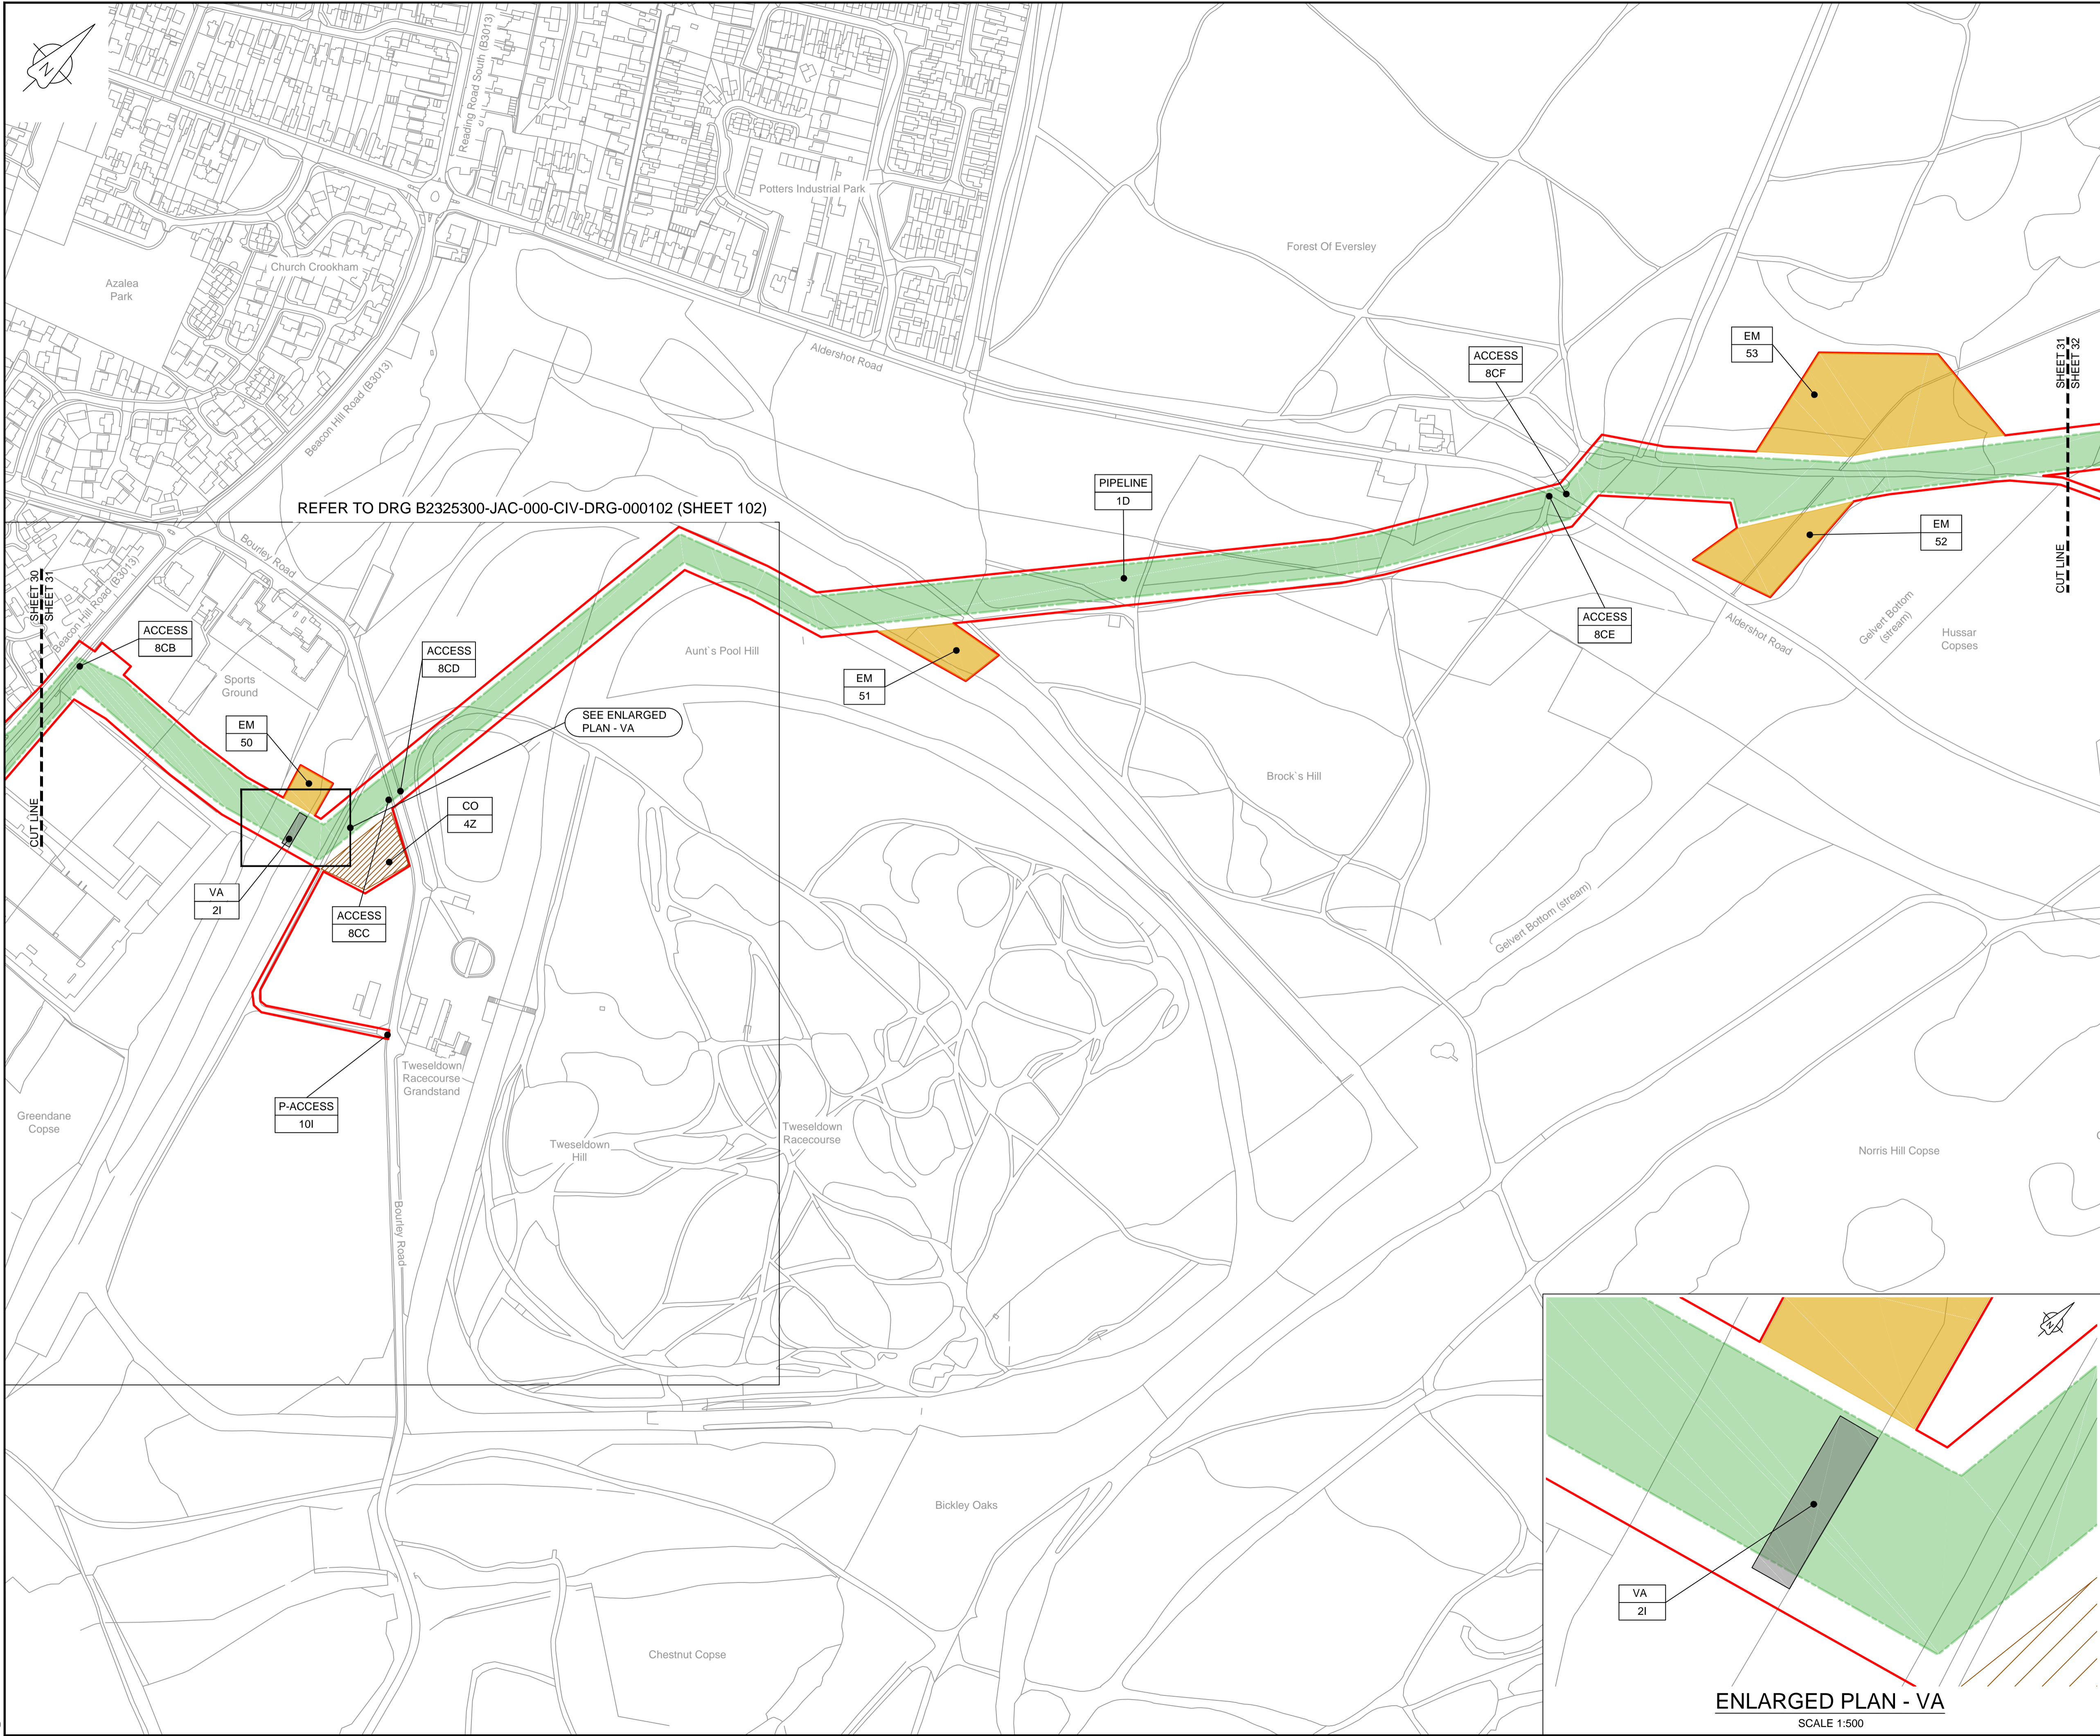

LOCATION PLAN  
SCALE 1:500,000

NOTES  
1. THIS DRAWING IS IN METRES UNLESS STATED OTHERWISE.

**LEGEND**

	ORDER LIMITS
	LIMITS OF DEVIATION
	COMPOUND (CO)
	ENVIRONMENTAL MITIGATION AREA (EM)
	ABOVE GROUND INSTALLATION (AGI) / VALVE (VA) / PRESSURE TRANSDUCER (PT)
	DESCRIPTION
	ID or WORK NUMBER (if applicable)
	ACCESS
	TEMPORARY CONSTRUCTION ACCESS
	P-ACCESS
	COMMENCEMENT / TERMINATION OF WORKS (COMMENCEMENT = OPEN, TERMINATION = CLOSED)

Contains Ordnance Survey data © Crown copyright and database rights 2019.  
© Crown copyright and database rights 2019 OS Licence Number AL100005237.



C02	19/06/19	SHEETS 36 AND 109 REVISED FOLLOWING SSI ADVICE	SH	JA	ND	PH
C03	09/09/19	SHEETS 10, 11 AND 54 REVISED TO WITHDRAW A2b SUB-OPTION	BT	JA	ND	NJ
Rev	Rev. Date	Purpose of revision	Drawn	Checked	Rev'd	Appr'd

**JACOBS**

1180 Eskdale Road, Wokingham, Wokingham, RG41 5TU  
Tel: +44(0)118 946 7000 Fax: +44(0)118 946 7001  
www.jacobs.com

Client: Esso Petroleum Company, Limited  
Emryn House,  
Emryn Way,  
Leatherhead,  
Surrey,  
KT22 8UX


Project: Southampton to London Pipeline Project

Drawing title: **WORKS PLAN SHEET 31 REGULATION 5 (2)(J)**


Drawing status: **Fit for Stage Approval**

Scale	1:2500	DO NOT SCALE
Jacobs No.	B2325300	Rev
Client no.		<b>C03</b>

Drawing number: **B2325300-JAC-000-CIV-DRG-000041**

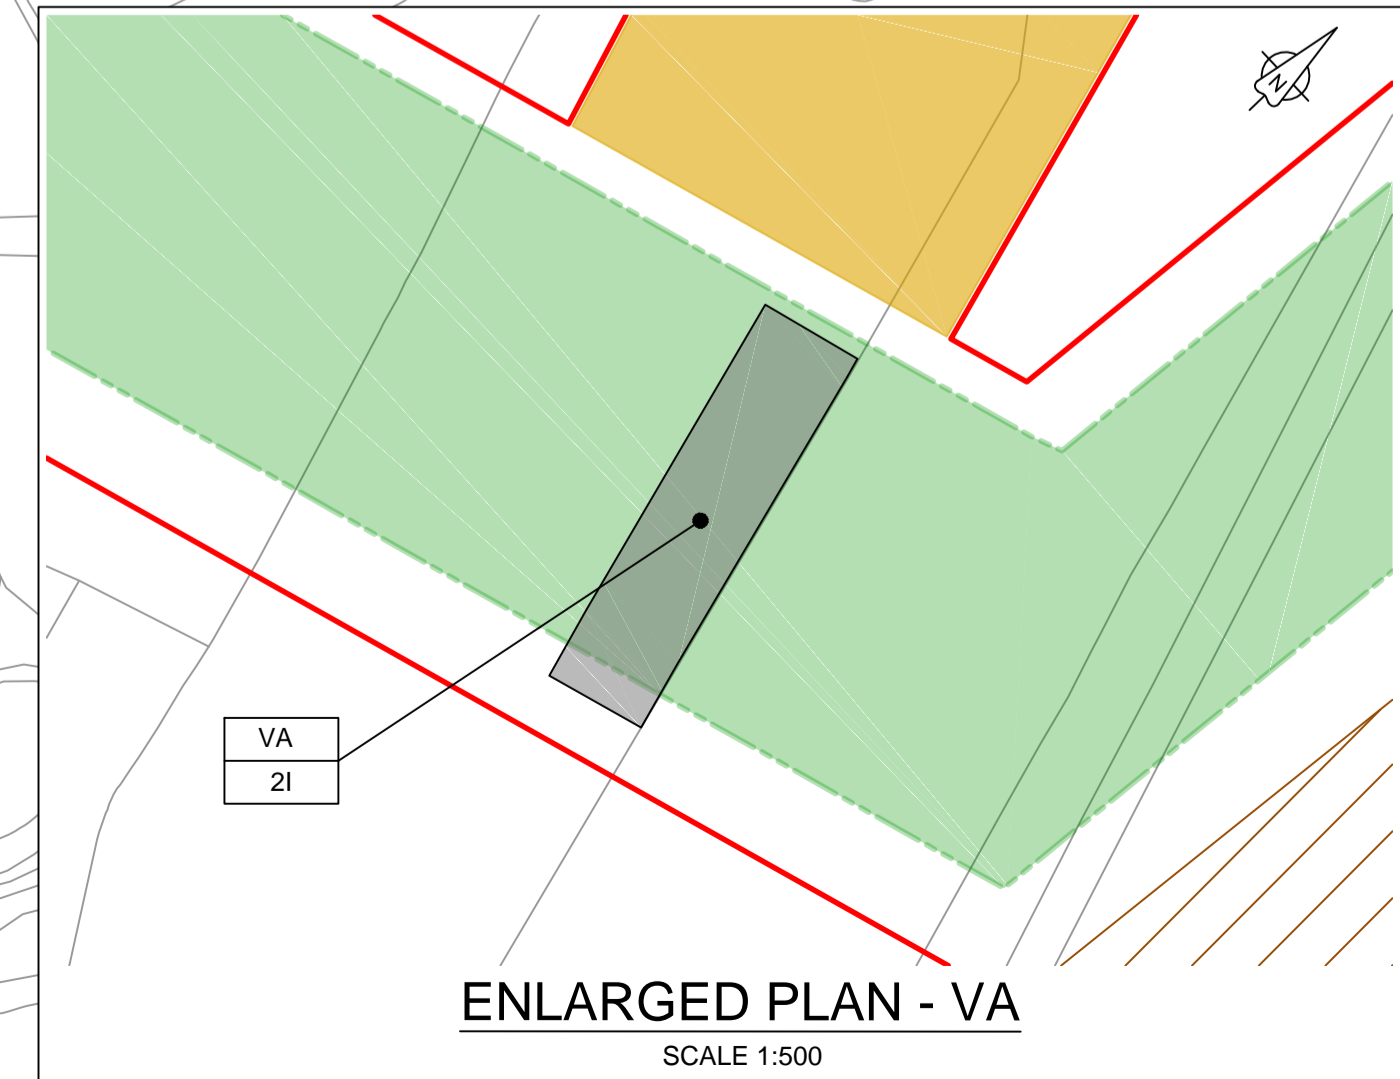

ENLARGED PLAN - VA  
SCALE 1:500

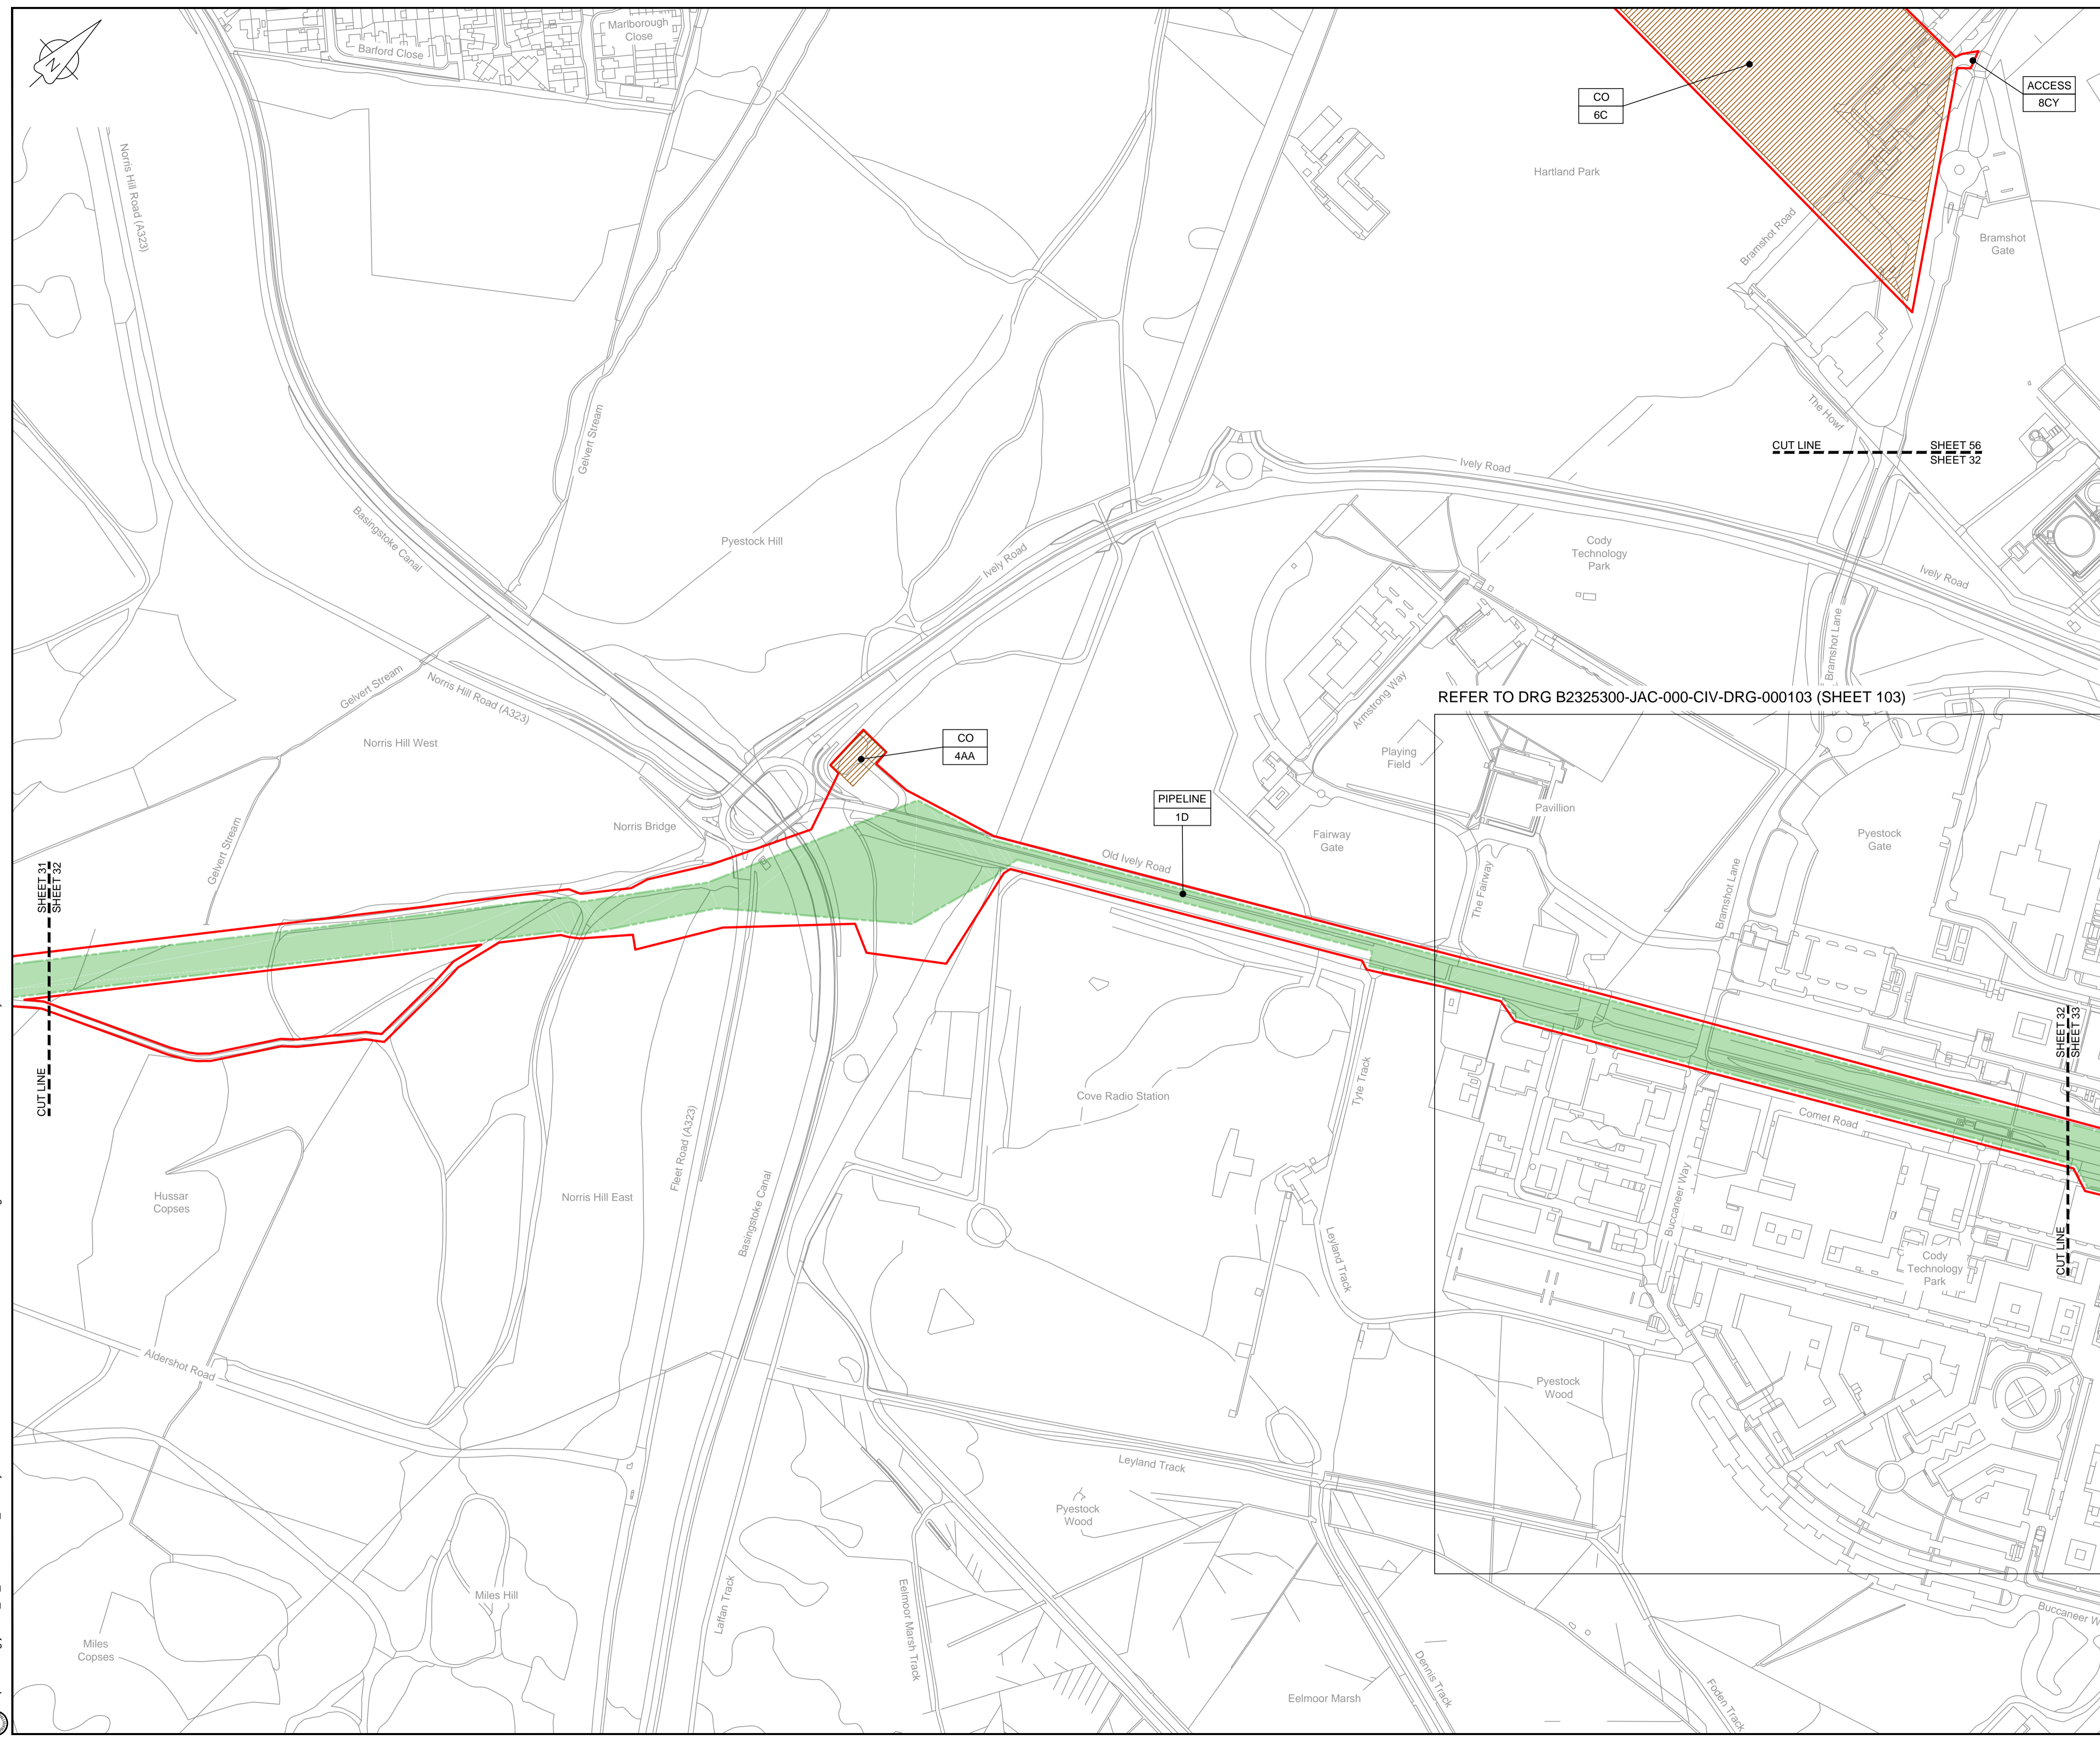

**LOCATION PLAN**  
SCALE 1:500,000

**NOTES**  
1. THIS DRAWING IS IN METRES UNLESS STATED OTHERWISE.

**LEGEND**

	ORDER LIMITS
	LIMITS OF DEVIATION
	COMPOUND (CO)
	ENVIRONMENTAL MITIGATION AREA (EM)
	ABOVE GROUND INSTALLATION (AGI) / VALVE (VA) / PRESSURE TRANSDUCER (PT)
	DESCRIPTION
	ID or WORK NUMBER (if applicable)
	ACCESS
	TEMPORARY CONSTRUCTION ACCESS
	P-ACCESS
	PERMANENT ACCESS
	COMMENCEMENT / TERMINATION OF WORKS
	(COMMENCEMENT = OPEN, TERMINATION = CLOSED)

REFER TO DRG B2325300-JAC-000-CIV-DRG-000103 (SHEET 103)

Contains Ordnance Survey data © Crown copyright and database rights 2019.  
© Crown copyright and database rights 2019 OS Licence Number AL100005237.



Rev	Rev. Date	Purpose of revision	Drawn	Checked	Rev'd	Appr'd
C02	19/06/19	SHEETS 35 AND 109 REVISED FOLLOWING SSI ADVICE	SH	JA	ND	PH
C03	09/09/19	SHEETS 10, 11 AND 54 REVISED TO WITHDRAW A2B SUB-OPTION	BT	JA	ND	NJ

**JACOBS**  
1180 Eskdale Road, Wokingham, Wokingham, RG41 5TU  
Tel: +44(0)118 946 7000 Fax: +44(0)118 946 7001  
www.jacobs.com

Client: Esso Petroleum Company, Limited  
Emryn House,  
Emryn Way,  
Leatherhead,  
Surrey,  
KT22 8UX

Project: Southampton to London Pipeline Project

Drawing title: **WORKS PLAN SHEET 32 REGULATION 5 (2)(J)**

Drawing status: **Fit for Stage Approval**

Scale	1:2500	DO NOT SCALE
Jacobs No.	B2325300	Rev
Client no.		<b>C03</b>

Drawing number: **B2325300-JAC-000-CIV-DRG-000042**

© Copyright 2019 Jacobs U.K. Limited. The concepts and information contained in this document are the property of Jacobs. Use or copying of this document in whole or in part without the written permission of Jacobs constitutes an infringement of copyright. Limitation. This drawing has been prepared on behalf of, and for the exclusive use of, the Client, and is subject to, and issued in accordance with, the provisions of the contract between Jacobs and the Client. Jacobs accepts no liability or responsibility whatsoever for, or in respect of, any use of, or reliance upon, this drawing by any third party.

REFER TO DRG B2325300-JAC-000-CIV-DRG-000103 (SHEET 103)

REFER TO DRG B2325300-JAC-000-CIV-DRG-000104 (SHEET 104)




LOCATION PLAN  
SCALE 1:500,000

NOTES  
1. THIS DRAWING IS IN METRES UNLESS STATED OTHERWISE.

**LEGEND**

	ORDER LIMITS
	LIMITS OF DEVIATION
	COMPOUND (CO)
	ENVIRONMENTAL MITIGATION AREA (EM)
	ABOVE GROUND INSTALLATION (AGI) / VALVE (VA) / PRESSURE TRANSDUCER (PT)
	DESCRIPTION
	ID or WORK NUMBER (if applicable)
	TEMPORARY CONSTRUCTION ACCESS
	PERMANENT ACCESS
	COMMENCEMENT / TERMINATION OF WORKS (COMMENCEMENT = OPEN, TERMINATION = CLOSED)

Contains Ordnance Survey data © Crown copyright and database rights 2019.  
© Crown copyright and database rights 2019 OS Licence Number AL100005237.

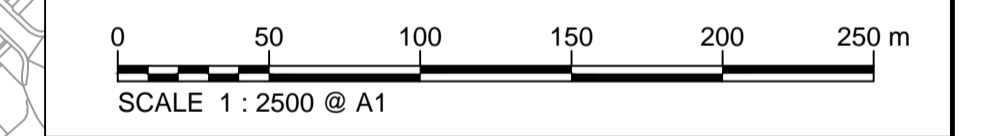

C02	19/06/19	SHEETS 35 AND 108 REVISED FOLLOWING SSI ADVICE	SH	JA	ND	NH
C03	09/09/19	SHEETS 10, 11 AND 54 REVISED TO WITHDRAW A2b SUB-OPTION	BT	JA	ND	NH
Rev	Rev. Date	Purpose of revision	Drawn	Checked	Rev'd	Appr'd

**JACOBS**  
1180 Eskdale Road, Winkesham, Wokingham, RG41 5TU  
Tel: +44(0)118 946 7000 Fax: +44(0)118 946 7001  
www.jacobs.com

Client: Esso Petroleum Company, Limited  
Emryn House,  
Emryn Way,  
Leatherhead,  
Surrey,  
KT22 8UX

Project: Southampton to London Pipeline Project


Drawing title: **WORKS PLAN SHEET 33 REGULATION 5 (2)(J)**

Drawing status: **Fit for Stage Approval**

Scale	1:2500	DO NOT SCALE
Jacobs No.	B2325300	Rev
Client no.		<b>C03</b>


Drawing number: **B2325300-JAC-000-CIV-DRG-000043**

© Copyright 2019 Jacobs U.K. Limited. The concepts and information contained in this document are the property of Jacobs. Use or copying of this document in whole or in part without the written permission of Jacobs constitutes an infringement of copyright. Limitation. This drawing has been prepared on behalf of, and for the exclusive use of, the Client, and is subject to, and issued in accordance with, the provisions of the contract between Jacobs and the Client. Jacobs accepts no liability or responsibility whatsoever for, or in respect of, any use of, or reliance upon, this drawing by any third party.

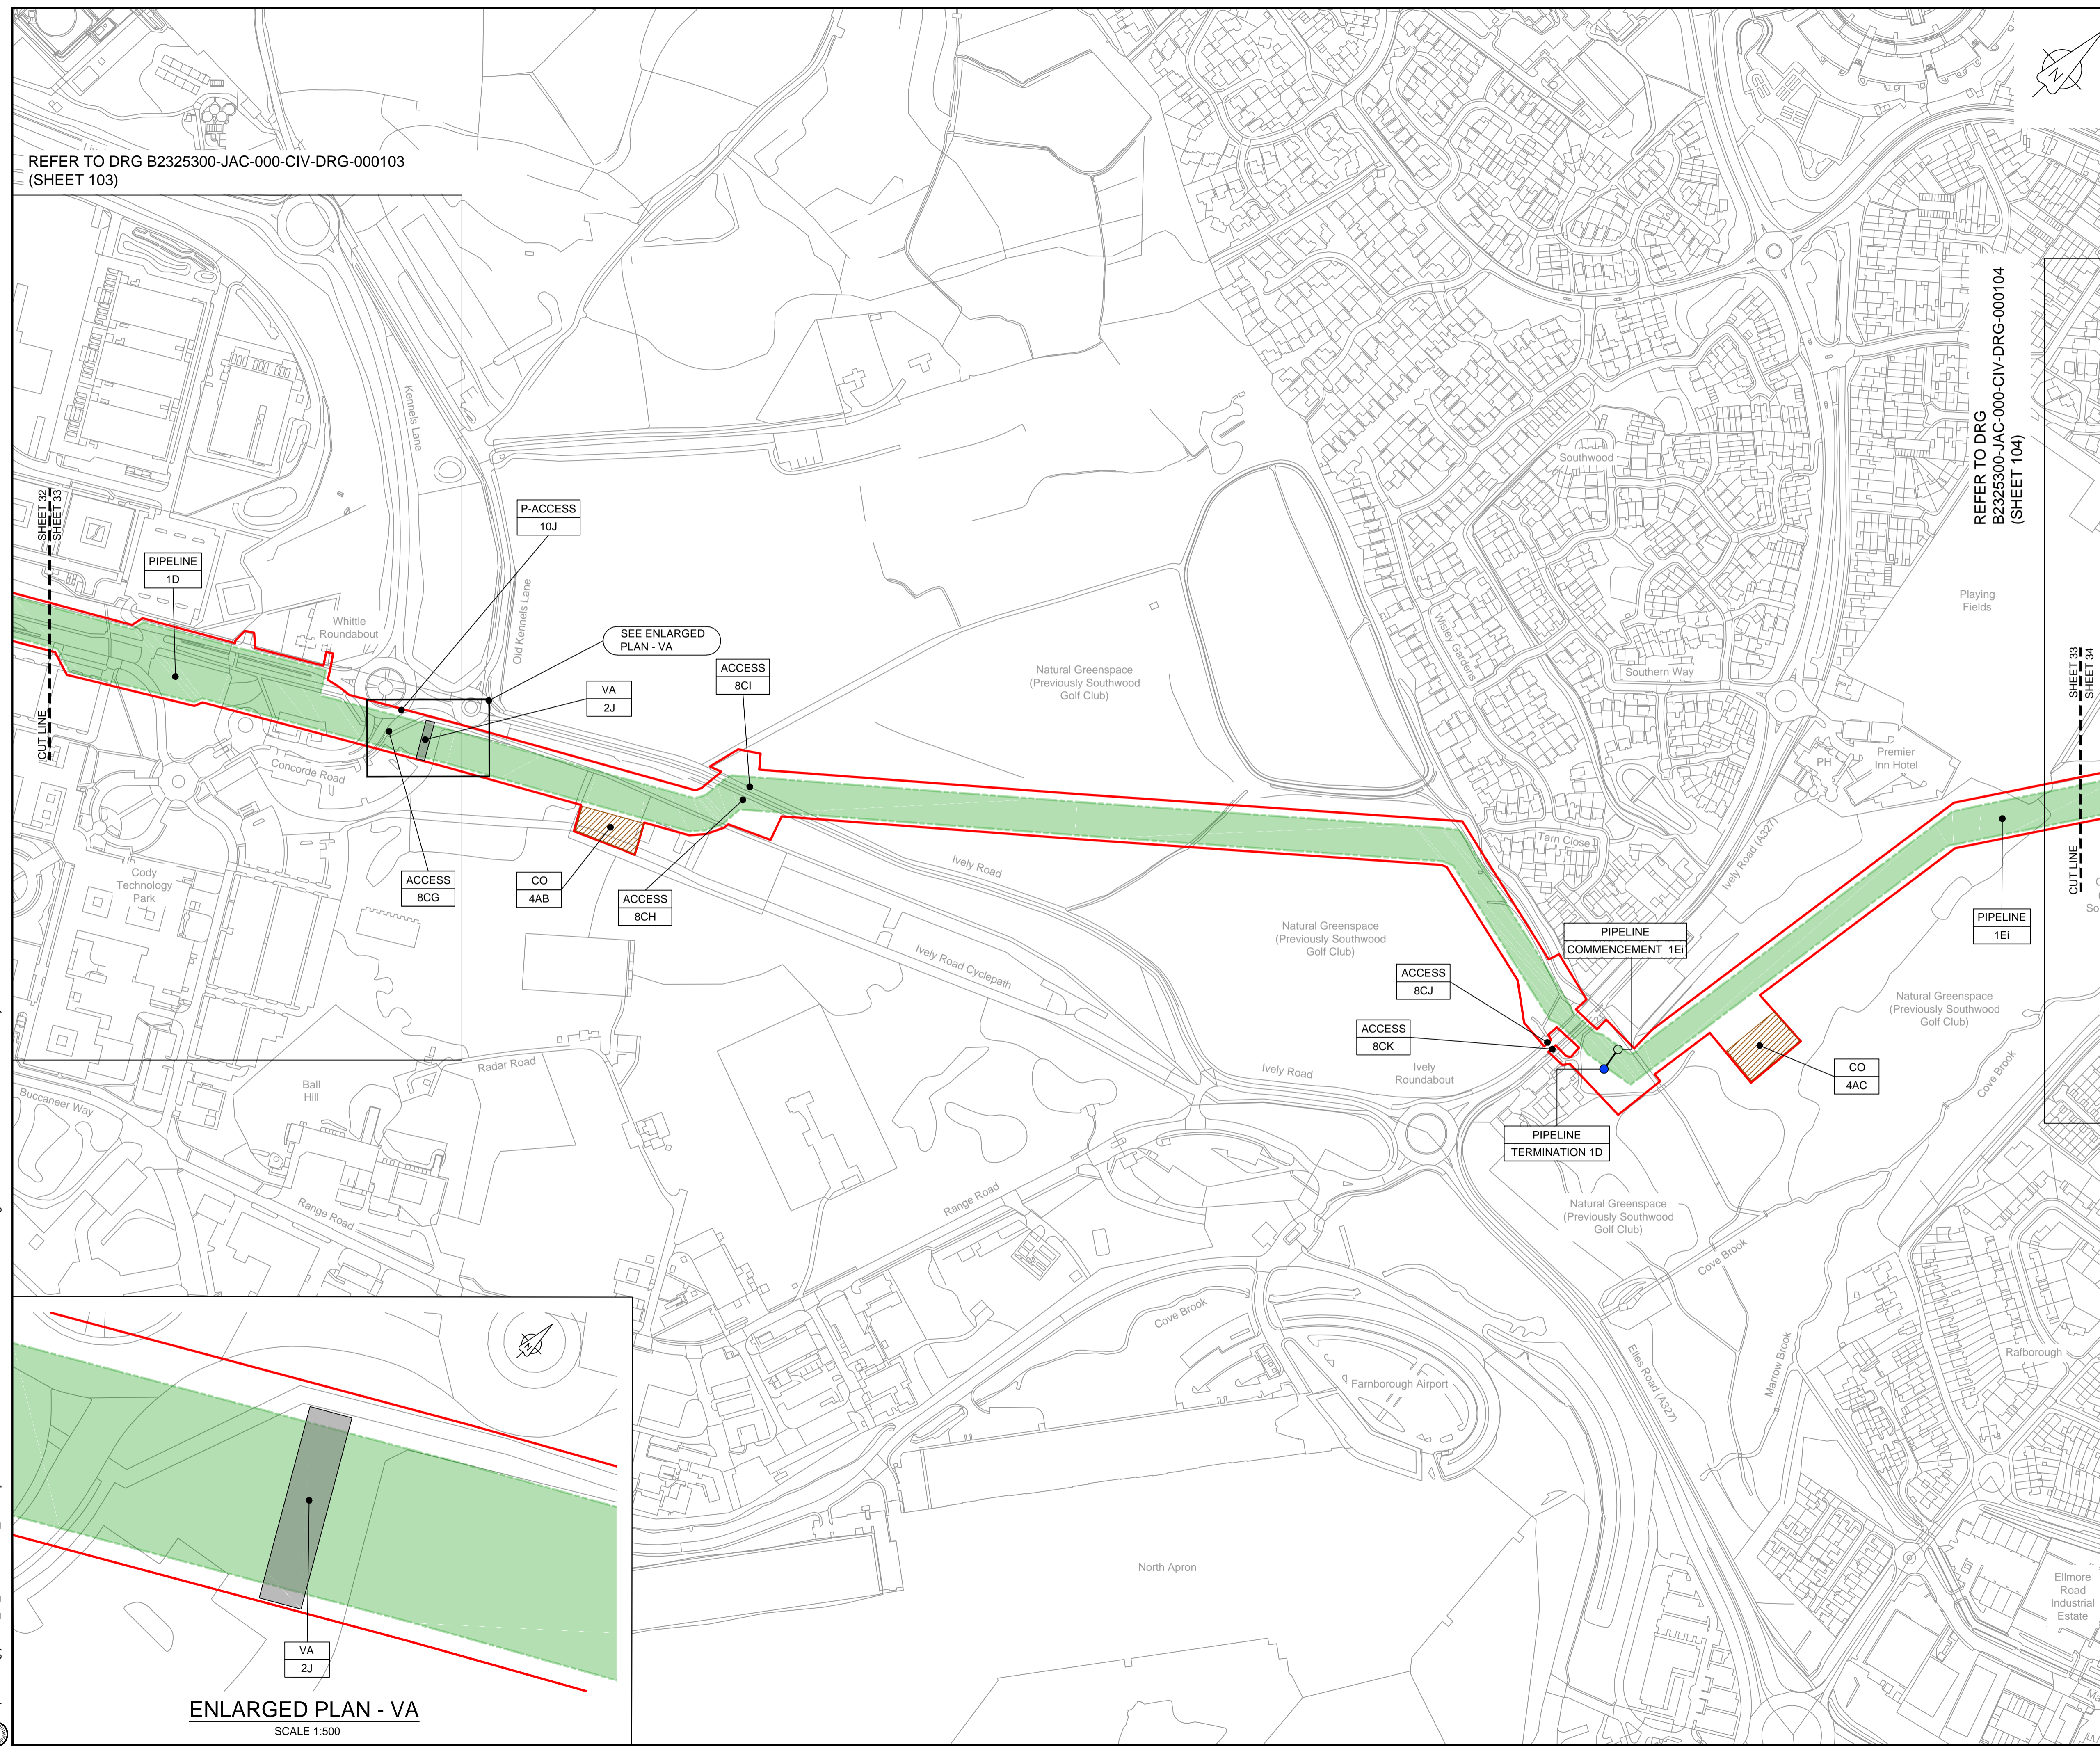

ENLARGED PLAN - VA  
SCALE 1:500



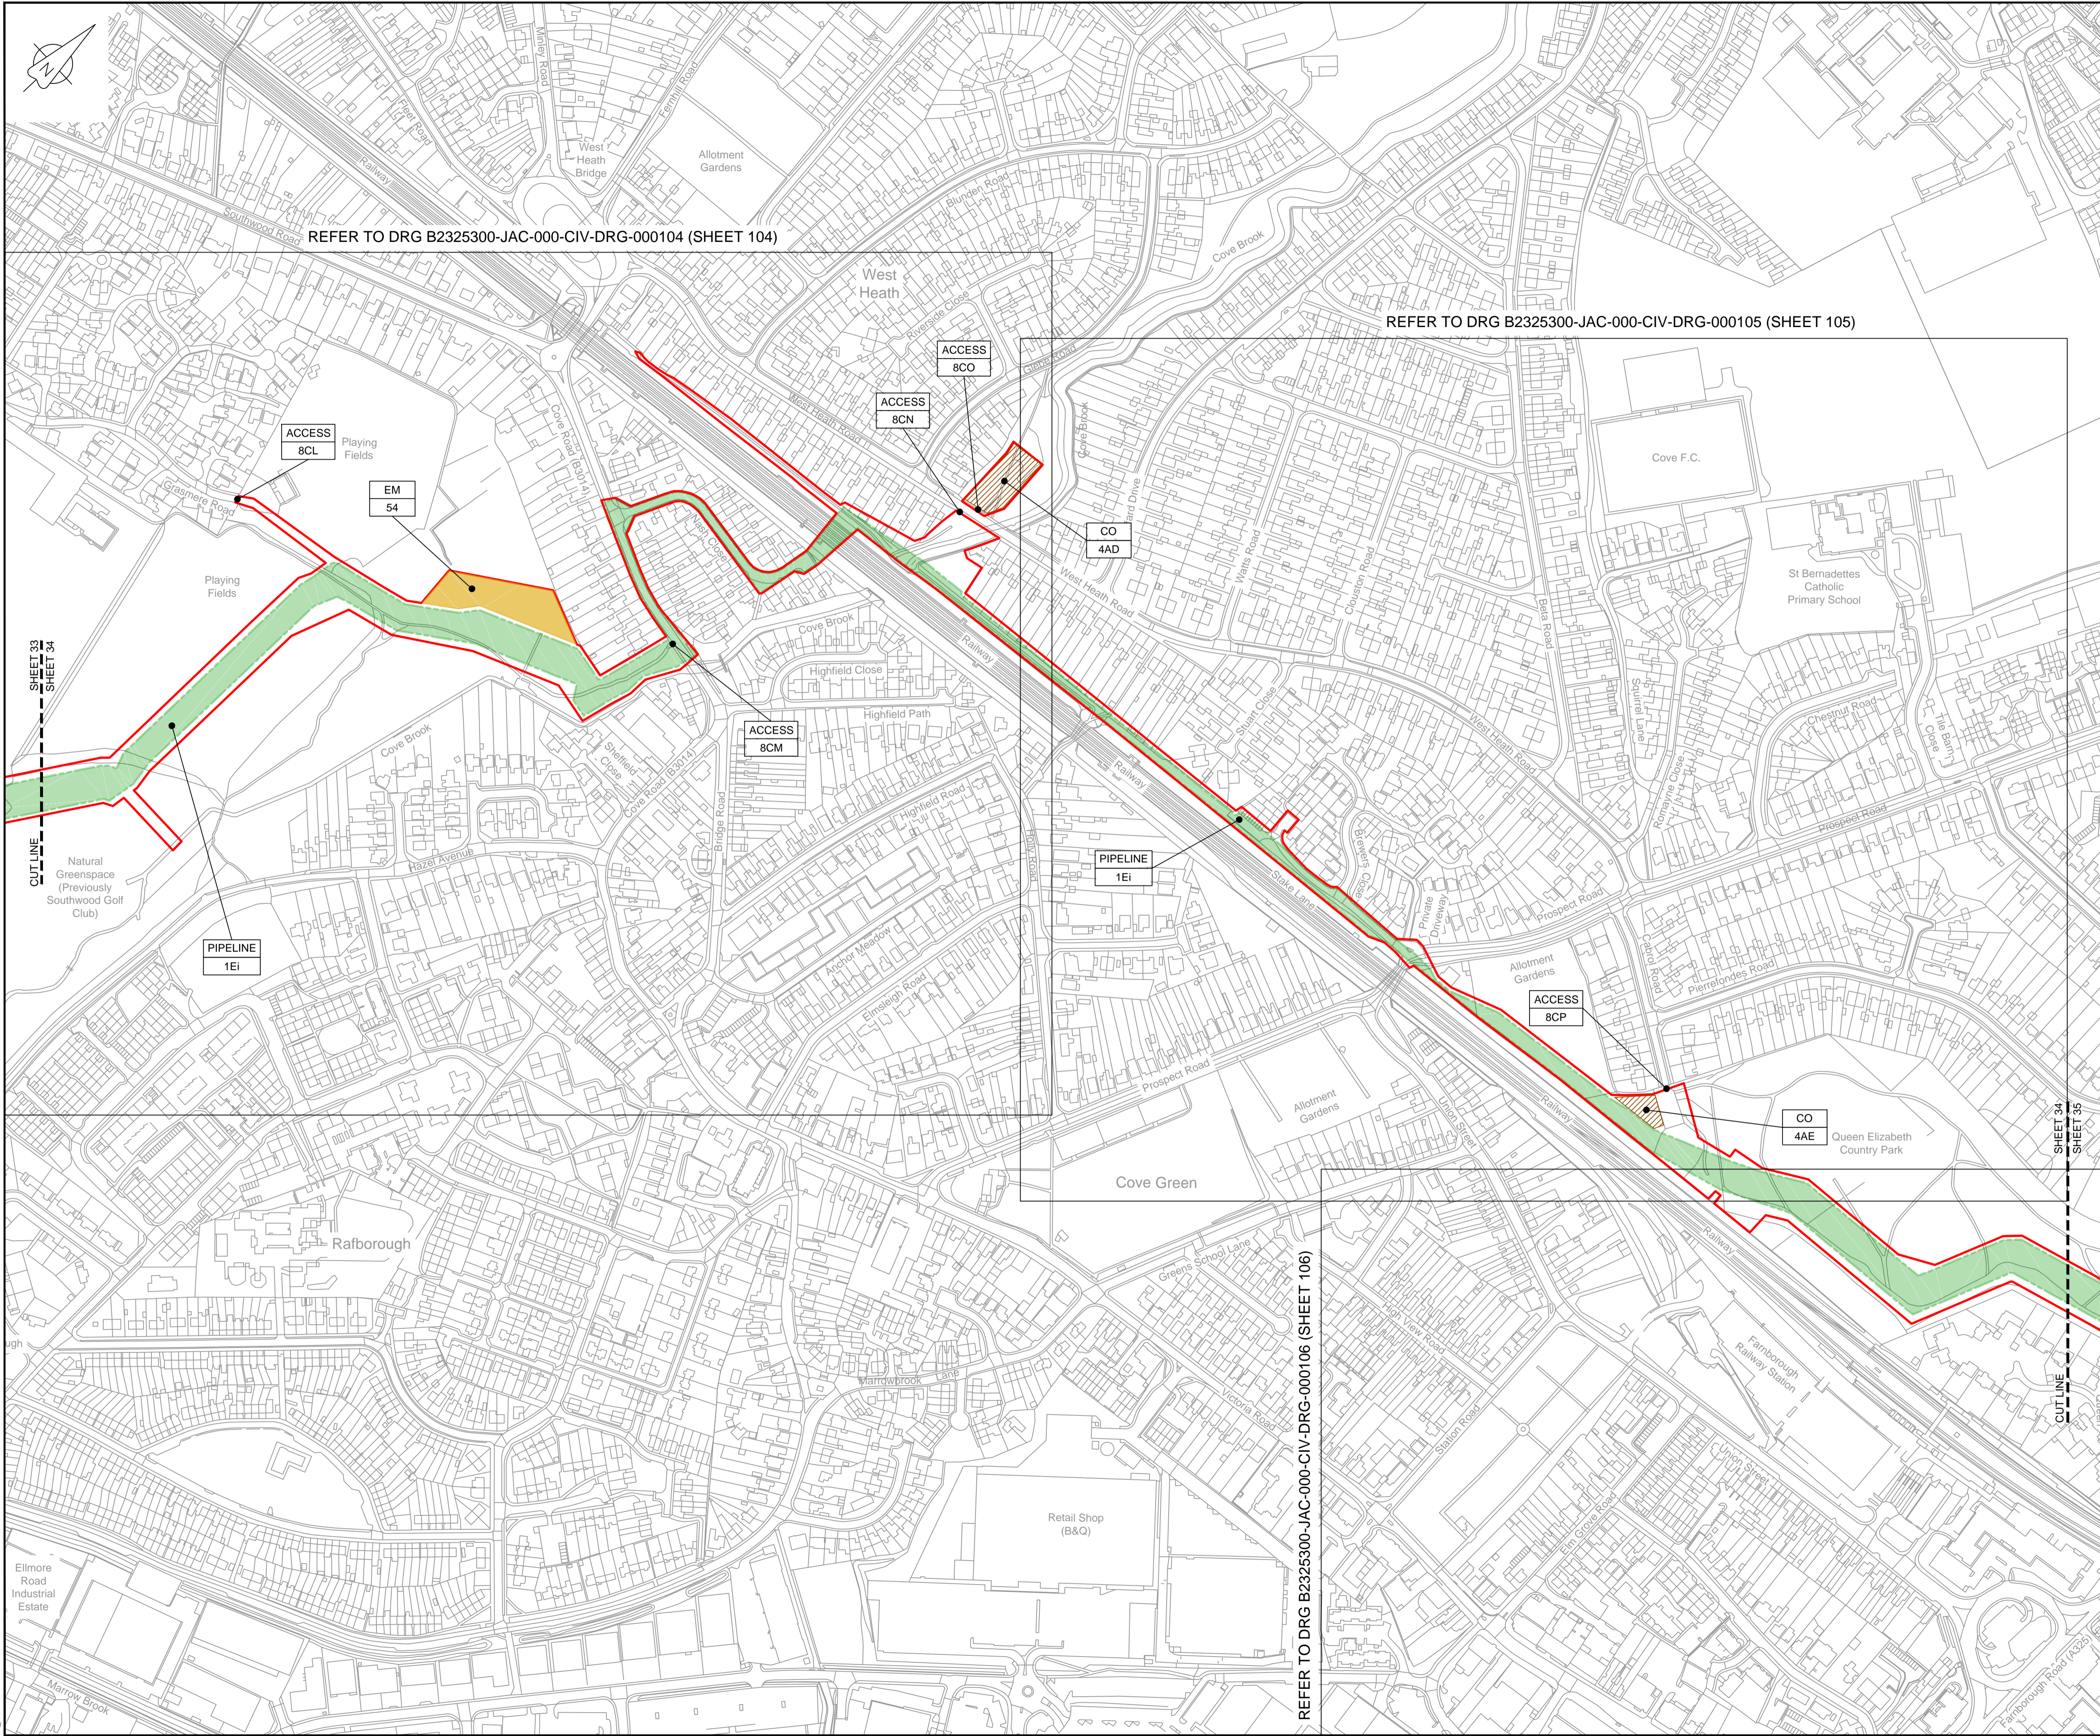

LOCATION PLAN  
SCALE 1:500,000


NOTES  
1. THIS DRAWING IS IN METRES UNLESS STATED OTHERWISE.

LEGEND

	ORDER LIMITS
	LIMITS OF DEVIATION
	COMPOUND (CO)
	ENVIRONMENTAL MITIGATION AREA (EM)
	ABOVE GROUND INSTALLATION (AGI) / VALVE (VA) / PRESSURE TRANSDUCER (PT)
	DESCRIPTION
	ID or WORK NUMBER (if applicable)
	ACCESS
	TEMPORARY CONSTRUCTION ACCESS
	PERMANENT ACCESS
	COMMENCEMENT / TERMINATION OF WORKS
	(COMMENCEMENT = OPEN, TERMINATION = CLOSED)

Contains Ordnance Survey data © Crown copyright and database rights 2019.

© Crown copyright and database rights 2019 OS Licence Number AL10005237.

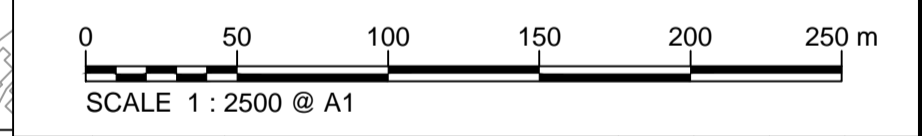

C02	19/06/19	SHEETS 35 AND 106 REVISED FOLLOWING SSI ADVICE	SH	JA	ND	PH
C03	09/09/19	SHEETS 10, 11 AND 54 REVISED TO WITHDRAW A2b SUB-OPTION	BT	JA	ND	NJ
Rev	Rev. Date	Purpose of revision	Drawn	Checked	Rev'd	Appr'd

**JACOBS**  
1180 Eskdale Road, Wokingham, Wokingham, RG41 5TU  
Tel: +44(0)118 946 7000 Fax: +44(0)118 946 7001  
www.jacobs.com

Client: Esso Petroleum Company, Limited  
Emryn House,  
Emryn Way,  
Leatherhead,  
Surrey,  
KT22 8UX

Project: Southampton to London Pipeline Project


Drawing title: **WORKS PLAN SHEET 34 REGULATION 5 (2)(J)**

Drawing status: **Fit for Stage Approval**

Scale	1:2500	DO NOT SCALE
Jacobs No.	B2325300	Rev
Client no.		<b>C03</b>

Drawing number: **B2325300-JAC-000-CIV-DRG-000044**

© Copyright 2019 Jacobs U.K. Limited. The concepts and information contained in this document are the property of Jacobs. Use or copying of this document in whole or in part without the written permission of Jacobs constitutes an infringement of copyright. Limitation: This drawing has been prepared on behalf of, and for the exclusive use of, Jacobs' Client, and is subject to, and issued in accordance with, the provisions of the contract between Jacobs and the Client. Jacobs accepts no liability or responsibility whatsoever for, or in respect of, any use of, or reliance upon, this drawing by any third party.

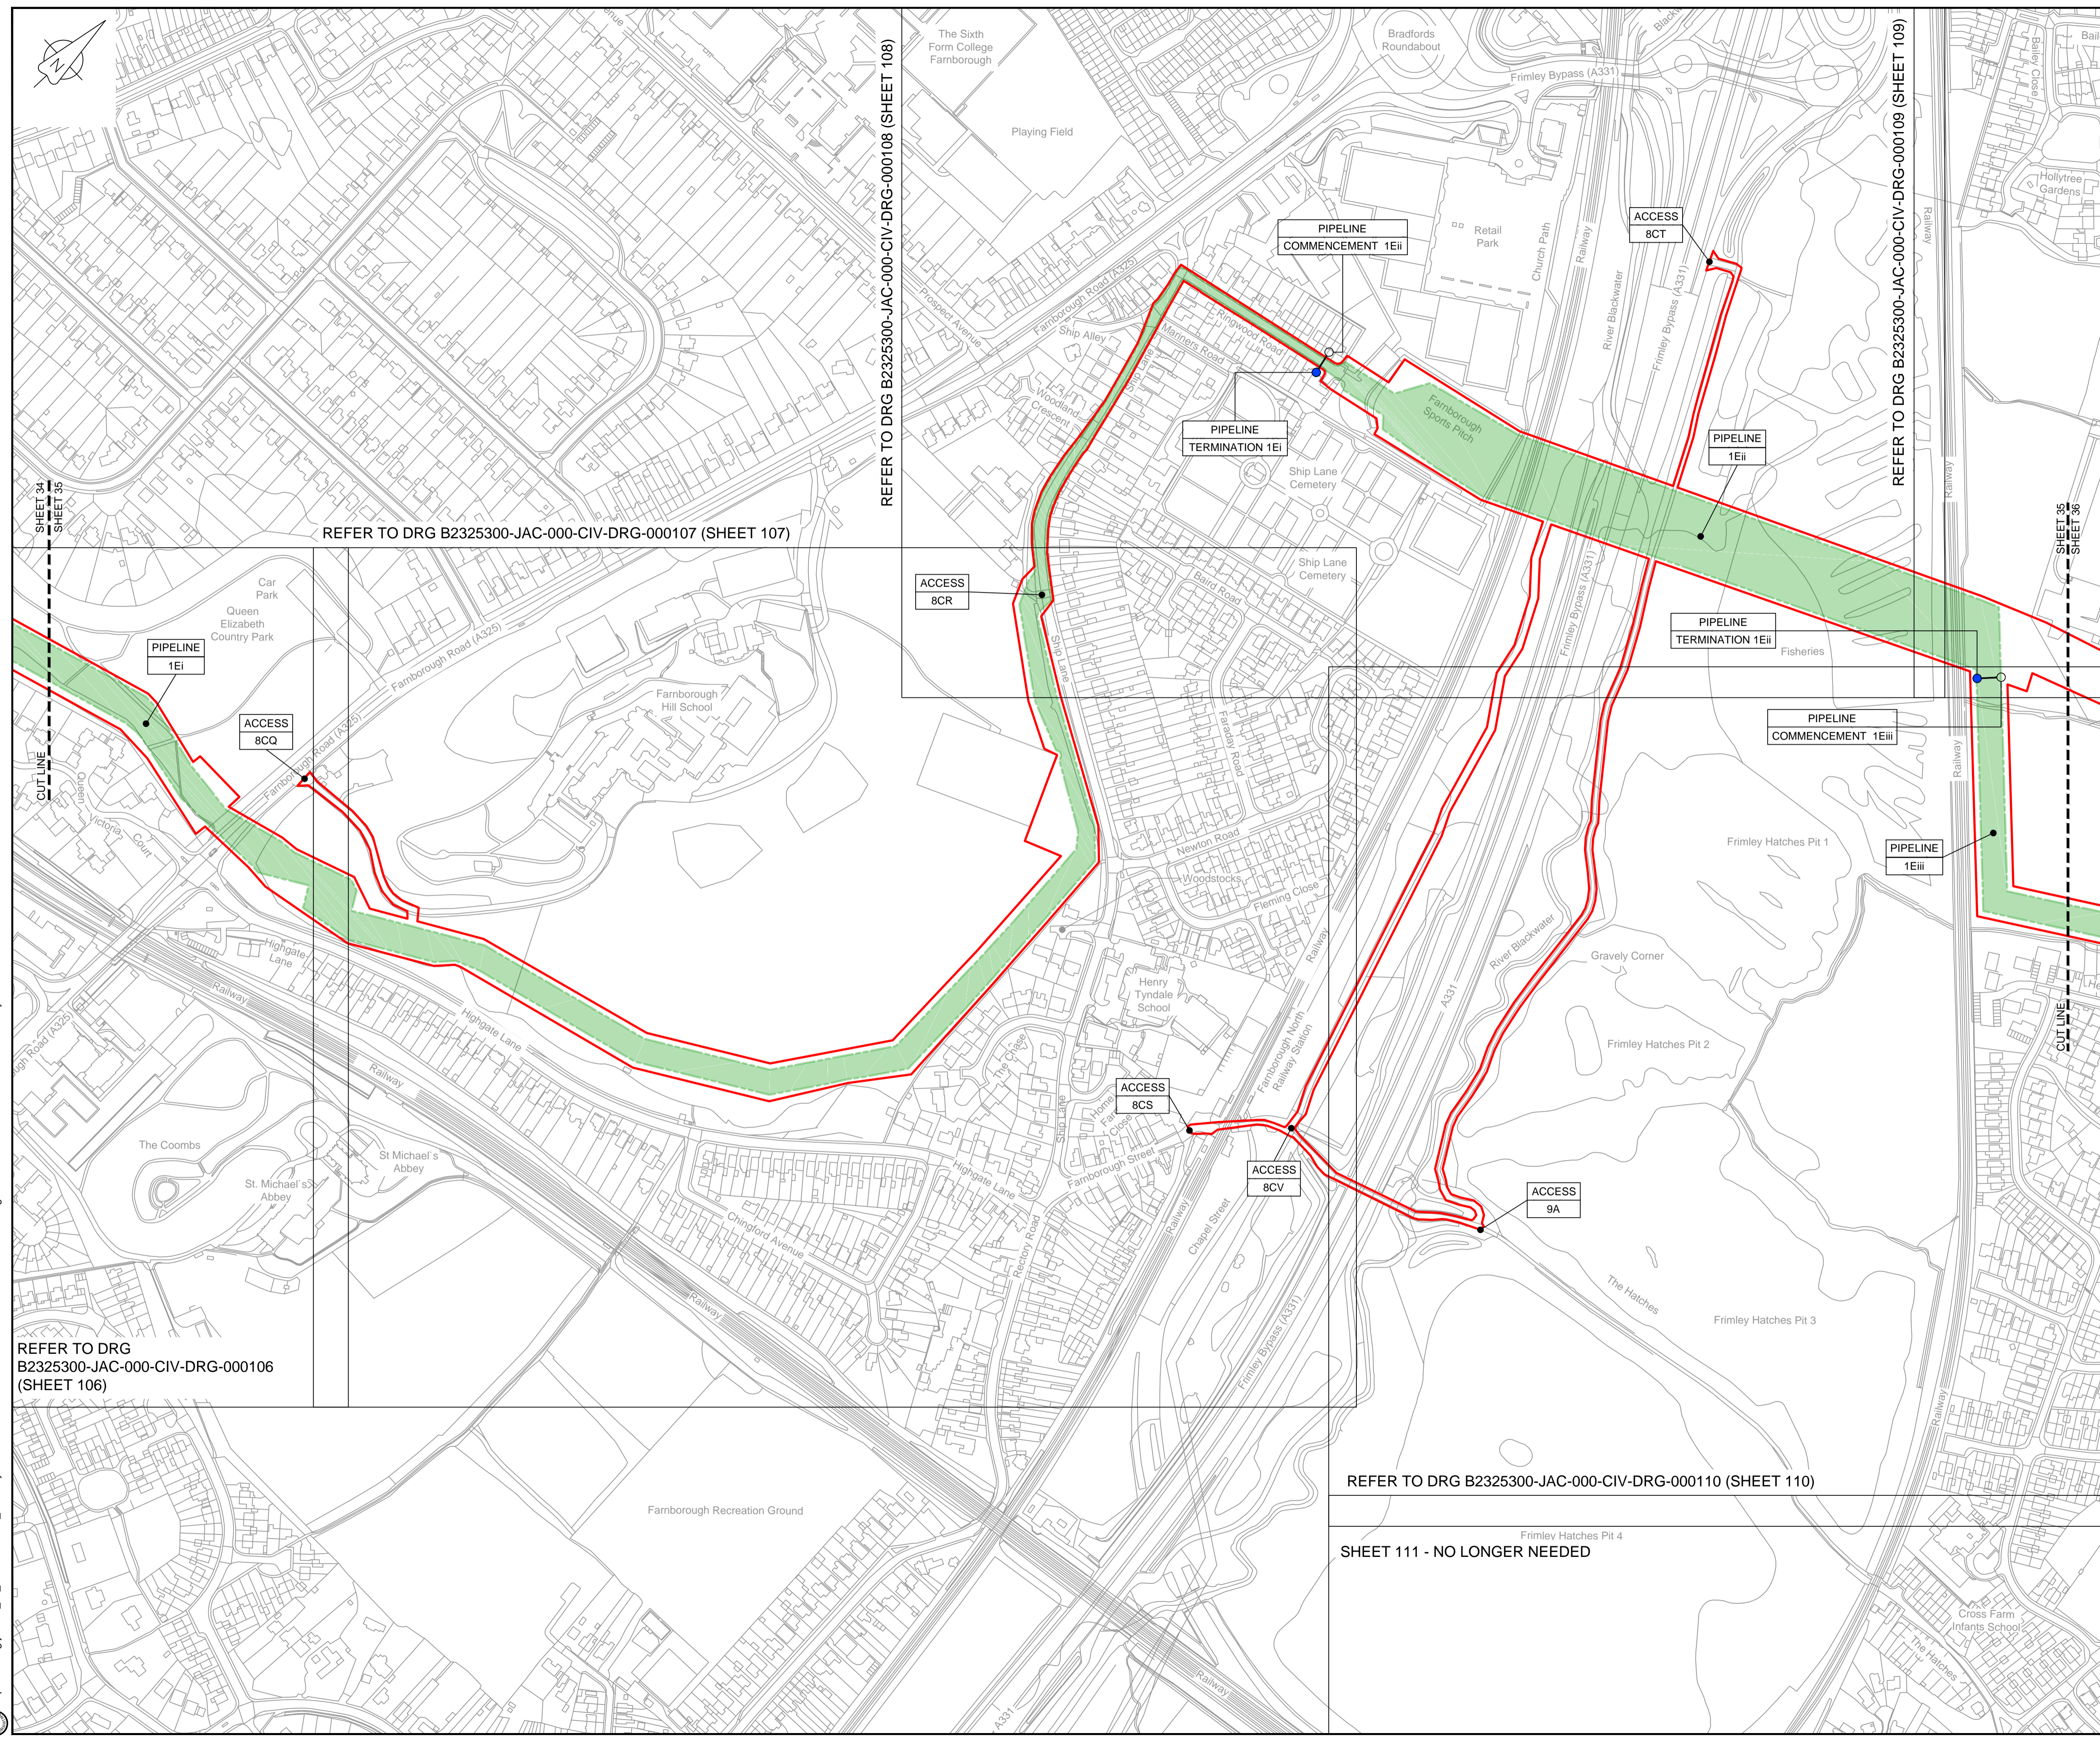

**LOCATION PLAN**  
SCALE 1:500,000

**NOTES**  
1. THIS DRAWING IS IN METRES UNLESS STATED OTHERWISE.

**LEGEND**

	ORDER LIMITS
	LIMITS OF DEVIATION
	COMPOUND (CO)
	ENVIRONMENTAL MITIGATION AREA (EM)
	ABOVE GROUND INSTALLATION (AGI) / VALVE (VA) / PRESSURE TRANSDUCER (PT)
	DESCRIPTION
	ID or WORK NUMBER (if applicable)
	ACCESS
	TEMPORARY CONSTRUCTION ACCESS
	PERMANENT ACCESS
	COMMENCEMENT / TERMINATION OF WORKS (COMMENCEMENT = OPEN, TERMINATION = CLOSED)

Contains Ordnance Survey data © Crown copyright and database rights 2019.

© Crown copyright and database rights 2019 OS Licence Number AL100005237.



C02	19/06/19	SHEETS 35 AND 109 REVISED FOLLOWING SSI ADVICE	SH	JA	ND	PH
C03	09/09/19	SHEETS 10, 11 AND 54 REVISED TO WITHDRAW A2B SUB-OPTION	BT	JA	ND	NJ
Rev	Rev. Date	Purpose of revision	Drawn	Checked	Rev'd	Appr'd

**JACOBS**  
1180 Eskdale Road, Wokingham, Wokingham, RG41 5TU  
Tel: +44(0)118 946 7000 Fax: +44(0)118 946 7001  
www.jacobs.com

Client: Esso Petroleum Company, Limited  
Emryn House,  
Emryn Way,  
Leatherhead,  
Surrey,  
KT22 8UX

**Esso** | Southampton to London Pipeline Project

**WORKS PLAN  
SHEET 35  
REGULATION 5 (2)(J)**

Drawing status: **Fit for Stage Approval**

Scale	1:2500	DO NOT SCALE
Jacobs No.	B2325300	Rev
Client no.		<b>C03</b>

Drawing number: **B2325300-JAC-000-CIV-DRG-000045**

© Copyright 2019 Jacobs U.K. Limited. The concepts and information contained in this document are the property of Jacobs. Use or copying of this document in whole or in part without the written permission of Jacobs constitutes an infringement of copyright. Limitation: This drawing has been prepared on behalf of, and for the exclusive use of, the Client, and is subject to, and issued in accordance with, the provisions of the contract between Jacobs and the Client. Jacobs accepts no liability or responsibility whatsoever for, or in respect of, any use of, or reliance upon, this drawing by any third party.

C:\pwworking\jacobs\_uk\_water&utilities\_ssf\bray\ordms3351\B2325300-JAC-000-CIV-DRG-000045.dwg - 10/09/2019 11:44:56 - A1Frame - BTaylor

REFER TO DRG  
B2325300-JAC-000-CIV-DRG-000106  
(SHEET 106)

REFER TO DRG B2325300-JAC-000-CIV-DRG-000107 (SHEET 107)


REFER TO DRG B2325300-JAC-000-CIV-DRG-000108 (SHEET 108)

REFER TO DRG B2325300-JAC-000-CIV-DRG-000110 (SHEET 110)

SHEET 111 - NO LONGER NEEDED

REFER TO DRG B2325300-JAC-000-CIV-DRG-000109 (SHEET 109)



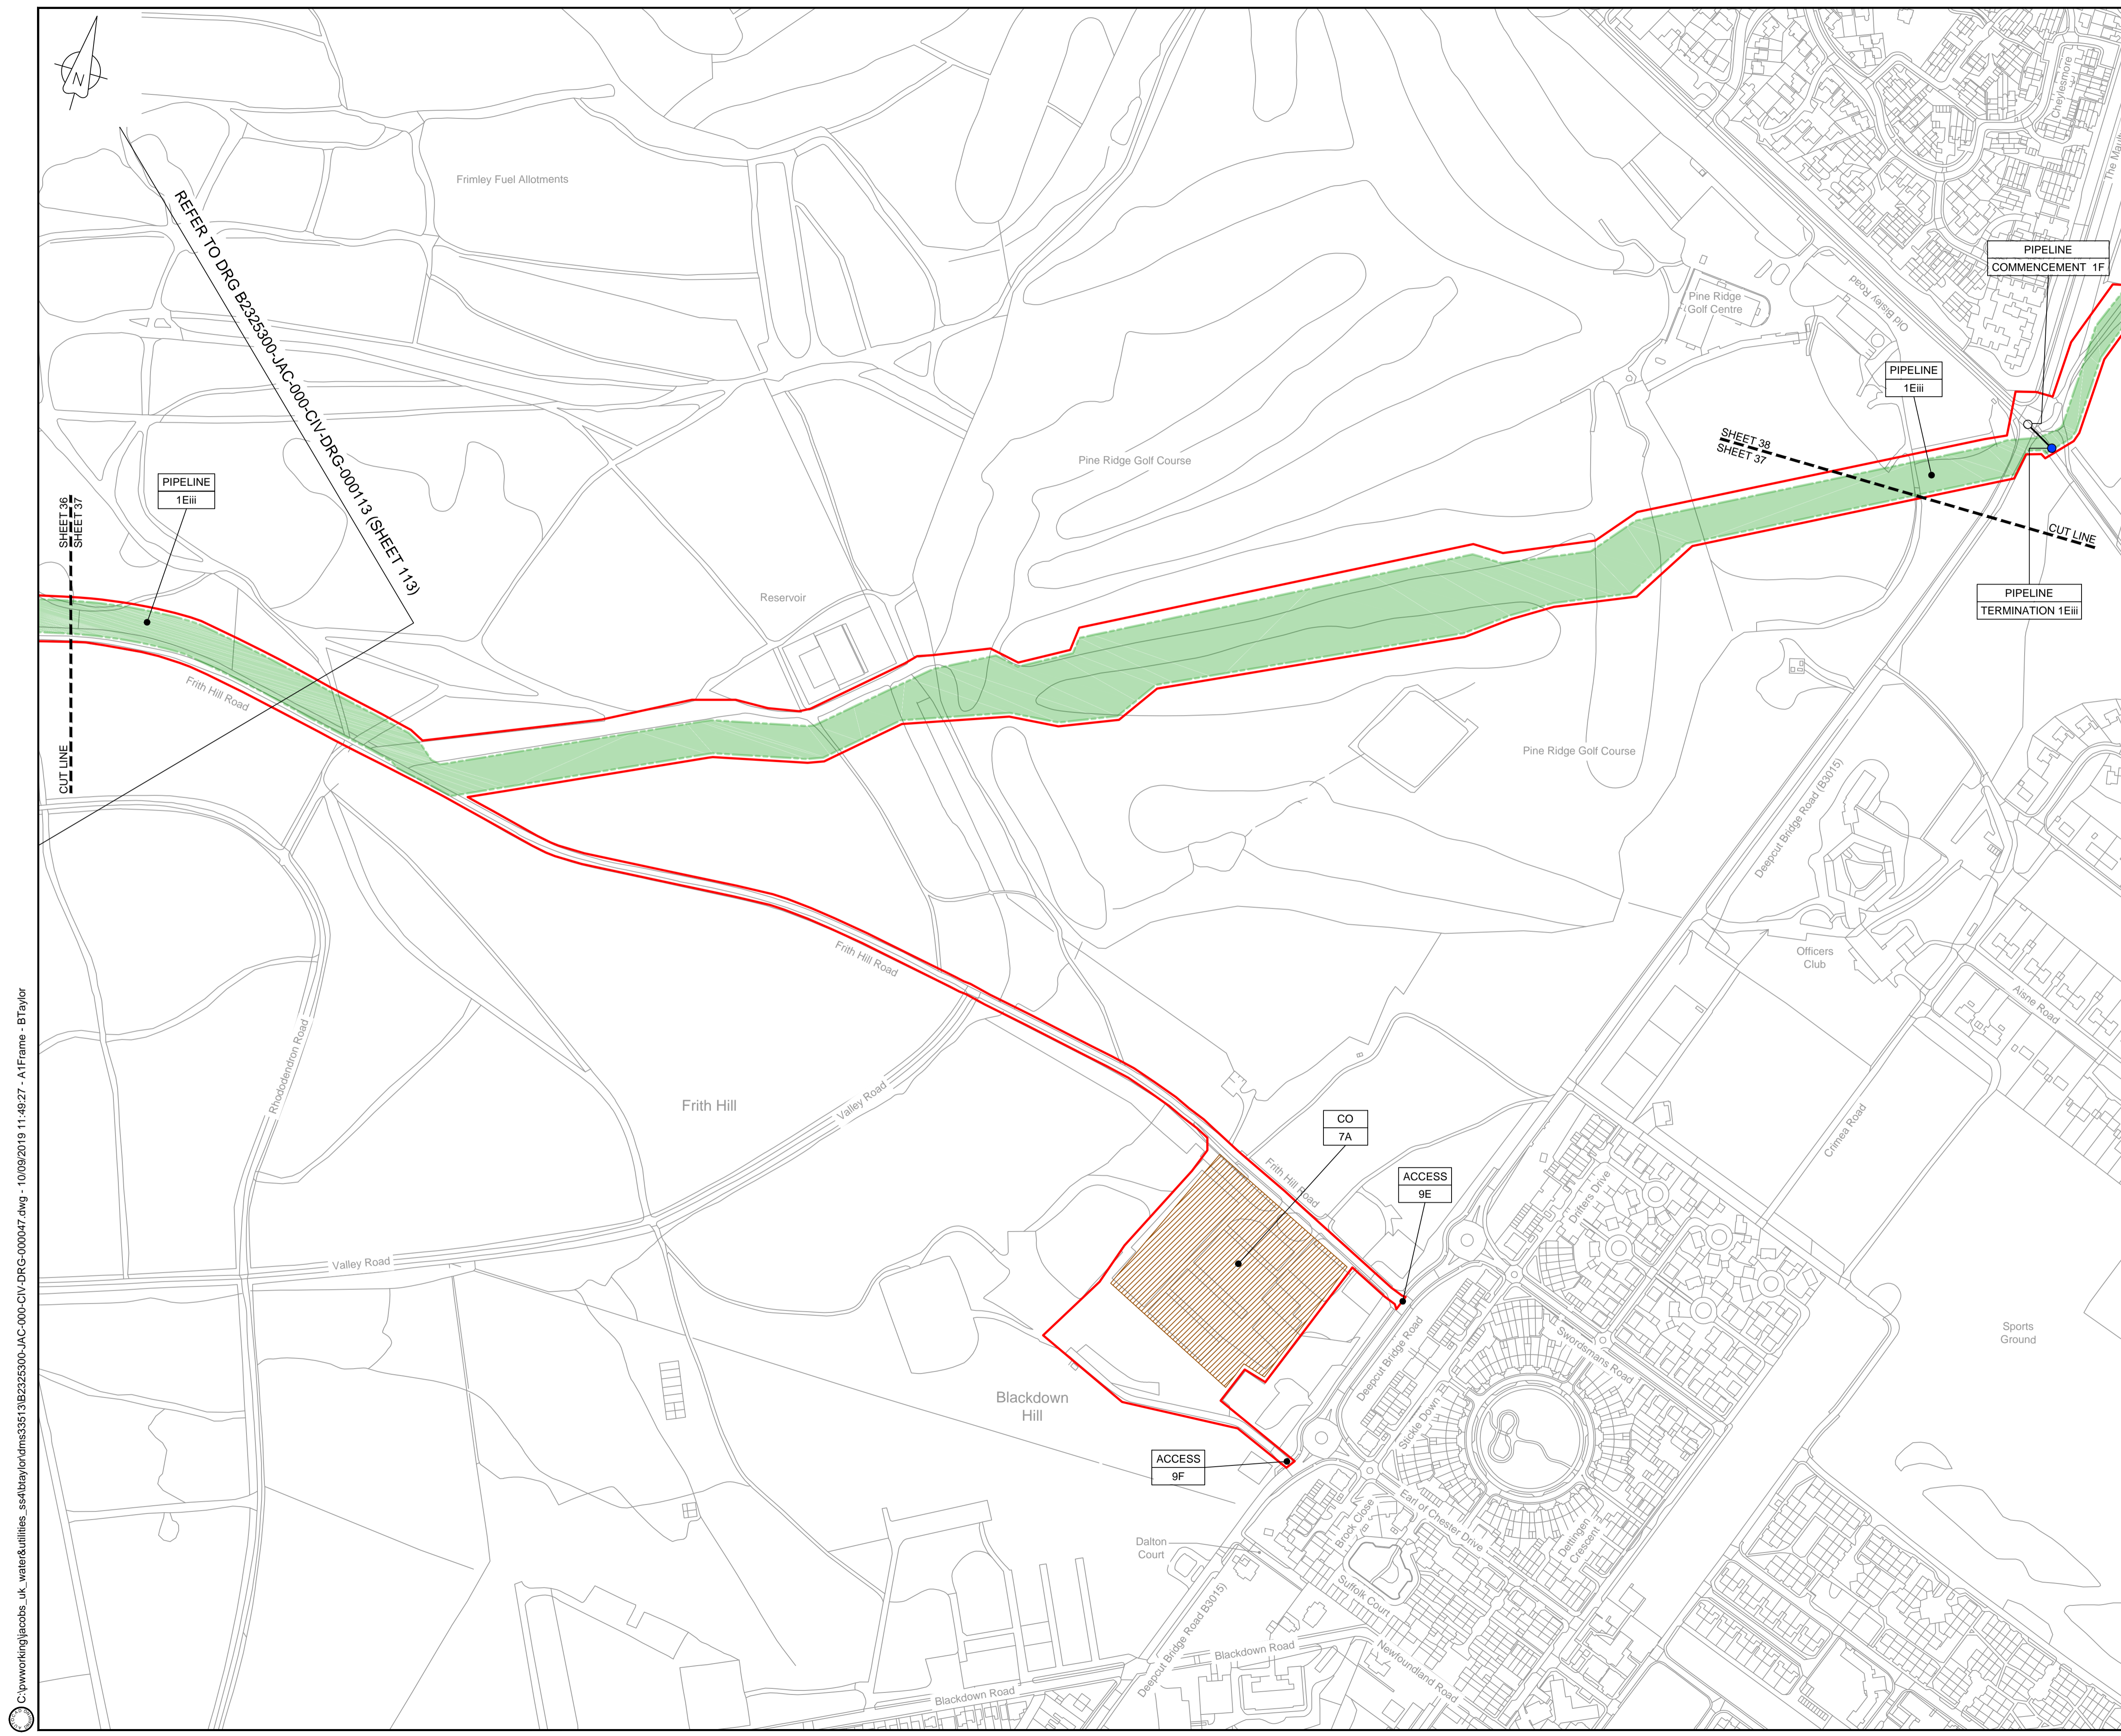

**LOCATION PLAN**  
SCALE 1:500,000

**NOTES**  
1. THIS DRAWING IS IN METRES UNLESS STATED OTHERWISE.

**LEGEND**

	ORDER LIMITS
	LIMITS OF DEVIATION
	COMPOUND (CO)
	ENVIRONMENTAL MITIGATION AREA (EM)
	ABOVE GROUND INSTALLATION (AGI) / VALVE (VA) / PRESSURE TRANSDUCER (PT)
	DESCRIPTION
	ID or WORK NUMBER (if applicable)
	ACCESS
	TEMPORARY CONSTRUCTION ACCESS
	PERMANENT ACCESS
	COMMENCEMENT / TERMINATION OF WORKS (COMMENCEMENT = OPEN, TERMINATION = CLOSED)

Contains Ordnance Survey data © Crown copyright and database rights 2019.  
© Crown copyright and database rights 2019 OS Licence Number AL100005237.



C02	19/06/19	SHEETS 36 AND 108 REVISED FOLLOWING SSI ADVICE	SH	JA	ND	PH
C03	09/09/19	SHEETS 10, 11 AND 54 REVISED TO WITHDRAW A2b SUB-OPTION	BT	JA	ND	NJ
Rev	Rev. Date	Purpose of revision	Drawn	Checked	Rev'd	Appr'd

**JACOBS**  
1180 Eskdale Road, Winnersh, Wokingham, RG41 5TU  
Tel:+44(0)118 946 7000 Fax:+44(0)118 946 7001  
www.jacobs.com

Client: Esso Petroleum Company, Limited  
Ermyn House,  
Ermyn Way,  
Leatherhead,  
Surrey,  
KT22 8UX

**Esso** | Southampton to London Pipeline Project


Drawing title: **WORKS PLAN SHEET 37 REGULATION 5 (2)(J)**

Drawing status: **Fit for Stage Approval**

Scale	1:2500	DO NOT SCALE
Jacobs No.	B2325300	Rev
Client no.		<b>C03</b>

Drawing number: **B2325300-JAC-000-CIV-DRG-000047**

© Copyright 2019 Jacobs U.K. Limited. The concepts and information contained in this document are the property of Jacobs. Use or copying of this document in whole or in part without the written permission of Jacobs constitutes an infringement of copyright. Limitation. This drawing has been prepared on behalf of, and for the exclusive use of, Jacobs' Client, and is subject to, and issued in accordance with, the provisions of the contract between Jacobs and the Client. Jacobs accepts no liability or responsibility whatsoever for, or in respect of, any use of, or reliance upon, this drawing by any third party.

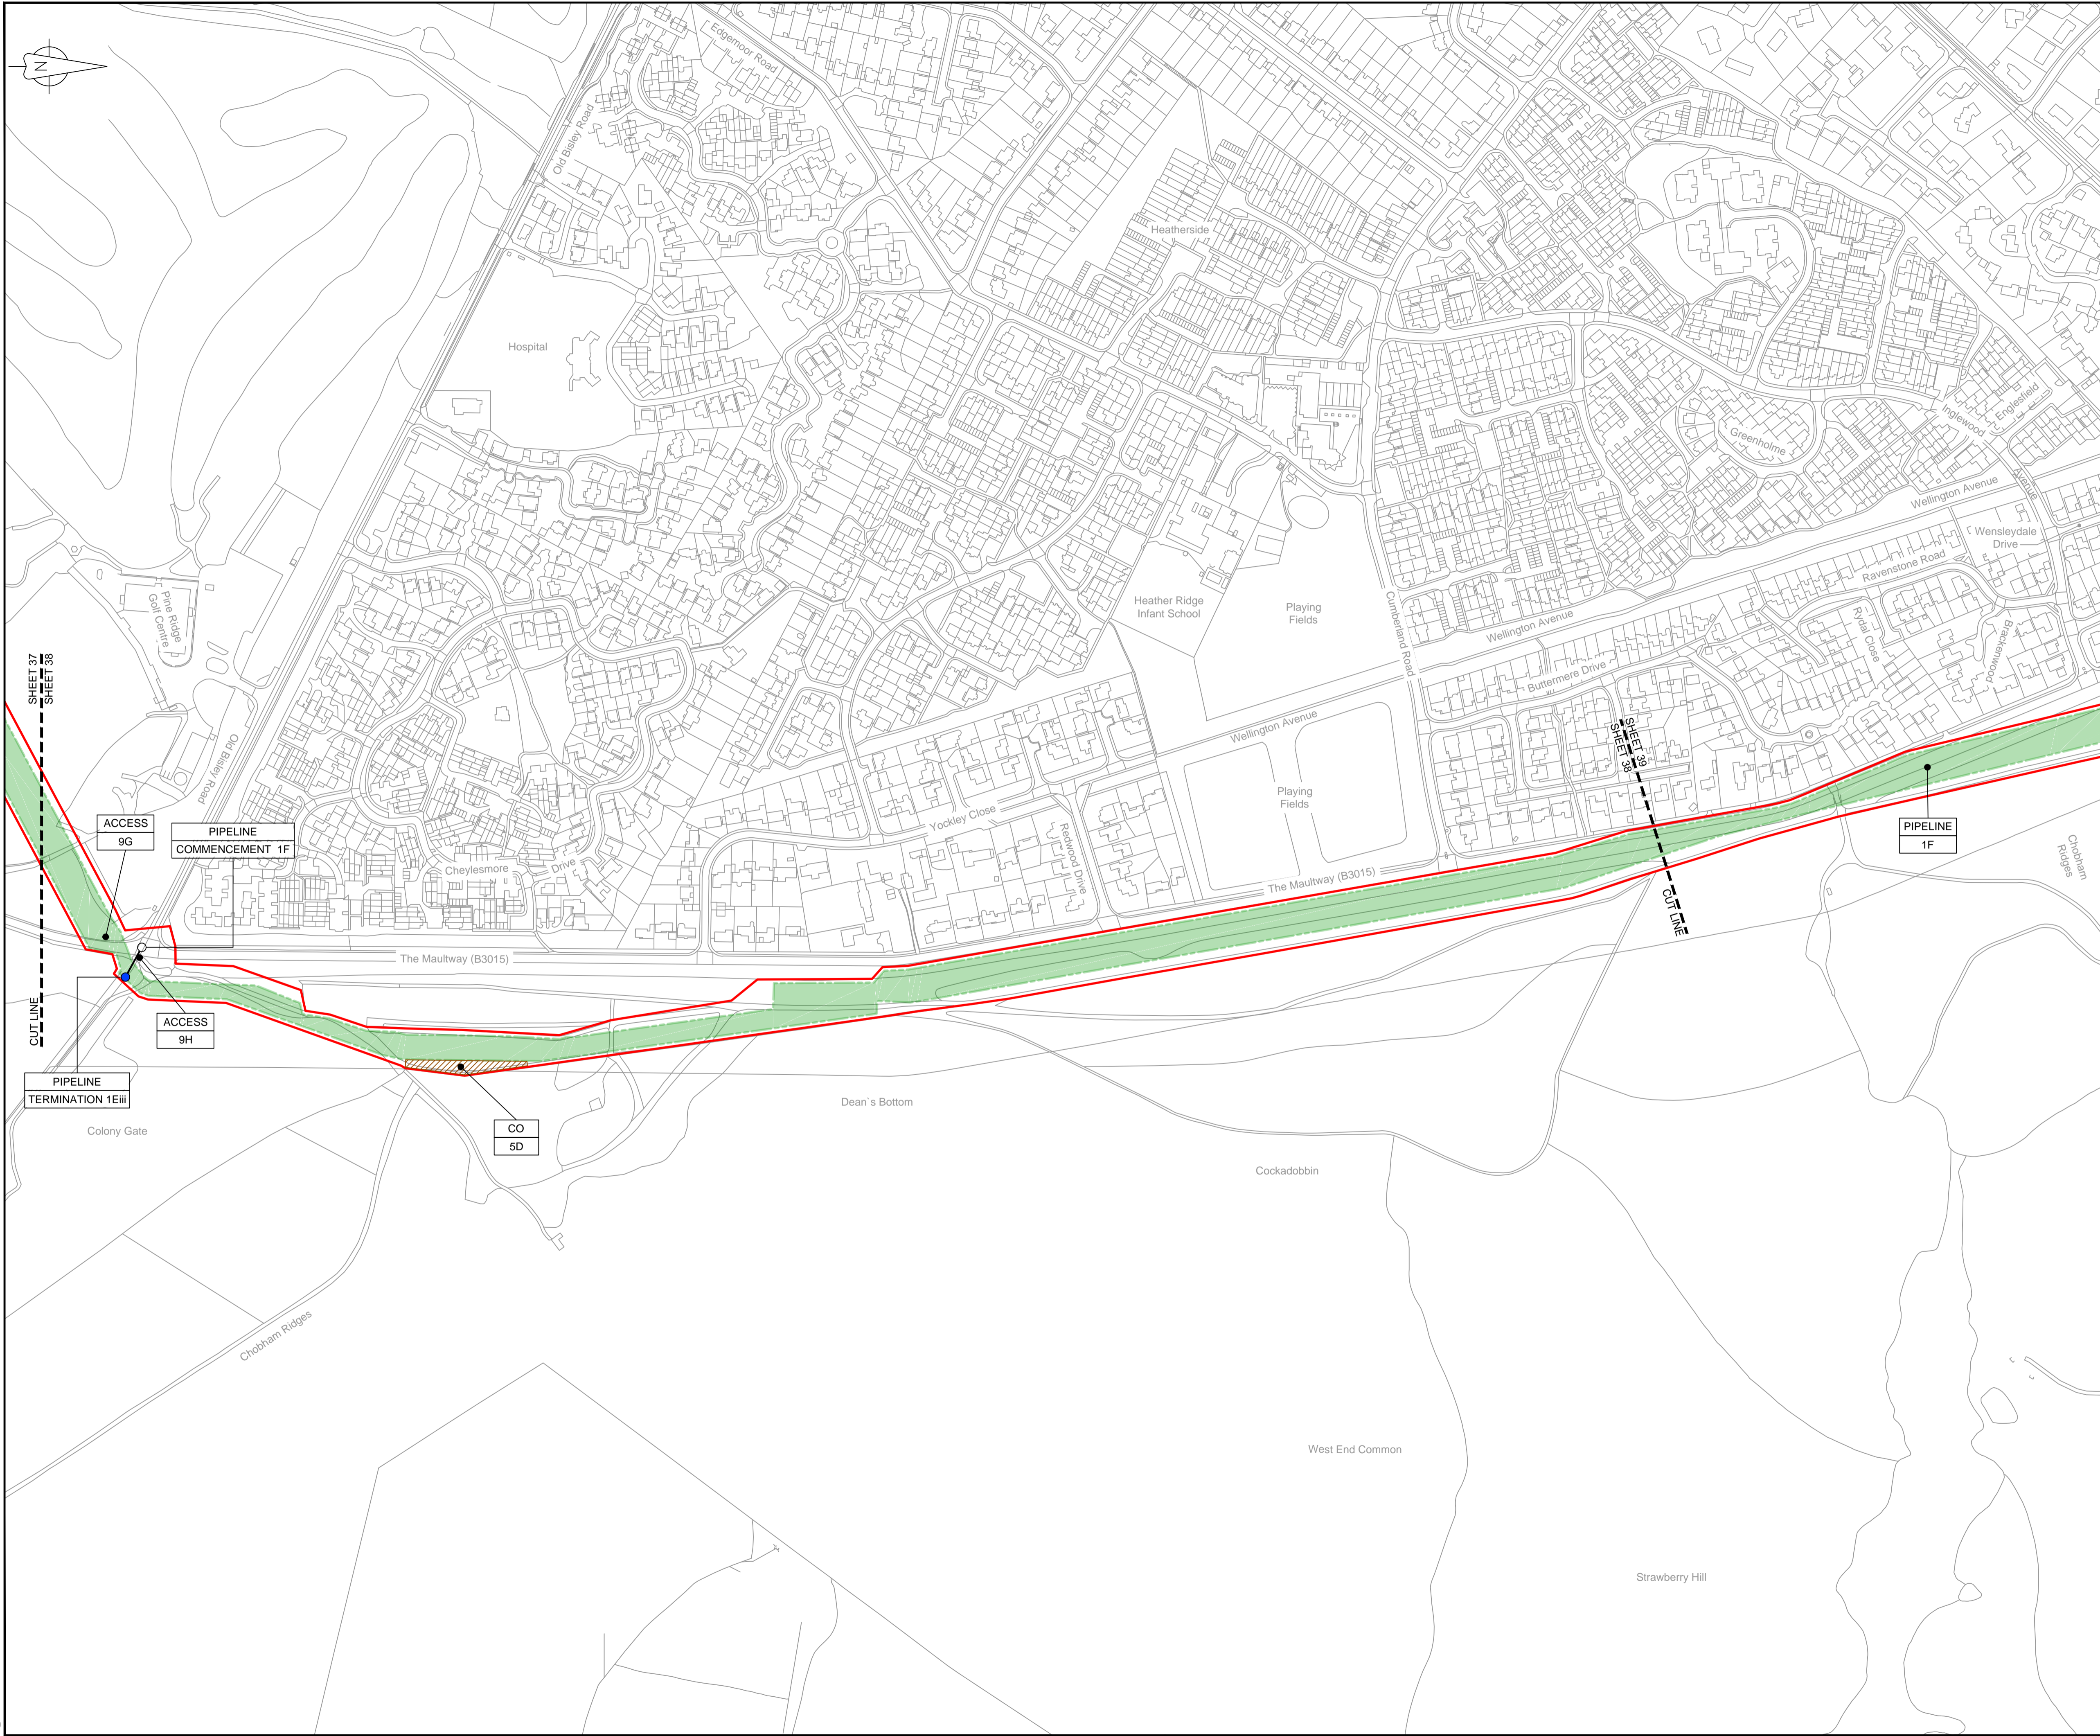


**LOCATION PLAN**  
SCALE 1:500,000

**NOTES**  
1. THIS DRAWING IS IN METRES UNLESS STATED OTHERWISE.

**LEGEND**

	ORDER LIMITS
	LIMITS OF DEVIATION
	COMPOUND (CO)
	ENVIRONMENTAL MITIGATION AREA (EM)
	ABOVE GROUND INSTALLATION (AGI) / VALVE (VA) / PRESSURE TRANSDUCER (PT)
	DESCRIPTION
	ID or WORK NUMBER (if applicable)
	ACCESS
	TEMPORARY CONSTRUCTION ACCESS
	P-ACCESS
	PERMANENT ACCESS
	COMMENCEMENT / TERMINATION OF WORKS (COMMENCEMENT = OPEN, TERMINATION = CLOSED)

Contains Ordnance Survey data © Crown copyright and database rights 2019.  
© Crown copyright and database rights 2019 OS Licence Number AL100005237.

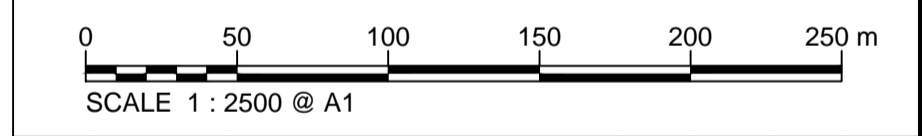

C02	19/06/19	SHEETS 36 AND 109 REVISED FOLLOWING SSI ADVICE	SH	JA	ND	PH
C03	09/09/19	SHEETS 10, 11 AND 54 REVISED TO WITHDRAW A2b SUB-OPTION	BT	JA	ND	NJ
Rev	Rev. Date	Purpose of revision	Drawn	Checked	Rev'd	Appr'd

**JACOBS**  
1180 Eskdale Road, Winnersh, Wokingham, RG41 5TU  
Tel:+44(0)118 946 7000 Fax:+44(0)118 946 7001  
www.jacobs.com

Client: Esso Petroleum Company, Limited  
Emryn House,  
Emryn Way,  
Leatherhead,  
Surrey,  
KT22 8UX

Project: Southampton to London Pipeline Project


Drawing title: **WORKS PLAN  
SHEET 38  
REGULATION 5 (2)(J)**

Drawing status: **Fit for Stage Approval**

Scale	1:2500	DO NOT SCALE
Jacobs No.	B2325300	Rev
Client no.		<b>C03</b>

Drawing number: **B2325300-JAC-000-CIV-DRG-000048**

© Copyright 2019 Jacobs U.K. Limited. The concepts and information contained in this document are the property of Jacobs. Use or copying of this document in whole or in part without the written permission of Jacobs constitutes an infringement of copyright. Limitation: This drawing has been prepared on behalf of, and for the exclusive use of, the Client, and is subject to, and issued in accordance with, the provisions of the contract between Jacobs and the Client. Jacobs accepts no liability or responsibility whatsoever for, or in respect of, any use of, or reliance upon, this drawing by any third party.

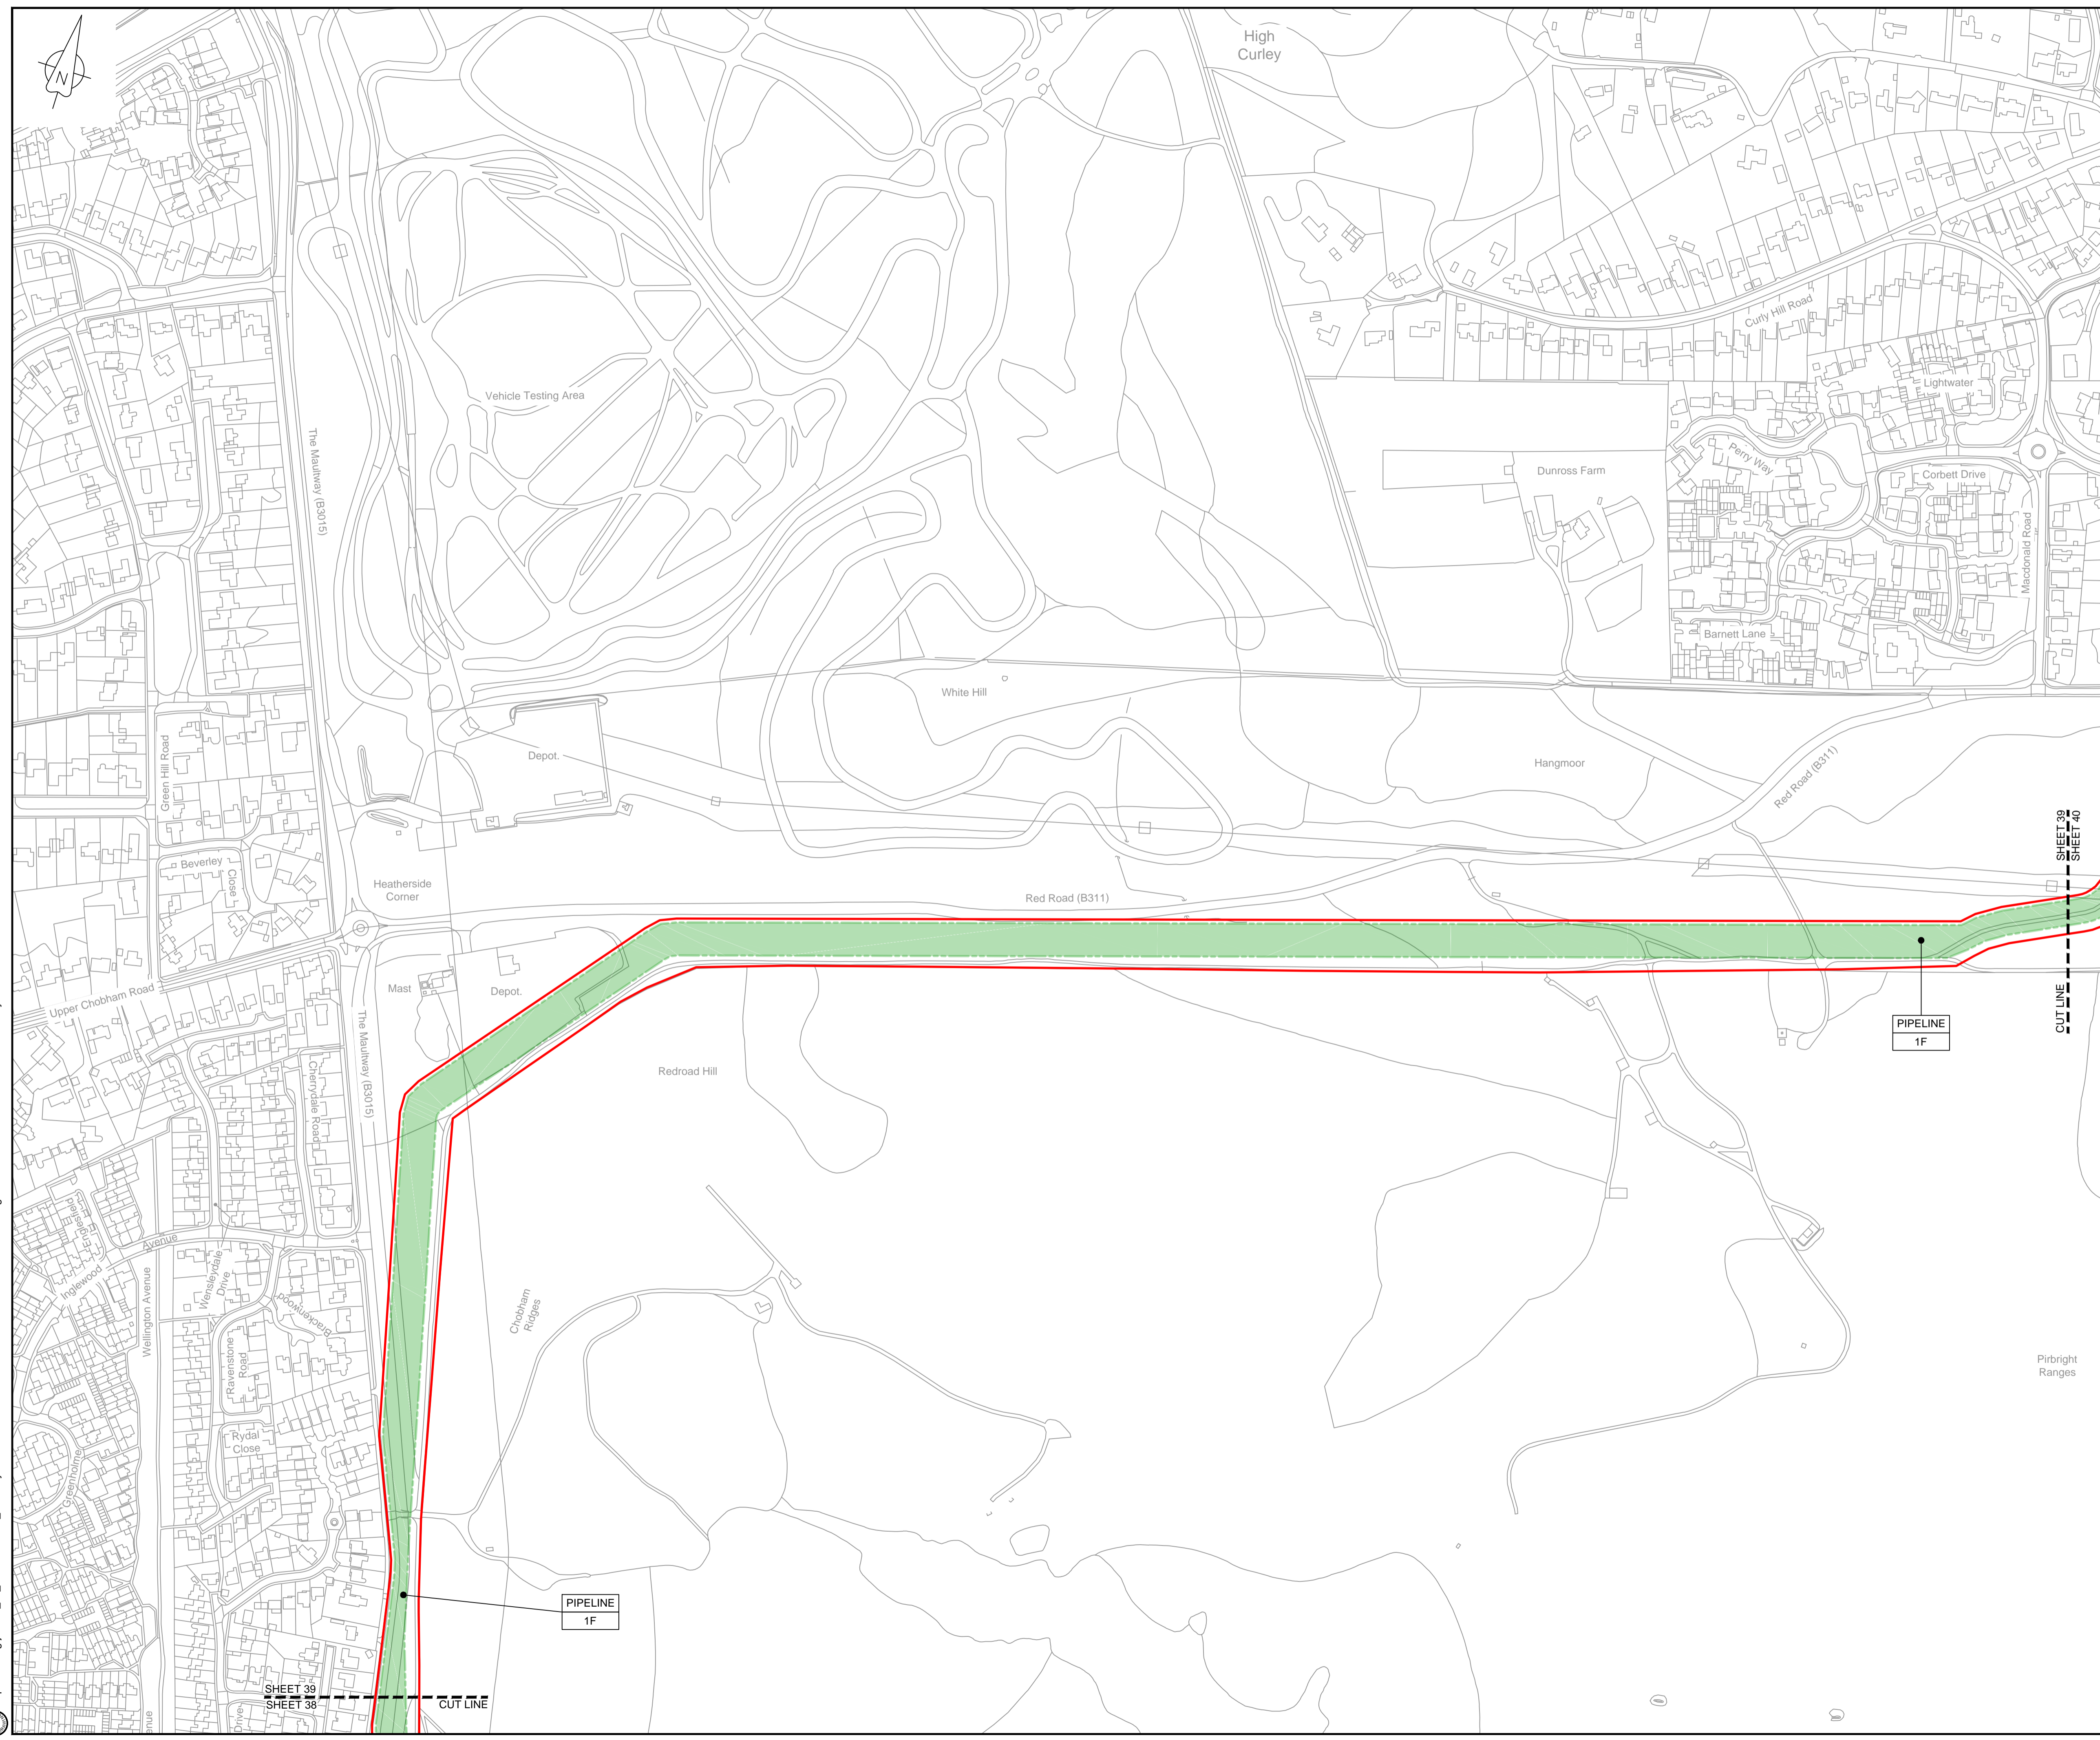

**LOCATION PLAN**  
SCALE 1:500,000

**NOTES**  
1. THIS DRAWING IS IN METRES UNLESS STATED OTHERWISE.

**LEGEND**

	ORDER LIMITS
	LIMITS OF DEVIATION
	COMPOUND (CO)
	ENVIRONMENTAL MITIGATION AREA (EM)
	ABOVE GROUND INSTALLATION (AGI) / VALVE (VA) / PRESSURE TRANSDUCER (PT)
	DESCRIPTION
	ID or WORK NUMBER (if applicable)
	ACCESS
	TEMPORARY CONSTRUCTION ACCESS
	P-ACCESS
	PERMANENT ACCESS
	COMMENCEMENT / TERMINATION OF WORKS
	(COMMENCEMENT = OPEN, TERMINATION = CLOSED)

Contains Ordnance Survey data © Crown copyright and database rights 2019.  
© Crown copyright and database rights 2019 OS Licence Number AL100005237.



C02	19/06/19	SHEETS 36 AND 109 REVISED FOLLOWING SSI ADVICE	SH	JA	ND	PH
C03	09/09/19	SHEETS 10, 11 AND 54 REVISED TO WITHDRAW A2b SUB-OPTION	BT	JA	ND	NJ
Rev	Rev. Date	Purpose of revision	Drawn	Checked	Rev'd	Appr'd

**JACOBS**  
1180 Eskdale Road, Winnersh, Wokingham, RG41 5TU  
Tel: +44(0)118 946 7000 Fax: +44(0)118 946 7001  
www.jacobs.com

Client: Esso Petroleum Company, Limited  
Emryn House,  
Emryn Way,  
Leatherhead,  
Surrey,  
KT22 8UX

Project: Southampton to London Pipeline Project

Drawing title: **WORKS PLAN SHEET 39 REGULATION 5 (2)(J)**


Drawing status: **Fit for Stage Approval**

Scale	1:2500	DO NOT SCALE
Jacobs No.	B2325300	Rev
Client no.		<b>C03</b>

Drawing number: **B2325300-JAC-000-CIV-DRG-000049**

© Copyright 2019 Jacobs U.K. Limited. The concepts and information contained in this document are the property of Jacobs. Use or copying of this document in whole or in part without the written permission of Jacobs constitutes an infringement of copyright. Limitation. This drawing has been prepared on behalf of and for the exclusive use of Jacobs' Client, and is subject to, and issued in accordance with, the provisions of the contract between Jacobs and the Client. Jacobs accepts no liability or responsibility whatsoever for, or in respect of, any use of, or reliance upon, this drawing by any third party.

C:\pwworking\jacobs\_uk\_water\utilities\_ssf\london\dms3351\B2325300-JAC-000-CIV-DRG-000049.dwg - 10/09/2019 11:53:23 - A1Frame - BTaylor

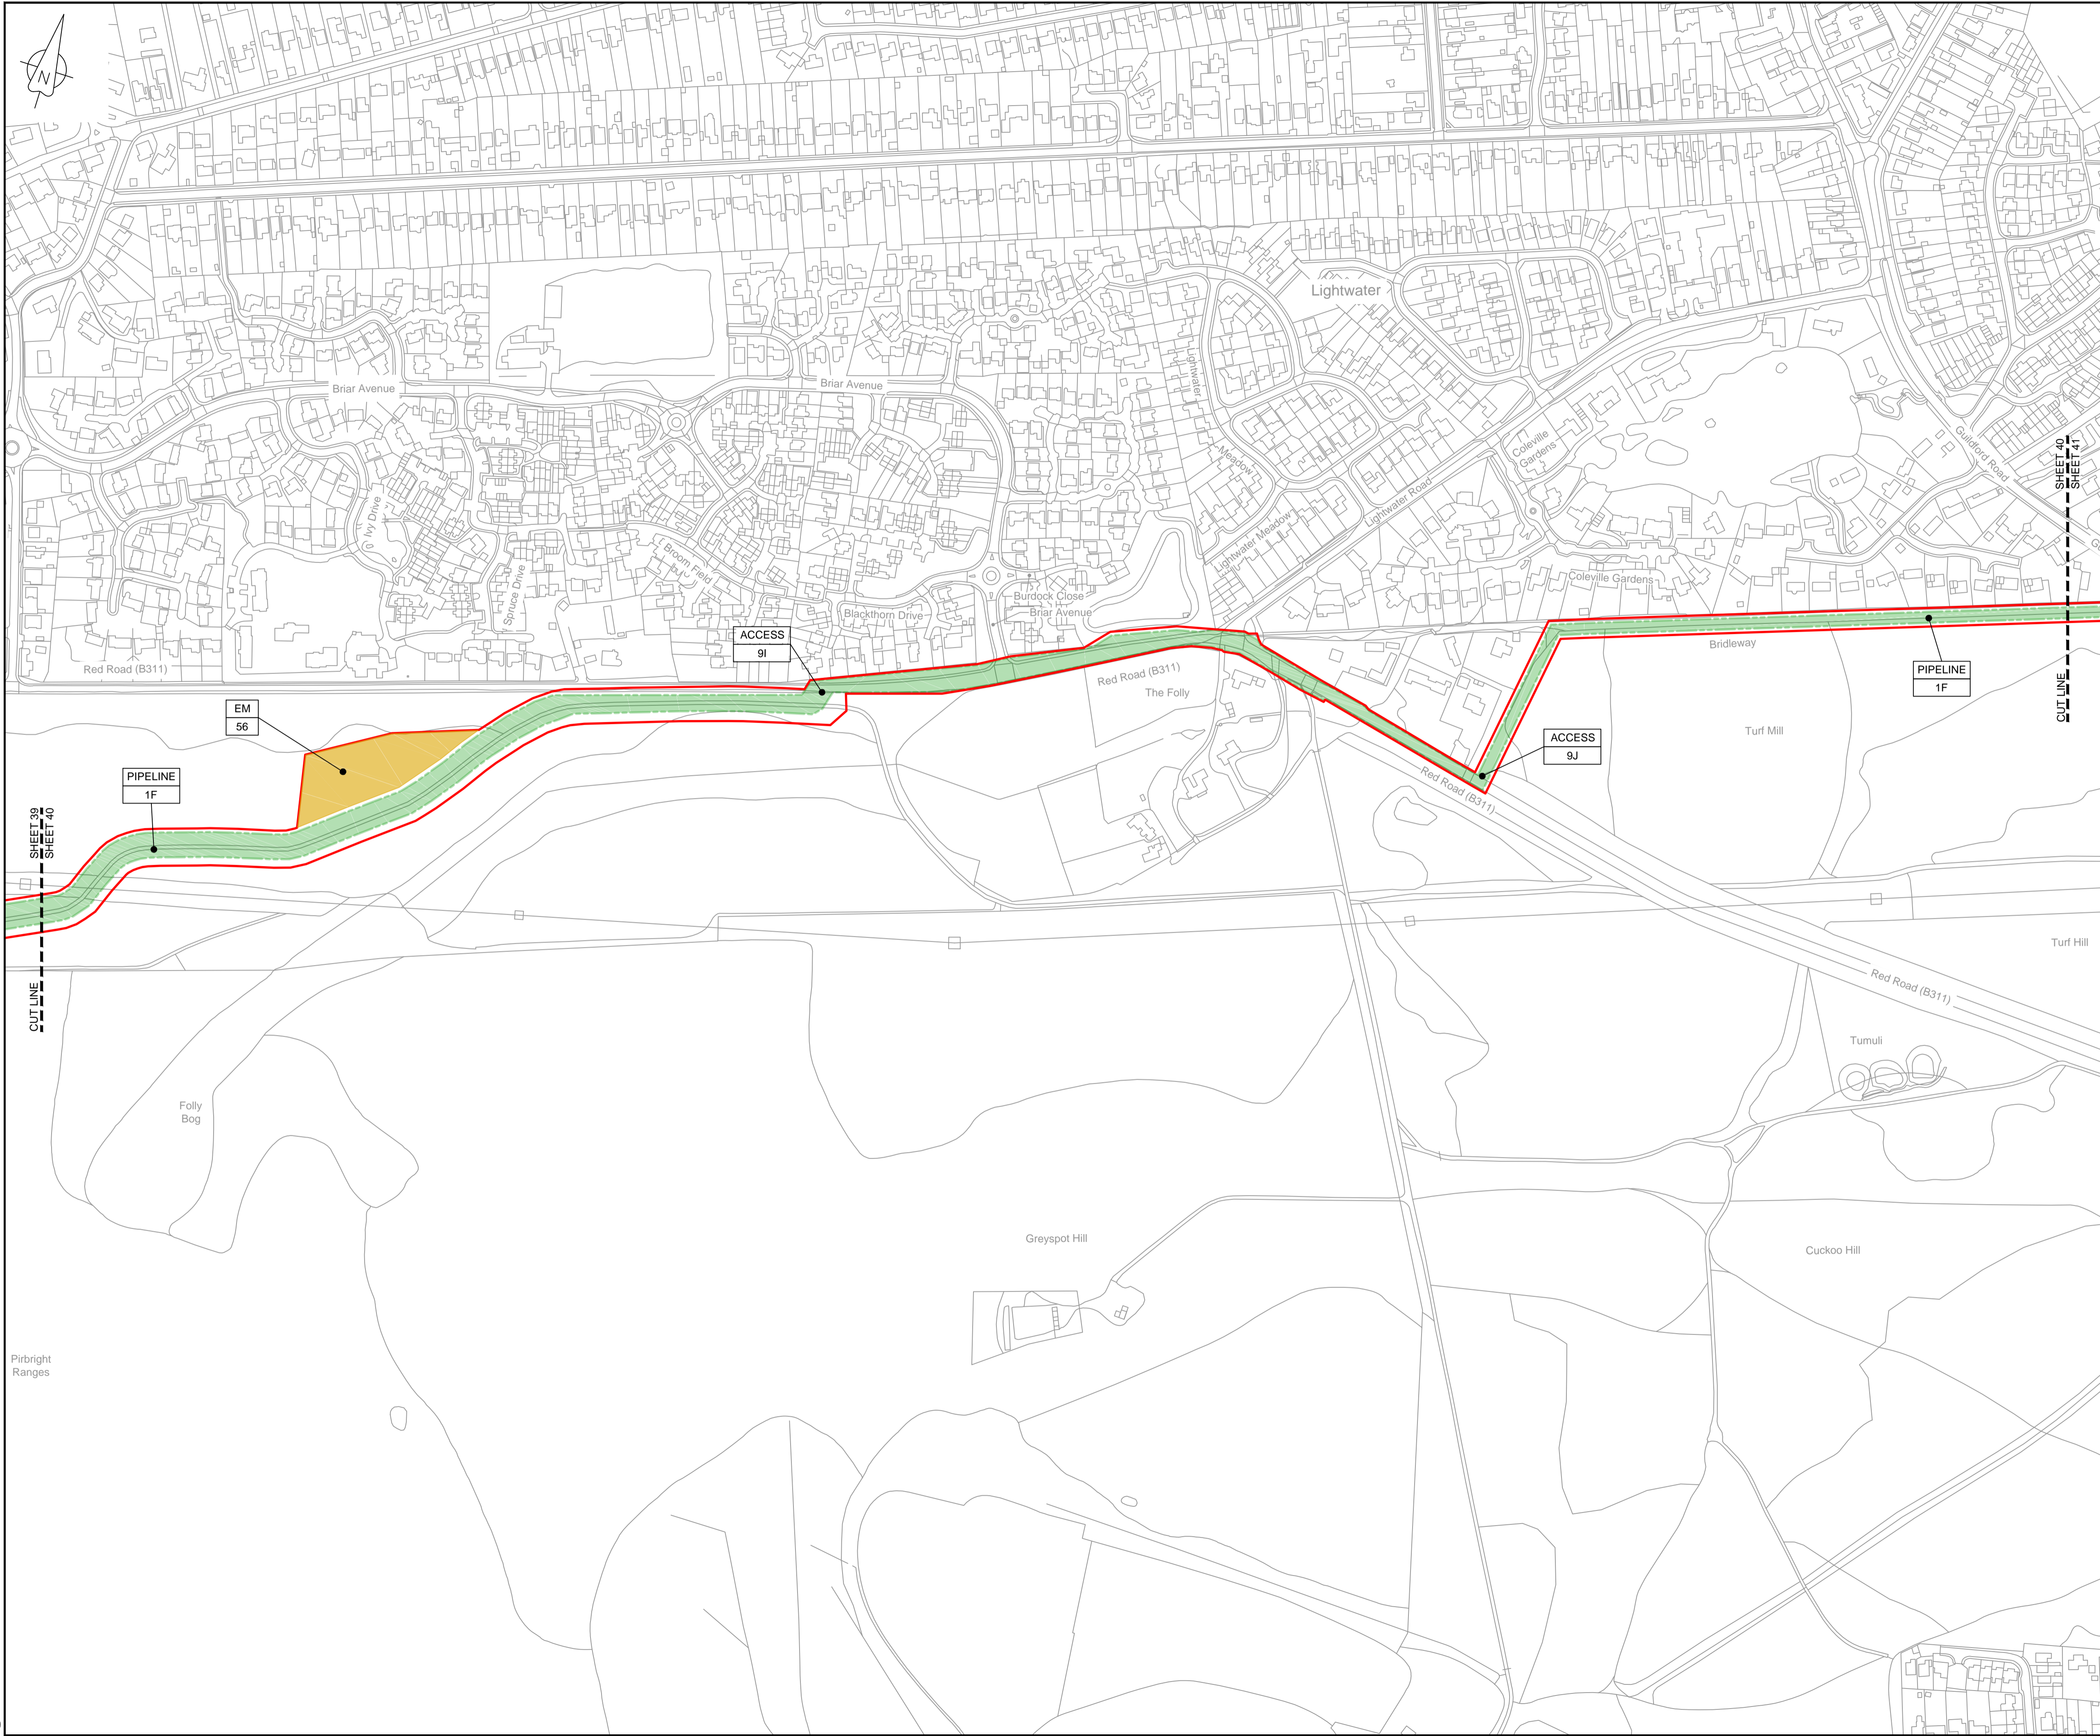


**LOCATION PLAN**  
SCALE 1:500,000

**NOTES**  
1. THIS DRAWING IS IN METRES UNLESS STATED OTHERWISE.

**LEGEND**

	ORDER LIMITS
	LIMITS OF DEVIATION
	COMPOUND (CO)
	ENVIRONMENTAL MITIGATION AREA (EM)
	ABOVE GROUND INSTALLATION (AGI) / VALVE (VA) / PRESSURE TRANSDUCER (PT)
	DESCRIPTION
	ID or WORK NUMBER (if applicable)
	ACCESS
	TEMPORARY CONSTRUCTION ACCESS
	P-ACCESS PERMANENT ACCESS
	COMMENCEMENT / TERMINATION OF WORKS (COMMENCEMENT = OPEN, TERMINATION = CLOSED)

Contains Ordnance Survey data © Crown copyright and database rights 2019.  
© Crown copyright and database rights 2019 OS Licence Number AL100005237.

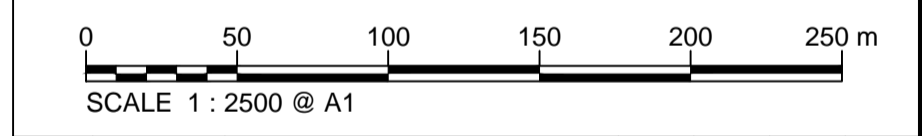

C02	19/06/19	SHEETS 36 AND 108 REVISED FOLLOWING SSI ADVICE	SH	JA	ND	PH
C03	09/09/19	SHEETS 10, 11 AND 54 REVISED TO WITHDRAW A2b SUB-OPTION	BT	JA	ND	NJ
Rev	Rev. Date	Purpose of revision	Drawn	Checked	Rev'd	Appr'd

**JACOBS**  
1180 Eskdale Road, Wokingham, Wokingham, RG41 5TU  
Tel:+44(0)118 946 7000 Fax:+44(0)118 946 7001  
www.jacobs.com

Client: Esso Petroleum Company, Limited  
Emryn House,  
Emryn Way,  
Leatherhead,  
Surrey,  
KT22 8UX

Project: Southampton to London Pipeline Project


Drawing title: **WORKS PLAN  
SHEET 40  
REGULATION 5 (2)(J)**

Drawing status: **Fit for Stage Approval**

Scale	1:2500	DO NOT SCALE
Jacobs No.	B2325300	Rev
Client no.		<b>C03</b>

Drawing number: **B2325300-JAC-000-CIV-DRG-000050**

© Copyright 2019 Jacobs U.K. Limited. The concepts and information contained in this document are the property of Jacobs. Use or copying of this document in whole or in part without the written permission of Jacobs constitutes an infringement of copyright. Limitation: This drawing has been prepared on behalf of, and for the exclusive use of, the Client, and is subject to, and issued in accordance with, the provisions of the contract between Jacobs and the Client. Jacobs accepts no liability or responsibility whatsoever for, or in respect of, any use of, or reliance upon, this drawing by any third party.

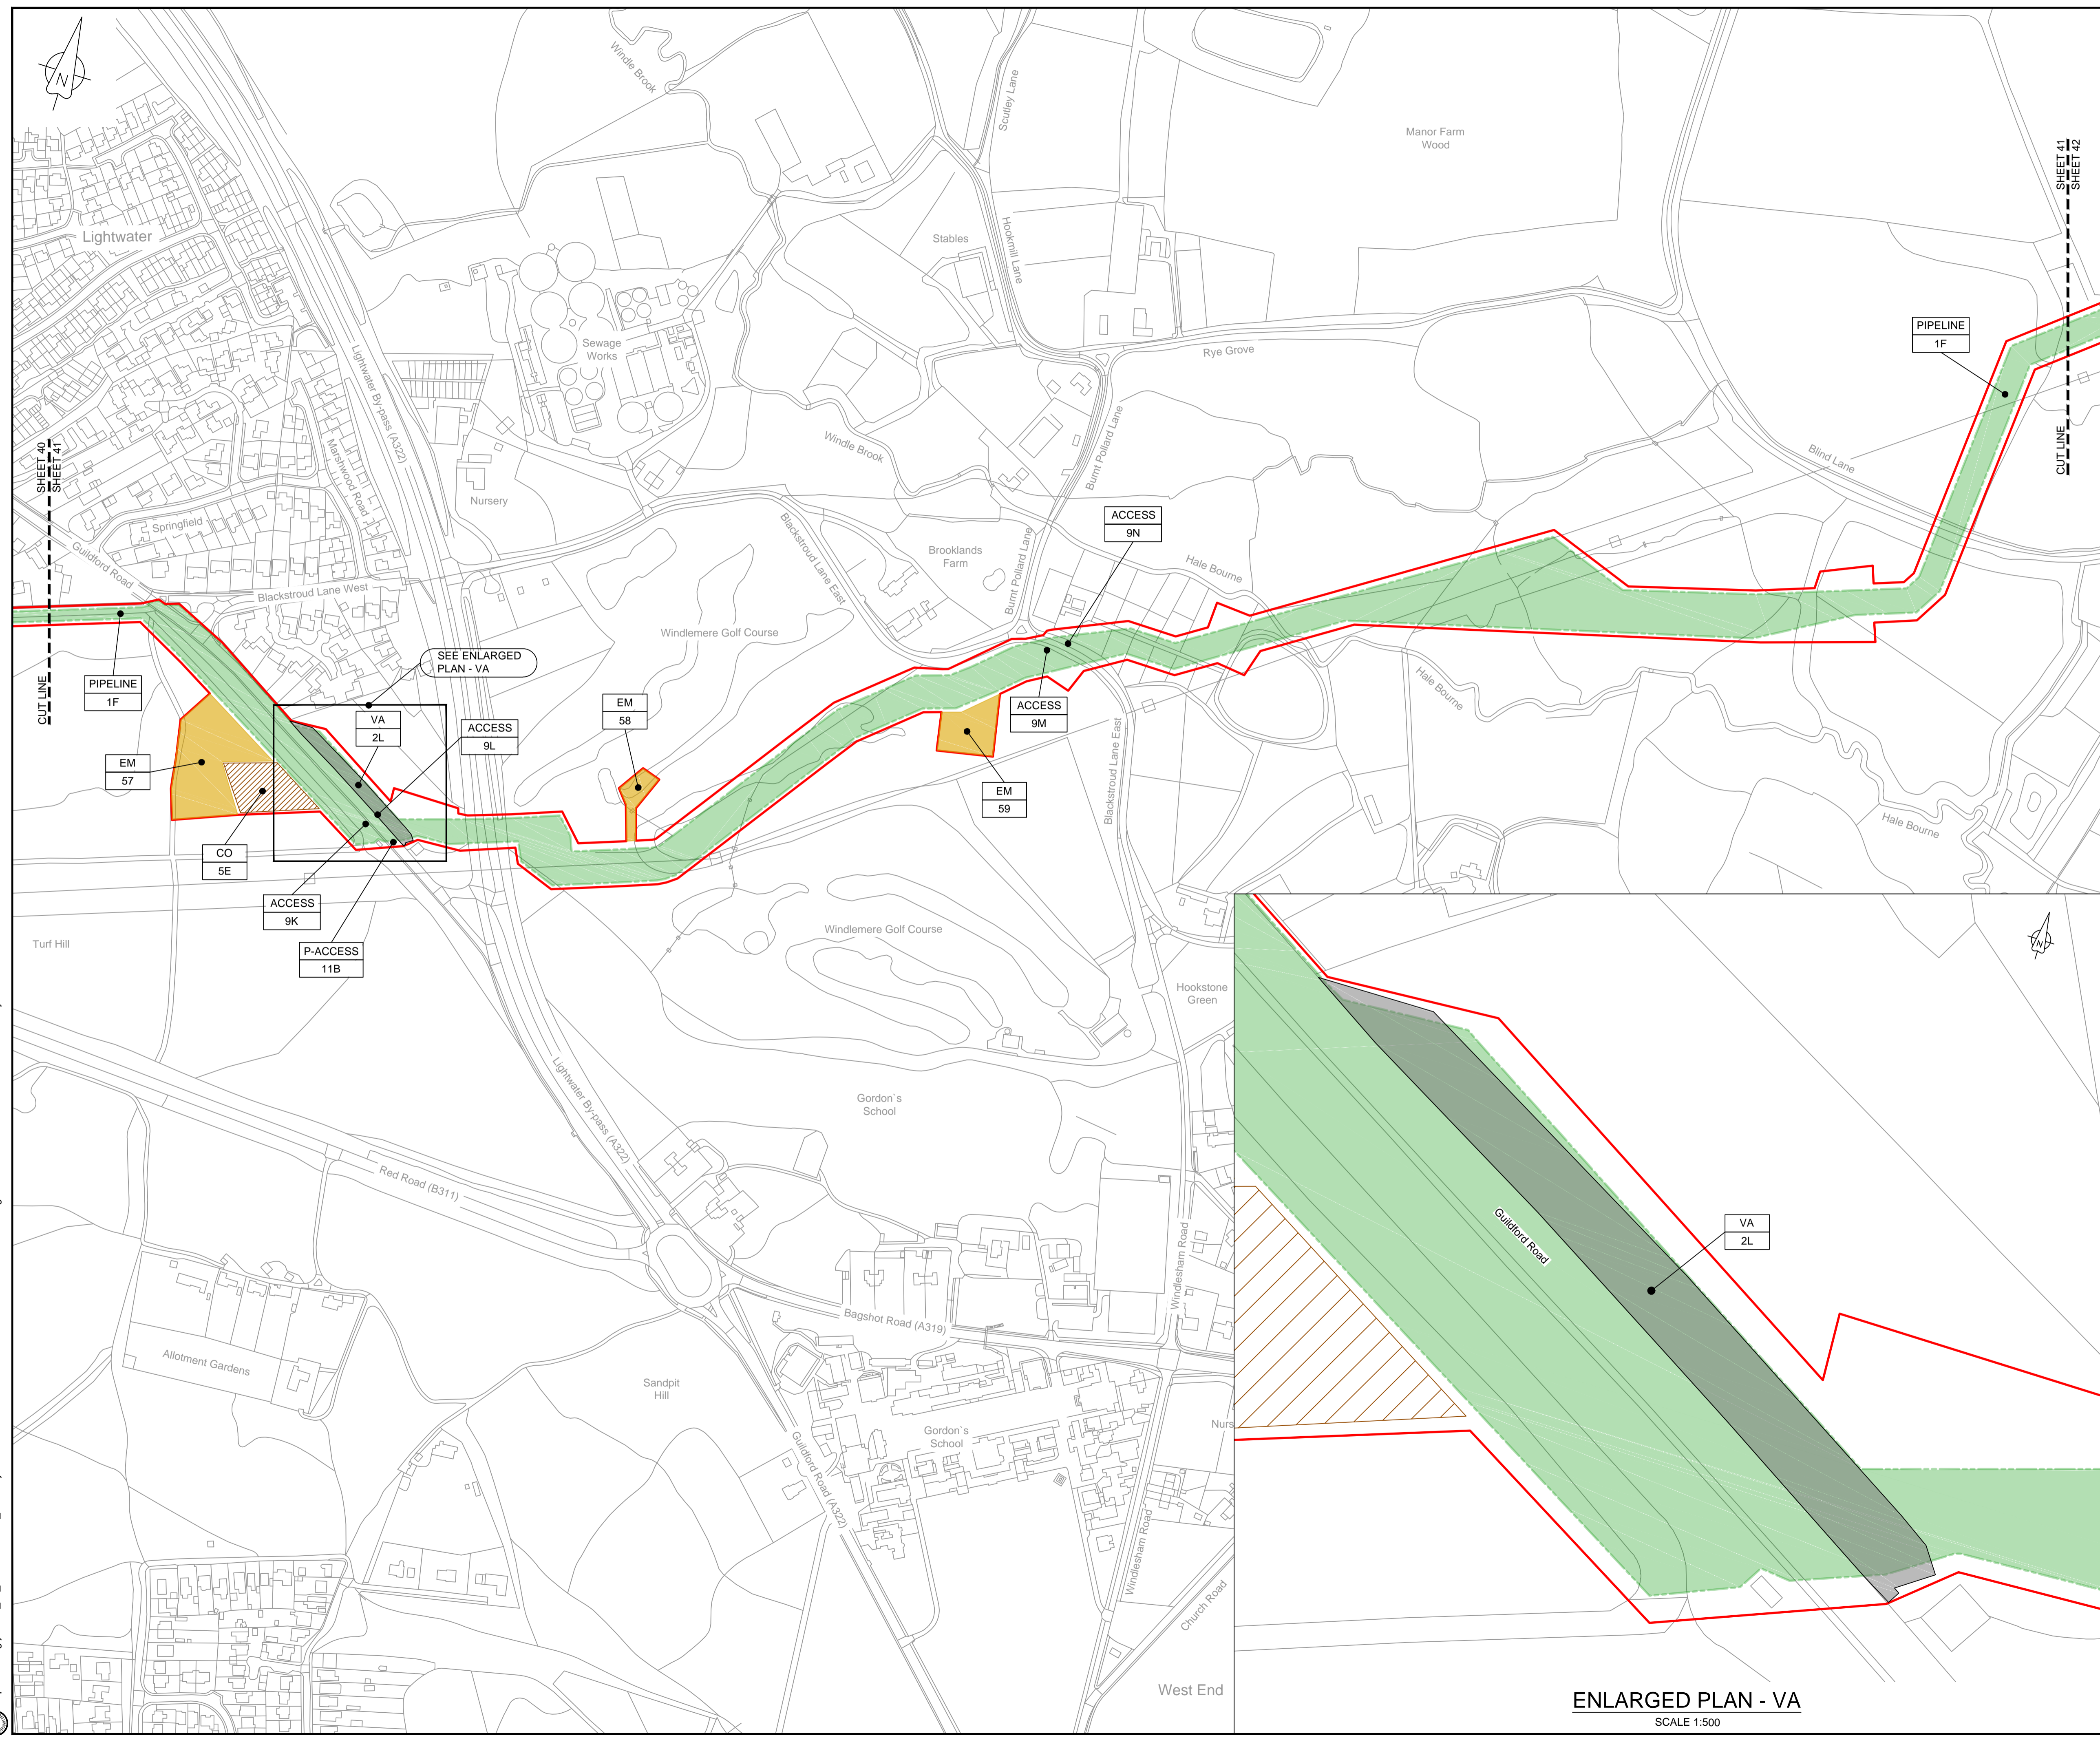

**LOCATION PLAN**  
SCALE 1:500,000

**NOTES**  
1. THIS DRAWING IS IN METRES UNLESS STATED OTHERWISE.

**LEGEND**

	ORDER LIMITS
	LIMITS OF DEVIATION
	COMPOUND (CO)
	ENVIRONMENTAL MITIGATION AREA (EM)
	ABOVE GROUND INSTALLATION (AGI) / VALVE (VA) / PRESSURE TRANSDUCER (PT)
	DESCRIPTION
	ID or WORK NUMBER (if applicable)
	ACCESS
	TEMPORARY CONSTRUCTION ACCESS
	P-ACCESS
	COMMENCEMENT / TERMINATION OF WORKS
	(COMMENCEMENT = OPEN, TERMINATION = CLOSED)

Contains Ordnance Survey data © Crown copyright and database rights 2019.  
© Crown copyright and database rights 2019 OS Licence Number AL100005237.



C02	19/06/19	SHEETS 36 AND 108 REVISED FOLLOWING SSI ADVICE	SH	JA	ND	PH
C03	09/09/19	SHEETS 10, 11 AND 54 REVISED TO WITHDRAW A2b SUB-OPTION	BT	JA	ND	NJ
Rev	Rev. Date	Purpose of revision	Drawn	Checked	Rev'd	Appr'd

**JACOBS**  
1180 Eskdale Road, Wokingham, Wokingham, RG41 5TU  
Tel: +44(0)118 946 7000 Fax: +44(0)118 946 7001  
www.jacobs.com

Client: Esso Petroleum Company, Limited  
Emryn House,  
Emryn Way,  
Leatherhead,  
Surrey,  
KT22 8UX

Project: Southampton to London Pipeline Project

Drawing title: **WORKS PLAN SHEET 41 REGULATION 5 (2)(J)**

Drawing status: **Fit for Stage Approval**

Scale	1:2500	DO NOT SCALE
Jacobs No.	B2325300	Rev
Client no.		<b>C03</b>


Drawing number: **B2325300-JAC-000-CIV-DRG-000051**

© Copyright 2019 Jacobs U.K. Limited. The concepts and information contained in this document are the property of Jacobs. Use or copying of this document in whole or in part without the written permission of Jacobs constitutes an infringement of copyright. Limitation. This drawing has been prepared on behalf of, and for the exclusive use of, Jacobs' Client, and is subject to, and issued in accordance with, the provisions of the contract between Jacobs and the Client. Jacobs accepts no liability or responsibility whatsoever for, or in respect of, any use of, or reliance upon, this drawing by any third party.

C:\pwworking\jacobs\_uk\_water&utilities\_ssf\by\ordms33513\B2325300-JAC-000-CIV-DRG-000051.dwg - 10/09/2019 11:57:43 - A1Frame - BTaylor

**ENLARGED PLAN - VA**  
SCALE 1:500



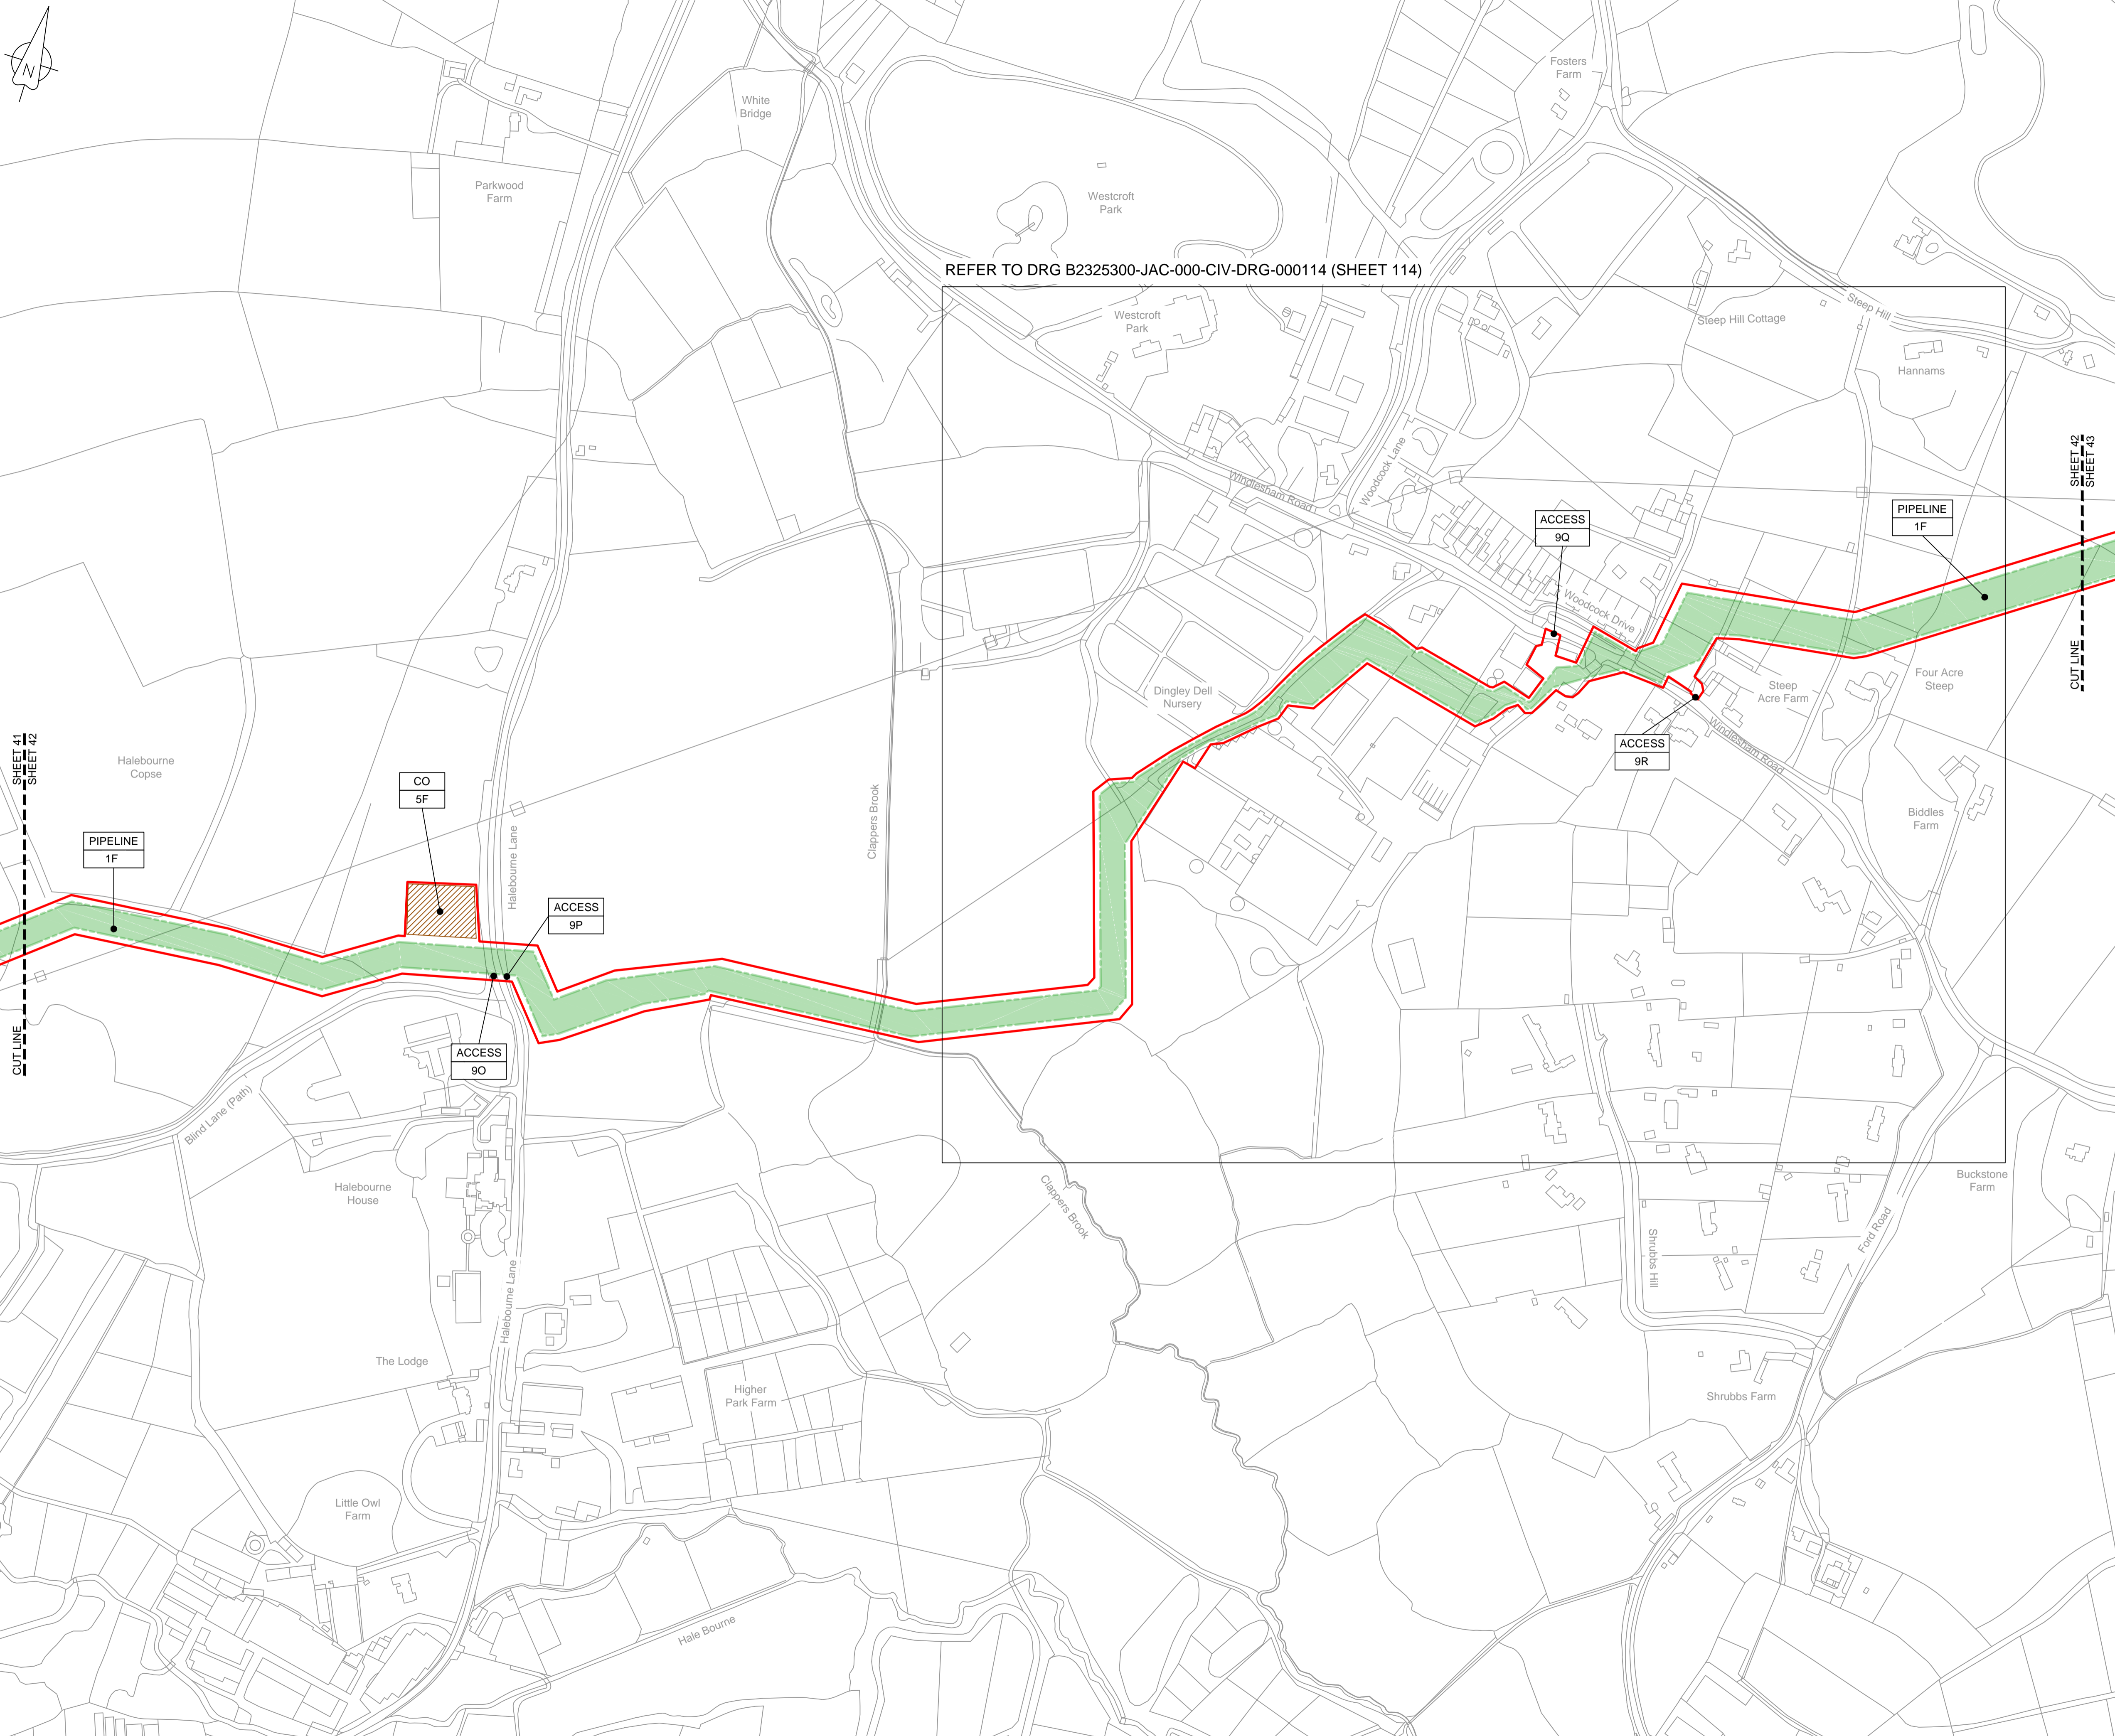

REFER TO DRG B2325300-JAC-000-CIV-DRG-000114 (SHEET 114)



LOCATION PLAN  
SCALE 1:500,000

NOTES  
1. THIS DRAWING IS IN METRES UNLESS STATED OTHERWISE.

**LEGEND**

	ORDER LIMITS
	LIMITS OF DEVIATION
	COMPOUND (CO)
	ENVIRONMENTAL MITIGATION AREA (EM)
	ABOVE GROUND INSTALLATION (AGI) / VALVE (VA) / PRESSURE TRANSDUCER (PT)
	DESCRIPTION
	ID or WORK NUMBER (if applicable)
	ACCESS
	TEMPORARY CONSTRUCTION ACCESS
	PERMANENT ACCESS
	COMMENCEMENT / TERMINATION OF WORKS (COMMENCEMENT = OPEN, TERMINATION = CLOSED)

Contains Ordnance Survey data © Crown copyright and database rights 2019.  
© Crown copyright and database rights 2019 OS Licence Number AL10005237.



C02	19/06/19	SHEETS 36 AND 108 REVISED FOLLOWING S51 ADVICE	SH	JA	ND	PH
C03	09/09/19	SHEETS 10, 11 AND 54 REVISED TO WITHDRAW A2b SUB-OPTION	BT	JA	ND	NJ
Rev	Rev. Date	Purpose of revision	Drawn	Checked	Rev'd	Appr'd

**JACOBS**

1180 Eskdale Road, Winnersh, Wokingham, RG41 5TU  
Tel: +44(0)118 946 7000 Fax: +44(0)118 946 7001  
www.jacobs.com

Client: Esso Petroleum Company, Limited  
Emryn House,  
Emryn Way,  
Leatherhead,  
Surrey,  
KT22 8UX




Drawing title  
**WORKS PLAN  
SHEET 42  
REGULATION 5 (2)(J)**

Drawing status: **Fit for Stage Approval**

Scale	1:2500	DO NOT SCALE
Jacobs No.	B2325300	Rev
Client no.		<b>C03</b>

Drawing number  
**B2325300-JAC-000-CIV-DRG-000052**

© Copyright 2019 Jacobs U.K. Limited. The concepts and information contained in this document are the property of Jacobs. Use or copying of this document in whole or in part without the written permission of Jacobs constitutes an infringement of copyright. Limitation: This drawing has been prepared on behalf of, and for the exclusive use of, Jacobs' Client, and is subject to, and issued in accordance with, the provisions of the contract between Jacobs and the Client. Jacobs accepts no liability or responsibility whatsoever for, or in respect of, any use of, or reliance upon, this drawing by any third party.

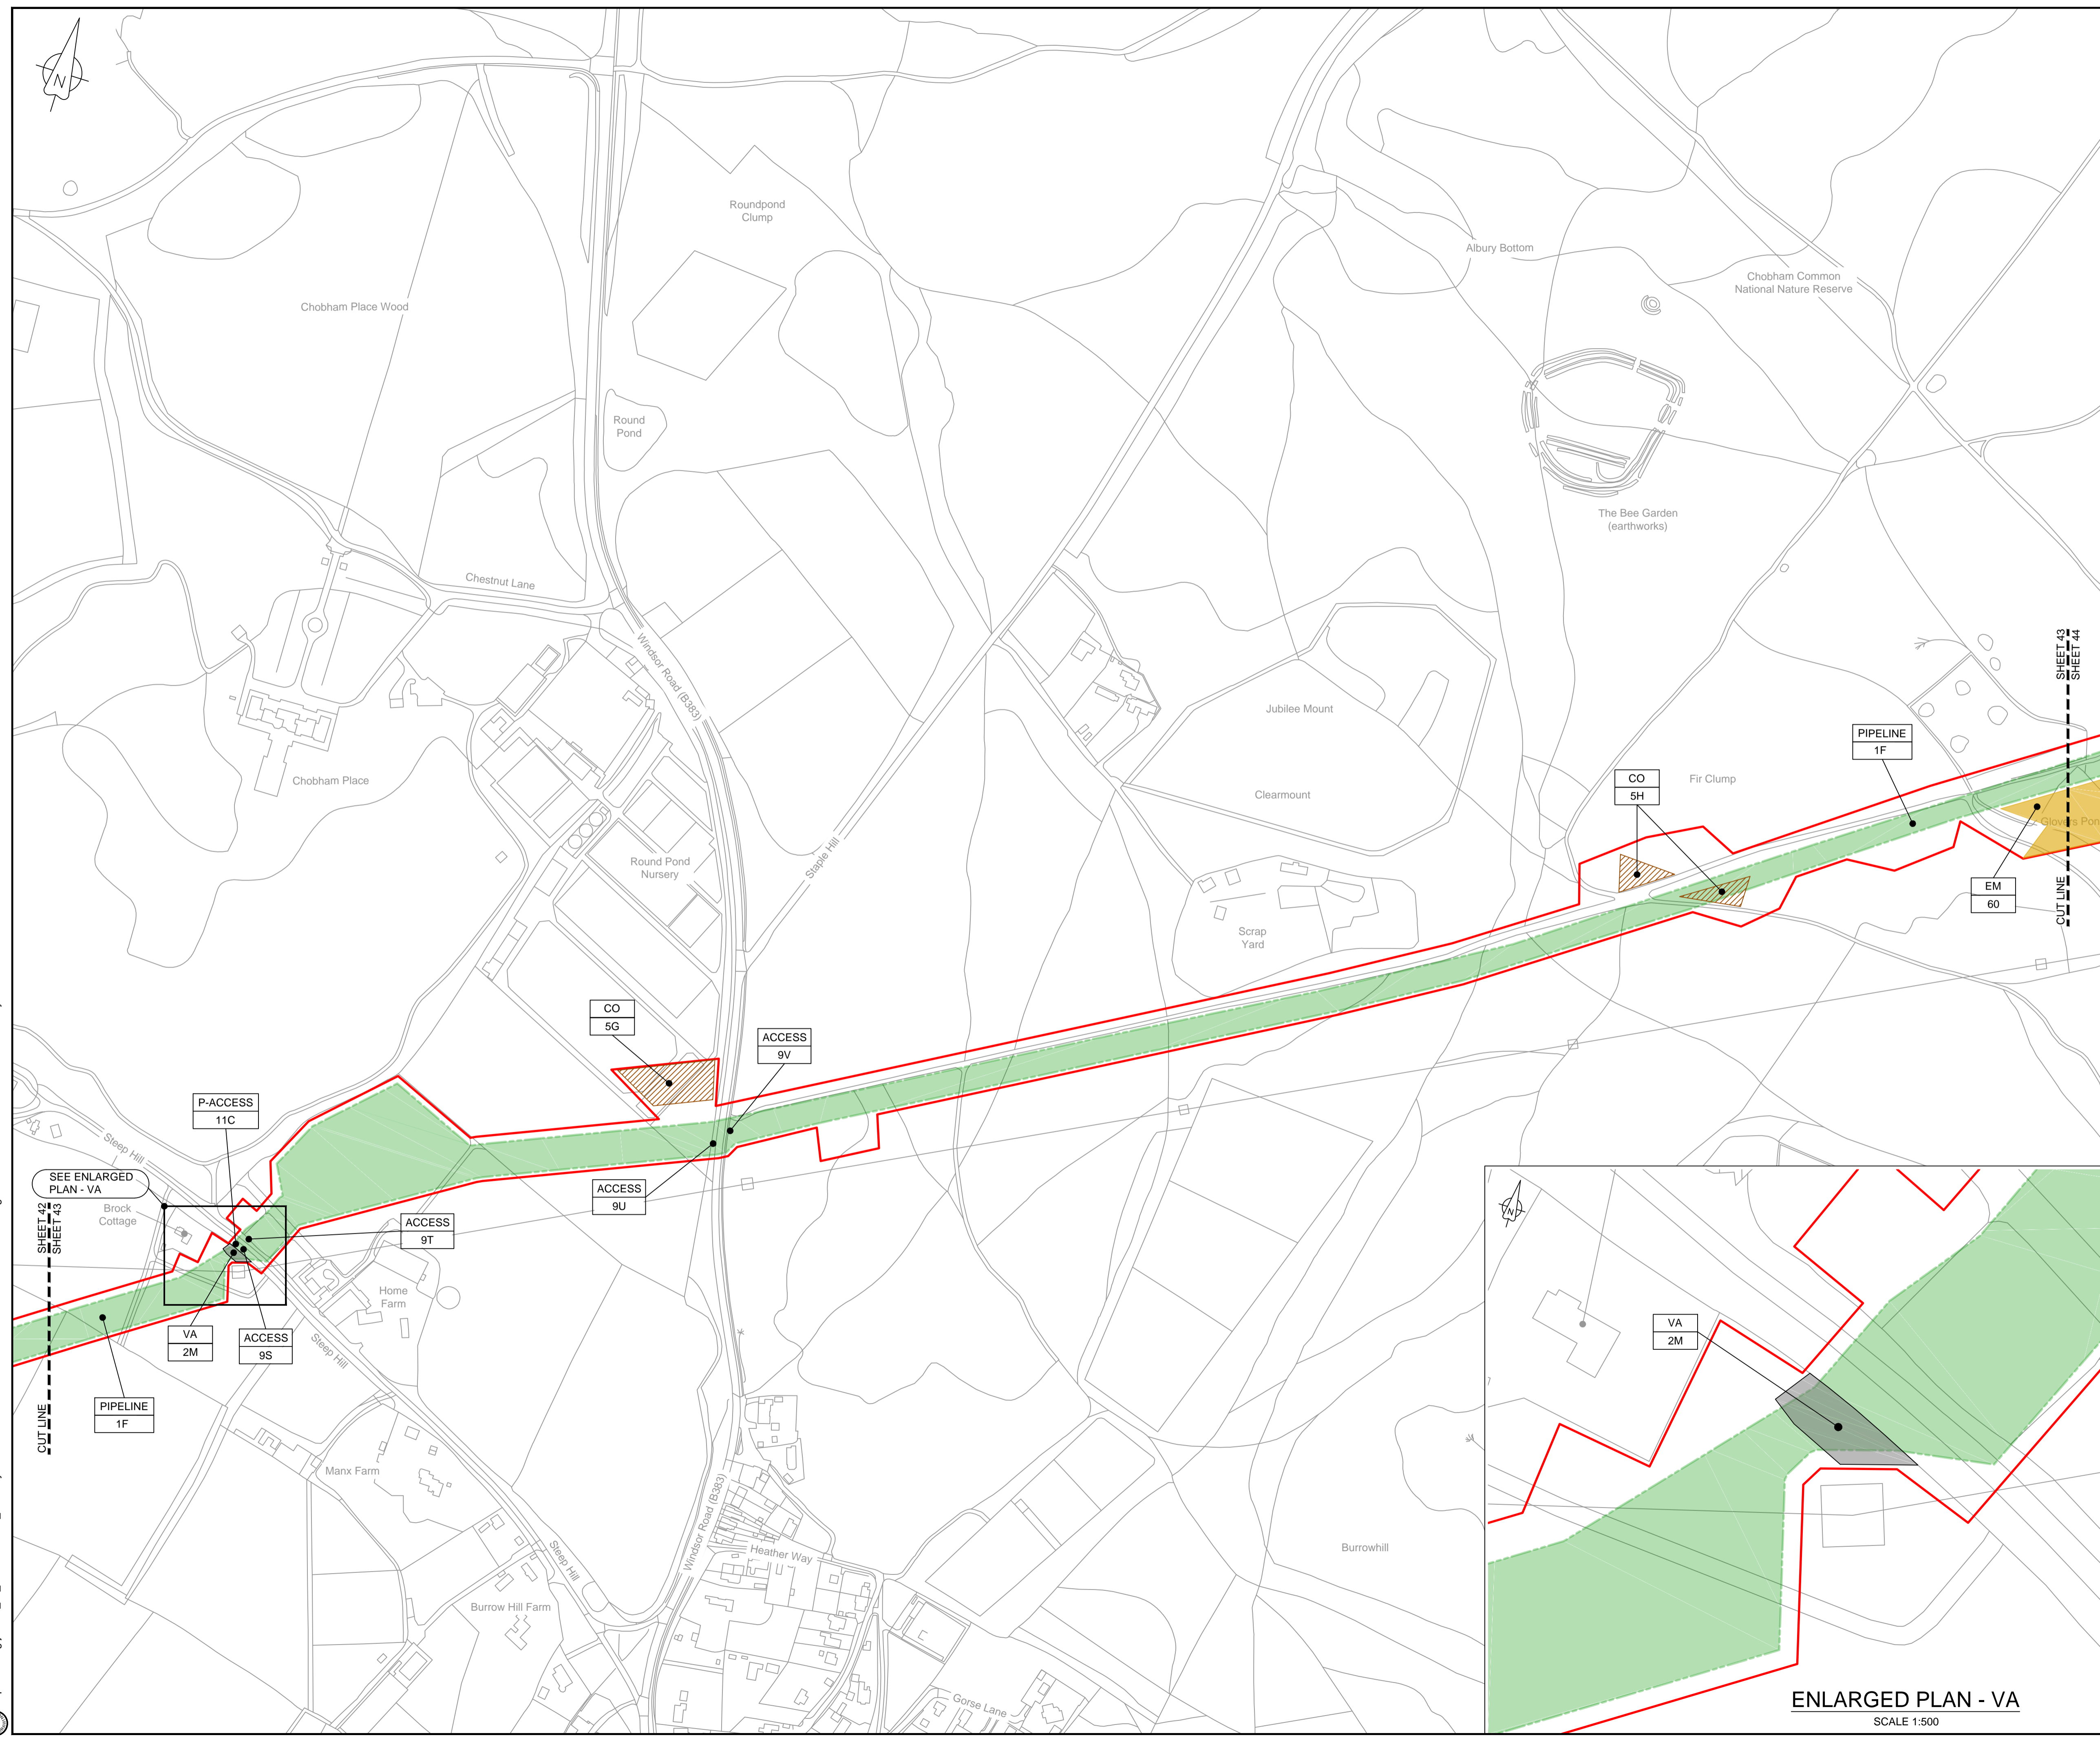

**LOCATION PLAN**  
SCALE 1:500,000

**NOTES**  
1. THIS DRAWING IS IN METRES UNLESS STATED OTHERWISE.

**LEGEND**

	ORDER LIMITS
	LIMITS OF DEVIATION
	COMPOUND (CO)
	ENVIRONMENTAL MITIGATION AREA (EM)
	ABOVE GROUND INSTALLATION (AGI) / VALVE (VA) / PRESSURE TRANSDUCER (PT)
	DESCRIPTION
	ID or WORK NUMBER (if applicable)
	ACCESS
	TEMPORARY CONSTRUCTION ACCESS
	P-ACCESS
	PERMANENT ACCESS
	COMMENCEMENT / TERMINATION OF WORKS (COMMENCEMENT = OPEN, TERMINATION = CLOSED)

Contains Ordnance Survey data © Crown copyright and database rights 2019.  
© Crown copyright and database rights 2019 OS Licence Number AL100005237.



Rev	Rev. Date	Purpose of revision	Drawn	Checked	Rev'd	Appr'd
C02	19/06/19	SHEETS 36 AND 109 REVISED FOLLOWING SSI ADVICE	SH	JA	ND	PH
C03	09/09/19	SHEETS 10, 11 AND 54 REVISED TO WITHDRAW A2b SUB-OPTION	BT	JA	ND	NJ

**JACOBS**  
1180 Eskdale Road, Wokingham, Wokingham, RG41 5TU  
Tel:+44(0)118 946 7000 Fax:+44(0)118 946 7001  
www.jacobs.com

Client: Esso Petroleum Company, Limited  
Emryn House,  
Emryn Way,  
Leatherhead,  
Surrey,  
KT22 8UX

Project: Southampton to London Pipeline Project

Drawing title: **WORKS PLAN SHEET 43 REGULATION 5 (2)(J)**


Drawing status: **Fit for Stage Approval**

Scale	1:2500	DO NOT SCALE
Jacobs No.	B2325300	Rev
Client no.		<b>C03</b>

Drawing number: **B2325300-JAC-000-CIV-DRG-000053**

© Copyright 2019 Jacobs U.K. Limited. The concepts and information contained in this document are the property of Jacobs. Use or copying of this document in whole or in part without the written permission of Jacobs constitutes an infringement of copyright. Limitation. This drawing has been prepared on behalf of, and for the exclusive use of, the Client, and is subject to, and issued in accordance with, the provisions of the contract between Jacobs and the Client. Jacobs accepts no liability or responsibility whatsoever for, or in respect of, any use of, or reliance upon, this drawing by any third party.

C:\pwworking\jacobs\_uk\_water\utilities\_ssf\by\ordms33519B2325300-JAC-000-CIV-DRG-000053.dwg - 10/09/2019 12:11:45 - A1Frame - BTaylor

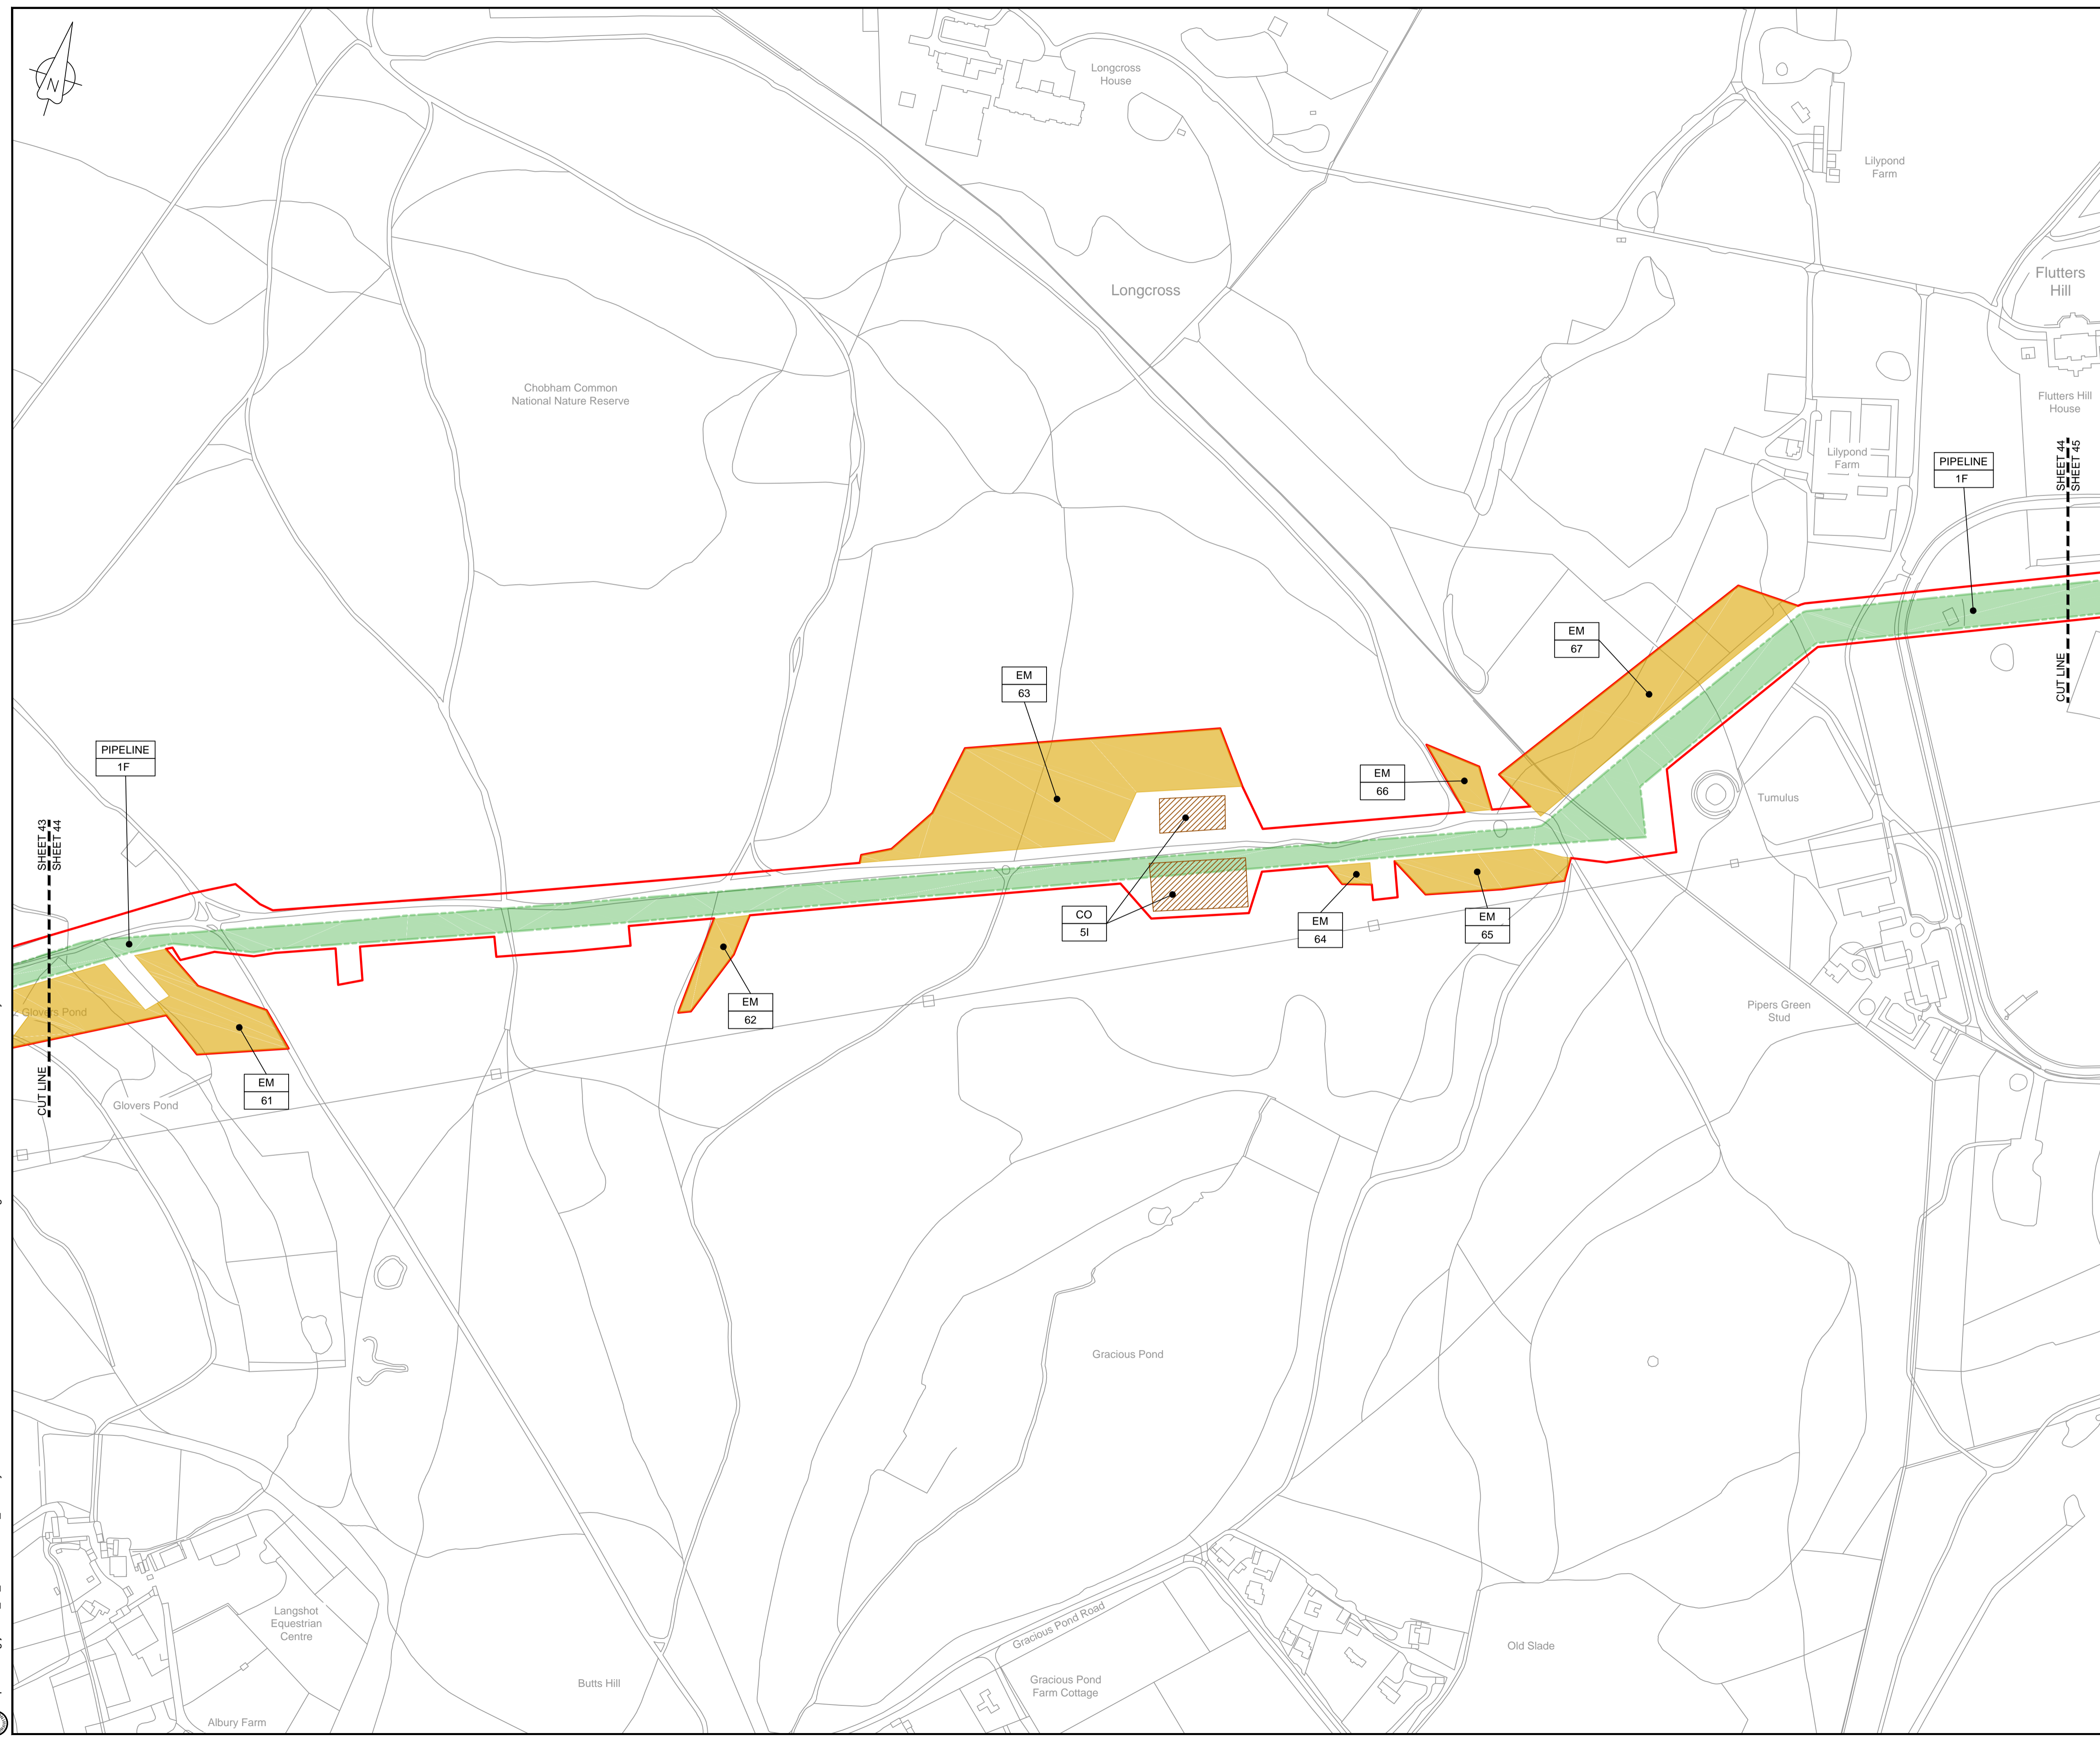

LOCATION PLAN  
SCALE 1:500,000

NOTES  
1. THIS DRAWING IS IN METRES UNLESS STATED OTHERWISE.

- LEGEND**
- ORDER LIMITS
  - LIMITS OF DEVIATION
  - COMPOUND (CO)
  - ENVIRONMENTAL MITIGATION AREA (EM)
  - ABOVE GROUND INSTALLATION (AGI) / VALVE (VA) / PRESSURE TRANSDUCER (PT)
  - DESCRIPTION
  - ID or WORK NUMBER (if applicable)
  - ACCESS TEMPORARY CONSTRUCTION ACCESS
  - P-ACCESS PERMANENT ACCESS
  - COMMENCEMENT / TERMINATION OF WORKS (COMMENCEMENT = OPEN, TERMINATION = CLOSED)

Contains Ordnance Survey data © Crown copyright and database rights 2019.  
© Crown copyright and database rights 2019 OS Licence Number AL10005237.



Rev	Rev. Date	Purpose of revision	Drawn	Checked	Rev'd	Appr'd
C02	19/06/19	SHEETS 36 AND 109 REVISED FOLLOWING SSI ADVICE	SH	JA	ND	PH
C03	09/09/19	SHEETS 10, 11 AND 54 REVISED TO WITHDRAW A2b SUB-OPTION	BT	JA	ND	NJ



1180 Eskdale Road, Winnersh, Wokingham, RG41 5TU  
Tel: +44(0)118 946 7000 Fax: +44(0)118 946 7001  
www.jacobs.com

Client: Esso Petroleum Company, Limited  
Emryn House,  
Emryn Way,  
Leatherhead,  
Surrey,  
KT22 8UX



Drawing title  
**WORKS PLAN  
SHEET 44  
REGULATION 5 (2)(J)**


Drawing status  
**Fit for Stage Approval**

Scale	1:2500	DO NOT SCALE
Jacobs No.	B2325300	Rev
Client no.		<b>C03</b>

Drawing number  
**B2325300-JAC-000-CIV-DRG-000054**

© Copyright 2019 Jacobs U.K. Limited. The concepts and information contained in this document are the property of Jacobs. Use or copying of this document in whole or in part without the written permission of Jacobs constitutes an infringement of copyright. Limitation: This drawing has been prepared on behalf of, and for the exclusive use of, the Client, and is subject to, and issued in accordance with, the provisions of the contract between Jacobs and the Client. Jacobs accepts no liability or responsibility whatsoever for, or in respect of, any use of, or reliance upon, this drawing by any third party.

C:\pwworking\jacobs\_uk\_water\utilities\_ssf\london\dms33519\B2325300-JAC-000-CIV-DRG-000054.dwg - 10/09/2019 12:13:58 - A1Frame - BTaylor

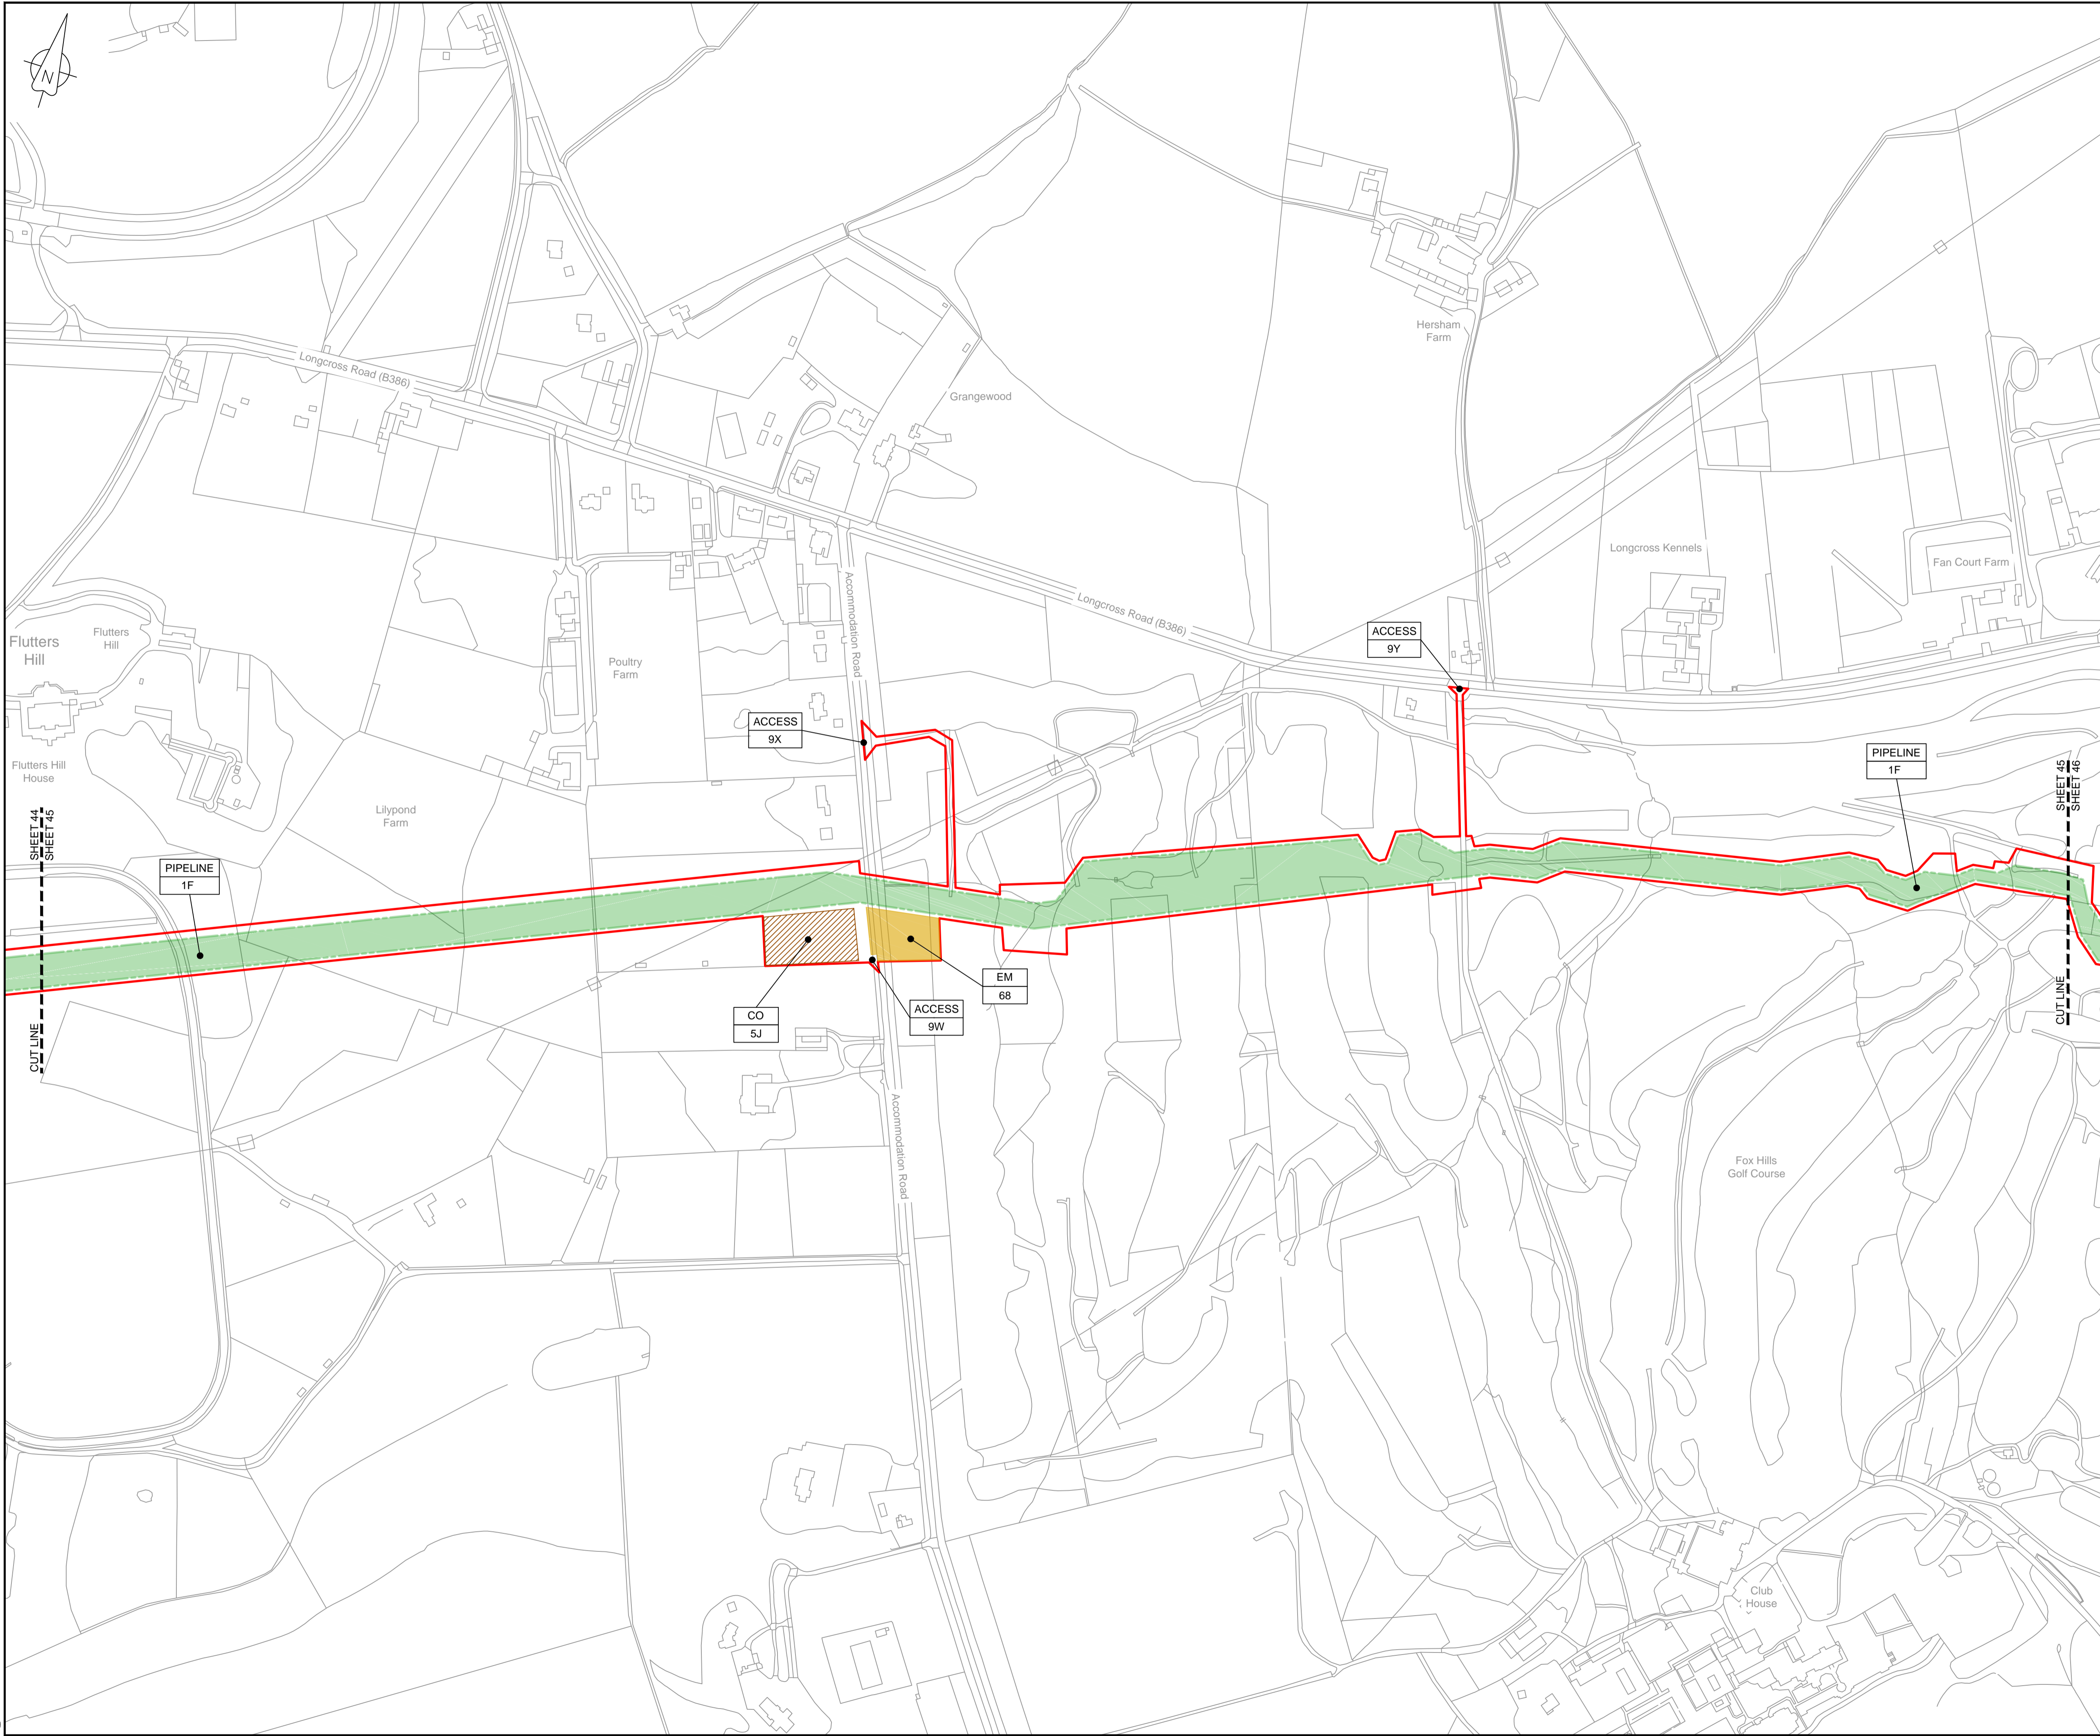


**LOCATION PLAN**  
SCALE 1:500,000

**NOTES**  
1. THIS DRAWING IS IN METRES UNLESS STATED OTHERWISE.

**LEGEND**

	ORDER LIMITS
	LIMITS OF DEVIATION
	COMPOUND (CO)
	ENVIRONMENTAL MITIGATION AREA (EM)
	ABOVE GROUND INSTALLATION (AGI) / VALVE (VA) / PRESSURE TRANSDUCER (PT)
	DESCRIPTION
	ID or WORK NUMBER (if applicable)
	ACCESS
	TEMPORARY CONSTRUCTION ACCESS
	P-ACCESS
	PERMANENT ACCESS
	COMMENCEMENT / TERMINATION OF WORKS (COMMENCEMENT = OPEN, TERMINATION = CLOSED)

Contains Ordnance Survey data © Crown copyright and database rights 2019.  
© Crown copyright and database rights 2019 OS Licence Number AL10005237.

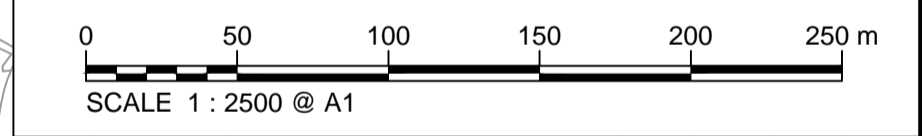

C02	19/06/19	SHEETS 36 AND 108 REVISED FOLLOWING SSI ADVICE	SH	JA	ND	PH
C03	09/09/19	SHEETS 10, 11 AND 54 REVISED TO WITHDRAW A2b SUB-OPTION	BT	JA	ND	NJ
Rev	Rev. Date	Purpose of revision	Drawn	Checked	Rev'd	Appr'd

**JACOBS**  
1180 Eskdale Road, Winnersh, Wokingham, RG41 5TU  
Tel: +44(0)118 946 7000 Fax: +44(0)118 946 7001  
www.jacobs.com

Client: Esso Petroleum Company, Limited  
Emryn House,  
Emryn Way,  
Leatherhead,  
Surrey,  
KT22 8UX

Project: Southampton to London Pipeline Project


Drawing title: **WORKS PLAN SHEET 45 REGULATION 5 (2)(J)**

Drawing status: **Fit for Stage Approval**

Scale	1:2500	DO NOT SCALE
Jacobs No.	B2325300	Rev
Client no.		<b>C03</b>

Drawing number: **B2325300-JAC-000-CIV-DRG-000055**

© Copyright 2019 Jacobs U.K. Limited. The concepts and information contained in this document are the property of Jacobs. Use or copying of this document in whole or in part without the written permission of Jacobs constitutes an infringement of copyright. Limitation: This drawing has been prepared on behalf of, and for the exclusive use of, the Client, and is subject to, and issued in accordance with, the provisions of the contract between Jacobs and the Client. Jacobs accepts no liability or responsibility whatsoever for, or in respect of, any use of, or reliance upon, this drawing by any third party.

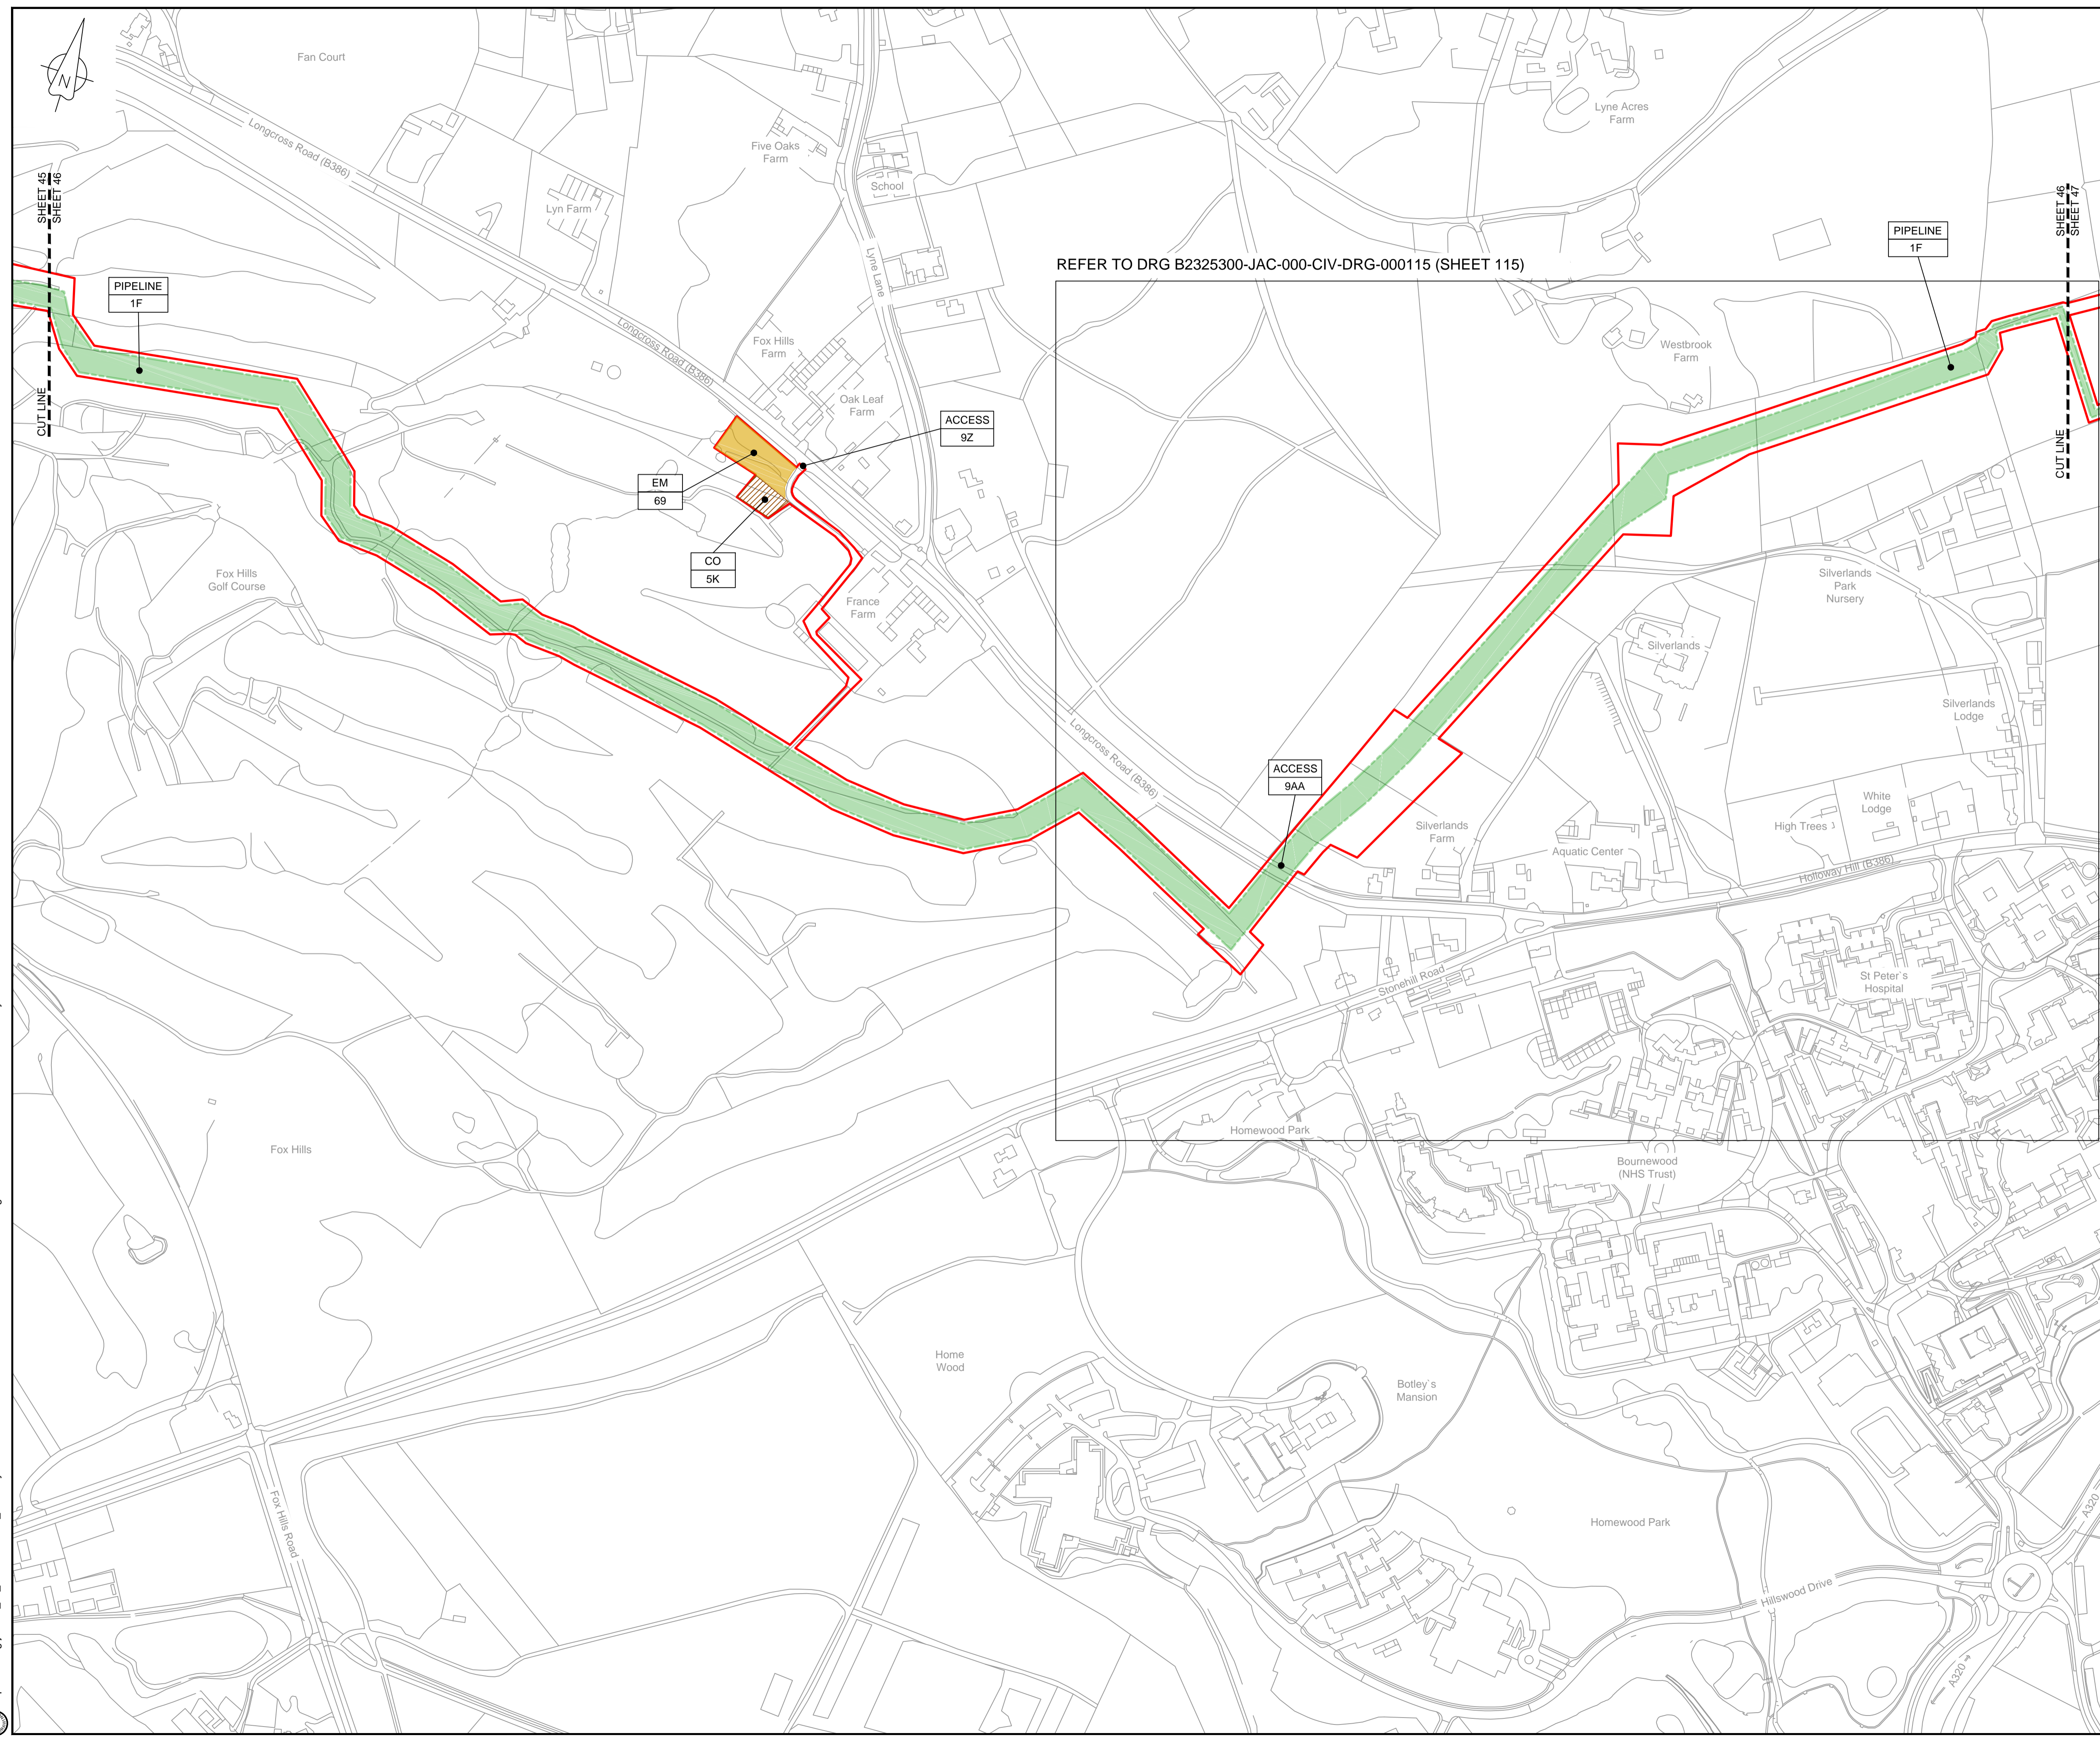

**LOCATION PLAN**  
SCALE 1:500,000

**NOTES**  
1. THIS DRAWING IS IN METRES UNLESS STATED OTHERWISE.

**LEGEND**

	ORDER LIMITS
	LIMITS OF DEVIATION
	COMPOUND (CO)
	ENVIRONMENTAL MITIGATION AREA (EM)
	ABOVE GROUND INSTALLATION (AGI) / VALVE (VA) / PRESSURE TRANSDUCER (PT)
	DESCRIPTION
	ID or WORK NUMBER (if applicable)
	ACCESS
	TEMPORARY CONSTRUCTION ACCESS
	P-ACCESS
	PERMANENT ACCESS
	COMMENCEMENT / TERMINATION OF WORKS (COMMENCEMENT = OPEN, TERMINATION = CLOSED)

Contains Ordnance Survey data © Crown copyright and database rights 2019.  
© Crown copyright and database rights 2019 OS Licence Number AL10005237.



Rev	Rev. Date	Purpose of revision	Drawn	Checked	Rev'd	Appr'd
C02	19/06/19	SHEETS 35 AND 109 REVISED FOLLOWING SSI ADVICE	SH	JA	ND	PH
C03	09/09/19	SHEETS 10, 11 AND 54 REVISED TO WITHDRAW A2b SUB-OPTION	BT	JA	ND	NJ

**JACOBS**  
1180 Skidale Road, Wokingham, Wokingham, RG41 5TU  
Tel: +44(0)118 946 7000 Fax: +44(0)118 946 7001  
www.jacobs.com

Client: Esso Petroleum Company, Limited  
Emryn House,  
Emryn Way,  
Leatherhead,  
Surrey,  
KT22 8UX

Project: Southampton to London Pipeline Project

Drawing title: **WORKS PLAN SHEET 46 REGULATION 5 (2)(J)**


Drawing status: **Fit for Stage Approval**

Scale	1:2500	DO NOT SCALE
Jacobs No.	B2325300	Rev
Client no.		<b>C03</b>

Drawing number: **B2325300-JAC-000-CIV-DRG-000056**

© Copyright 2019 Jacobs U.K. Limited. The concepts and information contained in this document are the property of Jacobs. Use or copying of this document in whole or in part without the written permission of Jacobs constitutes an infringement of copyright. Limitation: This drawing has been prepared on behalf of, and for the exclusive use of, the Client, and is subject to, and issued in accordance with, the provisions of the contract between Jacobs and the Client. Jacobs accepts no liability or responsibility whatsoever for, or in respect of, any use of, or reliance upon, this drawing by any third party.

C:\pwworking\jacobs\_uk\_water\utilities\_ssf\lby\ordms3351\B2325300-JAC-000-CIV-DRG-000056.dwg - 10/09/2019 13:16:42 - A1Frame - BTaylor

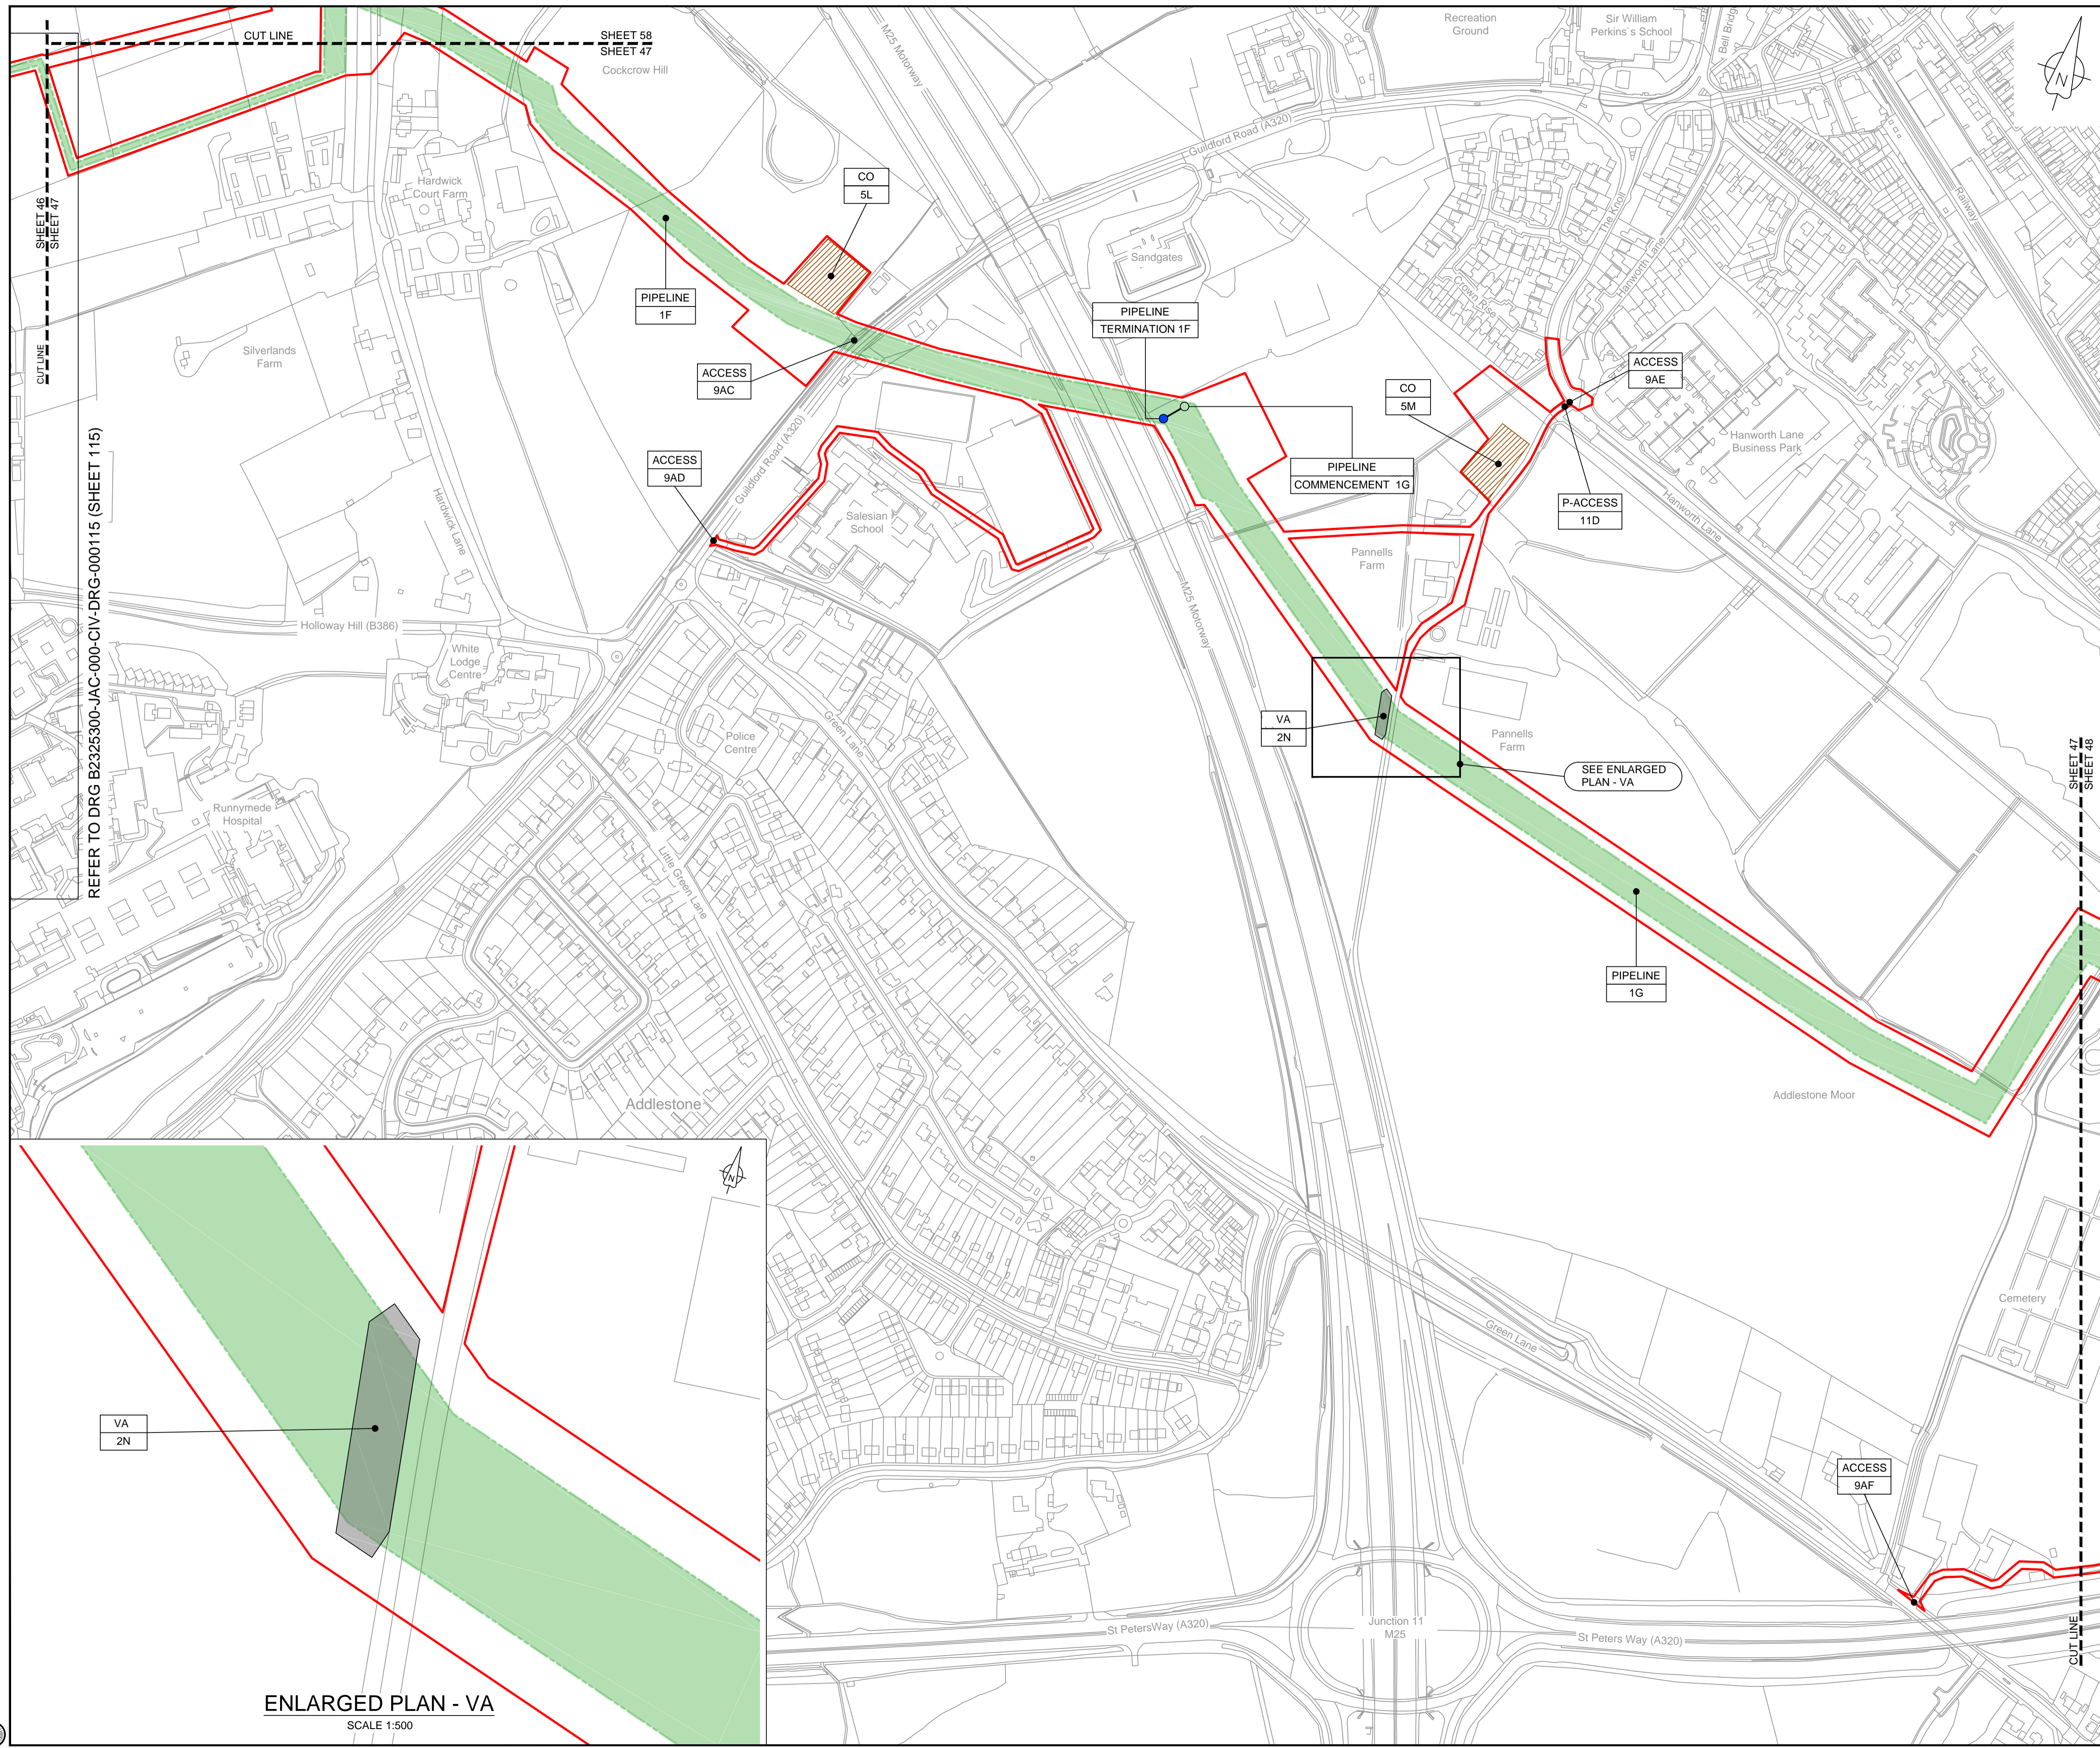


**LOCATION PLAN**  
SCALE 1:500,000

**NOTES**  
1. THIS DRAWING IS IN METRES UNLESS STATED OTHERWISE.

**LEGEND**

	ORDER LIMITS
	LIMITS OF DEVIATION
	COMPOUND (CO)
	ENVIRONMENTAL MITIGATION AREA (EM)
	ABOVE GROUND INSTALLATION (AGI) / VALVE (VA) / PRESSURE TRANSDUCER (PT)
	DESCRIPTION ID or WORK NUMBER (if applicable)
	ACCESS TEMPORARY CONSTRUCTION ACCESS
	P-ACCESS PERMANENT ACCESS
	COMMENCEMENT / TERMINATION OF WORKS (COMMENCEMENT = OPEN, TERMINATION = CLOSED)

Contains Ordnance Survey data © Crown copyright and database rights 2019.  
© Crown copyright and database rights 2019 OS Licence Number AL100005237.

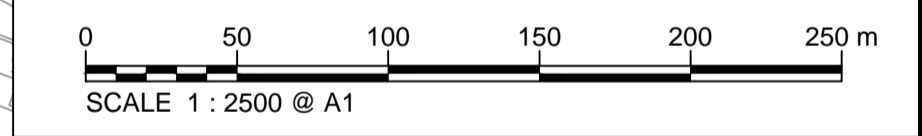

C02	19/06/19	SHEETS 36 AND 108 REVISED FOLLOWING SSI ADVICE	SH	JA	ND	PH
C03	09/09/19	SHEETS 10, 11 AND 54 REVISED TO WITHDRAW A2b SUB-OPTION	BT	JA	ND	NJ
Rev	Rev. Date	Purpose of revision	Drawn	Checked	Rev'd	Appr'd

**JACOBS**  
1180 Eskdale Road, Winnersh, Wokingham, RG41 5TU  
Tel: +44(0)118 946 7000 Fax: +44(0)118 946 7001  
www.jacobs.com

Client: Esso Petroleum Company, Limited  
Emryn House,  
Emryn Way,  
Leatherhead,  
Surrey,  
KT22 8UX

Project: Southampton to London Pipeline Project

Drawing title: **WORKS PLAN SHEET 47 REGULATION 5 (2)(J)**

Drawing status: **Fit for Stage Approval**


Scale	1:2500	DO NOT SCALE
Jacobs No.	B2325300	Rev
Client no.		<b>C03</b>

Drawing number: **B2325300-JAC-000-CIV-DRG-000057**


© Copyright 2019 Jacobs U.K. Limited. The concepts and information contained in this document are the property of Jacobs. Use or copying of this document in whole or in part without the written permission of Jacobs constitutes an infringement of copyright. Limitation: This drawing has been prepared on behalf of, and for the exclusive use of, the Client. Jacobs accepts no liability or responsibility whatsoever for, or in respect of, any use of, or reliance upon, this drawing by any third party.

C:\pwworking\jacobs\_uk\_water&utilities\_ssf\byondms33513\B2325300-JAC-000-CIV-DRG-000057.dwg - 10/09/2019 13:19:03 - A1Frame - BTaylor

REFER TO DRG B2325300-JAC-000-CIV-DRG-000115 (SHEET 115)

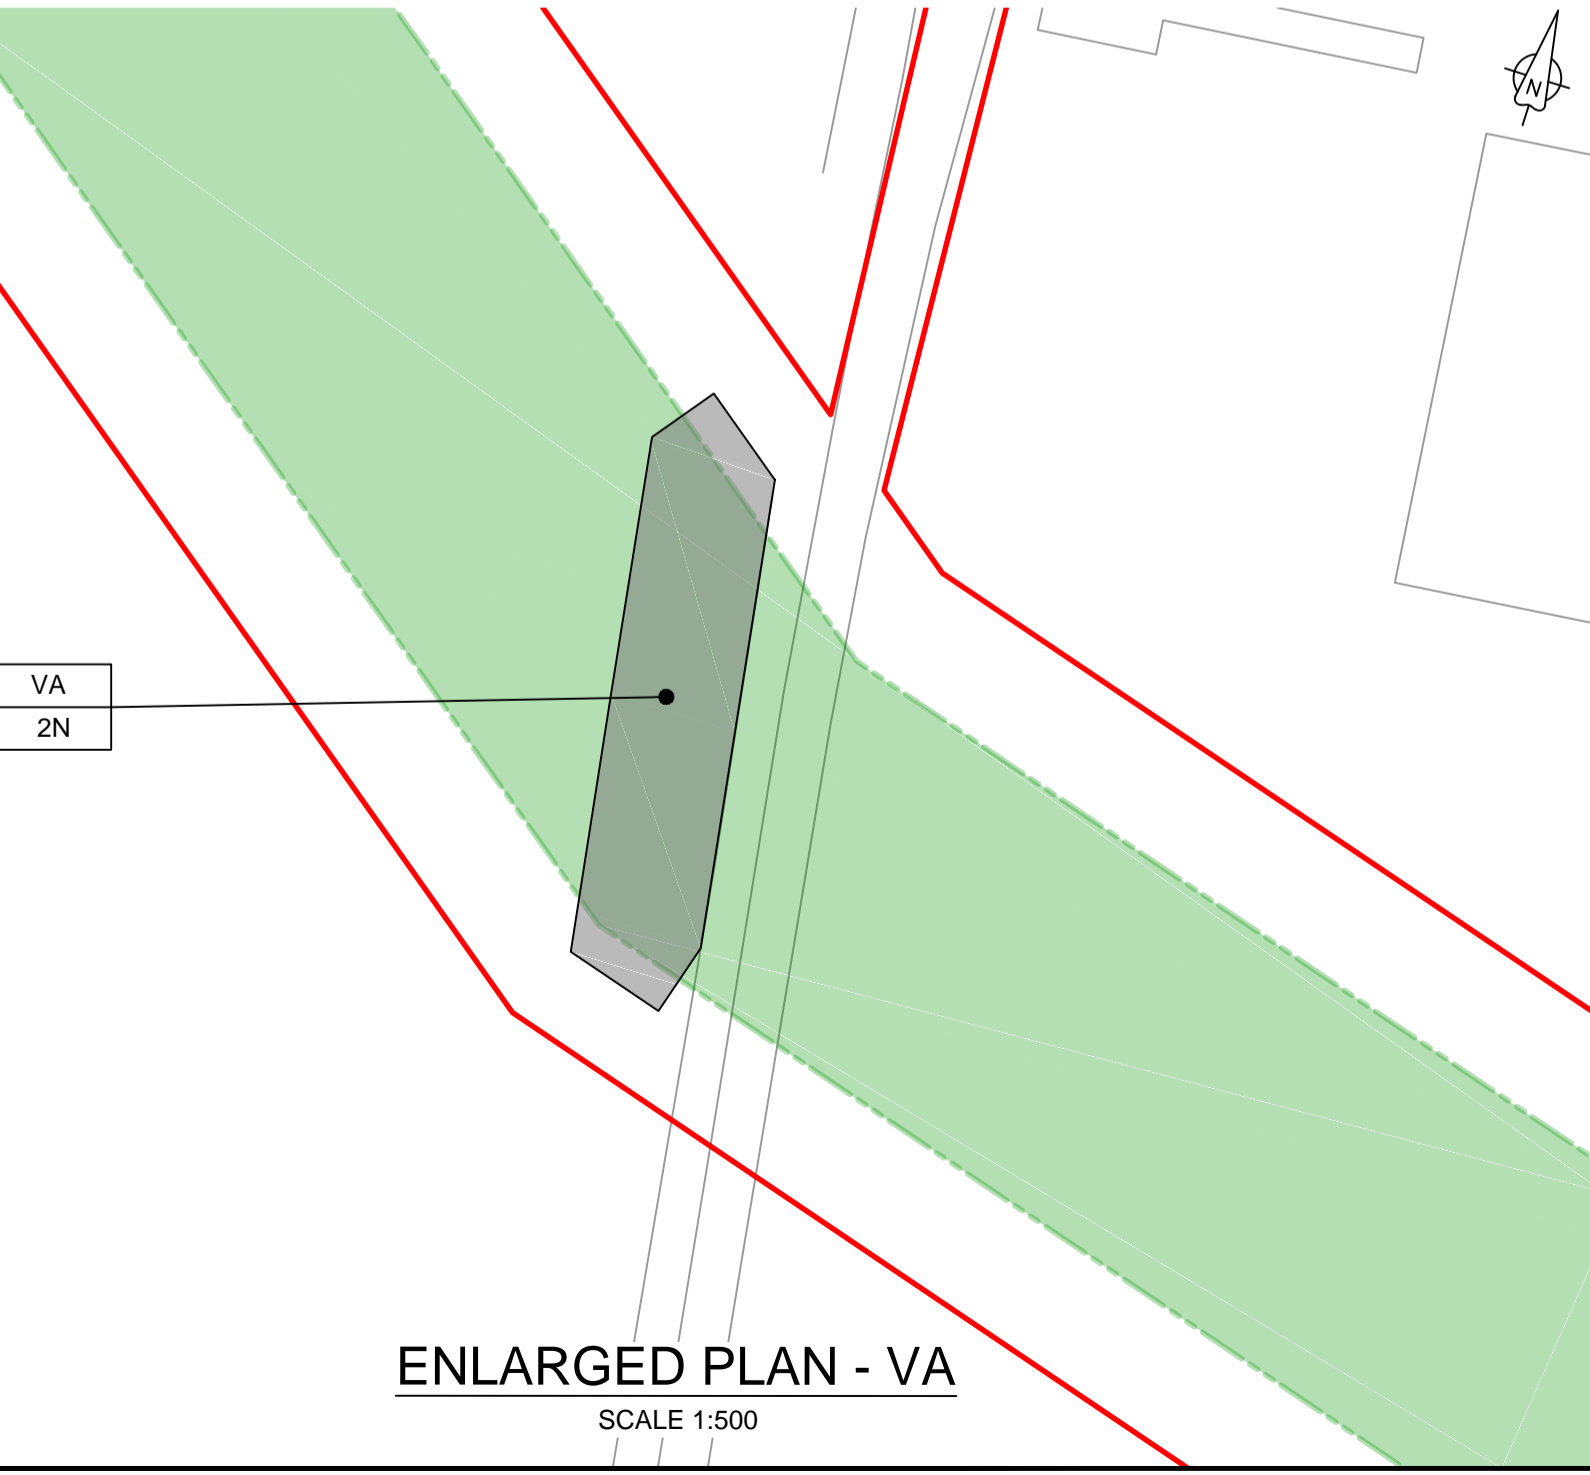

**ENLARGED PLAN - VA**  
SCALE 1:500

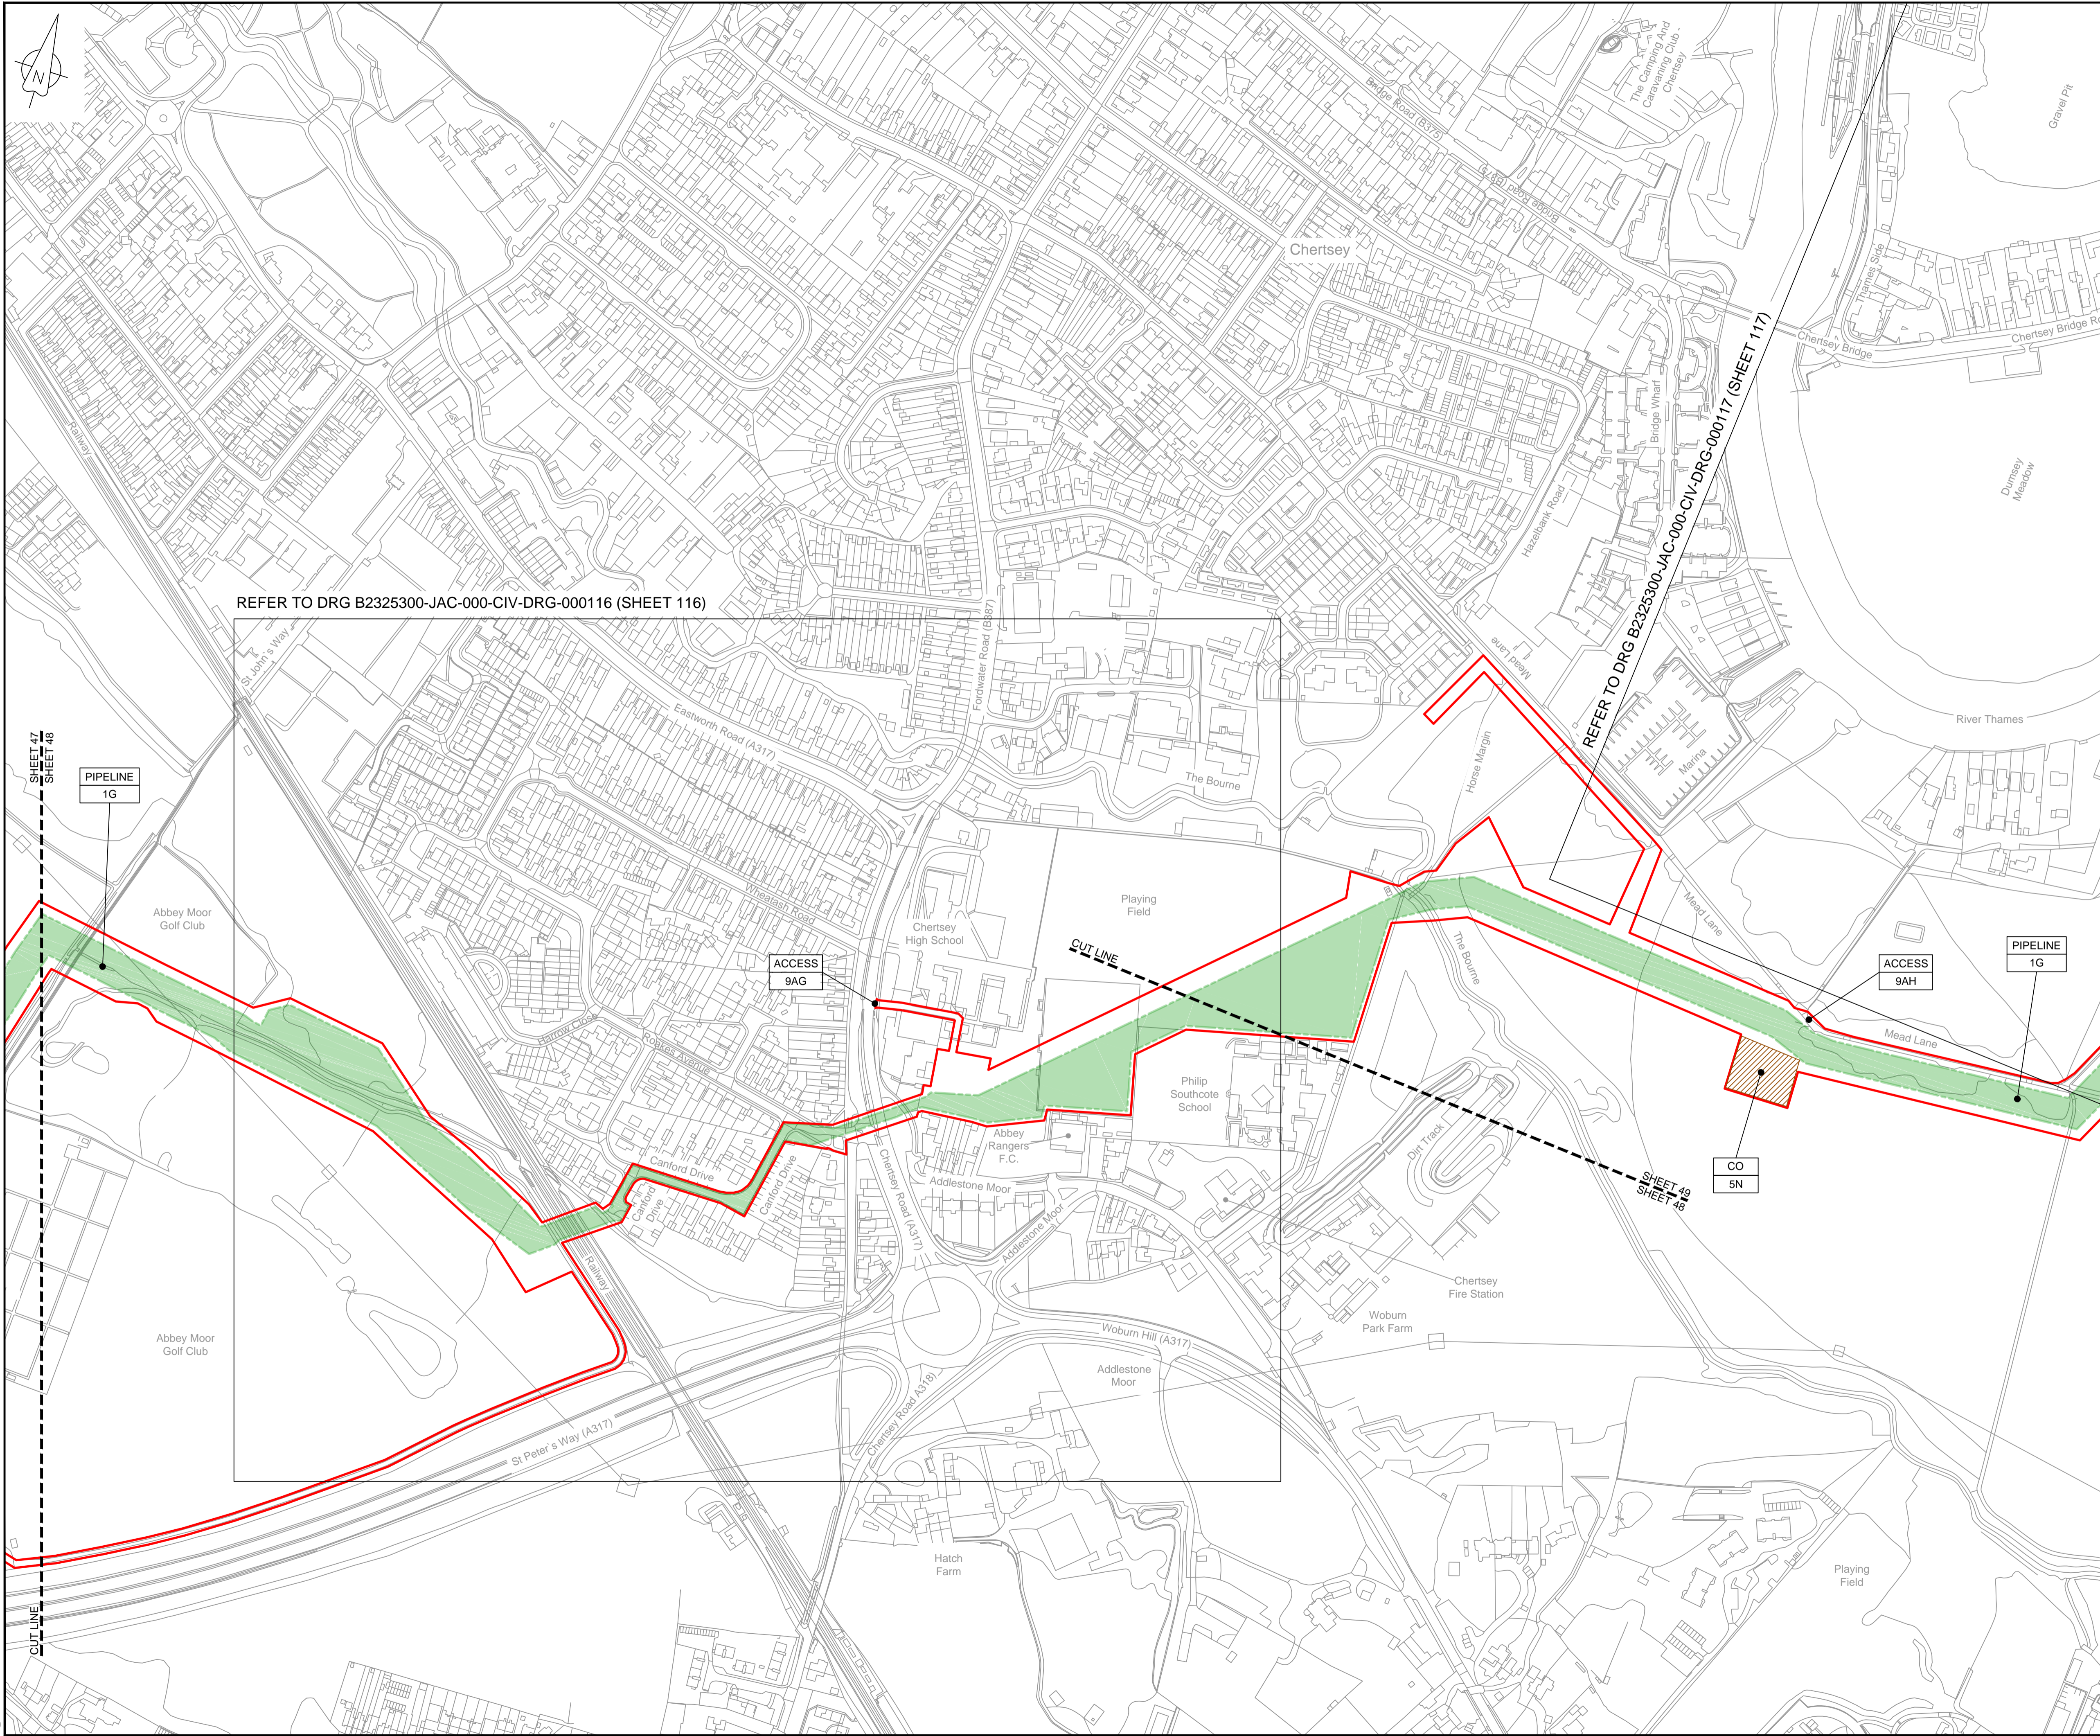

REFER TO DRG B2325300-JAC-000-CIV-DRG-000116 (SHEET 116)

REFER TO DRG B2325300-JAC-000-CIV-DRG-000117 (SHEET 117)




LOCATION PLAN  
SCALE 1:500,000

NOTES  
1. THIS DRAWING IS IN METRES UNLESS STATED OTHERWISE.

**LEGEND**

- ORDER LIMITS
- LIMITS OF DEVIATION
- COMPOUND (CO)
- ENVIRONMENTAL MITIGATION AREA (EM)
- ABOVE GROUND INSTALLATION (AGI) / VALVE (VA) / PRESSURE TRANSDUCER (PT)
- DESCRIPTION
- ID or WORK NUMBER (if applicable)
- ACCESS
- TEMPORARY CONSTRUCTION ACCESS
- P-ACCESS
- PERMANENT ACCESS
- COMMENCEMENT / TERMINATION OF WORKS (COMMENCEMENT = OPEN, TERMINATION = CLOSED)

Contains Ordnance Survey data © Crown copyright and database rights 2019.  
© Crown copyright and database rights 2019 OS Licence Number AL10005237.

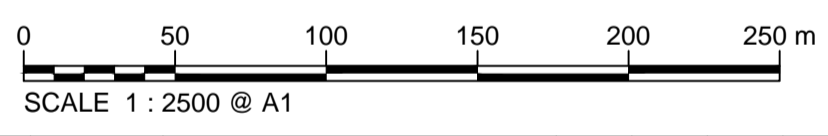

C02	19/06/19	SHEETS 36 AND 108 REVISED FOLLOWING SSI ADVICE	SH	JA	ND	PH
C03	09/09/19	SHEETS 10, 11 AND 54 REVISED TO WITHDRAW A2b SUB-OPTION	BT	JA	ND	NJ
Rev	Rev. Date	Purpose of revision	Drawn	Checked	Rev'd	Appr'd

**JACOBS**

1180 Eskdale Road, Winnersh, Wokingham, RG41 5TU  
Tel:+44(0)118 946 7000 Fax:+44(0)118 946 7001  
www.jacobs.com

Client: Esso Petroleum Company, Limited  
Ermyn House,  
Ermyn Way,  
Leatherhead,  
Surrey,  
KT22 8UX

Project: Southampton to London Pipeline Project

Drawing title: **WORKS PLAN  
SHEET 48  
REGULATION 5 (2)(J)**


Drawing status: **Fit for Stage Approval**

Scale	1:2500	DO NOT SCALE
Jacobs No.	B2325300	Rev
Client no.		<b>C03</b>

Drawing number: **B2325300-JAC-000-CIV-DRG-000058**

© Copyright 2019 Jacobs U.K. Limited. The concepts and information contained in this document are the property of Jacobs. Use or copying of this document in whole or in part without the written permission of Jacobs constitutes an infringement of copyright. Limitation: This drawing has been prepared on behalf of, and for the exclusive use of, Jacobs' Client, and is subject to, and issued in accordance with, the provisions of the contract between Jacobs and the Client. Jacobs accepts no liability or responsibility whatsoever for, or in respect of, any use of, or reliance upon, this drawing by any third party.

C:\pwworking\jacobs\_uk\_water\utilities\_ssf\byondms33519B2325300-JAC-000-CIV-DRG-000058.dwg - 10/09/2019 13:21:01 - A1Frame - BTaylor

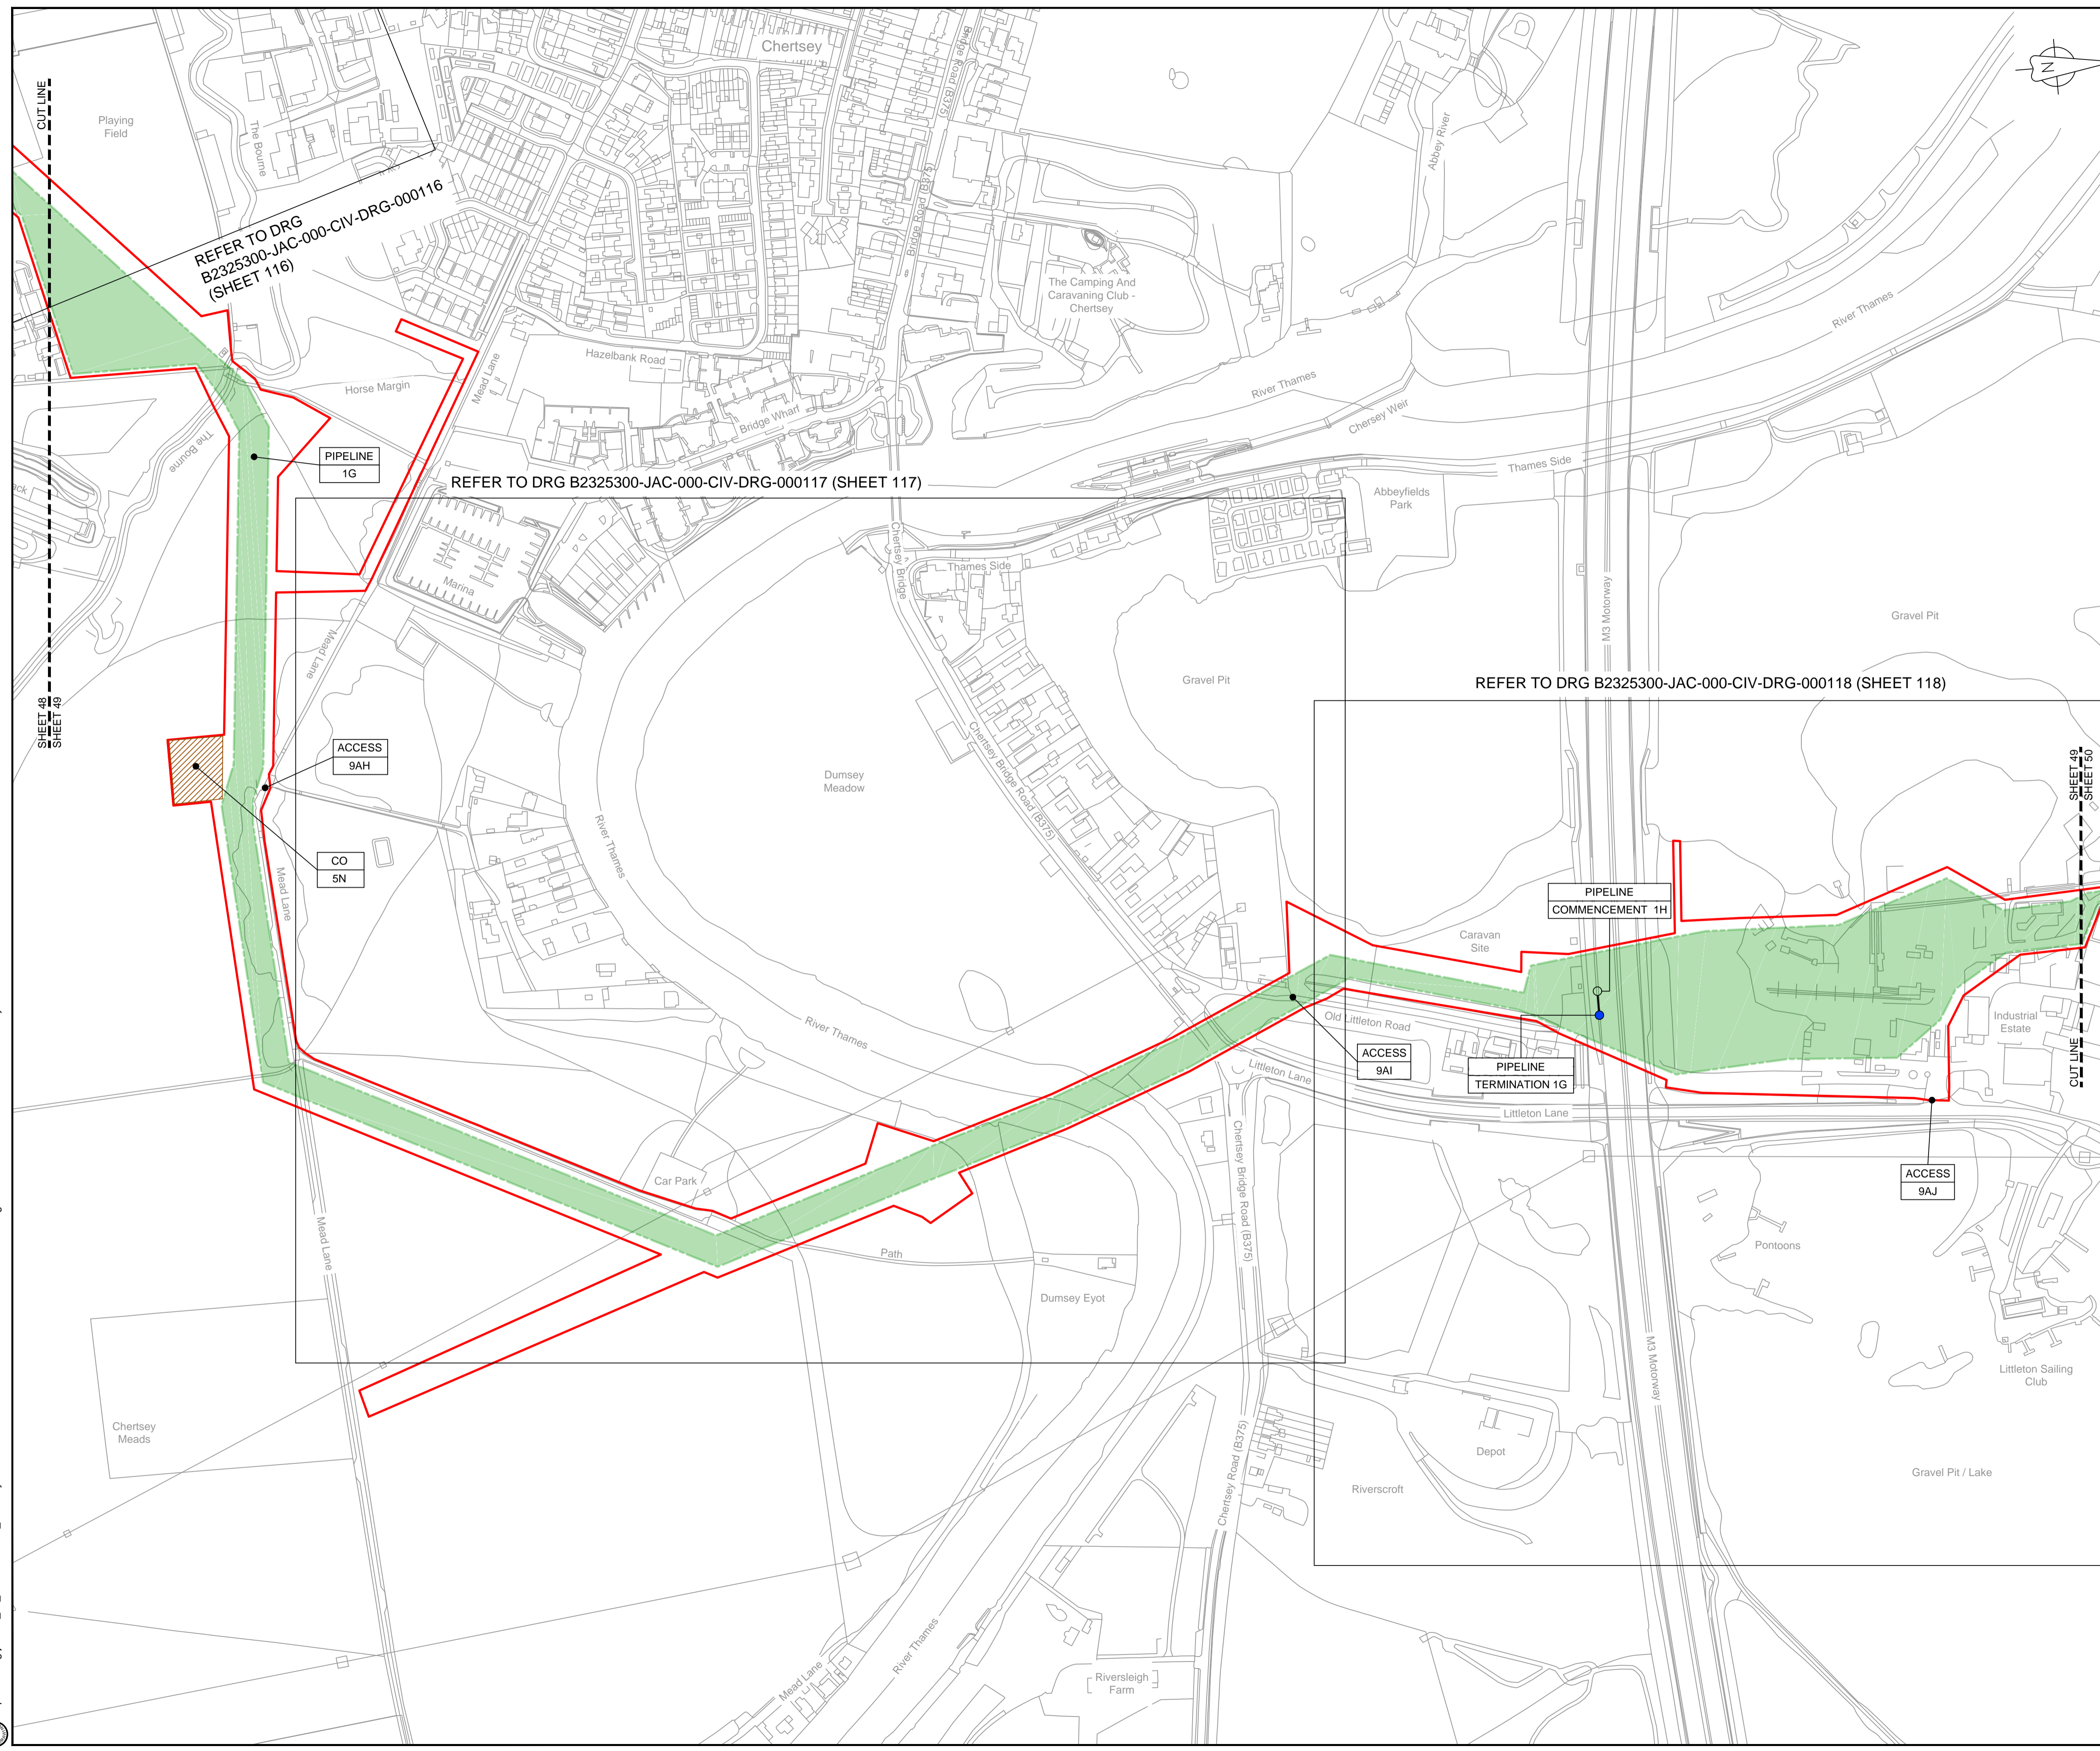

**LOCATION PLAN**  
SCALE 1:500,000

**NOTES**  
1. THIS DRAWING IS IN METRES UNLESS STATED OTHERWISE.

**LEGEND**

	ORDER LIMITS
	LIMITS OF DEVIATION
	COMPOUND (CO)
	ENVIRONMENTAL MITIGATION AREA (EM)
	ABOVE GROUND INSTALLATION (AGI) / VALVE (VA) / PRESSURE TRANSDUCER (PT)
	DESCRIPTION
	ID or WORK NUMBER (if applicable)
	ACCESS
	TEMPORARY CONSTRUCTION ACCESS
	P-ACCESS
	PERMANENT ACCESS
	COMMENCEMENT / TERMINATION OF WORKS (COMMENCEMENT = OPEN, TERMINATION = CLOSED)

Contains Ordnance Survey data © Crown copyright and database rights 2019.  
© Crown copyright and database rights 2019 OS Licence Number AL100005237.



Rev	Rev. Date	Purpose of revision	Drawn	Checked	Rev'd	Appr'd
C03	19/06/19	SHEETS 35 AND 109 REVISED FOLLOWING SSI ADVICE	SH	JA	ND	PH
C02	09/09/19	SHEETS 10, 11 AND 54 REVISED TO WITHDRAW A2b SUB-OPTION	BT	JA	ND	NJ

**JACOBS**  
1180 Eskdale Road, Winnersh, Wokingham, RG41 5TU  
Tel: +44(0)118 946 7000 Fax: +44(0)118 946 7001  
www.jacobs.com

Client: Esso Petroleum Company, Limited  
Emryn House,  
Emryn Way,  
Leatherhead,  
Surrey,  
KT22 8UX

**Esso** | Southampton to London Pipeline Project

Drawing title  
**WORKS PLAN  
SHEET 49  
REGULATION 5 (2)(J)**


Drawing status  
**Fit for Stage Approval**

Scale	1:2500	DO NOT SCALE
Jacobs No.	B2325300	Rev
Client no.		<b>C03</b>

Drawing number  
**B2325300-JAC-000-CIV-DRG-000059**

© Copyright 2019 Jacobs U.K. Limited. The concepts and information contained in this document are the property of Jacobs. Use or copying of this document in whole or in part without the written permission of Jacobs constitutes an infringement of copyright. Limitation. This drawing has been prepared on behalf of, and for the exclusive use of, Jacobs' Client, and is subject to, and issued in accordance with, the provisions of the contract between Jacobs and the Client. Jacobs accepts no liability or responsibility whatsoever for, or in respect of, any use of, or reliance upon, this drawing by any third party.



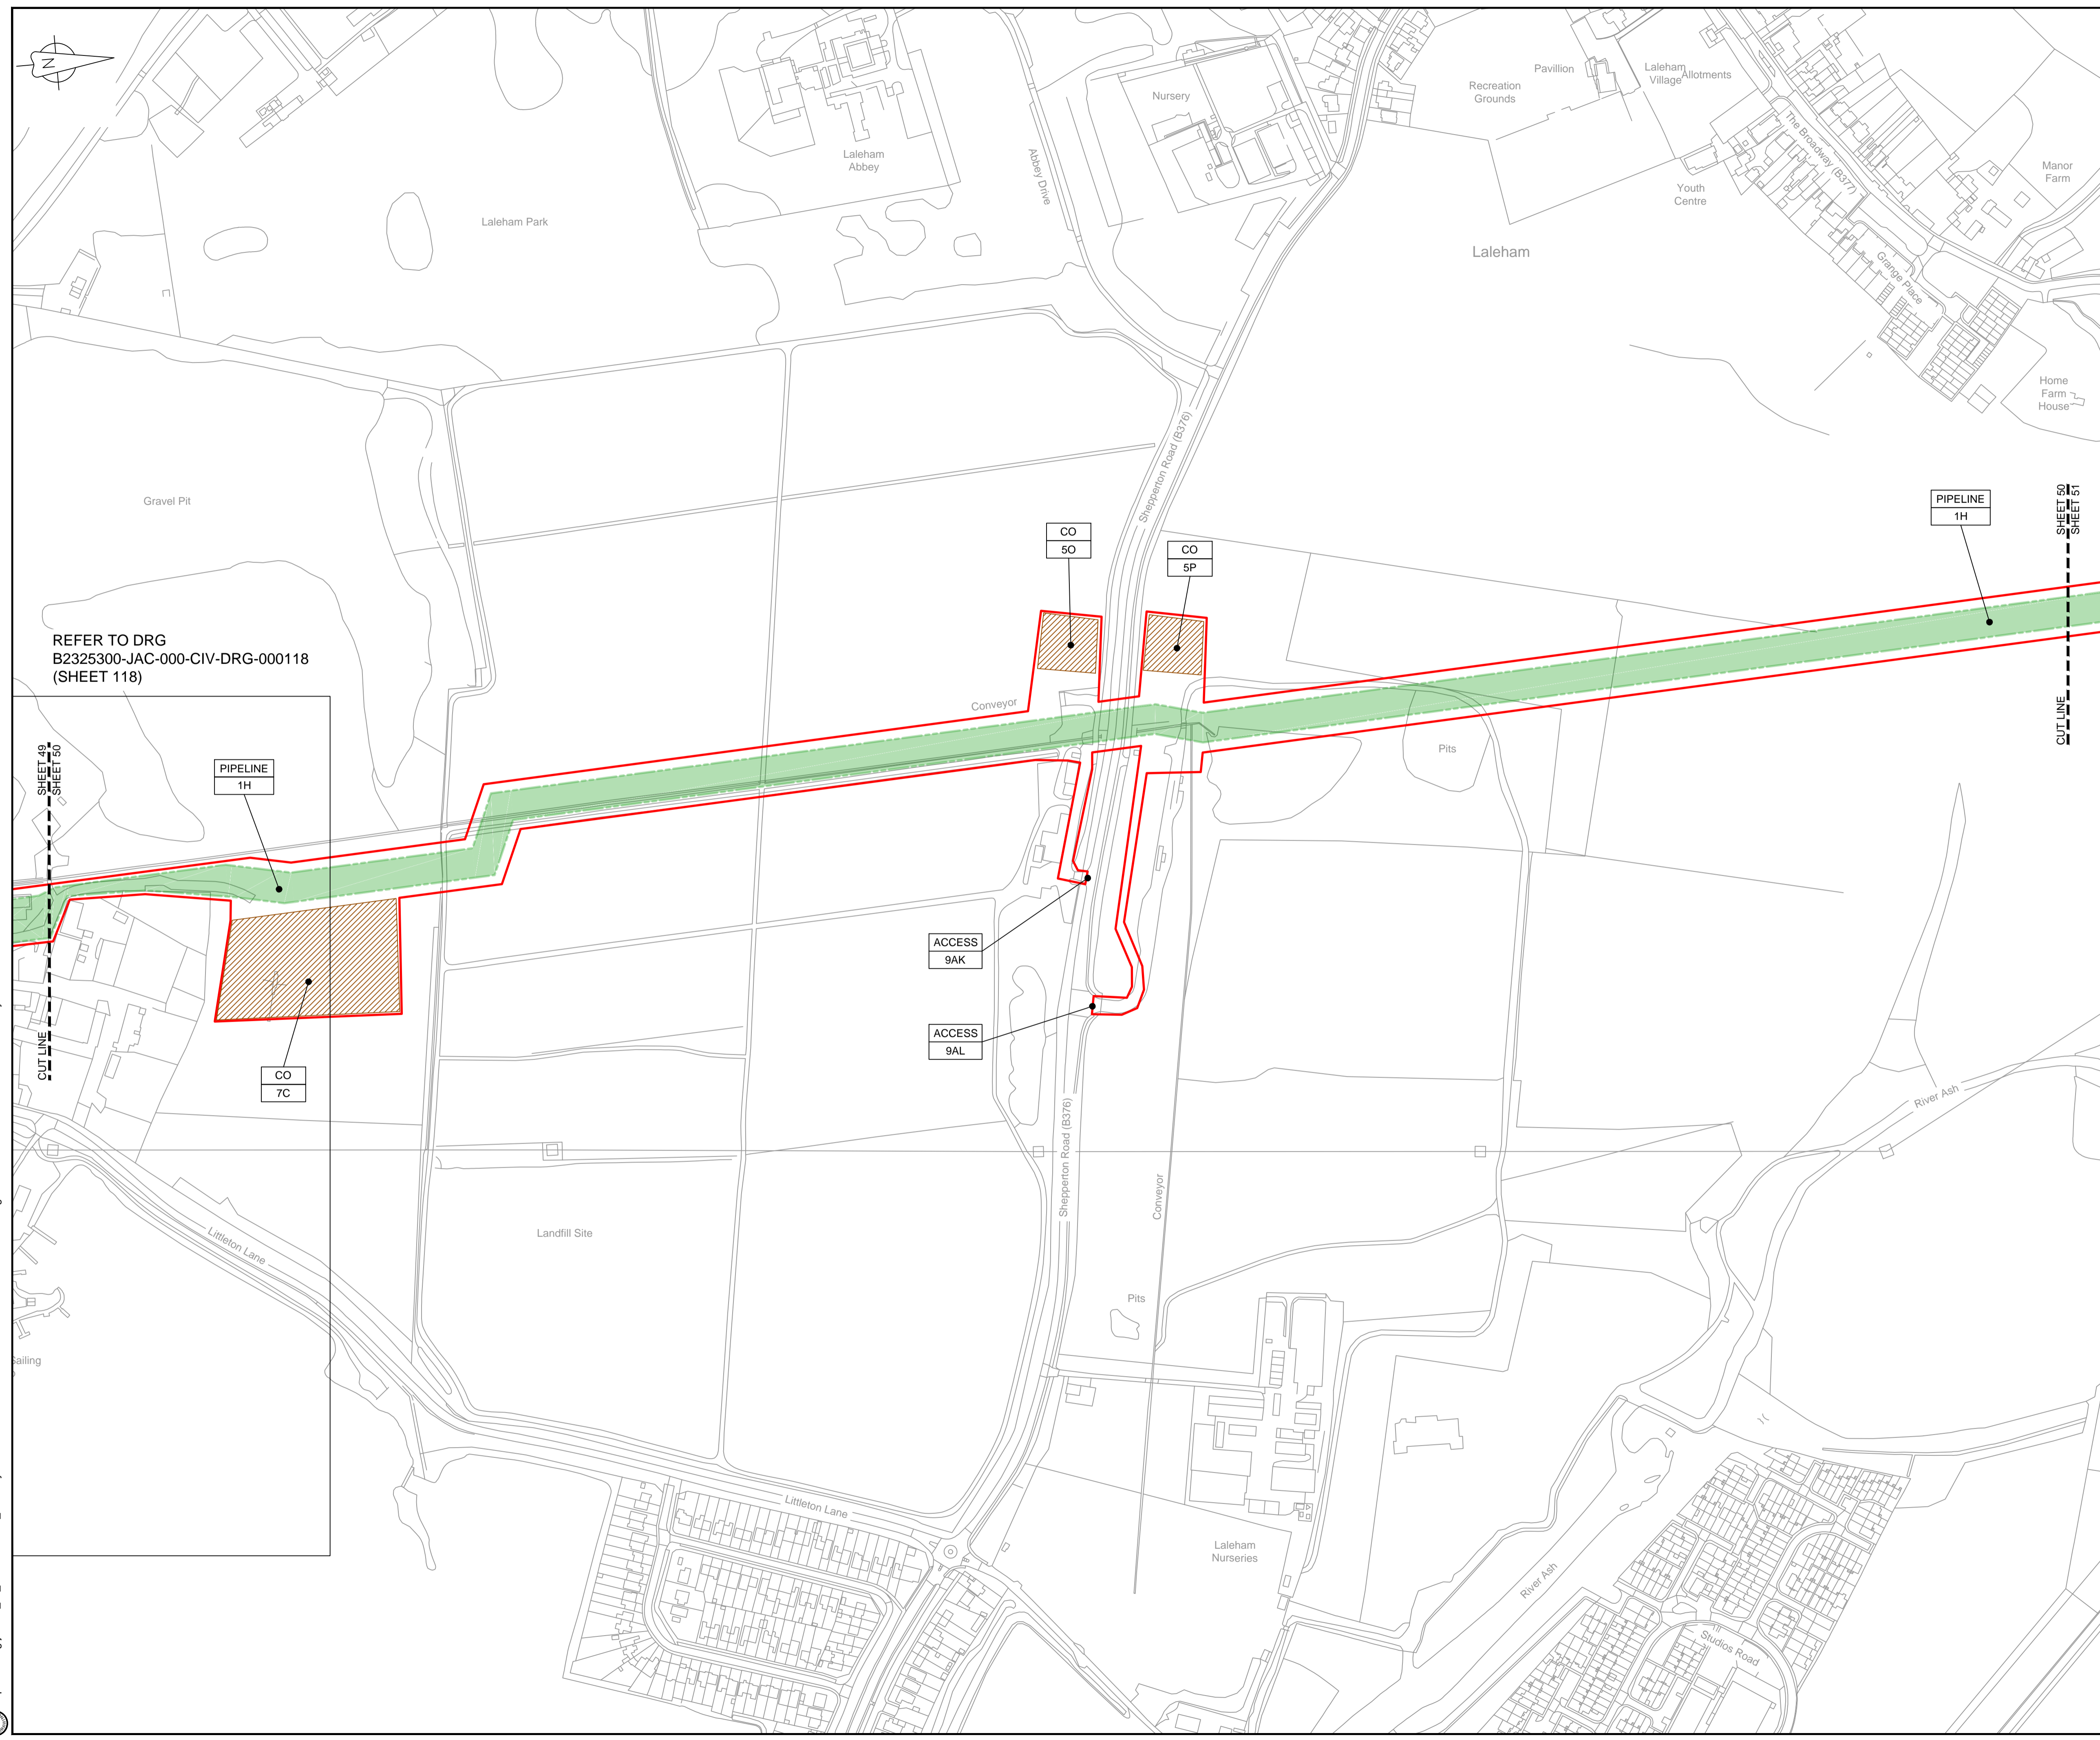


**LOCATION PLAN**  
SCALE 1:500,000

**NOTES**  
1. THIS DRAWING IS IN METRES UNLESS STATED OTHERWISE.

**LEGEND**

[Red line]	ORDER LIMITS
[Green shaded area]	LIMITS OF DEVIATION
[Hatched area]	COMPOUND (CO)
[Yellow shaded area]	ENVIRONMENTAL MITIGATION AREA (EM)
[Grey shaded area]	ABOVE GROUND INSTALLATION (AGI) / VALVE (VA) / PRESSURE TRANSDUCER (PT)
[Symbol]	DESCRIPTION
[Symbol]	ID or WORK NUMBER (if applicable)
[Symbol]	ACCESS
[Symbol]	TEMPORARY CONSTRUCTION ACCESS
[Symbol]	PERMANENT ACCESS
[Symbol]	COMMENCEMENT / TERMINATION OF WORKS (COMMENCEMENT = OPEN, TERMINATION = CLOSED)

Contains Ordnance Survey data © Crown copyright and database rights 2019.  
© Crown copyright and database rights 2019 OS Licence Number AL100005237.

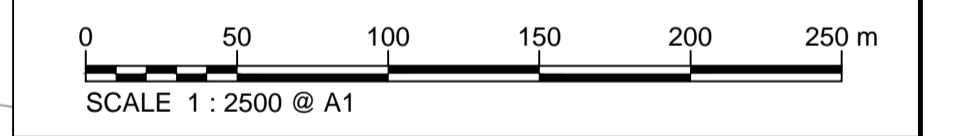

C02	19/06/19	SHEETS 36 AND 109 REVISED FOLLOWING SSI ADVICE	SH	JA	ND	PH
C03	09/09/19	SHEETS 10, 11 AND 54 REVISED TO WITHDRAW A2b SUB-OPTION	BT	JA	ND	NJ
Rev	Rev. Date	Purpose of revision	Drawn	Checked	Rev'd	Appr'd

**JACOBS**  
1180 Eskdale Road, Winnersh, Wokingham, RG41 5TU  
Tel: +44(0)118 946 7000 Fax: +44(0)118 946 7001  
www.jacobs.com

Client: Esso Petroleum Company, Limited  
Emryn House,  
Emryn Way,  
Leatherhead,  
Surrey,  
KT22 8UX

Project: Southampton to London Pipeline Project

Drawing title: **WORKS PLAN SHEET 50 REGULATION 5 (2)(J)**


Drawing status: **Fit for Stage Approval**

Scale: 1:2500 DO NOT SCALE

Jacobs No. B2325300 Rev C03

Drawing number: **B2325300-JAC-000-CIV-DRG-000060**

C:\pwworking\jacobs\_uk\_water\utilities\_ssf\london\dms33519\B2325300-JAC-000-CIV-DRG-000060.dwg - 10/09/2019 13:25:08 - A1Frame - BTaylor

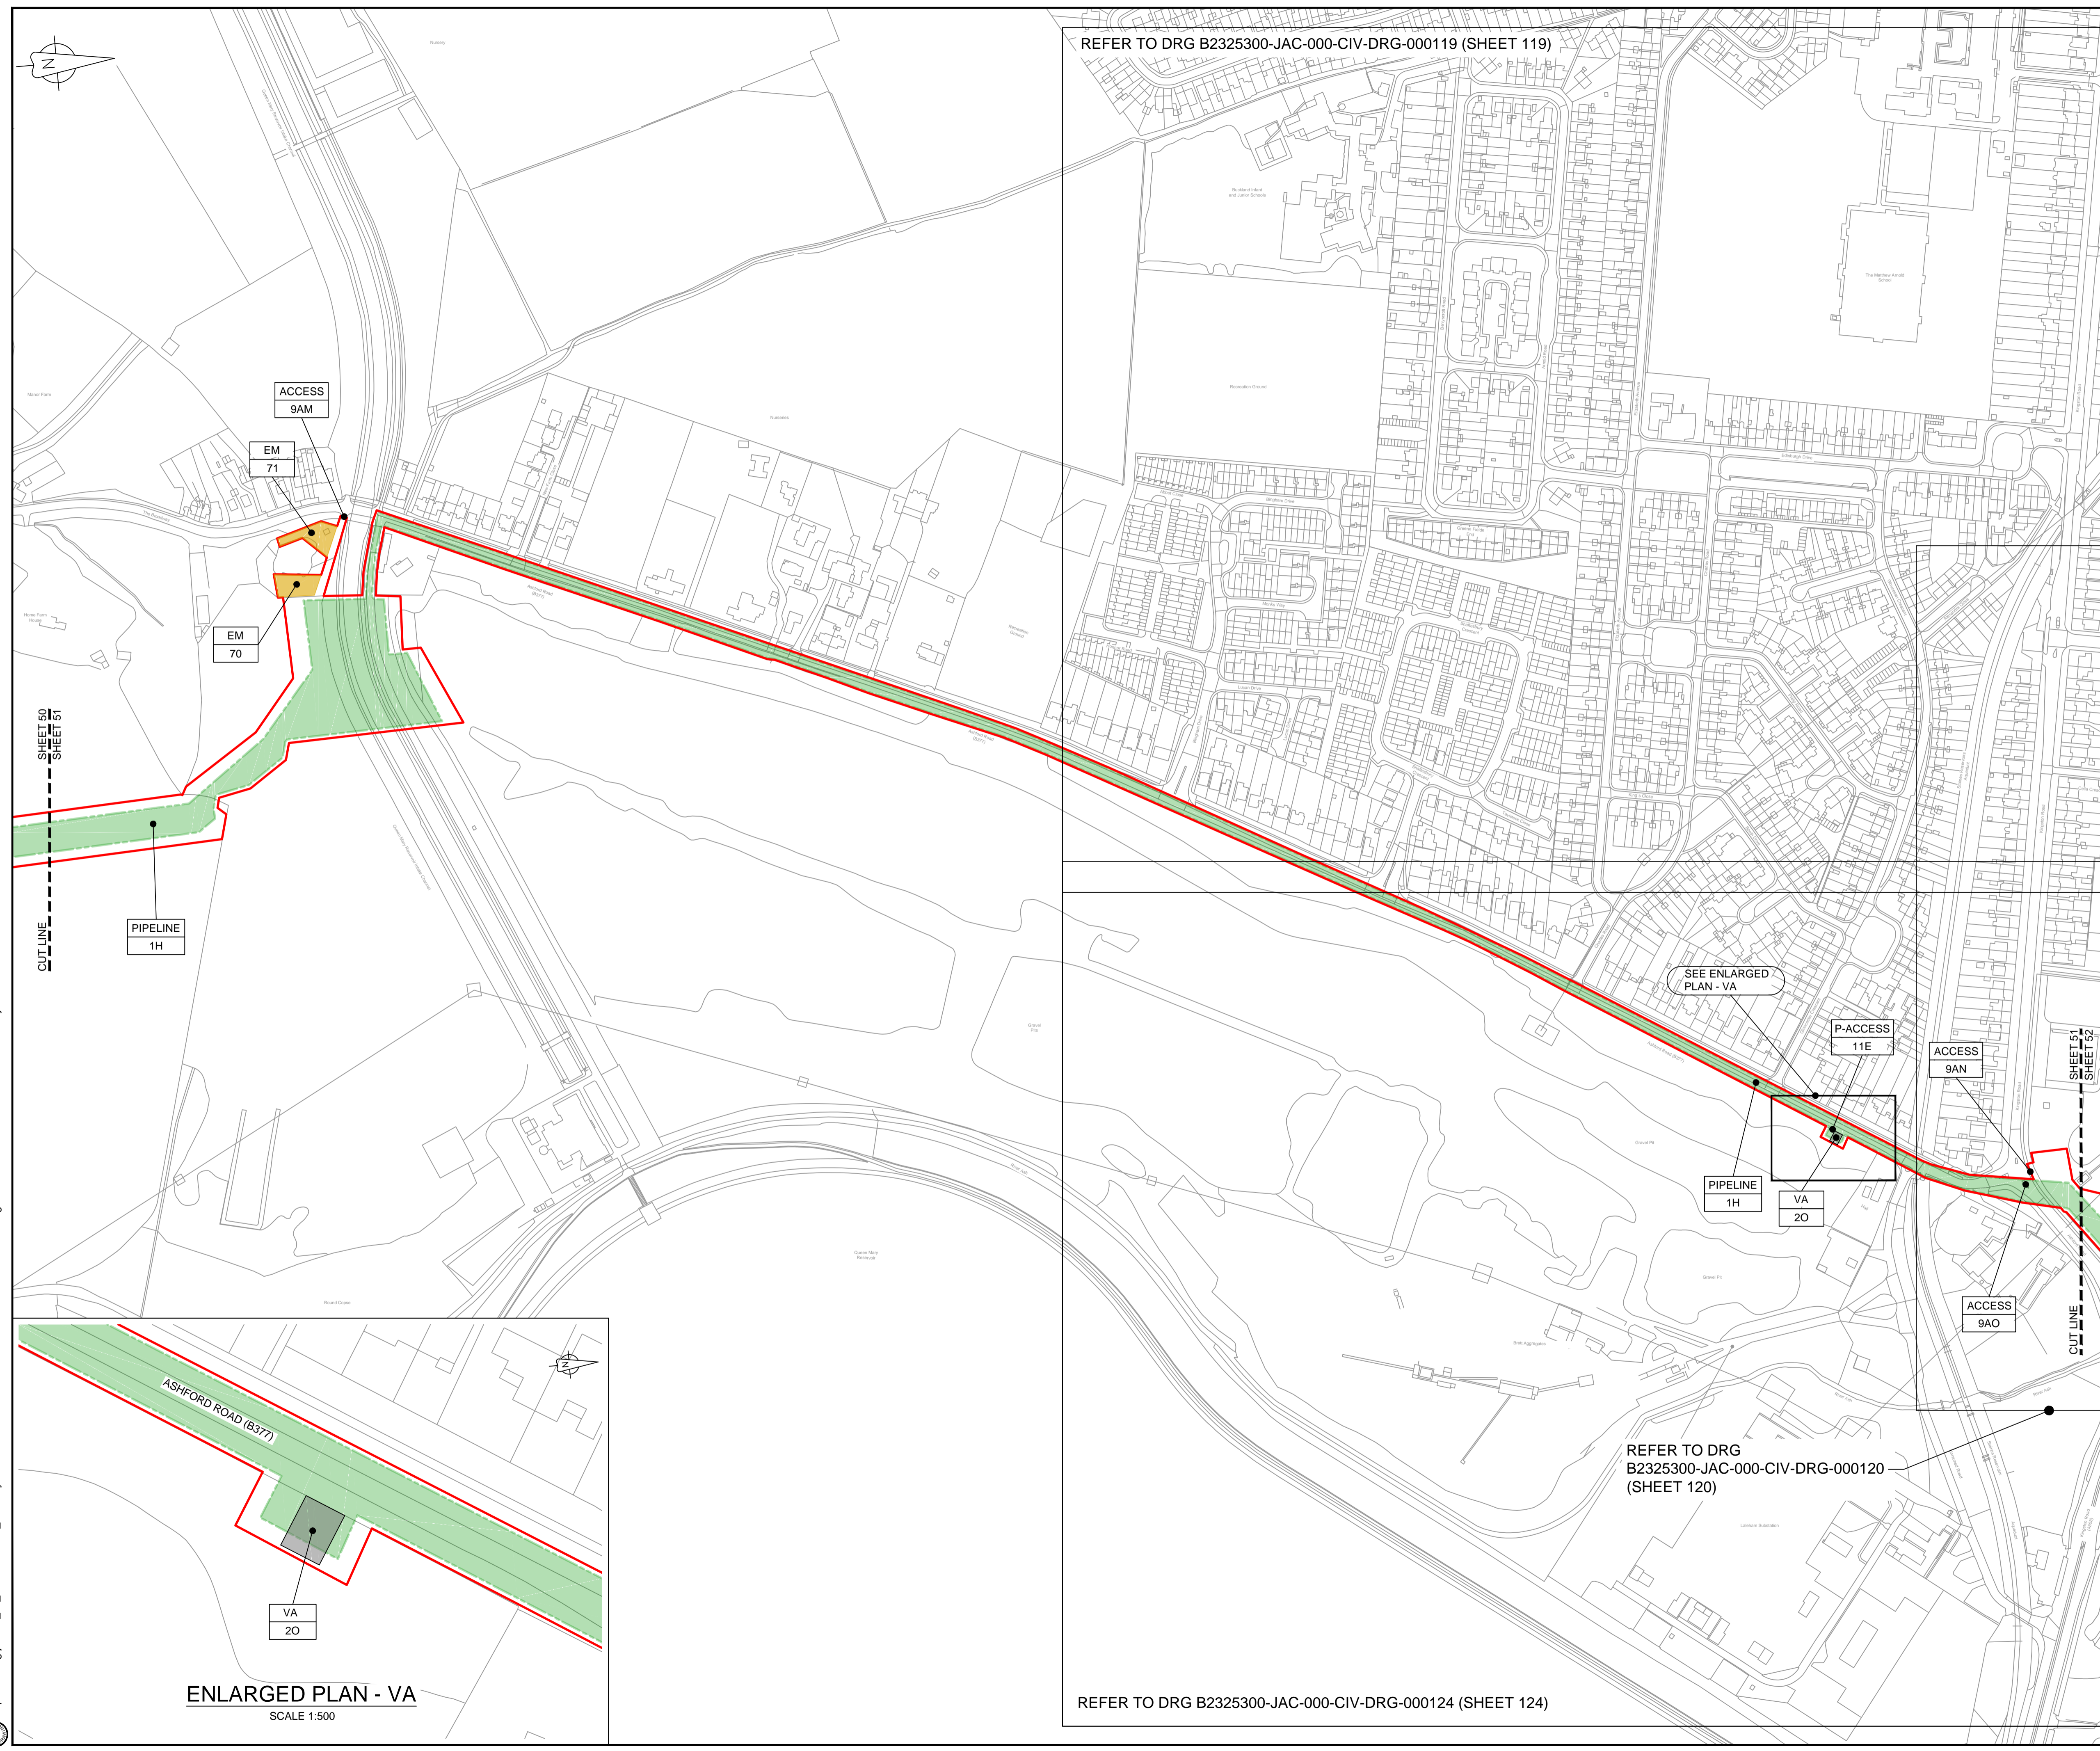

**LOCATION PLAN**  
SCALE 1:500,000

**NOTES**  
1. THIS DRAWING IS IN METRES UNLESS STATED OTHERWISE.

- LEGEND**
- ORDER LIMITS
  - LIMITS OF DEVIATION
  - COMPOUND (CO)
  - ENVIRONMENTAL MITIGATION AREA (EM)
  - ABOVE GROUND INSTALLATION (AGI) / VALVE (VA) / PRESSURE TRANSDUCER (PT)
  - DESCRIPTION
  - ID or WORK NUMBER (if applicable)
  - ACCESS
  - TEMPORARY CONSTRUCTION ACCESS
  - PERMANENT ACCESS
  - COMMENCEMENT / TERMINATION OF WORKS (COMMENCEMENT = OPEN, TERMINATION = CLOSED)

Contains Ordnance Survey data © Crown copyright and database rights 2019.  
© Crown copyright and database rights 2019 OS Licence Number AL10005237.



Rev	Rev. Date	Purpose of revision	Drawn	Checked	Rev'd	Appr'd
C02	19/06/19	SHEETS 35 AND 109 REVISED FOLLOWING SSI ADVICE	SH	JA	ND	PH
C03	09/09/19	SHEETS 10, 11 AND 54 REVISED TO WITHDRAW A2b SUB-OPTION	BT	JA	ND	NJ

**JACOBS**  
1180 Eskdale Road, Wokingham, Wokingham, RG41 5TU  
Tel: +44(0)118 946 7000 Fax: +44(0)118 946 7001  
www.jacobs.com

Client: Esso Petroleum Company, Limited  
Ermyn House,  
Ermyn Way,  
Leatherhead,  
Surrey,  
KT22 8UX



Drawing title  
**WORKS PLAN  
SHEET 51  
REGULATION 5 (2)(J)**


Drawing status: **Fit for Stage Approval**

Scale	1:2500	DO NOT SCALE
Jacobs No.	B2325300	Rev
Client no.		<b>C03</b>

Drawing number  
**B2325300-JAC-000-CIV-DRG-000061**

© Copyright 2019 Jacobs U.K. Limited. The concepts and information contained in this document are the property of Jacobs. Use or copying of this document in whole or in part without the written permission of Jacobs constitutes an infringement of copyright. Limitation. This drawing has been prepared on behalf of, and for the exclusive use of, the Client, and is subject to, and issued in accordance with, the provisions of the contract between Jacobs and the Client. Jacobs accepts no liability or responsibility whatsoever for, or in respect of, any use of, or reliance upon, this drawing by any third party.


C:\pwworking\jacobs\_uk\_water\utilities\_ssf\by\ordms3351\B2325300-JAC-000-CIV-DRG-000061.dwg - 10/09/2019 13:28:06 - A1Frame - BTaylor

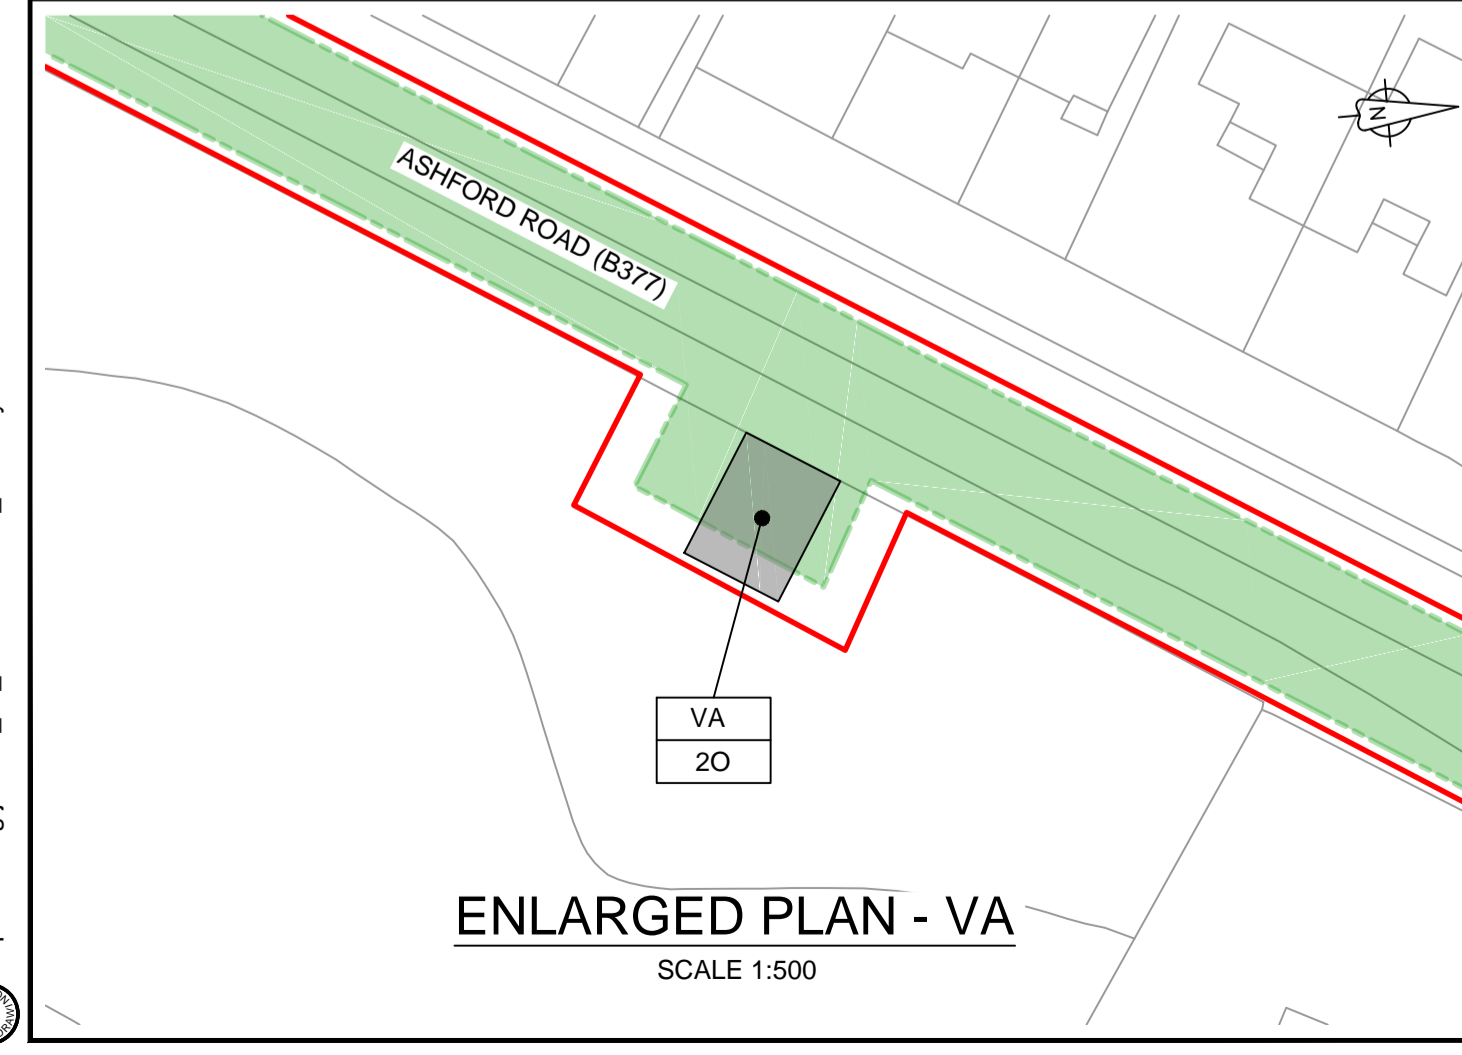

REFER TO DRG B2325300-JAC-000-CIV-DRG-000119 (SHEET 119)

REFER TO DRG  
B2325300-JAC-000-CIV-DRG-000120  
(SHEET 120)

REFER TO DRG B2325300-JAC-000-CIV-DRG-000124 (SHEET 124)

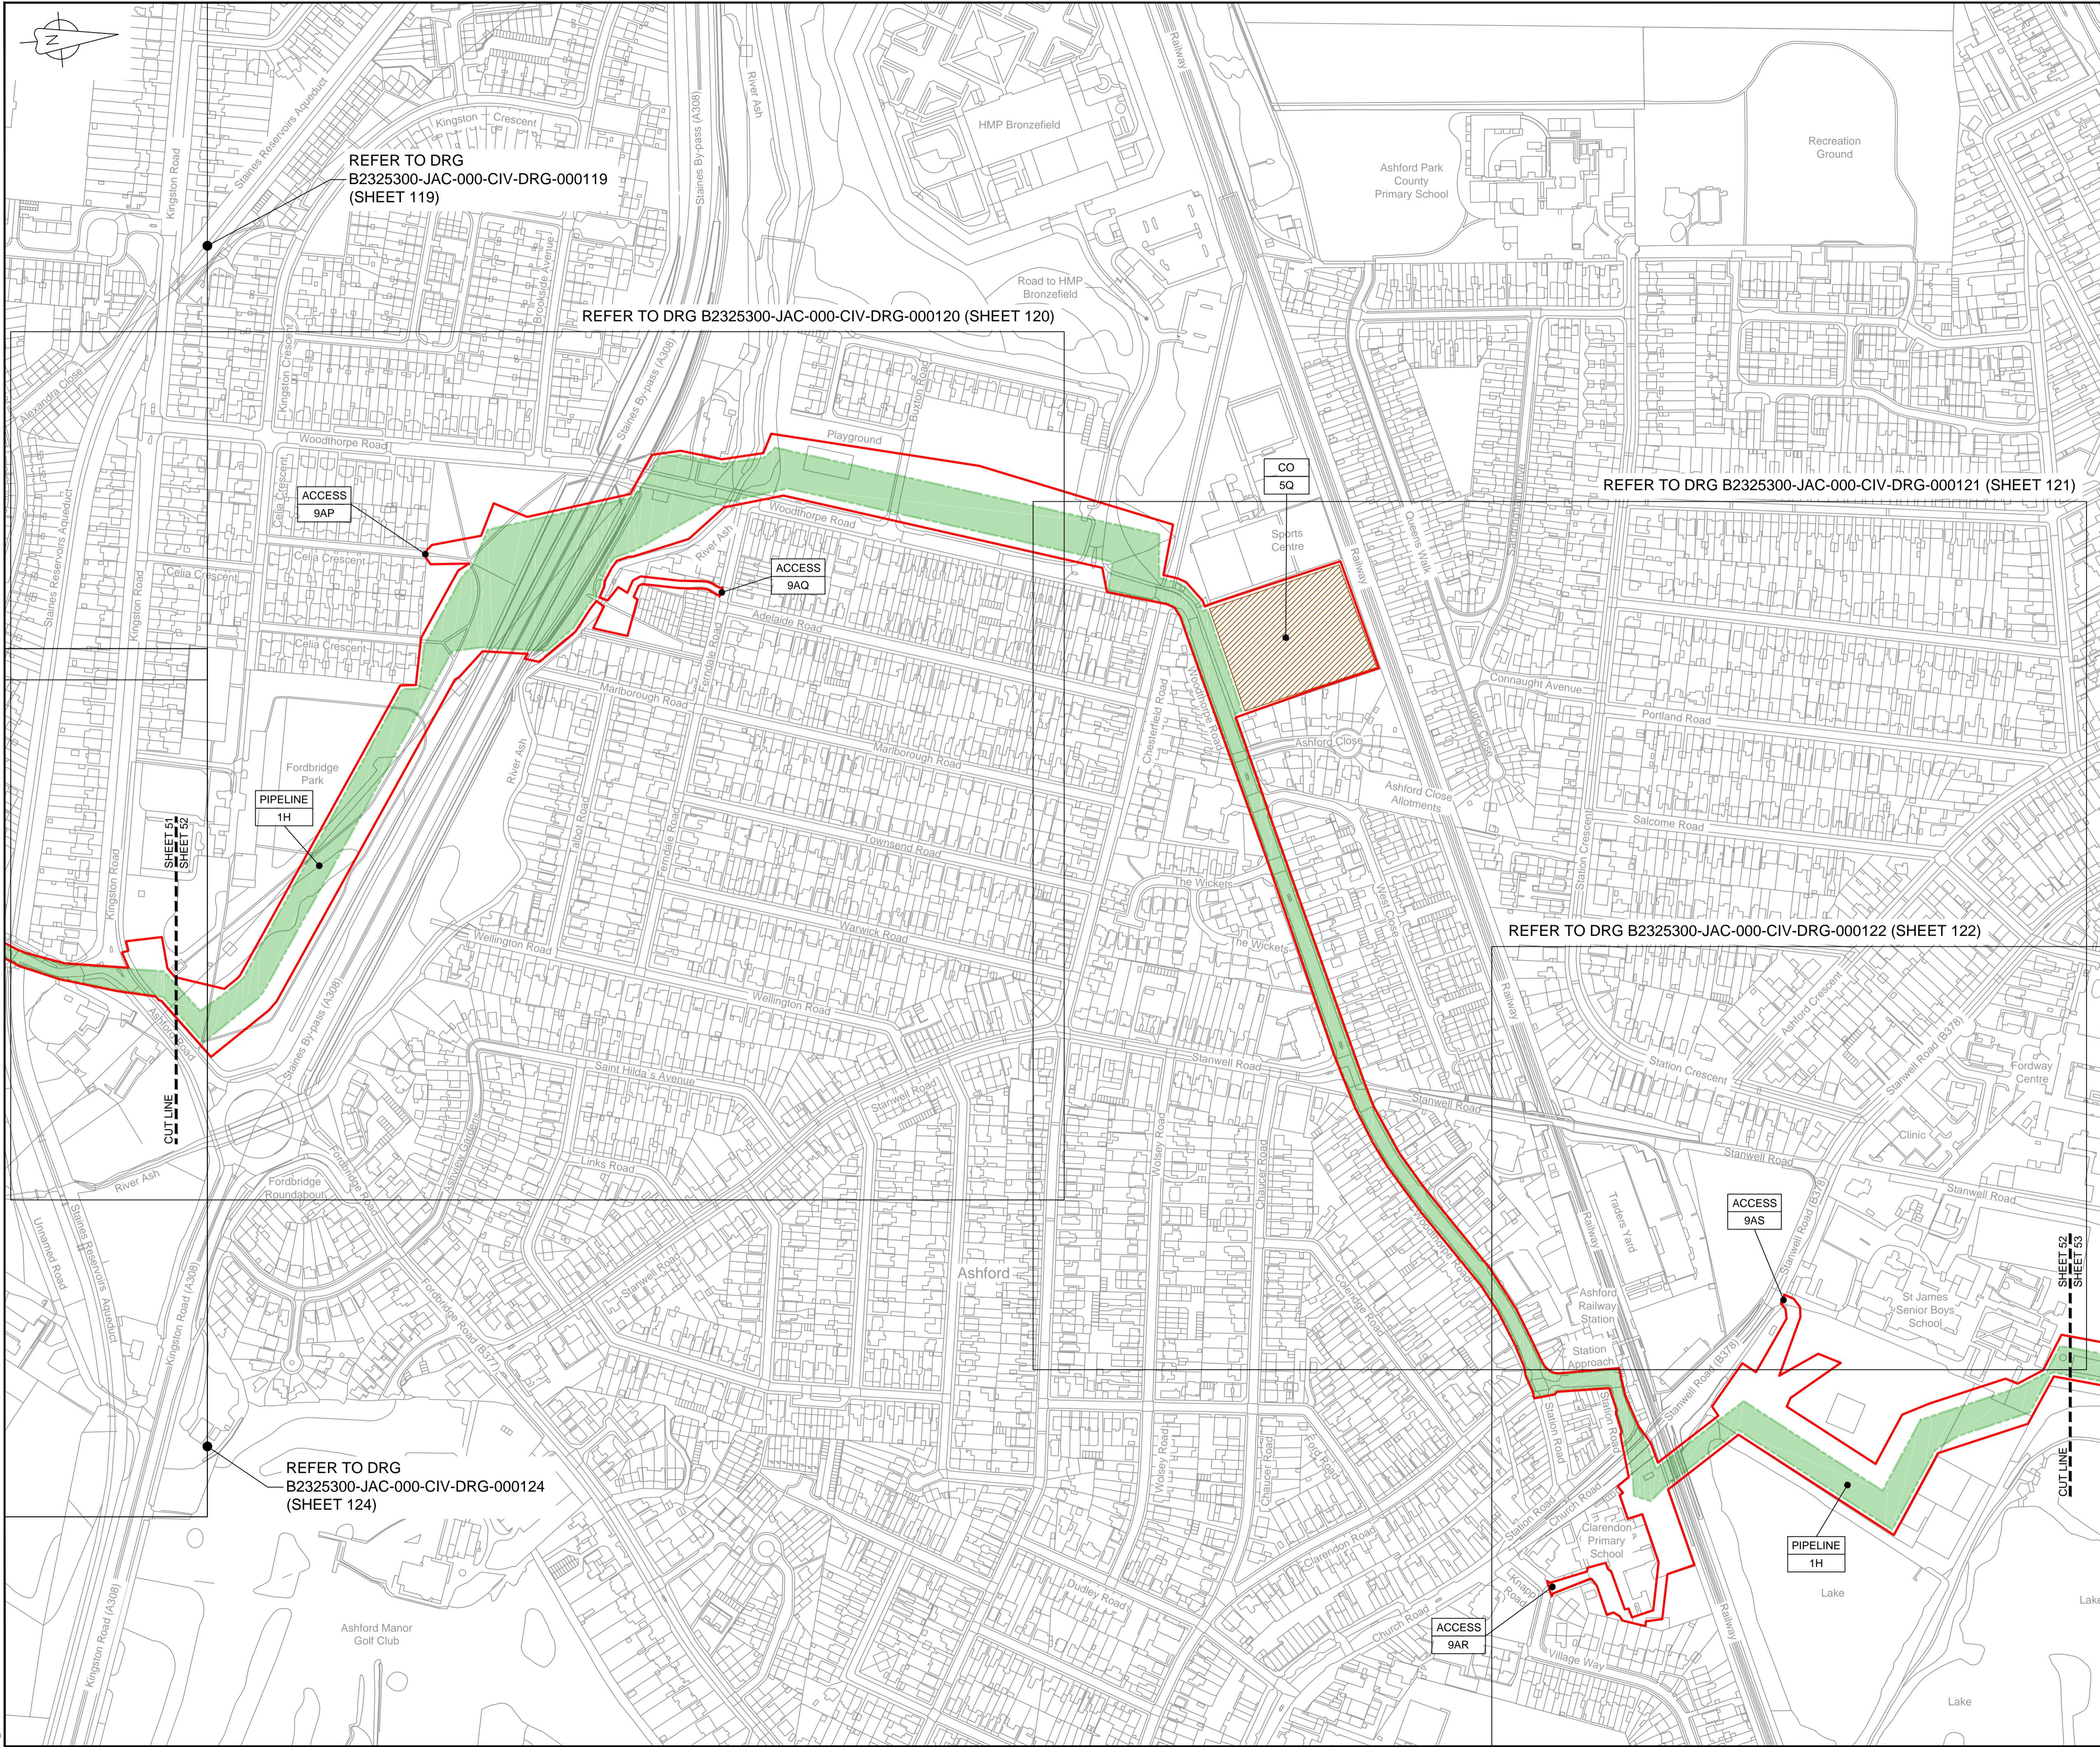

C:\pwworking\jacobs\_uk\_water\utilities\_ssf\byondms3351\B2325300-JAC-000-CIV-DRG-000062.dwg - 10/09/2019 13:30:31 - A1Frame - BTaylor




**LOCATION PLAN**  
SCALE 1:500,000

**NOTES**  
1. THIS DRAWING IS IN METRES UNLESS STATED OTHERWISE.

**LEGEND**

	ORDER LIMITS
	LIMITS OF DEVIATION
	COMPOUND (CO)
	ENVIRONMENTAL MITIGATION AREA (EM)
	ABOVE GROUND INSTALLATION (AGI) / VALVE (VA) / PRESSURE TRANSDUCER (PT)
	DESCRIPTION
	ID or WORK NUMBER (if applicable)
	ACCESS TEMPORARY CONSTRUCTION ACCESS
	P-ACCESS PERMANENT ACCESS
	COMMENCEMENT / TERMINATION OF WORKS (COMMENCEMENT = OPEN, TERMINATION = CLOSED)

Contains Ordnance Survey data © Crown copyright and database rights 2019.  
© Crown copyright and database rights 2019 OS Licence Number AL100005237.

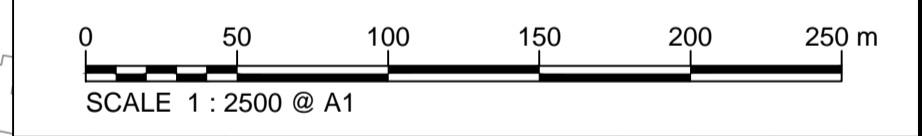

C02	19/06/19	SHEETS 35 AND 108 REVISED FOLLOWING SSI ADVICE	SH	JA	ND	PH
C03	09/09/19	SHEETS 10, 11 AND 54 REVISED TO WITHDRAW A2B SUB-OPTION	BT	JA	ND	NJ
Rev	Rev. Date	Purpose of revision	Drawn	Checked	Rev'd	Appr'd

**JACOBS**  
1180 Eskdale Road, Wokingham, Wokingham, RG41 5TU  
Tel: +44(0)118 946 7000 Fax: +44(0)118 946 7001  
www.jacobs.com

Client: Esso Petroleum Company, Limited  
Emryn House,  
Emryn Way,  
Leatherhead,  
Surrey,  
KT22 6UX

Southampton to London Pipeline Project


Drawing title  
**WORKS PLAN  
SHEET 52  
REGULATION 5 (2)(J)**

Drawing status: **Fit for Stage Approval**

Scale	1:2500	DO NOT SCALE
Jacobs No.	B2325300	Rev
Client no.		<b>C03</b>

Drawing number  
**B2325300-JAC-000-CIV-DRG-000062**

© Copyright 2019 Jacobs U.K. Limited. The concepts and information contained in this document are the property of Jacobs. Use or copying of this document in whole or in part without the written permission of Jacobs constitutes an infringement of copyright. Limitation: This drawing has been prepared on behalf of, and for the exclusive use of, Jacobs' Client, and is subject to, and issued in accordance with, the provisions of the contract between Jacobs and the Client. Jacobs accepts no liability or responsibility whatsoever for, or in respect of, any use of, or reliance upon, this drawing by any third party.

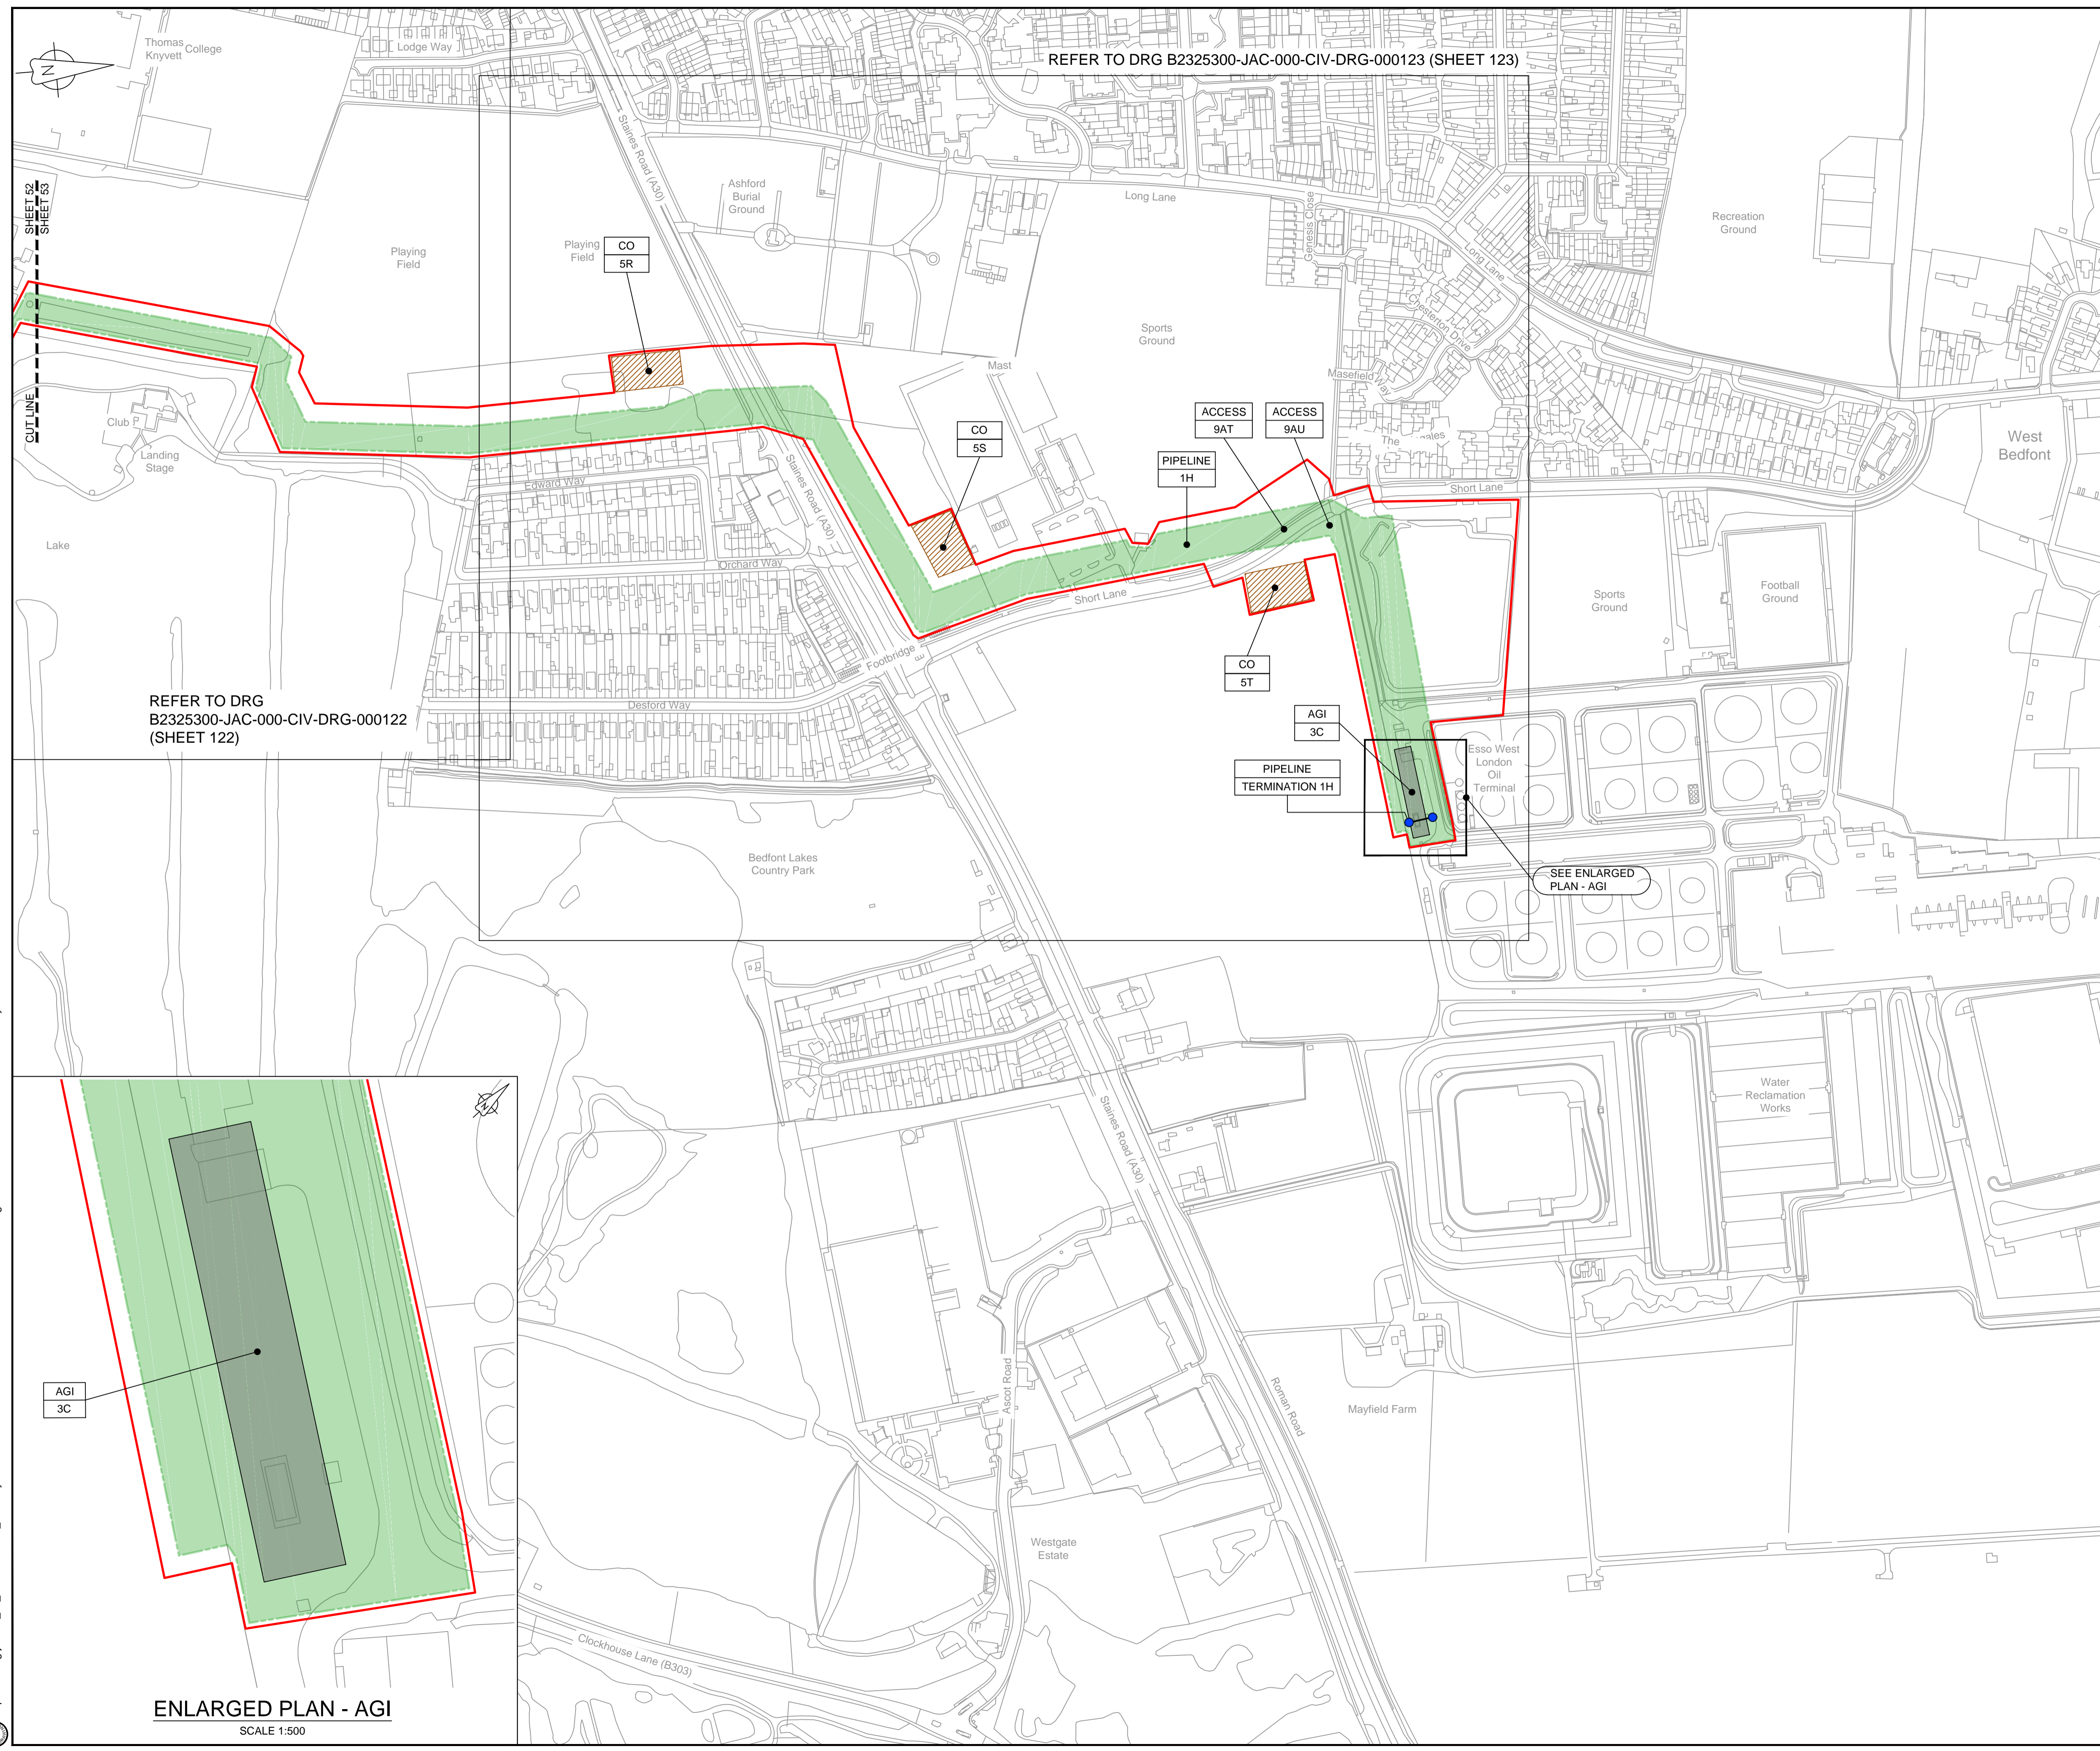

REFER TO DRG B2325300-JAC-000-CIV-DRG-000123 (SHEET 123)

REFER TO DRG B2325300-JAC-000-CIV-DRG-000122 (SHEET 122)



LOCATION PLAN  
SCALE 1:500,000

NOTES  
1. THIS DRAWING IS IN METRES UNLESS STATED OTHERWISE.

- LEGEND**
- ORDER LIMITS
  - LIMITS OF DEVIATION
  - COMPOUND (CO)
  - ENVIRONMENTAL MITIGATION AREA (EM)
  - ABOVE GROUND INSTALLATION (AGI) / VALVE (VA) / PRESSURE TRANSDUCER (PT)
  - DESCRIPTION
  - ID or WORK NUMBER (if applicable)
  - ACCESS TEMPORARY CONSTRUCTION ACCESS
  - P-ACCESS PERMANENT ACCESS
  - COMMENCEMENT / TERMINATION OF WORKS (COMMENCEMENT = OPEN, TERMINATION = CLOSED)

Contains Ordnance Survey data © Crown copyright and database rights 2019.

© Crown copyright and database rights 2019 OS Licence Number AL100005237.



Rev	Rev. Date	Purpose of revision	Drawn	Checked	Rev'd	Appr'd
C02	19/06/19	SHEETS 36 AND 108 REVISED FOLLOWING SSI ADVICE	SH	JA	ND	PH
C03	09/09/19	SHEETS 10, 11 AND 54 REVISED TO WITHDRAW A2b SUB-OPTION	BT	JA	ND	NJ

**JACOBS**

1180 Eskdale Road, Wokingham, Wokingham, RG41 5TU  
Tel: +44(0)118 946 7000 Fax: +44(0)118 946 7001  
www.jacobs.com

Client: Esso Petroleum Company, Limited  
Ermyn House,  
Ermyn Way,  
Leatherhead,  
Surrey,  
KT22 8UX



Drawing title  
**WORKS PLAN  
SHEET 53  
REGULATION 5 (2)(J)**

Drawing status  
**Fit for Stage Approval**


Scale	1:2500	DO NOT SCALE
Jacobs No.	B2325300	Rev
Client no.		<b>C03</b>


Drawing number  
**B2325300-JAC-000-CIV-DRG-000063**

© Copyright 2019 Jacobs U.K. Limited. The concepts and information contained in this document are the property of Jacobs. Use or copying of this document in whole or in part without the written permission of Jacobs constitutes an infringement of copyright. Limitation. This drawing has been prepared on behalf of, and for the exclusive use of, Jacobs' Client, and is subject to, and issued in accordance with, the provisions of the contract between Jacobs and the Client. Jacobs accepts no liability or responsibility whatsoever for, or in respect of, any use of, or reliance upon, this drawing by any third party.

C:\pwworking\jacobs\_uk\_water\utilities\_ssf\london\dm33519\B2325300-JAC-000-CIV-DRG-000063.dwg - 10/09/2019 13:32:50 - A1Frame - BTaylor

**ENLARGED PLAN - AGI**  
SCALE 1:500

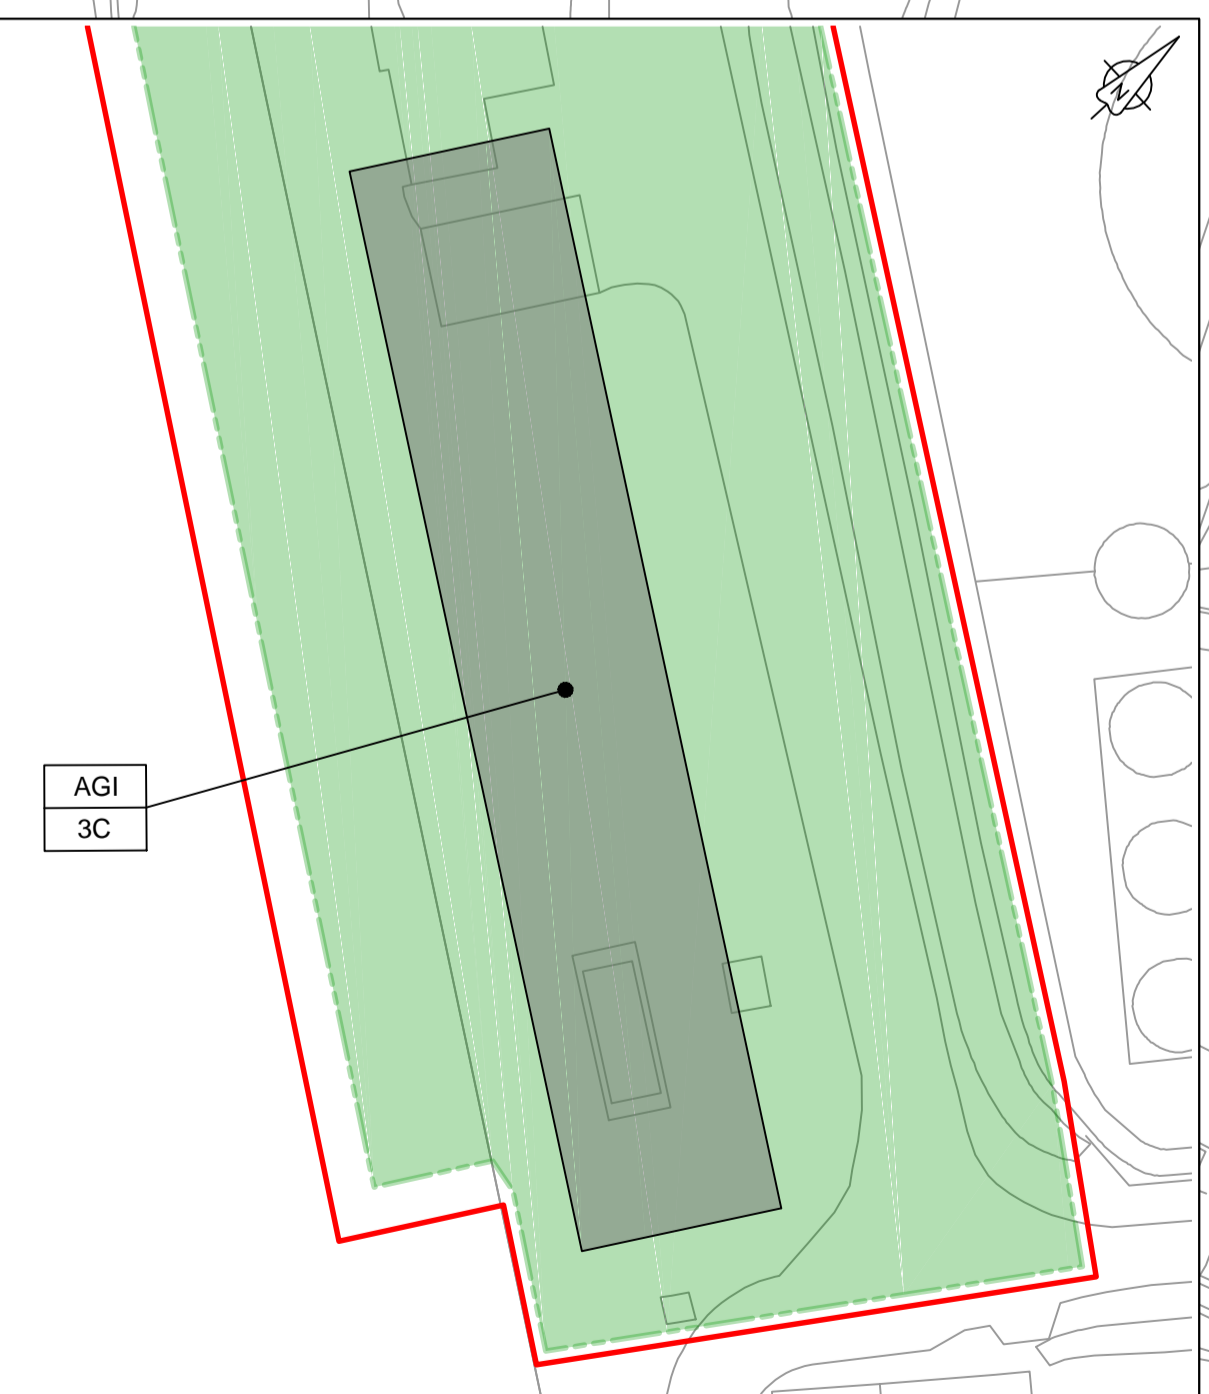

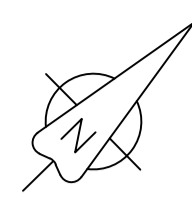

LOCATION PLAN  
SCALE 1:500,000

NOTES


1. THIS DRAWING IS IN METRES UNLESS STATED OTHERWISE.

LEGEND

- ORDER LIMITS
- LIMITS OF DEVIATION
- COMPOUND (CO)
- ENVIRONMENTAL MITIGATION AREA (EM)
- ABOVE GROUND INSTALLATION (AGI) / VALVE (VA) / PRESSURE TRANSDUCER (PT)
- DESCRIPTION
- ID or WORK NUMBER (if applicable)
- ACCESS
- TEMPORARY CONSTRUCTION ACCESS
- P-ACCESS
- PERMANENT ACCESS
- COMMENCEMENT / TERMINATION OF WORKS  
(COMMENCEMENT = OPEN, TERMINATION = CLOSED)

Contains Ordnance Survey data © Crown copyright and database rights 2019.

© Crown copyright and database rights 2019 OS Licence Number AL100005237.

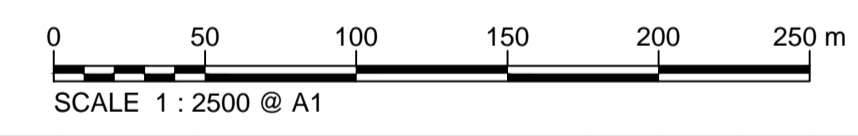

C02	19/06/19	SHEETS 36 AND 109 REVISED FOLLOWING SSI ADVICE	SH	JA	ND	PH
C03	09/09/19	SHEETS 10, 11 AND 54 REVISED TO WITHDRAW A2B SUB-OPTION	BT	JA	ND	NJ

Rev	Rev. Date	Purpose of revision	Drawn	Checked	Rev'd	Appr'd



1180 Eskdale Road, Winnersh, Wokingham, RG41 5TU  
Tel:+44(0)118 946 7000 Fax:+44(0)118 946 7001  
www.jacobs.com

Client: Esso Petroleum Company, Limited  
Emryn House,  
Emryn Way,  
Leatherhead,  
Surrey,  
KT22 8UX



Southampton to London  
Pipeline Project


Drawing title  
**WORKS PLAN  
SHEET 54  
REGULATION 5 (2)(J)**

Drawing status  
**Fit for Stage Approval**

Scale	1:2500	DO NOT SCALE
Jacobs No.	B2325300	Rev
Client no.		<b>C03</b>

Drawing number  
**B2325300-JAC-000-CIV-DRG-000064**

SHEET 54 - NO LONGER NEEDED

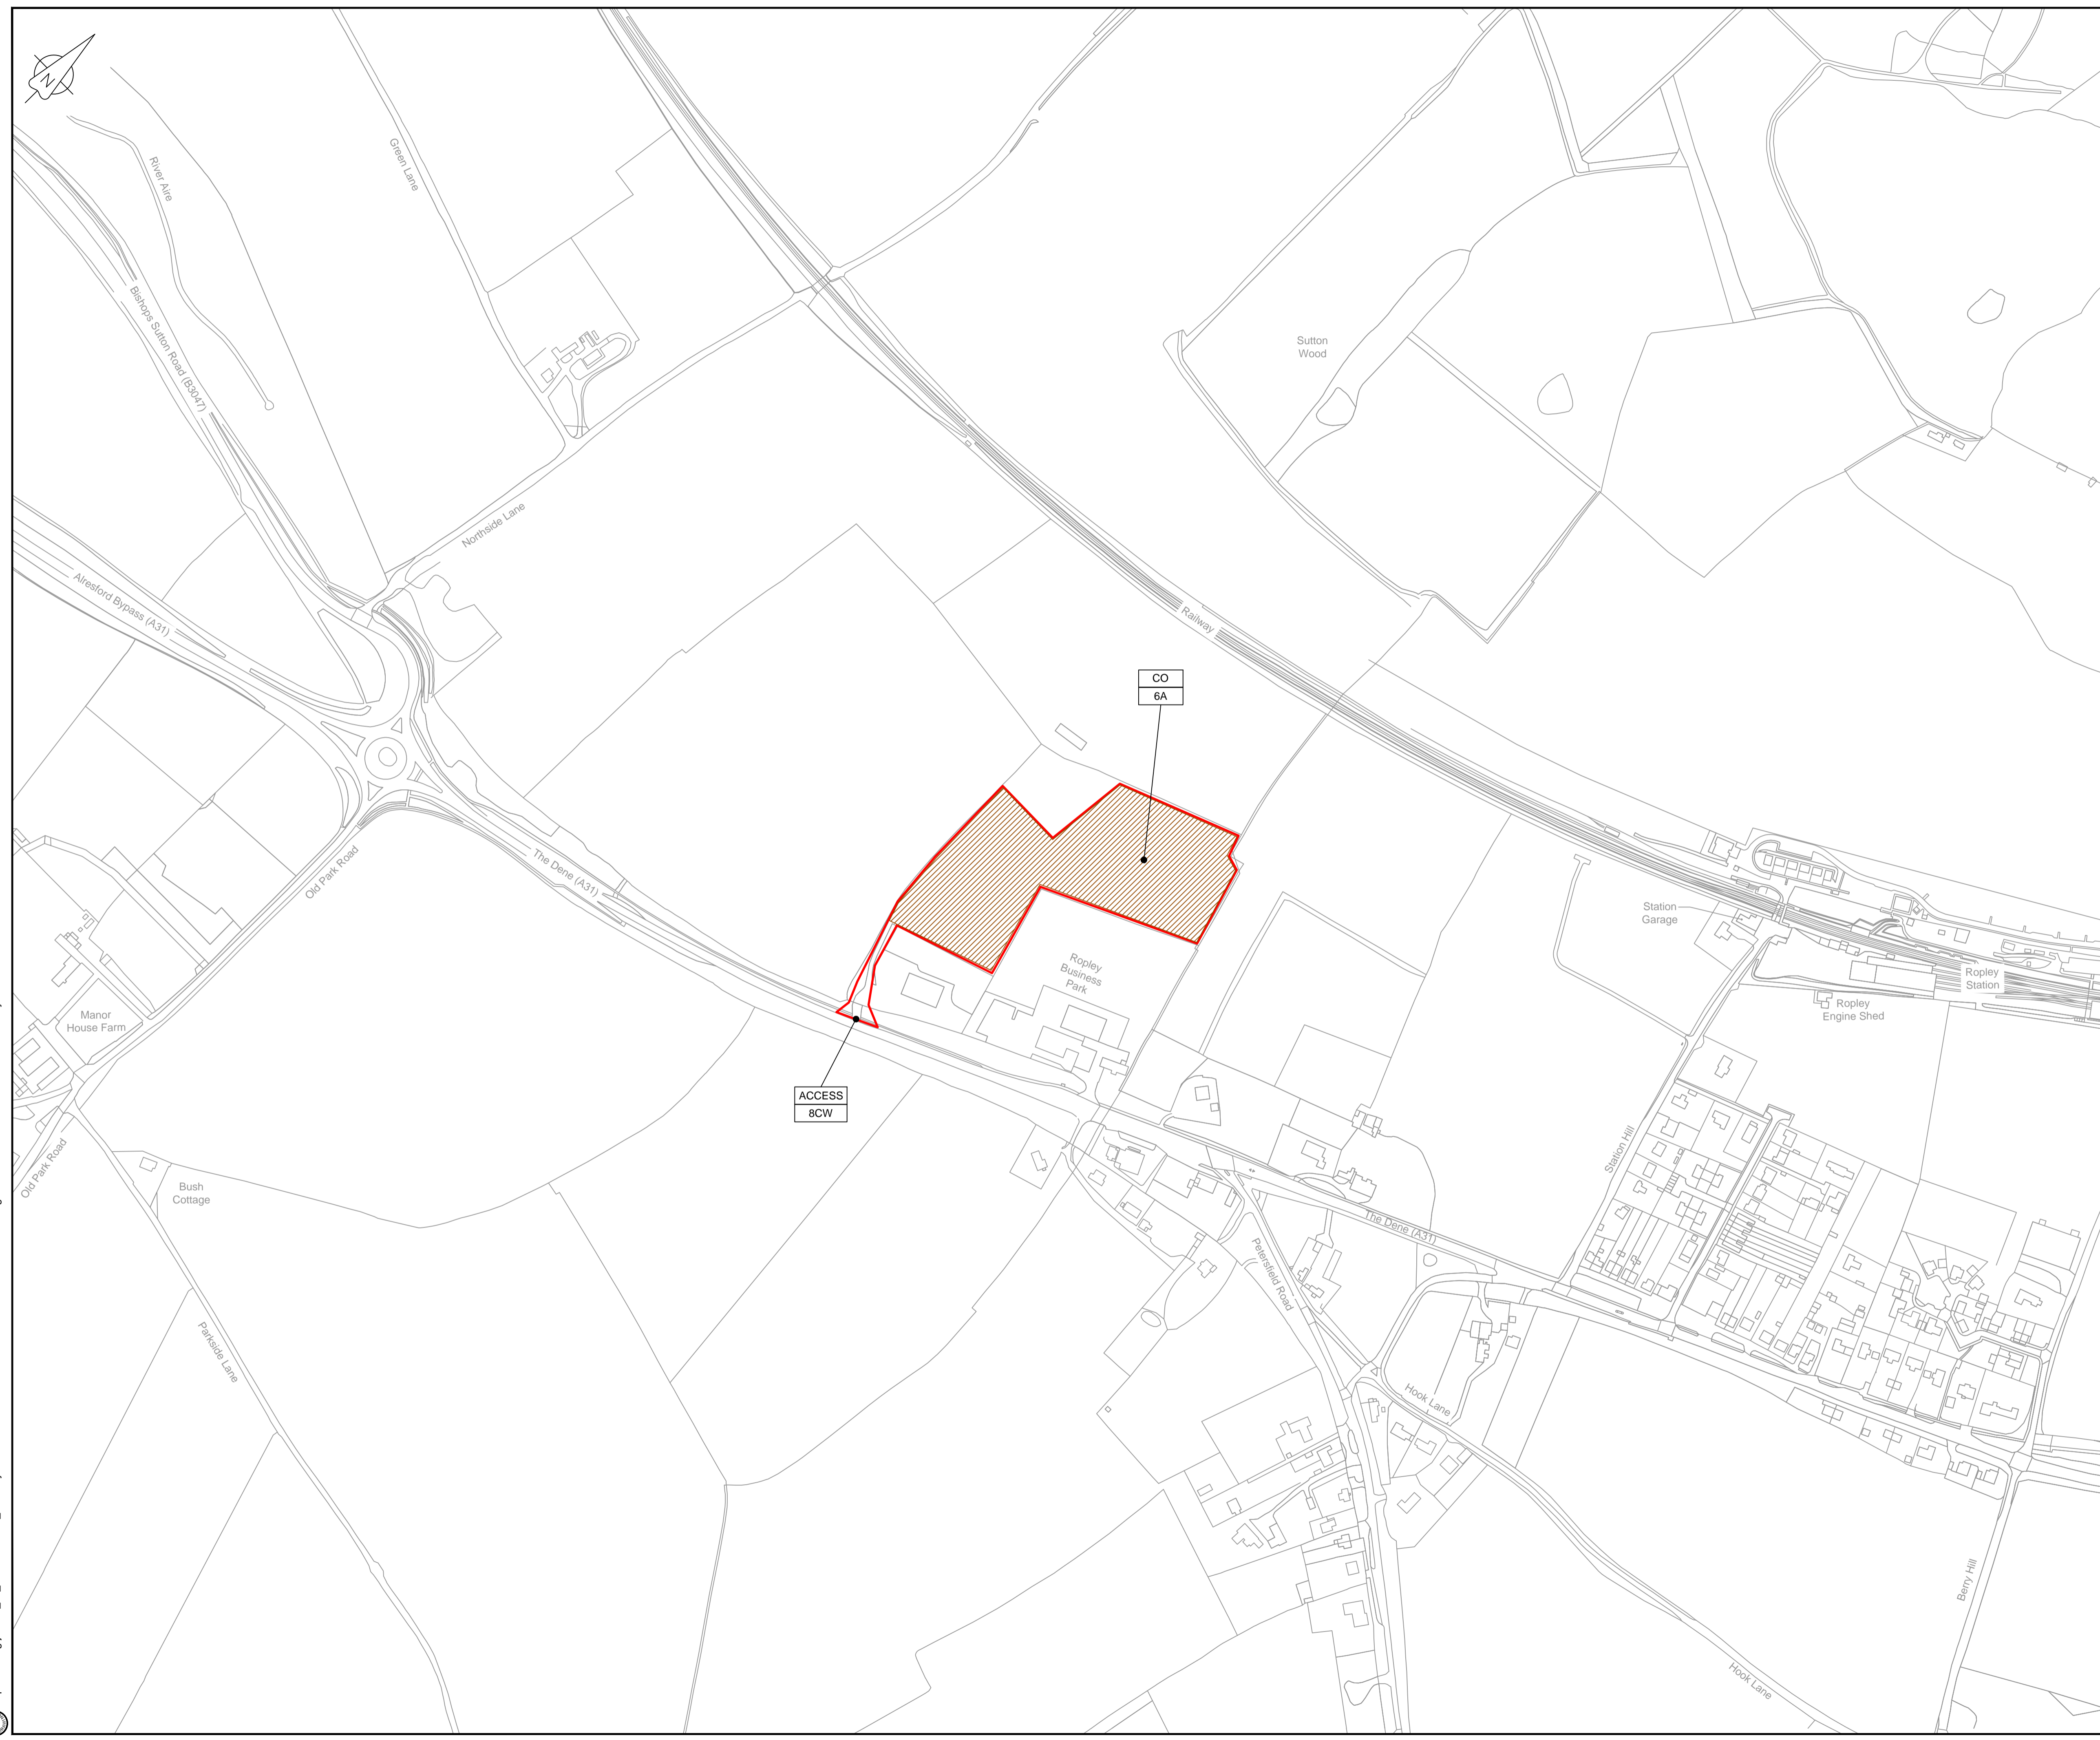

**LOCATION PLAN**  
SCALE 1:500,000

**NOTES**  
1. THIS DRAWING IS IN METRES UNLESS STATED OTHERWISE.

**LEGEND**

	ORDER LIMITS
	LIMITS OF DEVIATION
	COMPOUND (CO)
	ENVIRONMENTAL MITIGATION AREA (EM)
	ABOVE GROUND INSTALLATION (AGI) / VALVE (VA) / PRESSURE TRANSDUCER (PT)
	DESCRIPTION
	ID or WORK NUMBER (if applicable)
	ACCESS
	PERMANENT ACCESS
	COMMENCEMENT / TERMINATION OF WORKS (COMMENCEMENT = OPEN, TERMINATION = CLOSED)

Contains Ordnance Survey data © Crown copyright and database rights 2019.  
© Crown copyright and database rights 2019 OS Licence Number AL10005237.



C02	19/06/19	SHEETS 35 AND 109 REVISED FOLLOWING SSI ADVICE	SH	JA	ND	PH
C03	09/09/19	SHEETS 10, 11 AND 54 REVISED TO WITHDRAW A2b SUB-OPTION	BT	JA	ND	NJ
Rev	Rev. Date	Purpose of revision	Drawn	Checked	Rev'd	Appr'd

**JACOBS**

1180 Eskdale Road, Winnersh, Wokingham, RG41 5TU  
Tel: +44(0)118 946 7000 Fax: +44(0)118 946 7001  
www.jacobs.com

Client: Esso Petroleum Company, Limited  
Emryn House,  
Emryn Way,  
Leatherhead,  
Surrey,  
KT22 8UX

Project: Southampton to London Pipeline Project


Drawing title: **WORKS PLAN SHEET 55 REGULATION 5 (2)(J)**

Drawing status: **Fit for Stage Approval**

Scale	1:2500	DO NOT SCALE
Jacobs No.	B2325300	Rev
Client no.		<b>C03</b>

Drawing number: **B2325300-JAC-000-CIV-DRG-000065**

© Copyright 2019 Jacobs U.K. Limited. The concepts and information contained in this document are the property of Jacobs. Use or copying of this document in whole or in part without the written permission of Jacobs constitutes an infringement of copyright. Limitation: This drawing has been prepared on behalf of, and for the exclusive use of, the Client, and is subject to, and issued in accordance with, the provisions of the contract between Jacobs and the Client. Jacobs accepts no liability or responsibility whatsoever for, or in respect of, any use of, or reliance upon, this drawing by any third party.

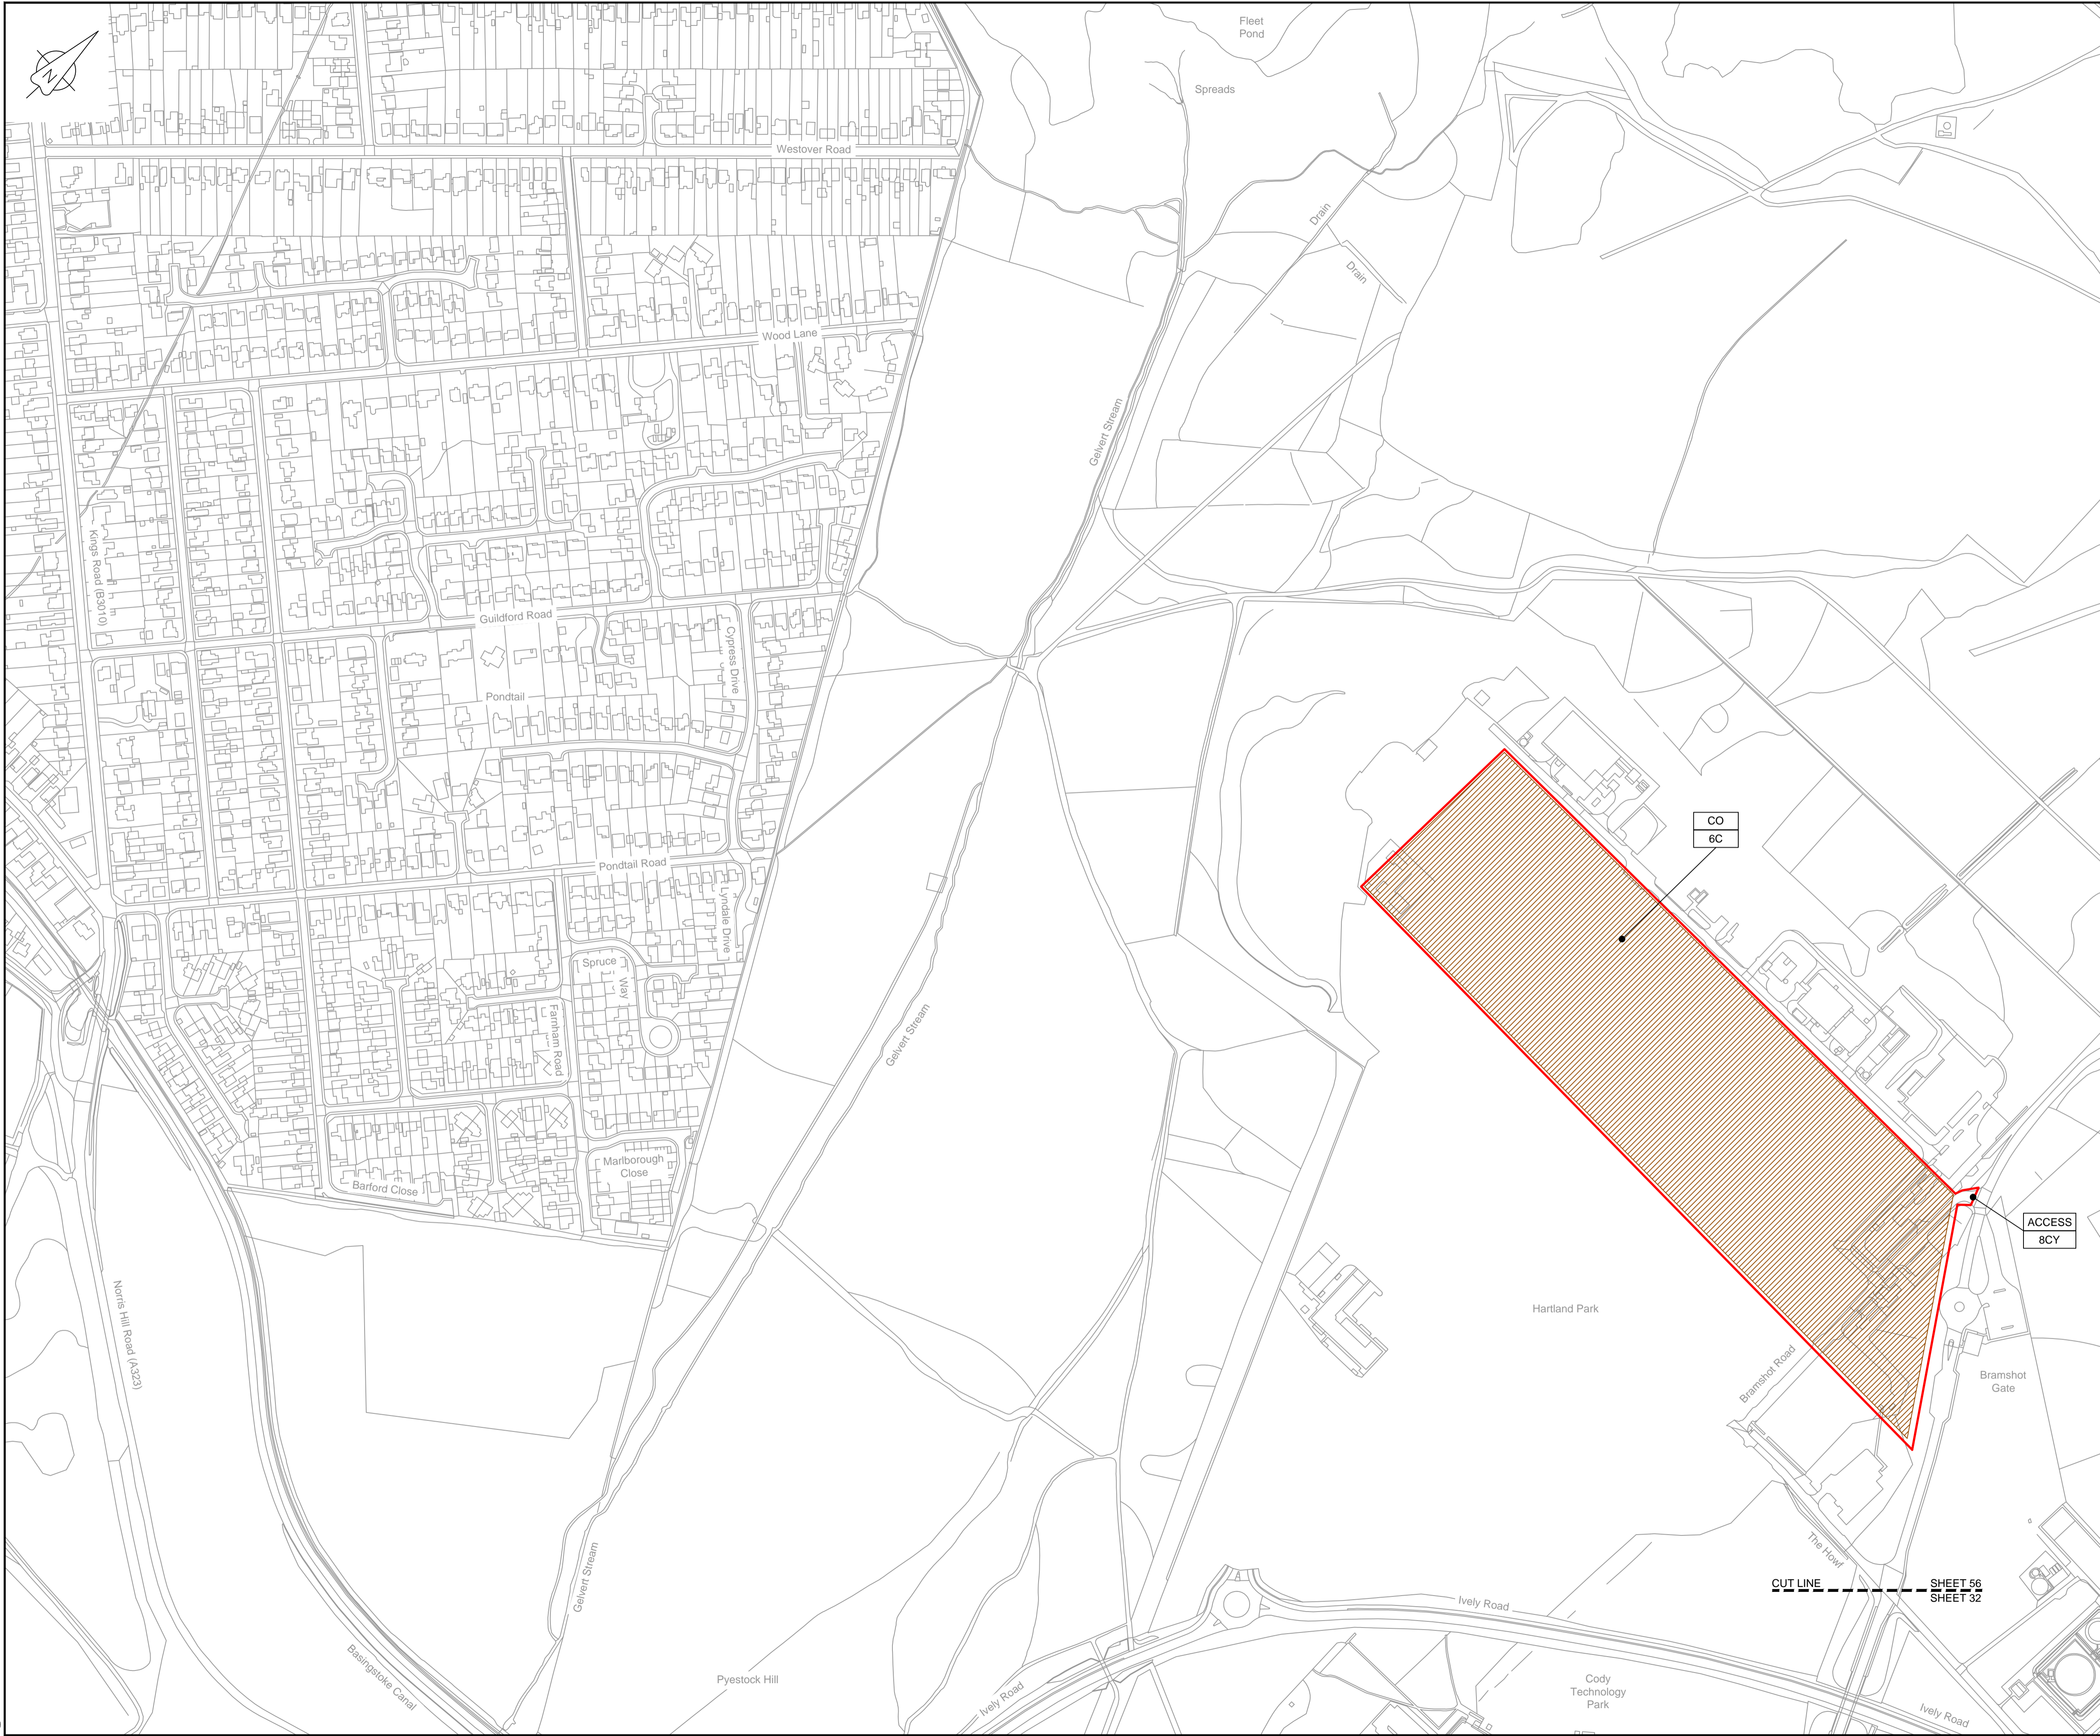

**LOCATION PLAN**  
SCALE 1:500,000

**NOTES**  
1. THIS DRAWING IS IN METRES UNLESS STATED OTHERWISE.

**LEGEND**

	ORDER LIMITS
	LIMITS OF DEVIATION
	COMPOUND (CO)
	ENVIRONMENTAL MITIGATION AREA (EM)
	ABOVE GROUND INSTALLATION (AGI) / VALVE (VA) / PRESSURE TRANSDUCER (PT)
	DESCRIPTION
	ID or WORK NUMBER (if applicable)
	ACCESS TEMPORARY CONSTRUCTION ACCESS
	P-ACCESS PERMANENT ACCESS
	COMMENCEMENT / TERMINATION OF WORKS (COMMENCEMENT = OPEN, TERMINATION = CLOSED)

Contains Ordnance Survey data © Crown copyright and database rights 2019.  
© Crown copyright and database rights 2019 OS Licence Number AL100005237.



Rev	Rev. Date	Purpose of revision	Drawn	Checked	Rev'd	Appr'd
C02	19/06/19	SHEETS 36 AND 108 REVISED FOLLOWING SSI ADVICE	SH	JA	ND	PH
C03	09/09/19	SHEETS 10, 11 AND 54 REVISED TO WITHDRAW A2b SUB-OPTION	BT	JA	ND	NJ

**JACOBS**

1180 Eskdale Road, Wokingham, RG41 5TU  
Tel: +44(0)118 946 7000 Fax: +44(0)118 946 7001  
www.jacobs.com

Client: Esso Petroleum Company, Limited  
Emryn House,  
Emryn Way,  
Leatherhead,  
Surrey,  
KT22 8UX




Drawing title  
**WORKS PLAN  
SHEET 56  
REGULATION 5 (2)(J)**

Drawing status  
**Fit for Stage Approval**

Scale	1:2500	DO NOT SCALE
Jacobs No.	B2325300	Rev
Client no.		<b>C03</b>

Drawing number  
**B2325300-JAC-000-CIV-DRG-000066**

© Copyright 2019 Jacobs U.K. Limited. The concepts and information contained in this document are the property of Jacobs. Use or copying of this document in whole or in part without the written permission of Jacobs constitutes an infringement of copyright. Limitation: This drawing has been prepared on behalf of, and for the exclusive use of, the Client, and is subject to, and issued in accordance with, the provisions of the contract between Jacobs and the Client. Jacobs accepts no liability or responsibility whatsoever for, or in respect of, any use of, or reliance upon, this drawing by any third party.

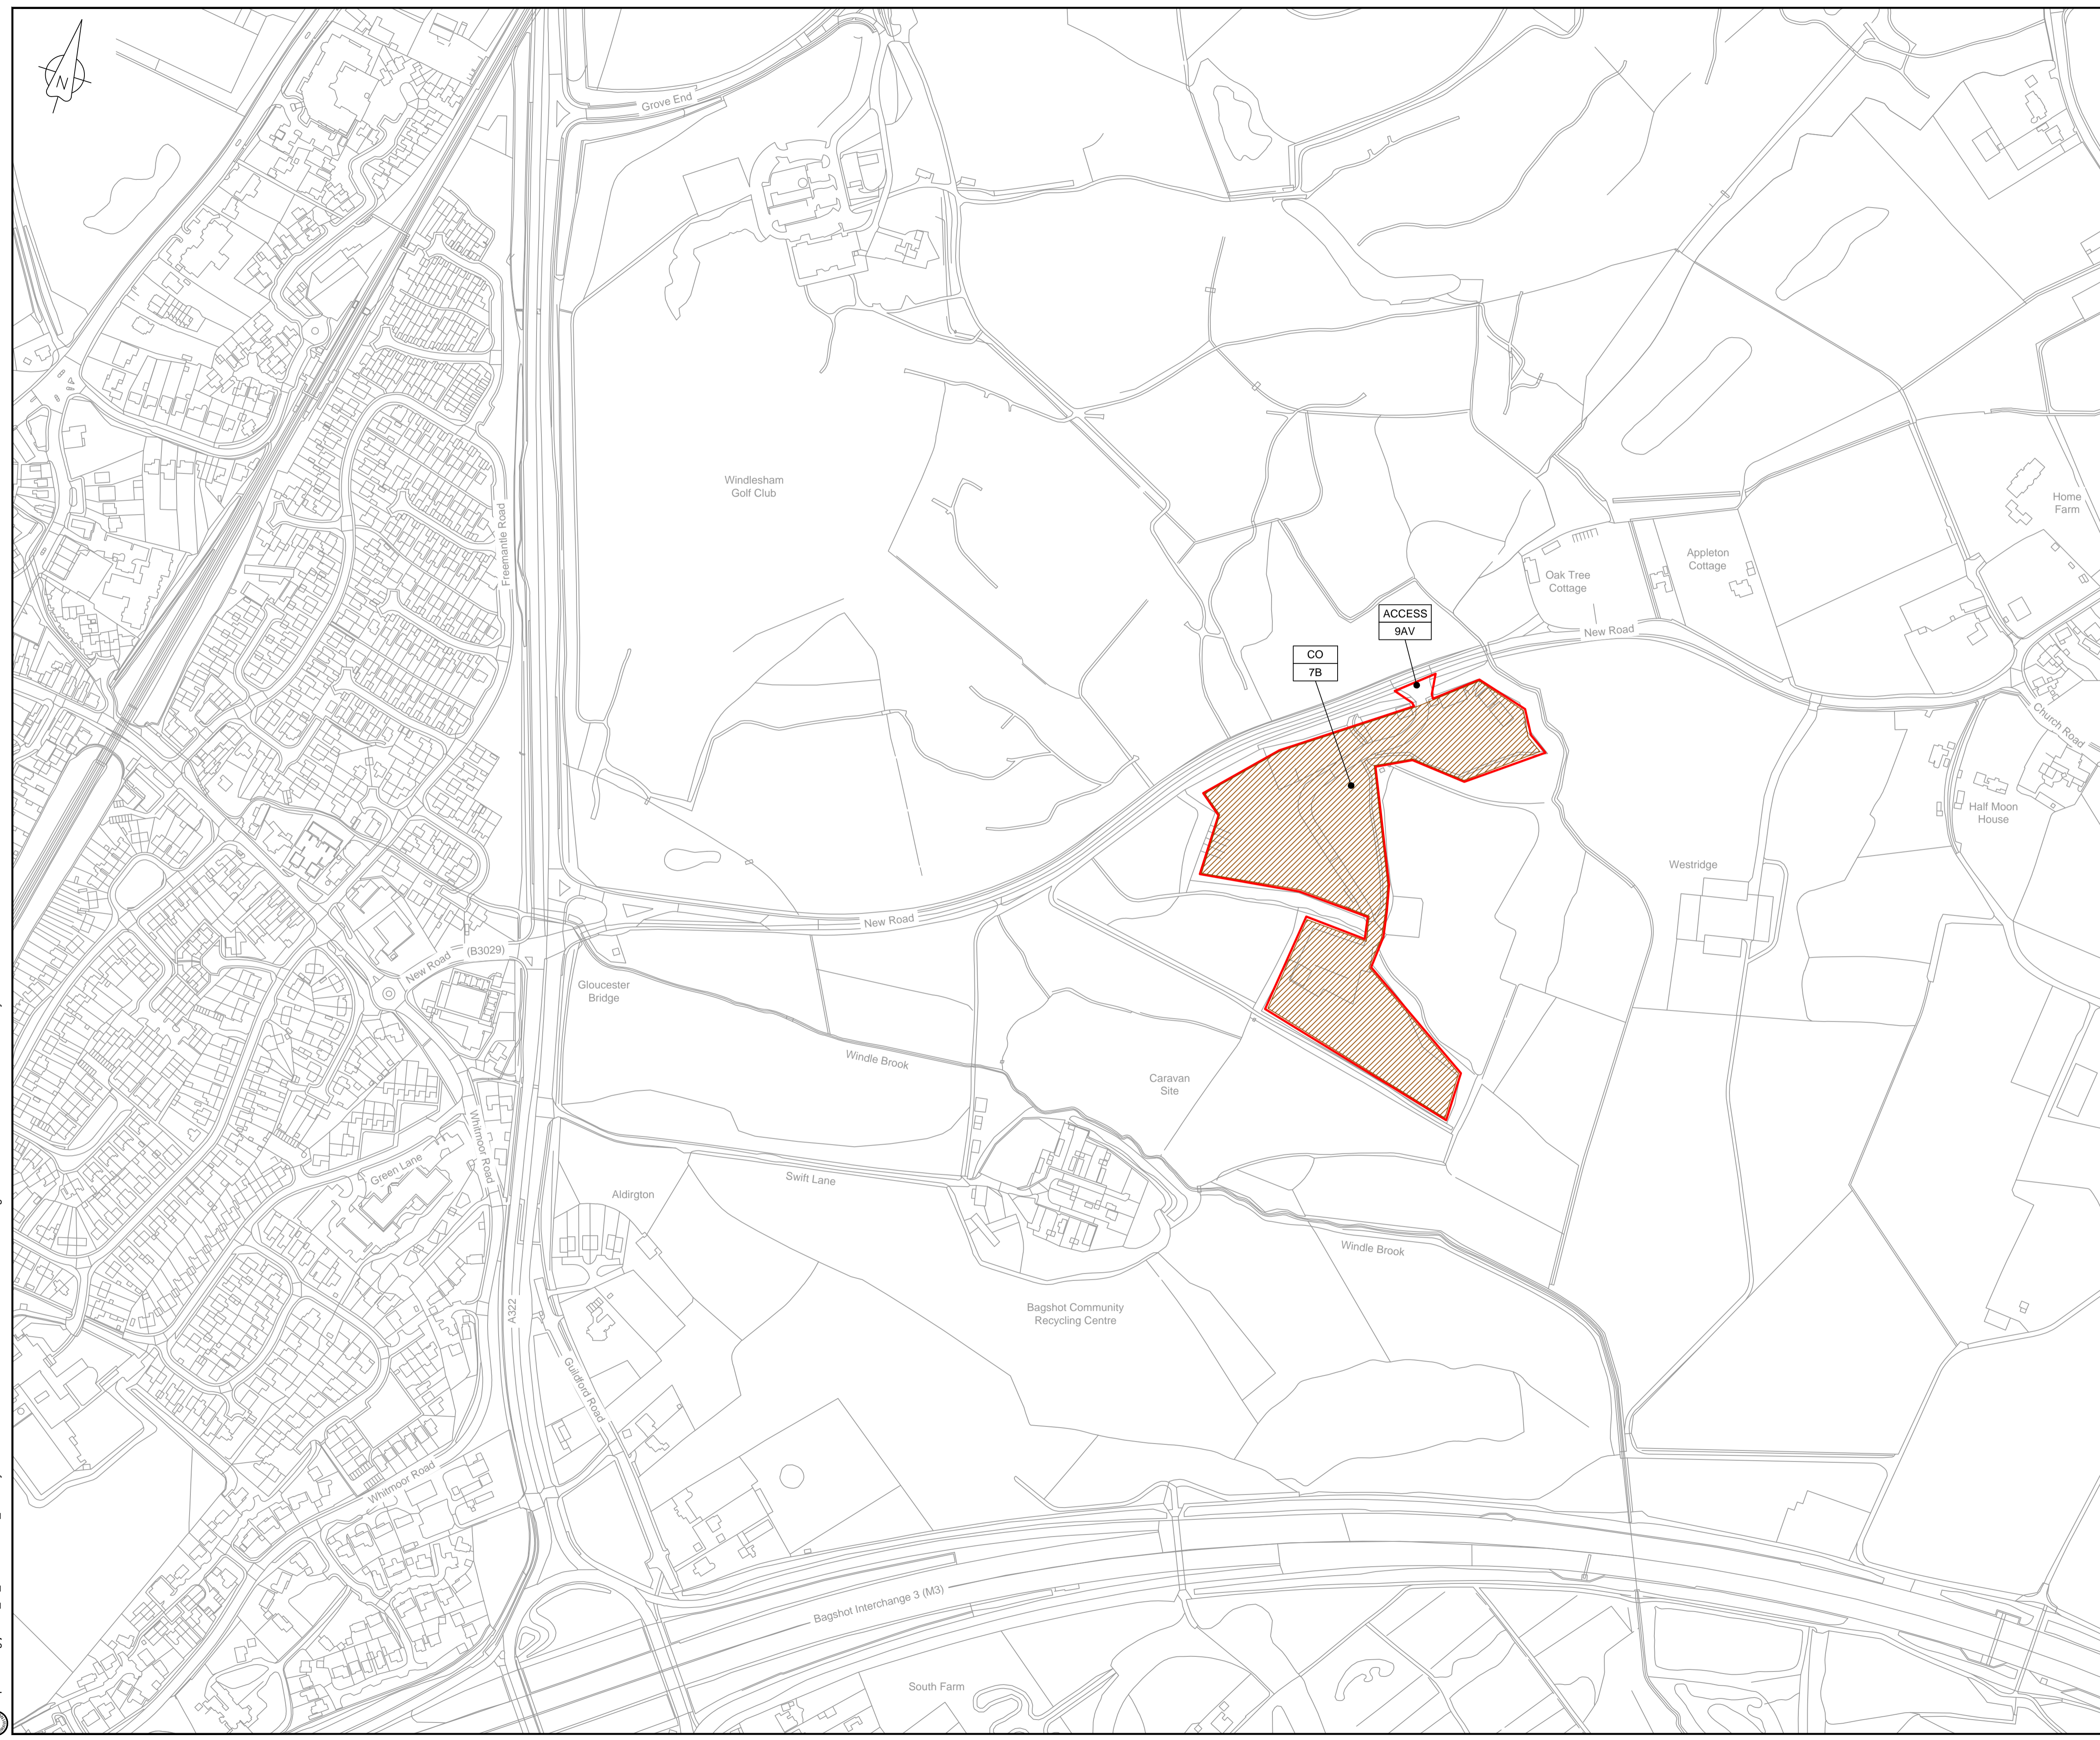

**LOCATION PLAN**  
SCALE 1:500,000

**NOTES**  
1. THIS DRAWING IS IN METRES UNLESS STATED OTHERWISE.

**LEGEND**

	ORDER LIMITS
	LIMITS OF DEVIATION
	COMPOUND (CO)
	ENVIRONMENTAL MITIGATION AREA (EM)
	ABOVE GROUND INSTALLATION (AGI) / VALVE (VA) / PRESSURE TRANSDUCER (PT)
	DESCRIPTION
	ID or WORK NUMBER (if applicable)
	ACCESS TEMPORARY CONSTRUCTION ACCESS
	P-ACCESS PERMANENT ACCESS
	COMMENCEMENT / TERMINATION OF WORKS (COMMENCEMENT = OPEN, TERMINATION = CLOSED)

Contains Ordnance Survey data © Crown copyright and database rights 2019.

© Crown copyright and database rights 2019 OS Licence Number AL100005237.



C02	19/06/19	SHEETS 36 AND 108 REVISED FOLLOWING S51 ADVICE	SH	JA	ND	PH
C03	09/09/19	SHEETS 10, 11 AND 54 REVISED TO WITHDRAW A2B SUB-OPTION	BT	JA	ND	NJ
Rev	Rev. Date	Purpose of revision	Drawn	Checked	Rev'd	Appr'd

**JACOBS**  
1180 Eskdale Road, Winnersh, Wokingham, RG41 5TU  
Tel: +44(0)118 946 7000 Fax: +44(0)118 946 7001  
www.jacobs.com

Client: Esso Petroleum Company, Limited  
Emryn House,  
Emryn Way,  
Leatherhead,  
Surrey,  
KT22 8UX

Project: Southampton to London Pipeline Project

Drawing title: **WORKS PLAN SHEET 57 REGULATION 5 (2)(J)**

Drawing status: **Fit for Stage Approval**


Scale	1:2500	DO NOT SCALE
Jacobs No.	B2325300	Rev
Client no.		<b>C03</b>

Drawing number: **B2325300-JAC-000-CIV-DRG-000067**

© Copyright 2019 Jacobs U.K. Limited. The concepts and information contained in this document are the property of Jacobs. Use or copying of this document in whole or in part without the written permission of Jacobs constitutes an infringement of copyright. Limitation: This drawing has been prepared on behalf of, and for the exclusive use of, the Client, and is subject to, and issued in accordance with, the provisions of the contract between Jacobs and the Client. Jacobs accepts no liability or responsibility whatsoever for, or in respect of, any use of, or reliance upon, this drawing by any third party.

C:\pwworking\jacobs\_uk\_water&utilities\_ssr\lby\ordms33519\B2325300-JAC-000-CIV-DRG-000067.dwg - 10/09/2019 13:39:24 - A1Frame - BTaylor



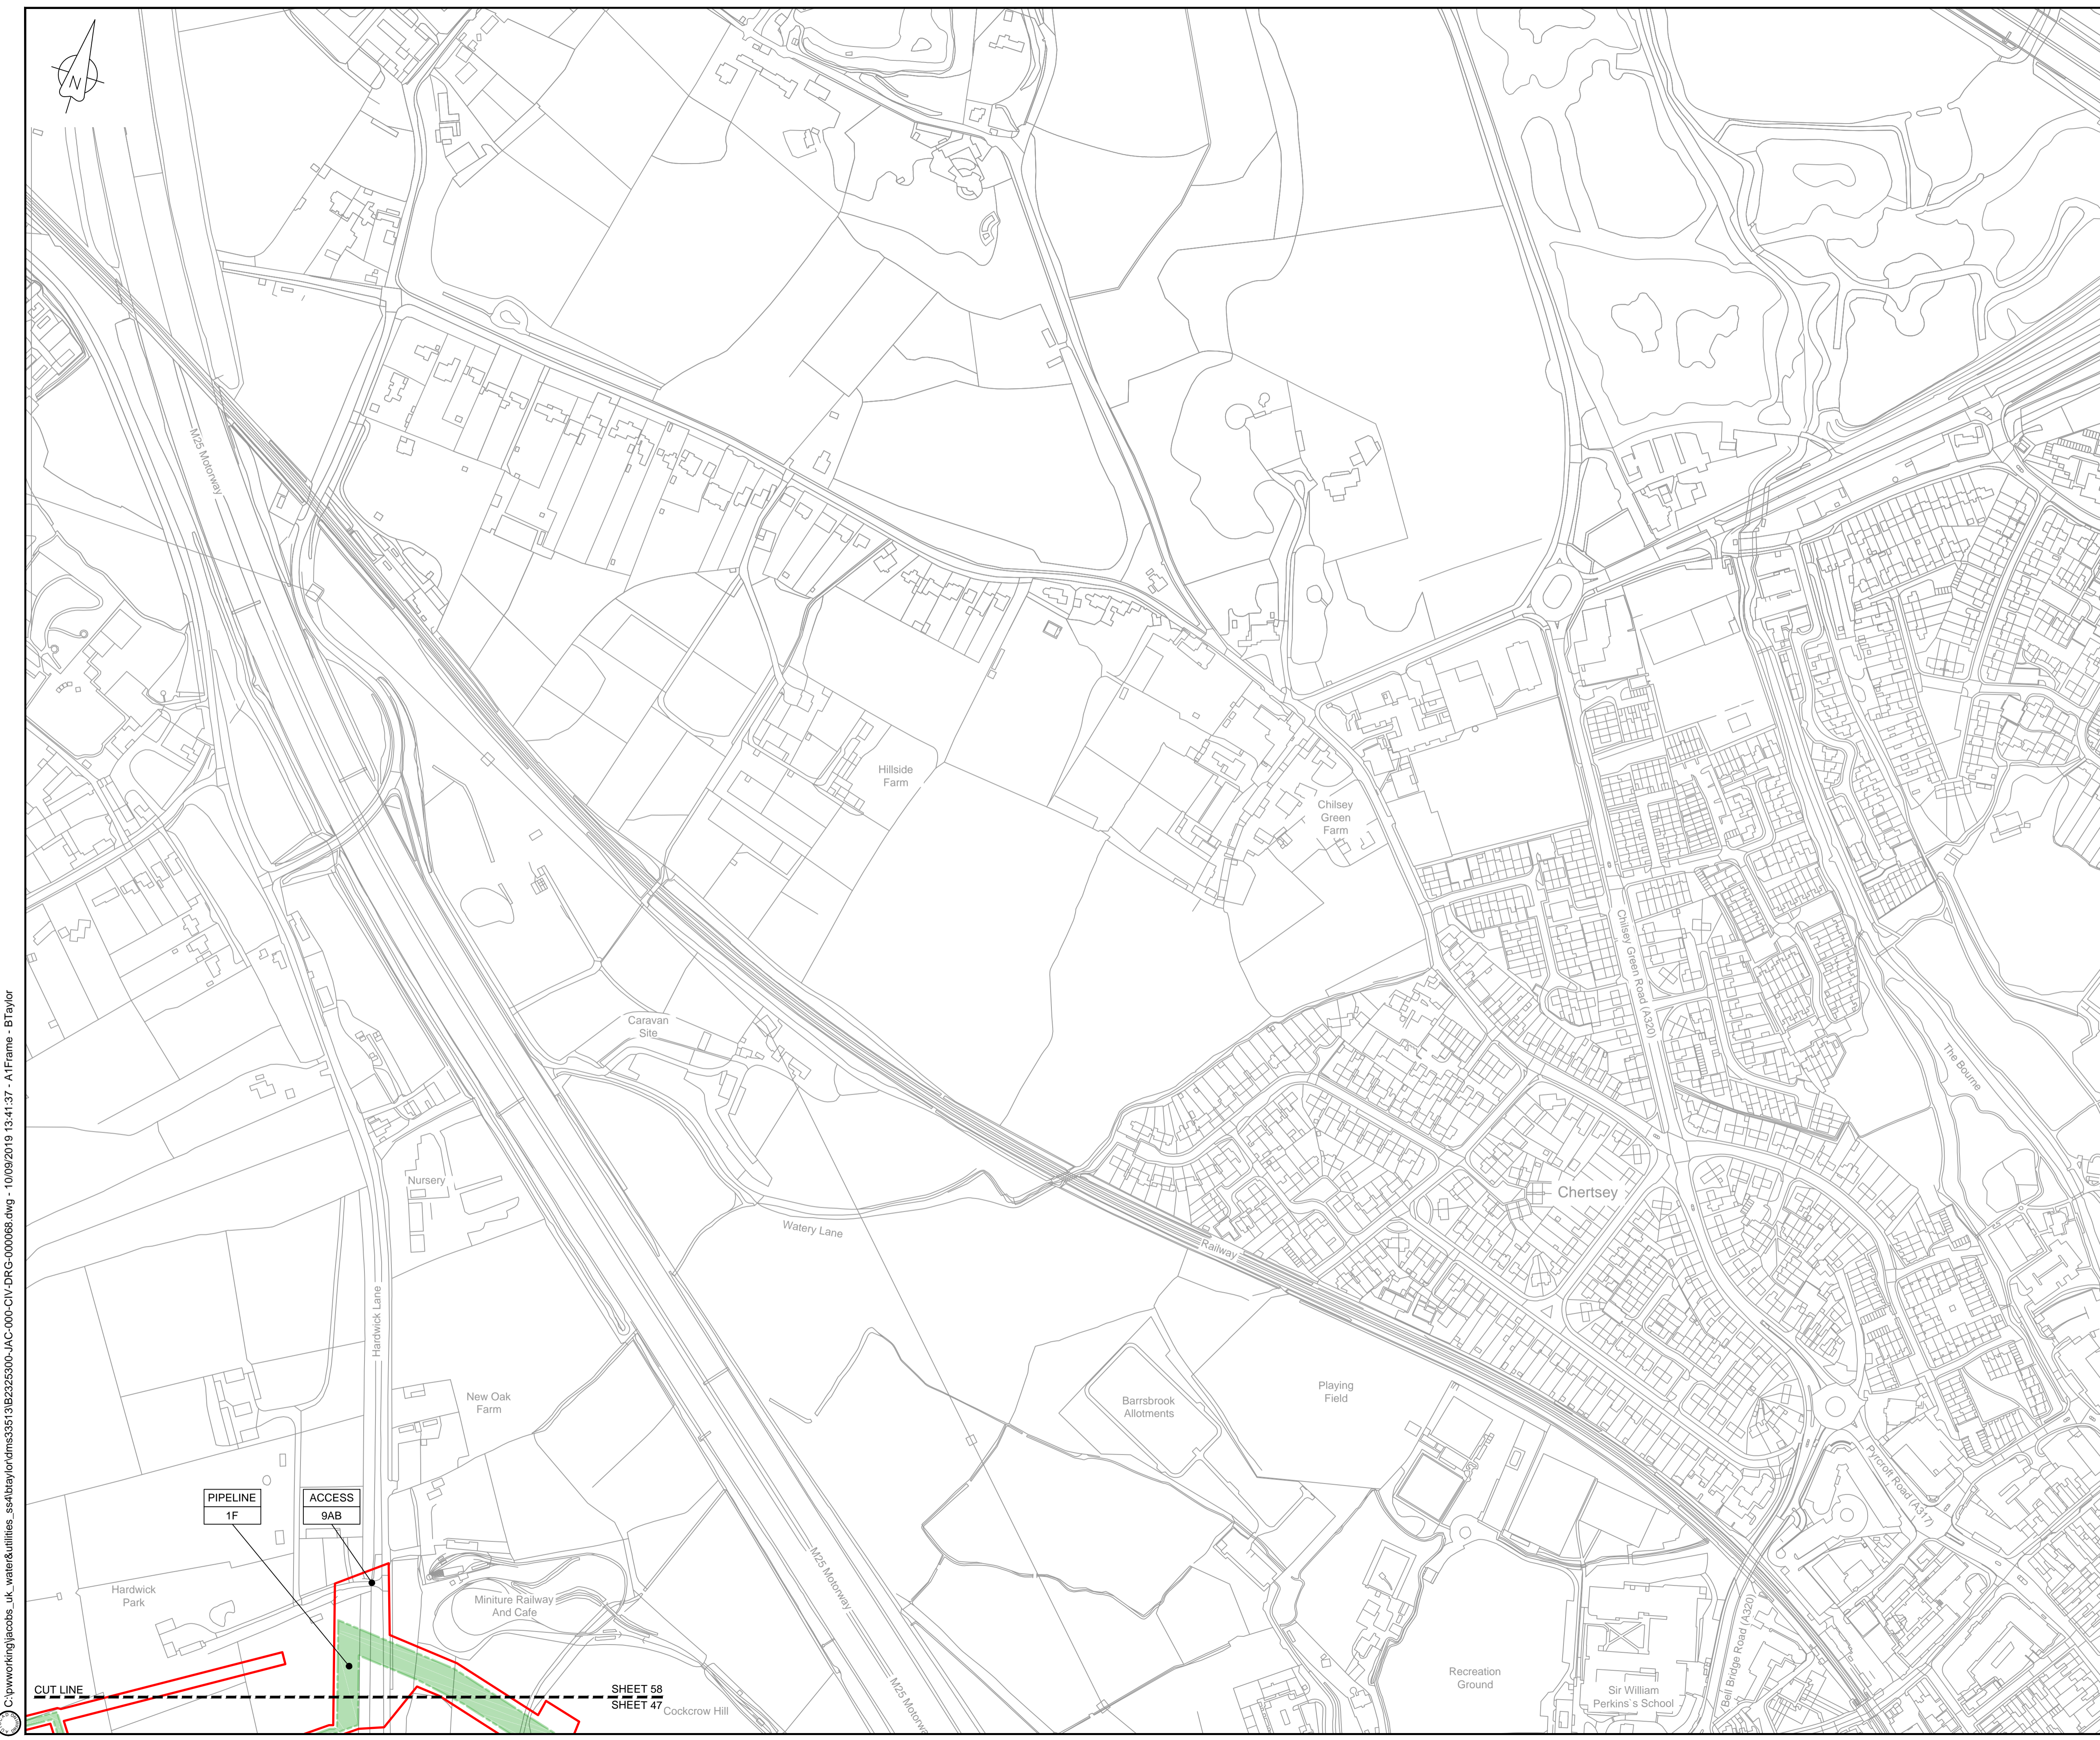

**LOCATION PLAN**  
SCALE 1:500,000

**NOTES**  
1. THIS DRAWING IS IN METRES UNLESS STATED OTHERWISE.

**LEGEND**

	ORDER LIMITS
	LIMITS OF DEVIATION
	COMPOUND (CO)
	ENVIRONMENTAL MITIGATION AREA (EM)
	ABOVE GROUND INSTALLATION (AGI) / VALVE (VA) / PRESSURE TRANSDUCER (PT)
	DESCRIPTION
	ID or WORK NUMBER (if applicable)
	ACCESS TEMPORARY CONSTRUCTION ACCESS
	P-ACCESS PERMANENT ACCESS
	COMMENCEMENT / TERMINATION OF WORKS (COMMENCEMENT = OPEN, TERMINATION = CLOSED)

Contains Ordnance Survey data © Crown copyright and database rights 2019.  
© Crown copyright and database rights 2019 OS Licence Number AL100005237.



C02	19/06/19	SHEETS 35 AND 109 REVISED FOLLOWING SSI ADVICE	SH	JA	ND	PH
C03	09/09/19	SHEETS 10, 11 AND 54 REVISED TO WITHDRAW A2B SUB-OPTION	BT	JA	ND	NJ
Rev	Rev. Date	Purpose of revision	Drawn	Checked	Rev'd	Appr'd

**JACOBS**  
1180 Eskdale Road, Wokingham, Wokingham, RG41 5TU  
Tel:+44(0)118 946 7000 Fax:+44(0)118 946 7001  
www.jacobs.com

Client: Esso Petroleum Company, Limited  
Emryn House,  
Emryn Way,  
Leatherhead,  
Surrey,  
KT22 8UX

Project: Southampton to London Pipeline Project

Drawing title: **WORKS PLAN SHEET 58 REGULATION 5 (2)(J)**


Drawing status: **Fit for Stage Approval**

Scale	1:2500	DO NOT SCALE
Jacobs No.	B2325300	Rev
Client no.		<b>C03</b>

Drawing number: **B2325300-JAC-000-CIV-DRG-000068**  
© Copyright 2019 Jacobs U.K. Limited. The concepts and information contained in this document are the property of Jacobs. Use or copying of this document in whole or in part without the written permission of Jacobs constitutes an infringement of copyright. Limitation: This drawing has been prepared on behalf of, and for the exclusive use of, Jacobs' Client, and is subject to, and issued in accordance with, the provisions of the contract between Jacobs and the Client. Jacobs accepts no liability or responsibility whatsoever for, or in respect of, any use of, or reliance upon, this drawing by any third party.

C:\pwworking\jacobs\_uk\_water\utilities\_ssf\london\dms33513\B2325300-JAC-000-CIV-DRG-000068.dwg - 10/09/2019 13:41:37 - A1Frame - BTaylor

CUT LINE SHEET 58 SHEET 47 Cockcrow Hill

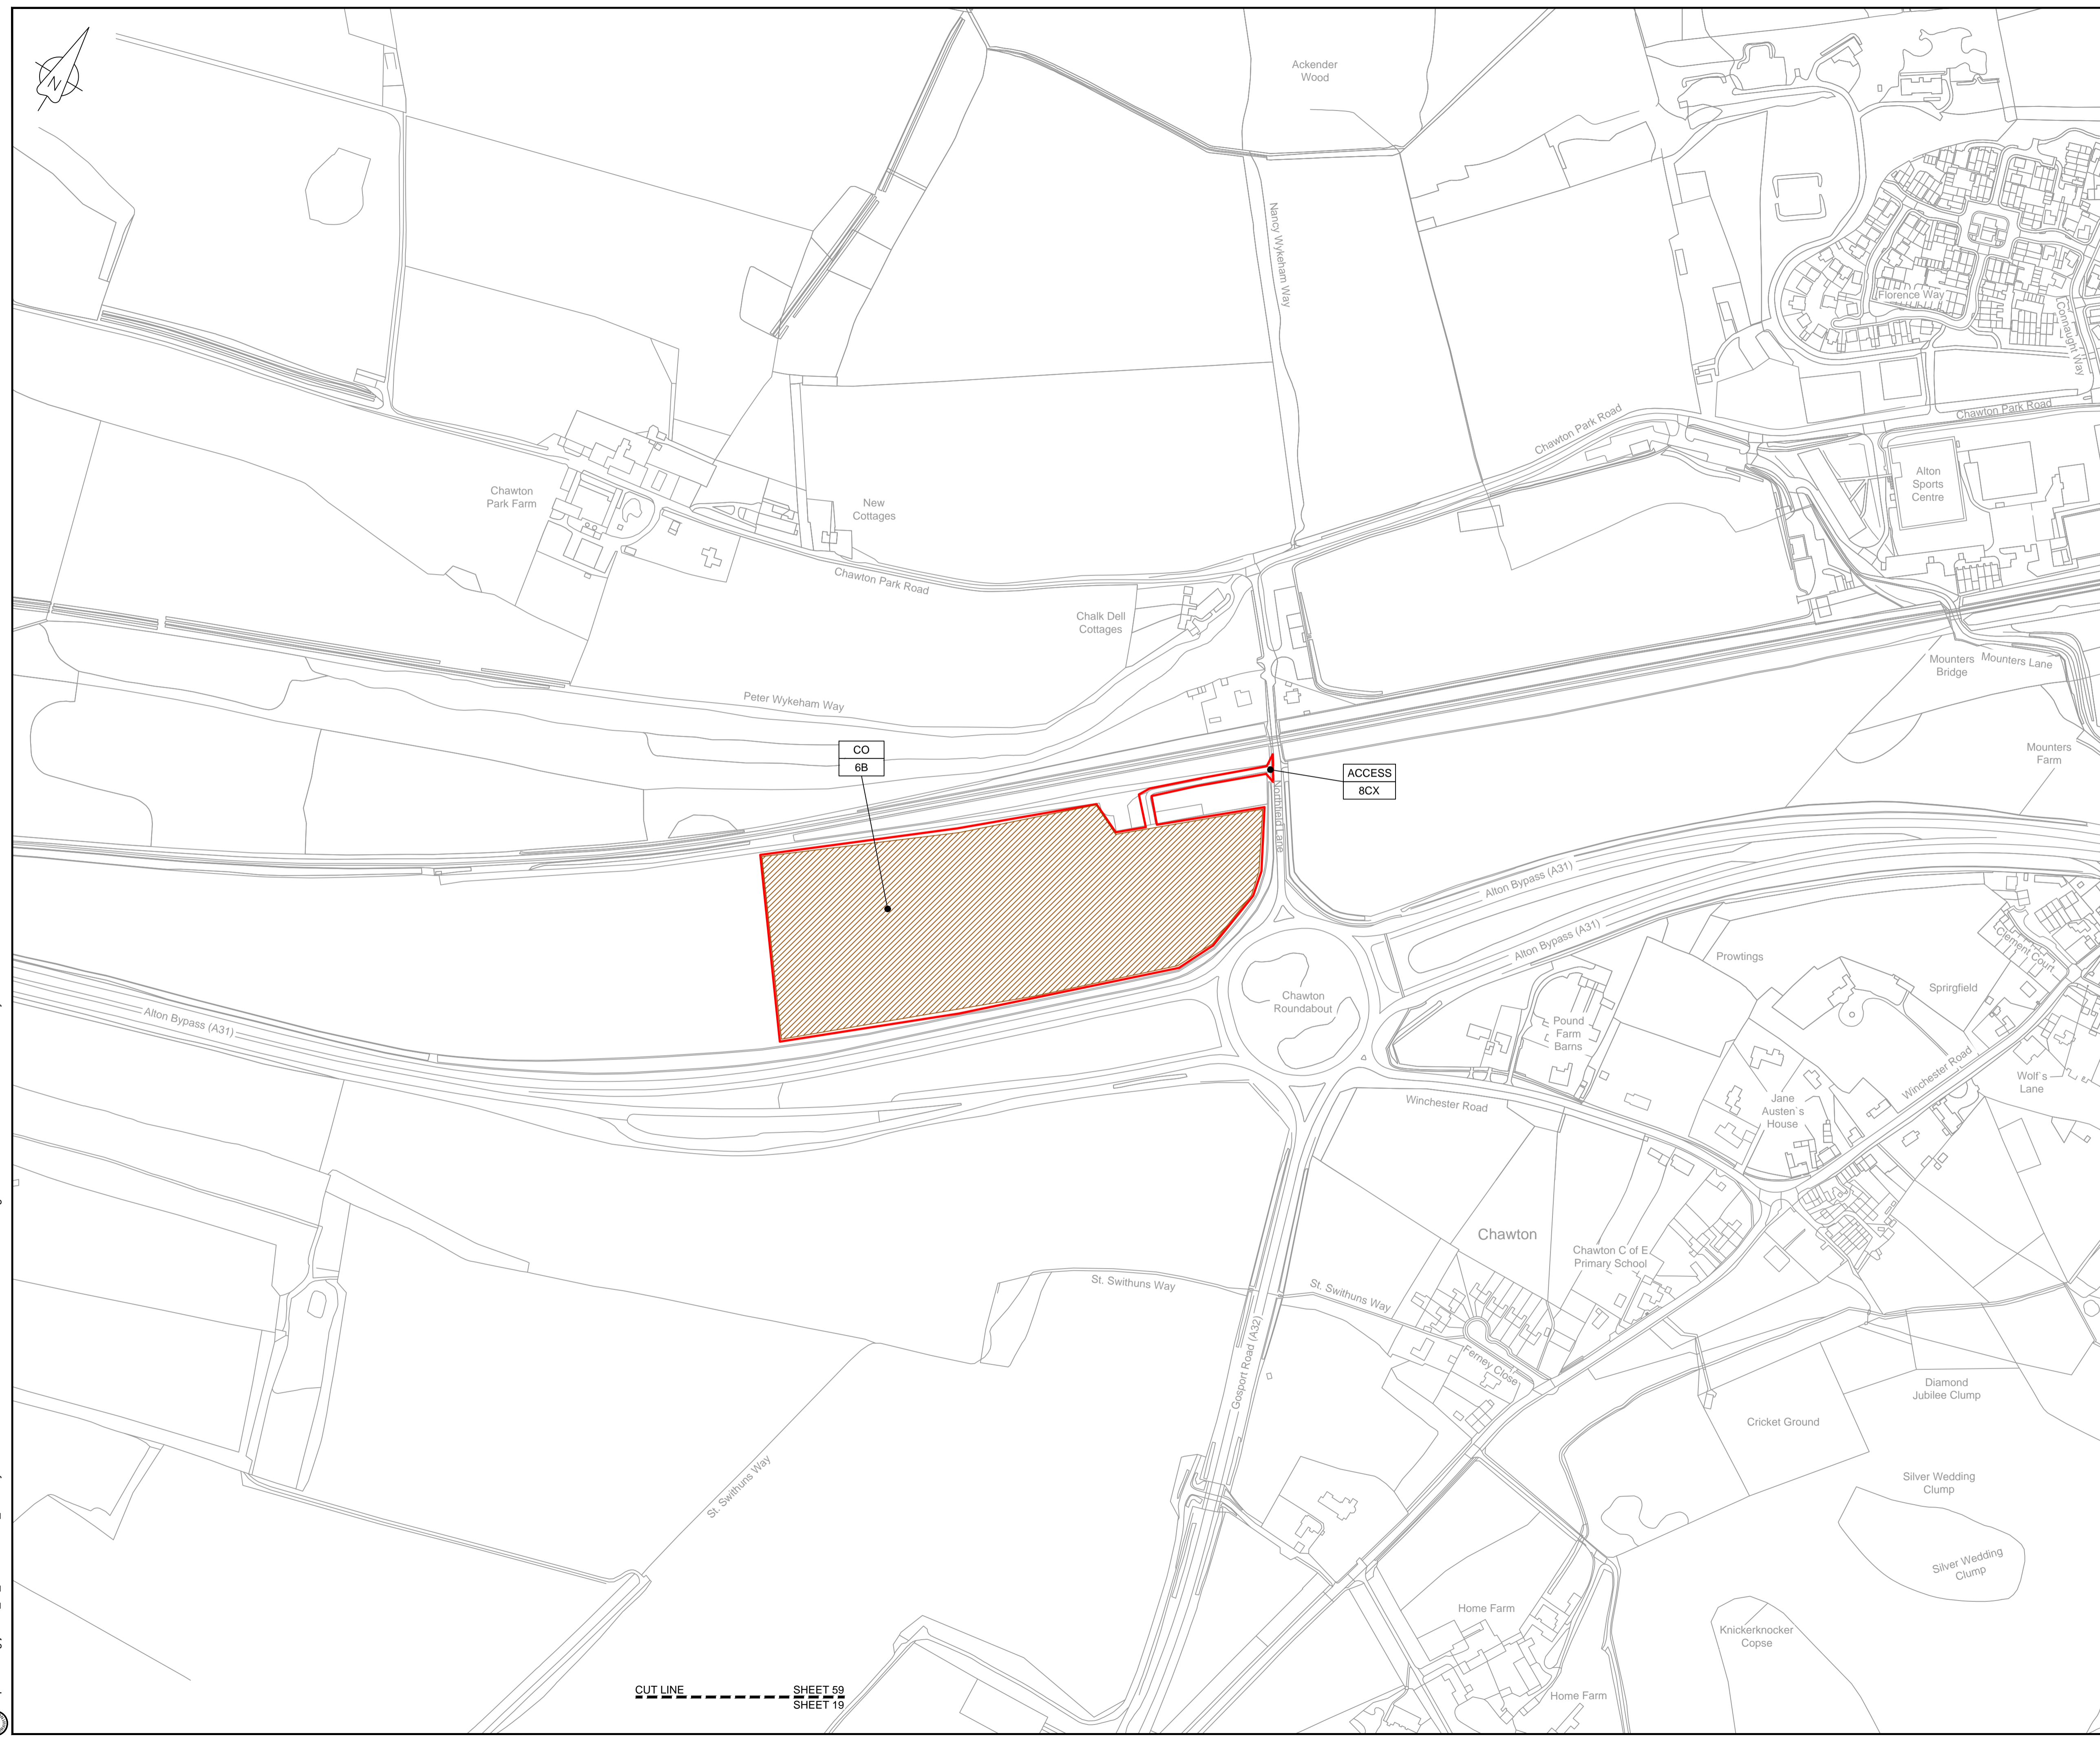

**LOCATION PLAN**  
SCALE 1:500,000

**NOTES**  
1. THIS DRAWING IS IN METRES UNLESS STATED OTHERWISE.

**LEGEND**

	ORDER LIMITS
	LIMITS OF DEVIATION
	COMPOUND (CO)
	ENVIRONMENTAL MITIGATION AREA (EM)
	ABOVE GROUND INSTALLATION (AGI) / VALVE (VA) / PRESSURE TRANSDUCER (PT)
	DESCRIPTION
	ID or WORK NUMBER (if applicable)
	ACCESS
	TEMPORARY CONSTRUCTION ACCESS
	P-ACCESS
	PERMANENT ACCESS
	COMMENCEMENT / TERMINATION OF WORKS (COMMENCEMENT = OPEN, TERMINATION = CLOSED)

Contains Ordnance Survey data © Crown copyright and database rights 2019.

© Crown copyright and database rights 2019 OS Licence Number AL10005237.



Rev	Rev. Date	Purpose of revision	Drawn	Checked	Rev'd	Appr'd
C02	19/06/19	SHEETS 36 AND 109 REVISED FOLLOWING SSI ADVICE	SH	JA	ND	PH
C03	09/09/19	SHEETS 10, 11 AND 54 REVISED TO WITHDRAW A2b SUB-OPTION	BT	JA	ND	NJ

**JACOBS**  
1180 Eskdale Road, Wokingham, Wokingham, RG41 5TU  
Tel: +44(0)118 946 7000 Fax: +44(0)118 946 7001  
www.jacobs.com

Client: Esso Petroleum Company, Limited  
Emryn House,  
Emryn Way,  
Leatherhead,  
Surrey,  
KT22 8UX

Southampton to London Pipeline Project

Drawing title  
**WORKS PLAN  
SHEET 59  
REGULATION 5 (2)(J)**

Drawing status  
**Fit for Stage Approval**


Scale	1:2500	DO NOT SCALE
Jacobs No.	B2325300	Rev
Client no.		<b>C03</b>

Drawing number  
**B2325300-JAC-000-CIV-DRG-000069**

© Copyright 2019 Jacobs U.K. Limited. The concepts and information contained in this document are the property of Jacobs. Use or copying of this document in whole or in part without the written permission of Jacobs constitutes an infringement of copyright. Limitation: This drawing has been prepared on behalf of, and for the exclusive use of, the Client. Jacobs accepts no liability or responsibility whatsoever for, or in respect of, any use of, or reliance upon, this drawing by any third party.

C:\pwworking\jacobs\_uk\_water&utilities\_ssf\london\dms33519B2325300-JAC-000-CIV-DRG-000069.dwg - 10/09/2019 13:42:56 - A1Frame - BTaylor

CUT LINE  
SHEET 59  
SHEET 19

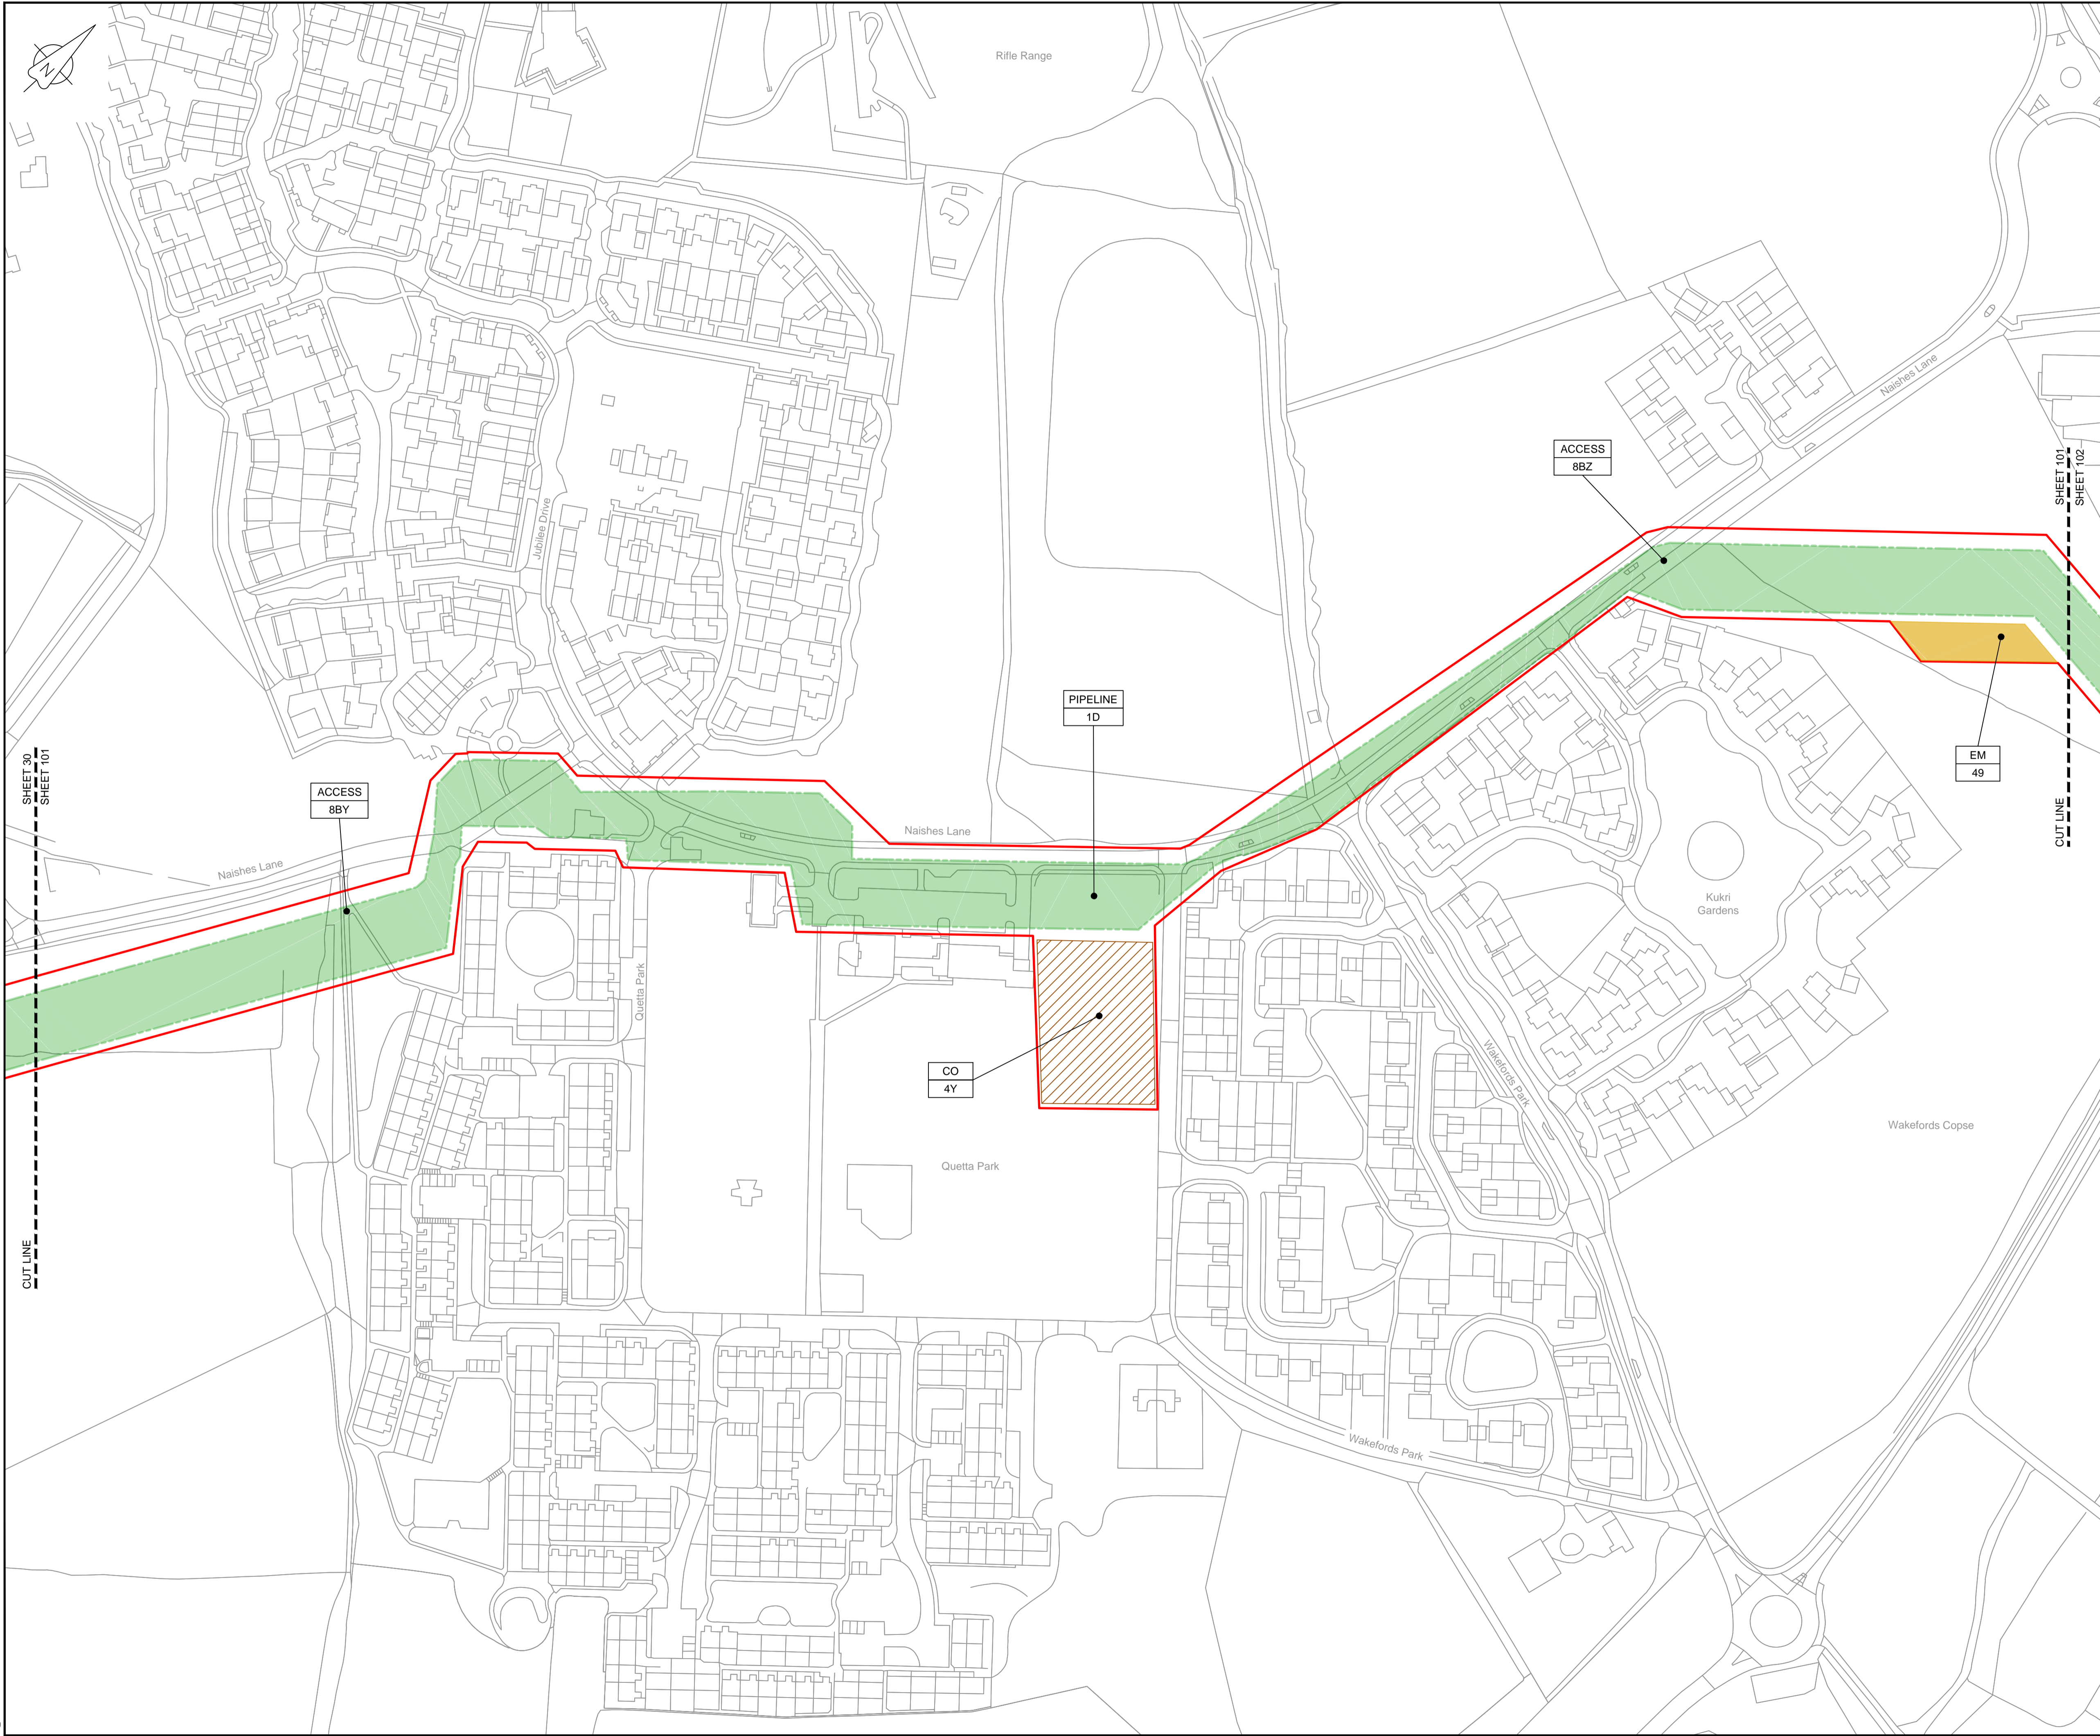

**LOCATION PLAN**  
SCALE 1:500,000

**NOTES**  
1. THIS DRAWING IS IN METRES UNLESS STATED OTHERWISE.

**LEGEND**

	ORDER LIMITS
	LIMITS OF DEVIATION
	COMPOUND (CO)
	ENVIRONMENTAL MITIGATION AREA (EM)
	ABOVE GROUND INSTALLATION (AGI) / VALVE (VA) / PRESSURE TRANSDUCER (PT)
	DESCRIPTION
	ID or WORK NUMBER (if applicable)
	ACCESS
	TEMPORARY CONSTRUCTION ACCESS
	PERMANENT ACCESS
	COMMENCEMENT / TERMINATION OF WORKS (COMMENCEMENT = OPEN, TERMINATION = CLOSED)

Contains Ordnance Survey data © Crown copyright and database rights 2019.  
© Crown copyright and database rights 2019 OS Licence Number AL10005237.



C02	14/06/19	SHEETS 35 AND 109 REVISED FOLLOWING SSI ADVICE	SH	JA	ND	PH
C03	09/09/19	SHEETS 10, 11 AND 54 REVISED TO WITHDRAW A2B SUB-OPTION	BT	JA	ND	NJ
Rev	Rev. Date	Purpose of revision	Drawn	Checked	Rev'd	Appr'd

**JACOBS**  
1180 Eskdale Road, Wokingham, Wokingham, RG41 5TU  
Tel:+44(0)118 946 7000 Fax:+44(0)118 946 7001  
www.jacobs.com

Client: Esso Petroleum Company, Limited  
Emryn House,  
Emryn Way,  
Leatherhead,  
Surrey,  
KT22 8UX

Project: Southampton to London Pipeline Project


Drawing title: **WORKS PLAN SHEET 101 REGULATION 5 (2)(J)**

Drawing status: **Fit for Stage Approval**

Scale	1:1250	DO NOT SCALE
Jacobs No.	B2325300	Rev
Client no.		<b>C03</b>

Drawing number: **B2325300-JAC-000-CIV-DRG-000101**

© Copyright 2019 Jacobs U.K. Limited. The concepts and information contained in this document are the property of Jacobs. Use or copying of this document in whole or in part without the written permission of Jacobs constitutes an infringement of copyright. Limitation: This drawing has been prepared on behalf of, and for the exclusive use of, the Client, and is subject to, and issued in accordance with, the provisions of the contract between Jacobs and the Client. Jacobs accepts no liability or responsibility whatsoever for, or in respect of, any use of, or reliance upon, this drawing by any third party.

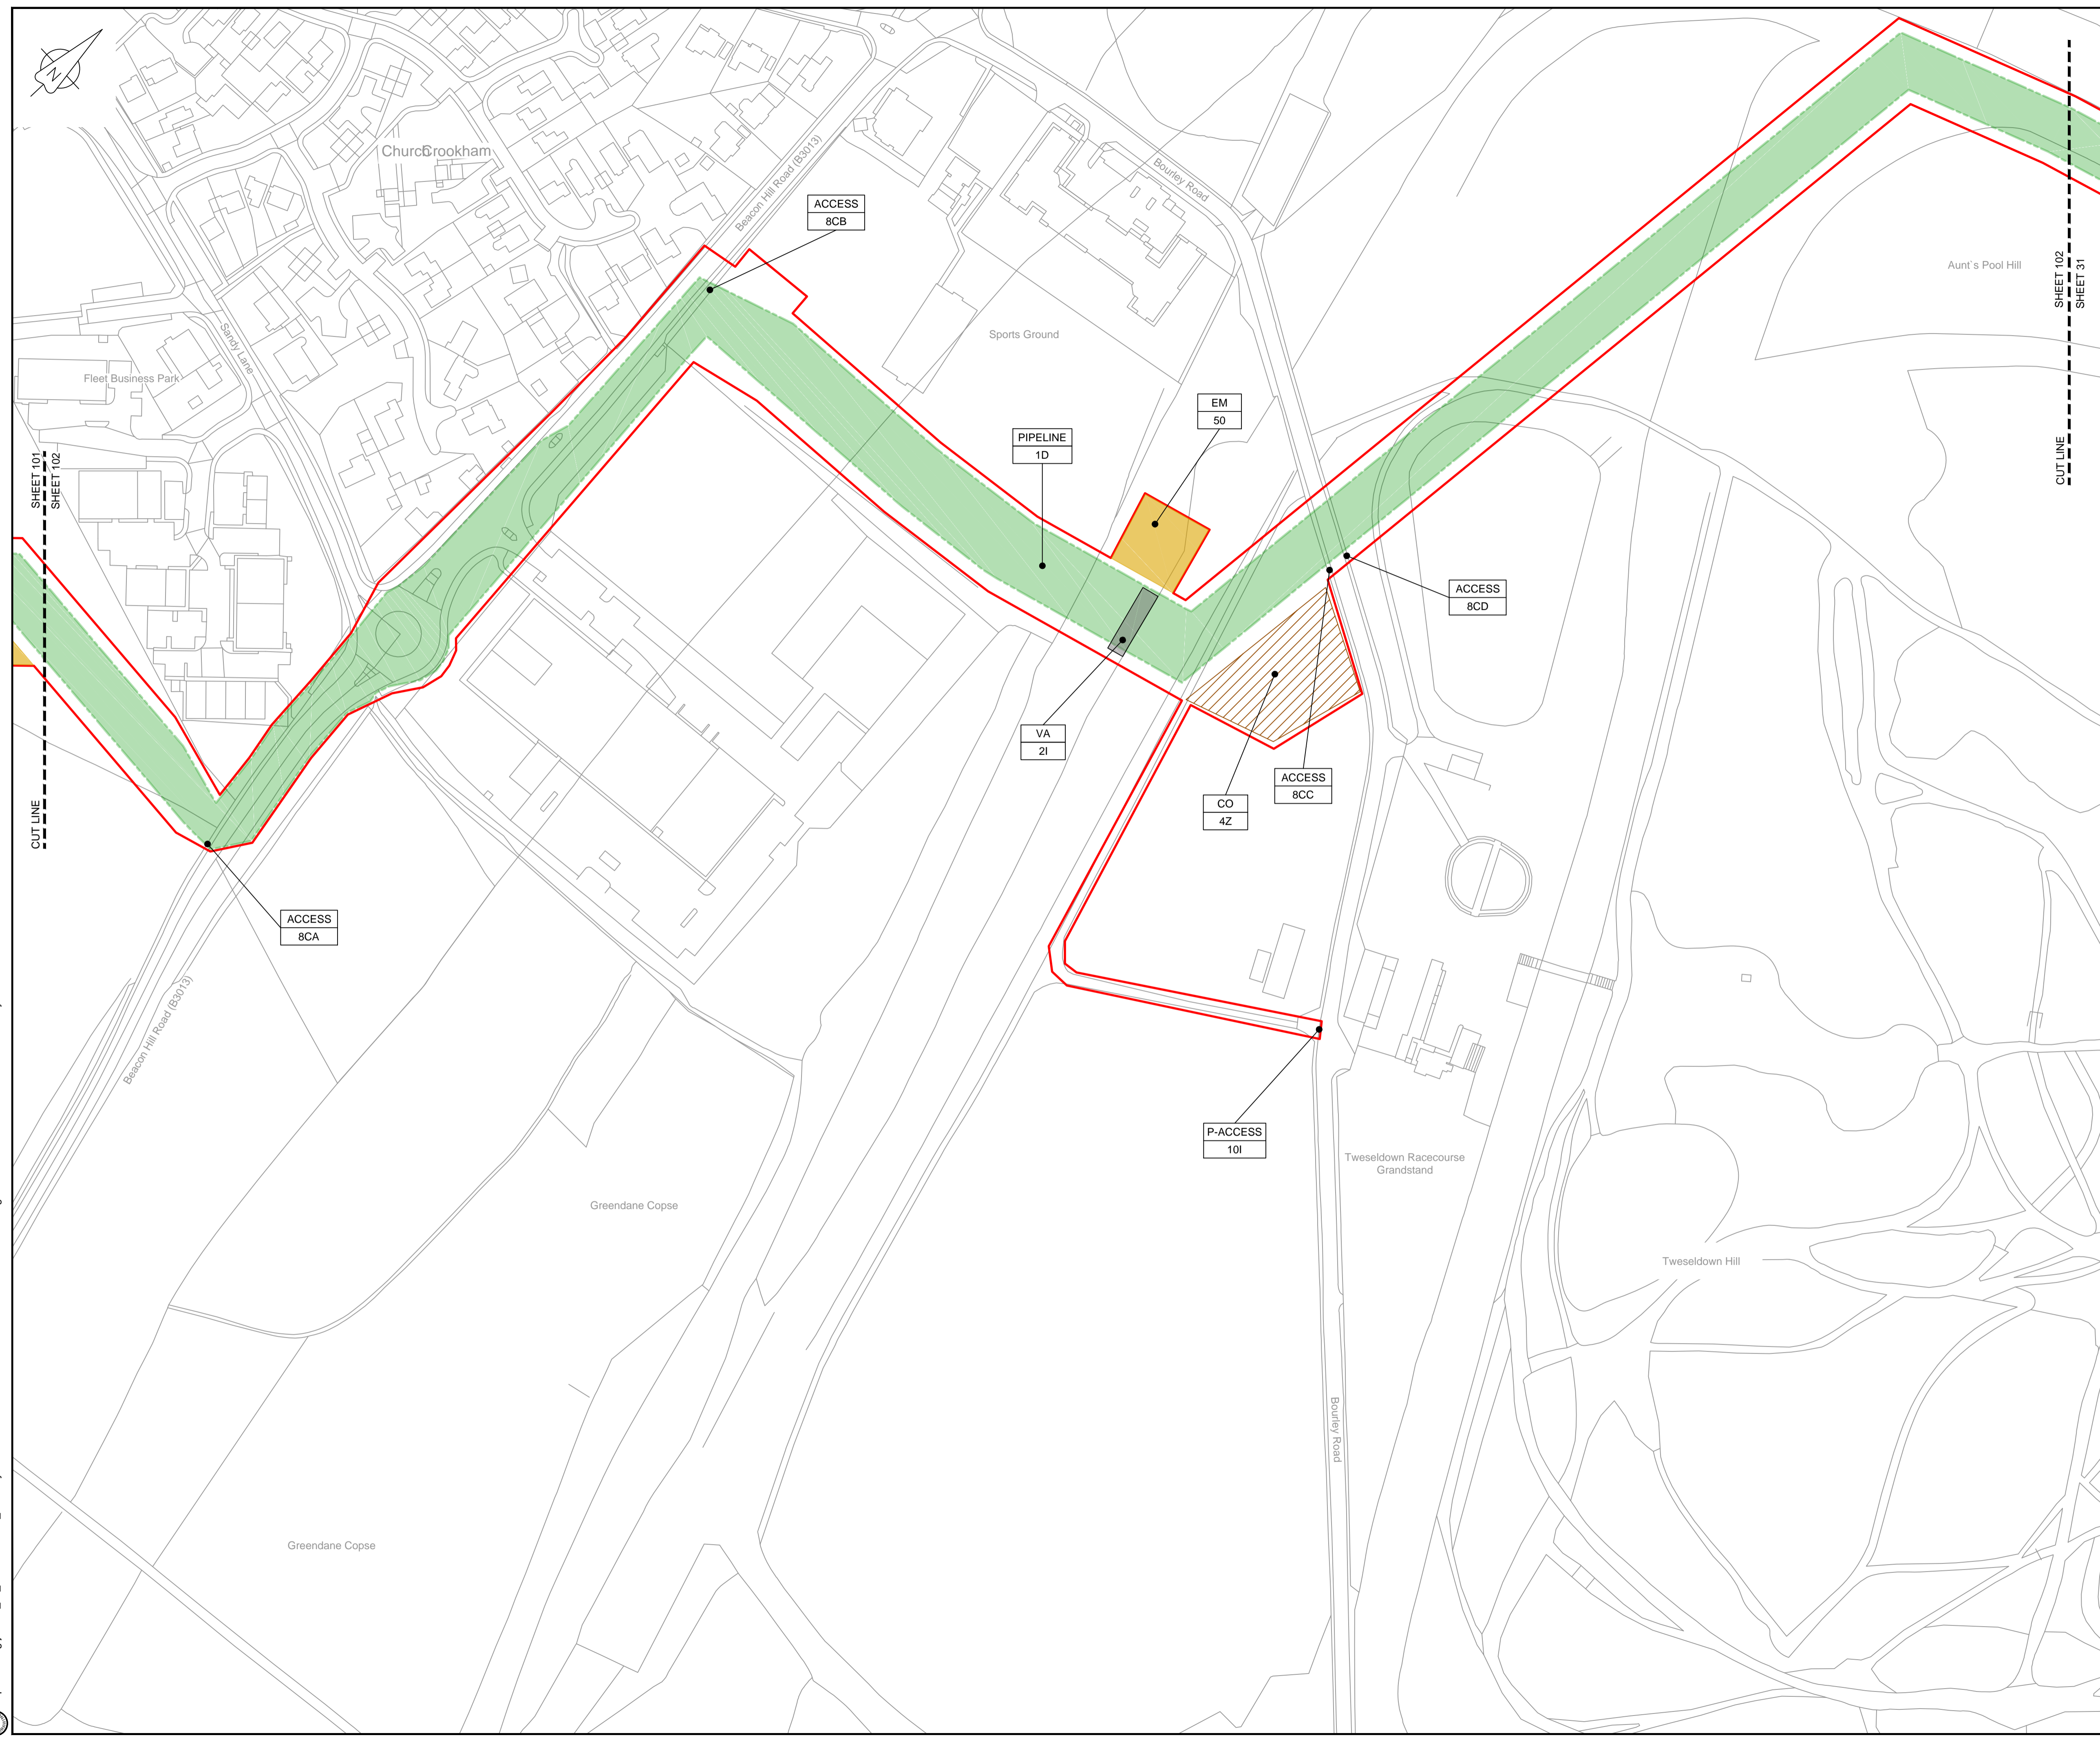


**LOCATION PLAN**  
SCALE 1:500,000

**NOTES**  
1. THIS DRAWING IS IN METRES UNLESS STATED OTHERWISE.

**LEGEND**

	ORDER LIMITS
	LIMITS OF DEVIATION
	COMPOUND (CO)
	ENVIRONMENTAL MITIGATION AREA (EM)
	ABOVE GROUND INSTALLATION (AGI) / VALVE (VA) / PRESSURE TRANSDUCER (PT)
	DESCRIPTION
	ID or WORK NUMBER (if applicable)
	ACCESS
	TEMPORARY CONSTRUCTION ACCESS
	P-ACCESS
	PERMANENT ACCESS
	COMMENCEMENT / TERMINATION OF WORKS (COMMENCEMENT = OPEN, TERMINATION = CLOSED)

Contains Ordnance Survey data © Crown copyright and database rights 2019.  
© Crown copyright and database rights 2019 OS Licence Number AL100005237.

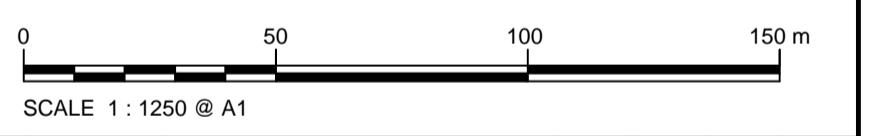

Rev	Rev. Date	Purpose of revision	Drawn	Checked	Rev'd	Appr'd
C02	14/06/19	SHEETS 38 AND 109 REVISED FOLLOWING SSI ADVICE	SH	JA	ND	PH
C03	09/09/19	SHEETS 10, 11 AND 54 REVISED TO WITHDRAW A2B SUB-OPTION	BT	JA	ND	NJ



1180 Eskdale Road, Wokingham, Wokingham, RG41 5TU  
Tel: +44(0)118 946 7000 Fax: +44(0)118 946 7001  
www.jacobs.com

Client: Esso Petroleum Company, Limited  
Ermyn House,  
Ermyn Way,  
Leatherhead,  
Surrey,  
KT22 8UX



Drawing title  
**WORKS PLAN  
SHEET 102  
REGULATION 5 (2)(J)**

Drawing status  
**Fit for Stage Approval**

Scale	1:1250	DO NOT SCALE
Jacobs No.	B2325300	Rev
Client no.		<b>C03</b>

Drawing number  
**B2325300-JAC-000-CIV-DRG-000102**

© Copyright 2019 Jacobs U.K. Limited. The concepts and information contained in this document are the property of Jacobs. Use or copying of this document in whole or in part without the written permission of Jacobs constitutes an infringement of copyright. Limitation. This drawing has been prepared on behalf of, and for the exclusive use of, the Client, and is subject to, and issued in accordance with, the provisions of the contract between Jacobs and the Client. Jacobs accepts no liability or responsibility whatsoever for, or in respect of, any use of, or reliance upon, this drawing by any third party.




**LOCATION PLAN**  
SCALE 1:500,000

**NOTES**  
1. THIS DRAWING IS IN METRES UNLESS STATED OTHERWISE.

**LEGEND**

	ORDER LIMITS
	LIMITS OF DEVIATION
	COMPOUND (CO)
	ENVIRONMENTAL MITIGATION AREA (EM)
	ABOVE GROUND INSTALLATION (AGI) / VALVE (VA) / PRESSURE TRANSDUCER (PT)
	DESCRIPTION
	ID or WORK NUMBER (if applicable)
	ACCESS
	TEMPORARY CONSTRUCTION ACCESS
	PERMANENT ACCESS
	COMMENCEMENT / TERMINATION OF WORKS (COMMENCEMENT = OPEN, TERMINATION = CLOSED)

Contains Ordnance Survey data © Crown copyright and database rights 2019.  
© Crown copyright and database rights 2019 OS Licence Number AL10005237.

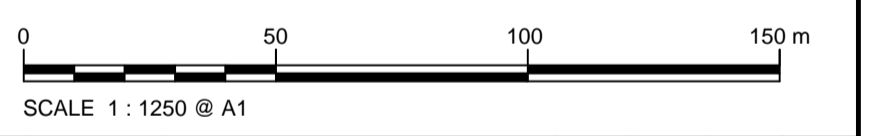

Rev	Rev. Date	Purpose of revision	Drawn	Checked	Rev'd	Appr'd
C02	14/06/19	SHEETS 35 AND 109 REVISED FOLLOWING SSI ADVICE	SH	JA	ND	PH
C03	09/09/19	SHEETS 10, 11 AND 54 REVISED TO WITHDRAW A2B SUB-OPTION	BT	JA	ND	NJ

**JACOBS**

1180 Eskdale Road, Wokingham, Wokingham, RG41 5TU  
Tel: +44(0)118 946 7000 Fax: +44(0)118 946 7001  
www.jacobs.com

Client: Esso Petroleum Company, Limited  
Ermyn House,  
Ermyn Way,  
Leatherhead,  
Surrey,  
KT22 8UX




Drawing title  
**WORKS PLAN  
SHEET 103  
REGULATION 5 (2)(J)**

Drawing status  
**Fit for Stage Approval**

Scale: 1:1250 DO NOT SCALE  
Jacobs No. B2325300 Rev. C03  
Client no.

Drawing number  
**B2325300-JAC-000-CIV-DRG-000103**

© Copyright 2019 Jacobs U.K. Limited. The concepts and information contained in this document are the property of Jacobs. Use or copying of this document in whole or in part without the written permission of Jacobs constitutes an infringement of copyright. Limitation: This drawing has been prepared on behalf of, and for the exclusive use of, the Client, and is subject to, and issued in accordance with, the provisions of the contract between Jacobs and the Client. Jacobs accepts no liability or responsibility whatsoever for, or in respect of, any use of, or reliance upon, this drawing by any third party.

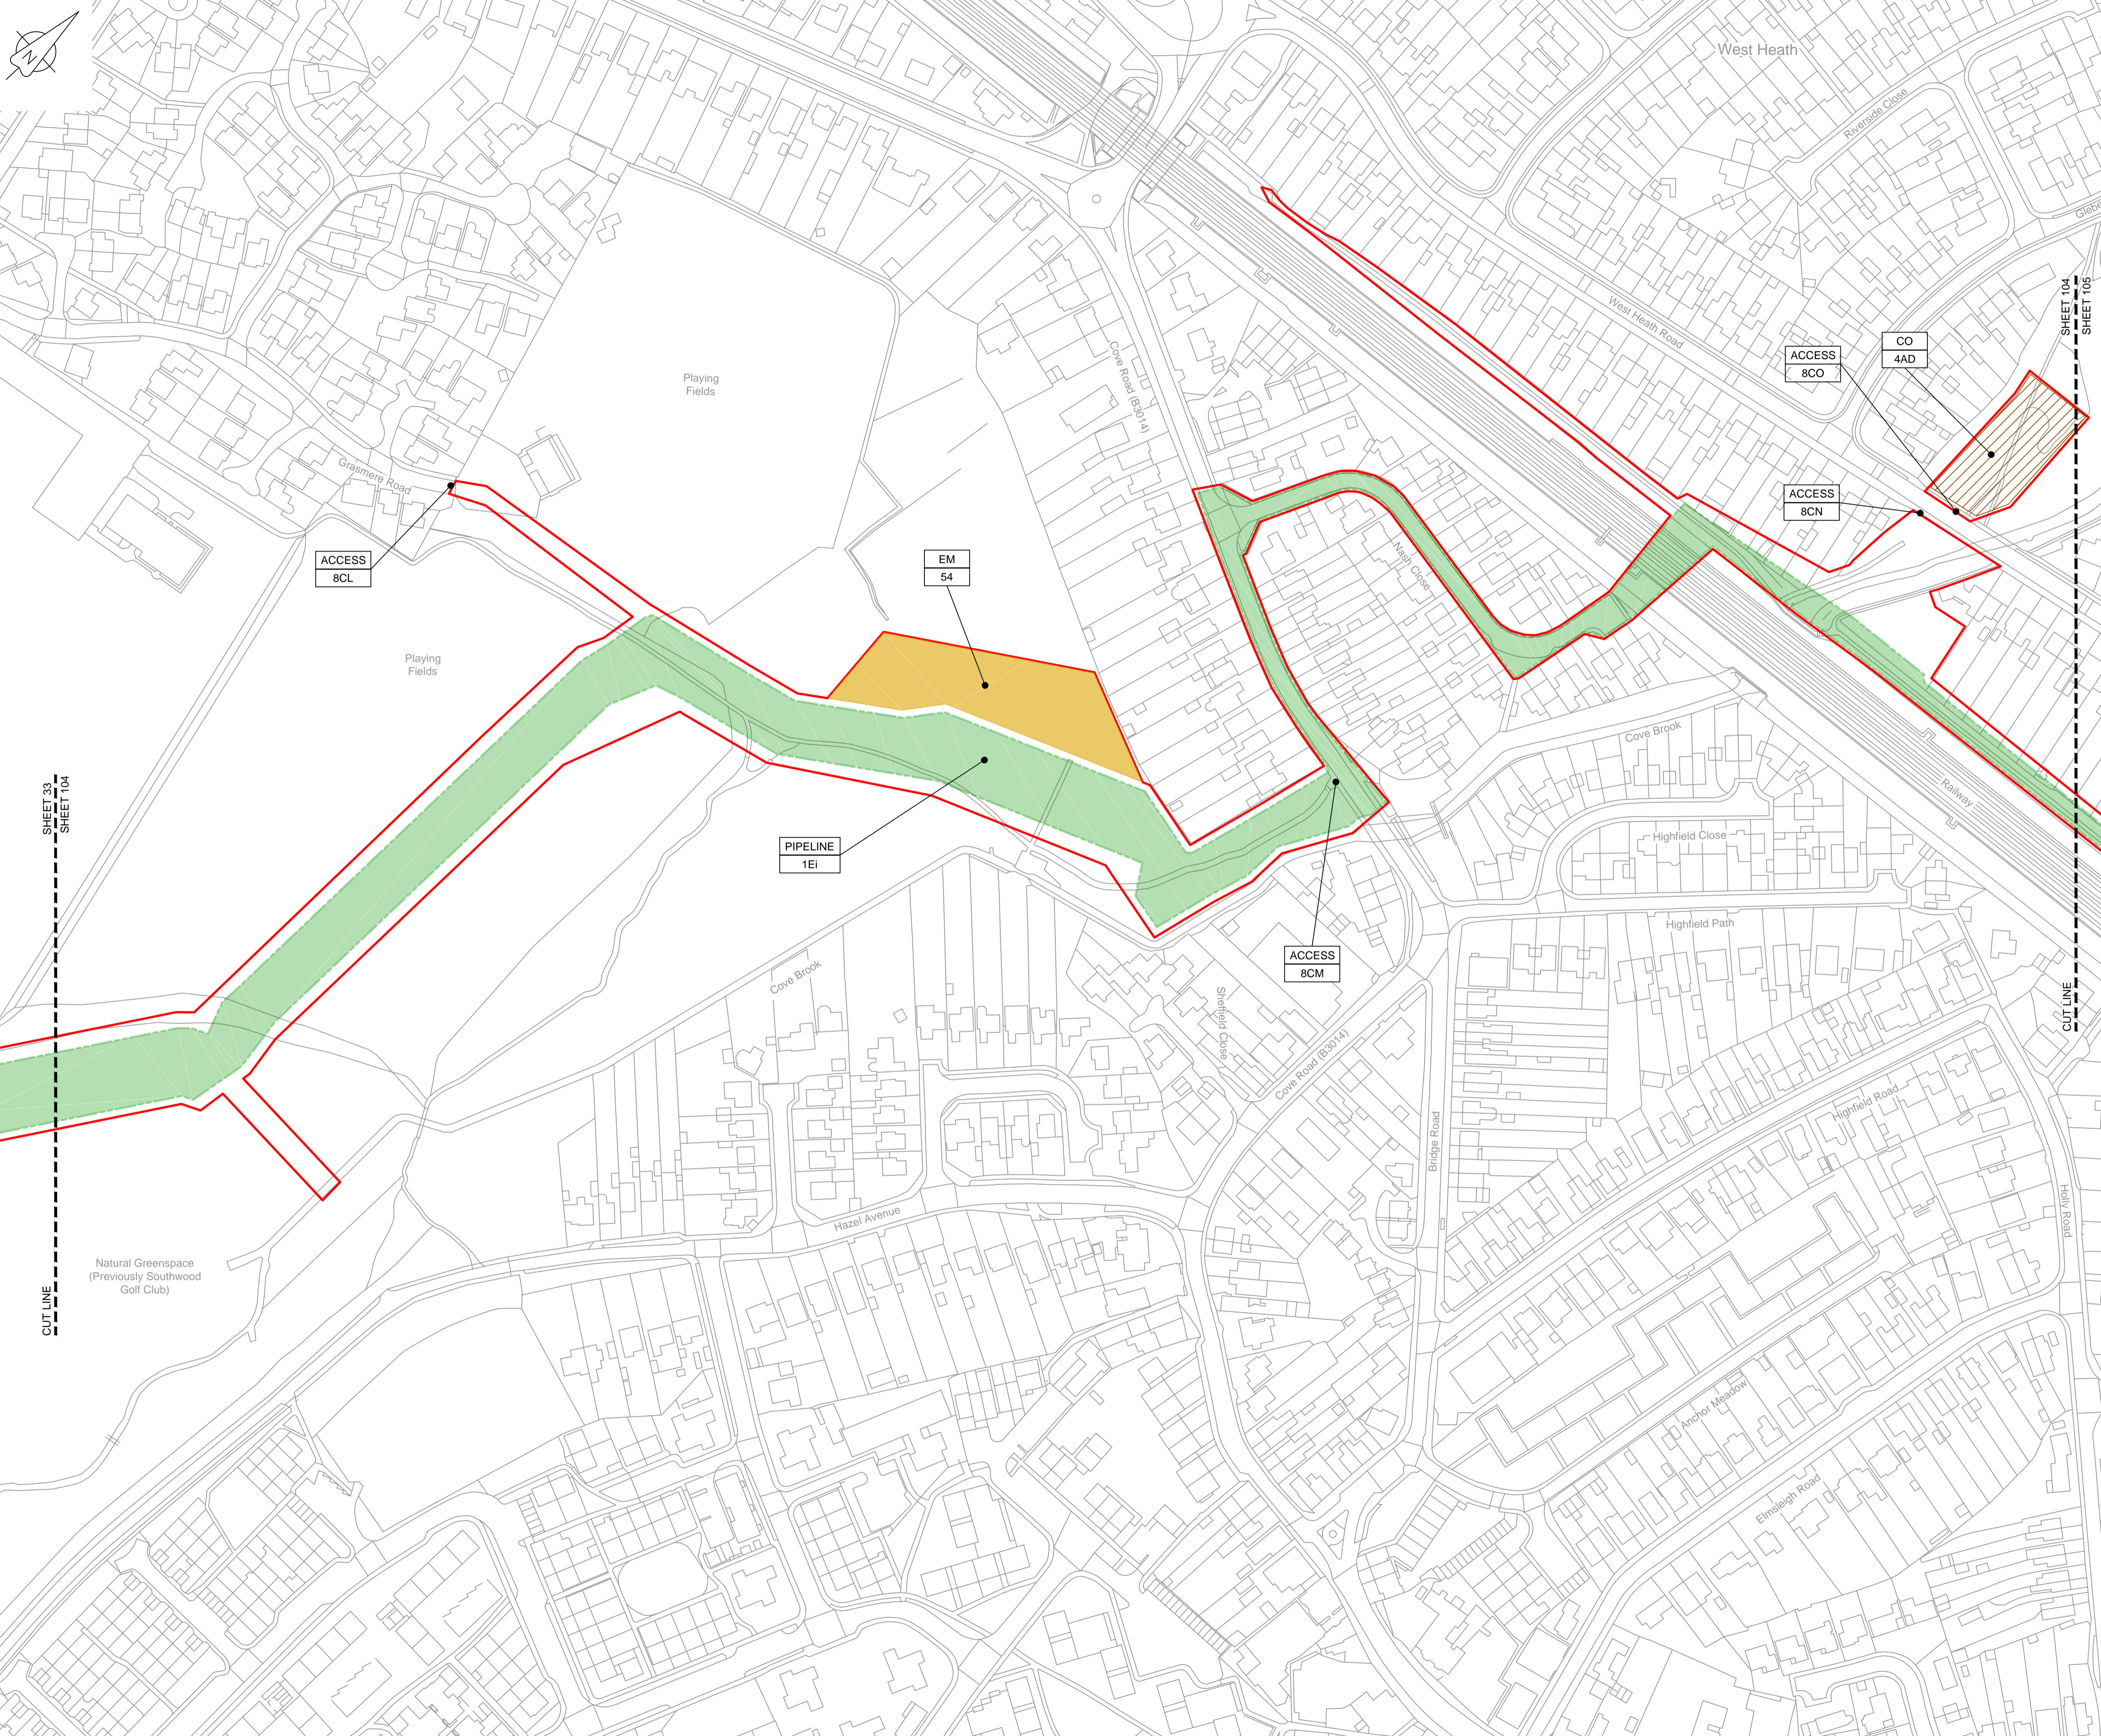

LOCATION PLAN  
SCALE 1:500,000

NOTES  
1. THIS DRAWING IS IN METRES UNLESS STATED OTHERWISE.

- LEGEND
- ORDER LIMITS
  - LIMITS OF DEVIATION
  - COMPOUND (CO)
  - ENVIRONMENTAL MITIGATION AREA (EM)
  - ABOVE GROUND INSTALLATION (AGI) / VALVE (VA) / PRESSURE TRANSDUCER (PT)
  - DESCRIPTION
  - ID or WORK NUMBER (if applicable)
  - ACCESS
  - P-ACCESS
  - COMMENCEMENT / TERMINATION OF WORKS (COMMENCEMENT = OPEN, TERMINATION = CLOSED)

Contains Ordnance Survey data © Crown copyright and database rights 2019.  
© Crown copyright and database rights 2019 OS Licence Number AL10005237.



Rev	Rev. Date	Purpose of revision	Drawn	Checked	Rev'd	Appr'd
C02	14/06/19	SHEETS 35 AND 109 REVISED FOLLOWING SSI ADVICE	SH	JA	ND	PH
C03	09/09/19	SHEETS 10, 11 AND 54 REVISED TO WITHDRAW A2b SUB-OPTION	BT	JA	ND	NJ



Client: Esso Petroleum Company, Limited  
Emryn House,  
Emryn Way,  
Leatherhead,  
Surrey,  
KT22 8UX



Drawing title  
**WORKS PLAN  
SHEET 104  
REGULATION 5 (2)(J)**

Drawing status: **Fit for Stage Approval**

Scale	1:1250	DO NOT SCALE
Jacobs No.	B2325300	Rev
Client no.		<b>C03</b>

Drawing number  
**B2325300-JAC-000-CIV-DRG-000104**

© Copyright 2019 Jacobs U.K. Limited. The concepts and information contained in this document are the property of Jacobs. Use or copying of this document in whole or in part without the written permission of Jacobs constitutes an infringement of copyright. Limitation. This drawing has been prepared on behalf of, and for the exclusive use of, the Client, and is subject to, and issued in accordance with, the provisions of the contract between Jacobs and the Client. Jacobs accepts no liability or responsibility whatsoever, for or in respect of, any use of, or reliance upon, this drawing by any third party.



**LOCATION PLAN**  
SCALE 1:500,000

**NOTES**  
1. THIS DRAWING IS IN METRES UNLESS STATED OTHERWISE.

**LEGEND**

	ORDER LIMITS
	LIMITS OF DEVIATION
	COMPOUND (CO)
	ENVIRONMENTAL MITIGATION AREA (EM)
	ABOVE GROUND INSTALLATION (AGI) / VALVE (VA) / PRESSURE TRANSDUCER (PT)
	DESCRIPTION
	ID or WORK NUMBER (if applicable)
	ACCESS
	TEMPORARY CONSTRUCTION ACCESS
	P-ACCESS
	COMMENCEMENT / TERMINATION OF WORKS
	(COMMENCEMENT = OPEN, TERMINATION = CLOSED)

Contains Ordnance Survey data © Crown copyright and database rights 2019.  
© Crown copyright and database rights 2019 OS Licence Number AL100005237.



C02	14/06/19	SHEETS 35 AND 108 REVISED FOLLOWING SSI ADVICE	SH	JA	ND	PH
C03	09/09/19	SHEETS 10, 11 AND 54 REVISED TO WITHDRAW A2b SUB-OPTION	BT	JA	ND	NJ
Rev	Rev. Date	Purpose of revision	Drawn	Checked	Rev'd	Appr'd

**JACOBS**  
1180 Eskdale Road, Wokingham, Wokingham, RG41 5TU  
Tel: +44(0)118 946 7000 Fax: +44(0)118 946 7001  
www.jacobs.com

Client: Esso Petroleum Company, Limited  
Emryn House,  
Emryn Way,  
Leatherhead,  
Surrey,  
KT22 8UX

Project: Southampton to London Pipeline Project

Drawing title: **WORKS PLAN SHEET 105 REGULATION 5 (2)(J)**


Drawing status: **Fit for Stage Approval**

Scale	1:1250	DO NOT SCALE
Jacobs No.	B2325300	Rev
Client no.		<b>C03</b>

Drawing number: **B2325300-JAC-000-CIV-DRG-000105**

© Copyright 2019 Jacobs U.K. Limited. The concepts and information contained in this document are the property of Jacobs. Use or copying of this document in whole or in part without the written permission of Jacobs constitutes an infringement of copyright. Limitation: This drawing has been prepared on behalf of, and for the exclusive use of, the Client. Jacobs accepts no liability or responsibility whatsoever for, or in respect of, any use of, or reliance upon, this drawing by any third party.

C:\pwworking\jacobs\_uk\_water\utilities\_ssf\byondms33519B2325300-JAC-000-CIV-DRG-000105.dwg - 10/09/2019 14:09:14 - A1Frame - BTaylor

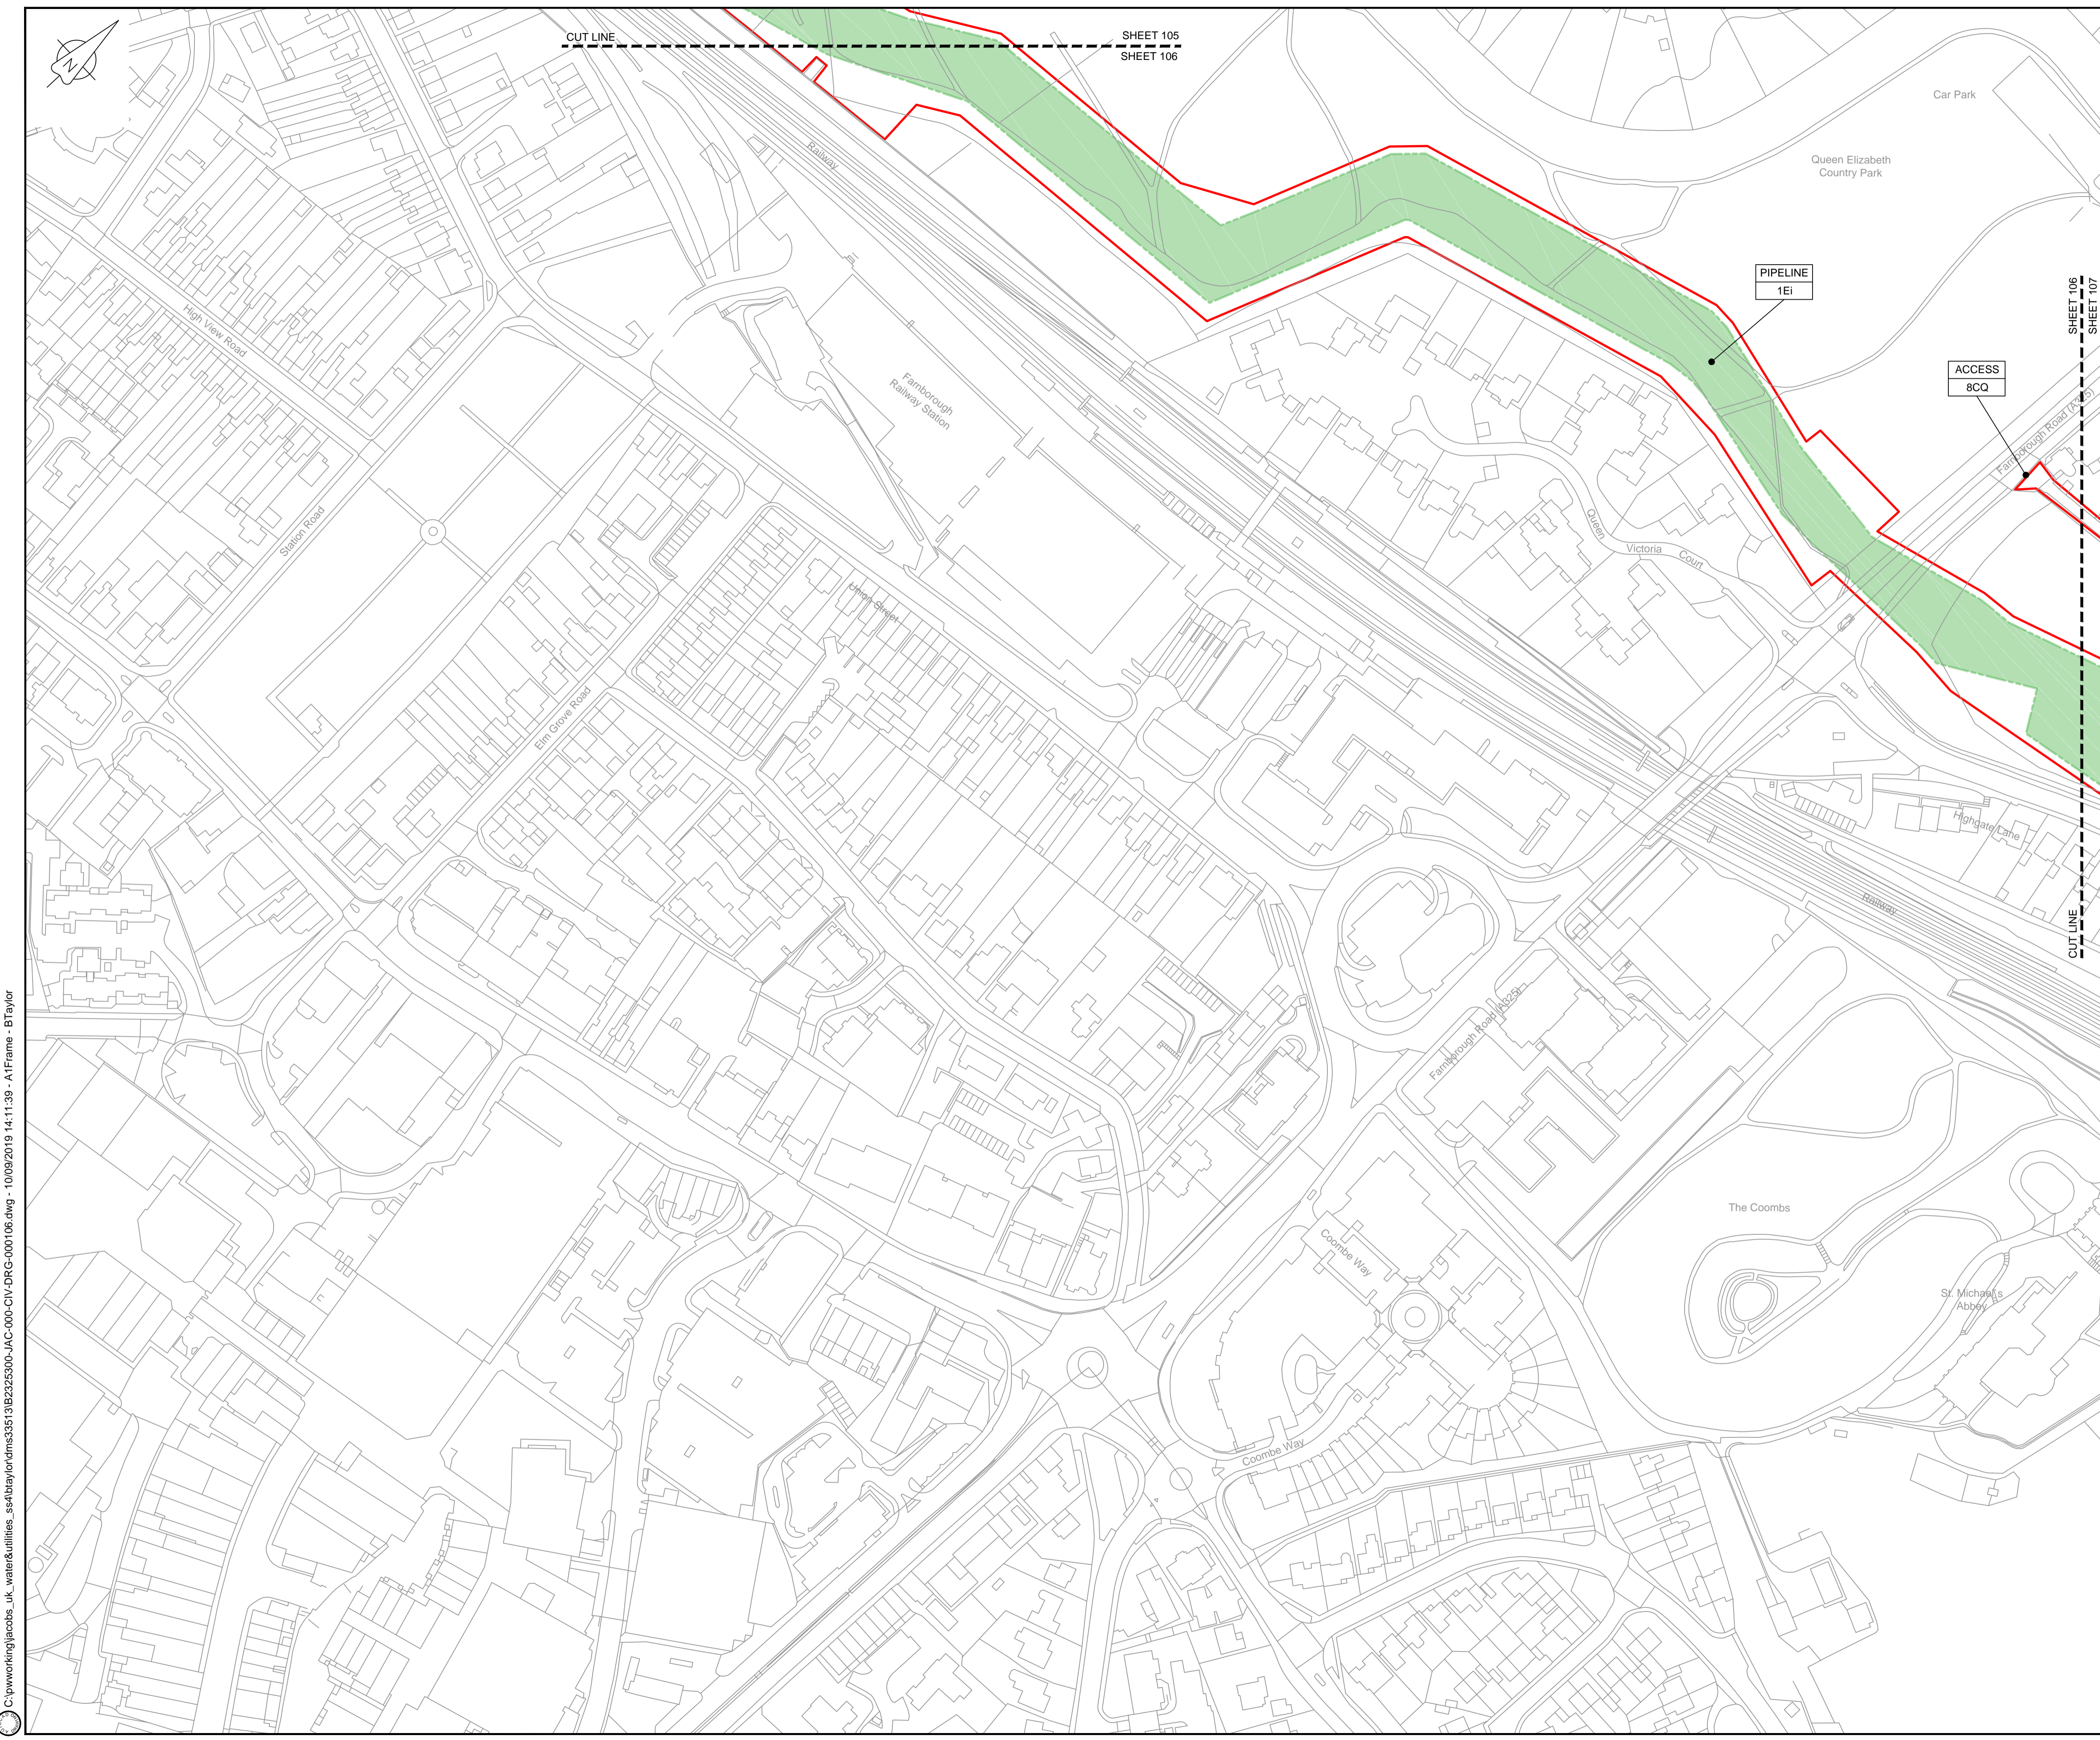

**LOCATION PLAN**  
SCALE 1:500,000

**NOTES**  
1. THIS DRAWING IS IN METRES UNLESS STATED OTHERWISE.

**LEGEND**

	ORDER LIMITS
	LIMITS OF DEVIATION
	COMPOUND (CO)
	ENVIRONMENTAL MITIGATION AREA (EM)
	ABOVE GROUND INSTALLATION (AGI) / VALVE (VA) / PRESSURE TRANSDUCER (PT)
	DESCRIPTION
	ID or WORK NUMBER (if applicable)
	ACCESS TEMPORARY CONSTRUCTION ACCESS
	P-ACCESS PERMANENT ACCESS
	COMMENCEMENT / TERMINATION OF WORKS (COMMENCEMENT = OPEN, TERMINATION = CLOSED)

Contains Ordnance Survey data © Crown copyright and database rights 2019.  
© Crown copyright and database rights 2019 OS Licence Number AL100005237.



C02	14/06/19	SHEETS 35 AND 108 REVISED FOLLOWING SSI ADVICE	SH	JA	ND	PH
C03	09/09/19	SHEETS 10, 11 AND 54 REVISED TO WITHDRAW A2B SUB-OPTION	BT	JA	ND	NJ
Rev	Rev. Date	Purpose of revision	Drawn	Checked	Rev'd	Appr'd

**JACOBS**  
1180 Eskdale Road, Winnersh, Wokingham, RG41 5TU  
Tel: +44(0)118 946 7000 Fax: +44(0)118 946 7001  
www.jacobs.com

Client: Esso Petroleum Company, Limited  
Ermyn House,  
Ermyn Way,  
Leatherhead,  
Surrey,  
KT22 8UX

Project: Southampton to London Pipeline Project

Drawing title: **WORKS PLAN SHEET 106 REGULATION 5 (2)(J)**


Drawing status: **Fit for Stage Approval**

Scale	1:1250	DO NOT SCALE
Jacobs No.	B2325300	Rev
Client no.		<b>C03</b>

Drawing number: **B2325300-JAC-000-CIV-DRG-000106**

© Copyright 2019 Jacobs U.K. Limited. The concepts and information contained in this document are the property of Jacobs. Use or copying of this document in whole or in part without the written permission of Jacobs constitutes an infringement of copyright. Limitation. This drawing has been prepared on behalf of, and for the exclusive use of, the Client. Jacobs accepts no liability or responsibility whatsoever for, or in respect of, any use of, or reliance upon, this drawing by any third party.



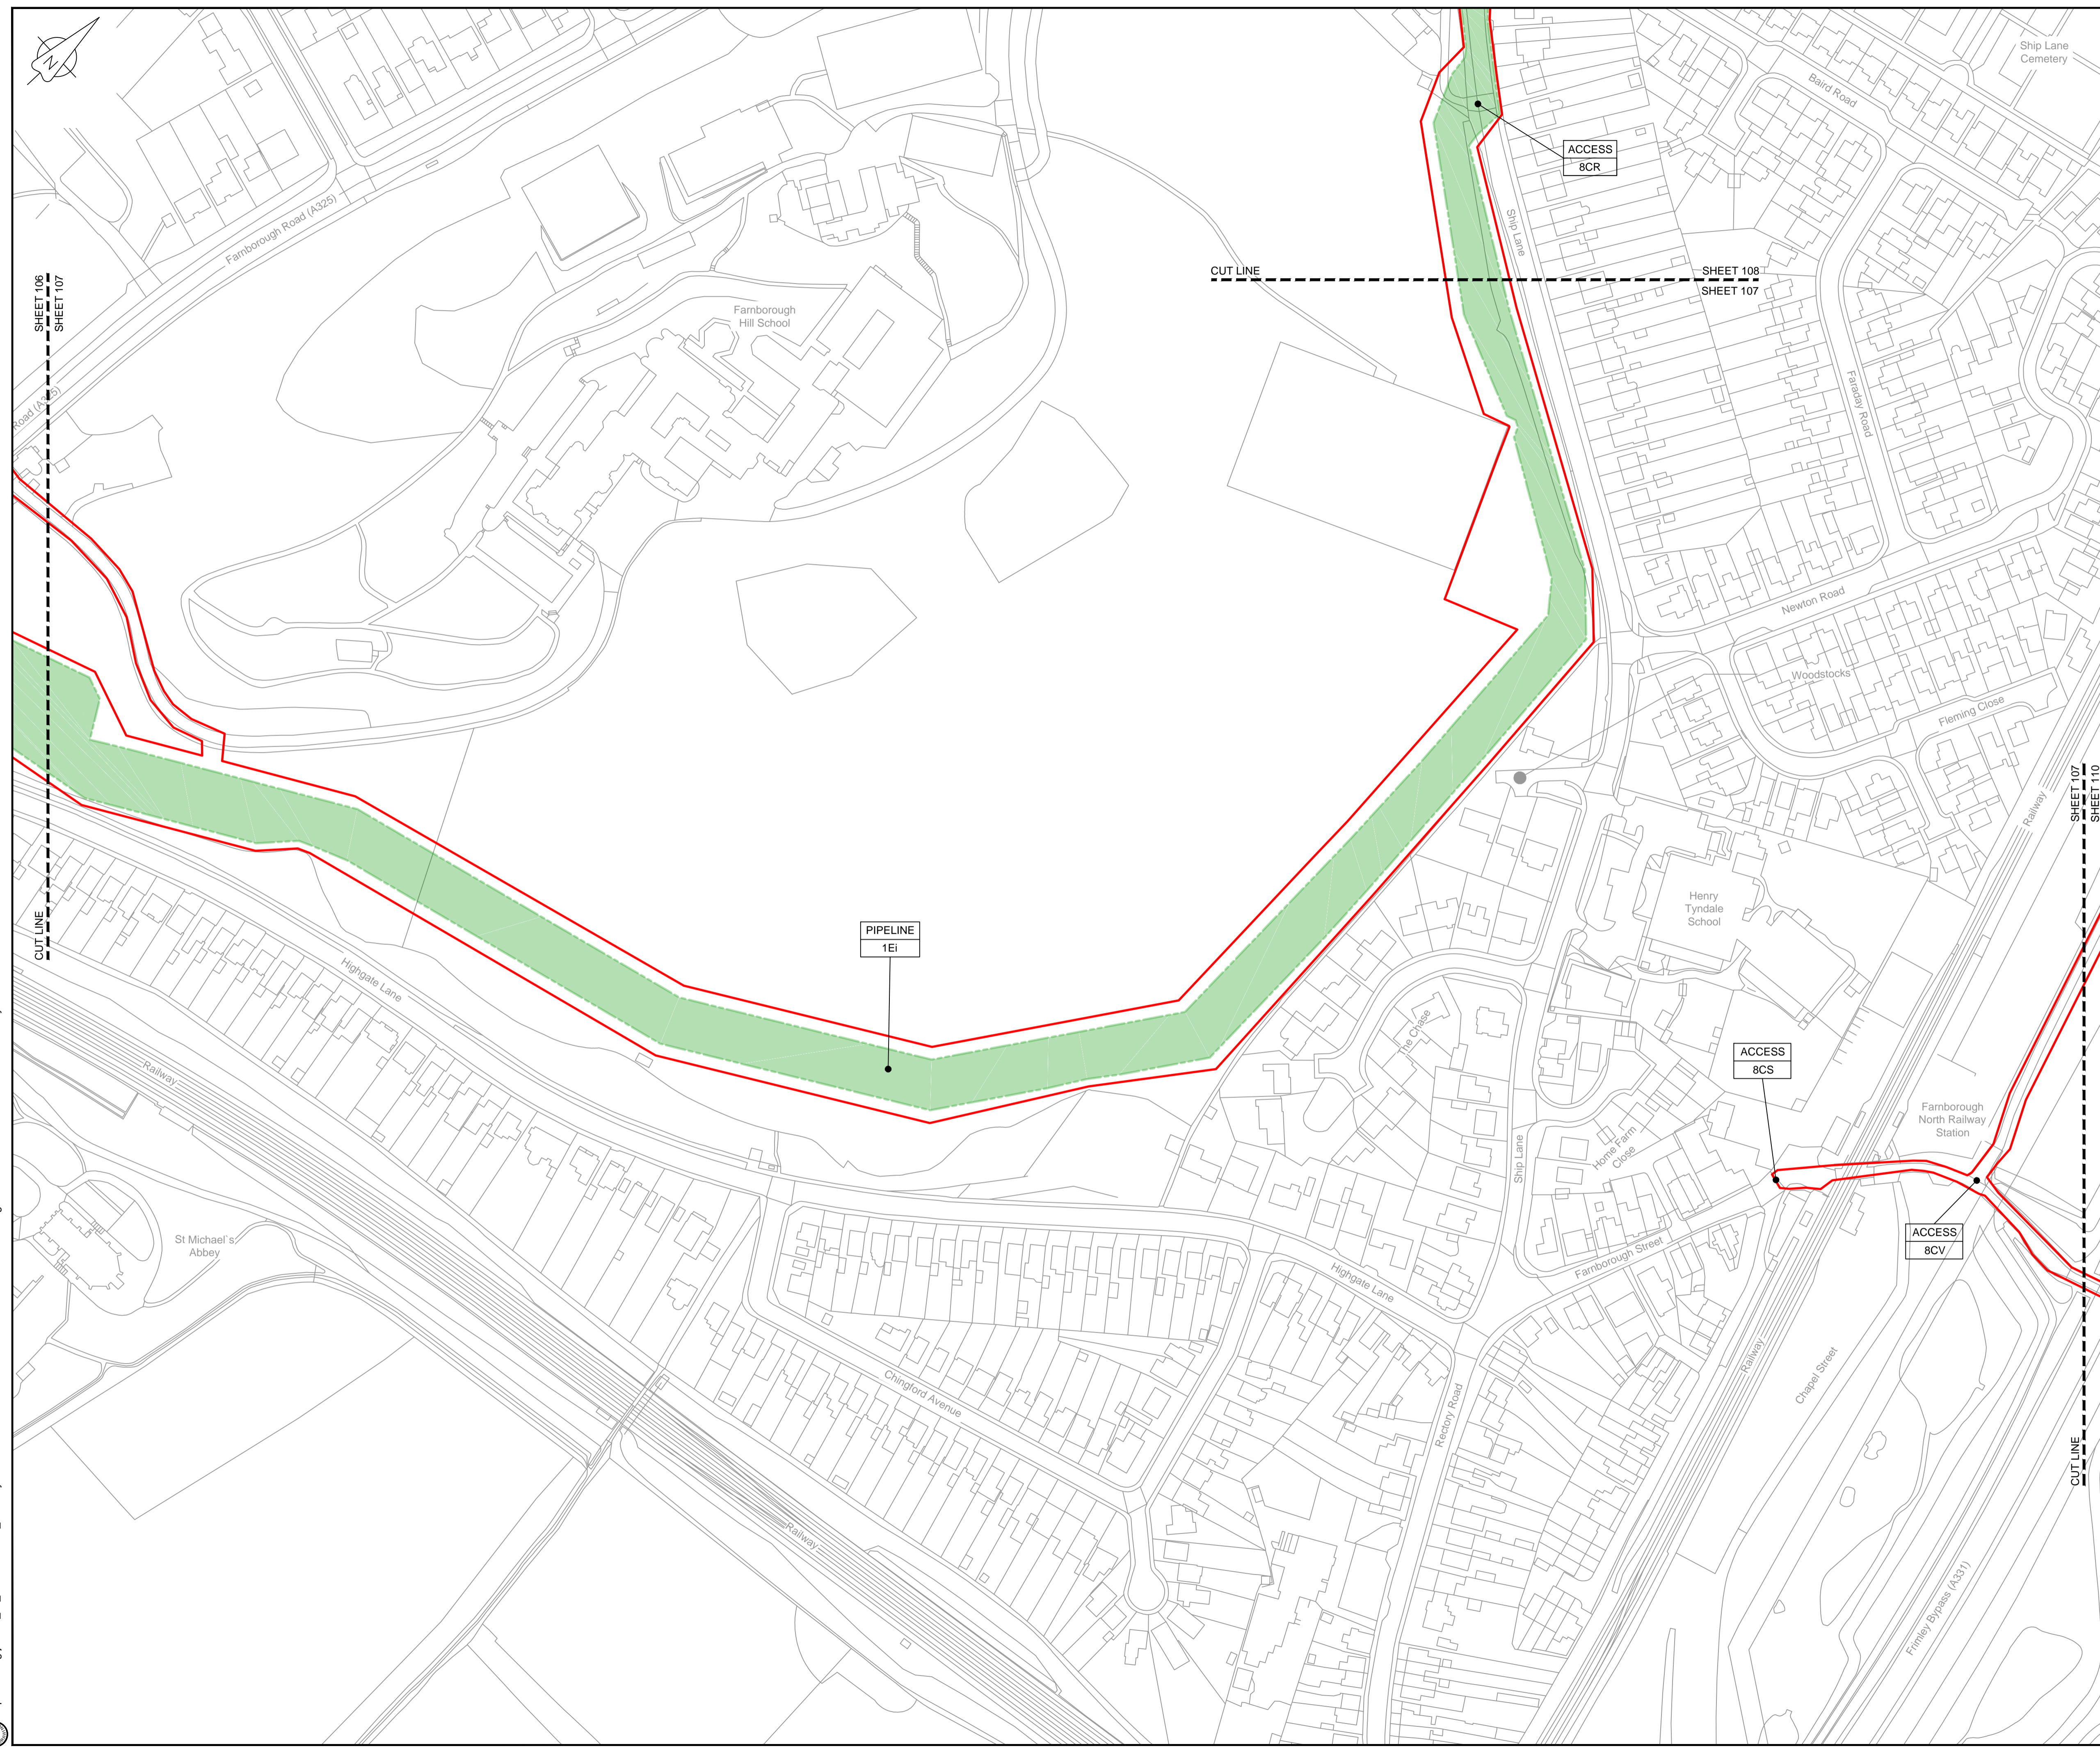

LOCATION PLAN  
SCALE 1:500,000

NOTES  
1. THIS DRAWING IS IN METRES UNLESS STATED OTHERWISE.

LEGEND

	ORDER LIMITS
	LIMITS OF DEVIATION
	COMPOUND (CO)
	ENVIRONMENTAL MITIGATION AREA (EM)
	ABOVE GROUND INSTALLATION (AGI) / VALVE (VA) / PRESSURE TRANSDUCER (PT)
	DESCRIPTION ID or WORK NUMBER (if applicable)
	ACCESS TEMPORARY CONSTRUCTION ACCESS
	P-ACCESS PERMANENT ACCESS
	COMMENCEMENT / TERMINATION OF WORKS (COMMENCEMENT = OPEN, TERMINATION = CLOSED)

Contains Ordnance Survey data © Crown copyright and database rights 2019.  
© Crown copyright and database rights 2019 OS Licence Number AL10005237.



Rev	Rev. Date	Purpose of revision	Drawn	Checked	Rev'd	Appr'd
C02	14/06/19	SHEETS 35 AND 108 REVISED FOLLOWING SSI ADVICE	SH	JA	ND	PH
C03	09/09/19	SHEETS 10, 11 AND 54 REVISED TO WITHDRAW A2b SUB-OPTION	BT	JA	ND	NJ



Client: Esso Petroleum Company, Limited  
Emryn House,  
Emryn Way,  
Leatherhead,  
Surrey,  
KT22 8UX




Drawing title  
**WORKS PLAN  
SHEET 107  
REGULATION 5 (2)(J)**

Drawing status  
**Fit for Stage Approval**

Scale	1:1250	DO NOT SCALE
Jacobs No.	B2325300	Rev
Client no.		<b>C03</b>

Drawing number  
**B2325300-JAC-000-CIV-DRG-000107**

© Copyright 2019 Jacobs U.K. Limited. The concepts and information contained in this document are the property of Jacobs. Use or copying of this document in whole or in part without the written permission of Jacobs constitutes an infringement of copyright. Limitation: This drawing has been prepared on behalf of, and for the exclusive use of, the Client, and is subject to, and issued in accordance with, the provisions of the contract between Jacobs and the Client. Jacobs accepts no liability or responsibility whatsoever for, or in respect of, any use of, or reliance upon, this drawing by any third party.

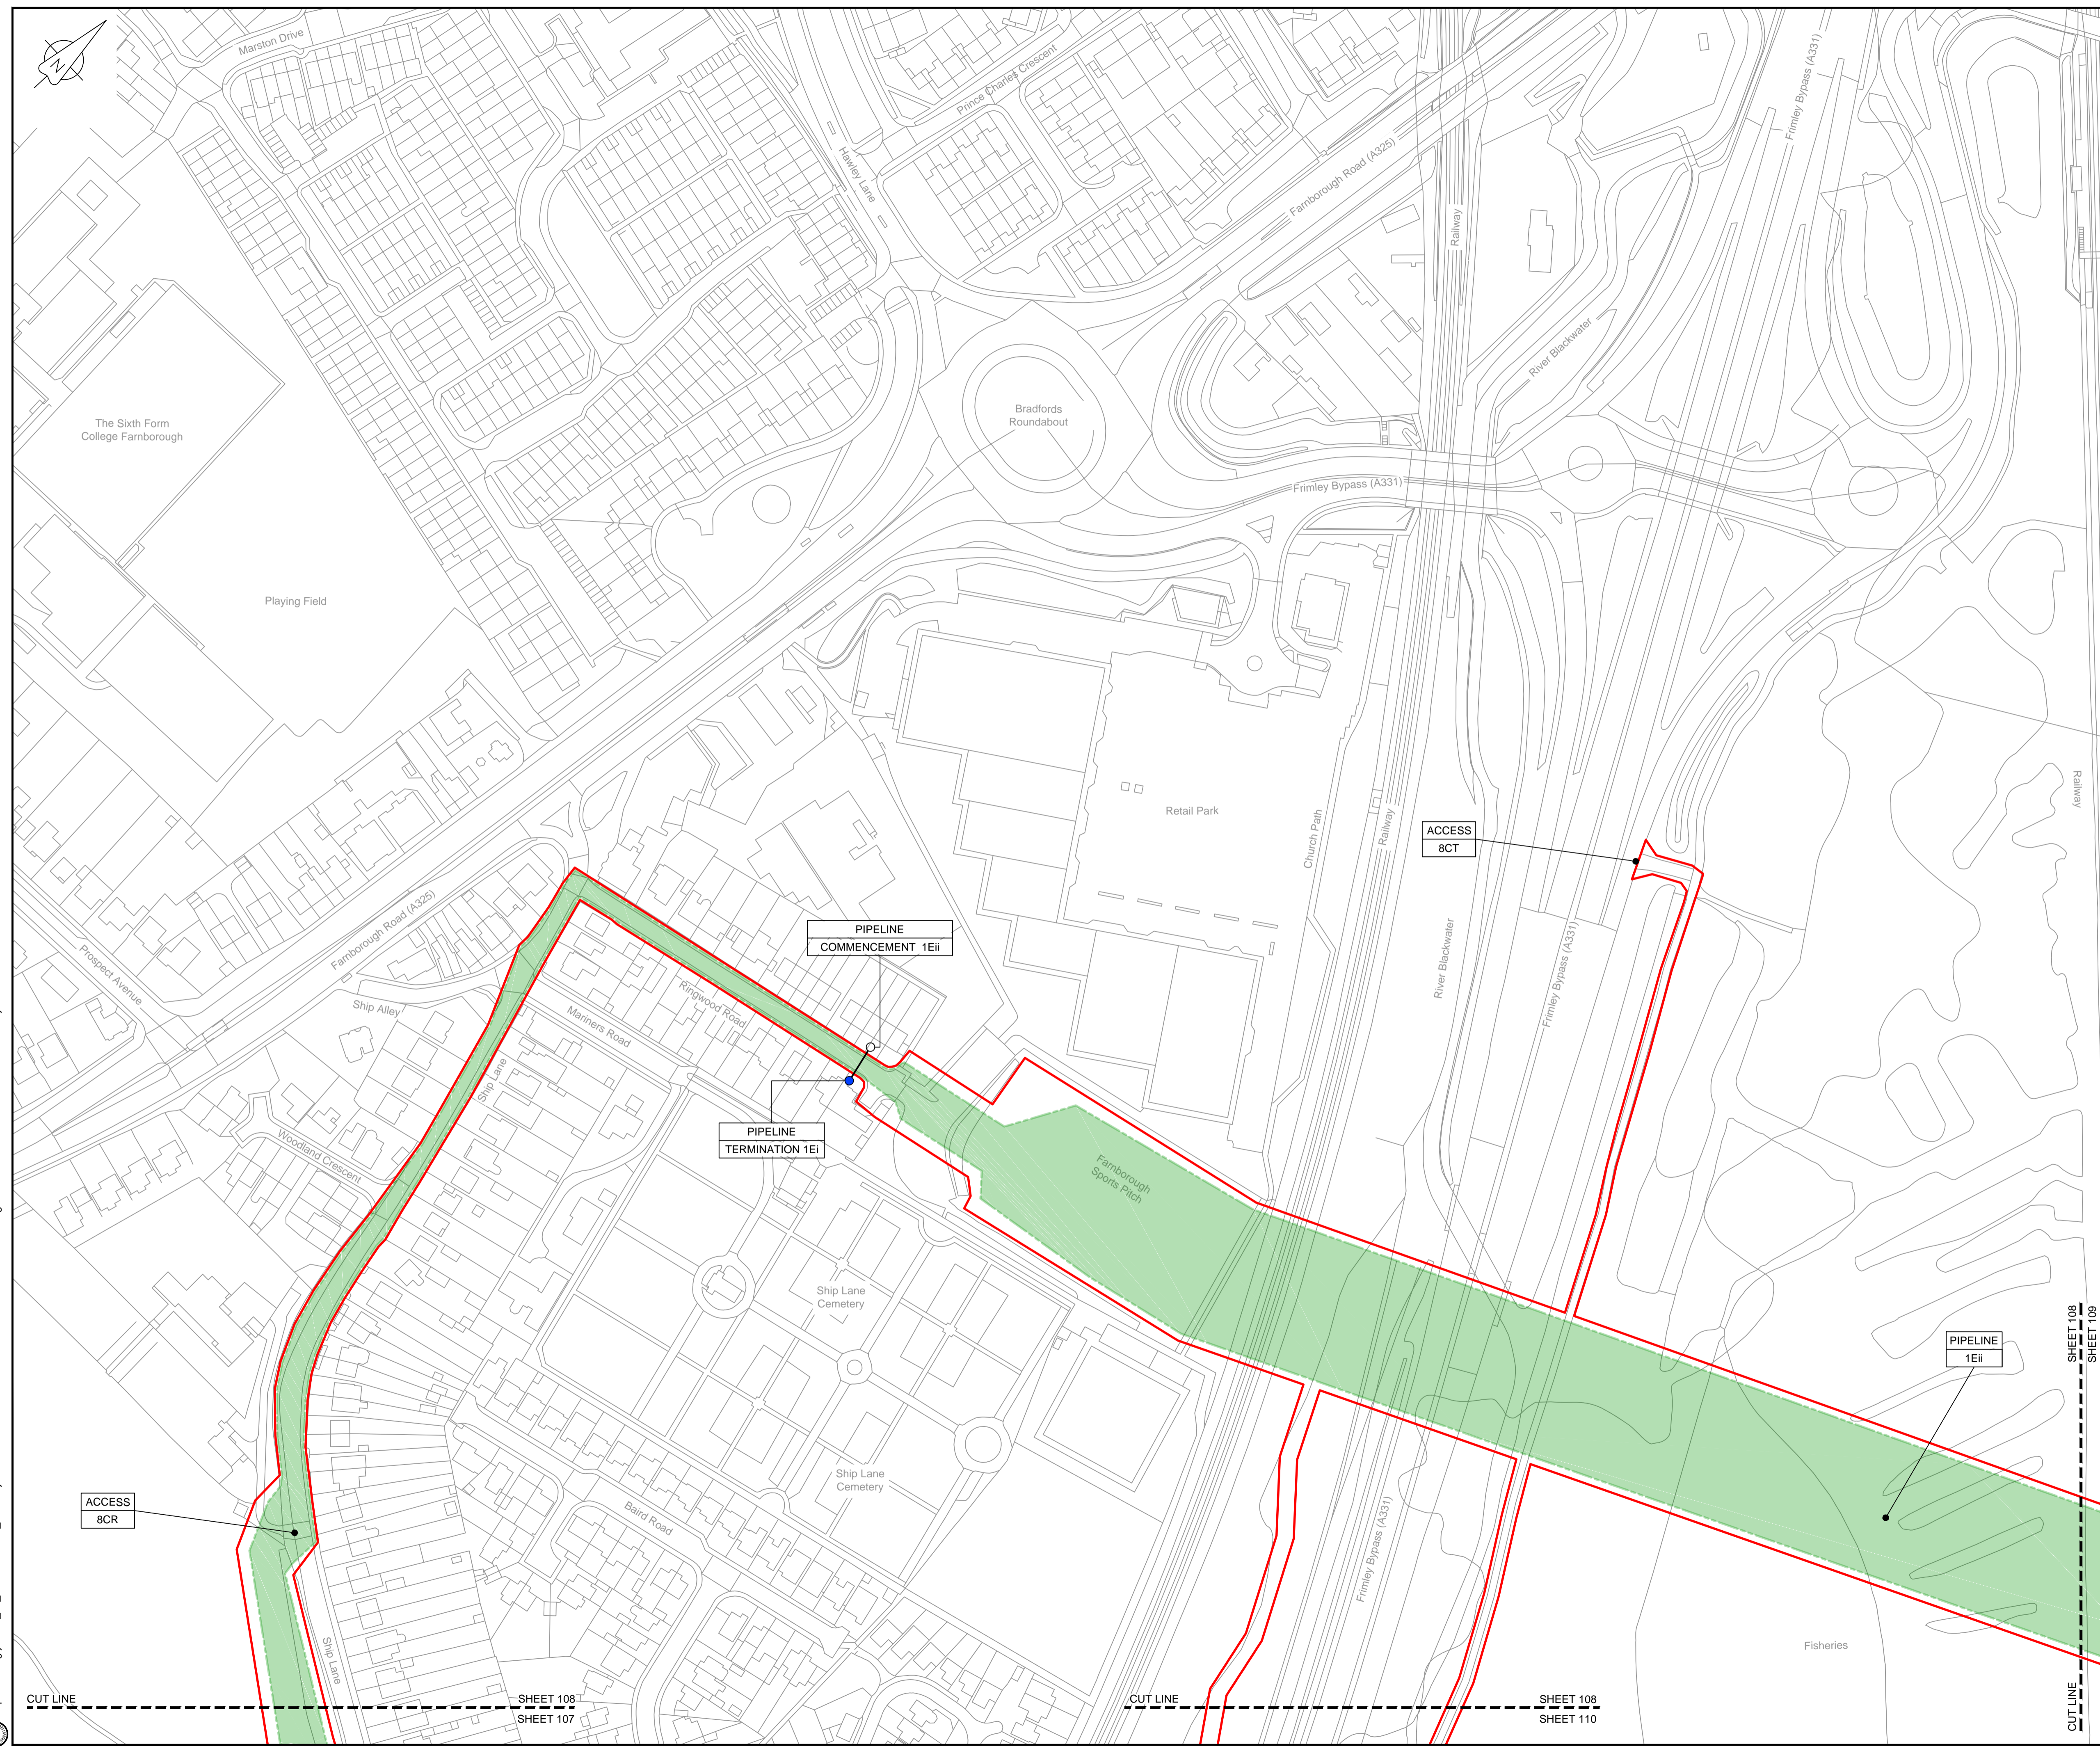


**NOTES**  
1. THIS DRAWING IS IN METRES UNLESS STATED OTHERWISE.

**LEGEND**

[Red line]	ORDER LIMITS
[Green shaded area]	LIMITS OF DEVIATION
[Hatched area]	COMPOUND (CO)
[Yellow shaded area]	ENVIRONMENTAL MITIGATION AREA (EM)
[Grey shaded area]	ABOVE GROUND INSTALLATION (AGI) / VALVE (VA) / PRESSURE TRANSDUCER (PT)
[Circle with dot]	DESCRIPTION
[Circle with ID]	ID or WORK NUMBER (if applicable)
[Dashed line]	ACCESS
[Dashed line]	TEMPORARY CONSTRUCTION ACCESS
[Dashed line]	PERMANENT ACCESS
[Blue circle]	COMMENCEMENT / TERMINATION OF WORKS (COMMENCEMENT = OPEN, TERMINATION = CLOSED)

Contains Ordnance Survey data © Crown copyright and database rights 2019.  
© Crown copyright and database rights 2019 OS Licence Number AL10005237.

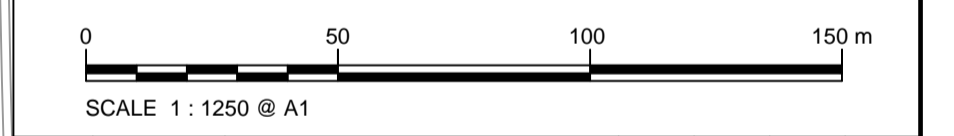

Rev	Rev. Date	Purpose of revision	Drawn	Checked	Rev'd	Appr'd
C02	14/06/19	SHEETS 38 AND 108 REVISED FOLLOWING S51 ADVICE	SH	JA	ND	PH
C03	09/09/19	SHEETS 10, 11 AND 54 REVISED TO WITHDRAW A2b SUB-OPTION	BT	JA	ND	NJ

**JACOBS**  
1180 Eskdale Road, Wokingham, Wokingham, RG41 5TU  
Tel: +44(0)118 946 7000 Fax: +44(0)118 946 7001  
www.jacobs.com

Client: Esso Petroleum Company, Limited  
Emryn House,  
Emryn Way,  
Leatherhead,  
Surrey,  
KT22 8UX

Project: Southampton to London Pipeline Project

Drawing title: **WORKS PLAN SHEET 108 REGULATION 5 (2)(J)**


Drawing status: **Fit for Stage Approval**

Scale	1:1250	DO NOT SCALE
Jacobs No.	B2325300	Rev
Client no.		<b>C03</b>

Drawing number: **B2325300-JAC-000-CIV-DRG-000108**

© Copyright 2019 Jacobs U.K. Limited. The concepts and information contained in this document are the property of Jacobs. Use or copying of this document in whole or in part without the written permission of Jacobs constitutes an infringement of copyright. Limitation: This drawing has been prepared on behalf of, and for the exclusive use of, the Client, and is subject to, and issued in accordance with, the provisions of the contract between Jacobs and the Client. Jacobs accepts no liability or responsibility whatsoever, for or in respect of, any use of, or reliance upon, this drawing by any third party.

C:\working\jacobs\_uk\_water&utilities\_ssr\blayford\ms33519\B2325300-JAC-000-CIV-DRG-000108.dwg - 10/09/2019 14:17:28 - A1Frame - BTaylor

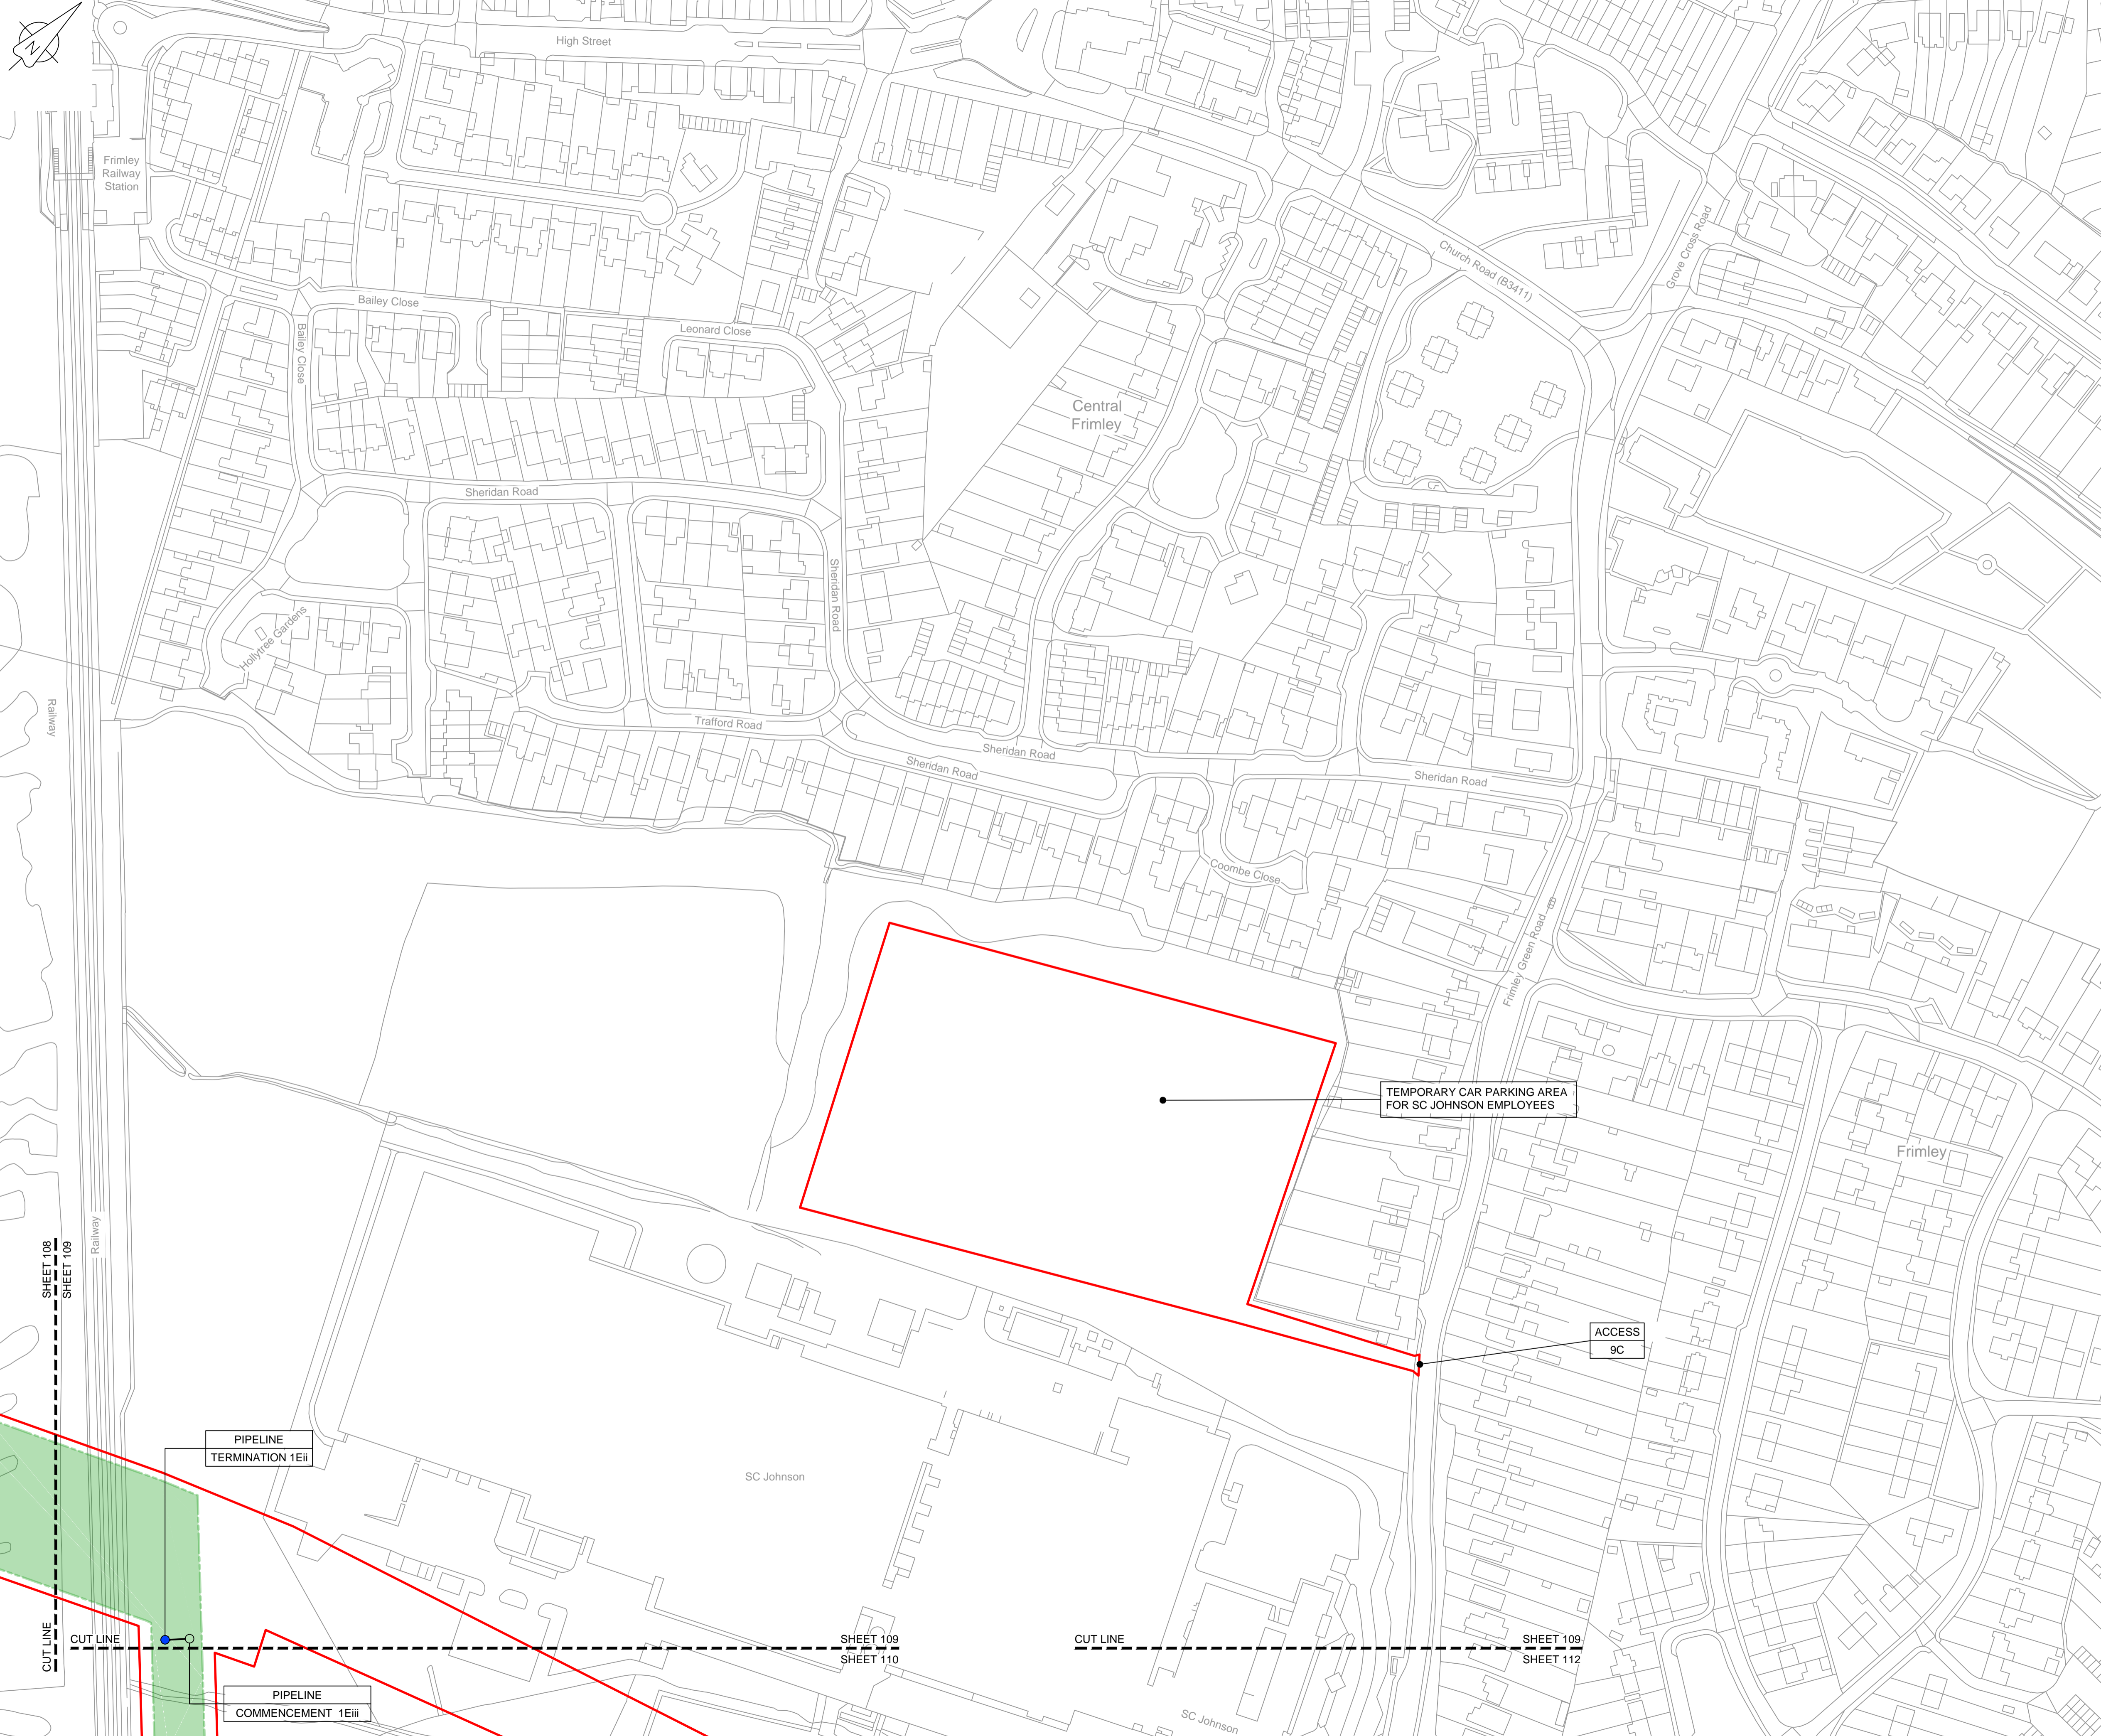

**LOCATION PLAN**  
SCALE 1:500,000

**NOTES**  
1. THIS DRAWING IS IN METRES UNLESS STATED OTHERWISE.

**LEGEND**

	ORDER LIMITS
	LIMITS OF DEVIATION
	COMPOUND (CO)
	ENVIRONMENTAL MITIGATION AREA (EM)
	ABOVE GROUND INSTALLATION (AGI) / VALVE (VA) / PRESSURE TRANSDUCER (PT)
	DESCRIPTION
	ID or WORK NUMBER (if applicable)
	ACCESS TEMPORARY CONSTRUCTION ACCESS
	P-ACCESS PERMANENT ACCESS
	COMMENCEMENT / TERMINATION OF WORKS (COMMENCEMENT = OPEN, TERMINATION = CLOSED)

Contains Ordnance Survey data © Crown copyright and database rights 2019.  
© Crown copyright and database rights 2019 OS Licence Number AL10005237.



Rev	Rev. Date	Purpose of revision	Drawn	Checked	Rev'd	Appr'd
C02	14/06/19	SHEETS 38 AND 109 REVISED FOLLOWING SSI ADVICE	SH	JA	ND	PH
C03	09/09/19	SHEETS 10, 11 AND 54 REVISED TO WITHDRAW A2b SUB-OPTION	BT	JA	ND	NJ



1180 Eskdale Road, Wokingham, Wokingham, RG41 5TU  
Tel: +44(0)118 946 7000 Fax: +44(0)118 946 7001  
www.jacobs.com

Client: Esso Petroleum Company, Limited  
Emryn House,  
Emryn Way,  
Leatherhead,  
Surrey,  
KT22 8UX



Drawing title  
**WORKS PLAN  
SHEET 109  
REGULATION 5 (2)(J)**


Drawing status  
**Fit for Stage Approval**

Scale	1:1250	DO NOT SCALE
Jacobs No.	B2325300	Rev
Client no.		<b>C03</b>

Drawing number  
**B2325300-JAC-000-CIV-DRG-000109**

© Copyright 2019 Jacobs U.K. Limited. The concepts and information contained in this document are the property of Jacobs. Use or copying of this document in whole or in part without the written permission of Jacobs constitutes an infringement of copyright. Limitation. This drawing has been prepared on behalf of, and for the exclusive use of, the Client, and is subject to, and issued in accordance with, the provisions of the contract between Jacobs and the Client. Jacobs accepts no liability or responsibility whatsoever for, or in respect of, any use of, or reliance upon, this drawing by any third party.

C:\pwworking\jacobs\_uk\_water\utilities\_ssf\by\ordms33519B2325300-JAC-000-CIV-DRG-000109.dwg - 10/09/2019 14:19:38 - A1Frame - BTaylor

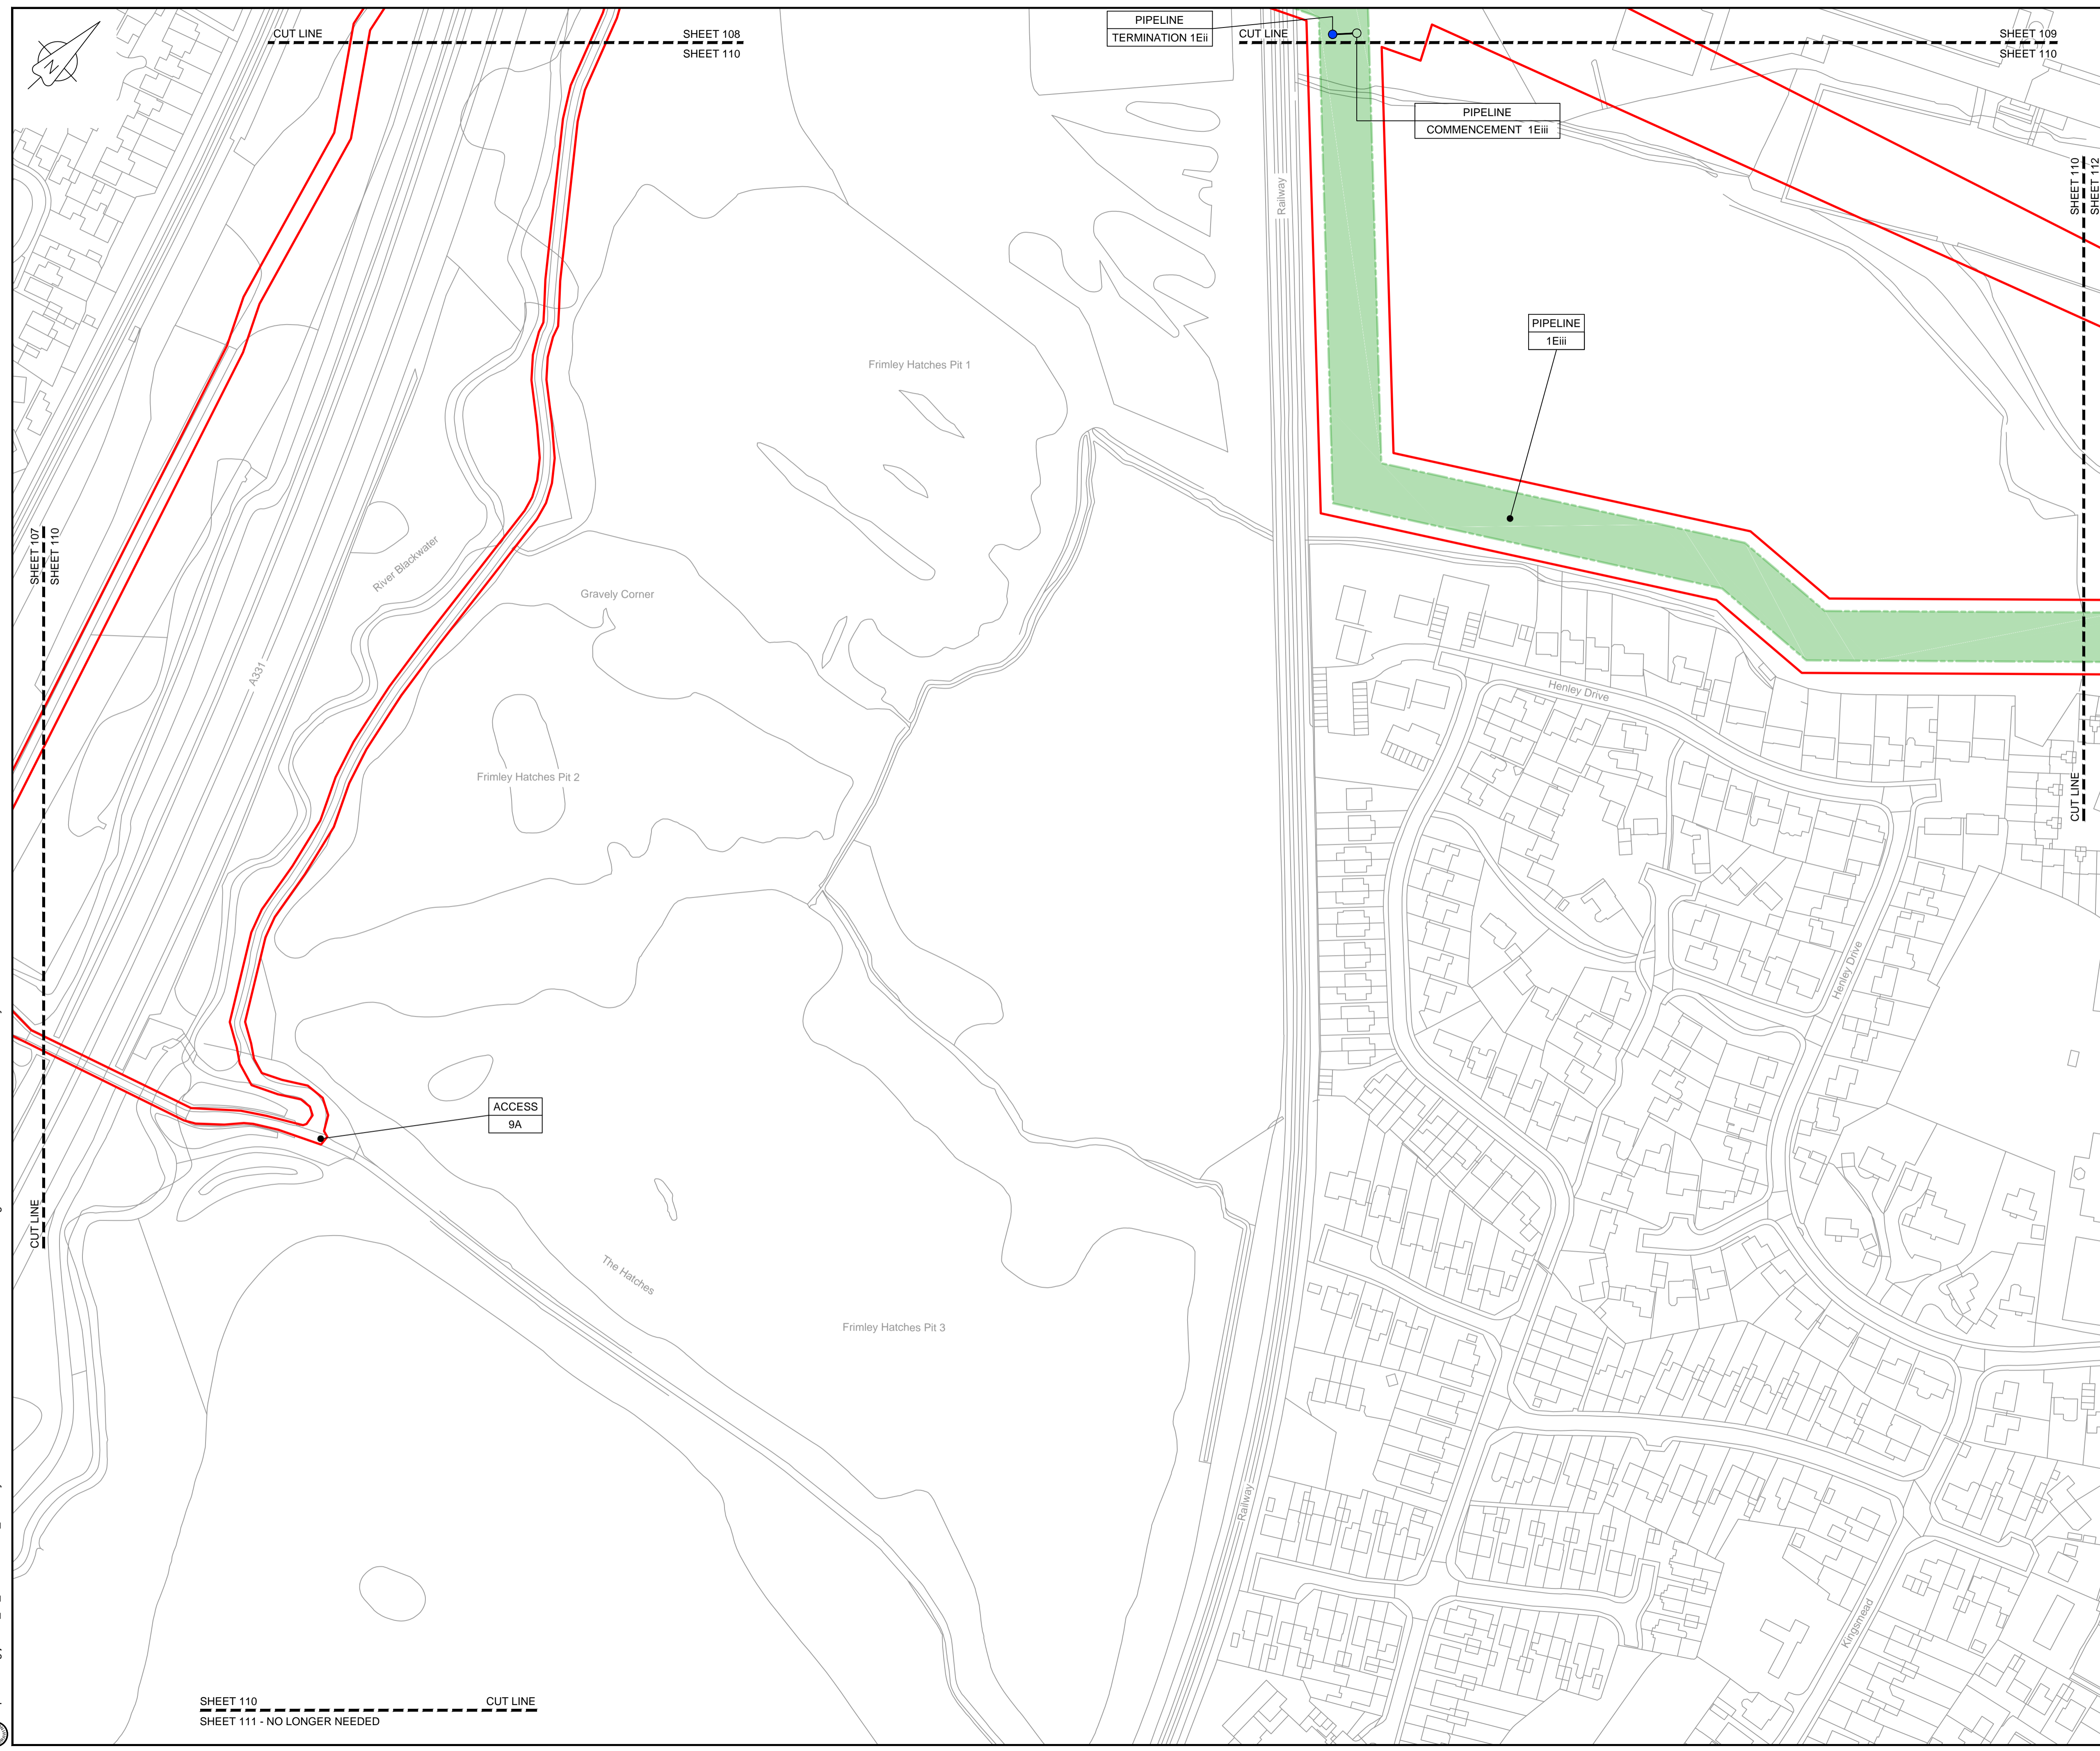

LOCATION PLAN  
SCALE 1:500,000

**NOTES**  
1. THIS DRAWING IS IN METRES UNLESS STATED OTHERWISE.

**LEGEND**

	ORDER LIMITS
	LIMITS OF DEVIATION
	COMPOUND (CO)
	ENVIRONMENTAL MITIGATION AREA (EM)
	ABOVE GROUND INSTALLATION (AGI) / VALVE (VA) / PRESSURE TRANSDUCER (PT)
	DESCRIPTION
	ID or WORK NUMBER (if applicable)
	ACCESS
	TEMPORARY CONSTRUCTION ACCESS
	P-ACCESS
	PERMANENT ACCESS
	COMMENCEMENT / TERMINATION OF WORKS (COMMENCEMENT = OPEN, TERMINATION = CLOSED)

Contains Ordnance Survey data © Crown copyright and database rights 2019.  
© Crown copyright and database rights 2019 OS Licence Number AL100005237.



Rev	Rev. Date	Purpose of revision	Drawn	Checked	Rev'd	Appr'd
C02	14/06/19	SHEETS 35 AND 109 REVISED FOLLOWING SSI ADVICE	SH	JA	ND	PH
C03	09/09/19	SHEETS 10, 11 AND 54 REVISED TO WITHDRAW A2b SUB-OPTION	BT	JA	ND	NJ

**JACOBS**  
1180 Eskdale Road, Wokingham, Wokingham, RG41 5TU  
Tel:+44(0)118 946 7000 Fax:+44(0)118 946 7001  
www.jacobs.com

Client: Esso Petroleum Company, Limited  
Emryn House,  
Emryn Way,  
Leatherhead,  
Surrey,  
KT22 8UX



Project: Southampton to London Pipeline Project

Drawing title: **WORKS PLAN SHEET 110 REGULATION 5 (2)(J)**

Drawing status: **Fit for Stage Approval**

Scale	1:1250	DO NOT SCALE
Jacobs No.	B2325300	Rev
Client no.		<b>C03</b>
Drawing number	<b>B2325300-JAC-000-CIV-DRG-000110</b>	

© Copyright 2019 Jacobs U.K. Limited. The concepts and information contained in this document are the property of Jacobs. Use or copying of this document in whole or in part without the written permission of Jacobs constitutes an infringement of copyright. Limitation: This drawing has been prepared on behalf of, and for the exclusive use of, Jacobs' Client, and is subject to, and issued in accordance with, the provisions of the contract between Jacobs and the Client. Jacobs accepts no liability or responsibility whatsoever for, or in respect of, any use of, or reliance upon, this drawing by any third party.

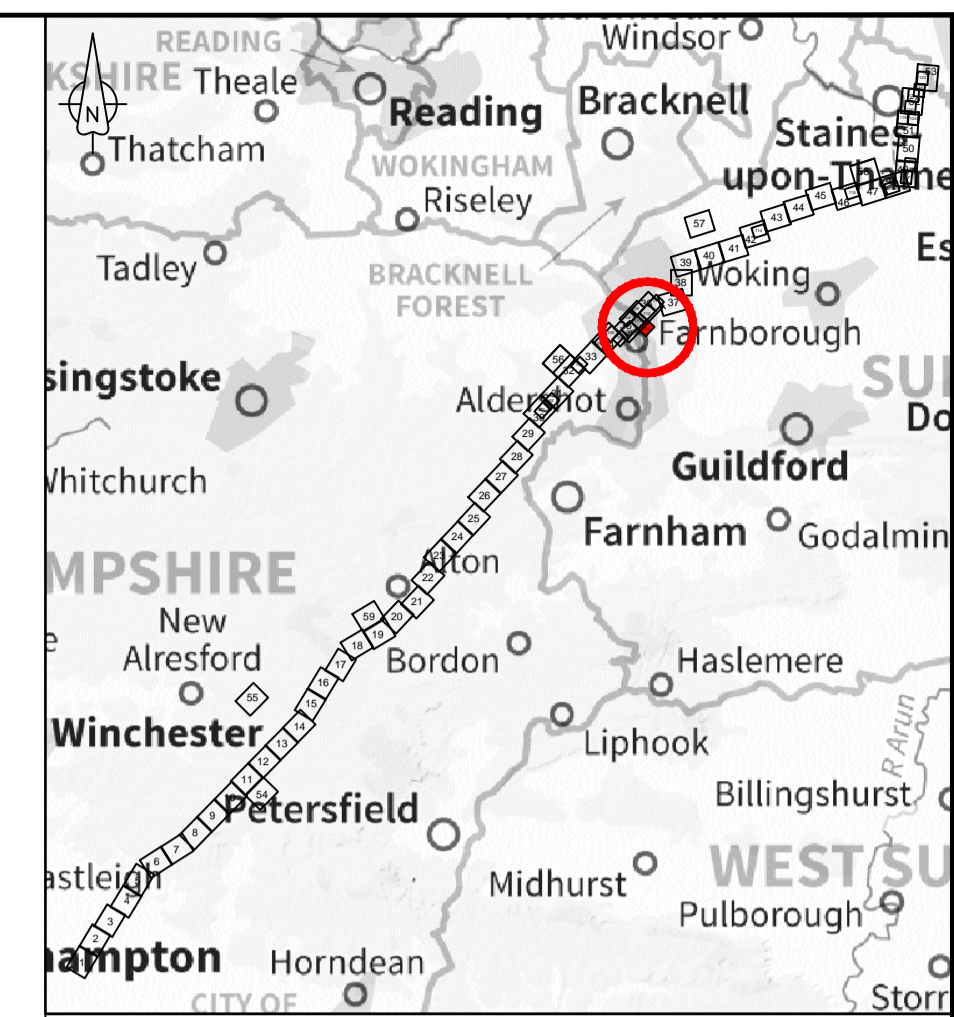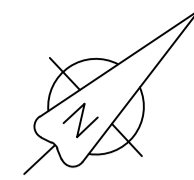

LOCATION PLAN  
SCALE 1:500,000

**NOTES**


1. THIS DRAWING IS IN METRES UNLESS STATED OTHERWISE.

**LEGEND**

- ORDER LIMITS
- LIMITS OF DEVIATION
- COMPOUND (CO)
- ENVIRONMENTAL MITIGATION AREA (EM)
- ABOVE GROUND INSTALLATION (AGI) / VALVE (VA) / PRESSURE TRANSDUCER (PT)
- DESCRIPTION  
ID or WORK NUMBER (if applicable)
- ACCESS  
TEMPORARY CONSTRUCTION ACCESS
- P-ACCESS  
PERMANENT ACCESS
- COMMENCEMENT / TERMINATION OF WORKS  
(COMMENCEMENT = OPEN, TERMINATION = CLOSED)

Contains Ordnance Survey data © Crown copyright and database rights 2019.

© Crown copyright and database rights 2019 OS Licence Number AL100005237.

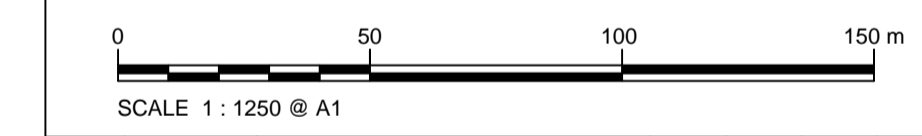

C02	14/06/19	SHEETS 36 AND 108 REVISED FOLLOWING SSI ADVICE	SH	JA	ND	PH
C03	09/09/19	SHEETS 10, 11 AND 54 REVISED TO WITHDRAW A2b SUB-OPTION	BT	JA	ND	NJ
Rev	Rev. Date	Purpose of revision	Drawn	Checked	Rev'd	Apprv'd



1180 Eskdale Road, Winnersh, Wokingham, RG41 5TU  
Tel:+44(0)118 946 7000 Fax:+44(0)118 946 7001  
www.jacobs.com

Client: Esso Petroleum Company, Limited  
Emryn House,  
Emryn Way,  
Leatherhead,  
Surrey,  
KT22 8UX



Southampton to London Pipeline Project

Drawing title  
**WORKS PLAN  
SHEET 111  
REGULATION 5 (2)(J)**


Drawing status  
**Fit for Stage Approval**

Scale	1:1250	DO NOT SCALE
Jacobs No.	B2325300	Rev
Client no.		<b>C03</b>

Drawing number  
**B2325300-JAC-000-CIV-DRG-000111**

© Copyright 2019 Jacobs U.K. Limited. The concepts and information contained in this document are the property of Jacobs. Use or copying of this document in whole or in part without the written permission of Jacobs constitutes an infringement of copyright. Limitation: This drawing has been prepared on behalf of, and for the exclusive use of, Jacobs' Client, and is subject to, and issued in accordance with, the provisions of the contract between Jacobs and the Client. Jacobs accepts no liability or responsibility whatsoever for, or in respect of, any use of, or reliance upon, this drawing by any third party.

SHEET 111 - NO LONGER NEEDED

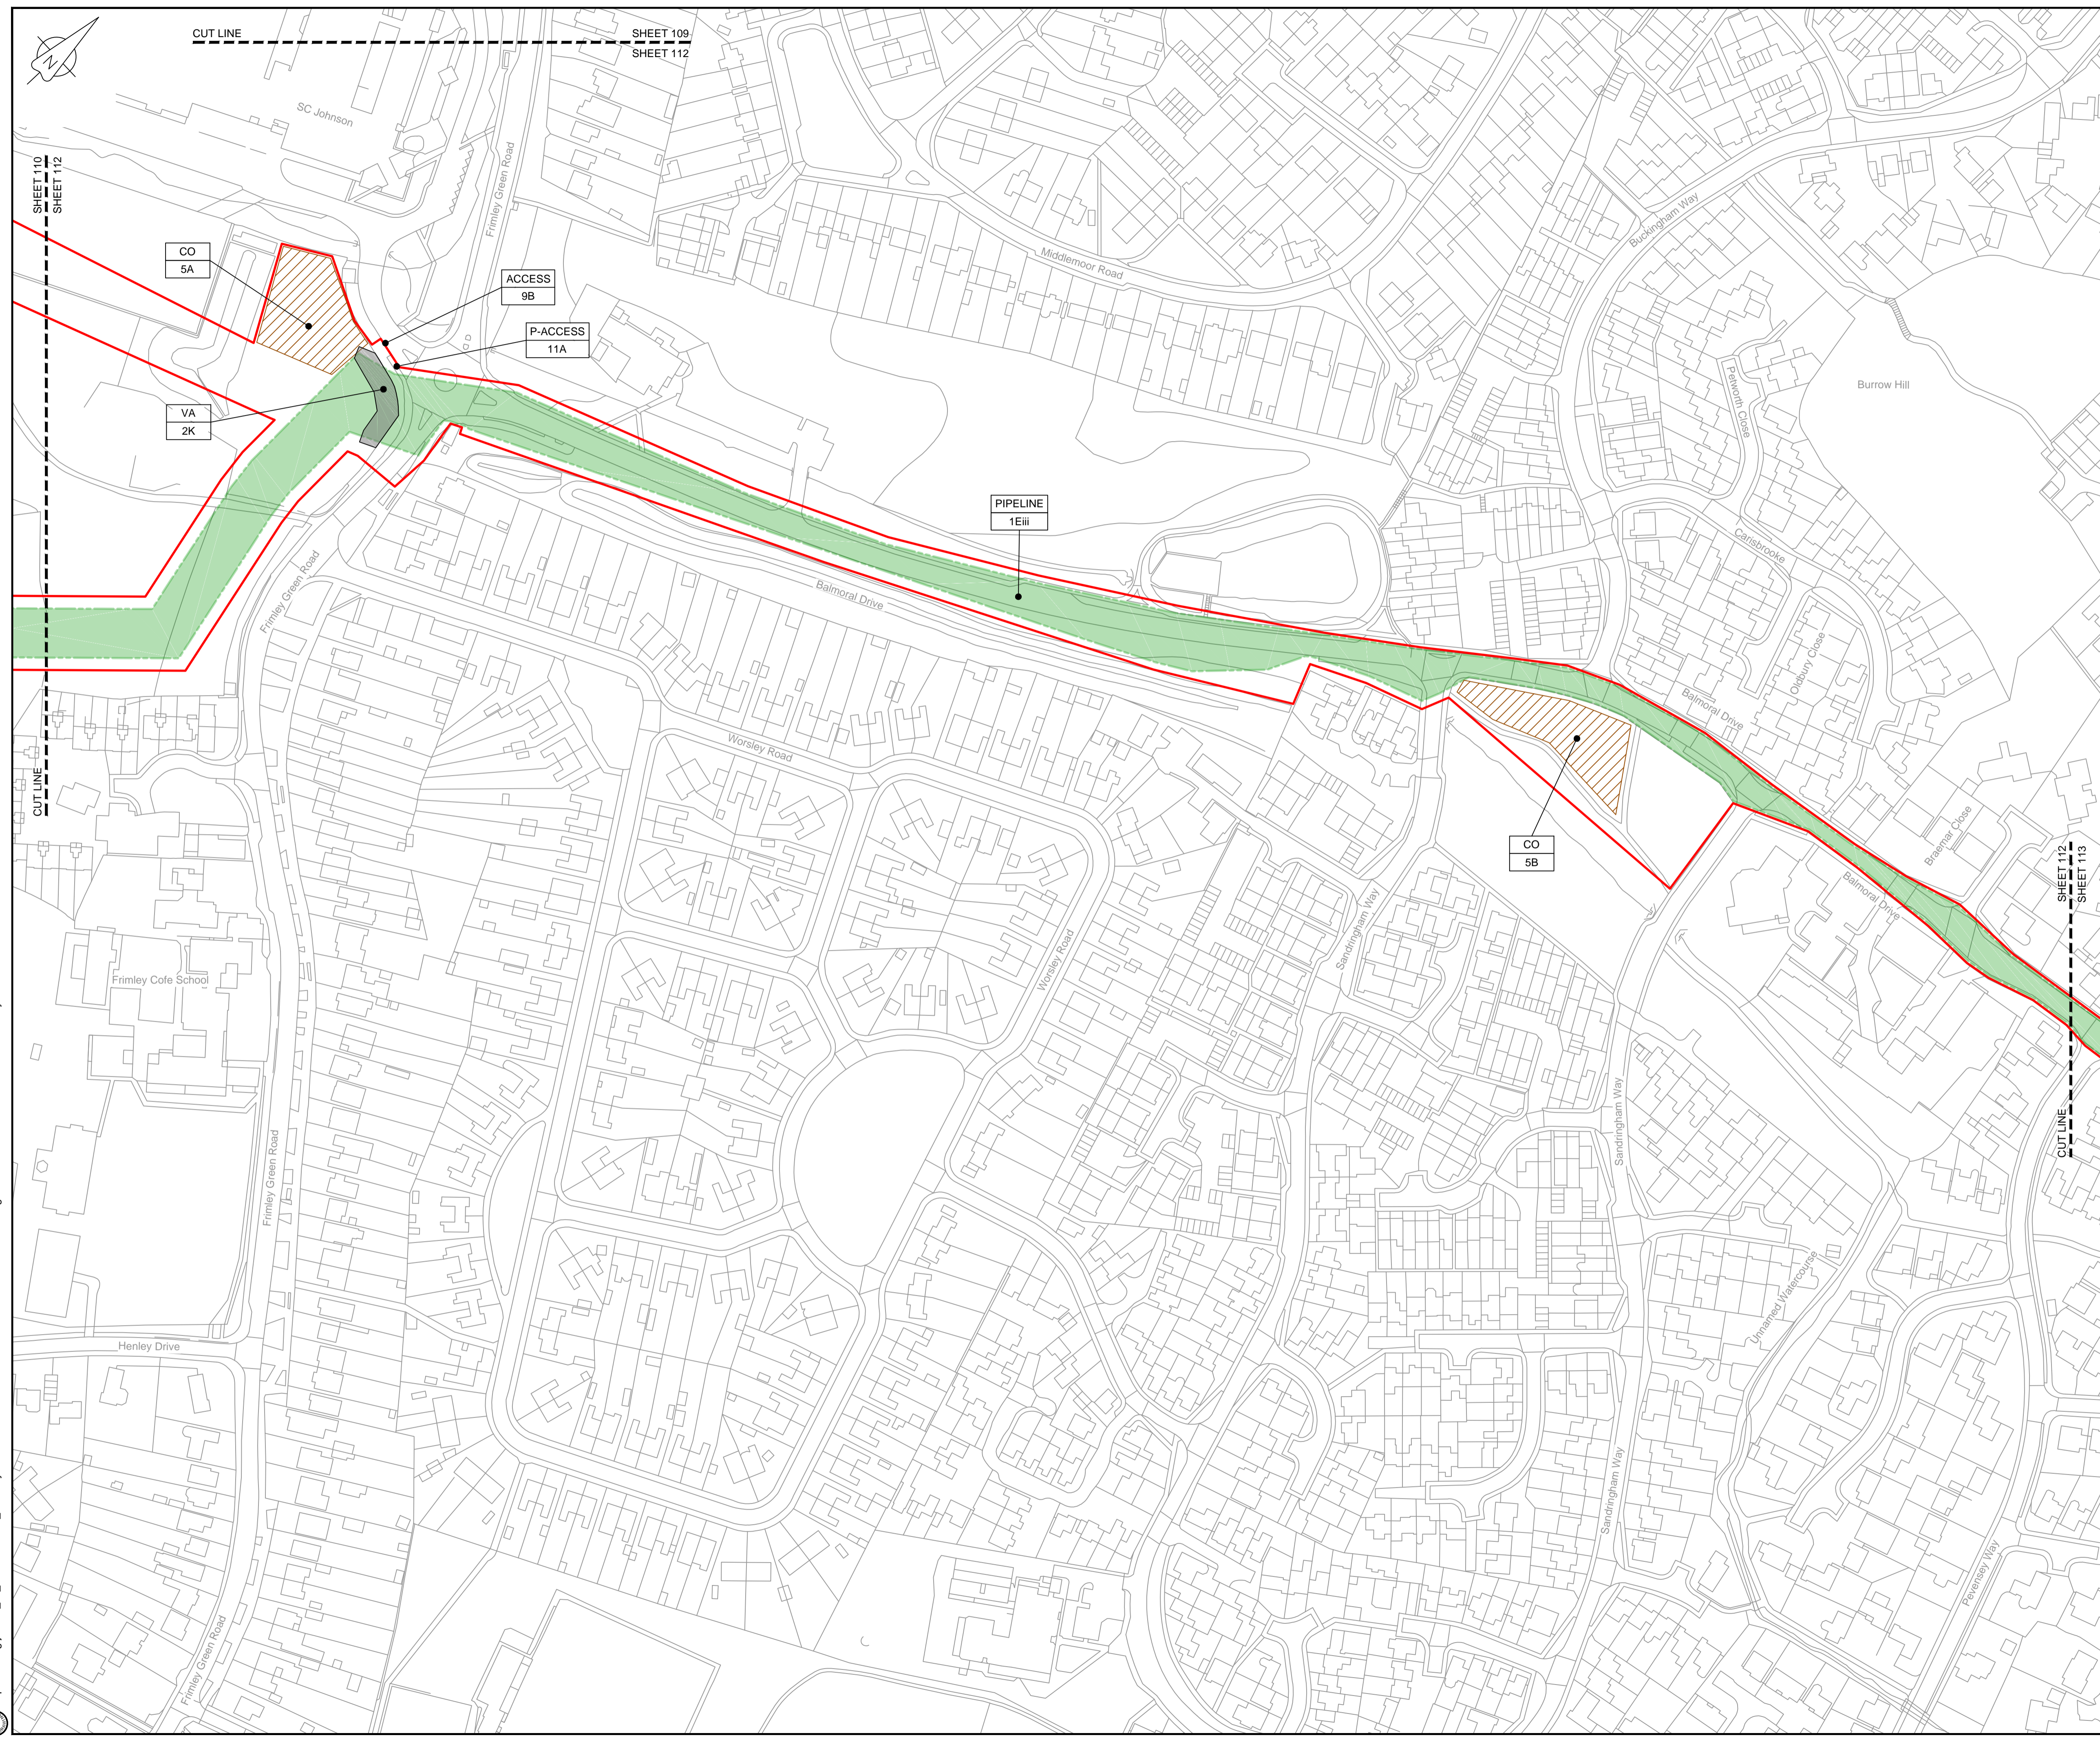

**LOCATION PLAN**  
SCALE 1:500,000

**NOTES**  
1. THIS DRAWING IS IN METRES UNLESS STATED OTHERWISE.

**LEGEND**

	ORDER LIMITS
	LIMITS OF DEVIATION
	COMPOUND (CO)
	ENVIRONMENTAL MITIGATION AREA (EM)
	ABOVE GROUND INSTALLATION (AGI) / VALVE (VA) / PRESSURE TRANSDUCER (PT)
	DESCRIPTION
	ID or WORK NUMBER (if applicable)
	ACCESS TEMPORARY CONSTRUCTION ACCESS
	P-ACCESS PERMANENT ACCESS
	COMMENCEMENT / TERMINATION OF WORKS (COMMENCEMENT = OPEN, TERMINATION = CLOSED)

Contains Ordnance Survey data © Crown copyright and database rights 2019.  
© Crown copyright and database rights 2019 OS Licence Number AL10005237.



Rev	Rev. Date	Purpose of revision	Drawn	Checked	Rev'd	Appr'd
C02	14/06/19	SHEETS 36 AND 108 REVISED FOLLOWING SSI ADVICE	SH	JA	ND	PH
C03	09/09/19	SHEETS 10, 11 AND 54 REVISED TO WITHDRAW A2B SUB-OPTION	BT	JA	ND	NJ

**JACOBS**  
1180 Eskdale Road, Wokingham, Wokingham, RG41 5TU  
Tel: +44(0)118 946 7000 Fax: +44(0)118 946 7001  
www.jacobs.com

Client: Esso Petroleum Company, Limited  
Emryn House,  
Emryn Way,  
Leatherhead,  
Surrey,  
KT22 8UX

Project: Southampton to London Pipeline Project

Drawing title: **WORKS PLAN SHEET 112 REGULATION 5 (2)(J)**


Drawing status: **Fit for Stage Approval**

Scale	1:1250	DO NOT SCALE
Jacobs No.	B2325300	Rev
Client no.		<b>C03</b>

Drawing number: **B2325300-JAC-000-CIV-DRG-000112**

© Copyright 2019 Jacobs U.K. Limited. The concepts and information contained in this document are the property of Jacobs. Use or copying of this document in whole or in part without the written permission of Jacobs constitutes an infringement of copyright. Limitation. This drawing has been prepared on behalf of, and for the exclusive use of, Jacobs' Client, and is subject to, and issued in accordance with, the provisions of the contract between Jacobs and the Client. Jacobs accepts no liability or responsibility whatsoever for, or in respect of, any use of, or reliance upon, this drawing by any third party.

C:\pwworking\jacobs\_uk\_water\utilities\_ssf\byondms33519\B2325300-JAC-000-CIV-DRG-000112.dwg - 10/09/2019 14:25:36 - A1Frame - BTaylor

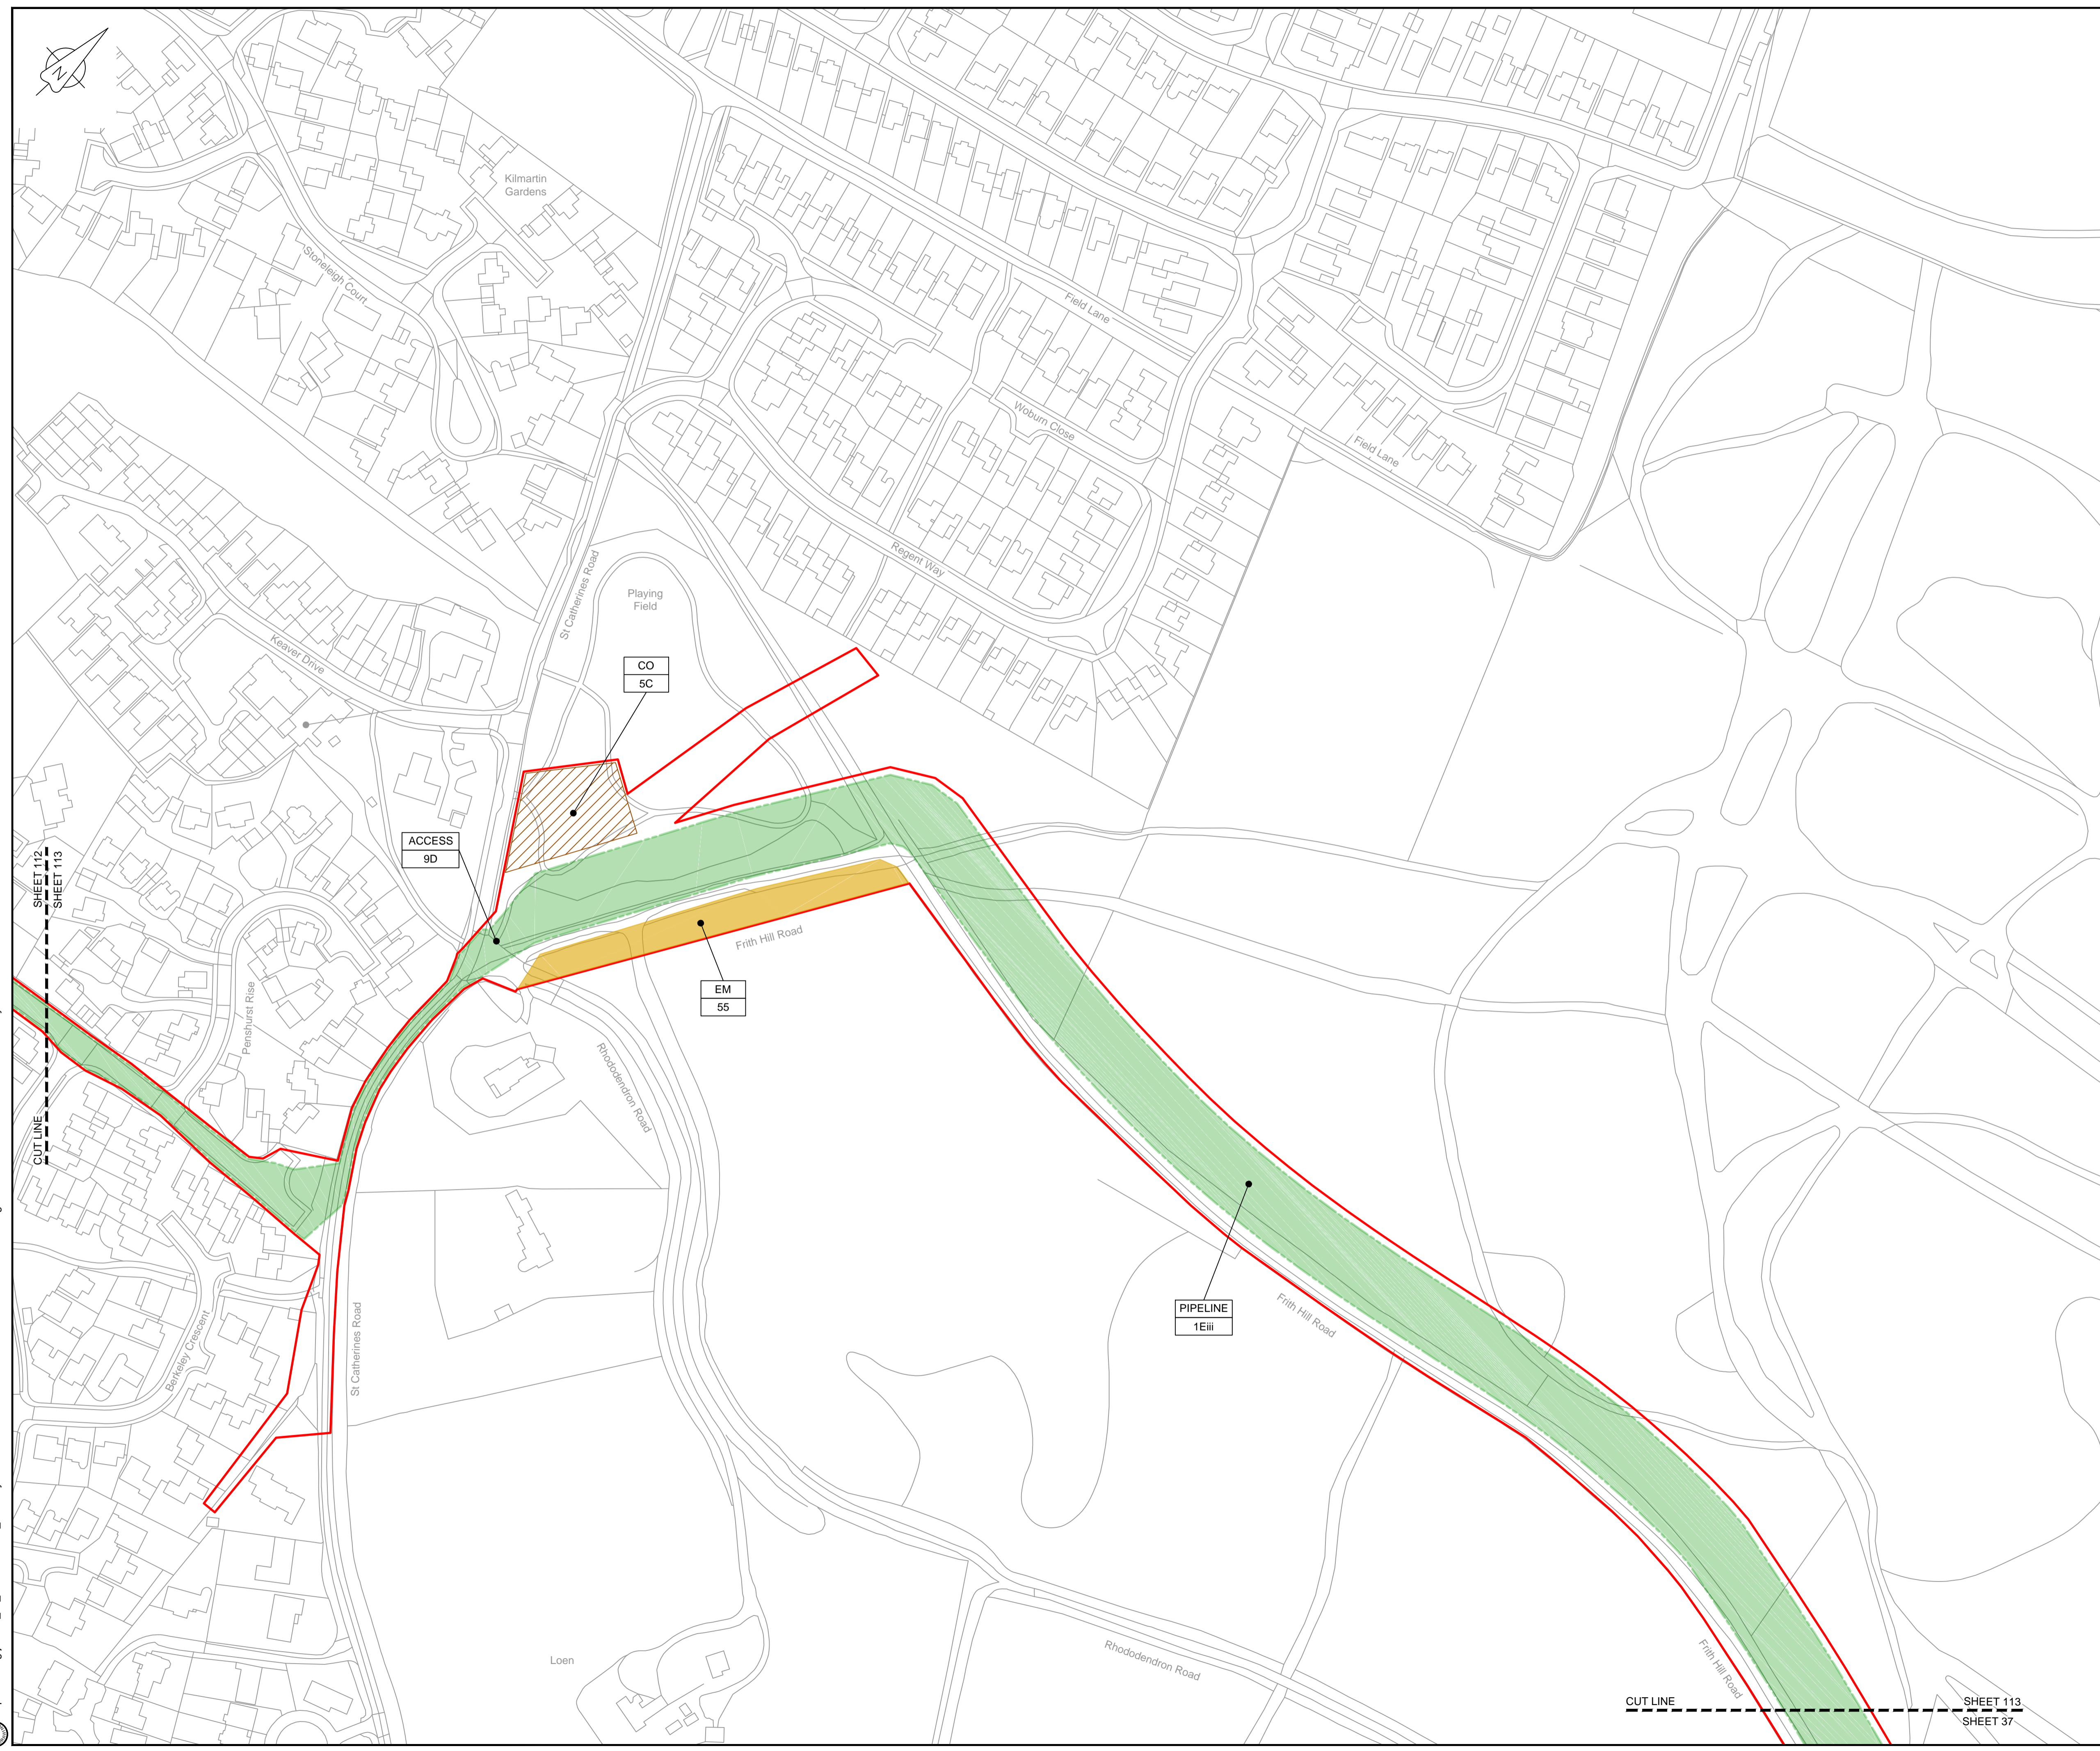

**LOCATION PLAN**  
SCALE 1:500,000

**NOTES**  
1. THIS DRAWING IS IN METRES UNLESS STATED OTHERWISE.

**LEGEND**

	ORDER LIMITS
	LIMITS OF DEVIATION
	COMPOUND (CO)
	ENVIRONMENTAL MITIGATION AREA (EM)
	ABOVE GROUND INSTALLATION (AGI) / VALVE (VA) / PRESSURE TRANSDUCER (PT)
	DESCRIPTION
	ID or WORK NUMBER (if applicable)
	ACCESS
	TEMPORARY CONSTRUCTION ACCESS
	P-ACCESS
	PERMANENT ACCESS
	COMMENCEMENT / TERMINATION OF WORKS (COMMENCEMENT = OPEN, TERMINATION = CLOSED)

Contains Ordnance Survey data © Crown copyright and database rights 2019.  
© Crown copyright and database rights 2019 OS Licence Number AL10005237.



Rev	Rev. Date	Purpose of revision	Drawn	Checked	Rev'd	Appr'd
C02	14/06/19	SHEETS 36 AND 109 REVISED FOLLOWING SSI ADVICE	SH	JA	ND	PH
C03	09/09/19	SHEETS 10, 11 AND 54 REVISED TO WITHDRAW A2b SUB-OPTION	BT	JA	ND	NJ



1180 Eskdale Road, Winnersh, Wokingham, RG41 5TU  
Tel:+44(0)118 946 7000 Fax:+44(0)118 946 7001  
www.jacobs.com

Client: Esso Petroleum Company, Limited  
Emryn House,  
Emryn Way,  
Leatherhead,  
Surrey,  
KT22 8UX

Project: Southampton to London Pipeline Project

Drawing title: **WORKS PLAN SHEET 113 REGULATION 5 (2)(J)**



Drawing status: **Fit for Stage Approval**

Scale	1:1250	DO NOT SCALE
Jacobs No.	B2325300	Rev
Client no.		<b>C03</b>
Drawing number	<b>B2325300-JAC-000-CIV-DRG-000113</b>	

C:\pwworking\jacobs\_uk\_water\utilities\_ssf\by\ordms3351\B2325300-JAC-000-CIV-DRG-000113.dwg - 10/09/2019 14:27:40 - A1Frame - BTaylor

SHEET 112  
SHEET 113

CUT LINE SHEET 113  
SHEET 37

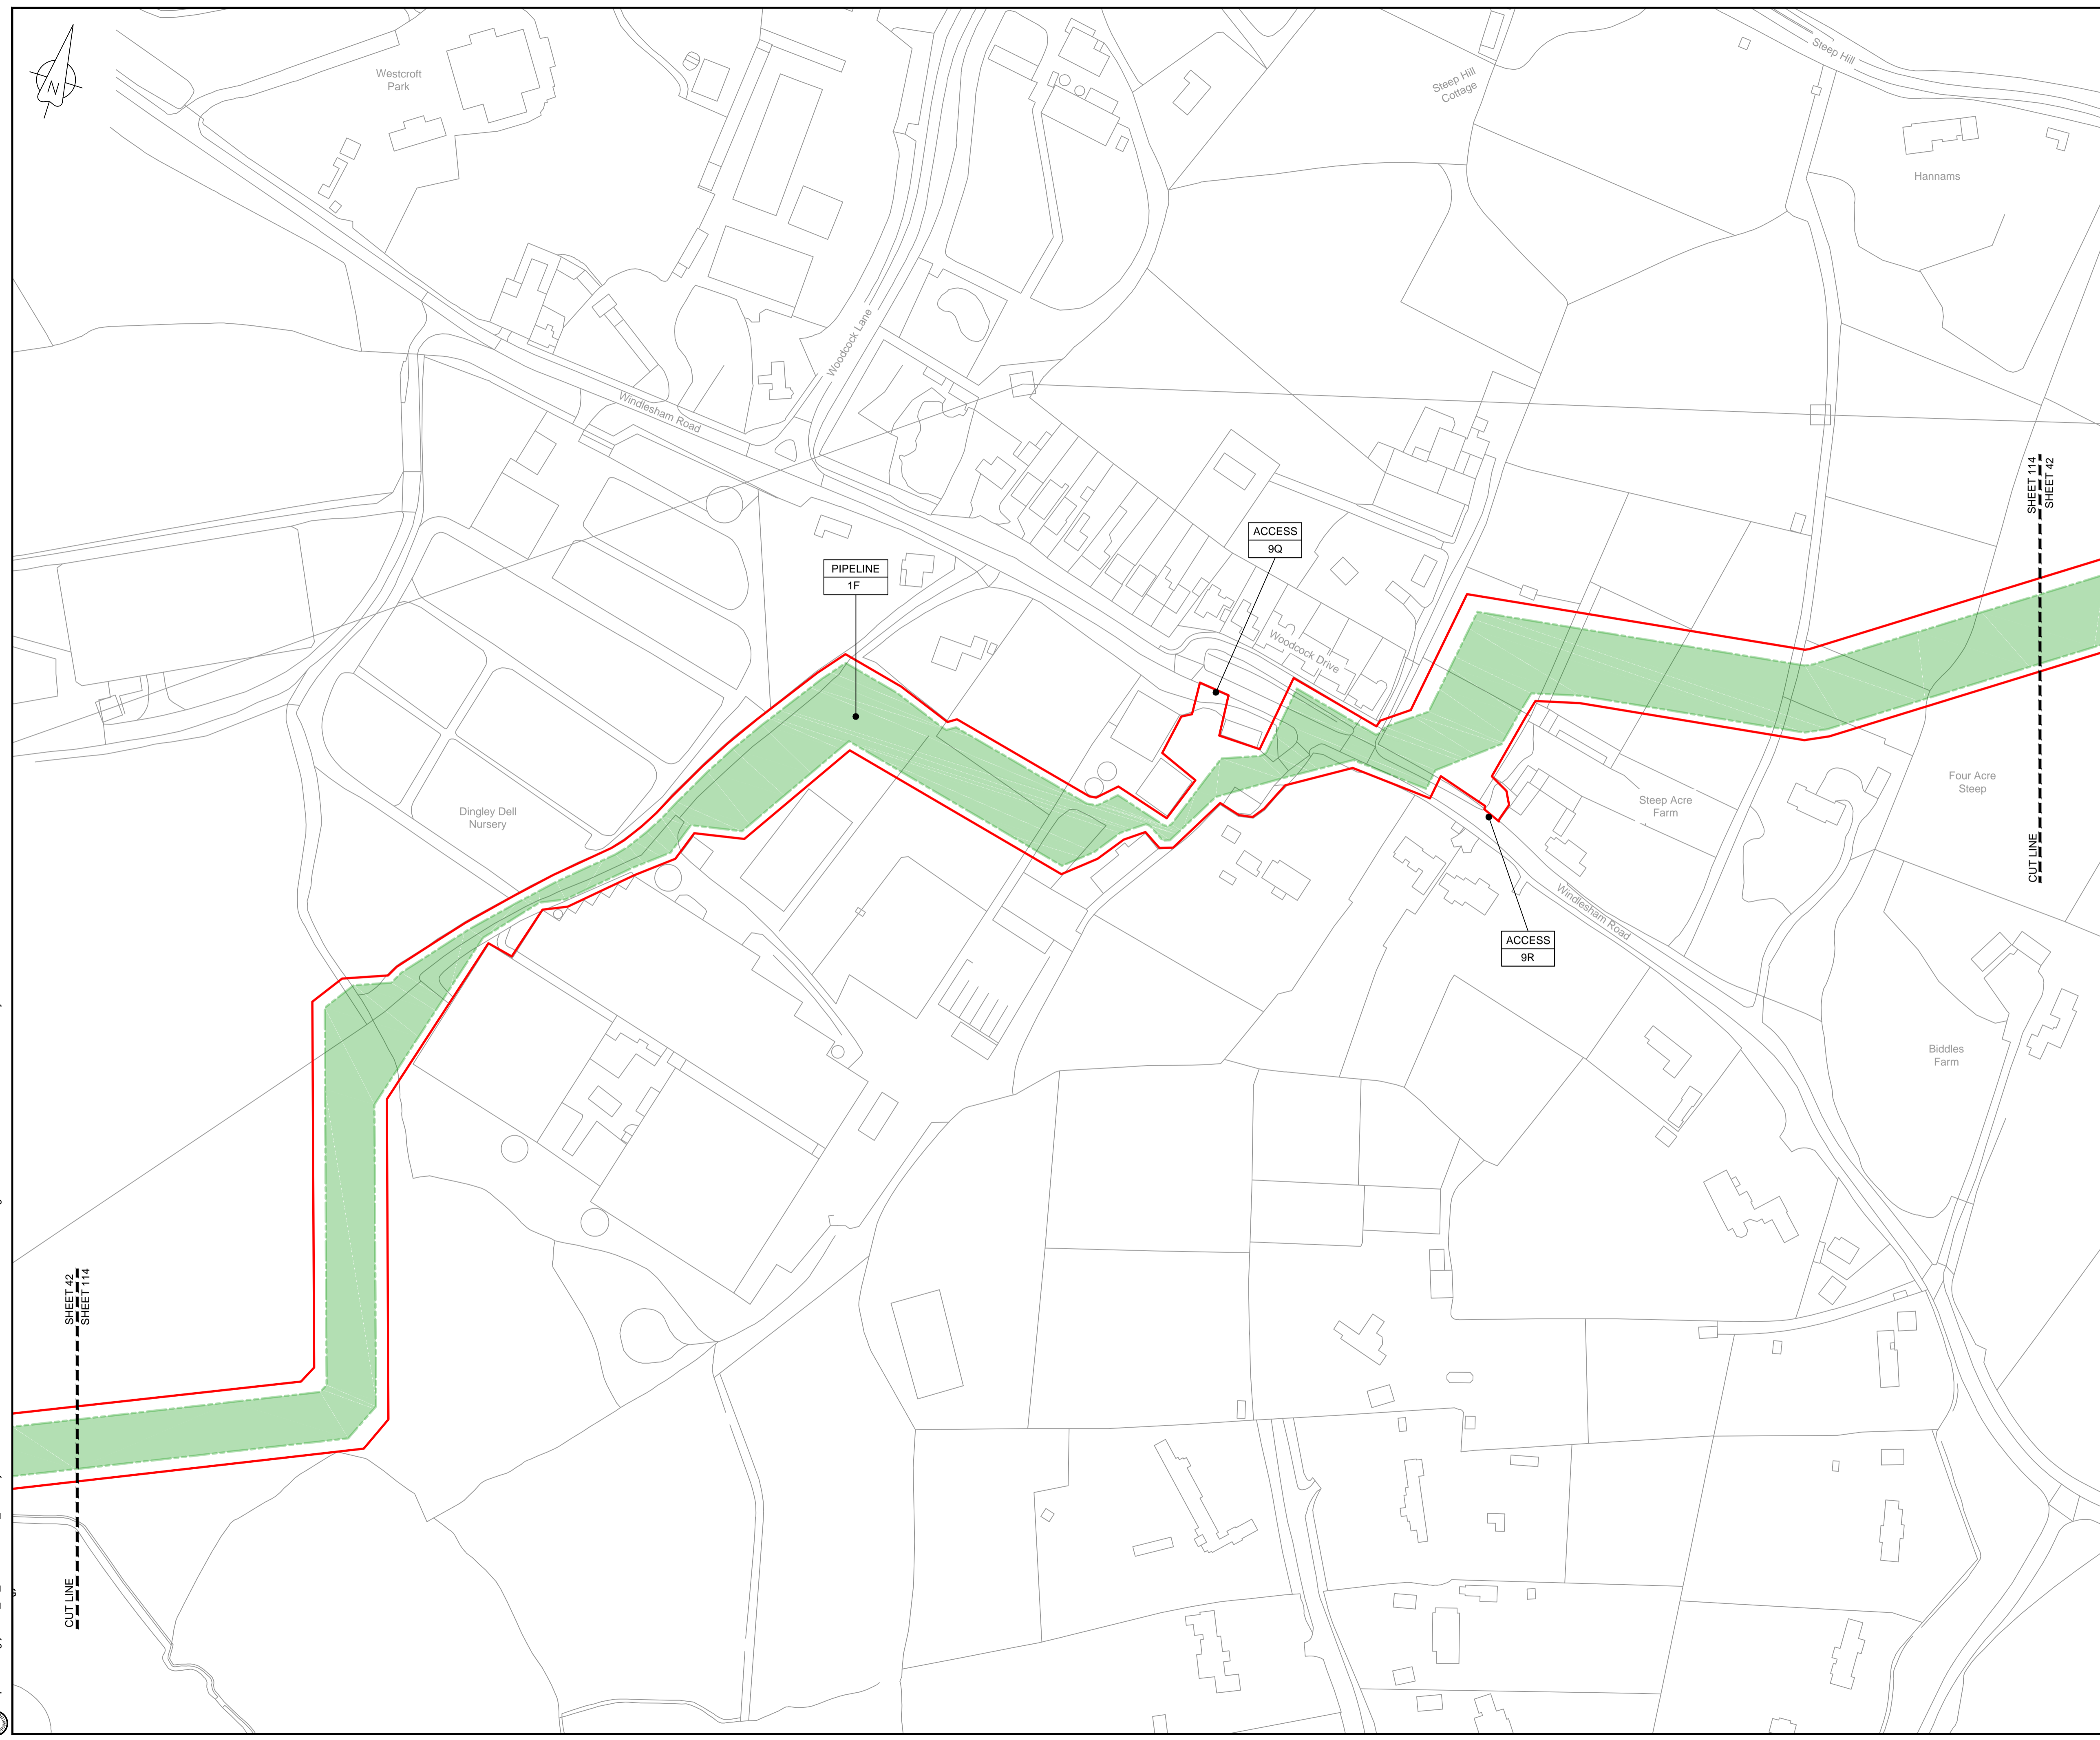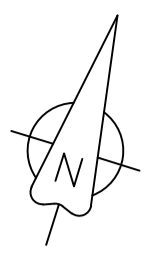

LOCATION PLAN  
SCALE 1:500,000

NOTES

1. THIS DRAWING IS IN METRES UNLESS STATED OTHERWISE.

LEGEND

- ORDER LIMITS
- LIMITS OF DEVIATION
- COMPOUND (CO)
- ENVIRONMENTAL MITIGATION AREA (EM)
- ABOVE GROUND INSTALLATION (AGI) / VALVE (VA) / PRESSURE TRANSDUCER (PT)
- DESCRIPTION
- ID or WORK NUMBER (if applicable)
- ACCESS TEMPORARY CONSTRUCTION ACCESS
- P-ACCESS PERMANENT ACCESS
- COMMENCEMENT / TERMINATION OF WORKS (COMMENCEMENT = OPEN, TERMINATION = CLOSED)

Contains Ordnance Survey data © Crown copyright and database rights 2019.

© Crown copyright and database rights 2019 OS Licence Number AL10005237.



Rev	Rev. Date	Purpose of revision	Drawn	Checked	Rev'd	Appr'd
C02	14/06/19	SHEETS 38 AND 109 REVISED FOLLOWING SSI ADVICE	SH	JA	ND	PH
C03	09/09/19	SHEETS 10, 11 AND 54 REVISED TO WITHDRAW A2B SUB-OPTION	BT	JA	ND	NJ



1180 Eskdale Road, Winnersh, Wokingham, RG41 5TU  
Tel:+44(0)118 946 7000 Fax:+44(0)118 946 7001  
www.jacobs.com

Client: Esso Petroleum Company, Limited  
Emryn House,  
Emryn Way,  
Leatherhead,  
Surrey,  
KT22 8UX



Southampton to London  
Pipeline Project

Drawing title  
**WORKS PLAN  
SHEET 114  
REGULATION 5 (2)(J)**


Drawing status  
**Fit for Stage Approval**

Scale	1:1250	DO NOT SCALE
Jacobs No.	B2325300	Rev
Client no.		<b>C03</b>

Drawing number  
**B2325300-JAC-000-CIV-DRG-000114**

© Copyright 2019 Jacobs U.K. Limited. The concepts and information contained in this document are the property of Jacobs. Use or copying of this document in whole or in part without the written permission of Jacobs constitutes an infringement of copyright. Limitation: This drawing has been prepared on behalf of, and for the exclusive use of, the Client. Jacobs accepts no liability or responsibility whatsoever for, or in respect of, any use of, or reliance upon, this drawing by any third party.



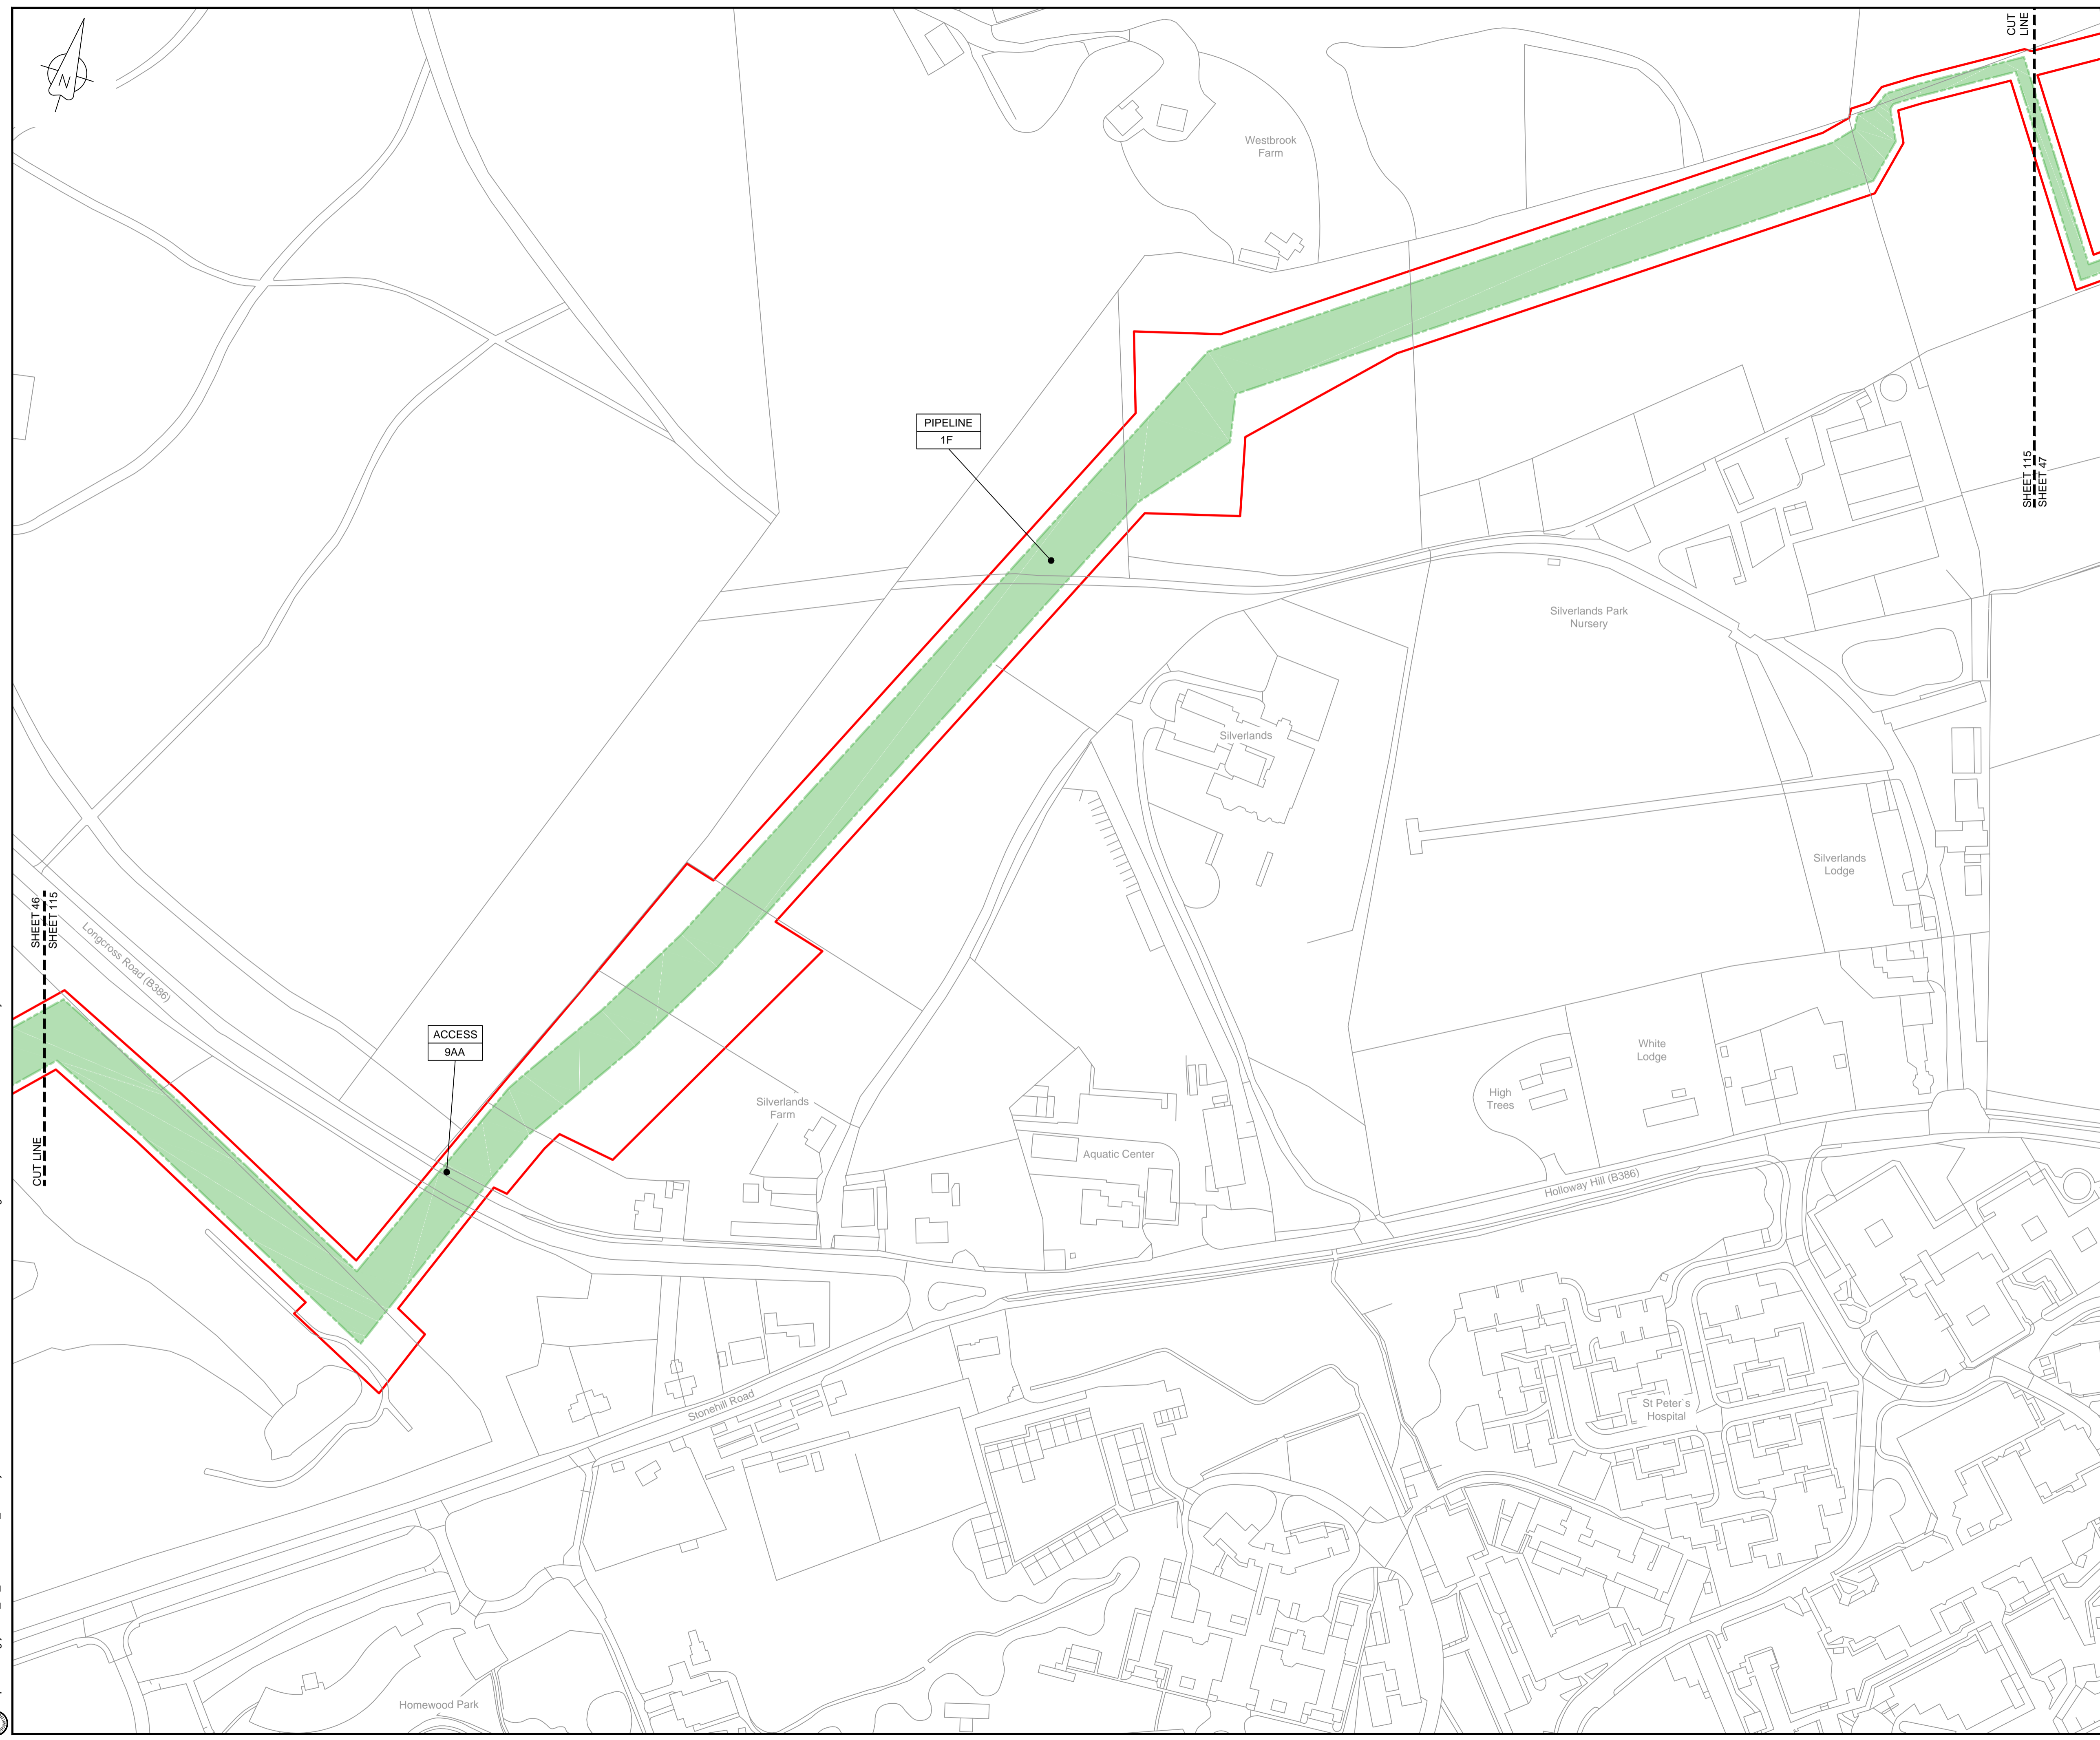

**LOCATION PLAN**  
SCALE 1:500,000

**NOTES**

1. THIS DRAWING IS IN METRES UNLESS STATED OTHERWISE.

**LEGEND**

- ORDER LIMITS
- LIMITS OF DEVIATION
- COMPOUND (CO)
- ENVIRONMENTAL MITIGATION AREA (EM)
- ABOVE GROUND INSTALLATION (AGI) / VALVE (VA) / PRESSURE TRANSDUCER (PT)
- DESCRIPTION
- ID or WORK NUMBER (if applicable)
- ACCESS
- TEMPORARY CONSTRUCTION ACCESS
- PERMANENT ACCESS
- COMMENCEMENT / TERMINATION OF WORKS  
(COMMENCEMENT = OPEN, TERMINATION = CLOSED)

Contains Ordnance Survey data © Crown copyright and database rights 2019.

© Crown copyright and database rights 2019 OS Licence Number AL10005237.



Rev	Rev. Date	Purpose of revision	Drawn	Checked	Rev'd	Appr'd
C02	14/06/19	SHEETS 38 AND 109 REVISED FOLLOWING SSI ADVICE	SH	JA	ND	PH
C03	09/09/19	SHEETS 10, 11 AND 54 REVISED TO WITHDRAW A2b SUB-OPTION	BT	JA	ND	NJ



1180 Eskdale Road, Winnersh, Wokingham, RG41 5TU  
Tel: +44(0)118 946 7000 Fax: +44(0)118 946 7001  
www.jacobs.com

Client: Esso Petroleum Company, Limited  
Emryn House,  
Emryn Way,  
Leatherhead,  
Surrey,  
KT22 8UX




Drawing title  
**WORKS PLAN  
SHEET 115  
REGULATION 5 (2)(J)**

Drawing status  
**Fit for Stage Approval**

Scale	1:1250	DO NOT SCALE
Jacobs No.	B2325300	Rev
Client no.		<b>C03</b>

Drawing number  
**B2325300-JAC-000-CIV-DRG-000115**

© Copyright 2019 Jacobs U.K. Limited. The concepts and information contained in this document are the property of Jacobs. Use or copying of this document in whole or in part without the written permission of Jacobs constitutes an infringement of copyright. Limitation: This drawing has been prepared on behalf of, and for the exclusive use of, Jacobs' Client, and is subject to, and issued in accordance with, the provisions of the contract between Jacobs and the Client. Jacobs accepts no liability or responsibility whatsoever for, or in respect of, any use of, or reliance upon, this drawing by any third party.

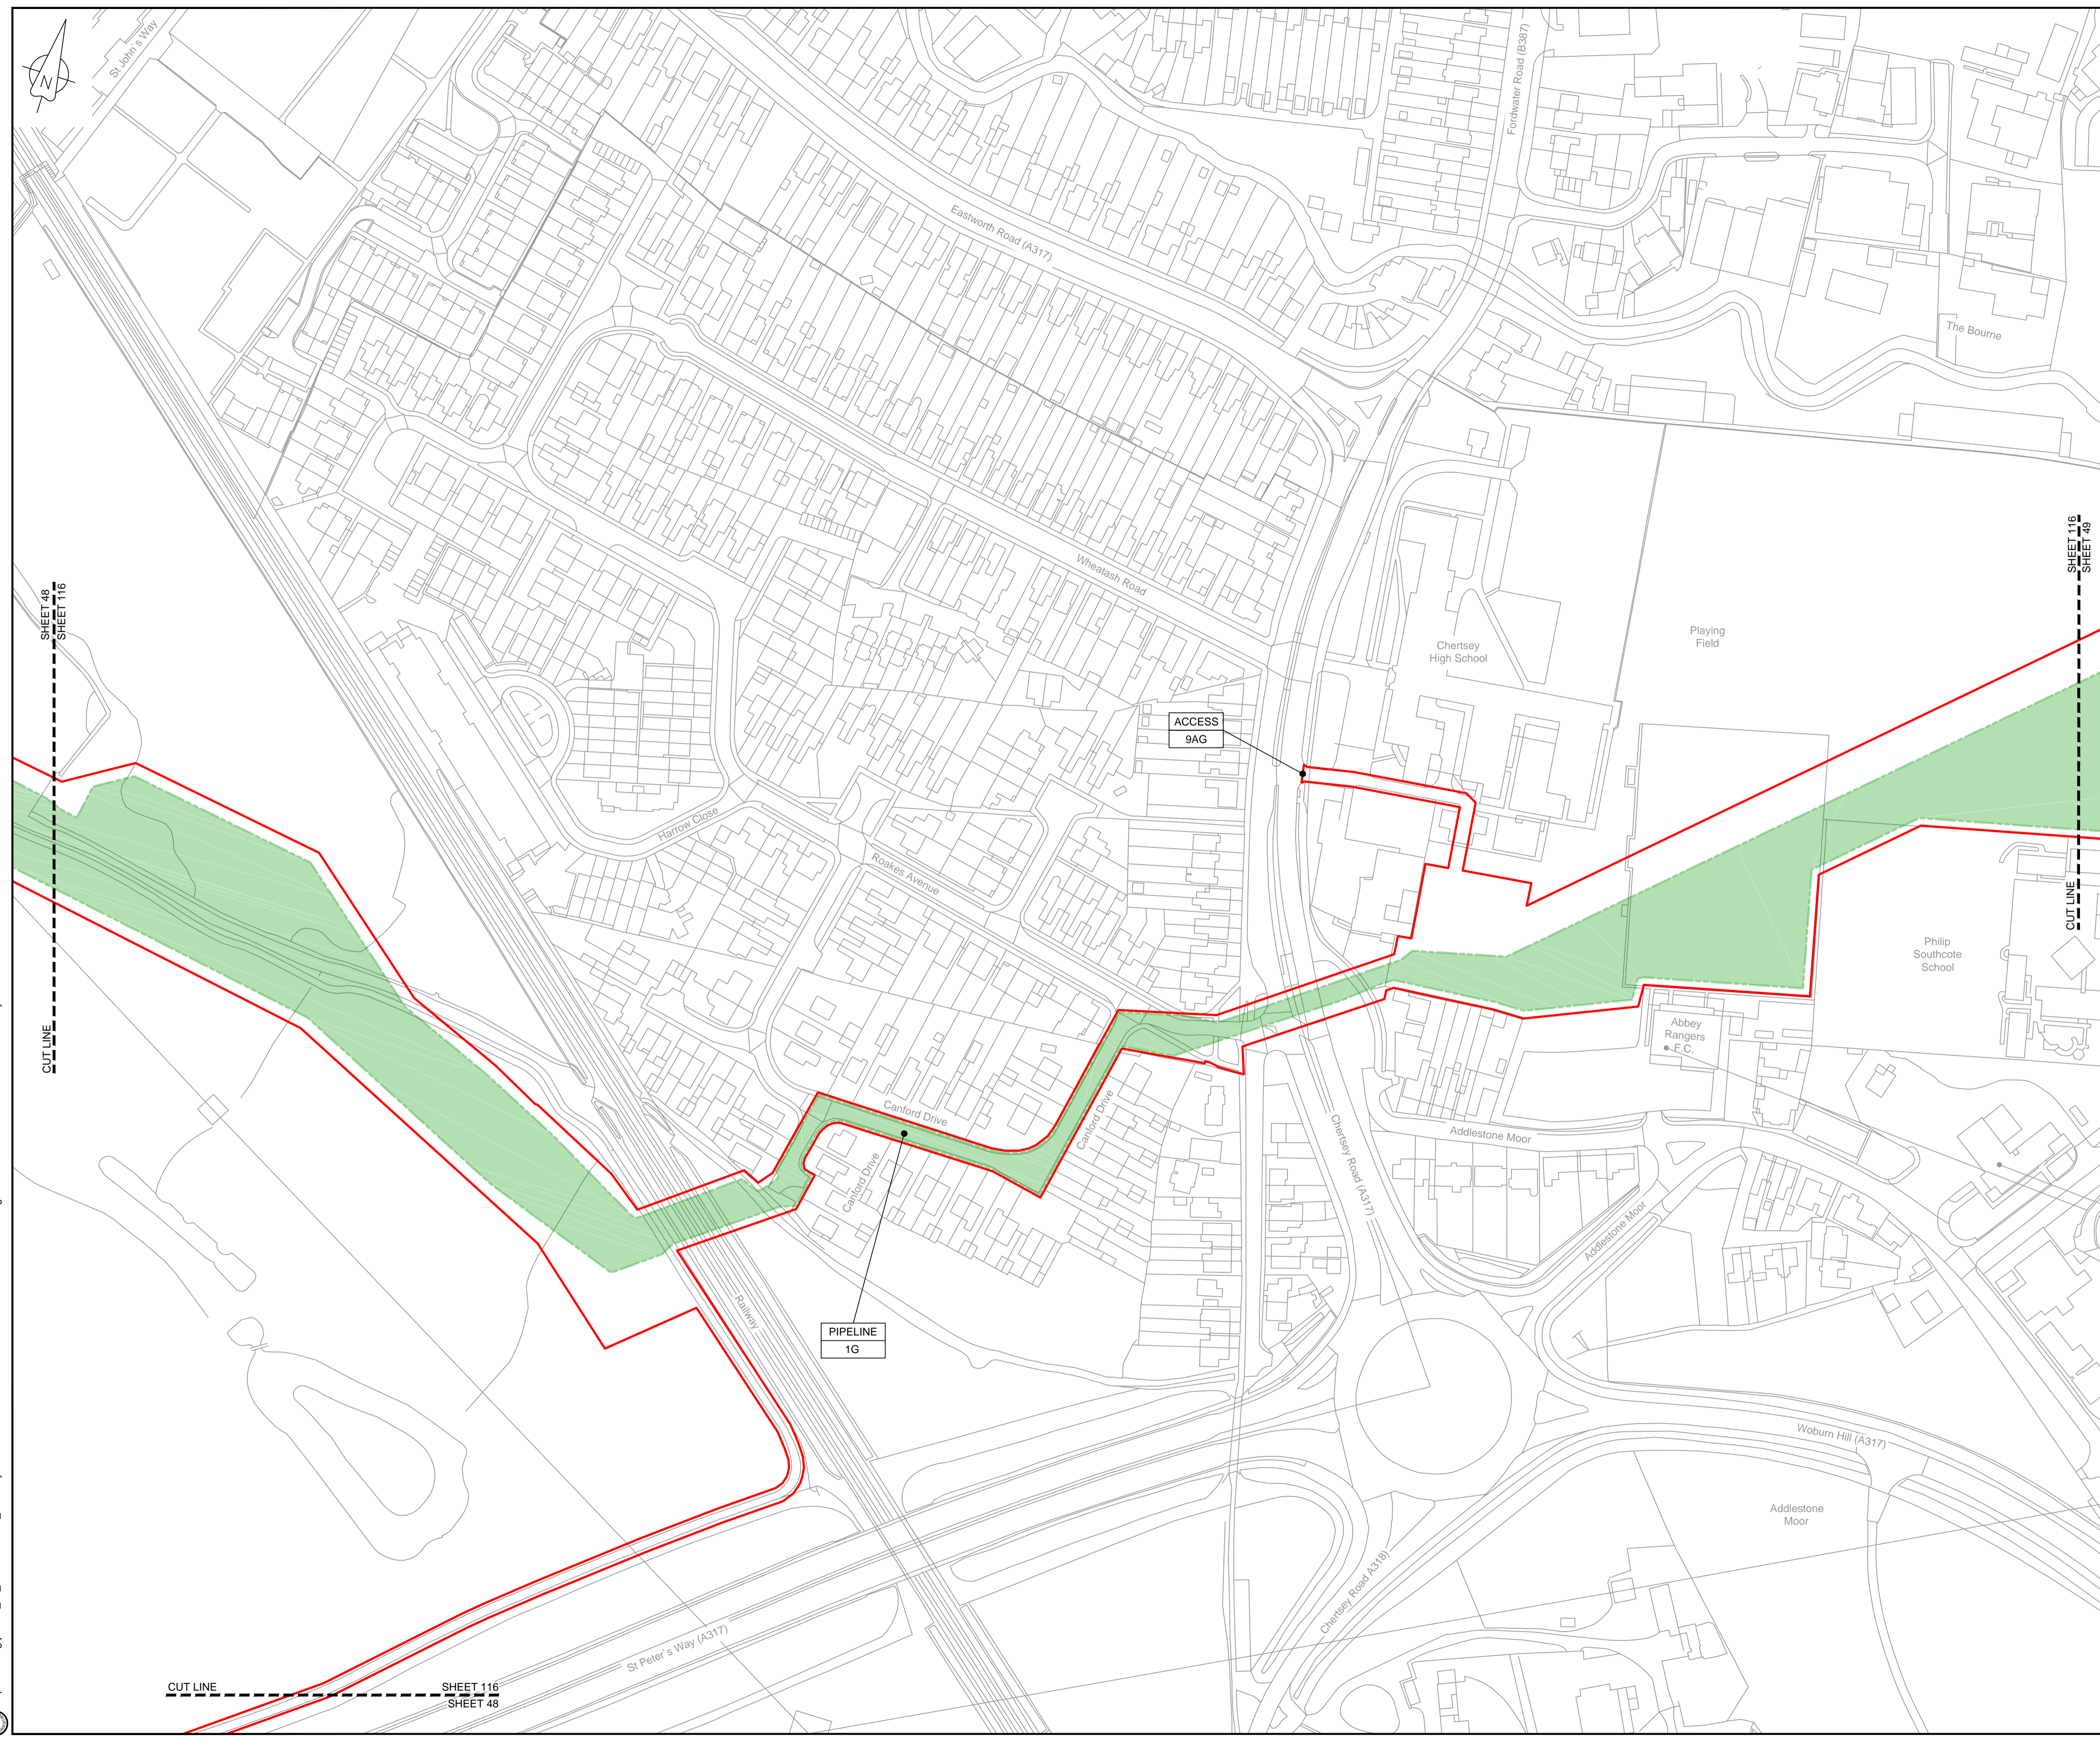


**LOCATION PLAN**  
SCALE 1:500,000

**NOTES**  
1. THIS DRAWING IS IN METRES UNLESS STATED OTHERWISE.

**LEGEND**

	ORDER LIMITS
	LIMITS OF DEVIATION
	COMPOUND (CO)
	ENVIRONMENTAL MITIGATION AREA (EM)
	ABOVE GROUND INSTALLATION (AGI) / VALVE (VA) / PRESSURE TRANSDUCER (PT)
	DESCRIPTION
	ID or WORK NUMBER (if applicable)
	ACCESS
	TEMPORARY CONSTRUCTION ACCESS
	PERMANENT ACCESS
	COMMENCEMENT / TERMINATION OF WORKS (COMMENCEMENT = OPEN, TERMINATION = CLOSED)

Contains Ordnance Survey data © Crown copyright and database rights 2019.  
© Crown copyright and database rights 2019 OS Licence Number AL10005237.

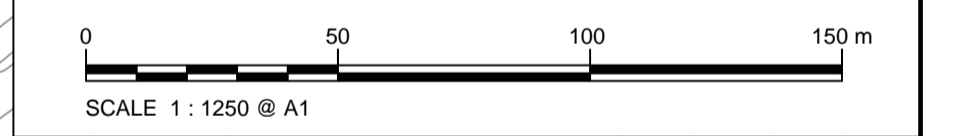

Rev	Rev. Date	Purpose of revision	Drawn	Checked	Rev'd	Appr'd
C02	14/06/19	SHEETS 38 AND 108 REVISED FOLLOWING SSI ADVICE	SH	JA	ND	PH
C03	09/09/19	SHEETS 10, 11 AND 54 REVISED TO WITHDRAW A2B SUB-OPTION	BT	JA	ND	NJ

**JACOBS**  
1180 Eskdale Road, Wokingham, Wokingham, RG41 5TU  
Tel: +44(0)118 946 7000 Fax: +44(0)118 946 7001  
www.jacobs.com

Client: Esso Petroleum Company, Limited  
Emryn House,  
Emryn Way,  
Leatherhead,  
Surrey,  
KT22 8UX

Southampton to London Pipeline Project

Drawing title  
**WORKS PLAN  
SHEET 116  
REGULATION 5 (2)(J)**

Drawing status  
**Fit for Stage Approval**

Scale	1:1250	DO NOT SCALE
Jacobs No.	B2325300	Rev
Client no.		<b>C03</b>


Drawing number  
**B2325300-JAC-000-CIV-DRG-000116**

© Copyright 2019 Jacobs U.K. Limited. The concepts and information contained in this document are the property of Jacobs. Use or copying of this document in whole or in part without the written permission of Jacobs constitutes an infringement of copyright. Limitation: This drawing has been prepared on behalf of, and for the exclusive use of, the Client, and is subject to, and issued in accordance with, the provisions of the contract between Jacobs and the Client. Jacobs accepts no liability or responsibility whatsoever for, or in respect of, any use of, or reliance upon, this drawing by any third party.

CUT LINE SHEET 48 SHEET 116

SHEET 116 SHEET 49

CUT LINE SHEET 116 SHEET 48

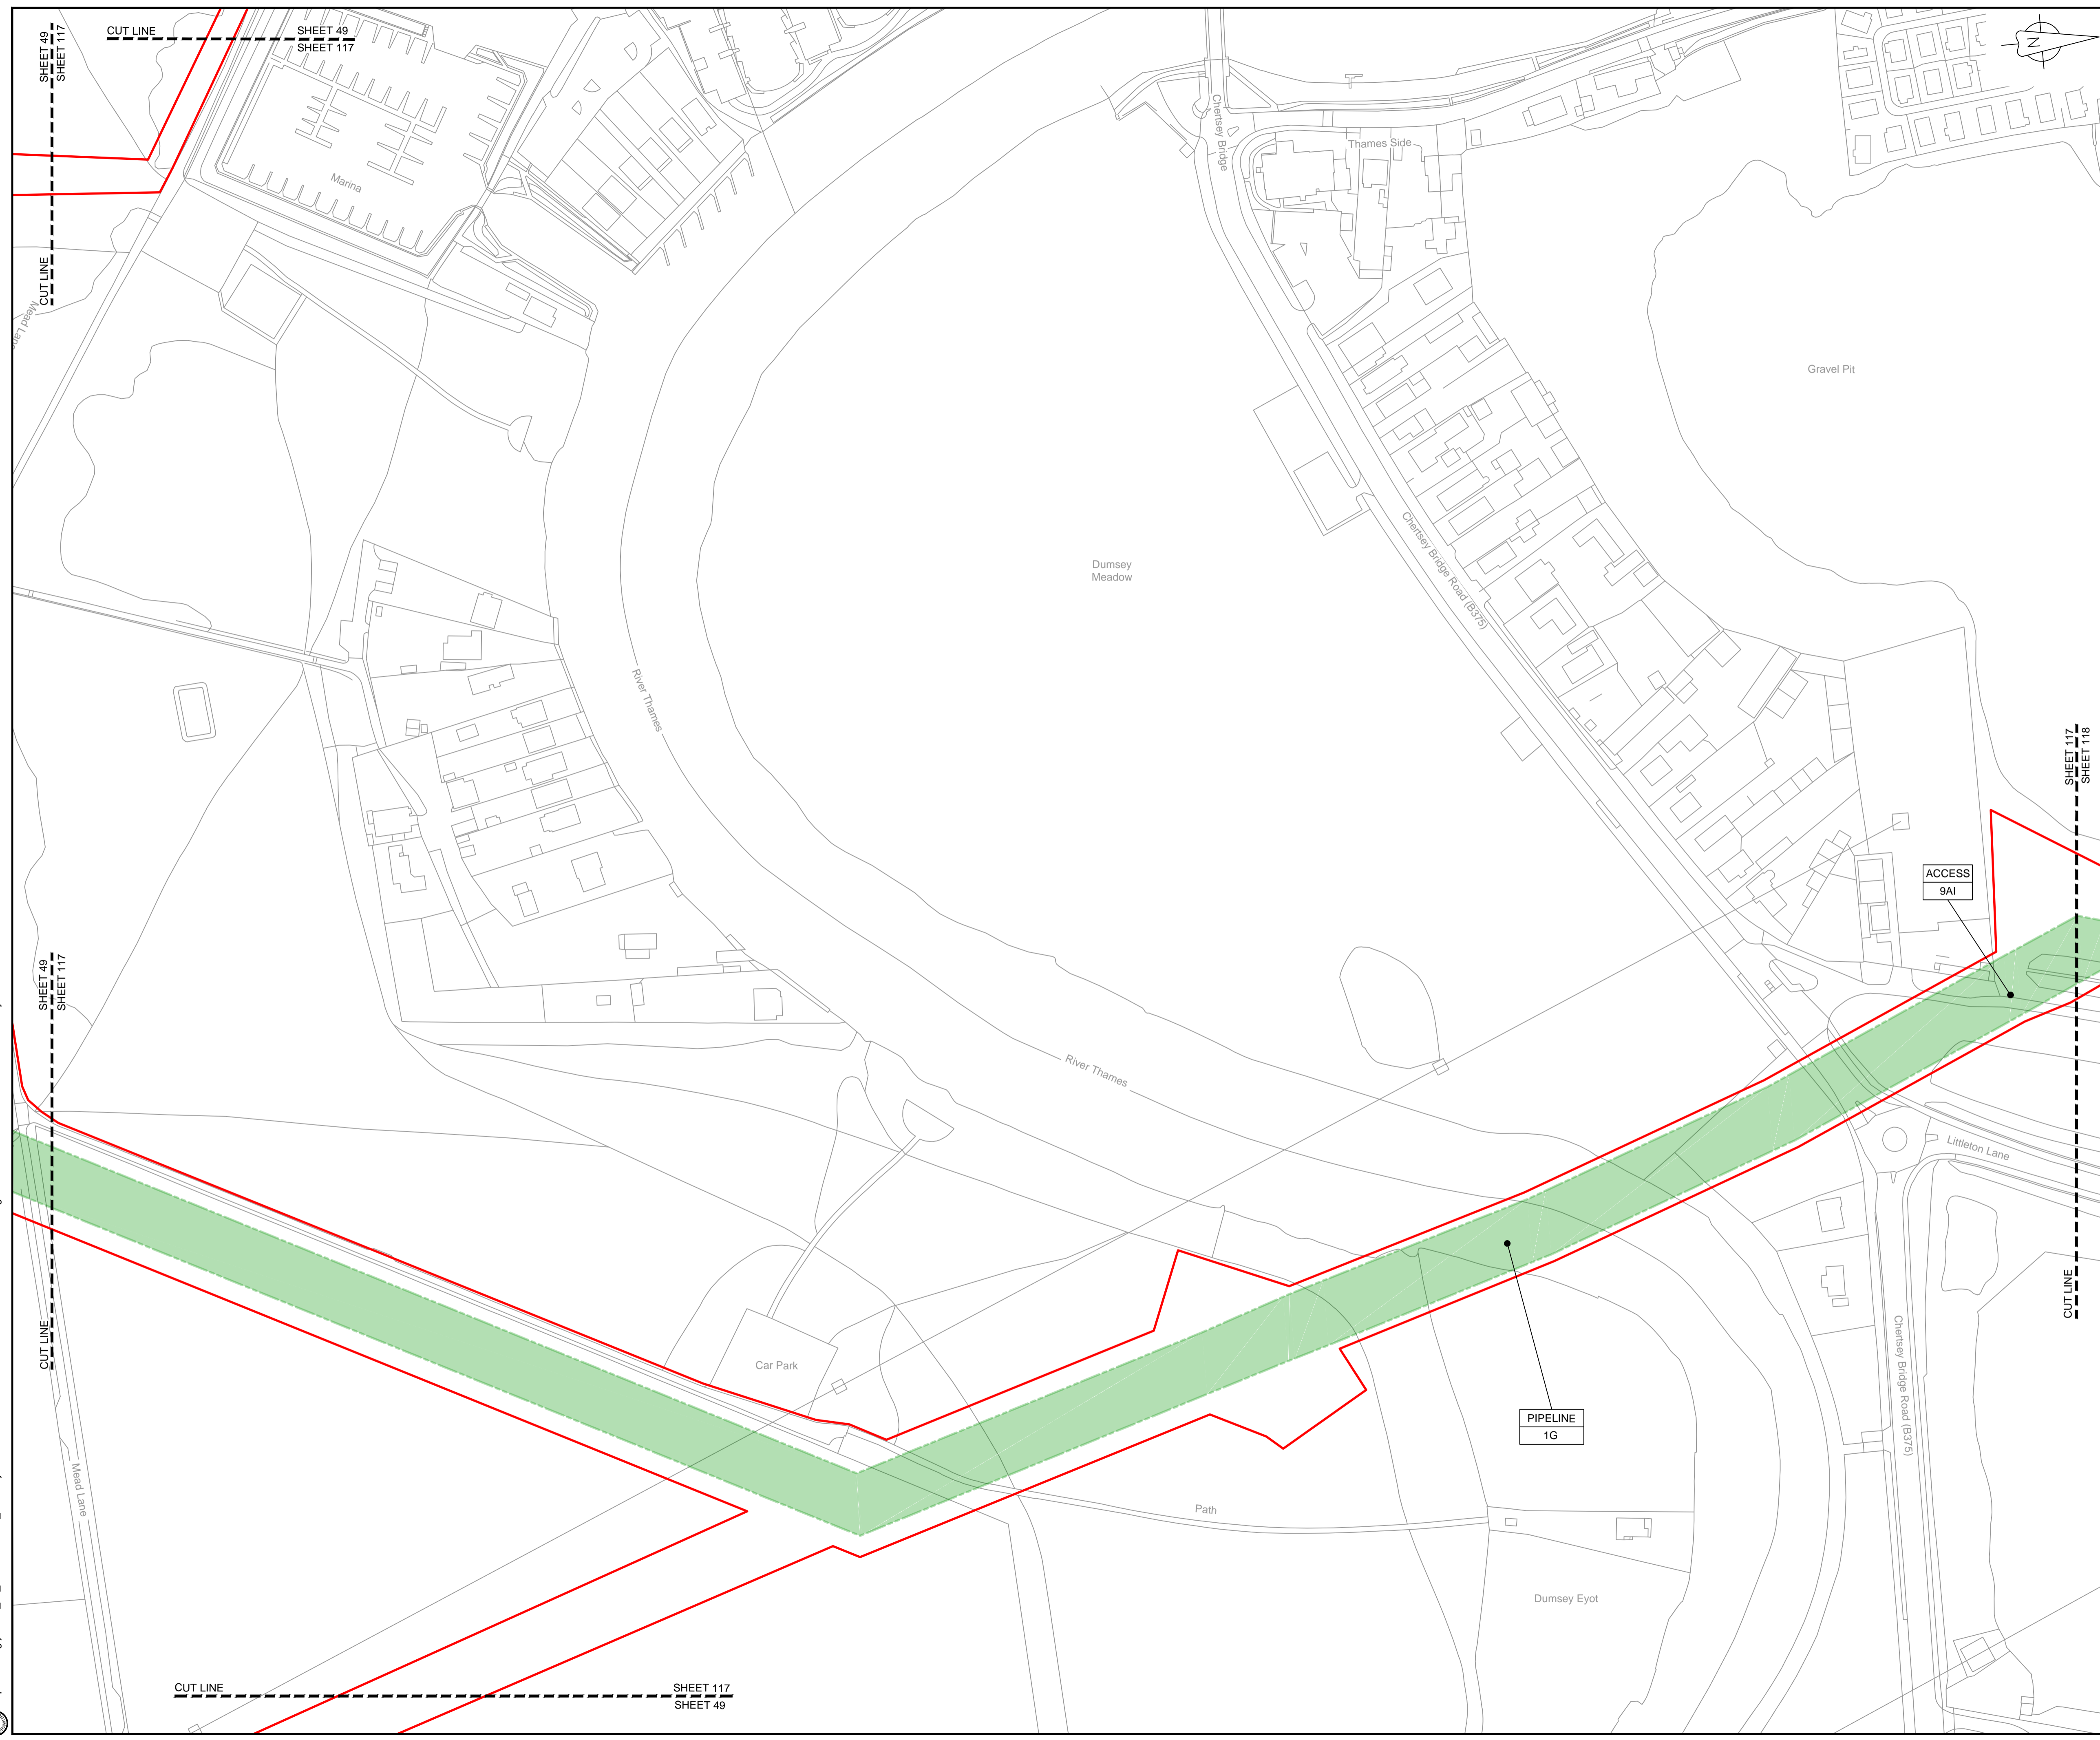


**LOCATION PLAN**  
SCALE 1:500,000

**NOTES**  
1. THIS DRAWING IS IN METRES UNLESS STATED OTHERWISE.

**LEGEND**

	ORDER LIMITS
	LIMITS OF DEVIATION
	COMPOUND (CO)
	ENVIRONMENTAL MITIGATION AREA (EM)
	ABOVE GROUND INSTALLATION (AGI) / VALVE (VA) / PRESSURE TRANSDUCER (PT)
	DESCRIPTION
	ID or WORK NUMBER (if applicable)
	ACCESS
	TEMPORARY CONSTRUCTION ACCESS
	P-ACCESS
	PERMANENT ACCESS
	COMMENCEMENT / TERMINATION OF WORKS (COMMENCEMENT = OPEN, TERMINATION = CLOSED)

Contains Ordnance Survey data © Crown copyright and database rights 2019.  
© Crown copyright and database rights 2019 OS Licence Number AL10005237.

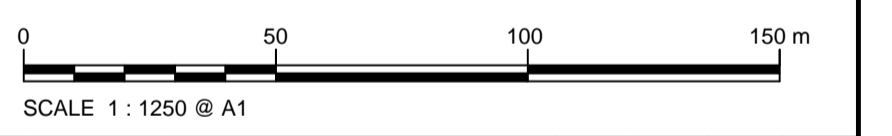

Rev	Rev. Date	Purpose of revision	Drawn	Checked	Rev'd	Appr'd
C02	14/06/19	SHEETS 36 AND 109 REVISED FOLLOWING SSI ADVICE	SH	JA	ND	PH
C03	09/09/19	SHEETS 10, 11 AND 54 REVISED TO WITHDRAW A2b SUB-OPTION	BT	JA	ND	NJ

**JACOBS**

1180 Eskdale Road, Wokingham, Wokingham, RG41 5TU  
Tel: +44(0)118 946 7000 Fax: +44(0)118 946 7001  
www.jacobs.com

Client: Esso Petroleum Company, Limited  
Emryn House,  
Emryn Way,  
Leatherhead,  
Surrey,  
KT22 8UX




Drawing title  
**WORKS PLAN  
SHEET 117  
REGULATION 5 (2)(J)**

Drawing status  
**Fit for Stage Approval**

Scale	1:1250	DO NOT SCALE
Jacobs No.	B2325300	Rev
Client no.		<b>C03</b>

Drawing number  
**B2325300-JAC-000-CIV-DRG-000117**

© Copyright 2019 Jacobs U.K. Limited. The concepts and information contained in this document are the property of Jacobs. Use or copying of this document in whole or in part without the written permission of Jacobs constitutes an infringement of copyright. Limitation: This drawing has been prepared on behalf of, and for the exclusive use of, the Client, and is subject to, and issued in accordance with, the provisions of the contract between Jacobs and the Client. Jacobs accepts no liability or responsibility whatsoever for, or in respect of, any use of, or reliance upon, this drawing by any third party.

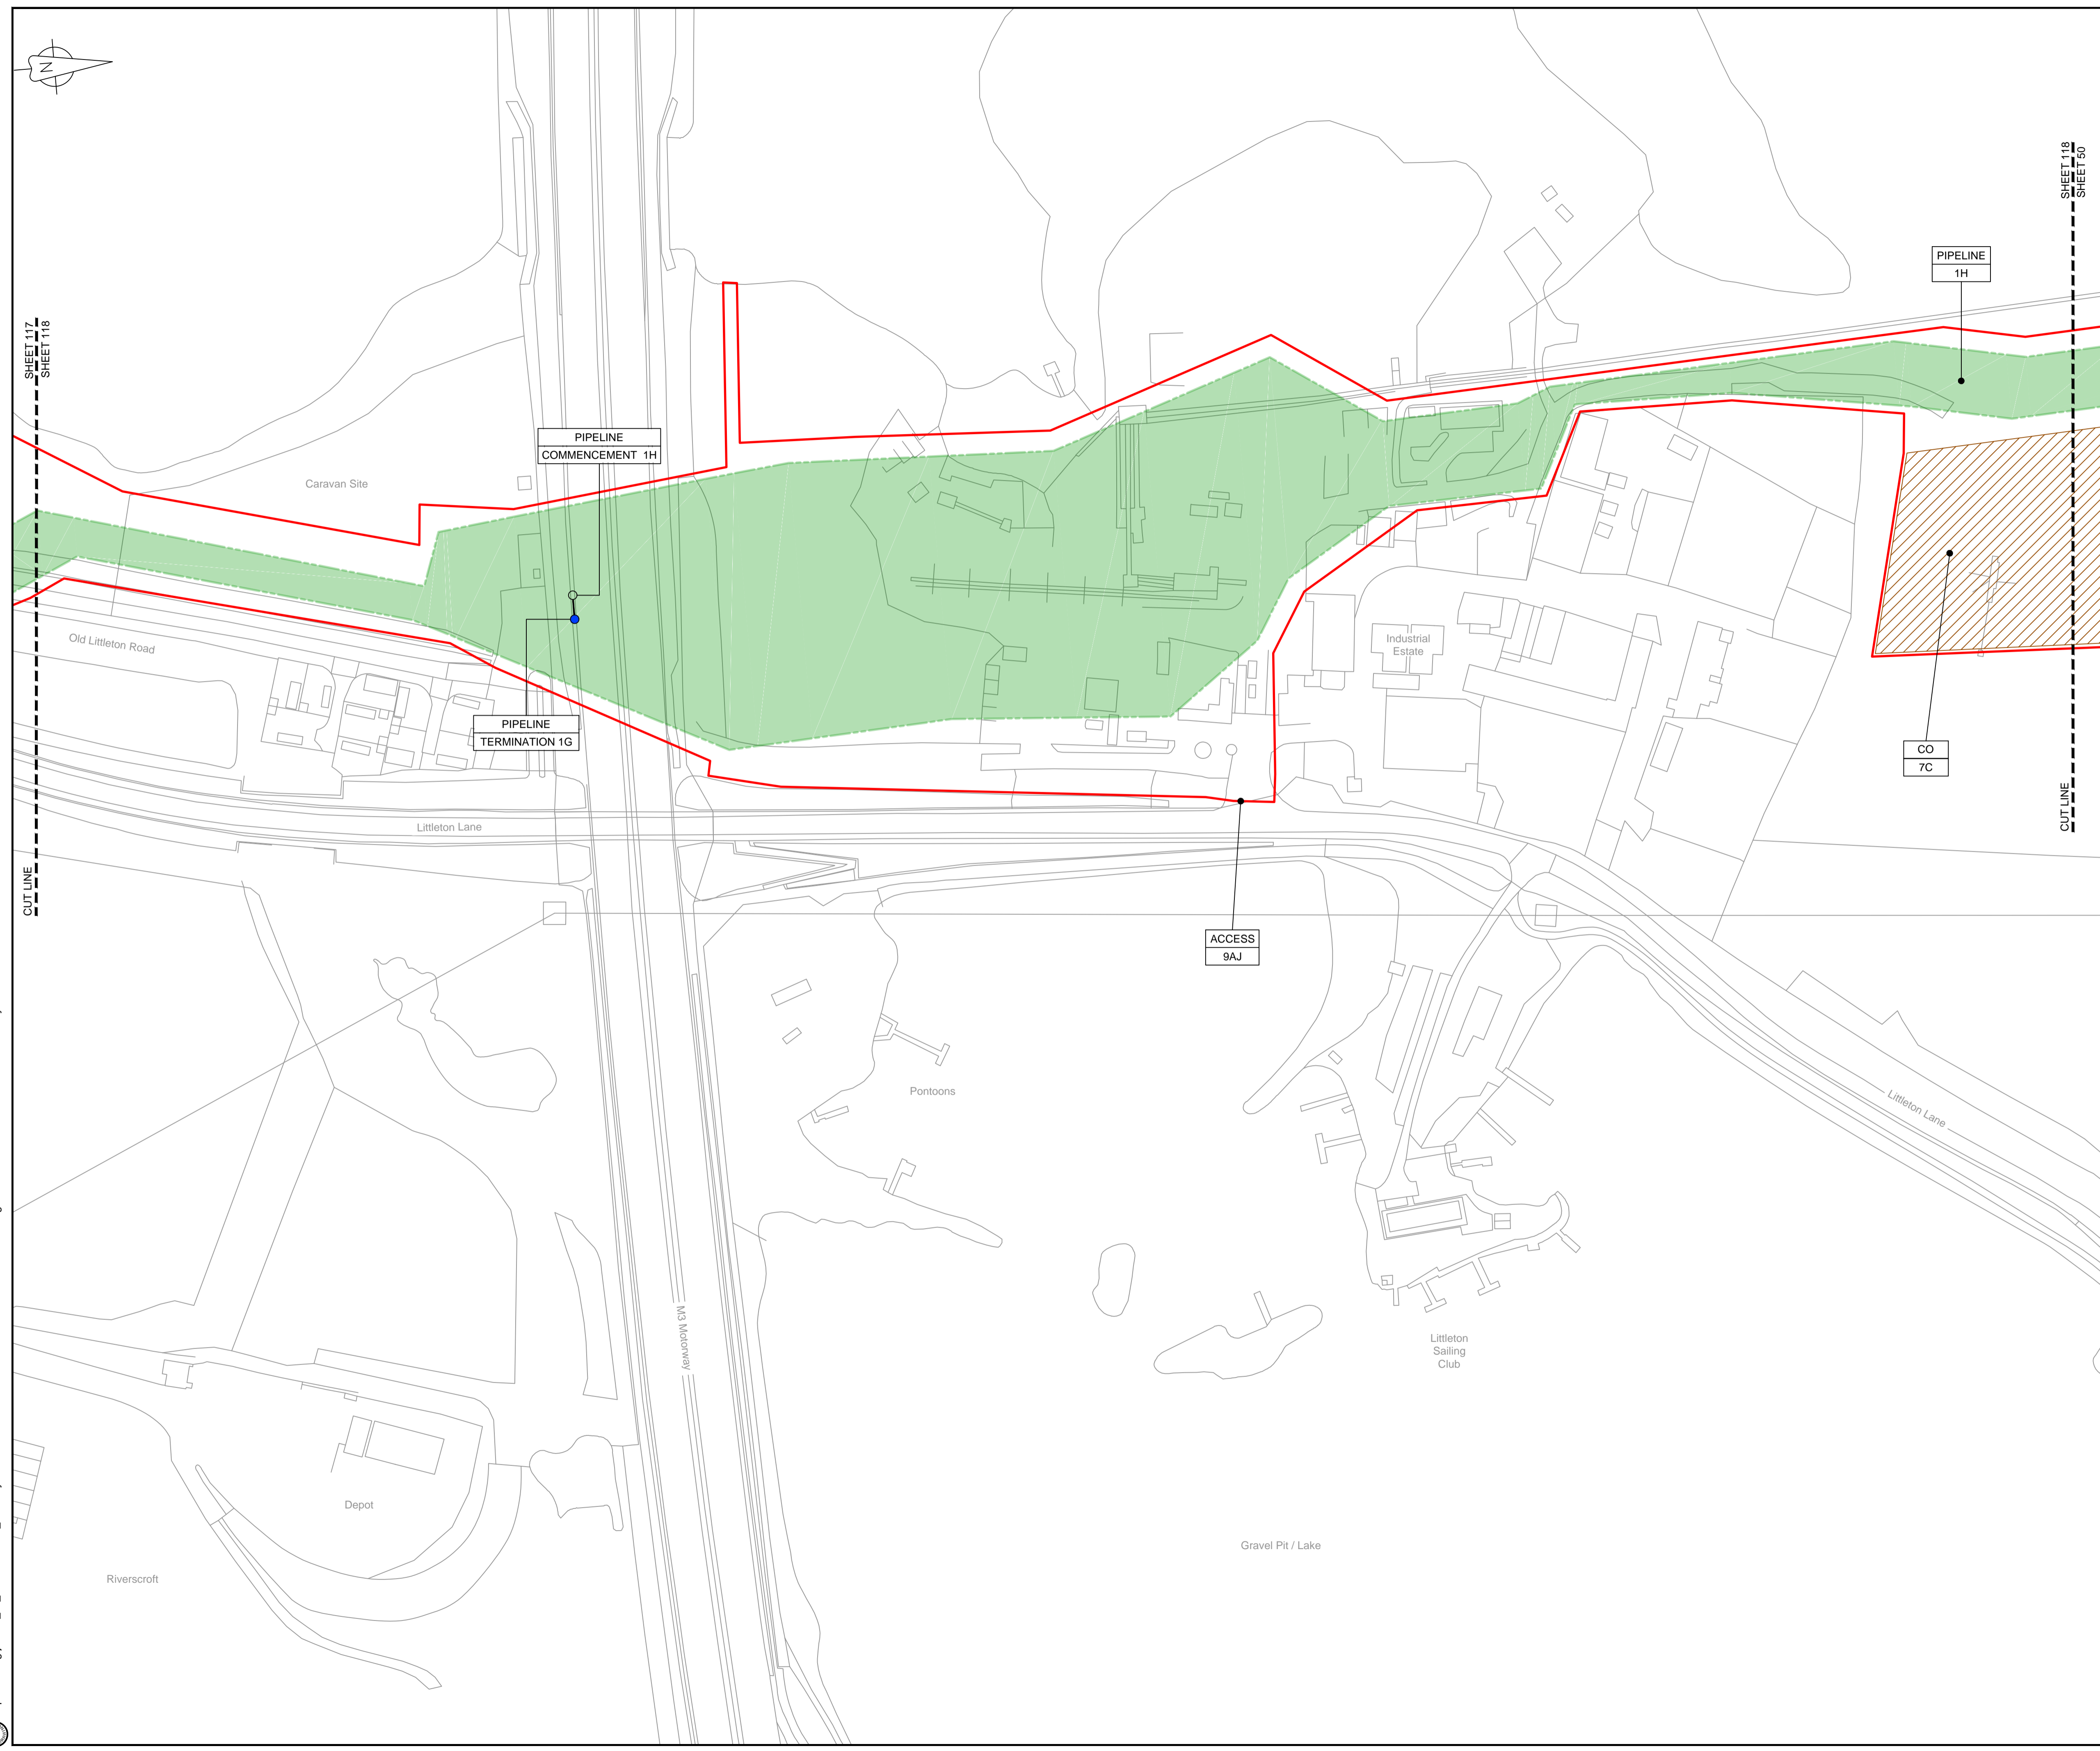

LOCATION PLAN  
SCALE 1:500,000

**NOTES**  
1. THIS DRAWING IS IN METRES UNLESS STATED OTHERWISE.

**LEGEND**

	ORDER LIMITS
	LIMITS OF DEVIATION
	COMPOUND (CO)
	ENVIRONMENTAL MITIGATION AREA (EM)
	ABOVE GROUND INSTALLATION (AGI) / VALVE (VA) / PRESSURE TRANSDUCER (PT)
	DESCRIPTION
	ID or WORK NUMBER (if applicable)
	ACCESS
	TEMPORARY CONSTRUCTION ACCESS
	P-ACCESS
	PERMANENT ACCESS
	COMMENCEMENT / TERMINATION OF WORKS (COMMENCEMENT = OPEN, TERMINATION = CLOSED)

Contains Ordnance Survey data © Crown copyright and database rights 2019.  
© Crown copyright and database rights 2019 OS Licence Number AL10005237.



C02	14/06/19	SHEETS 38 AND 108 REVISED FOLLOWING SSI ADVICE	SH	JA	ND	PH
C03	09/09/19	SHEETS 10, 11 AND 54 REVISED TO WITHDRAW A2B SUB-OPTION	BT	JA	ND	NJ
Rev	Rev. Date	Purpose of revision	Drawn	Checked	Rev'd	Appr'd

**JACOBS**  
1180 Eskdale Road, Winnersh, Wokingham, RG41 5TU  
Tel: +44(0)118 946 7000 Fax: +44(0)118 946 7001  
www.jacobs.com

Client: Esso Petroleum Company, Limited  
Emryn House,  
Emryn Way,  
Leatherhead,  
Surrey,  
KT22 8UX

Project: Southampton to London Pipeline Project

Drawing title: **WORKS PLAN SHEET 118 REGULATION 5 (2)(J)**

Drawing status: **Fit for Stage Approval**

Scale: 1:1250 DO NOT SCALE

Jacobs No. B2325300 Rev C03

Drawing number: **B2325300-JAC-000-CIV-DRG-000118**

© Copyright 2019 Jacobs U.K. Limited. The concepts and information contained in this document are the property of Jacobs. Use or copying of this document in whole or in part without the written permission of Jacobs constitutes an infringement of copyright. Limitation. This drawing has been prepared on behalf of, and for the exclusive use of, the Client, and is subject to, and issued in accordance with, the provisions of the contract between Jacobs and the Client. Jacobs accepts no liability or responsibility whatsoever for, or in respect of, any use of, or reliance upon, this drawing by any third party.




LOCATION PLAN  
SCALE 1:500,000

**NOTES**  
1. THIS DRAWING IS IN METRES UNLESS STATED OTHERWISE.

- LEGEND**
- ORDER LIMITS
  - LIMITS OF DEVIATION
  - COMPOUND (CO)
  - ENVIRONMENTAL MITIGATION AREA (EM)
  - ABOVE GROUND INSTALLATION (AGI) / VALVE (VA) / PRESSURE TRANSDUCER (PT)
  - DESCRIPTION
  - ID or WORK NUMBER (if applicable)
  - ACCESS TEMPORARY CONSTRUCTION ACCESS
  - P-ACCESS PERMANENT ACCESS
  - COMMENCEMENT / TERMINATION OF WORKS (COMMENCEMENT = OPEN, TERMINATION = CLOSED)

Contains Ordnance Survey data © Crown copyright and database rights 2019.  
© Crown copyright and database rights 2019 OS Licence Number AL100005237.

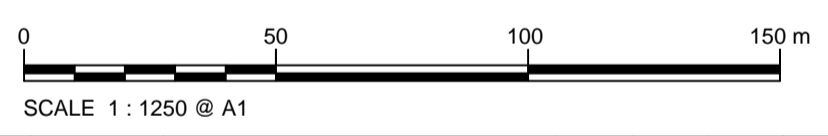

Rev	Rev. Date	Purpose of revision	Drawn	Checked	Rev'd	Appr'd
C02	14/06/19	SHEETS 38 AND 108 REVISED FOLLOWING S81 ADVICE	SH	JA	ND	PH
C03	09/09/19	SHEETS 10, 11 AND 54 REVISED TO WITHDRAW A2b SUB-OPTION	BT	JA	ND	NJ



Client: Esso Petroleum Company, Limited  
Emryn House,  
Emryn Way,  
Leatherhead,  
Surrey,  
KT22 8UX




Drawing title  
**WORKS PLAN  
SHEET 119  
REGULATION 5 (2)(J)**

Drawing status: **Fit for Stage Approval**

Scale	1:1250	DO NOT SCALE
Jacobs No.	B2325300	Rev
Client no.		<b>C03</b>

Drawing number  
**B2325300-JAC-000-CIV-DRG-000119**

© Copyright 2019 Jacobs U.K. Limited. The concepts and information contained in this document are the property of Jacobs. Use or copying of this document in whole or in part without the written permission of Jacobs constitutes an infringement of copyright. Limitation: This drawing has been prepared on behalf of, and for the exclusive use of, the Client, and is subject to, and issued in accordance with, the provisions of the contract between Jacobs and the Client. Jacobs accepts no liability or responsibility whatsoever for, or in respect of, any use of, or reliance upon, this drawing by any third party.

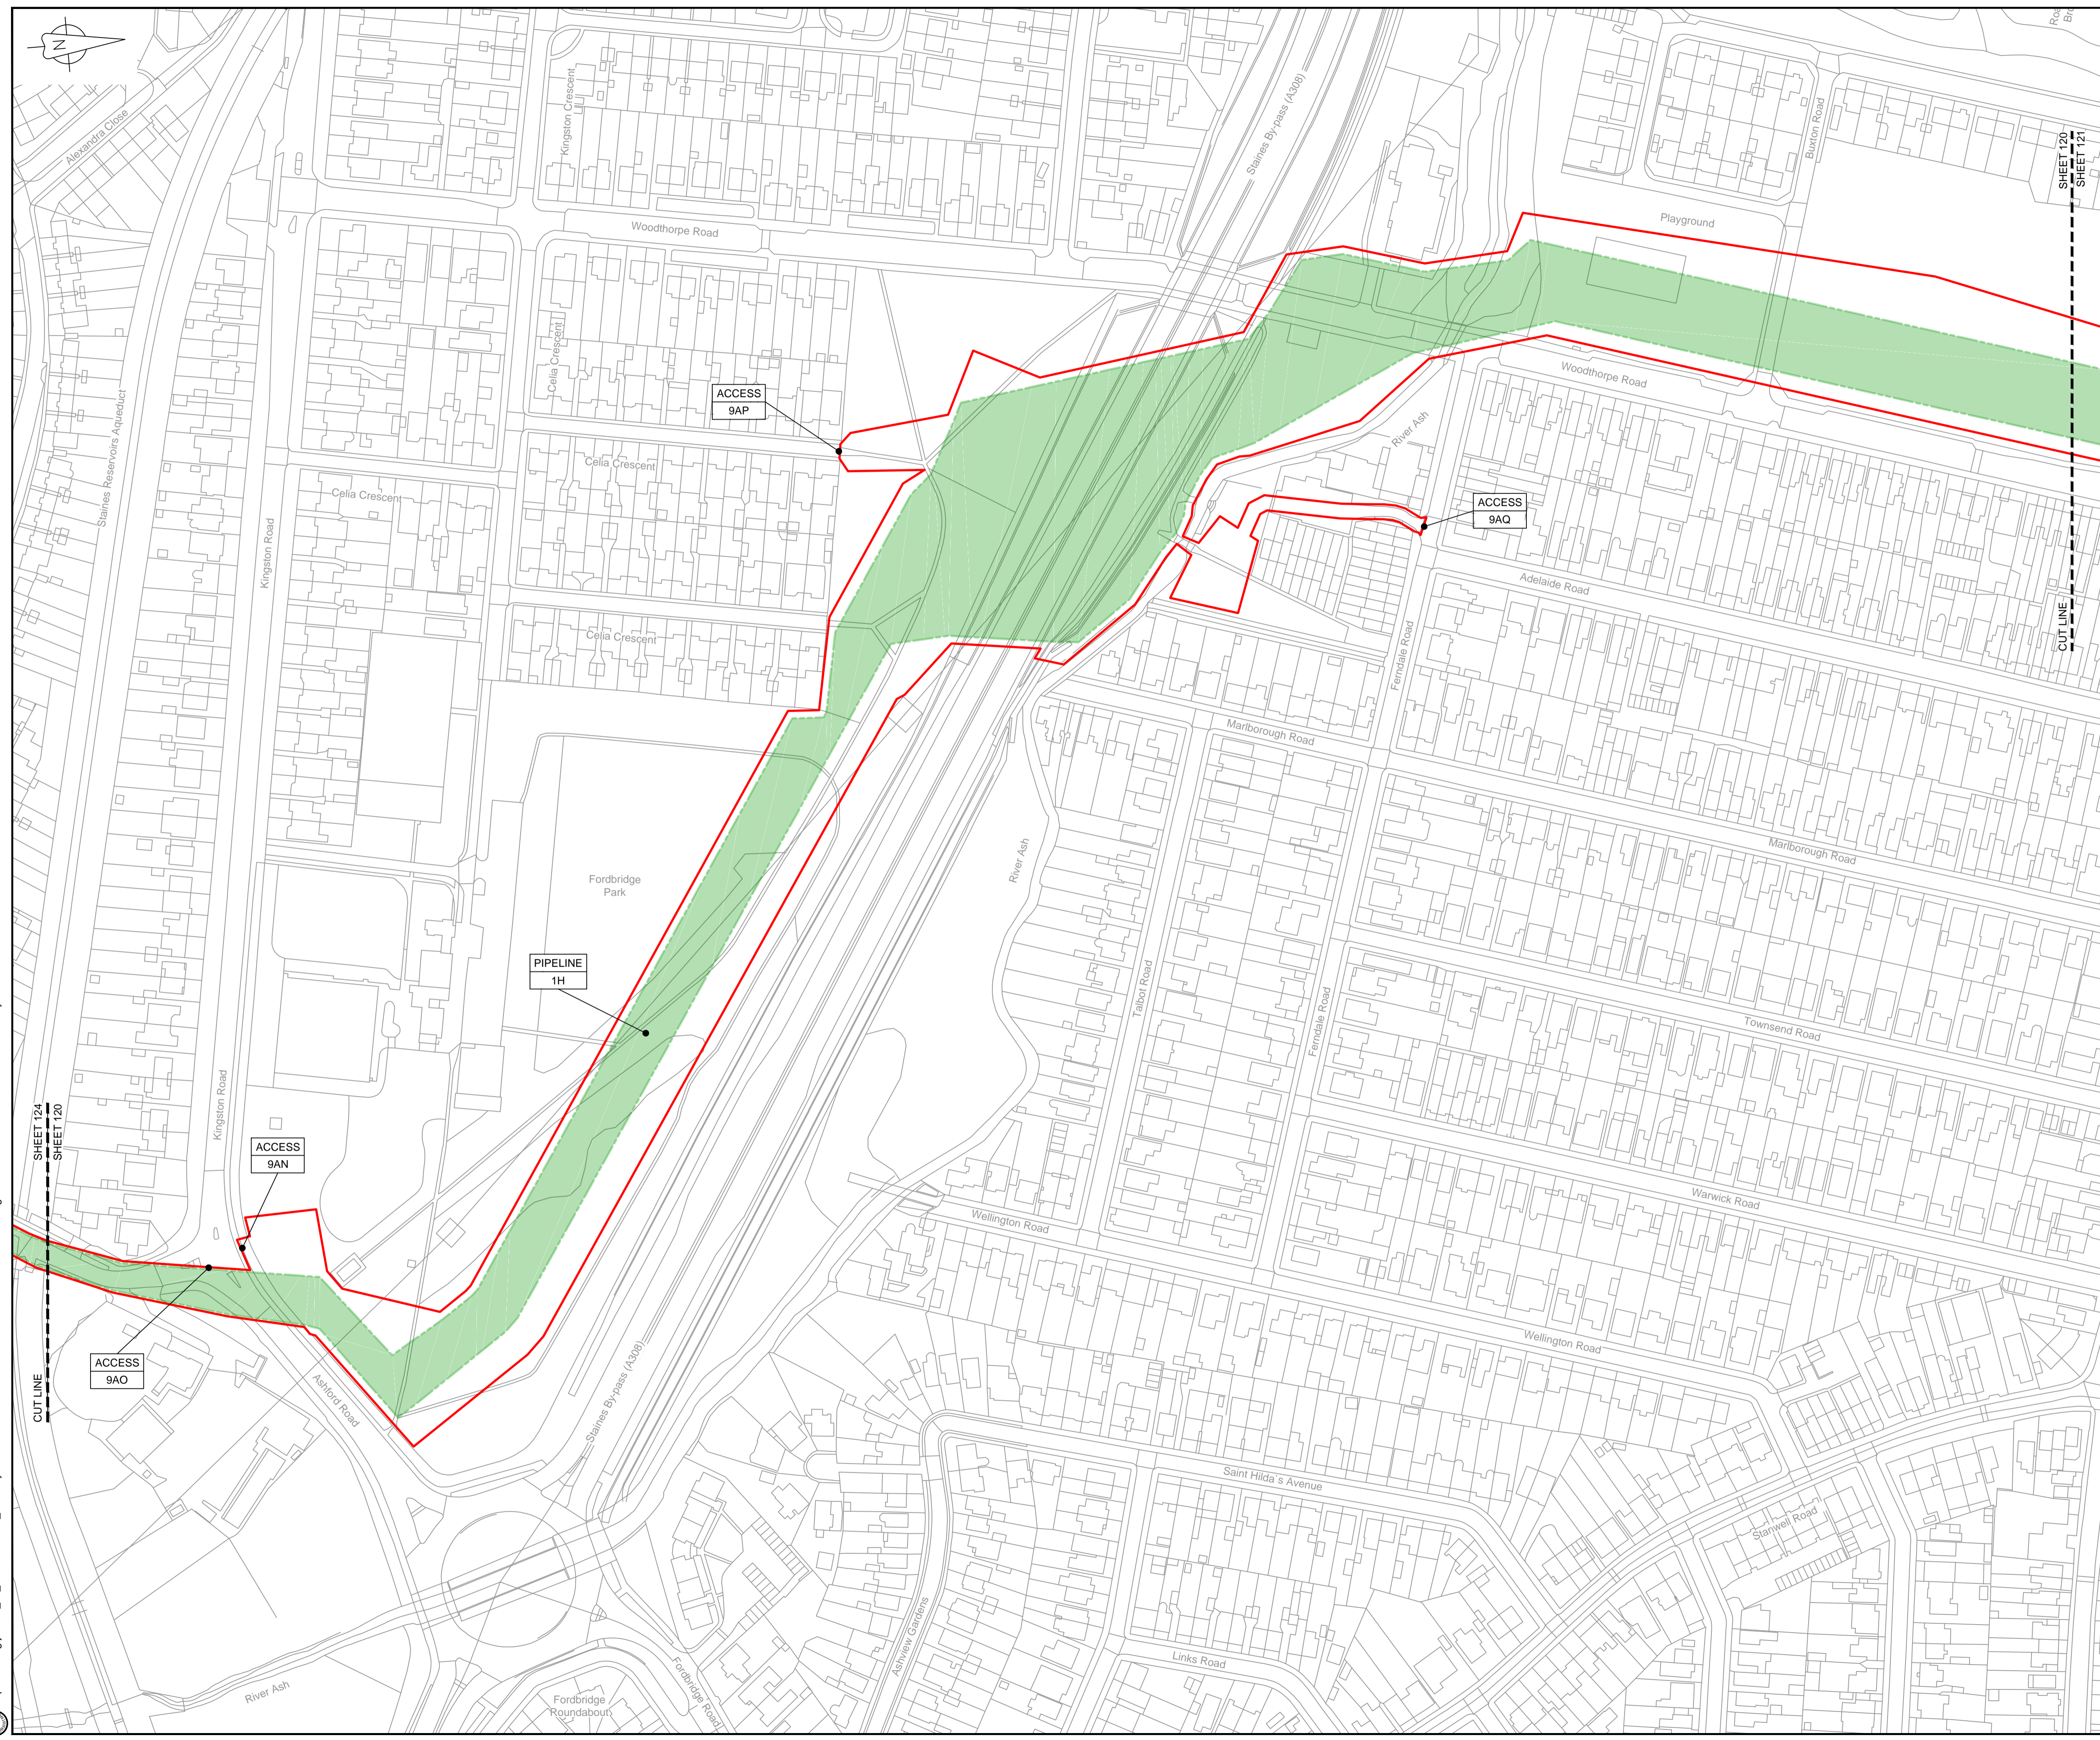


LOCATION PLAN  
SCALE 1:500,000

NOTES  
1. THIS DRAWING IS IN METRES UNLESS STATED OTHERWISE.

**LEGEND**

	ORDER LIMITS
	LIMITS OF DEVIATION
	COMPOUND (CO)
	ENVIRONMENTAL MITIGATION AREA (EM)
	ABOVE GROUND INSTALLATION (AGI) / VALVE (VA) / PRESSURE TRANSDUCER (PT)
	DESCRIPTION
	ID or WORK NUMBER (if applicable)
	ACCESS
	TEMPORARY CONSTRUCTION ACCESS
	P-ACCESS
	PERMANENT ACCESS
	COMMENCEMENT / TERMINATION OF WORKS (COMMENCEMENT = OPEN, TERMINATION = CLOSED)

Contains Ordnance Survey data © Crown copyright and database rights 2019.  
© Crown copyright and database rights 2019 OS Licence Number AL10005237.

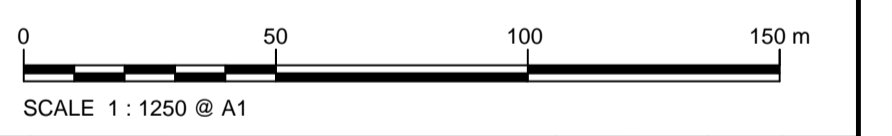

Rev	Rev. Date	Purpose of revision	Drawn	Checkd	Rev'd	Appr'd
C02	14/06/19	SHEETS 35 AND 108 REVISED FOLLOWING SSI ADVICE	SH	JA	ND	PH
C03	09/09/19	SHEETS 10, 11 AND 54 REVISED TO WITHDRAW A2b SUB-OPTION	BT	JA	ND	NJ



1180 Eskdale Road, Wokingham, Wokingham, RG41 5TU  
Tel: +44(0)118 946 7000 Fax: +44(0)118 946 7001  
www.jacobs.com

Client: Esso Petroleum Company, Limited  
Emryn House,  
Emryn Way,  
Leatherhead,  
Surrey,  
KT22 8UX




Drawing title  
**WORKS PLAN  
SHEET 120  
REGULATION 5 (2)(J)**

Drawing status: **Fit for Stage Approval**

Scale	1:1250	DO NOT SCALE
Jacobs No.	B2325300	Rev
Client no.		<b>C03</b>

Drawing number  
**B2325300-JAC-000-CIV-DRG-000120**

© Copyright 2019 Jacobs U.K. Limited. The concepts and information contained in this document are the property of Jacobs. Use or copying of this document in whole or in part without the written permission of Jacobs constitutes an infringement of copyright. Limitation. This drawing has been prepared on behalf of, and for the exclusive use of, Jacobs' Client, and is subject to, and issued in accordance with, the provisions of the contract between Jacobs and the Client. Jacobs accepts no liability or responsibility whatsoever for, or in respect of, any use of, or reliance upon, this drawing by any third party.

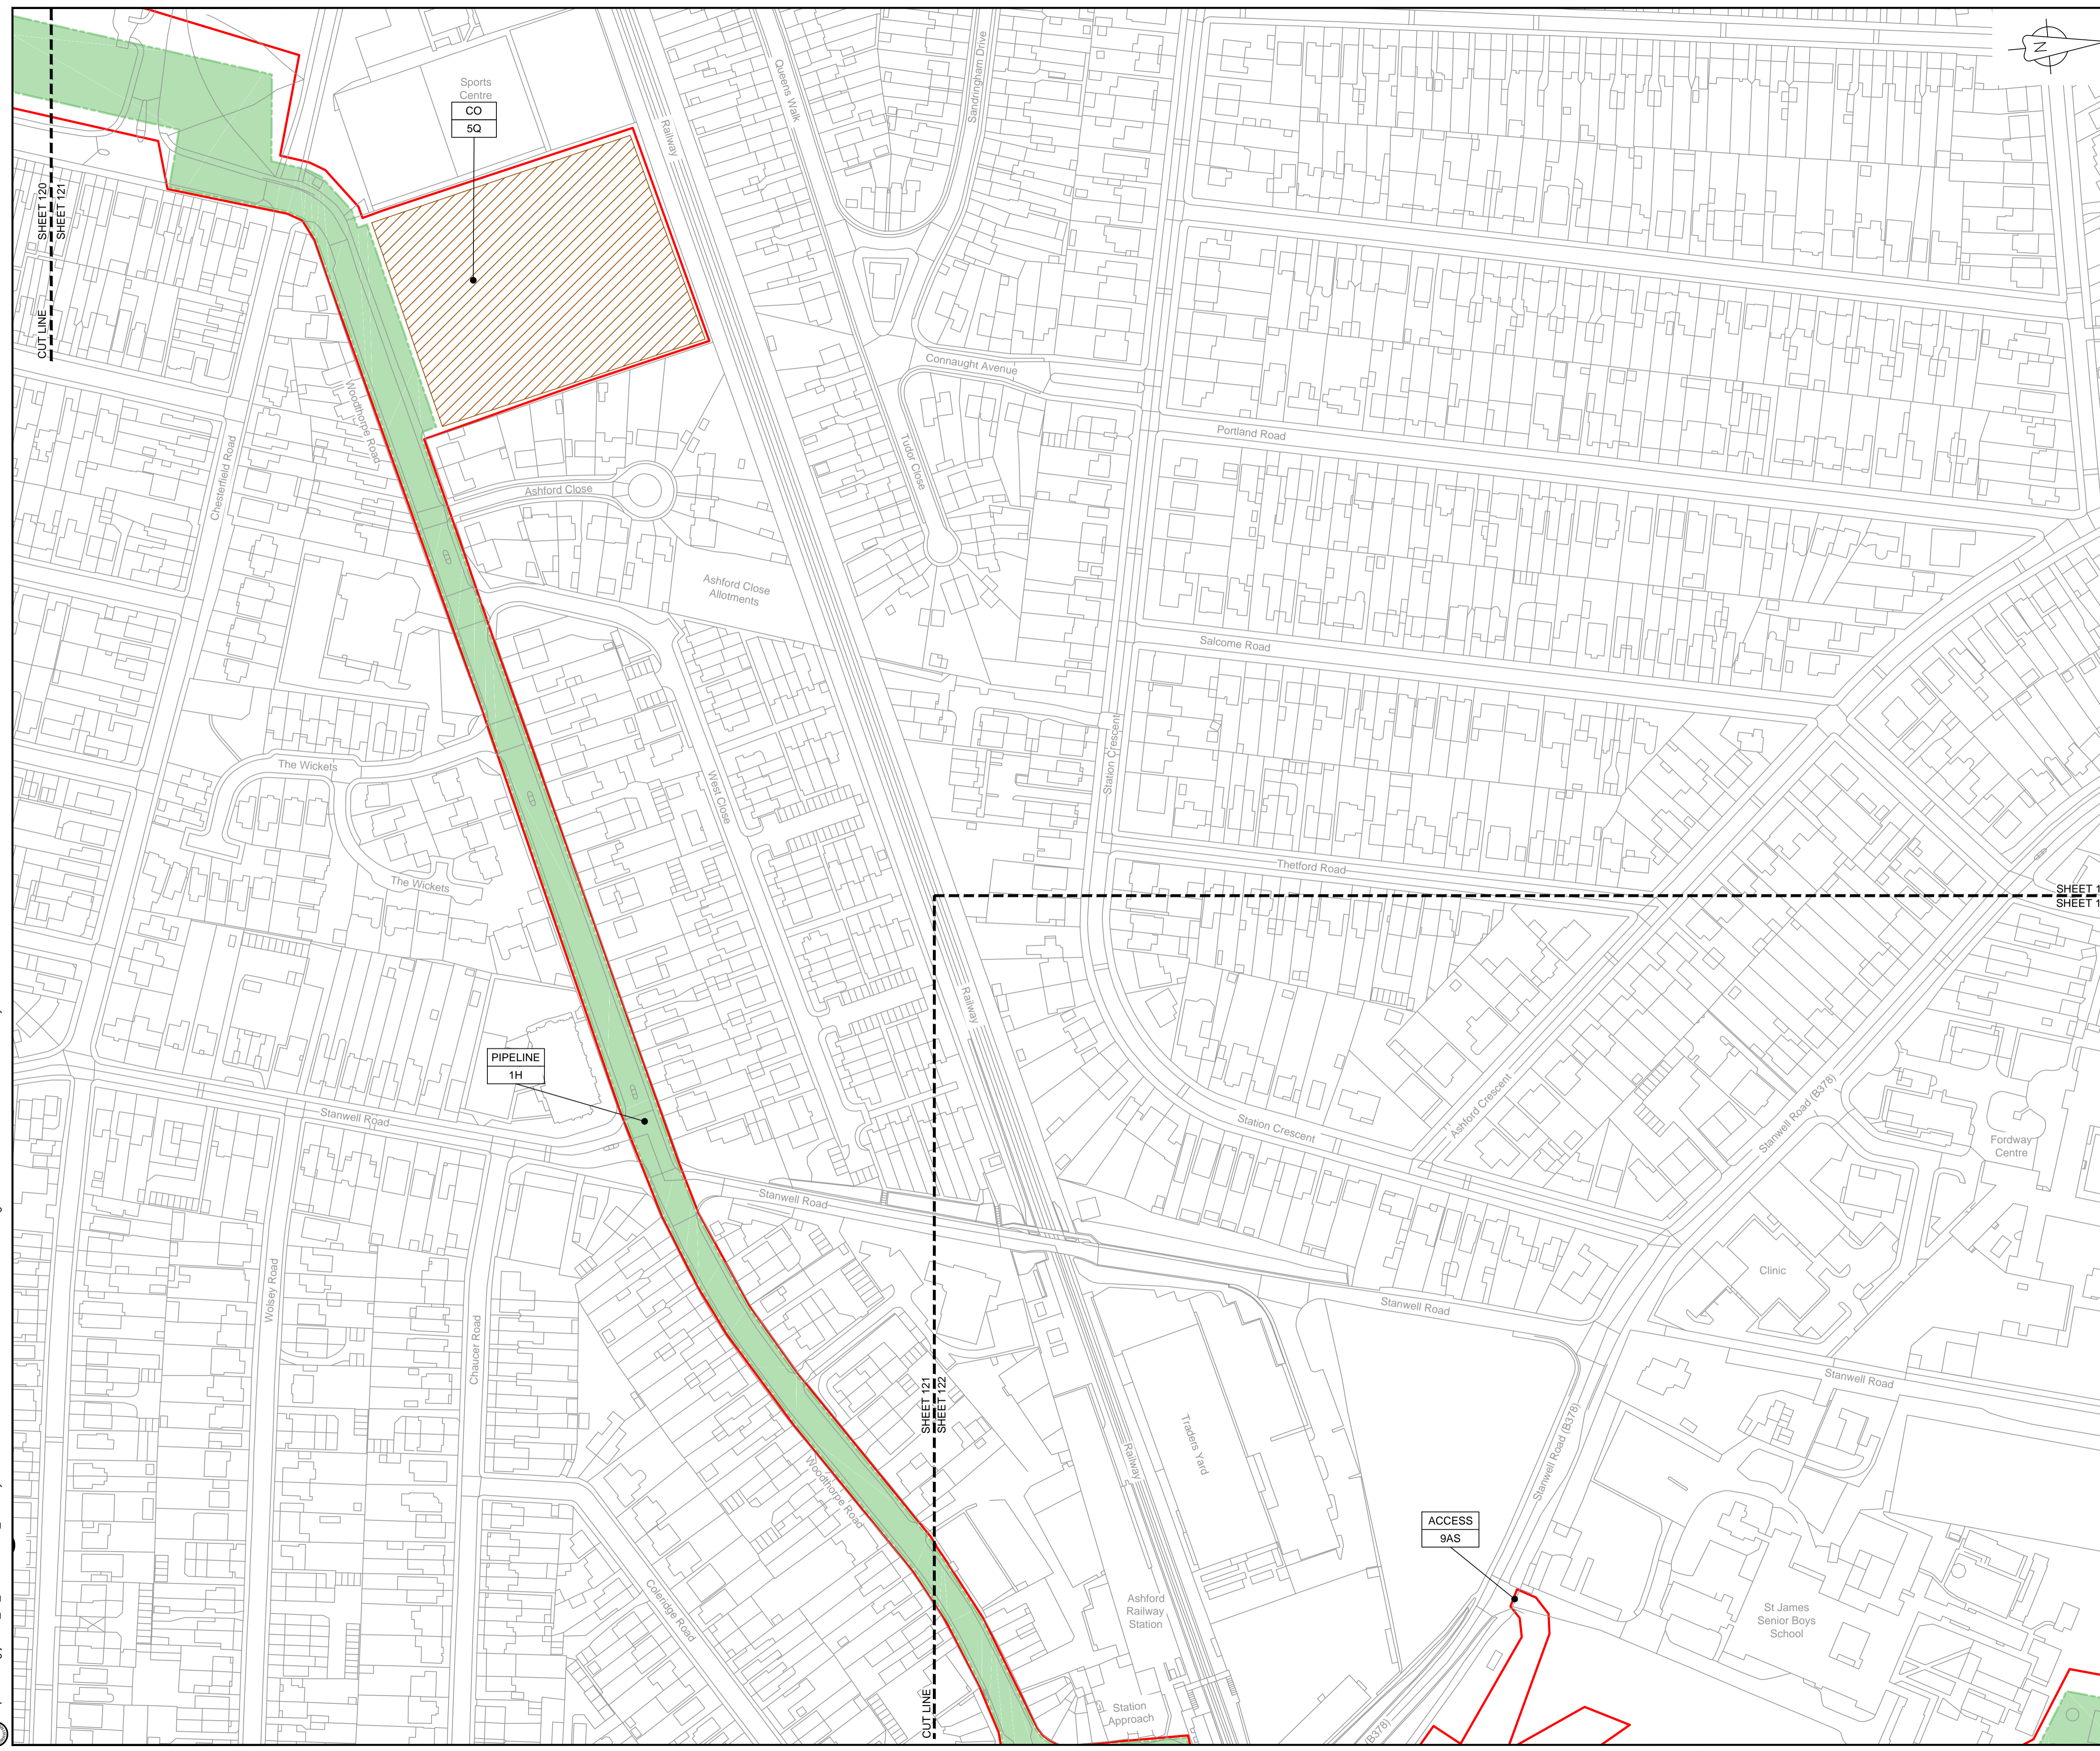


NOTES  
1. THIS DRAWING IS IN METRES UNLESS STATED OTHERWISE.

LEGEND

[Red line]	ORDER LIMITS
[Green line]	LIMITS OF DEVIATION
[Hatched area]	COMPOUND (CO)
[Yellow area]	ENVIRONMENTAL MITIGATION AREA (EM)
[Grey area]	ABOVE GROUND INSTALLATION (AGI) / VALVE (VA) / PRESSURE TRANSDUCER (PT)
[Symbol]	DESCRIPTION
[Symbol]	ID or WORK NUMBER (if applicable)
[Symbol]	ACCESS
[Symbol]	TEMPORARY CONSTRUCTION ACCESS
[Symbol]	PERMANENT ACCESS
[Symbol]	COMMENCEMENT / TERMINATION OF WORKS (COMMENCEMENT = OPEN, TERMINATION = CLOSED)

Contains Ordnance Survey data © Crown copyright and database rights 2019.  
© Crown copyright and database rights 2019 OS Licence Number AL10005237.

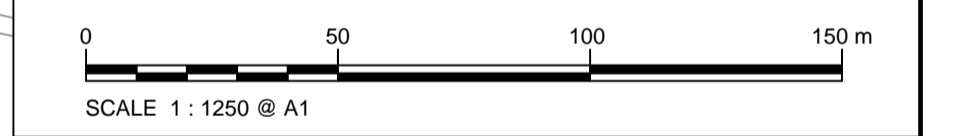

Rev	Rev. Date	Rev. Description	Drawn	Checked	Rev'd	Appr'd
C02	14/06/19	SHEETS 38 AND 108 REVISED FOLLOWING S51 ADVICE	SH	JA	ND	PH
C03	09/09/19	SHEETS 10, 11 AND 54 REVISED TO WITHDRAW A2b SUB-OPTION	BT	JA	ND	NJ



Client: Esso Petroleum Company, Limited  
Emryn House,  
Emryn Way,  
Leatherhead,  
Surrey,  
KT22 8UX




Drawing title: **WORKS PLAN SHEET 121 REGULATION 5 (2)(J)**

Drawing status: **Fit for Stage Approval**

Scale	1:1250	DO NOT SCALE
Jacobs No.	B2325300	Rev
Client no.		<b>C03</b>
Drawing number	<b>B2325300-JAC-000-CIV-DRG-000121</b>	

© Copyright 2019 Jacobs U.K. Limited. The concepts and information contained in this document are the property of Jacobs. Use or copying of this document in whole or in part without the written permission of Jacobs constitutes an infringement of copyright. Limitation: This drawing has been prepared on behalf of, and for the exclusive use of, Jacobs' Client, and is subject to, and issued in accordance with, the provisions of the contract between Jacobs and the Client. Jacobs accepts no liability or responsibility whatsoever for, or in respect of, any use of, or reliance upon, this drawing by any third party.

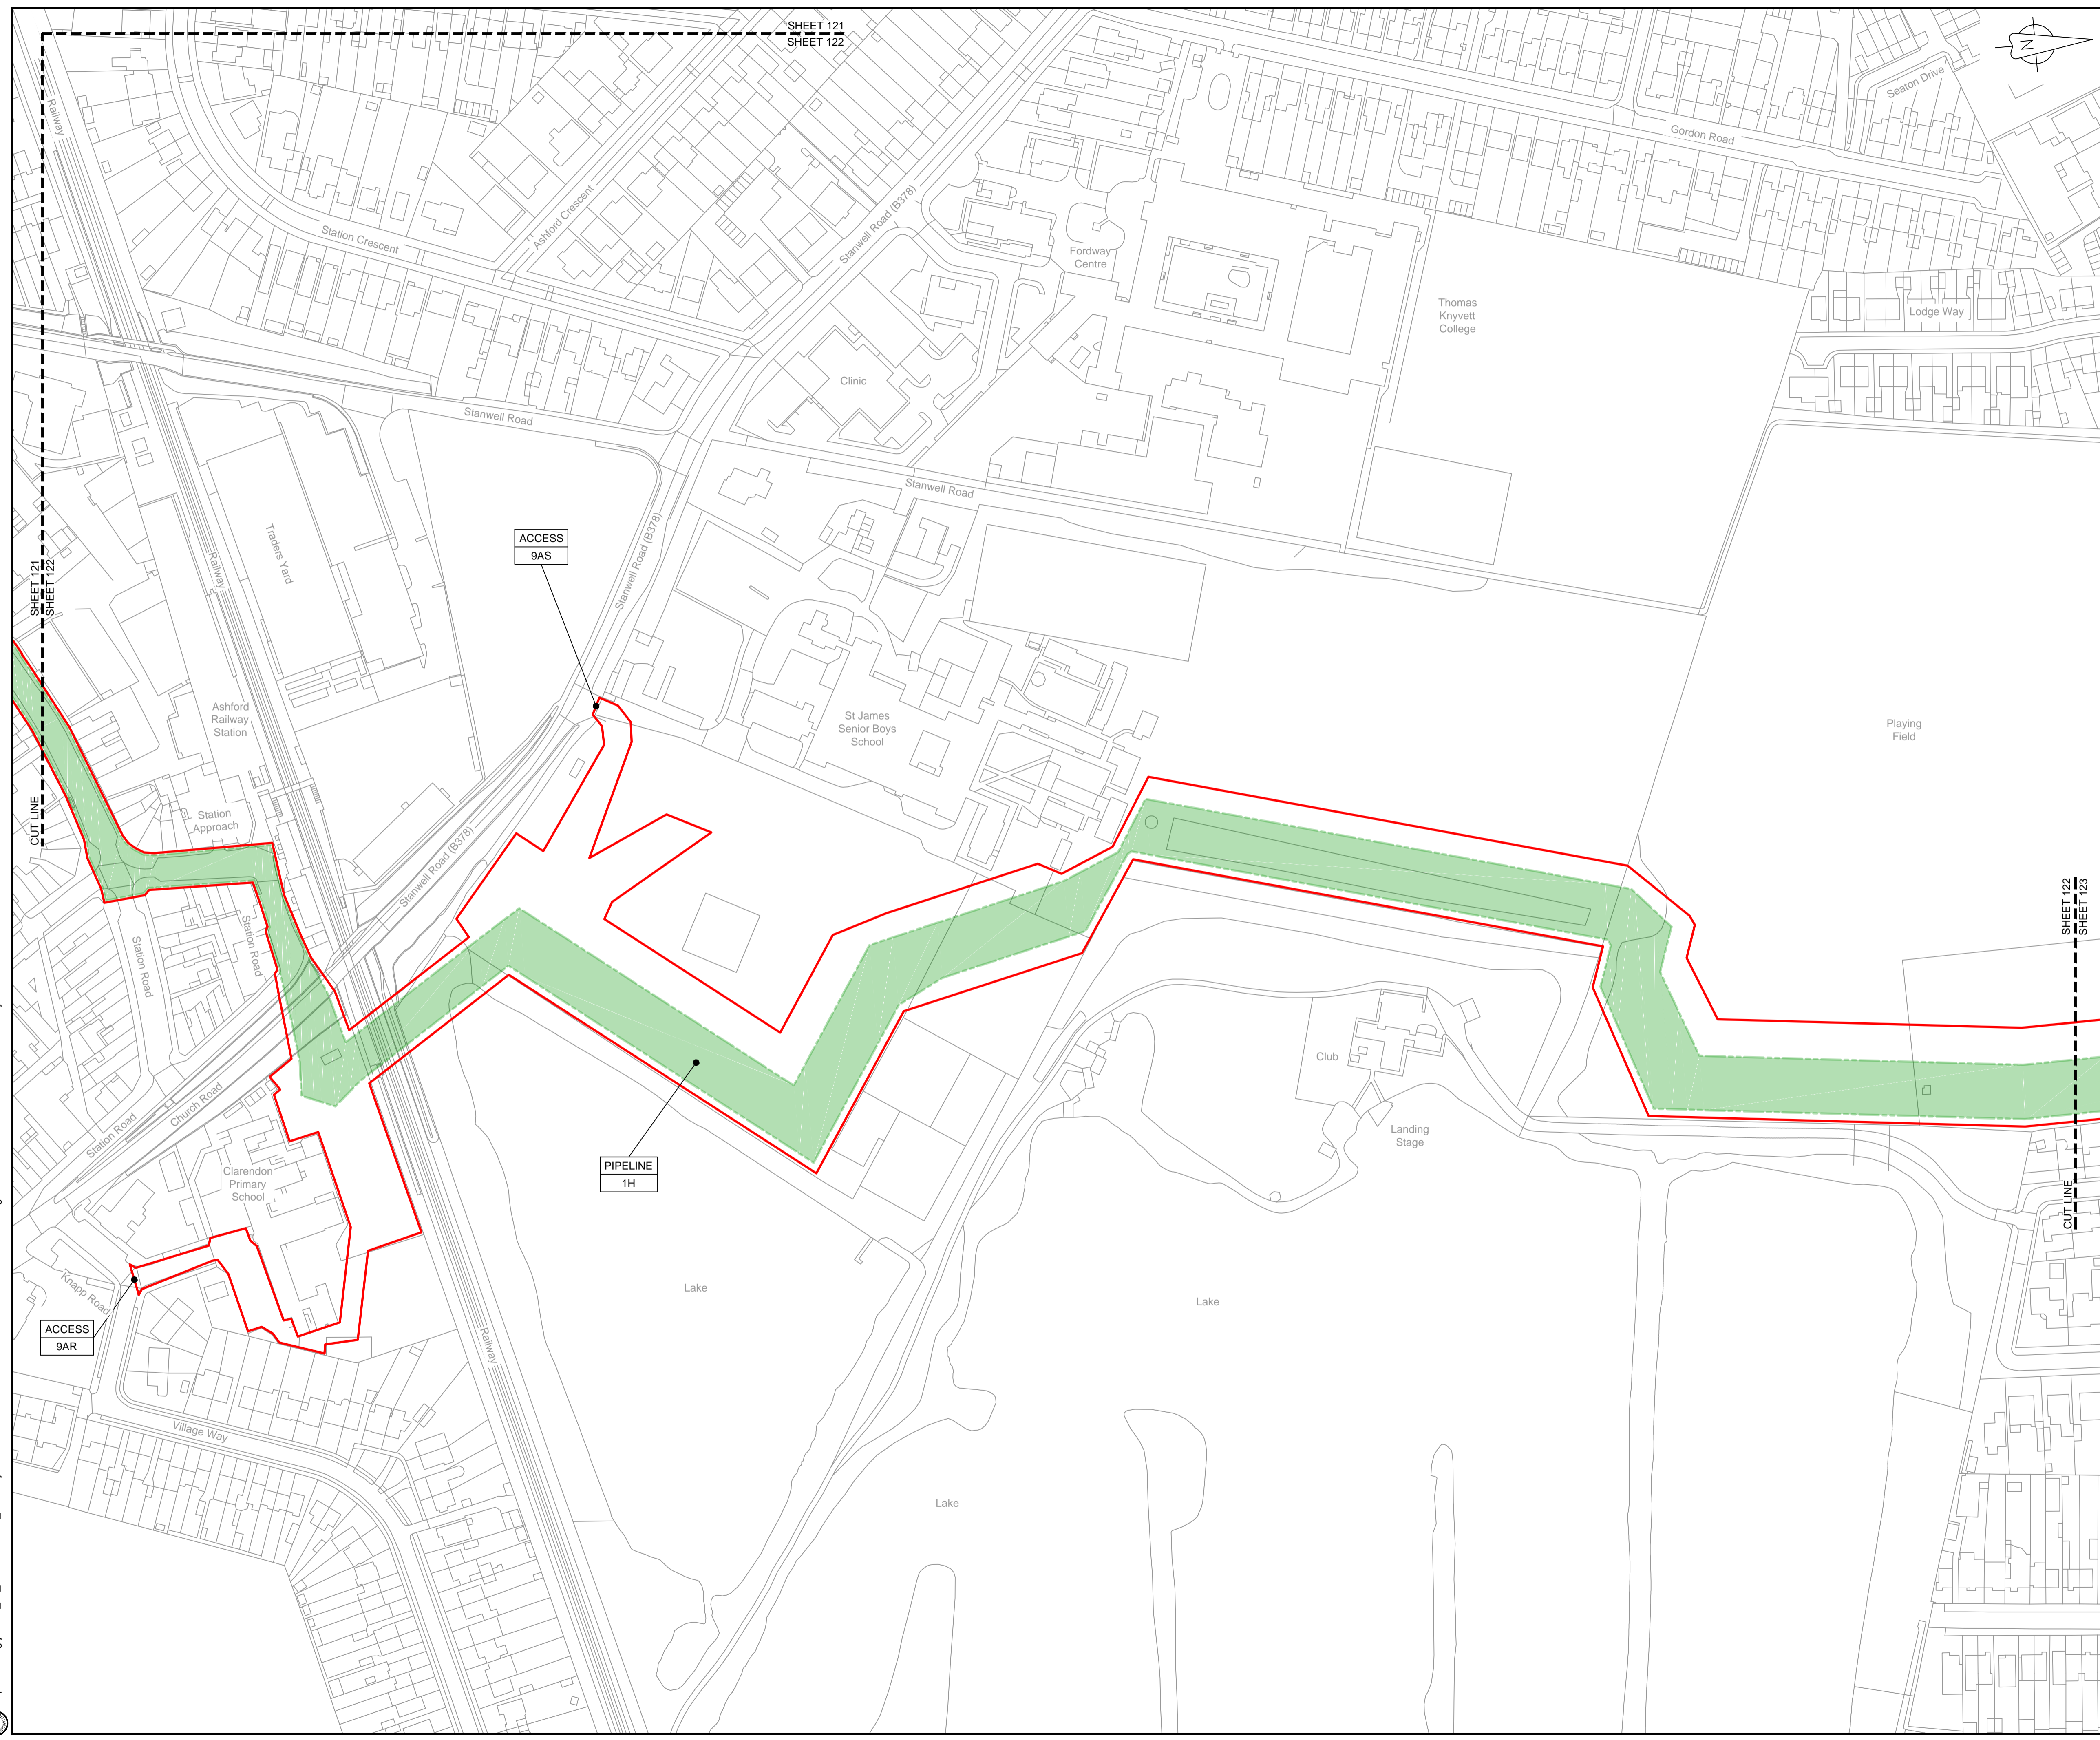


**LOCATION PLAN**  
SCALE 1:500,000

**NOTES**  
1. THIS DRAWING IS IN METRES UNLESS STATED OTHERWISE.

**LEGEND**

	ORDER LIMITS
	LIMITS OF DEVIATION
	COMPOUND (CO)
	ENVIRONMENTAL MITIGATION AREA (EM)
	ABOVE GROUND INSTALLATION (AGI) / VALVE (VA) / PRESSURE TRANSDUCER (PT)
	DESCRIPTION
	ID or WORK NUMBER (if applicable)
	ACCESS TEMPORARY CONSTRUCTION ACCESS
	P-ACCESS PERMANENT ACCESS
	COMMENCEMENT / TERMINATION OF WORKS (COMMENCEMENT = OPEN, TERMINATION = CLOSED)

Contains Ordnance Survey data © Crown copyright and database rights 2019.  
© Crown copyright and database rights 2019 OS Licence Number AL10005237.

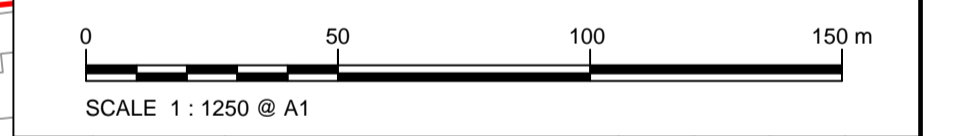

Rev	Rev. Date	Purpose of revision	Drawn	Checked	Rev'd	Appr'd
C02	14/06/19	SHEETS 38 AND 108 REVISED FOLLOWING SSI ADVICE	SH	JA	ND	PH
C03	09/09/19	SHEETS 10, 11 AND 54 REVISED TO WITHDRAW A2b SUB-OPTION	BT	JA	ND	NJ

**JACOBS**  
1180 Eskdale Road, Winnersh, Wokingham, RG41 5TU  
Tel: +44(0)118 946 7000 Fax: +44(0)118 946 7001  
www.jacobs.com

Client: Esso Petroleum Company, Limited  
Emryn House,  
Emryn Way,  
Leatherhead,  
Surrey,  
KT22 8UX

Project: Southampton to London Pipeline Project

Drawing title: **WORKS PLAN SHEET 122 REGULATION 5 (2)(J)**


Drawing status: **Fit for Stage Approval**

Scale: 1:1250 DO NOT SCALE  
Jacobs No. B2325300 Rev  
Client no. C03

Drawing number: **B2325300-JAC-000-CIV-DRG-000122**

© Copyright 2019 Jacobs U.K. Limited. The concepts and information contained in this document are the property of Jacobs. Use or copying of this document in whole or in part without the written permission of Jacobs constitutes an infringement of copyright. Limitation: This drawing has been prepared on behalf of, and for the exclusive use of, Jacobs' Client, and is subject to, and issued in accordance with, the provisions of the contract between Jacobs and the Client. Jacobs accepts no liability or responsibility whatsoever for, or in respect of, any use of, or reliance upon, this drawing by any third party.



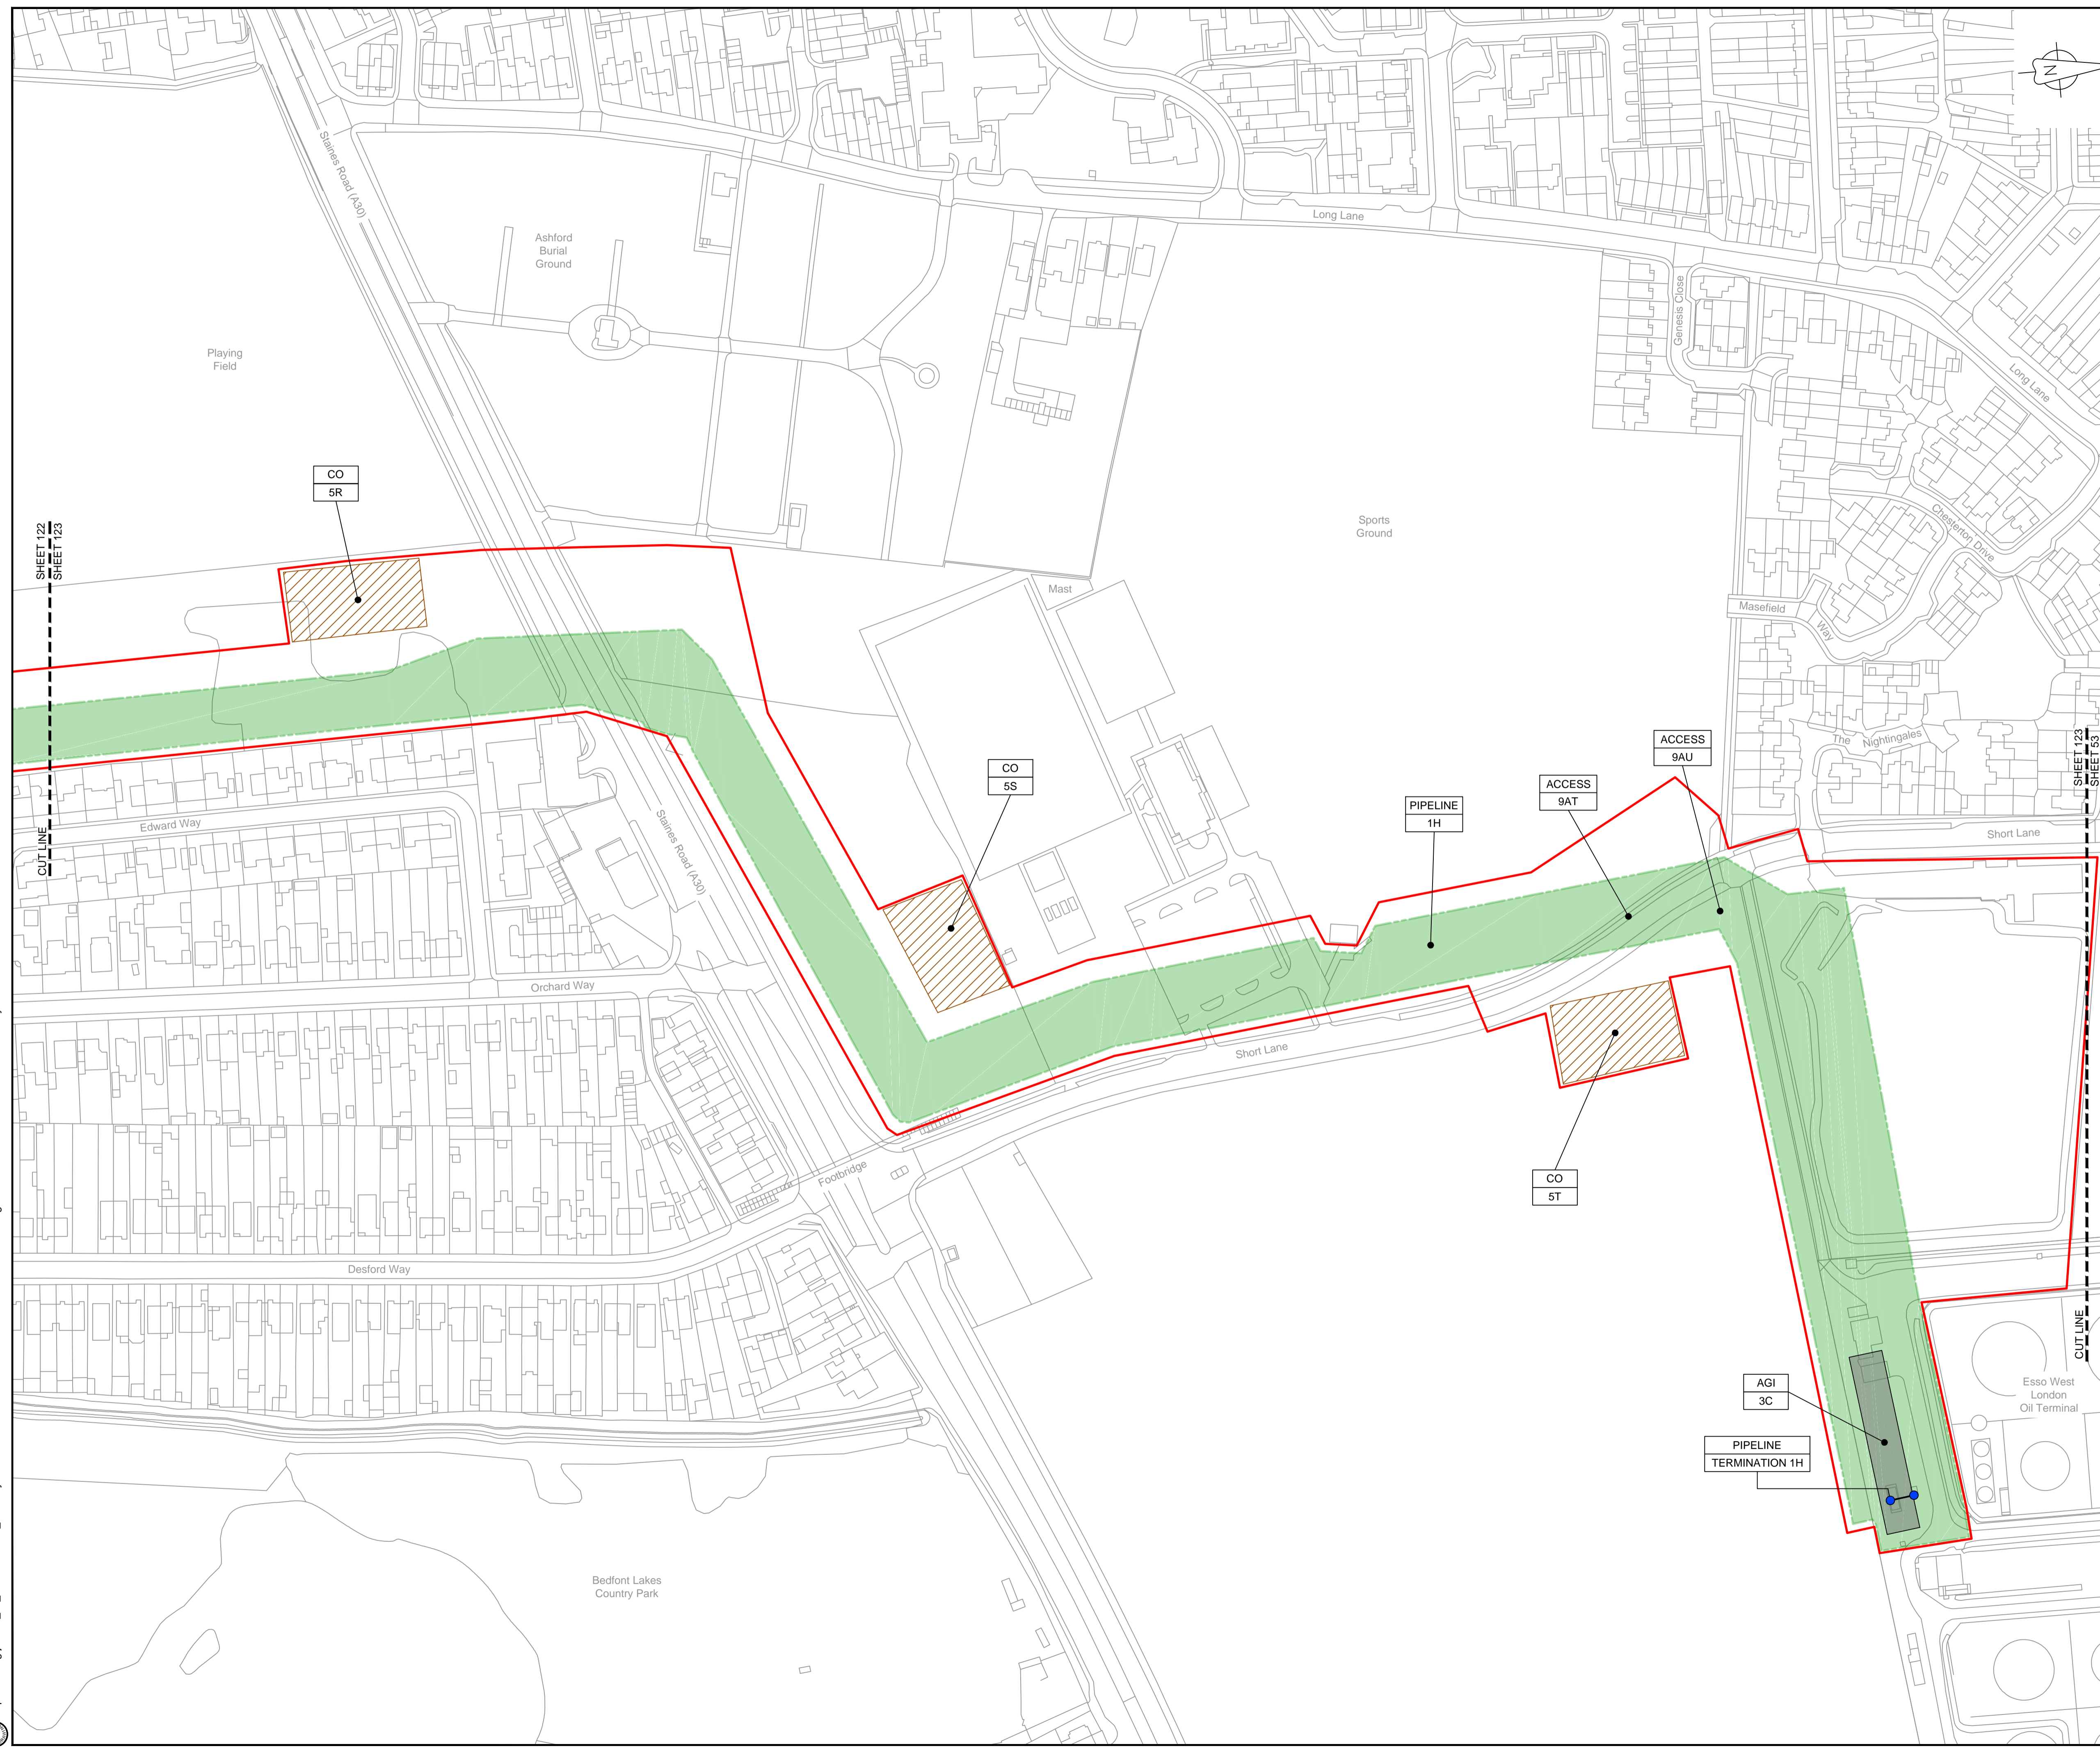

**LOCATION PLAN**  
SCALE 1:500,000

**NOTES**  
1. THIS DRAWING IS IN METRES UNLESS STATED OTHERWISE.

- LEGEND**
- ORDER LIMITS
  - LIMITS OF DEVIATION
  - COMPOUND (CO)
  - ENVIRONMENTAL MITIGATION AREA (EM)
  - ABOVE GROUND INSTALLATION (AGI) / VALVE (VA) / PRESSURE TRANSDUCER (PT)
  - DESCRIPTION
  - ID or WORK NUMBER (if applicable)
  - ACCESS TEMPORARY CONSTRUCTION ACCESS
  - P-ACCESS PERMANENT ACCESS
  - COMMENCEMENT / TERMINATION OF WORKS (COMMENCEMENT = OPEN, TERMINATION = CLOSED)

Contains Ordnance Survey data © Crown copyright and database rights 2019.  
© Crown copyright and database rights 2019 OS Licence Number AL100005237.



Rev	Rev. Date	Purpose of revision	Drawn	Checked	Rev'd	Appr'd
C02	14/06/19	SHEETS 3E AND 10E REVISED FOLLOWING SSI ADVICE	SH	JA	ND	PH
C03	09/09/19	SHEETS 10, 11 AND 54 REVISED TO WITHDRAW A2B SUB-OPTION	BT	JA	ND	NJ

**JACOBS**  
1180 Eskdale Road, Wokingham, Wokingham, RG41 5TU  
Tel: +44(0)118 946 7000 Fax: +44(0)118 946 7001  
www.jacobs.com

Client: Esso Petroleum Company, Limited  
Emryn House,  
Emryn Way,  
Leatherhead,  
Surrey,  
KT22 8UX

Project: Southampton to London Pipeline Project

Drawing title: **WORKS PLAN SHEET 123 REGULATION 5 (2)(J)**


Drawing status: **Fit for Stage Approval**

Scale	1:1250	DO NOT SCALE
Jacobs No.	B2325300	Rev
Client no.		<b>C03</b>

Drawing number: **B2325300-JAC-000-CIV-DRG-000123**

© Copyright 2019 Jacobs U.K. Limited. The concepts and information contained in this document are the property of Jacobs. Use or copying of this document in whole or in part without the written permission of Jacobs constitutes an infringement of copyright. Limitation: This drawing has been prepared on behalf of, and for the exclusive use of, the Client, and is subject to, and issued in accordance with, the provisions of the contract between Jacobs and the Client. Jacobs accepts no liability or responsibility whatsoever for, or in respect of, any use of, or reliance upon, this drawing by any third party.

C:\pwworking\jacobs\_uk\_water&utilities\_ssf\by\ordms33513B2325300-JAC-000-CIV-DRG-000123.dwg - 10/09/2019 14:50:07 - A1Frame - BTaylor

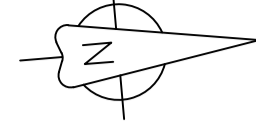

CUT LINE

SHEET 119  
SHEET 124

PIPELINE  
1H

Ashford Road (B377)

P-ACCESS  
11E

VA  
2O

SHEET 124  
SHEET 120

CUT LINE

ACCESS  
9AN

ACCESS  
9AO

Gravel Pit

Hall

Gravel Pit

Brett  
Aggregates

River Ash

River Ash

Access/Egress  
Road to  
Brett  
Aggregates

Laleham Substation

Unnamed Road

Surrey  
Railway  
Embankment

Kingston Road  
(A209)



LOCATION PLAN  
SCALE 1:500,000

NOTES

 
1. THIS DRAWING IS IN METRES UNLESS STATED OTHERWISE.

LEGEND

- ORDER LIMITS
- LIMITS OF DEVIATION
- COMPOUND (CO)
- ENVIRONMENTAL MITIGATION AREA (EM)
- ABOVE GROUND INSTALLATION (AGI) / VALVE (VA) / PRESSURE TRANSDUCER (PT)
- DESCRIPTION
- ID or WORK NUMBER (if applicable)
- ACCESS TEMPORARY CONSTRUCTION ACCESS
- P-ACCESS PERMANENT ACCESS
- COMMENCEMENT / TERMINATION OF WORKS (COMMENCEMENT = OPEN, TERMINATION = CLOSED)

Contains Ordnance Survey data © Crown copyright and database rights 2019.

© Crown copyright and database rights 2019 OS Licence Number AL100005237.



SCALE 1 : 1250 @ A1

C02	14/06/19	SHEETS 38 AND 109 REVISED FOLLOWING SSI ADVICE	SH	JA	ND	PH
C03	09/09/19	SHEETS 10, 11 AND 54 REVISED TO WITHDRAW A2B SUB-OPTION	BT	JA	ND	NJ
Rev	Rev. Date	Purpose of revision	Drawn	Checked	Rev'd	Appr'd



1180 Eskdale Road, Winnersh, Wokingham, RG41 5TU  
Tel:+44(0)118 946 7000 Fax:+44(0)118 946 7001  
www.jacobs.com

Client: Esso Petroleum Company, Limited  
Ermyn House,  
Ermyn Way,  
Leatherhead,  
Surrey,  
KT22 8UX



Southampton to London  
Pipeline Project

Drawing title  
**WORKS PLAN  
SHEET 124  
REGULATION 5 (2)(J)**

Drawing status  
**Fit for Stage Approval**

Scale 1:1250 DO NOT SCALE  
Jacobs No. B2325300 Rev  
Client no. C03

Drawing number  
**B2325300-JAC-000-CIV-DRG-000124**

© Copyright 2019 Jacobs U.K. Limited. The concepts and information contained in this document are the property of Jacobs. Use or copying of this document in whole or in part without the written permission of Jacobs constitutes an infringement of copyright. Limitation: This drawing has been prepared on behalf of, and for the exclusive use of, the Client, and is subject to, and issued in accordance with, the provisions of the contract between Jacobs and the Client. Jacobs accepts no liability or responsibility whatsoever for, or in respect of, any use of, or reliance upon, this drawing by any third party.