

THE PLANNING ACT 2008


**M4 (JUNCTIONS 3 TO 12) (SMART MOTORWAY) DEVELOPMENT CONSENT
ORDER APPLICATION**

TR010019

**Response to Written Representation - London
Borough of Hillingdon**


Appendix A - Schematic Lighting Plan

Deadline IX - 3 March 2016

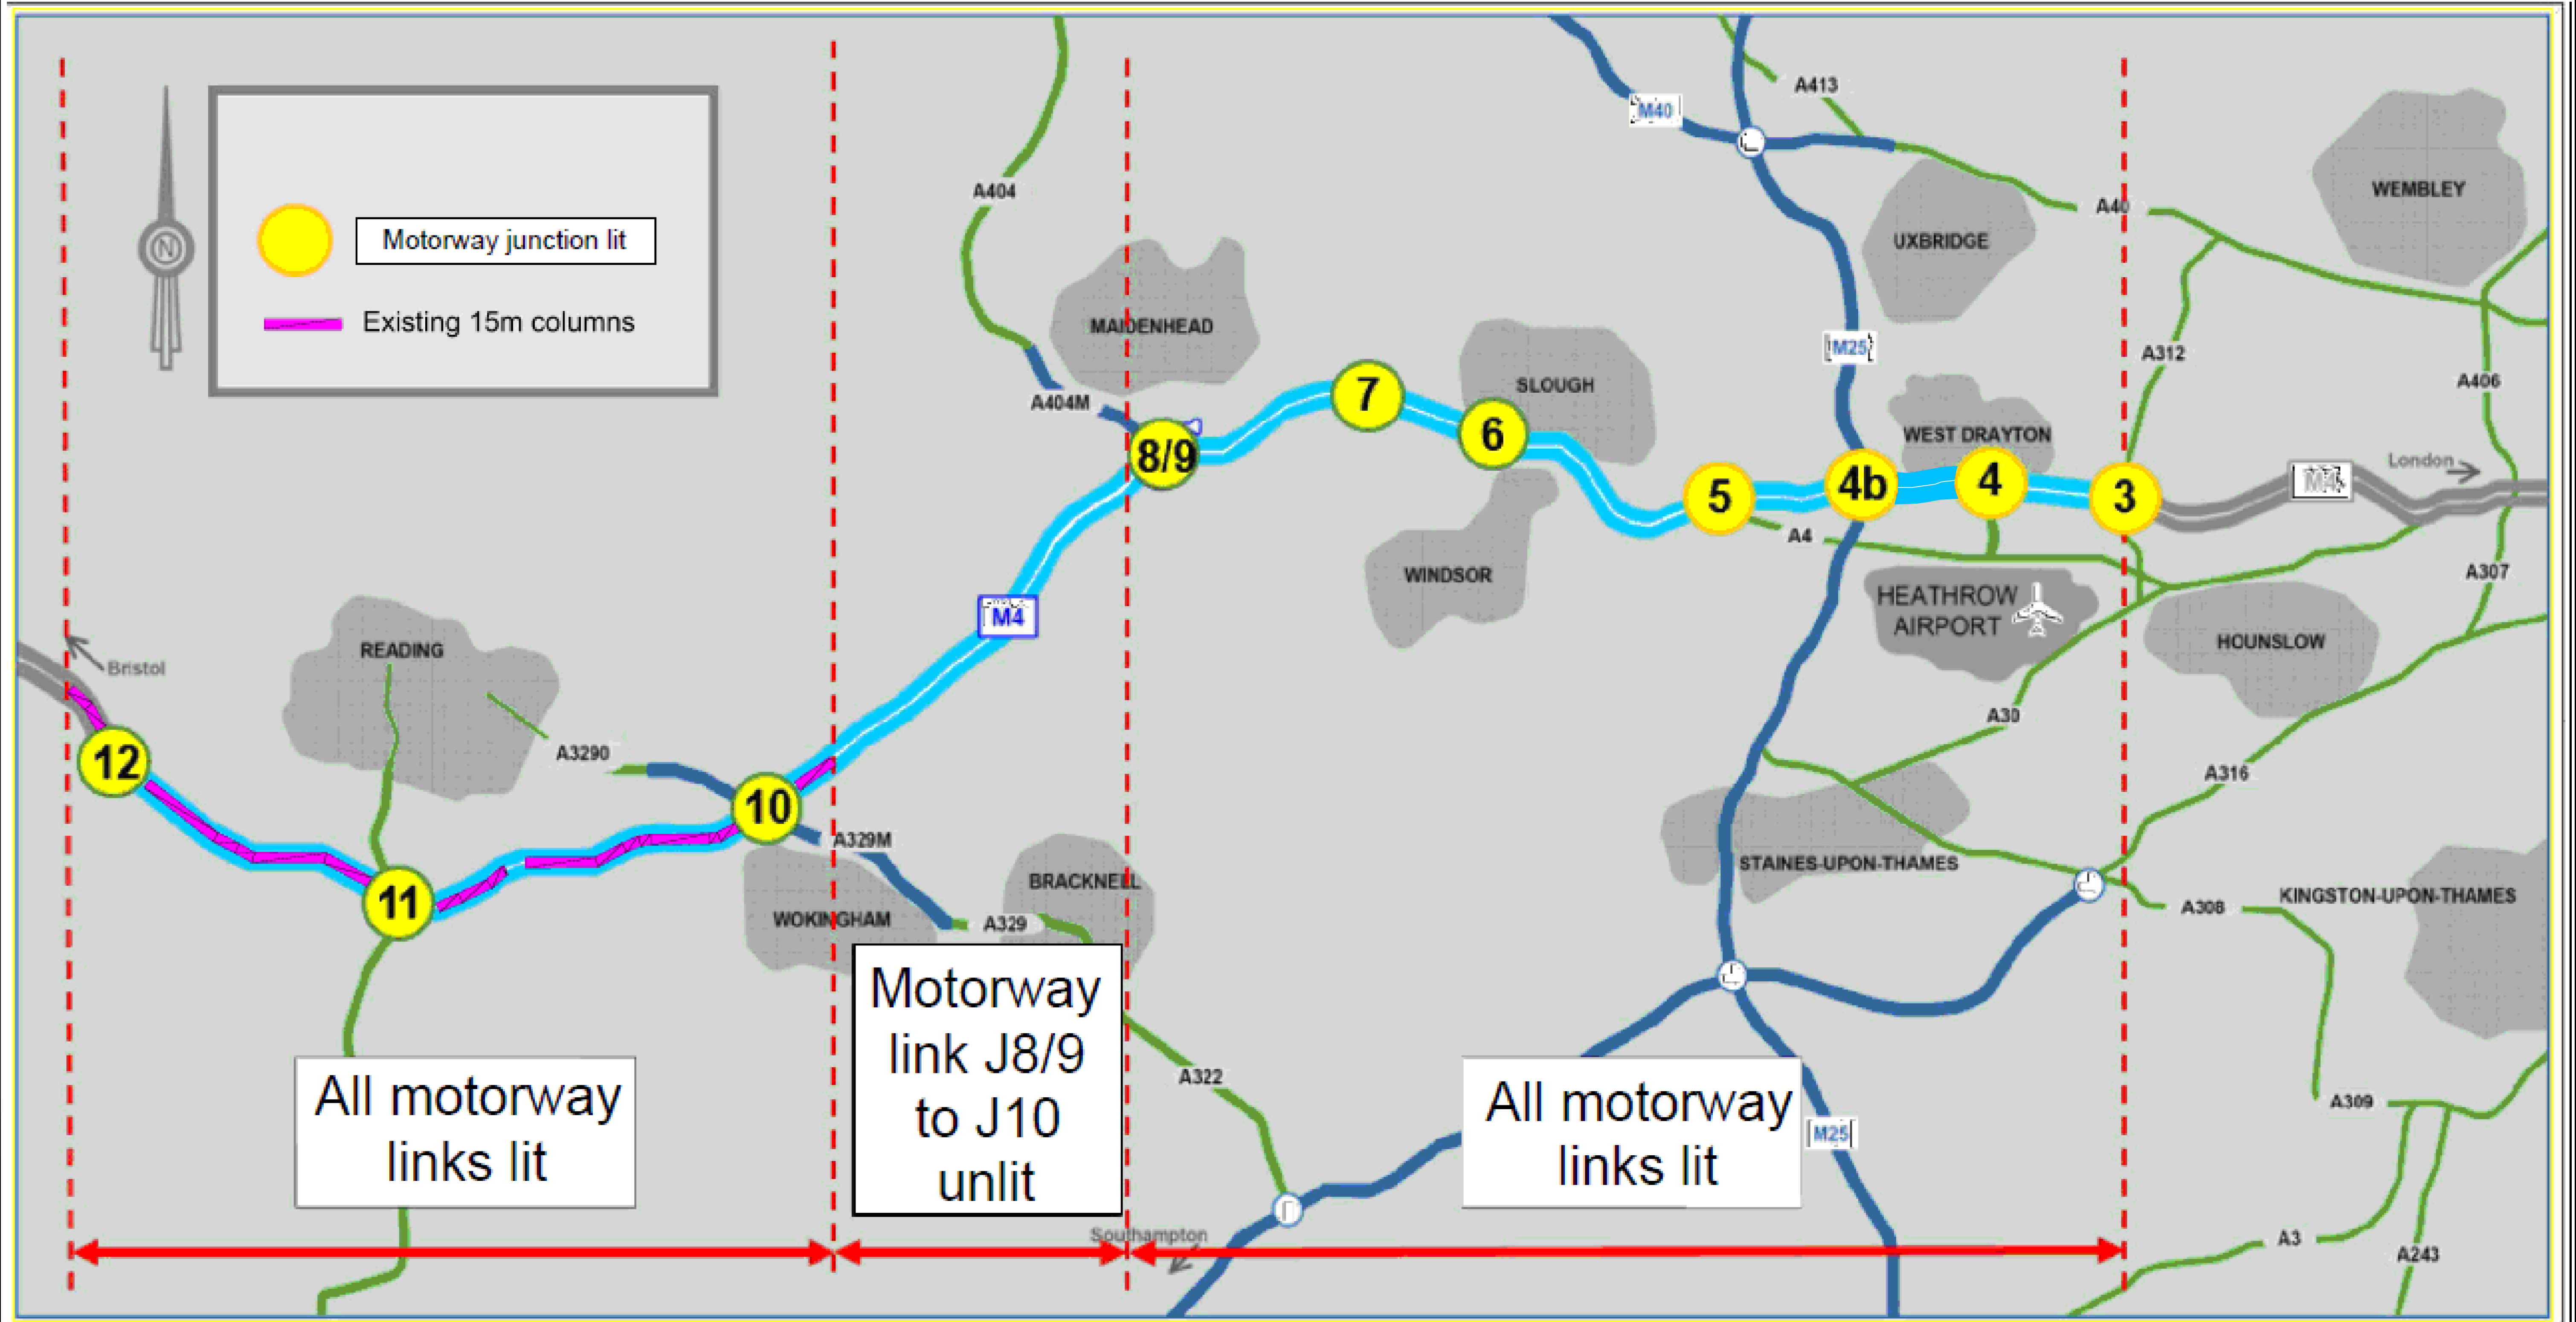

2F	03/03/2016	SUBMITTED FOR DCO DEADLINE IX SUBMISSION	ES	JP	SV	SF
1F	17/02/2016	SUBMITTED FOR DCO DEADLINE VII SUBMISSION	LE	RR	GM	SF
Rev #/Revision Date/Revision Details			Drawn	Check	Review	Appr'd

NOTES

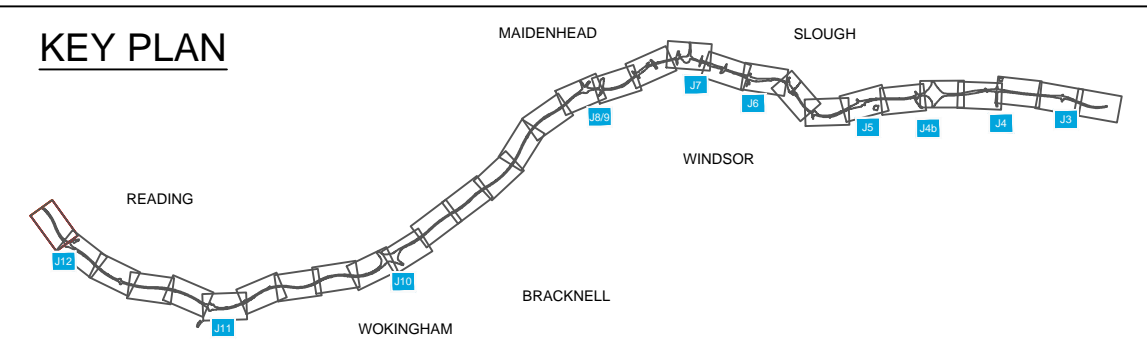

Highways England
Major Projects
Piccadilly Gate
Staircase
Manchester
M1 2WD

Alliance Document Reference
514451-MUH-00-ZZ-SK-DC-400224

Rev 2F Scale at A1 1:2500

Job Title	M4 JUNCTIONS 3 TO 12 SMART MOTORWAY
Drawing Title	SCHEMATIC LIGHTING PLAN
Drawing Number	TR010019 - IX - 01